

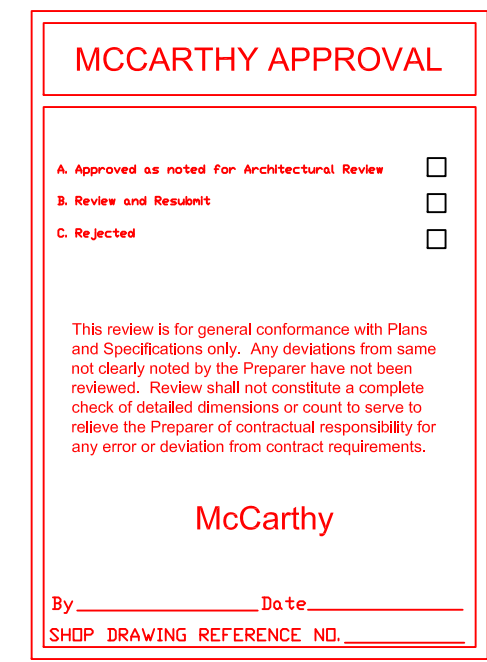


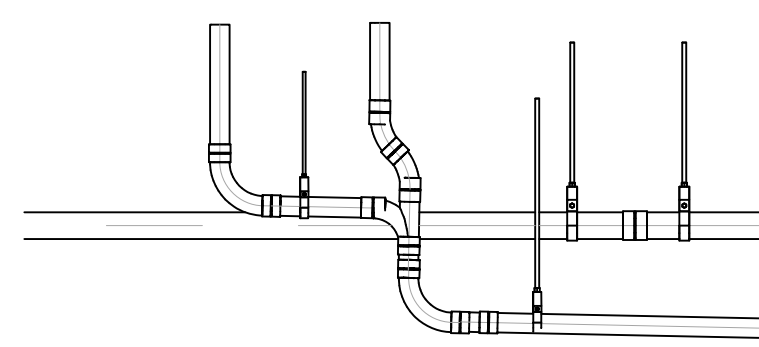


DRAWN R.O.
CHECKED
M.M.
DATE 4/30/2012
SCALE 1/4"=1'-0"
JOB NO. 09-006
DRAWING NUMBER PL3.2A
REFERENCE DRAWING A3.2A P3.2A
1 OF 1 SHEETS

This document and the design it covers are the property of Murray Co. They are loaned only with the borrower's expressed written agreement that they will not be reproduced, copied, loaned, exhibited, or used in any way, except by written consent from Murray Co. to the borrower.

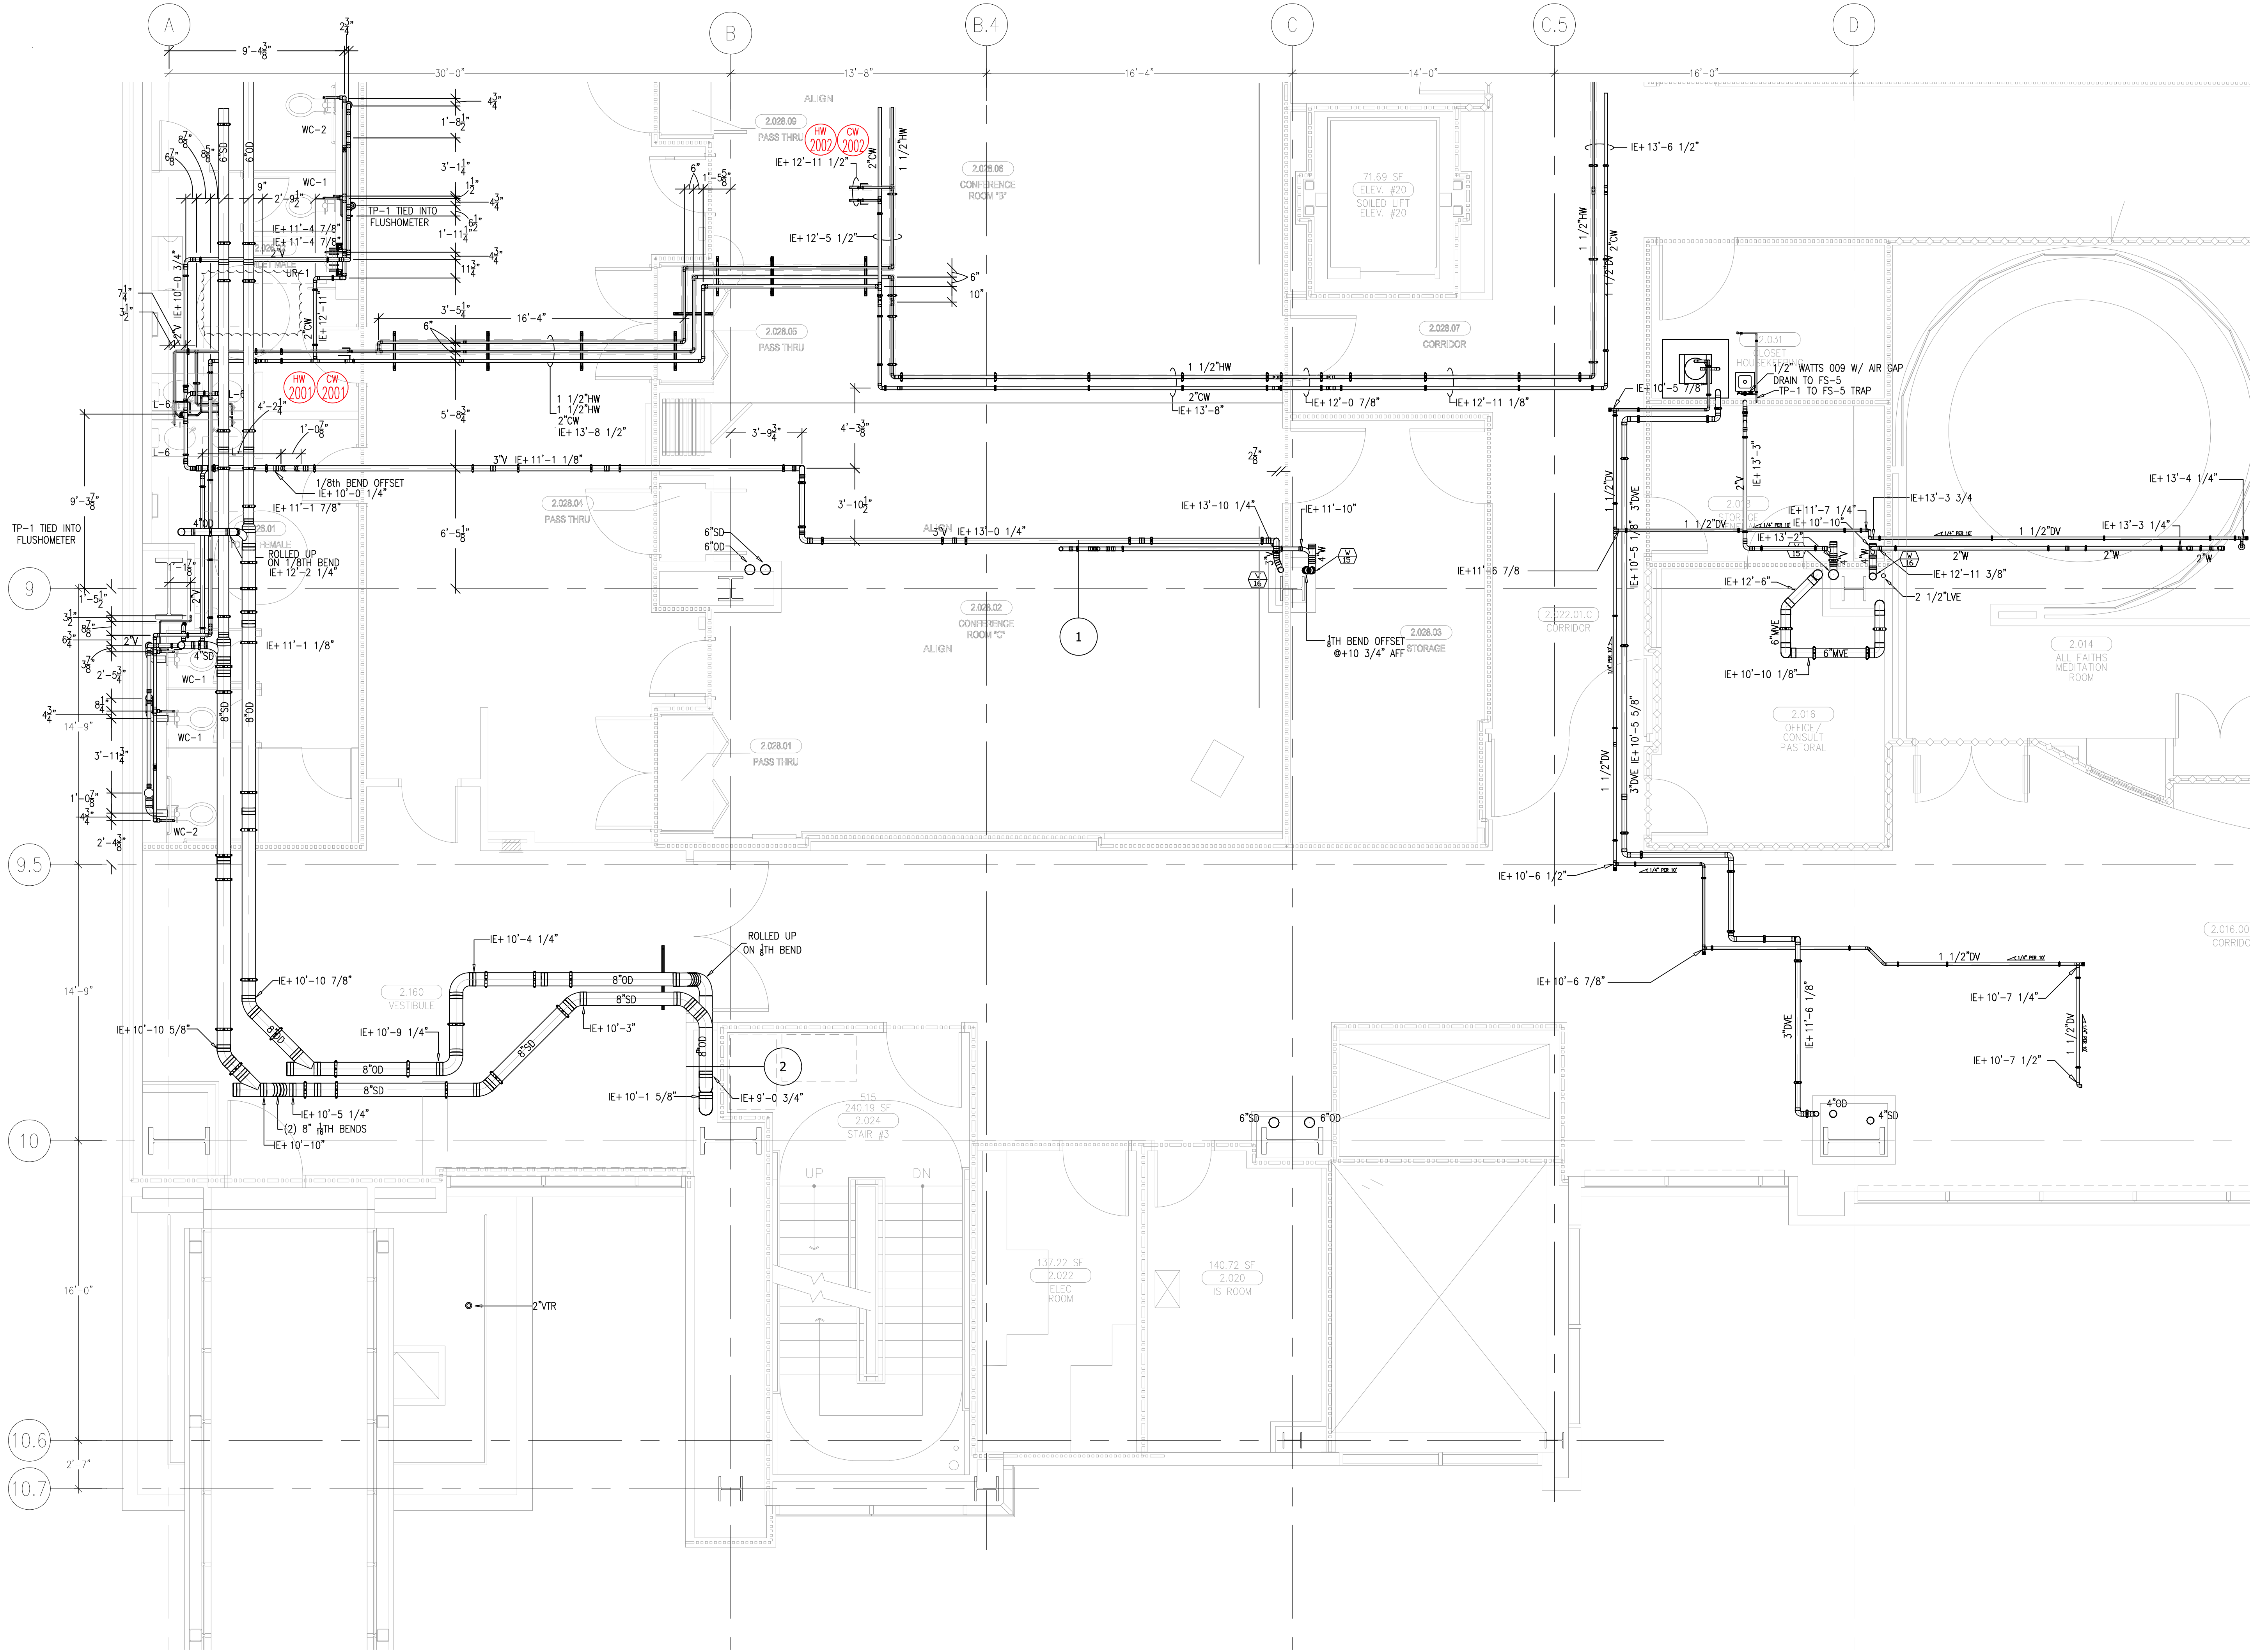

1 SECTION VIEW
Scale: 1/2"=1'

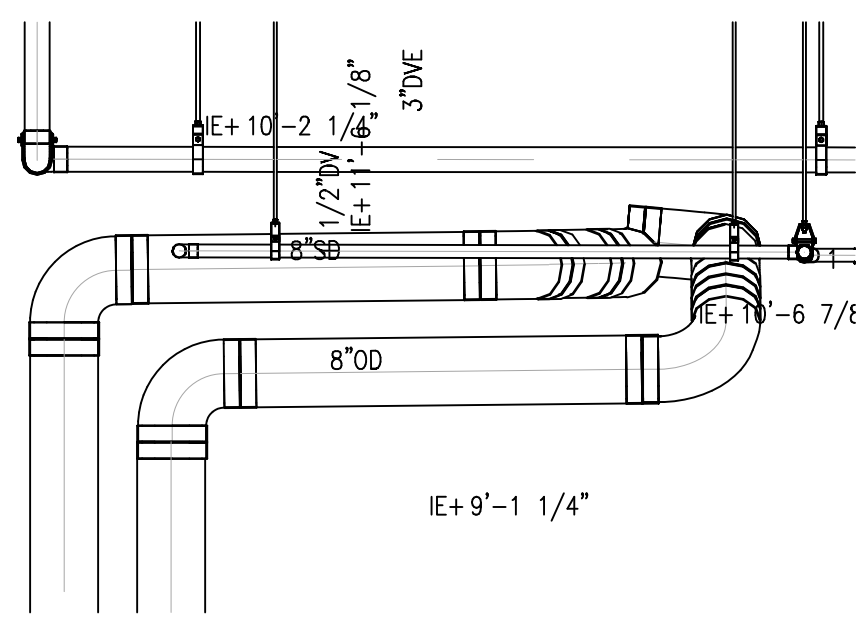

2 SECTION VIEW
Scale: 1/2"=1'


MCCARTHY APPROVAL

A. Approved as noted for Architectural Review ☐
B. Review and Re-submit ☐
C. Rejected ☐

This review is for general conformance with Plans and Specifications only. Any deviations from same not clearly noted by the Proprietary name and date, reviewed. Review shall not constitute a complete check of detailed dimensions or space to serve to release the Proprietor of contractual responsibility for any error or deviation from contract requirements.

McCarthy

By: _____ Date: _____
SHEP. DRAWING REFERENCE NO. _____

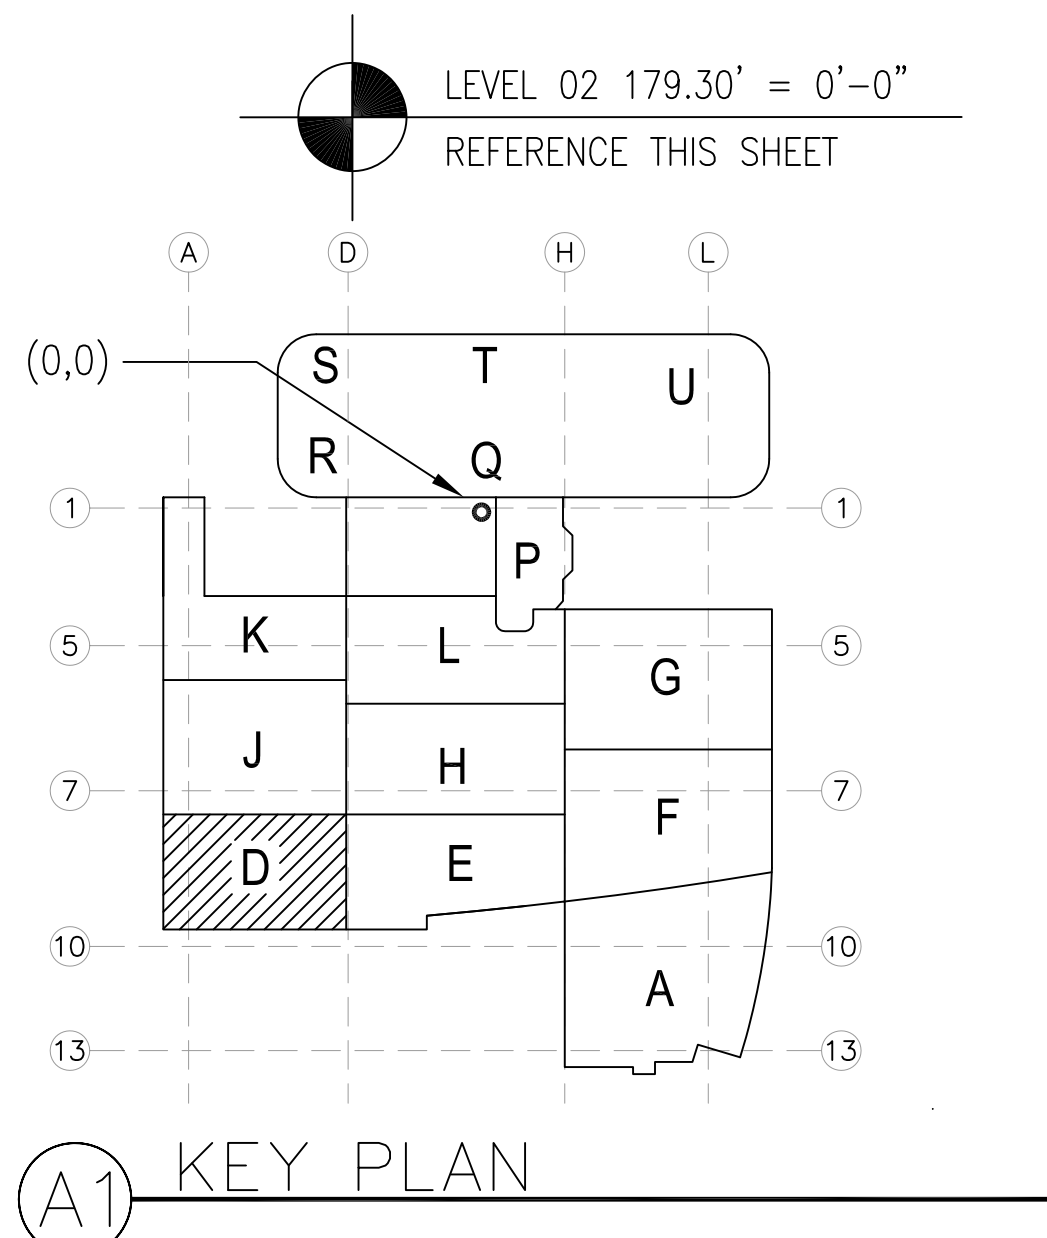

REVISIONS		BY
A	ISSUED FOR COORDINATION SIGN-OFF 11-30-09	DK
B	ISSUED FOR COORDINATION SIGN-OFF 11-30-09	DK
0	ISSUED FOR CONSTRUCTION 04-28-10	DK
1	PNM: 891 321 REVISION 08-21-10	JT
2	RELOCATED SS-TS DUE TO DOOR RELOCATION. 12-22-10	DK
3	ADDED 2"V AT FIREPUMP ROOM. DOOR RELOCATION. 12-22-10	DK
4	REVISED PER CO# 62 SS-CHURCH 1-10-11	DK
5	REVISED PER CO 134 PNM: 0264/ 05 0264 6-15-2011	JT
6	CO# 134 SIGN OFF 10-07-11	DK

COORD.	SIGNATURE	DATE
MECHANICAL		
ELECTRICAL		
PLUMBING		
STRUCTURAL		

R.F.I.	SENT	ANS.	R.F.I.	SENT	ANS.
0321	08/17/09	08/28/09			
0384	09/02/09	10/26/09			
0372	09/04/09	10/13/09			

**CHILDREN'S HOSPITAL
OF ORANGE COUNTY**
455 S. MAIN ST., SUITE 200
ORANGE, CA 92668-3974

TOWER II

PLUMBING FLOOR PLAN - LEVEL 02 / AREA D

PAN-PACIFIC
PLUMBING & MECHANICAL
2919 E. VICTORIA STREET, RANCHO DOMINGUEZ, CA 90221
PH. 310 637-1500 FAX 310 604-0359

DRAWN
R.O.
CHECKED
M.M.
DATE
4/30/2012
SCALE
1/4"=1'-0"
JOB NO.
09-006
DRAWING NUMBER
PL3.2D
REFERENCE DRAWING
A3.2D
P3.2D
1 OF 1 SHEETS

LEVEL 02 179.30' = 0'-0"


REFERENCE THIS SHEET

(0,0)


1 5 7 10 13

1 5 7 10 13

KEY PLAN

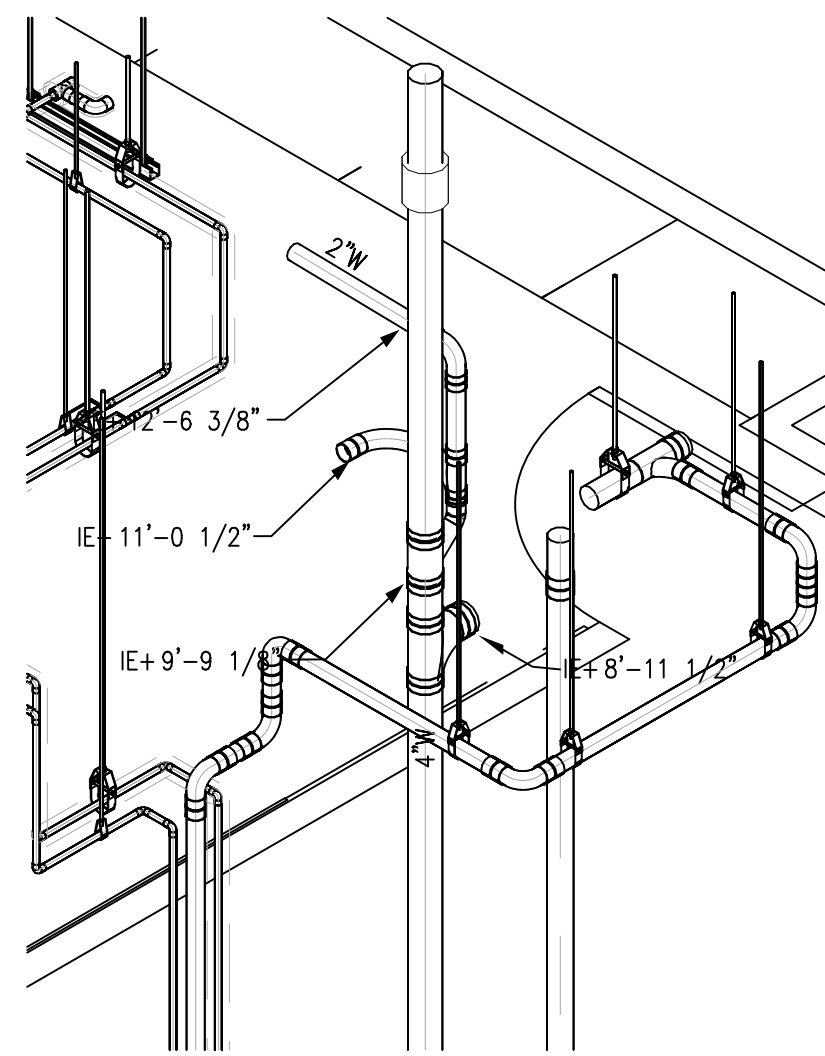

1 SECTION VIEW
Scale: 1/2"=1'

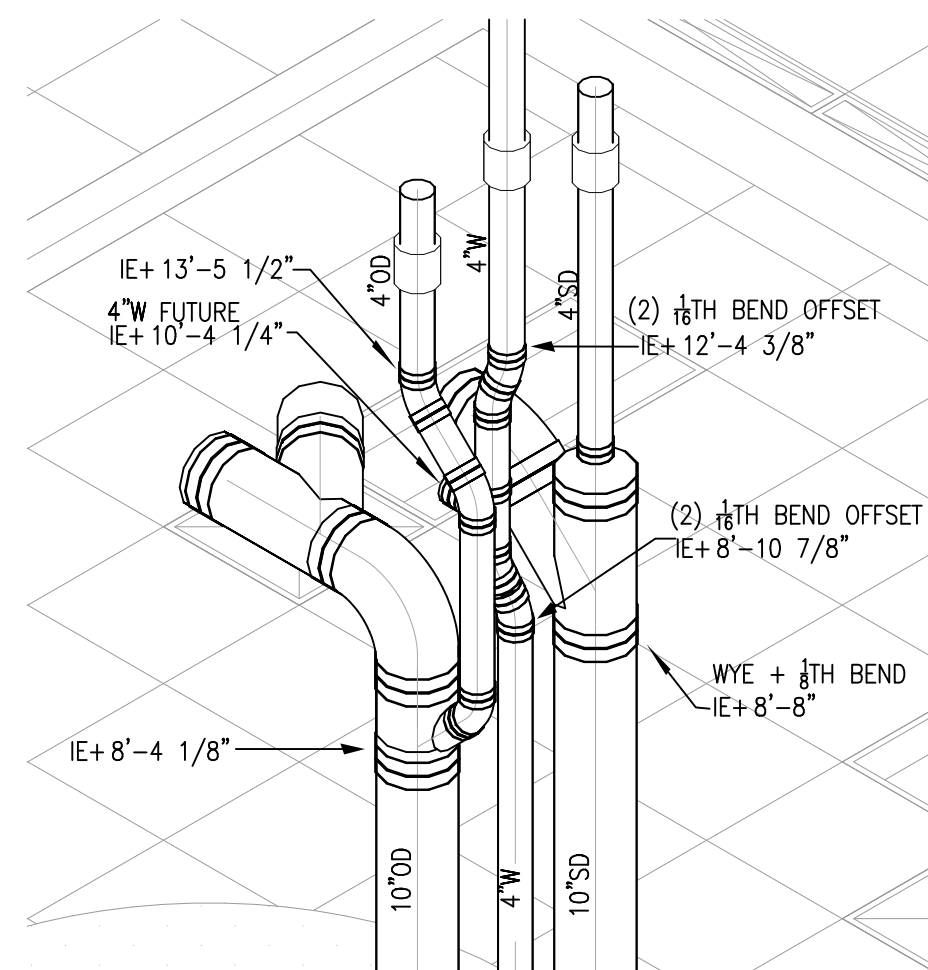

2 SECTION VIEW
Scale: 1/2"=1'

	REVISIONS	BY
A	ISSUED FOR COORDINATION SIGN-OFF 11-30-09	DK
B	ISSUED FOR OSHPO PERMIT RE-COORDINATION SIGN OFF 5-10-10	DK
0	ISSUED FOR CONSTRUCTION 04-28-10	DK
1	REVISED PER CO# 62. D-0167LAB1 03-10-11	DK
2	REVISED WASTE PIPING TO MISS CEILING FRAMING 04-29-11	DK
3	REVISED DUO TO CHANGE ORDER NO. 134.	DK
4	REVISED DUO TO CONDITIONS AT TIME OF INSTALLATION. 9-27-11	DK
5	CO# 134 SIGN OFF 10-07-11	DK

COORD.	SIGNATURE	DATE
McARTHUR		
MECHANICAL DUCT		
MECHANICAL PIPE		
PLUMBING		
ELECTRICAL		
FIRE SPRINKLER		
PT/UE		
DRYWALL/FRAMER		
REFRIGERATION		
STRUCTURAL		

R.F.I.	SENT	ANS.	R.F.I.	SENT	ANS.	R.F.I.	SENT	ANS.
01386R	06/12/09	06/16/09						
01522	05/28/09	06/05/09						
03777	09/05/09	09/18/09						
03989	09/11/09	09/29/09						
04554	09/29/09	10/16/09						
08885	07/19/10	07/23/10						

**CHILDREN'S HOSPITAL
OF ORANGE COUNTY**
455 S. Main St.
Orange, CA. 92668-3874

TOWER II

PLUMBING FLOOR PLAN - LEVEL 02 AREA-F

PAN-PACIFIC
PLUMBING & MECHANICAL


PAN-PACIFIC
PLUMBING & MECHANICAL


Murray Company

2919 E. VICTORIA STREET, RANCHO DOMINGUEZ, CA 90221

DRAWN R.O.
CHECKED
M.M.
DATE
4/30/2012
SCALE
1/4" = 1'-0"
JOB NO.
09-006
DRAWING NUMBER
PL3.2E
REFERENCE DRAWING
A3.2F
P3.2F
1 OF 1 SHEETS

This document and the design it covers are the property of Murray Co. They are loaned only with the borrower's expressed written agreement that they will not be reproduced, copied, loaned, exhibited, or used in any other way, except by written consent from Murray Co. to the borrower.

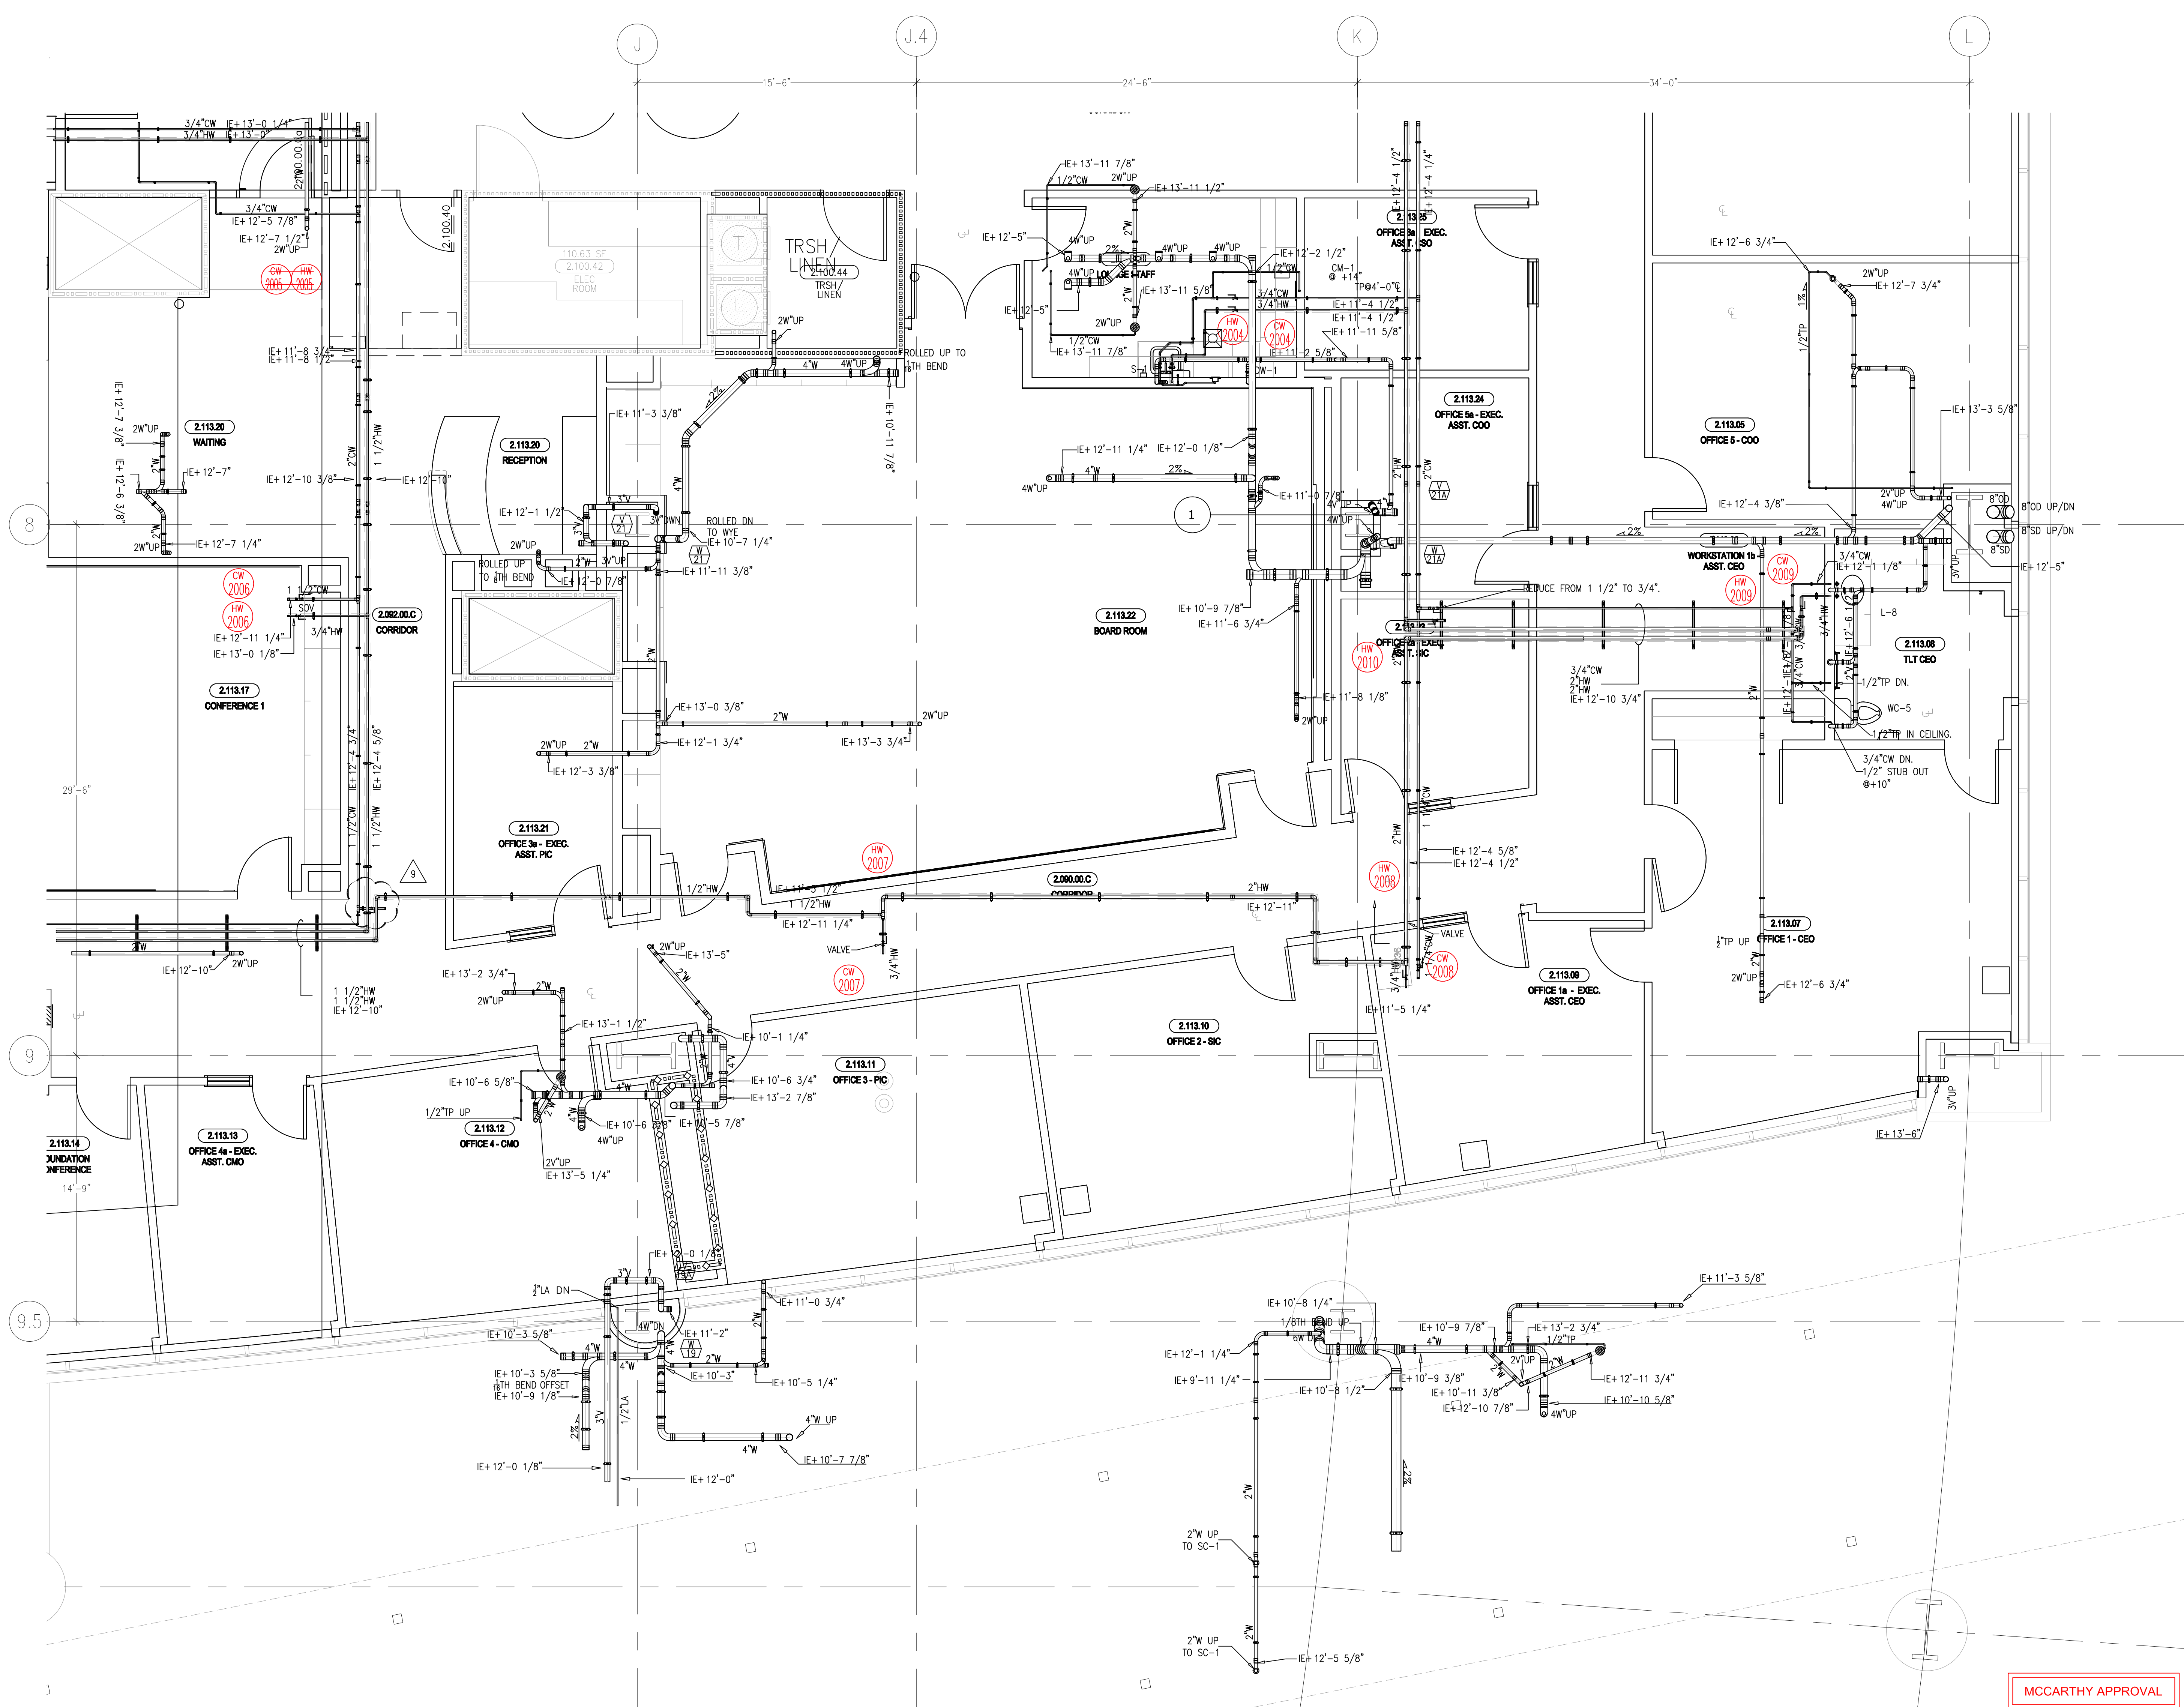

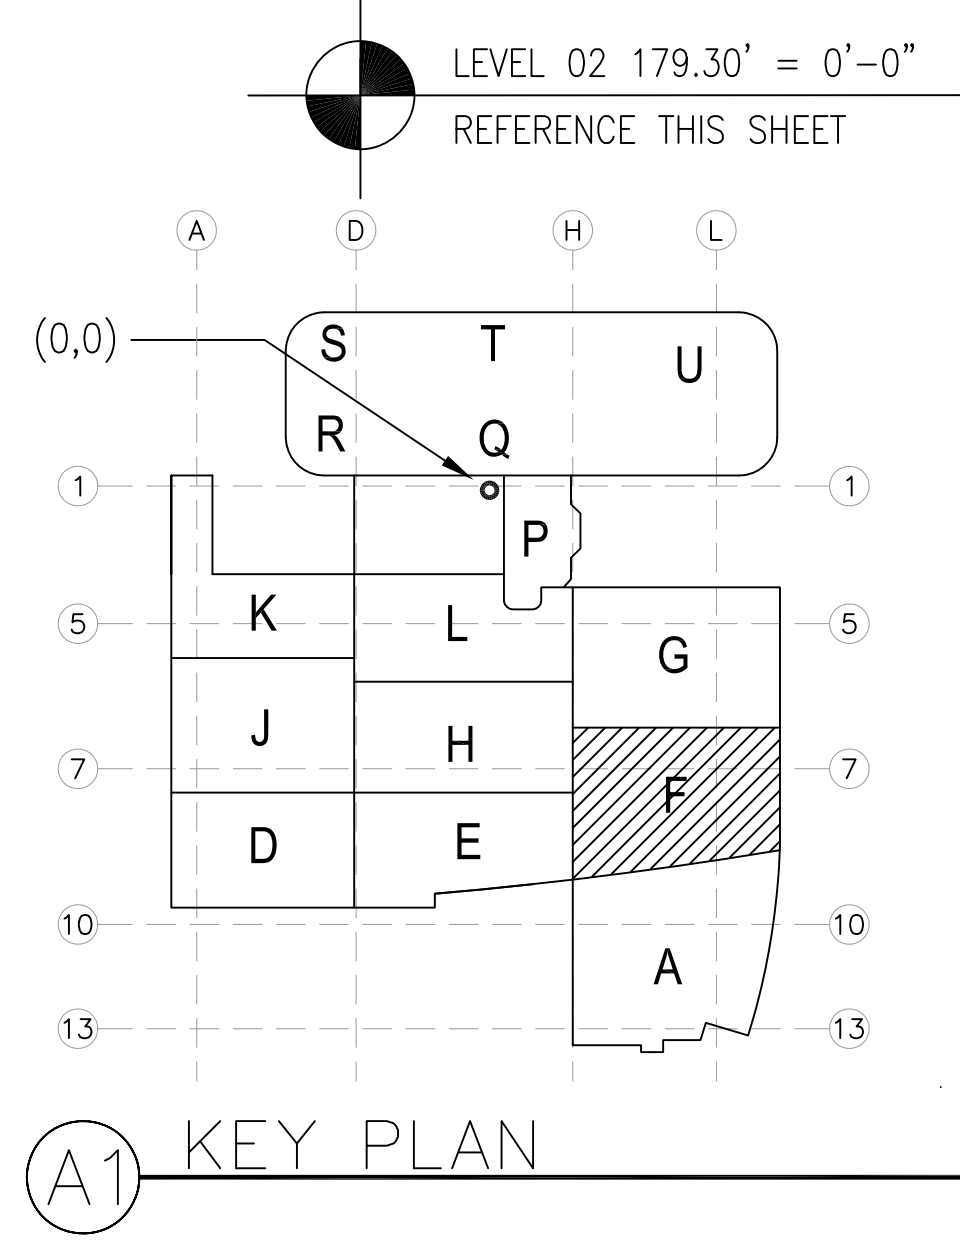

	REVISIONS	BY
3	REVISED VENT CALLOUT XX-XX-XX	MO
4	REVISED WASTE TO AVOID CONFLICT WITH FRAMING. 04-02-11	DK
5	REVISED PERMIT CON RPT 1978, PACE 323 CO# 140 05-16-11	JT
6	REVISED PER CO 134 P.M. 0264/ 05 0264 06-01-11	JT
7	REVISED LOCATION DUE TO CONGESTION IN WALL. 8-10-2011	DK
8	REVISED PIPE SIZING. 8-29-11	DK
9	SHORTENED TRANCH TO MISS DUCT FOR CO# 134. 11-4-11	DK
10	REVISED PER CO# 299 ADDED SCRUB SINK WASTE. 02-01-12	DK

COORD.	SIGNATURE	DATE
McCarthy		
MECHANICAL DUCT		
MECHANICAL PIPE		
PLUMBING		
ELECTRICAL		
FIRE SPRINKLER		
PLUMB		
DRYWALL/FRAMER		
REFRIGERATION		
STRUCTURAL		

R.F.I.	SENT	ANS.	R.F.I.	SENT	ANS.	R.F.I.	SENT	ANS.
0699	05/04/09	07/29/09						
0356	08/21/09	09/15/09						
0402	09/11/09	09/29/09						
0403	09/11/09	09/29/09						
0436	09/29/09	10/26/09						
0684	01/09/10	03/04/10						

CHILDREN'S HOSPITAL
OF ORANGE COUNTY
455 S. Main St.
Orange, CA 92668-3874
TOWER II
PLUMBING FLOOR PLAN - LEVEL 02 AREA-F

PAN-PACIFIC
PLUMBING & MECHANICAL


PAN-PACIFIC
PLUMBING & MECHANICAL

Murray Company

2919 E. VICTORIA STREET, RANCHO DOMINGUEZ, CA 90221
PH. 310 637-1500 FAX 310 604-0359

DRAWN	R.O.
CHECKED	
M.M.	
DATE	4/30/2012
SCALE	1/4"=1'-0"
JOB NO.	09-006
DRAWING NUMBER	PL3.2F
REFERENCE DRAWING	A3.2F P3.2F
1	OF 1 SHEETS

This document and the design it covers are the property of Murray Co. They are loaned only with the borrower's expressed written agreement that they will not be reproduced, copied, loaned, exhibited, or used in any other way, except by written consent from Murray Co. to the borrower.

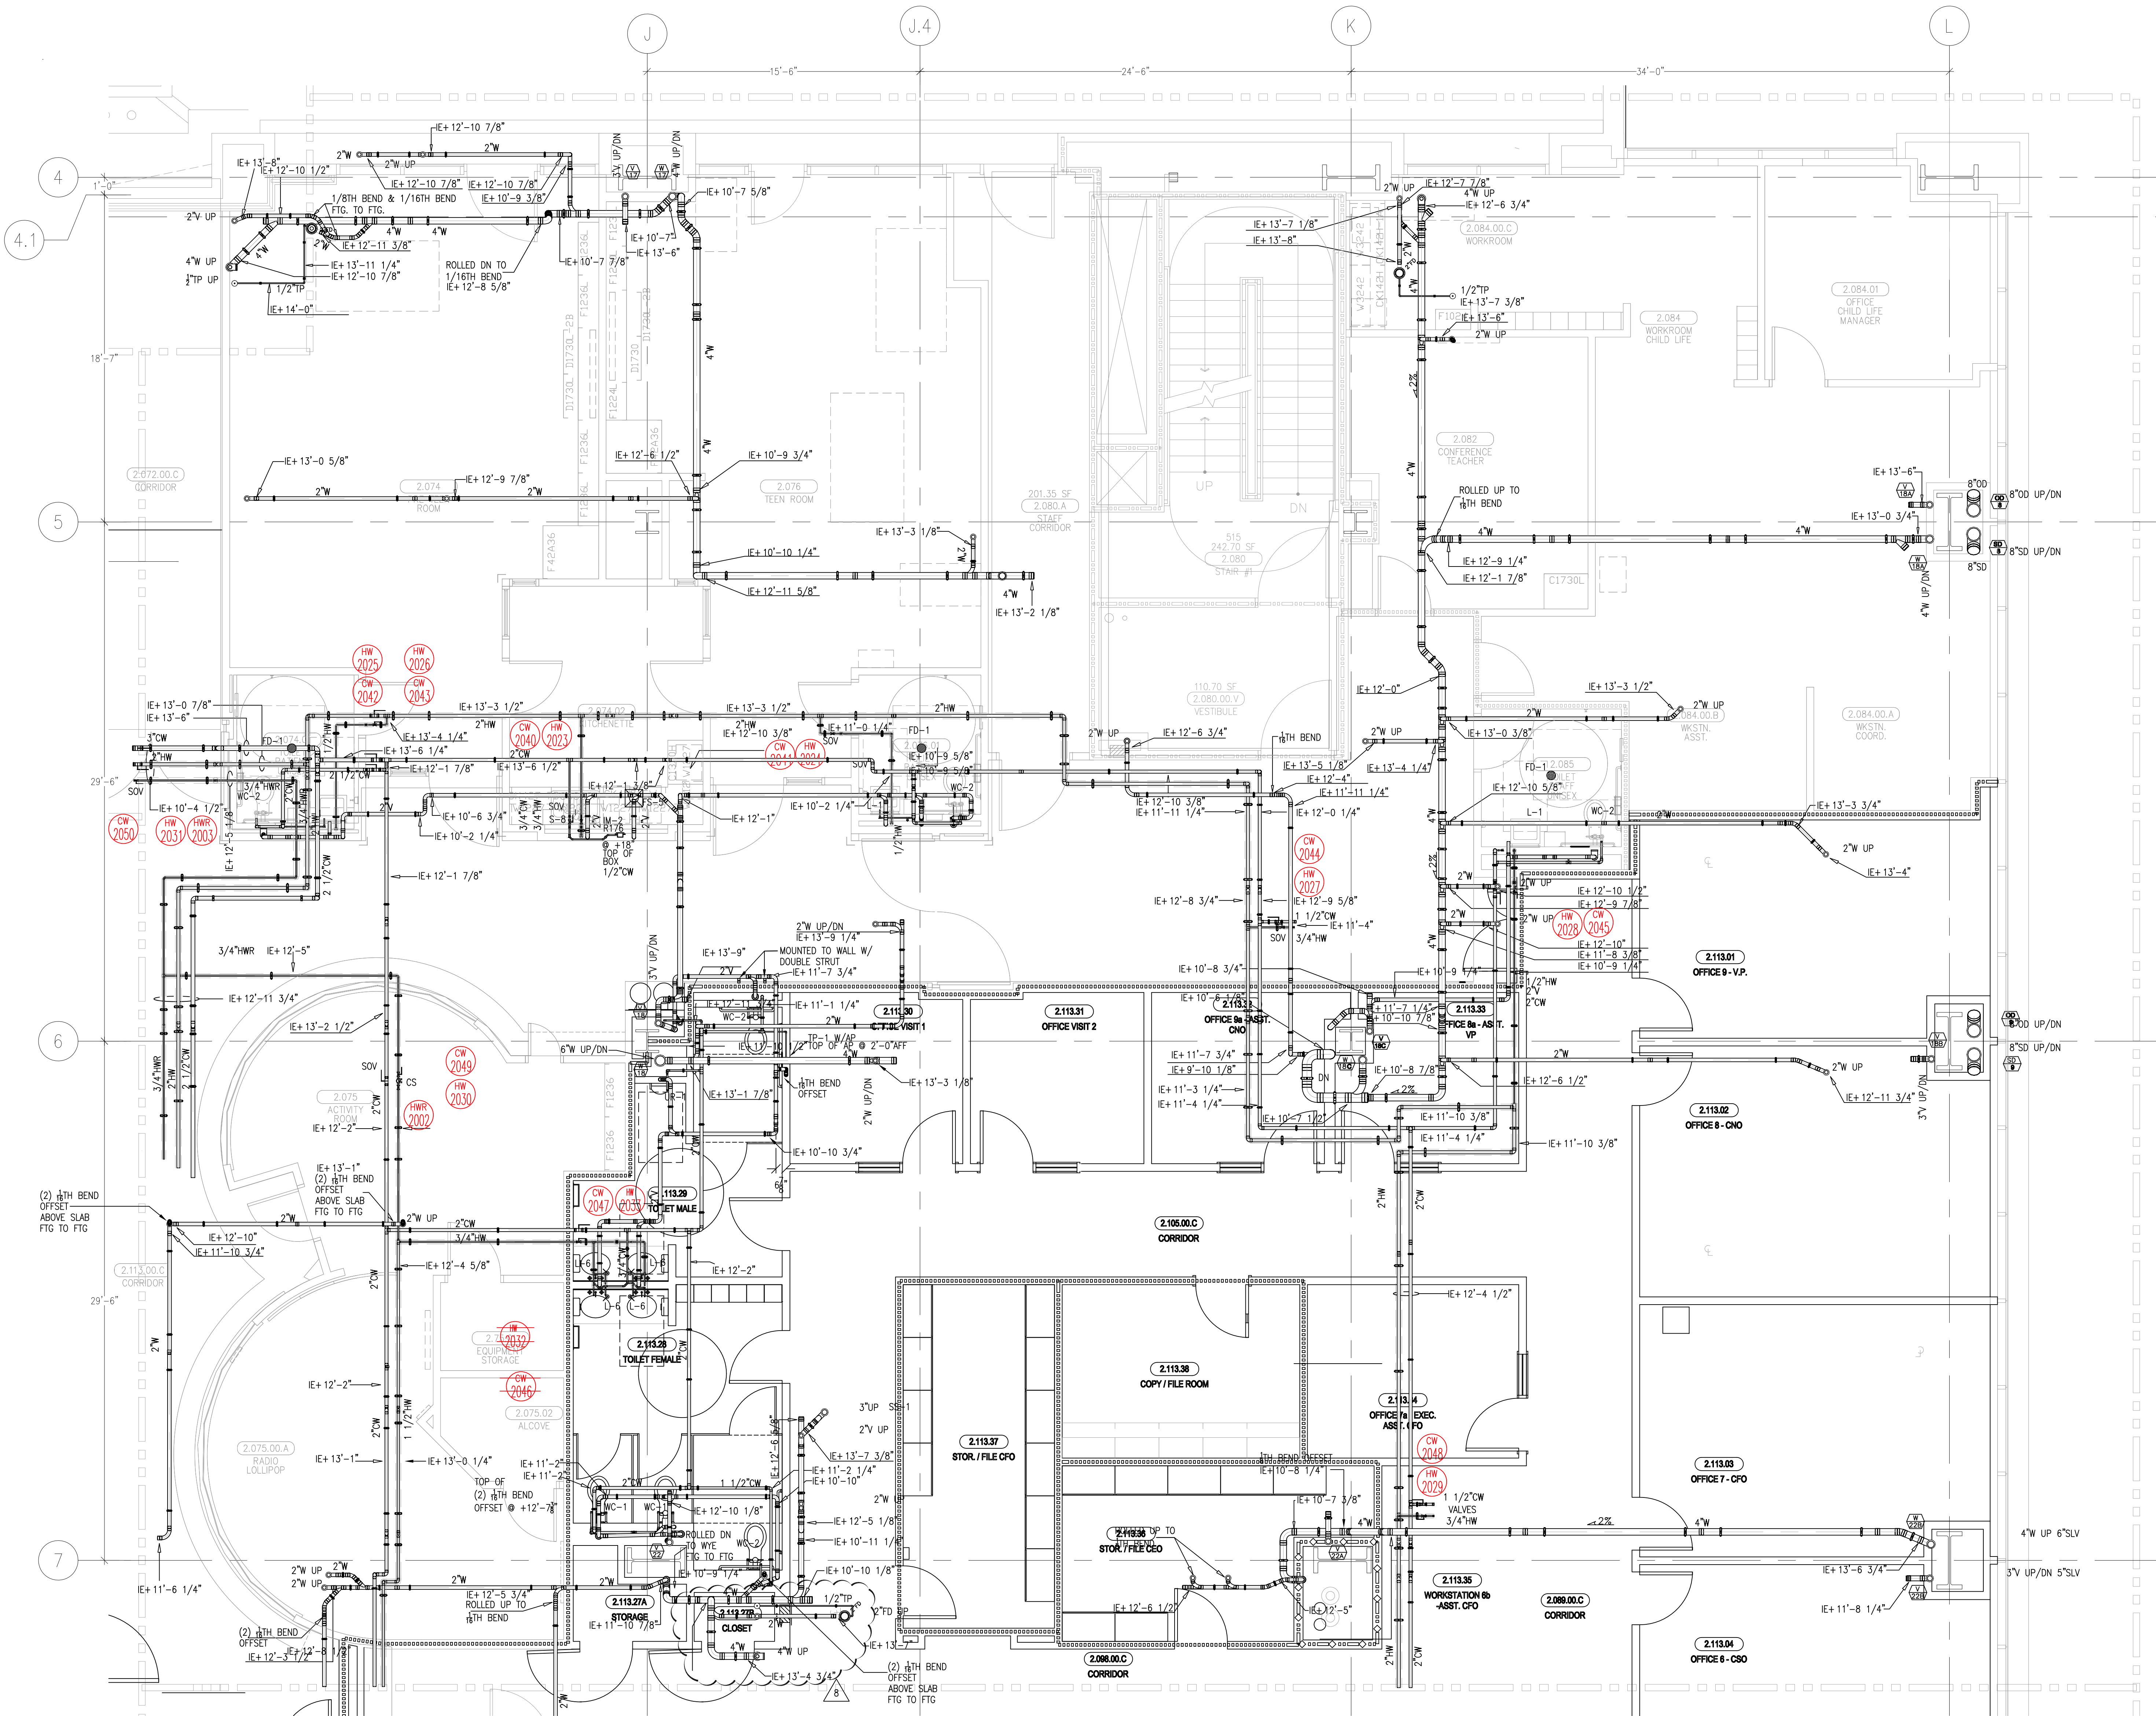

- ALL FD-1 TOP OF DRAINS TO BE SET 1/2" BELOW FINISHED FLOOR PER PMWC 0800
- ISSUED FOR COORDINATION SIGN-OFF 11-30-09
- CONSTRUCTION RFI 281
- CONSTRUCTION RFI 212
- ISSUED FOR OSHPD PERMIT RE-COORDINATION SIGN OFF 3-10-10
- ISSUED FOR CONSTRUCTION 04-26-10
- ADDED NOTE FOR FD-1 PER CON RFI 1270 PMWC RFI 0800 5-4-10 REVISED WASTE SLOPE PER DRAINERS REQUEST 6-20-2010

REVISIONS	BY
ADDED MISSING VENT PIPE 11-18-2010	DK
REVISED FLOOR DRAIN PIPING DUE TO ELEVATION ISSUES 11-18-2010	DK
REVISED PER ICE MAKER ROUGH-IN 11-24-10	JT
REVISED PER CO 134 PMWC 0804/RS 0384 6-21-2011	DK
COV 134 SIGN OFF 10-07-11	DK
COV 134 CHANGES TO EXISTING PIPE 11-11-11	DK

COORD.	SIGNATURE	DATE
MECHANICAL		
ELECTRICAL		
PLUMBING		
STRUCTURAL		

ANS.	SENT	R.F.I.	SENT	R.F.I.	SENT	ANS.	SENT	R.F.I.	SENT	R.F.I.	SENT	ANS.	SENT	R.F.I.	SENT
0137	05/20/09	0538	10/22/09	0538	10/28/09	0137	05/20/09	0538	10/22/09	0538	10/28/09	0137	05/20/09	0538	10/22/09
0165	06/02/09	0576	11/27/09	0576	12/04/09	0165	06/02/09	0576	11/27/09	0576	12/04/09	0165	06/02/09	0576	11/27/09
0381	09/02/09	0656	01/08/10	0656	01/25/10	0381	09/02/09	0656	01/08/10	0656	01/25/10	0381	09/02/09	0656	01/08/10
0404	09/11/09	0672	01/12/10	0672	02/01/10	0404	09/11/09	0672	01/12/10	0672	02/01/10	0404	09/11/09	0672	01/12/10

MCCARTHY APPROVAL


A. Approved as noted for Architectural Review
B. Review and Revisions
C. Rejected

This review is for general conformance with Plans and Specifications only. Any deviations from same not clearly noted by the Designer are not to be reviewed. Review shall not constitute a complete check of details, dimensions or count to serve as release the Designer of contractual responsibility for any error or deviation from contract requirements.

McCarthy

By: _____ Date: _____
Title: _____ Drawing Reference No. _____

LEVEL 02 179.30' = 0'-0"
REFERENCE THIS SHEET

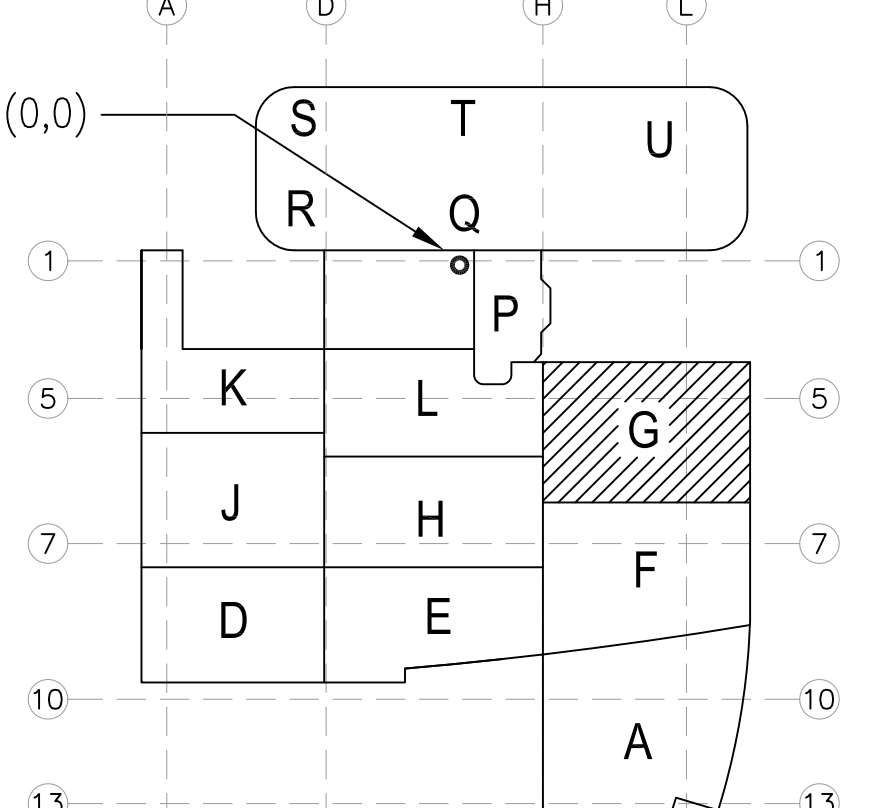


CHILDREN'S HOSPITAL OF ORANGE COUNTY
455 S. MAIN ST., ORANGE, CA 92668-3974
TOWER II
PLUMBING FLOOR PLAN - LEVEL 02 AREA A

PAN-PACIFIC COMPANY
PLUMBING & MECHANICAL
2919 E. VICTORIA STREET, RANCHO DOMINGUEZ, CA 90221
PH. 310 637-1500 FAX 310 604-0359

DRAWN: R.O.
CHECKED: M.M.
DATE: 4/30/2012
SCALE: 1/4" = 1'-0"
JOB NO.: 09-006
DRAWING NUMBER: PL3.2G
REFERENCE DRAWING: A3.2A, P3.2A
1 OF 1 SHEETS

This document and the design it covers are the property of Murray Co. They are loaned only with the borrower's expressed written agreement that they will not be reproduced, copied, loaned, or used in any way, except by written consent from Murray Co. to the borrower.

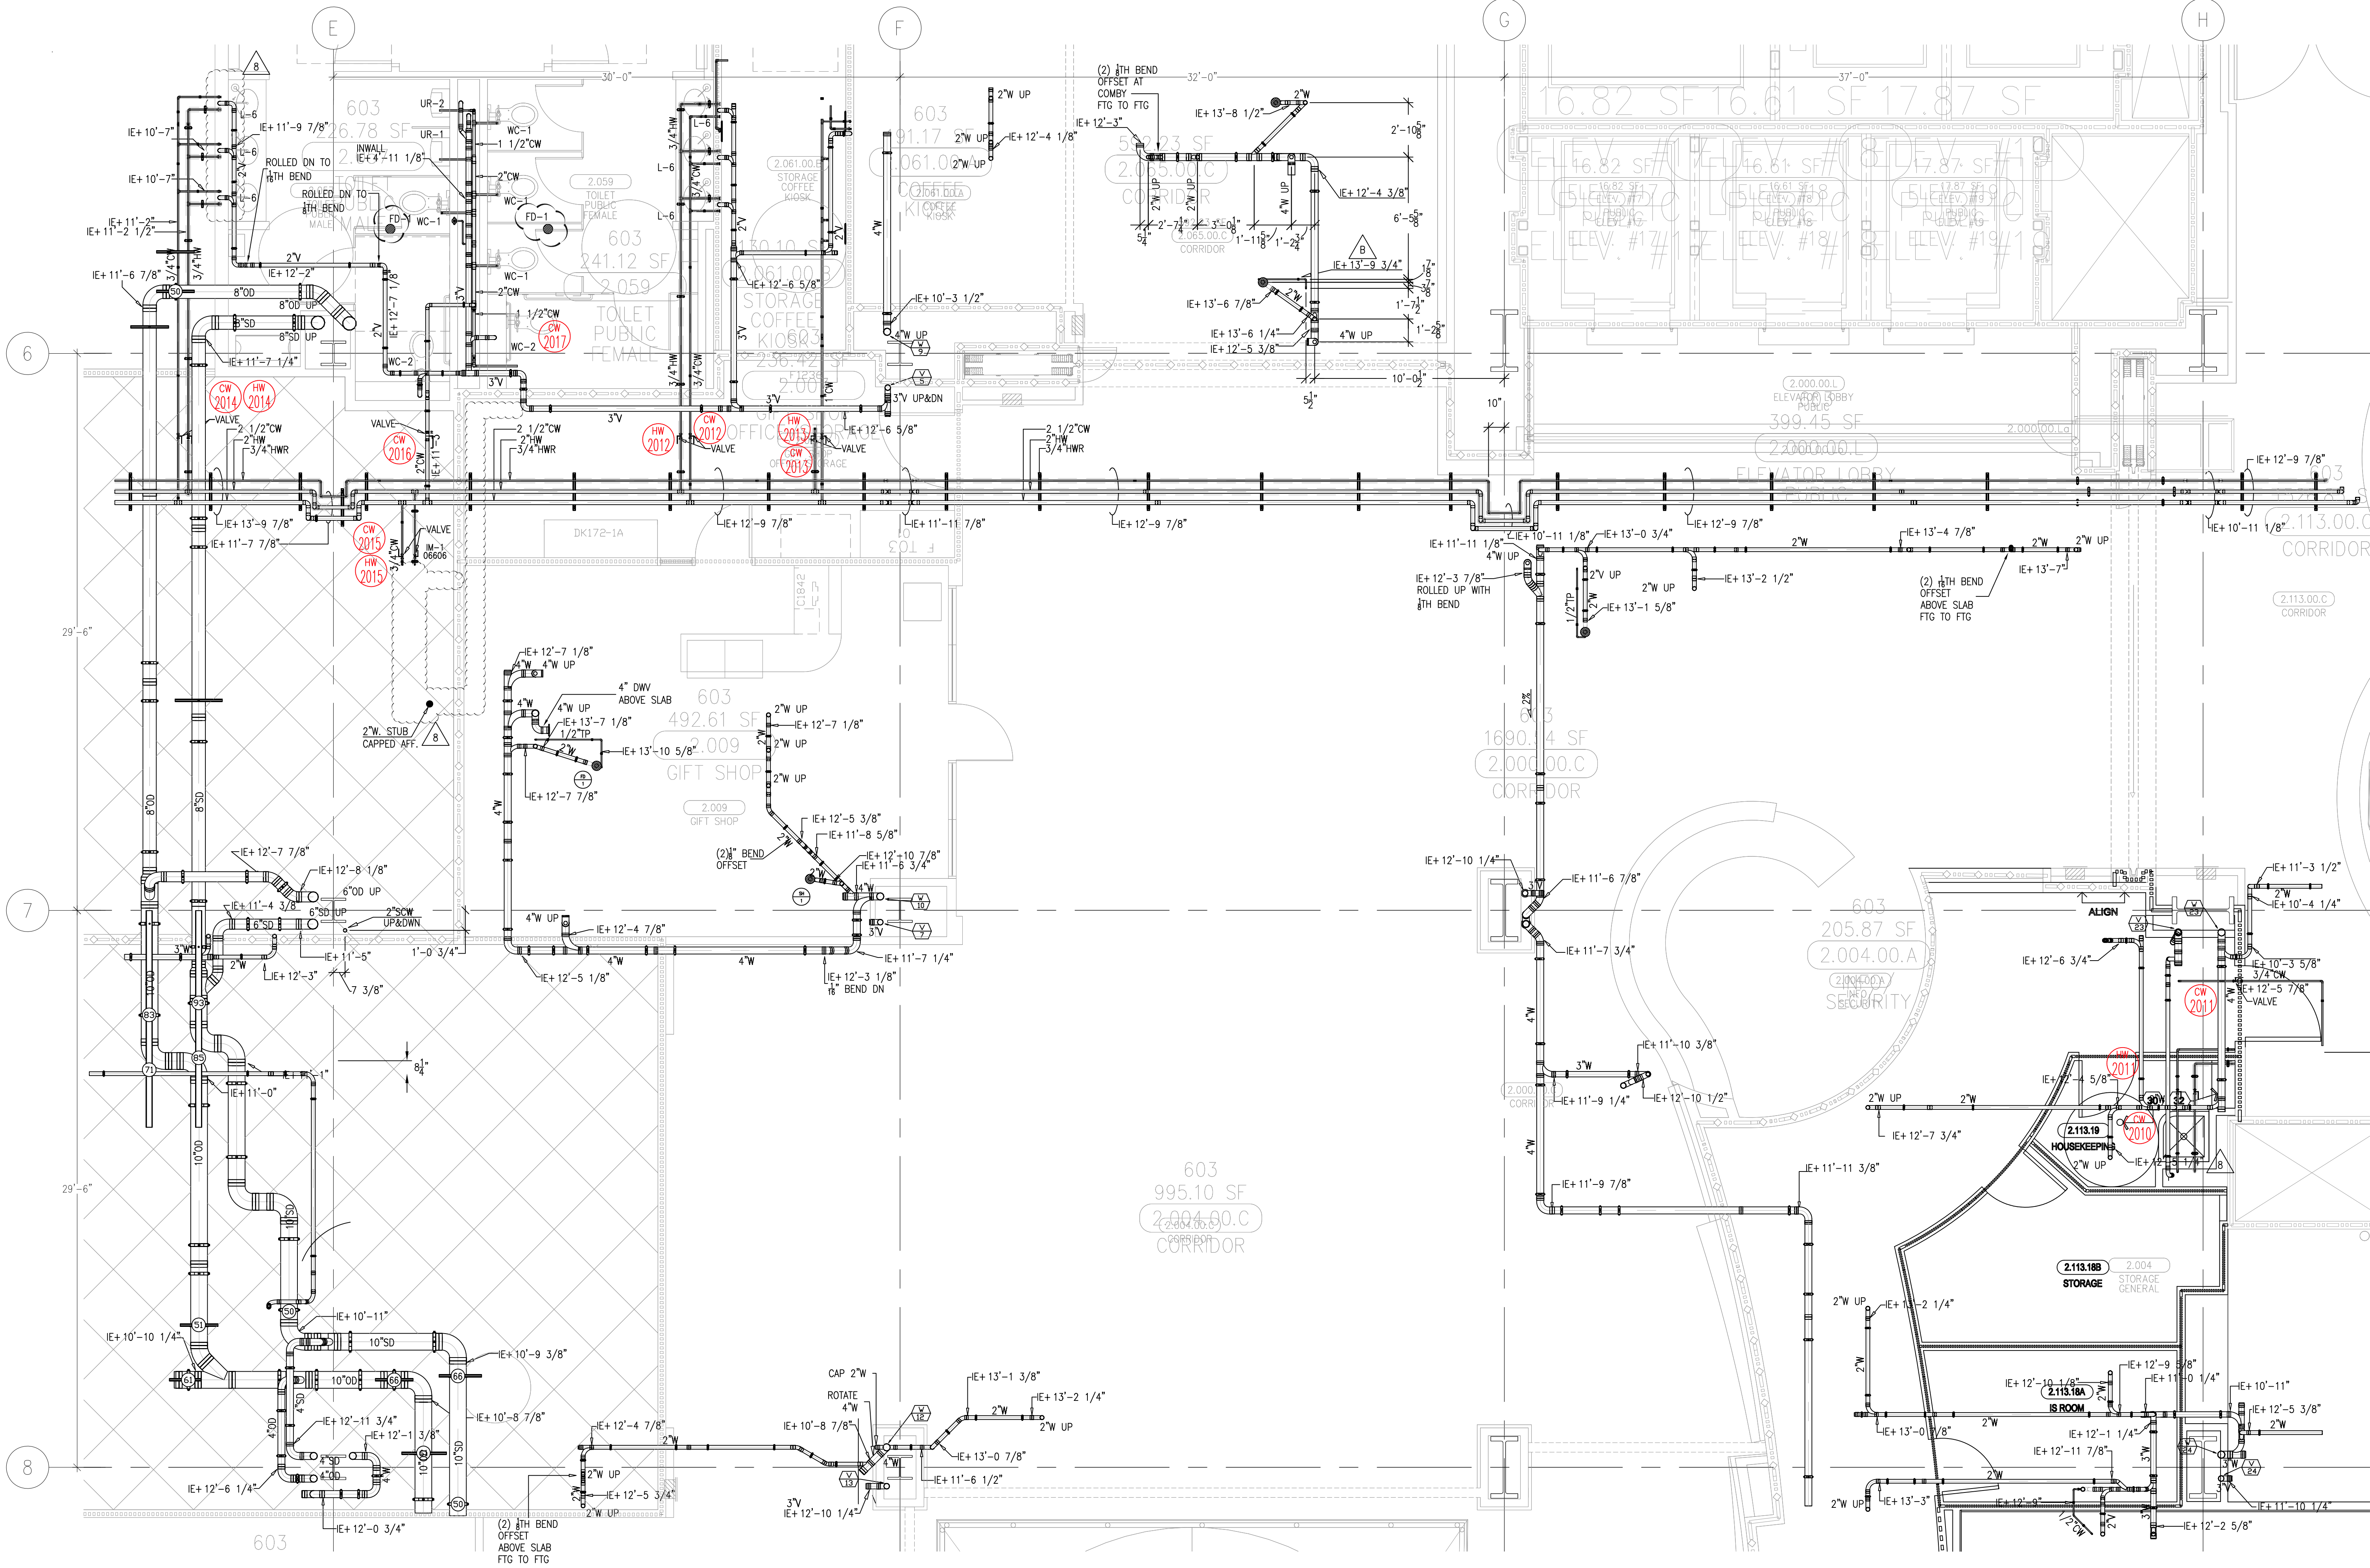

- 0

ISSUED FOR CONSTRUCTION
04-28-10

DK
- 1

ADDED NOTE FOR FD-1
PER CON RFI 1270
PMO RFI 0800 5-4-10
ROOFED SUPPL
PER ENGINEER'S COMMENTS.
5-1-10

DK
- 2

CHANGE ORDER 14
7-7-10

DK
- 3

ISSUED FOR COORDINATION
SIGN-OFF 11-30-09

DK
- 4

ISSUED FOR COORDINATION
SIGN-OFF 11-30-09

DK
- 5

ISSUED FOR COORDINATION
SIGN-OFF 11-30-09

DK
- 6

ISSUED FOR COORDINATION
SIGN-OFF 11-30-09

DK
- 7

ISSUED FOR COORDINATION
SIGN-OFF 11-30-09

DK
- 8

ISSUED FOR COORDINATION
SIGN-OFF 11-30-09

DK
- 9

ISSUED FOR COORDINATION
SIGN-OFF 11-30-09

DK
- 10

ISSUED FOR COORDINATION
SIGN-OFF 11-30-09

DK

REVISIONS	BY
1	DK
2	DK
3	DK
4	DK
5	DK
6	DK
7	DK
8	DK
9	DK
10	DK

COORD.	SIGNATURE	DATE
MECHANICAL		
ELECTRICAL		
PLUMBING		
STRUCTURAL		

REV.	SENT	ANS.	REV.	SENT	ANS.	REV.	SENT	ANS.
0314	08/14/09	10/13/09	0360	09/02/09	10/01/09	0376	09/02/09	10/13/09
0377	09/02/09	09/18/09	0379	09/02/09	10/26/09	0480	10/03/09	10/22/09
0510	10/08/09	10/15/09						

CHILDREN'S HOSPITAL
OF ORANGE COUNTY
455 S. IRLAND AVE.
ORANGE, CA 92668-3974

TOWER II
PLUMBING FLOOR PLAN - LEVEL 02 AREA H


PAN-PACIFIC
PLUMBING & MECHANICAL
2919 E. VICTORIA STREET, RANCHO DOMINGUEZ, CA 90221
PH. 310.637.1500 FAX 310.604.0359

company

PH

2919 E. VICTORIA STREET, RANCHO DOMINGUEZ, CA 90221
PH. 310.637.1500 FAX 310.604.0359

DRAWN
R.O.
CHECKED
M.M.
DATE
4/30/2012
SCALE
1/4" = 1'-0"
JOB NO.
09-006
DRAWING NUMBER
PL3.2H
REFERENCE DRAWING
A3.2H
P3.2H
1 OF 1 SHEETS

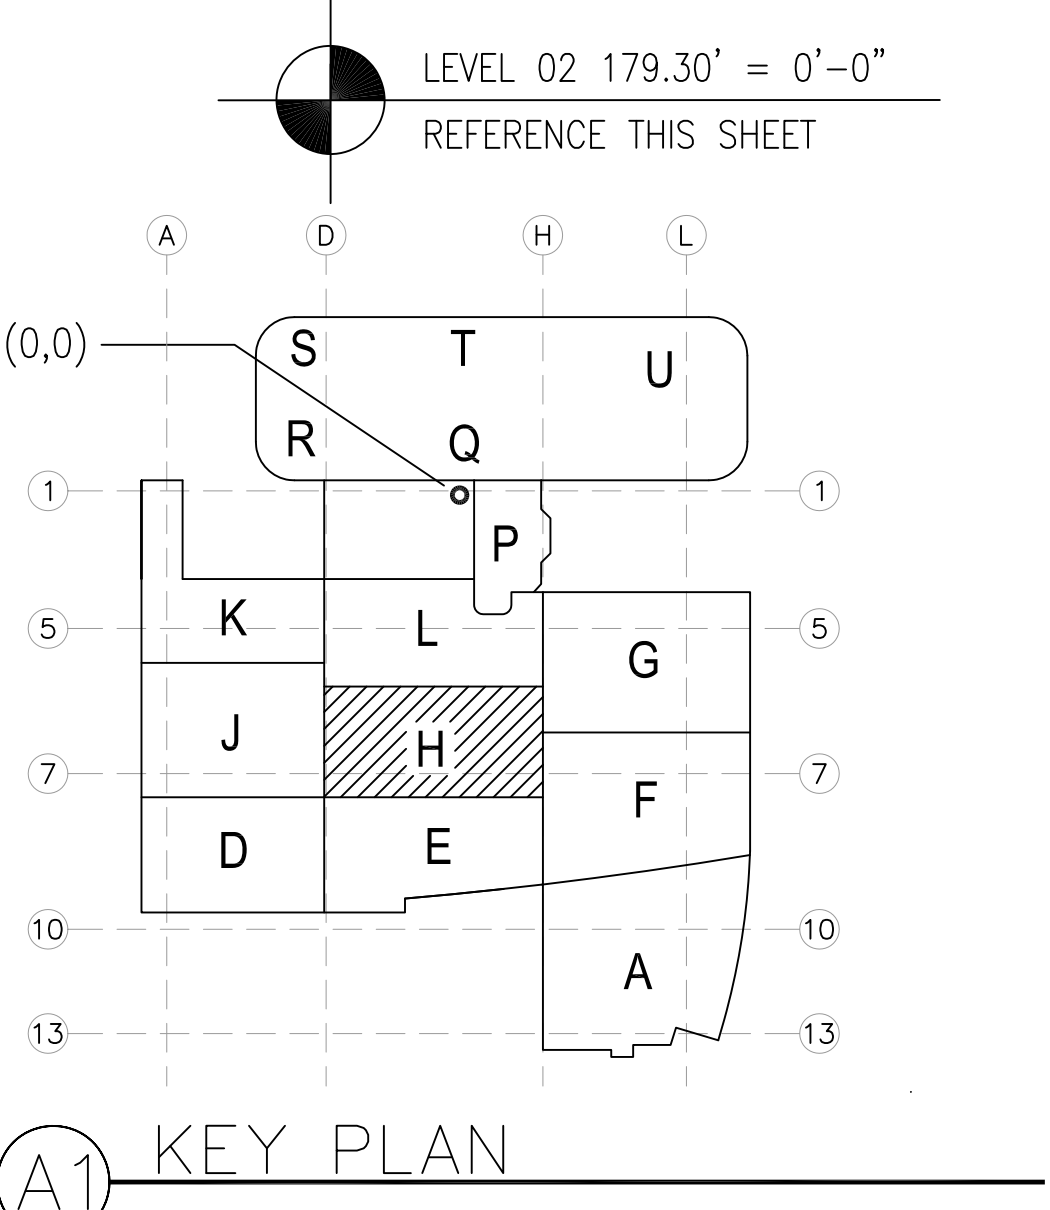

MCCARTHY APPROVAL

A. Approved as noted for Architectural Review

B. Review and Rebuild

C. Rejected


This review is for general conformance with Plans and Specifications only. Any deviations from same not clearly noted by the Engineer hereon are not reviewed. Review shall not constitute a guarantee of check of detail dimensions or count to serve to release the Engineer of contractual responsibility for any error or deviation from contract requirements.

McCarthy

By _____ Date _____
SHOP DRAWING REFERENCE NO. _____

Dwg File: 09-006-000-MCCARTHY APPROVAL-PL3.2H-A3.2H-P3.2H.dwg Plotted by: PPM/SSB 4/30/2012 1:30pm

This document and the design it covers are the property of Murray Co. They are loaned only with the borrower's expressed written agreement that they will not be reproduced, copied, loaned, or used in any way, except by written consent from Murray Co. to the borrower.

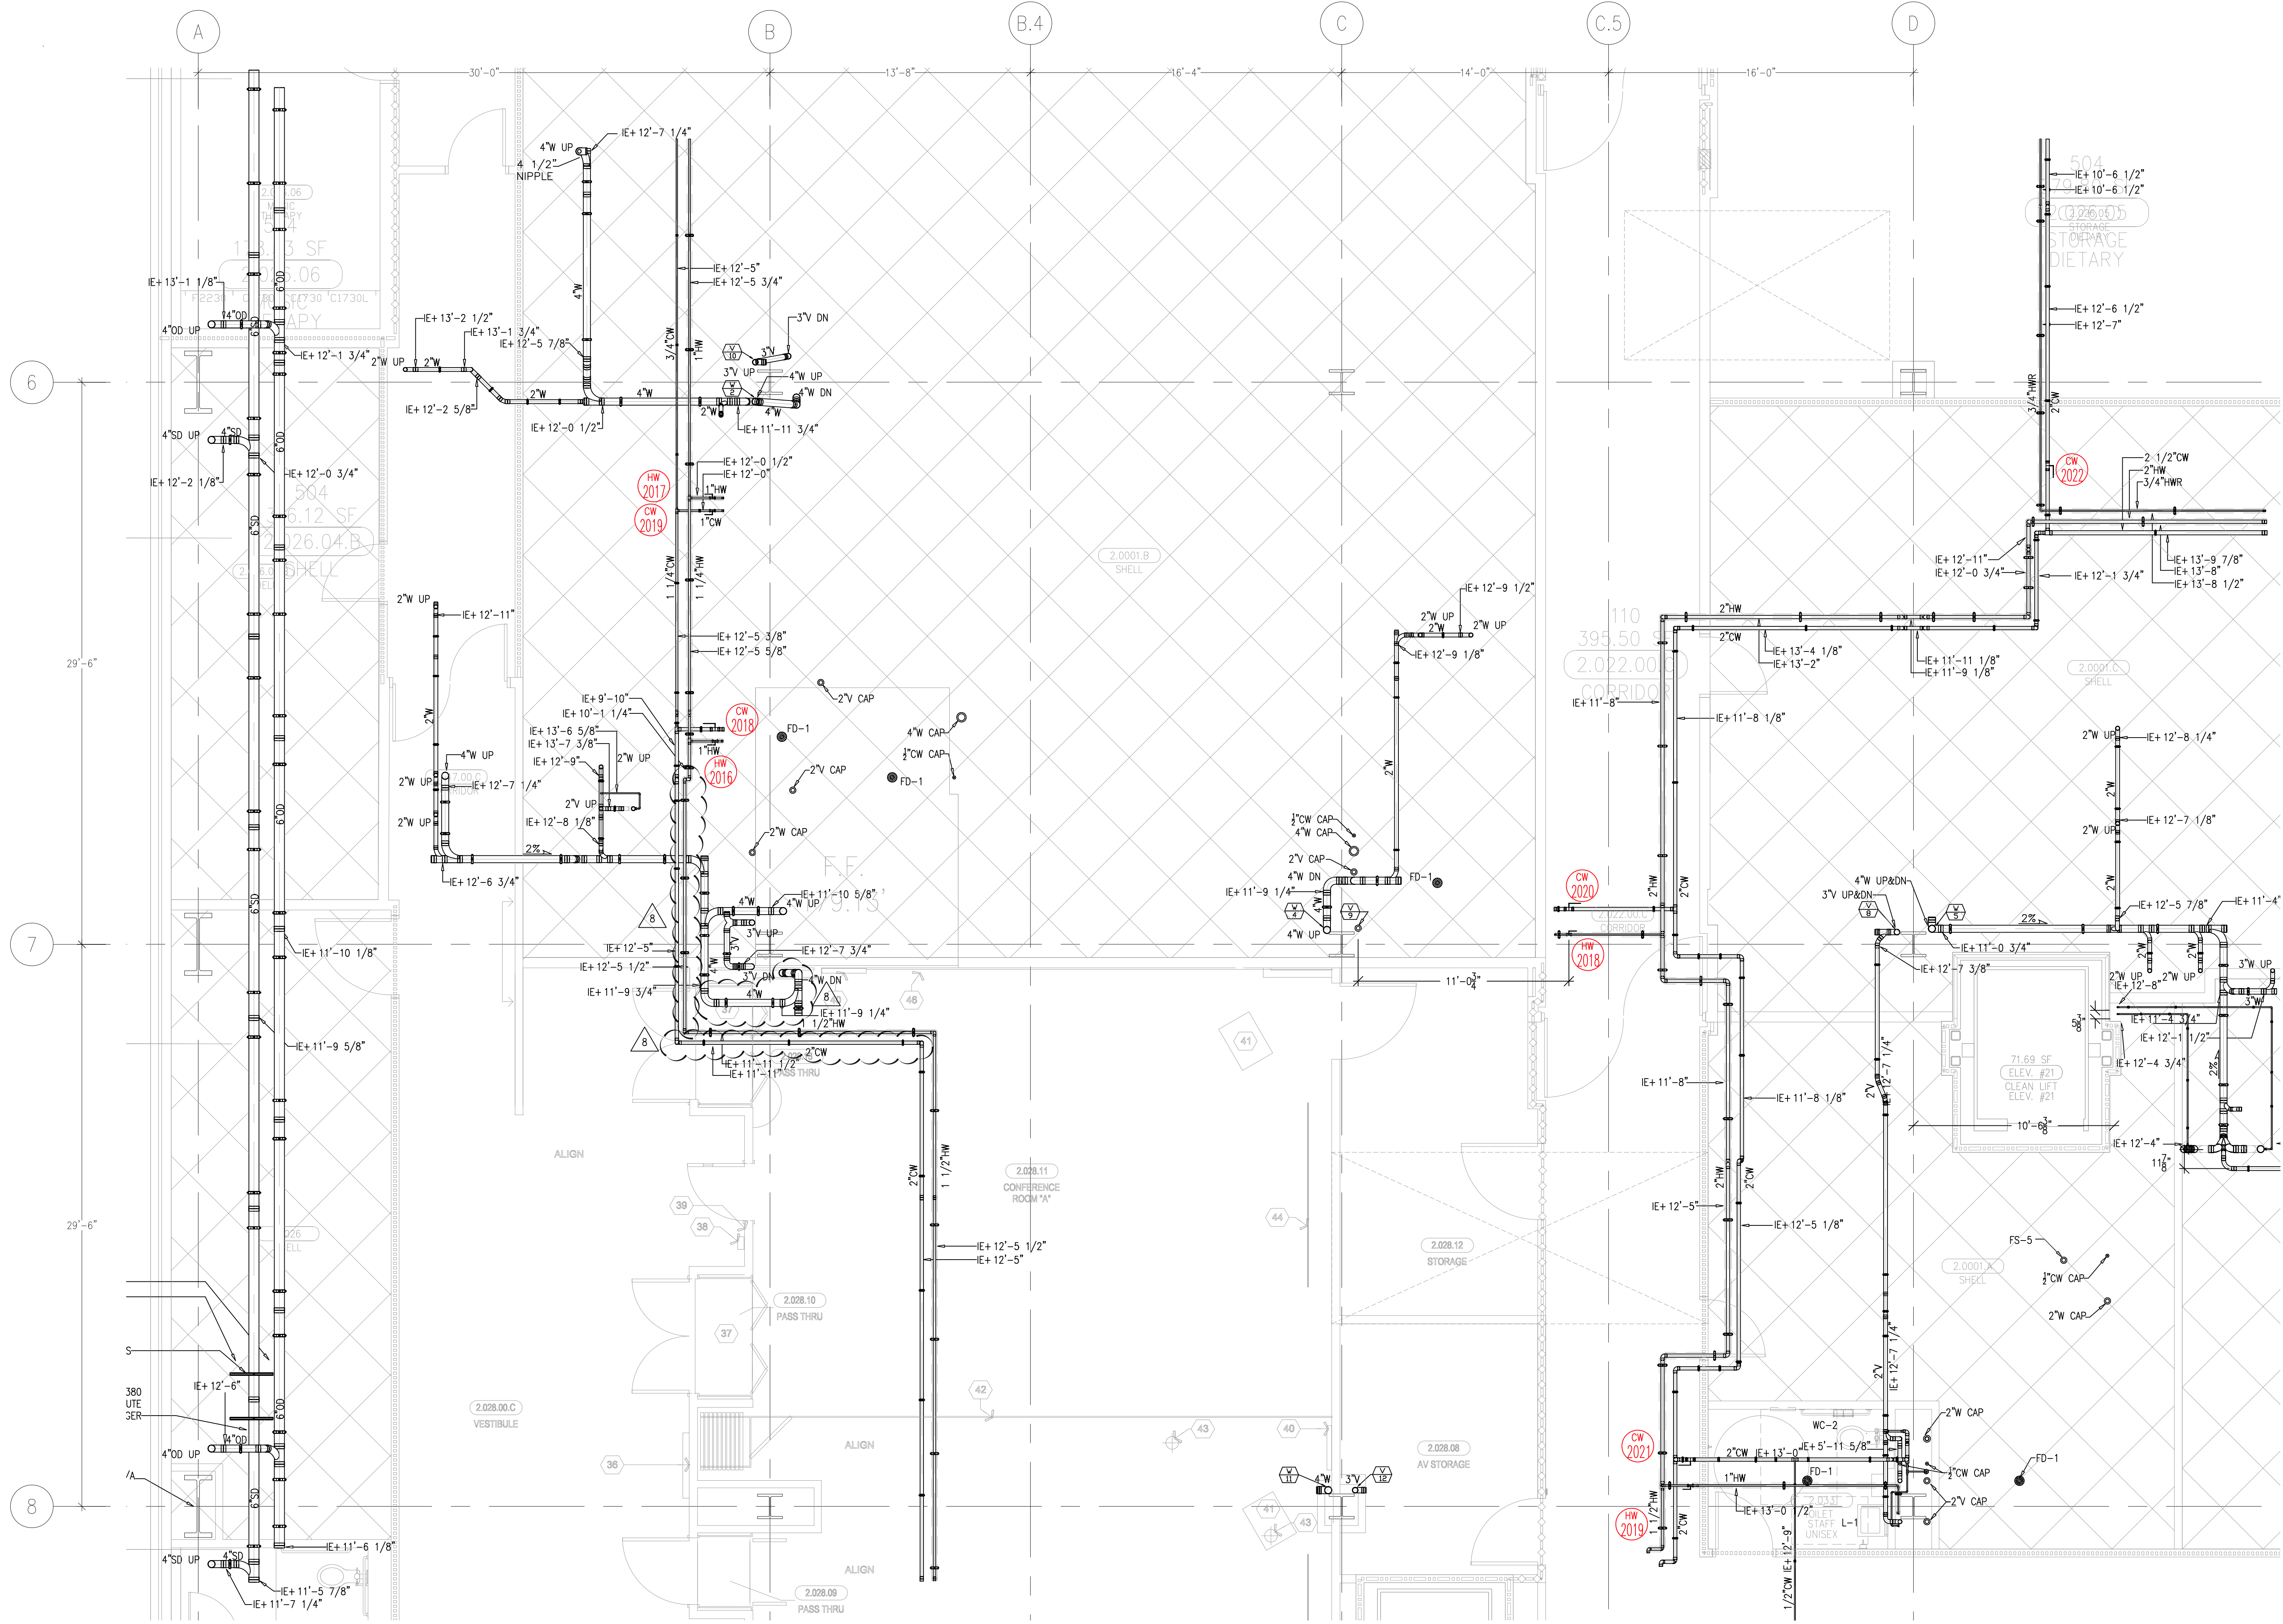

NOTE:

- ALL FD-1 TOP OF DRAIN TO BE SET -1/2" BELOW FINISHED FLOOR PER PPMC 0800
- PROVIDE ALL WASTE PIPING BELOW FLR & STUB OUT 4"WT W/ PLUG AND PROVIDE TRAP PRIMER PIPING BELOW FOR FUR DRW & STUB OUT 4"WT W/ CAP FOR FUTURE CONNECTION.

MCCARTHY APPROVAL


- A. Approved as noted for architectural Review
- B. Review and Revisit
- C. Rejected

This review is for general conformance with Plans and Specifications only. Any deviations from same not clearly noted by the Engineer have not been reviewed. Reviewer shall not constitute a complete check of detailed drawings or cover to same to release the Engineer of contractual responsibility for any error or deviation from contract requirements.

McCarthy

By: _____ On: _____
SHP: DRAWING REFERENCE NO. _____

LEVEL 02 179.30' = 0'-0"
REFERENCE THIS SHEET

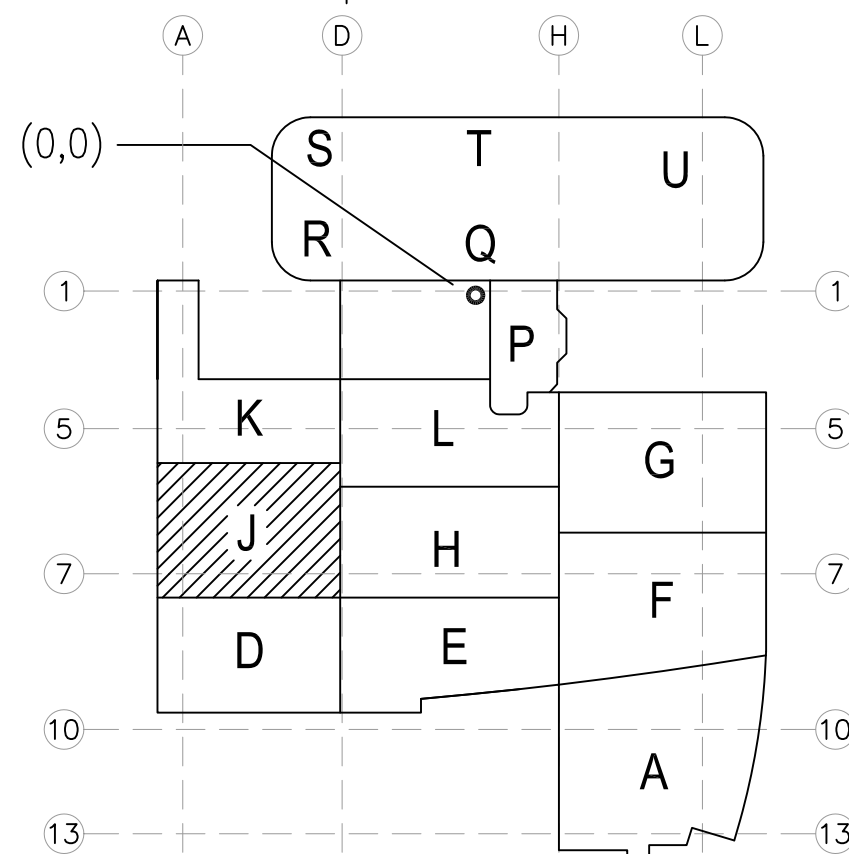

REVISIONS	BY
1. ADDED NOTE FOR FD-1 FOR CON R1 1270	REO
2. ADDED NOTE FOR FD-1 FOR CON R1 1270	REO
3. ADDED NOTE FOR FD-1 FOR CON R1 1270	REO
4. ADDED NOTE FOR FD-1 FOR CON R1 1270	REO
5. ADDED NOTE FOR FD-1 FOR CON R1 1270	REO
6. ADDED NOTE FOR FD-1 FOR CON R1 1270	REO
7. ADDED NOTE FOR FD-1 FOR CON R1 1270	REO
8. ADDED NOTE FOR FD-1 FOR CON R1 1270	REO

COORD.	SIGNATURE	DATE
MECHANICAL		
ELECTRICAL		
PLUMBING		
STRUCTURAL		

R.F.I.	SENT	ANS.	R.F.I.	SENT	ANS.
0146	05/22/09	07/11/09	0941	09/17/10	XX/XX/XX
0147	05/22/09	06/09/09			
0304	08/02/09	09/28/09			
0383	09/02/09	09/29/09			
0392	09/10/09	10/13/09			
0405	09/11/09	10/01/09			
0479	09/30/09	10/20/09			

CHILDREN'S HOSPITAL
OF ORANGE COUNTY
455 S. MAIN ST., SUITE 200
ORANGE, CA 92668-3974
TOWER II
PLUMBING FLOOR PLAN - LEVEL 02 AREA F

PAN-PACIFIC
PLUMBING & MECHANICAL
company
2919 E. VICTORIA STREET, RANCHO DOMINGUEZ, CA 90221
PH. 310 637-1500 FAX 310 604-0359

DRAWN
R.O.
CHECKED
M.M.
DATE
4/30/2012
SCALE
1/4" = 1'-0"
JOB NO.
09-006
DRAWING NUMBER
PL3.2J
REFERENCE DRAWING
A3.2J
P3.2J
1 OF 1 SHEETS

		REVISONS	BY
OK	1	ADDED NOTE FOR PD-1 PER CON RSI 1-270 PPMIC RSI 0800 5-4-10	REO
OK	2	REVISED TWE-3 PER CON RSI 1505 PPMIC RSI 0816 6-8-10	JT
OK	3	MOVED TO CONFORM TO FIELD INSTALLATION 7-2-10	DK
OK	4	ADJUSTED GASE ON PIPE 9-29-10	DK
OK	5	ADDED ELEVATIONS 9-30-10	DK
OK	6	REVISED H&COW FOR SHELL SPACE 10-21-10	DK
OK	7	REVISED GAS FOR TWO SOLENOID VALVES 01-12-11	DK
OK	8	ADDED MISSING HW CONNECTION 01-27-11	
OK	9	COY 134 SIGN OFF 10-07-11	

COORD.	SIGNATURE	DATE
McCarthy		
MECHANICAL DUCT		
MECHANICAL PIPE		
PLUMBING		
ELECTRICAL		
FIRE SPRINKLER		
PIPE		
DRYWALL/FRAMER		
REFRIGERATION		
STRUCTURAL		

	R.F.I.	SENT	ANS.	R.F.I.	SENT	ANS.	R.F.I.	SENT	ANS.
0178	06/19/09	06/19/09	0278	07/25/09	06/14/09	0398	09/10/09	10/02/09	
0179	06/10/09	10/09/09	0279	07/25/09	08/12/09	0399	09/10/09	10/13/09	
0228	07/02/09	08/28/09	0380	07/25/09	10/10/09	0516	10/12/09	10/30/09	
0320	07/02/09	08/26/09	0381	07/25/09	09/22/09	0244	12/01/09	12/22/09	
0685	07/18/09	07/31/09	0387	07/25/09	08/31/09	CON3432-0	12/24/09	01/06/10	
0724	07/24/09	09/13/09	0387	08/07/09	07/15/09	0844	08/17/10	XX/XX/XX	
0726	07/24/09	08/18/09	0390	09/05/09	10/03/09	0845	08/17/10	09/23/10	

MCCARTHY APPROVAL	
A. Agreement as noted for Architectural Review	☐
B. Review and Revisit	☐
C. Rejected	☐


This review is for general conformance with Plans and Specifications *only*. Any deviations from name not clearly noted by the Preparer have not been reviewed. Review should not constitute a complete check of detailed dimensions or count to serve to release the Preparer of contractual responsibility for any error or deviation from contract requirements.

McCarthy

By _____, Date _____

SHIP DRAWING REFERENCE NO. _____

LEVEL 02 179.30' = 0'-0"
REFERENCE THIS SHEET

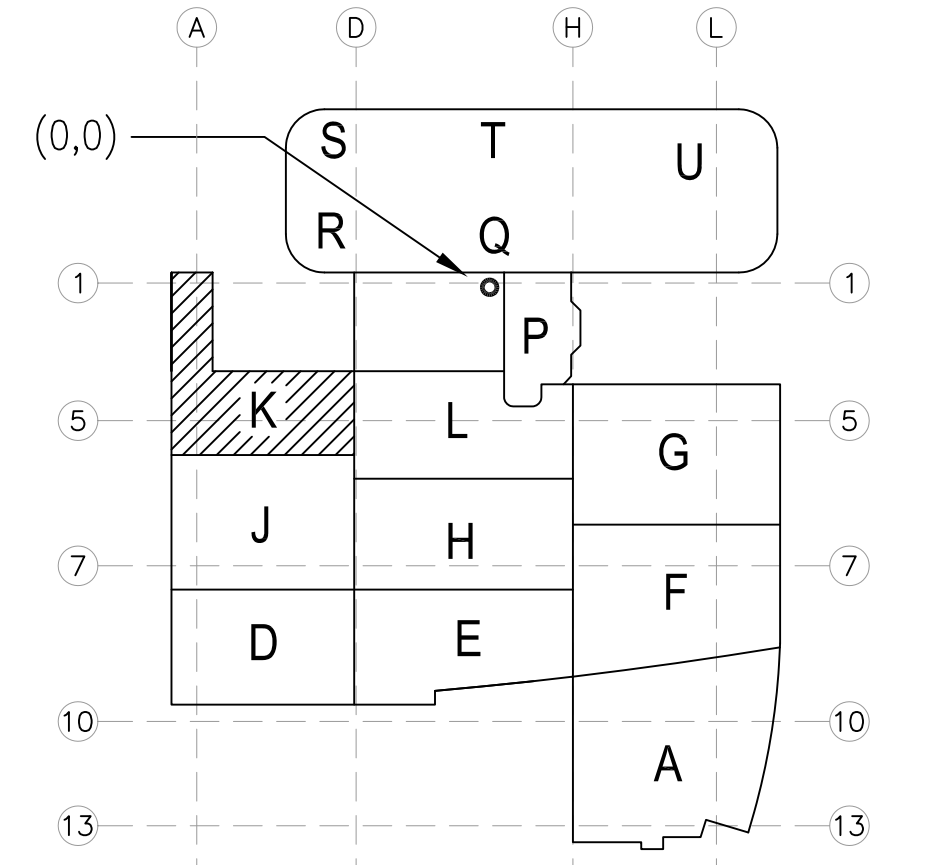


A1 KEY PLAN

CHILDREN'S HOSPITAL
OF ORANGE COUNTY
465 S. Main St.
Orange, CA 92665-3874
TOWER II
PLUMBING FLOOR PLAN - LEVEL 02 AREA-K

Printed by 895128 4-30-2012 1:56pm

DRAWN	R.O.
CHECKED	
M.M.	
DATE	4/30/2012
SCALE	1/4" = 1' - 0"
JOB NO.	09-006
DRAWING NUMBER	PL3.2K
REFERENCE DRAWING	A3.2K P3.2K
1	OF 1 SHEETS

This document and the design it covers are the property of Murray Co. They are loaned only with the borrower's expressed agreement that they will not be reproduced, copied, loaned, exhibited, or used in any other way, except by written consent from Murray Co. to the borrower.

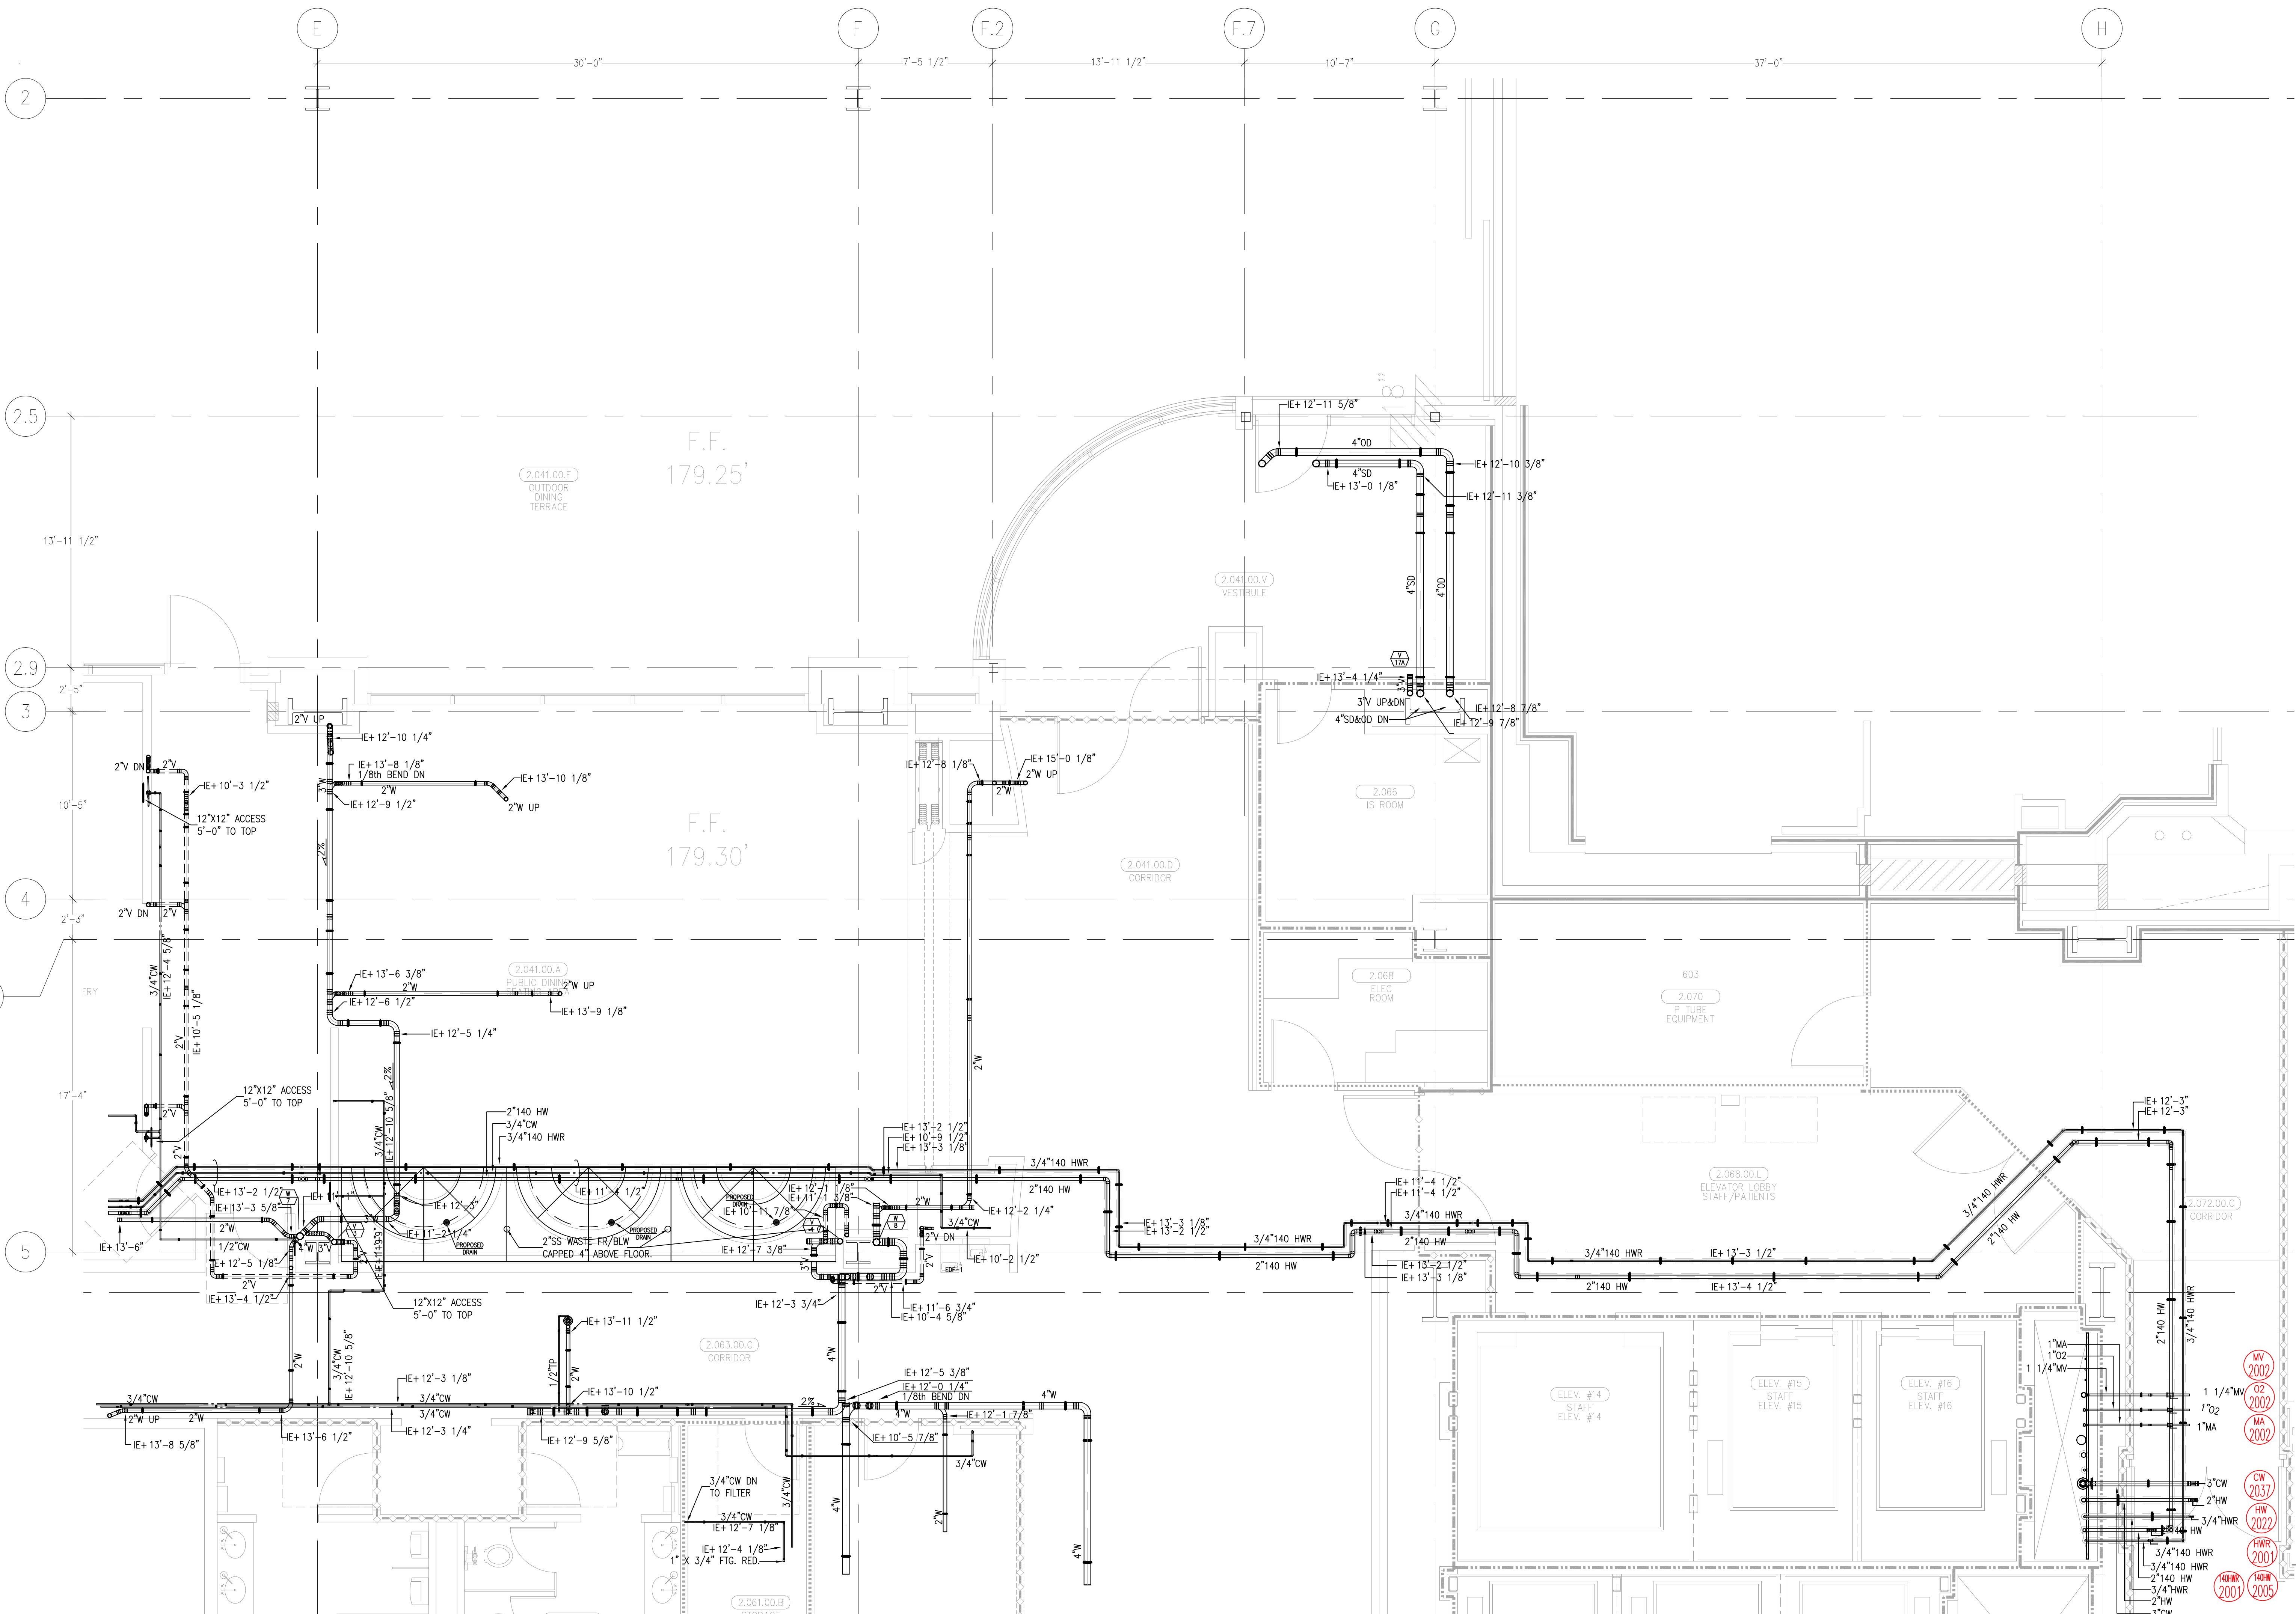

LEVEL 02 179.30' = 0'-0"
REFERENCE THIS SHEET

MCCARTHY APPROVAL	
A. Approved as noted for Architectural Review B. Review and Resubmit: C. Rejected	☐ ☐ ☐
This review is for general conformance with Plans and Specifications only. Any deviations from same not clearly noted by the Preparer have not been reviewed. Review shall not contribute a complete check of detailed dimensions or count to serve to relieve the Preparer of contractual responsibility for any error or deviation from contract requirements.	
McCarthy	
By: _____ Date _____ SHIP DRAWING REFERENCE NO. _____	

	REVISIONS	BY
A	ISSUED FOR COORDINATION SIGN OFF 11-30-09	DK
B	ISSUED FOR OSHPO PERMIT RE-COORDINATION SIGN OFF 2-10-10	DK
0	ISSUED FOR CONSTRUCTION 04-28-10	DK
1	REVISED WASTE SLOPE PER ENGINEERS REQUEST 6-03-2010	JT
2	REVISED WATER STUB-OUT TO ICE MAKER 1-14-11	DK
3	ADDED DRAIN CONNECTIONS FOR BUBBLE WALLS 4-29-11	DK
4	COV 134 SIGN OFF 10-07-11	DK

COORD.	SIGNATURE	DATE
McARTHUR		
MECHANICAL DUCT		
MECHANICAL PIPE		
PLUMBING		
ELECTRICAL		
FIRE SPRINKLER		
PIPE		
DRYWALL/FRAMER		
REFRIGERATION		
STRUCTURAL		


R.F.I.	SENT	ANS.	R.F.I.	SENT	ANS.	R.F.I.	SENT	ANS.
0177	06/09/09	06/15/09	0944	06/19/10	08/26/10			
0292	06/05/09	09/01/09						
0342	06/28/09	09/09/09						
0368	09/03/09	10/01/09						
0379	09/05/09	10/26/09						
0753	03/16/10	03/24/10						
0923	06/05/10	XX/XX/XX						

CHILDREN'S HOSPITAL
OF ORANGE COUNTY
455 S. Main St.
Orange, CA 92668-3874
TOWER II
PLUMBING FLOOR PLAN - LEVEL 02 AREA-L

IPMC
PAN-PACIFIC
PLUMBING & MECHANICAL
Murray Company
3919 E. VICTORIA STREET, RANCHO DOMINGUEZ, CA 90221

DRAWN R.O.
CHECKED
M.M.
DATE 4/30/2012
SCALE 1/4" = 1'-0"
JOB NO. 09-006
DRAWING NUMBER PL3.2L
REFERENCE DRAWING A3.2L P3.2L
1 of 1 SHEETS

document and the design it covers are the property of Murray Co. They are loaned only with the borrower's expressed written agreement that they will not be reproduced, copied, loaned, exhibited, or used in any other way, except by written consent from Murray Co. to the borrower.

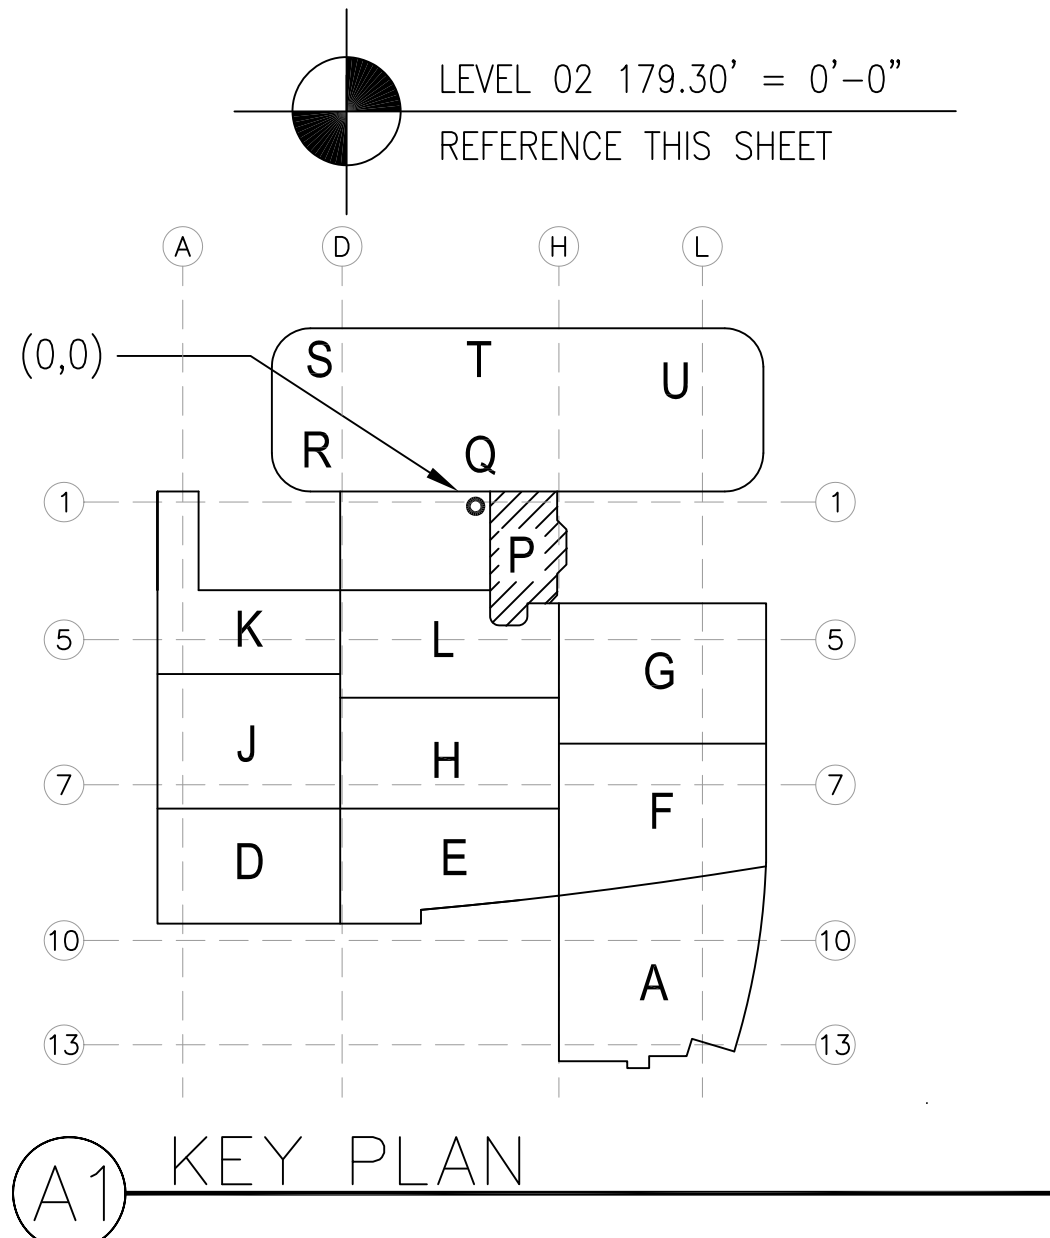

	REVISIONS	BY
A	ISSUED FOR COORDINATION SIGN-OFF 11-30-09	DK
B	FGMP REVISION 02-11-10	DK
C	ISSUED FOR OSHFO PERMIT RE-COORDINATION SIGN OFF 3-10-10	DK
O	ISSUED FOR CONSTRUCTION 04-28-10	DK
1	CD# 134 SIGN OFF 10-07-11	DK

COORD.	SIGNATURE	DATE
MCARTHY		
MECHANICAL DUCT		
MECHANICAL PIPE		
PLUMBING		
ELECTRICAL		
FIRE SPRINKLER		
PTUBE		
DRYWALL / FORMER		
REFRIGERATION		
STRUCTURAL		

[illegible]

CHILDREN'S HOSPITAL
OF ORANGE COUNTY
455 S. Main St.
Orange, CA 92668-3874
TOWER II
PLUMBING FLOOR PLAN - LEVEL 02 AREA-P

PMI
PAN-PACIFIC
PLUMBING & MECHANICAL

Murray Company

2919 E. VICTORIA STREET, RANCHO DOMINGUEZ, CA 90221
PH. 310 637-1500 FAX. 310 604-0359

DRAWN R.O.
CHECKED
M.M.
DATE
4/30/2012
SCALE
1/4" = 1'-0"
JOB NO.
09-006
DRAWING NUMBER
PL3.2P
REFERENCE DRAWING
A3.2P
P3.2P
1 OF 1 SHEETS