
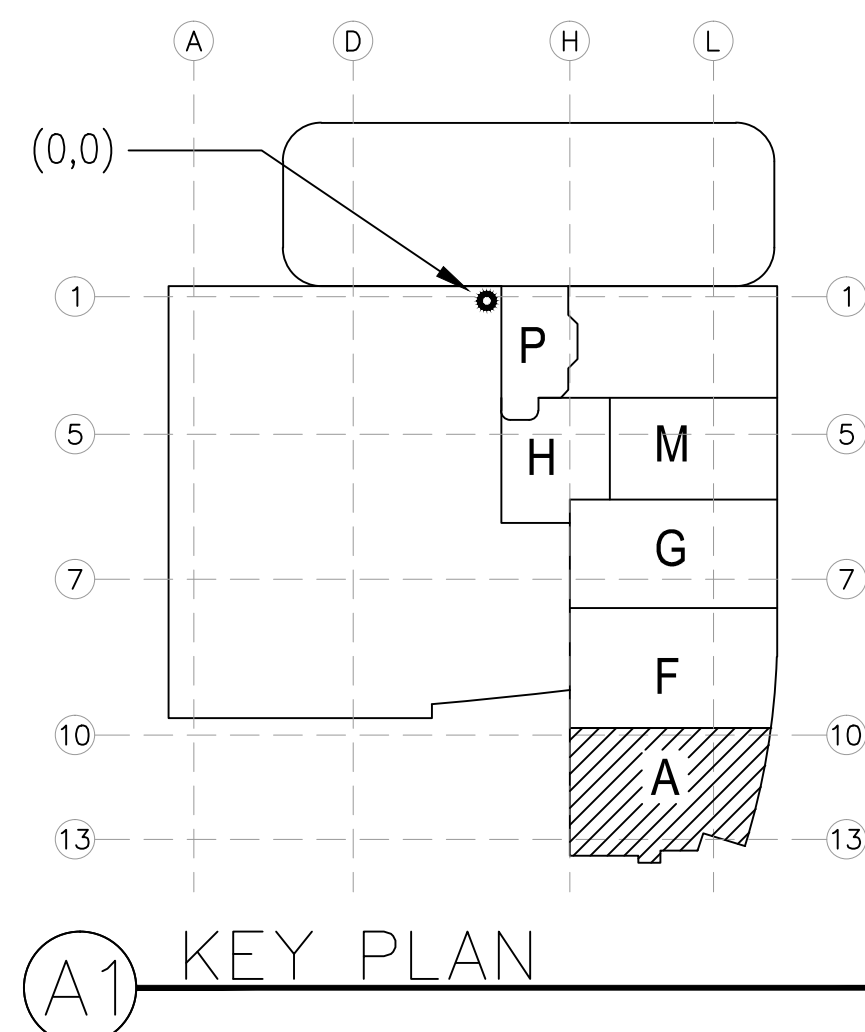
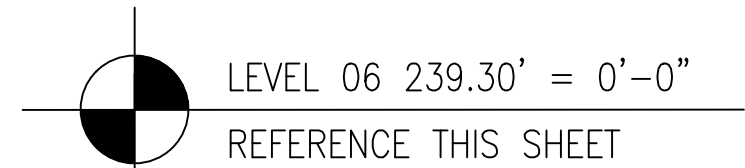


document and the design it covers are the property of Murray Co. They are loaned only with the borrower's expressed written agreement that they will not be reproduced, copied, loaned, exhibited, or used in any other way, except by written consent from Murray Co. to the borrower.

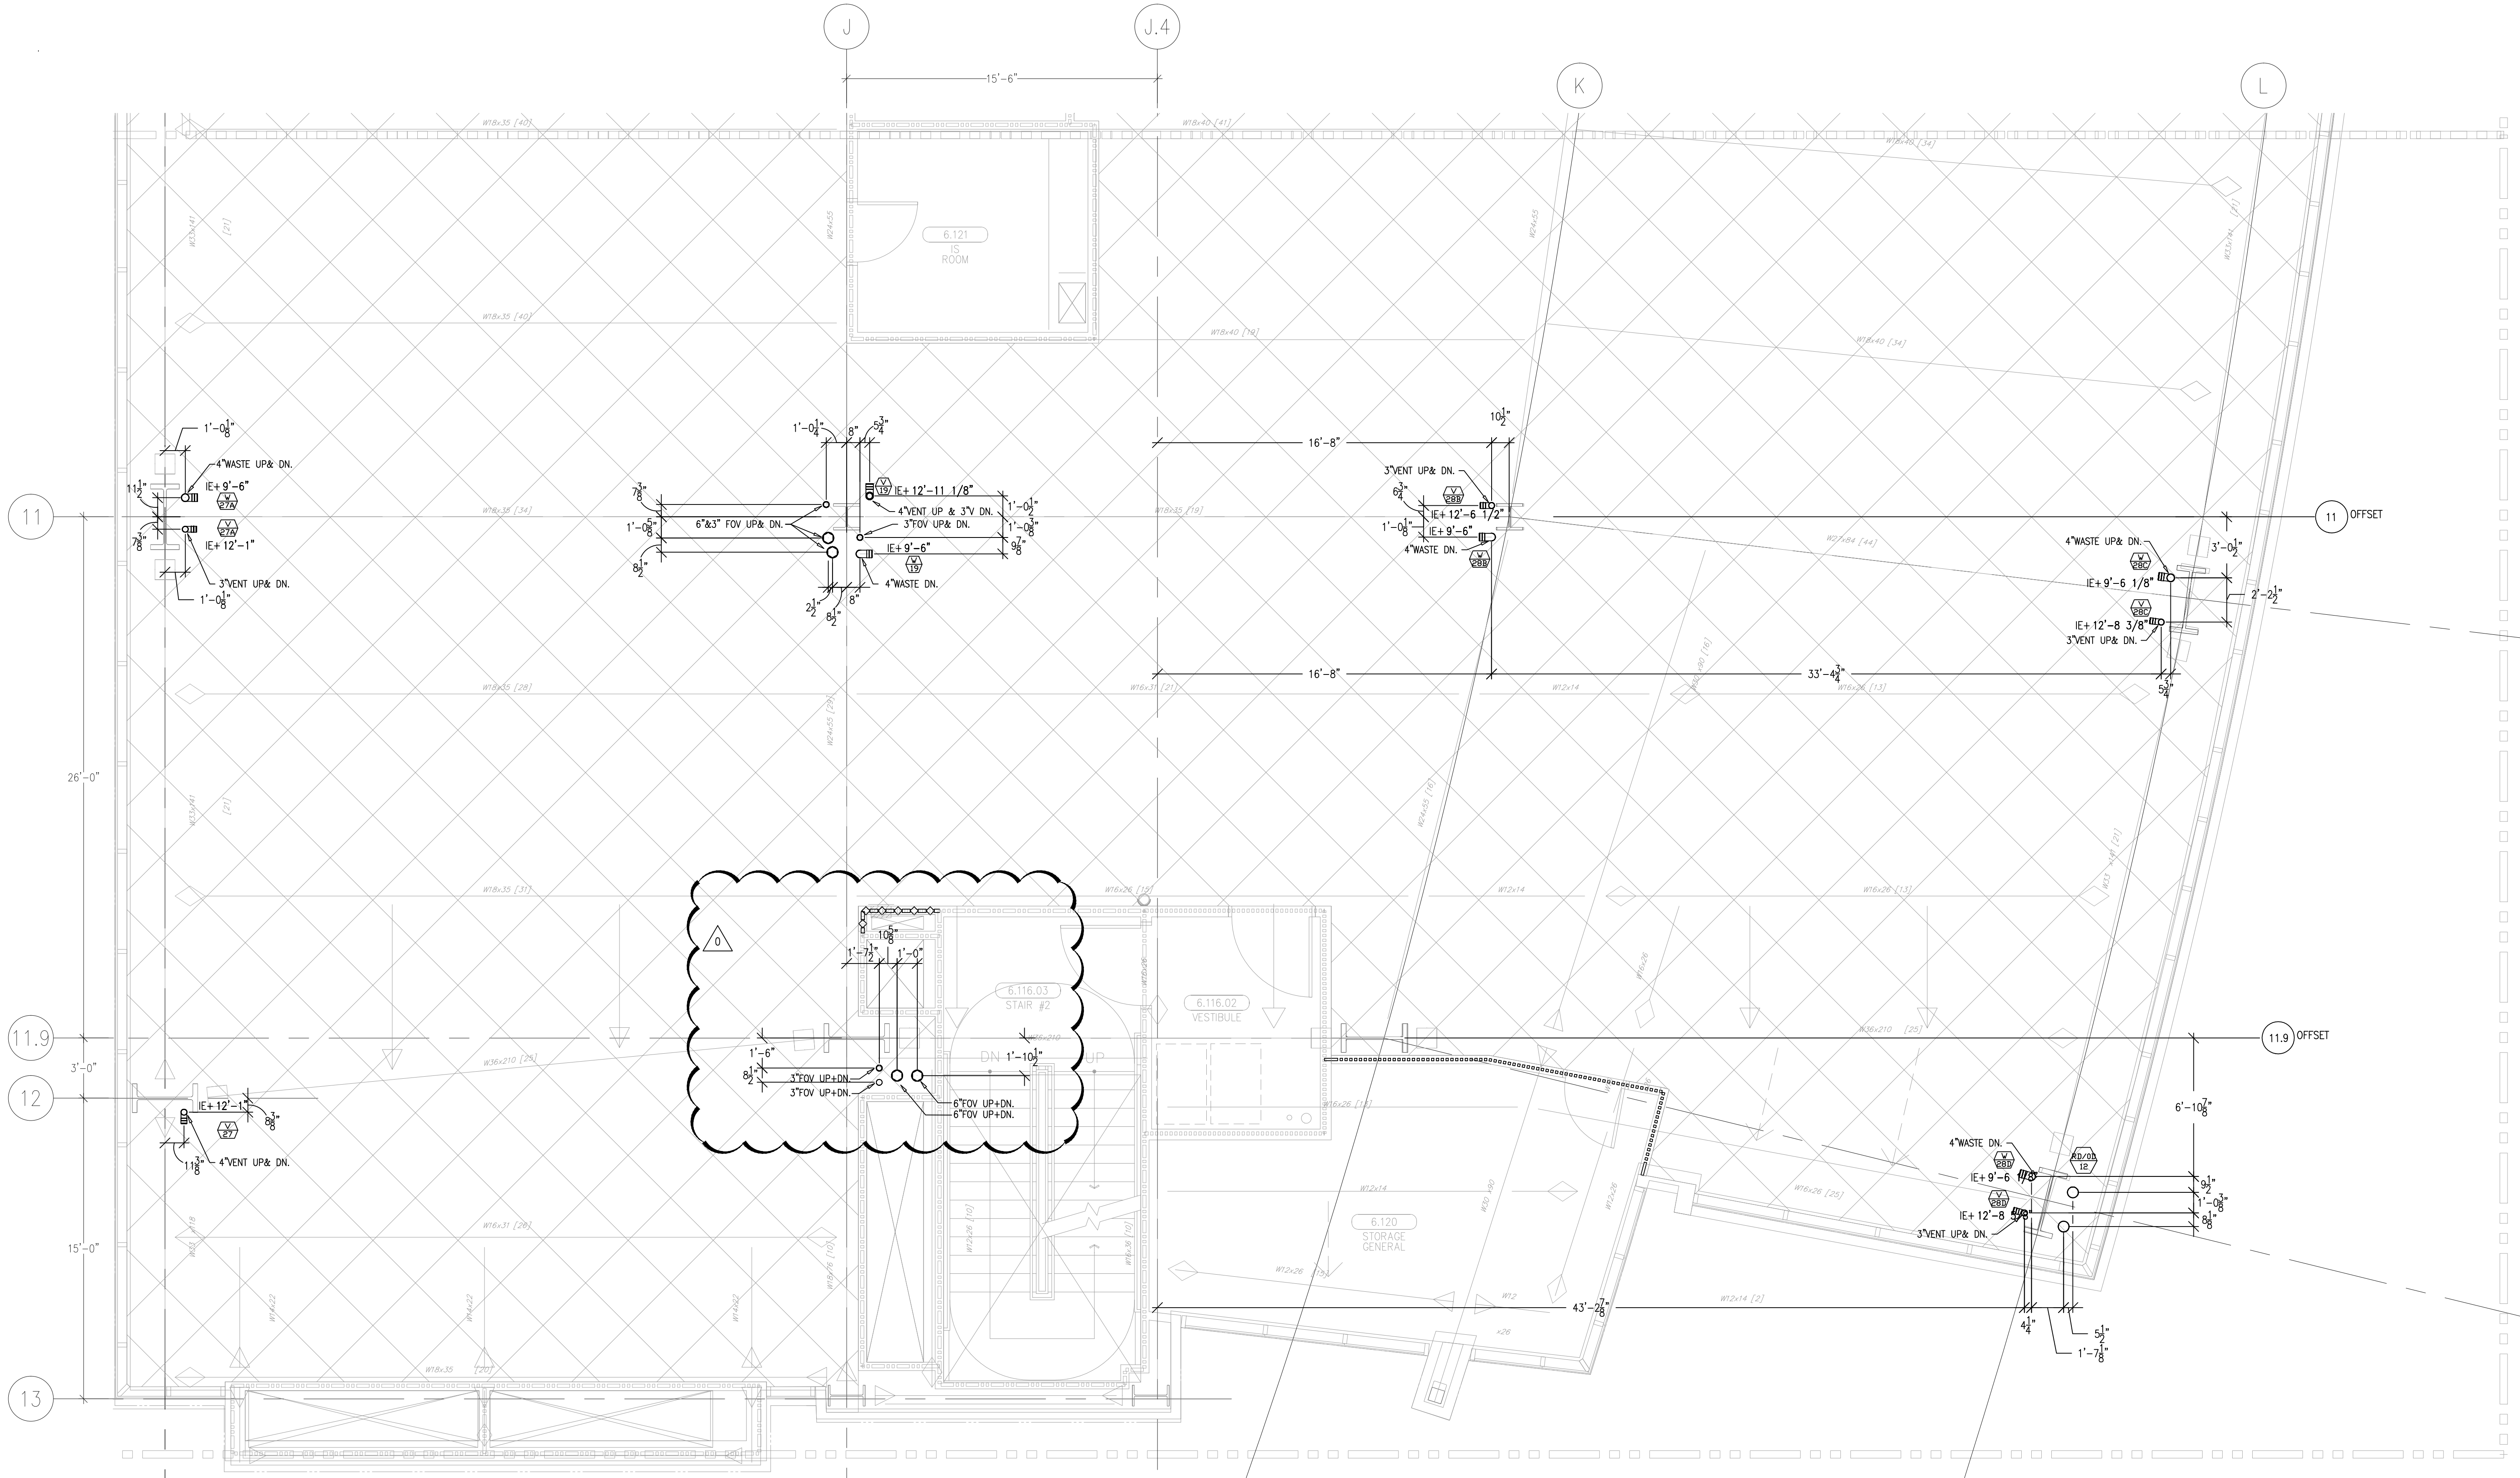

MCCARTHY APPROVAL	
A. Approved as noted for Architectural Review	<input type="checkbox"/>
B. Review and Resubmit	<input type="checkbox"/>
C. Rejected	<input type="checkbox"/>

This review is for general conformance with Plans and Specifications only. Any deviations from same not clearly noted by the Preparer have not been reviewed. Review shall not constitute a complete check of detailed dimensions or count to serve to relieve the Preparer of contractual responsibility for any error or deviation from contract requirements.

## McCarthy

By \_\_\_\_\_ Date \_\_\_\_\_  
 SHOP DRAWING REFERENCE NO. \_\_\_\_\_

[illegible]

COORD.	SIGNATURE	DATE
MCCARTHY		
MECHANICAL DUCT		
MECHANICAL PIPE		
PLUMBING		
ELECTRICAL		
FIRE SPRINKLER		
PIUPE		
DRYWALL / FRAMER		
REFRIGERATION		
STRUCTURAL		

[illegible]

**CHILDREN'S HOSPITAL  
CHOC™ OF ORANGE COUNTY  
HOSPITAL**  
465 S. Main St.  
Orange, CA 92668-3874

**TOWER II**

**PLUMBING FLOOR PLAN - LEVEL 06 AREA-A**

**PAN-PACIFIC**  
PLUMBING & MECHANICAL


**PAN-PACIFIC**  
PLUMBING & MECHANICAL

**Murray**  
Company

2919 E. VICTORIA STREET, RANCHO DOMINGUEZ, CA 90221  
PH. 310 637-1500 FAX 310 604-0359

DRAWN
R.O.
CHECKED
M.M.
DATE
10/10/2011
SCALE
1/4"=1'-0"
JOB NO.
09-006
DRAWING NUMBER
PL3.6A
REFERENCE DRAWING
A3.6A
P3.6A
1 OF 1 SHEETS


document and the design it covers are the property of Murray Co. They are loaned only with the borrower's expressed written agreement that they will not be reproduced, copied, loaned, exhibited, or used in any other way, except by written consent from Murray Co. to the borrower.

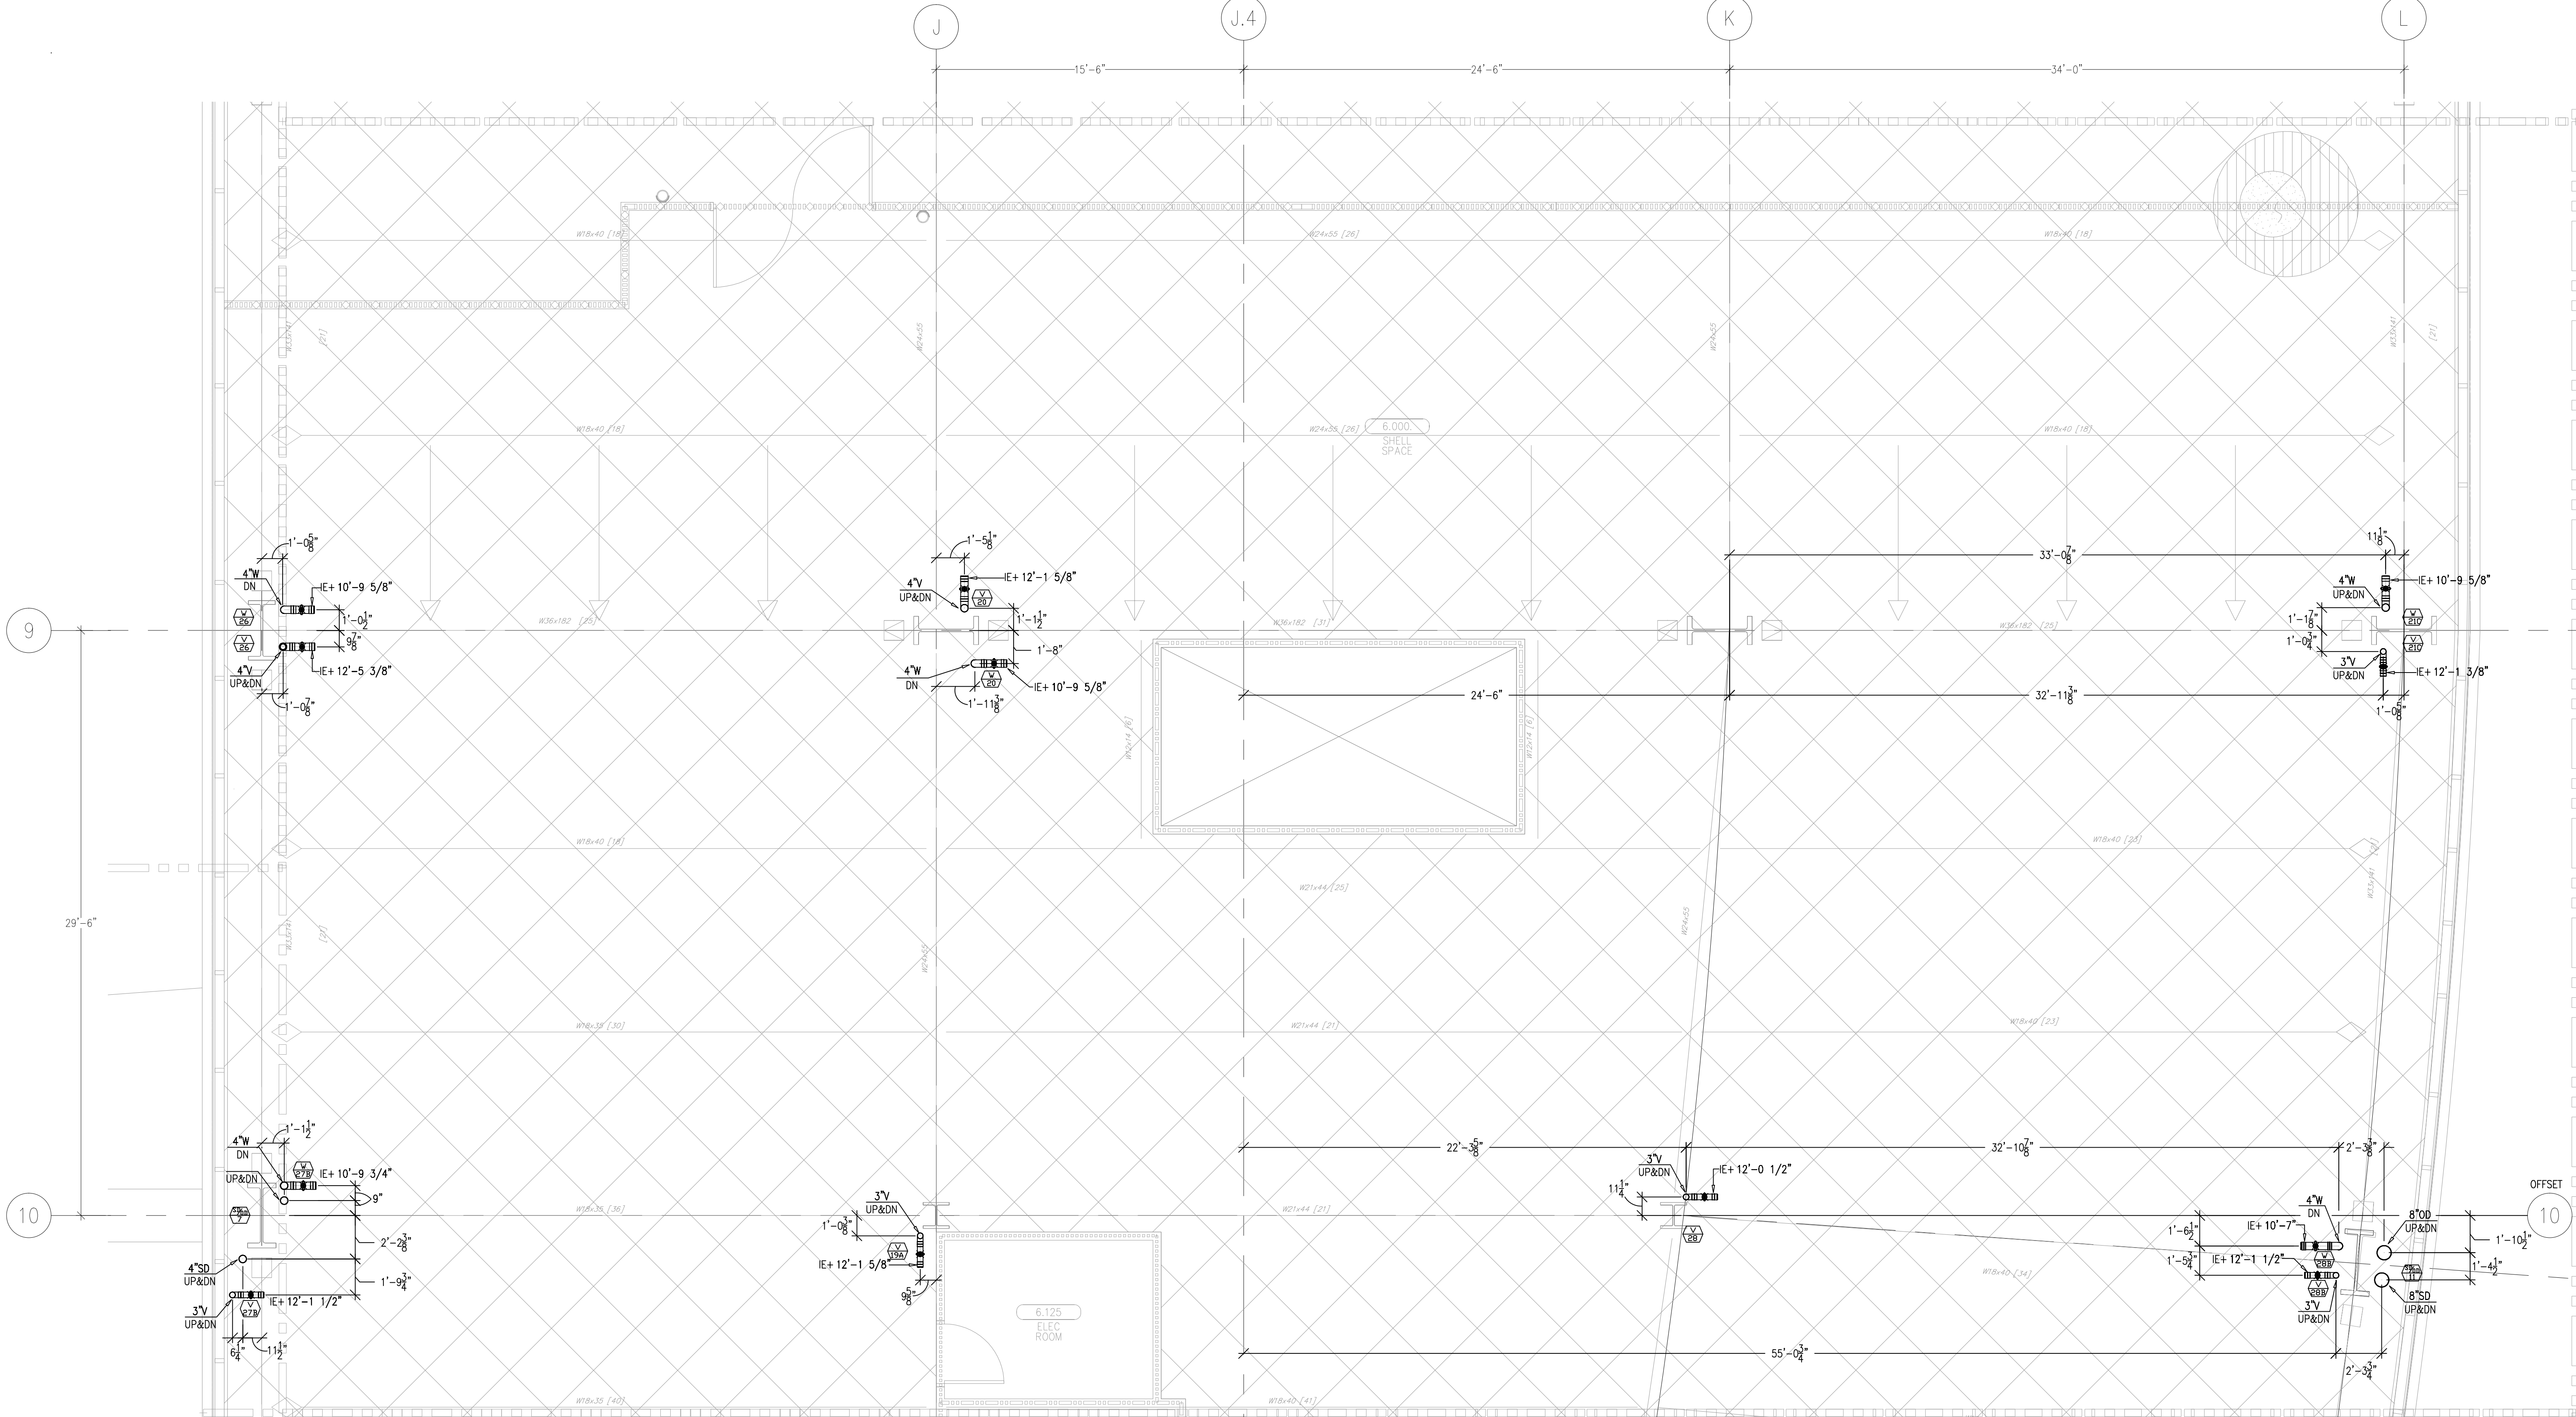

LEVEL 06 239.30' = 0'-0"

---

REFERENCE THIS SHEET

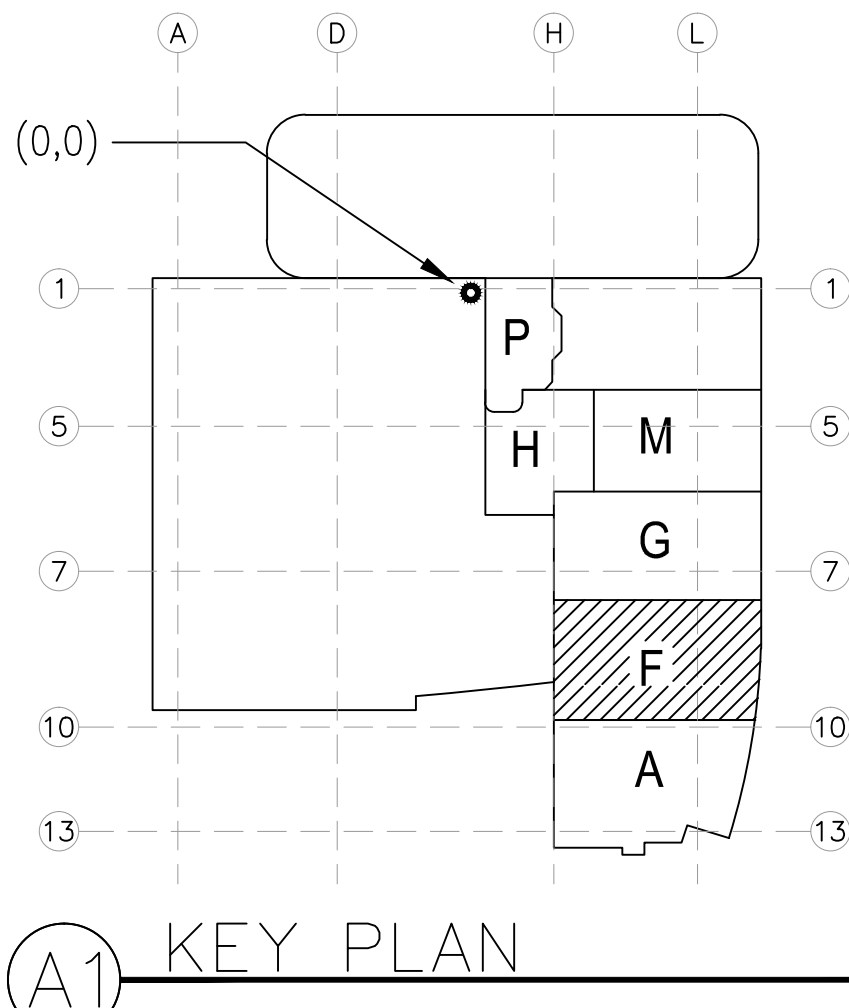

<h1 style="text-align: center;">MC CARTHY APPROVAL</h1>	
A. Approved as noted for Architectural Review	<input type="checkbox"/>
B. Review and Re-submit	<input type="checkbox"/>
C. Rejected	<input type="checkbox"/>
<p>This review is for general conformance with Plans and Specifications only. Any deviations from same not clearly noted by the Preparer have not been reviewed. Review shall not constitute a complete check of detailed dimensions or count to serve to relieve the Preparer of contractual responsibility for any error or deviation from contract requirements.</p> <h2 style="text-align: center;">McCarthy</h2> <p>By _____ Date _____</p> <p>EXHIBIT, DRAWING, REFERENCE NO. _____</p>	

[illegible]

MONTHLY		
MECHANICAL DUCT		
MECHANICAL PIPE		
PLUMBING		
ELECTRICAL		
FIRE SPRINKLER		
PIPE		
RYWALL/FRAMER		
REFRIGERATION		
CONCRETE		

[illegible]

**CHOC**<sup>®</sup> HOSPITAL  
CHILDREN'S HOSPITAL  
OF ORANGE COUNTY  
455 S. Main St.  
Orange, CA 92668-3874  
**TOWER II**  
PLUMBING FLOOR PLAN - LEVEL 06 AREA-F

**CPM**  
**PAN-PACIFIC**  
PLUMBING & MECHANICAL  
 **Murray**  
**Company**  
2919 E. VICTORIA STREET, RANCHO DOMINGUEZ, CA 90221

DRAWN  
R.O.  
CHECKED  
M.M.  
DATE  
10/10/2011  
SCALE  
1/4"=1'-0"  
JOB NO.  
09-006  
DRAWING NUMBER  
PL3.6F  
REFERENCE DRAWING  
A3.6F  
P3.6F  
1 OF 1 SHEETS

[illegible][illegible]

COORD.	SIGNATURE	DATE
McARTHUR		
MECHANICAL DUCT		
MECHANICAL PIPE		
PLUMBING		
ELECTRICAL		
FIRE SPRINKLER PIPE		
DRYWALL/FRAMER		
REFRIGERATION		
STRUCTURAL		

[illegible]

**CHOC<sup>™</sup> HOSPITAL**  
**CHILDREN'S HOSPITAL**  
**OF ORANGE COUNTY**  
 455 S. Main St.  
 Orange, CA 92668-3874  
**TOWER II**  
 PLUMBING FLOOR PLAN - LEVEL 06 AREA-G

**PAN-PACIFIC**  
PLUMBING & MECHANICAL

**PAN-PACIFIC**




**Murray Company**

2919 E. VICTORIA STREET, RANCHO DOMINGUEZ, CA 90221  
PH. 310 637-1500 FAX 310 604-0359

DRAWN R.O.
CHECKED
M.M.
DATE 10/10/2011
SCALE 1/4" = 1' - 0"
JOB NO. 09-006
DRAWING NUMBER PL3.6G
REFERENCE DRAWING A3.6G P3.6G
1 OF 1 SHEETS



This document and the design it covers are the property of Murray Co. They are loaned only with the borrower's expressed written agreement that they will not be reproduced, copied, loaned, exhibited, or used in any other way, except by written consent from Murray Co. to the borrower.

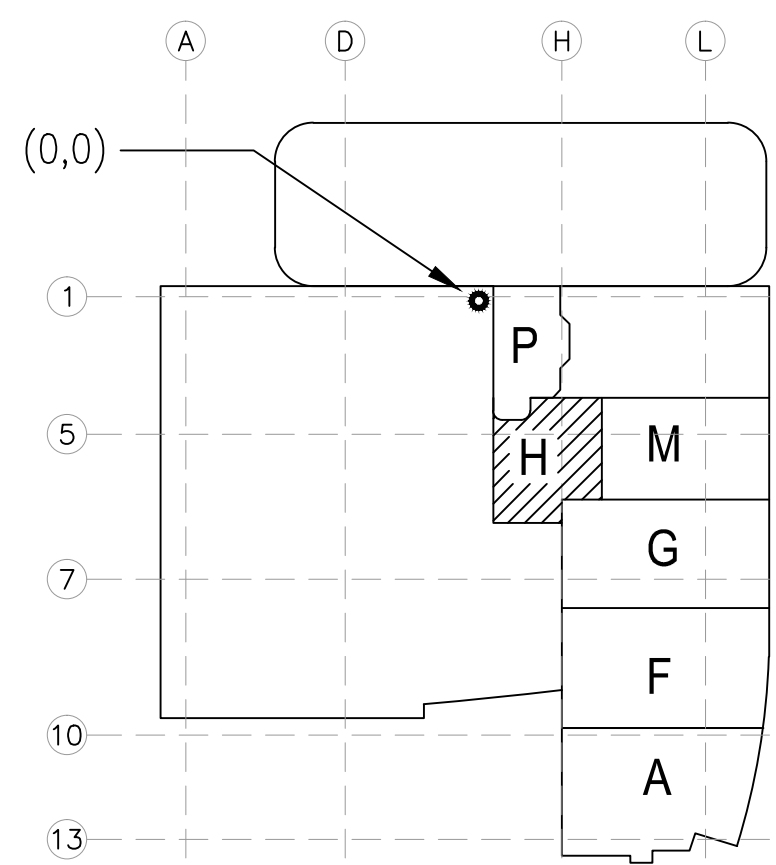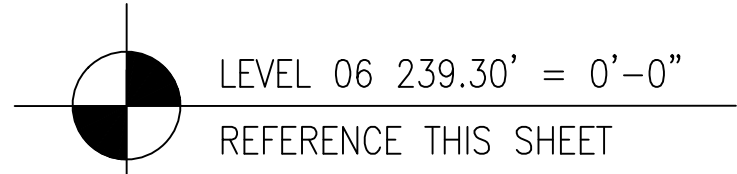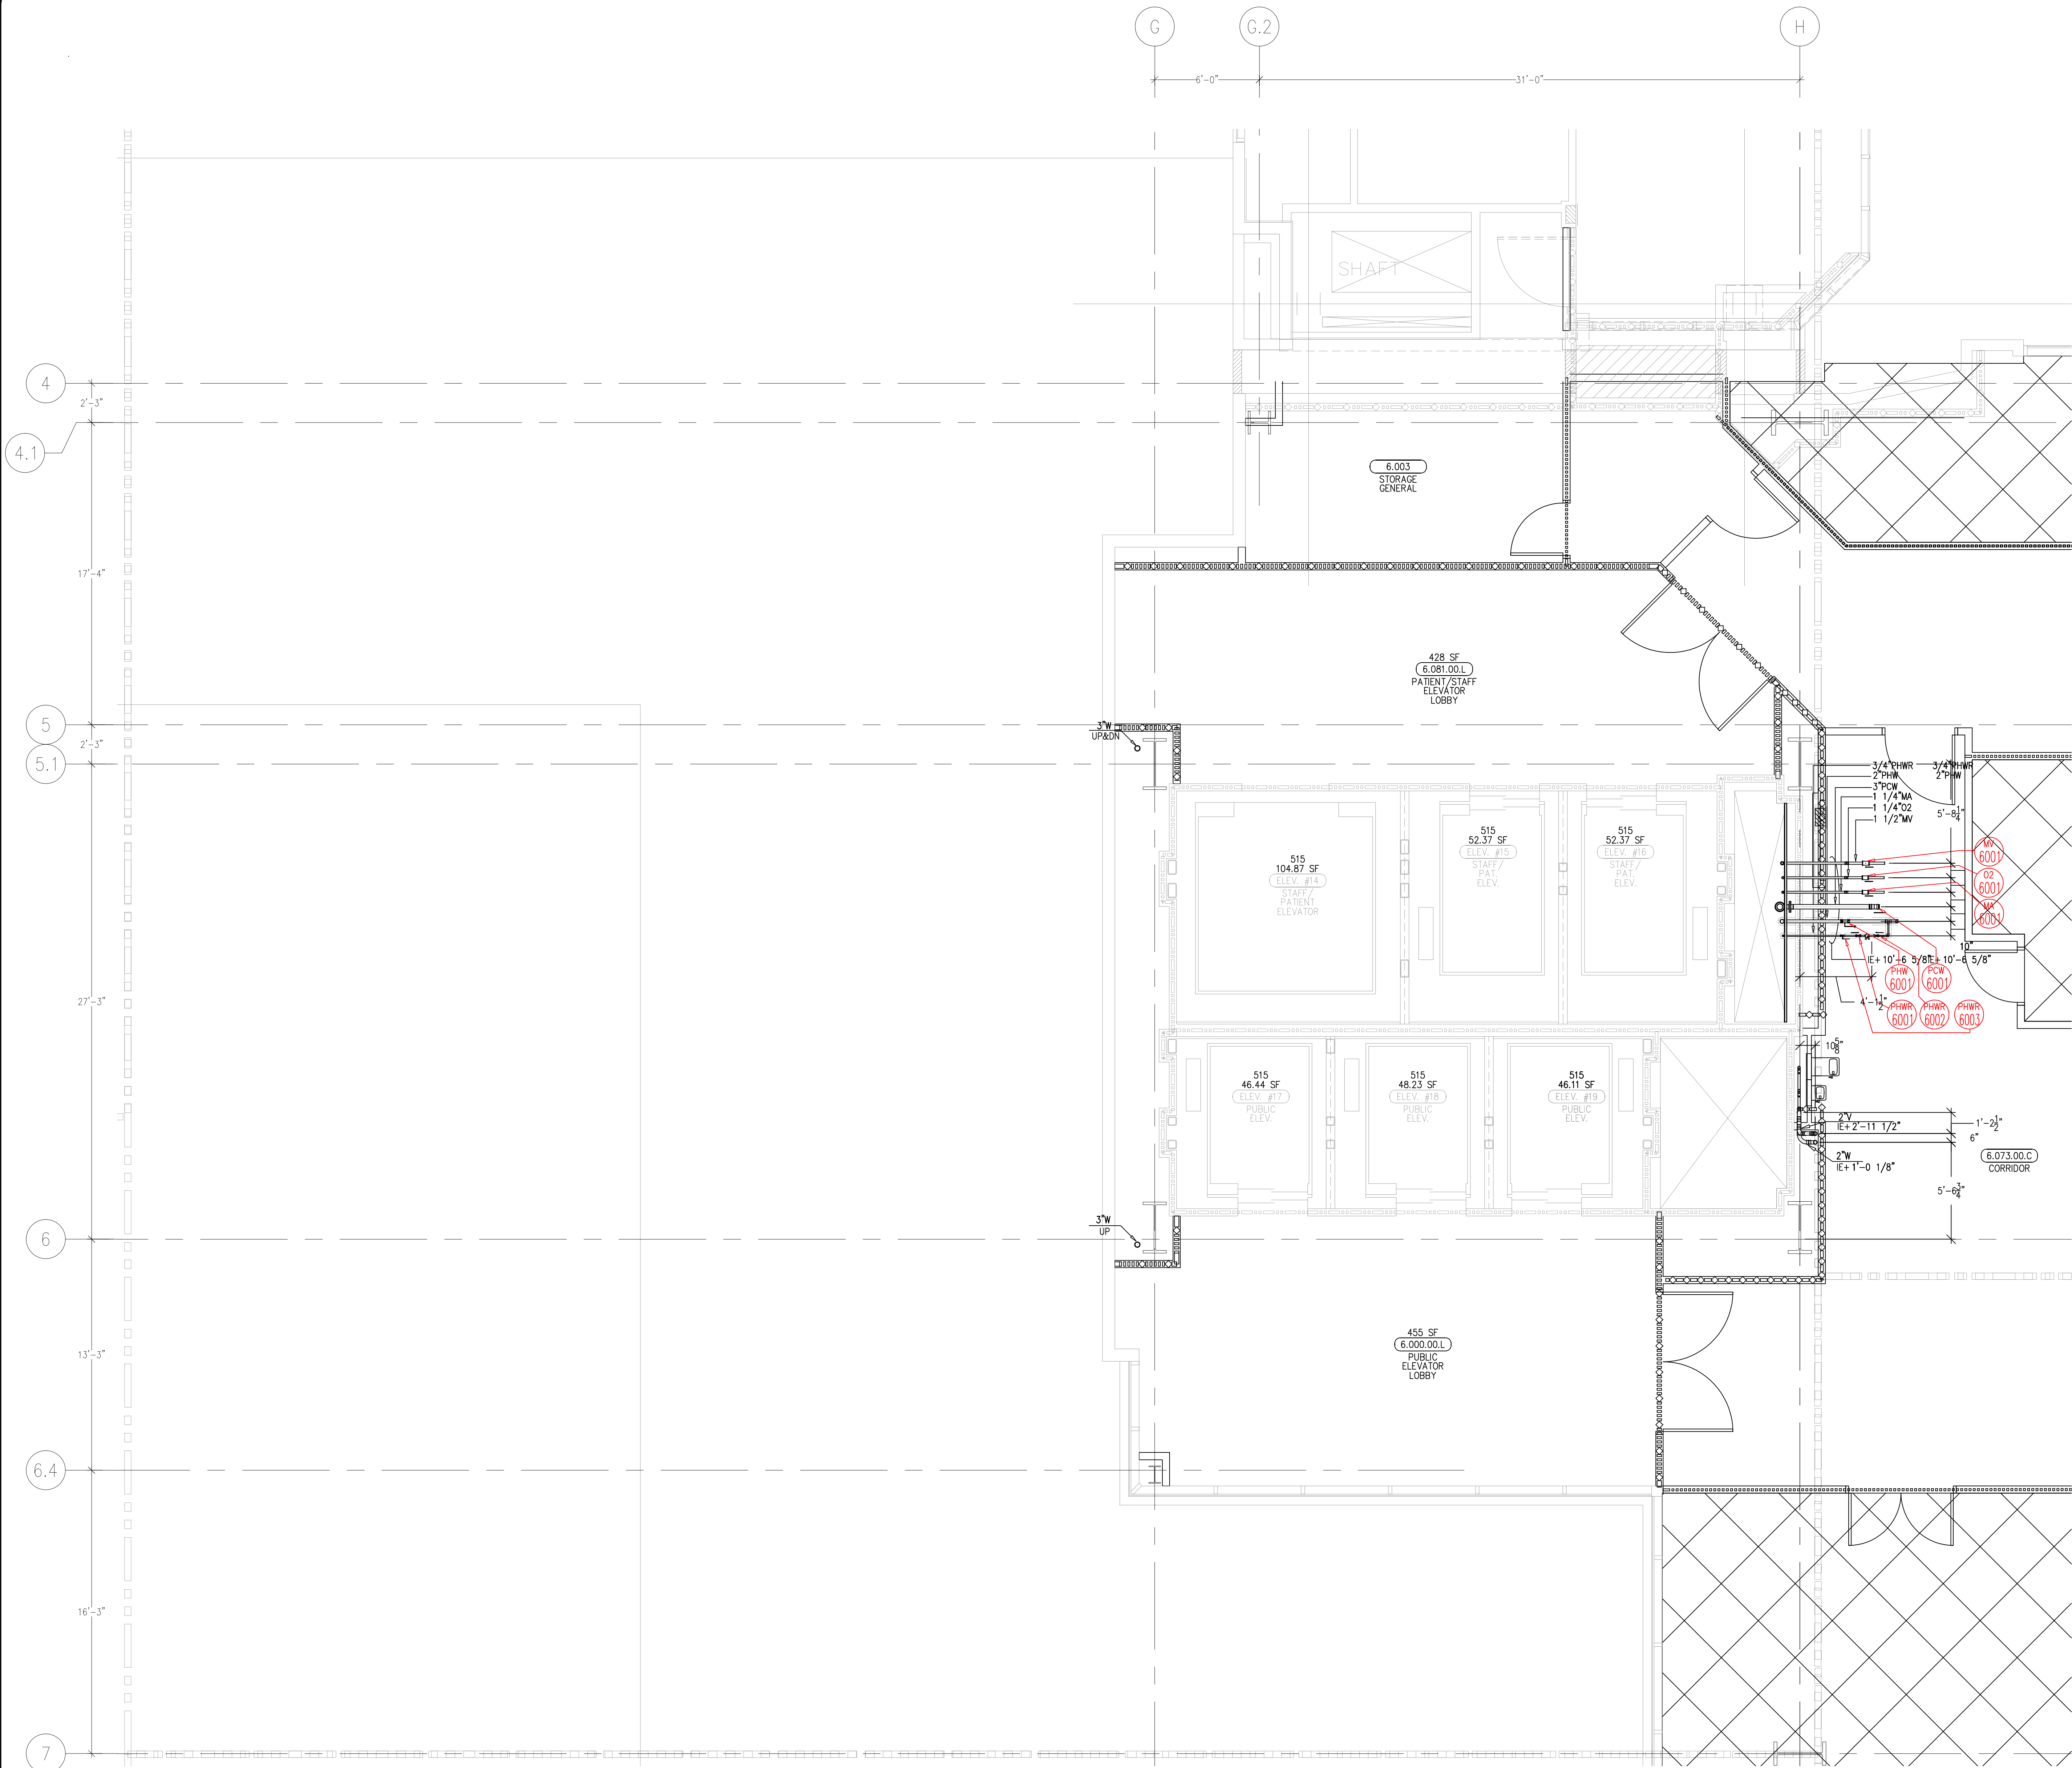

(A1) KEY PLAN

**MCCARTHY APPROVAL**

A. Approved as noted for Architectural Review ☐  
B. Review and Resubmit ☐  
C. Rejected ☐

This review is for general conformance with Plans and Specifications only. Any deviations from same not clearly noted by the Engineer shall be deemed reviewed. Review shall not constitute a complete check of detailed dimensions or shall be taken to release the Engineer of contractual responsibility for any error or deviation from contract requirements.

McCarthy

By: \_\_\_\_\_ Date: \_\_\_\_\_  
SHOP DRAWING REFERENCE NO. \_\_\_\_\_

REVISIONS		BY
ISSUED FOR COORDINATION	SDV-SFT 04-07-10	DK

COORD.	SIGNATURE	DATE
MCCARTHY		
MECHANICAL		
PLUMBING		
ELECTRICAL		
FIRE SPRINKLER		
PIPE		
DRYWALL/FRAMER		
REFRIGERATION		
STRUCTURAL		

R.F.I.	SENT	ANS.	R.F.I.	SENT	ANS.	R.F.I.	SENT	ANS.
0440	10/02/09	10/22/09						
0943	08/29/10	09/08/10						

**CHILDREN'S HOSPITAL  
OF ORANGE COUNTY**  
455 S. TOLSON CA 92668-3874  
ORANGE, CA 92668-3874

**TOWER II**

PLUMBING FLOOR PLAN - LEVEL 06 AREA H

**PAN-PACIFIC**  
PLUMBING & MECHANICAL

**Murray Company**

2919 E. VICTORIA STREET, RANCHO DOMINGUEZ, CA 90221  
PH. 310 637-1500 FAX 310 604-0359

DRAWN  
R.O.

CHECKED  
M.M.

DATE  
10/10/2011

SCALE  
1/4" = 1'-0"


JOB NO.  
09-006

DRAWING NUMBER  
PL3.6H


REFERENCE DRAWING  
A3.6H  
P3.6H

1 OF 1 SHEETS

This document and the design it covers are the property of Murray Co. They are loaned only with the borrower's expressed written agreement that they will not be reproduced, copied, loaned, exhibited, or used in any way, except by written consent from Murray Co. to the borrower.

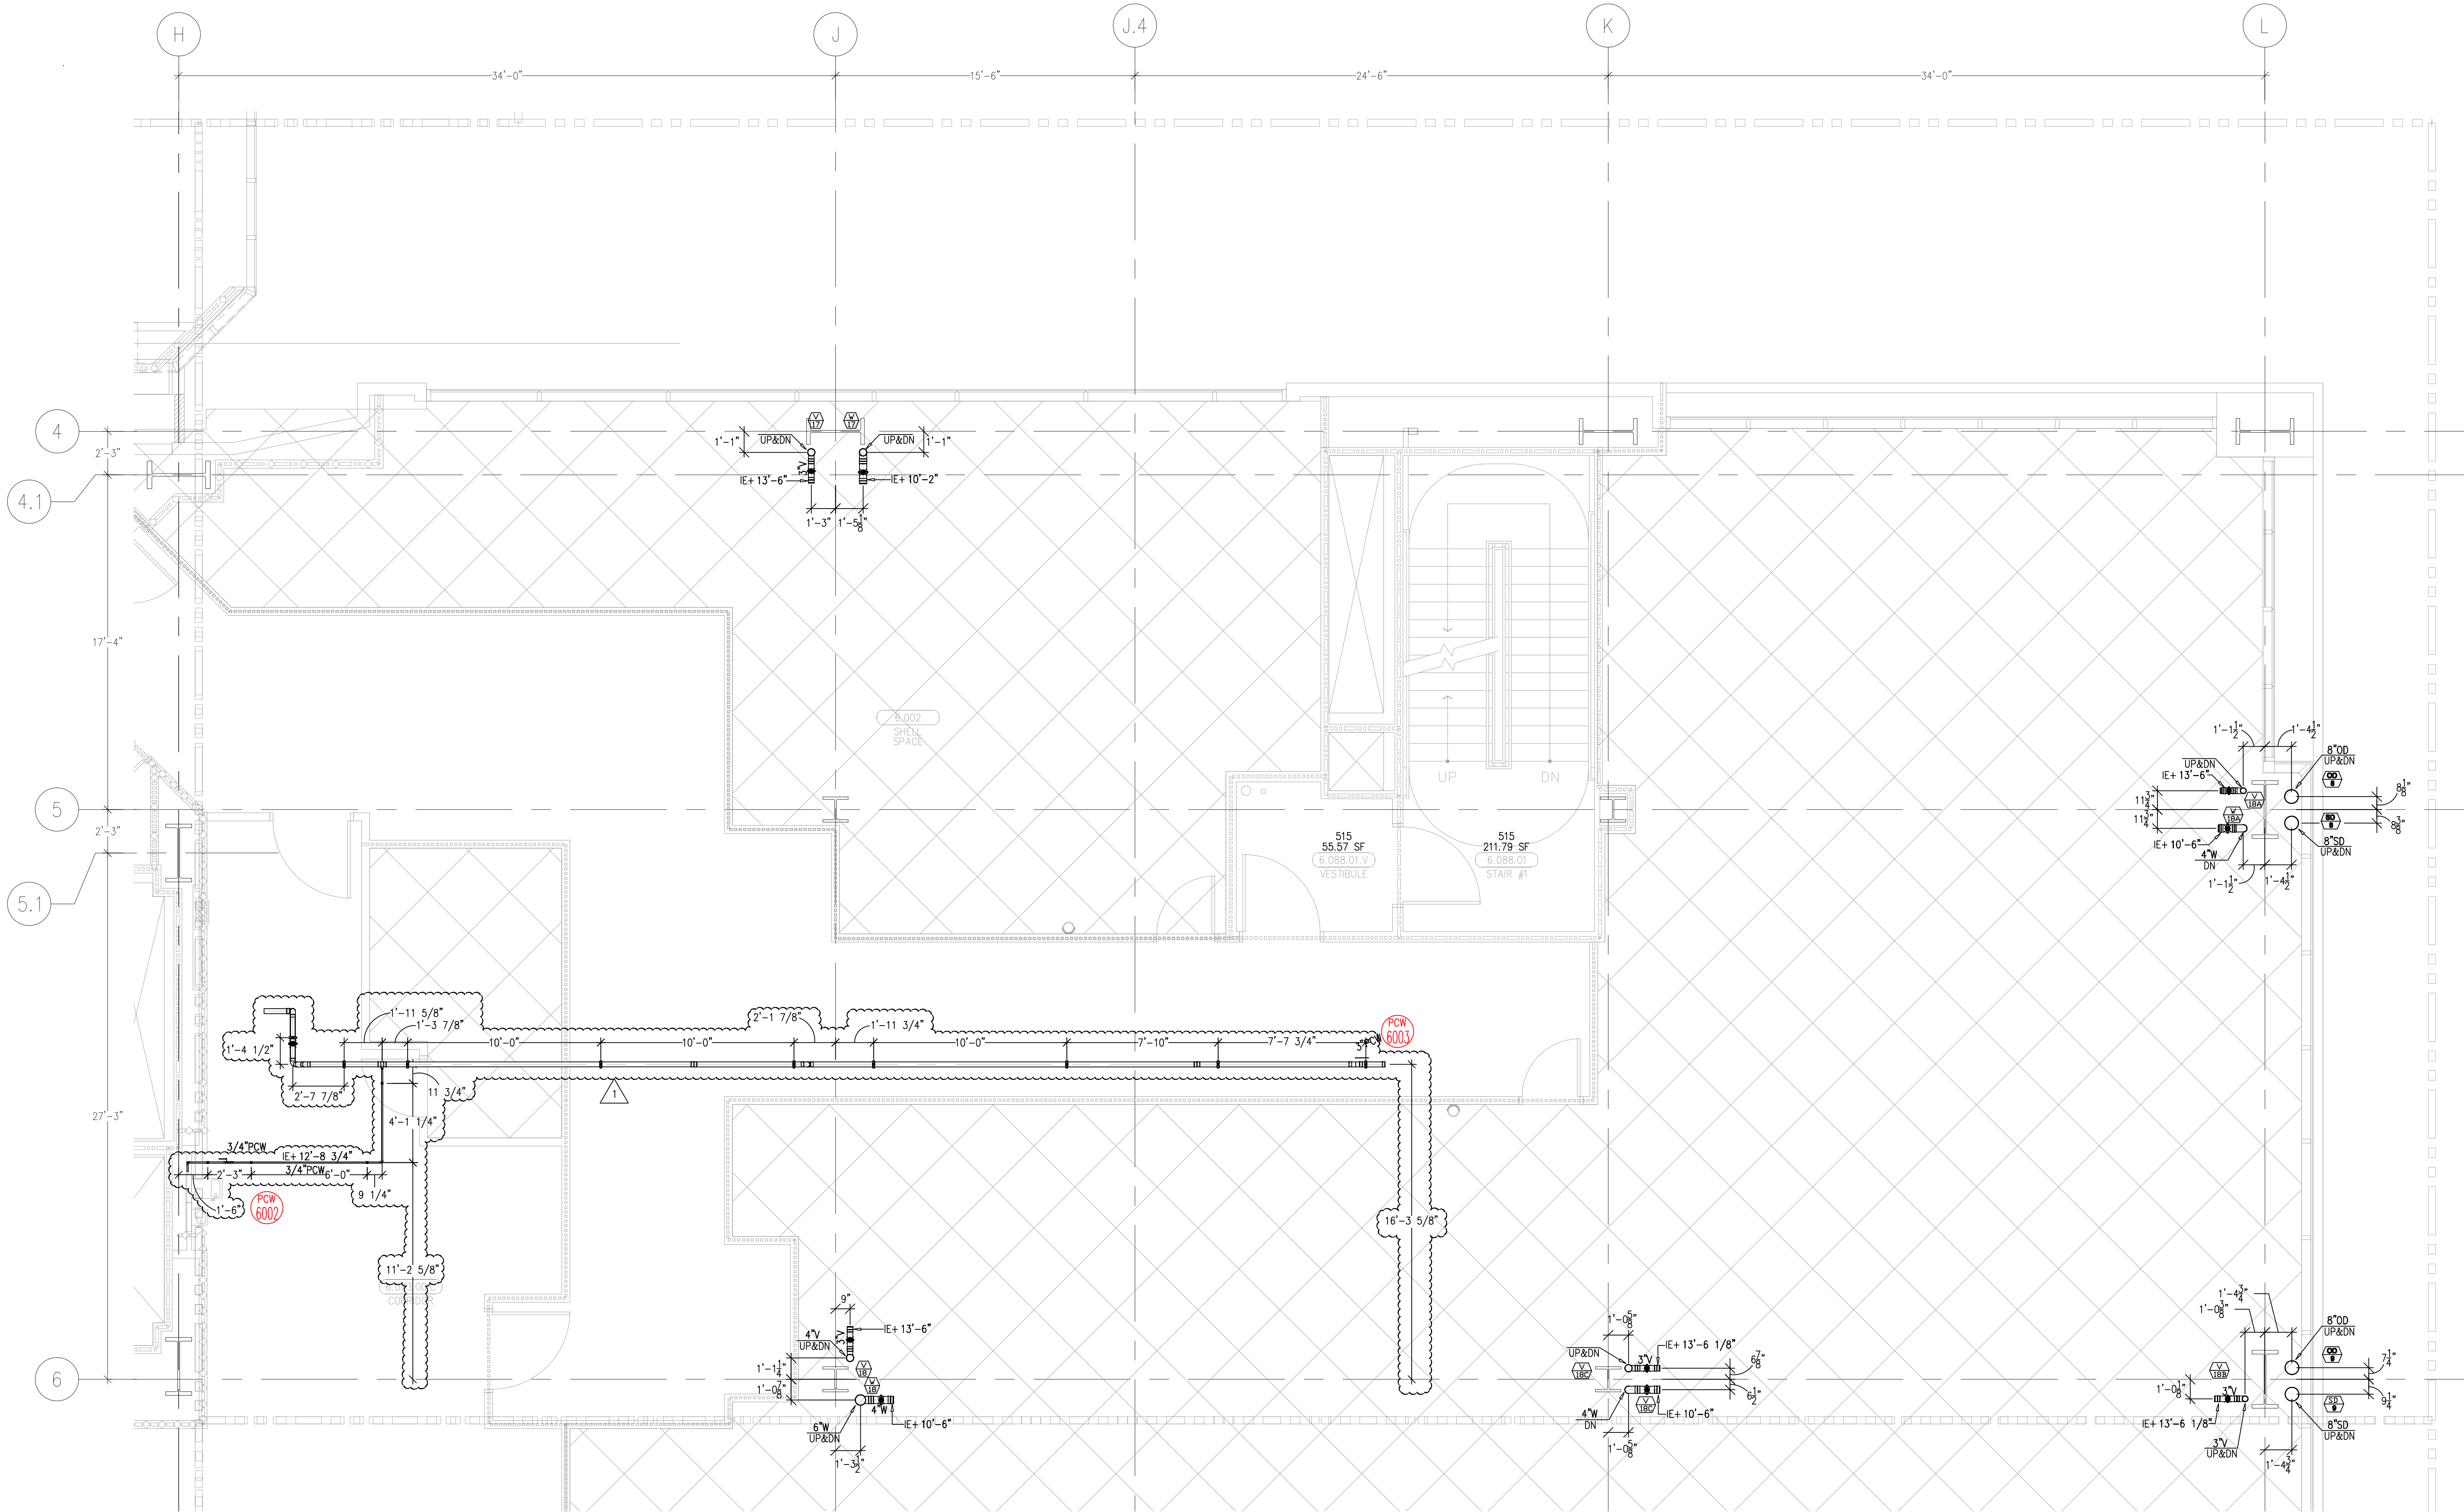

LEVEL 06 239.30' = 0'-0"  
REFERENCE THIS SHEET

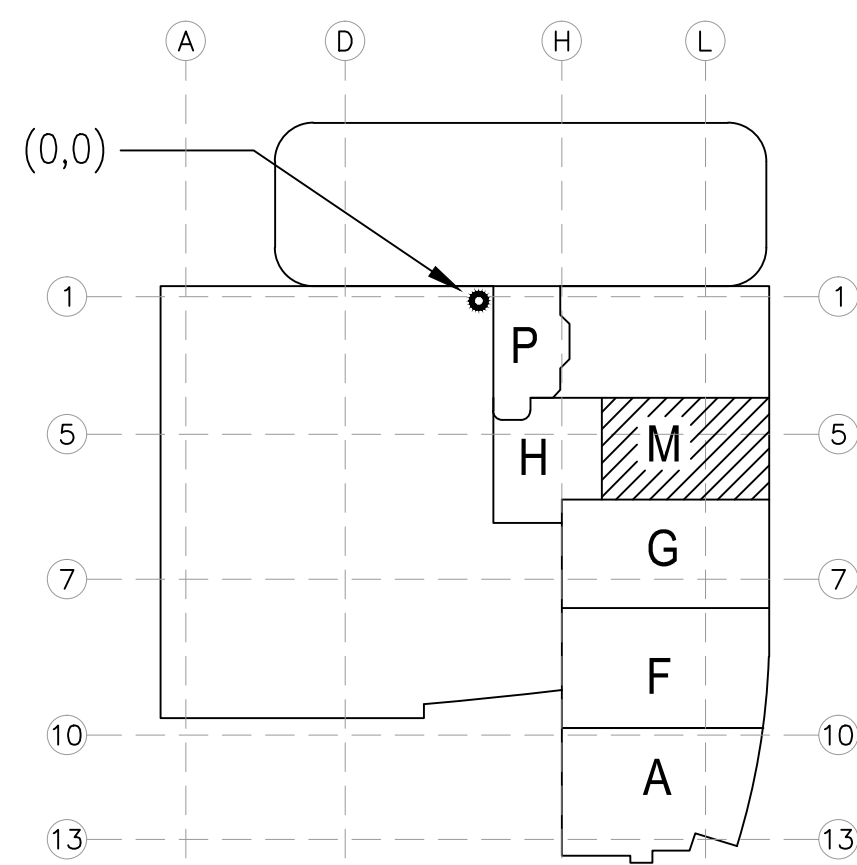

A1 KEY PLAN

MCCARTHY APPROVAL	
A. Approved as noted for Architectural Review	<input type="checkbox"/>
B. Review and Requisite	<input type="checkbox"/>
C. Engineer	<input type="checkbox"/>
McCarthy	
By _____	Date _____
SHEP DRAWING REFERENCE NO.	

REVISIONS		BY
1	ISSUED FOR COORDINATION SOW-07 04-07-10	DK
2	REVISED BLUE TO ADDED HANGERS 12-02-10	DK

COORD.	SIGNATURE	DATE
KASPER PERMANENTE		
FEDERAL CONTRACTOR		
MECHANICAL DUCT		
PLUMBING		
ELECTRICAL		
SPRINKLER		
P-TUBE		
DRYAL/FRAMER		
REFRIGERATION		

R.F.I.	SENT	ANS.	R.F.I.	SENT	ANS.	R.F.I.	SENT	ANS.

**CHILDREN'S HOSPITAL  
CHOC OF ORANGE COUNTY**  
HOSPITAL  
455 S. TOLSON AVE.  
ORANGE, CA 92668-3874

**TOWER II**  
PLUMBING FLOOR PLAN - LEVEL 06 AREA M

**PAN-PACIFIC**  
PLUMBING & MECHANICAL  
2919 E. VICTORIA STREET, RANCHO DOMINGUEZ, CA 90221  
PH. 310 637-1500 FAX 310 604-0359

**Murray Co.**  
2919 E. VICTORIA STREET, RANCHO DOMINGUEZ, CA 90221  
PH. 310 637-1500 FAX 310 604-0359

DRAWN R.O.
CHECKED M.M.
DATE 10/10/2011
SCALE 1/4" = 1'-0"
JOB NO. 09-006
DRAWING NUMBER PL3.6M
REFERENCE DRAWING A3.6M P3.6M
1 OF 1 SHEETS