


This document and the design it covers are the property of Murray Co. They are loaned only with the borrowers' expressed written agreement that they will not be reproduced, copied, loaned, exhibited, or used in any other way, except by written consent from Murray Co. to the borrower.

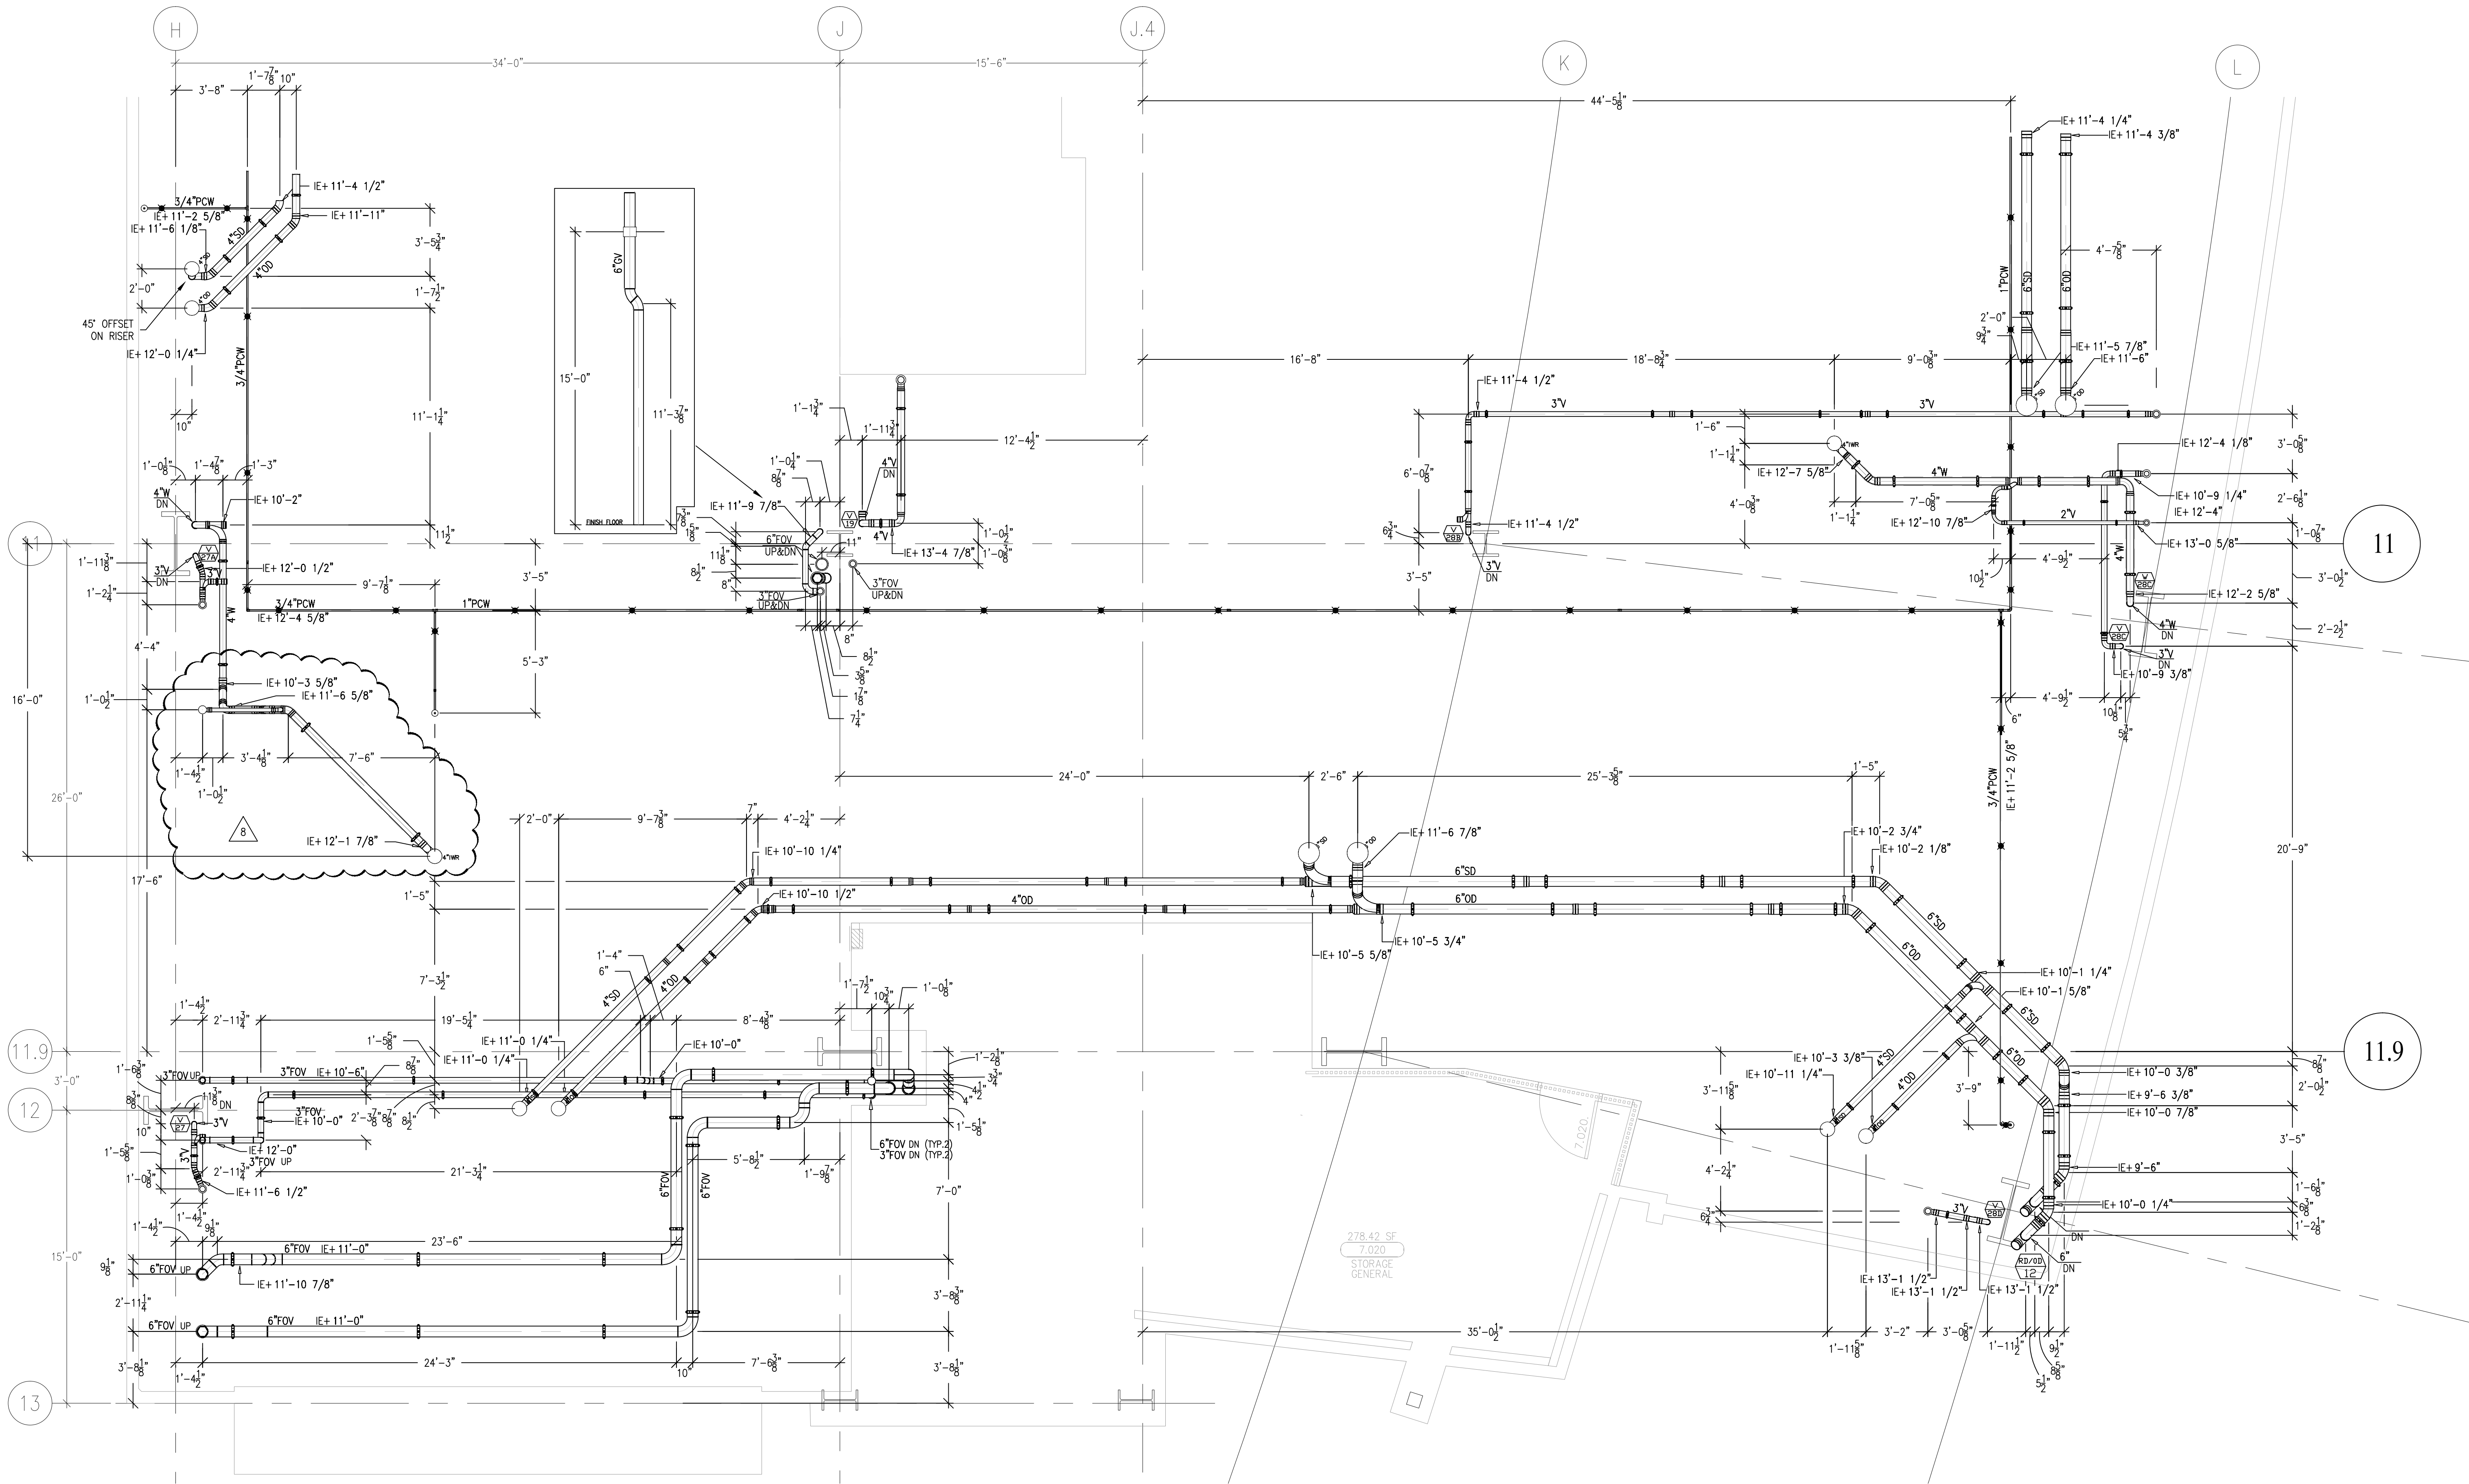

A	ISSUED FOR COORDINATION SIGN-OFF 04-27-10	DK
0	ISSUED FOR CONSTRUCTION 08-05-10	DK
1	REVISED DUE TO DAVIT CONFLICT 08-06-10	DK
2	REVISED PER PPMC RFI 745 09-02-10	JT
3	REVISED TO MISS ELECTRICAL FLOOR OPENING 10-12-10	DK

	REVISIONS	BY
4	REVISED TO MISS ELECTRICAL PAD ABOVE 12-27-10	DK
5	REVISED PER OSHPD CD 110 PMCE 0247 03-09-2011	JT
6	REVISED CORES TO MISS STEEL IN SLAB CO#110 03-18-11	JT
7	REVISED TO SHORTEN TRAP ARM 06-25-11	DK
8	REVISED RR LOCATION 08-18-11	DK

COORD.	SIGNATURE	DATE
MECHANICAL DUCT		
MECHANICAL PIPE		
PLUMBING		
ELECTRICAL		
FIRE SPRINKLER PIPE		
DRYWALL/FRAMER		
REFRIGERATION		
STRUCTURAL		

[illegible]

CHOC^{HO}SPITAL
CHILDREN'S HOSPITAL
OF ORANGE COUNTY
 455 S. Main St.
 Orange, CA 92668-3874
TOWER II

PLUMBING FLOOR PLAN - LEVEL 07 AREA-A


DM

PAN-PACIFIC
PLUMBING & MECHANICAL

Murray Company


2819 E. VICTORIA STREET, RANCHO DOMINGUEZ, CA 90221
PH. 310 637-1500 FAX 310 604-0359

DRAWN
R.O.
CHECKED
M.M.
DATE
10/10/2011
SCALE
1/4" = 1'-0"
JOB NO.
09-006
DRAWING NUMBER
PL3.7A
REFERENCE DRAWING
A3.7A
P3.7A
1 OF 1 SHEETS




LEVEL 07 254.30' = 0'-0"

REFERENCE THIS SHEET

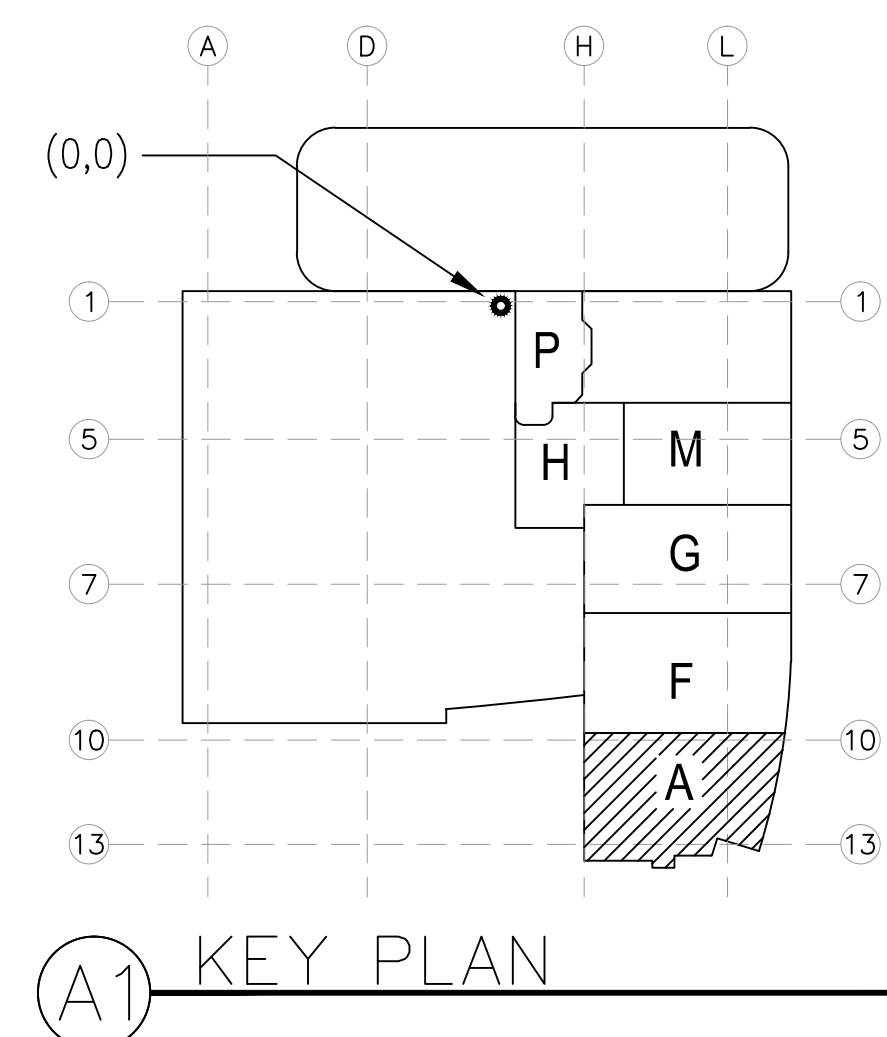

<h2 style="margin: 0;">MCCARTHY APPROVAL</h2>	
<p>A. Approved as noted for Architecture Review <input type="checkbox"/></p> <p>B. Review and Re-submit <input type="checkbox"/></p> <p>C. Rejected <input type="checkbox"/></p>	
<p>This review is for general conformance with Plans and Specifications only. Any deviations from same not clearly noted by the Preparer have not been reviewed. Review shall not constitute a complete check of detailed dimensions or count to serve to relieve the Preparer of contractual responsibility for any error or deviation from contract requirements.</p>	
<h1 style="margin: 0;">McCarthy</h1>	
By _____	Date _____
<div style="border: 1px solid black; display: inline-block; padding: 2px 10px;">SHOP DRAWING REFERENCE NO.</div>	

document and the design it covers are the property of Murray Co. They are loaned only with the borrowers' expressed written agreement that they will not be reproduced, copied, loaned, exhibited, or used in any other way, except by written consent from Murray Co. to the borrower.

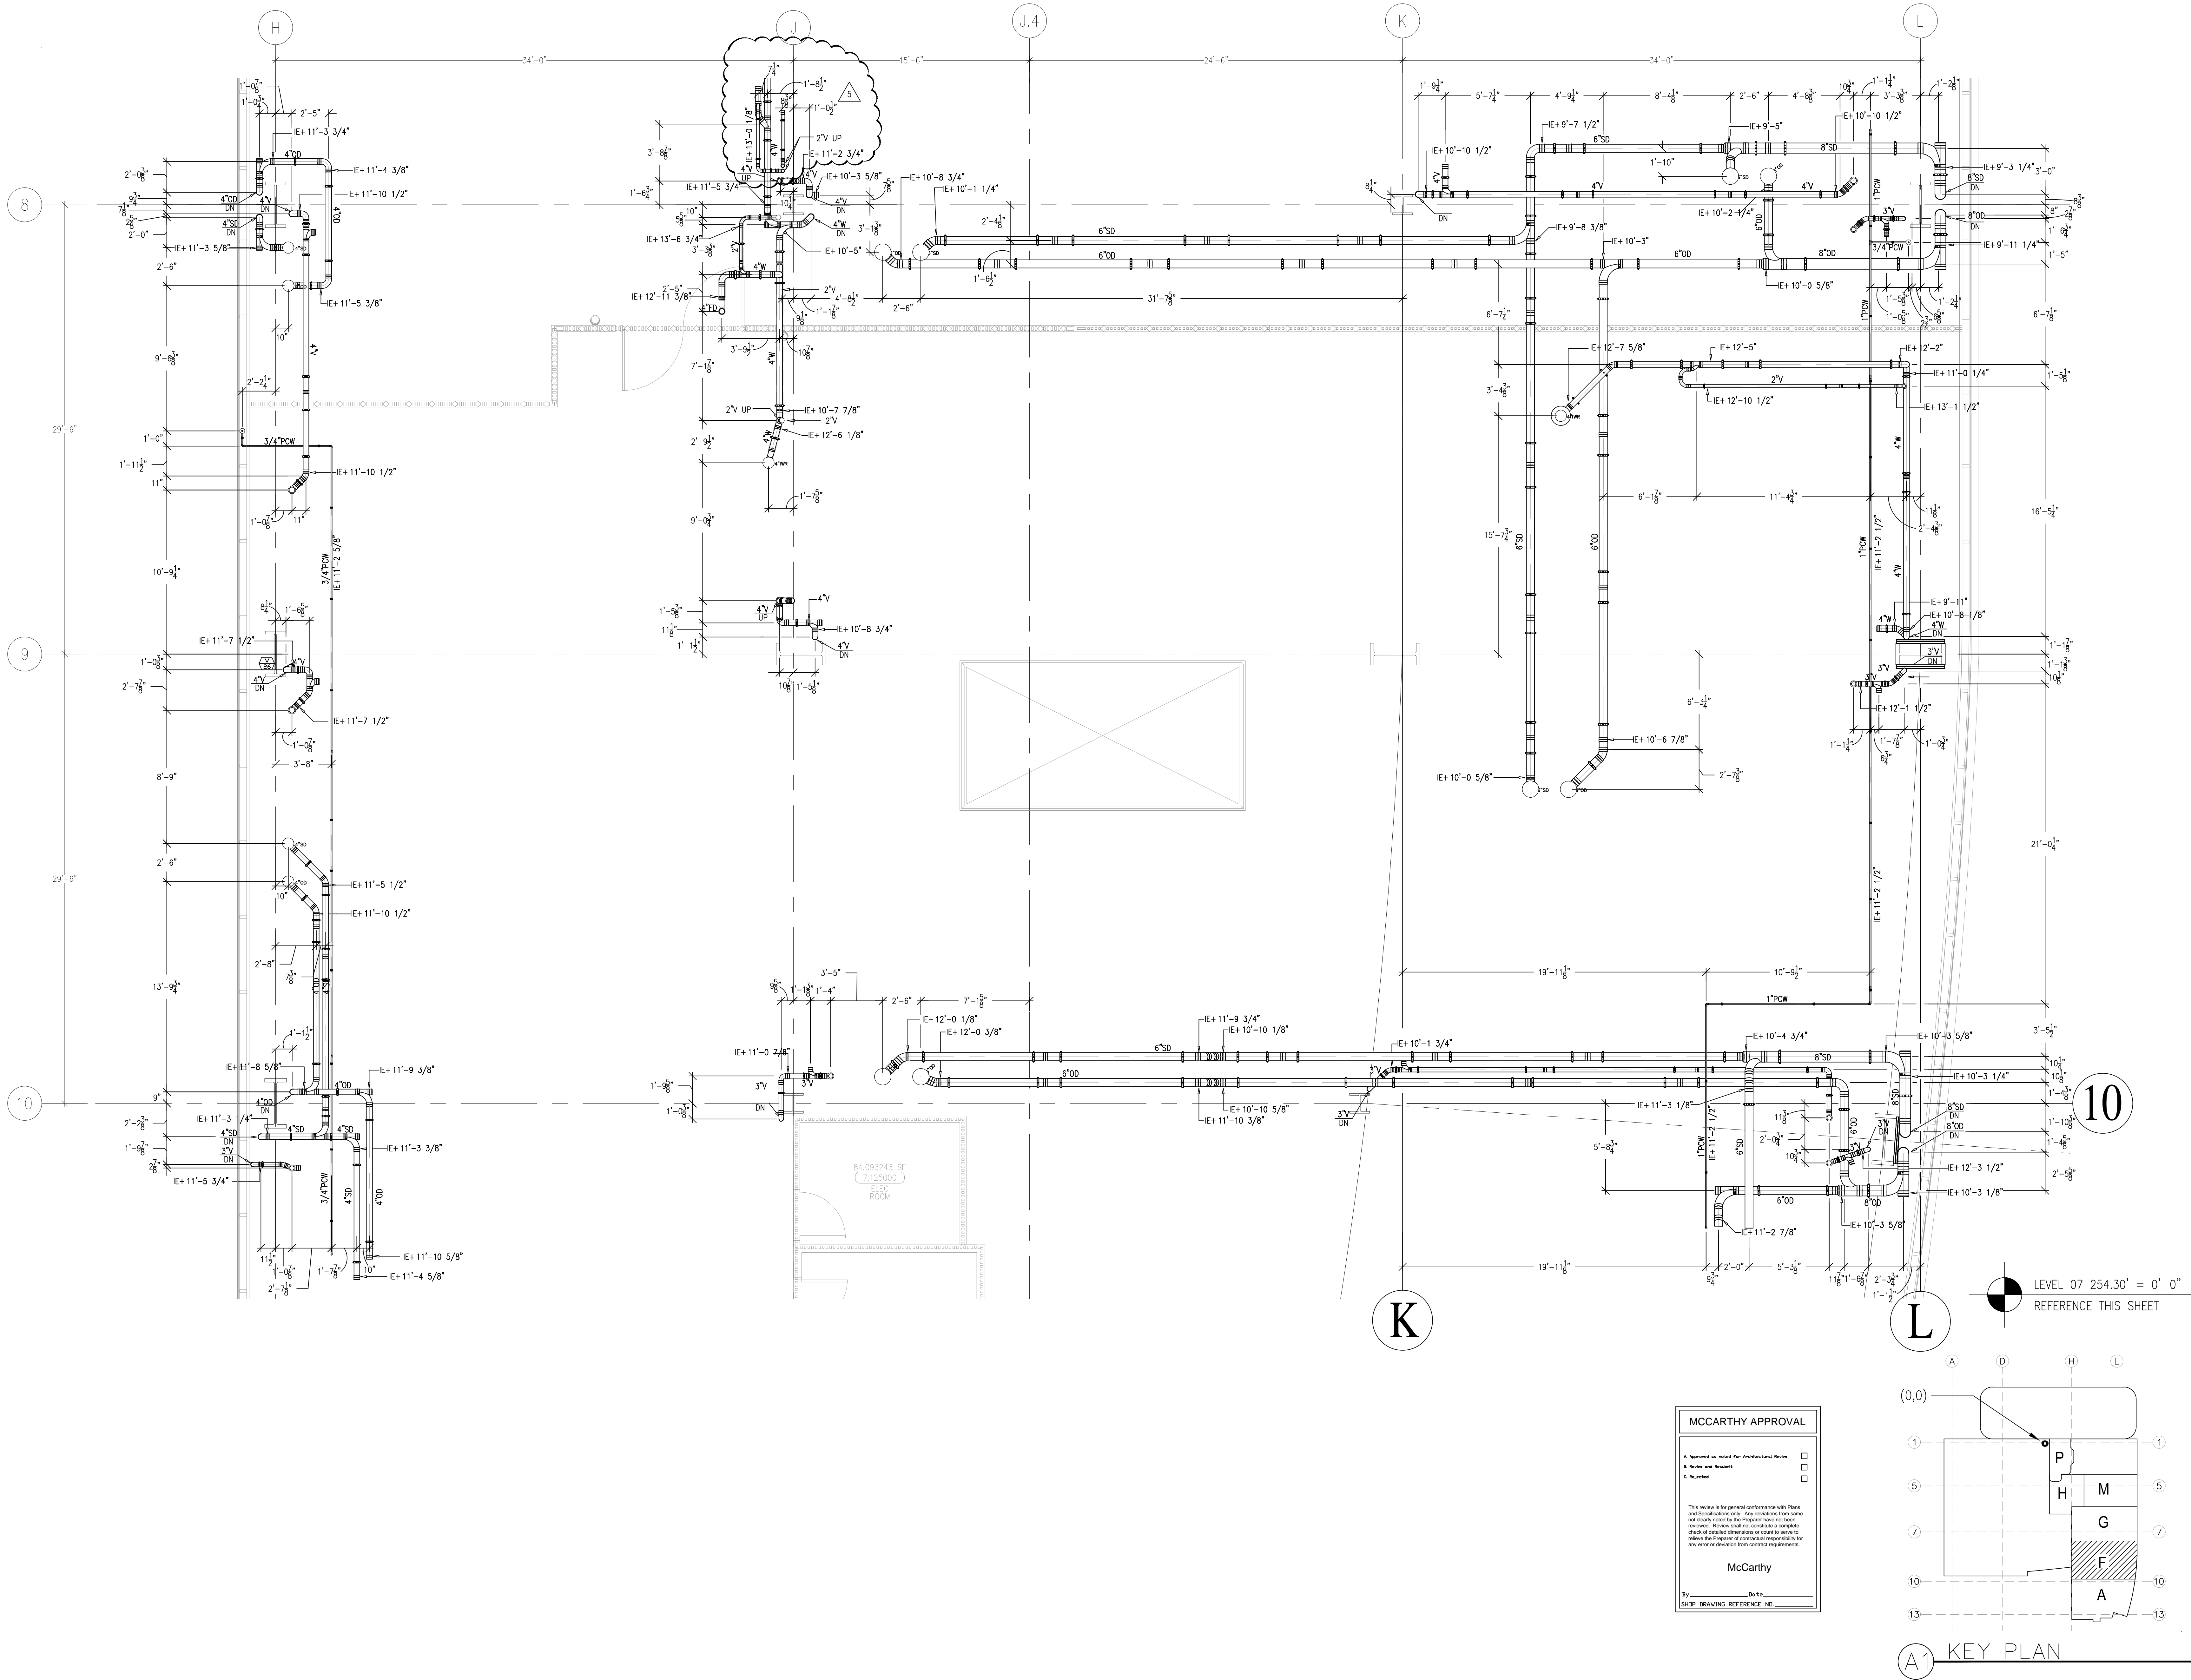

	REVISIONS	BY
A	ISSUED FOR COORDINATION SIGN-OFF 04-27-10	DK
0	ISSUED FOR CONSTRUCTION 08-05-10	DK
1	REVISED DUE TO DAWT CONFLICT 08-06-10	DK
2	REVISED TO MISS ELECTRICAL FLOOR OPENING. 10-12-10	DK
3	REVISED DUE DRAIN HAS BEEN MOVED. 12-01-10	DK
4	RELOCATE VENT DUE TO ASH 11 (D500011AB1). 03-01-11	GP
5	RELOCATE VENTS DUE TO CONFLICT WITH PANELS 09-27-11	DK

COORD.	SIGNATURE	DATE
McCarthy		
MECHANICAL DUCT		
MECHANICAL PIPE		
PLUMBING		
ELECTRICAL		
FIRE SPRINKLER		
PITING		
DRYWALL/FRAMER		
REFRIGERATION		
STRUCTURAL		

[illegible]

CHILDREN'S HOSPITAL
OF ORANGE COUNTY
455 S. Main St.
Orange, CA 92668-3874
TOWER II

PLUMBING FLOOR PLAN - LEVEL 07 AREA-F

PAN-PACIFIC
PLUMBING & MECHANICAL




PAN-PACIFIC
PLUMBING & MECHANICAL

Murray Company

2919 E. VICTORIA STREET, RANCHO DOMINGUEZ, CA 90221

Drawn
 R.O.
 Checked
 M.M.
 Date
 10/10/2011
 Scale
 $1/4" = 1' - 0"$
 Job No.
 09-006
 Drawing Number
 PL3.7F
 Reference Drawing
 A3.7F
 P3.7F
 1 OF 1 SHEETS

document and the design it covers are the property of Murray Co. They are loaned only with the borrower's expressed written agreement that they will not be reproduced, copied, loaned, exhibited, or used in any other way, except by written consent from Murray Co. to the borrower.

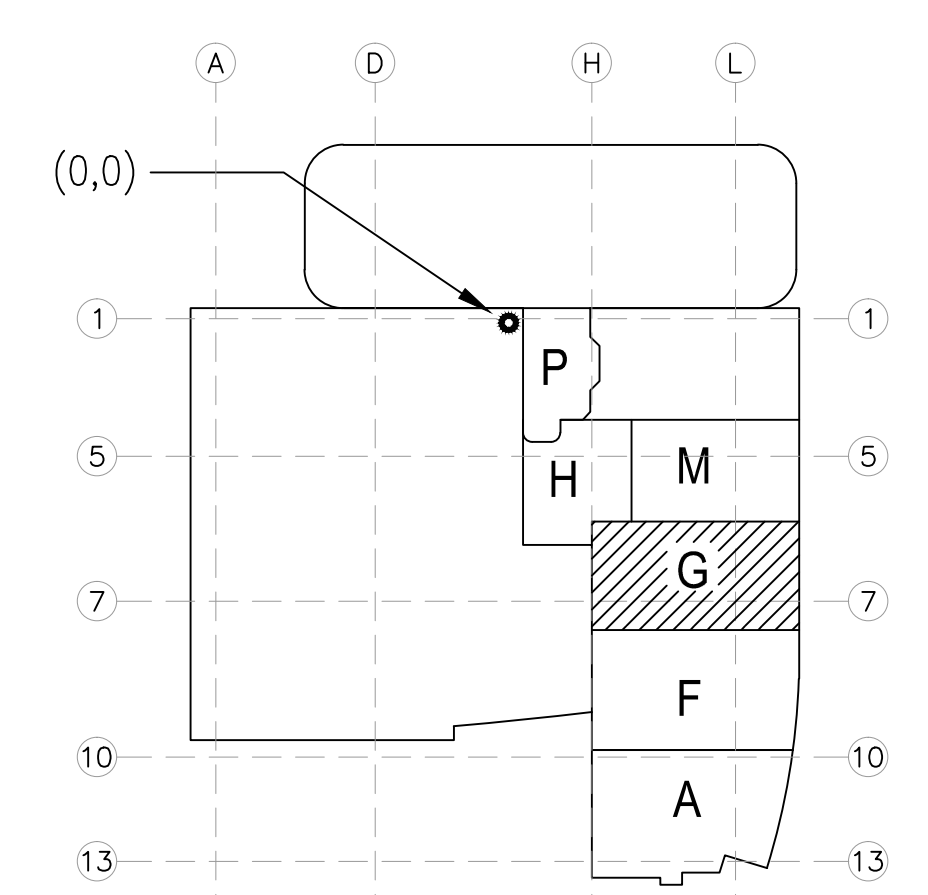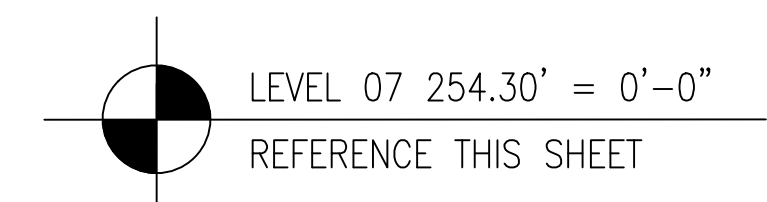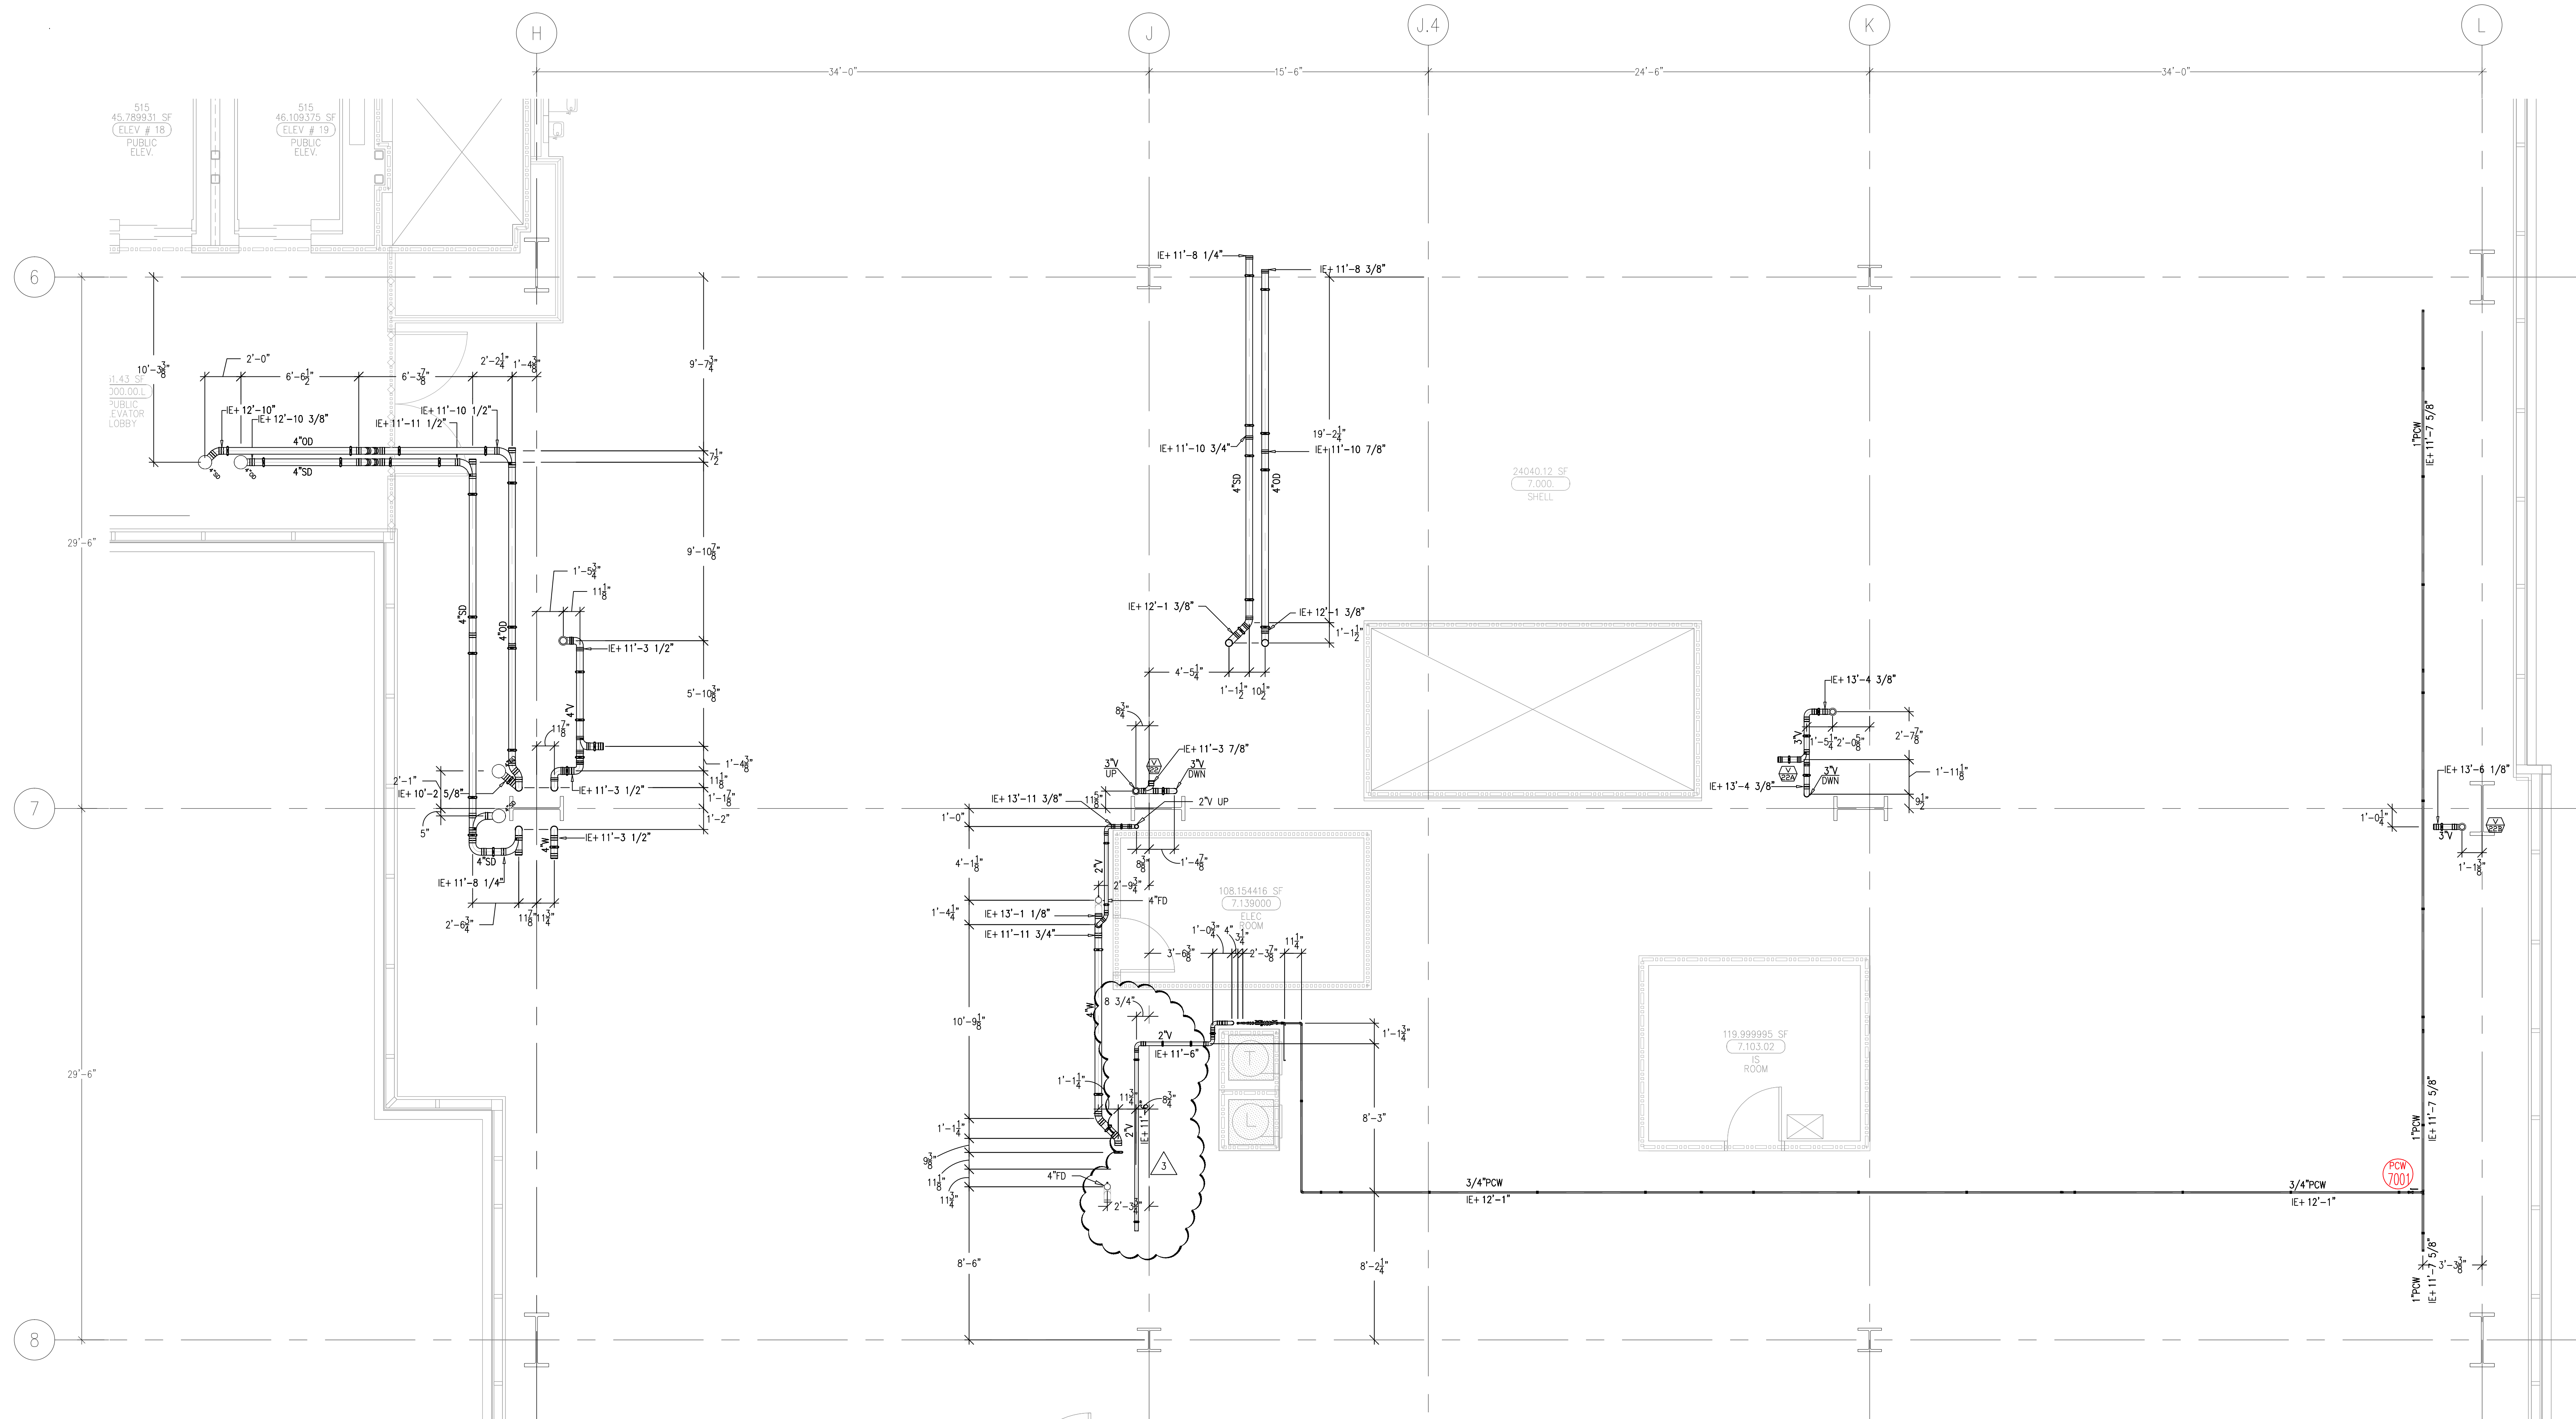

A1 KEY PLAN

<h2 style="margin: 0;">MCCARTHY APPROVAL</h2>	
A. Approved as noted for Architectural Review	<input type="checkbox"/>
B. Review and Rebuild	<input type="checkbox"/>
C. Rejected	<input type="checkbox"/>
<p>This review is for general conformance with Plans and Specifications only. Any deviations from same not clearly noted by the Preparer have not been reviewed. Review shall not constitute a complete check of detailed dimensions or cover to serve to relieve the Preparer of contractual responsibility for any error or deviation from requirements.</p> <div style="text-align: center; margin-top: 20px;"> <h1 style="margin: 0;">McCarthy</h1> </div> <div style="display: flex; justify-content: space-between; margin-top: 20px;"> <div style="width: 45%;"> <p>By _____</p> <p><u>SHD</u> DRAWING REFERENCE <u>ND</u></p> </div> <div style="width: 45%; text-align: right;"> <p>Date _____</p> </div> </div>	

	REVISIONS	BY
A	SIGN-OUT FOR COORDINATION 04-27-10	DK
0	ISSUED FOR CONSTRUCTION 08-05-10	DK
1	UPDATED PER PPWC RF1 831 10-05-10	JT
2	ADDED RD & GO PER CONST. RF1 2627 12-28-10	DK
3	REVISED VENT LOCATIONS DUE TO CONFLICT WITH PANELS 09-27-11	DK



COORD:	SIGNATURE	DATE
McARTHUR		
MECHANICAL DUCT		
MECHANICAL PIPE		
PLUMBING		
ELECTRICAL		
FIRE SPRINKLER		
PLUMB		
DRYWALL/FRAMER		
REFRIGERATION		
STRUCTURAL		

[illegible]

**CHILDREN'S HOSPITAL
CHOC[®] OF ORANGE COUNTY**
HOSPITAL
465 S. Main St.
Orange, CA 92665-3874


TOWER II

PLUMBING FLOOR PLAN - LEVEL 07 AREA-G


PAN-PACIFIC
 PLEADING & MECHANICAL

Murrey Company
 2919 E. VICTORIA STREET, RANCHO DOMINGUEZ, CA 90221
 PH. 310 637-1500 FAX 310 604-0359

DRAWN
R.O.
CHECKED
M.M.
DATE
10/10/2011
SCALE
1/4"=1'-0"
JOB NO.
09-006
DRAWING NUMBER
PL3.7G
REFERENCE DRAWING
A3.7G
P3.7G
1 OF 1 SHEETS

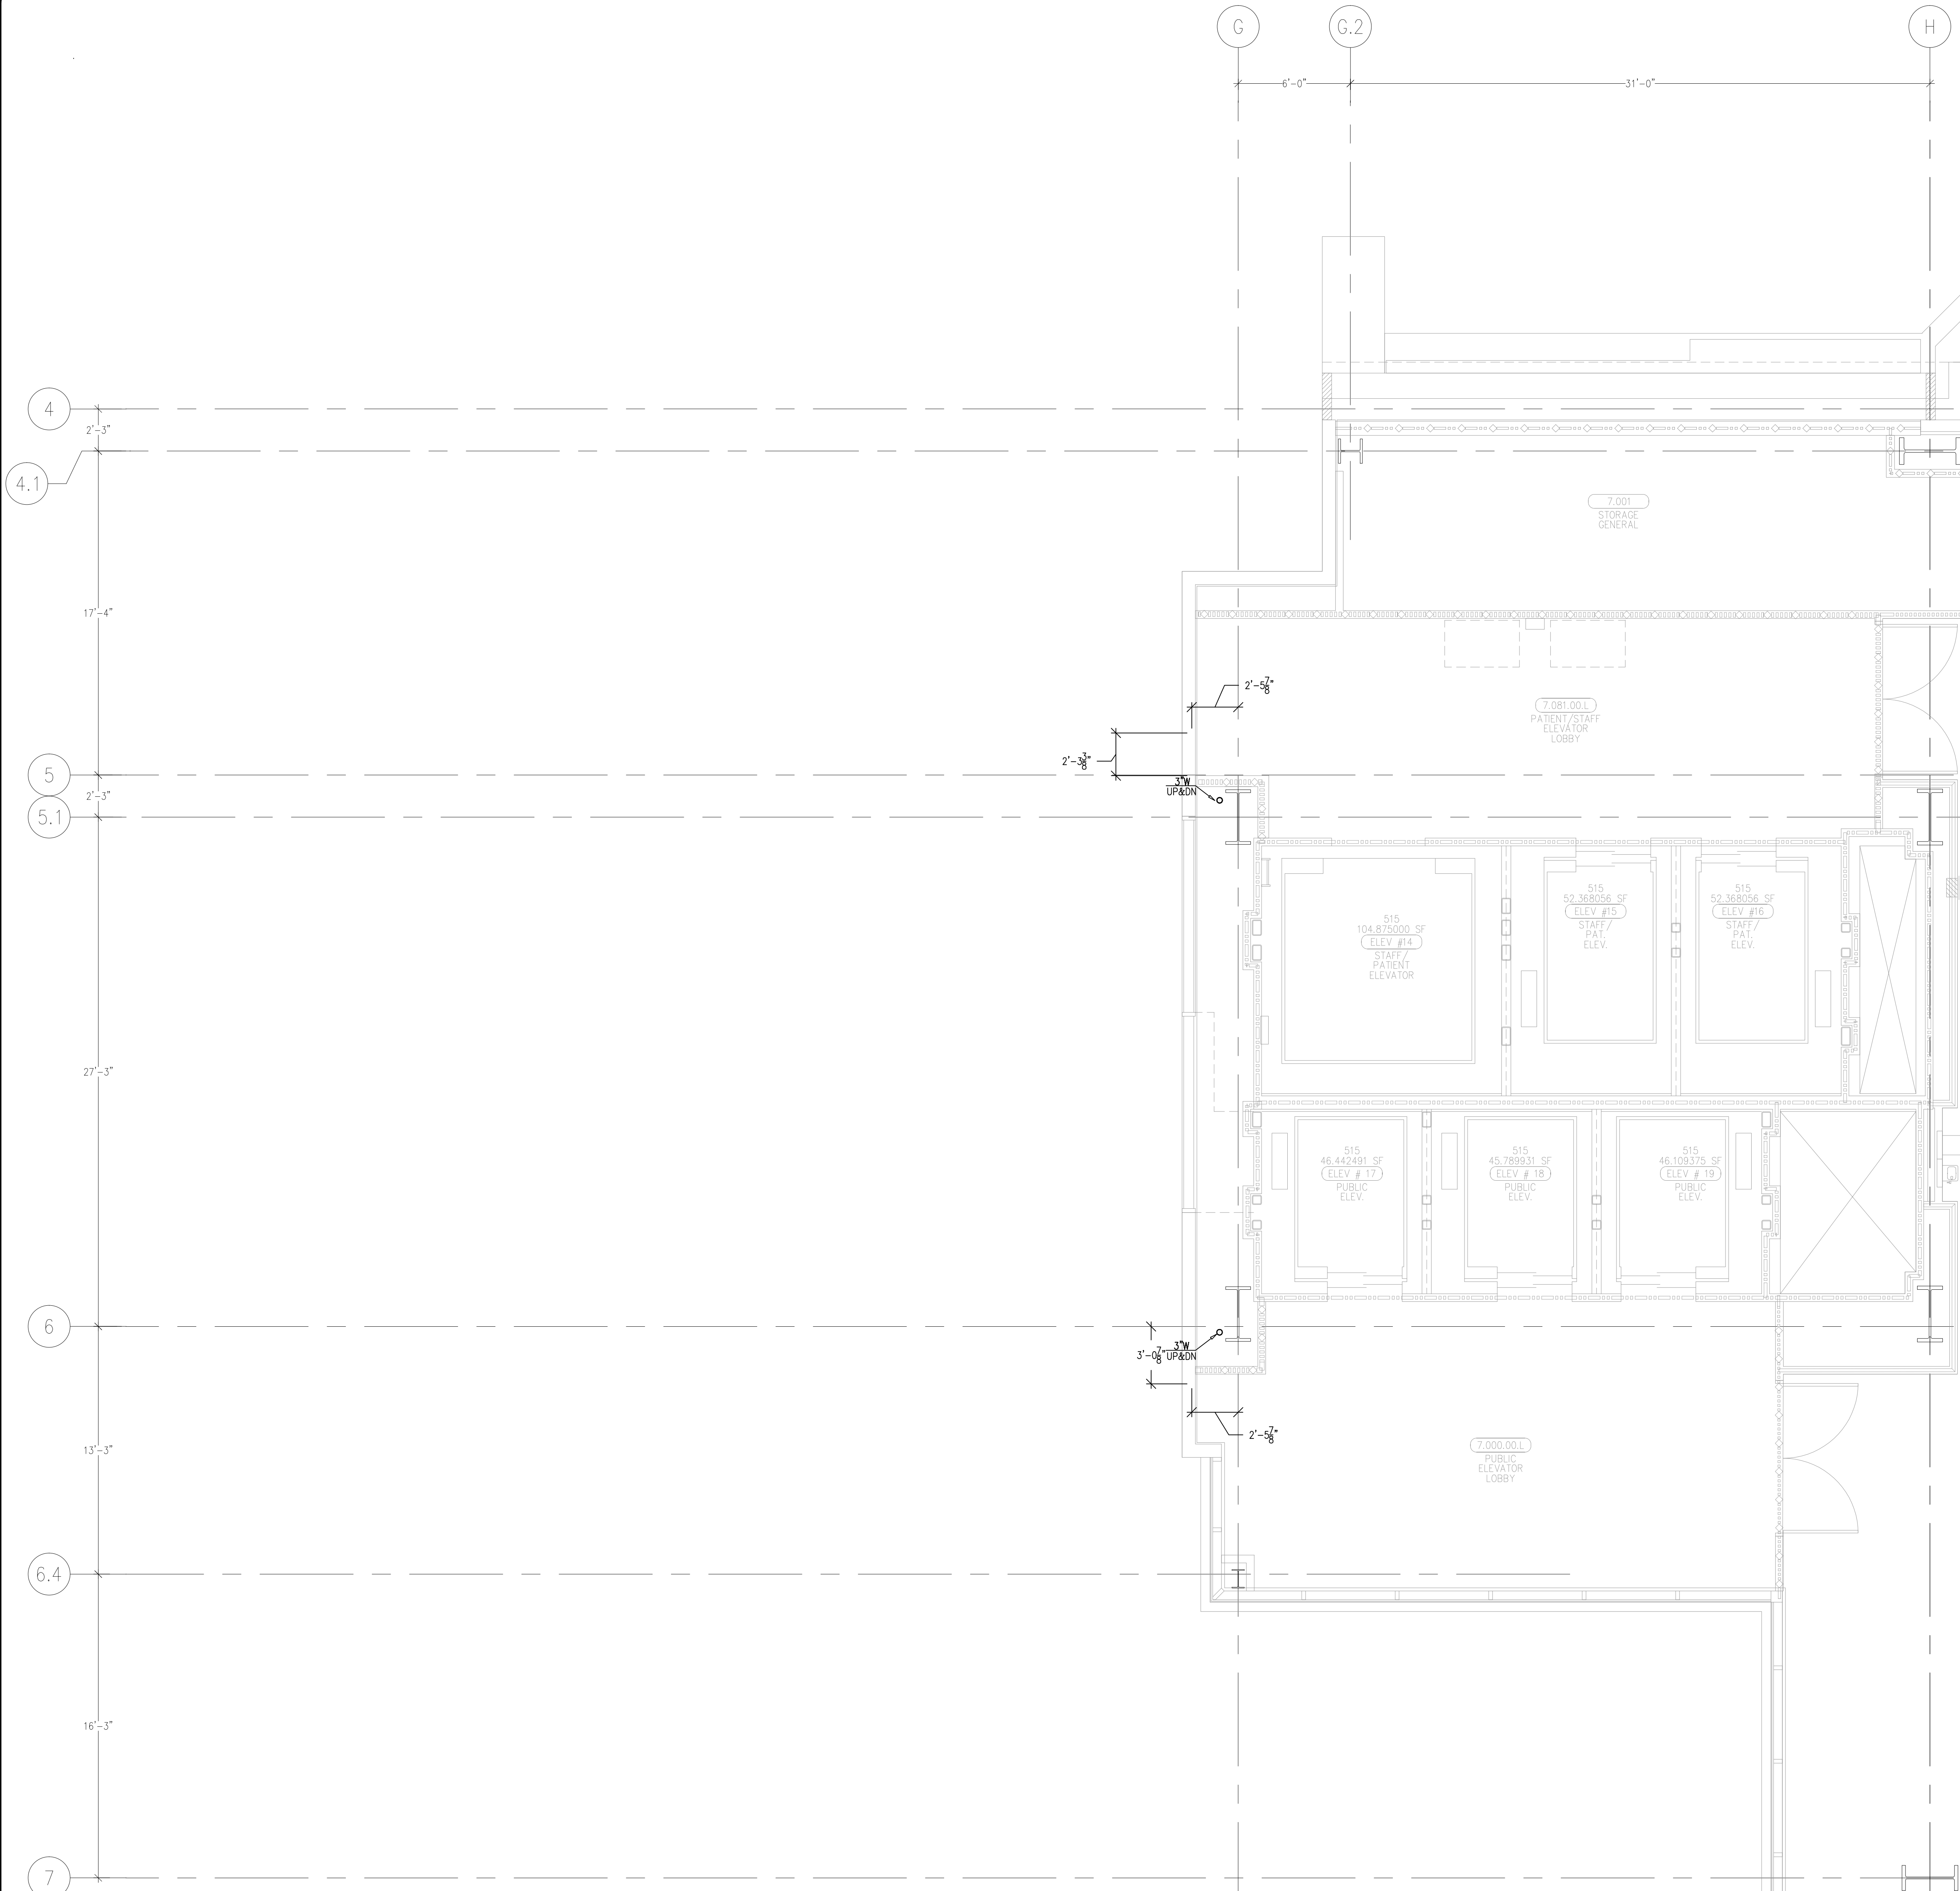This document and the design it covers are the property of Murray Co. They are loaned only with the borrower's expressed written agreement that they will not be reproduced, copied, loaned, exhibited, or used in any other way, except by written consent from Murray Co. to the borrower.



MCCARTHY APPROVAL

A. Approved as noted For Architectural Review

B. Review and Request

C. Rejected

This review is for general performance with Plans and Specifications only. Any deviations from same not clearly noted by the Prepared here not been reviewed. Reviewer shall not constitute a complete check of detailed dimensions or count to serve to release the Preparer of contractual responsibility for any error or deviation from contract requirements.

McCarthy

By: _____ Date: _____

SHEP. DRAWING REFERENCE NO. _____

LEVEL 07 254.30' = 0'-0" REFERENCE THIS SHEET

REVISIONS		BY
A	ISSUED FOR COORDINATION SON-OFF 04-27-10	DK
D	ISSUED FOR CONSTRUCTION 08-16-10	DK

COORD.	SIGNATURE	DATE
MECHANICAL		
ELECTRICAL		
PLUMBING		
STRUCTURAL		

R.F.I.	SENT	ANS.	R.F.I.	SENT	ANS.	R.F.I.	SENT	ANS.
0433	07/25/09	10/13/09						
0440	10/22/09	10/22/09						
0478	07/14/10	07/21/10						
0483	08/15/10	09/09/10						

CHILDREN'S HOSPITAL

CHOC

OF ORANGE COUNTY

HOSPITAL

465 S. MAIN ST.

ORANGE, CA 92668-3874

TOWER II

PLUMBING FLOOR PLAN - LEVEL 07 AREA-H

PAN-PACIFIC

PLUMBING & MECHANICAL

Murray Co.

2919 E. VICTORIA STREET, RANCHO DOMINGUEZ, CA 90221

PH. 310 637-1500 FAX 310 604-0359

DRAWN R.O.

CHECKED M.M.

DATE 10/10/2011

SCALE 1/4" = 1'-0"

JOB NO. 09-006

DRAWING NUMBER PL3.7H

REFERENCE DRAWING A3.7H P3.7H

1 OF 1 SHEETS

Day: FILED:09-08-2010 09:00:00 AM DRAWING: PLUMBING/LEVEL 07 PL3.7H.dwg Printed By: User 10-10-2011 11:38am

Drawn
R.O.
Checked
M.M.
Date
10/10/2011
Scale
1/4" = 1' - 0"
Job No.
09-006
Drawing Number
PL3.7M
Reference Drawing
A3.7M
P3.7M
1 OF 1 SHEETS

Dwg File: Z:\09-006_CHCC\MURRAY DRAWINGS\PLUMBING\14-7\PL37M.dwg Plotted by: User 10-10-2011 11:40am