


This document and the design it covers are the property of Murray Co. They are loaned only with the borrower's expressed written agreement that they will not be reproduced, copied, loaned, exhibited, or used in any way, except by written consent from Murray Co. to the borrower.

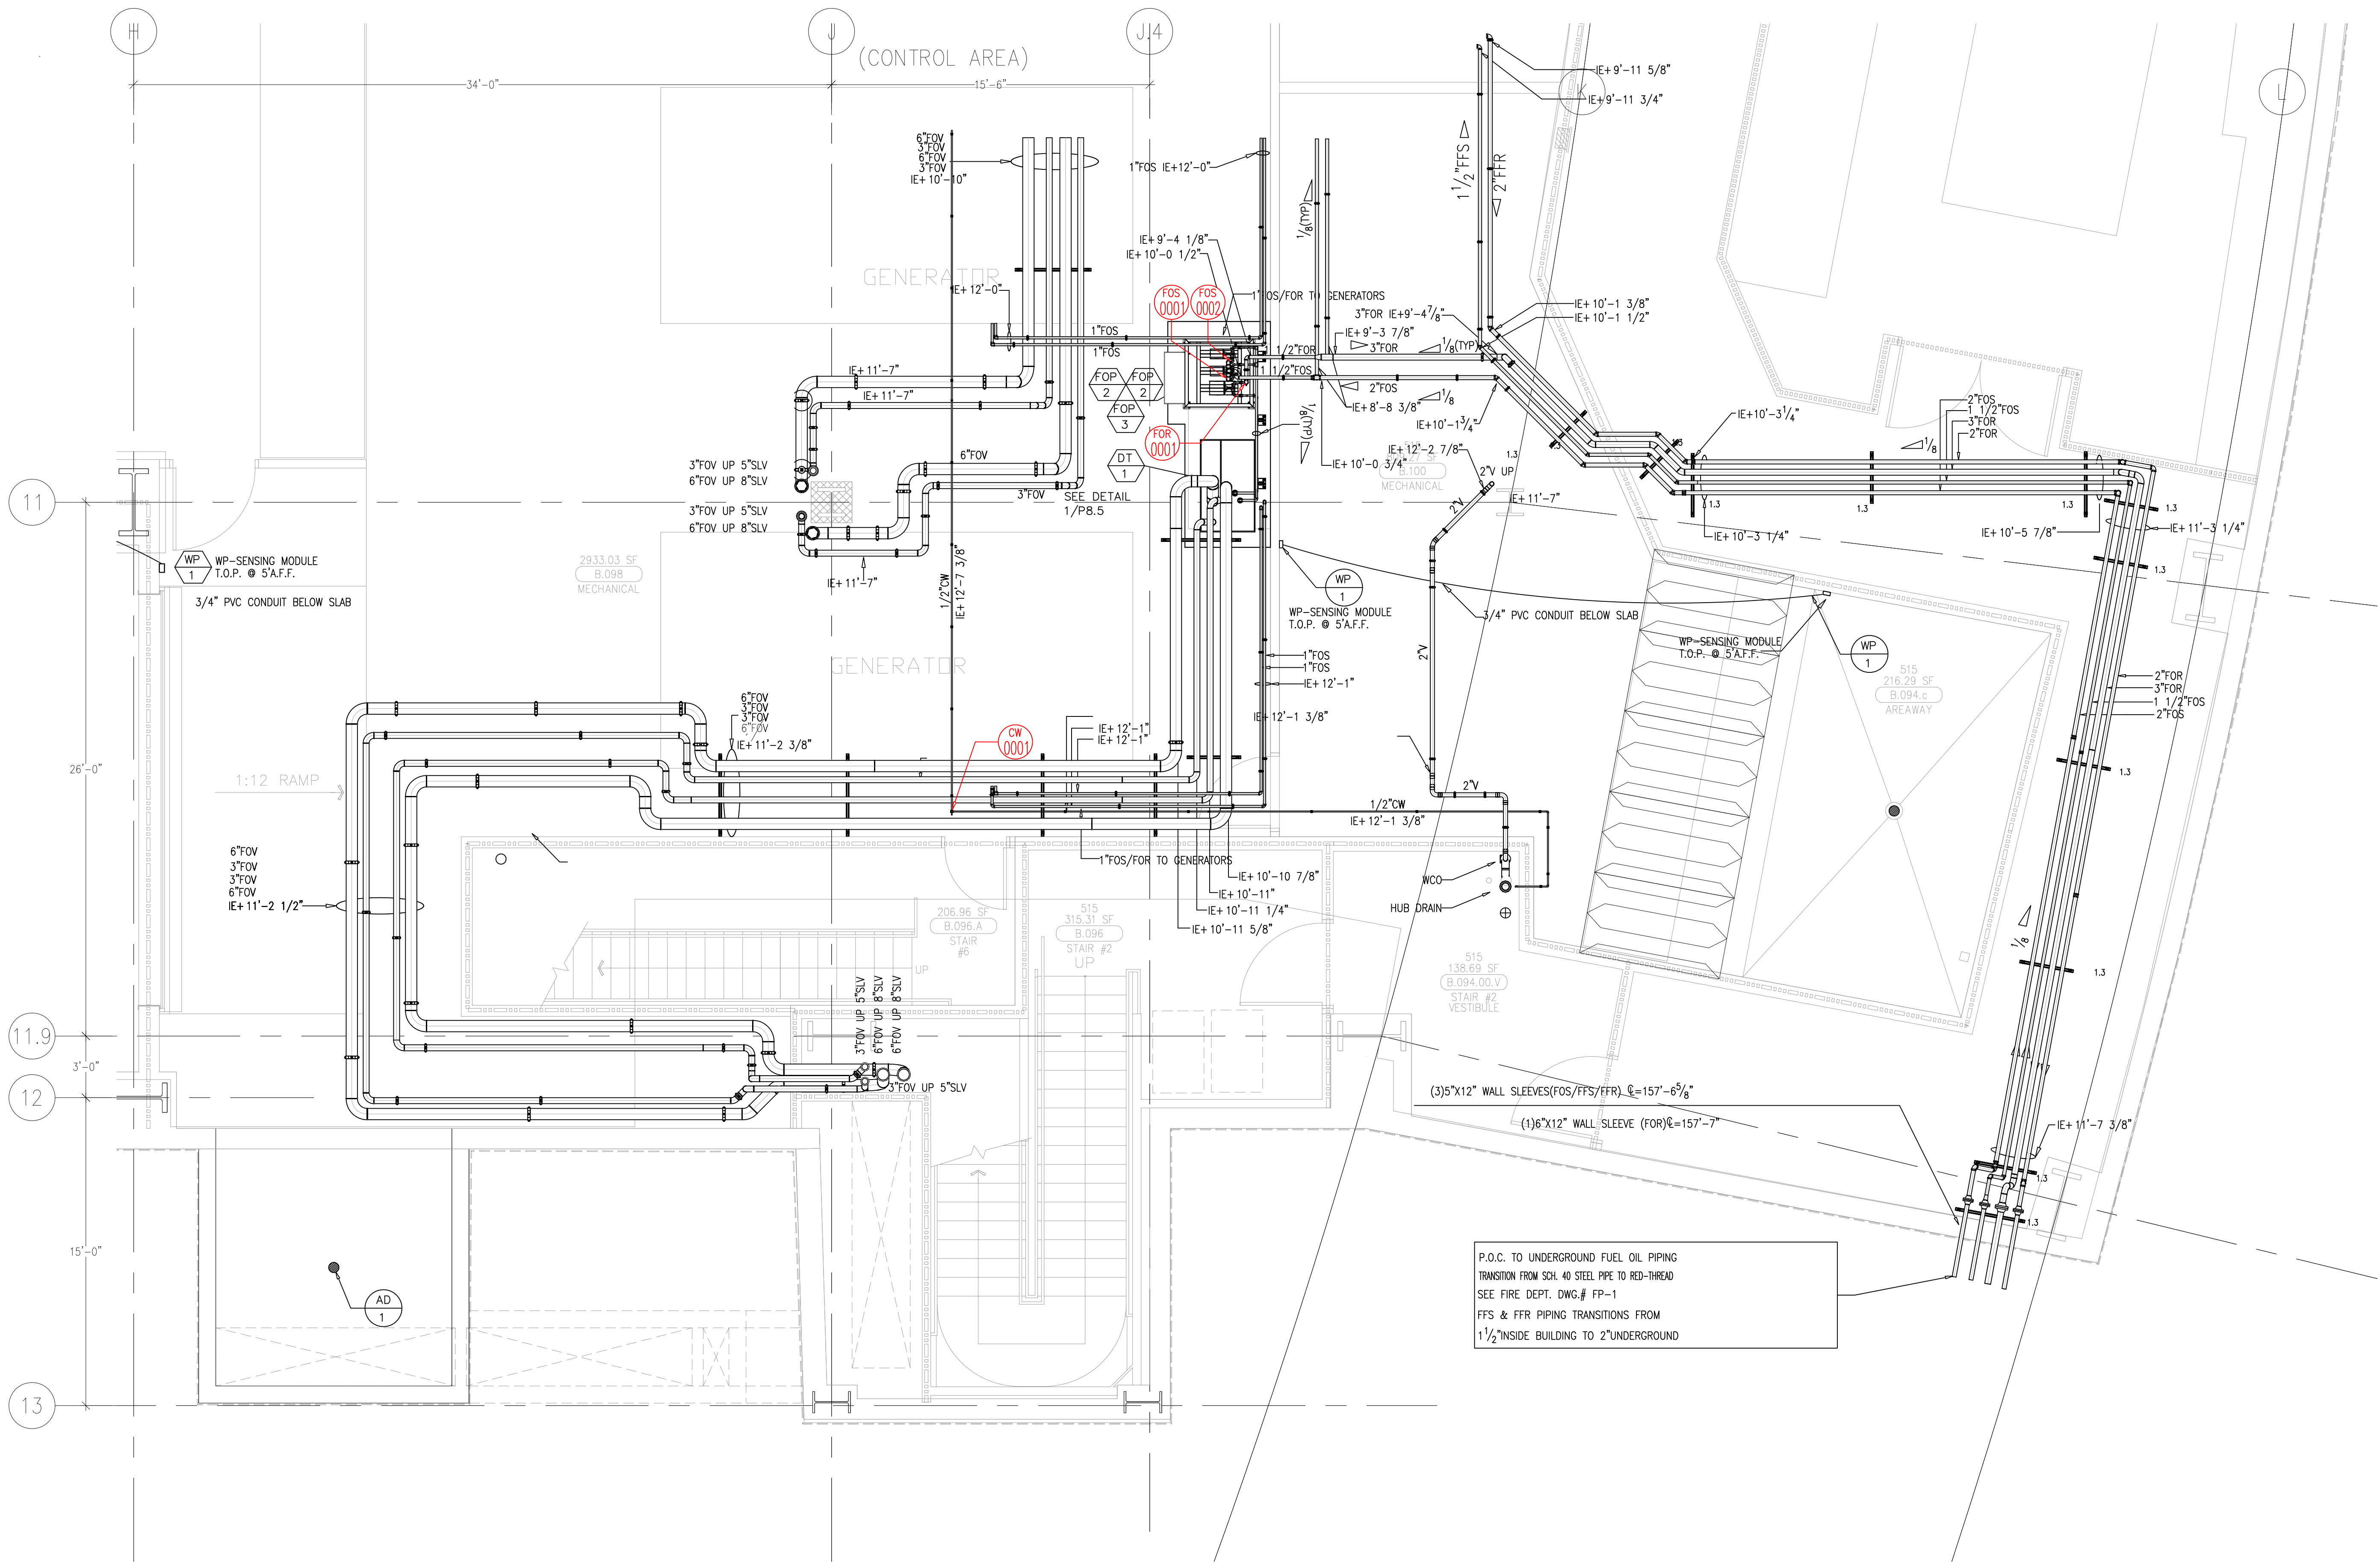

MCCARTHY APPROVAL

A. Approved as noted for Architectural Review

B. Review and Recheck

C. Rejected

This review is for general conformance with Plans and Specifications only. Any deviations from same not clearly noted by the Engineer shall not be considered. Review shall not constitute a complete check of detailed dimensions or exact compliance with the Plans or Specifications of construction responsibility for any error or deviation from contract requirements.

McCarthy

By _____ Date _____
(SHOP DRAWING REFERENCE NO.)

REVISIONS		BY
A	ISSUED FOR COORDINATION SIGN-OFF 8-18-09	DK
B	ISSUED FOR COORDINATION SIGN-OFF 10-27-09	DK
C	REVISED STANDPIPE Riser Location per FP 11-18-09	REO
D	ISSUED FOR IE-COORDINATION SIGN-OFF 2-26-10	DK
E	ISSUED FOR CONSTRUCTION 04-06-10	DK
F	REVISED PER OSHPD C0 110 PAC 0241 03-09-2011	JT
G	ISSUED FOR CONSTRUCTION 04-01-11	GP

COORD.	SIGNATURE	DATE
MECHANICAL		
PLUMBING		
ELECTRICAL		
FIRE SPRINKLER		
PIPE		
DRYWALL/FRAMER		
REPAIR/STRUCT		

R.F.I.	SENT	ANS.	R.F.I.	SENT	ANS.	R.F.I.	SENT	ANS.
004	07/05/09	04/20/09						
005	04/15/09	04/27/09						
007	04/16/09	05/06/09						
0041	04/22/09	04/29/09						
0039	08/27/09	10/15/09						
0035	10/21/09	10/26/09						

CHILDREN'S HOSPITAL
CHOCTM OF ORANGE COUNTY
HOSPITAL
455 S. MAIN ST.
ORANGE, CA 92668-3974

TOWER II

PLUMBING FLOOR PLAN - LEVEL 00 AREA A

PAN-PACIFIC
PLUMBING & MECHANICAL

2919 E. VICTORIA STREET, RANCHO DOMINGUEZ, CA 90221
PH. 310.637-1500 FAX 310.604-0359

PAN-PACIFIC
PLUMBING & MECHANICAL

company

2919 E. VICTORIA STREET, RANCHO DOMINGUEZ, CA 90221
PH. 310.637-1500 FAX 310.604-0359

DRAWN
R.O.

CHECKED
M.M.

DATE
4/30/2012

SCALE
1/4" = 1'-0"

JOB NO.


09-006

DRAWING NUMBER
PL3.0A

REFERENCE DRAWING
A3.0A
P3.0A

1 OF 1 SHEETS

This document and the design it covers are the property of Murray Co. They are loaned only with the borrower's expressed written agreement that they will not be reproduced, copied, loaned, exhibited, or used in any other way, except by written consent from Murray Co. to the borrower.

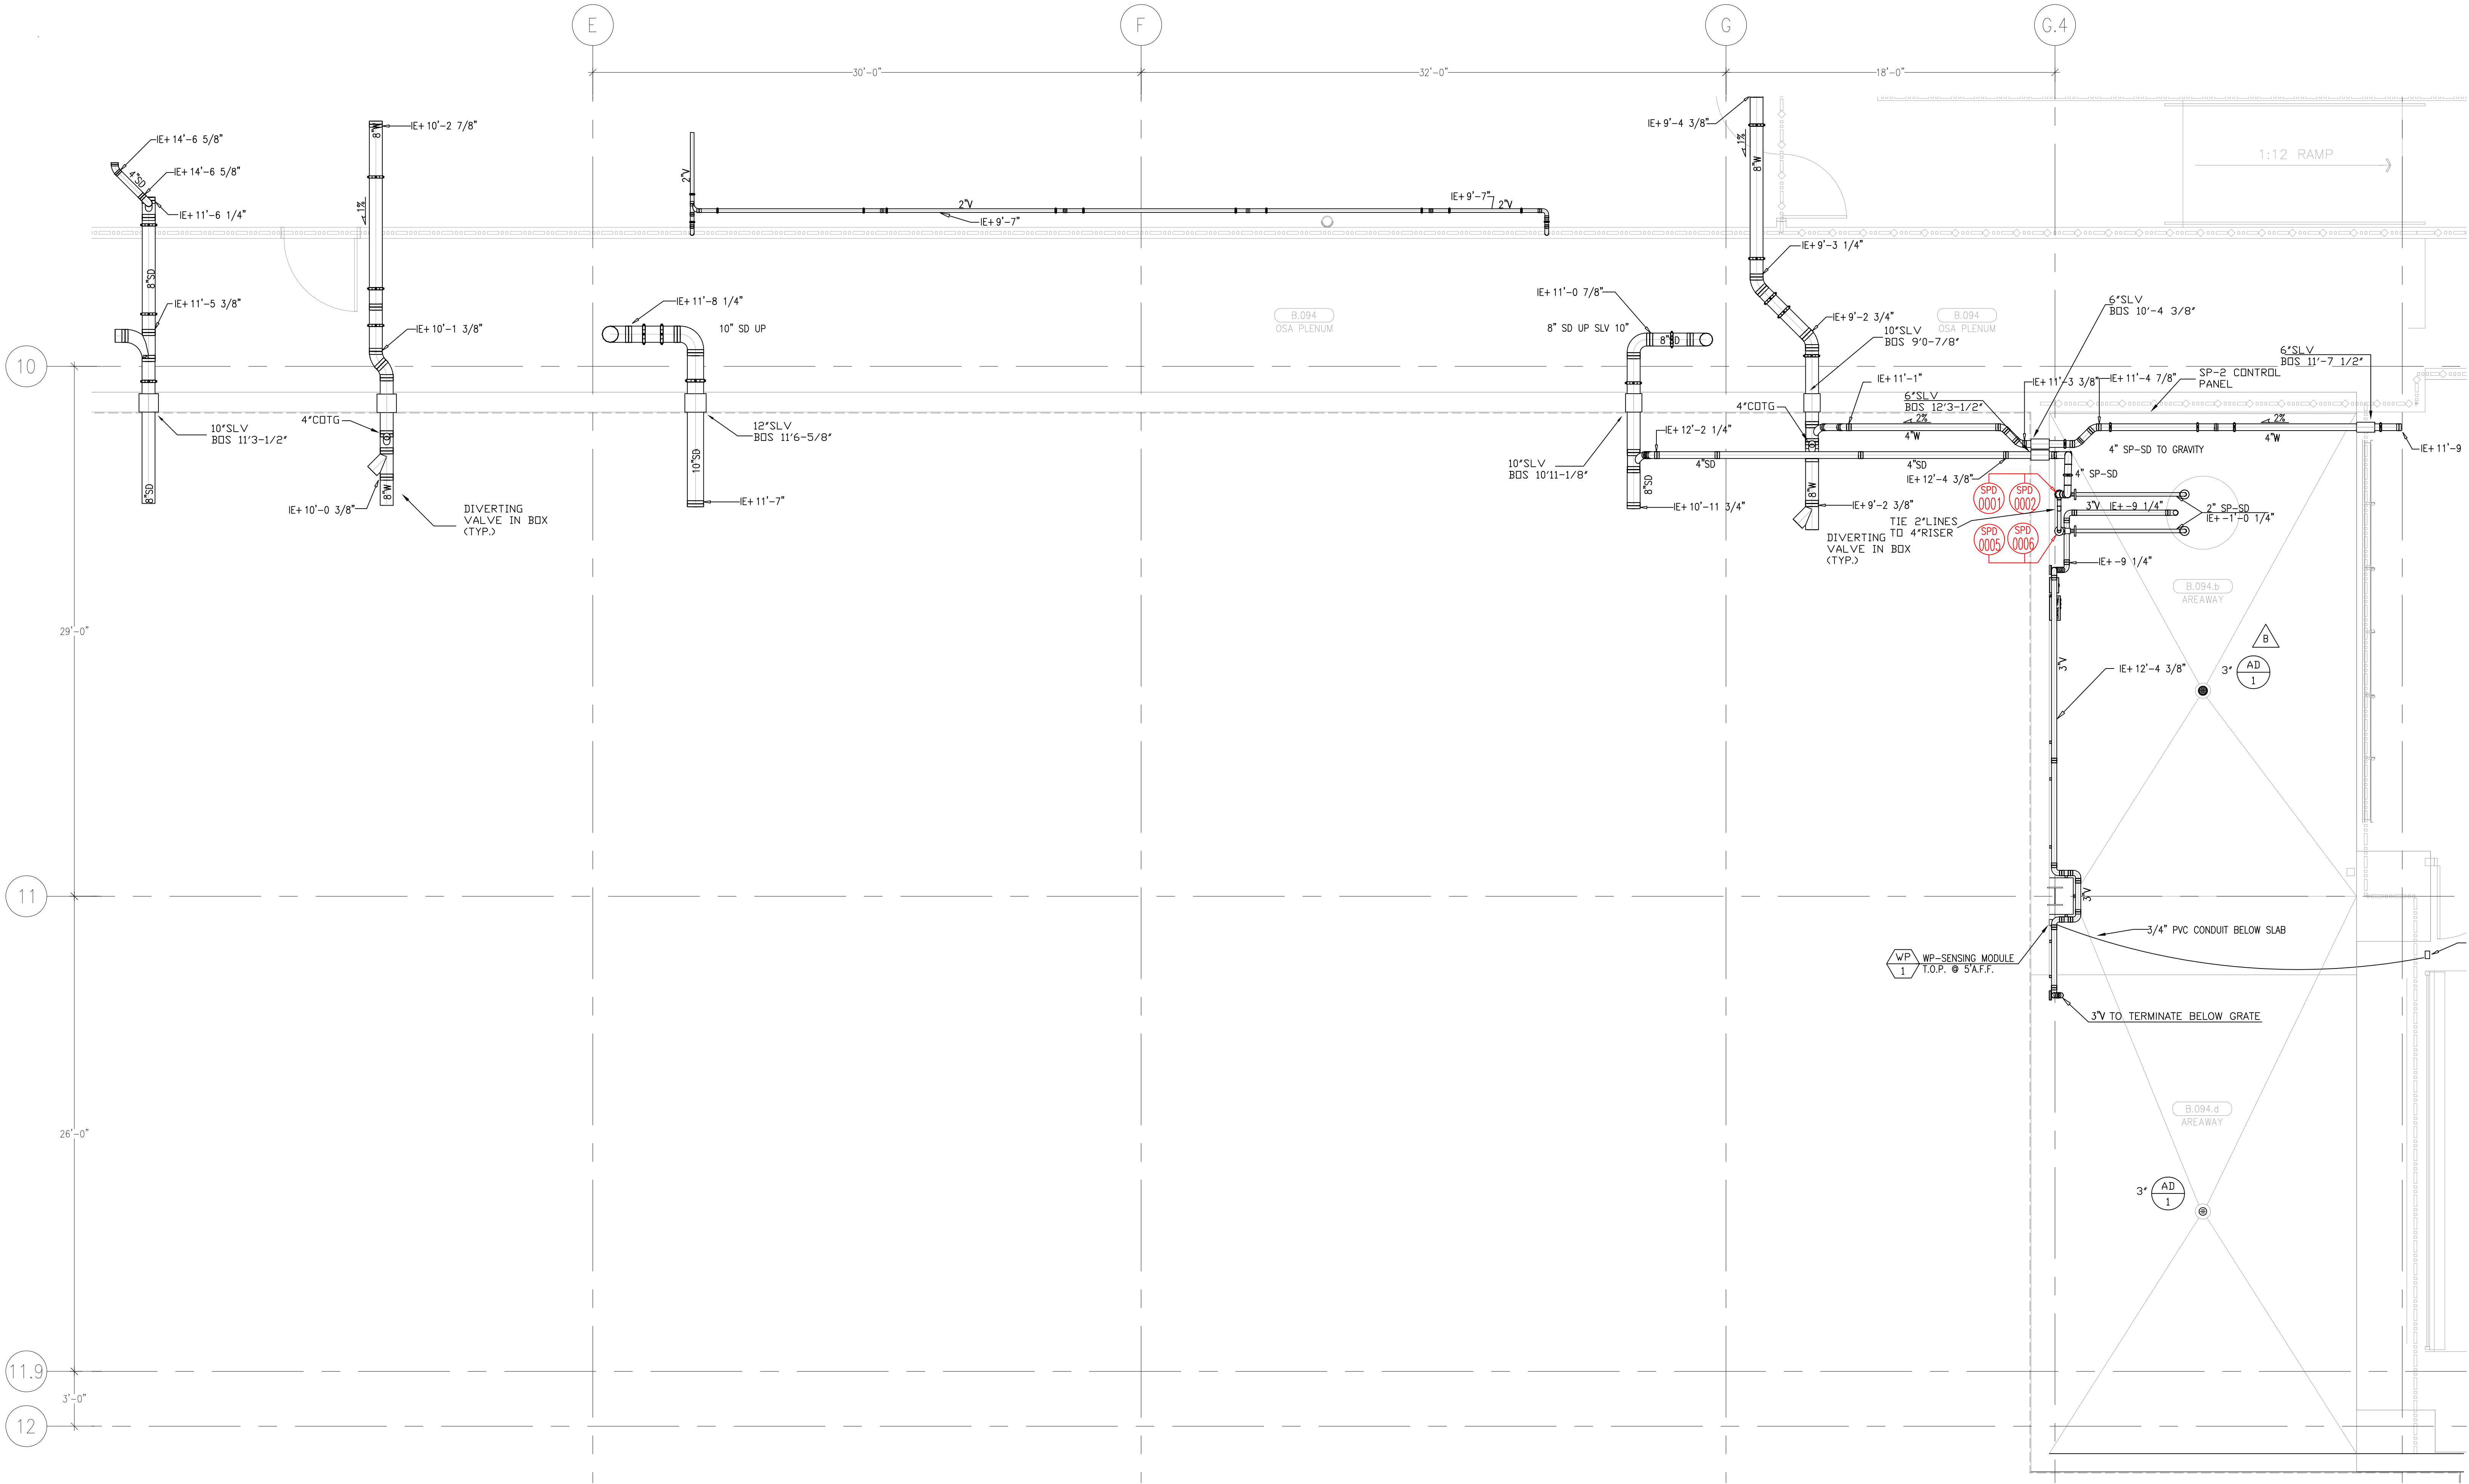

MCCARTHY APPROVAL

A. Approved as noted for Architectural Review

B. Review and Resubmit

C. Rejected

This review is for general conformance with Plans and Specifications only. Any deviations from same not clearly noted by the Proprietor have not been reviewed. Review shall not constitute a complete check of detailed dimensions or count to serve to release the Proprietor of contractual responsibility for any error or deviation from contract requirements.

McCarthy

By: _____ Date: _____

SHOP DRAWING REFERENCE NO. _____

LEVEL 00 144.30' = 0'-0"
REFERENCE THIS SHEET

REVISIONS		BY
A	FWP	JT
B	ISSUED FOR COORDINATION	DK
C	ISSUED FOR COORDINATION	DK
D	ISSUED FOR RE-COORDINATION	DK
E	ISSUED FOR CONSTRUCTION	DK
F	REVISED FOR CON. RFI	DK
G	REVISED SLOPE TO 2%	DK
H	ADDED SLOPE NOTATIONS	DK
I	ADDED VENT LINE	MO

COORD.	SIGNATURE	DATE
MECHANICAL		
ELECTRICAL		
PLUMBING		
STRUCTURAL		


R.F.I.	SENT	ANS.	R.F.I.	SENT	ANS.
004	07/09/09	04/20/09			
005	04/24/09	05/01/09			
039	08/27/09	10/15/09			
055	10/21/09	10/26/09			
CON	1261	04/14/10			

CHILDREN'S HOSPITAL
OF ORANGE COUNTY
455 S. MAIN ST.
ORANGE, CA 92668-5874
TOWER II
PLUMBING FLOOR PLAN - LEVEL 00 AREA-B

PAN-PACIFIC
PLUMBING & MECHANICAL
2919 E. VICTORIA STREET, RANCHO DOMINGUEZ, CA 90221
PH. 310.637-1500 FAX 310.604-0359

DRAWN
R.O.
CHECKED
M.M.
DATE
4/30/2012
SCALE
1/4" = 1'-0"
JOB NO.
09-006
DRAWING NUMBER
PL3.0B
REFERENCE DRAWING
A3.0B
P3.0B
1 OF 1 SHEETS

This document and the design it covers are the property of Murray Co. They are loaned only with the borrower's expressed written agreement that they will not be reproduced, copied, loaned, exhibited, or used in any other way, except by written consent from Murray Co. to the borrower.

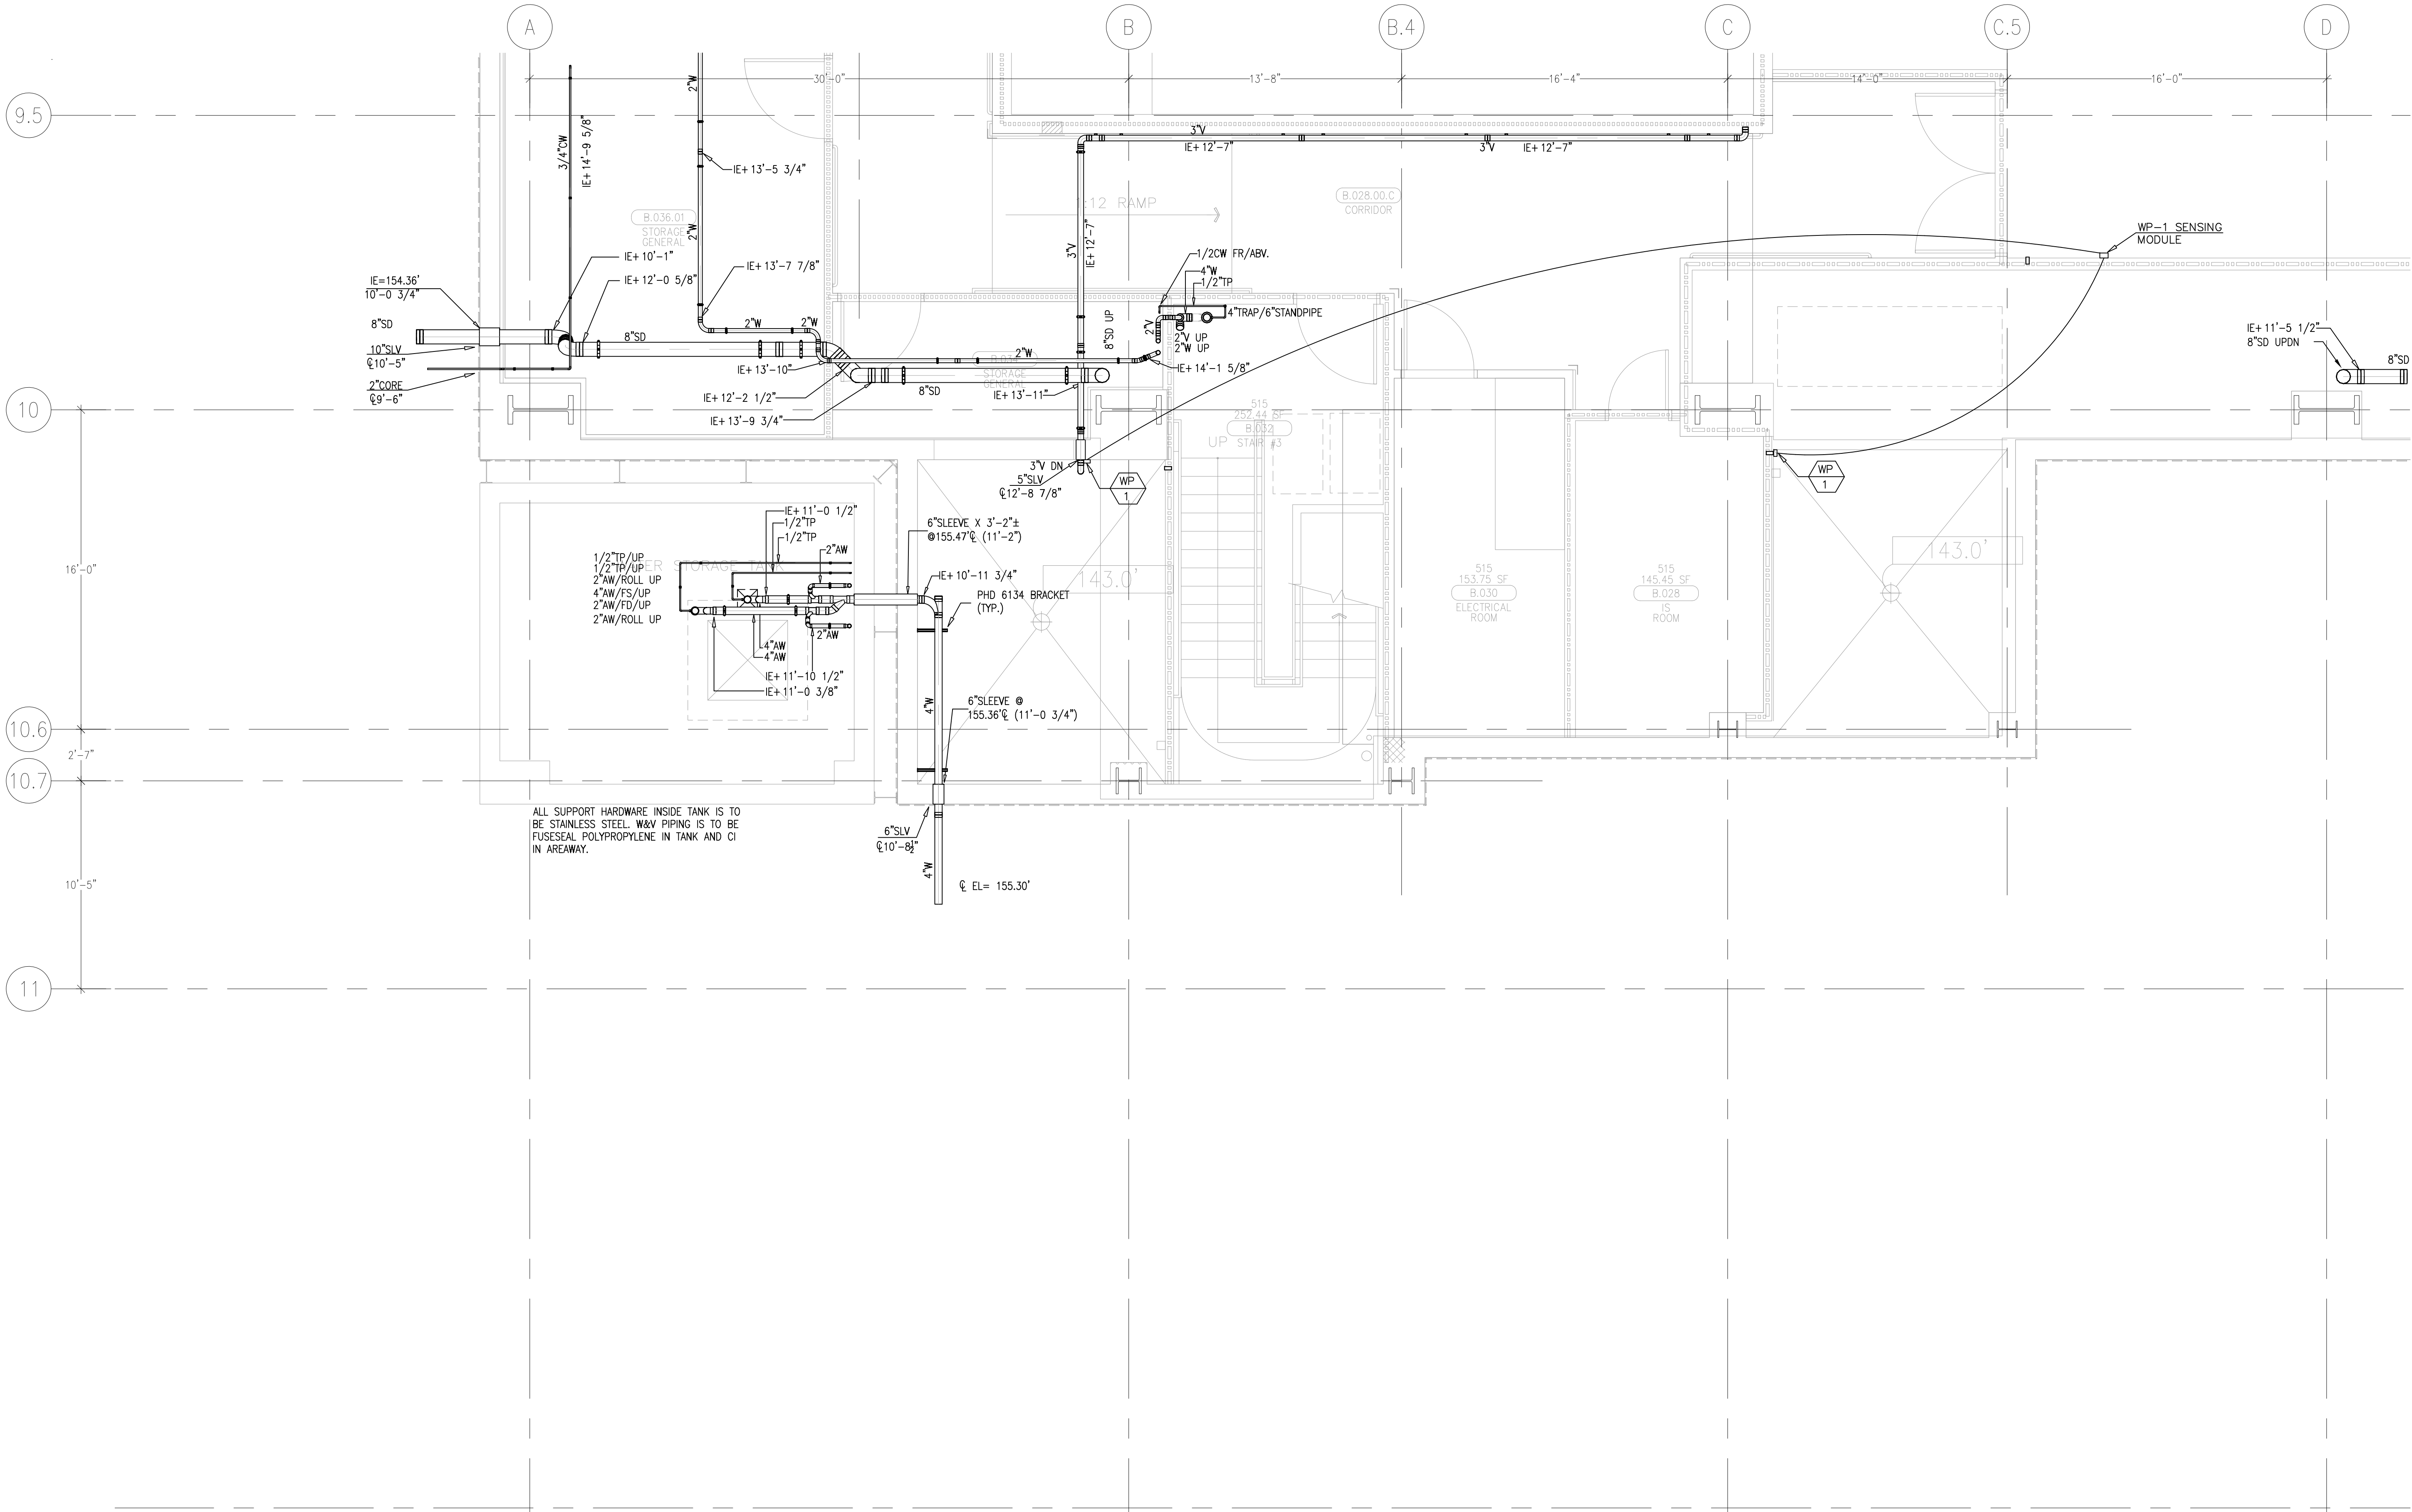

- ISSUED FOR COORDINATION SIGN-OFF 8-18-09 DK
- ISSUED FOR COORDINATION SIGN-OFF 10-27-09 DK
- REVISED STANDPIPE REPER LOCATION PER FP 11-18-09 REO
- REVISED PLUMBING PER FIRE PUMP ROOM 01-26-10 DK
- ISSUED FOR RE-COORDINATION SIGN-OFF 2-26-10 DK
- REVISED STORM DRAIN AND SANITARY LINE 3-23-10 DK
- ISSUED FOR CONSTRUCTION 04-08-10 DK

REVISIONS		BY
1	REVISED VENT LINE 05/26/2010	JT
2	LOWEDED SD DUE TO GRADE ISSUES OUTSIDE 10-12-10	DK
3	REROUTED DW PER RFI 3939 RESPONSE 02-11-11	DK

COORD.	SIGNATURE	DATE
MECHANICAL		
ELECTRICAL		
PLUMBING		
STRUCTURAL		

R.F.I.	SENT	ANS.	R.F.I.	SENT	ANS.	R.F.I.	SENT	ANS.
0174	09/09/09	06/16/09						

CHILDREN'S HOSPITAL CHOC OF ORANGE COUNTY
155 S. MAIN ST. ORANGE, CA 92668-3974
TOWER II
PLUMBING FLOOR PLAN - LEVEL 00 AREA-C

PAN-PACIFIC
PLUMBING & MECHANICAL
2919 E. VICTORIA STREET, RANCHO DOMINGUEZ, CA 90221
PH. 310.637-1500 FAX 310.604-0359

DRAWN R.O.
CHECKED M.M.
DATE 4/30/2012
SCALE 1/4" = 1'-0"
JOB NO. 09-006
DRAWING NUMBER PL3.0C
REFERENCE DRAWING A3.0C P3.0C
1 OF 1 SHEETS

MCCARTHY APPROVAL

A. Approved as noted for Architectural Review

B. Review and Recheck

C. Rejected


This review is for general conformance with Plans and Specifications only. Any deviations from same not clearly noted by the Designer shall not be reviewed. Review shall not constitute a complete check of detailed dimensions or shall be used to relieve the Designer of contractual responsibility for any error or deviation from contract requirements.

McCarthy


By _____ Date _____

SHOP DRAWING REFERENCE NO. _____

LEVEL 00 144.30' = 0'-0"
REFERENCE THIS SHEET

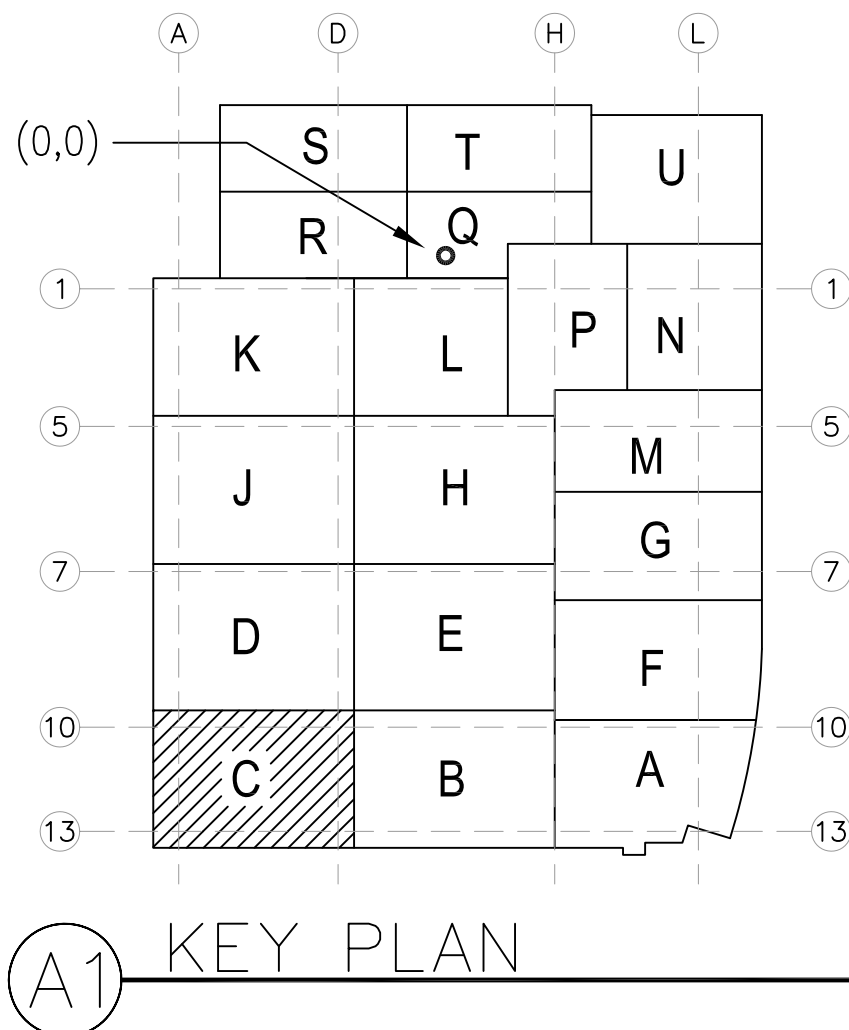

This document and the design it covers are the property of Murray Co. They are loaned only with the borrower's expressed written agreement that they not be reproduced, copied, loaned, exhibited, or used in any way, except by written consent from Murray Co. to the borrower.

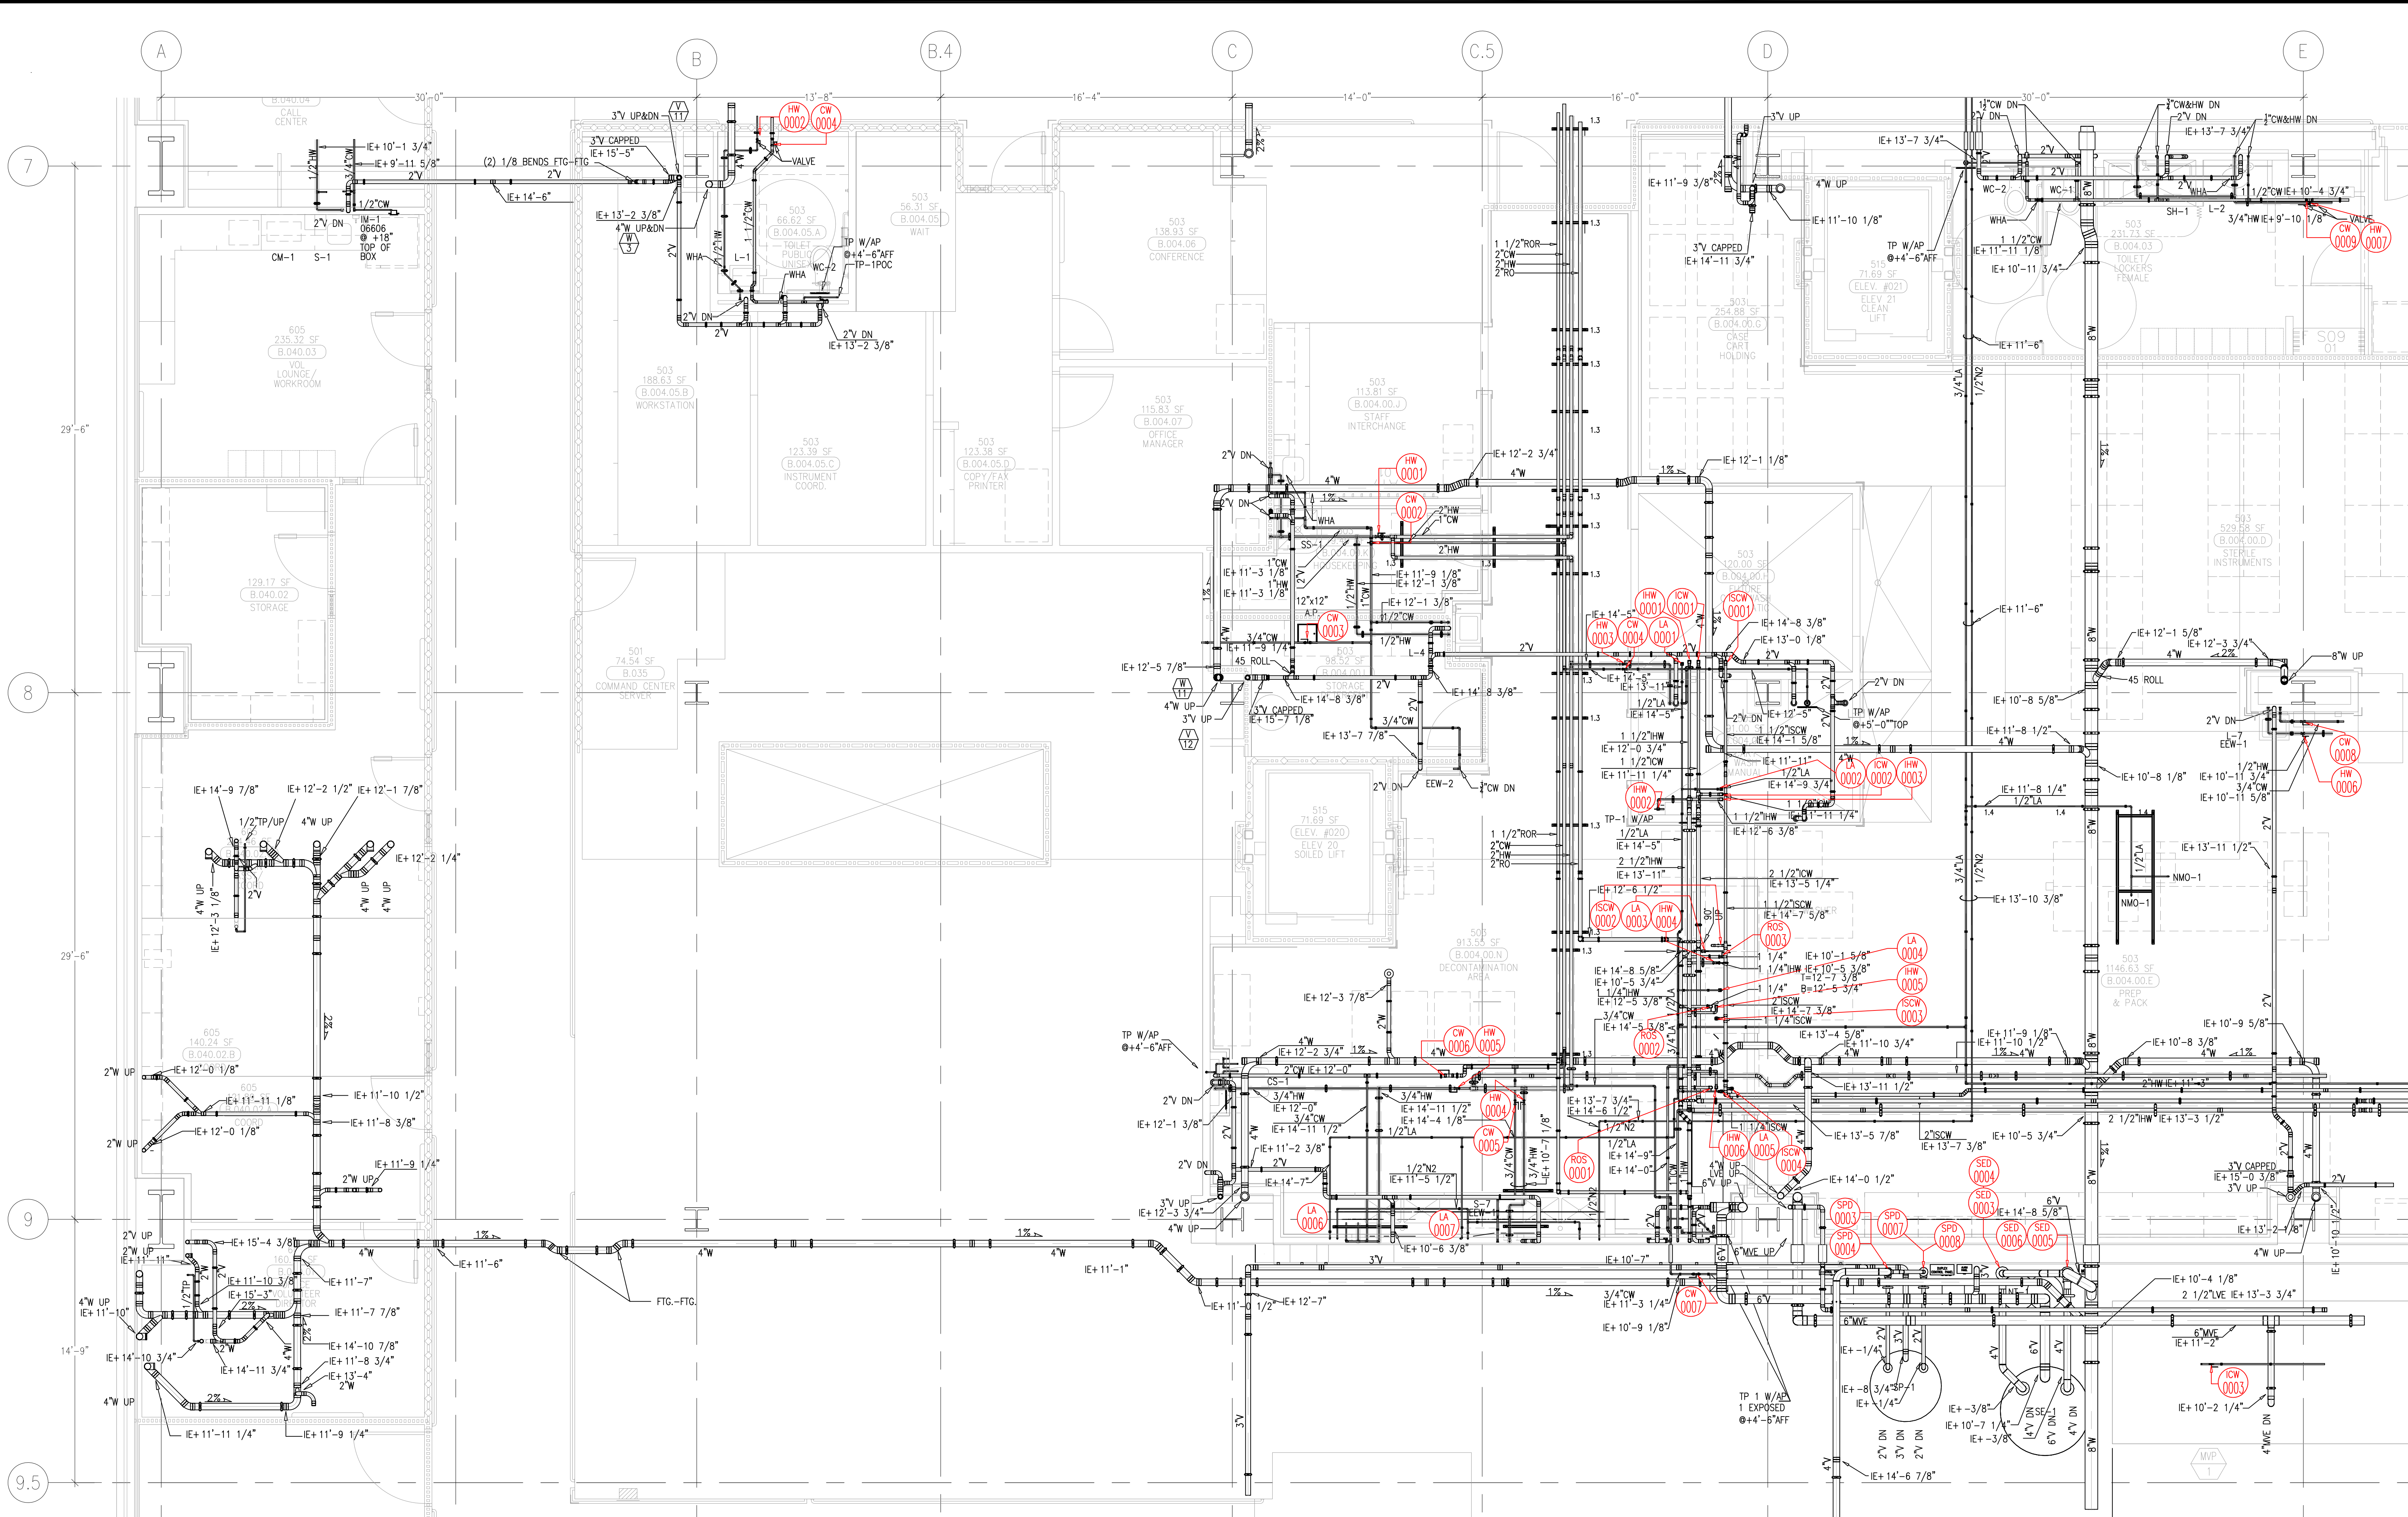

ISSUED FOR COORDINATION
SIGN-OFF 9-18-09
DK

ISSUED FOR COORDINATION
SIGN-OFF 10-27-09
DK

INCORPORATED RFI RESPONSE
1-25-10
REO

ISSUED FOR RE-COORDINATION
SIGN-OFF 2-28-10
DK

ISSUED FOR CONSTRUCTION
03-08-10
DK

REVISED VENT LINE
06/26/2010
JT

REVISED WASTE SLOPE
PER DRAINERS REQUEST
5/28/2010
JT

REVISED MVE DUE TO
RELOCATED SLEEVES
6/16-10
DK

REVISED PER ICE MAKER
ROUGH-IN
11-24-10
OFFSET WASTE AROUND
KING STUD
12-20-10
ADDED SLOPE NOTION TO
WASTE LINES.
01-12-11
JT

REVISIONS	BY
1. ADDED WASTE BRBS PER COW 108 01-28-11 JT	JT
2. REVISED DUE TO COW#3 05-08-10 GP	GP
3. REVISED DUE TO COW#3 05-08-10 JT	JT
4. REVISED DUE TO COW#75 05-08-10 DK	DK
5. REVISED DUE TO COW#75 05-08-10 DK	DK

COORD.	SIGNATURE	DATE
MECHANICAL		
ELECTRICAL		
PLUMBING		
STRUCTURAL		

R.F.I.	SENT	ANS.	R.F.I.	SENT	ANS.	R.F.I.	SENT	ANS.
0022	04/13/09	04/20/09	0076	04/30/09	07/08/09	0174	06/05/09	06/19/09
0028	04/13/09	05/27/09	0078	05/07/09	06/02/09	0304	06/19/09	06/24/09
0034	04/16/09	04/29/09	0081	05/07/09	05/06/09	0312	06/19/09	06/19/09
0036	04/16/09	04/30/09	0082	05/07/09	05/06/09	0360	06/19/09	06/19/09
0043	04/22/09	04/30/09	0083	05/07/09	05/13/09	0440	06/29/09	06/29/09
0061	04/24/09	05/07/09	0131R1	05/29/09	07/08/09	0484	06/30/09	06/30/09
0068	04/27/09	05/07/09	0159	06/07/09	06/11/09	0530	10/19/09	10/26/09

CHILDREN'S HOSPITAL
CHOC OF ORANGE COUNTY
TOWER II
PLUMBING FLOOR PLAN - LEVEL 00 AREAD

PAN-PACIFIC
PLUMBING & MECHANICAL
2919 E. VICTORIA STREET, RANCHO DOMINGUEZ, CA 90221
PH. 310 637-1500 FAX 310 604-0359

DRAWN
R.O.
CHECKED
M.M.
DATE
4/30/2012
SCALE
1/4" = 1'-0"
JOB NO.
09-006
DRAWING NUMBER
PL3.0D
REFERENCE DRAWING
A3.0D
P3.0D
1 OF 1 SHEETS


MCCARTHY APPROVAL

A. Approved as noted for Architectural Review
B. Review and Rejected
C. Rejected

This module is for general coordination with Plans and Specifications only. Any deviations from same not clearly noted by the Preparer must not be required. Review shall not constitute a complete check of detailed dimensions or detail to serve as release the Preparer of contractual responsibility for any error or deviation from contract requirements.


McCarthy

By _____ Date _____
SHOP DRAWING REFERENCE NO. _____

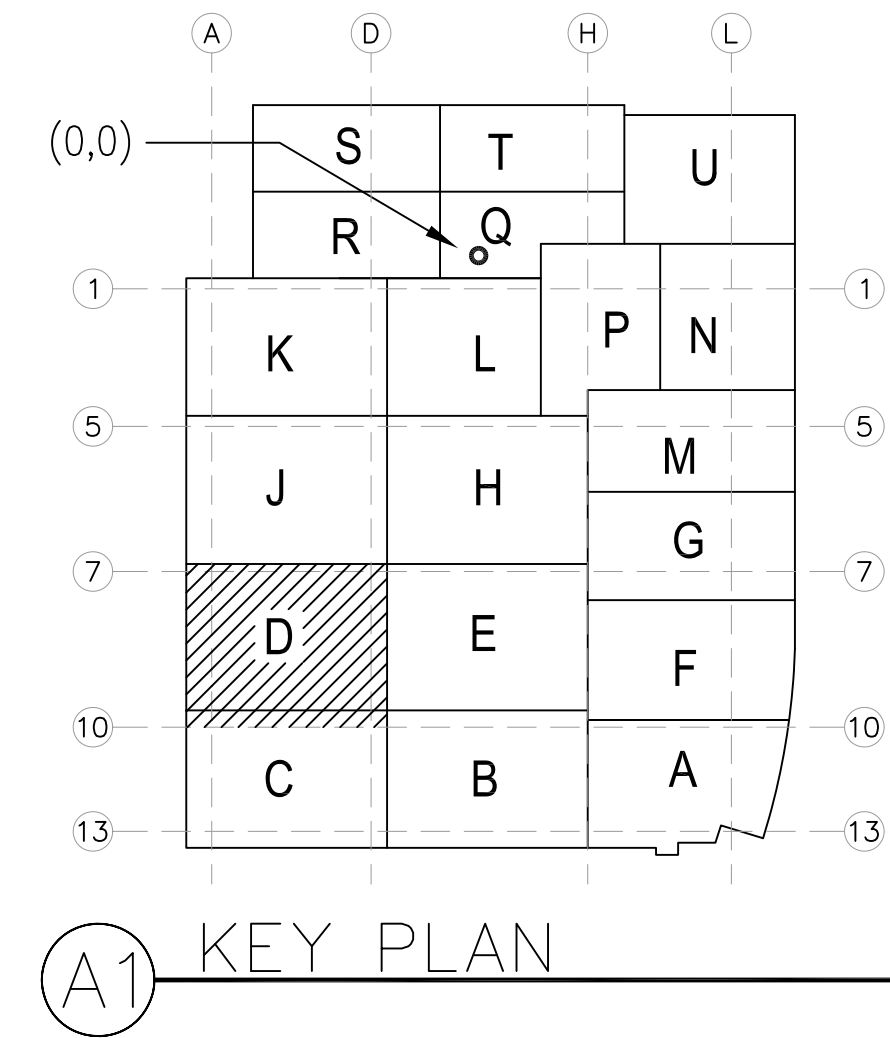

LEVEL 00 144.30' = 0'-0"
REFERENCE THIS SHEET

This document and the design it covers are the property of Murray Co. They are loaned only with the borrower's expressed written agreement that they will not be reproduced, copied, loaned, exhibited, or used in any other way, except by written consent from Murray Co. to the borrower.

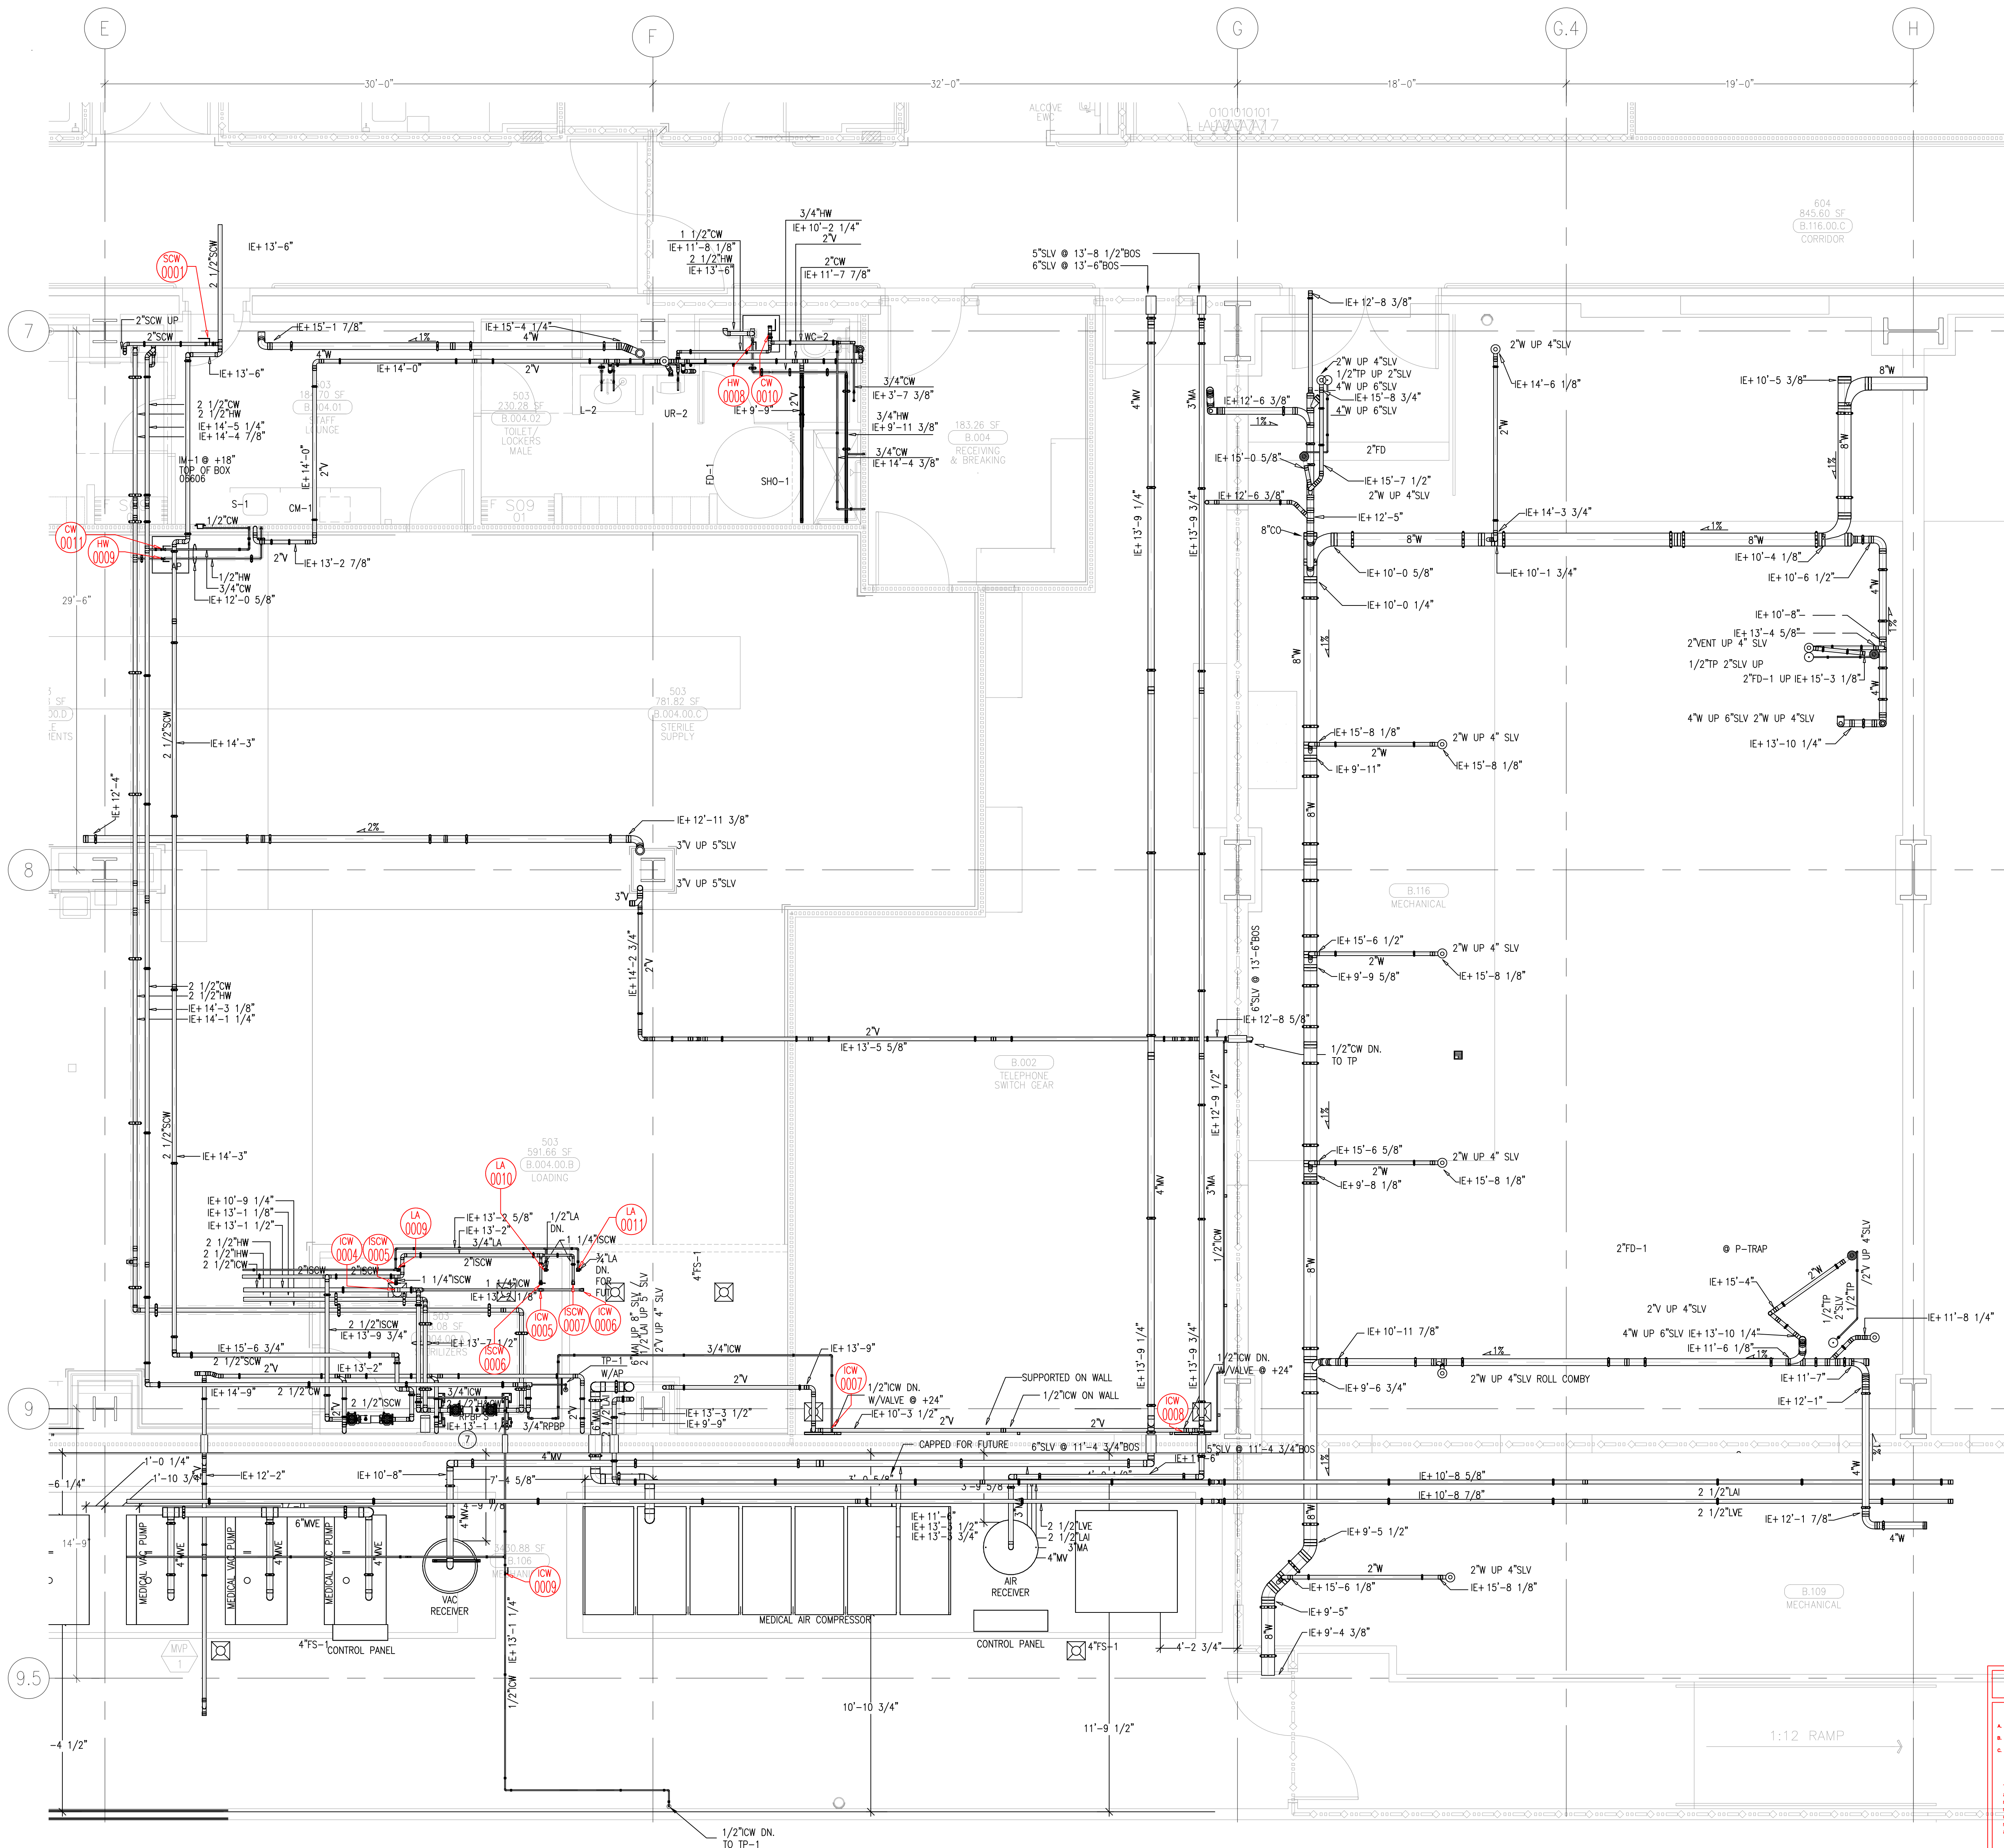

- KEY NOTES :
- ⑦ 2 1/2" RFBP ON WALL AT MAX 60" A.F.F. PROVIDE FIXED AIR GAP & SPILL DRAIN TO NEAREST APPROVED RECEPTOR
 - ⑧ 1 1/4" ICW. STUBBED ABOVE CLG. FOR FUTURE CONNECTION
 - ⑨ 1 1/4" ICW. STUBBED DN. W/BALL VALVE TO STERILIZER


MCCARTHY APPROVAL

A. Approved as noted for Architectural Review
B. Review and Record
C. Rejected

This review is for general conformance with Plans and Specifications only. Any deviation from same not clearly noted by the Engineer has not been reviewed. Review and not constitute a warranty check of detailed dimensions or count to same to release the Engineer of contractual responsibility for any error or deviation from contract requirements.

McCarthy

By: _____ Date: _____
SHOP DRAWING REFERENCE NO. _____

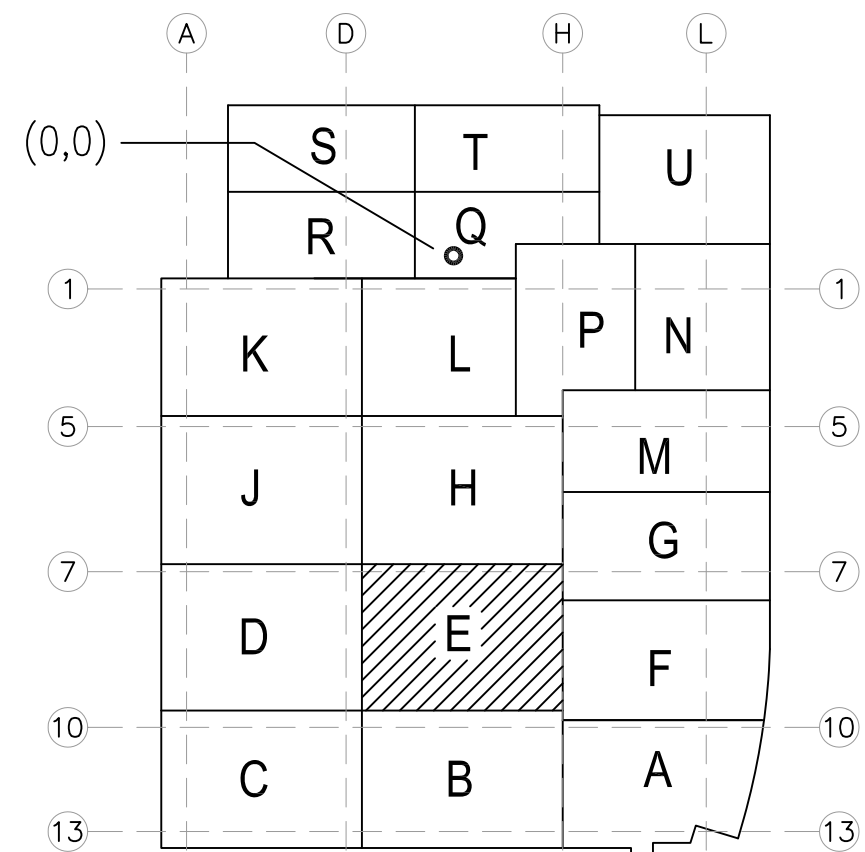

KEY PLAN

LEVEL 00 144.30' = 0'-0"
REFERENCE THIS SHEET

A	ISSUED FOR COORDINATION SIGN-OFF 9-18-09	DK
B	FEMP SIGN-OFF 9-18-09	JT
C	ISSUED FOR COORDINATION SIGN-OFF 10-27-09	DK
D	ISSUED FOR RE-COORDINATION SIGN-OFF 2-26-10	DK
E	ISSUED FOR CONSTRUCTION 04-07-10	DK
F	REVISED WASTE SLOPE PER ENGINEERS REQUEST 05-08-10	GP
G	REVISED WASTE SLOPE PER ENGINEERS REQUEST 5/28/2010	JT

REVISIONS	BY
1	DK
2	DK
3	JT
4	JT
5	DK
6	GP
7	DK

COORD.	SIGNATURE	DATE
MECHANICAL		
PLUMBING		
ELECTRICAL		
FIRE SPRINKLER		
PIPE		
DRAIN/WASTE/VENT		
REFRIGERATION		
STRUCTURAL		

R.F.I.	SENT	ANS.	R.F.I.	SENT	ANS.	R.F.I.	SENT	ANS.
0031	04/17/09	04/20/09						
0075	04/20/09	05/05/09						
0205	06/19/09	08/21/09						
0207	06/19/09	09/09/09						
0209F	09/01/09	09/11/09						
0418	09/29/09	10/13/09						
0439	09/29/09	10/14/09						

**CHILDREN'S HOSPITAL
OF ORANGE COUNTY**
455 S. MAIN ST., SUITE 900
ORANGE, CA 92668-3974


TOWER II

PLUMBING FLOOR PLAN - LEVEL 00 ARENA

PAN-PACIFIC
PLUMBING & MECHANICAL
2919 E. VICTORIA STREET, RANCHO DOMINGUEZ, CA 90221
PH. 310.637-1500 FAX 310.604-0359

DRAWN
R.O.
CHECKED
M.M.
DATE
4/30/2012
SCALE
1/4" = 1'-0"
JOB NO.
09-006
DRAWING NUMBER
PL3.0E
REFERENCE DRAWING
A3.0E
P3.0E
1 OF 1 SHEETS

This document and the design it covers are the property of Murray Co. They are loaned only with the borrower's expressed written agreement that they will not be reproduced, copied, loaned, exhibited, or used in any other way, except by written consent from Murray Co. to the borrower.

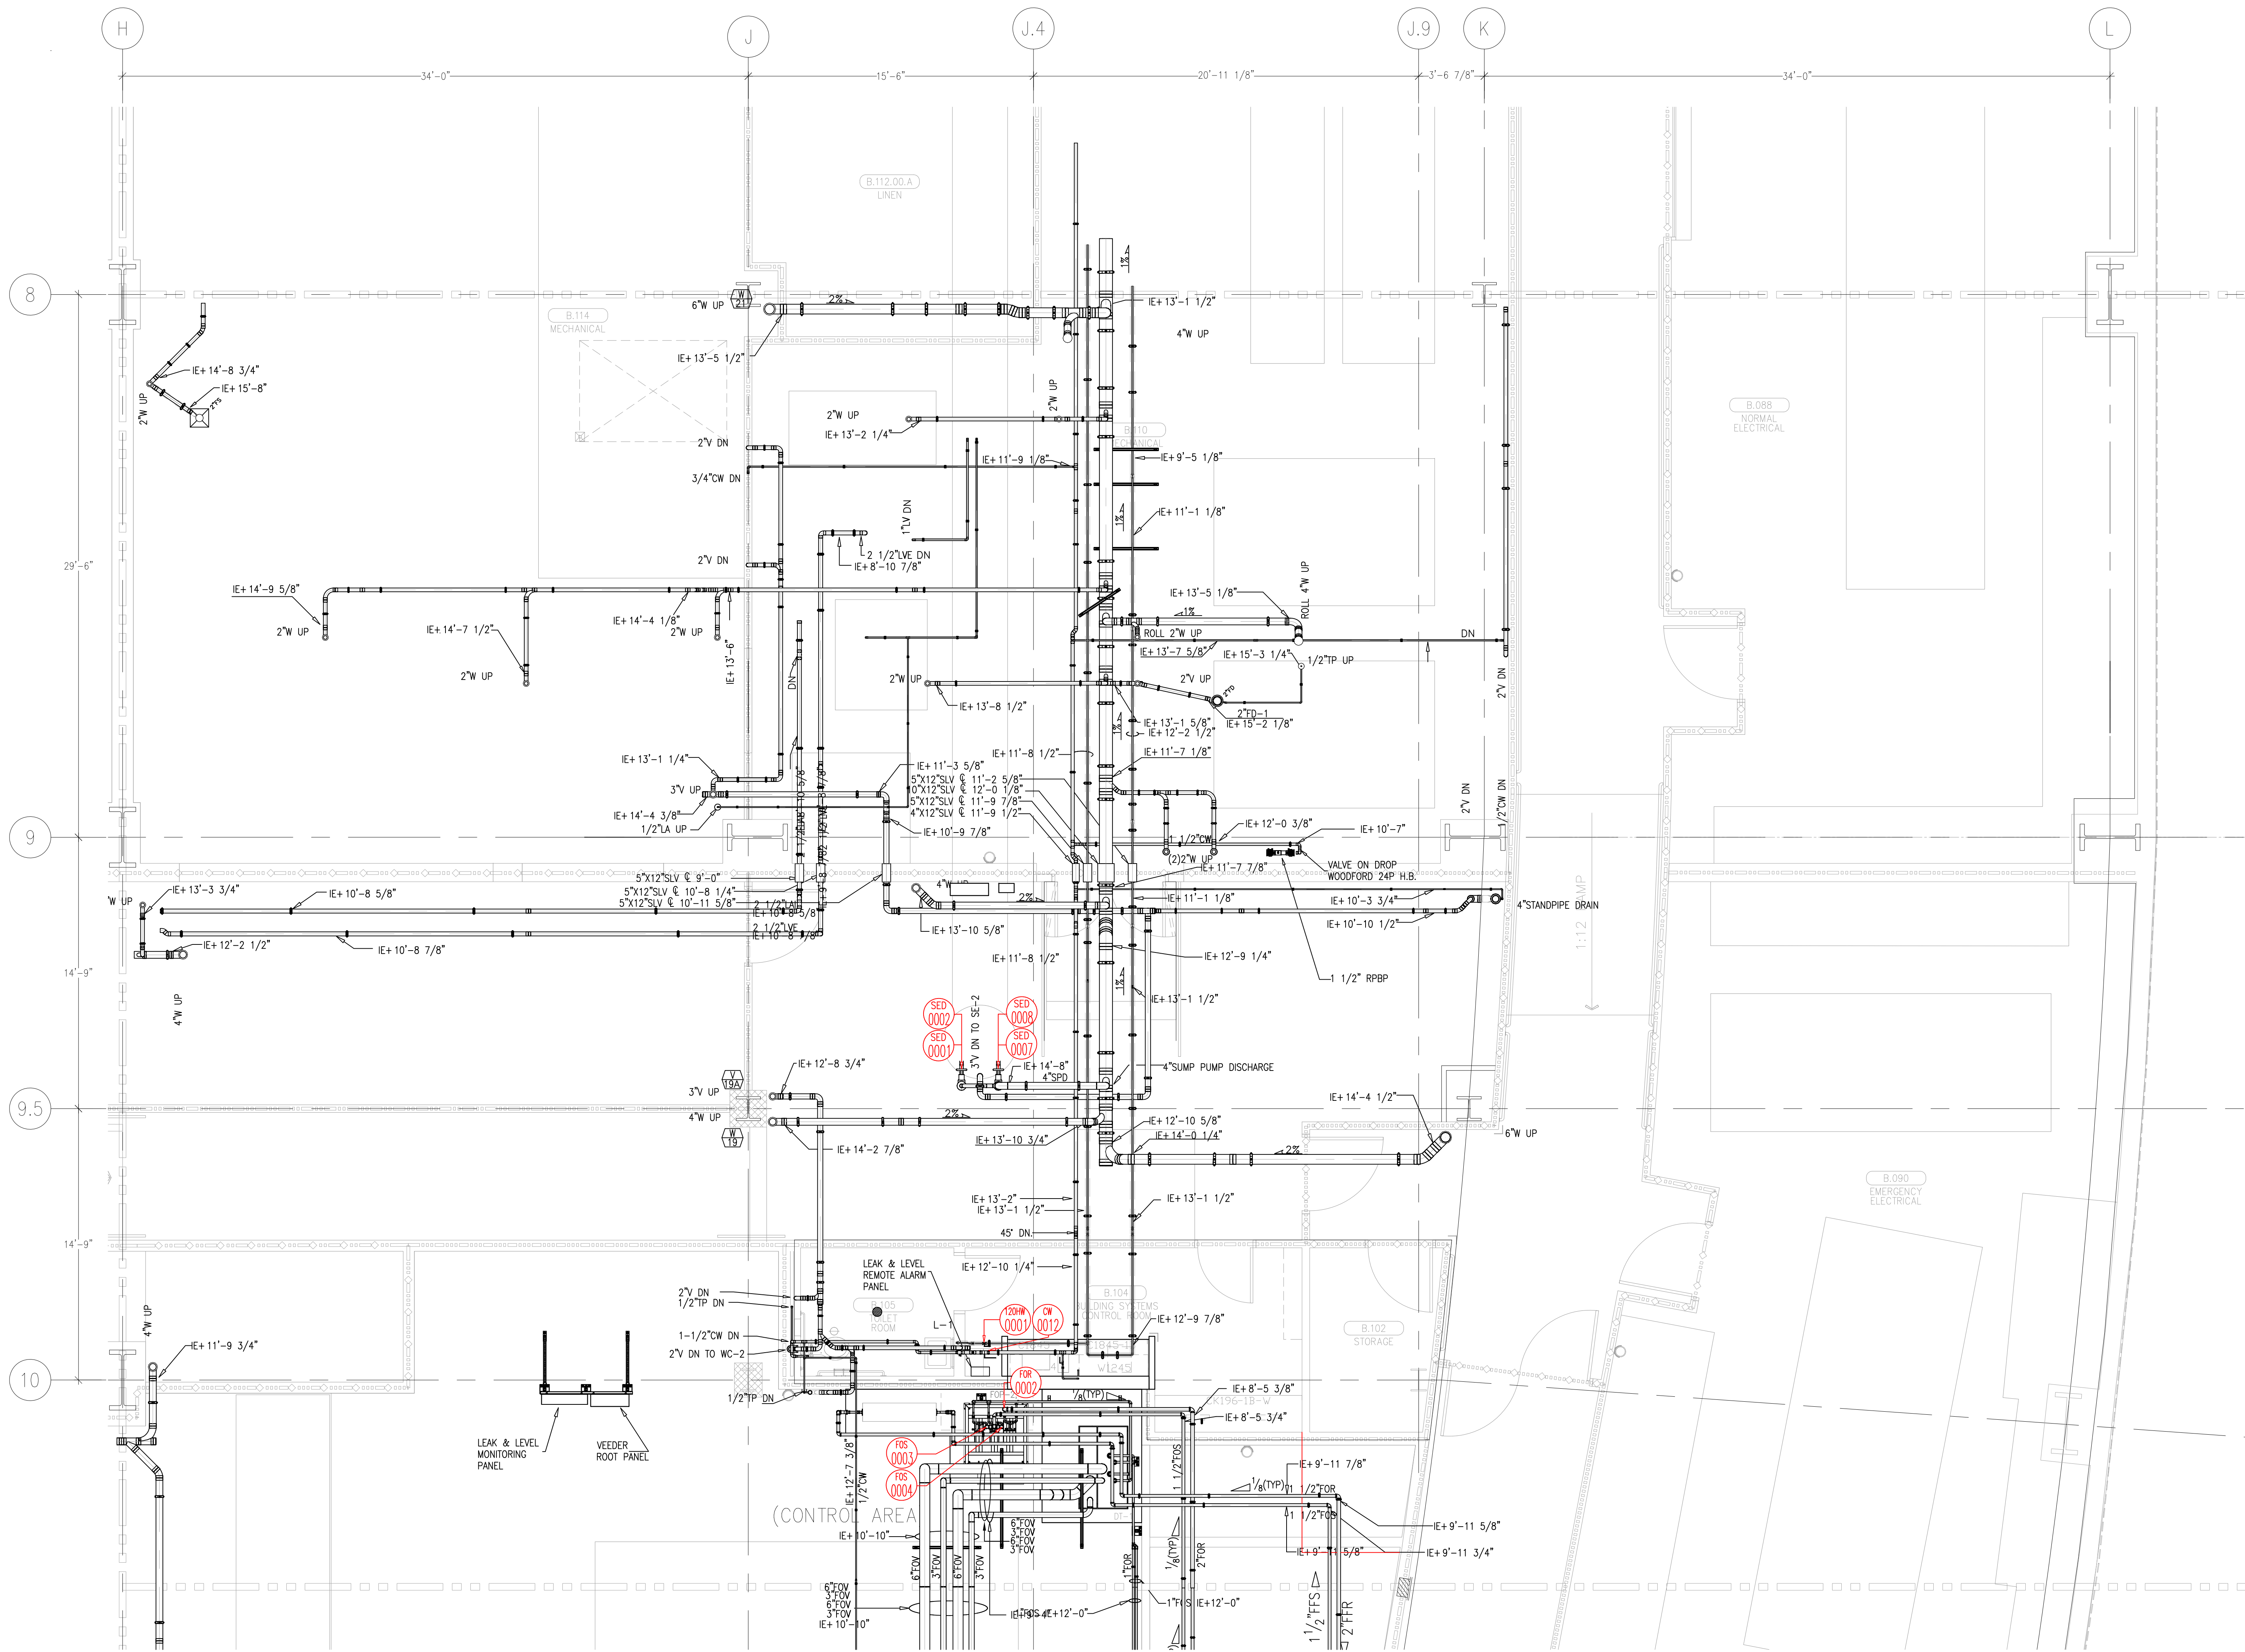

MCCARTHY APPROVAL


A. Approved as noted for Subcontractor Review
B. Review and Rebuild
C. Rebuild

This review is for general conformance with Plans and Specifications only. Any deviations from same not clearly noted by the Project team are not to be construed as approval. Review shall not constitute a complete check of detailed dimensions or count to serve to release the Project of contractual responsibility for any error or deviation from contract requirements.

McCarthy

By: _____ Date: _____
SHOP DRAWING REFERENCE NO. _____

LEVEL 00 144.30' = 0'-0"
REFERENCE THIS SHEET

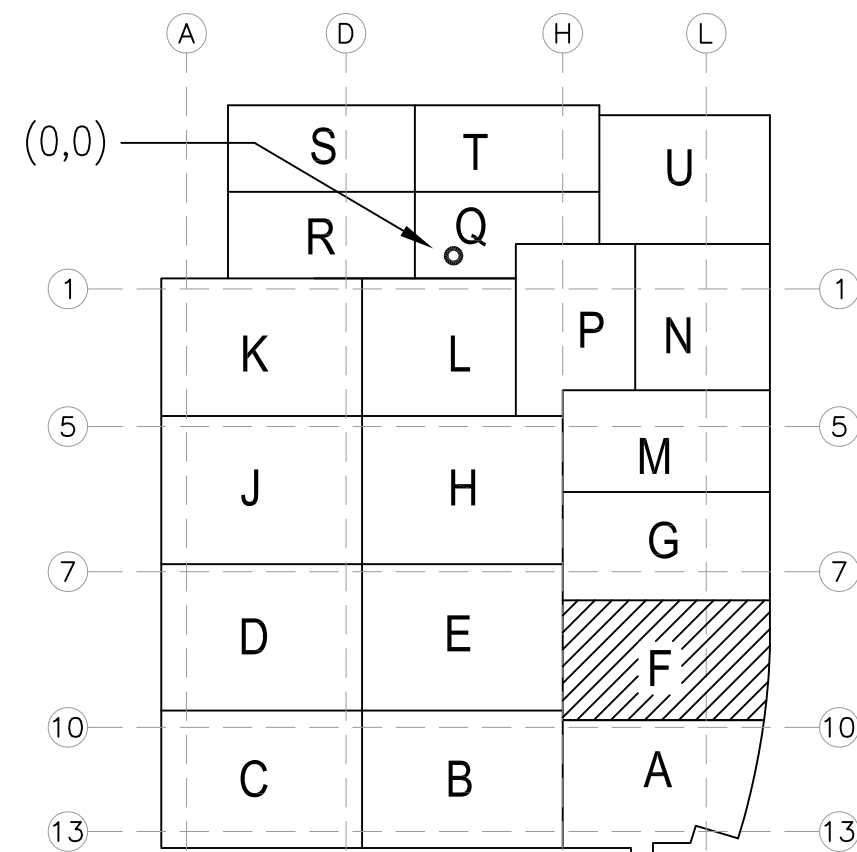

- ISSUED FOR COORDINATION
SIGN-OFF 04-10-09
- ISSUED FOR COORDINATION
SIGN-OFF 10-27-09
- ADDED 2-TS-1 PER
CON. RFI 0381
1-25-10
- ISSUED FOR RE-COORDINATION
SIGN-OFF 2-28-10
- ISSUED FOR CONSTRUCTION
04-07-10

REVISIONS	BY
1	DK
2	DK
3	REO
4	DK
5	DK
6	GP
7	DK

COORD.	SIGNATURE	DATE
MECHANICAL		
ELECTRICAL		
PLUMBING		
STRUCTURAL		

R.F.I.	SENT	ANS.	R.F.I.	SENT	ANS.
008	04/09/09	04/13/09	0436	07/29/09	10/26/09
019	04/17/09	06/04/09	0489	10/02/09	10/13/09
0441	04/22/09	04/29/09	0614	12/16/09	01/22/10
0131R1	06/22/09	07/08/09			
0216	06/23/09	09/10/09			
0253	07/13/09	07/29/09			
0356	08/13/09	09/15/09			



**CHILDREN'S HOSPITAL
OF ORANGE COUNTY**
455 S. MAIN ST., ORANGE, CA 92668-3974
TOWER II

PLUMBING FLOOR PLAN - LEVEL 00 AREA

PAN-PACIFIC
PLUMBING & MECHANICAL
2919 E. VICTORIA STREET, RANCHO DOMINGUEZ, CA 90221
PH. 310.637-1500 FAX 310.604-0359

DRAWN
R.O.
CHECKED
M.M.
DATE
4/30/2012
SCALE
1/4" = 1'-0"
JOB NO.
09-006
DRAWING NUMBER
PL3.0F
REFERENCE DRAWING
A3.0F
P3.0F
1 OF 1 SHEETS


8

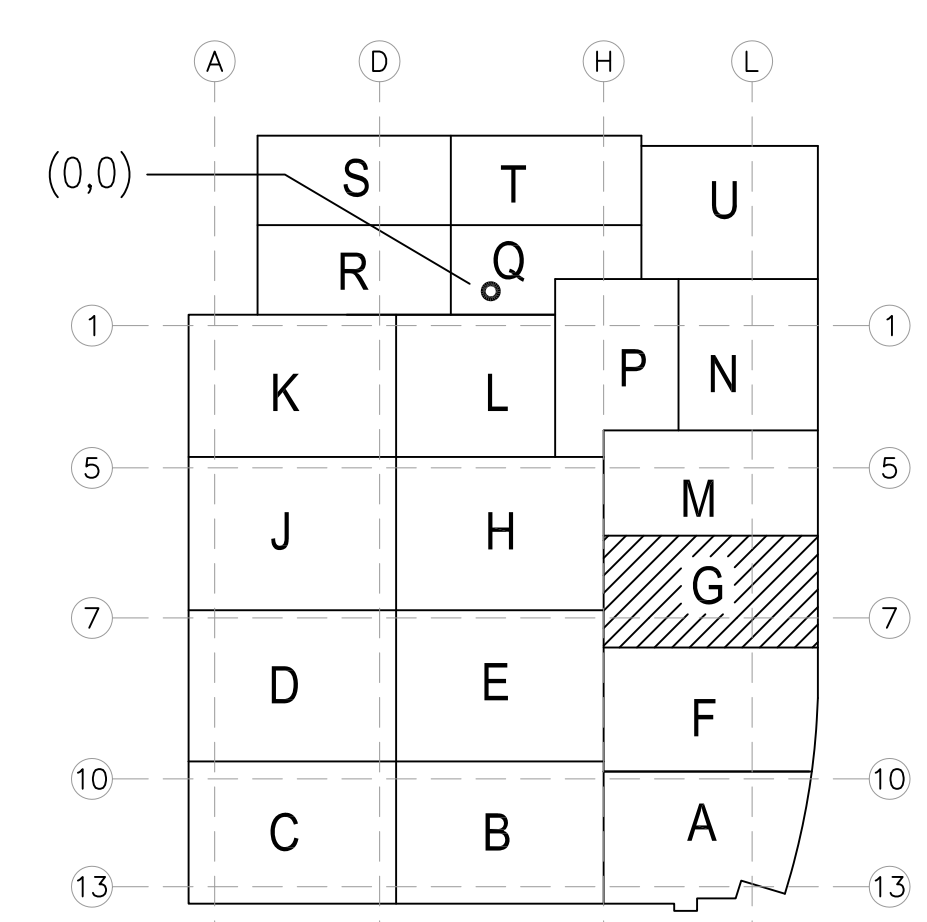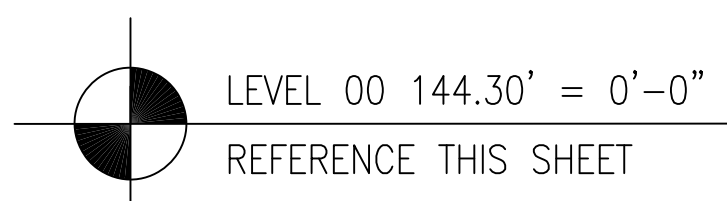

A1 KEY PLAN

Drawn
 R.O.
 Checked
 M.M.
 Date
 4/30/2012
 Scale
 $1/4" = 1'-0"$
 Job No.
 09-006
 Drawing Number
 PL3.0G
 Reference Drawing
 A3.0G
 P3.0G
 1 OF 1 SHEETS

This document and the design it covers are the property of Murray Co. They are loaned only with the borrower's expressed written agreement that they will not be reproduced, copied, loaned, exhibited, or used in any way, except by written consent from Murray Co. to the borrower.

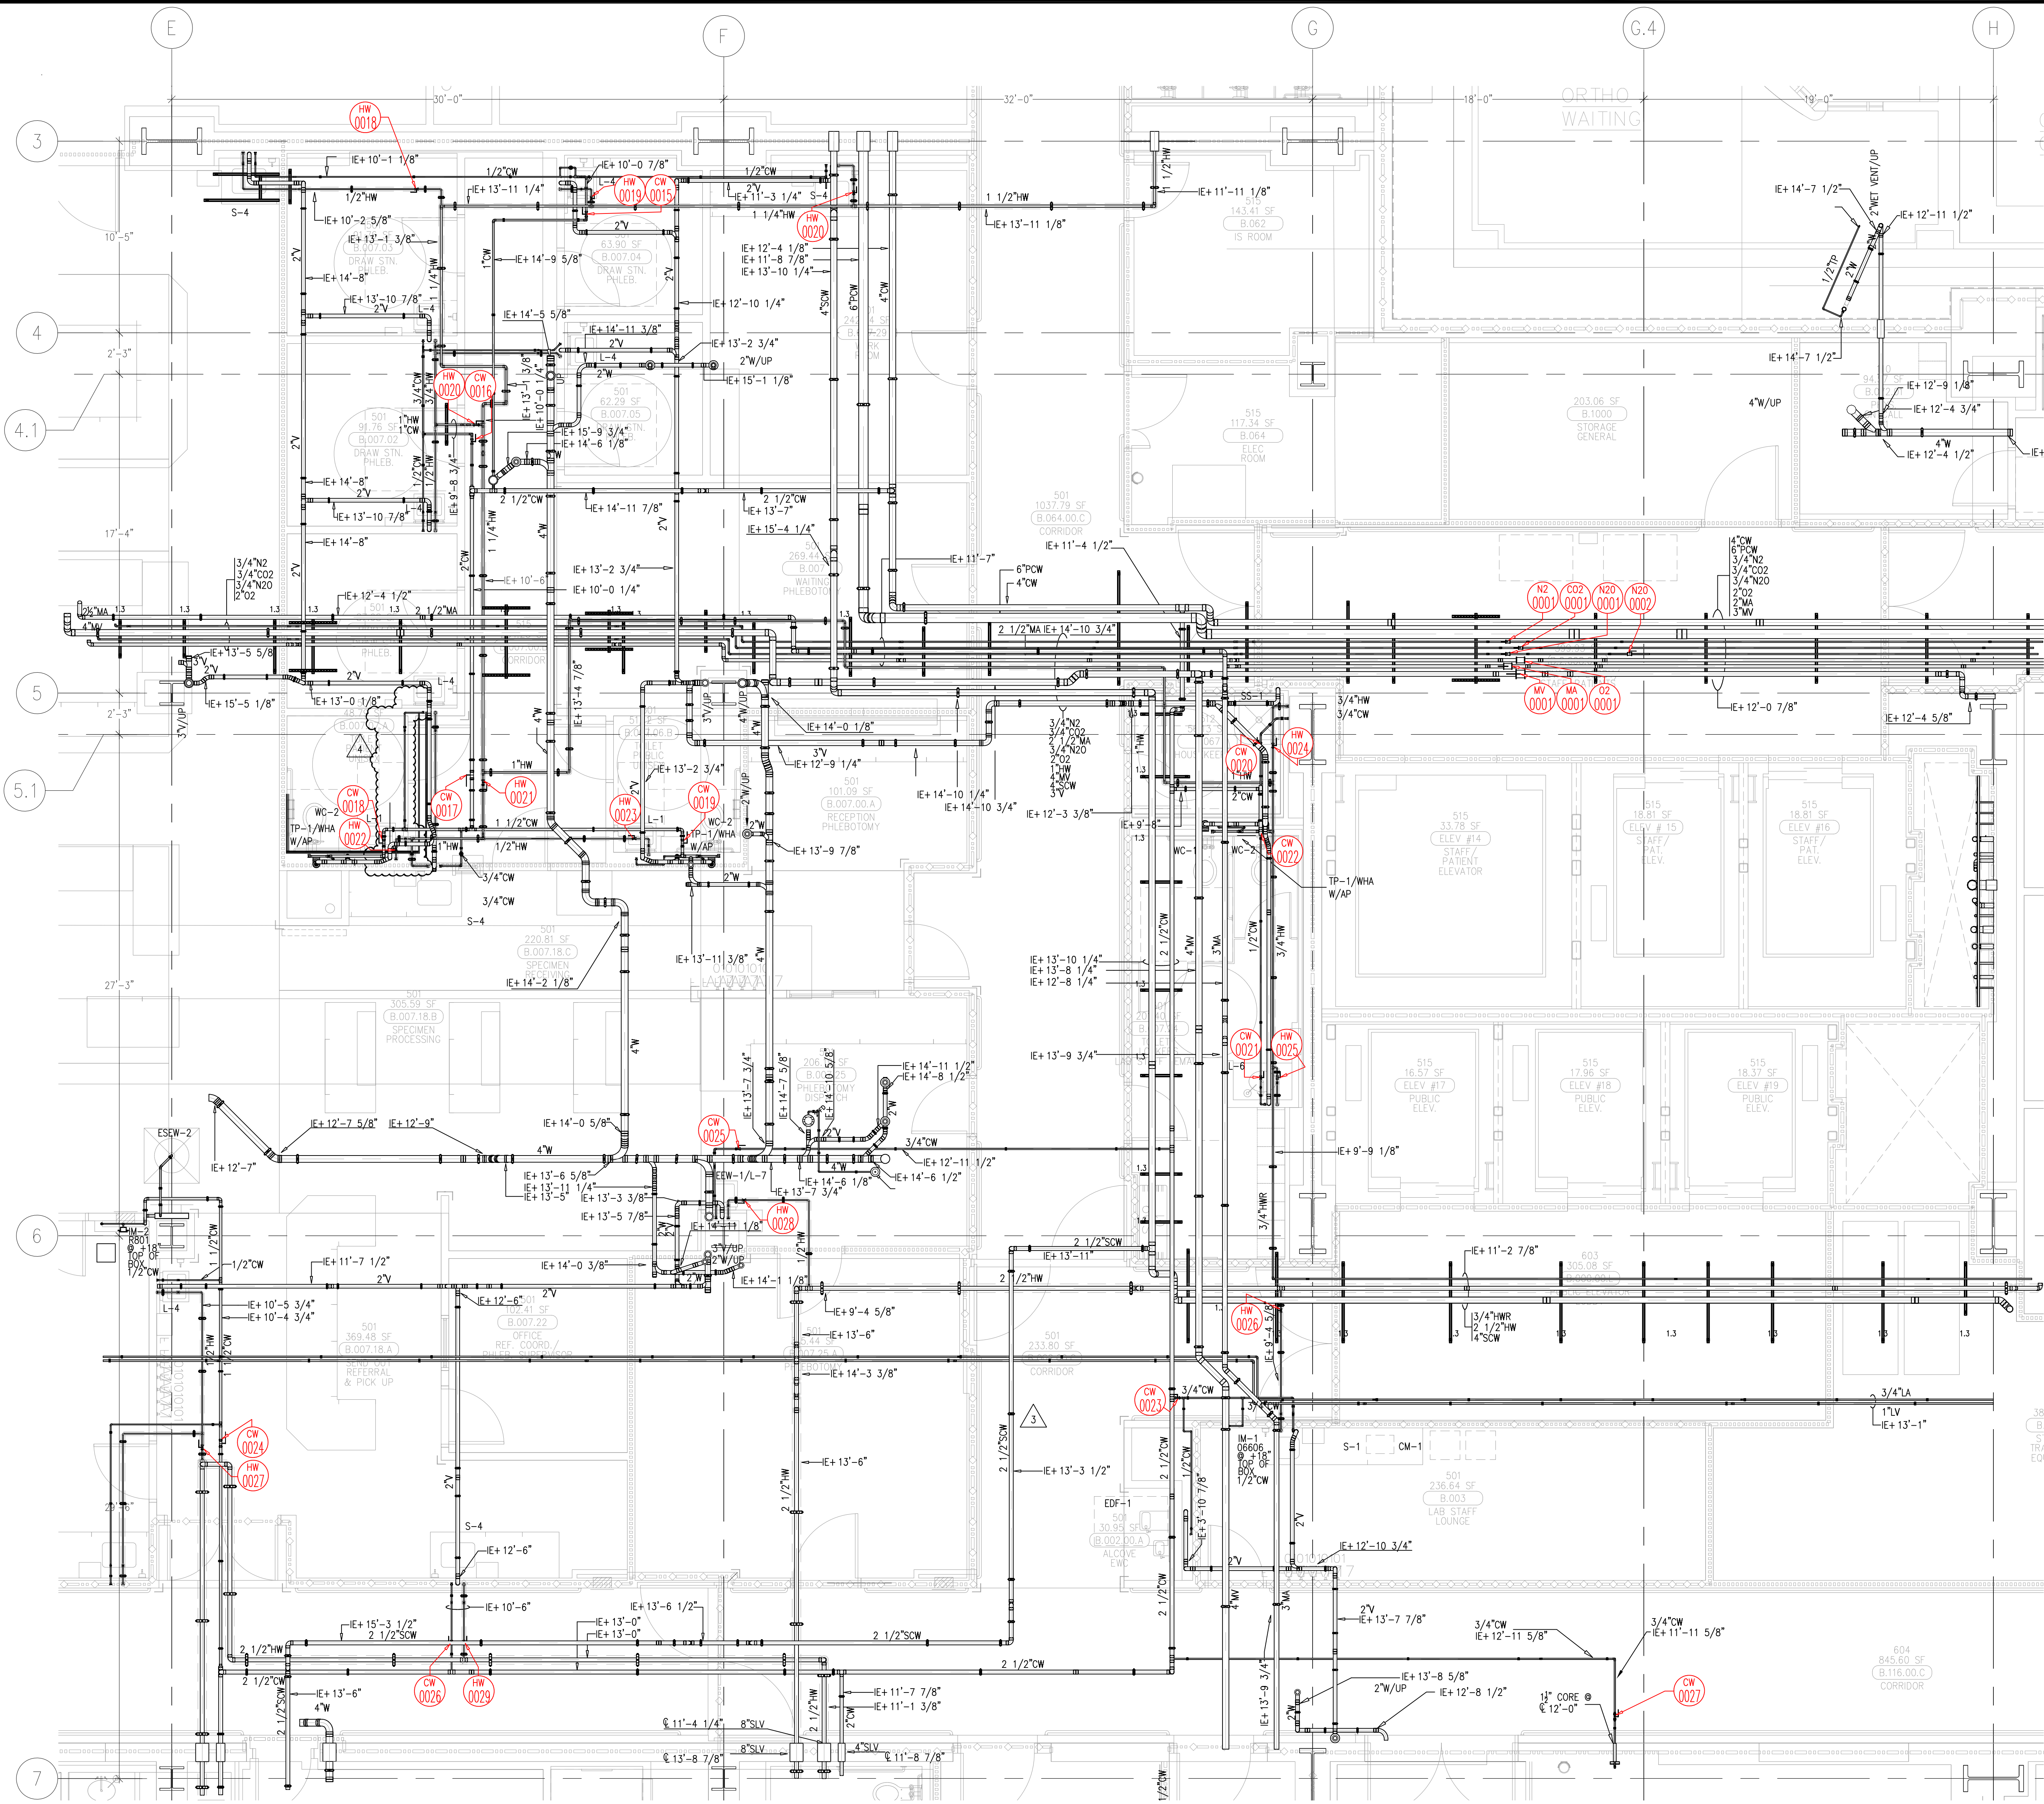

MCCARTHY APPROVAL

A. Approved as noted for Installation Review ☐


B. Review and Rebuild ☐

C. Rejected ☐

This review is for general conformance with Plans and Specifications only. Any deviations from same not clearly noted by the Preparer have not been reviewed. Reviewer shall not constitute a warranty, check of detailed observations or consent to serve to release the Preparer of contractual responsibility for any error or deviation from contract requirements.

McCarthy

By: _____ Date: _____
Shop Drawing Reference No. _____

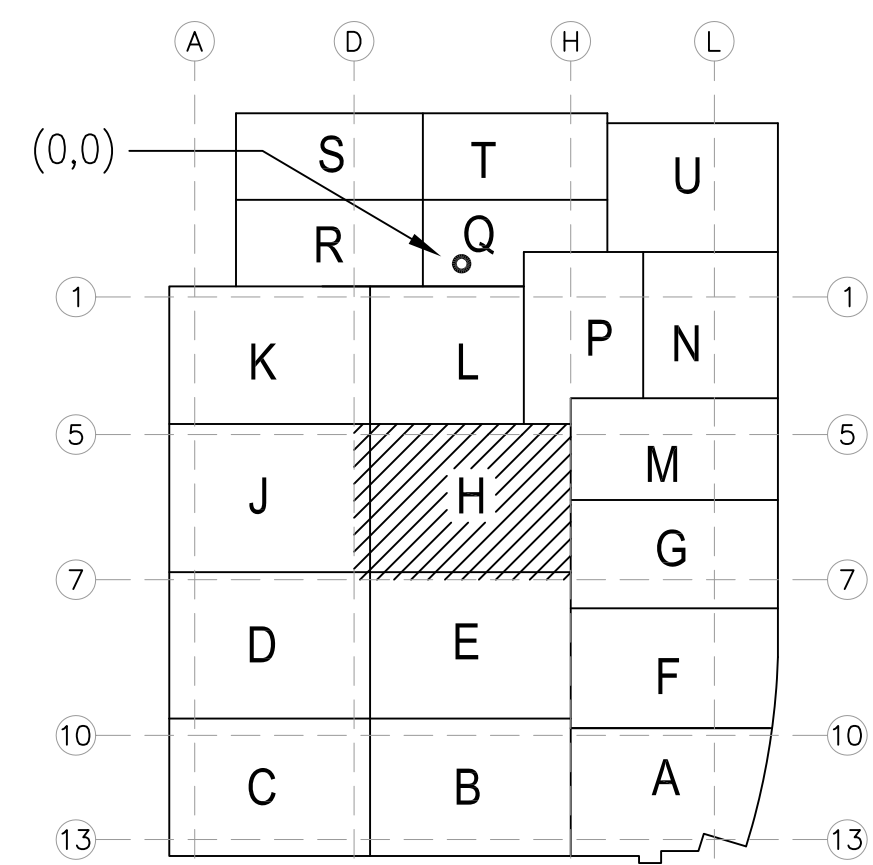

LEVEL 00 144.30' = 0'-0"
REFERENCE THIS SHEET

REVISIONS	BY
ISSUED FOR COORDINATION SIGN-OFF 9-18-09	DK
ISSUED FOR COORDINATION SIGN-OFF 10-27-09	DK
ISSUED FOR RE-COORDINATION SIGN-OFF 2-26-10	DK
ISSUED FOR CONSTRUCTION 04-08-10	DK
REVISED PER ICE MAKER ROUGH-IN	JT
REVISIONS PER CIP 126, 01-25-11	JT
REVISED DUE TO COR#3 05-08-11 (LAB)	GP
REVISED DUE TO COR#3 05-22-11 (LAB)	GP
REVISED DUE TO COR#3 05-22-11 (LAB)	GP

COORD.	SIGNATURE	DATE
MECHANICAL		
ELECTRICAL		
PLUMBING		
STRUCTURAL		




ANS.	SENT	R.F.I.	SENT	ANS.	SENT	R.F.I.	SENT	ANS.	SENT	R.F.I.	SENT
0001	04/27/09	05/13/09	0024	10/19/09	10/29/09						
0002	05/04/09	05/13/09									
0003	05/04/09	07/08/09									
0004	05/04/09	06/12/09									
0005	05/04/09	06/12/09									
0006	05/04/09	06/12/09									
0007	05/04/09	06/12/09									
0008	05/04/09	06/12/09									
0009	05/04/09	06/12/09									
0010	05/04/09	06/12/09									
0011	05/04/09	06/12/09									
0012	05/04/09	06/12/09									
0013	05/04/09	06/12/09									
0014	05/04/09	06/12/09									
0015	05/04/09	06/12/09									
0016	05/04/09	06/12/09									
0017	05/04/09	06/12/09									
0018	05/04/09	06/12/09									
0019	05/04/09	06/12/09									
0020	05/04/09	06/12/09									
0021	05/04/09	06/12/09									
0022	05/04/09	06/12/09									
0023	05/04/09	06/12/09									
0024	05/04/09	06/12/09									
0025	05/04/09	06/12/09									
0026	05/04/09	06/12/09									
0027	05/04/09	06/12/09									
0028	05/04/09	06/12/09									
0029	05/04/09	06/12/09									
0030	05/04/09	06/12/09									
0031	05/04/09	06/12/09									
0032	05/04/09	06/12/09									
0033	05/04/09	06/12/09									
0034	05/04/09	06/12/09									
0035	05/04/09	06/12/09									
0036	05/04/09	06/12/09									
0037	05/04/09	06/12/09									
0038	05/04/09	06/12/09									
0039	05/04/09	06/12/09									
0040	05/04/09	06/12/09									

**CHILDREN'S HOSPITAL
CHOC[®] OF ORANGE COUNTY**
155 S. MAIN ST., SUITE 300
ORANGE, CA 92668-3974
TOWER II
PLUMBING FLOOR PLAN - LEVEL 00 AREA H

PAN-PACIFIC
PLUMBING & MECHANICAL
2919 E. VICTORIA STREET, RANCHO DOMINGUEZ, CA 90221
PH. 310.637.1500 FAX 310.604.0359

DRAWN
R.O.
CHECKED
M.M.
DATE
4/30/2012
SCALE
1/4" = 1'-0"
JOB NO.
09-006
DRAWING NUMBER
PL3.0H
REFERENCE DRAWING
A3.0H
P3.0H
1 OF 1 SHEETS

This document and the design it covers are the property of Murray Co. They are loaned only with the borrowers's expressed agreement that they will not be reproduced, copied, loaned, exhibited, or used in any other way, except by written consent from Murray Co. to the borrower.

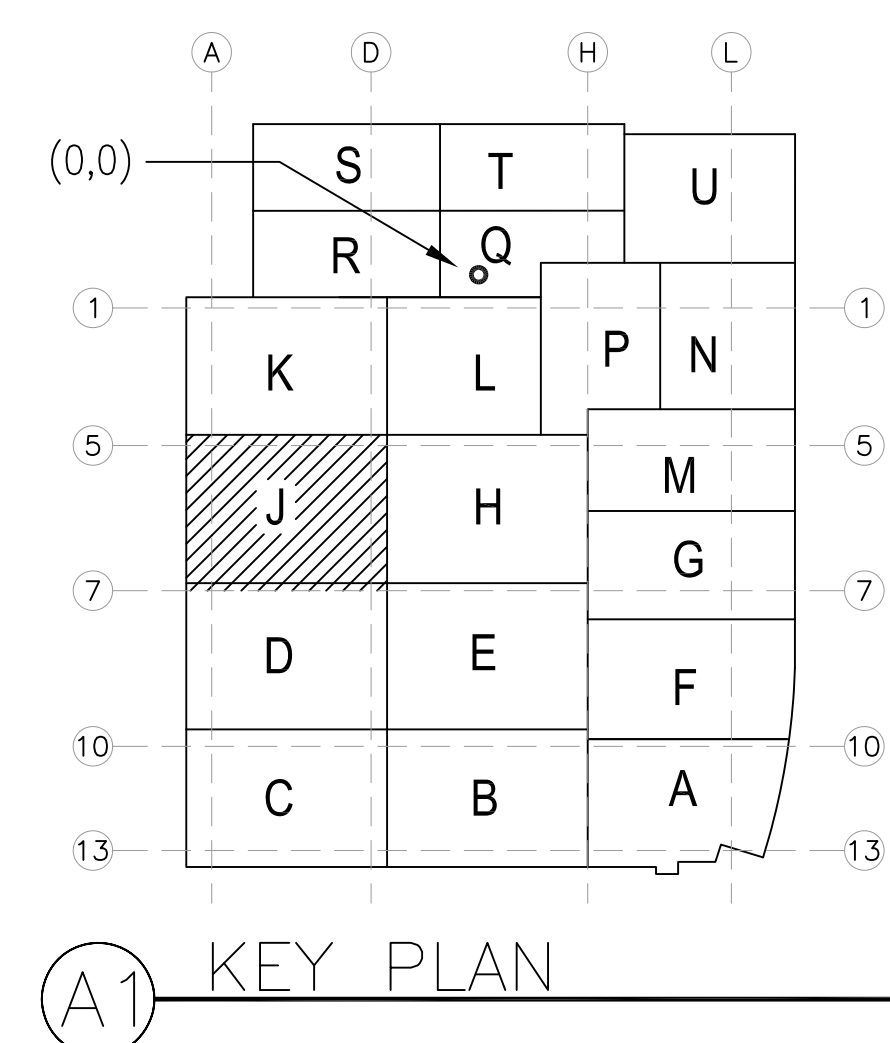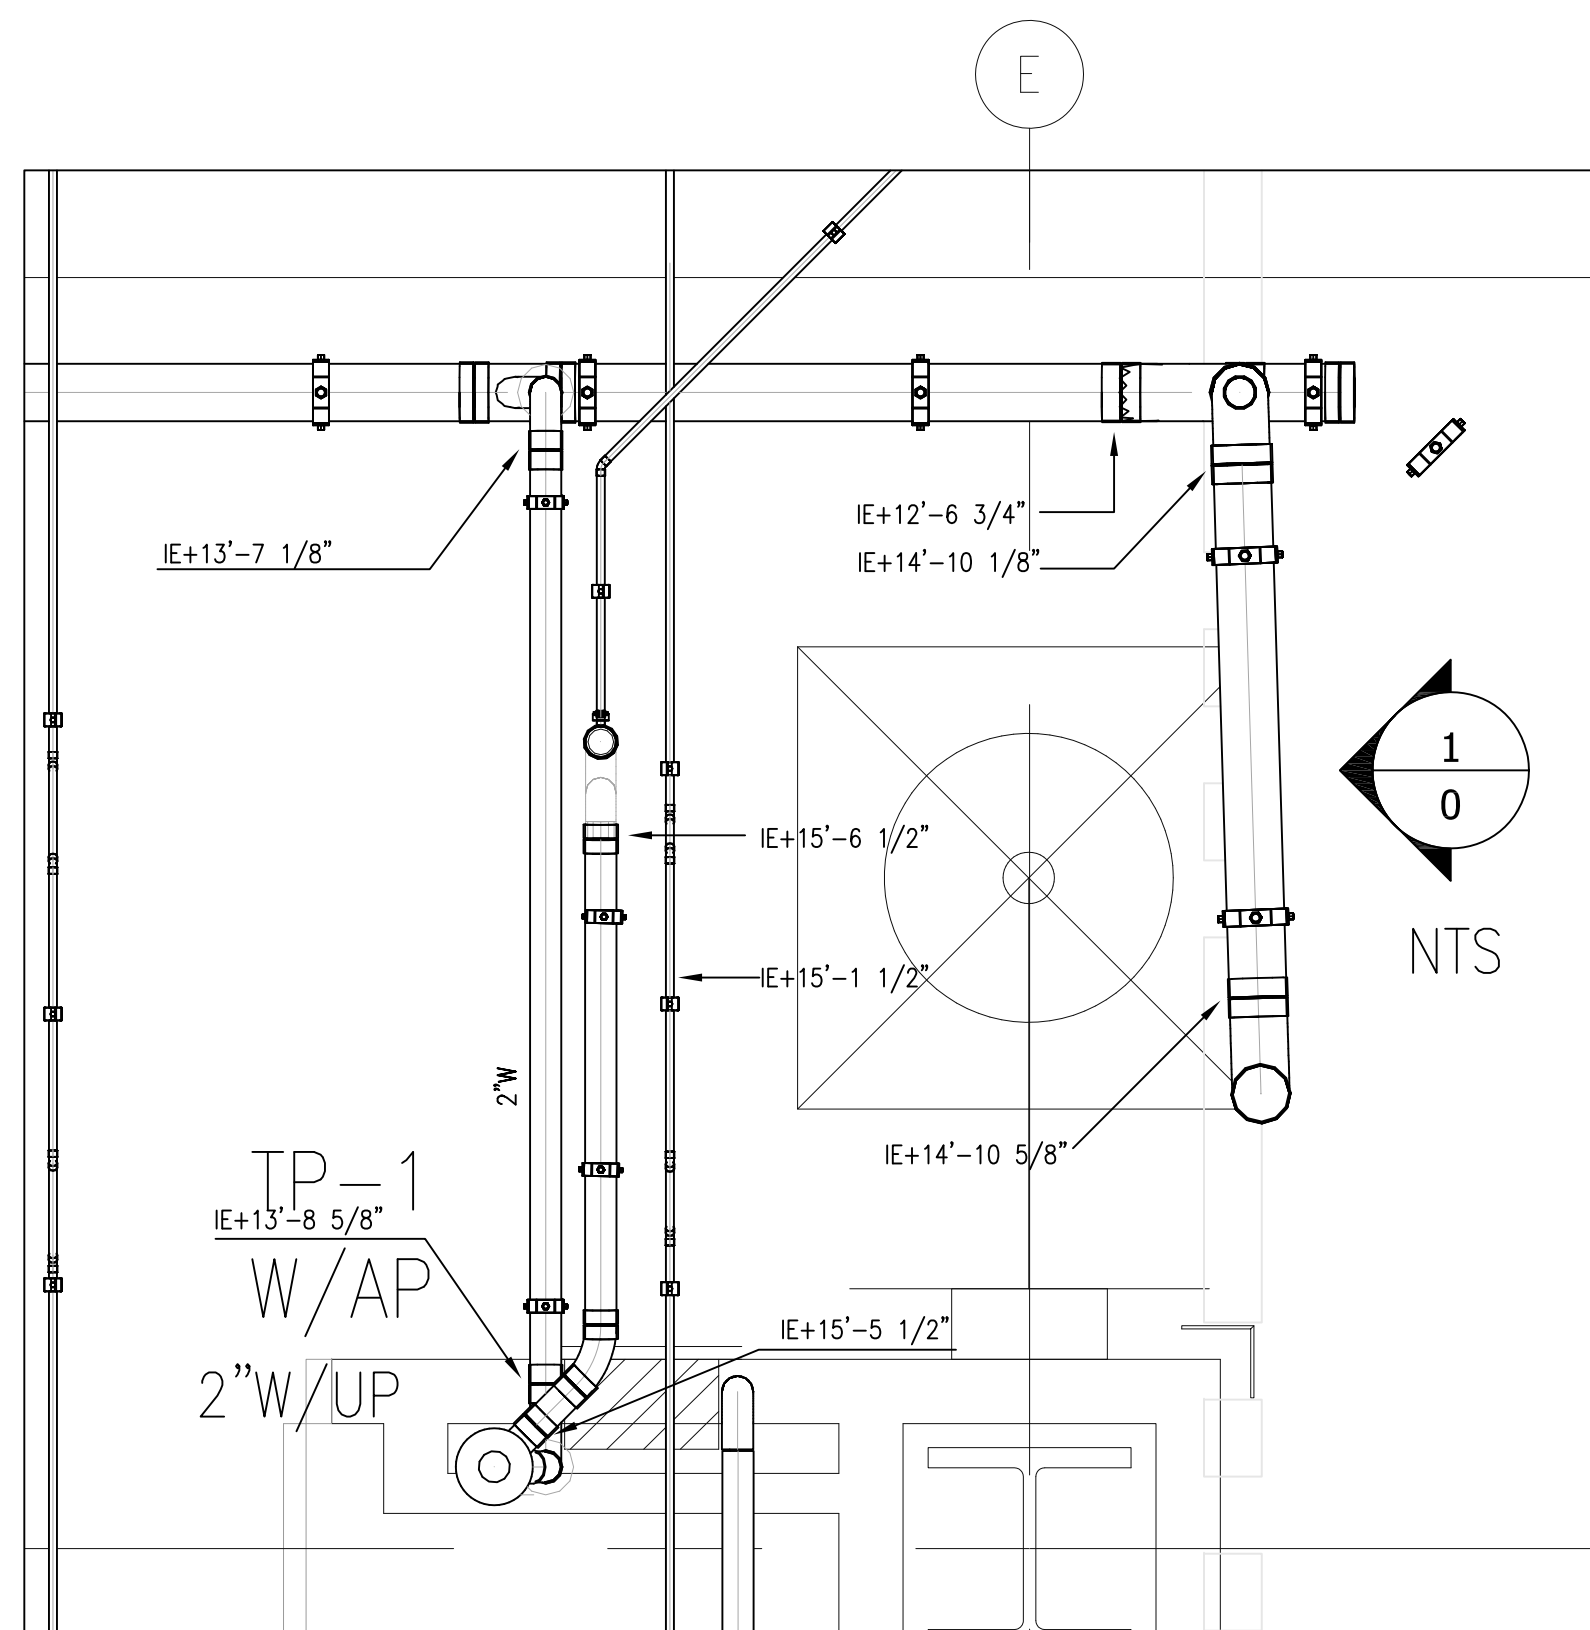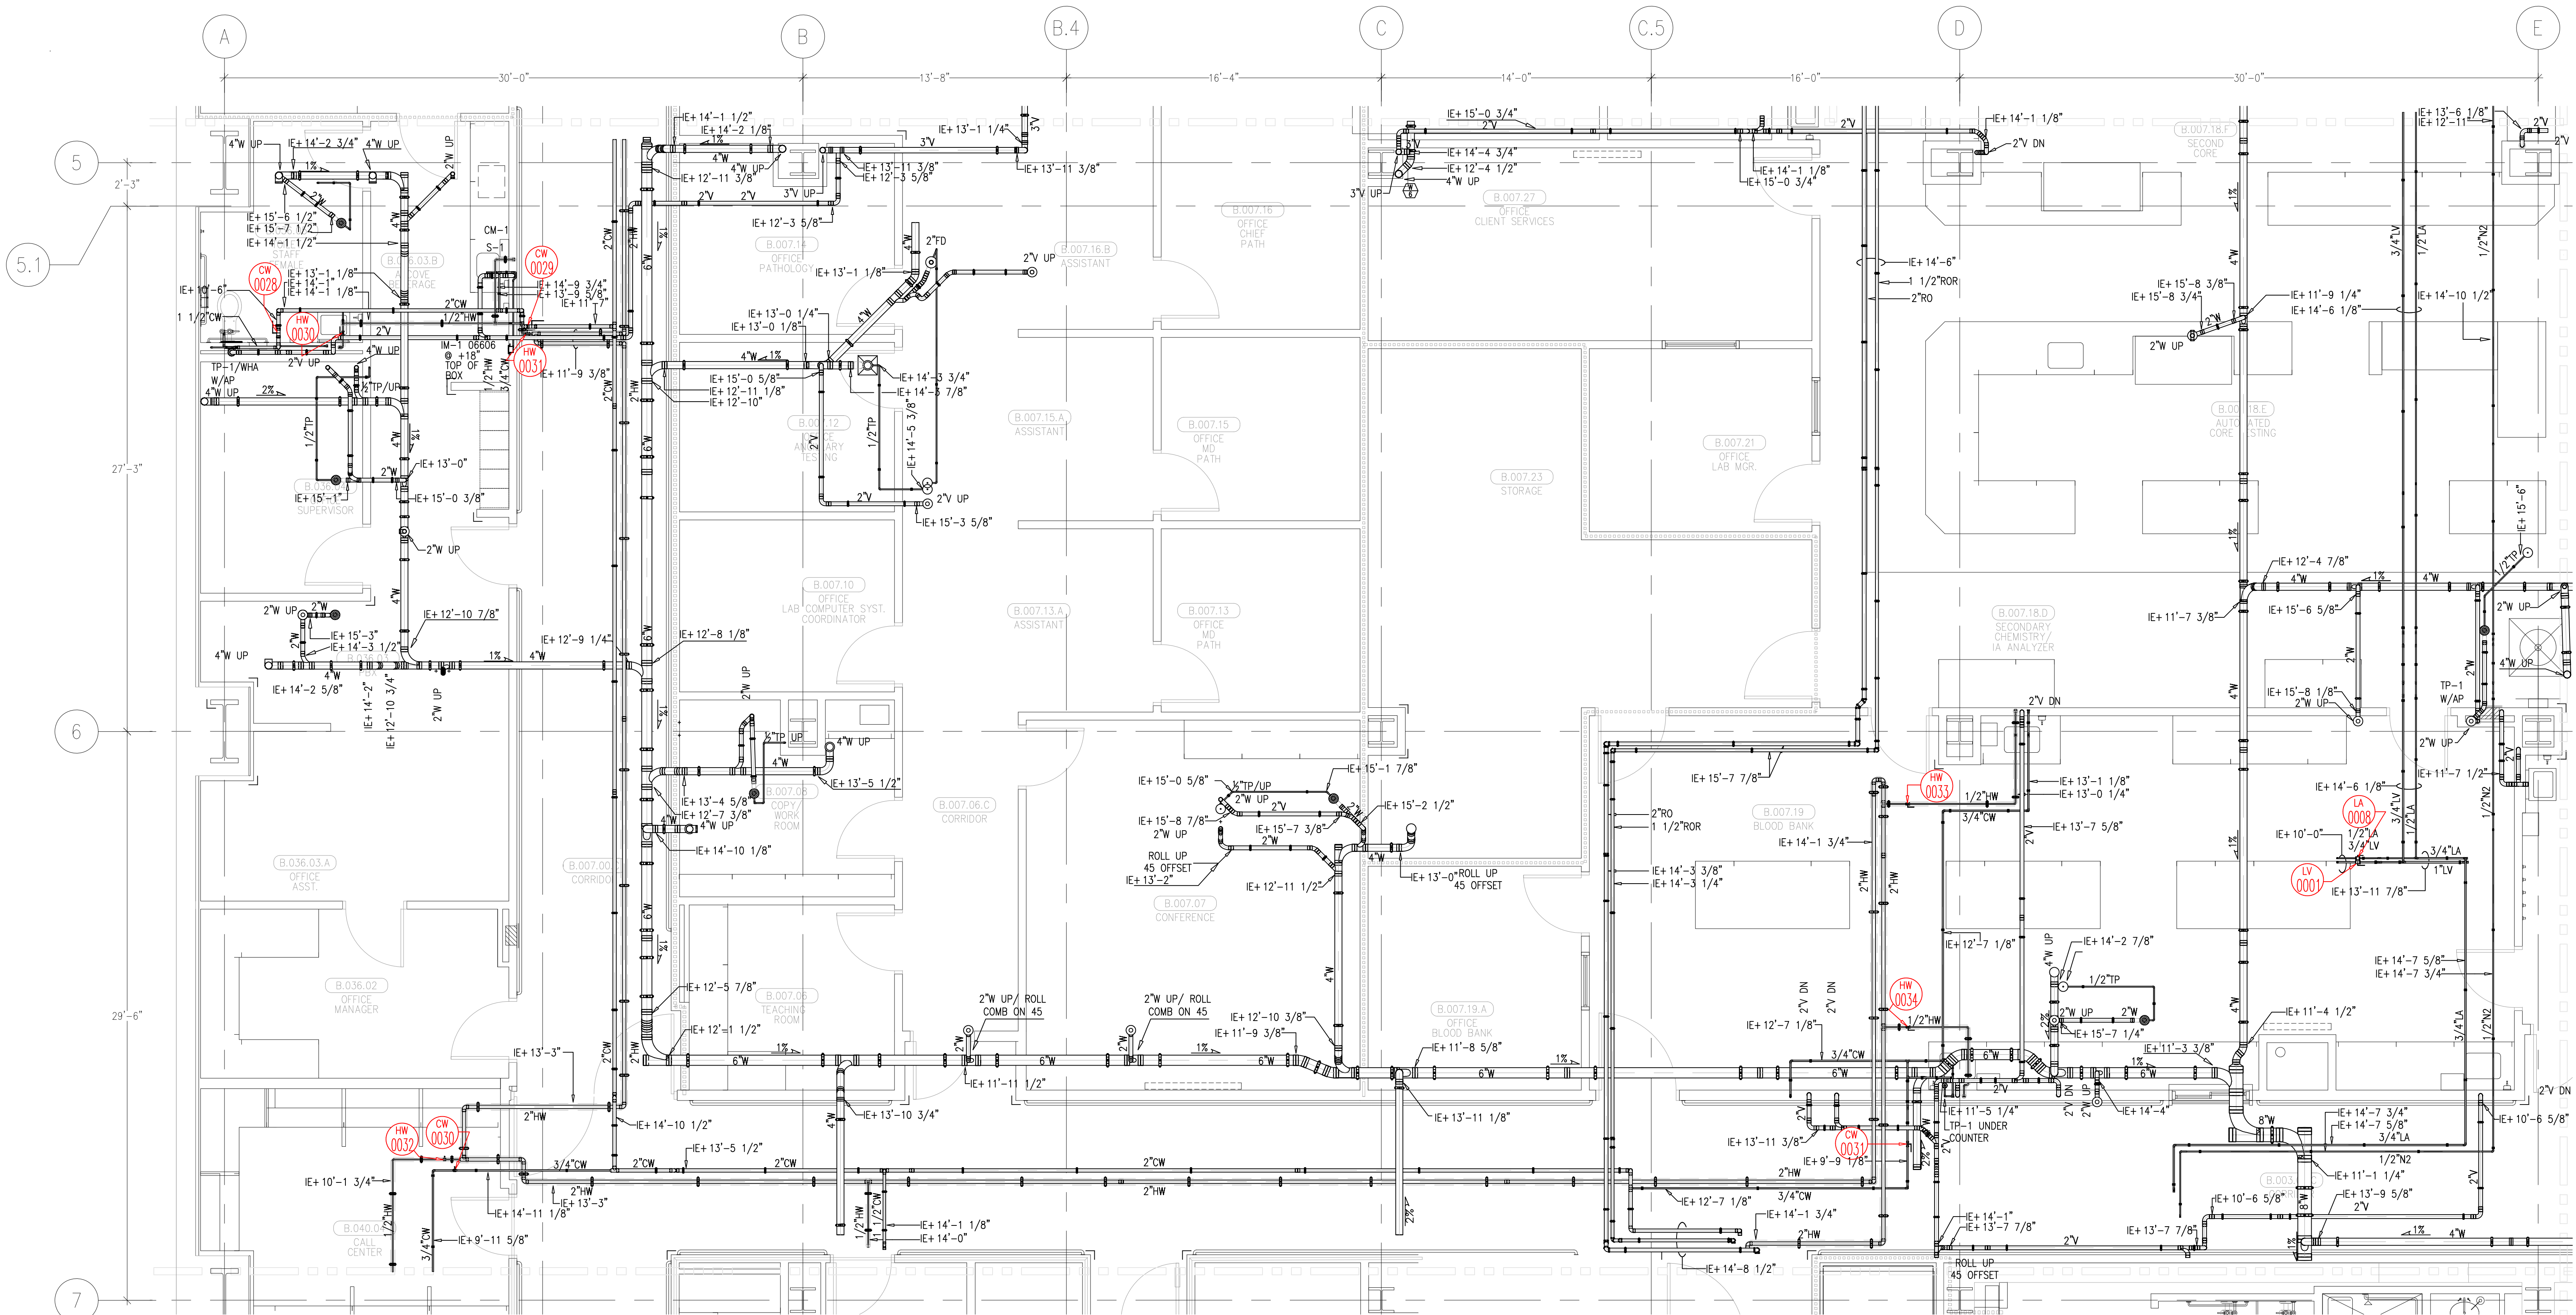

	REVISIONS	BY
A	ISSUED FOR COORDINATION SIGN-OFF 9-18-09	DK
B	ISSUED FOR COORDINATION SIGN-OFF 10-27-09	DK
C	ISSUED FOR RE-COORDINATION SIGN-OFF 2-26-10	DK
D	ISSUED FOR CONSTRUCTION 04-07-10	DK
1	REVISED WASTE SLOPE PER ENGINEERS REQUEST 5-17-2010	JT
2	ADDED FLOOR SINK AND TRAP PRIMER AT MR. ROOM. 6-18-10	DK
3	REVISED PER ICE MAKER ROOM-IN 11-24-10	JT
4	REVISED PIPING PER CG1125 AND RRI 1012 P-0011A81 2-24-11	MO
5	REVISED VENT DUE TO FRAMING CONFLICT. 3-9-11	DK

COORD.	SIGNATURE	DATE
MCCARTHY		
MECHANICAL DUCT		
MECHANICAL PIPE		
PLUMBING		
ELECTRICAL		
FIRE SPROINKLER		
PTUBE		
DRYWALL/FRAMER		
REFRIGERATION		
STRUCTURAL		

R.F.I.	SENT	ANS.	R.F.I.	SENT	ANS.
0080	05/01/09	05/05/09			
0429	09/29/09	10/14/09			
0485	09/30/09	10/13/09			
0533	10/20/09	11/09/09			

 CHILDREN'S HOSPITAL
OF ORANGE COUNTY



455 S. Main St.
Orange, CA 92668-3874
TOWER II

PLUMBING FLOOR PLAN - LEVEL 00 AREA-J

PMF
PAN-PACIFIC
PLUMBING & MECHANICAL
Murray Company
2919 E. VICTORIA STREET, RANCHO DOMINGUEZ, CA 90221

DRAWN	
R.O.	
CHECKED	
M.M.	
DATE	4/30/2012
SCALE	1/4" = 1'-0"
JOB NO.	09-006
DRAWING NUMBER	PL3.0J
REFERENCE DRAWING	A3.0J
	P3.0J
1	OF 1 SHEETS

This document and the design it covers are the property of Murray Co. They are loaned only with the borrower's expressed written agreement that they will not be reproduced, copied, loaned, exhibited, or used in any other way, except by written consent from Murray Co. to the borrower.

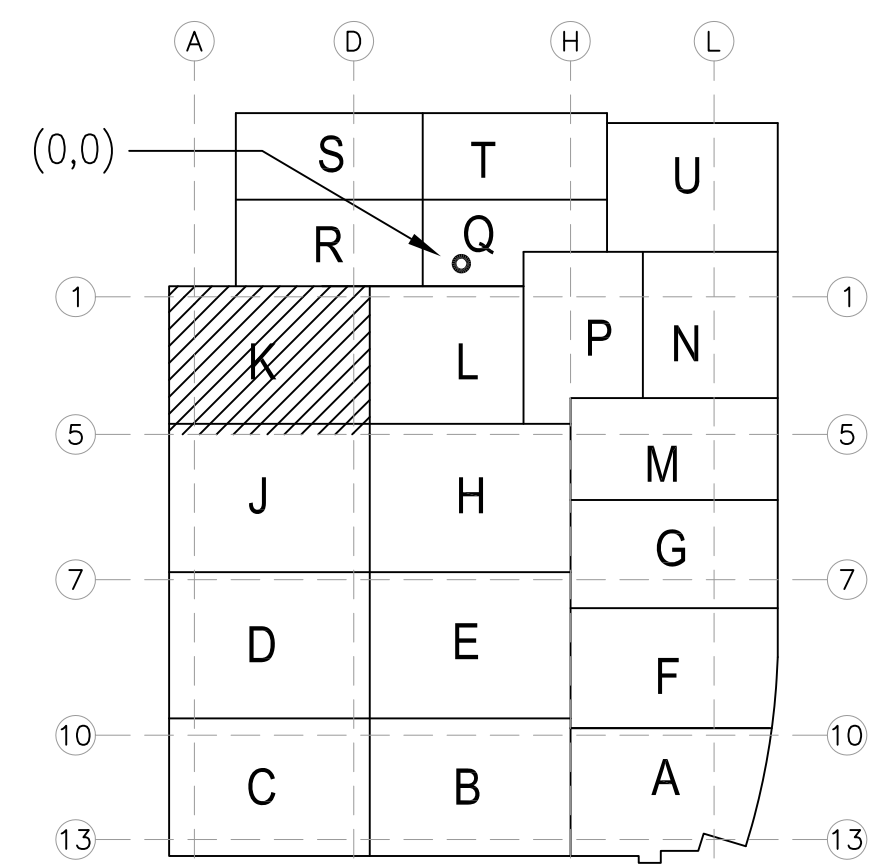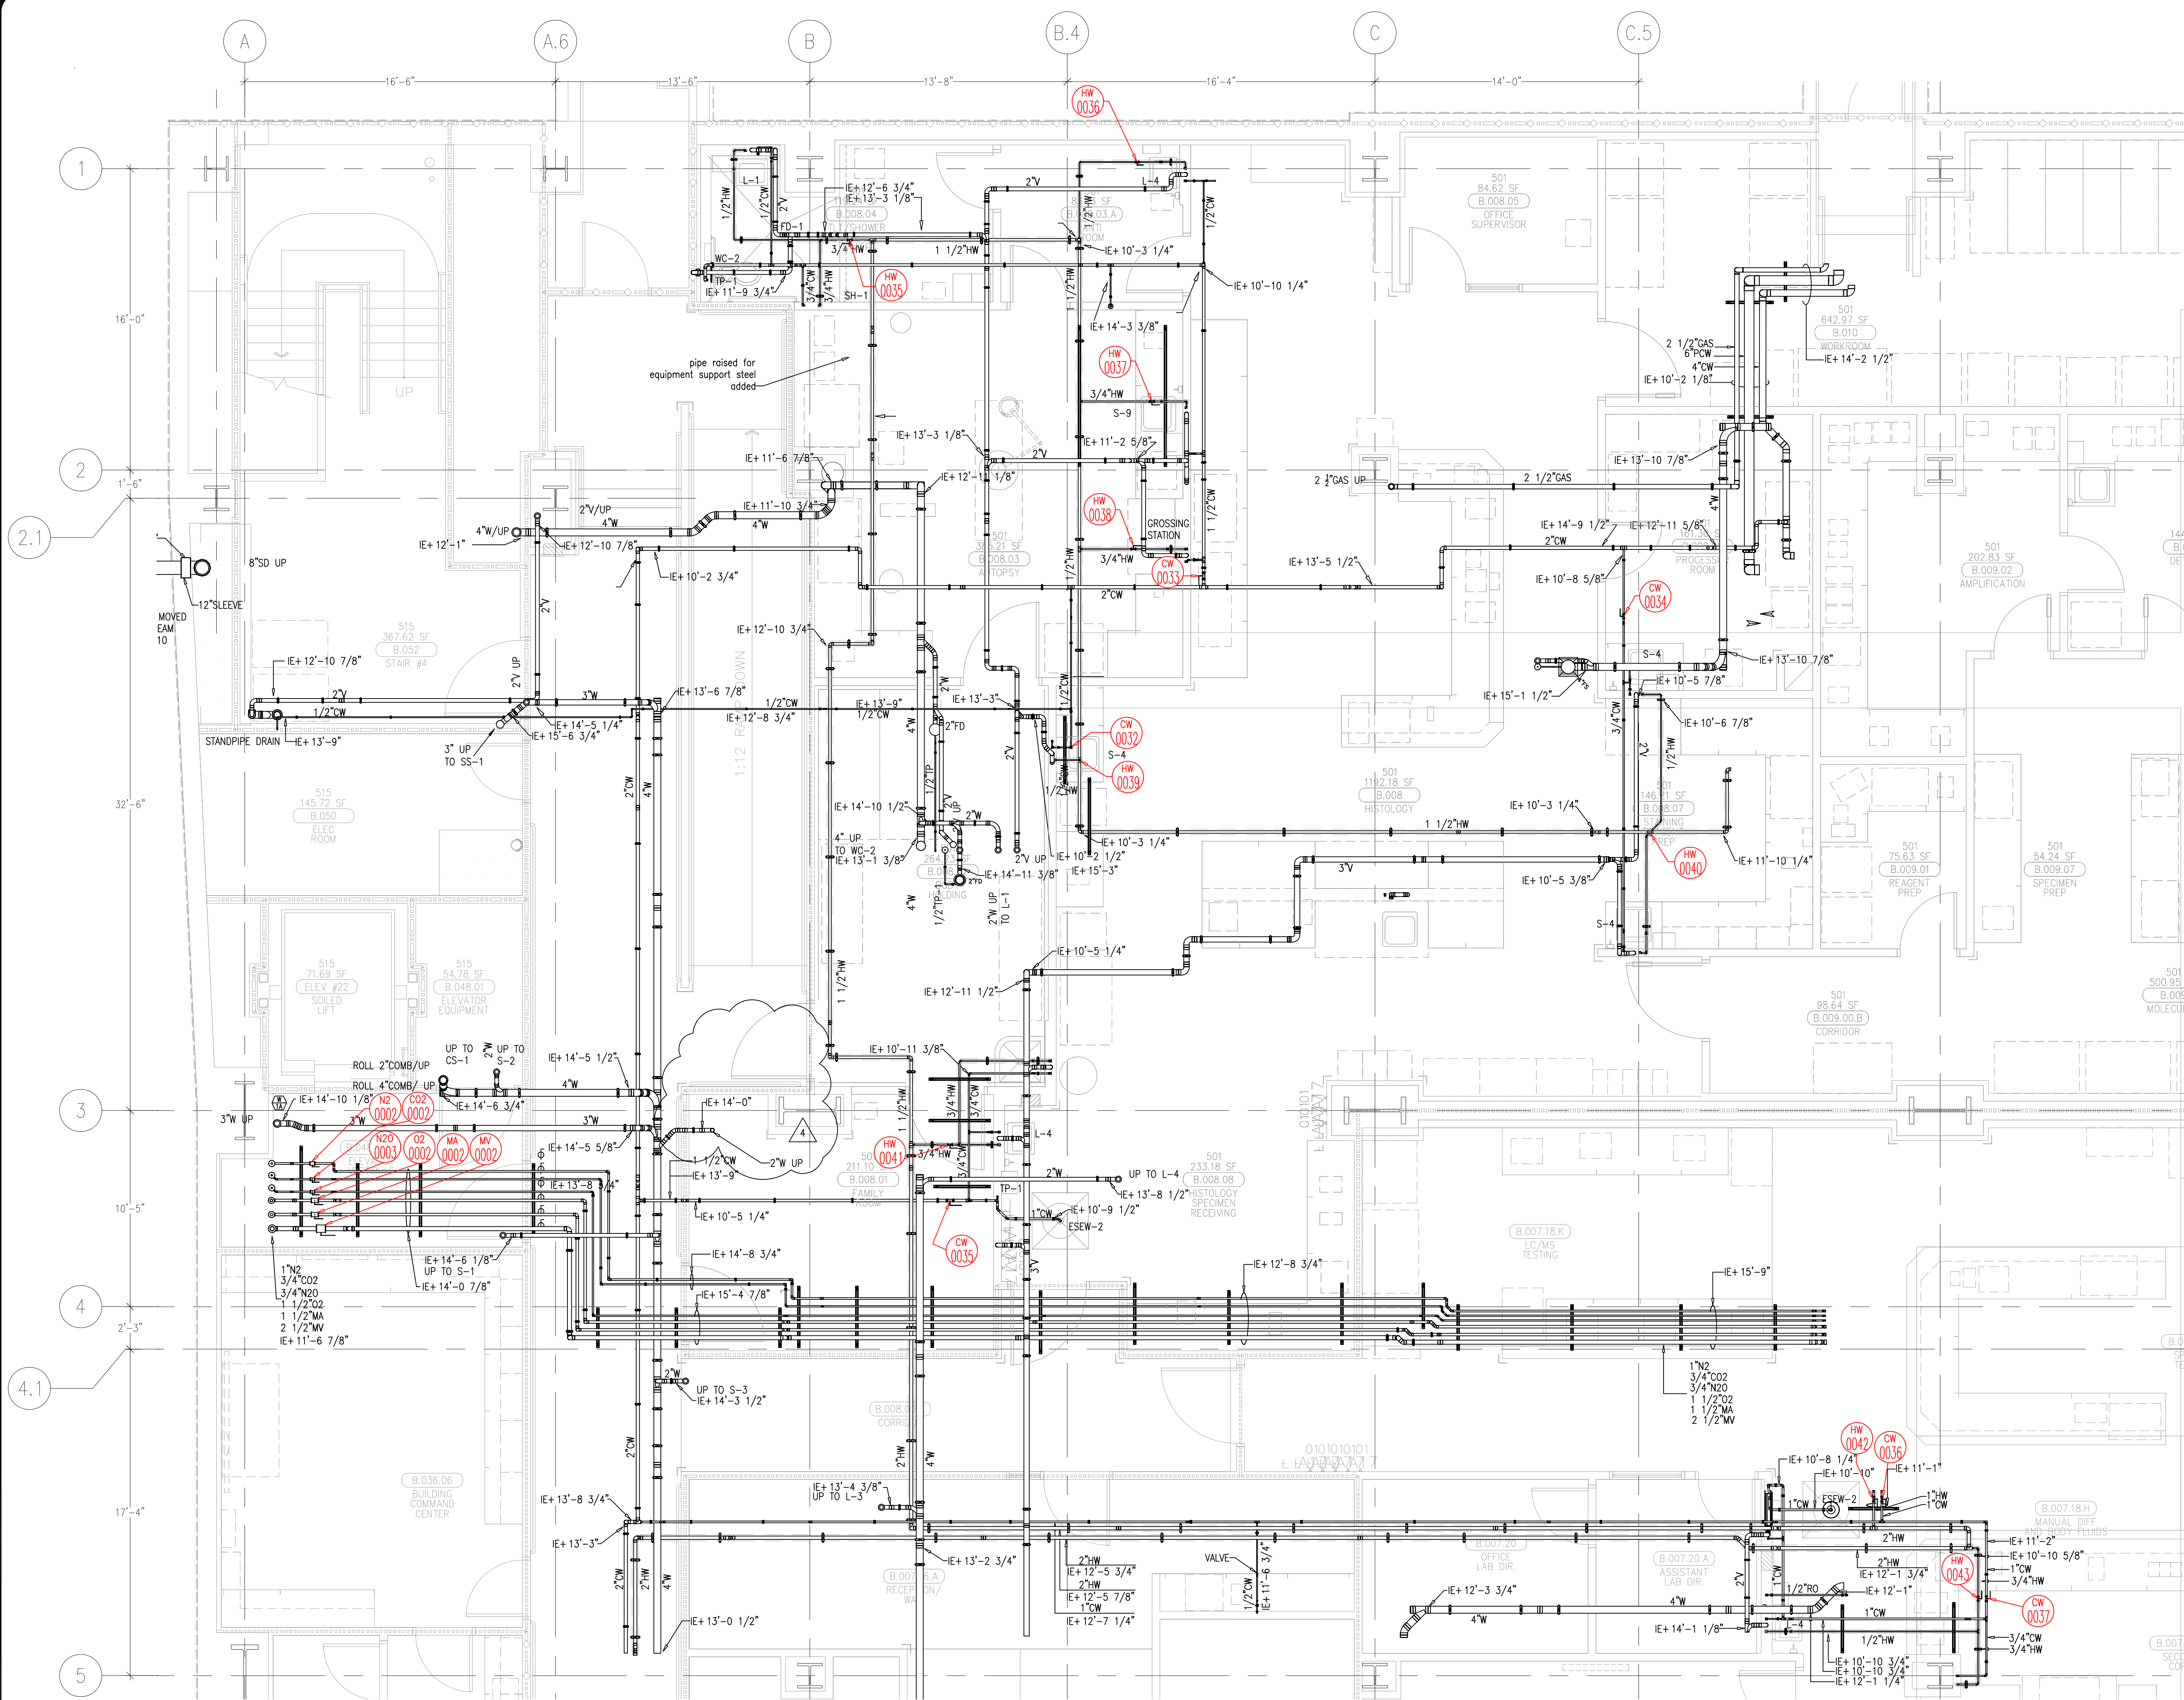

LEVEL 00 144.30' = 0'-0"
REFERENCE THIS SHEET

ISSUED FOR COORDINATION
SIGN-OFF 9-18-09
ISSUED FOR COORDINATION
SIGN-OFF 10-27-09
REVISED STANDPIPE
RISER LOCATION PER PP
11-18-09

DK
DK
REO

REVISIONS	BY
ISSUED FOR COORDINATION SIGN-OFF 9-18-09	DK
ISSUED FOR COORDINATION SIGN-OFF 10-27-09	DK
REVISED STANDPIPE RISER LOCATION PER PP 11-18-09	REO
ADDED FLOOR DRAINS IN THE MIR ROOMS. IE+15-10	DK
REVISED DUE TO SLAB CONFLICT 02-24-11	DK
501 262 ADDED WATER FOR CM-1. 12-18-10	DK
501 272 ADDED WASTE FOR SK-3 03-22-10	DK

COORD.	SIGNATURE	DATE
MECHANICAL		
ELECTRICAL		
PLUMBING		
STRUCTURAL		


R.F.I.	SENT	ANS.	R.F.I.	SENT	ANS.	R.F.I.	SENT	ANS.
0038	05/28/09	07/10/09	0131	07/08/09	0415	07/08/09	0415	07/08/09
0039	05/28/09	07/10/09	0141	06/24/09	0421	06/24/09	0421	06/24/09
0040	05/28/09	07/10/09	0181	06/11/09	0463	06/11/09	0463	06/11/09
0041	05/28/09	07/10/09	0219	06/23/09	0486	06/23/09	0486	06/23/09
0042	05/28/09	07/10/09	0242	06/23/09	0487	06/23/09	0487	06/23/09
0043	05/28/09	07/10/09	0245	06/23/09	0519	06/23/09	0519	06/23/09
0044	05/28/09	07/10/09	0266	07/18/09	0731	07/18/09	0731	07/18/09

CHILDREN'S HOSPITAL
OF ORANGE COUNTY
455 S. MAIN ST.
ORANGE, CA 92668-3974
TOWER II
PLUMBING FLOOR PLAN - LEVEL 00 AREA K

PAN-PACIFIC
PLUMBING & MECHANICAL
2919 E. VICTORIA STREET, RANCHO DOMINGUEZ, CA 90221
PH. 310 637-1500 FAX 310 604-0359

DRAWN
R.O.
CHECKED
M.M.
DATE
4/30/2012
SCALE
1/4" = 1'-0"
JOB NO.
09-006
DRAWING NUMBER
PL3.0K
REFERENCE DRAWING
A3.0K
P3.0K
1 OF 1 SHEETS

This document and the design it covers are the property of Murray Co. They are loaned only with the borrower's expressed written agreement that they will not be reproduced, copied, loaned, exhibited, or used in any way, except by written consent from Murray Co. to the borrower.

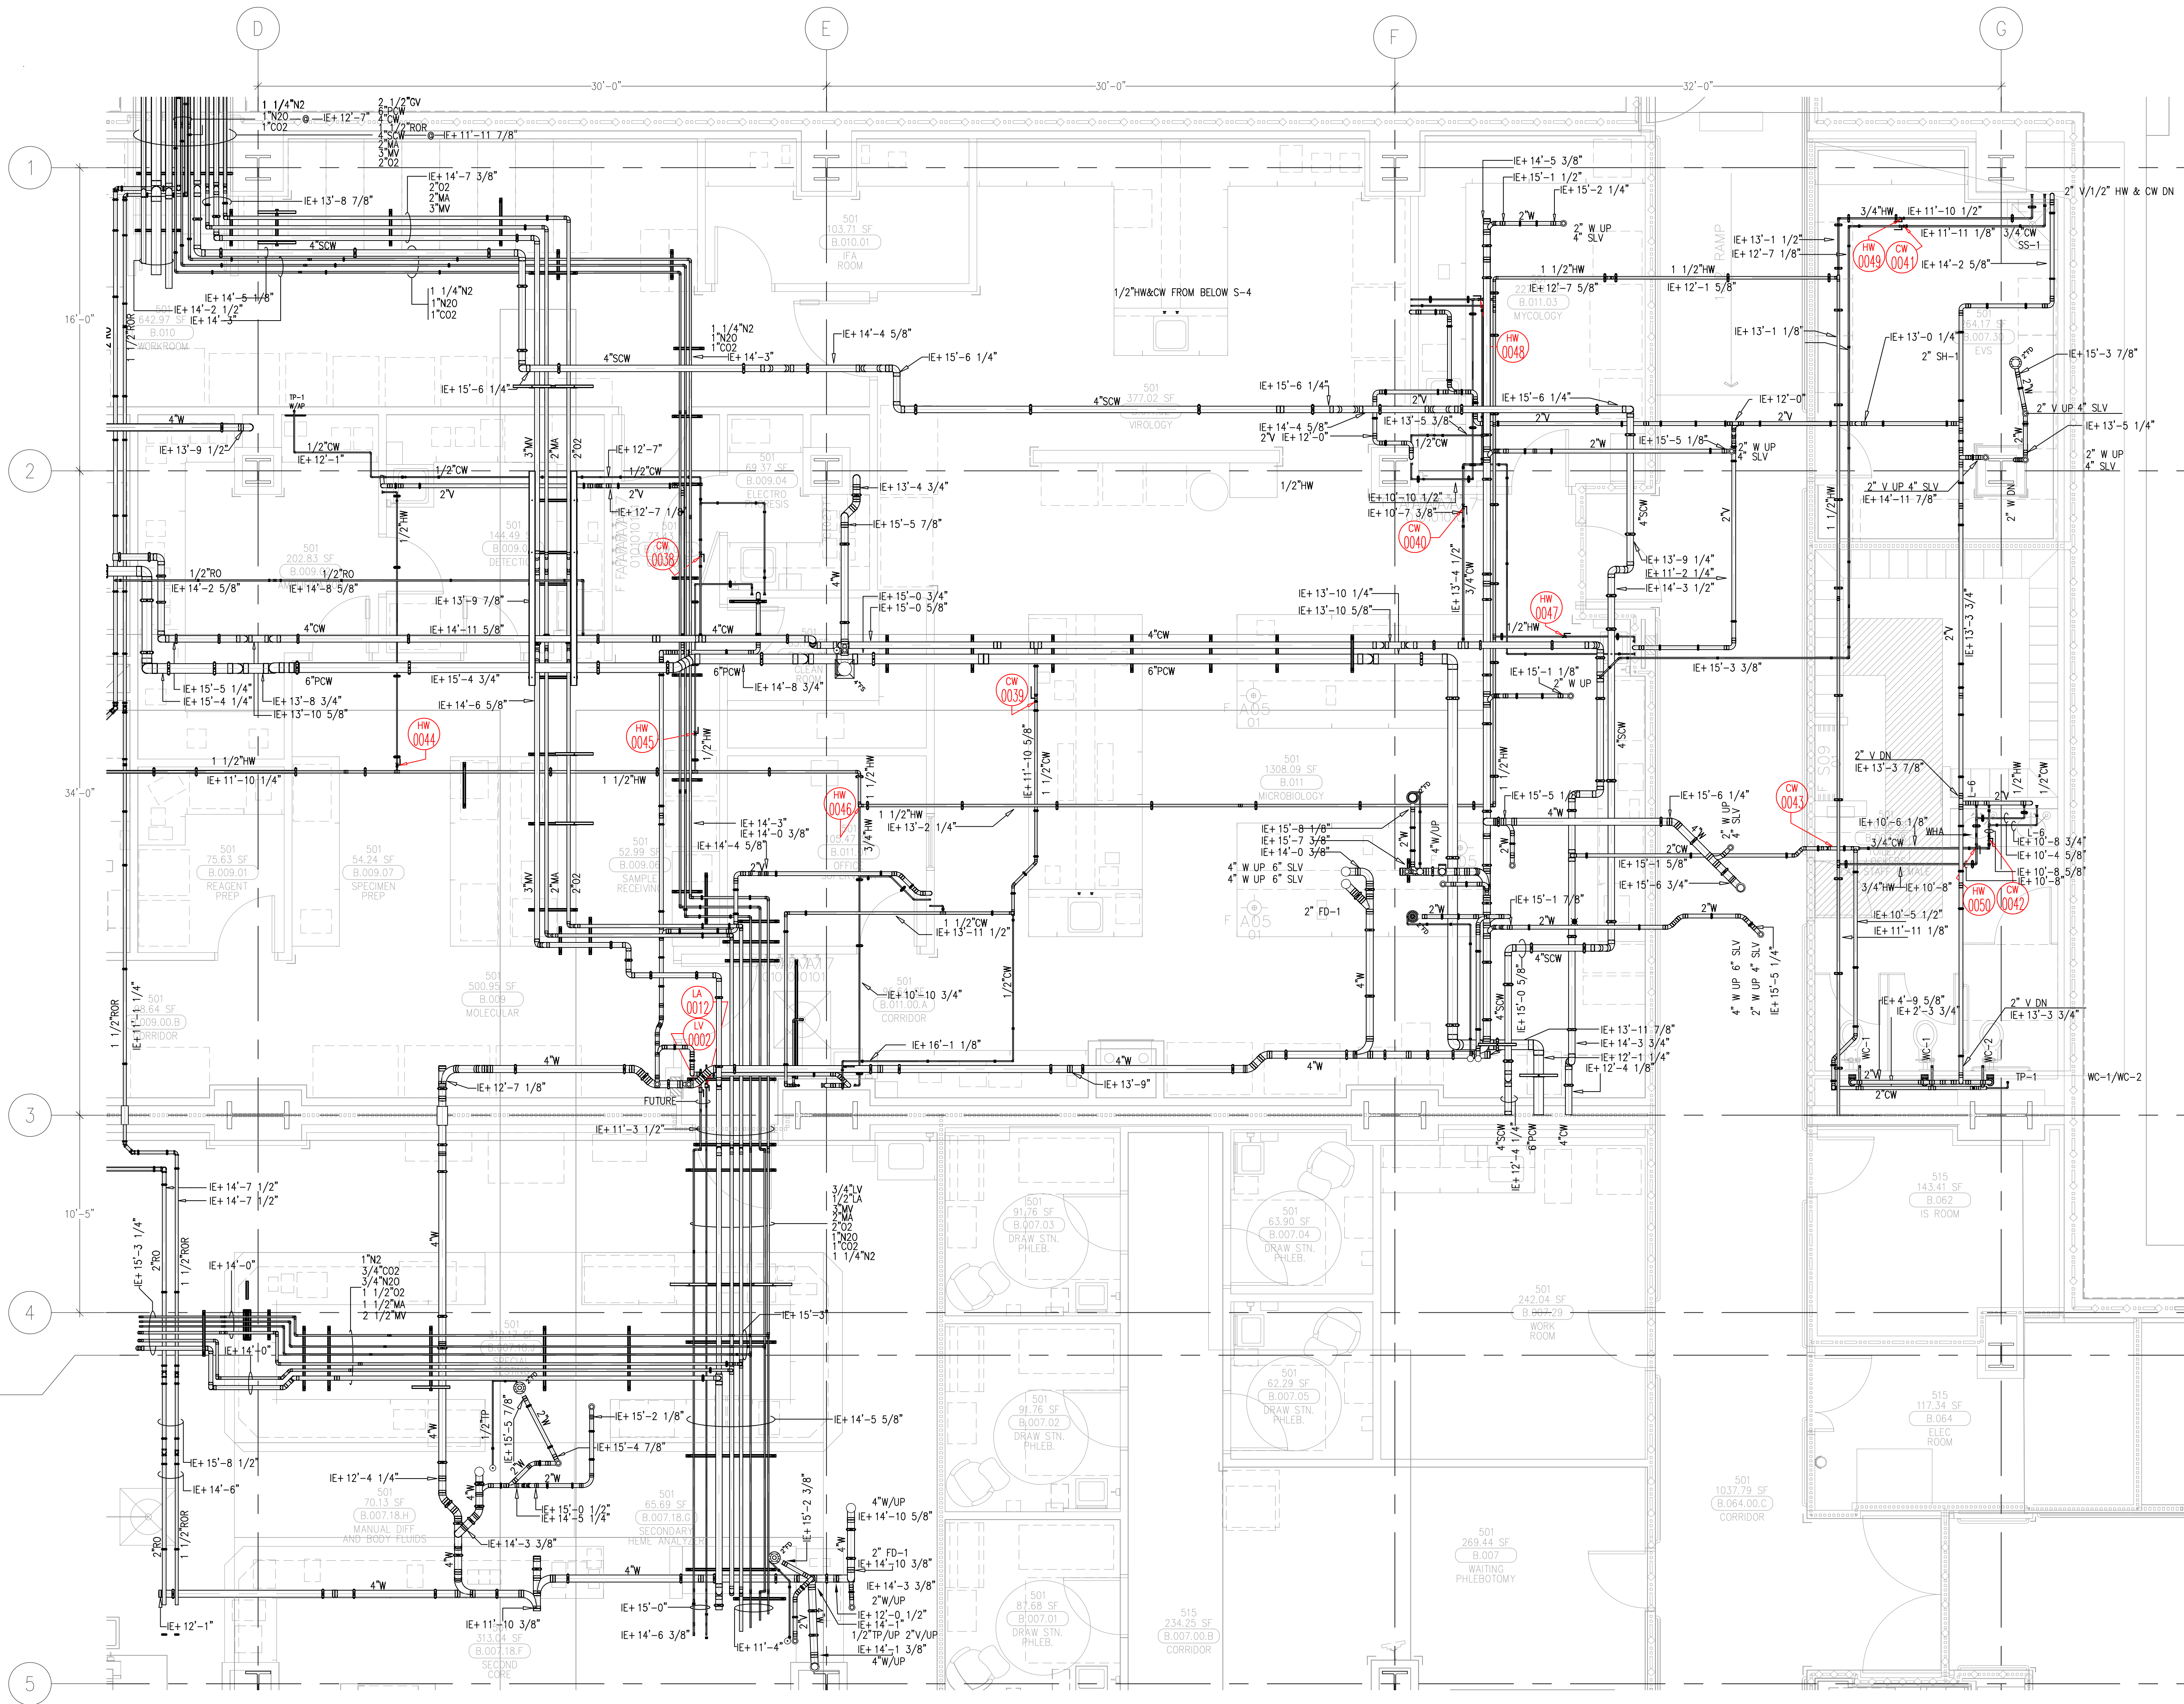

McCARTHY APPROVAL

A. Approved as noted for Architectural Review

B. Review and Re-submit


C. Rejected

This review is for general conformance with Plans and Specifications only. Any deviations from same not clearly noted by the Proposer have not been reviewed. Review shall not constitute a warranty, check of detailed dimensions or count to serve to release the Proposer of contractual responsibility for any error or deviation from contract requirements.

McCarthy

By _____ Date _____

SHOP DRAWING REFERENCE NO. _____

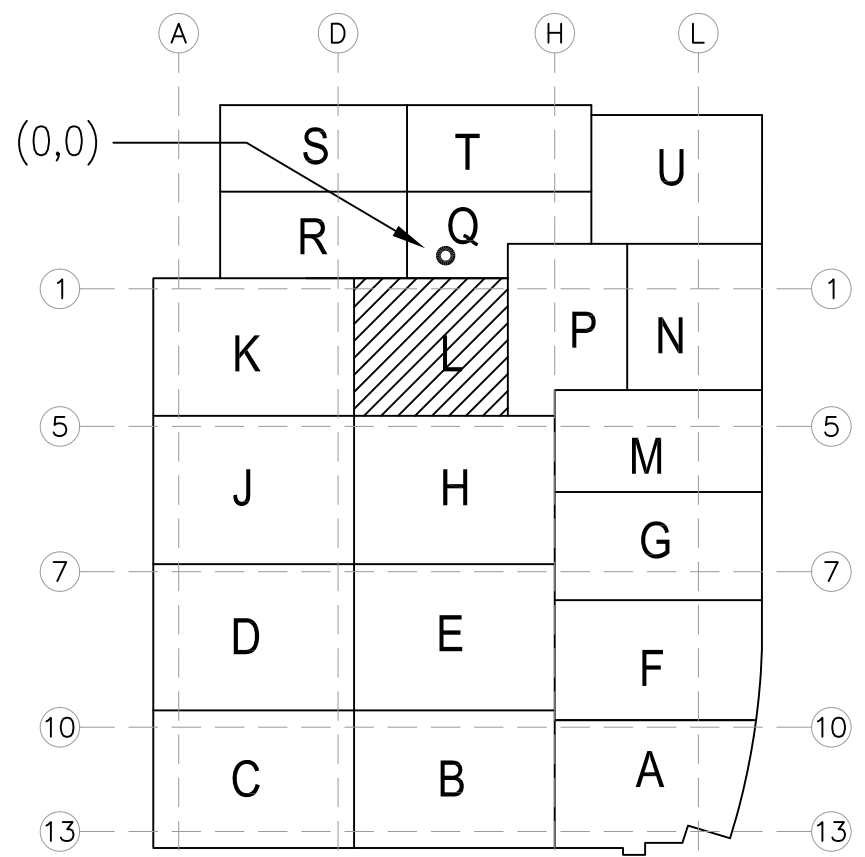

REVISIONS	BY
A	ISSUED FOR COORDINATION SIGN-OFF 9-18-09 DK
B	FMP 9-19-2009 JT
C	ISSUED FOR COORDINATION SIGN-OFF 10-27-09 DK
D	FWING 881 0431 INCORPORATED 11-5-09 RED
E	ISSUED FOR COORDINATION SIGN-OFF 02-28-10 DK
F	ISSUED FOR CONSTRUCTION 04-08-10 DK
G	REVISED PIPING DUE TO OVERLOOKED SILL 12-13-10 DK
H	REVISED PIPING DUE TO SUP. STEEL CONFLICT. 10-08-11 GP

COORD.	SIGNATURE	DATE
MECHANICAL		
ELECTRICAL		
PLUMBING		
STRUCTURAL		



R.F.I.	SENT	ANS.	R.F.I.	SENT	ANS.
0161	05/11/09	06/23/09	0431	09/29/09	10/20/09
0203	06/26/09	08/24/09			
0212	06/19/09	09/19/09			
0219R1	07/04/09	09/25/09			
0265	07/16/09	07/25/09			
0420	06/29/09	10/13/09			
0428	09/29/09	10/14/09			

CHILDREN'S HOSPITAL
CHOC[®] OF ORANGE COUNTY
455 S. MAIN ST., 3RD FLOOR
ORANGE, CA 92668-3974
TOWER II
PLUMBING FLOOR PLAN - LEVEL 00 AREA-L


PAN-PACIFIC
PLUMBING & MECHANICAL
company
2919 E. VICTORIA STREET, RANCHO DOMINGUEZ, CA 90221
PH. 310 637-1500 FAX 310 604-0359

DRAWN
R.O.
CHECKED
M.M.
DATE
4/30/2012
SCALE
1/4" = 1'-0"
JOB NO.
09-006
DRAWING NUMBER
PL3.0L
REFERENCE DRAWING
A3.0L
P3.0L
1 OF 1 SHEETS

This document and the design it covers are the property of Murray Co. They are loaned only with the borrower's expressed written agreement that they will not be reproduced, copied, loaned, exhibited, or used in any other way, except by written consent from Murray Co. to the borrower.

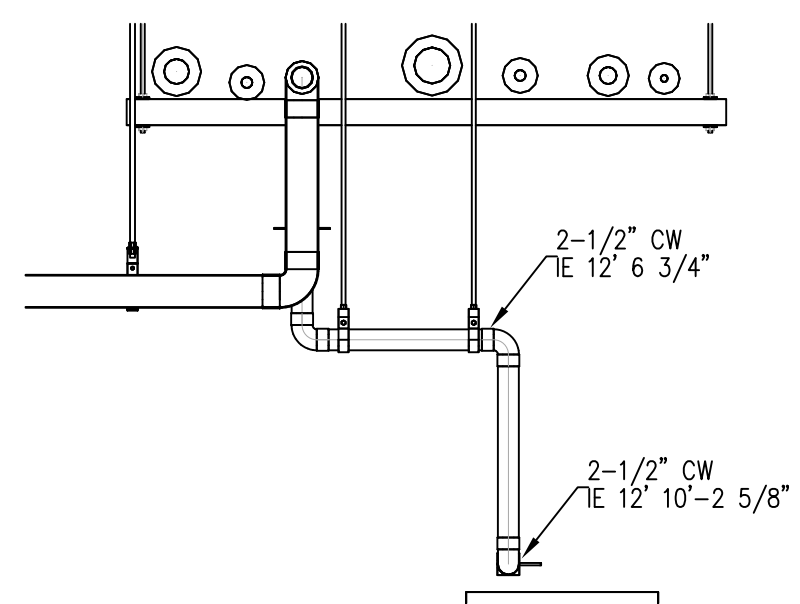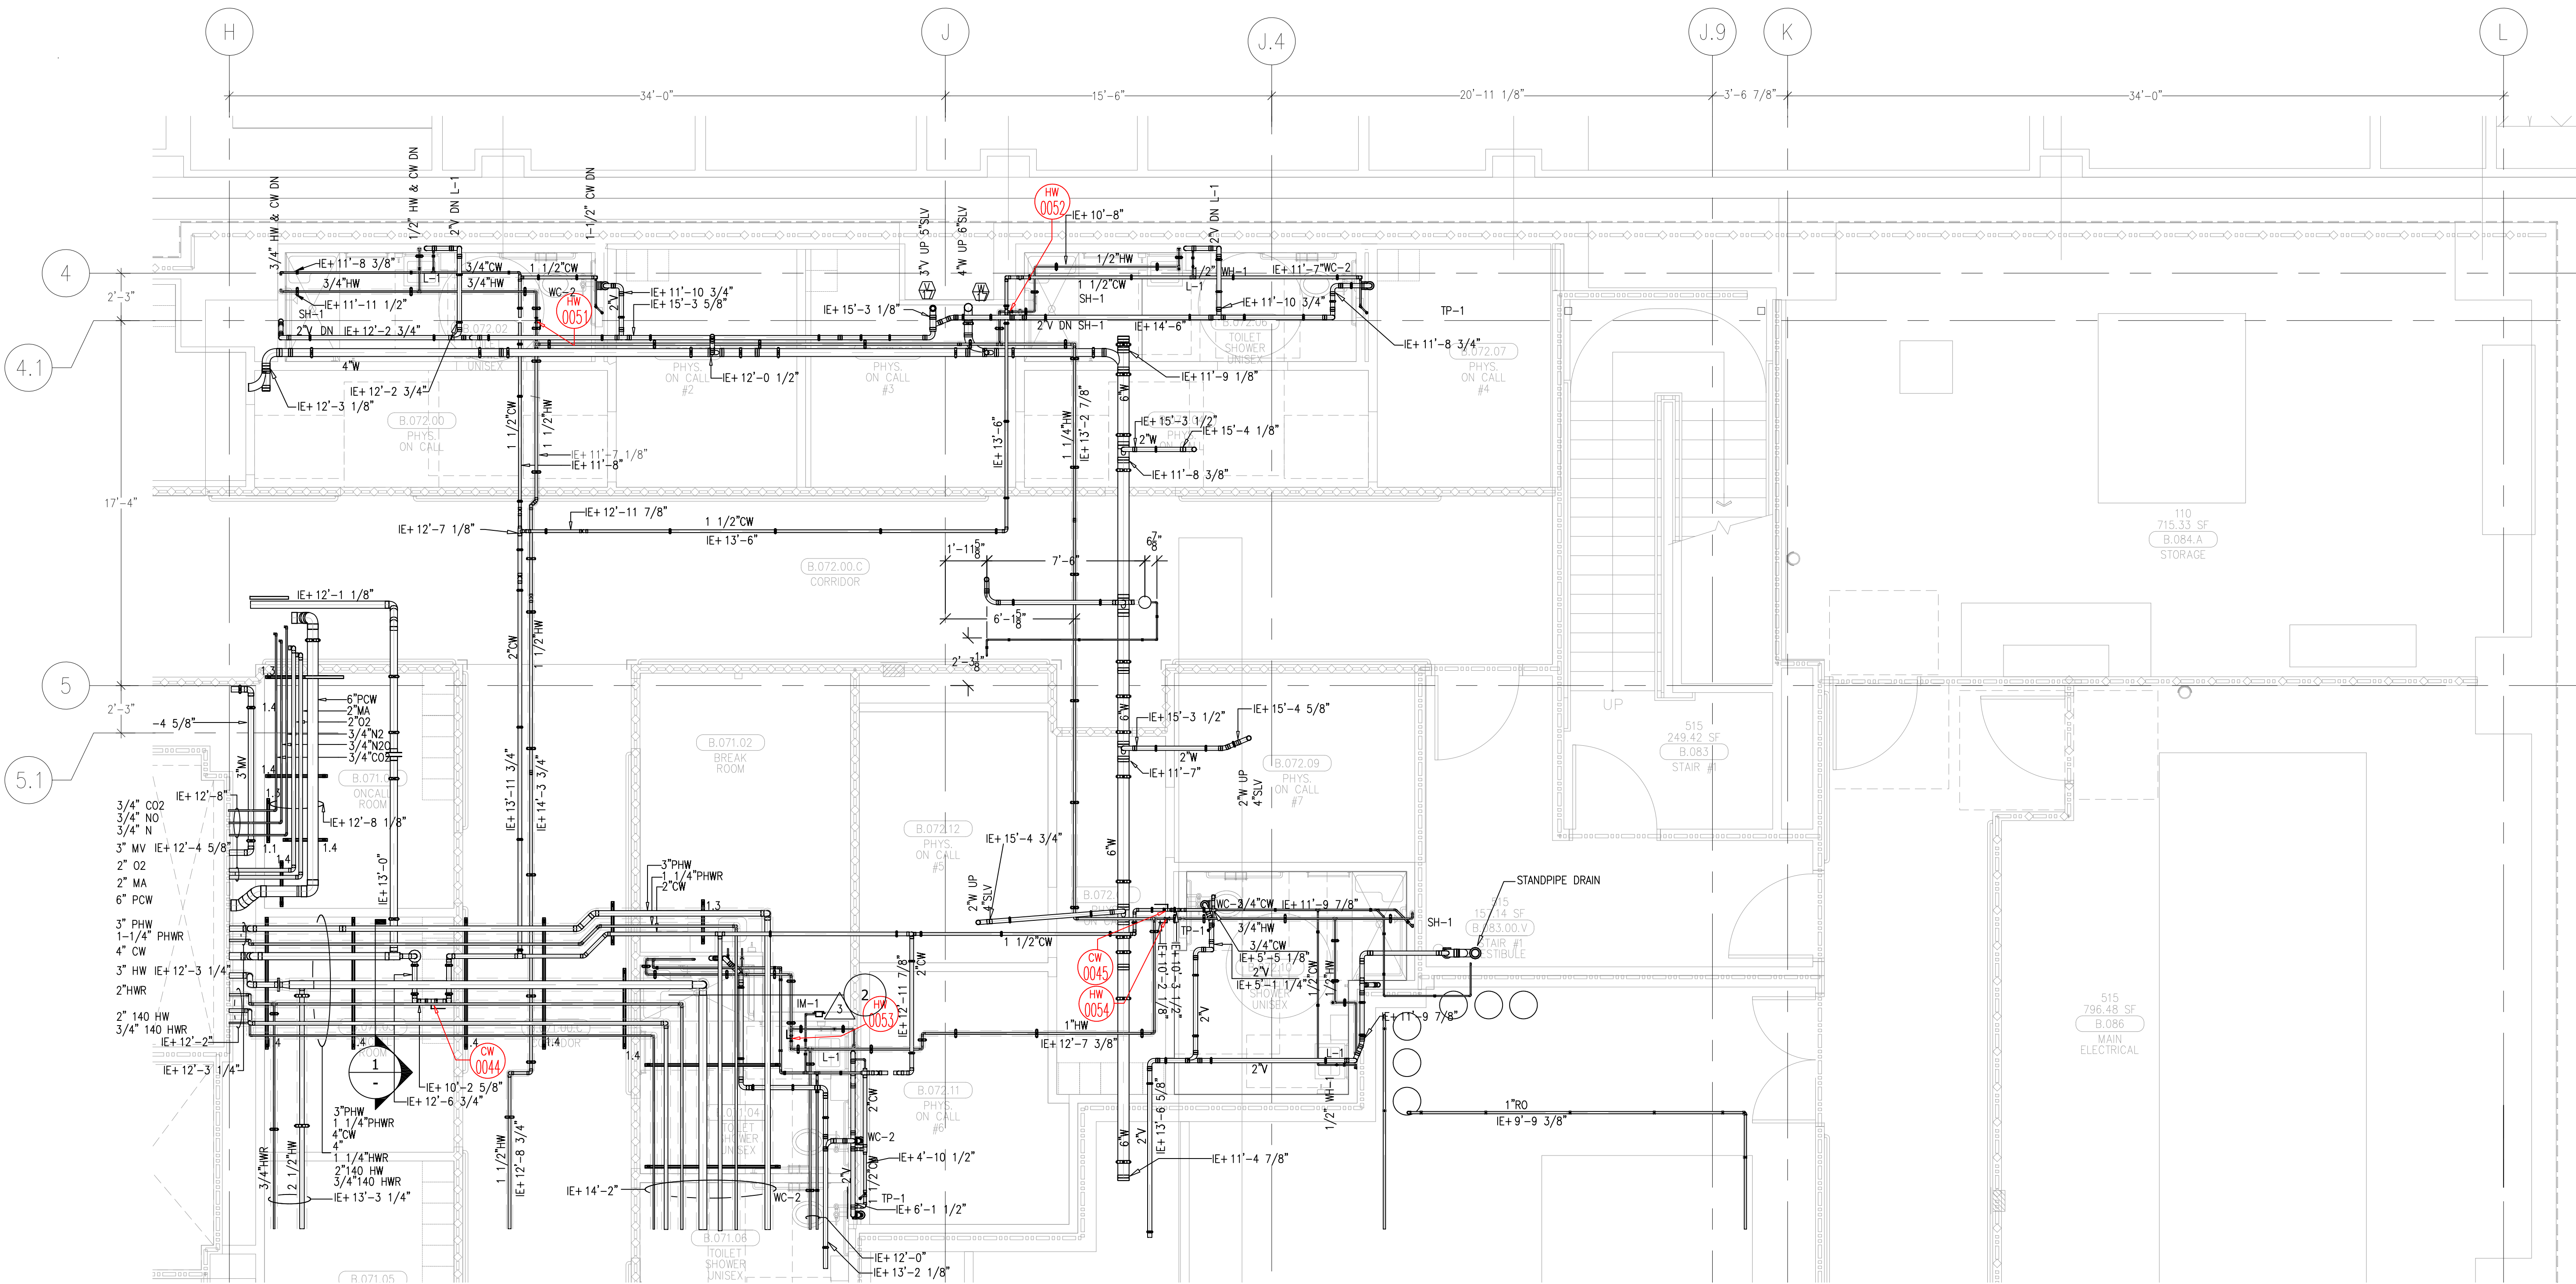

1 SECTION VIEW
Scale: 1/2"=1'

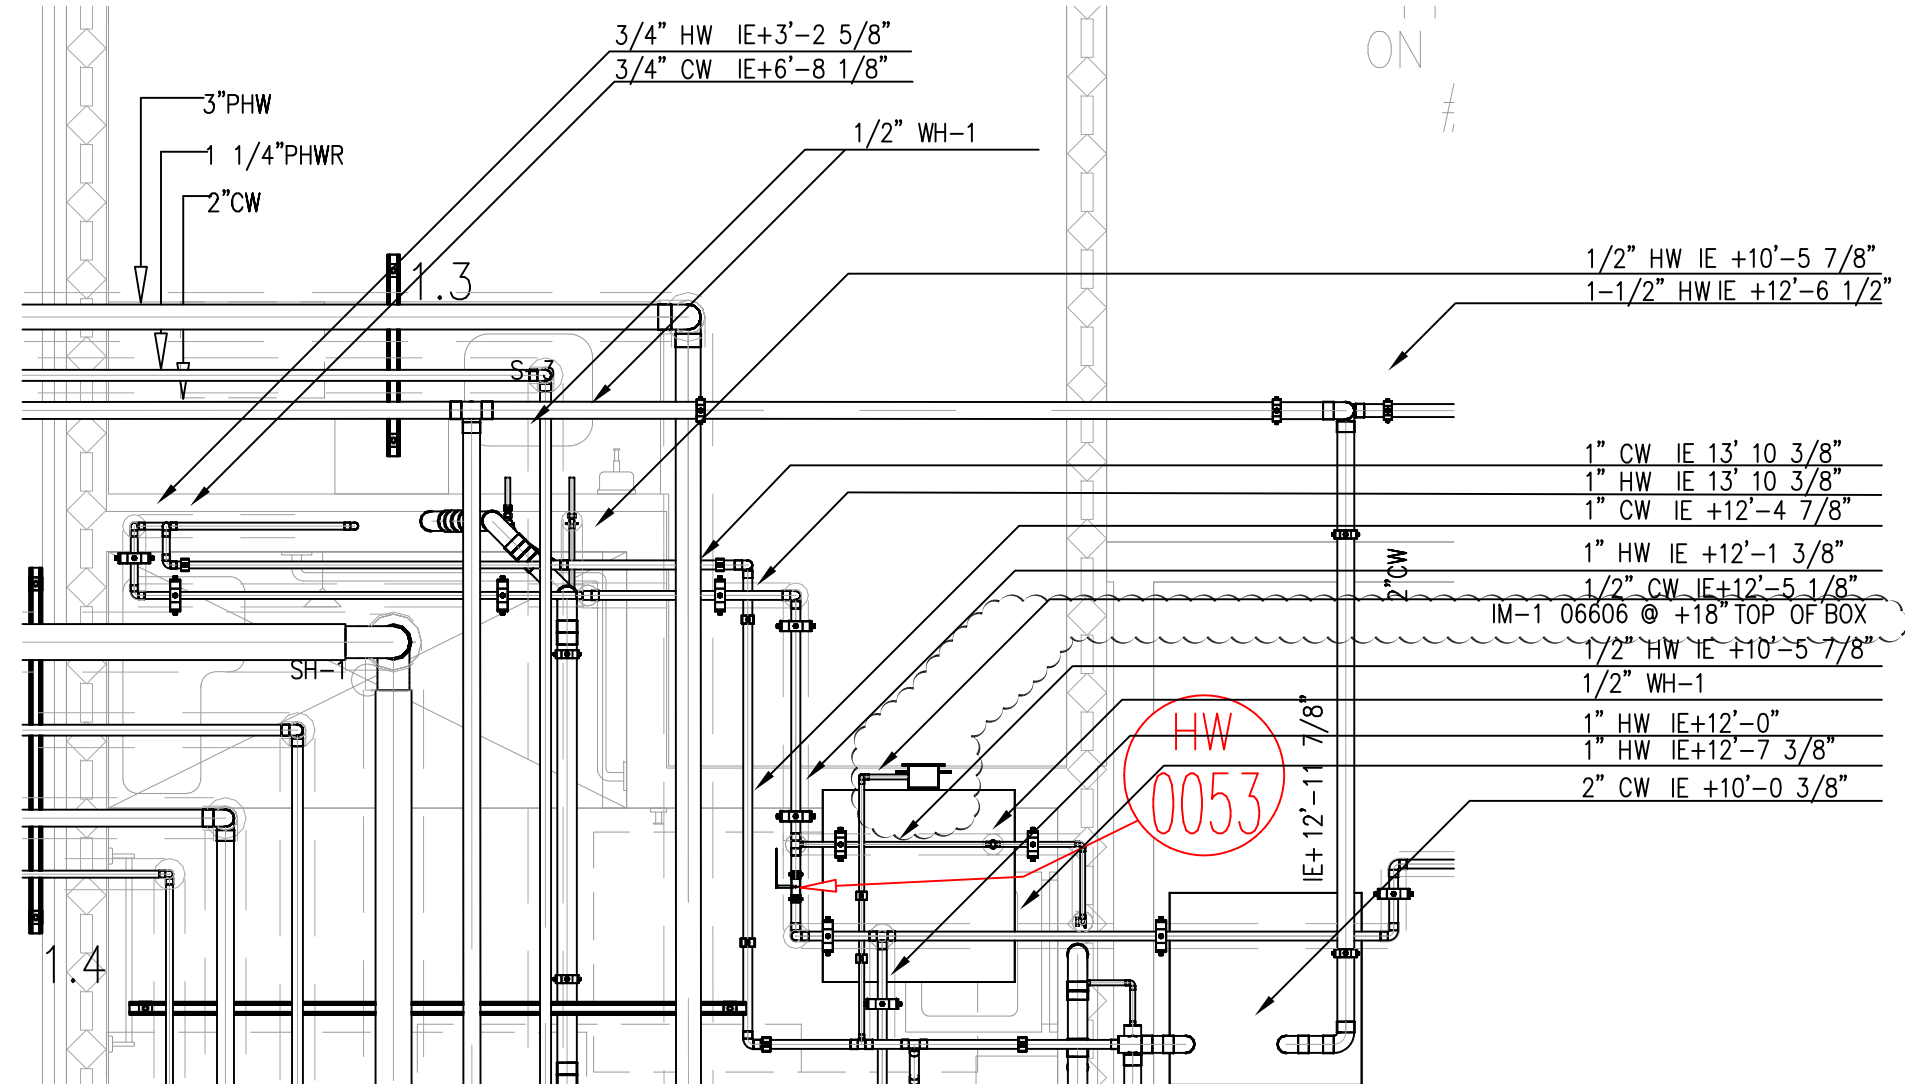

2 SECTION VIEW
Scale: 1/2"=1'


MCCARTHY APPROVAL	
A. Approved as noted for Architectural Review	☐
B. Review and Revisit	☐
C. Rejected	☐

This review is for general conformance with Plans and Specifications only. Any deviations from same not clearly noted by the Preparer have not been reviewed. Review shall not constitute a complete check of detailed dimensions or count to serve to relieve the Preparer of contractual responsibility for any error or deviation from contract requirements.

McCarthy

By _____ Date _____

SHOP DRAWING REFERENCE NO. _____

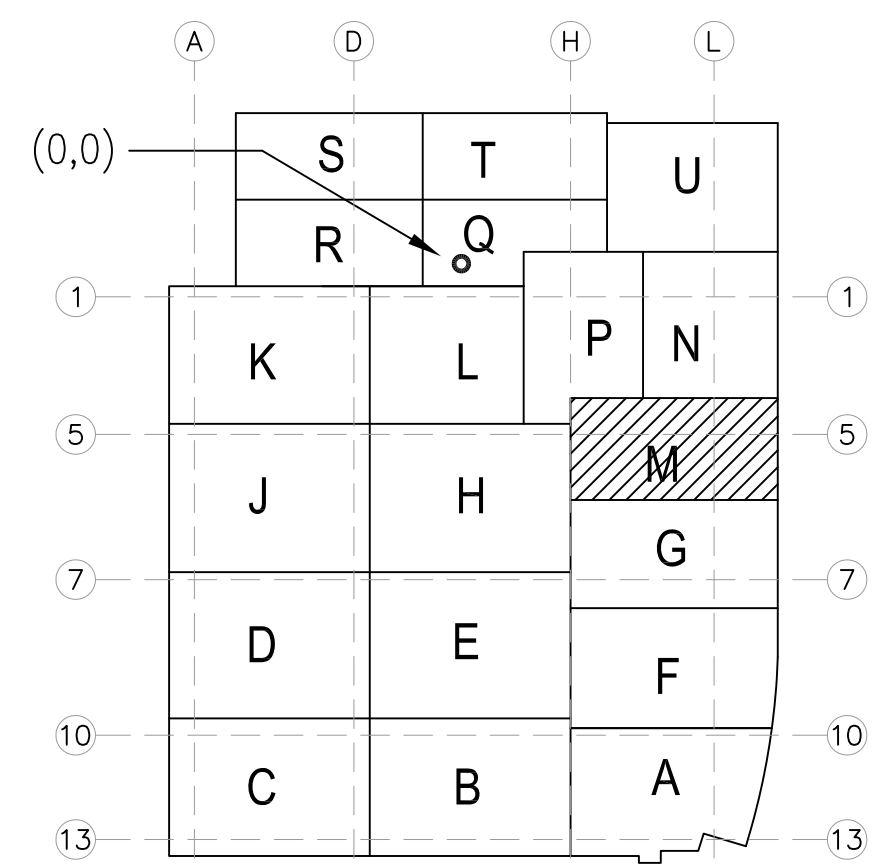

A1 KEY PLAN

A	ISSUED FOR COORDINATION SIGN-OFF 9-18-09	DK
B	ISSUED FOR COORDINATION SIGN-OFF 10-27-09	DK
C	REVISED STANDPIPE RISER LOCATION PER FP 11-18-09	REC
D	ISSUED FOR RE-COORDINATION SIGN-OFF 2-26-10	DK

0	ISSUED FOR CONSTRUCTION 04-08-10	DK
1	REMOVED OLD STANDPIPE PLUMBING NOT USED. 5-27-10	DK
2	W/FM 965 ADDED FLOOR DRAIN 09-10-10	DK
3	REVISED PER ICE MAKER ROUGH-IN 11-24-10	JT

COORD.	SIGNATURE	DATE
MCCARTHY		
MECHANICAL DUCT		
MECHANICAL PIPE		
PLUMBING		
ELECTRICAL		
FIRE SPRINKLER		
PLUMB		
DRYWALL/FRAMER		
REFRIGERATION		
STRUCTURAL		

R.F.L.	SENT	ANS.	R.F.L.	SENT	ANS.	R.F.L.	SENT	ANS.
008	04/09/09	04/13/09						
0019	04/11/09	06/03/09						
	09/29/09	10/10/09	0425					
0437	09/29/09	10/14/09						
0522	10/19/09	10/28/09						
	10/19/09	11/03/09						
0866	9/10/10							

CHOC[™] HOSPITAL
CHILDREN'S HOSPITAL
OF ORANGE COUNTY
455 S. Main St.
Orange, CA 92668-3874
TOWER II
PLUMBING FLOOR PLAN - LEVEL 00 AREA-M


PAN-PACIFIC
PLUMBING & MECHANICAL

PM Murray Company


2919 E. VICTORIA STREET, RANCHO DOMINGUEZ, CA 90221
PH. 310 837-1500 FAX 310 604-0359

DRAWN R.O.
CHECKED M.M.
DATE 4/30/2012
SCALE 1/4"=1'-0"
JOB NO. 09-006
DRAWING NUMBER PL3.0M
REFERENCE DRAWING A3.0M P3.0M

This document and the design it covers are the property of Murray Co. They are loaned only with the borrower's expressed written agreement that they will not be reproduced, copied, loaned, exhibited, or used in any other way, except by written consent from Murray Co. to the borrower.

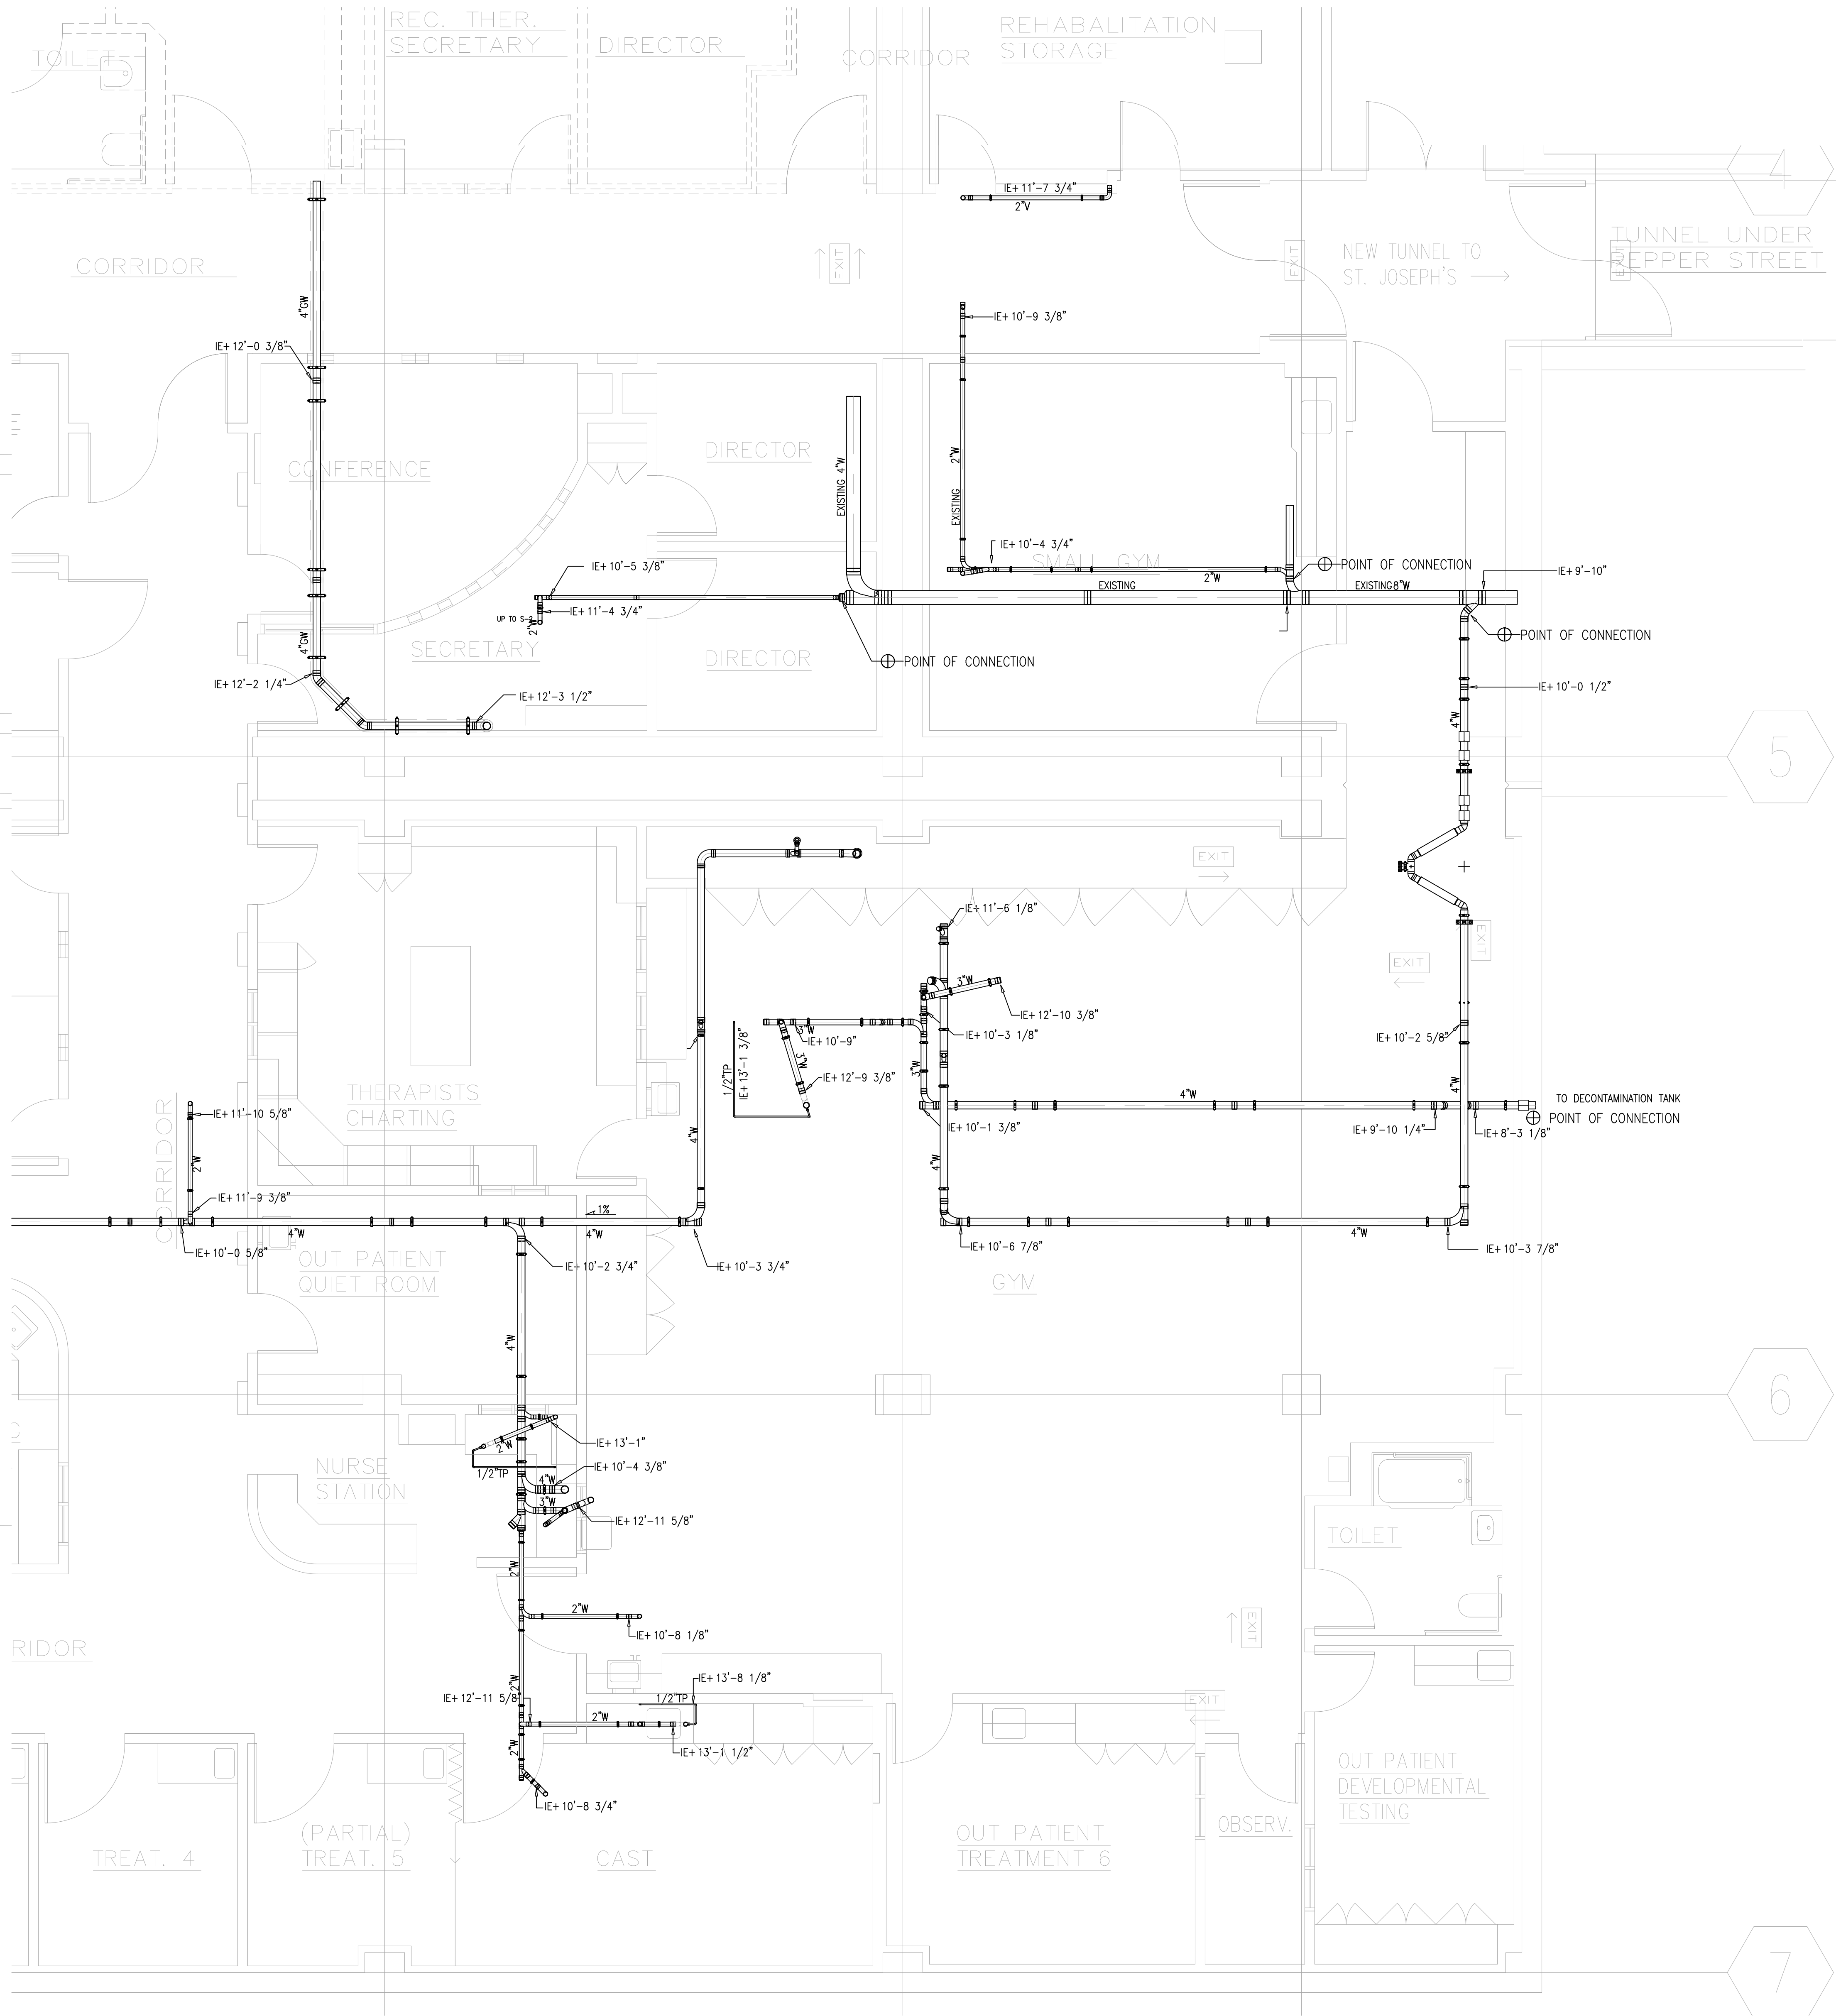

LEVEL 00 144.30' = 0'-0"
REFERENCE THIS SHEET

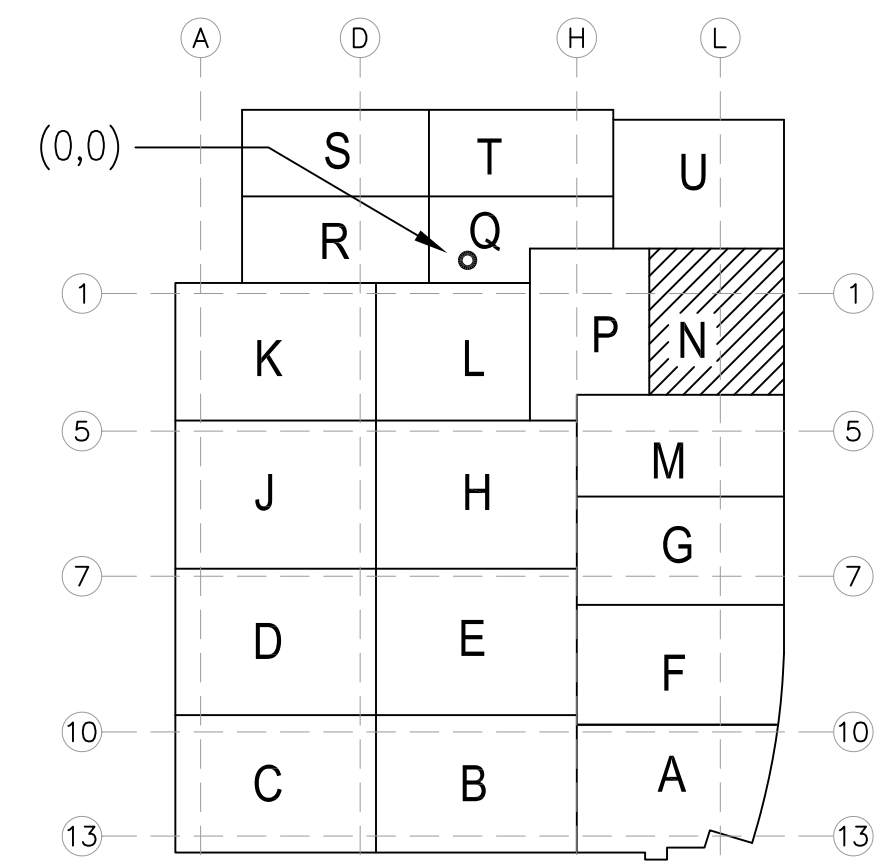

REVISIONS	BY
A	ISSUED FOR COORDINATION SIGN-OFF 9-18-09 DK
B	ISSUED FOR COORDINATION SIGN-OFF 10-27-09 DK
C	ISSUED FOR RE-COORDINATION SIGN-OFF 2-26-10 DK
D	ISSUED FOR CONSTRUCTION 04-08-10 DK
1	MOVED OR RISER DUE TO SHEAR WALL CONFLICT. DK
2	REROUTED WASTE TO NEW POC. DK

COORD.	SIGNATURE	DATE
MECHANICAL		
ELECTRICAL		
PLUMBING		
STRUCTURAL		

R.F.I.	SENT	ANS.	R.F.I.	SENT	ANS.	R.F.I.	SENT	ANS.
0331	08/25/09	08/25/09						
0373	08/02/09	09/18/09						
0409	09/22/09	10/02/09						

**CHILDREN'S HOSPITAL
CHOCTM OF ORANGE COUNTY**
455 S. MAIN ST., 3RD FLOOR
ORANGE, CA 92668-3974




TOWER II

PLUMBING FLOOR PLAN - LEVEL 00 AREA

PAN-PACIFIC
PLUMBING & MECHANICAL
2919 E. VICTORIA STREET, RANCHO DOMINGUEZ, CA 90221
PH. 310.637-1500 FAX 310.604-0359

DRAWN
R.O.
CHECKED
M.M.
DATE
4/30/2012
SCALE
1/4" = 1'-0"
JOB NO.
09-006
DRAWING NUMBER
PL3.0N
REFERENCE DRAWING
A3.0N
P3.0N
1 OF 1 SHEETS

This document and the design it covers are the property of Murray Co. They are loaned only with the borrower's expressed written agreement that they will be reproduced, copied, loaned, exhibited, or used in any other way, except by written consent from Murray Co. to the borrower.

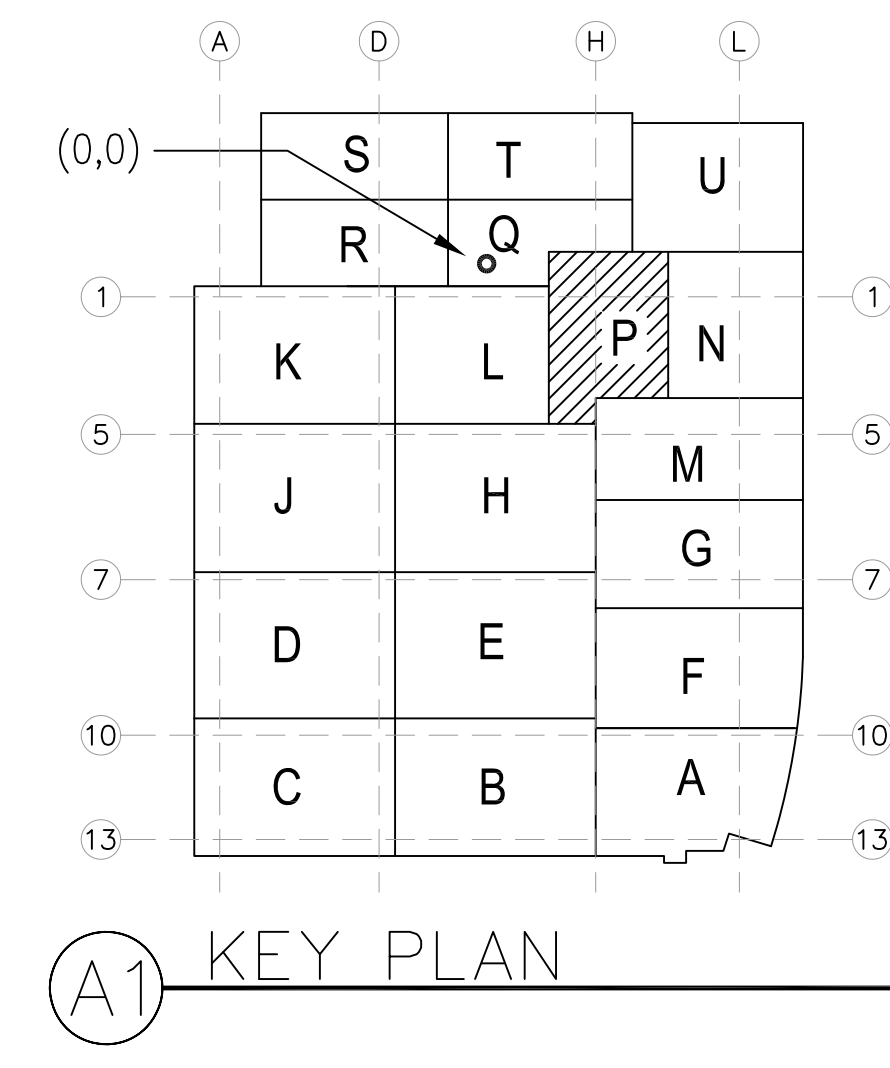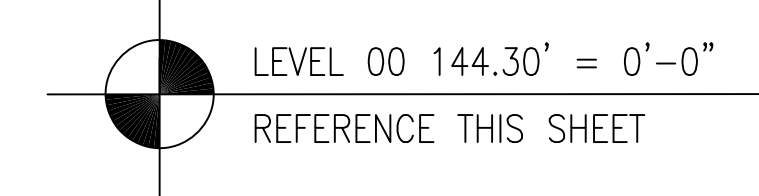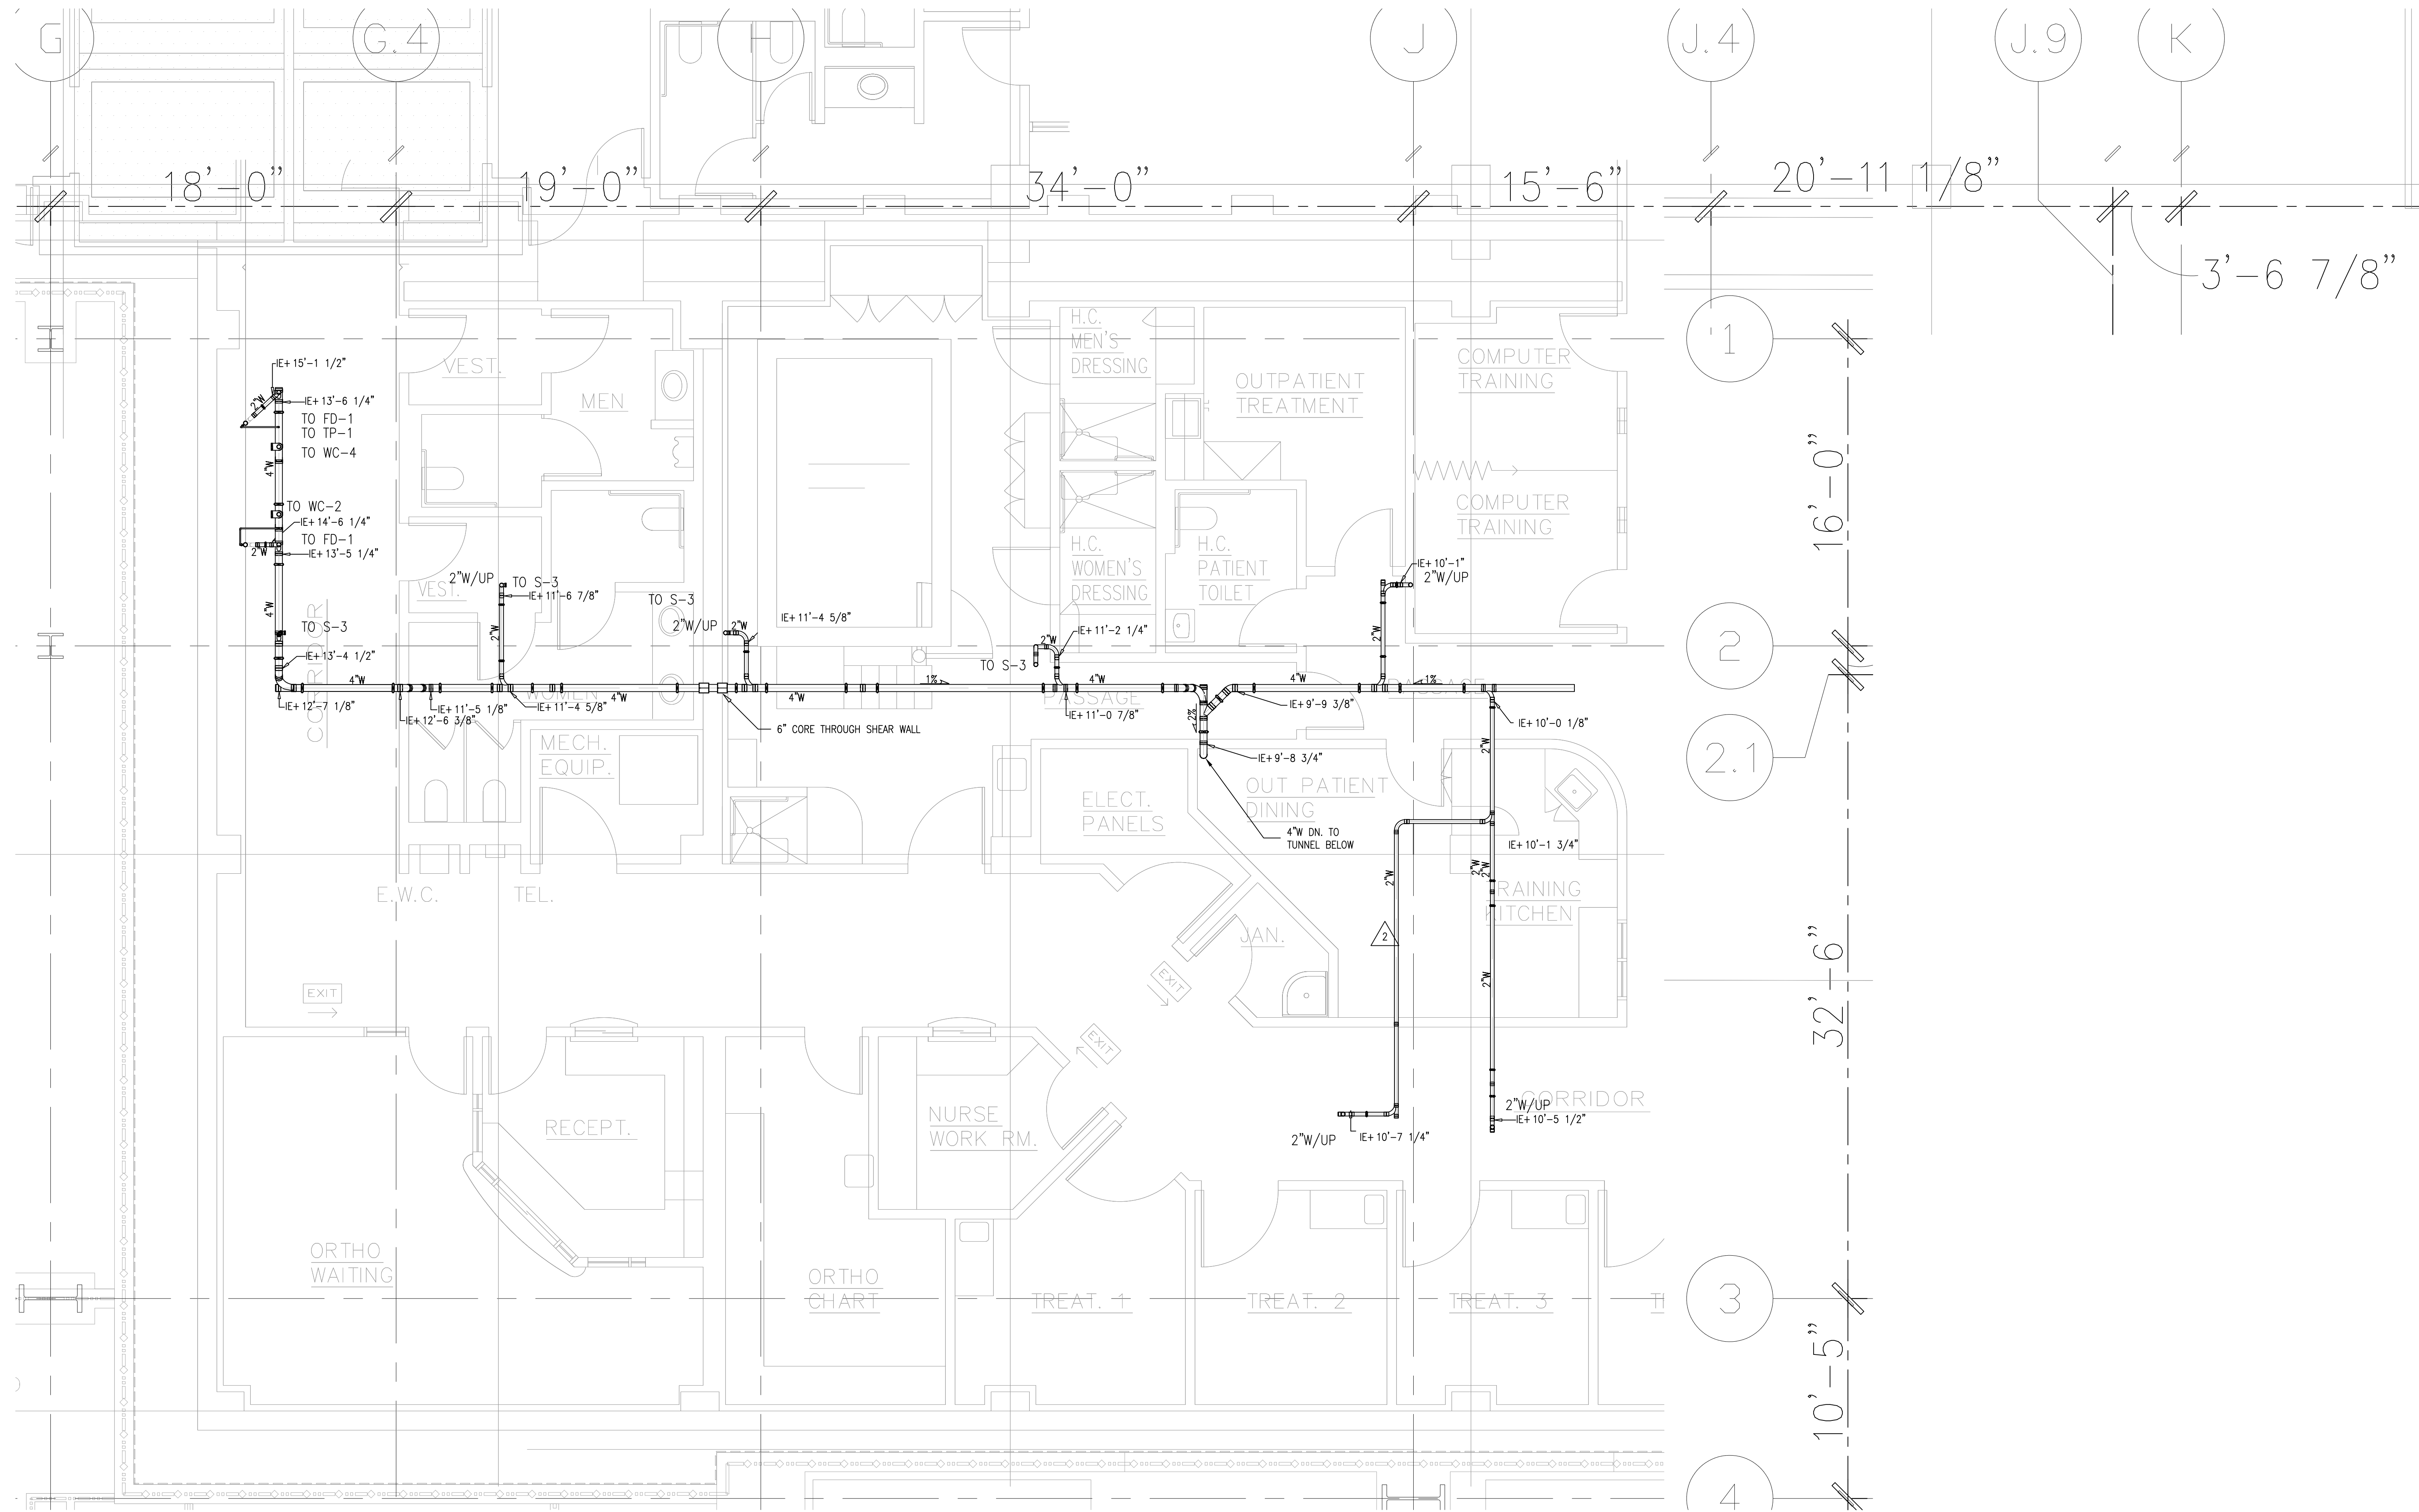

REVISIONS		BY
A	ISSUED FOR COORDINATION SIGN-OFF 9-18-09	DK
B	ISSUED FOR COORDINATION SIGN-OFF 10-27-09	DK
C	ISSUED FOR RE-COORDINATION SIGN-OFF 2-26-10	DK
D	ISSUED FOR CONSTRUCTION 04-08-10	DK
E	REVISED WASTE LAYOUT 05-18-10	JT
F	REVISED WASTE LAYOUT 08-17-10	DK

COORD.	SIGNATURE	DATE
MECHANICAL		
ELECTRICAL		
PLUMBING		
STRUCTURAL		

R.F.I.	SENT	ANS.	R.F.I.	SENT	ANS.
0301	08/25/09	08/31/09			


**CHILDREN'S HOSPITAL
OF ORANGE COUNTY**
455 S. MAIN ST.
ORANGE, CA 92668-3974
TOWER II
PLUMBING FLOOR PLAN - LEVEL 00 AREAP

PAN-PACIFIC
PLUMBING & MECHANICAL
2919 E. VICTORIA STREET, RANCHO DOMINGUEZ, CA 90221
PH. 310 637-1500 FAX 310 604-0359

DRAWN
R.O.
CHECKED
M.M.
DATE
4/30/2012
SCALE
1/4" = 1'-0"
JOB NO.
09-006
DRAWING NUMBER
PL3.0P
REFERENCE DRAWING
A3.0P
P3.0P
1 OF 1 SHEETS

Dwg File: 09-006-000-MURRAY-DRAWING-PLUMBING-LEVEL 00 AREAP.dwg Plot by: PPI026 4-30-2012 10:22am

This document and the design it covers are the property of Murray Co. They are loaned only with the borrower's expressed written agreement that they will not be reproduced, copied, loaned, exhibited, or used in any other way, except by written consent from Murray Co. to the borrower.

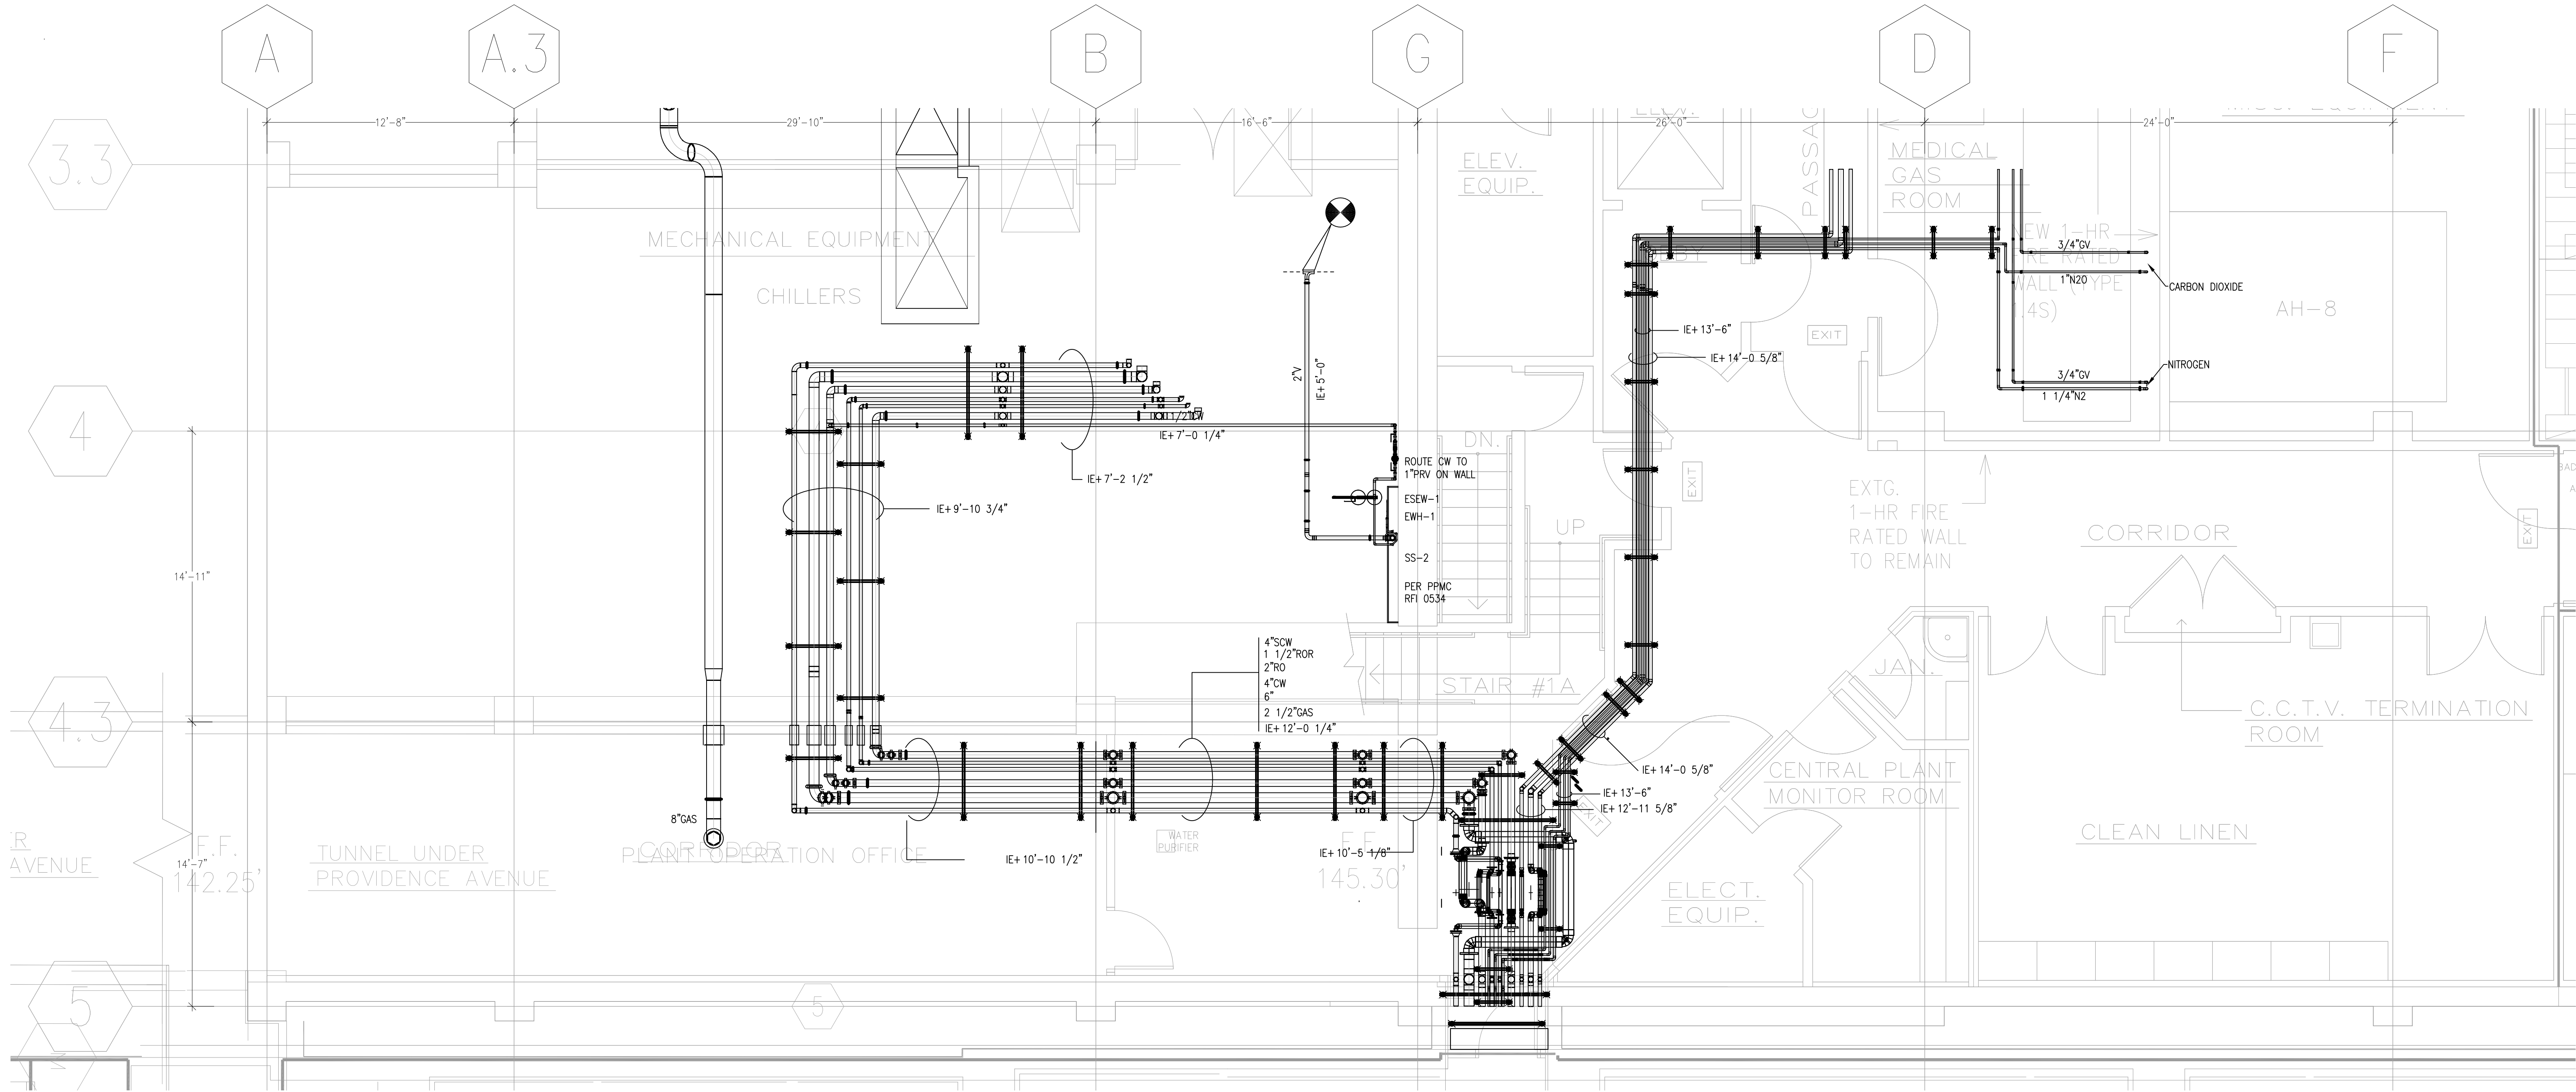

McCarthy APPROVAL

A. Approved as noted for Architectural Review

B. Review and Resubmit

C. Rejected

This review is for general conformance with Plans and Specifications only. Any deviations from same not clearly noted by the Proprietor have not been reviewed. Review shall not constitute a complete check of detailed dimensions or count to same to release the Proprietor of contractual responsibility for any error or deviation from contract requirements.

McCarthy

By: _____ Date: _____

SHOP DRAWING REFERENCE NO. _____

LEVEL 00 144.30' = 0'-0"
REFERENCE THIS SHEET

REVISIONS		BY
A	ISSUED FOR COORDINATION SIGN-OFF 9-18-09	DK
B	ISSUED FOR COORDINATION SIGN-OFF 10-27-09	DK
C	PPMC RFI 0534 INCORPORATED 11-5-09	REO
D	ISSUED FOR RE-COORDINATION SIGN-OFF 2-26-10	DK
E	ISSUED FOR CONSTRUCTION SIGN-OFF 4-21-10	DK
F	REVISED PIPING DUE TO OVERPOURED SILL 12-13-10	DK

COORD.	SIGNATURE	DATE
MECHANICAL		
ELECTRICAL		
PLUMBING		
STRUCTURAL		


R.F.I.	SENT	ANS.	R.F.I.	SENT	ANS.
0106	05/06/09	05/14/09			
0255	07/15/09	08/20/09			
0291	08/01/09	08/31/09			
0534	10/20/09	11/04/09			

CHILDREN'S HOSPITAL
OF ORANGE COUNTY
405 S. MAIN ST., SUITE 200
ORANGE, CA 92668-3974
TOWER II
PLUMBING FLOOR PLAN - LEVEL 00 AREA R

PAN-PACIFIC
PLUMBING & MECHANICAL
company
2919 E. VICTORIA STREET, RANCHO DOMINGUEZ, CA 90221
PH. 310 637-1500 FAX 310 604-0359

DRAWN
R.O.
CHECKED
M.M.
DATE
4/30/2012
SCALE
1/4" = 1'-0"
JOB NO.
09-006
DRAWING NUMBER
PL3.0R
REFERENCE DRAWING
A3.0R
P3.0R
1 OF 1 SHEETS

This document and the design it covers are the property of Murray Co. They are loaned only with the borrower's expressed written agreement that they will not be reproduced, copied, loaned, exhibited, or used in any way, except by written consent from Murray Co. to the borrower.

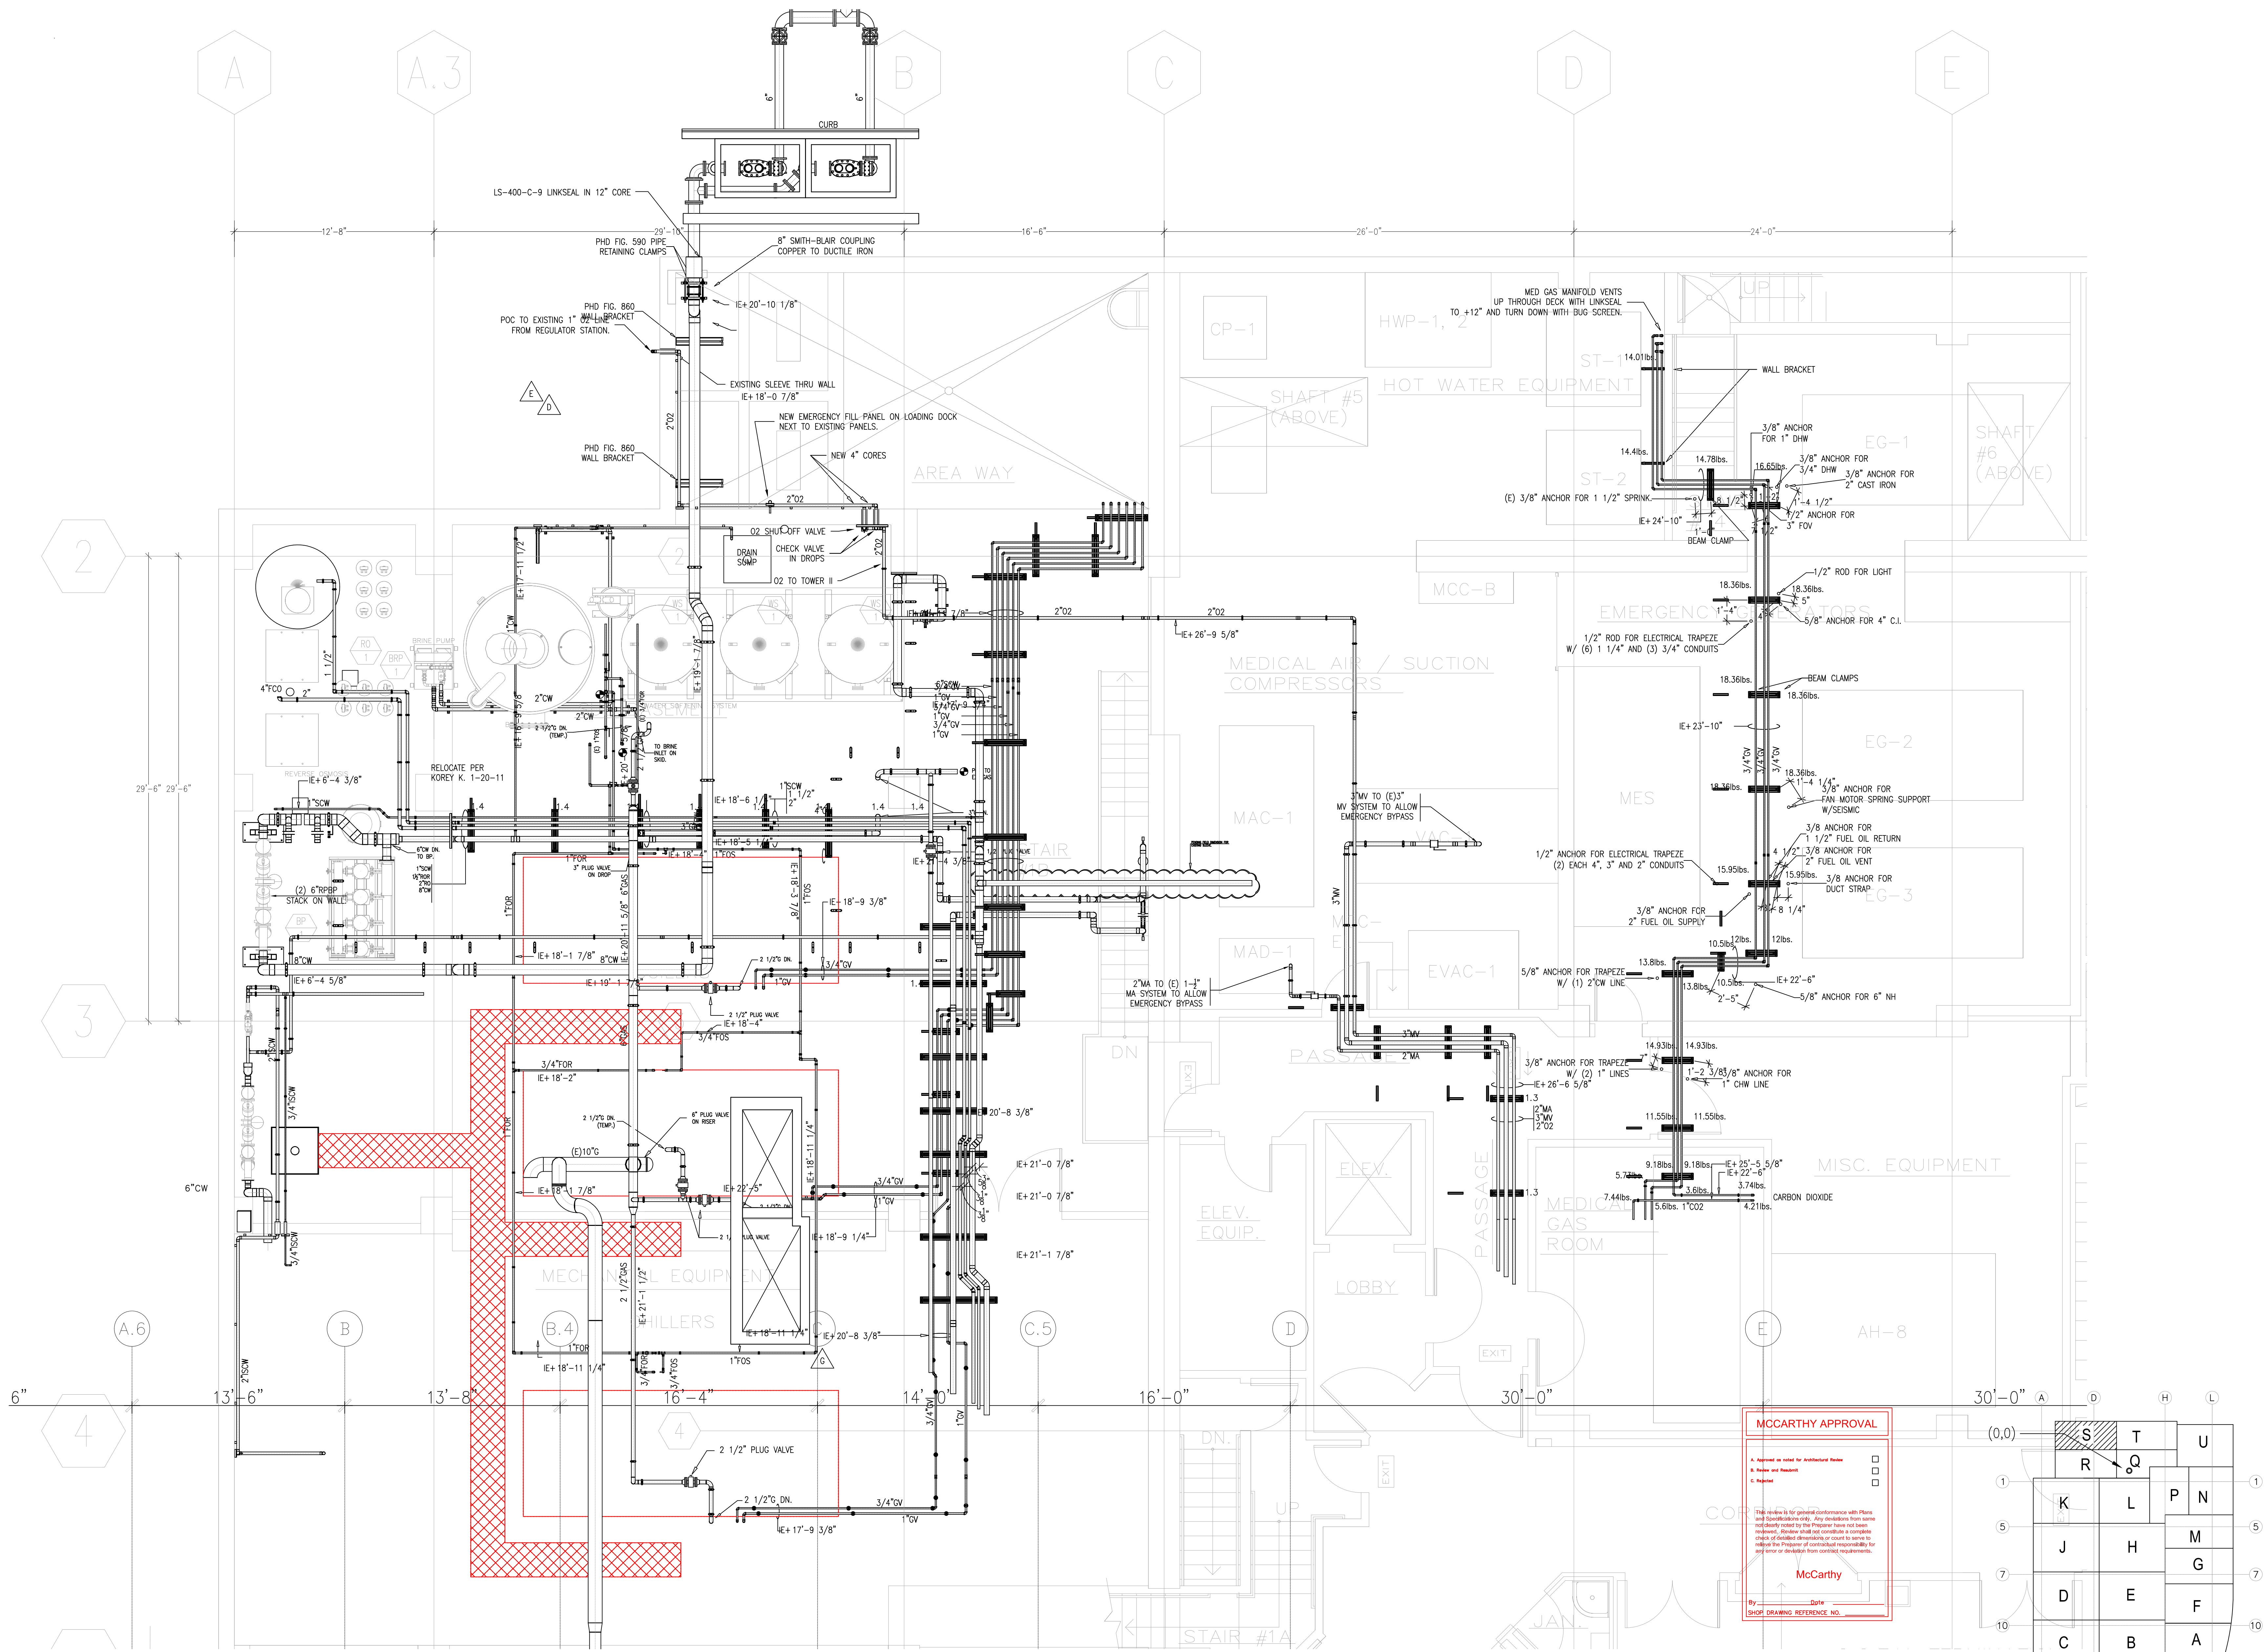


MCCARTHY APPROVAL

A. Approved as noted for Subcontract Review
B. Review and Rebuild
C. Rebuild

McCarthy

By: _____ Date: _____
SHOP DRAWING REFERENCE NO. _____

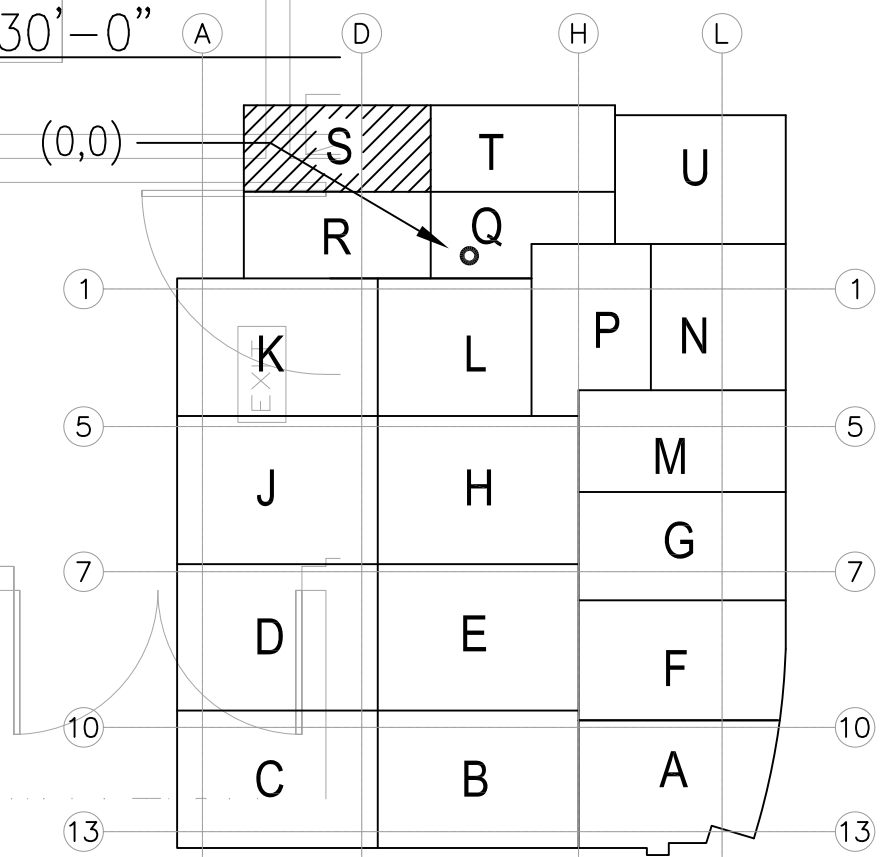

LEVEL 00 144.30' = 0'-0"
REFERENCE THIS SHEET

REVISIONS	BY
ISSUED FOR COORDINATION SIGN-OFF 9-18-09	DK
ISSUED FOR COORDINATION SIGN-OFF 10-27-09	DK
ISSUED FOR RE-COORDINATION SIGN-OFF 2-26-10	DK
ISSUED FOR REVIEW OF ADD'D O2 FILL 2-5-10	DK
ISSUED FOR REVIEW OF REVISED WATER SERVICE 2-26-10	DK
ISSUED FOR RE-COORDINATION SIGN-OFF 2-04-11	DK
MODIFIED FOR FLL SHFT CHANGE, RS 0106081 04-12-11	DK

COORD.	SIGNATURE	DATE
MECHANICAL		
ELECTRICAL		
PLUMBING		
STRUCTURAL		

REF.	SENT	ANS.	REF.	SENT	ANS.
0130	05/15/09	06/26/09			
0169	06/04/09	06/16/09			
0170	06/04/09	06/17/09			
0258	07/16/09	07/24/09			

CHILDREN'S HOSPITAL
OF ORANGE COUNTY

TOWER II

PLUMBING FLOOR PLAN - LEVEL 00 AREAS

PAN-PACIFIC
PLUMBING & MECHANICAL
2919 E. VICTORIA STREET, RANCHO DOMINGUEZ, CA 90221
PH. 310 637-1500 FAX 310 604-0359

DRAWN
R.O.
CHECKED
M.M.
DATE
4/30/2012
SCALE
1/4" = 1'-0"
JOB NO.
09-006
DRAWING NUMBER
PL3.0S
REFERENCE DRAWING
A3.0S
P3.0S
1 OF 1 SHEETS

Architectural floor plan of Level 00 showing a 9-inch core for pipe and insulation. The plan includes various rooms such as Director, Supervisor, Report, Respiratory Exam Room, Outpatient Waiting, Control Room, and Electrical Room. A detailed section view 'CORE THROUGH SHEAR WALL ON M LINE' is shown on the right, indicating a 9-inch core with rebar. A key plan at the bottom right shows the grid layout with columns K, L, M, N and rows 1, 2, 3, 4.

DRAWN
 R.O.
 CHECKED
 M.M.
 DATE
 4/30/2012
 SCALE
 $1/4" = 1' - 0"$
 JOB NO.
 09-006
 DRAWING NUMBER
 PL3.0U
 REFERENCE DRAWING
 A3.0U
 P3.0U
 1 OF 1 SHEETS

