


document and the design it covers are the property of Murray Co. They are loaned only with the borrowers' expressed written agreement that they will not be reproduced, copied, loaned, exhibited, or used in any other way, except by written consent from Murray Co. to the borrower.

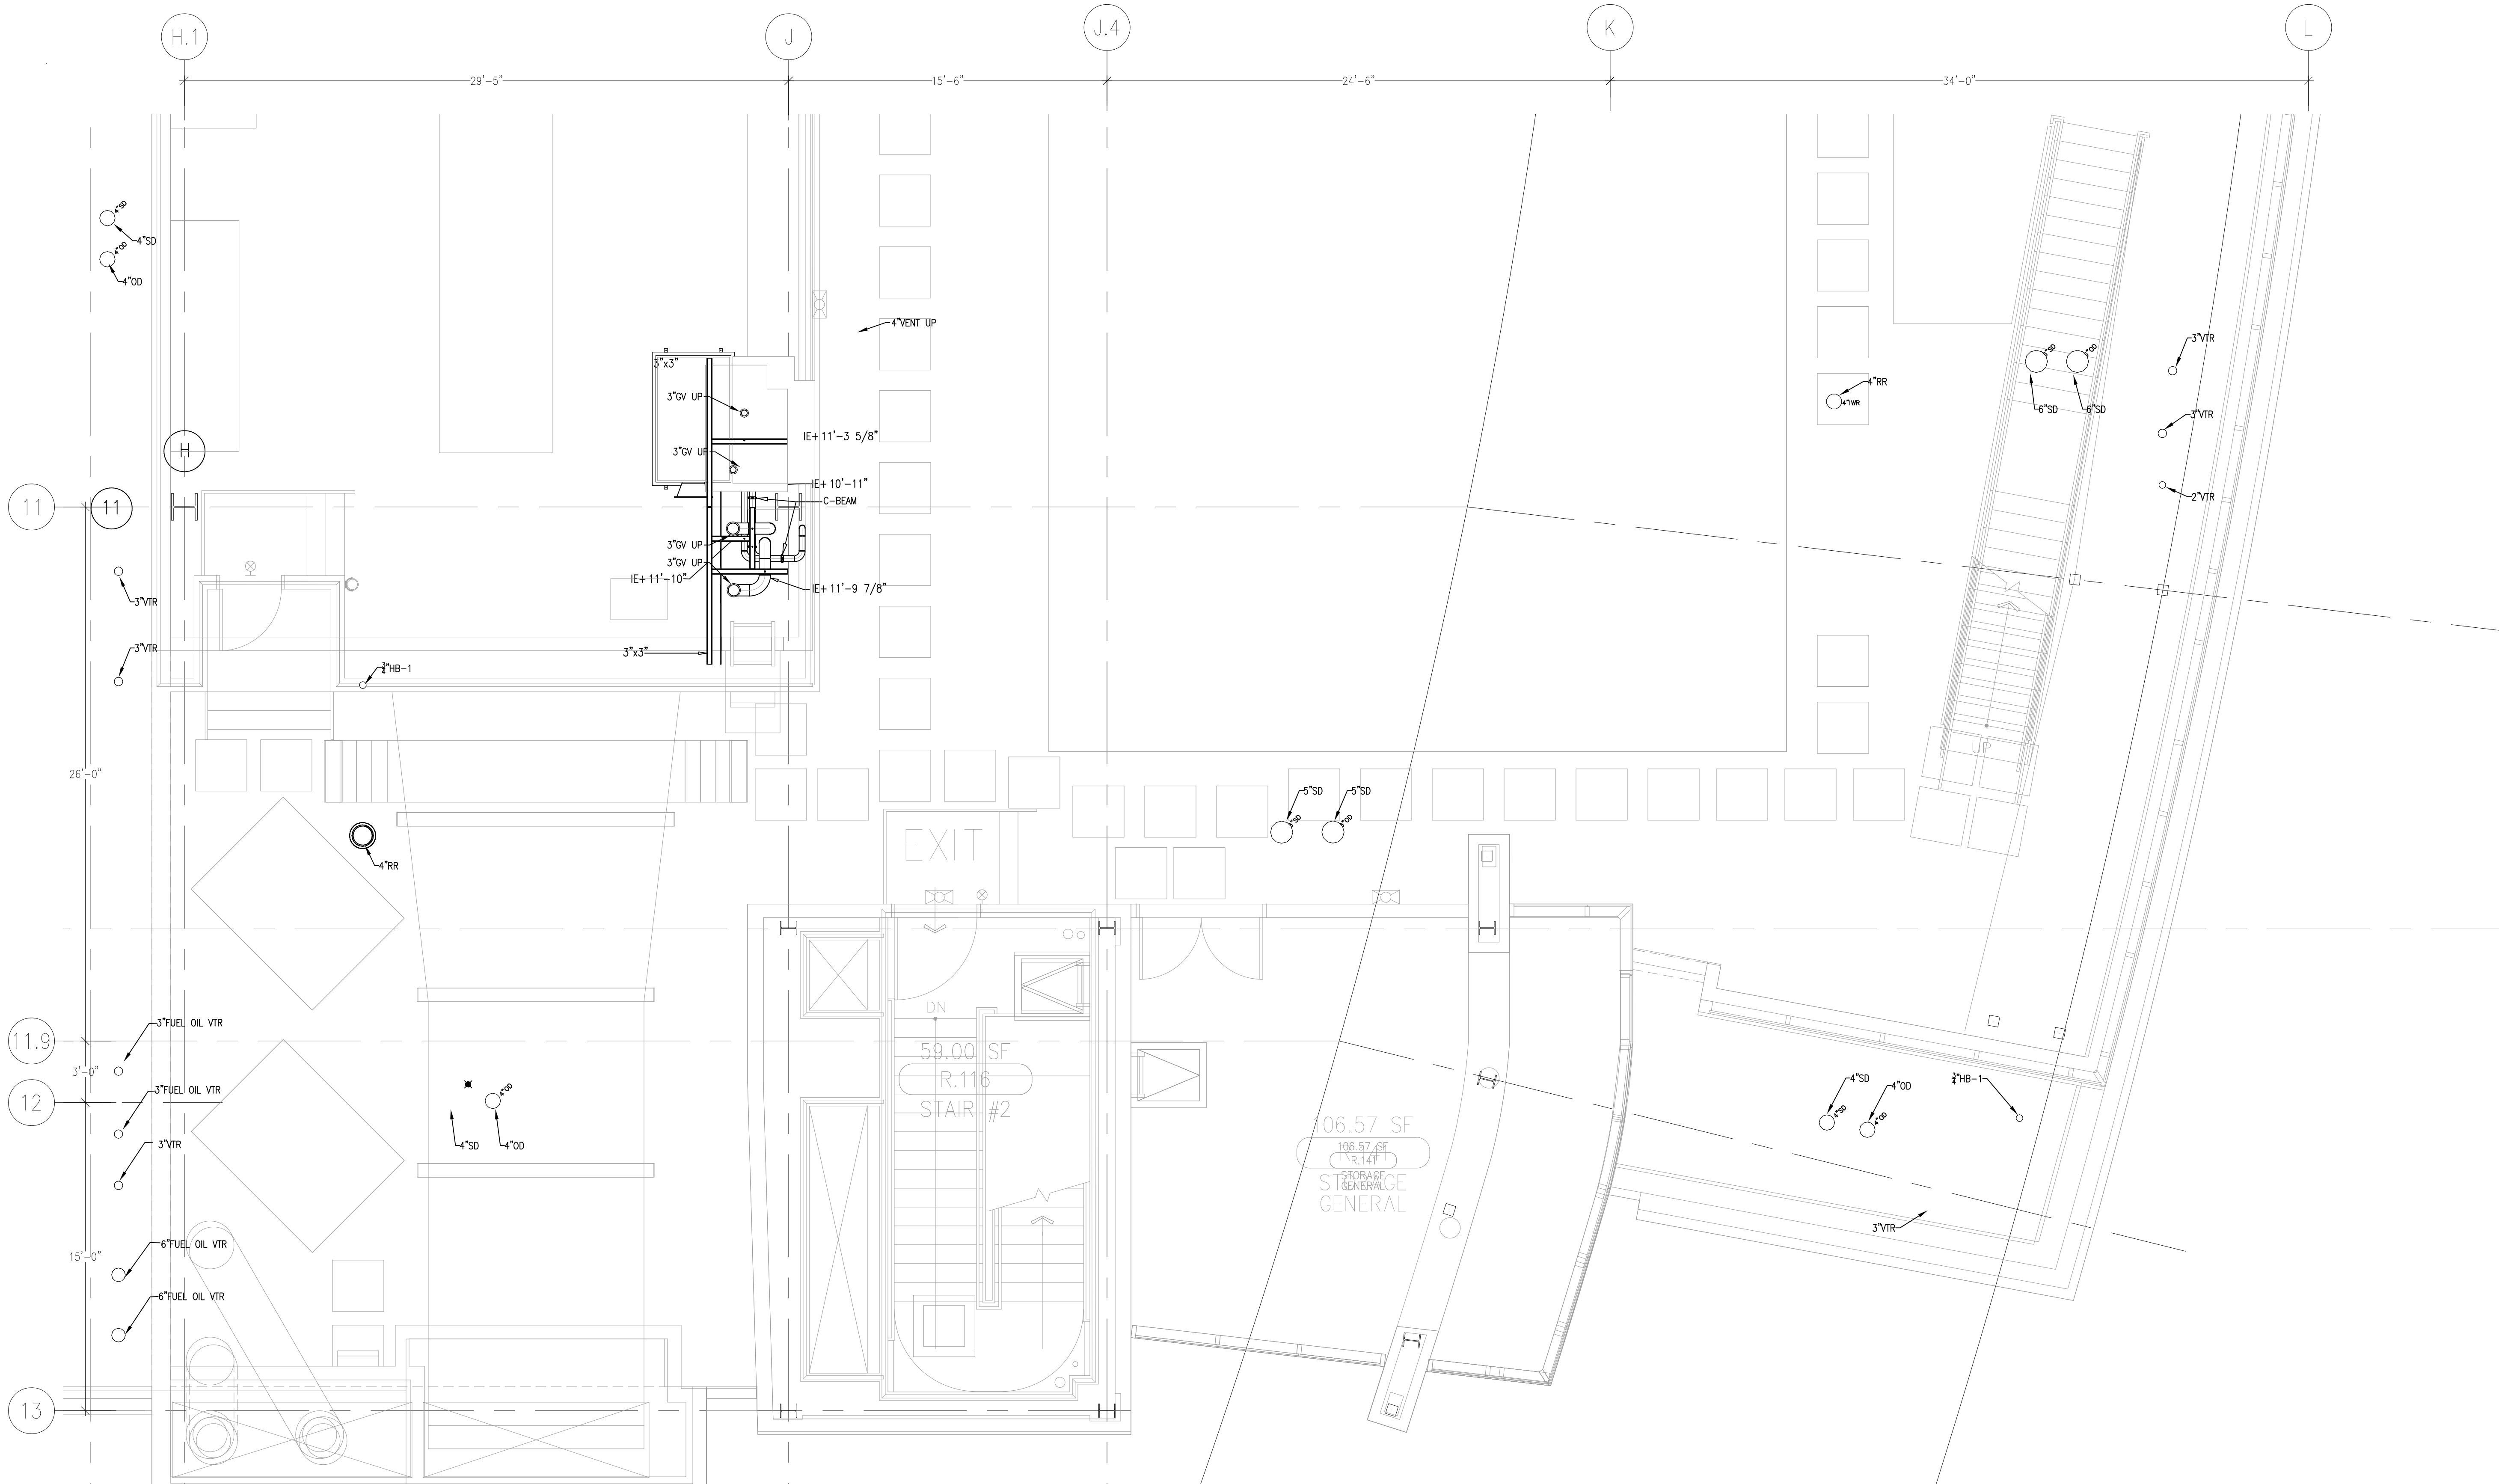


MCCARTHY APPROVAL	
A. Approved as noted for Architectural Review	<input type="checkbox"/>
B. Review and Revisit	<input type="checkbox"/>
C. Rejected	<input type="checkbox"/>

This review is for general conformance with Plans and Specifications only. Any deviations from same not clearly noted by the Preparer have not been reviewed. Review does not constitute a complete check of detailed dimensions or count to serve to relieve the Preparer of contractual responsibility for any error or deviation from contract requirements.

**McCarthy**

By \_\_\_\_\_ Date \_\_\_\_\_

**SHIP DRAWING REFERENCE NO.**

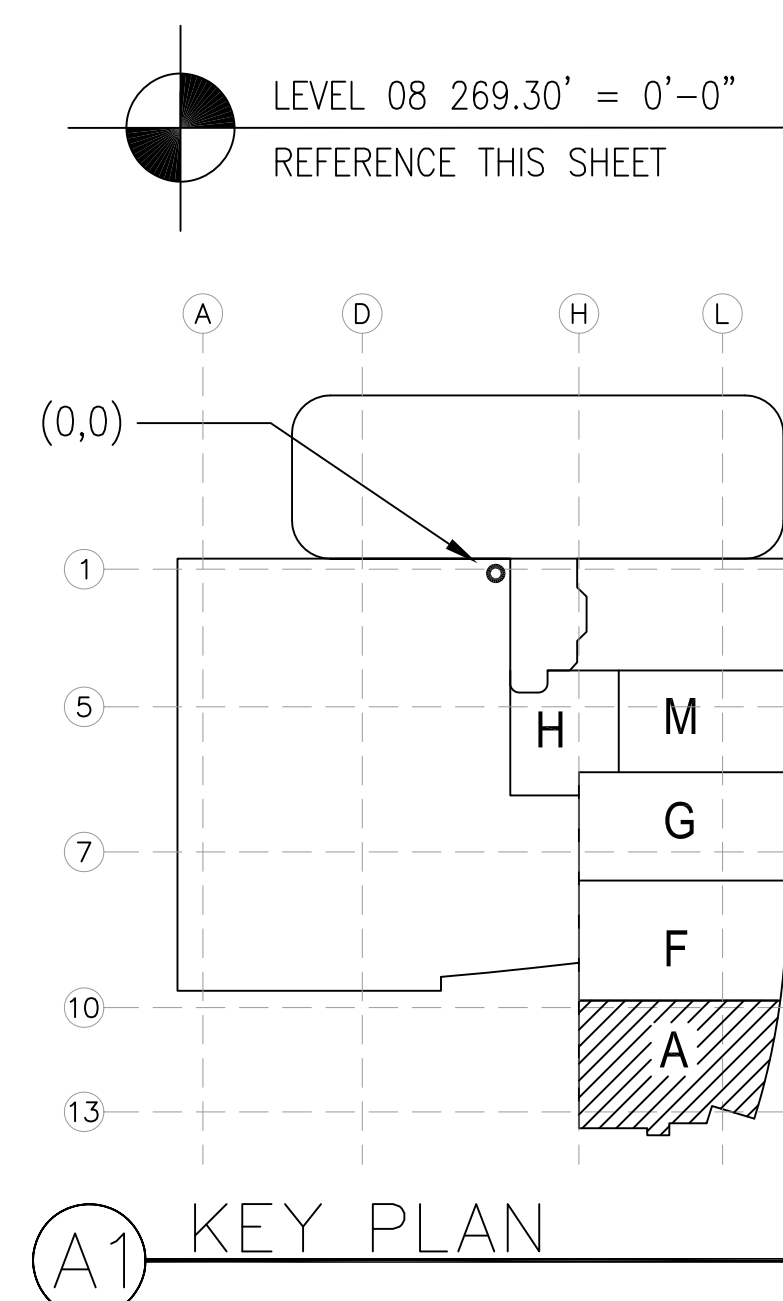[illegible]

COORD.	SIGNATURE	DATE
McCarthy		
MECHANICAL DUCT		
MECHANICAL PIPE		
PLUMBING		
ELECTRICAL		
FIRE SPRINKLER		
PT/GE		
DRYWALL/FRAMER		
REFRIGERATION		
STRUCTURAL		


[illegible]

CHILDREN'S HOSPITAL  
OF ORANGE COUNTY  
455 S. Main St.  
Orange, CA 92668-3874  
TOWER II  
PLUMBING FLOOR PLAN - LEVEL 08 AREA-F


**PAN-PACIFIC**  
PLUMBING & MECHANICAL  
**P&M**  
**Murray Company**  
2919 E. VICTORIA STREET, RANCHO DOMINGUEZ CA 90221

DRAWN
R.O.
CHECKED
M.M.
DATE
4/30/2012
SCALE
1/4"=1'-0"
JOB NO.
09-006
DRAWING NUMBER
PL3.8A
REFERENCE DRAWING
A3.8F
P3.8F
1 OF 1 SHEETS

This document and the design it covers are the property of Murray Co. They are loaned only with the borrower's expressed written agreement that they will not be reproduced, copied, loaned, exhibited, or used in any way, except by written consent from Murray Co. to the borrower.

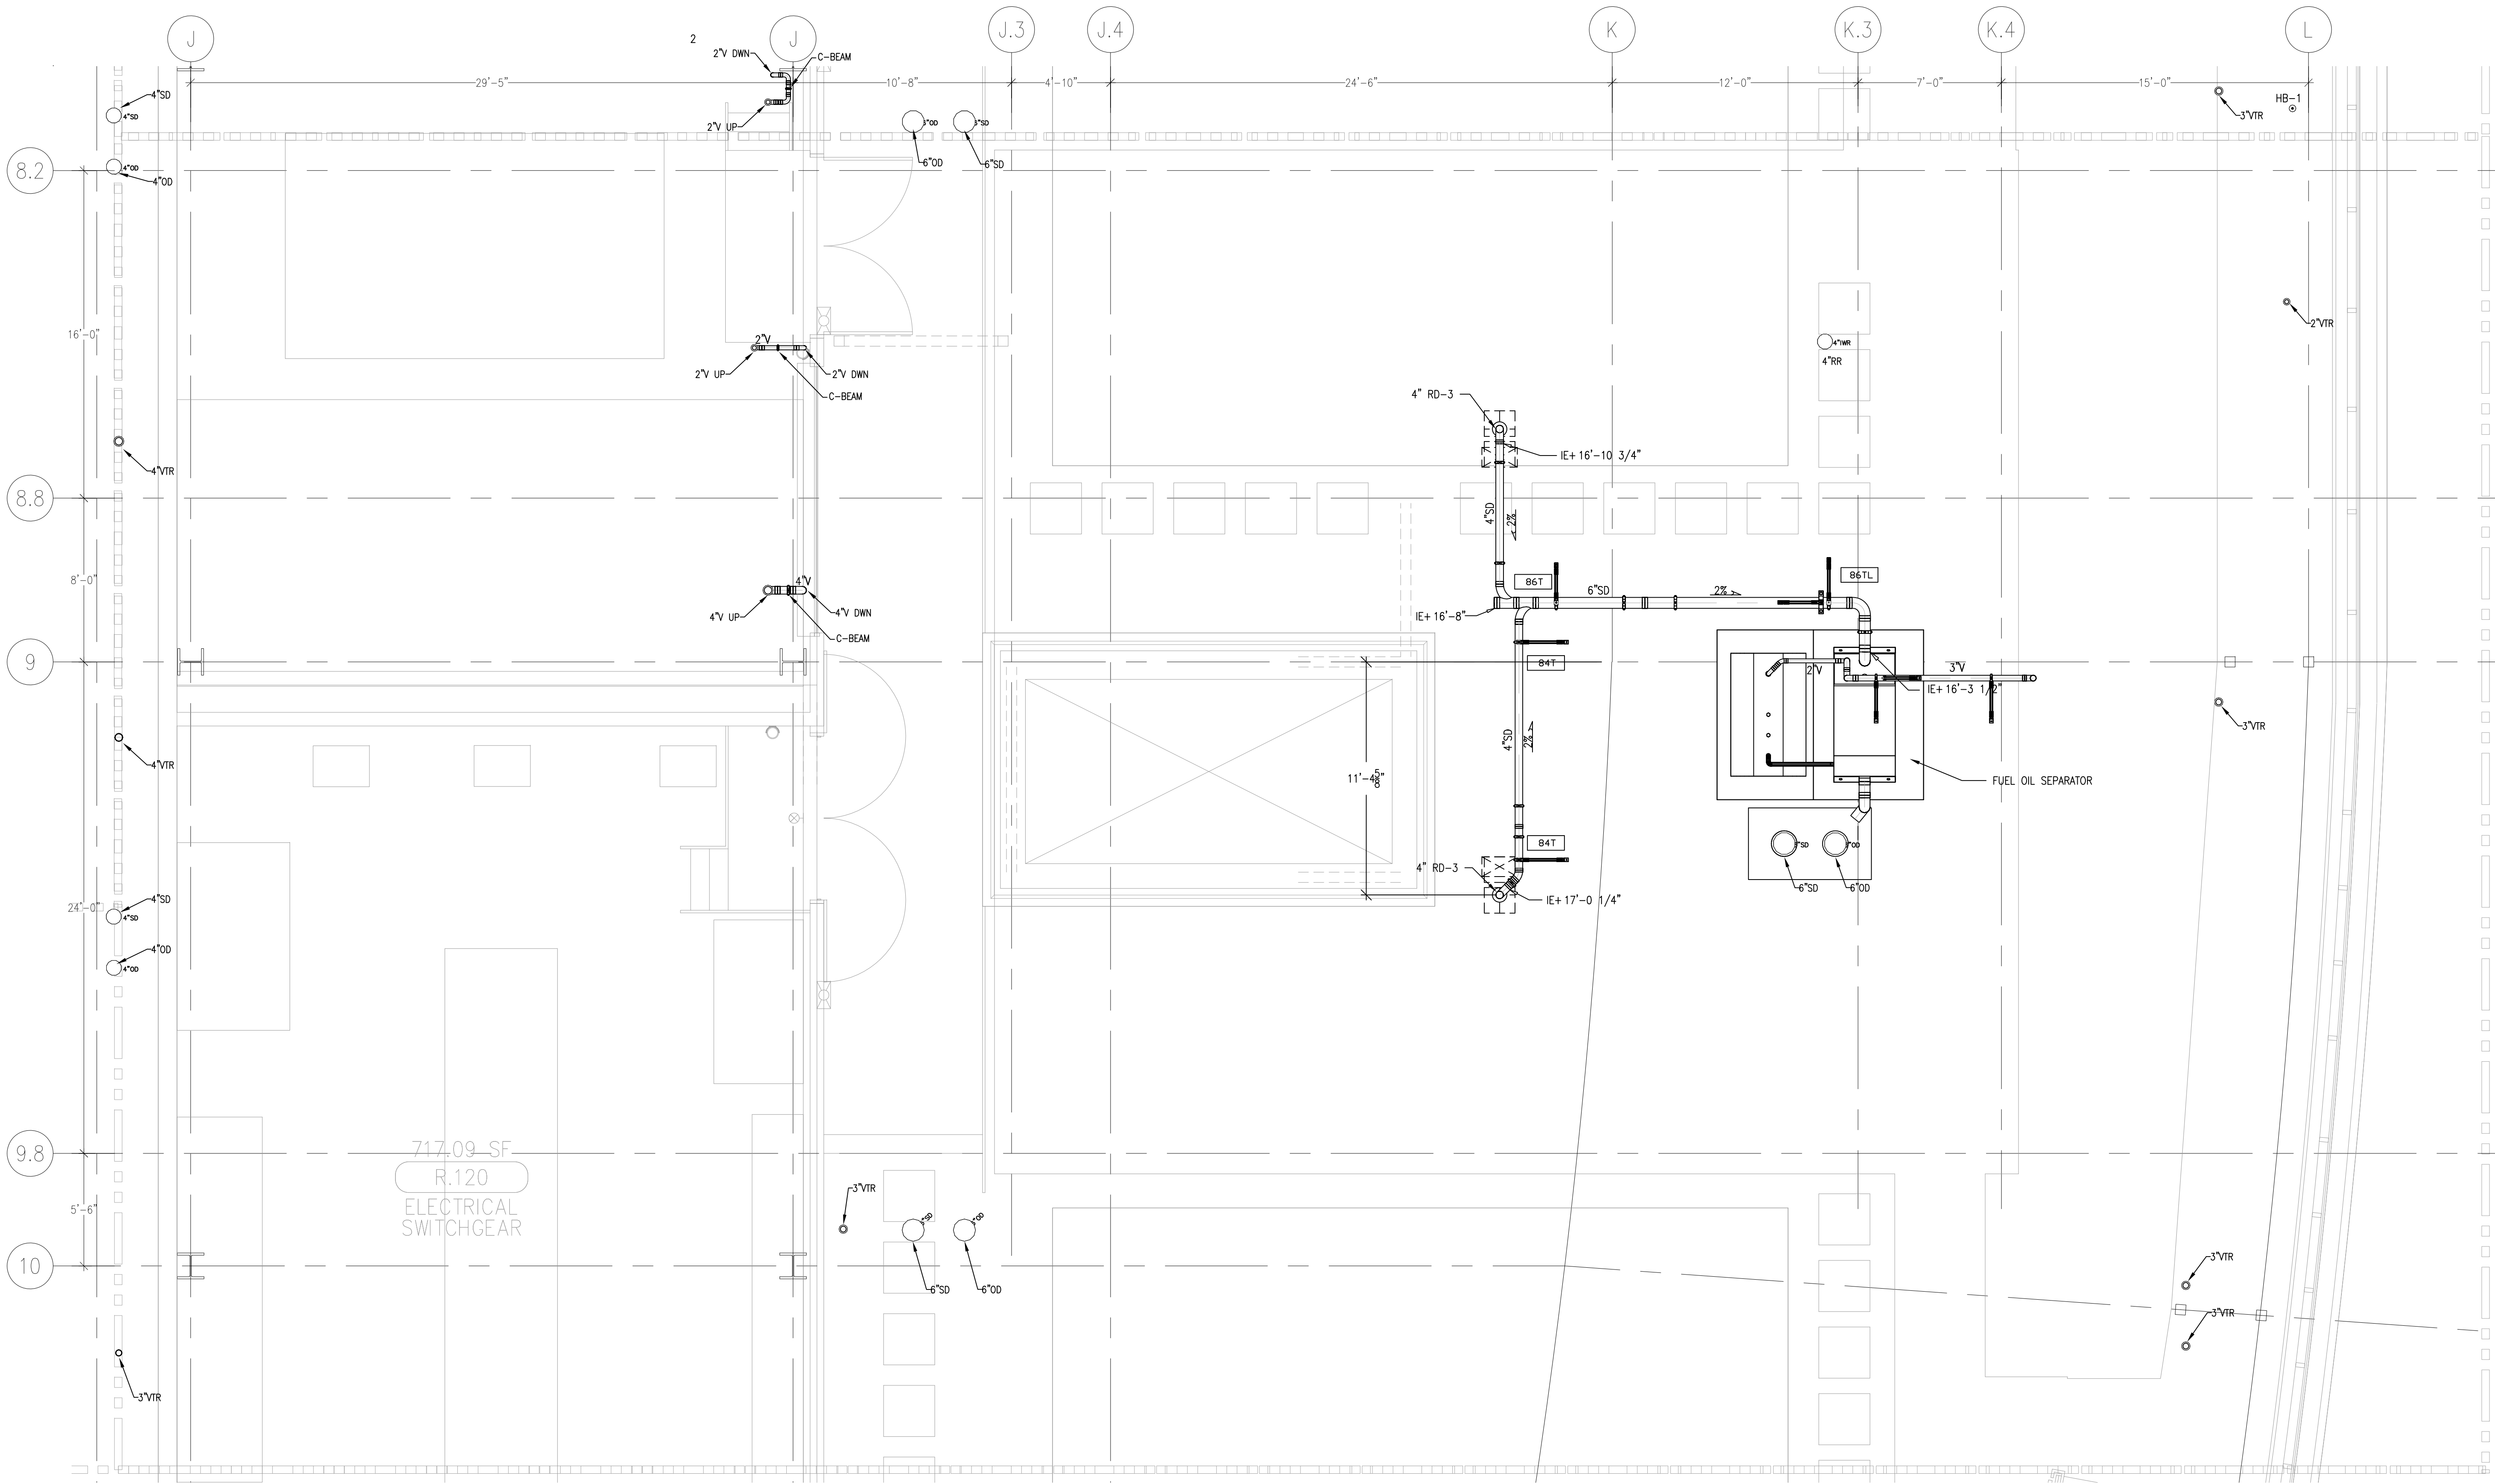

LEVEL 08 269.30' = 0'-0"  
REFERENCE THIS SHEET

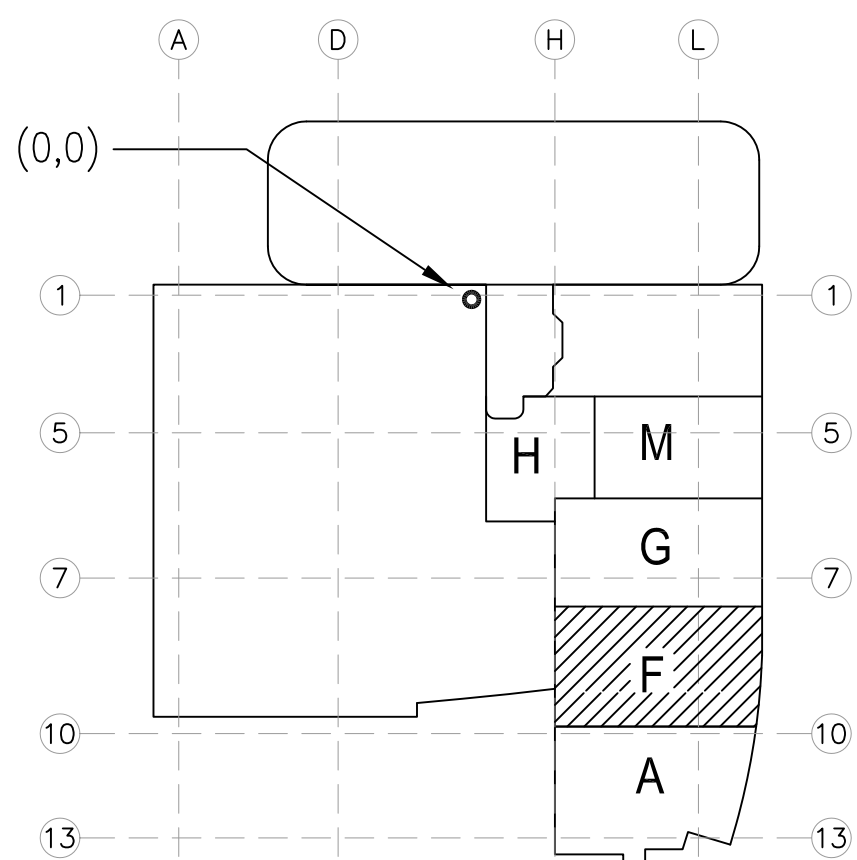

A1 KEY PLAN

MCCARTHY APPROVAL	
A. Approved in detail for Architectural Review	<input type="checkbox"/>
B. Review and Resident	<input type="checkbox"/>
C. Engineer	<input type="checkbox"/>

This review is for general conformance with Plans and Specifications only. Any deviation from same not clearly noted by the Engineer has not been reviewed. Review shall not constitute a warranty or check of detailed dimensions or count to verify or release the Engineer of contractual responsibility for any error or deviation from contract requirements.

**McCarthy**

By: \_\_\_\_\_ Date: \_\_\_\_\_  
SHOP DRAWING REFERENCE NO. \_\_\_\_\_

REVISIONS		BY
1	ISSUED FOR COORDINATION 09-28-10	DK
2	ISSUED FOR CONSTRUCTION 10-12-10	DK
3	TRENCH DRAINS MOVED WEST DUE TO CONFLICT IN FIELD. (SEE PLAN)	DK
4	RELOCATE VENT DUE TO ASH 11 (COORDINATED)	GP
5	REMOVE TWO'S 400 SUMP BRINGS PER COM 152 & 154	DK
6	RELOCATE VENT DUE TO ASH 11	DK
7	ADDED INTERCEPTOR TANK VENTS PER COM 287	DK

COORD.	SIGNATURE	DATE
MECHANICAL		
ELECTRICAL		
PLUMBING		
STRUCTURAL		

R.F.I.	SENT	ANS.	R.F.I.	SENT	ANS.	R.F.I.	SENT	ANS.

**CHILDREN'S HOSPITAL  
OF ORANGE COUNTY**  
455 S. MAIN ST.  
ORANGE, CA 92668-5874

**TOWER II**

PLUMBING FLOOR PLAN - LEVEL 08 AREA F

**PAN-PACIFIC**  
PLUMBING & MECHANICAL  
2919 E. VICTORIA STREET, RANCHO DOMINGUEZ, CA 90221  
PH. 310 637-1500 FAX 310 604-0359

DRAWN  
R.O.

CHECKED  
M.M.

DATE  
5/1/2012

SCALE  
1/4" = 1'-0"

JOB NO.  
09-006


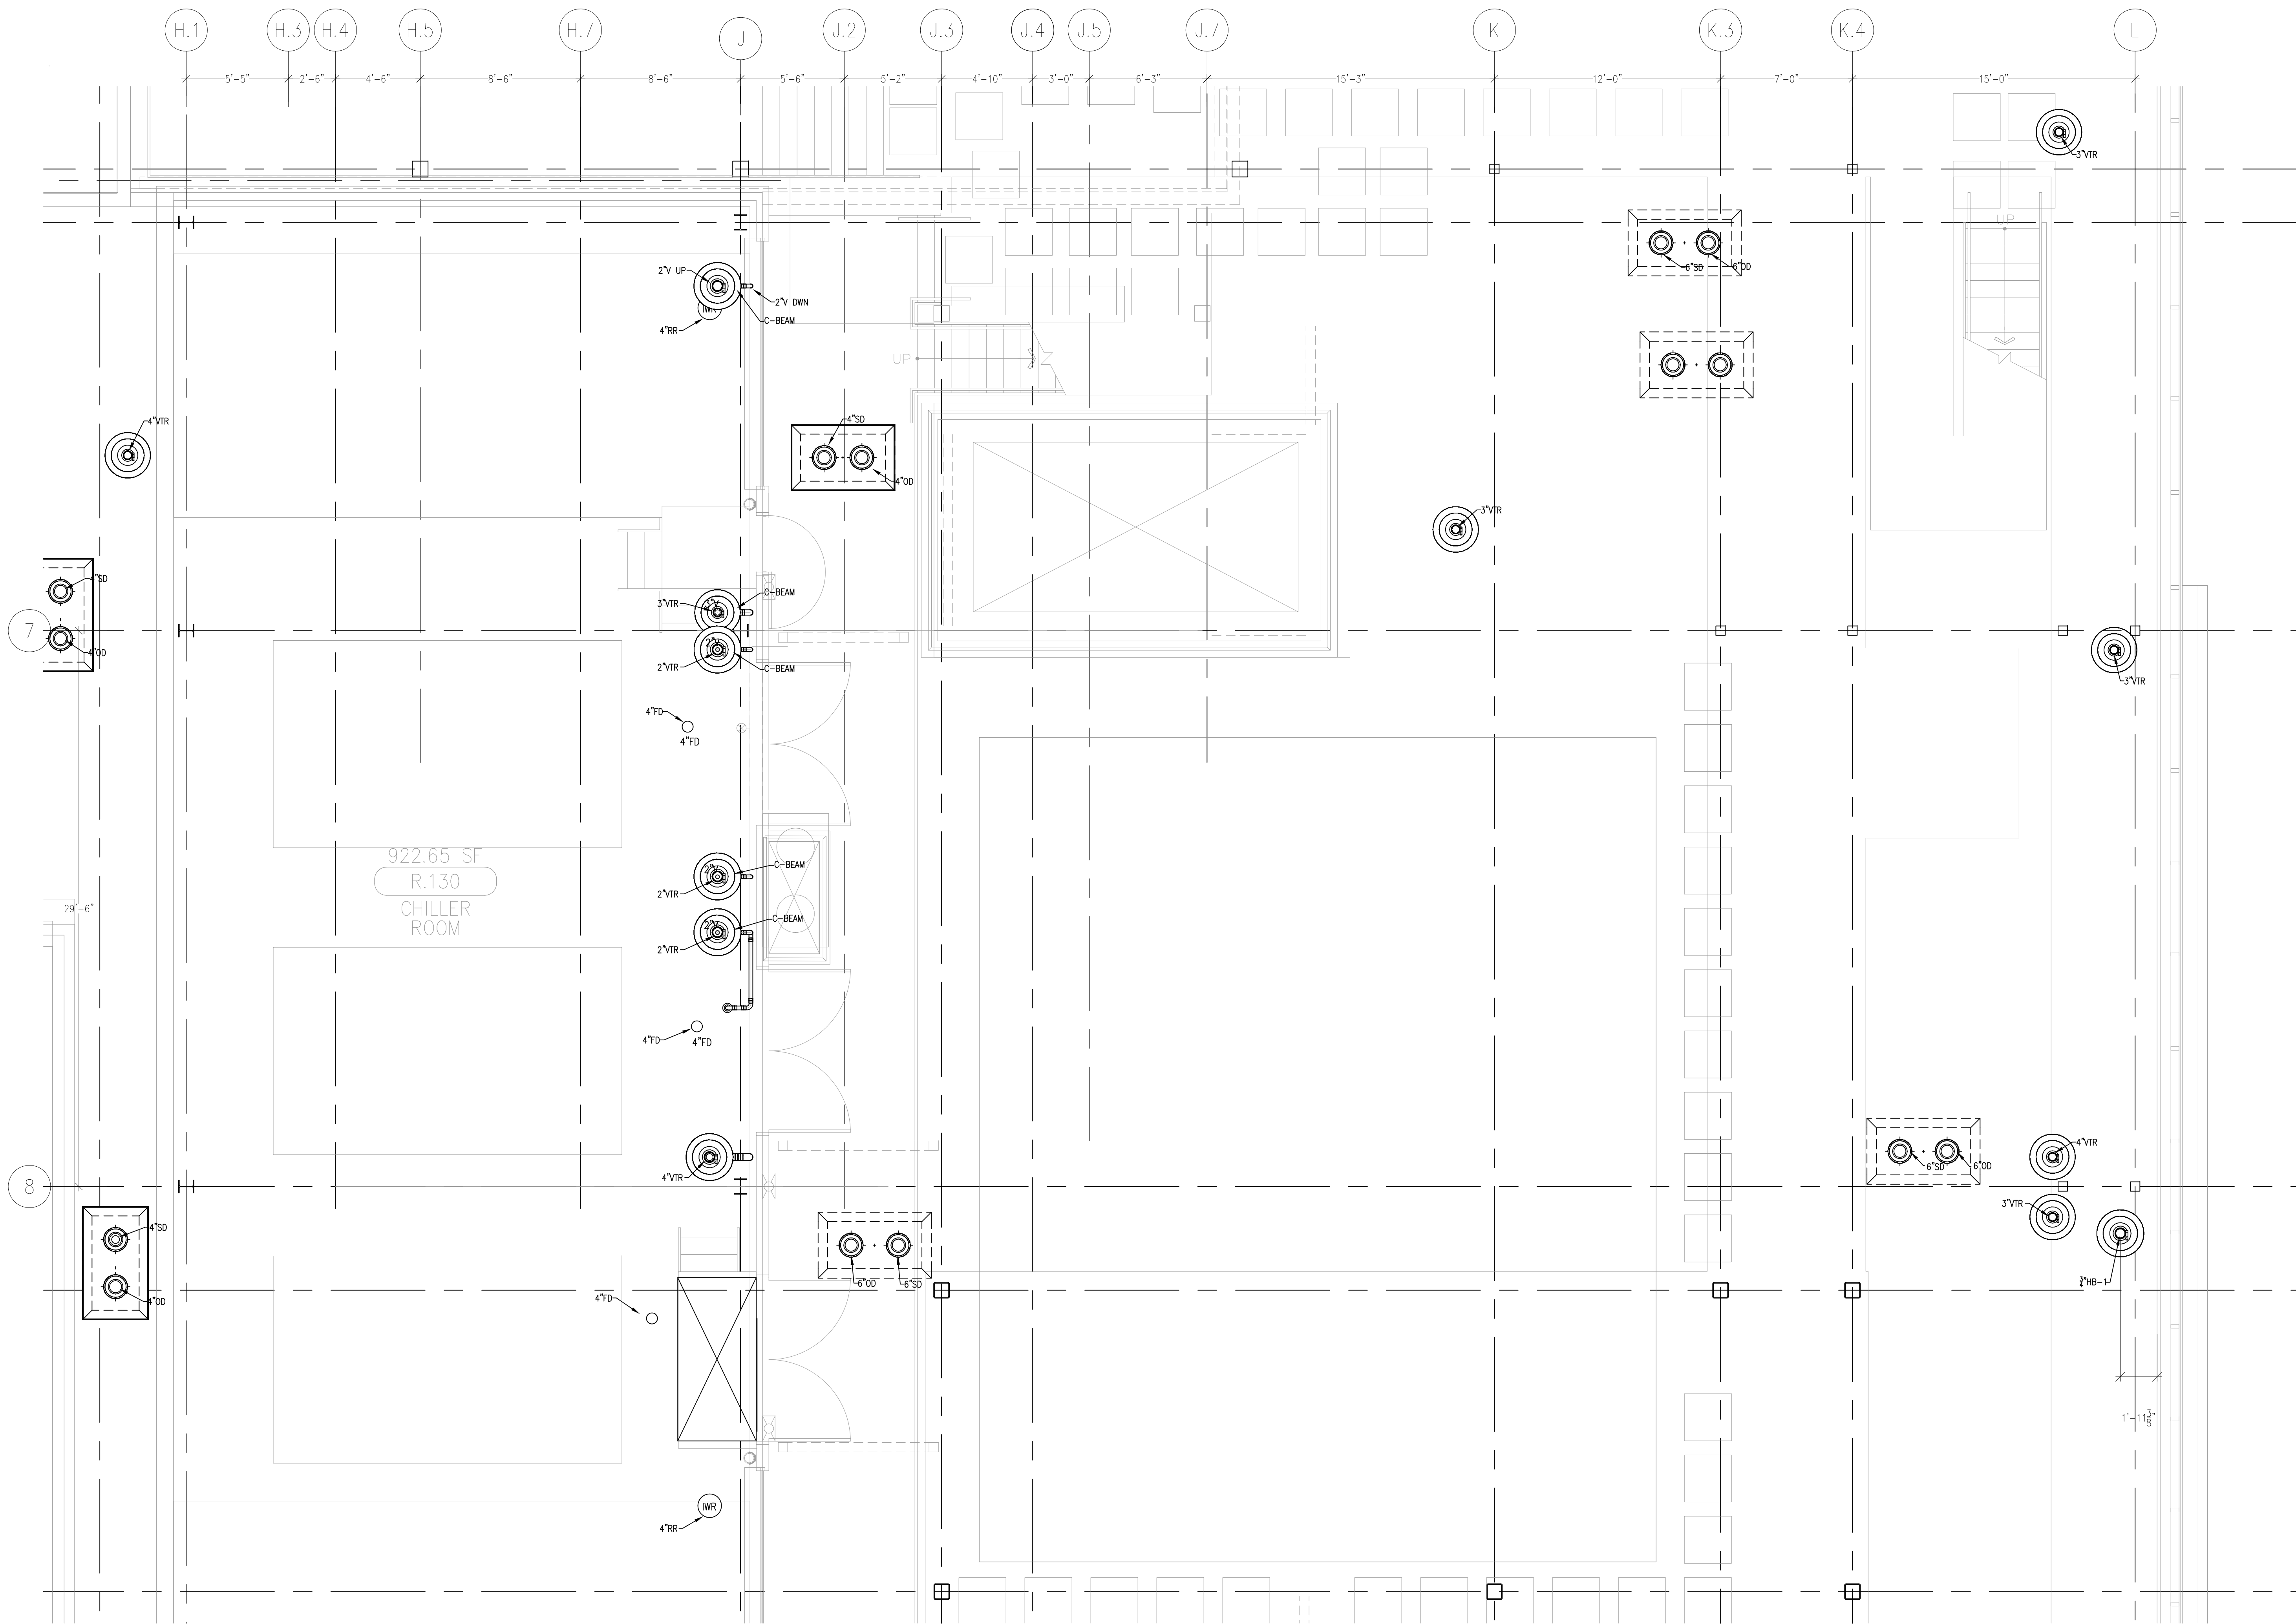
DRAWING NUMBER  
PL3.8F

REFERENCE DRAWING  
A3.8F  
P3.8F


1 OF 1 SHEETS



document and the design it covers are the property of Murray Co. They are loaned only with the borrowers' expressed written agreement that they will not be reproduced, copied, loaned, exhibited, or used in any other way, except by written consent from Murray Co. to the borrower.



LEVEL 08 269.30' = 0'-0"  
REFERENCE THIS SHEET

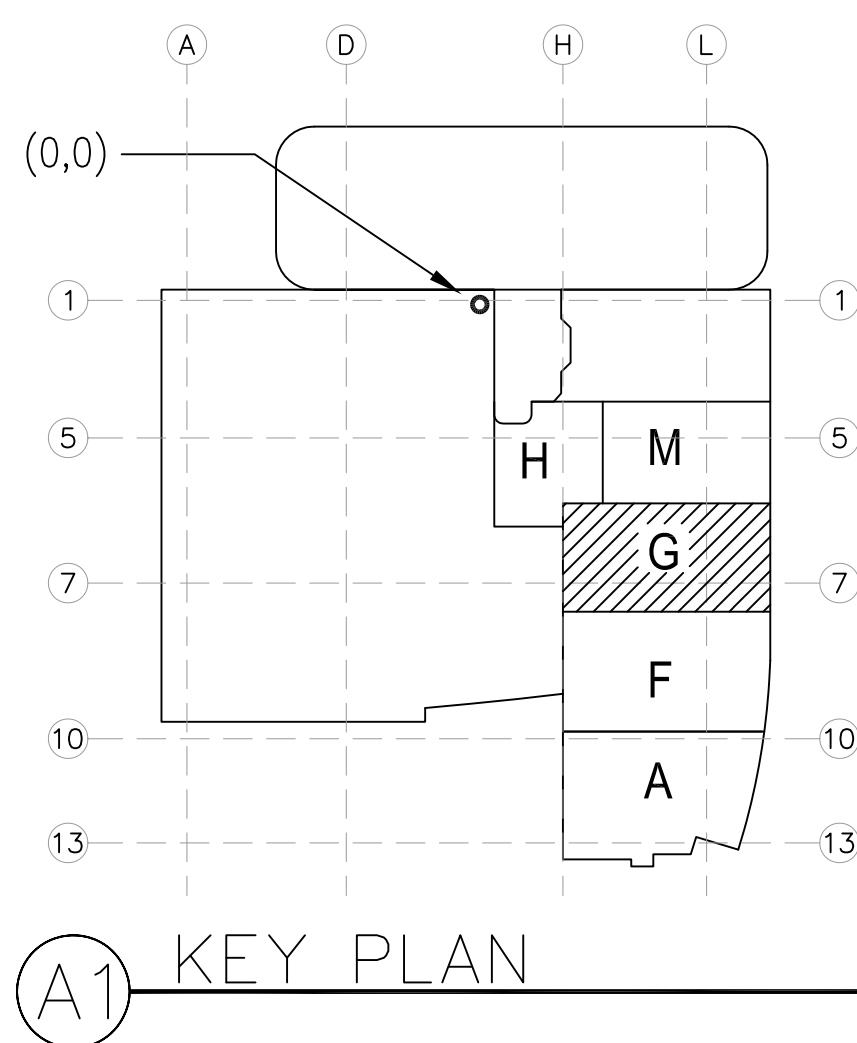

<h2 style="margin: 0;">MC CARTHY APPROVAL</h2>	
<p><b>A. Approved as noted for Architectural Review</b></p>	<input type="checkbox"/>
<p><b>B. Review and Re-submit</b></p>	<input type="checkbox"/>
<p><b>C. Rejects</b></p>	<input type="checkbox"/>
<p>This review is for general conformance with Plans and Specifications only. Any deviations from same not clearly noted by the Preparer have not been reviewed. Review shall not constitute a complete check of detailed dimensions or count to serve to relieve the Preparer of contractual responsibility for any error or deviation from contract requirements.</p>	
<h2 style="margin: 0;">McCarthy</h2>	
<p>By _____</p>	<p>Date _____</p>
<p><b>SHOP DRAWING REFERENCE NO.</b></p>	

[illegible]

COORD.	SIGNATURE	DATE
MCARTY		
MECHANICAL DUCT		
MECHANICAL PIPE		
PLUMBING		
ELECTRICAL		
FIRE SPRINKLER		
PIPE		
DRYWALL / FRAMER		
REFRIGERATION		
STRUCTURAL		

[illegible]

CHILDREN'S HOSPITAL  
OF ORANGE COUNTY  
HOSPITAL  
465 S. Main St.  
Orange, CA 92668-3874  
TOWER II  
PLUMBING FLOOR PLAN - LEVEL 08 AREA-G

1 hp. 8991506 5-01-2012 23mm

Def: Proj2, 09-006, 0000, WURRY DRAWINGS PLUMING (U-PH) PL3.8G.jpg

DRAWN R.O.
CHECKED
M.M.
DATE 5/1/2012
SCALE 1/4" = 1' - 0"
JOB NO. 09-006
DRAWING NUMBER PL3.8G
REFERENCE DRAWING A3.8G P3.8G
1 OF 1 SHEETS

DRAWN  
 R.O.  
 CHECKED  
 M.M.  
 DATE  
 5/1/2012  
 SCALE  
 $1/4" = 1' - 0"$   
 JOB NO.  
 09-006  
 DRAWING NUMBER  
 PL3.8H  
 REFERENCE DRAWING  
 A3.8H  
 P3.8H  
 1 OF 1 SHEETS



Architectural floor plan of a building with a grid system (H-L, 3-6). The plan shows various rooms including a Cooling Towers room (R.070, 23.79 SF), a Radio Room (R.087, 129.74 SF), and a Stair #1 (R.088, 133.84 SF). It also features an Exit, a Power Distribution Unit (PDU), and various electrical symbols like 2VIR, 4VIR, and 4VIR. Dimensions are provided for various sections and rooms.

LEVEL 08 269.30' = 0°-0"

USE THIS SHEET

(0,0)

1

5

7

10

13

A

D

H

L

H

M

G

F

A

A1 KEY PLAN

DRAWN  
 R.O.  
 CHECKED  
 M.M.  
 DATE  
 5/1/2012  
 SCALE  
 $1/4" = 1'-0"$   
 JOB NO.  
 09-006  
 DRAWING NUMBER  
 PL3.8M  
 REFERENCE DRAWING  
 A3.8M  
 P3.8M  
 1 OF 1 SHEETS