



This document and the design it covers are the property of Murray Co. They are loaned only with the borrower's expressed written agreement that they will not be reproduced, copied, loaned, exhibited, or used in any way, except by written consent from Murray Co. to the borrower.

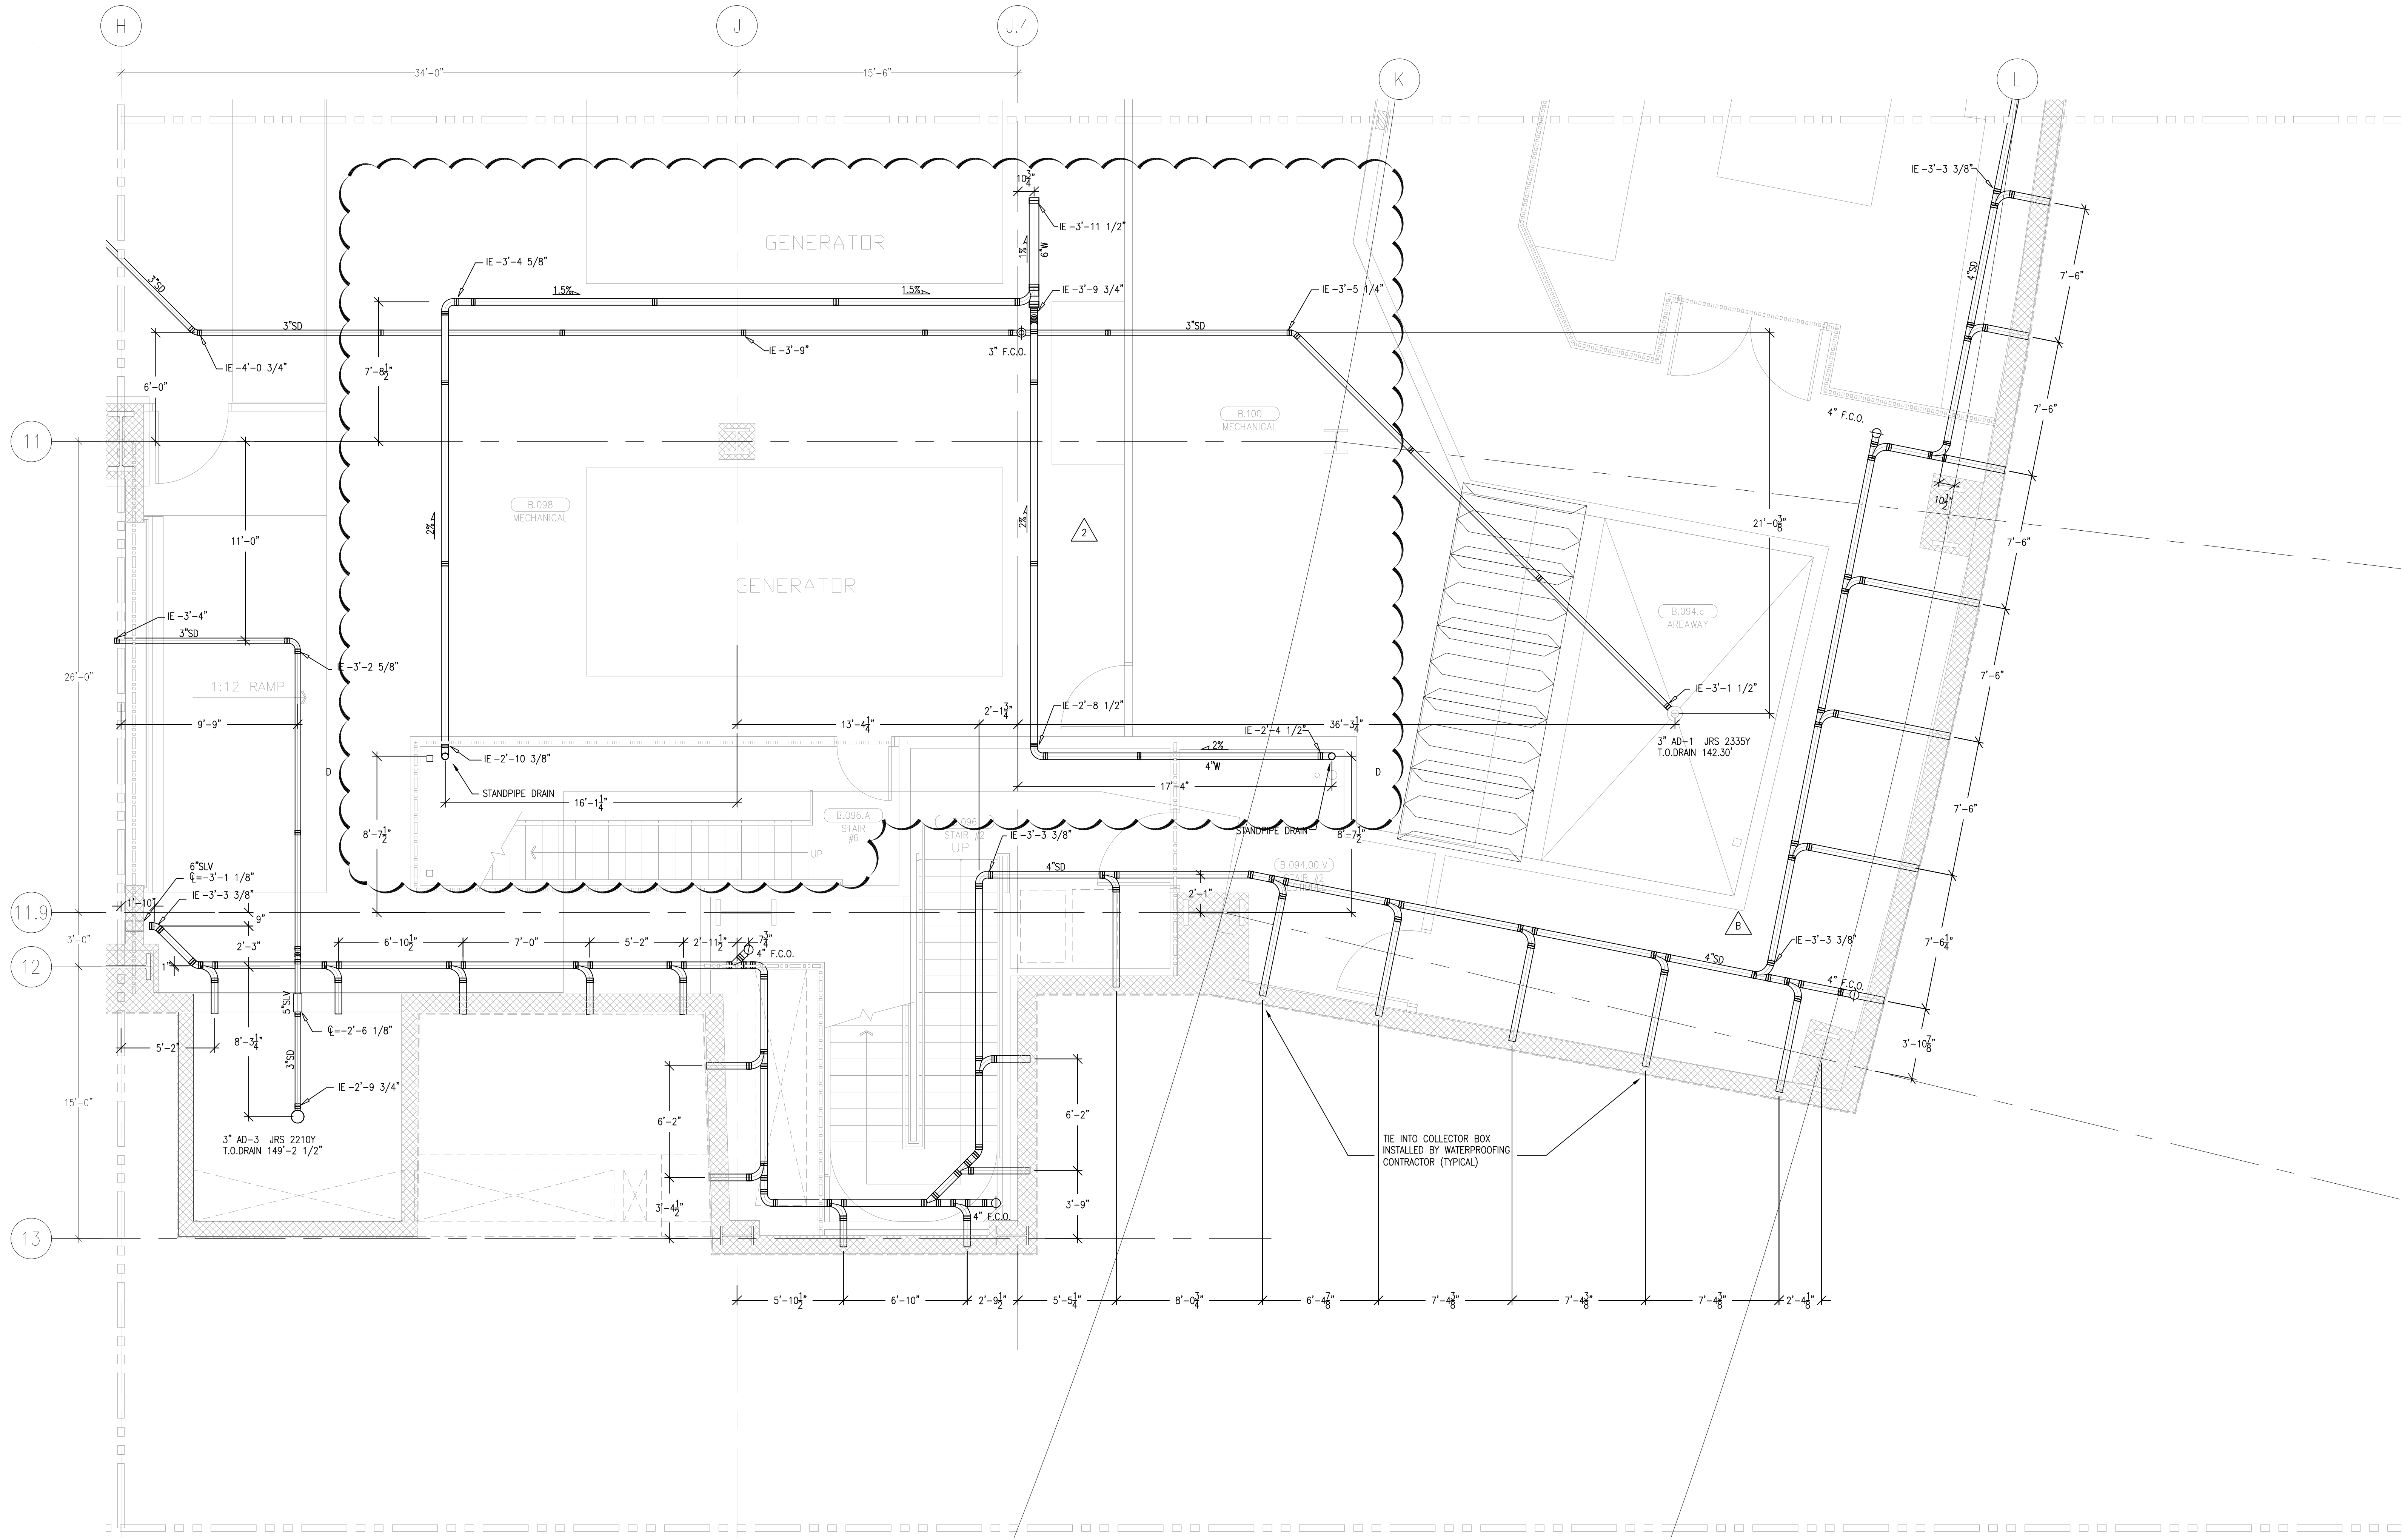

LEVEL 00 144.30' = 0'-0"
REFERENCE THIS SHEET

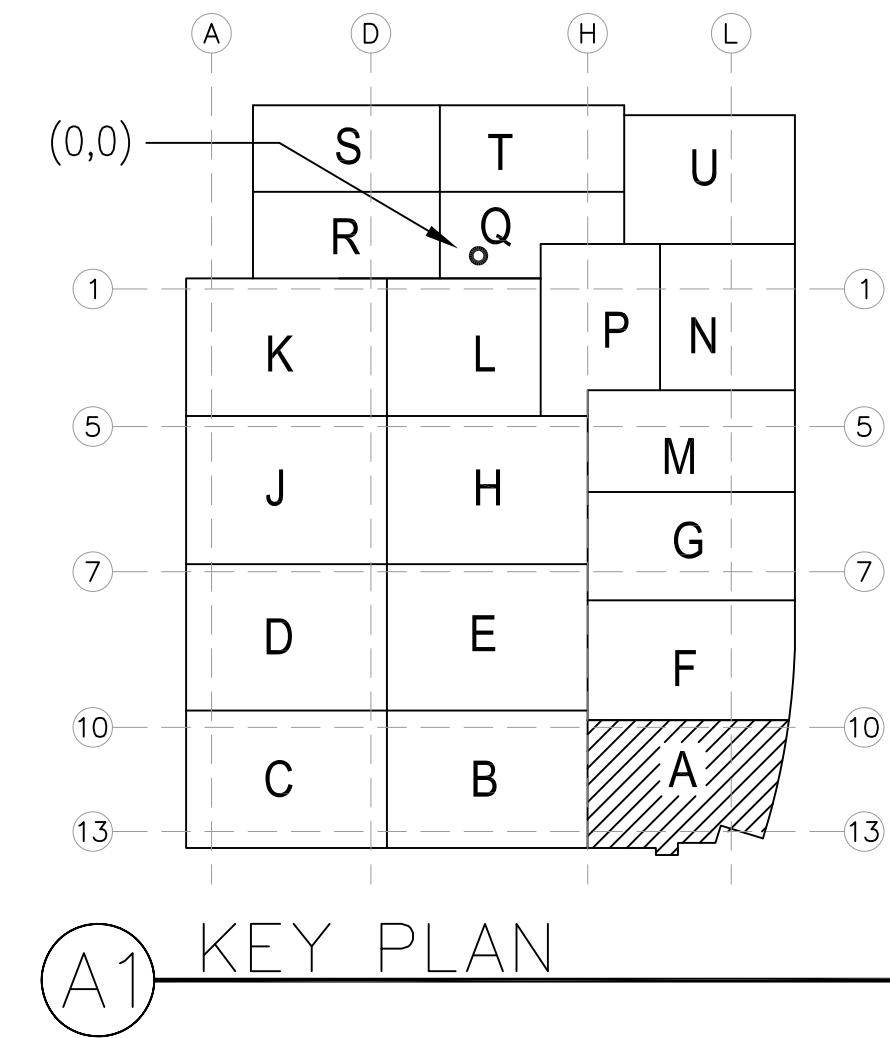

REVISIONS		BY
A	ISSUED FOR COORDINATION SIGN-OFF 6-30-09	DK
B	REVISED TO STORM DRAIN COLLECTION 8-25-09	REO
C	ISSUED FOR PUMP COORDINATION SIGN-OFF 10-28-09	JT
D	ADDED STANDPIPE RISER LOCATING PER FP 11-18-09	REO
E	REVISED PER ELECTRICIAN'S REQUEST 01-28-10	DK
F	REVISED DUE TO CONFLICT WITH STEEL SUPPORT 02-16-10	DK
G	REVISED DUE TO CONFLICT 4-8-10	DK
H	REVISED PIPE SLOPE 6-11-10	DK
I	REVISED PIPE SLOPE 6-22-10	DK

COORD.	SIGNATURE	DATE
MECHANICAL		
MECHANICAL		
PLUMBING		
ELECTRICAL		
FIRE SPRINKLER		
PIPE		
DRAIN/WALL/FRAMER		
REFRIGERATION		
STRUCTURAL		

R.F.I.	SENT	ANS.	R.F.I.	SENT	ANS.
0003	04/22/09	04/22/09	0339	08/27/09	08/19/09
0004	04/24/09	04/20/09	0335	10/27/09	10/26/09
0018	04/11/09	04/21/09			
0025	04/14/09	05/03/09			
0118	05/13/09	09/03/09			
0271	07/20/09	08/26/09			
0286	08/06/09	08/26/09			

**CHILDREN'S HOSPITAL
OF ORANGE COUNTY**
455 S. MAIN ST.
ORANGE, CA 92668-3974

TOWER II
PLUMBING FLOOR PLAN - LEVEL UNDERGROUND AREA-A


PAN-PACIFIC
PLUMBING & MECHANICAL

Murray Company
2919 E. VICTORIA STREET, RANCHO DOMINGUEZ, CA 90221
PH. 310.637-1500 FAX 310.604-0359


DRAWN
R.O.
CHECKED
M.M.
DATE
2/3/2011
SCALE
1/4" = 1'-0"
JOB NO.
09-006
DRAWING NUMBER
PL3.0AU
REFERENCE DRAWING
A3.0AU
P3.0AU
1 OF 1 SHEETS

Drawn by: R.O. 2-03-2011 9:45am
Checked by: M.M. 2-03-2011 9:45am
Date: 2/3/2011
Scale: 1/4" = 1'-0"
Job No.: 09-006
Drawing Number: PL3.0AU
Reference Drawing: A3.0AU, P3.0AU
1 of 1 sheets

This document and the design it covers are the property of Murray Co. They are loaned only with the borrower's expressed written agreement that they will not be reproduced, copied, loaned, exhibited, or used in any other way, except by written consent from Murray Co. to the borrower.

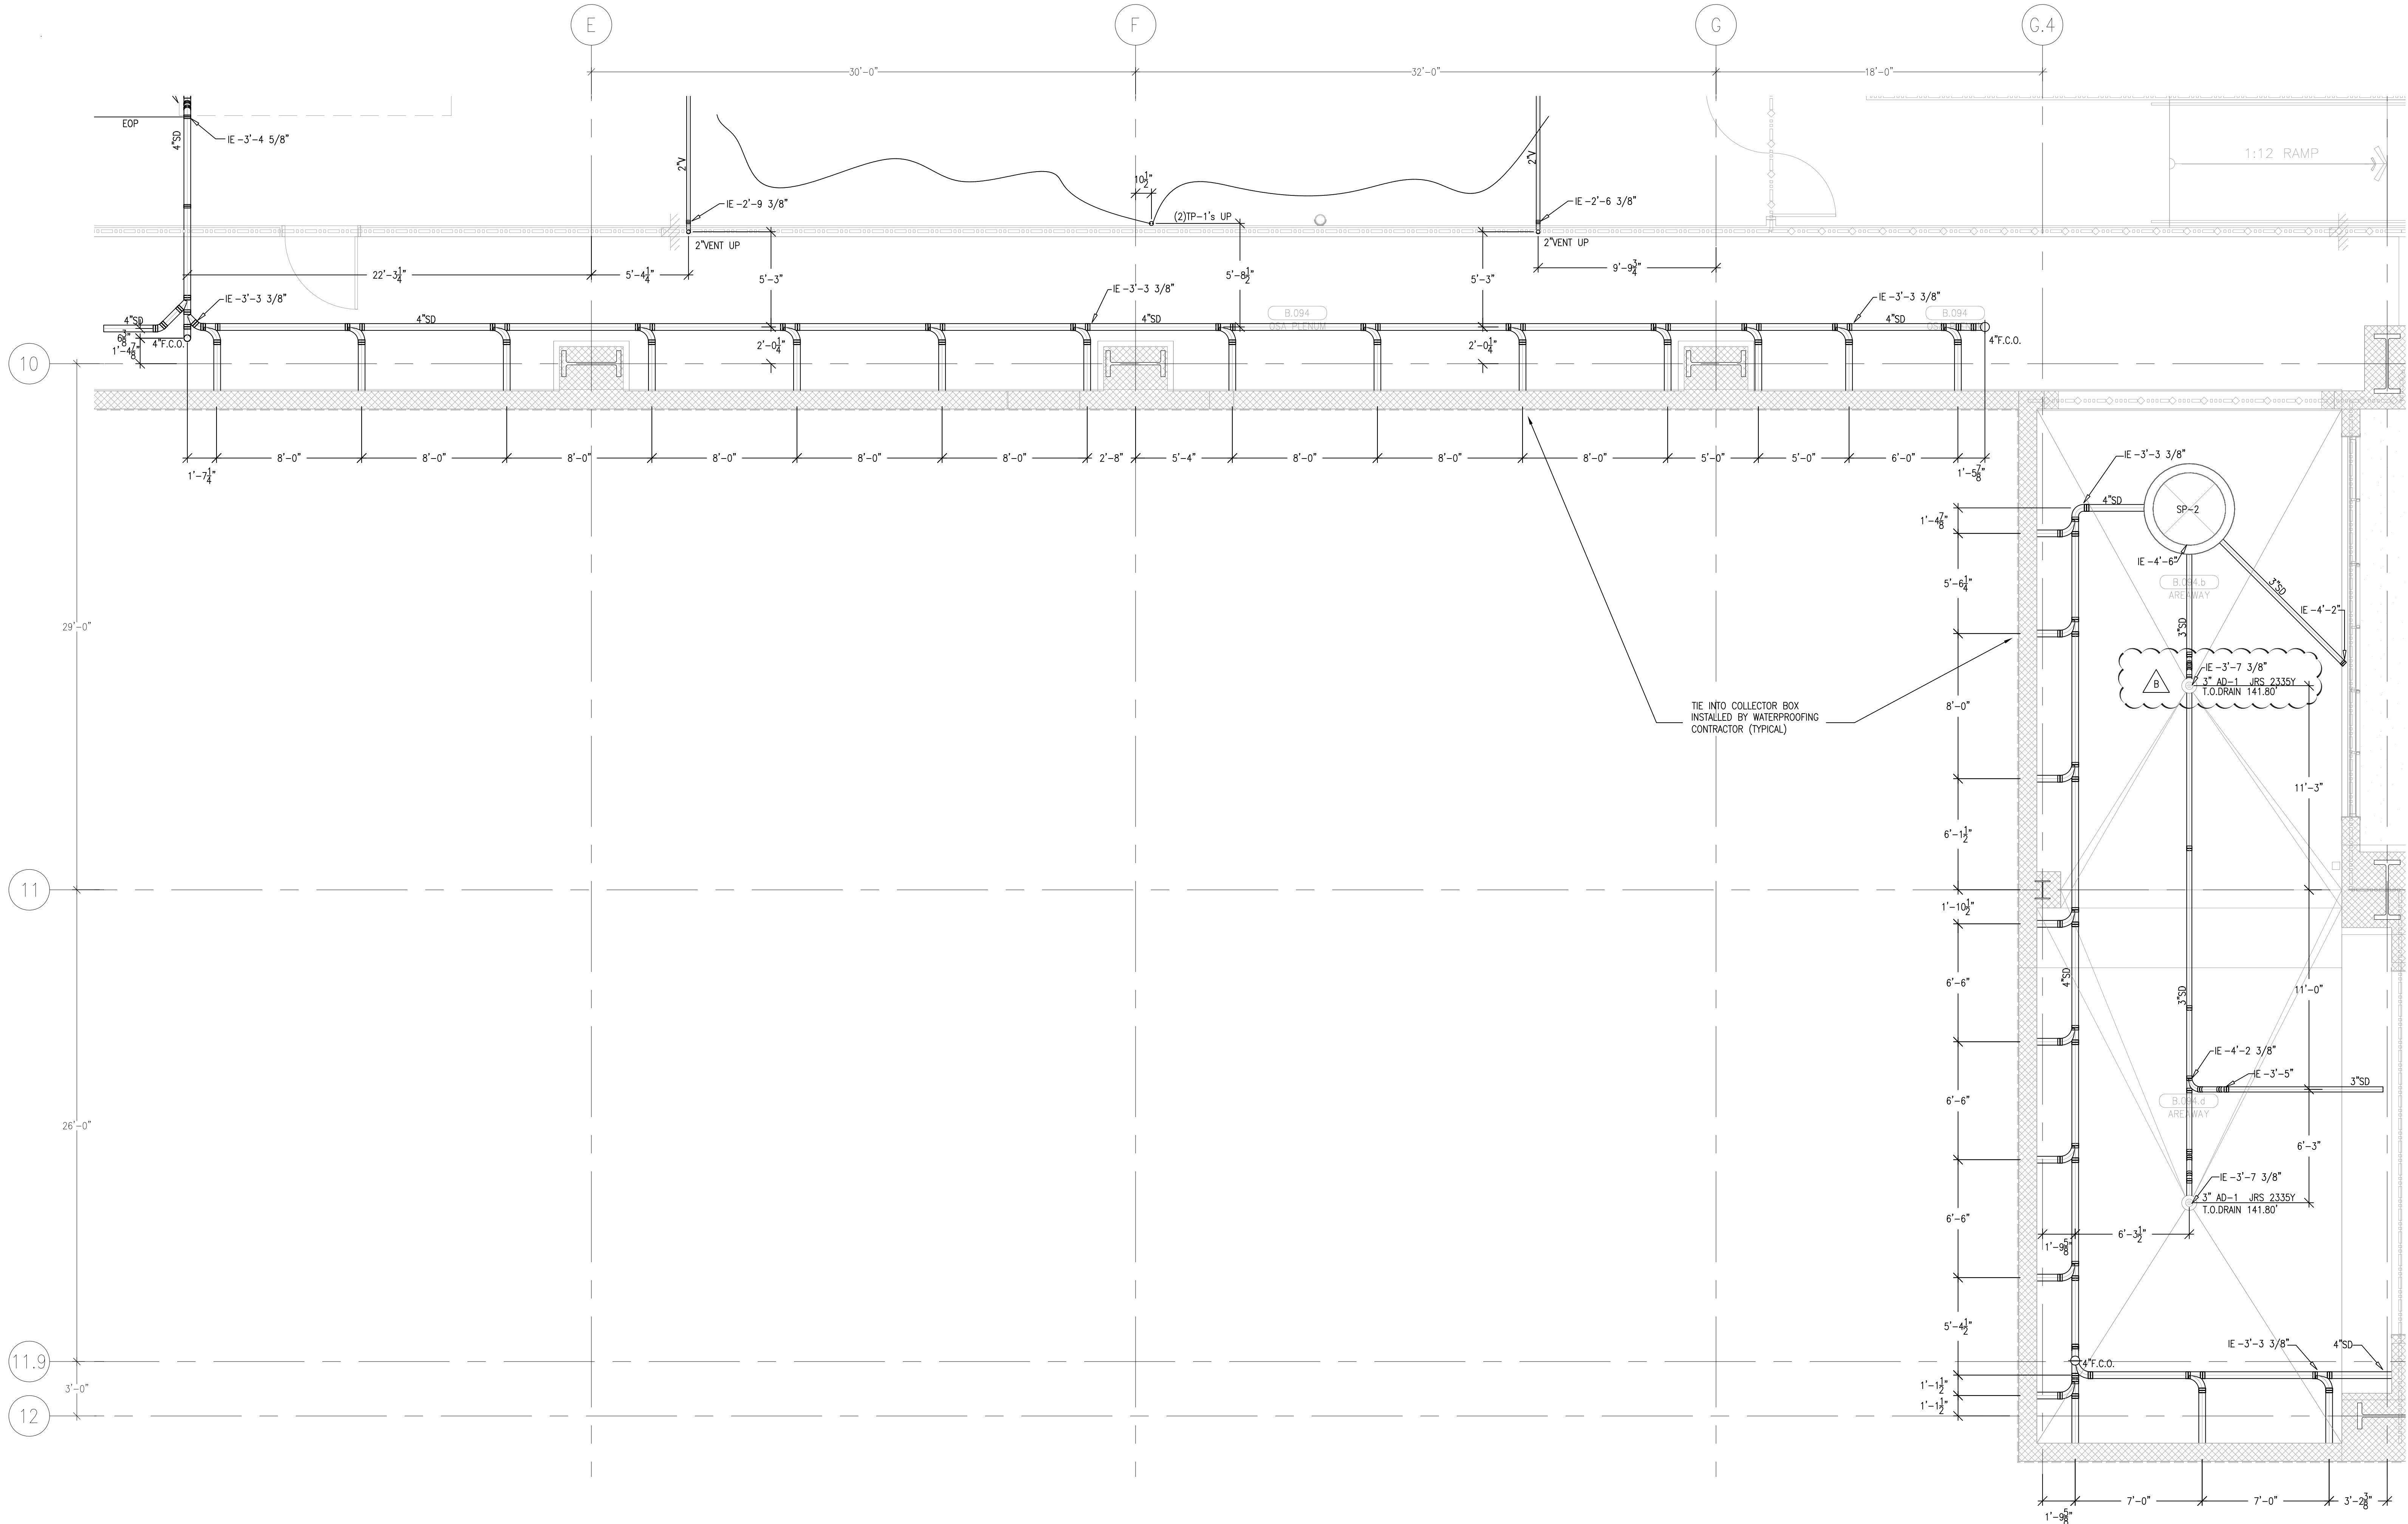

LEVEL 00 144.30' = 0'-0"
REFERENCE THIS SHEET

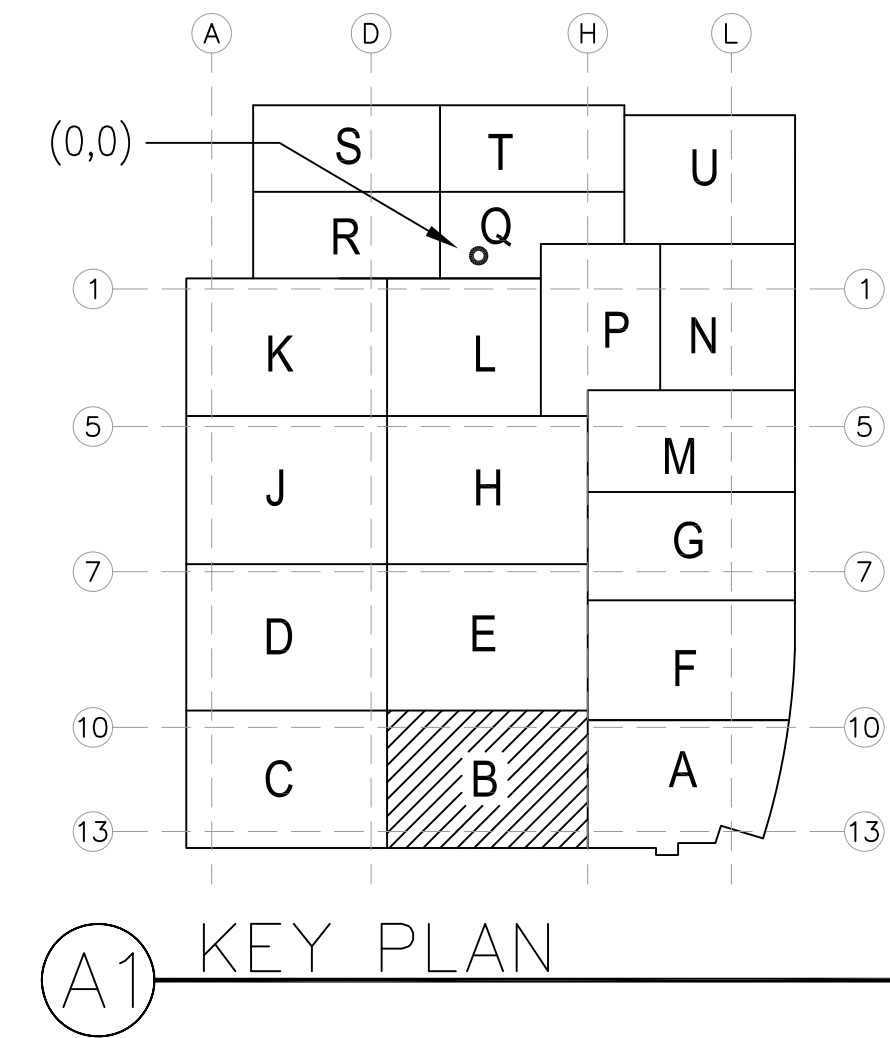

REVISIONS		BY
A	ISSUED FOR COORDINATION SIGN-OFF 6-30-09	DK
B	ISSUED FOR TOWER COORDINATION SIGN-OFF 8-22-09	JT
C	ISSUED FOR CONSTRUCTION 4-8-10	DK

COORD.	SIGNATURE	DATE
MECHANICAL		
ELECTRICAL		
PLUMBING		
STRUCTURAL		

R.F.I.	SENT	ANS.	R.F.I.	SENT	ANS.	R.F.I.	SENT	ANS.
004	04/04/09	04/20/09						
039	08/27/09	09/19/09						

**CHILDREN'S HOSPITAL
OF ORANGE COUNTY**
455 S. MAIN ST., SUITE 200
ORANGE, CA 92668-3974




TOWER II
PLUMBING FLOOR PLAN - LEVEL UNDERGROUND AREA-B

PAN-PACIFIC
PLUMBING & MECHANICAL
Murray Company
2919 E. VICTORIA STREET, RANCHO DOMINGUEZ, CA 90221
PH. 310 637-1500 FAX 310 604-0359

DRAWN
R.O.
CHECKED
M.M.
DATE
2/3/2011
SCALE
1/4" = 1'-0"
JOB NO.
09-006
DRAWING NUMBER
PL3.0BU
REFERENCE DRAWING
A3.0B
P3.0B
1 OF 1 SHEETS

Doc: PL3.0B-00-00-00-MURRAY-DRAWING-PLUMBING-LEVEL UNDERGROUND AREA-B
Printed by: eef 2-15-2011 9:40am

document and the design it covers are the property of Murray Co. They are loaned only with the borrower's expressed written agreement that they will not be reproduced, copied, loaned, exhibited, or used in any other way, except by written consent from Murray Co. to the borrower.

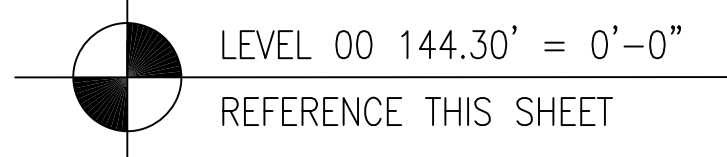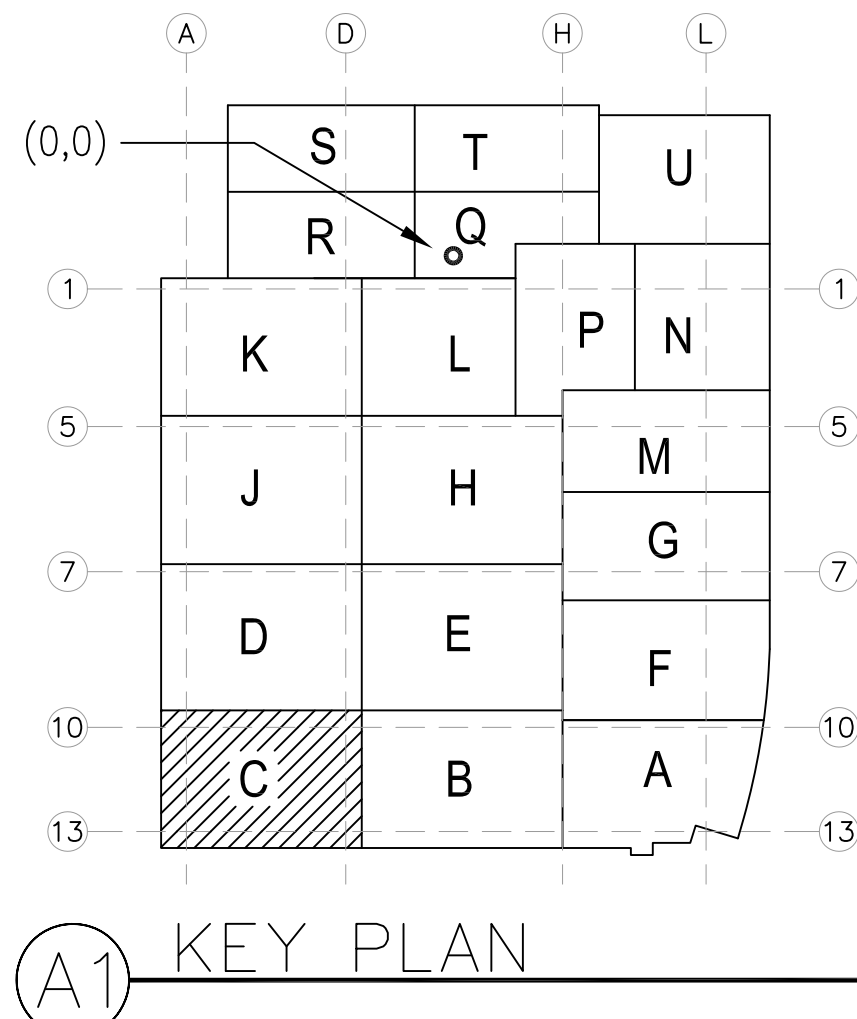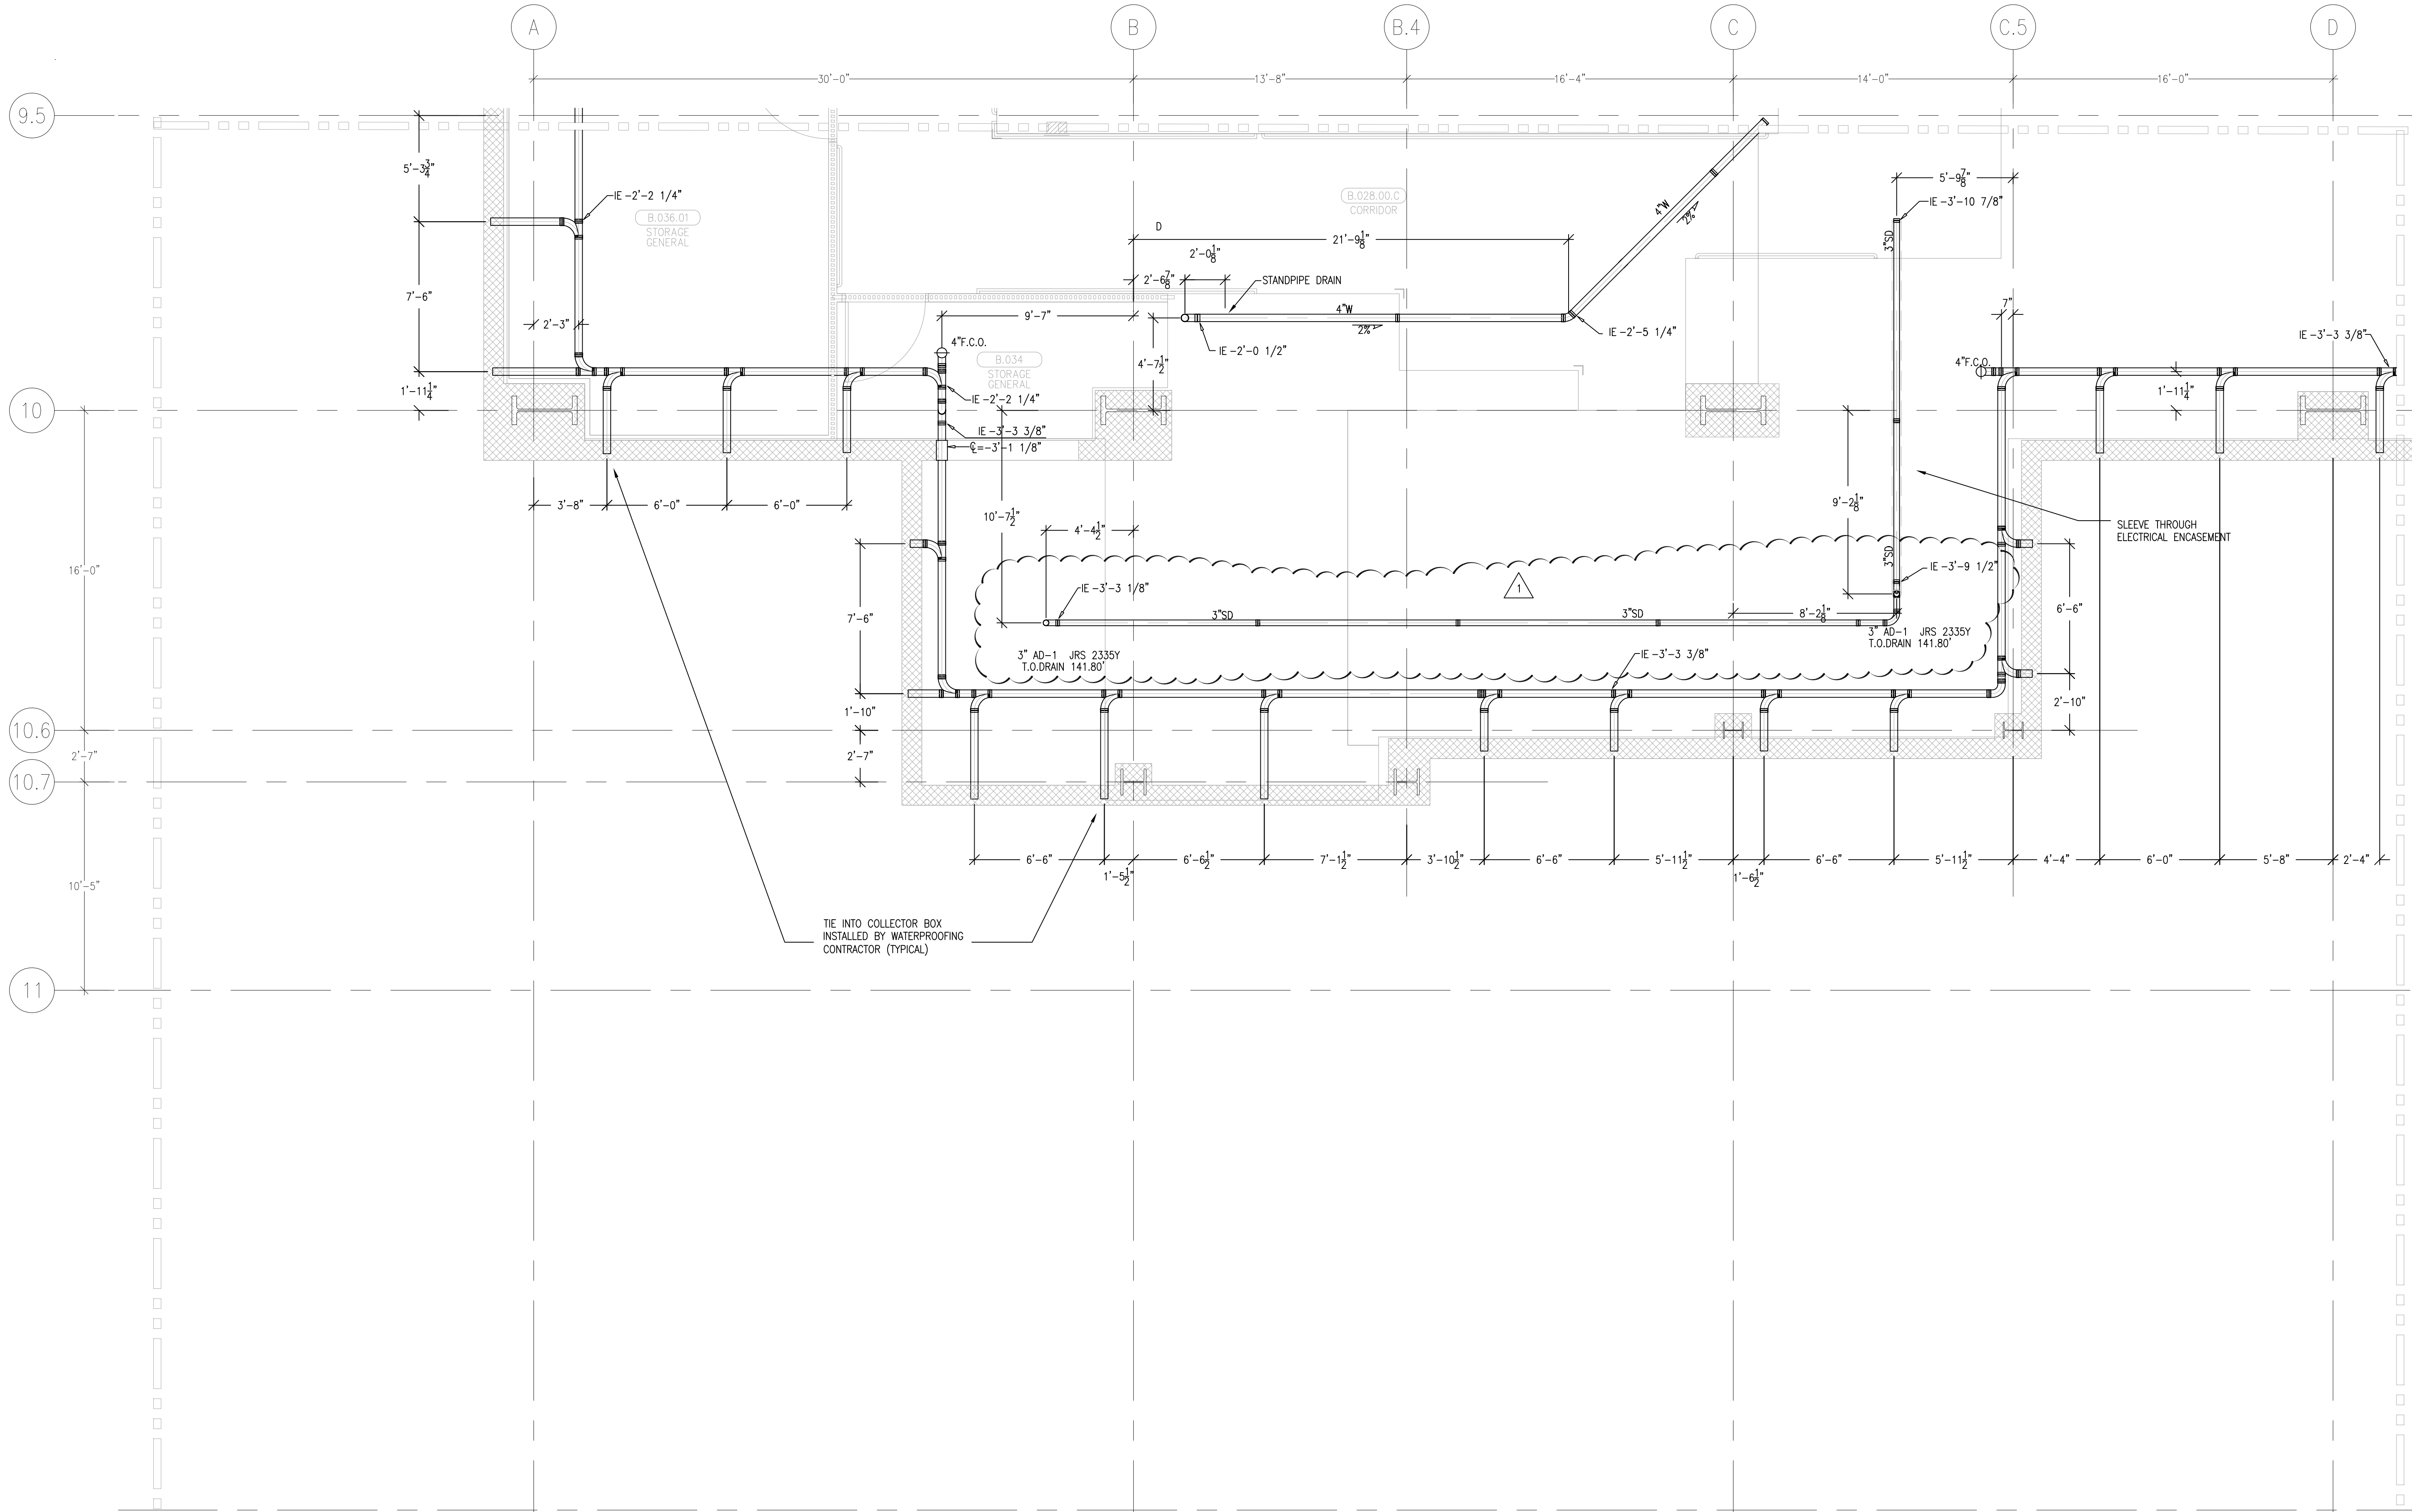

	REVISONS	BY
A	ISSUED FOR COORDINATION SIGN-OFF 6-30-09	DK
B	ISSUED FOR FGMP COORDINATION SIGN-OFF 10-29-09	JT
C	ADDED 4" W/ STANDPIPE DRAIN 11-XX-09	REO
D	ADDED STANDPIPE RISER LOCATION PER FP 11-18-09	REO
E	ADDED SLEEVE 3-15-10	DK
O	ISSUED FOR CONSTRUCTION 4-21-10	DK
I	REVISED STORM DRAIN ROUTING 7-23-10	DK

COORD.	SIGNATURE	DATE
McARTHUR		
MECHANICAL DUCT		
MECHANICAL PIPE		
PLUMBING		
ELECTRICAL		
FIRE SPRINKLER		
PLUMB		
DRYWALL/FRAMER		
REFRIGERATION		
STRUCTURAL		

[illegible]

**CHILDREN'S HOSPITAL
OF ORANGE COUNTY**
455 S. Main St.
Orange, CA 92668-3874

TOWER II

PLUMBING FLOOR PLAN - LEVEL UNDERGROUND AREA-C


PAN-PACIFIC
PLUMBING & MECHANICAL

Murray Company


2919 E. VICTORIA STREET, RANCHO DOMINGUEZ, CA 90221
DUL. 310. 673-1600 FAX 310. 604. 0360.

DRAWN
R.O.
CHECKED
M.M.
DATE
2/3/2011
SCALE
1/4"=1'-0"
JOB NO.
09-006
DRAWING NUMBER
PL3.0CU
REFERENCE DRAWING
A3.0C
P3.0C
1 OF 1 SHEETS

TIE INTO COLLECTOR BOX
INSTALLED BY WATERPROOFING
CONTRACTOR (TYPICAL)

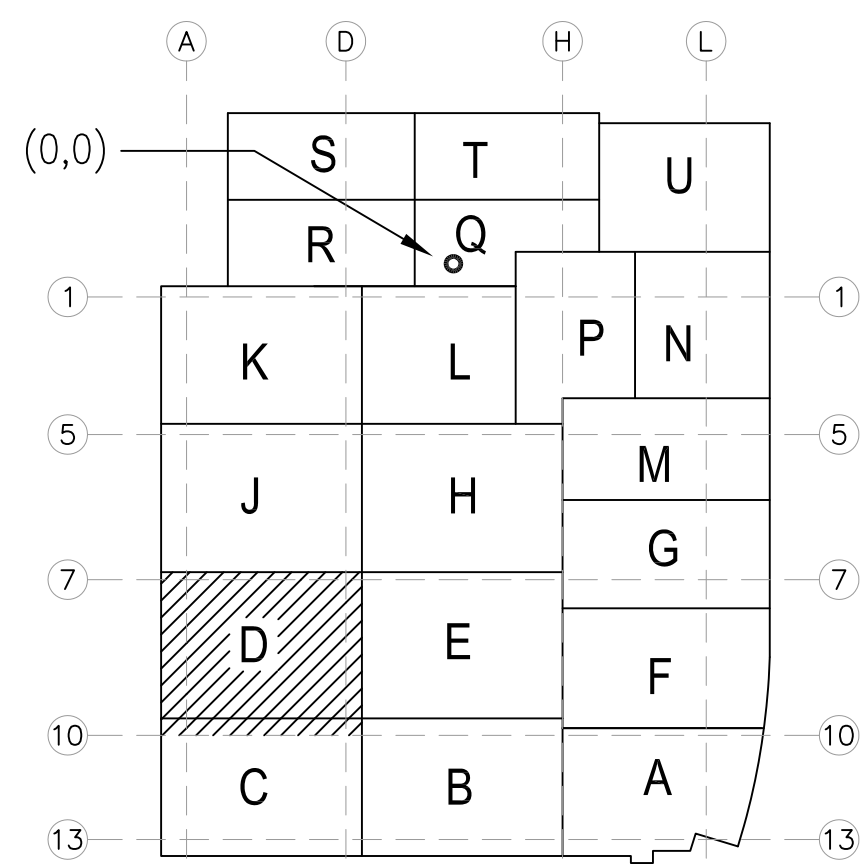

A1 KEY PLAN

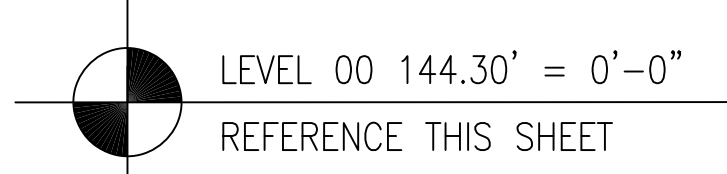

	REVISIONS	BY
D	REVISED 5-7 DRAW LOCATIONS PER COMMENTS FROM TACCO & CON REF 0052 01-25-10	DK
E	CORRECTED ELEVATIONS 5-1-10	DK
F	ADDED MISSING DIMENSIONS 5-2-10	DK
G	CHANGED TO 2X SLOPE 5-5-10	DK
H	ADDED DIMENSIONS RE-COLORED WASTE LINE 5-2-10	DK
O	ISSUED FOR CONSTRUCTION 4-21-10	DK
1	REVISED DUE TO WASTE/SOIL CONTACT 4-29-10	DK
2	ADDED LINE TO GET 2X GRADE 4-30-10	DK
3	MOVED DRAWN IN FUTURE CARTWASH, REWORKED 3' S.D.	DK

COORD.	SIGNATURE	DATE
McCarthy		
MECHANICAL DUCT		
MECHANICAL PIPE		
PLUMBING		
ELECTRICAL		
FIRE SPRINKLER		
PIPE		
DRYWALL/FRAME		
REFRIGERATION		
STRUCTURAL		

	R.F.I.	SENT	ANS.	R.F.I.	SENT	ANS.	R.F.I.	SENT	ANS.
0019	04/11/09	06/04/09							
0022	04/13/09	04/20/09	0174			06/19/09			
0028	04/16/09	05/27/09							
0034	04/18/09	04/29/09							
0043	04/22/09	04/30/09							
0044	04/23/09	05/01/09							
0076	04/30/09	07/08/09							

CHOCSM HOSPITAL
CHILDREN'S HOSPITAL
OF ORANGE COUNTY
455 S. Main St.
Orange, CA 92666-3874
TOWER II

PLUMBING FLOOR PLAN - LEVEL UNDERGROUND AREA-D


PAN-PACIFIC
PLUMBING & MECHANICAL

Murray Company


2919 E. VICTORIA STREET, RANCHO DOMINGUEZ, CA 90221
PH. 310 637-1500 FAX 310 604-0359

DRAWN
R.O.
CHECKED
M.M.
DATE
2/3/2011
SCALE
1/4"=1'-0"
JOB NO.
09-006
DRAWING NUMBER
PL3.0DU
REFERENCE DRAWING
A3.0D
P3.0D
1 OF 1 SHEETS

This document and the design it covers are the property of Murray Co. They are loaned only with the borrower's expressed written agreement that they will not be reproduced, copied, loaned, exhibited, or used in any other way, except by written consent from Murray Co. to the borrower.

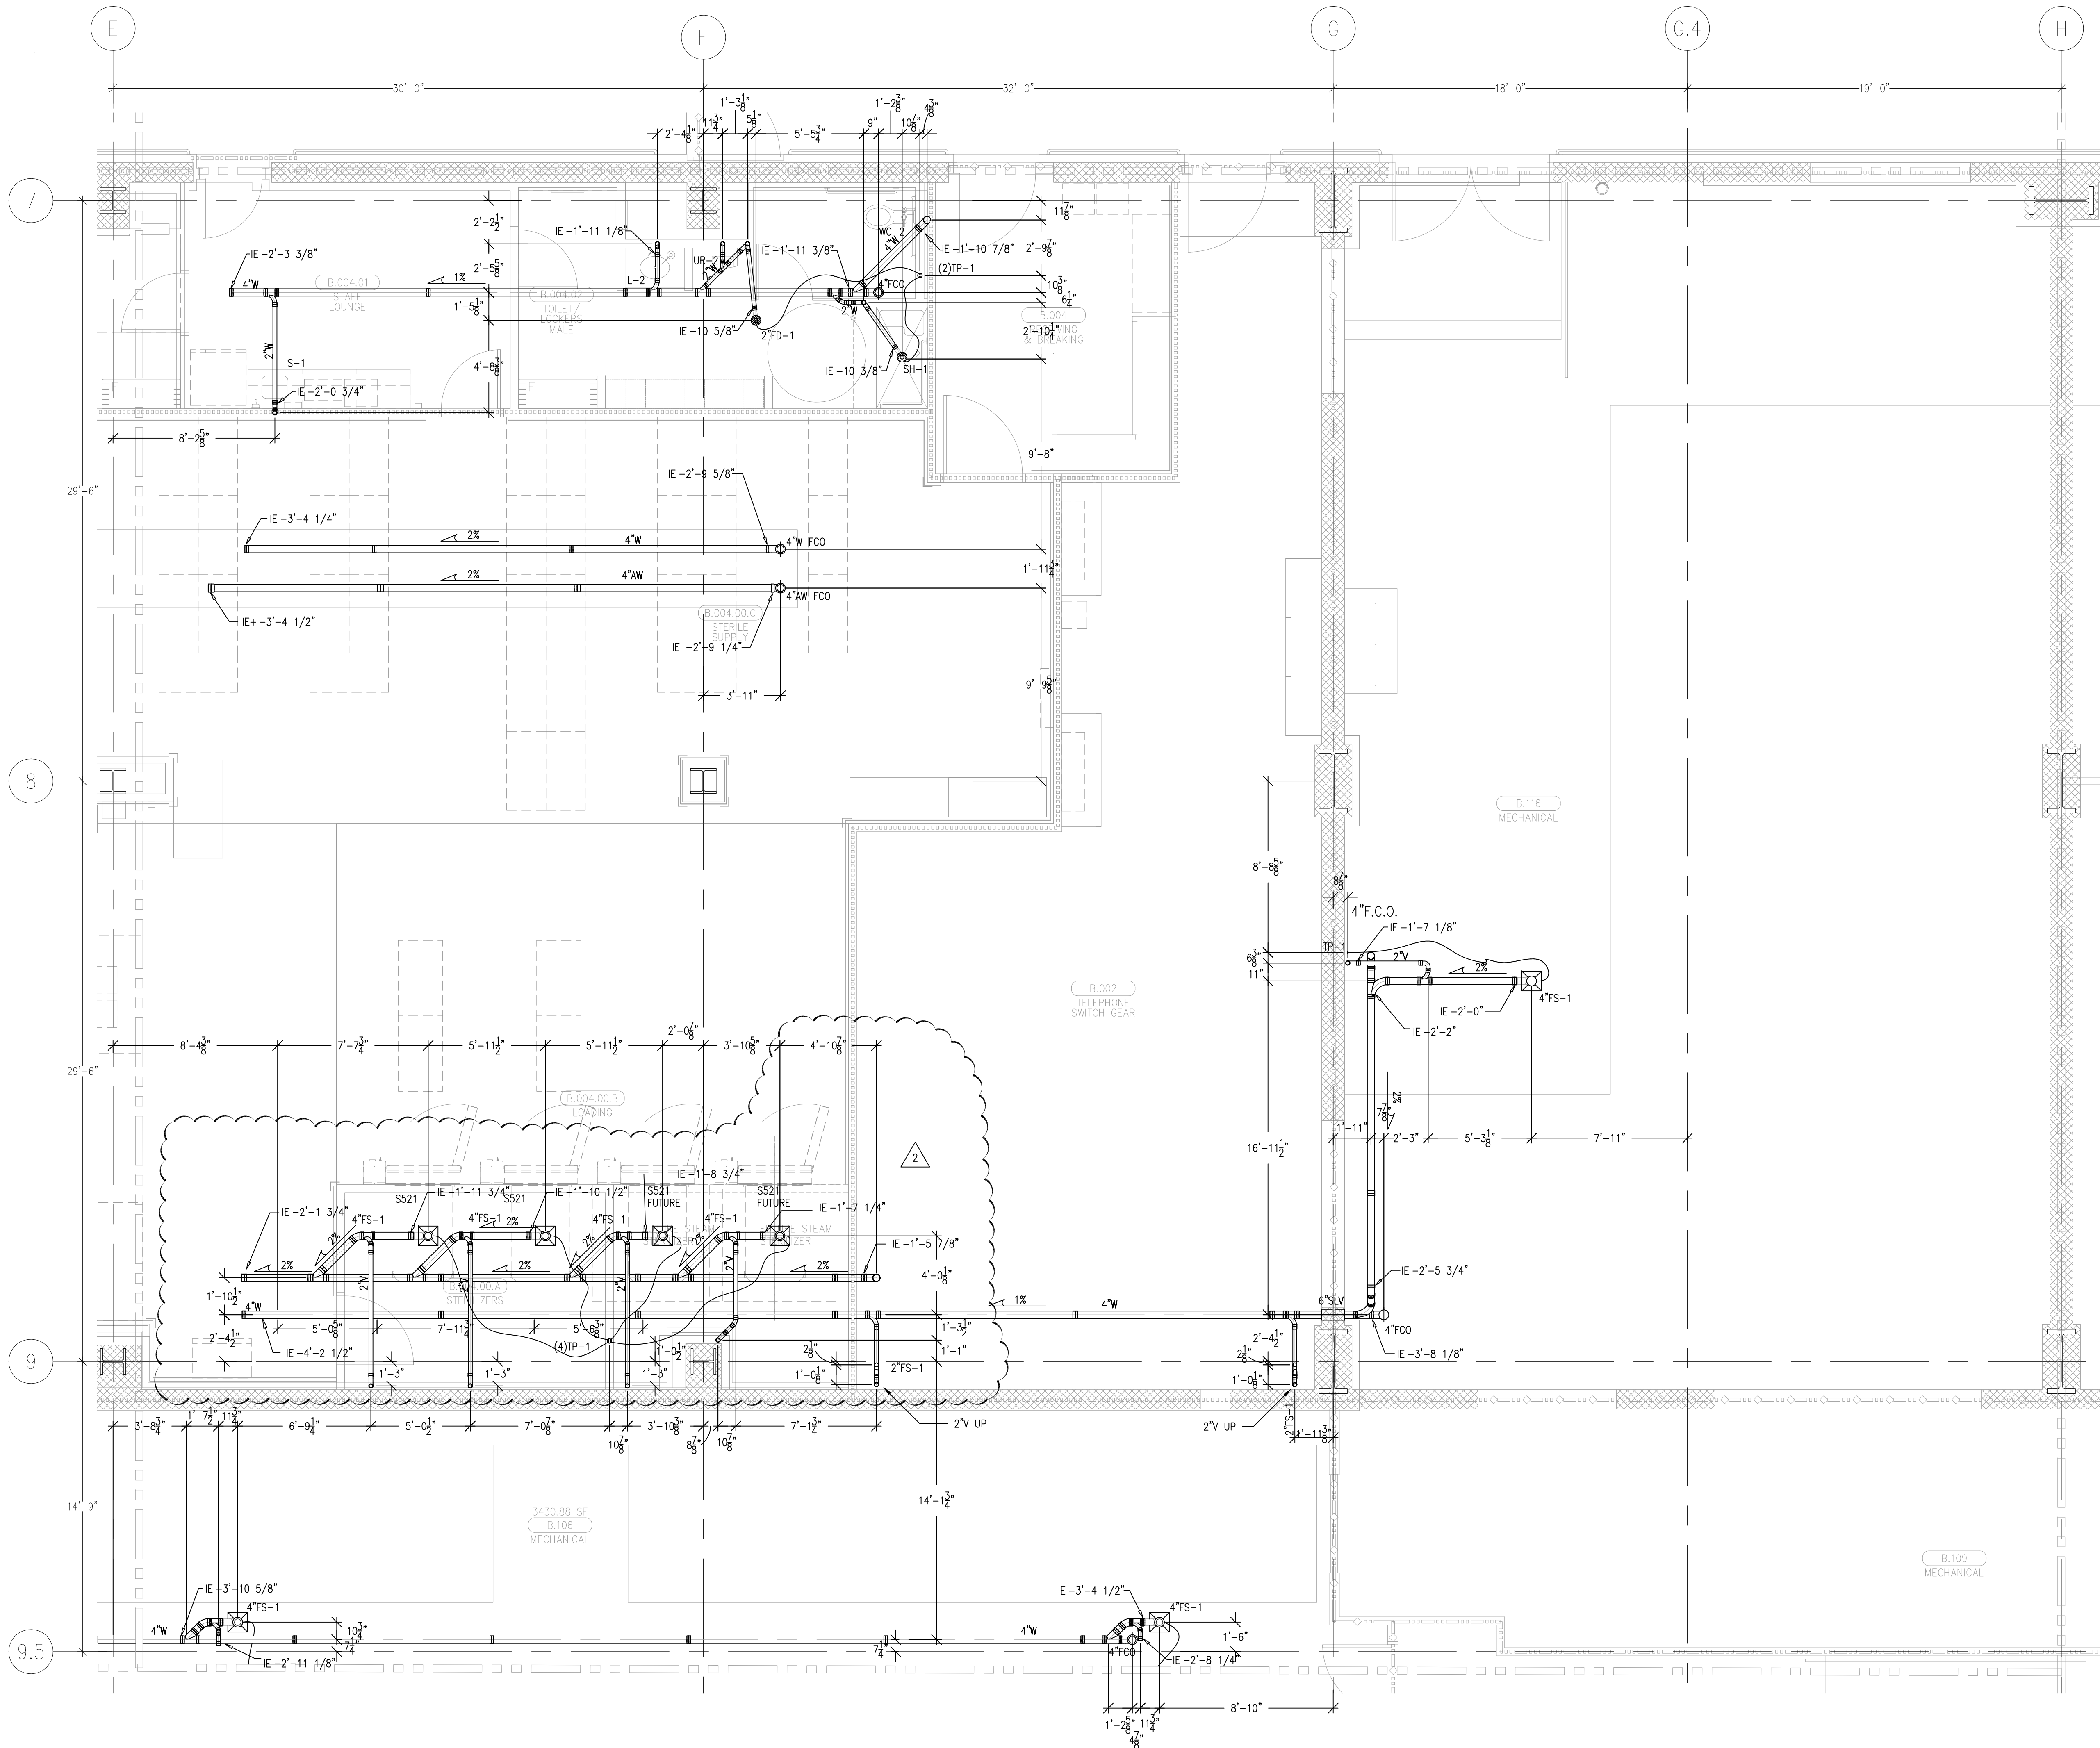

LEVEL 00 144.30' = 0'-0"
REFERENCE THIS SHEET

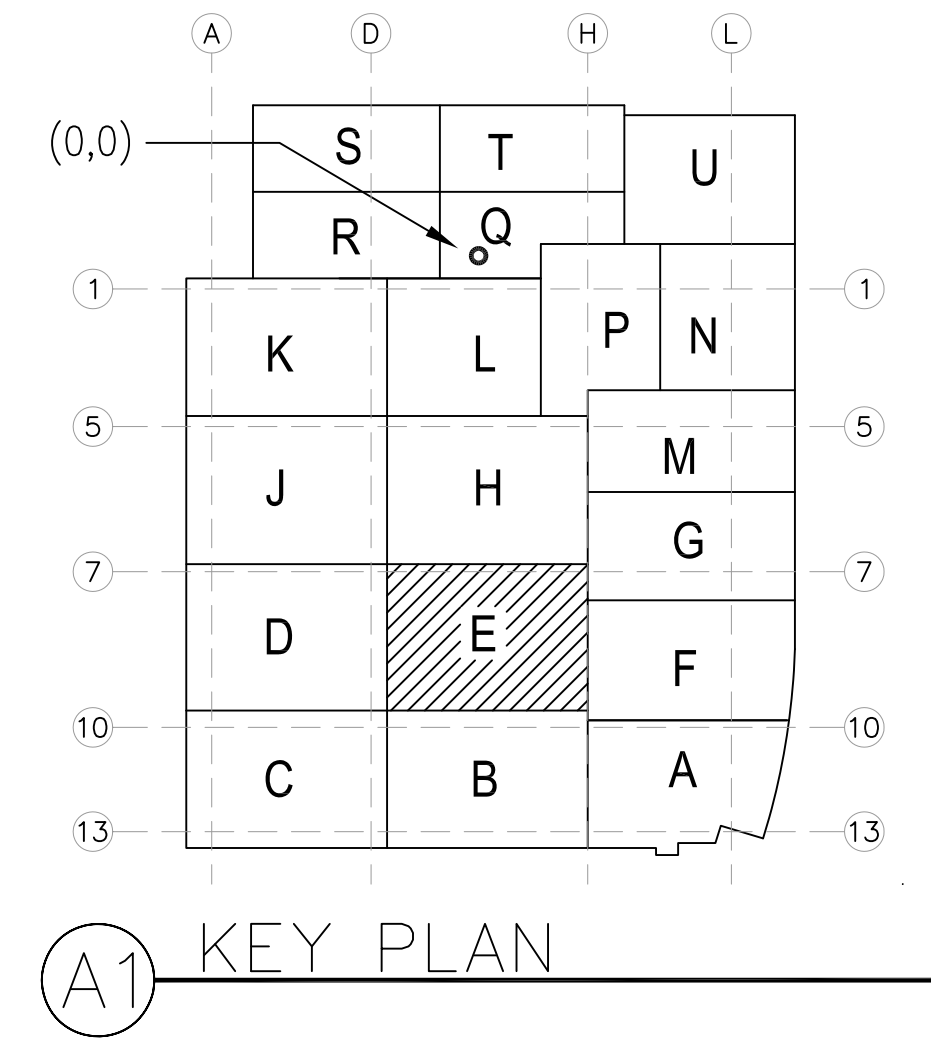

REVISIONS	BY
1. ISSUED FOR COORDINATION SIGN-OFF 6-30-09	DK
2. ISSUED FOR T&M COORDINATION SIGN-OFF 10-29-09	JT
3. CORRECTED ELEVATIONS 3-1-10	DK
4. REVISED ELEVATIONS TO REFLECT CHANGED GRADE 3-5-10	DK
5. REVISED FLOOR SINK LOCATION 3-5-10	DK
6. ADDED FLOOR SINKS PER RFI 768 3-5-10	DK
7. ISSUED FOR CONSTRUCTION 4-8-10	DK
8. REVISED FLOOR SINK LOCATIONS & STERILIZERS 4-18-10	REO
9. ADDED LINE TO GET 2% GRADE 4-28-10	DK

COORD.	SIGNATURE	DATE
MECHANICAL		
ELECTRICAL		
PLUMBING		
STRUCTURAL		

R.F.I.	SENT	ANS.	R.F.I.	SENT	ANS.
0019	04/17/09	06/04/09			
0031	04/17/09	04/20/09			
0075	04/20/09	05/05/09			
0768		03/10/10			
CON. 671	01/26/10	03/14/10			

CHILDREN'S HOSPITAL
CHOC OF ORANGE COUNTY
455 S. MAIN ST., 3RD FLOOR
ORANGE, CA 92668-3974
TOWER II
PLUMBING FLOOR PLAN - LEVEL UNDERGROUND AREA C

PAN-PACIFIC
PLUMBING & MECHANICAL
2919 E. VICTORIA STREET, RANCHO DOMINGUEZ, CA 90221
PH. 310.637-1500 FAX 310.604-0359

DRAWN
R.O.
CHECKED
M.M.
DATE
2/3/2011
SCALE
1/4" = 1'-0"
JOB NO.
09-006
DRAWING NUMBER
PL3.0FU
REFERENCE DRAWING
A3.0E
P3.0E
1 OF 1 SHEETS

	REVISIONS	BY
A	ISSUED FOR COORDINATION SIGN-OFF 6-30-09	DK
B	REVISED UG STORM DRAIN COLLECTION 8-25-09	REO
C	4.5 PSI 22.246 REVISIONS ISSUED FOR FGMP COORDINATION SIGN-OFF 7-29-09	JT
D	ADDED STAIRDRIPE RISER LOCATION PER PP 1-18-09	REO
E	REVISED PER ELECTRICIAN'S REQUEST 01-28-10	DK
F	REVISED FLOOR SINK LOCATION. 3-9-10	DK
G	ISSUED FOR CONSTRUCTION 4-8-10	DK
H	REVISED SLOPE 6-11-10	DK

COORD.	SIGNATURE	DATE
McARTHUR		
MECHANICAL DUCT		
MECHANICAL PIPE		
PLUMBING		
ELECTRICAL		
FIRE SPRINKLER		
PULSE		
DRYWALL/FRAMER		
REFRIGERATION		
STRUCTURAL		

R.F.I.	SENT	ANS.	R.F.I.	SENT	ANS.
0008	04/09/09	04/13/09			
0019	04/11/09	06/24/09			
0296	08/06/09	08/28/09			
0489	10/02/09	10/13/09			

CHOC™
HOSPITAL
CHILDREN'S HOSPITAL
OF ORANGE COUNTY
455 S. Main St.
Orange, CA 92668-3874
TOWER II
PLUMBING FLOOR PLAN - LEVEL UNDERGROUND AREA-F

PAN-PACIFIC
PLUMBING & MECHANICAL


PAN-PACIFIC
PLUMBING & MECHANICAL

Murray
Company


2919 E. VICTORIA STREET, RANCHO DOMINGUEZ, CA 90221
PH. 310 637-1500 FAX. 310 604-0359

DRAWN
R.O.
CHECKED
M.M.
DATE
2/3/2011
SCALE
1/4"=1'-0"
JOB NO.
09-006
DRAWING NUMBER
PL3.0FU
REFERENCE DRAWING
A3.0F
P3.0F
1 OF 1 SHEETS

This document and the design it covers are the property of Murray Co. They are loaned only with the borrower's expressed written agreement that they will not be reproduced, copied, loaned, exhibited, or used in any other way, except by written consent from Murray Co. to the borrower.

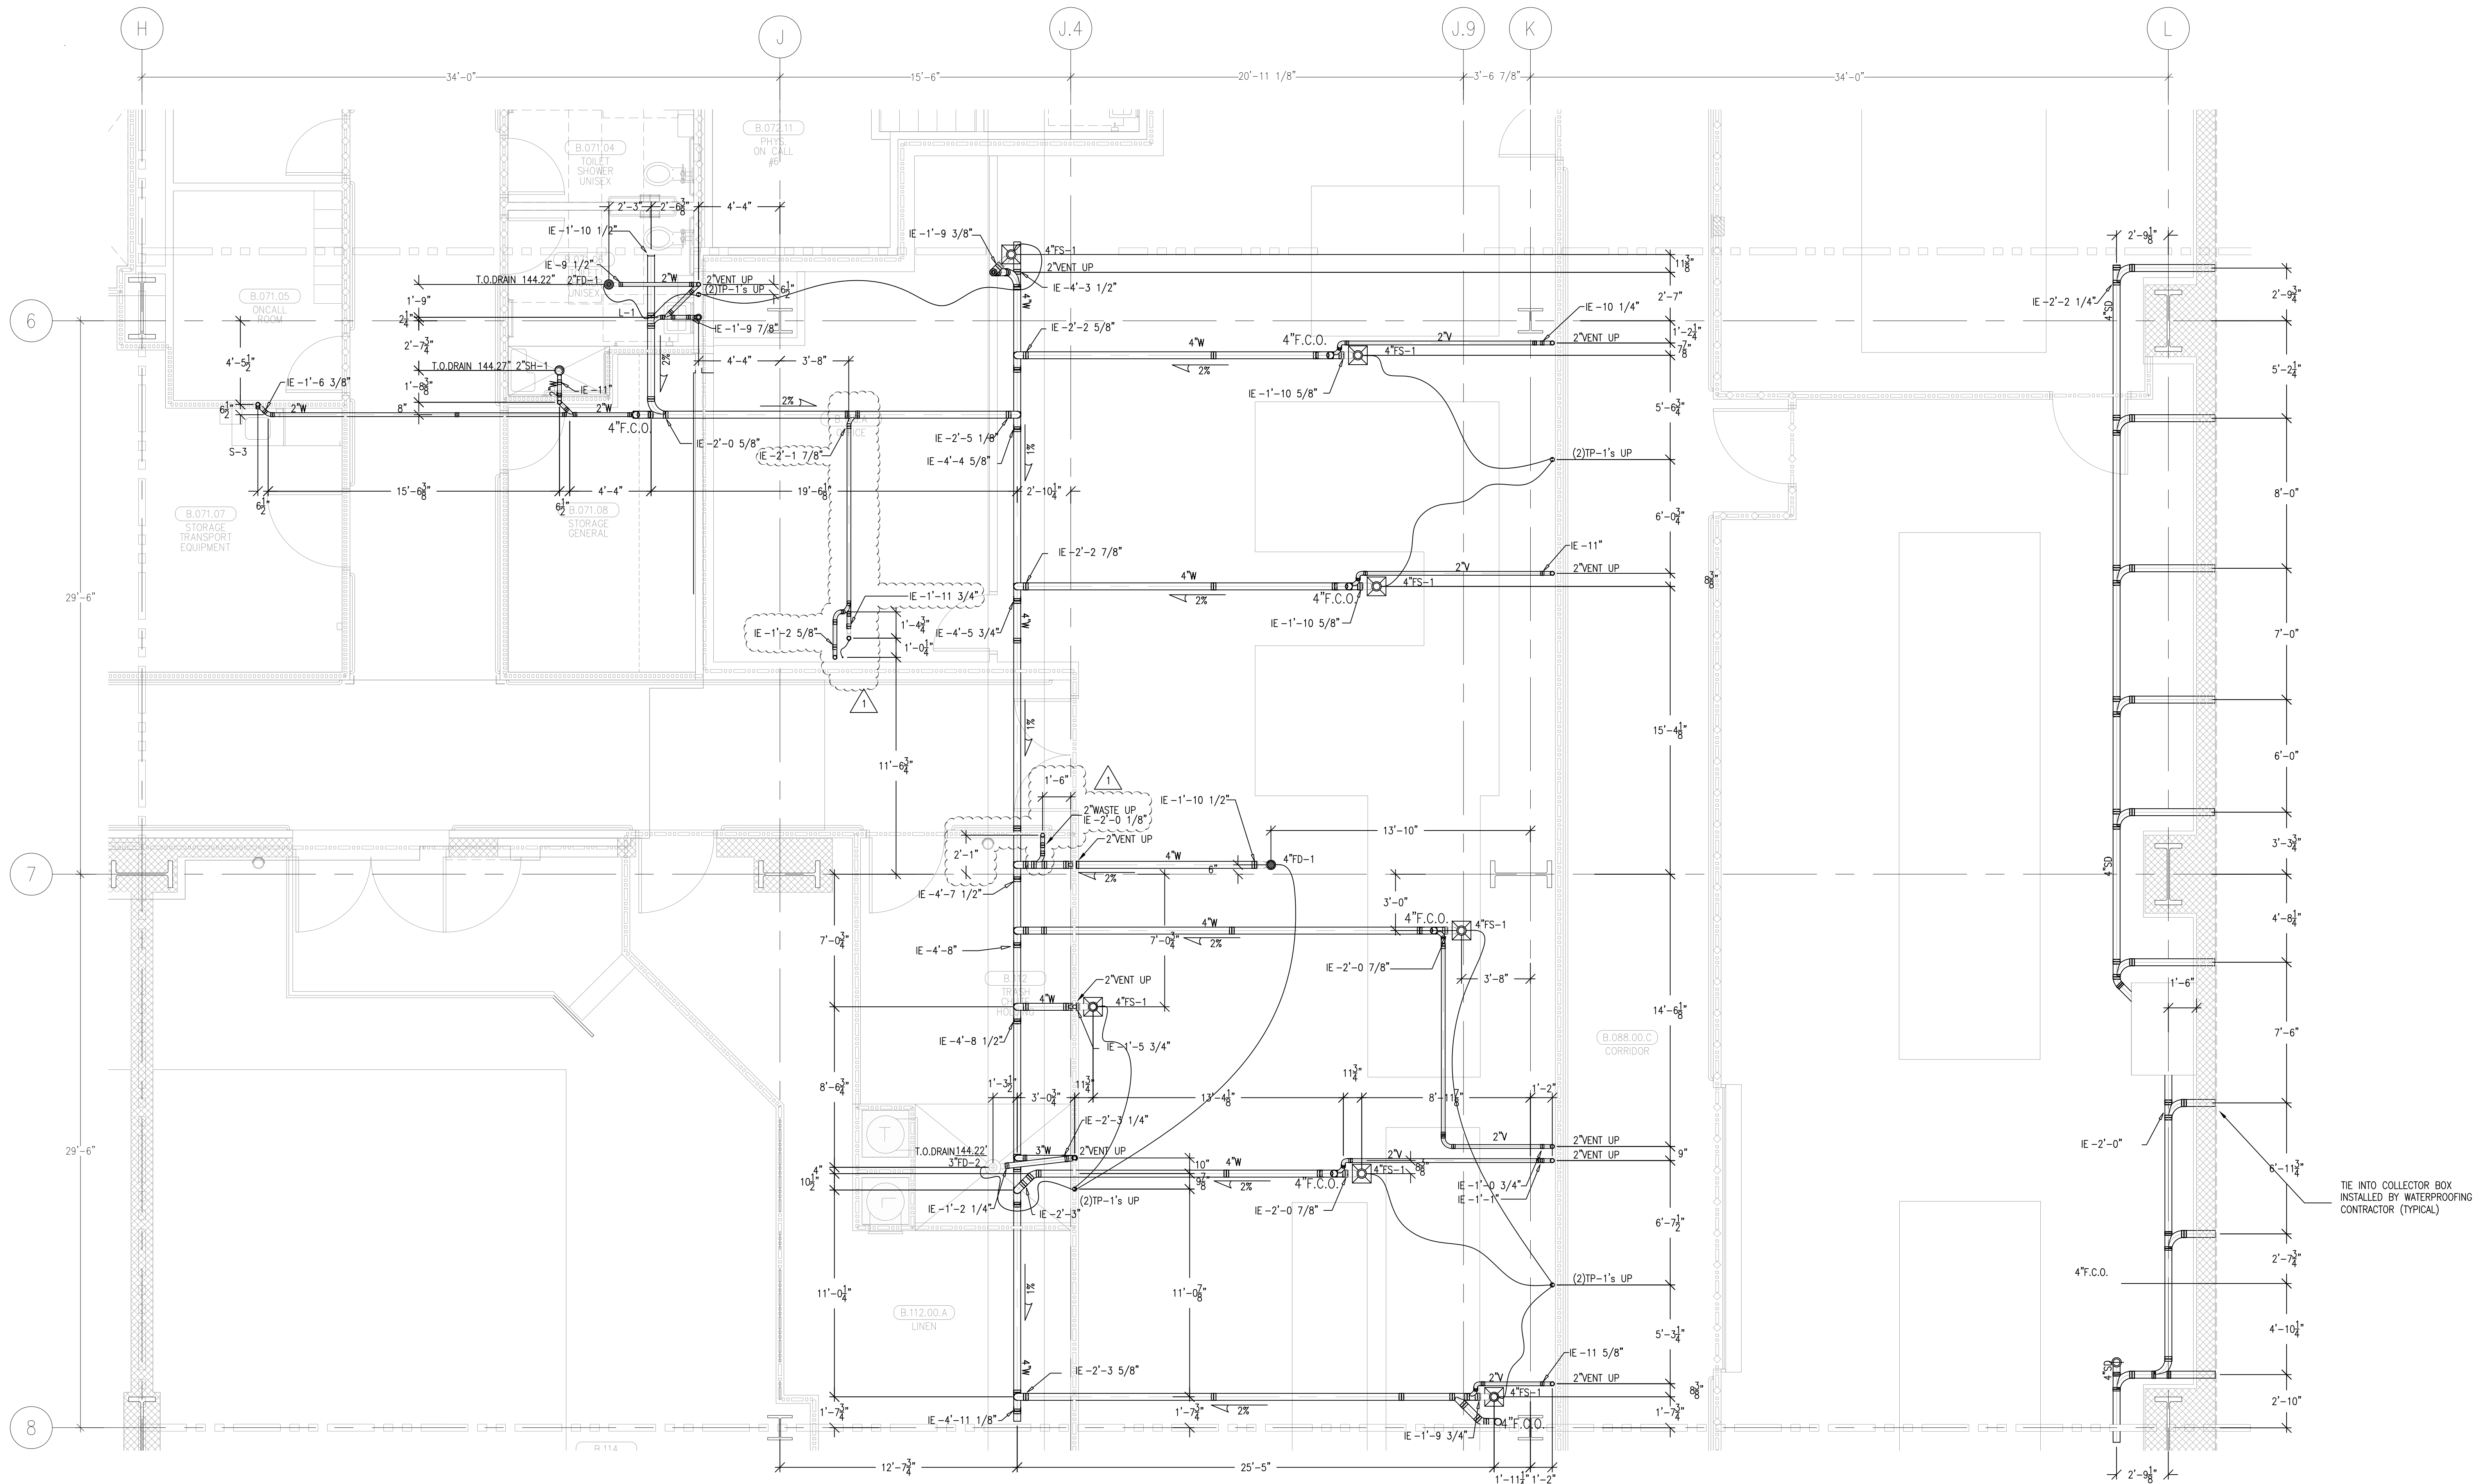

LEVEL 00 144.30' = 0'-0"
REFERENCE THIS SHEET

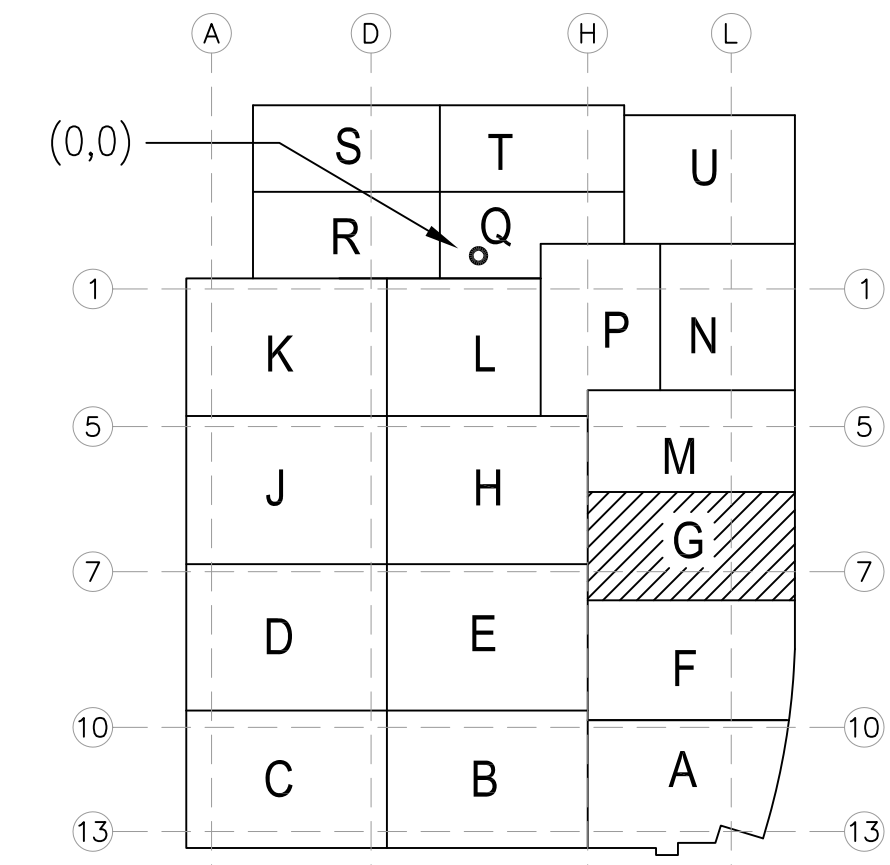


REVISIONS		BY
A	ISSUED FOR COORDINATION SIGN-OFF 6-30-09	DK
B	REVISED UIC STORM DRAIN COLLECTION 8-25-09	REO
C	ISSUED FOR RMPM COORDINATION SIGN-OFF 10-28-09	MLV
D	REVISED PER ELECTRICIAN'S REQUEST 01-28-10	DK
E	ADDED FLOOR DRAIN AND FLOOR SINK 03-29-10	DK
F	ADDED FLOOR SINK PER RFI 0790 04-07-10	REO
G	ISSUED FOR CONSTRUCTION 4-9-10	REO
H	REVISIONS PER CIP 19 PPMC RFI 790 01-22-11	JT

COORD.	SIGNATURE	DATE
MECHANICAL		
ELECTRICAL		
PLUMBING		
STRUCTURAL		

R.F.I.	SENT	ANS.	R.F.I.	SENT	ANS.	R.F.I.	SENT	ANS.
0005	04/04/09	04/20/09						
0008	04/09/09	04/13/09						
0009	04/09/09	04/13/09						
0019	04/11/09	06/04/09						
0025	04/14/09	05/04/09						
0296	06/06/09	08/26/09						


**CHILDREN'S HOSPITAL
OF ORANGE COUNTY**
455 S. MAIN ST.
ORANGE, CA 92668-9874

TOWER II
PLUMBING FLOOR PLAN - LEVEL UNDERGROUND AREA-G

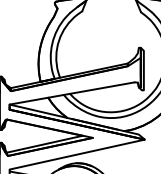**Murray Company**
PAN-PACIFIC
PLUMBING & MECHANICAL
2919 E. VICTORIA STREET, RANCHO DOMINGUEZ, CA 90221
PH. 310 637-1500 FAX 310 604-0359



DRAWN
R.O.
CHECKED
M.M.
DATE
2/3/2011
SCALE
1/4" = 1'-0"
JOB NO.
09-006
DRAWING NUMBER
PL3.0GU
REFERENCE DRAWING
A3.0G
P3.0G
1 OF 1 SHEETS

Printed by: cadd 2-10-2011 9:40am
Dwg File: L:\09-006-CHOC-MURRAY-DRAWING\PLUMBING\LEVEL UNDERGROUND AREA-G.dwg

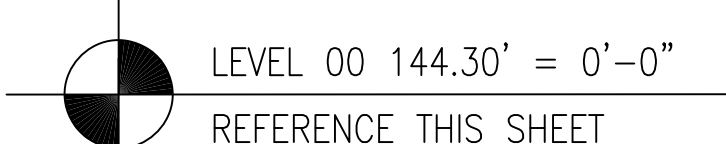

DRAWN
R.O.
CHECKED
M.M.
DATE
2/3/2011
SCALE
1/4" = 1'-0"
JOB NO.
09-006
DRAWING NUMBER
PL3.0HU
REFERENCE DRAWING
A3.0H
P3.0H
1 OF 1 SHEETS

This document and the design it covers are the property of Murray Co. They are loaned only with the borrower's expressed written agreement that they will not be reproduced, copied, loaned, exhibited, or used in any other way, except by written consent from Murray Co. to the borrower.

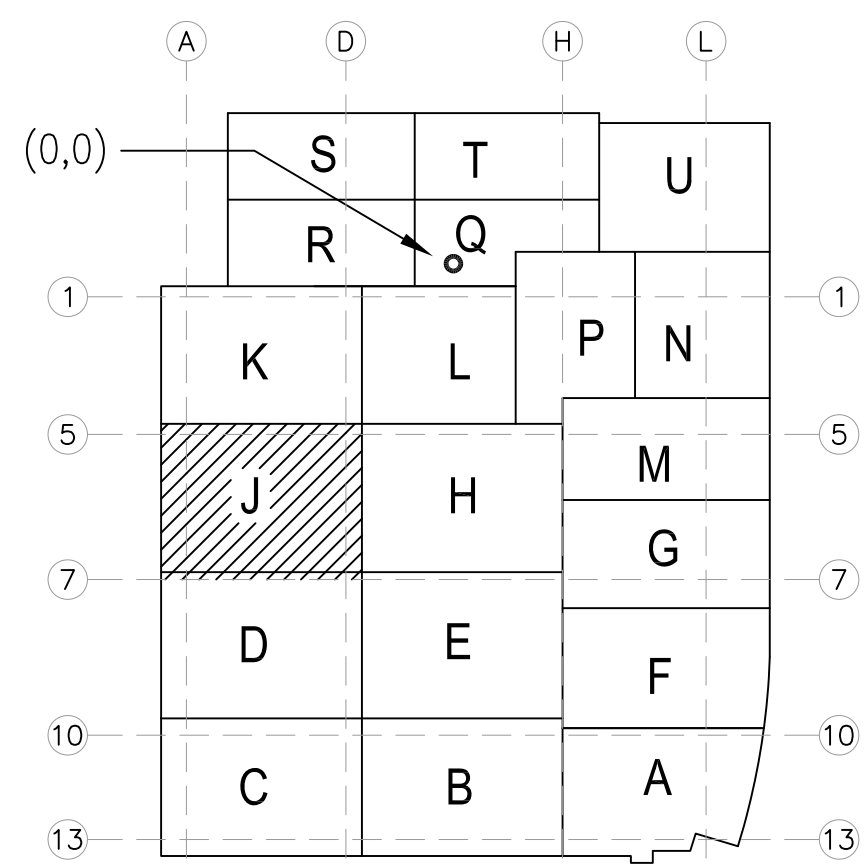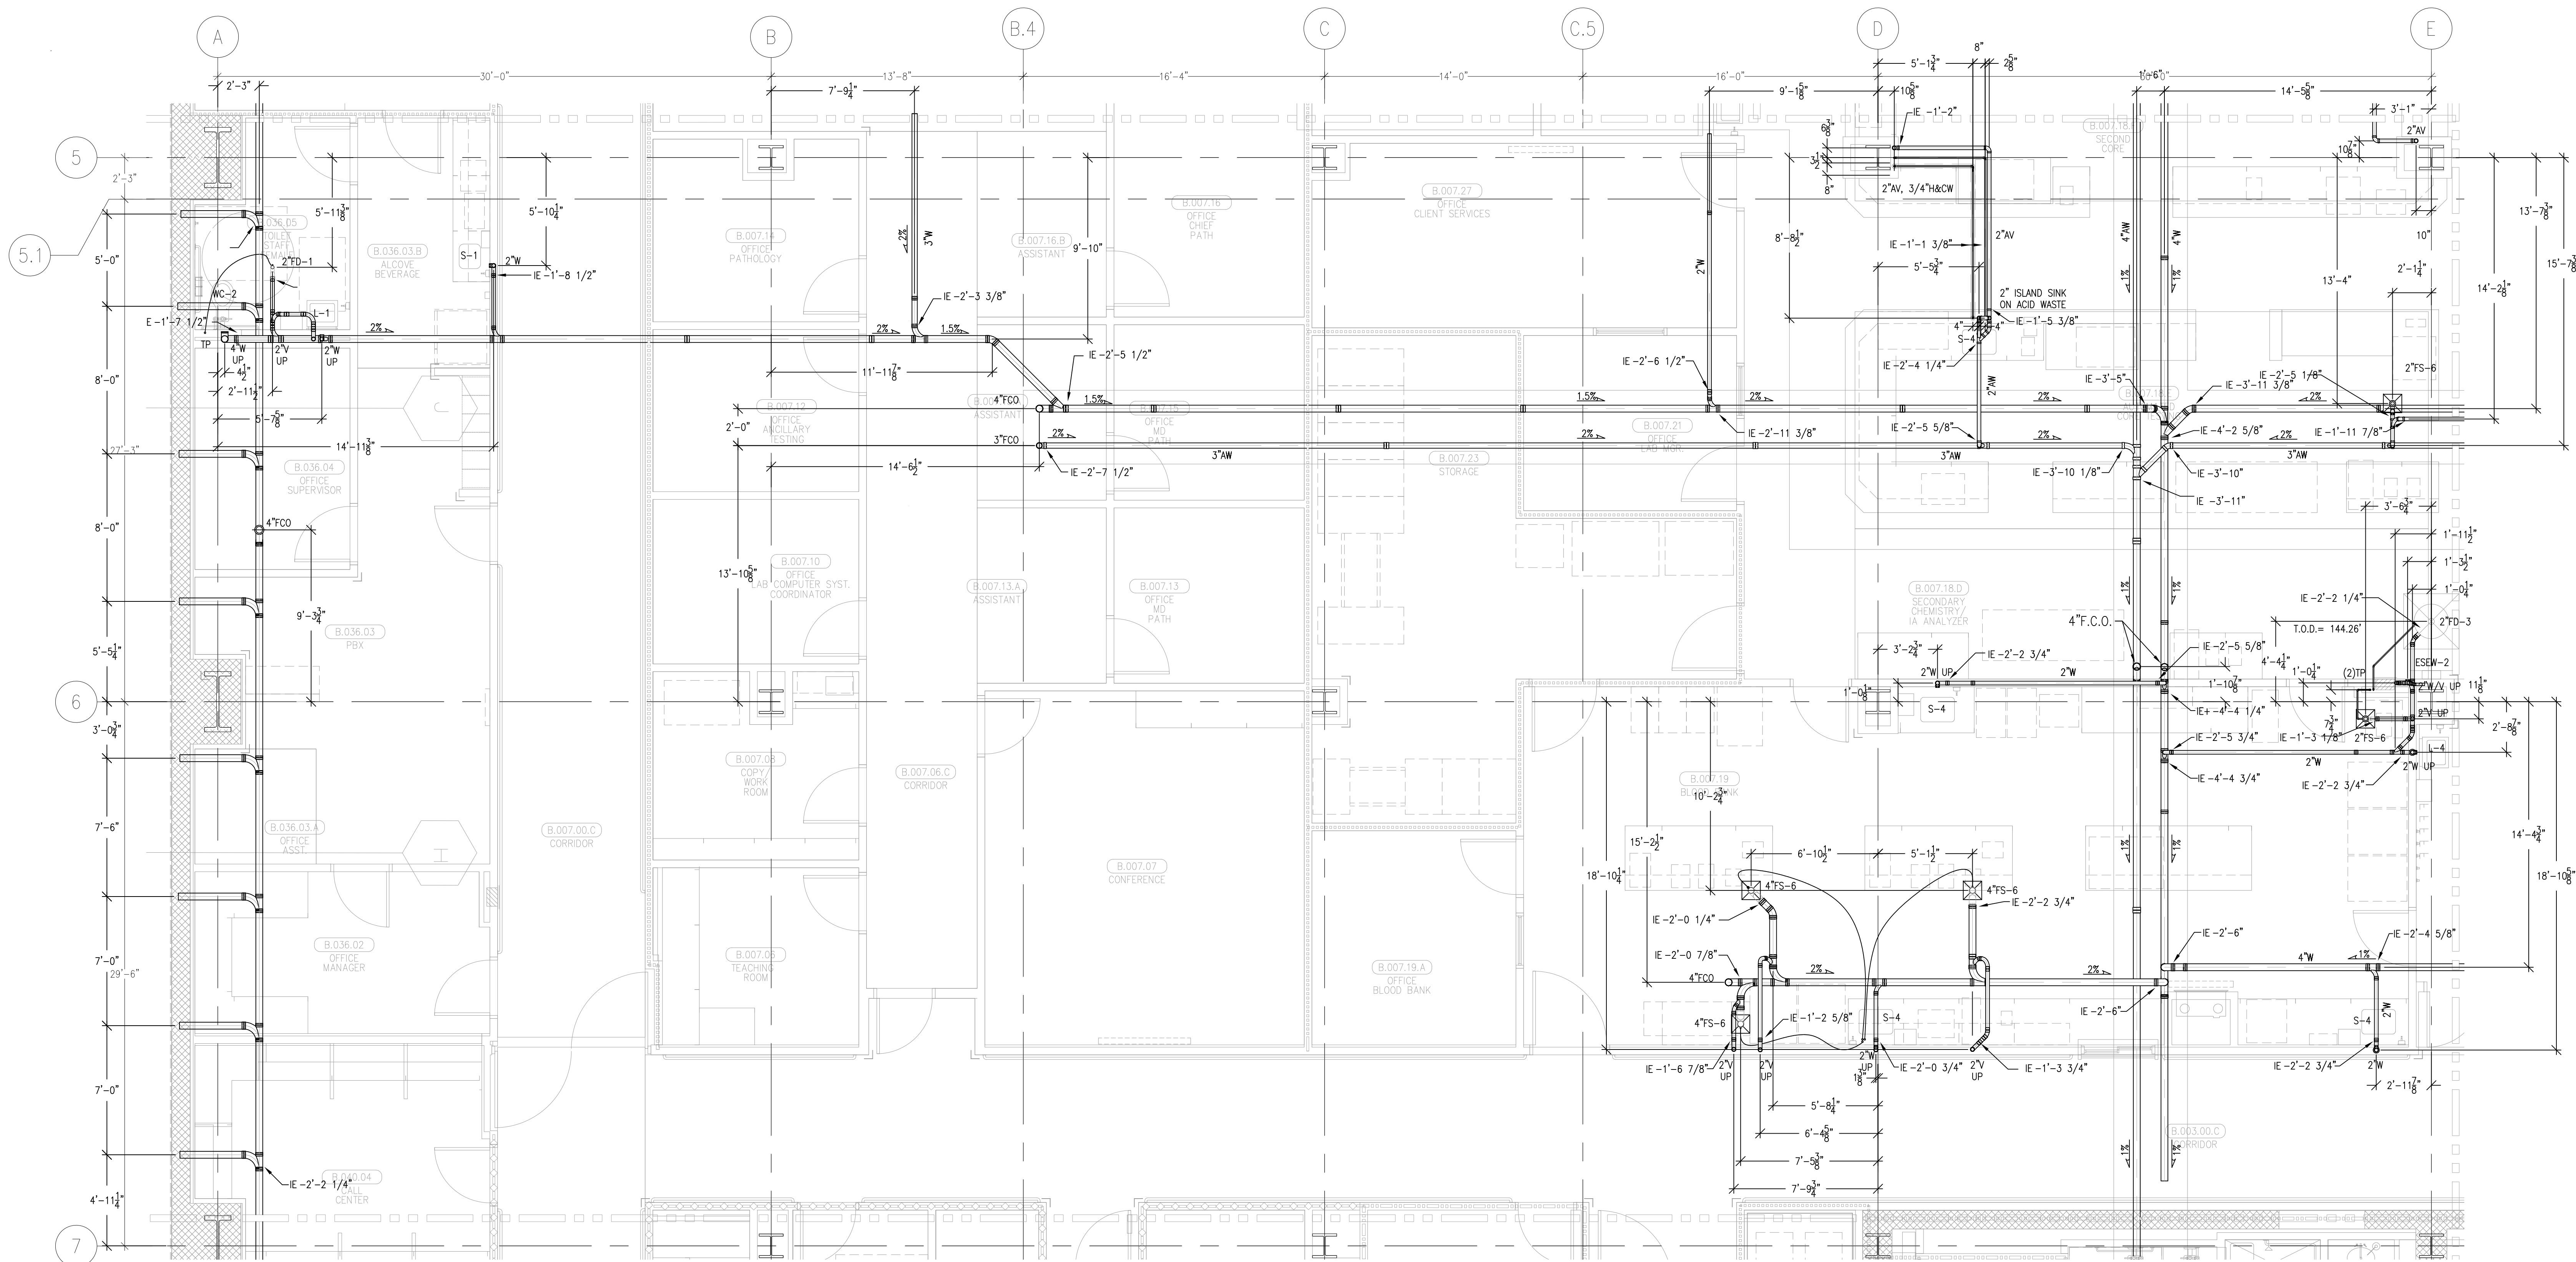

LEVEL 00 144.30' = 0'-0"
REFERENCE THIS SHEET

REVISIONS		BY
A	ISSUED FOR COORDINATION SIGN-OFF 6-30-09	DK
B	ISSUED FOR TEMP COORDINATION SIGN-OFF 10-28-09	JT
C	CORRECTED ELEVATION 5-1-10	DK
D	ISSUED FOR CONSTRUCTION 4-8-10	DK

COORD.	SIGNATURE	DATE
MECHANICAL		
ELECTRICAL		
PLUMBING		
STRUCTURAL		

R.F.I.	SENT	ANS.	R.F.I.	SENT	ANS.
0080	04/29/09	05/05/09			
0081	10/14/09	10/14/09			

CHILDREN'S HOSPITAL OF ORANGE COUNTY
405 S. MAIN ST., 3RD FLOOR
ORANGE, CA 92668-5874

TOWER II

PLUMBING FLOOR PLAN - LEVEL UNDERGROUND AREA-J


PAN-PACIFIC
PLUMBING & MECHANICAL

Murray Company


2919 E. VICTORIA STREET, RANCHO DOMINGUEZ, CA 90221
PH. 310 637-1500 FAX 310 604-0359

DRAWN: R.O.
CHECKED: M.M.
DATE: 2/3/2011
SCALE: 1/4" = 1'-0"
JOB NO.: 09-006
DRAWING NUMBER: PL3.0JU
REFERENCE DRAWING: A3.0J, P3.0J
1 OF 1 SHEETS

This document and the design it covers are the property of Murray Co. They are loaned only with the borrower's expressed written agreement that they will not be reproduced, copied, loaned, exhibited, or used in any other way, except by written consent from Murray Co. to the borrower.

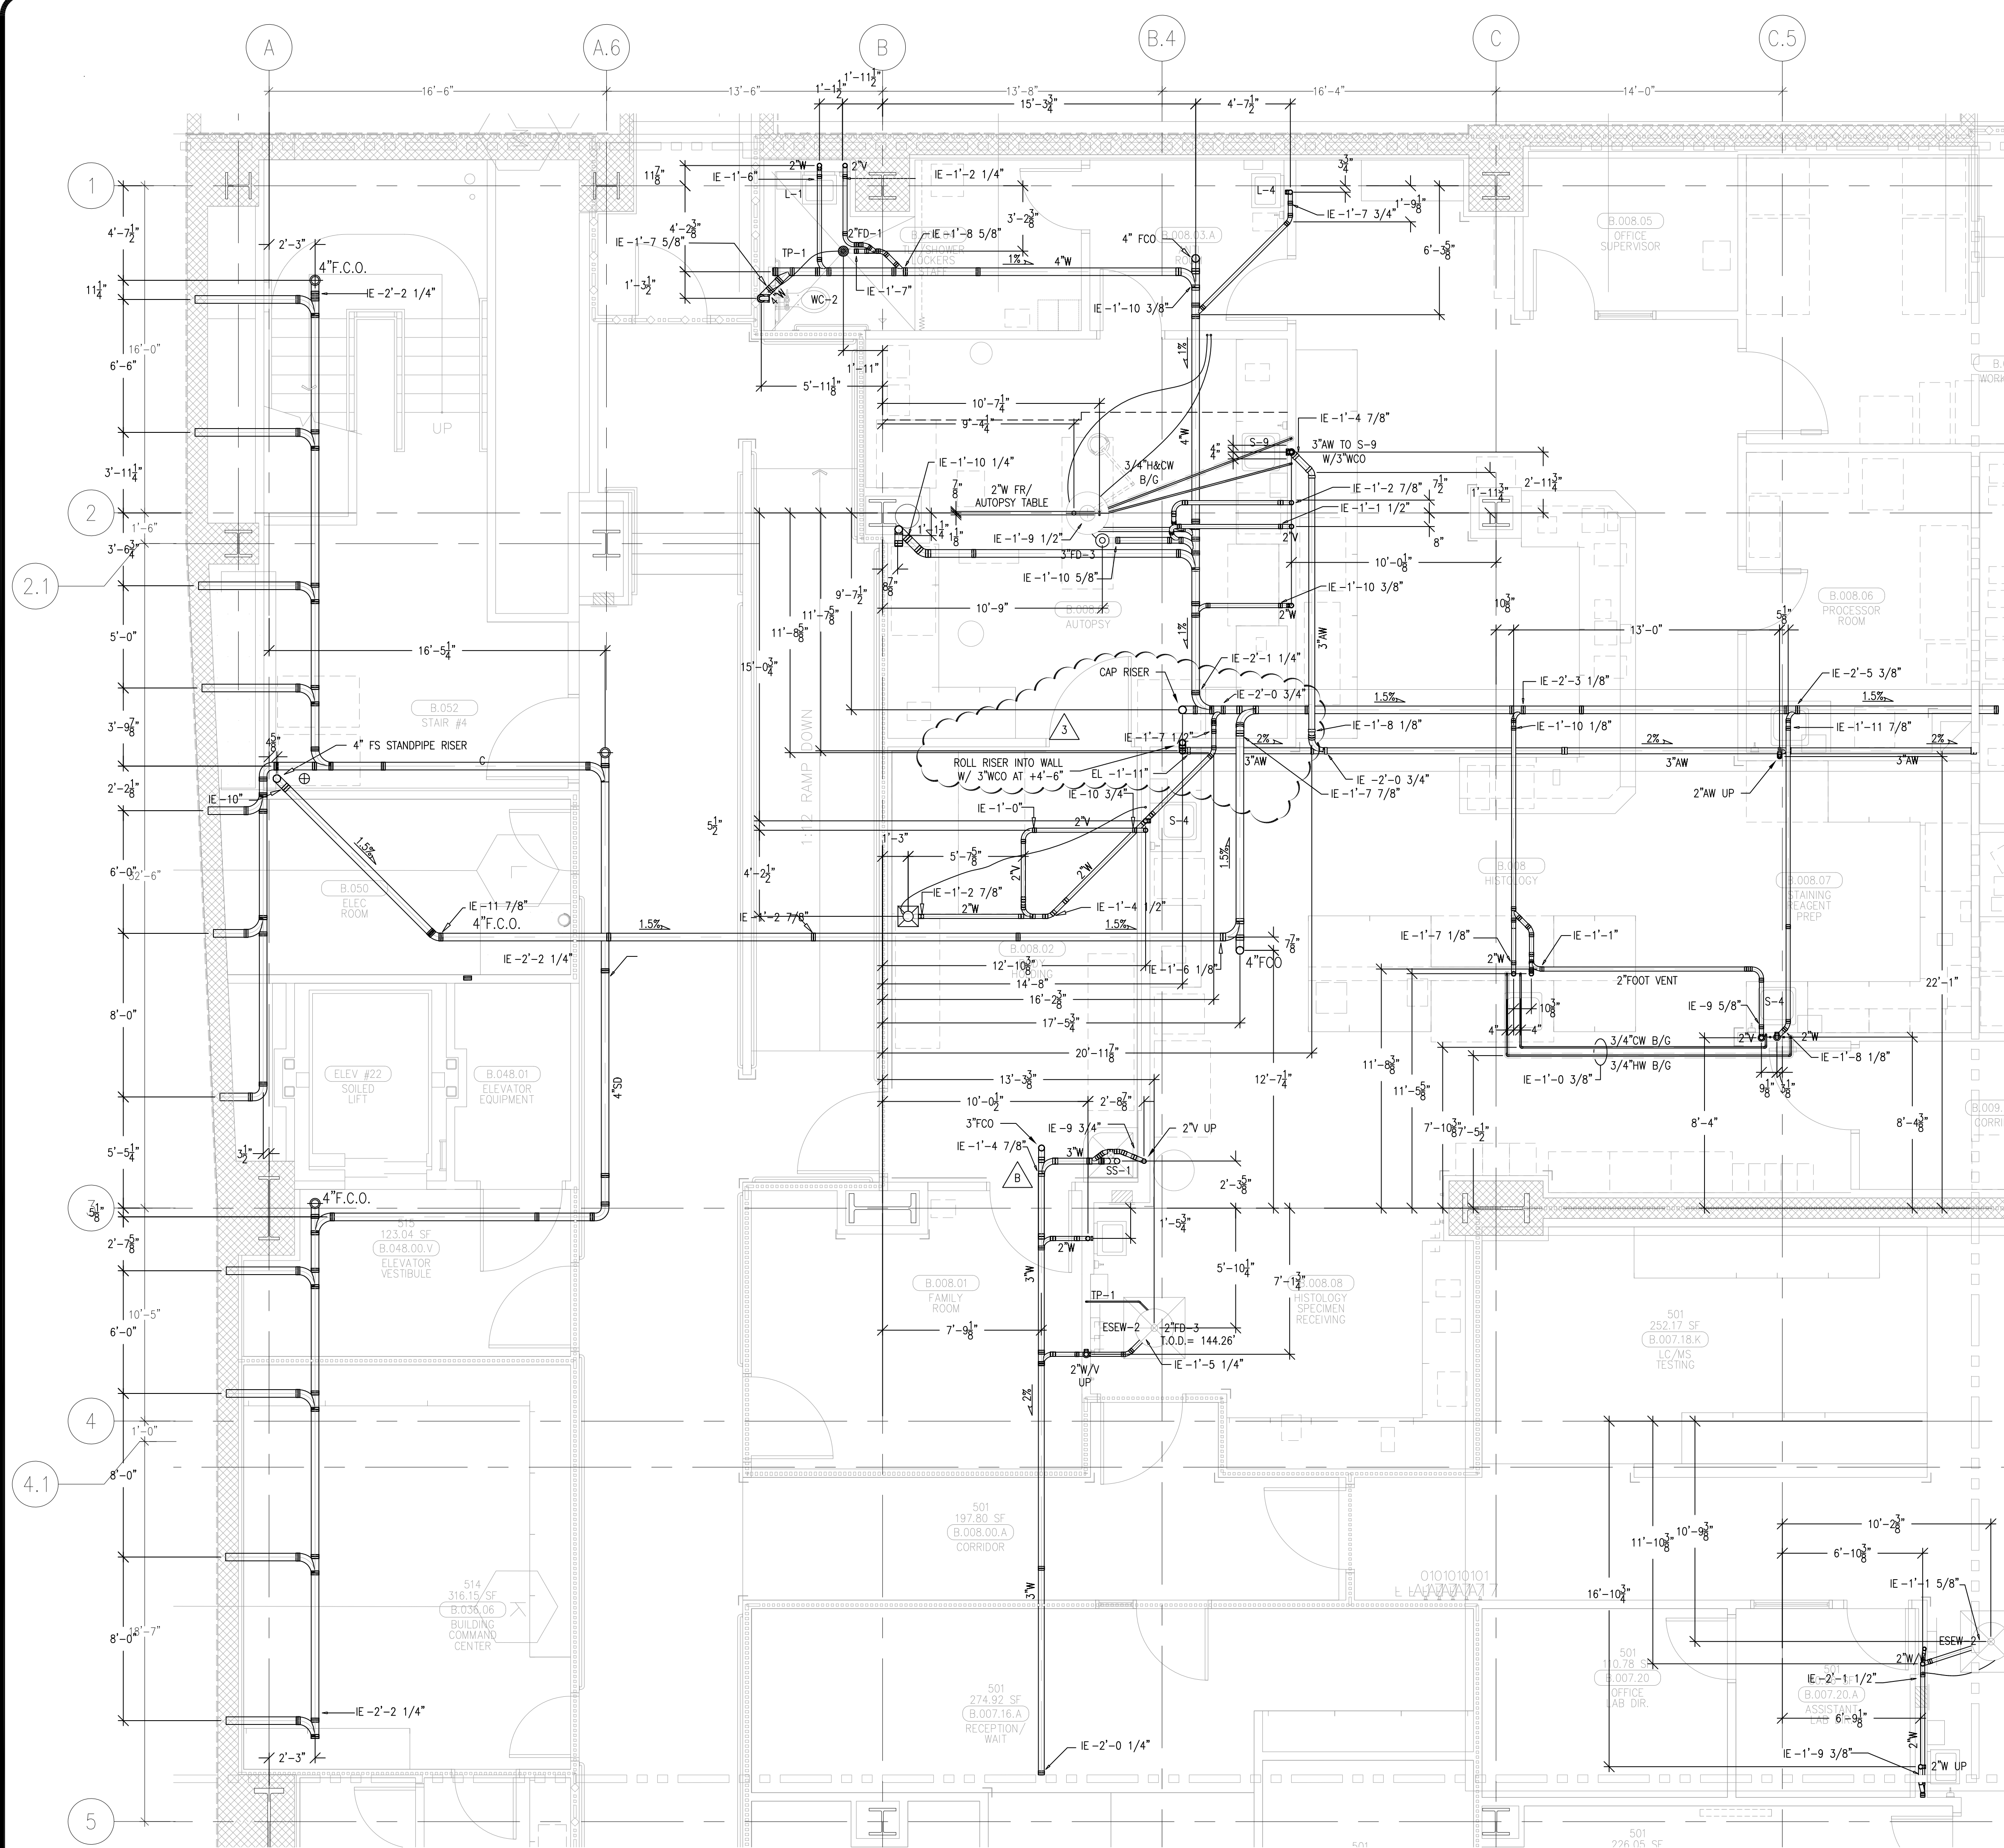

LEVEL 00 144.30' = 0'-0"
REFERENCE THIS SHEET

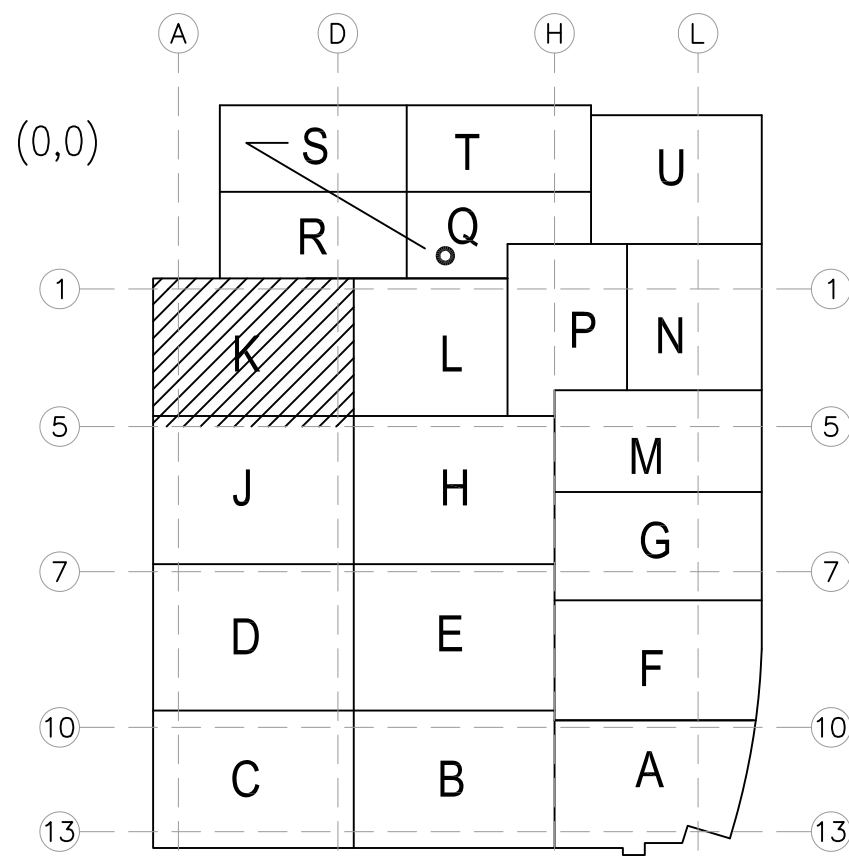

ISSUED FOR PUMP
COORDINATION SIGN-OFF
10-29-09
REVISED STANDPIPE
RISER LOCATION PER FP
11-18-09

JT
REO

REVISIONS	BY
REVISED PER OSHPD PERMIT SET 02-23-10	DK
ADDED DIMENSIONS AND TEXT 02-24-10	DK
CORRECTED ELEVATIONS 3-1-10	DK
CHANGED ELEVATIONS DUE TO PUMP CONFLICT 3-8-10	DK
ISSUED FOR CONSTRUCTION 4-08-10	DK
REVISED PER RPT 1203 5-04-10	DK
REVISED PER BERG ELECTRICAL REQUEST 6-30-10	DK
REVISED PER CONVERSATION WITH ED SAKAMOTO 6-30-10	DK

COORD.	SIGNATURE	DATE
MECHANICAL		
ELECTRICAL		
PLUMBING		
STRUCTURAL		


R.F.I.	SENT	ANS.	R.F.I.	SENT	ANS.	R.F.I.	SENT	ANS.
0084	05/04/09	05/14/09						
0085	05/04/09	06/09/09						
0087	05/04/09	05/18/09						
0104	05/07/09	06/12/09						
0141	05/22/09	06/04/09						
0489	10/06/09	10/13/09						
0519	10/14/09	10/14/09						

CHILDREN'S HOSPITAL
CHOC OF ORANGE COUNTY
365 S. MAIN ST., 3RD FL.
ORANGE, CA 92668-3874
TOWER II
PLUMBING FLOOR PLAN - LEVEL UNDERGROUND AREA-K


PAN-PACIFIC
PLUMBING & MECHANICAL
Murray Company
2919 E. VICTORIA STREET, RANCHO DOMINGUEZ, CA 90221
PH. 310.637-1500 FAX 310.604-0359

DRAWN
R.O.
CHECKED
M.M.
DATE
2/3/2011
SCALE
1/4" = 1'-0"
JOB NO.
09-006
DRAWING NUMBER
PL3.0KU
REFERENCE DRAWING
A3.0K
P3.0K
1 OF 1 SHEETS

This document and the design it covers are the property of Murray Co. They are loaned only with the borrower's expressed written agreement that they will not be reproduced, copied, loaned, exhibited, or used in any other way, except by written consent from Murray Co. to the borrower.

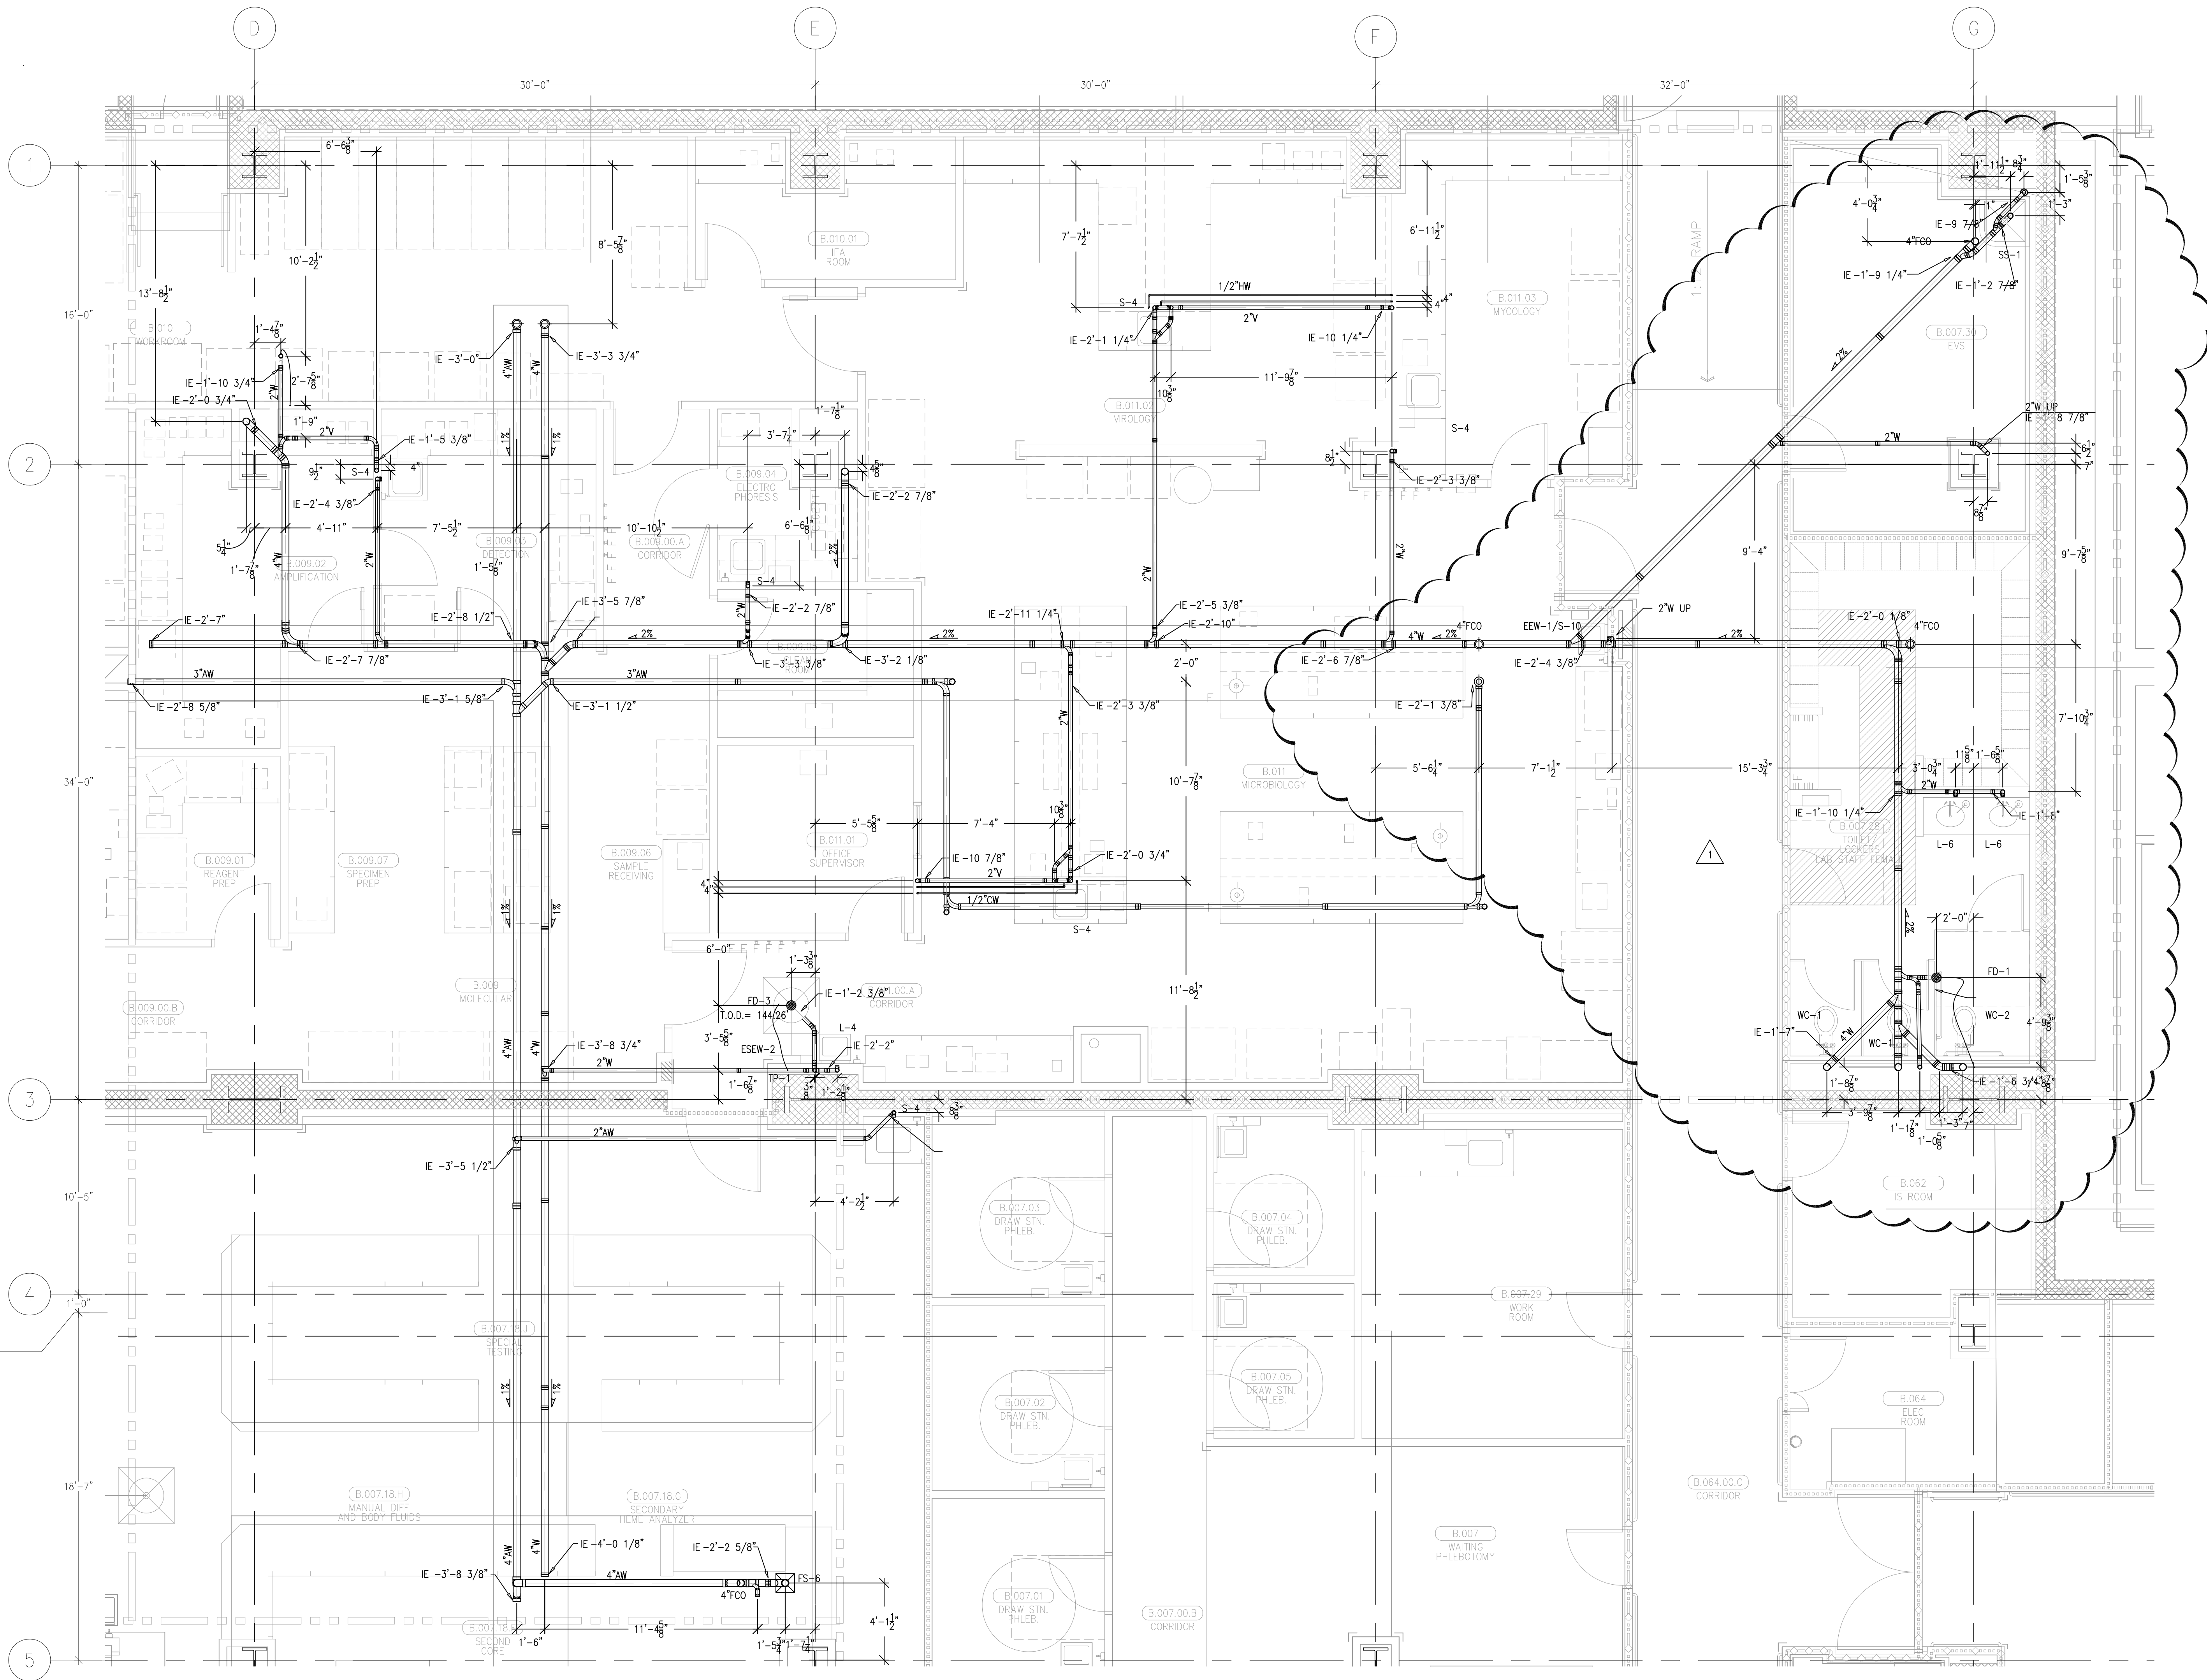

LEVEL 00 144.30' = 0'-0"
REFERENCE THIS SHEET

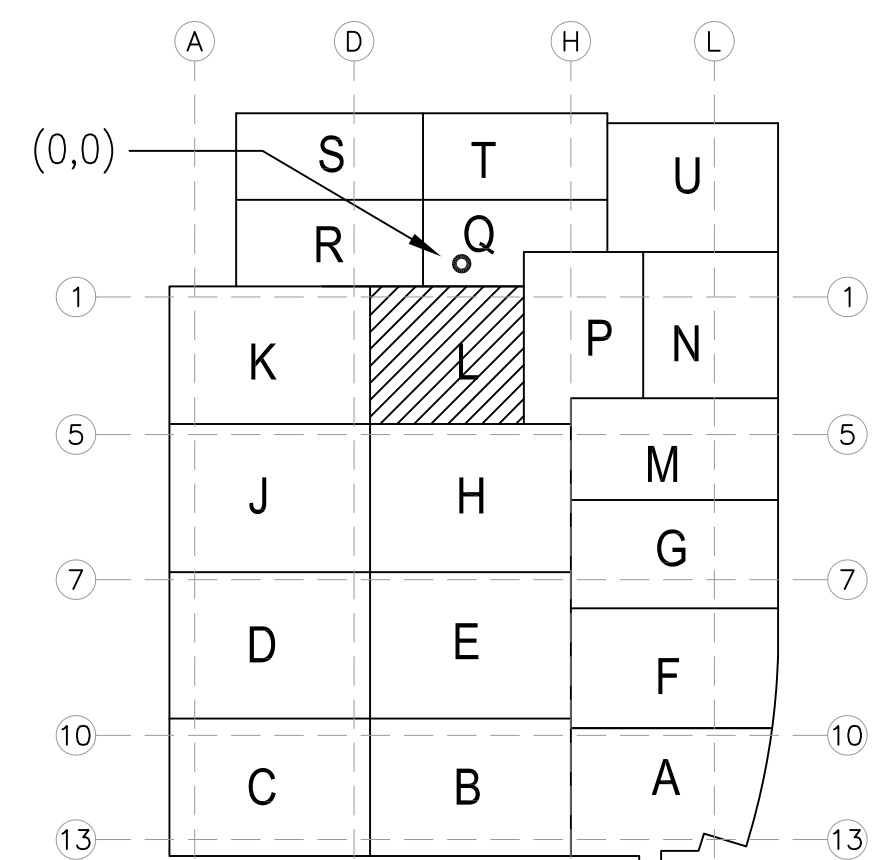

REVISIONS		BY
A	ISSUED FOR COORDINATION SIGN-OFF 6-30-09	DK
B	ISSUED FOR PUMP COORDINATION SIGN-OFF 10-20-09	JT
C	CORRECTED ELEVATIONS 3-1-10	DK
D	ISSUED FOR CONSTRUCTION 4-21-10	DK
E	RE-ELEVATED 5-10 ADDED 9-2-10	DK

COORD.	SIGNATURE	DATE
MECHANICAL		
ELECTRICAL		
PLUMBING		
STRUCTURAL		



R.F.I.	SENT	ANS.	R.F.I.	SENT	ANS.	R.F.I.	SENT	ANS.
02/01/11	09/09/09	09/25/09						

CHILDREN'S HOSPITAL CHOC OF ORANGE COUNTY
455 S. MAIN ST. STE. 200
ORANGE, CA 92668-3974
TOWER II
PLUMBING FLOOR PLAN - LEVEL UNDERGROUND AREA-L

PAN-PACIFIC
PLUMBING & MECHANICAL
Murray Company
2919 E. VICTORIA STREET, RANCHO DOMINGUEZ, CA 90221
PH. 310 637-1500 FAX 310 604-0359

DRAWN R.O.
CHECKED M.M.
DATE 2/3/2011
SCALE 1/4" = 1'-0"
JOB NO. 09-006
DRAWING NUMBER PL3.0LU
REFERENCE DRAWING A3.0L P3.0L
1 OF 1 SHEETS

This document and the design it covers are the property of Murray Co. They are loaned only with the borrower's expressed written agreement that they will not be reproduced, copied, loaned, exhibited, or used in any other way, except by written consent from Murray Co. to the borrower.

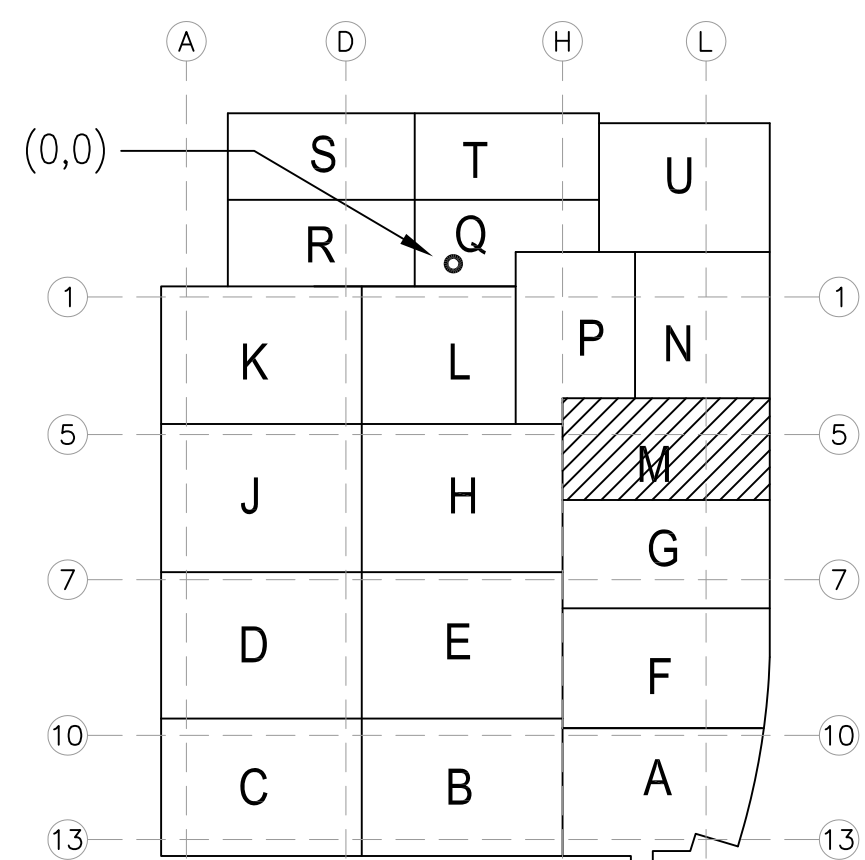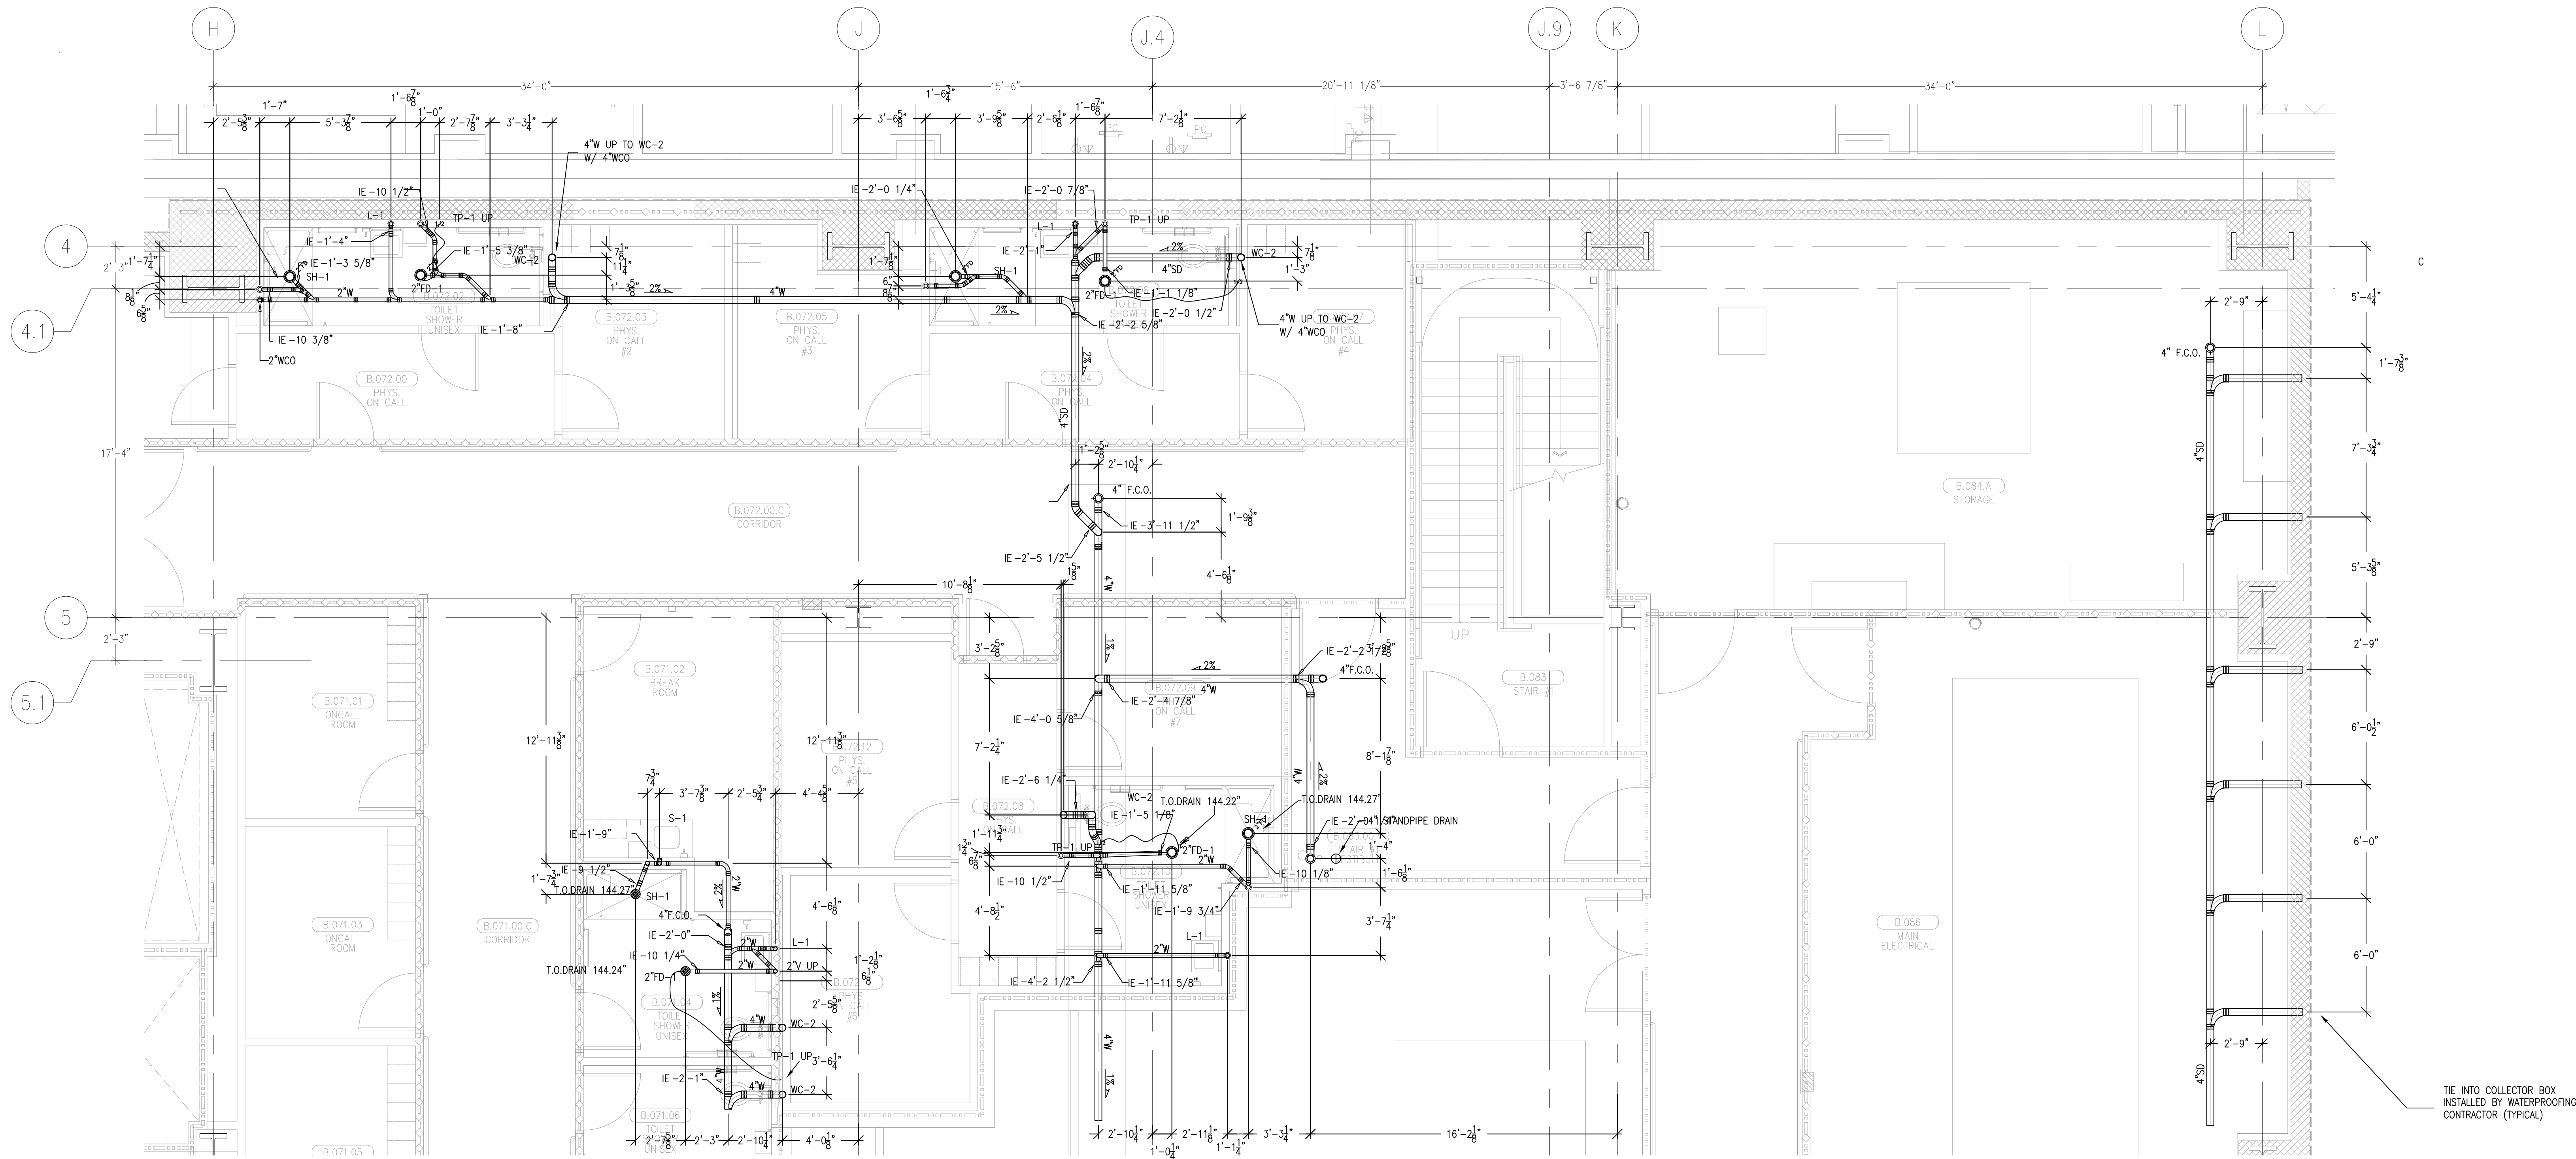

LEVEL 00 144.30' = 0'-0"
REFERENCE THIS SHEET

REVISIONS		BY
A	ISSUED FOR COORDINATION SIGN-OFF 6-30-09	DK
B	ISSUED FOR TEMP COORDINATION SIGN-OFF 10-28-09	MLV
C	REVISED STANDPIPE ROSEY LOCATION PER FP 11-18-09	REO
D	REVISED PER OSIPD PERMIT SET 3-2-10	DK
E	REVISED SHOWER/TO PIPING DUE TO ELEVATION ISSUES 3-18-10	DK
F	ISSUED FOR CONSTRUCTION 4-8-10	DK

COORD.	SIGNATURE	DATE
MECHANICAL		
ELECTRICAL		
PLUMBING		
STRUCTURAL		

R.F.I.	SENT	ANS.	R.F.I.	SENT	ANS.
0008	04/05/09	04/13/09			
0019	04/11/09	06/04/09			
0025	04/11/09	05/04/09			
0469	10/05/09	10/13/09			

**CHILDREN'S HOSPITAL
OF ORANGE COUNTY**
HOSPITAL
455 S. MAIN ST.
ORANGE, CA 92668-5874

TOWER II
PLUMBING FLOOR PLAN - LEVEL UNDERGROUND AREA-M


PAN-PACIFIC
PLUMBING & MECHANICAL

Murray Company
2919 E. VICTORIA STREET, RANCHO DOMINGUEZ, CA 90221
PH. 310.637-1500 FAX 310.604-0359


DRAWN
R.O.
CHECKED
M.M.
DATE
2/3/2011
SCALE
1/4" = 1'-0"
JOB NO.
09-006
DRAWING NUMBER
PL3.0MU
REFERENCE DRAWING
A3.0M
P3.0M
1 OF 1 SHEETS

Printed by: ead 2-03-2011 9:01am
Dwg: PL3.0M-09-006-MURRAY-DRAWING-PLUMBING-LEVEL-UNDERGROUND-PLUMBING

This document and the design it covers are the property of Murray Co. They are loaned only with the borrower's expressed written agreement that they will not be reproduced, copied, loaned, exhibited, or used in any other way, except by written consent from Murray Co. to the borrower.

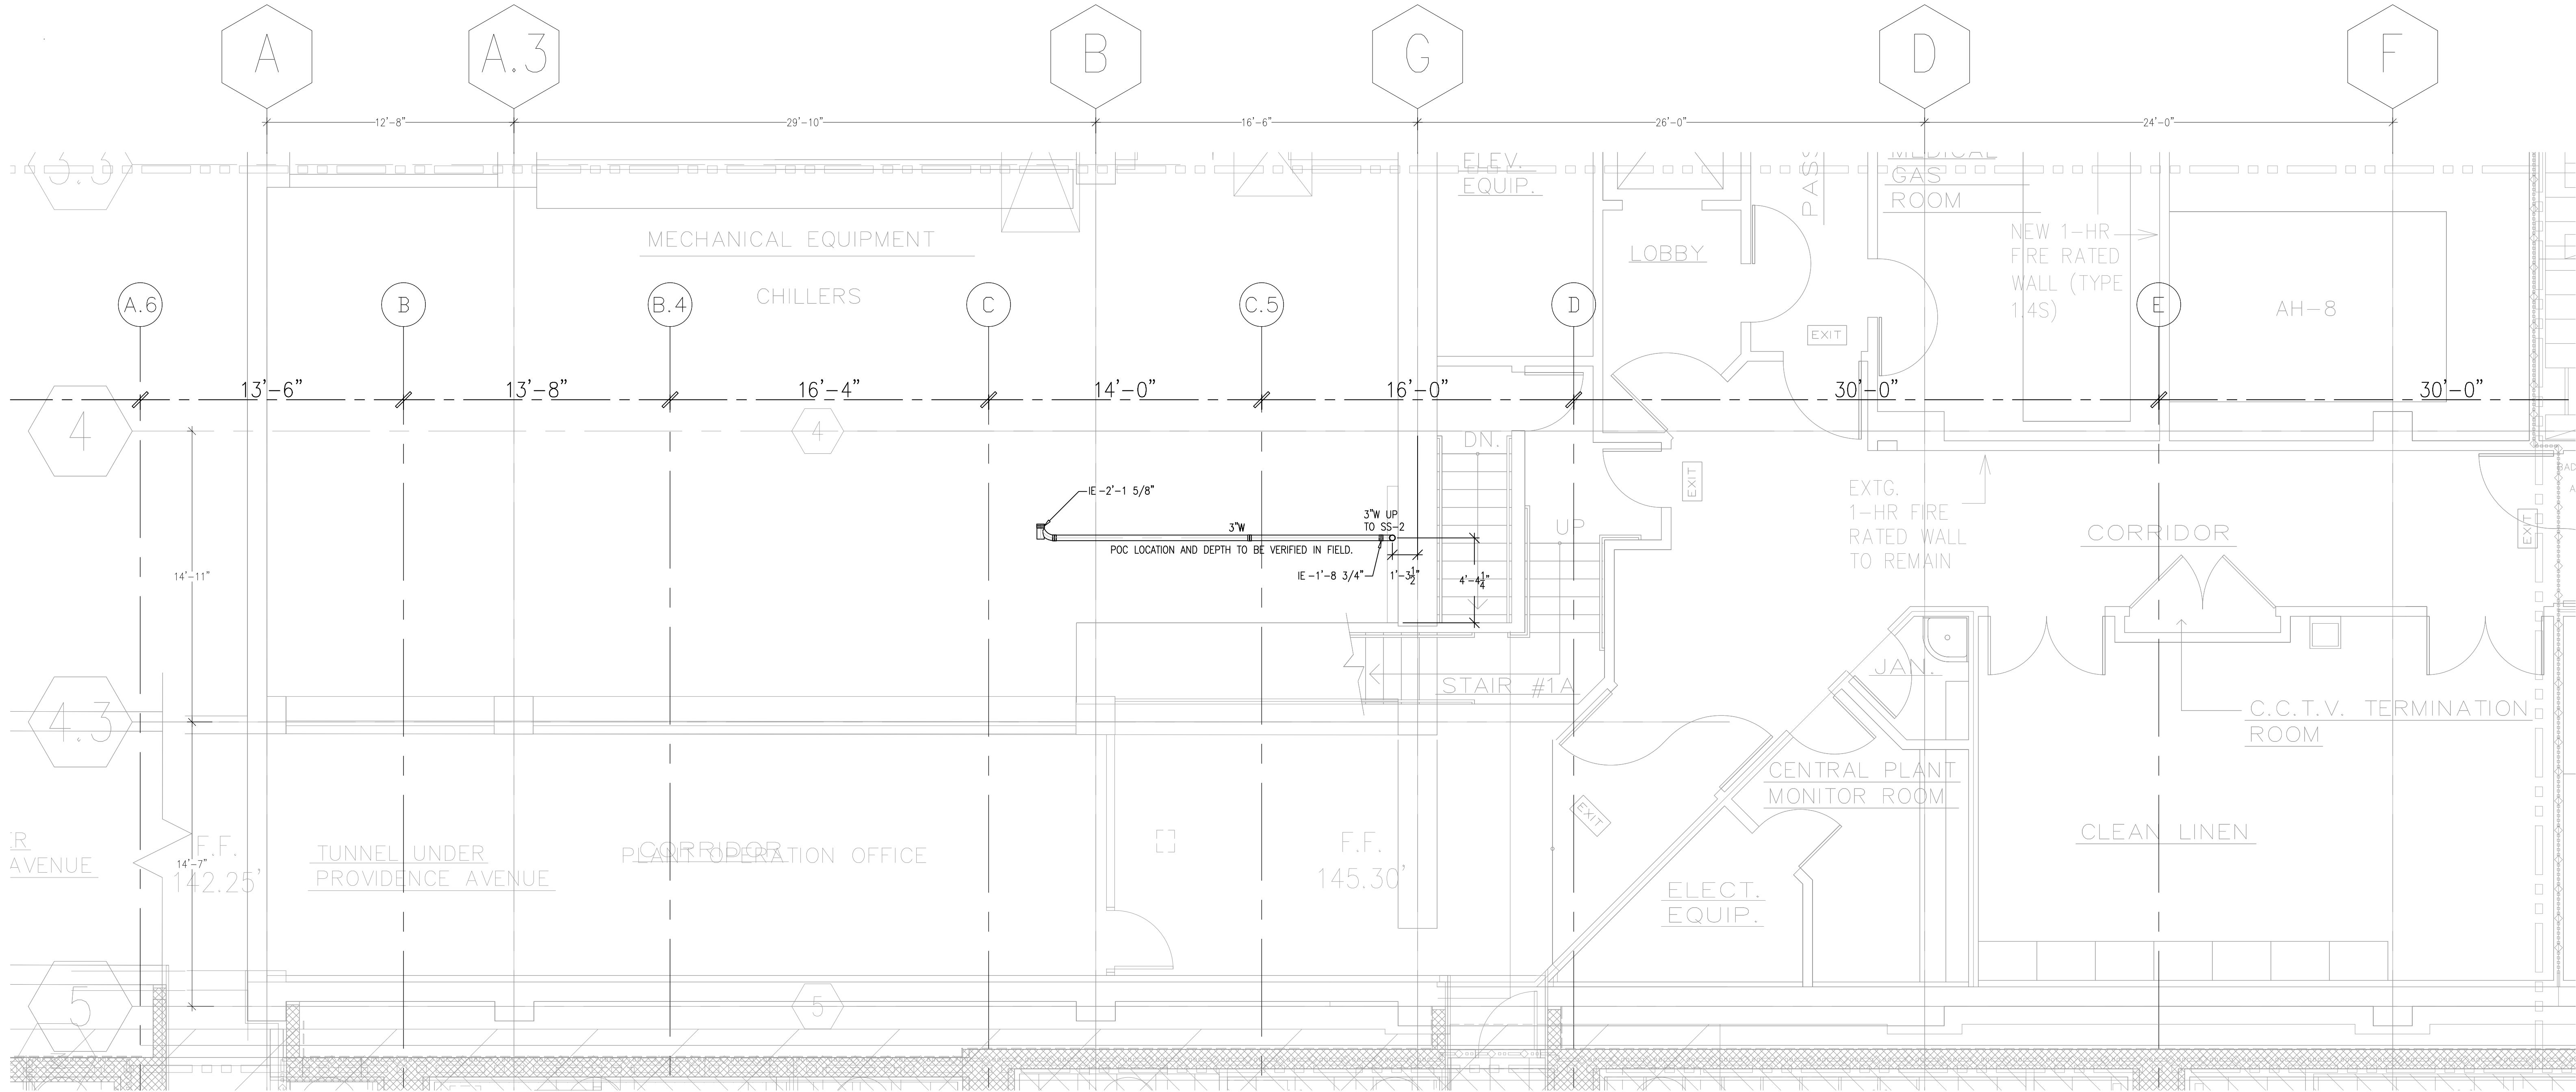

LEVEL 00 144.30' = 0'-0"
REFERENCE THIS SHEET

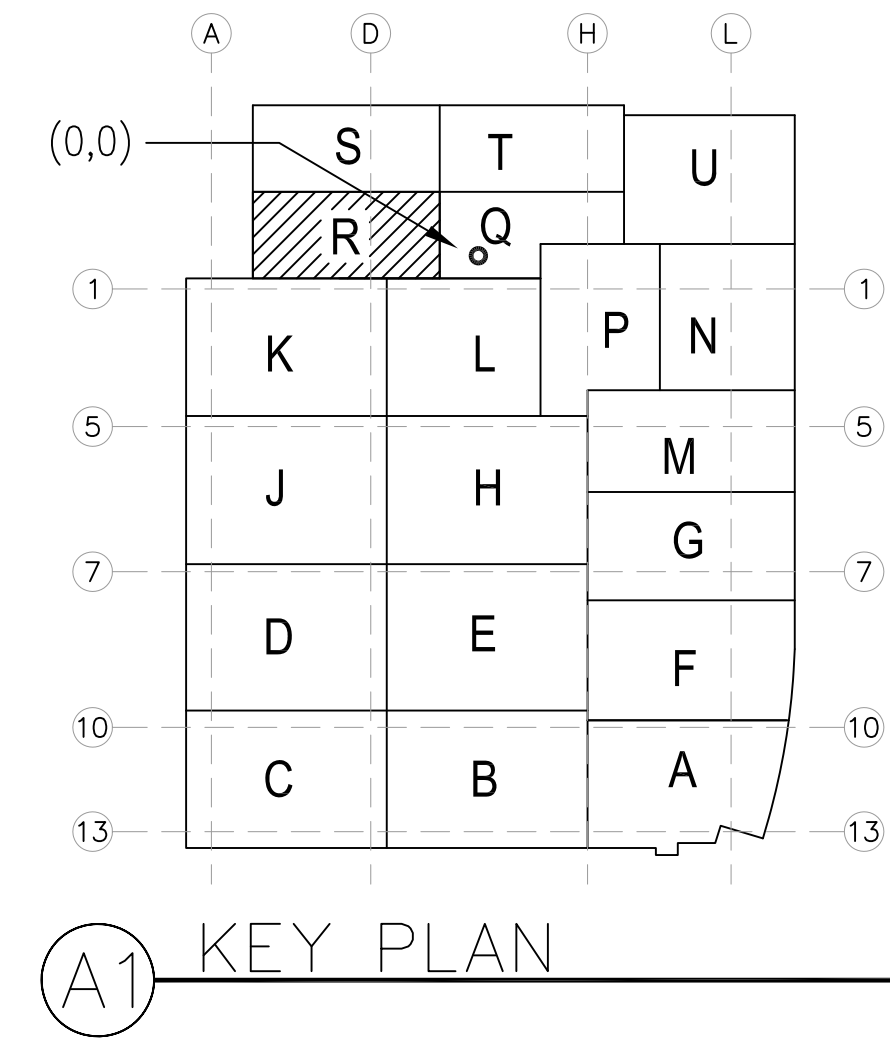

REVISIONS		BY
A	ISSUED FOR COORDINATION SIGN-OFF 6-30-09	DK
B	ISSUED FOR T&P SIGN-OFF 10-29-09	DK
0	ISSUED FOR CONSTRUCTION 4-21-10	DK

COORD.	SIGNATURE	DATE
MECHANICAL		
PLUMBING		
ELECTRICAL		
FIRE SPRINKLER		
PIPE		
DRYWALL/FRAME		
REFRIGERATION		
STRUCTURAL		

R.F.I.	SENT	ANS.	R.F.I.	SENT	ANS.
0168	02/02/09	02/14/09			
0281	02/07/09	02/23/09			
0534	10/20/09	11/03/09			

**CHILDREN'S HOSPITAL
OF ORANGE COUNTY**
455 S. MAIN ST.
ORANGE, CA 92668-9874

TOWER II

PLUMBING FLOOR PLAN - LEVEL UNDERGROUND AREA

PAN-PACIFIC
PLUMBING & MECHANICAL

Murray Company
2919 E. VICTORIA STREET, RANCHO DOMINGUEZ, CA 90221
PH. 310 637-1500 FAX 310 604-0359

DRAWN
R.O.

CHECKED
M.M.

DATE
2/3/2011

SCALE
1/4" = 1'-0"



JOB NO.
09-006

DRAWING NUMBER
PL3.0RU

REFERENCE DRAWING
A3.0R
P3.0R

1 OF 1 SHEETS

This document and the design it covers are the property of Murray Co. They are loaned only with the borrower's expressed written agreement that they will not be reproduced, copied, loaned, exhibited, or used in any other way, except by written consent from Murray Co. to the borrower.

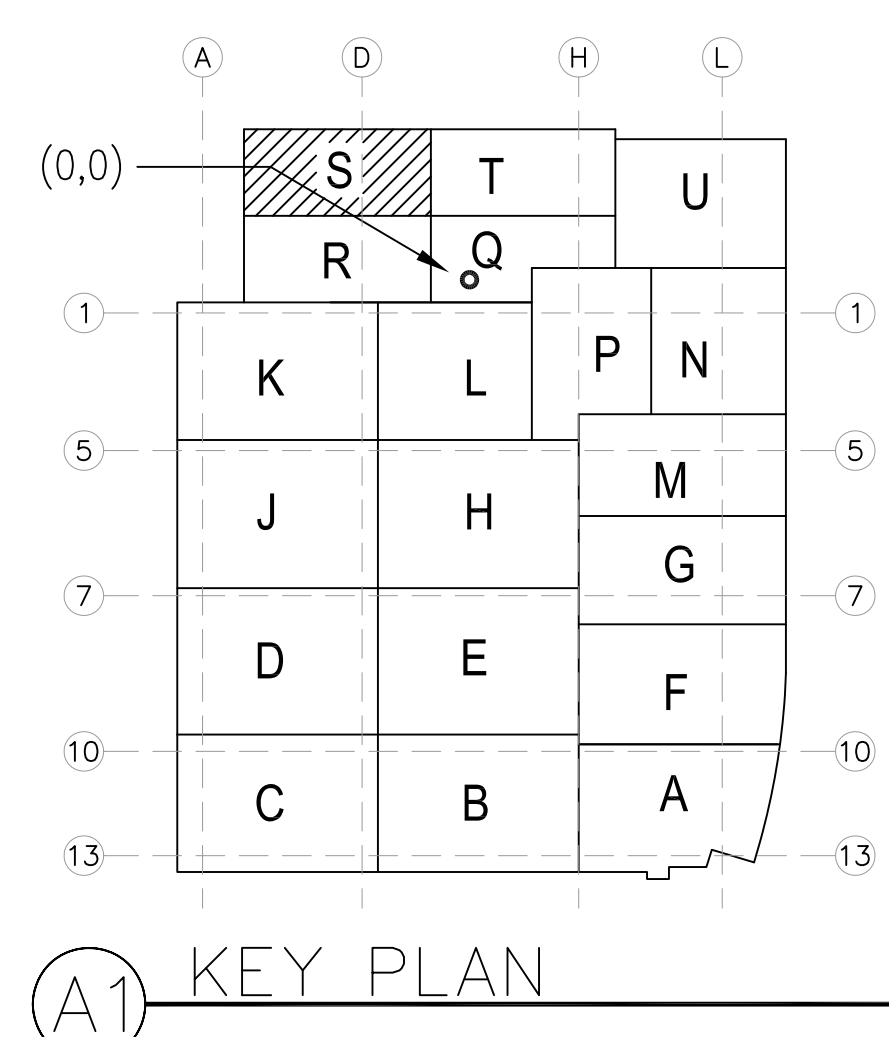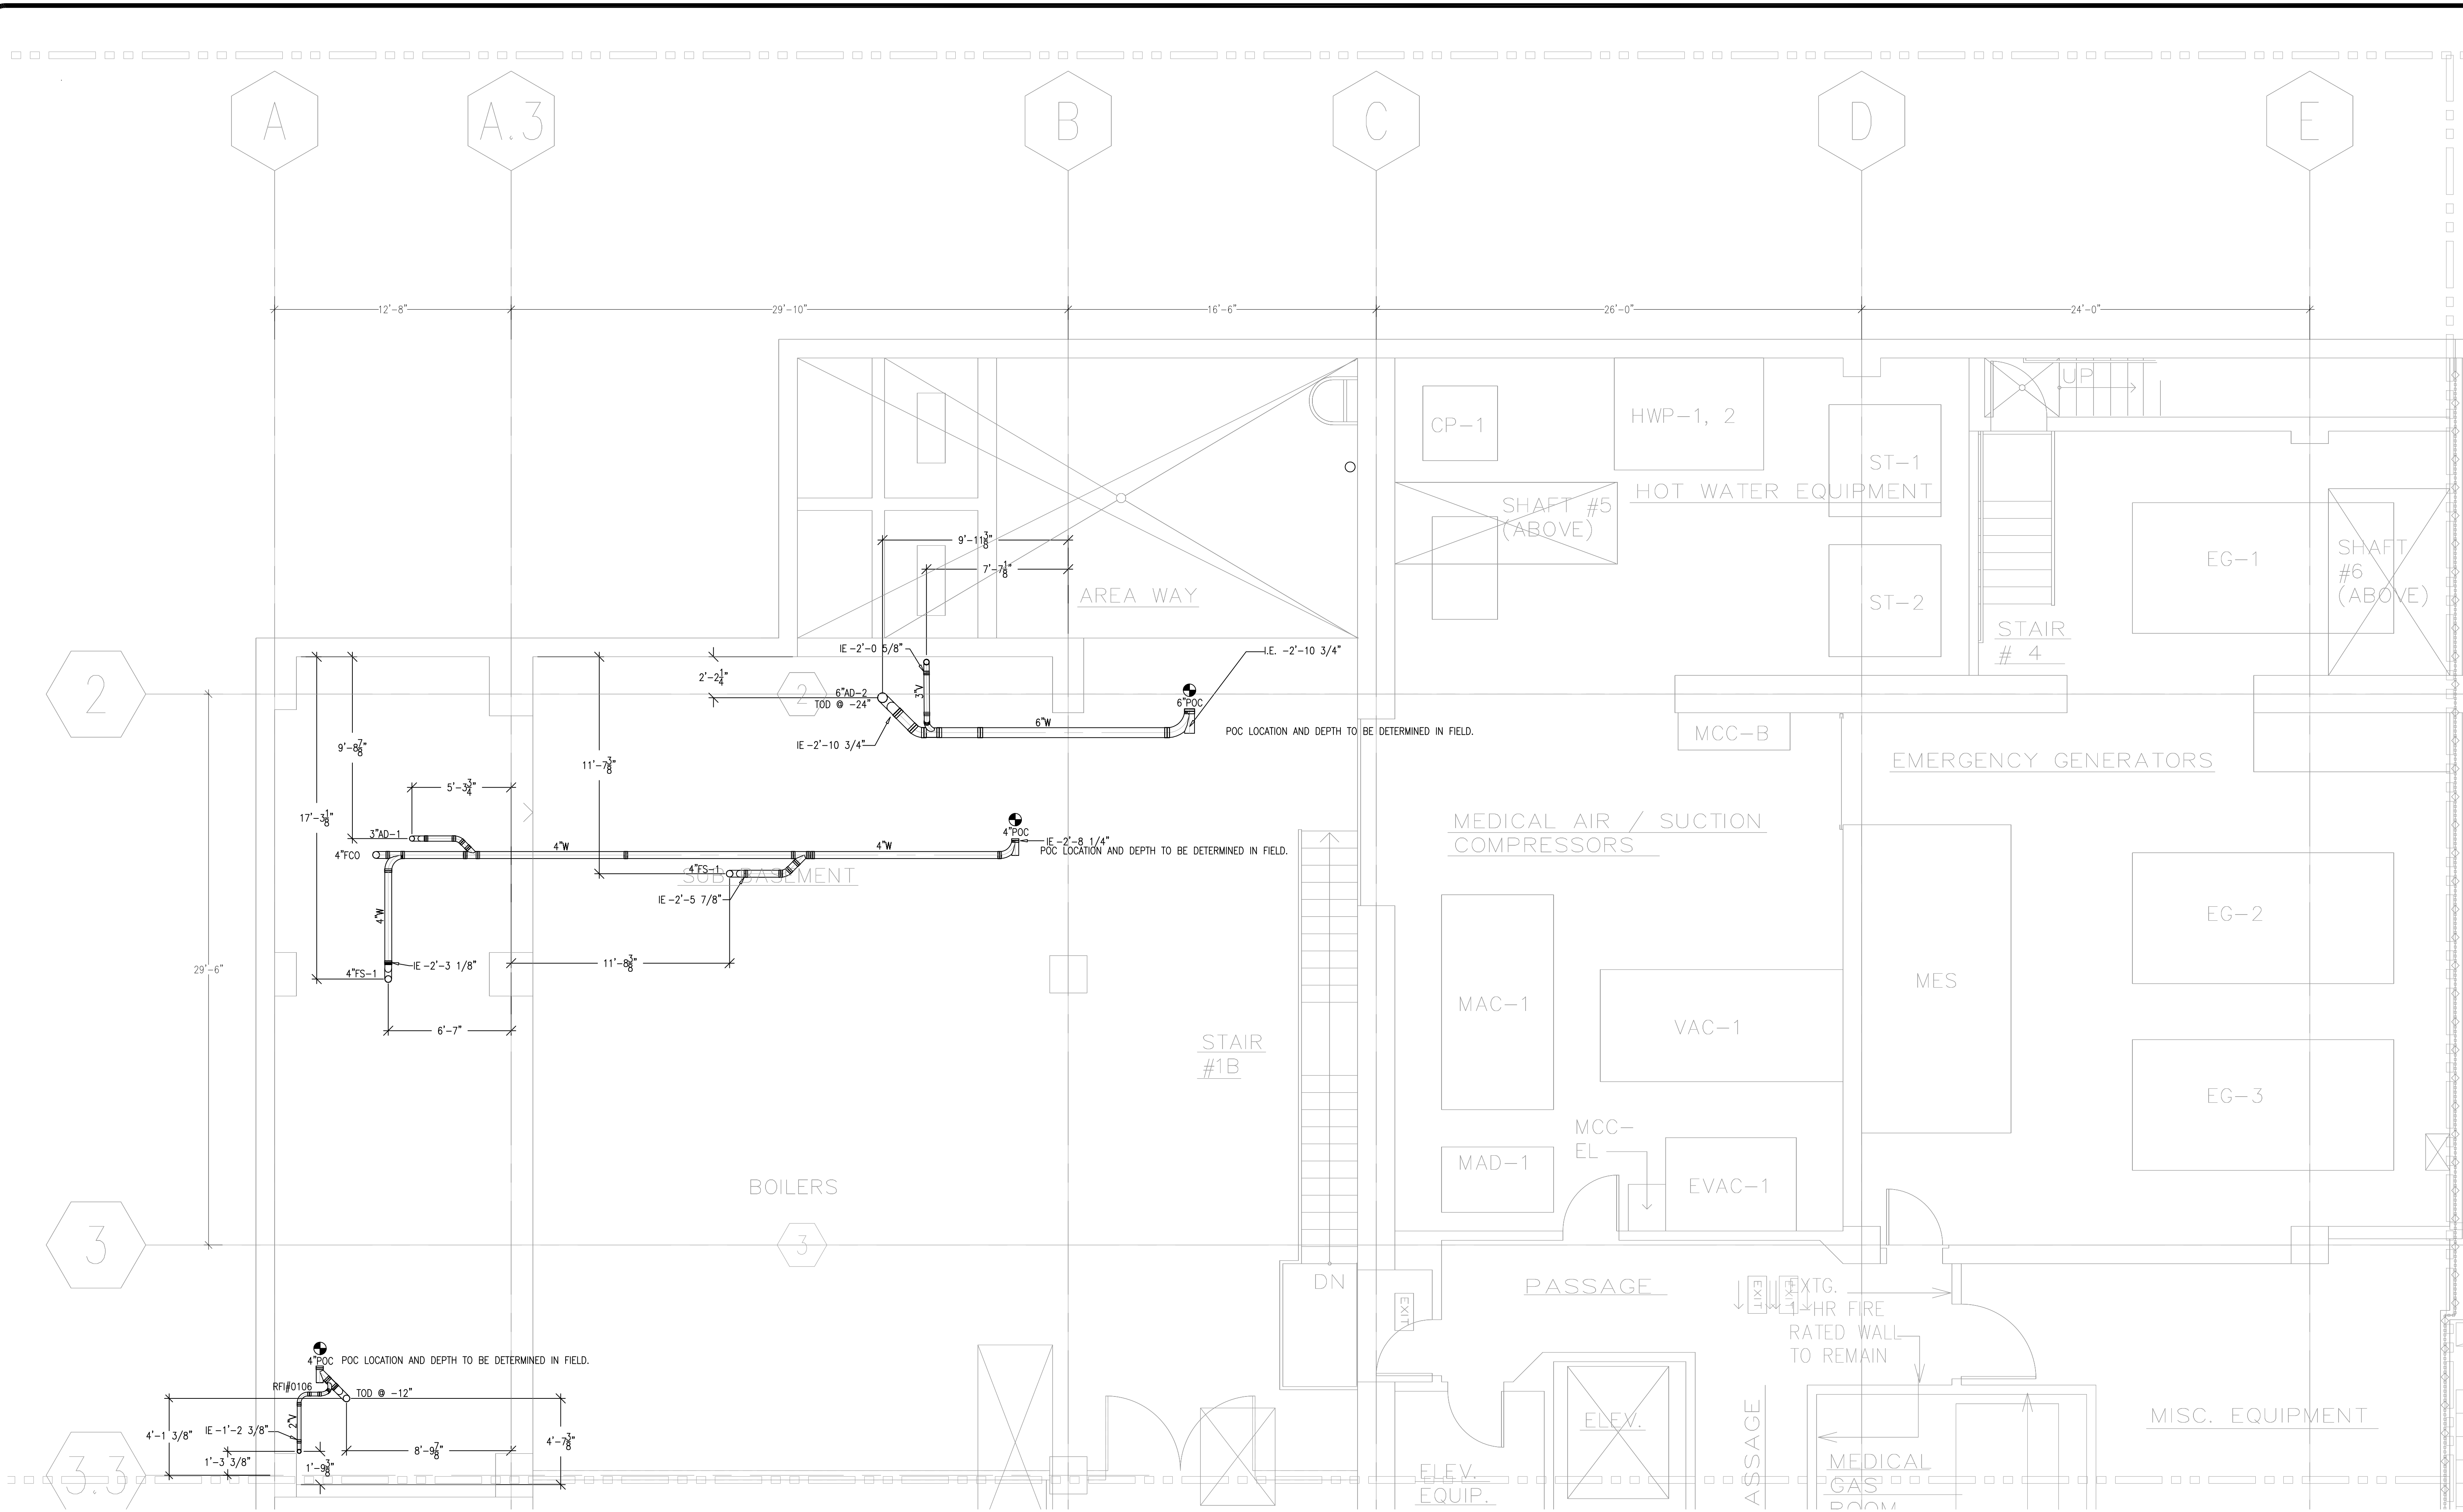

	REVISIONS	BY
A	ISSUED FOR COORDINATION SIGN-OFF 6-30-09	DK
B	ISSUED FOR FGMP SIGN-OFF 10-29-09	DK
0	ISSUED FOR CONSTRUCTION 4-21-10	DK

COORD.	SIGNATURE	DATE
MCARTHY		
MECHANICAL DUCT		
MECHANICAL PIPE		
PLUMBING		
ELECTRICAL		
FIRE SPRINKLER		
PIPE		
DRYWALL/FRAMER		
REFRIGERATION		
STRUCTURAL		

[illegible]

CHOCTM
HOSPITAL

CHILDREN'S HOSPITAL
OF ORANGE COUNTY

455 S. Main St.
Orange, CA 92668-3874

TOWER II

PLUMBING FLOOR PLAN - LEVEL UNDERGROUND AREAS

PAN-PACIFIC
PLUMBING & MECHANICAL

Murray
Company

2919 E. VICTORIA STREET, RANCHO DOMINGUEZ, CA 90221
PH. 310. 633-1500 FAX 310. 604-0359

DRAWN
R.O.
CHECKED
M.M.
DATE
2/3/2011
SCALE
1/4"=1'-0"
JOB NO.
09-006
DRAWING NUMBER
PL3.OSU
REFERENCE DRAWING
A3.OS
P3.OS
1 OF 1 SHEETS