

DRAWING PREPARED BY:
KRATOS
HBE

1511 E. ORANGETHORPE BLVD.
FULLERTON, CALIFORNIA 92831
714-525-4350 - o; 714-525-4386 - f
(c) Copyright 2012 KRATOS | HBE
All Rights Reserved.

MUST BE SIGNED BY HBE
TO AUTHENTICATE CONTENT(S).
ALL DETAILS CHECKED FOR ACCURACY.

SIGNATURE _____ DATE _____

HBE JOB # _____

DEVICE	DESCRIPTION	QTY.
CR	CARD READER	33
DC	DOOR CONTACT	39
REX	REQUEST TO EXIT DEVICE W/ DOOR LOCKS	33
EL	ELECTRIFIED LOCK	33
PB	PANIC BUTTON	1
IC	INTERCOMS	2
FC	FIXED IP DOME COLOR CAMERA	29
PTZ	PTZ IP DOME COLOR CAMERA	3
ACP	ACCESS CONTROL PANEL	3
CCTV	CCTV HEAD END LOCATIONS	2
PS	PENETRATION SLEEVES	6

ACCESS CONTROL W/
FIRE PROTECTION DOORS:

CARD READER #	DOOR #
CR-02	2.080
CR-09	2.024
CR-21	2.056b
CR-25	2.100.00

CONFIDENTIAL

THE INFORMATION CONTAINED HEREIN MAY
NOT BE USED OR REPRODUCED IN ANY
MANNER WITHOUT WRITTEN PERMISSION OF
KRATOS | HBE.

KEY PLAN

NO.	REV DESCRIPTION REV DATE	APPROVED BY
1.	AS BUILTS 08/15/2012	JOHN J. CHRISTIE

REV. DESCRIPTION APPROVED BY

CUSTOMER:

CHOC
Children's Hospital
of Orange County

PROJECT:

CHOC CHILDREN'S
HOSPITAL
455 SOUTH MAIN ST.
ORANGE, CA 92668

DRAWING TITLE:


SECOND LEVEL
SECURITY PLAN

DRN BY	DATE DRN	CHK BY	DATE CHK
JOSH G.	08/08/2012	JJC	

SCALE: NTS

DWG NO. SE3.02

ASBUILTS
08/15/2012

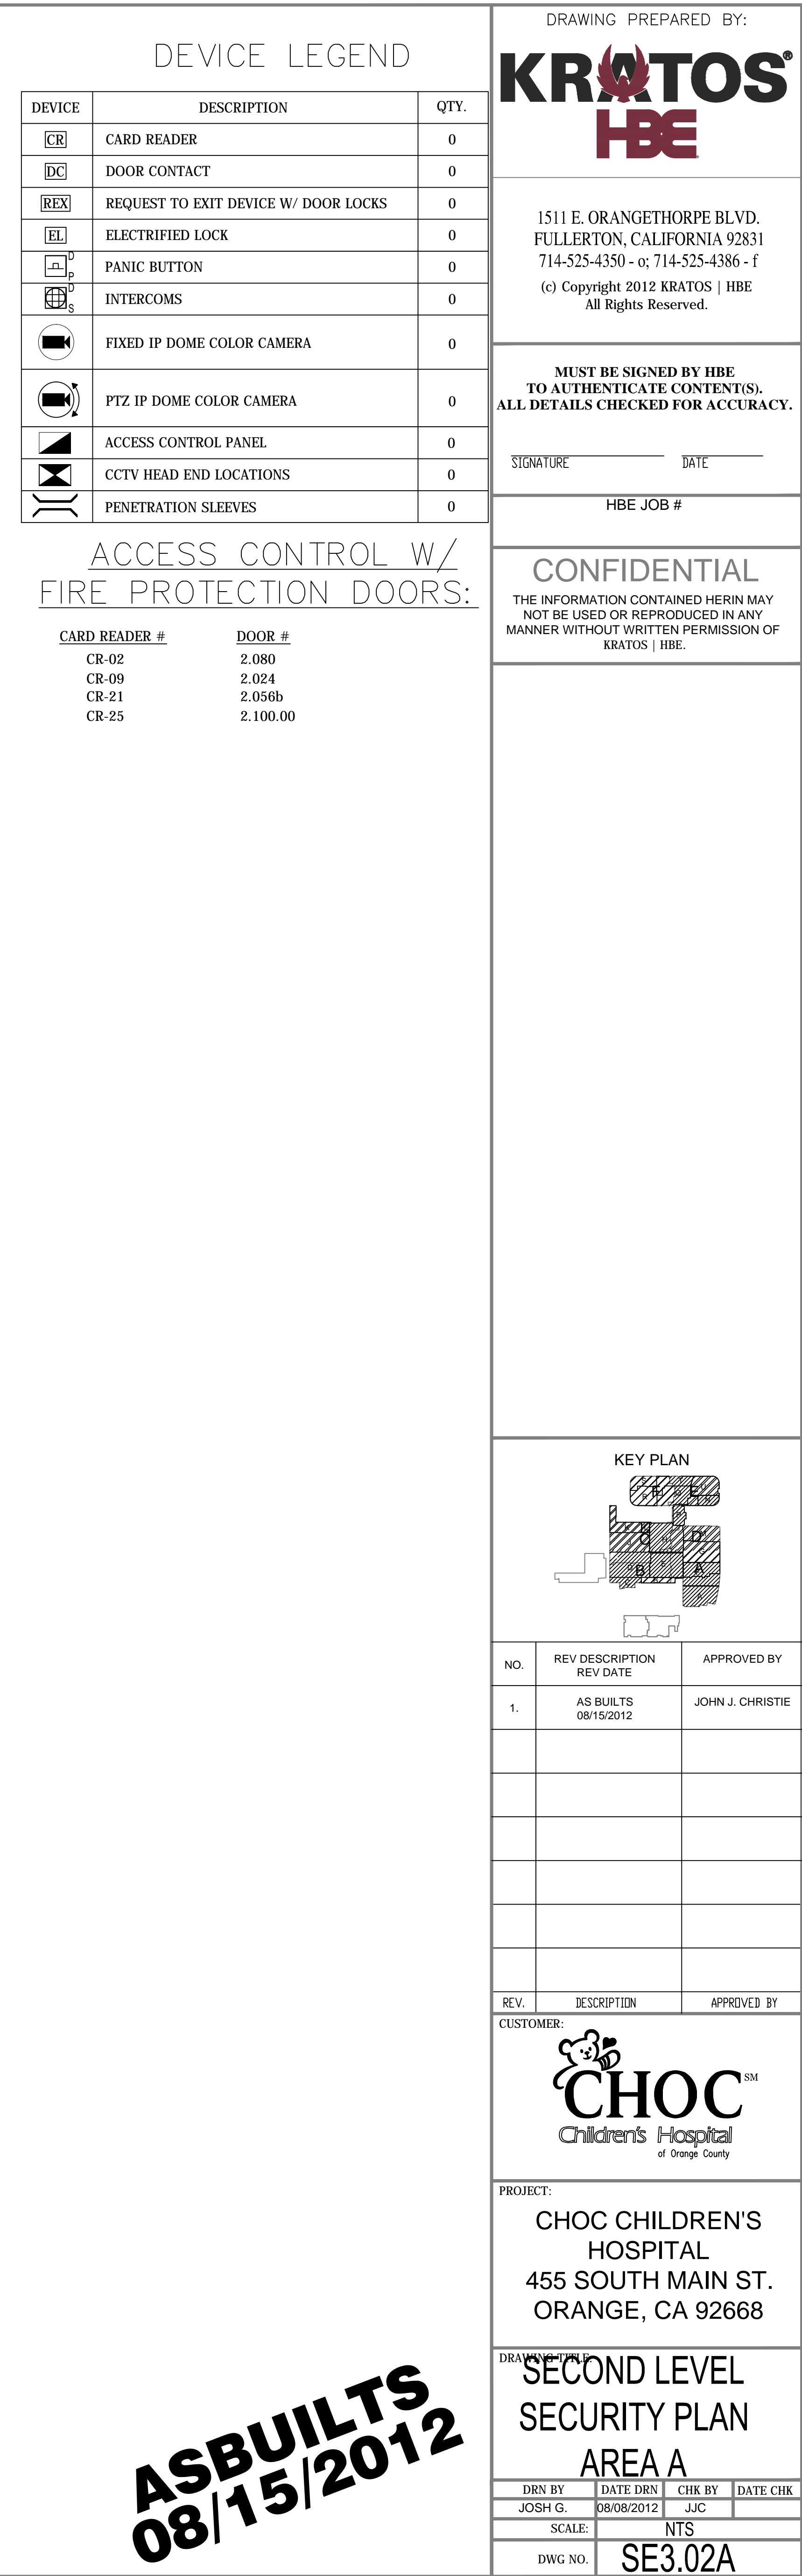

ASBUILTS
08/15/2012

DRAWING PREPARED BY:




1511 E. ORANGETHORPE BLVD.
FULLERTON, CALIFORNIA 92831
714-525-4350 - o; 714-525-4386 - f
(c) Copyright 2012 KRATOS | HBE
All Rights Reserved.

**MUST BE SIGNED BY HBE
TO AUTHENTICATE CONTENT(S).
ALL DETAILS CHECKED FOR ACCURACY.**

SIGNATURE _____ DATE _____

HBE JOB # _____

CONFIDENTIAL
THE INFORMATION CONTAINED HERIN MAY
NOT BE USED OR REPRODUCED IN ANY
MANNER WITHOUT WRITTEN PERMISSION OF
KRATOS | HBE.

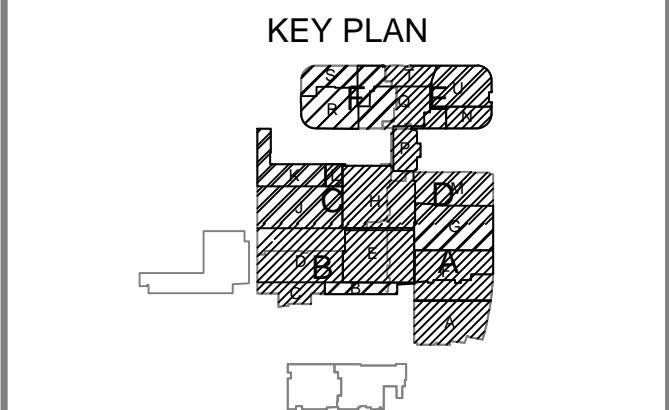

NO.	REV DESCRIPTION REV DATE	APPROVED BY
1.	AS BUILTS 08/15/2012	JOHN J. CHRISTIE

REV.	DESCRIPTION	APPROVED BY
------	-------------	-------------



PROJECT:
CHOC CHILDREN'S
HOSPITAL
455 SOUTH MAIN ST.
ORANGE, CA 92668

DRAWN BY: JOSH G.
**SECOND LEVEL
SECURITY PLAN
AREA D**

DRN BY	DATE DRN	CHK BY	DATE CHK
JOSH G.	08/08/2012	JJC	
SCALE:	NTS		
DWG NO.	SE3.02D		

DEVICE LEGEND


DEVICE	DESCRIPTION	QTY.
CR	CARD READER	8
DC	DOOR CONTACT	12
REX	REQUEST TO EXIT DEVICE W/ DOOR LOCKS	8
EL	ELECTRIFIED LOCK	8
PB	PANIC BUTTON	0
IC	INTERCOMS	0
FC	FIXED IP DOME COLOR CAMERA	5
PTZ	PTZ IP DOME COLOR CAMERA	0
ACP	ACCESS CONTROL PANEL	0
CCTV	CCTV HEAD END LOCATIONS	0
PS	PENETRATION SLEEVES	0

SECURITY DEVICE NOTES:


- 1) CARD READERS #29& #33 ARE NOT INCLUDED
IN DEVICE LEGEND ON THIS SHEET.
- 2) CAMERA #24 IS NOT INCLUDED
IN DEVICE LEGEND ON THIS SHEET.

ACCESS CONTROL W/ FIRE PROTECTION DOORS:

CARD READER #	DOOR #
CR-02	2.080
CR-09	2.024
CR-21	2.056b
CR-25	2.100.00

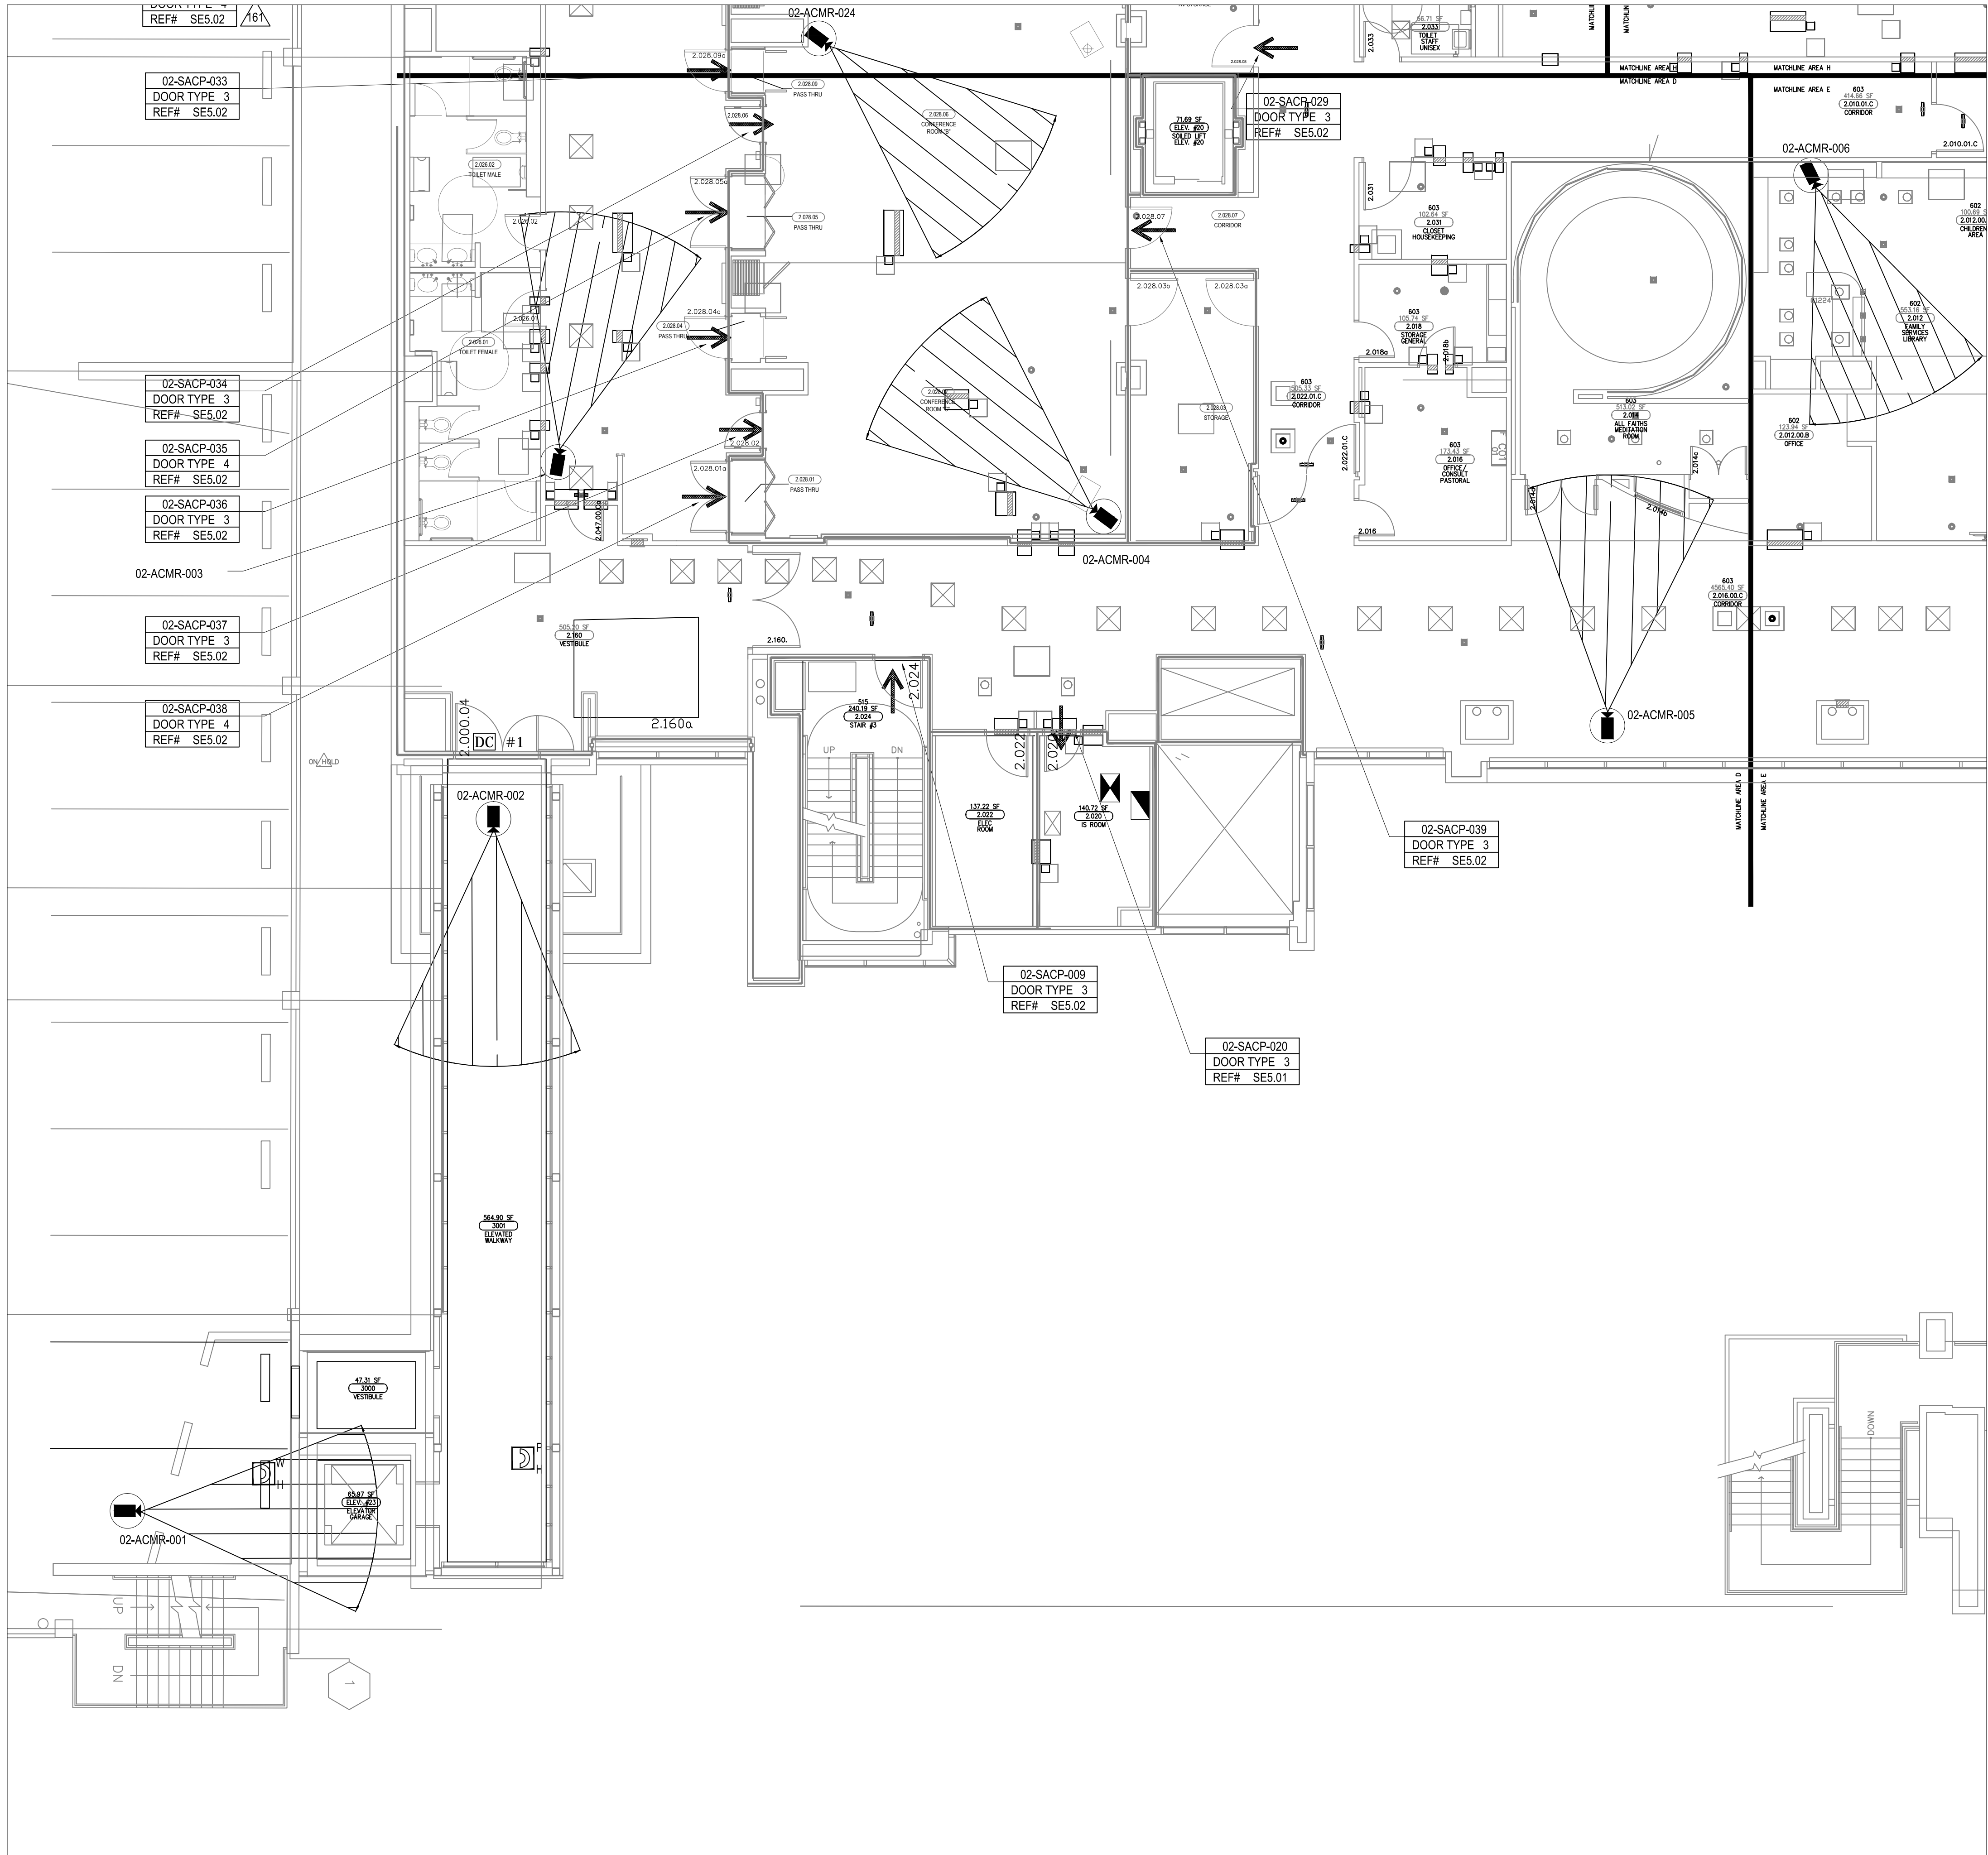

**ASBUILTS
08/15/2012**

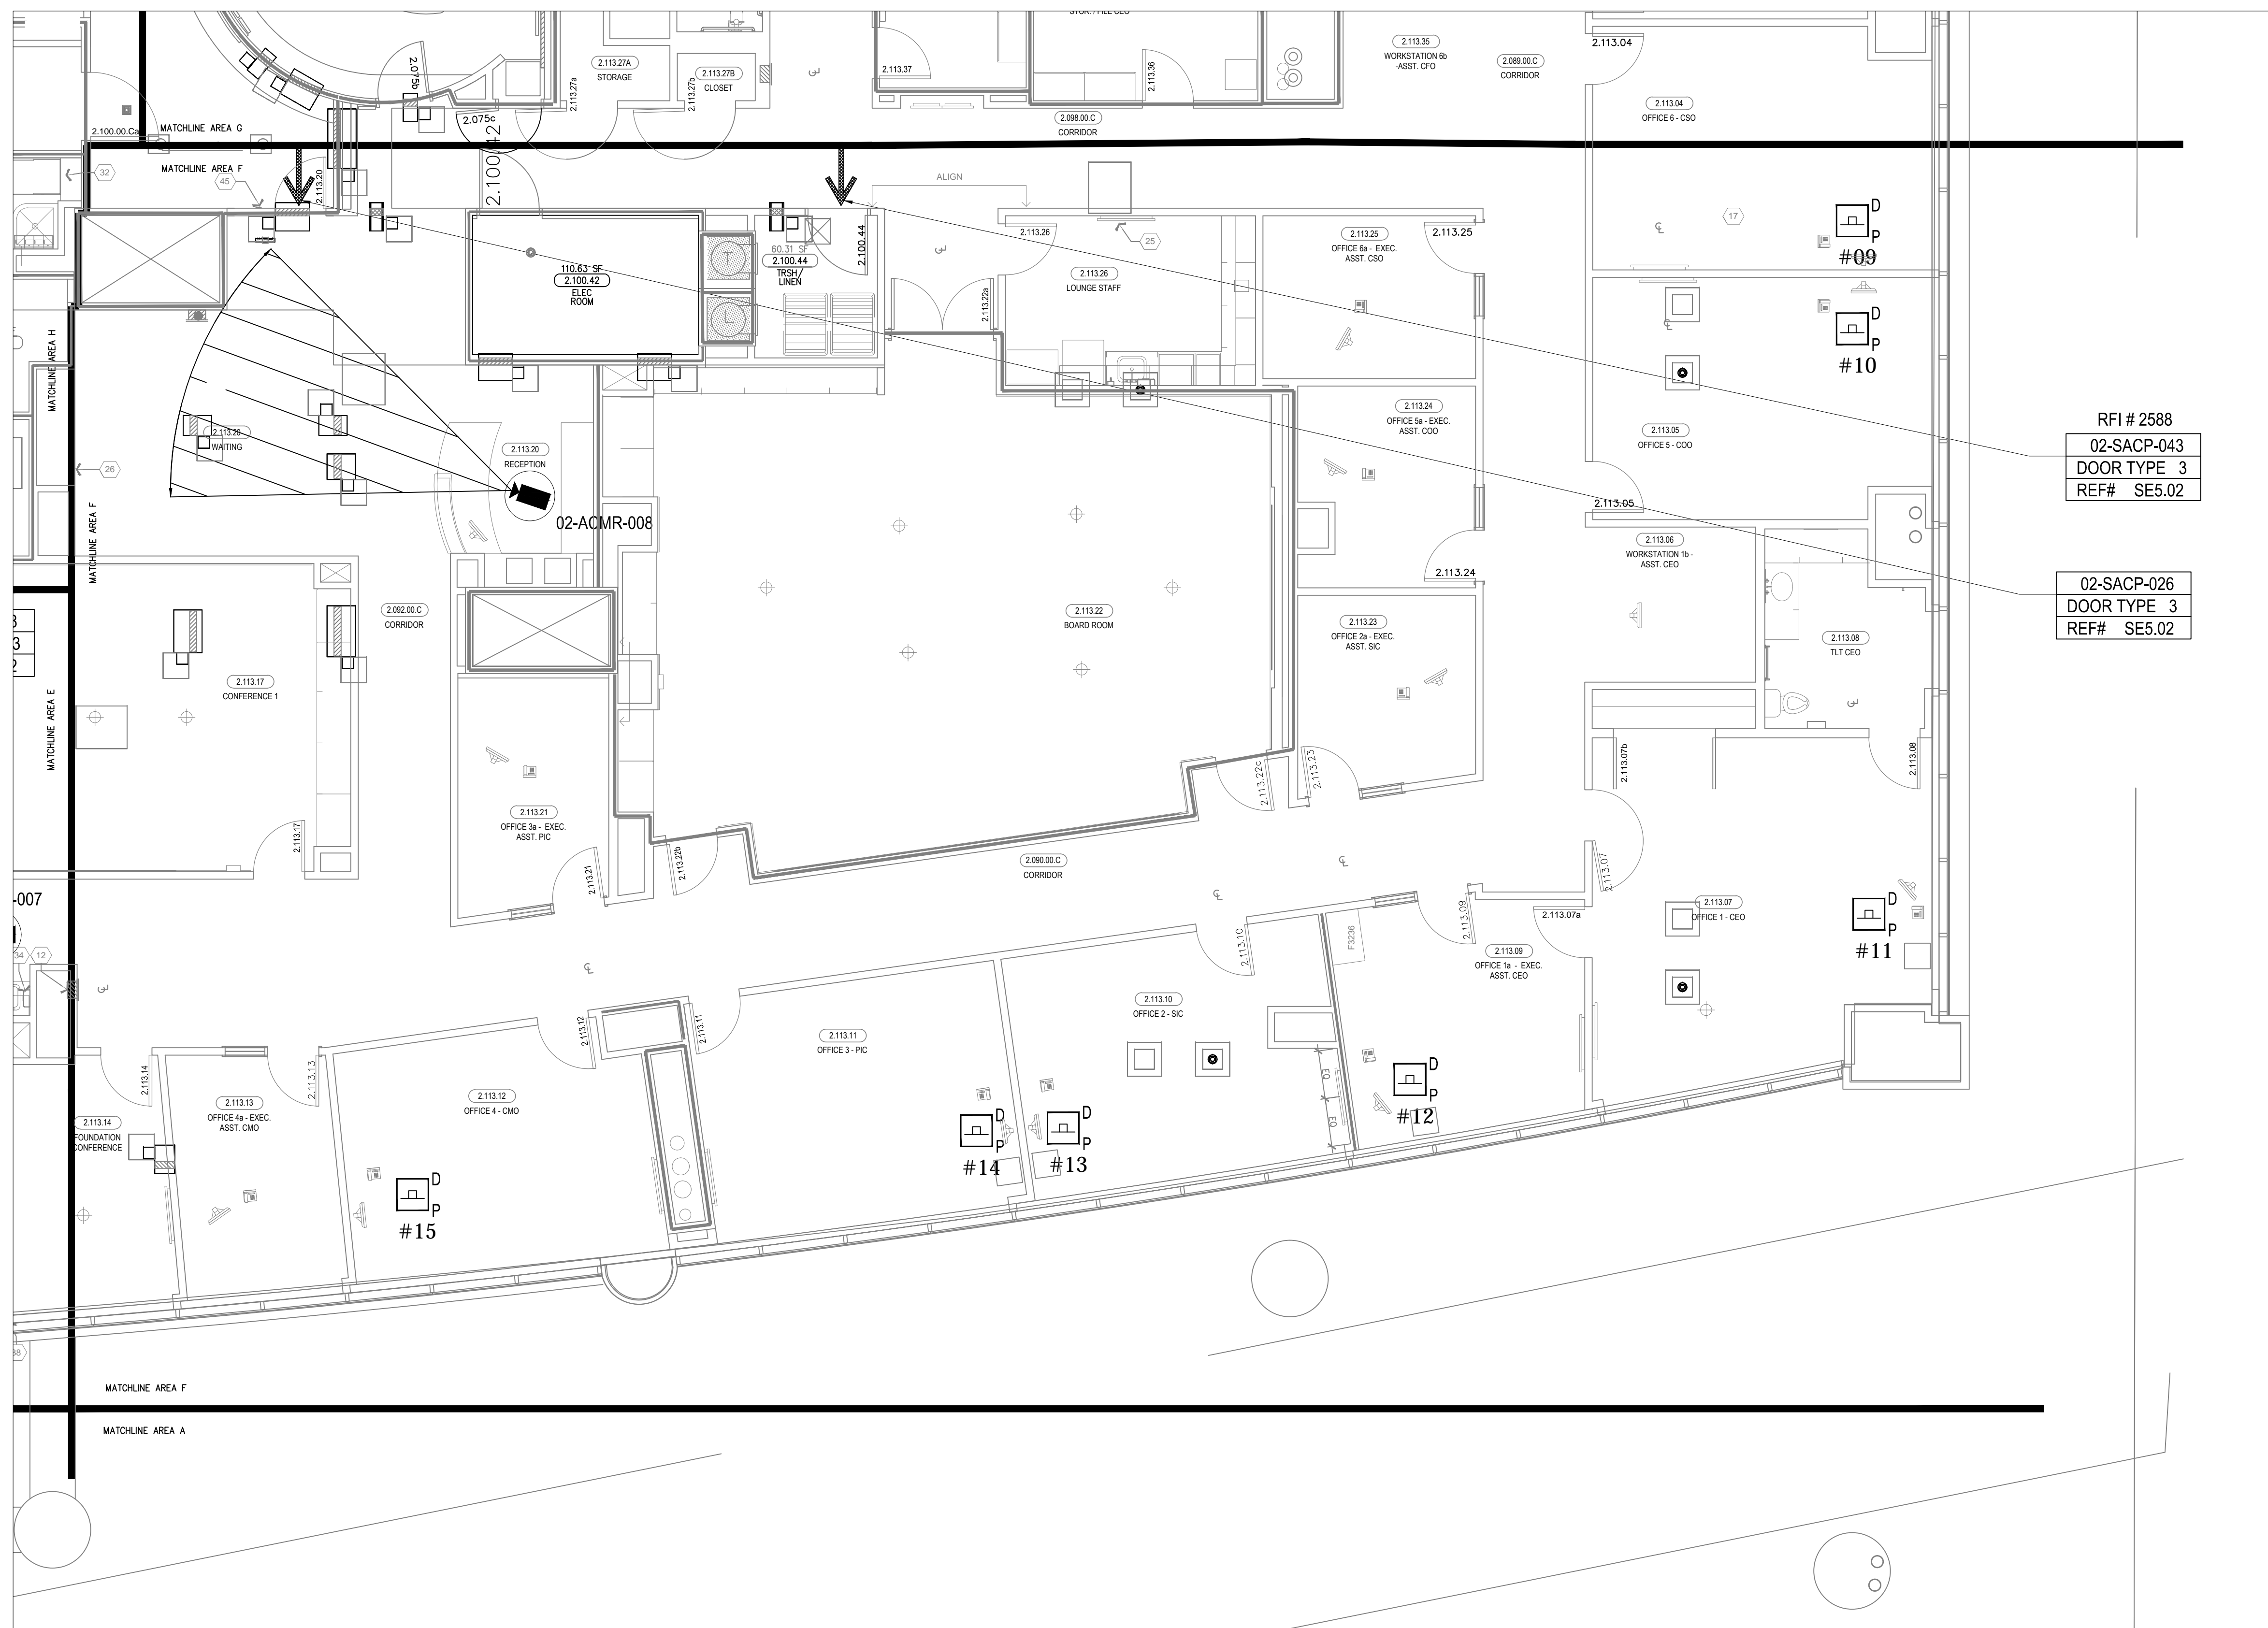

DEVICE LEGEND

DEVICE	DESCRIPTION	QTY.
CR	CARD READER	2
DC	DOOR CONTACT	2
REX	REQUEST TO EXIT DEVICE W/ DOOR LOCKS	2
EL	ELECTRIFIED LOCK	2
P	PANIC BUTTON	7
I	INTERCOMS	0
CC	FIXED IP DOME COLOR CAMERA	1
PTZ	PTZ IP DOME COLOR CAMERA	0
ACP	ACCESS CONTROL PANEL	0
CCTV	CCTV HEAD END LOCATIONS	0
PS	PENETRATION SLEEVES	0

ACCESS CONTROL W/
FIRE PROTECTION DOORS:

CARD READER #	DOOR #
CR-02	2.080
CR-09	2.024
CR-21	2.056b
CR-25	2.100.00

DRAWING PREPARED BY:



1511 E. ORANGETHORPE BLVD.
FULLERTON, CALIFORNIA 92831
714-525-4350 - o; 714-525-4386 - f
(c) Copyright 2012 KRATOS | HBE
All Rights Reserved.


MUST BE SIGNED BY HBE
TO AUTHENTICATE CONTENT(S).
ALL DETAILS CHECKED FOR ACCURACY.

SIGNATURE _____ DATE _____

HBE JOB #

CONFIDENTIAL
THE INFORMATION CONTAINED HEREIN MAY
NOT BE USED OR REPRODUCED IN ANY
MANNER WITHOUT WRITTEN PERMISSION OF
KRATOS | HBE.

KEY PLAN

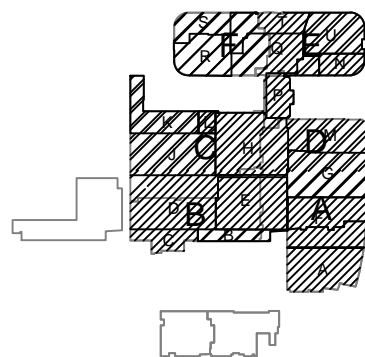

NO.	REV DESCRIPTION REV DATE	APPROVED BY
1.	AS BUILTS 08/15/2012	JOHN J. CHRISTIE

REV. DESCRIPTION APPROVED BY

CUSTOMER:



PROJECT:
CHOC CHILDREN'S
HOSPITAL
455 SOUTH MAIN ST.
ORANGE, CA 92668

SECOND LEVEL
SECURITY PLAN
AREA F

DRN BY	DATE DRN	CHK BY	DATE CHK
JOSH G.	08/08/2012	JJC	
SCALE:	NTS		
DWG NO.	SE3.02F		

ASBUILTS
08/15/2012



1511 E. ORANGETHORPE BLVD.
FULLERTON, CALIFORNIA 92831
714-525-4350 - o; 714-525-4386 - f
(c) Copyright 2012 KRATOS | HBE
All Rights Reserved.


MUST BE SIGNED BY HBE
TO AUTHENTICATE CONTENT(S).
ALL DETAILS CHECKED FOR ACCURACY.

SIGNATURE: DATE:

HBE JOB #

CONFIDENTIAL
THE INFORMATION CONTAINED HEREIN MAY
NOT BE USED OR REPRODUCED IN ANY
MANNER WITHOUT WRITTEN PERMISSION OF
KRATOS | HBE.

KEY PLAN

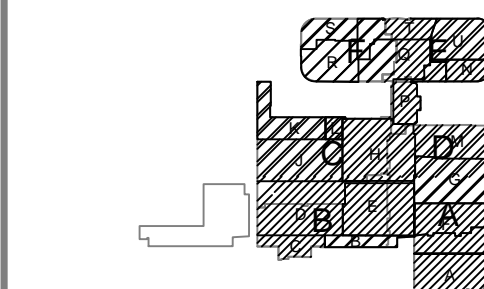

NO.	REV DESCRIPTION REV DATE	APPROVED BY
1.	AS BUILTS 08/15/2012	JOHN J. CHRISTIE

REV.	DESCRIPTION	APPROVED BY
------	-------------	-------------



PROJECT:
CHOC CHILDREN'S
HOSPITAL
455 SOUTH MAIN ST.
ORANGE, CA 92668

SECOND LEVEL
SECURITY PLAN
AREA G


DRN BY JOSH G.	DATE DRN 08/08/2012	CHK BY JJC	DATE CHK
SCALE:	NTS		
DWG NO.	SE3.02G		

DEVICE LEGEND

DEVICE	DESCRIPTION	QTY.
CR	CARD READER	9
DC	DOOR CONTACT	12
REX	REQUEST TO EXIT DEVICE W/ DOOR LOCKS	9
EL	ELECTRIFIED LOCK	9
PB	PANIC BUTTON	2
IC	INTERCOMS	0
FC	FIXED IP DOME COLOR CAMERA	6
PTZ	PTZ IP DOME COLOR CAMERA	0
ACP	ACCESS CONTROL PANEL	0
CCTV	CCTV HEAD END LOCATIONS	0
PS	PENETRATION SLEEVES	0

 

 
 
 
 

 



ACCESS CONTROL W/ FIRE PROTECTION DOORS:

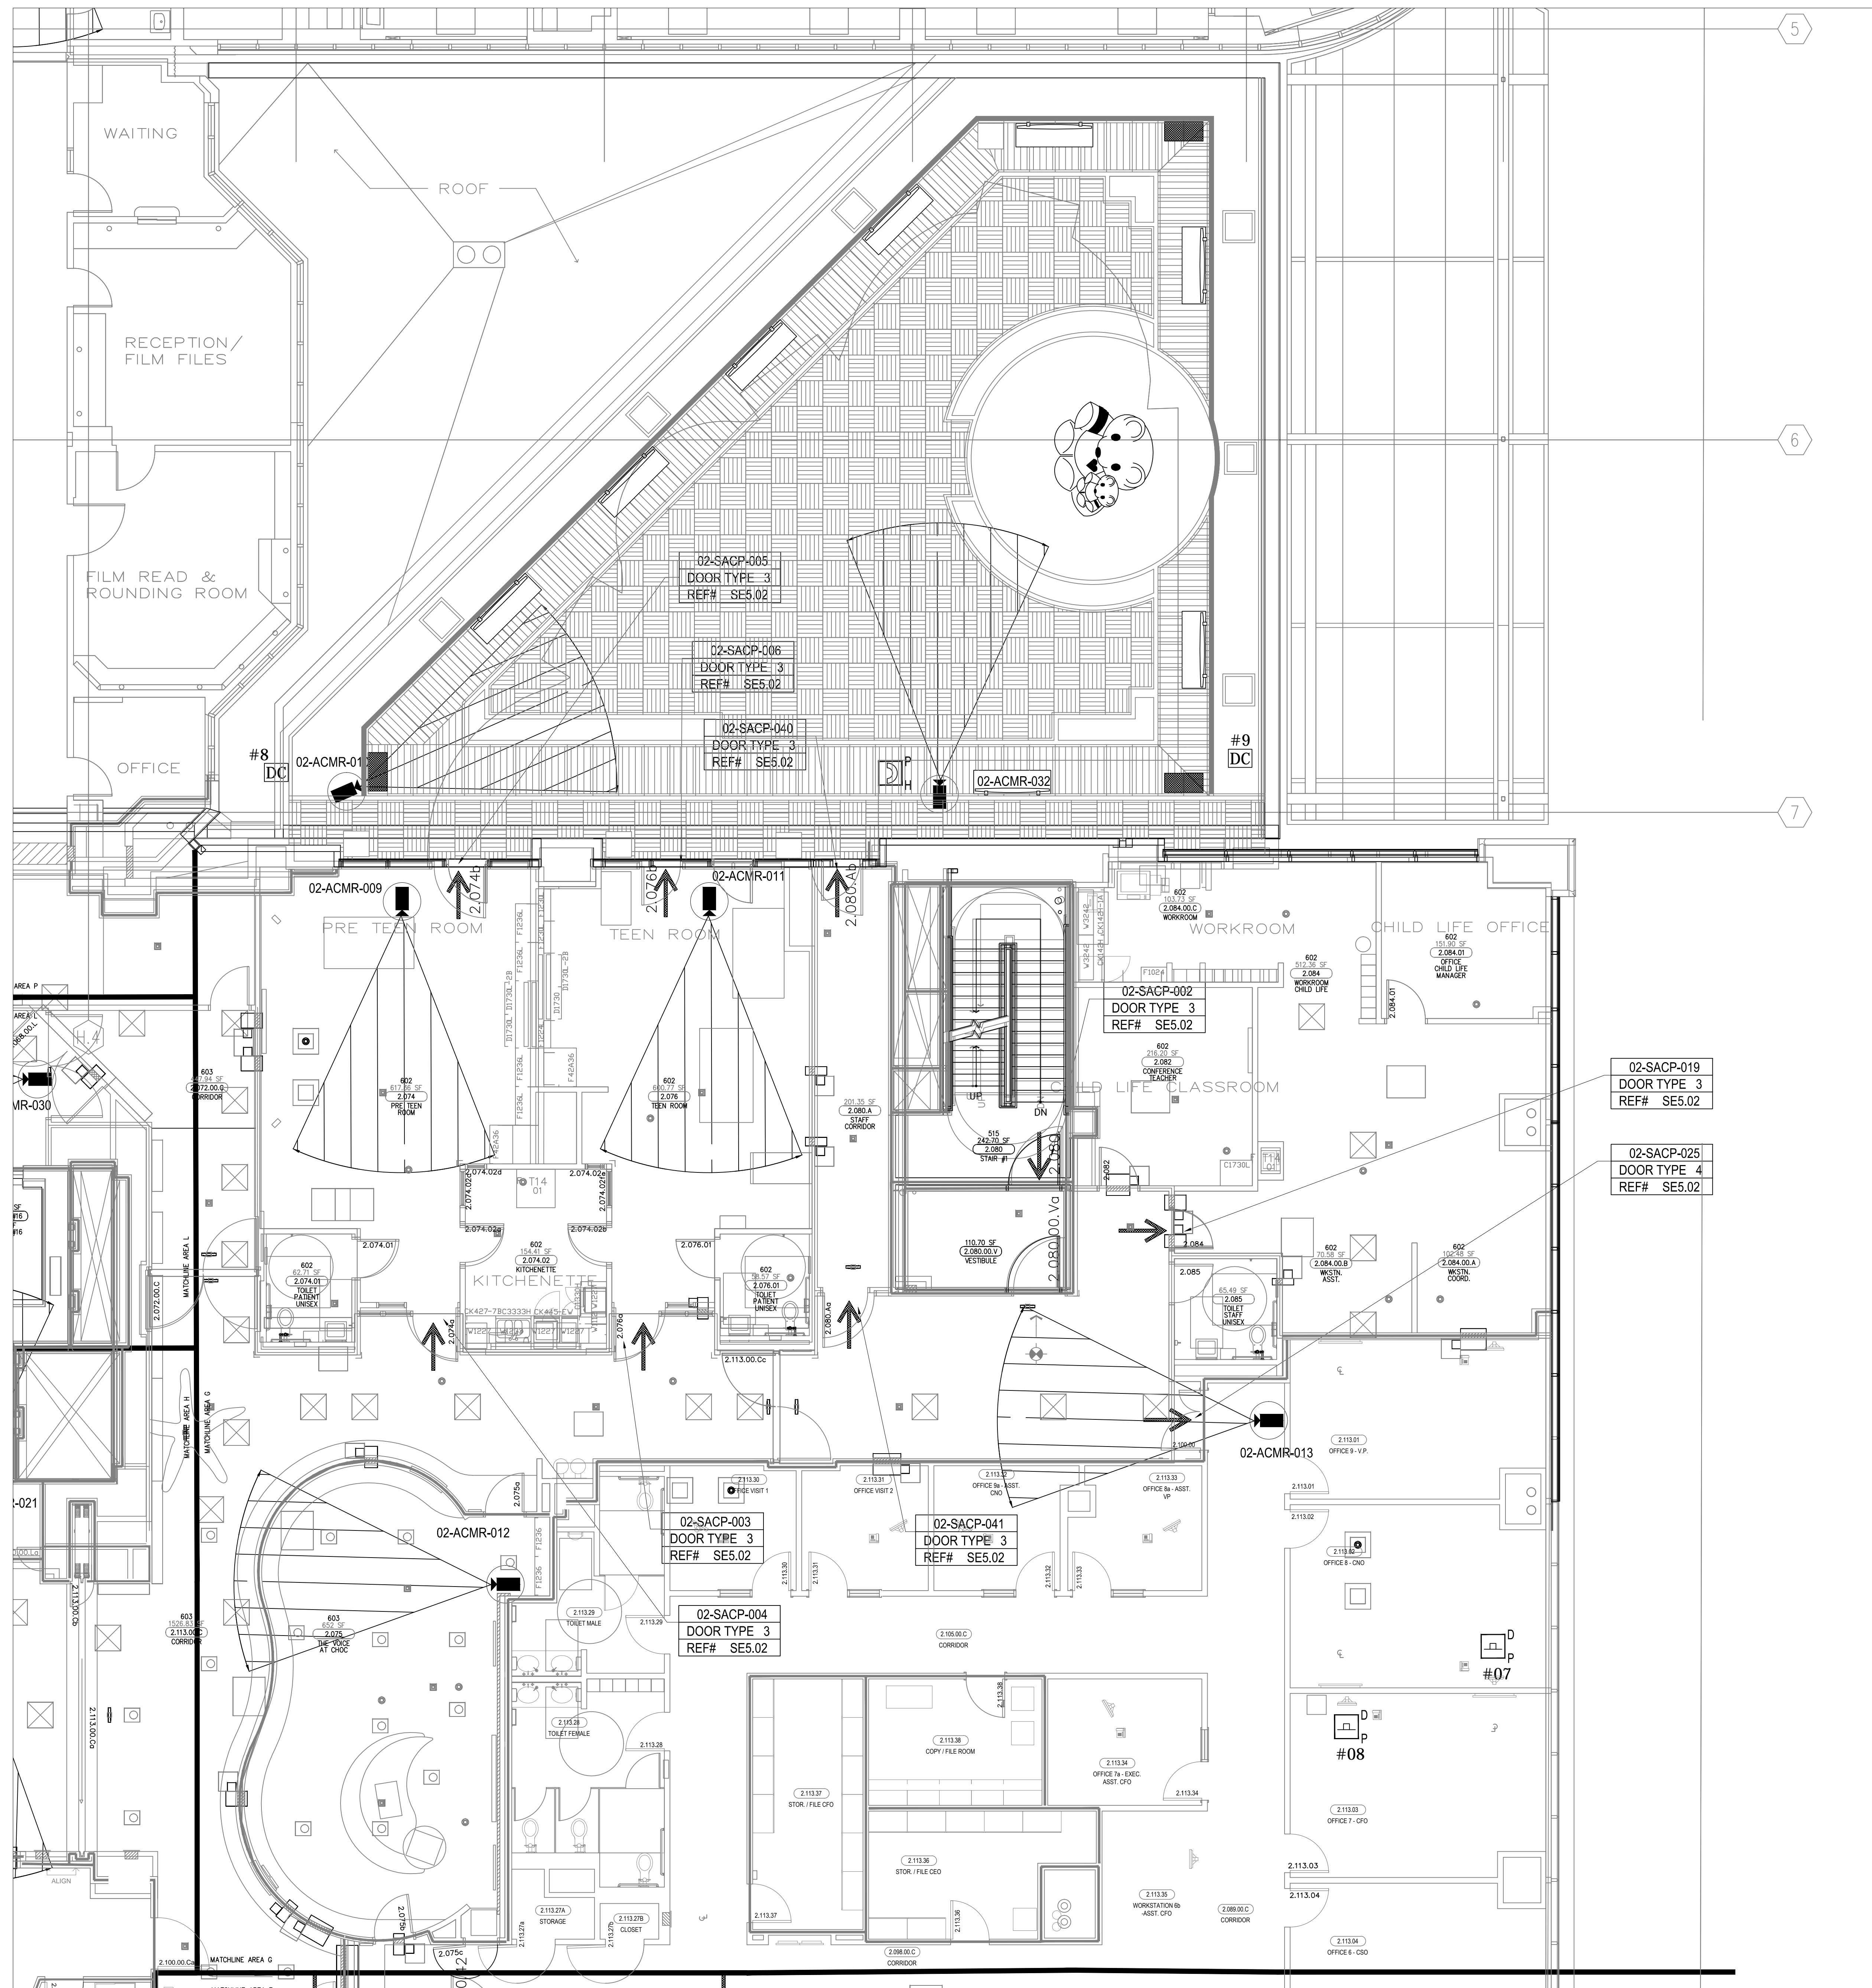CARD READER #	DOOR #
CR-02	2.080
CR-09	2.024
CR-21	2.056b
CR-25	2.100.00



ASBUILTS
08/15/2012

DEVICE LEGEND

DEVICE	DESCRIPTION	QTY.
	CARD READER	5
	DOOR CONTACT	7
	REQUEST TO EXIT DEVICE W/ DOOR LOCKS	5
	ELECTRIFIED LOCK	5
	PANIC BUTTON	0
	INTERCOMS	0
	FIXED IP DOME COLOR CAMERA	3
	PTZ IP DOME COLOR CAMERA	0
	ACCESS CONTROL PANEL	0
	CCTV HEAD END LOCATIONS	0
	PENETRATION SLEEVES	0

ACCESS CONTROL W/
FIRE PROTECTION DOORS:

<u>CARD READER #</u>	<u>DOOR #</u>
CR-02	2.080
CR-09	2.024
CR-21	2.056b
CR-25	2.100.00

DRAWING PREPARED BY:



1511 E. ORANGETHORPE BLVD.
FULLERTON, CALIFORNIA 92831
714-525-4350 - o; 714-525-4386 - f
(c) Copyright 2012 KRATOS | HBE
All Rights Reserved.


**MUST BE SIGNED BY HBE
TO AUTHENTICATE CONTENT(S).
ALL DETAILS CHECKED FOR ACCURACY.**

SIGNATURE _____ DATE _____

HBE JOB #

CONFIDENTIAL

THE INFORMATION CONTAINED HEREIN MAY NOT BE USED OR REPRODUCED IN ANY MANNER WITHOUT WRITTEN PERMISSION OF KRATOS | HBE.

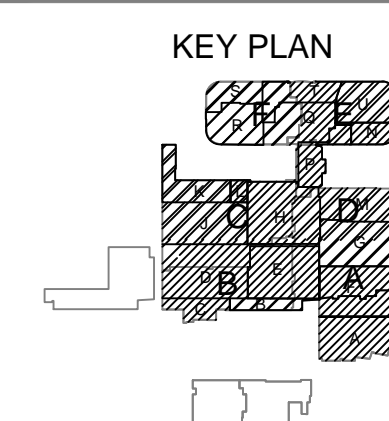

NO.	REV DESCRIPTION REV DATE	APPROVED BY
1.	AS BUILTS 08/16/2013	JOHN J. CHRISTIE

REV.	DESCRIPTION	APPROVED BY
CUSTOMER:		



PROJECT:

CHOC CHILDREN'S
HOSPITAL
455 SOUTH MAIN ST.
ORANGE, CA 92668


DRAFTING TITLE:

DRAWING TITLE

SECOND LEVEL
SECURITY PLAN
AREA J

DRN BY	DATE DRN	CHK BY	DATE CH
JOSH G.	08/08/2012	JJC	
SCALE:	NTS		
DWG NO.	SE3.02J		

ASBUILTS
08/15/2012

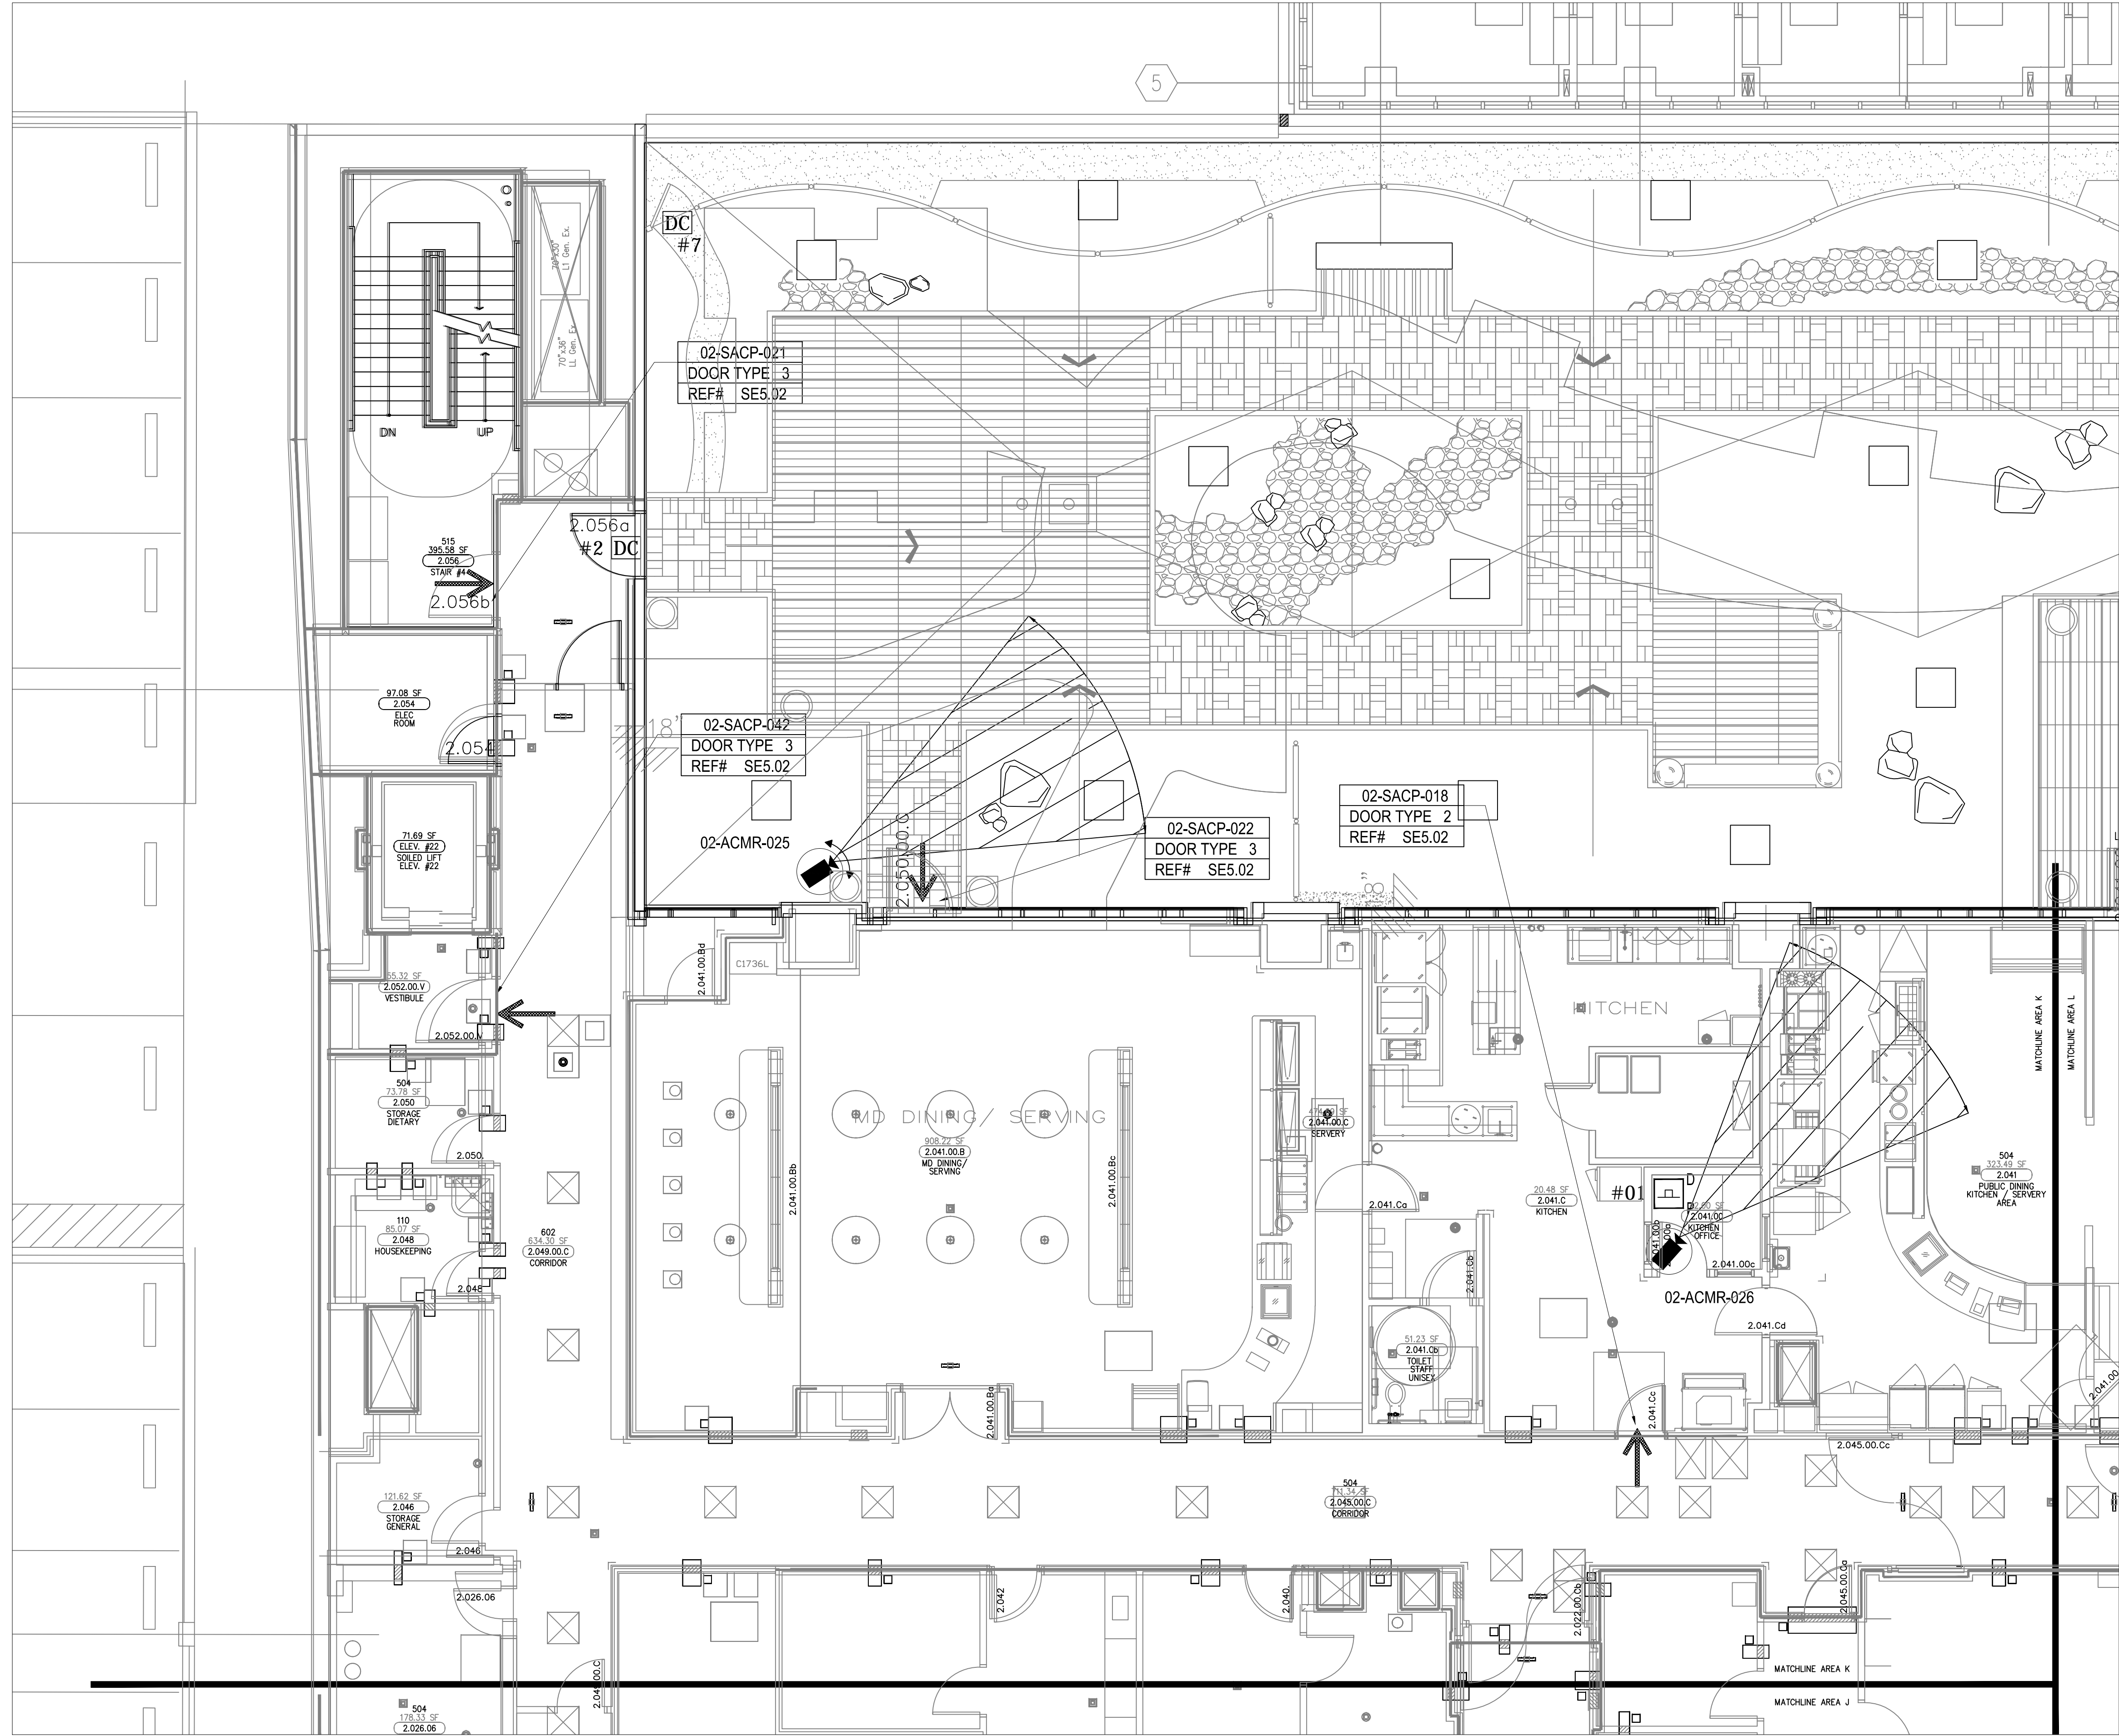

DEVICE LEGEND

DEVICE	DESCRIPTION	QTY.
CR	CARD READER	4
DC	DOOR CONTACT	5
REX	REQUEST TO EXIT DEVICE W/ DOOR LOCKS	4
EL	ELECTRIFIED LOCK	4
PB	PANIC BUTTON	1
IC	INTERCOMS	0
FC	FIXED IP DOME COLOR CAMERA	1
PTZ	PTZ IP DOME COLOR CAMERA	1
ACP	ACCESS CONTROL PANEL	0
CH	CCTV HEAD END LOCATIONS	0
PS	PENETRATION SLEEVES	0

ACCESS CONTROL W/
FIRE PROTECTION DOORS:

CARD READER #	DOOR #
CR-02	2.080
CR-09	2.024
CR-21	2.056b
CR-25	2.100.00

DRAWING PREPARED BY:



1511 E. ORANGETHORPE BLVD.
FULLERTON, CALIFORNIA 92831
714-525-4350 - o; 714-525-4386 - f
(c) Copyright 2012 KRATOS | HBE
All Rights Reserved.

MUST BE SIGNED BY HBE
TO AUTHENTICATE CONTENT(S).
ALL DETAILS CHECKED FOR ACCURACY.


SIGNATURE: DATE:

HBE JOB #

CONFIDENTIAL

THE INFORMATION CONTAINED HEREIN MAY
NOT BE USED OR REPRODUCED IN ANY
MANNER WITHOUT WRITTEN PERMISSION OF
KRATOS | HBE.

KEY PLAN

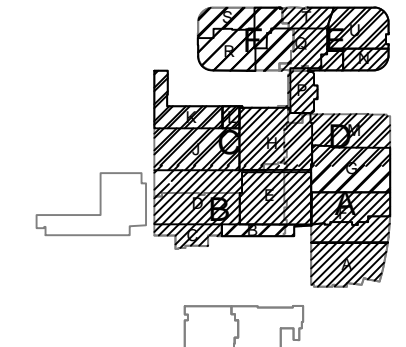

NO.	REV DESCRIPTION REV DATE	APPROVED BY
1.	AS BUILTS 08/15/2012	JOHN J. CHRISTIE

REV.	DESCRIPTION	APPROVED BY
------	-------------	-------------




PROJECT:
CHOC CHILDREN'S
HOSPITAL
455 SOUTH MAIN ST.
ORANGE, CA 92668

SECOND LEVEL
SECURITY PLAN
AREA K

DRN BY	DATE DRN	CHK BY	DATE CHK
JOSH G.	08/08/2012	JJC	
SCALE:	NTS		
DWG NO.	SE3.02K		

ASBUILTS
08/15/2012

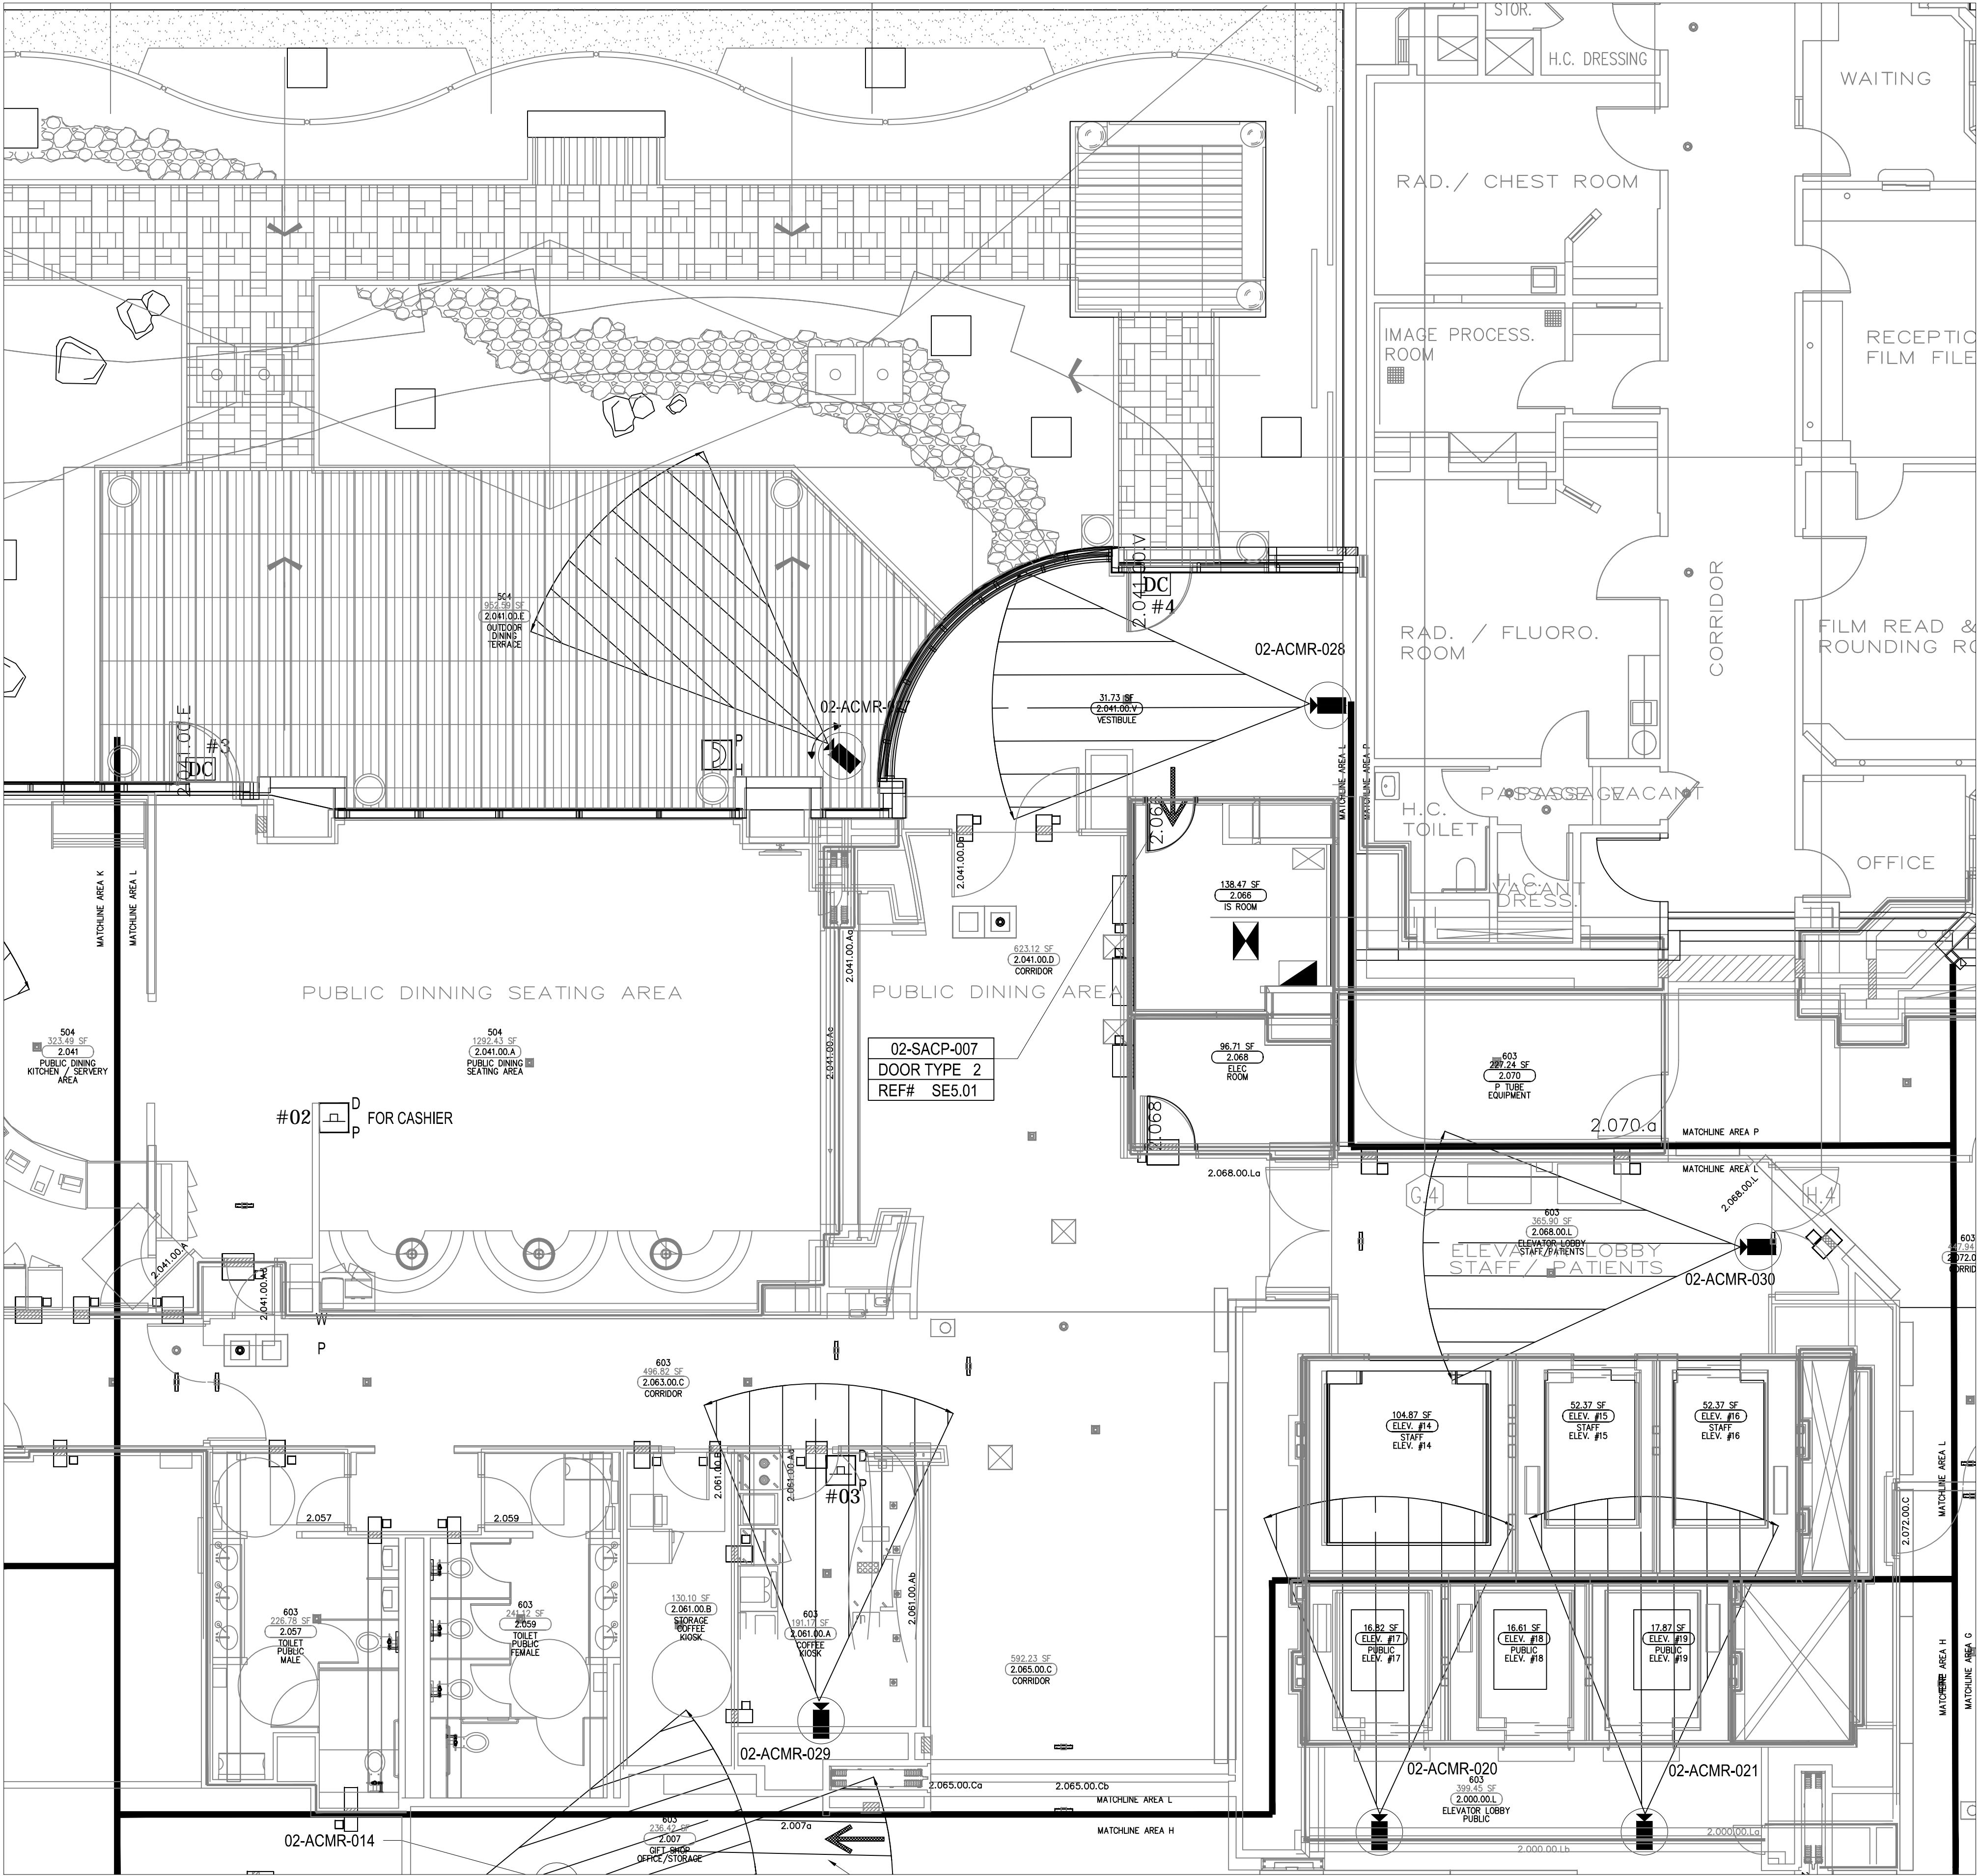

DEVICE LEGEND

DEVICE	DESCRIPTION	QTY.
CR	CARD READER	1
DC	DOOR CONTACT	3
REX	REQUEST TO EXIT DEVICE W/ DOOR LOCKS	1
EL	ELECTRIFIED LOCK	1
PB	PANIC BUTTON	2
IC	INTERCOMS	0
FC	FIXED IP DOME COLOR CAMERA	3
PTZ	PTZ IP DOME COLOR CAMERA	1
ACP	ACCESS CONTROL PANEL	1
CCTV	CCTV HEAD END LOCATIONS	1
PS	PENETRATION SLEEVES	0

SECURITY DEVICE NOTES:

1) CAMERAS #20 & 21 ARE NOT INCLUDED IN DEVICE LEGEND ON THIS SHEET.

ACCESS CONTROL W/
FIRE PROTECTION DOORS:

CARD READER #	DOOR #
CR-02	2.080
CR-09	2.024
CR-21	2.056b
CR-25	2.100.00

DRAWING PREPARED BY:



1511 E. ORANGETHORPE BLVD.
FULLERTON, CALIFORNIA 92831
714-525-4350 - o; 714-525-4386 - f
(c) Copyright 2012 KRATOS | HBE
All Rights Reserved.

MUST BE SIGNED BY HBE
TO AUTHENTICATE CONTENT(S).
ALL DETAILS CHECKED FOR ACCURACY.


SIGNATURE: _____ DATE: _____

HBE JOB #

CONFIDENTIAL

THE INFORMATION CONTAINED HEREIN MAY
NOT BE USED OR REPRODUCED IN ANY
MANNER WITHOUT WRITTEN PERMISSION OF
KRATOS | HBE.

KEY PLAN

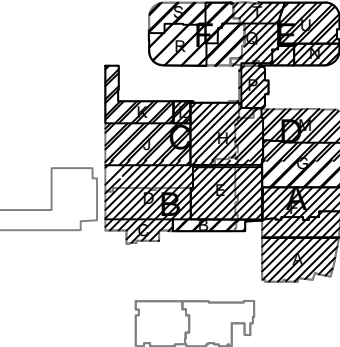

NO.	REV DESCRIPTION REV DATE	APPROVED BY
1.	AS BUILTS 08/15/2012	JOHN J. CHRISTIE

REV.	DESCRIPTION	APPROVED BY
------	-------------	-------------

CUSTOMER:



PROJECT:


CHOC CHILDREN'S
HOSPITAL
455 SOUTH MAIN ST.
ORANGE, CA 92668

DRAWING TITLE:

SECOND LEVEL
SECURITY PLAN
AREA L

DRN BY	DATE DRN	CHK BY	DATE CHK
JOSH G.	08/08/2012	JJC	
SCALE:	NTS		
DWG NO.	SE3.02L		

ASBUILTS
08/15/2012

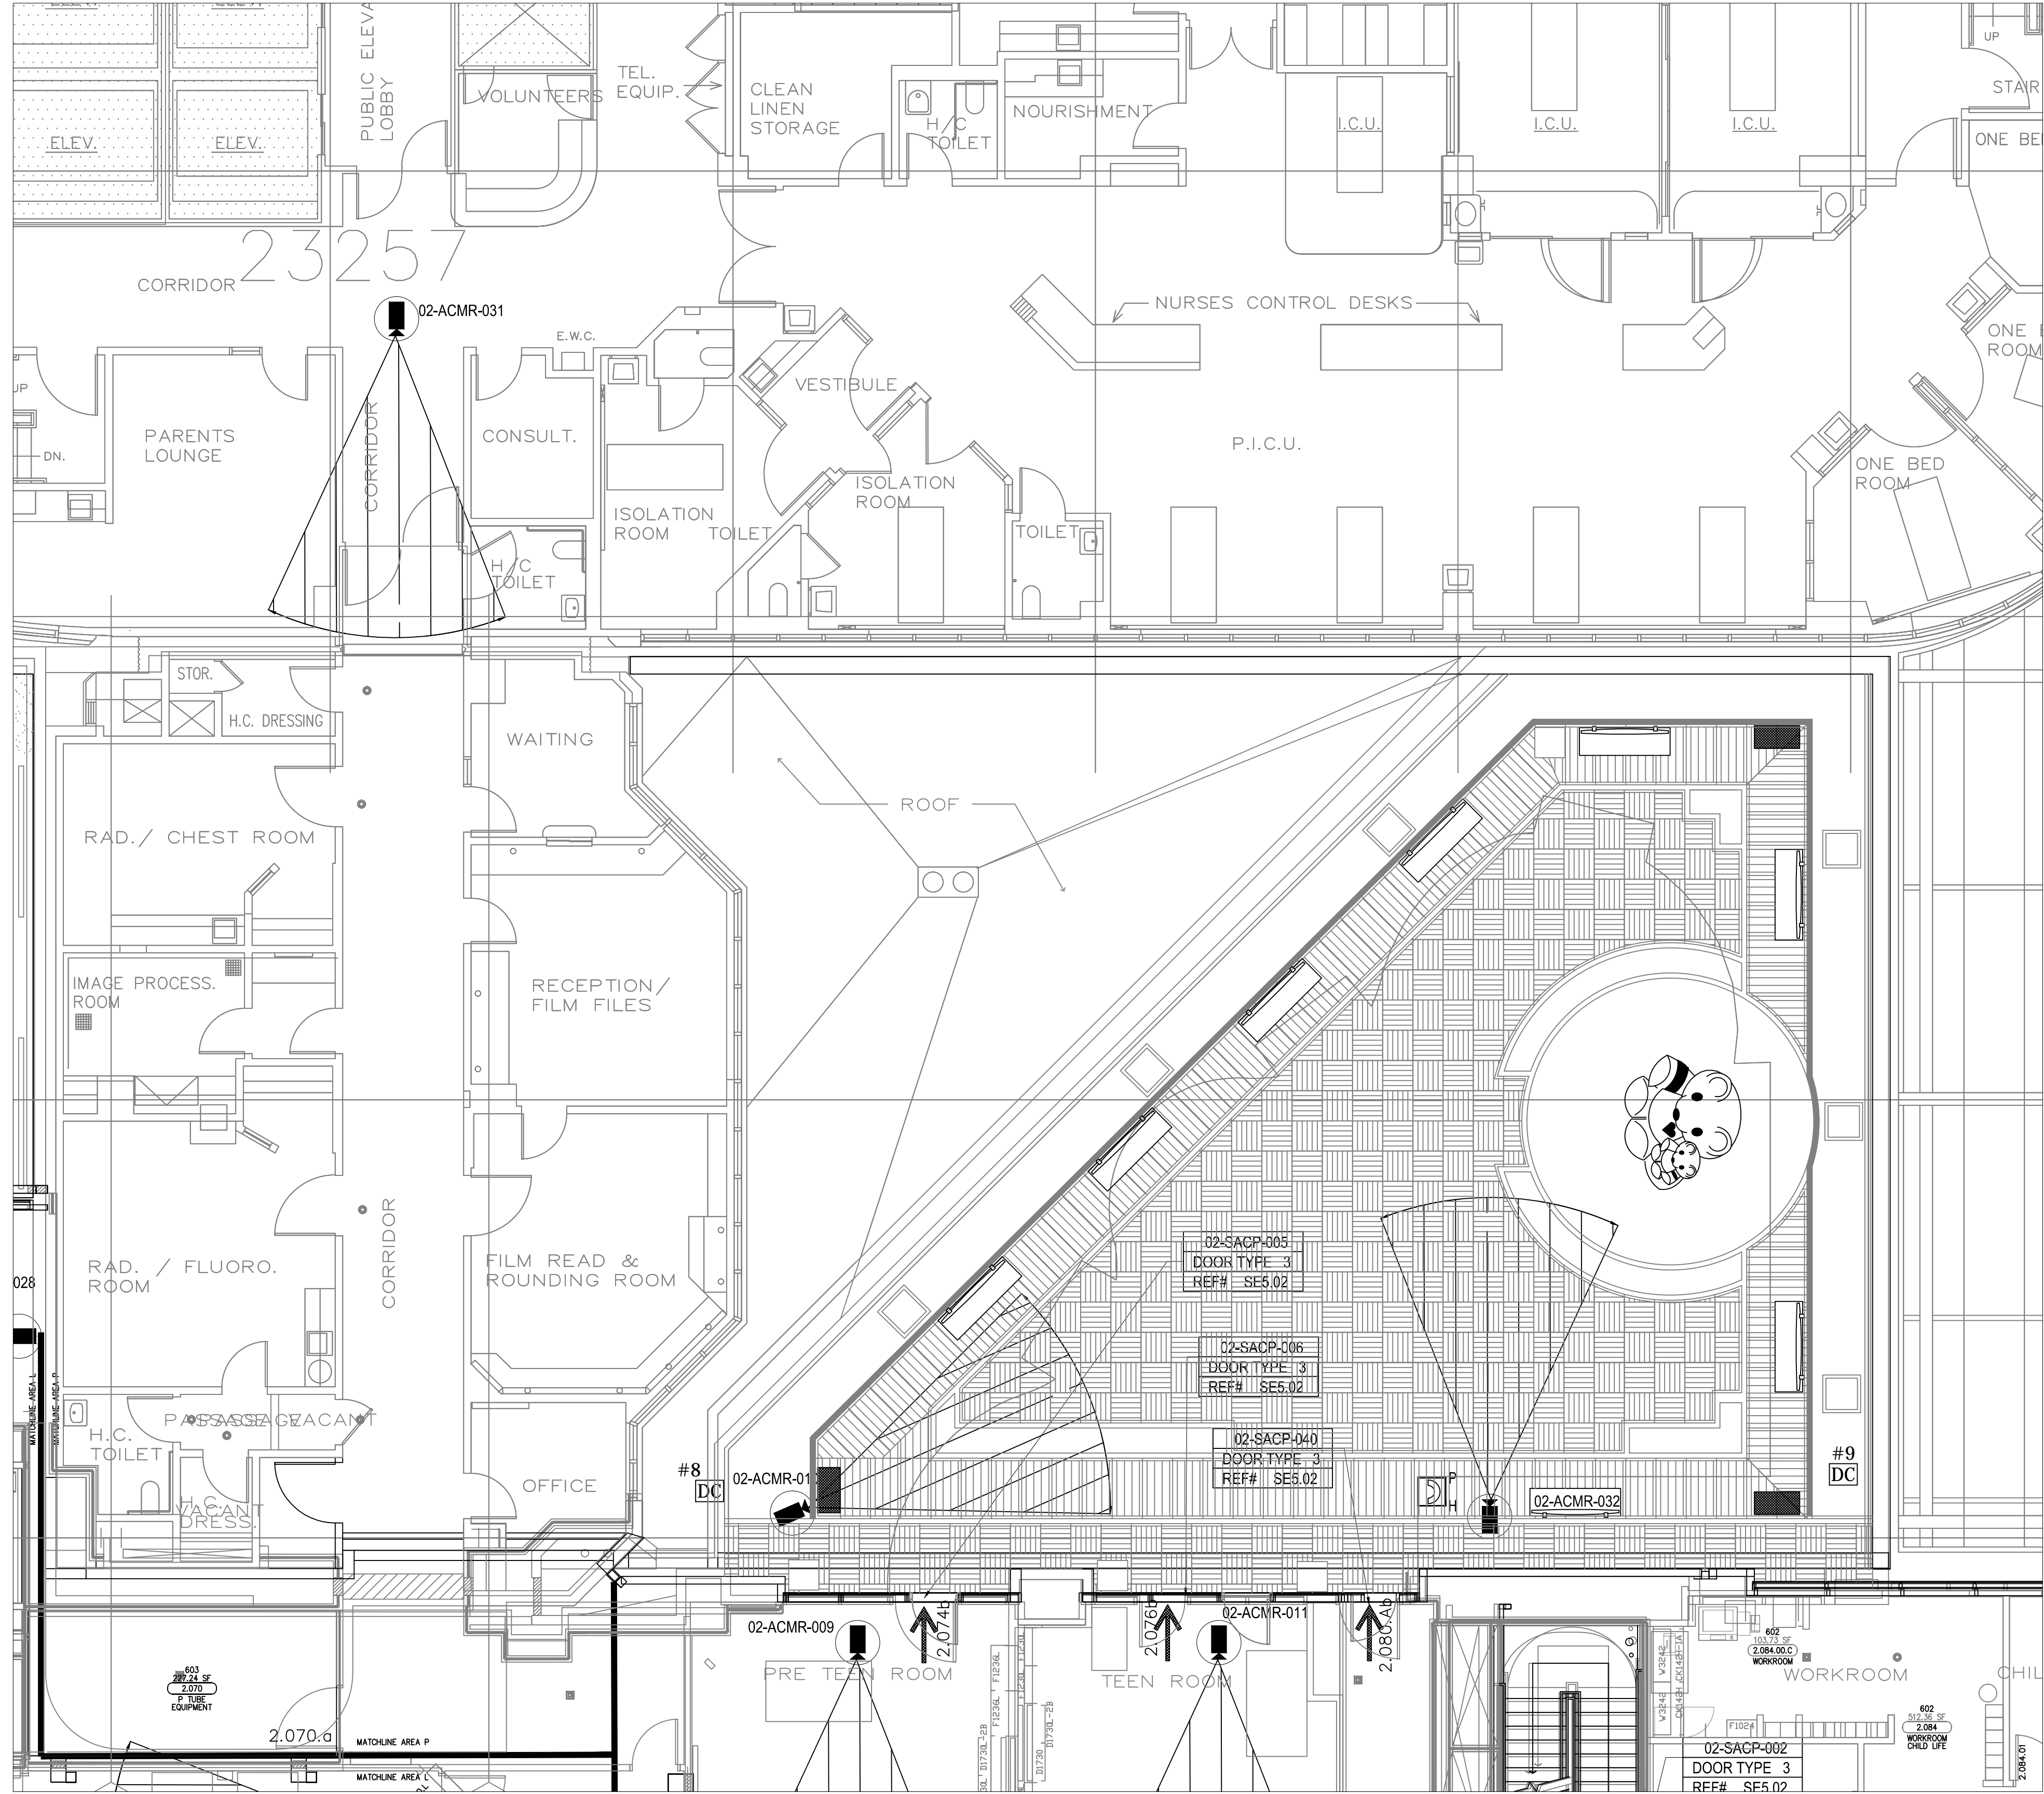

DEVICE LEGEND

DEVICE	DESCRIPTION	QTY.
CR	CARD READER	0
DC	DOOR CONTACT	0
REX	REQUEST TO EXIT DEVICE W/ DOOR LOCKS	0
EL	ELECTRIFIED LOCK	0
P	PANIC BUTTON	0
I	INTERCOMS	0
CC	FIXED IP DOME COLOR CAMERA	1
PTZ	PTZ IP DOME COLOR CAMERA	0
ACP	ACCESS CONTROL PANEL	0
CCTV	CCTV HEAD END LOCATIONS	0
PS	PENETRATION SLEEVES	0

SECURITY DEVICE NOTES:

- 1) CARD READERS #05, #06 & #40 ARE NOT INCLUDED IN DEVICE LEGEND ON THIS SHEET.
- 2) DOOR CONTACTS #8 & #9 ARE NOT INCLUDED IN DEVICE LEGEND ON THIS SHEET.
- 3) CAMERAS #09, #10 & #32 ARE NOT INCLUDED IN DEVICE LEGEND ON THIS SHEET.

ACCESS CONTROL W/
FIRE PROTECTION DOORS:

CARD READER #	DOOR #
CR-02	2.080
CR-09	2.024
CR-21	2.056b
CR-25	2.100.00

DRAWING PREPARED BY:



1511 E. ORANGETHORPE BLVD.
FULLERTON, CALIFORNIA 92831
714-525-4350 - o; 714-525-4386 - f
(c) Copyright 2012 KRATOS | HBE
All Rights Reserved.

MUST BE SIGNED BY HBE
TO AUTHENTICATE CONTENT(S).
ALL DETAILS CHECKED FOR ACCURACY.


SIGNATURE: _____ DATE: _____

HBE JOB #

CONFIDENTIAL

THE INFORMATION CONTAINED HEREIN MAY
NOT BE USED OR REPRODUCED IN ANY
MANNER WITHOUT WRITTEN PERMISSION OF
KRATOS | HBE.

KEY PLAN

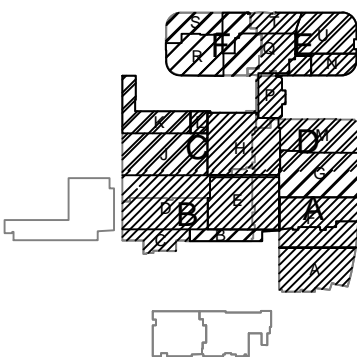

NO.	REV DESCRIPTION REV DATE	APPROVED BY
1.	AS BUILTS 08/15/2012	JOHN J. CHRISTIE

REV. DESCRIPTION APPROVED BY

CUSTOMER:



PROJECT:

CHOC CHILDREN'S
HOSPITAL
455 SOUTH MAIN ST.
ORANGE, CA 92668

DRAWING TITLE:

SECOND LEVEL
SECURITY PLAN
AREA P

DRN BY	DATE DRN	CHK BY	DATE CHK
JOSH G.	08/08/2012	JJC	
SCALE:	NTS		
DWG NO.	SE3.02P		

ASBUILTS
08/15/2012