


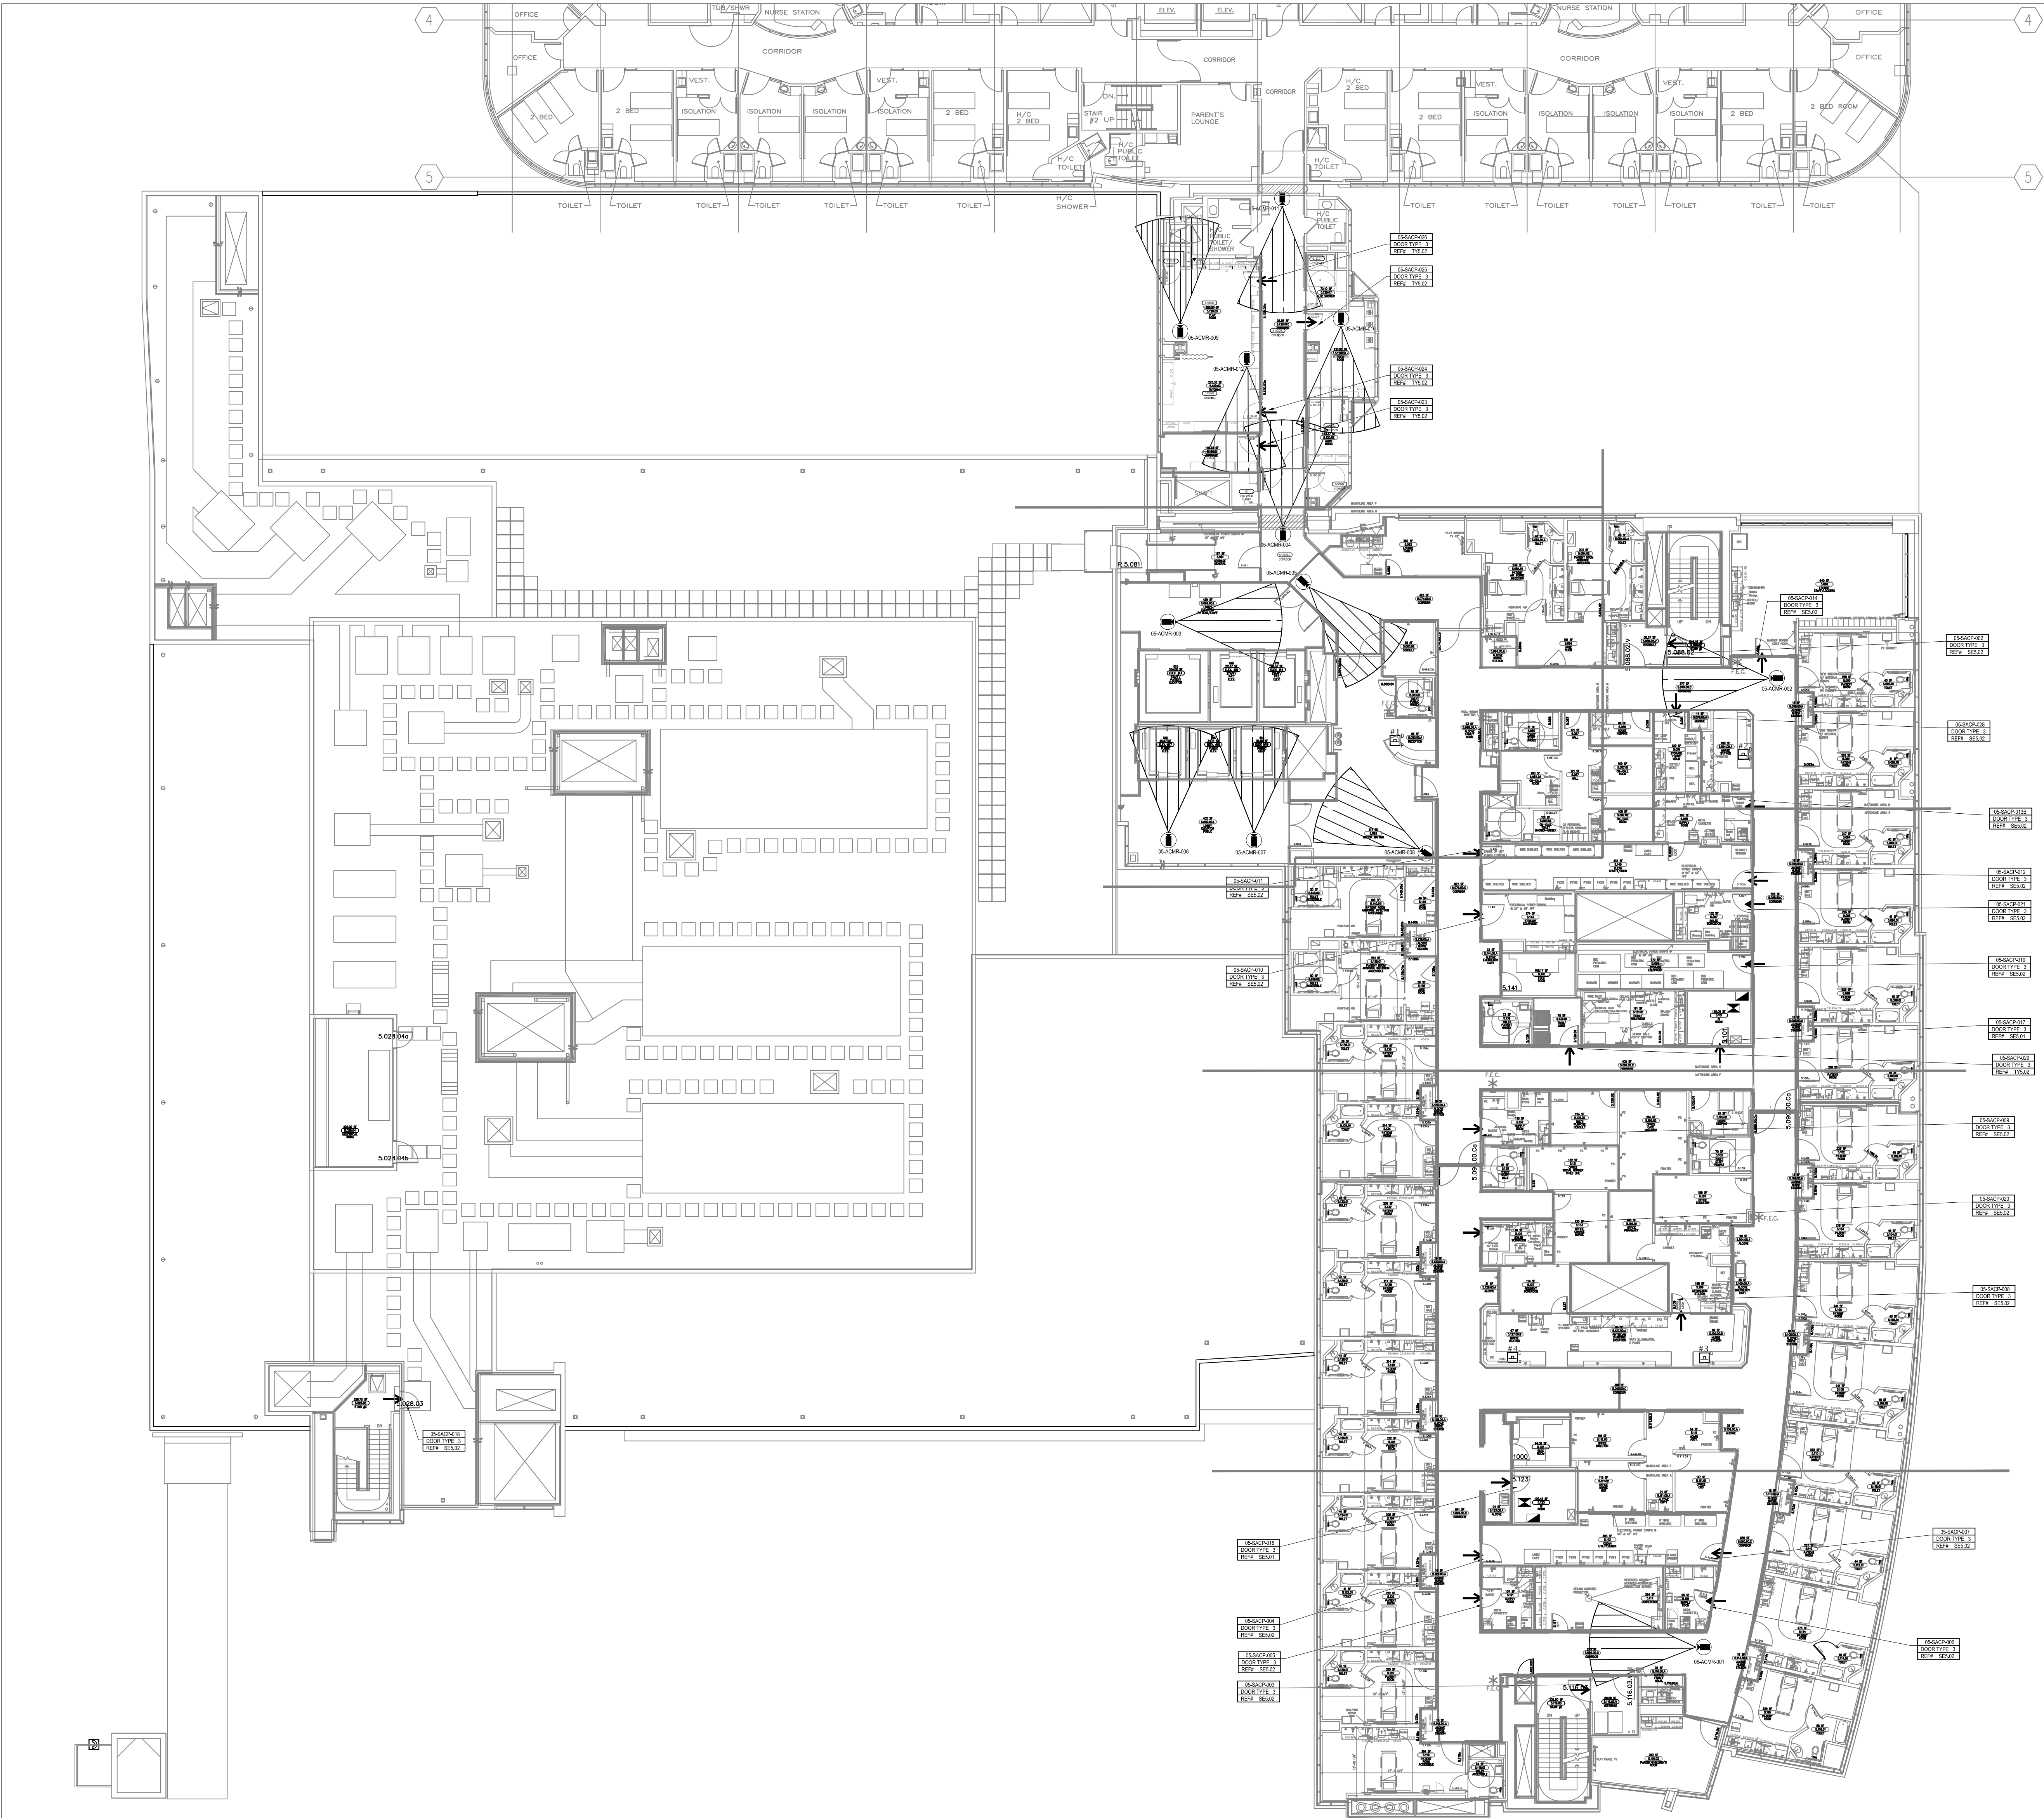

DEVICE LEGEND

| DEVICE | DESCRIPTION                          | QTY. |
|--------|--------------------------------------|------|
| CR     | CARD READER                          | 25   |
| DC     | DOOR CONTACT                         | 25   |
| REX    | REQUEST TO EXIT DEVICE W/ DOOR LOCKS | 25   |
| EL     | ELECTRIFIED LOCK                     | 25   |
| PB     | PANIC BUTTON                         | 4    |
| IC     | INTERCOMS                            | 0    |
| FC     | FIXED IP DOME COLOR CAMERA           | 12   |
| PTZ    | PTZ IP DOME COLOR CAMERA             | 0    |
| ACP    | ACCESS CONTROL PANEL                 | 2    |
| CCTV   | CCTV HEAD END LOCATIONS              | 2    |
| PS     | PENETRATION SLEEVES                  | 0    |

ACCESS CONTROL W/  
FIRE PROTECTION DOORS:

| CARD READER # | DOOR #   |
|---------------|----------|
| CR-02         | 5.088.02 |
| CR-03         | 5.116.03 |
| CR-18         | 5.028.03 |

DRAWING PREPARED BY:



1511 E. ORANGETHORPE BLVD.  
FULLERTON, CALIFORNIA 92831  
714-525-4350 - o; 714-525-4386 - f  
(c) Copyright 2012 KRATOS | HBE  
All Rights Reserved.

MUST BE SIGNED BY HBE  
TO AUTHENTICATE CONTENT(S).  
ALL DETAILS CHECKED FOR ACCURACY.


SIGNATURE \_\_\_\_\_ DATE \_\_\_\_\_

HBE JOB #

CONFIDENTIAL

THE INFORMATION CONTAINED HERIN MAY  
NOT BE USED OR REPRODUCED IN ANY  
MANNER WITHOUT WRITTEN PERMISSION OF  
KRATOS | HBE.

KEY PLAN

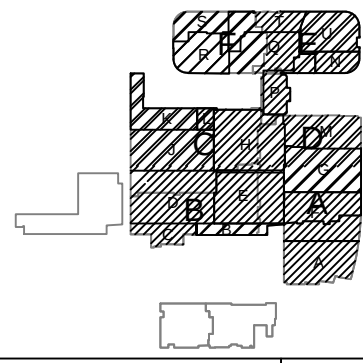

| NO. | REV DESCRIPTION<br>REV DATE | APPROVED BY      |
|-----|-----------------------------|------------------|
| 1.  | AS BUILTS<br>08/15/2012     | JOHN J. CHRISTIE |

| REV. | DESCRIPTION | APPROVED BY |
|------|-------------|-------------|
|------|-------------|-------------|

CUSTOMER:



PROJECT:


CHOC CHILDREN'S  
HOSPITAL  
455 SOUTH MAIN ST.  
ORANGE, CA 92668

DRAWING TITLE:

FIFTH LEVEL  
SECURITY PLAN

|         |            |        |          |
|---------|------------|--------|----------|
| DRN BY  | DATE DRN   | CHK BY | DATE CHK |
| JOSH G. | 08/08/2012 | JJC    |          |
| SCALE:  | NTS        |        |          |
| DWG NO. | SE3.05     |        |          |

ASBUILTS  
08/15/2012

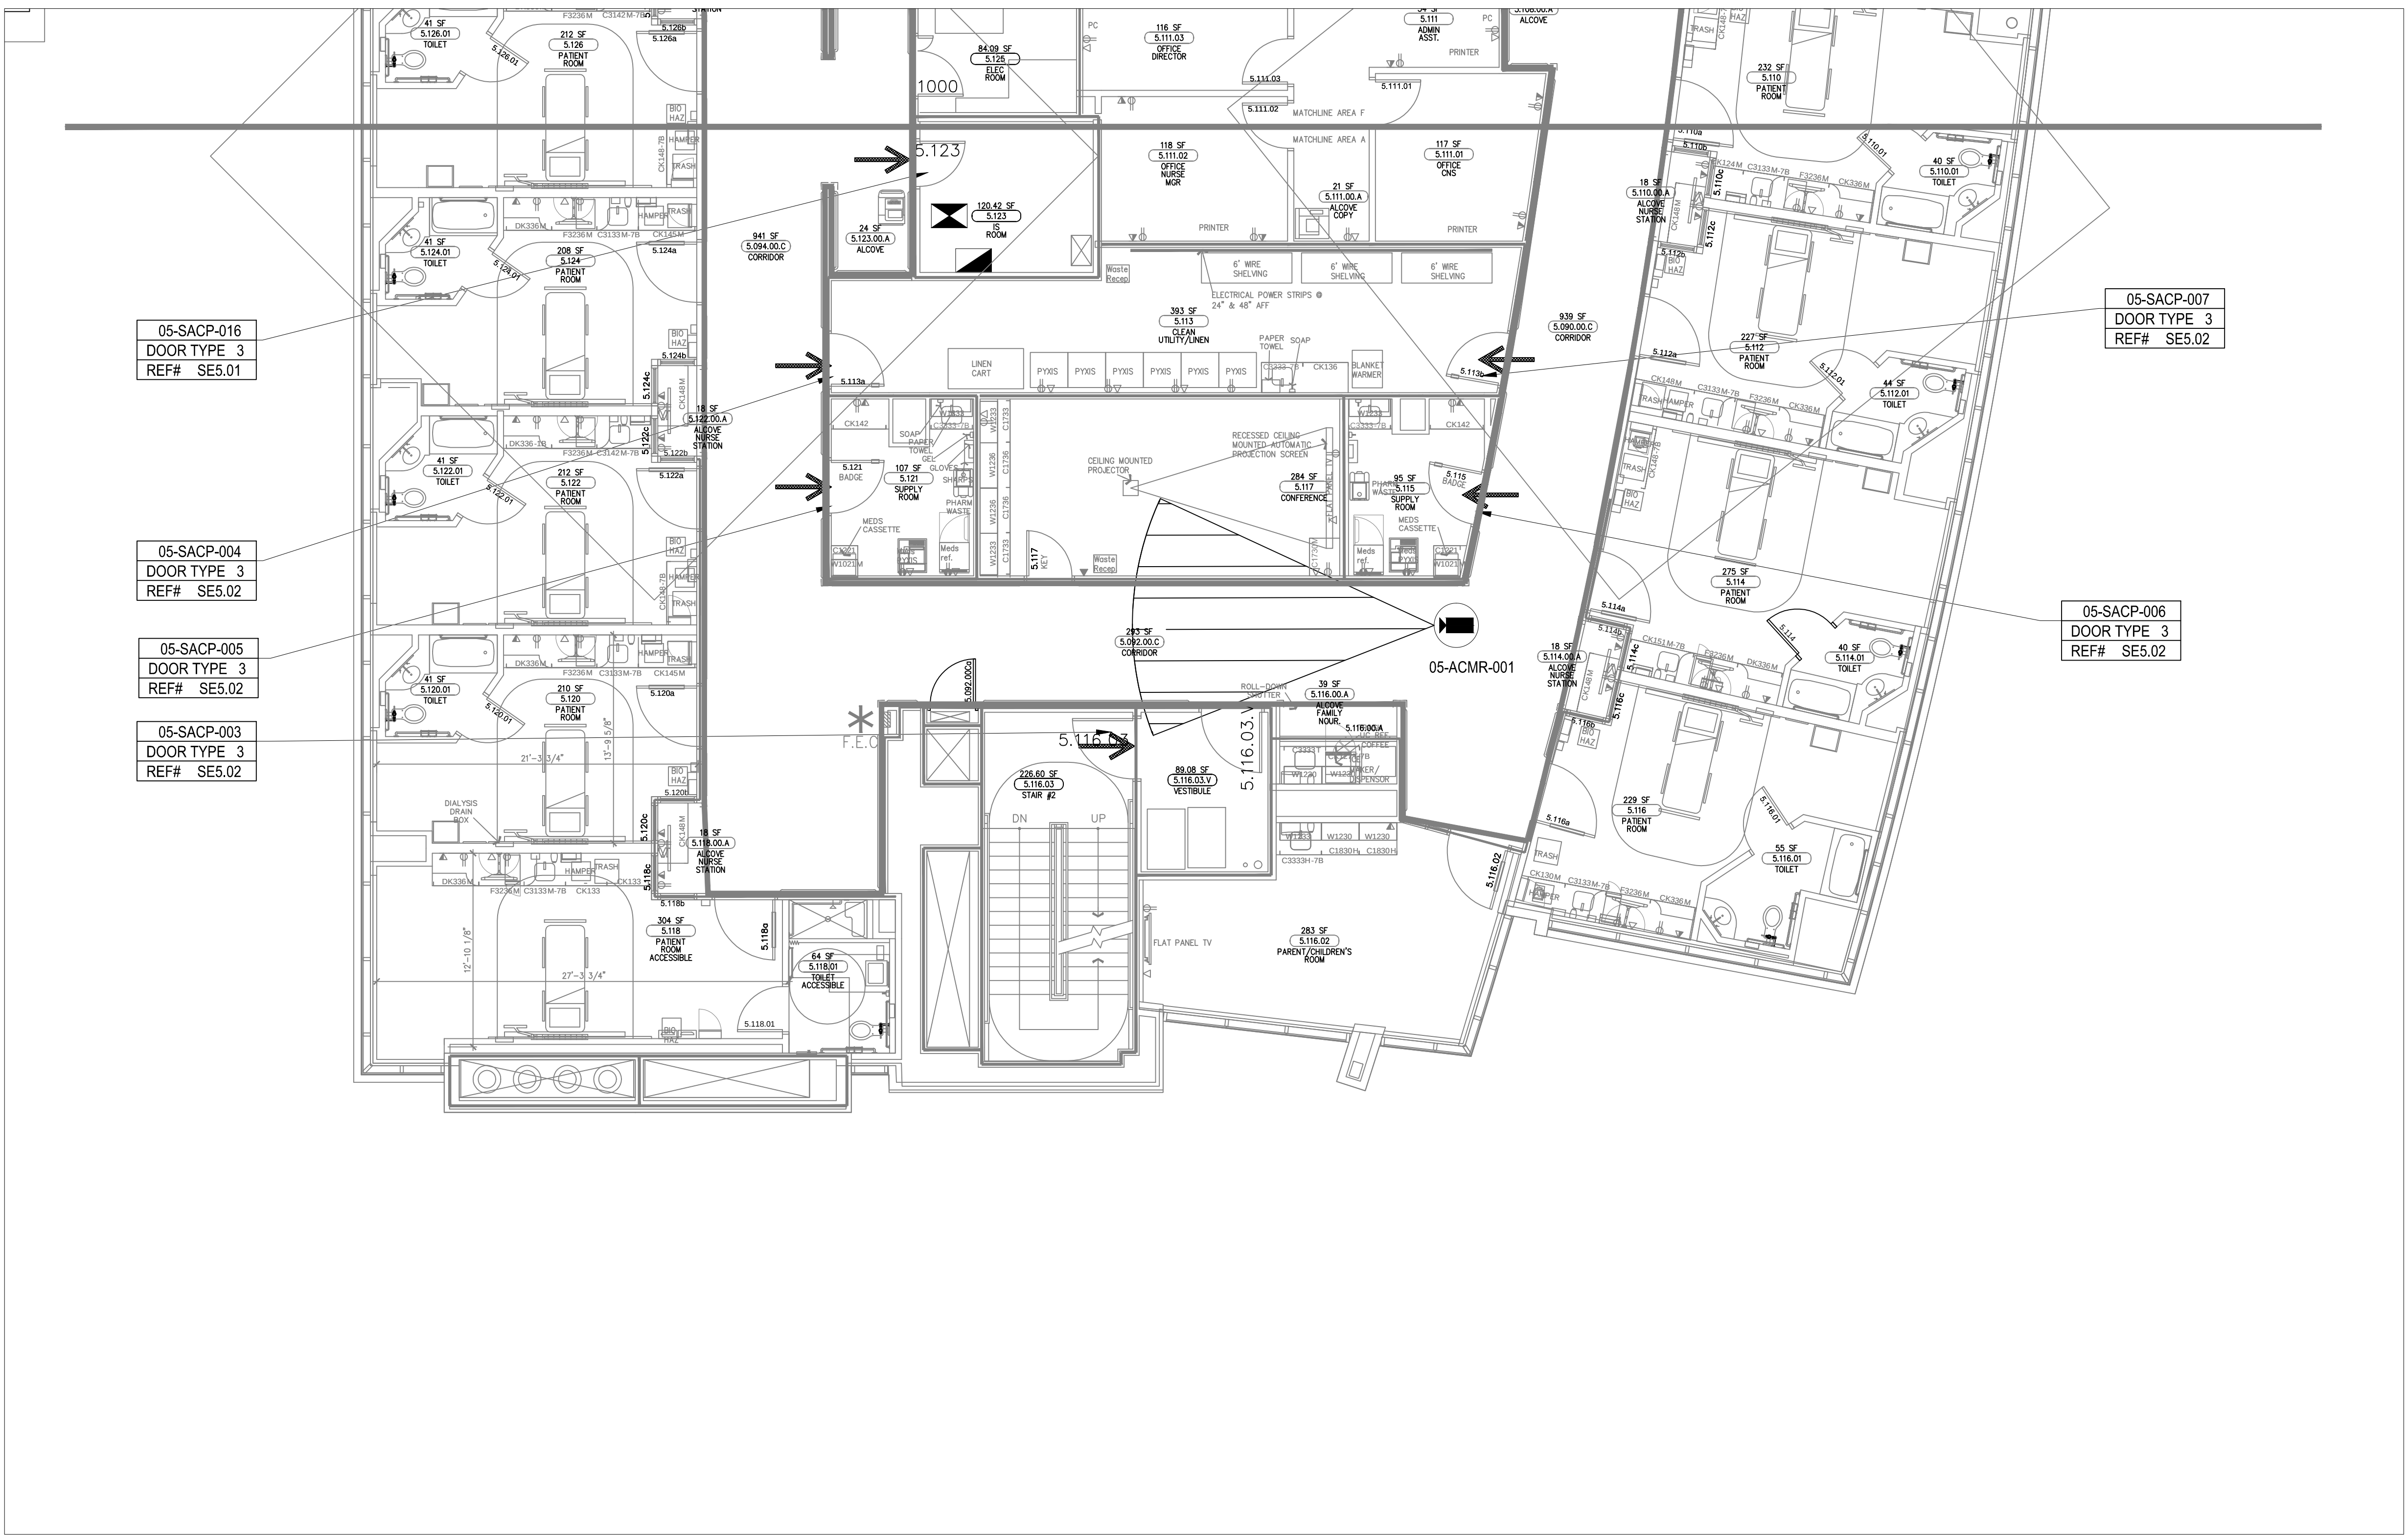

DEVICE LEGEND

| DEVICE | DESCRIPTION                          | QTY. |
|--------|--------------------------------------|------|
| CR     | CARD READER                          | 6    |
| DC     | DOOR CONTACT                         | 6    |
| REX    | REQUEST TO EXIT DEVICE W/ DOOR LOCKS | 6    |
| EL     | ELECTRIFIED LOCK                     | 6    |
| P      | PANIC BUTTON                         | 0    |
| IS     | INTERCOMS                            | 0    |
| FC     | FIXED IP DOME COLOR CAMERA           | 1    |
| PTZ    | PTZ IP DOME COLOR CAMERA             | 0    |
| ACP    | ACCESS CONTROL PANEL                 | 1    |
| CCTV   | CCTV HEAD END LOCATIONS              | 1    |
| PS     | PENETRATION SLEEVES                  | 0    |

ACCESS CONTROL W/  
FIRE PROTECTION DOORS:

| CARD READER # | DOOR #   |
|---------------|----------|
| CR-02         | 5.088.02 |
| CR-03         | 5.116.03 |
| CR-18         | 5.028.03 |

DRAWING PREPARED BY:



1511 E. ORANGETHORPE BLVD.  
FULLERTON, CALIFORNIA 92831  
714-525-4350 - o; 714-525-4386 - f  
(c) Copyright 2012 KRATOS | HBE  
All Rights Reserved.

MUST BE SIGNED BY HBE  
TO AUTHENTICATE CONTENT(S).  
ALL DETAILS CHECKED FOR ACCURACY.


SIGNATURE DATE

HBE JOB #

CONFIDENTIAL

THE INFORMATION CONTAINED HERIN MAY  
NOT BE USED OR REPRODUCED IN ANY  
MANNER WITHOUT WRITTEN PERMISSION OF  
KRATOS | HBE.

KEY PLAN

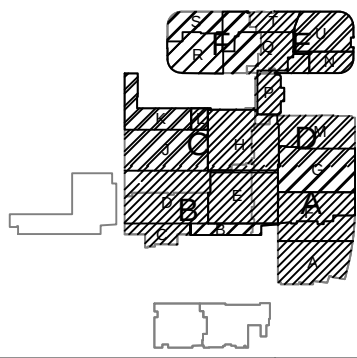

| NO. | REV DESCRIPTION<br>REV DATE | APPROVED BY      |
|-----|-----------------------------|------------------|
| 1.  | AS BUILTS<br>08/15/2012     | JOHN J. CHRISTIE |
|     |                             |                  |
|     |                             |                  |
|     |                             |                  |
|     |                             |                  |
|     |                             |                  |
|     |                             |                  |
|     |                             |                  |

| REV. | DESCRIPTION | APPROVED BY |
|------|-------------|-------------|
|------|-------------|-------------|

CUSTOMER:



PROJECT:


CHOC CHILDREN'S  
HOSPITAL  
455 SOUTH MAIN ST.  
ORANGE, CA 92668

DRAWING TITLE:

FIFTH LEVEL  
SECURITY PLAN  
AREA A

| DRN BY  | DATE DRN   | CHK BY | DATE CHK |
|---------|------------|--------|----------|
| JOSH G. | 08/08/2012 | JJC    |          |
| SCALE:  | NTS        |        |          |
| DWG NO. | SE3.05A    |        |          |

ASBUILTS  
08/15/2012

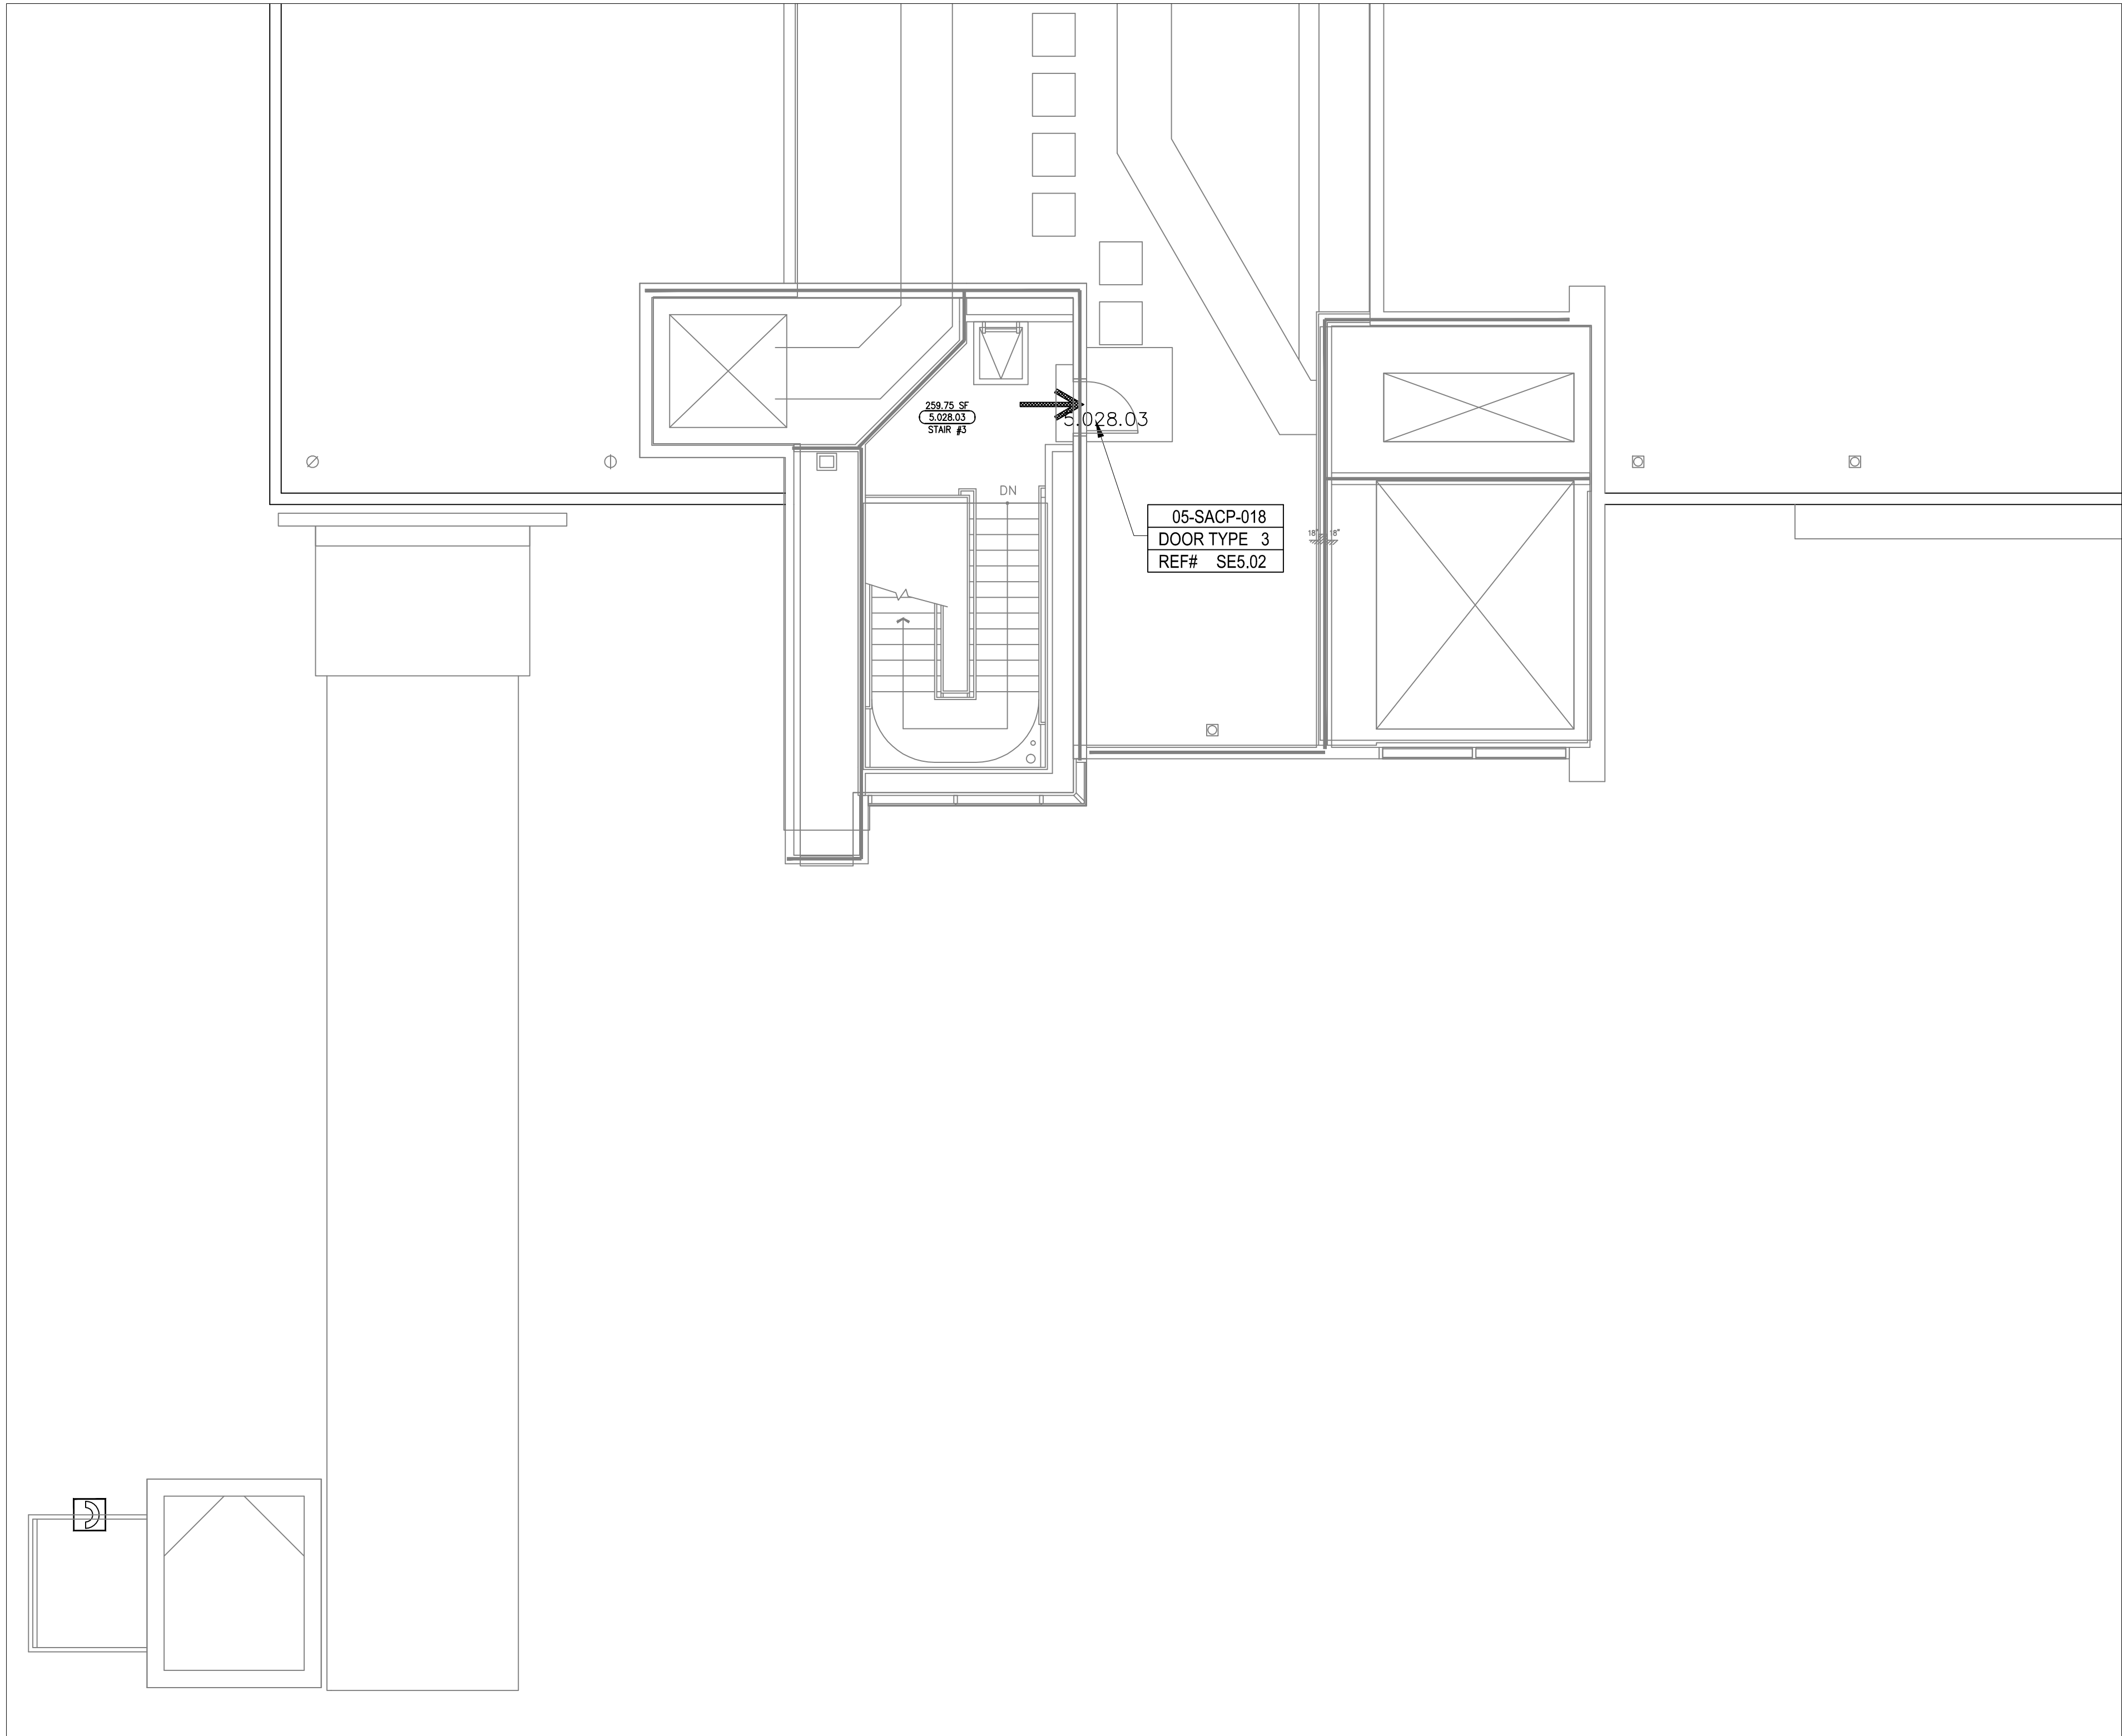

DEVICE LEGEND

| DEVICE  | DESCRIPTION                          | QTY. |
|---------|--------------------------------------|------|
| CR      | CARD READER                          | 6    |
| DC      | DOOR CONTACT                         | 6    |
| REX     | REQUEST TO EXIT DEVICE W/ DOOR LOCKS | 6    |
| EL      | ELECTRIFIED LOCK                     | 6    |
| P       | PANIC BUTTON                         | 0    |
| IS      | INTERCOMS                            | 0    |
| EP      | EMERGENCY PHONE                      | 1    |
| FIPDC   | FIXED IP DOME COLOR CAMERA           | 1    |
| PTZIPDC | PTZ IP DOME COLOR CAMERA             | 0    |
| ACP     | ACCESS CONTROL PANEL                 | 1    |
| CCTV    | CCTV HEAD END LOCATIONS              | 1    |
| PS      | PENETRATION SLEEVES                  | 0    |

ACCESS CONTROL W/  
FIRE PROTECTION DOORS:

| CARD READER # | DOOR #   |
|---------------|----------|
| CR-02         | 5.088.02 |
| CR-03         | 5.116.03 |
| CR-18         | 5.028.03 |

DRAWING PREPARED BY:



1511 E. ORANGETHORPE BLVD.  
FULLERTON, CALIFORNIA 92831  
714-525-4350 - o; 714-525-4386 - f  
(c) Copyright 2012 KRATOS | HBE  
All Rights Reserved.

MUST BE SIGNED BY HBE  
TO AUTHENTICATE CONTENT(S).  
ALL DETAILS CHECKED FOR ACCURACY.


SIGNATURE \_\_\_\_\_ DATE \_\_\_\_\_

HBE JOB #

CONFIDENTIAL

THE INFORMATION CONTAINED HERIN MAY  
NOT BE USED OR REPRODUCED IN ANY  
MANNER WITHOUT WRITTEN PERMISSION OF  
KRATOS | HBE.

KEY PLAN

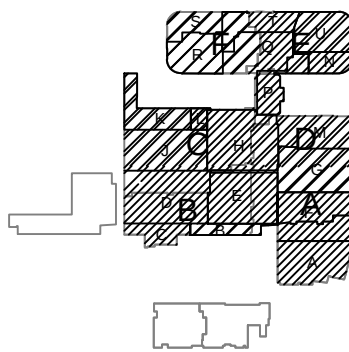

| NO. | REV DESCRIPTION<br>REV DATE | APPROVED BY      |
|-----|-----------------------------|------------------|
| 1.  | AS BUILTS<br>08/15/2012     | JOHN J. CHRISTIE |
|     |                             |                  |
|     |                             |                  |
|     |                             |                  |
|     |                             |                  |
|     |                             |                  |
|     |                             |                  |

| REV. | DESCRIPTION | APPROVED BY |
|------|-------------|-------------|
|------|-------------|-------------|

CUSTOMER:



PROJECT:

CHOC CHILDREN'S  
HOSPITAL  
455 SOUTH MAIN ST.  
ORANGE, CA 92668

DRAWING TITLE:

FIFTH LEVEL  
SECURITY PLAN  
AREA D

|         |            |        |          |
|---------|------------|--------|----------|
| DRN BY  | DATE DRN   | CHK BY | DATE CHK |
| JOSH G. | 08/08/2012 | JJC    |          |
| SCALE:  | NTS        |        |          |
| DWG NO. | SE3.05D    |        |          |

ASBUILTS  
08/15/2012

DEVICE LEGEND

| DEVICE | DESCRIPTION                          | QTY. |
|--------|--------------------------------------|------|
| CR     | CARD READER                          | 3    |
| DC     | DOOR CONTACT                         | 3    |
| REX    | REQUEST TO EXIT DEVICE W/ DOOR LOCKS | 3    |
| EL     | ELECTRIFIED LOCK                     | 3    |
| P      | PANIC BUTTON                         | 2    |
| IC     | INTERCOMS                            | 0    |
| EP     | EMERGENCY PHONE                      | 0    |
| FC     | FIXED IP DOME COLOR CAMERA           | 0    |
| PTZ    | PTZ IP DOME COLOR CAMERA             | 0    |
| ACP    | ACCESS CONTROL PANEL                 | 0    |
| CCTV   | CCTV HEAD END LOCATIONS              | 0    |
| PS     | PENETRATION SLEEVES                  | 0    |

ACCESS CONTROL W/  
FIRE PROTECTION DOORS:

| CARD READER # | DOOR #   |
|---------------|----------|
| CR-02         | 5.088.02 |
| CR-03         | 5.116.03 |
| CR-18         | 5.028.03 |

DRAWING PREPARED BY:



1511 E. ORANGETHORPE BLVD.  
FULLERTON, CALIFORNIA 92831  
714-525-4350 - o; 714-525-4386 - f  
(c) Copyright 2012 KRATOS | HBE  
All Rights Reserved.

MUST BE SIGNED BY HBE  
TO AUTHENTICATE CONTENT(S).  
ALL DETAILS CHECKED FOR ACCURACY.


SIGNATURE \_\_\_\_\_ DATE \_\_\_\_\_

HBE JOB #

CONFIDENTIAL

THE INFORMATION CONTAINED HERIN MAY  
NOT BE USED OR REPRODUCED IN ANY  
MANNER WITHOUT WRITTEN PERMISSION OF  
KRATOS | HBE.

KEY PLAN

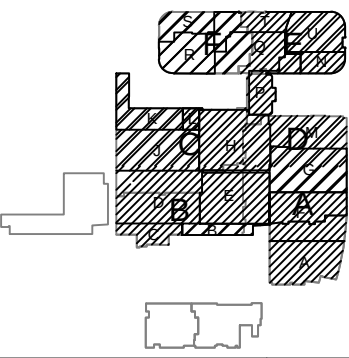

| NO. | REV DESCRIPTION<br>REV DATE | APPROVED BY      |
|-----|-----------------------------|------------------|
| 1.  | AS BUILTS<br>08/15/2012     | JOHN J. CHRISTIE |

| REV. | DESCRIPTION | APPROVED BY |
|------|-------------|-------------|
|------|-------------|-------------|

CUSTOMER:



PROJECT:

CHOC CHILDREN'S  
HOSPITAL  
455 SOUTH MAIN ST.  
ORANGE, CA 92668

DRAWING TITLE:

FIFTH LEVEL  
SECURITY PLAN  
AREA F

| DRN BY  | DATE DRN   | CHK BY | DATE CHK |
|---------|------------|--------|----------|
| JOSH G. | 08/08/2012 | JJC    |          |
| SCALE:  | NTS        |        |          |
| DWG NO. | SE3.05F    |        |          |

ASBUILTS  
08/15/2012

DEVICE LEGEND

| DEVICE | DESCRIPTION                          | QTY. |
|--------|--------------------------------------|------|
| CR     | CARD READER                          | 5    |
| DC     | DOOR CONTACT                         | 5    |
| REX    | REQUEST TO EXIT DEVICE W/ DOOR LOCKS | 5    |
| EL     | ELECTRIFIED LOCK                     | 5    |
| P      | PANIC BUTTON                         | 0    |
| IC     | INTERCOMS                            | 0    |
| EP     | EMERGENCY PHONE                      | 0    |
| FC     | FIXED IP DOME COLOR CAMERA           | 0    |
| PTZ    | PTZ IP DOME COLOR CAMERA             | 0    |
| ACP    | ACCESS CONTROL PANEL                 | 1    |
| CCTV   | CCTV HEAD END LOCATIONS              | 1    |
| PS     | PENETRATION SLEEVES                  | 0    |

SECURITY DEVICE NOTES:

- 1) CARD READER #11, #13B ARE NOT INCLUDED IN DEVICE LEGEND ON THIS SHEET.
- 2) CAMERAS #7 & #8 ARE NOT INCLUDED IN DEVICE LEGEND ON THIS SHEET.

ACCESS CONTROL W/  
FIRE PROTECTION DOORS:

| CARD READER # | DOOR #   |
|---------------|----------|
| CR-02         | 5.088.02 |
| CR-03         | 5.116.03 |
| CR-18         | 5.028.03 |

DRAWING PREPARED BY:



1511 E. ORANGETHORPE BLVD.  
FULLERTON, CALIFORNIA 92831  
714-525-4350 - o; 714-525-4386 - f  
(c) Copyright 2012 KRATOS | HBE  
All Rights Reserved.

MUST BE SIGNED BY HBE  
TO AUTHENTICATE CONTENT(S).  
ALL DETAILS CHECKED FOR ACCURACY.


SIGNATURE \_\_\_\_\_ DATE \_\_\_\_\_

HBE JOB #

CONFIDENTIAL

THE INFORMATION CONTAINED HERIN MAY  
NOT BE USED OR REPRODUCED IN ANY  
MANNER WITHOUT WRITTEN PERMISSION OF  
KRATOS | HBE.

KEY PLAN

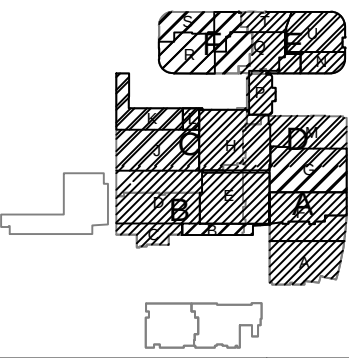

| NO. | REV DESCRIPTION<br>REV DATE | APPROVED BY      |
|-----|-----------------------------|------------------|
| 1.  | AS BUILT<br>08/15/2012      | JOHN J. CHRISTIE |

| REV. | DESCRIPTION | APPROVED BY |
|------|-------------|-------------|
|------|-------------|-------------|

CUSTOMER:



PROJECT:


CHOC CHILDREN'S  
HOSPITAL  
455 SOUTH MAIN ST.  
ORANGE, CA 92668

DRAWING TITLE:

FIFTH LEVEL  
SECURITY PLAN  
AREA G

| DRN BY  | DATE DRN   | CHK BY | DATE CHK |
|---------|------------|--------|----------|
| JOSH G. | 08/08/2012 | JJC    |          |
| SCALE:  | NTS        |        |          |
| DWG NO. | SE3.05G    |        |          |

ASBUILT  
08/15/2012

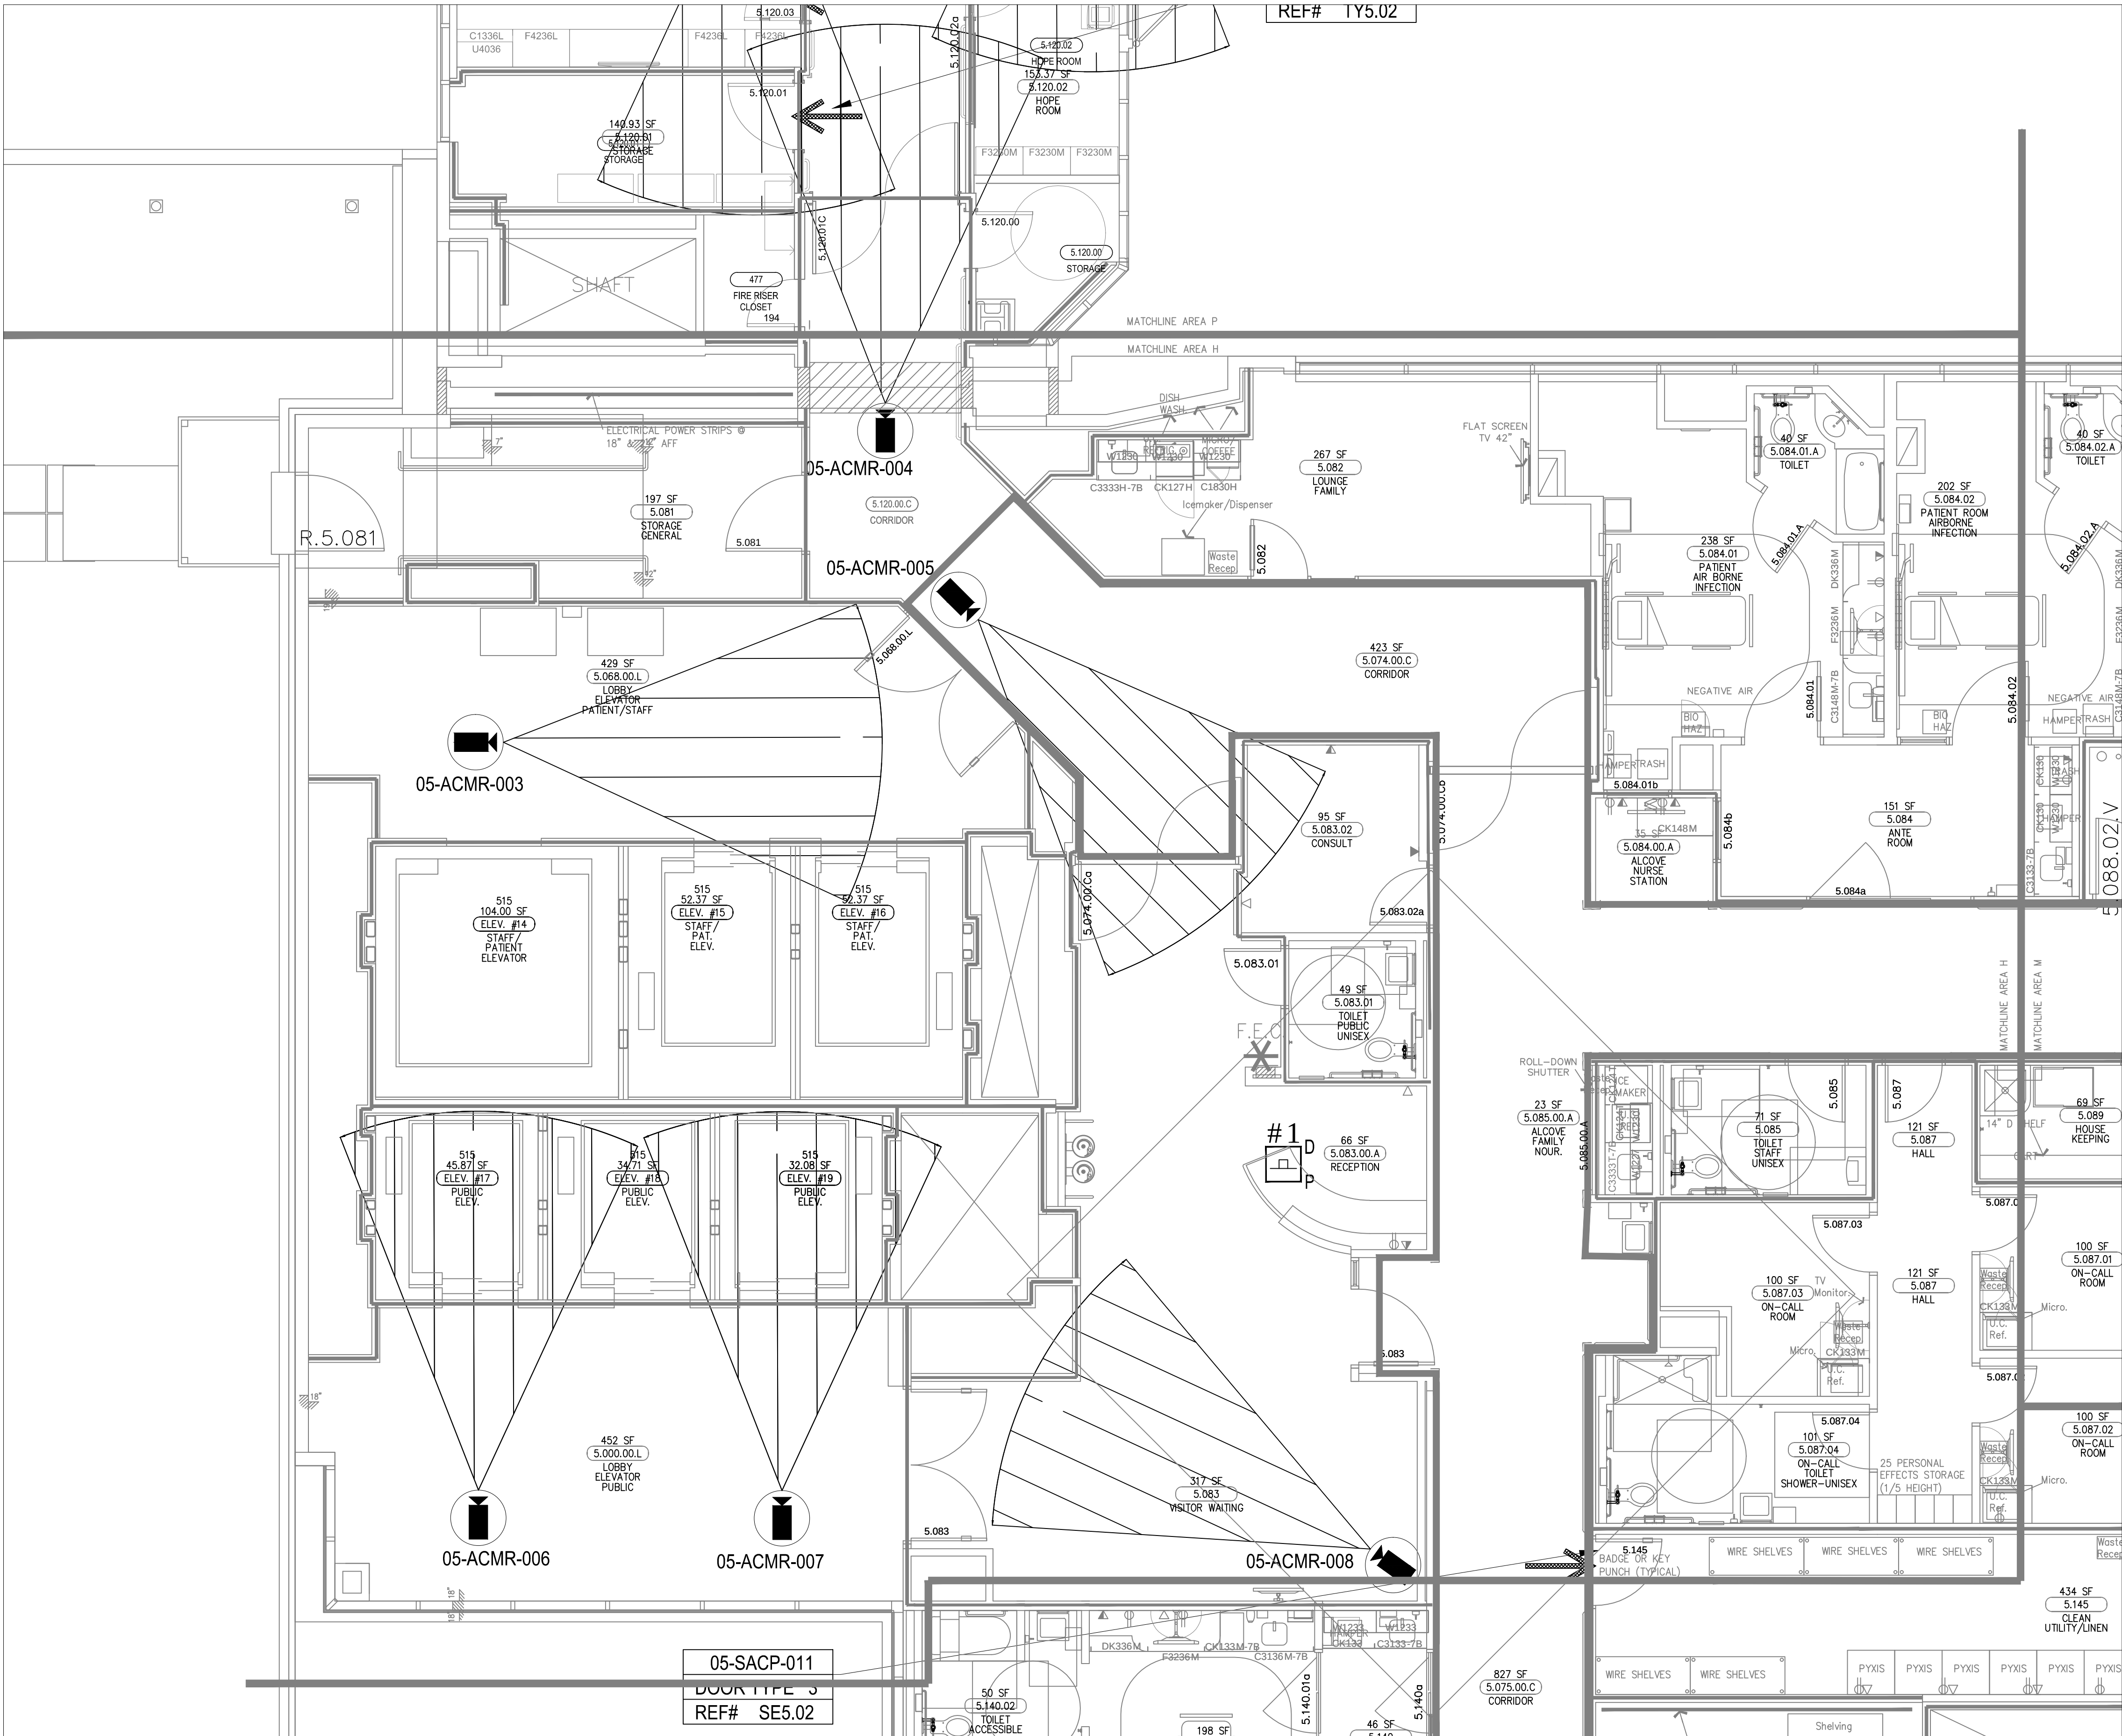

DEVICE LEGEND

| DEVICE | DESCRIPTION                          | QTY. |
|--------|--------------------------------------|------|
| CR     | CARD READER                          | 1    |
| DC     | DOOR CONTACT                         | 1    |
| REX    | REQUEST TO EXIT DEVICE W/ DOOR LOCKS | 1    |
| EL     | ELECTRIFIED LOCK                     | 1    |
| P      | PANIC BUTTON                         | 1    |
| IC     | INTERCOMS                            | 0    |
| EP     | EMERGENCY PHONE                      | 0    |
| FC     | FIXED IP DOME COLOR CAMERA           | 6    |
| PTZ    | PTZ IP DOME COLOR CAMERA             | 0    |
| ACP    | ACCESS CONTROL PANEL                 | 0    |
| CCTV   | CCTV HEAD END LOCATIONS              | 0    |
| PS     | PENETRATION SLEEVES                  | 0    |

ACCESS CONTROL W/  
FIRE PROTECTION DOORS:

| CARD READER # | DOOR #   |
|---------------|----------|
| CR-02         | 5.088.02 |
| CR-03         | 5.116.03 |
| CR-18         | 5.028.03 |

DRAWING PREPARED BY:

**KRATOS**  
**HBE**

1511 E. ORANGETHORPE BLVD.  
FULLERTON, CALIFORNIA 92831  
714-525-4350 - o; 714-525-4386 - f  
(c) Copyright 2012 KRATOS | HBE  
All Rights Reserved.

**MUST BE SIGNED BY HBE  
TO AUTHENTICATE CONTENT(S).  
ALL DETAILS CHECKED FOR ACCURACY.**


SIGNATURE \_\_\_\_\_ DATE \_\_\_\_\_

HBE JOB #

CONFIDENTIAL

THE INFORMATION CONTAINED HERIN MAY  
NOT BE USED OR REPRODUCED IN ANY  
MANNER WITHOUT WRITTEN PERMISSION OF  
KRATOS | HBE.

KEY PLAN

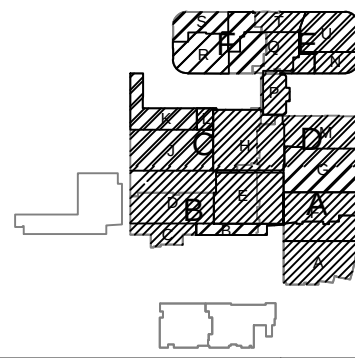

| NO. | REV DESCRIPTION<br>REV DATE | APPROVED BY      |
|-----|-----------------------------|------------------|
| 1.  | AS BUILTS<br>08/15/2012     | JOHN J. CHRISTIE |
|     |                             |                  |
|     |                             |                  |
| REV. | DESCRIPTION | APPROVED BY |
|------|-------------|-------------|
|------|-------------|-------------|

CUSTOMER:

**CHOC**  
Children's Hospital  
of Orange County

PROJECT:


CHOC CHILDREN'S  
HOSPITAL  
455 SOUTH MAIN ST.  
ORANGE, CA 92668

DRAWING TITLE:

FIFTH LEVEL  
SECURITY PLAN  
AREA H

| DRN BY  | DATE DRN   | CHK BY | DATE CHK |
|---------|------------|--------|----------|
| JOSH G. | 08/08/2012 | JJC    |          |
| SCALE:  | NTS        |        |          |
| DWG NO. | SE3.05H    |        |          |

**ASBUILTS**  
**08/15/2012**

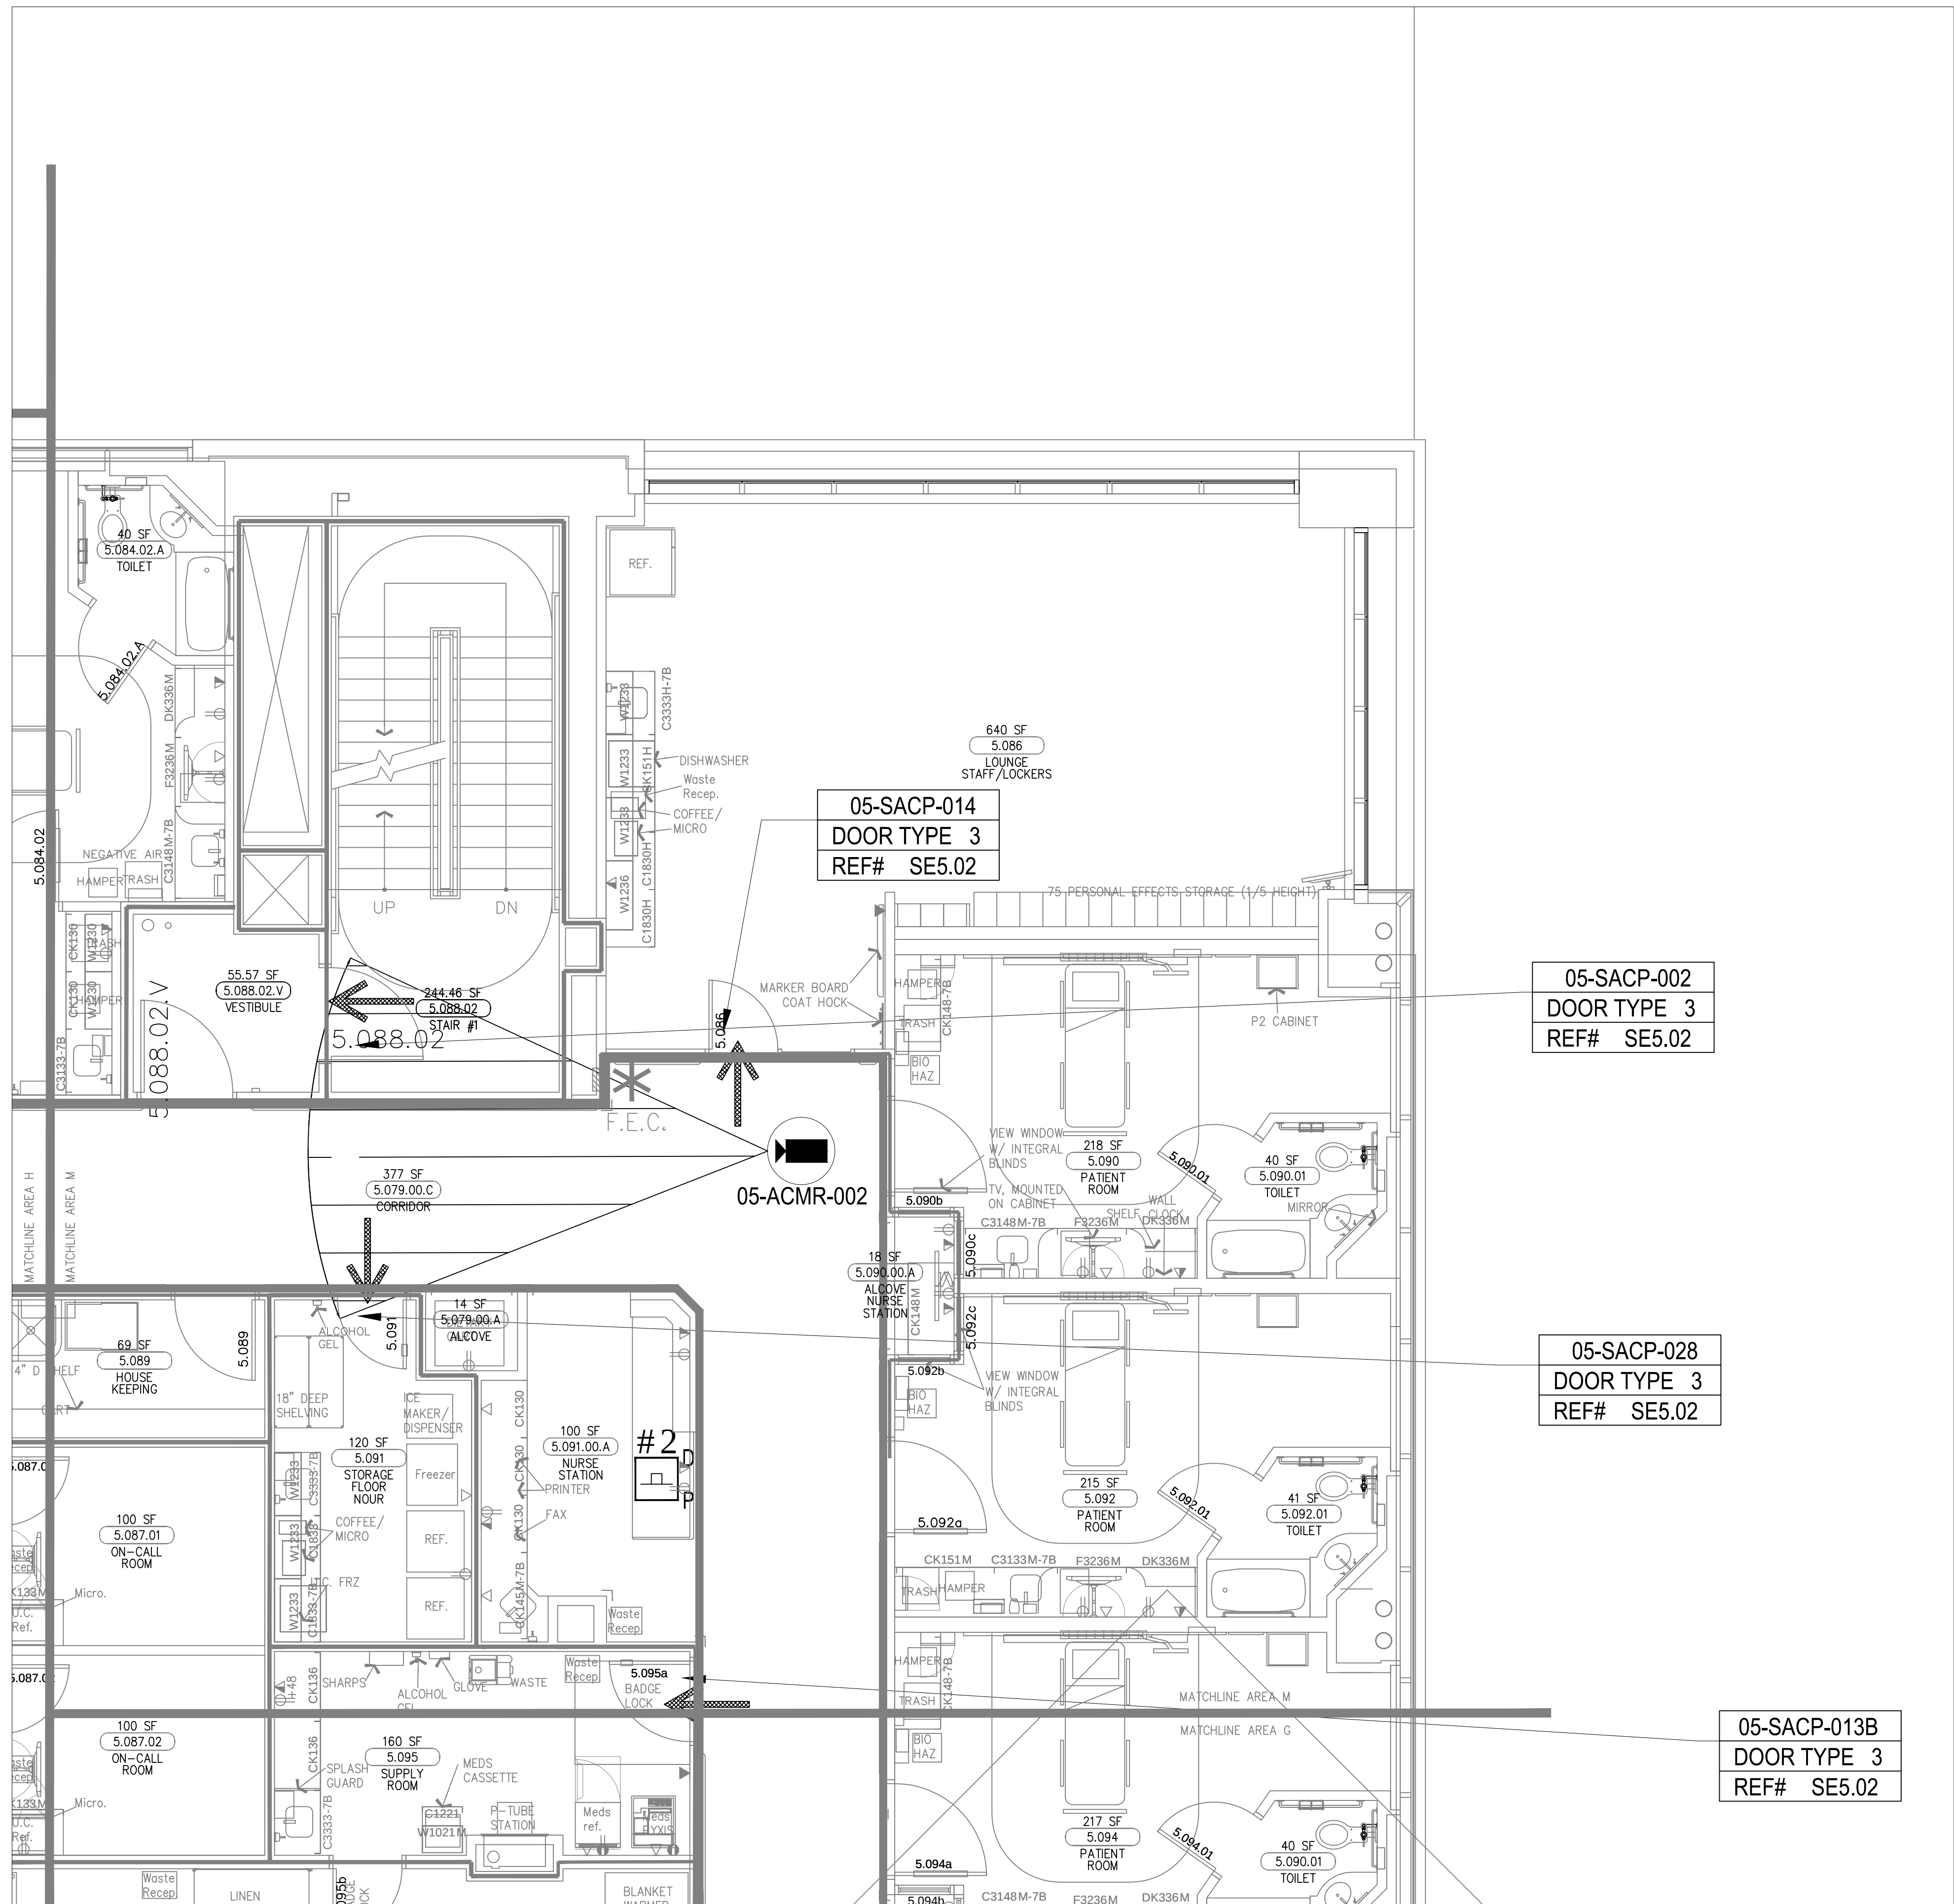

| DEVICE LEGEND |                                      |      |
|---------------|--------------------------------------|------|
| DEVICE        | DESCRIPTION                          | QTY. |
|               | CARD READER                          | 4    |
|               | DOOR CONTACT                         | 4    |
|               | REQUEST TO EXIT DEVICE W/ DOOR LOCKS | 4    |
|               | ELECTRIFIED LOCK                     | 4    |
|               | PANIC BUTTON                         | 1    |
|               | INTERCOMS                            | 0    |
|               | EMERGENCY PHONE                      | 0    |
|               | FIXED IP DOME COLOR CAMERA           | 1    |
|               | PTZ IP DOME COLOR CAMERA             | 0    |
|               | ACCESS CONTROL PANEL                 | 0    |
|               | CCTV HEAD END LOCATIONS              | 0    |
|               | PENETRATION SLEEVES                  | 0    |

ACCESS CONTROL W/  
FIRE PROTECTION DOORS:

| CARD READER # | DOOR #   |
|---------------|----------|
| CR-02         | 5.088.02 |
| CR-03         | 5.116.03 |
| CR-18         | 5.028.03 |

DRAWING PREPARED BY:

1511 E. ORANGETHORPE BLVD.  
FULLERTON, CALIFORNIA 92831  
714-525-4350 - o; 714-525-4386 - f  
(c) Copyright 2012 KRATOS | HBE  
All Rights Reserved.

MUST BE SIGNED BY HBE  
TO AUTHENTICATE CONTENT(S).  
ALL DETAILS CHECKED FOR ACCURACY.

SIGNATURE \_\_\_\_\_ DATE \_\_\_\_\_

HBE JOB # \_\_\_\_\_

CONFIDENTIAL

THE INFORMATION CONTAINED HEREIN MAY  
NOT BE USED OR REPRODUCED IN ANY  
MANNER WITHOUT WRITTEN PERMISSION OF  
KRATOS | HBE.

KEY PLAN

| NO. | REV DESCRIPTION<br>REV DATE | APPROVED BY      |
|-----|-----------------------------|------------------|
| 1.  | AS BUILTS<br>08/15/2012     | JOHN J. CHRISTIE |
|     |                             |                  |
|     |                             |                  |
| REV.                                                                  | DESCRIPTION | APPROVED BY |
|-----------------------------------------------------------------------|-------------|-------------|
| CUSTOMER:                                                             |             |             |
|                                                                       |             |             |
| PROJECT:                                                              |             |             |
| CHOC CHILDREN'S<br>HOSPITAL<br>455 SOUTH MAIN ST.<br>ORANGE, CA 92668 |             |             |
| DRAWING TITLE:                                                        |             |             |
| FIFTH LEVEL<br>SECURITY PLAN<br>AREA M                                |             |             |
| DRN BY                                                                | DATE DRN    | CHK BY      |
| JOSH G.                                                               | 08/08/2012  | JJC         |
| SCALE:                                                                | NTS         |             |
| DWG NO.                                                               | SE3.05M     |             |

ASBUILTS  
08/15/2012

