


<u>ACCESS CONTROL W/ FIRE PROTECTION DOORS:</u>	
<u>CARD READER #</u>	<u>DOOR #</u>
CR-02	7.088.01
CR-03	7.116.02
LEVEL P1 - CR-P1-02	R.088
LEVEL P1 - CR-P1-04	R.087
LEVEL P2 - CR-P2-02	R.002b

<u>CARD READER #</u>	<u>DOOR #</u>
CR-02	7.088.01
CR-03	7.116.02
LEVEL P1 - CR-P1-02	R.088
LEVEL P1 - CR-P1-04	R.087
LEVEL P2 - CR-P2-02	R.002b

CONFIDENTIAL


THE INFORMATION CONTAINED HERIN MAY
NOT BE USED OR REPRODUCED IN ANY
MANNER WITHOUT WRITTEN PERMISSION OF
KRATOS | HBE.

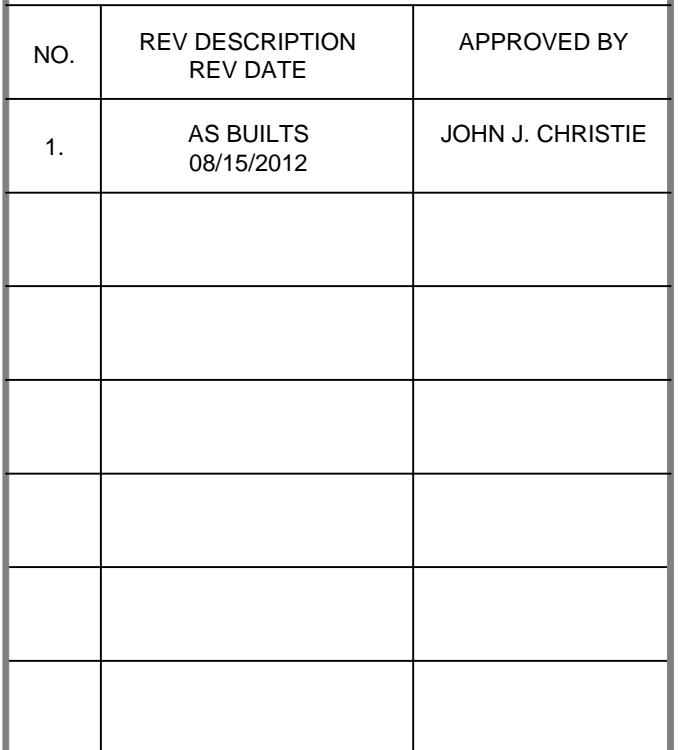








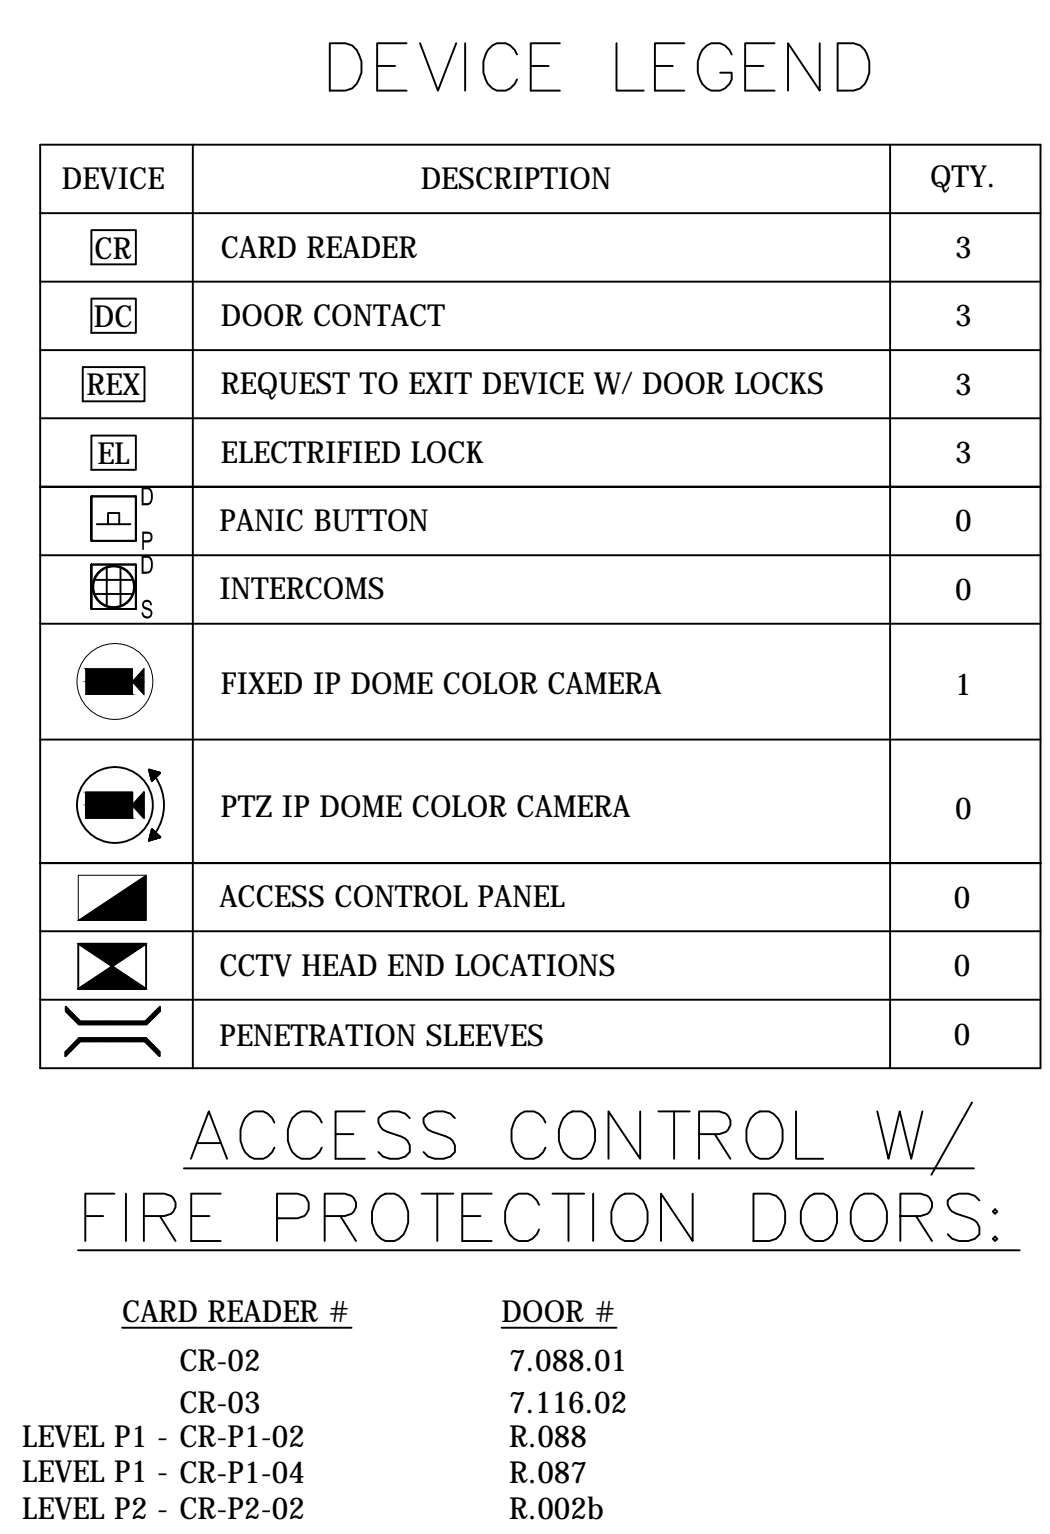



PROJECT:

 CHOC CHILDREN'S
HOSPITAL
455 SOUTH MAIN ST.
ORANGE, CA 92668

DRN BY	DATE DRN	CHK BY	DATE CHK
JOSH G.	08/08/2012	JJC	
SCALE:		NTS	
DWG NO.	SE3.07		



DEVICE	DESCRIPTION	QTY.
	CARD READER	3
	DOOR CONTACT	3
	REQUEST TO EXIT DEVICE W/ DOOR LOCKS	3
	ELECTRIFIED LOCK	3
	PANIC BUTTON	0
	INTERCOMS	0
	FIXED IP DOME COLOR CAMERA	1
	PTZ IP DOME COLOR CAMERA	0
	ACCESS CONTROL PANEL	0
	CCTV HEAD END LOCATIONS	0
	PENETRATION SLEEVES	0

ACCESS CONTROL W/
FIRE PROTECTION DOORS:

<u>CARD READER #</u>	<u>DOOR #</u>
CR-02	7.088.01
CR-03	7.116.02
LEVEL P1 - CR-P1-02	R.088
LEVEL P1 - CR-P1-04	R.087
LEVEL P2 - CR-P2-02	R.002b



**MUST BE SIGNED BY HBE
TO AUTHENTICATE CONTENT(S).
ALL DETAILS CHECKED FOR ACCURACY.**


SIGNATURE _____ DATE _____

HBE JOB #

CONFIDENTIAL

THE INFORMATION CONTAINED HEREIN MAY
NOT BE USED OR REPRODUCED IN ANY
MANNER WITHOUT WRITTEN PERMISSION OF
KRATOS | HBE.

KEY PLAN

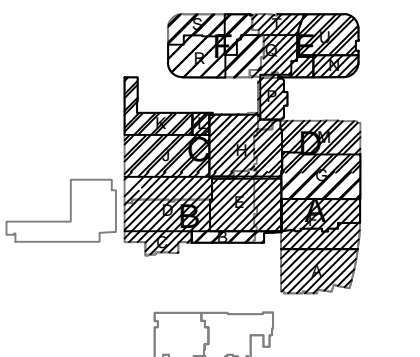

NO.	REV DESCRIPTION REV DATE	APPROVED BY
1.	AS BUILTS 08/15/2012	JOHN J. CHRISTIE
REV.	DESCRIPTION	APPROVED BY

REV.	DESCRIPTION	APPROVED BY
------	-------------	-------------



CHOCSM
Children's Hospital
of Orange County

CHOC CHILDREN'S
HOSPITAL
455 SOUTH MAIN ST.
ORANGE, CA 92668

SEVENTH LEVEL
SECURITY PLAN
AREA A

DRN BY	DATE DRN	CHK BY	DATE CHK
JOSH G.	08/08/2012	JJC	
SCALE:	NTS		
DWG NO.	SE3.07A		


ASBUILTS
08/15/2012

DEVICE LEGEND

DEVICE	DESCRIPTION	QTY.
CR	CARD READER	1
DC	DOOR CONTACT	1
REX	REQUEST TO EXIT DEVICE W/ DOOR LOCKS	1
EL	ELECTRIFIED LOCK	1
P	PANIC BUTTON	0
IS	INTERCOMS	0
FC	FIXED IP DOME COLOR CAMERA	3
PTZ	PTZ IP DOME COLOR CAMERA	0
ACP	ACCESS CONTROL PANEL	1
CCTV	CCTV HEAD END LOCATIONS	1
PS	PENETRATION SLEEVES	0

ACCESS CONTROL W/
FIRE PROTECTION DOORS:

CARD READER #	DOOR #
CR-02	7.088.01
CR-03	7.116.02
LEVEL P1 - CR-P1-02	R.088
LEVEL P1 - CR-P1-04	R.087
LEVEL P2 - CR-P2-02	R.002b

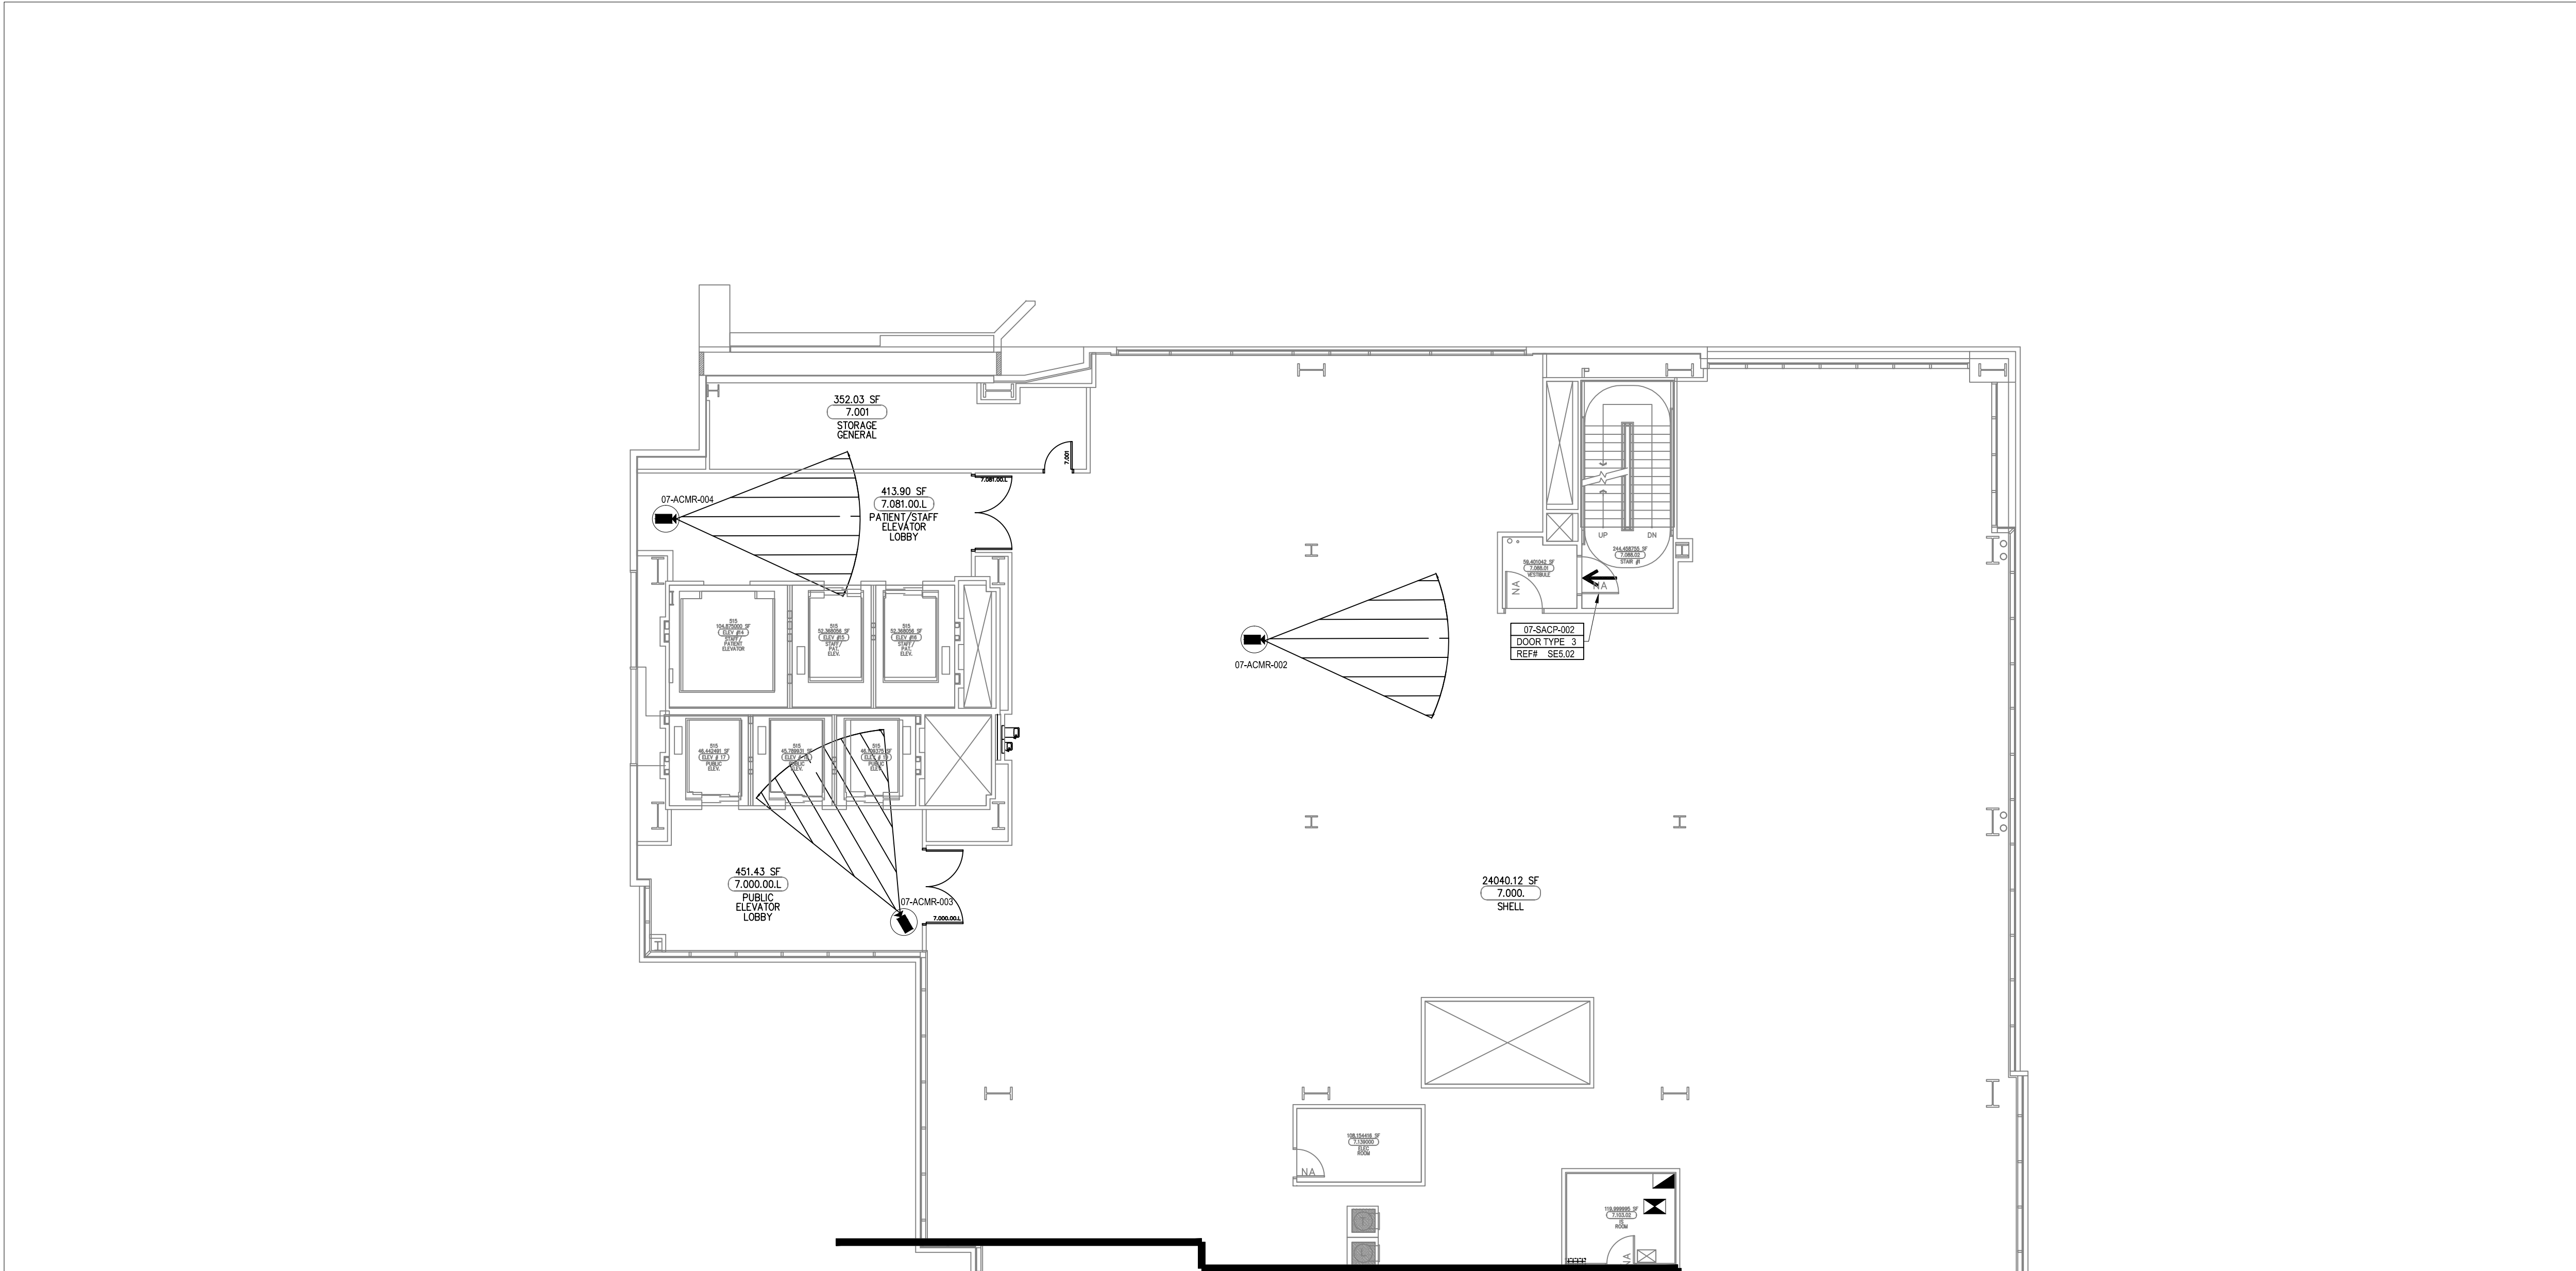

DRAWING PREPARED BY:



1511 E. ORANGETHORPE BLVD.
FULLERTON, CALIFORNIA 92831
714-525-4350 - o; 714-525-4386 - f
(c) Copyright 2012 KRATOS | HBE
All Rights Reserved.

**MUST BE SIGNED BY HBE
TO AUTHENTICATE CONTENT(S).
ALL DETAILS CHECKED FOR ACCURACY.**


SIGNATURE _____ DATE _____

HBE JOB #

CONFIDENTIAL

THE INFORMATION CONTAINED HERIN MAY
NOT BE USED OR REPRODUCED IN ANY
MANNER WITHOUT WRITTEN PERMISSION OF
KRATOS | HBE.

KEY PLAN

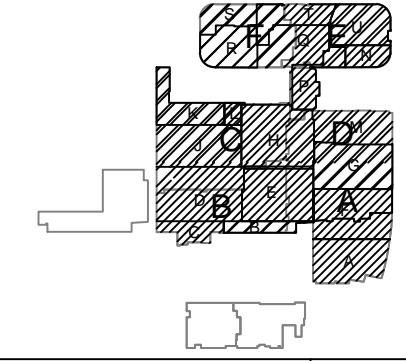

NO.	REV DESCRIPTION REV DATE	APPROVED BY
1.	AS BUILTS 08/15/2012	JOHN J. CHRISTIE

REV.	DESCRIPTION	APPROVED BY
------	-------------	-------------



PROJECT:
CHOC CHILDREN'S
HOSPITAL
455 SOUTH MAIN ST.
ORANGE, CA 92668

DRAWING TITLE:
SEVENTH LEVEL
SECURITY PLAN
AREA D

DRN BY	DATE DRN	CHK BY	DATE CHK
JOSH G.	08/08/2012	JJC	
SCALE:	NTS		
DWG NO.	SE3.07D		

**ASBUILTS
08/15/2012**