



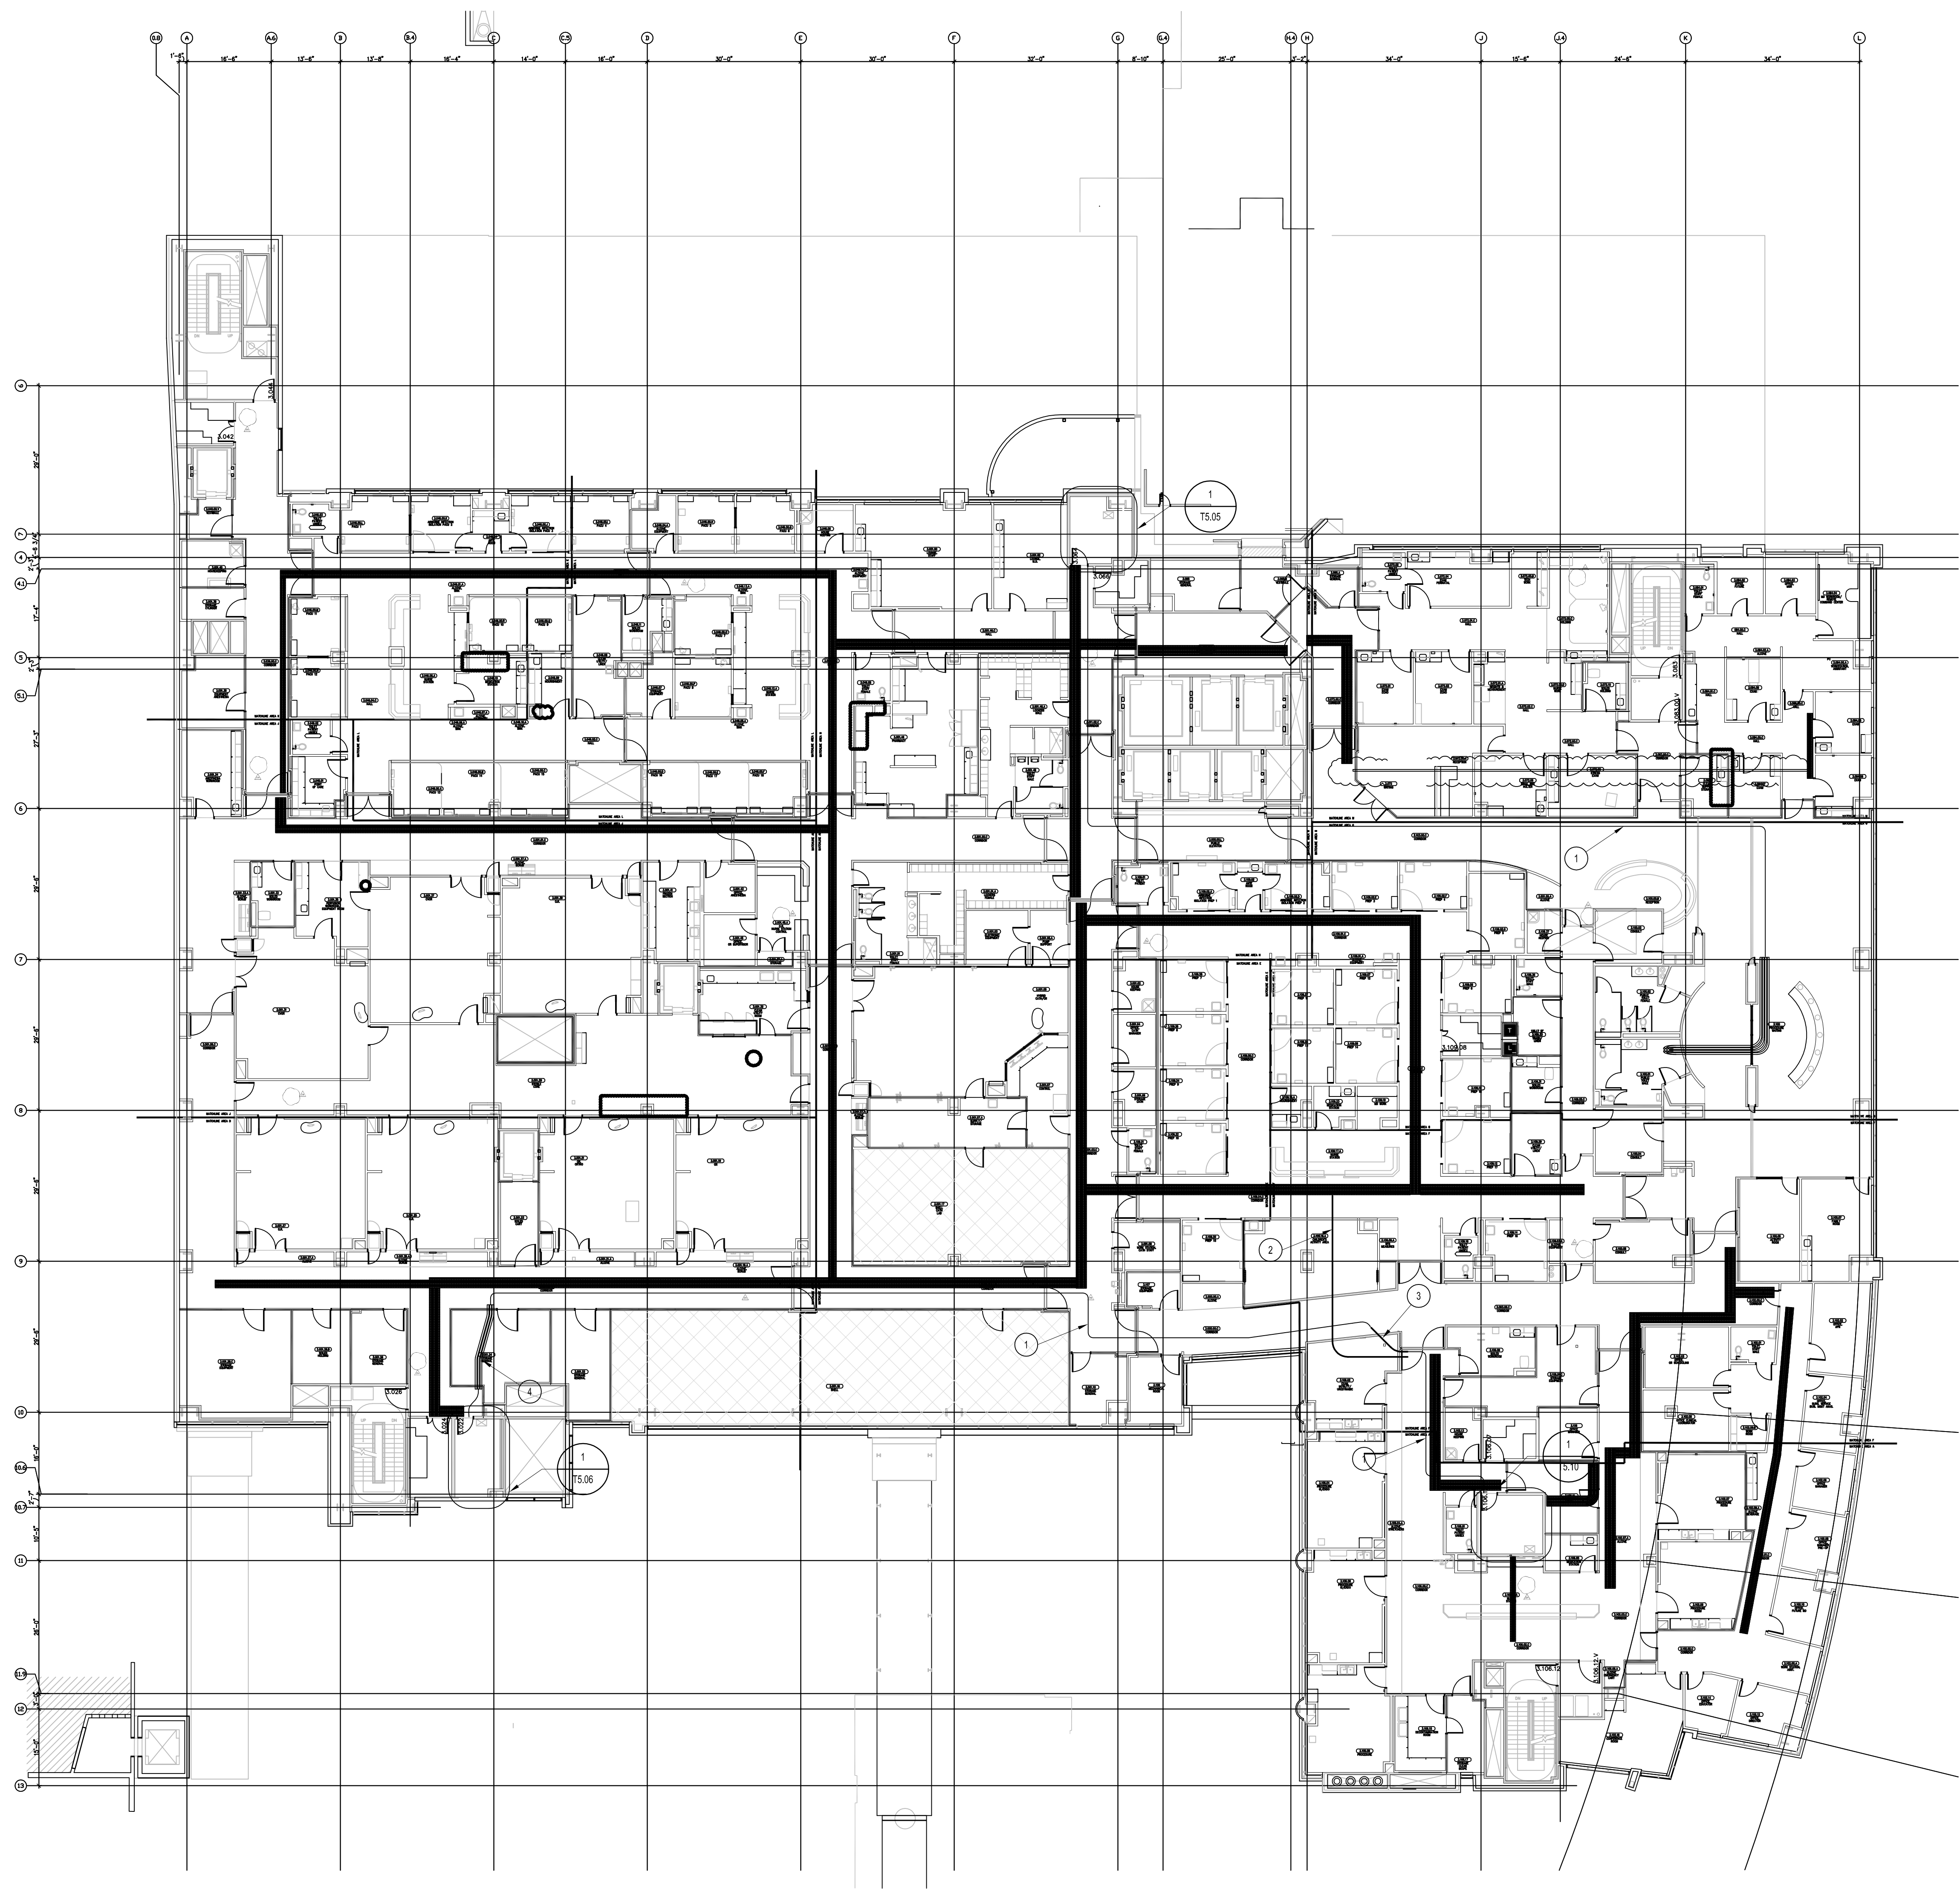

**T1** LEVEL 3 - TELECOM PLAN - OVERALL  
1/16" = 1'-0"

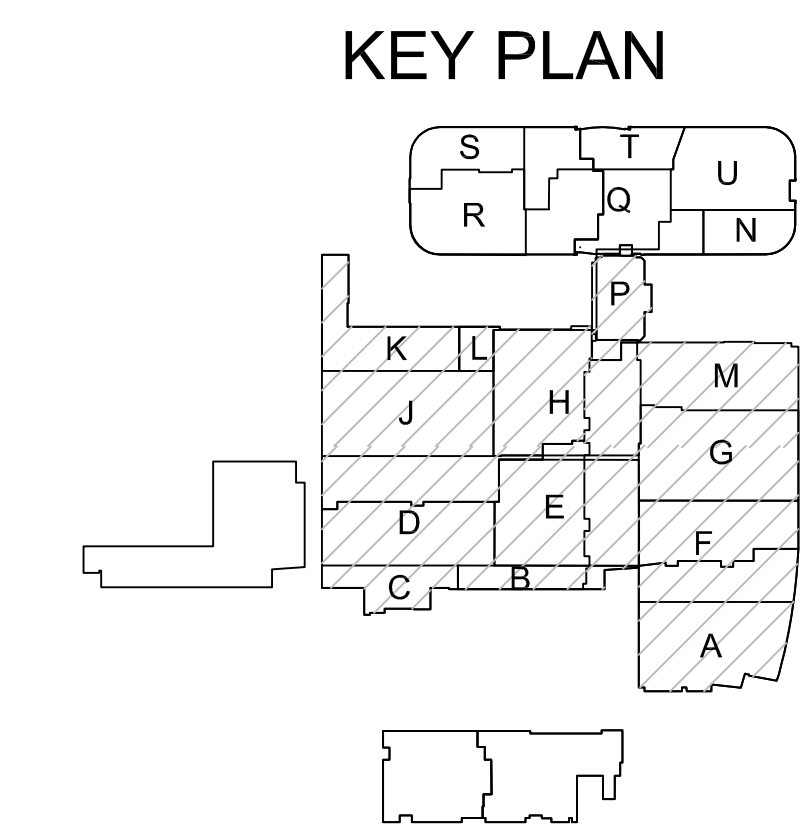

**GENERAL SHEET NOTES**

1. THE DRAWINGS ARE DIAGRAMMATIC ONLY AND MAY NOT SHOW ALL COMPONENTS, MATERIALS, OFFSETS, BENDS, ELBOWS AND OTHER SPECIFIC ELEMENTS THAT MAY BE REQUIRED FOR A COMPLETE INSTALLATION. THE CONTRACTOR SHALL BE RESPONSIBLE FOR PROVIDING ALL MATERIALS NEEDED FOR A COMPLETE AND FUNCTIONAL INSTALLATION.

**SHEET KEYNOTES**

1. CABLE SUPPORT PATHWAY FOR BACKBONE CABLES. SUPPORT UP TO 100 LB/SQ FT OF CABLE RUNWAY CONTENTS.
2. TWELVE 4" CONDUITS.
3. ONE 4" CONDUIT.
4. THREE 4" CONDUITS.

**PROJECT:** CHILDREN'S HOSPITAL  
OF ORANGE COUNTY - TOWER II

**ADDRESS:** 455 South Main Street  
Orange, CA 92668-3874

**W.O. NO.:** 12684

**PROPRIETARY STATEMENT**  
THESE DRAWINGS AND DOCUMENTS HEREON ATTACHED ARE THE PROPERTY OF BERGELECTRIC CORPORATION. ANY REUSE OR REPRODUCTION OF THESE DOCUMENTS WITHOUT WRITTEN PERMISSION OF BERGELECTRIC CORPORATION IS STRICTLY FORBIDDEN. ALL RIGHTS RESERVED.

**DRAWN BY:**  
J. RAMIREZ

**DESIGN SUPERVISOR:**


**INSTALL SUPERVISOR:**  
Scott Adams  
Tel Data Systems  
Bergelectric Corporation  
650 Oppen Street  
Escondido, CA 92029

**REVISION:**  
05-30-12 RECORD DRAWINGS

**SHEET TITLE:**  
TELECOM  
FLOOR PLAN  
LEVEL 3  
OVERALL

**SCALE:**  
1/16"=1'0"

**DRAWING NO.:**  
**T3.3**  
**RECORD  
DRAWING**

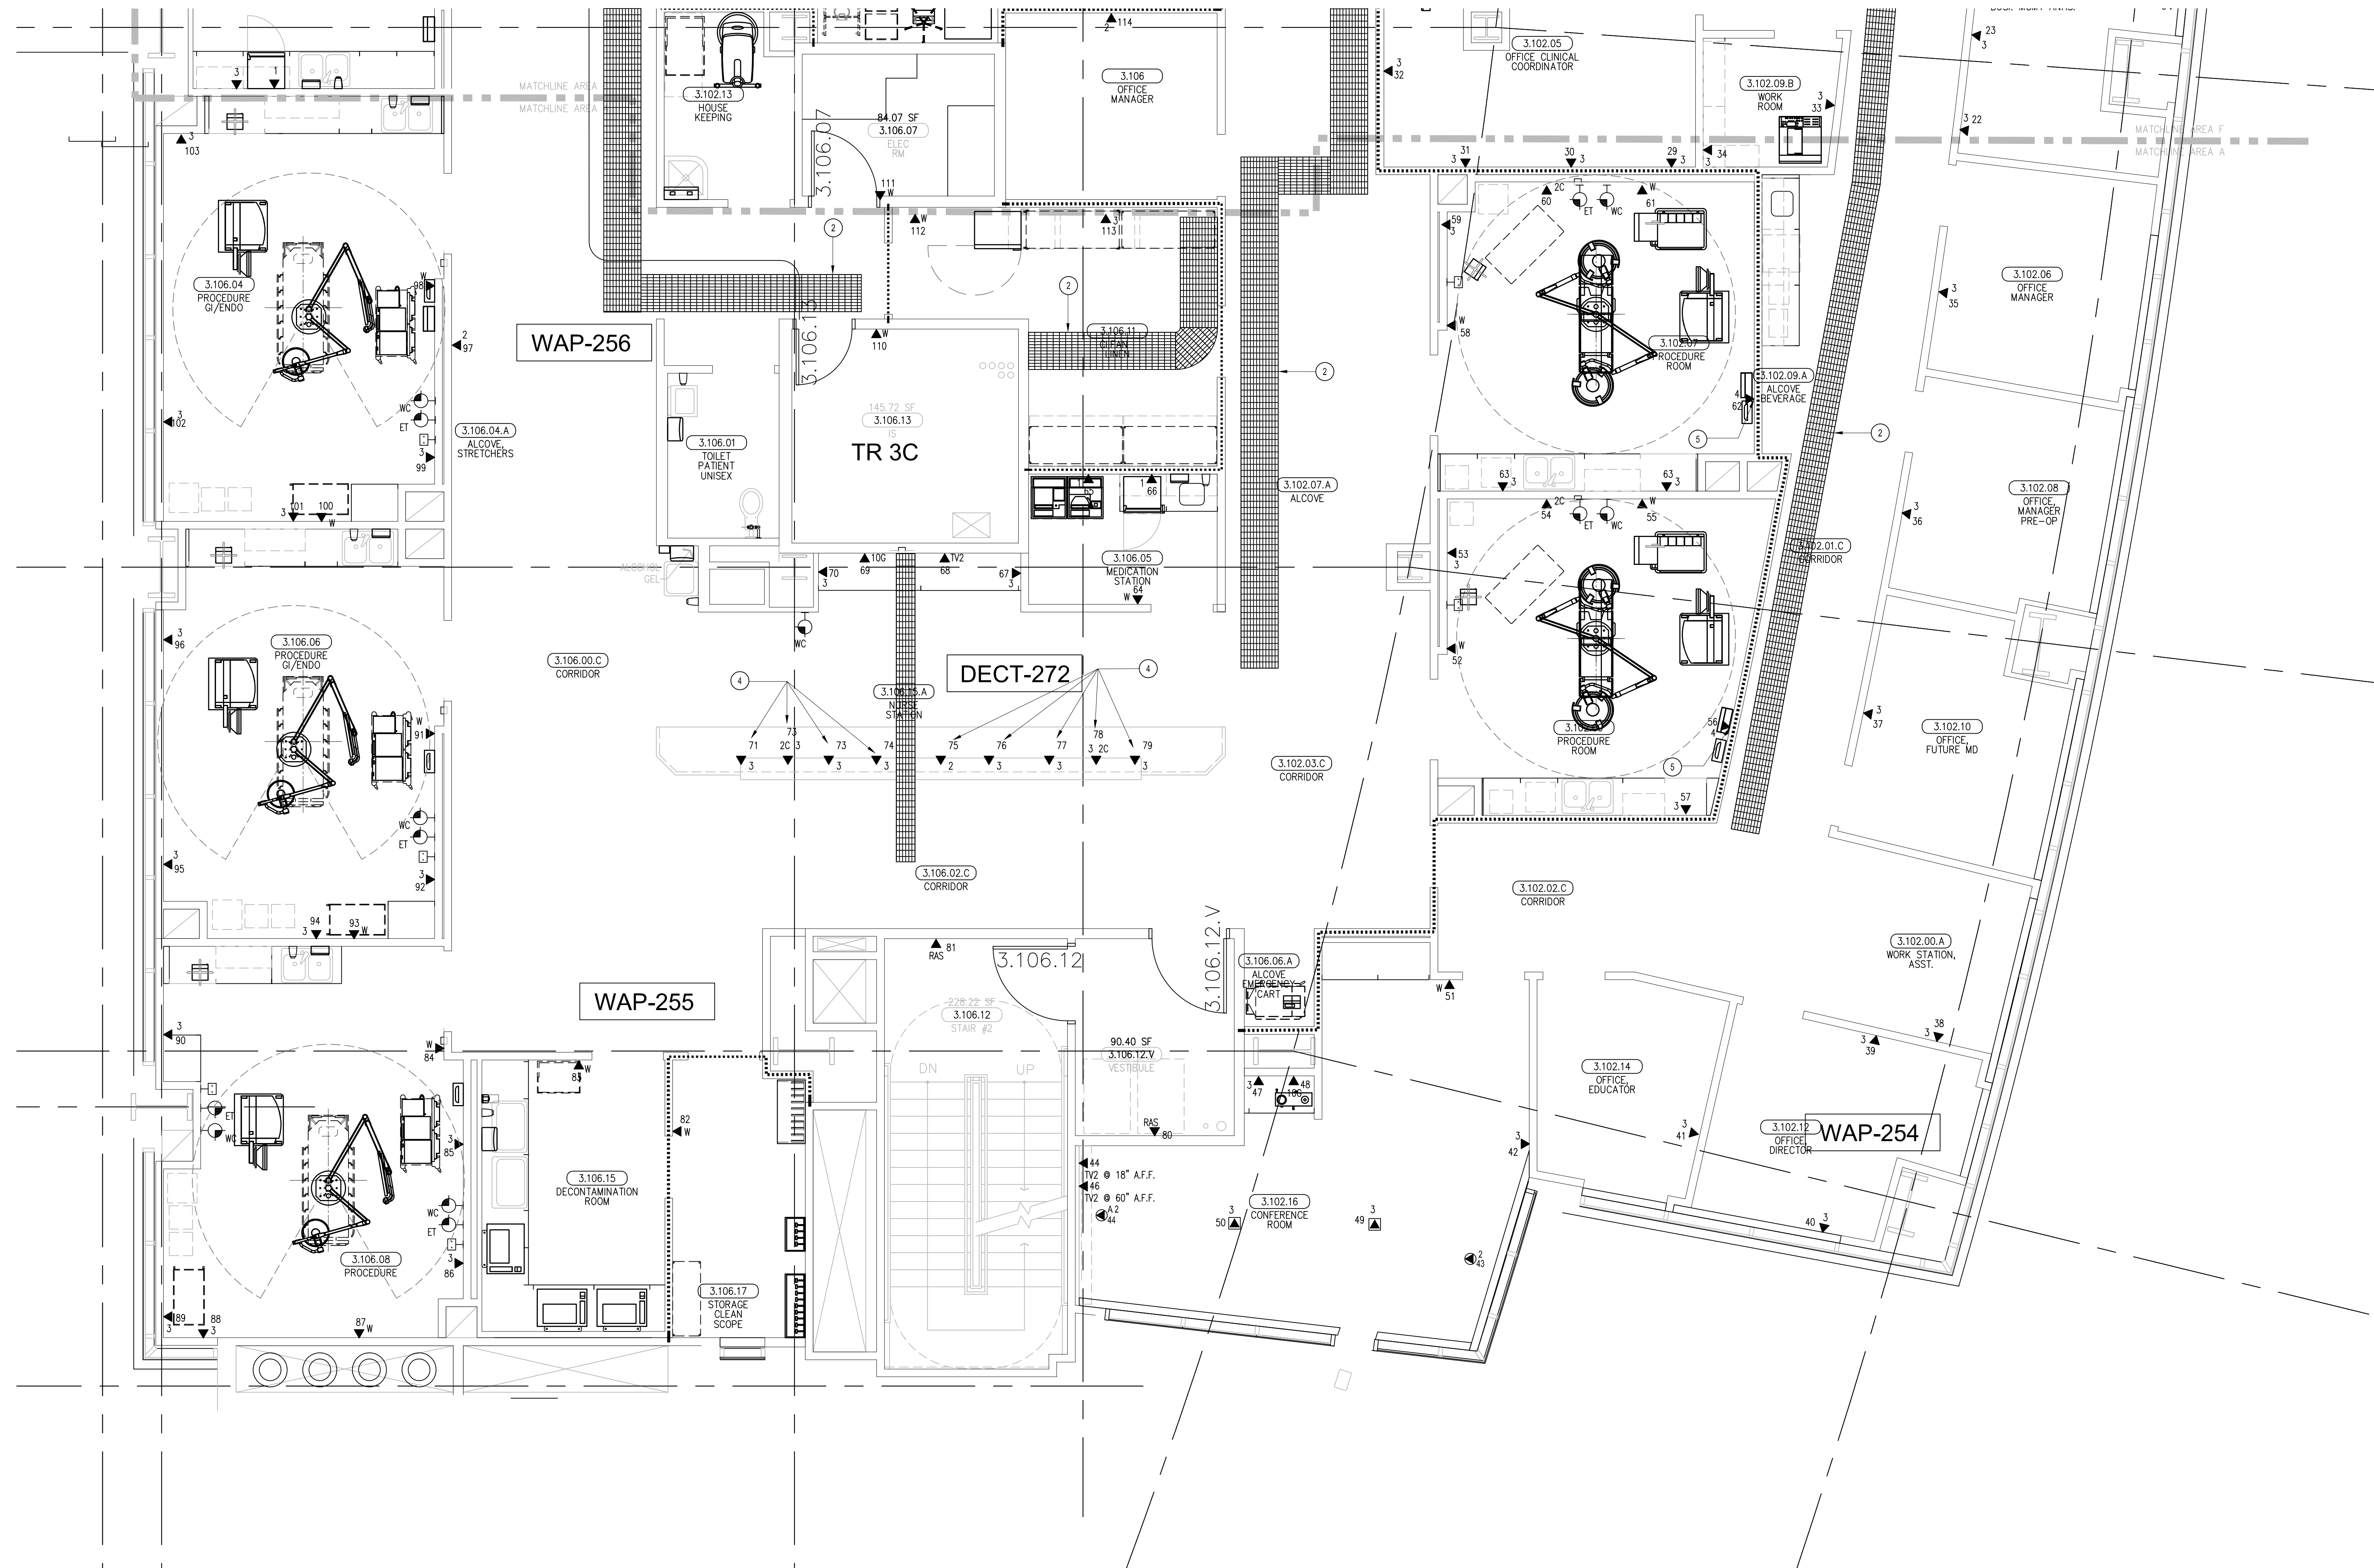

#### SHEET KEYNOTES


- 12" W X 6" H CABLE RUNWAY
- 24" W X 6" H CABLE RUNWAY
- 18" W X 6" H CABLE RUNWAY
- OUTLETS ARE TO BE FED VIA WALL FROM ABOVE CEILING SPACE. PROVIDE TWO (2) 1/4" CONDUITS FROM CABLE RUNWAY TO MILLWORK. TERMINATE CONDUITS AT 24" A.F.F. AND EXTEND ONTO MILLWORK USING NON-METALLIC SURFACE RACEWAYS WITH MINIMUM OF 1"X1" INTERNAL AREA TO EACH OUTLET.
- WORK AREA OUTLET: 3 VOICE/DATA, 1C - CLINICAL NETWORK

#### GENERAL SHEET NOTES

- THE DRAWINGS ARE DIAGRAMMATIC ONLY AND MAY NOT SHOW ALL COMPONENTS, MATERIALS, OFFSETS, BENDS, ELBOWS AND OTHER SPECIFIC ELEMENTS THAT MAY BE REQUIRED FOR A COMPLETE INSTALLATION. THE CONTRACTOR SHALL BE RESPONSIBLE FOR PROVIDING ALL MATERIALS NEEDED FOR A COMPLETE AND FUNCTIONAL INSTALLATION.
- ELECTRIC EQUIPMENT AND DEVICES (E.G. PBX, NETWORK SWITCHES) ARE SHOWN FOR REFERENCE ONLY.
- REFER TO ARCHITECTURAL DETAIL PLANS FOR FINAL PATIENT ROOM DEVICE LOCATIONS. REFER TO ARCHITECTURAL DETAILS FOR OVERCOUNTER WAO HEIGHTS. REFER TO ARCHITECTURAL DETAILS FOR WALL MOUNT WAO HEIGHTS.
- HORIZONTAL DATA/VOICE/VIDEO CABLE SHALL TERMINATE IN THE TECHNOLOGY ROOM ON THE SAME FLOOR AS THE WORK AREA OUTLETS.
- WORK AREA OUTLETS SHALL CONSIST OF SINGLE PLASTER REDUCING RINGS INSTALLED ON OVERSIZE DOUBLE GANG BACKBOXES, UNLESS OTHERWISE NOTED.
- TV COAX CABLES SHALL BE COILED IN THE RESPECTIVE TECHNOLOGY ROOMS WITH A 20' SERVICE LOOP PRIOR TO TERMINATIONS. COILS SHALL BE SECURED TO THE AUDIOVISUAL WALL FIELD FOR AV CONTRACTOR.

- COMMON LOW VOLTAGE CABLE RUNWAY IS 24" W X 6" H HIGH. PROVIDE ALL MATERIALS AS NEEDED FOR A COMPLETE, MANUFACTURER-APPROVED SYSTEM USING CABLE TRAY MANUFACTURERS' MATERIALS AND PARTS WHEN AVAILABLE FROM THE MANUFACTURER AND AS INTENDED. REFER TO DRAWING T4.01 FOR DETAILS. ALL CHANGES IN DIRECTION AND INTERSECTIONS SHALL USE PRE-MANUFACTURED OR FIELD-INSTALLED SWEEPS AND TEES. ALL SWEEPS AND TEES SHALL MAINTAIN A 1' FOOT MINIMUM RADIUS IN CHANGES OF DIRECTION.
- CABLE TRAY SHALL NOT PENETRATE WALLS. PROVIDE TRANSITION FROM CABLE TRAY TO LISTED FIRESTOP ASSEMBLIES IN ORDER TO PENETRATE FIRE/SMOKE WALLS. TRANSITION TO 4" CONDUITS/SLEEVES FOR NON-RATED WALLS. PROVIDE SUFFICIENT CONDUITS/SLEEVES TO ACCOMMODATE 100% VISUAL CABLE TRAY LOAD AT 30% VISUAL CONDUIT FILL.
- REFER TO ELECTRICAL DRAWINGS & SPECIFICATIONS FOR SHARED FLOOR BOXES & LOW VOLTAGE CONDUIT.
- PROVIDE BRACING TO MEET OSHPD SEISMIC REQUIREMENTS. REFER TO SHEET T4.02 FOR MORE INFORMATION.
- PROVIDE ALL OUTLET CONDUITS FROM WORK AREA OUTLETS, DEVICES OR PULL BOXES TO NEAREST CABLE TRAY.
- INSTALL CABLE TRAY @ 8" ABOVE CEILING.

#### KEY PLAN

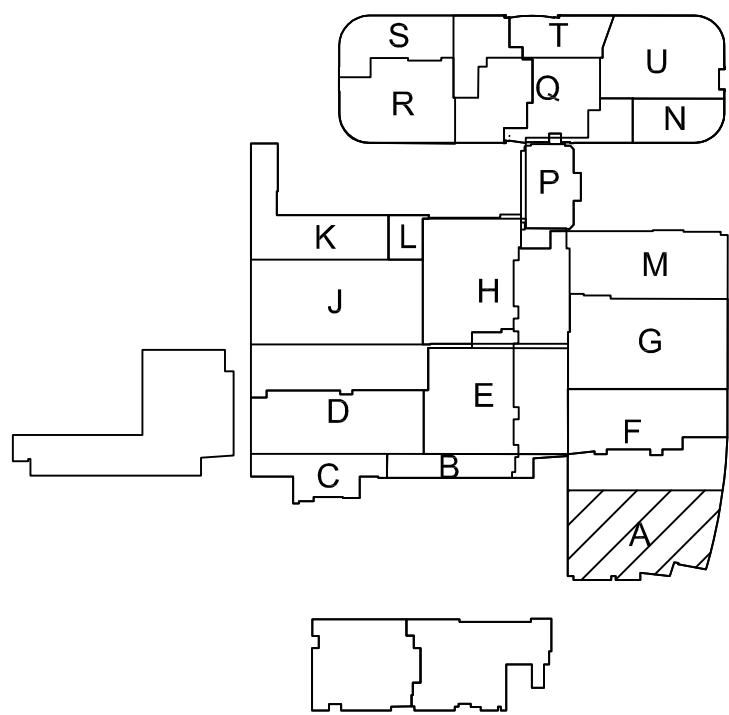

## CHILDREN'S HOSPITAL OF ORANGE COUNTY - TOWER II

PROJECT:  
ADDRESS:  
W.O. NO.:

PROPRIETARY STATEMENT  
THESE DRAWING DOCUMENTS HEREBY ATTACHED ARE THE PROPERTY OF BERGELECTRIC CORPORATION ANY REUSE OR REPRODUCTION OF THESE DOCUMENTS WITHOUT WRITTEN PERMISSION OF BERGELECTRIC CORPORATION IS STRICTLY FORBIDDEN. ALL RIGHTS RESERVED.

DRAWN BY:  
J. RAMIREZ

DESIGN SUPERVISOR:

INSTALL SUPERVISOR:  
Scott Adams  
Tel Data Systems  
Bergelectric Corporation  
650 Oppen Street  
Escondido, CA 92029

REVISIONS:  
05-30-12 RECORD DRAWINGS

SHEET TITLE:


TELECOM  
FLOOR PLAN  
LEVEL 3  
AREA-A

SCALE:  
1/4"=1'0"

DRAWING NO.:

T3.3A  
RECORD  
DRAWING


Bergelectric Corp.  
Contractors & Engineers

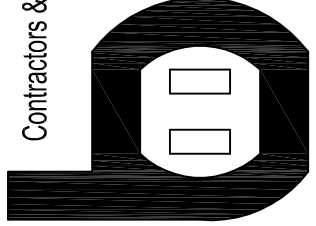

AC 10-485046  
1760 74E-1033  
650 OPPEN ST.  
ESCONDIDO, CA 92029  
FAX (760) 74E-4619

T3 LEVEL 3 - TELECOM PLAN - AREA A

1/4" = 1'-0"

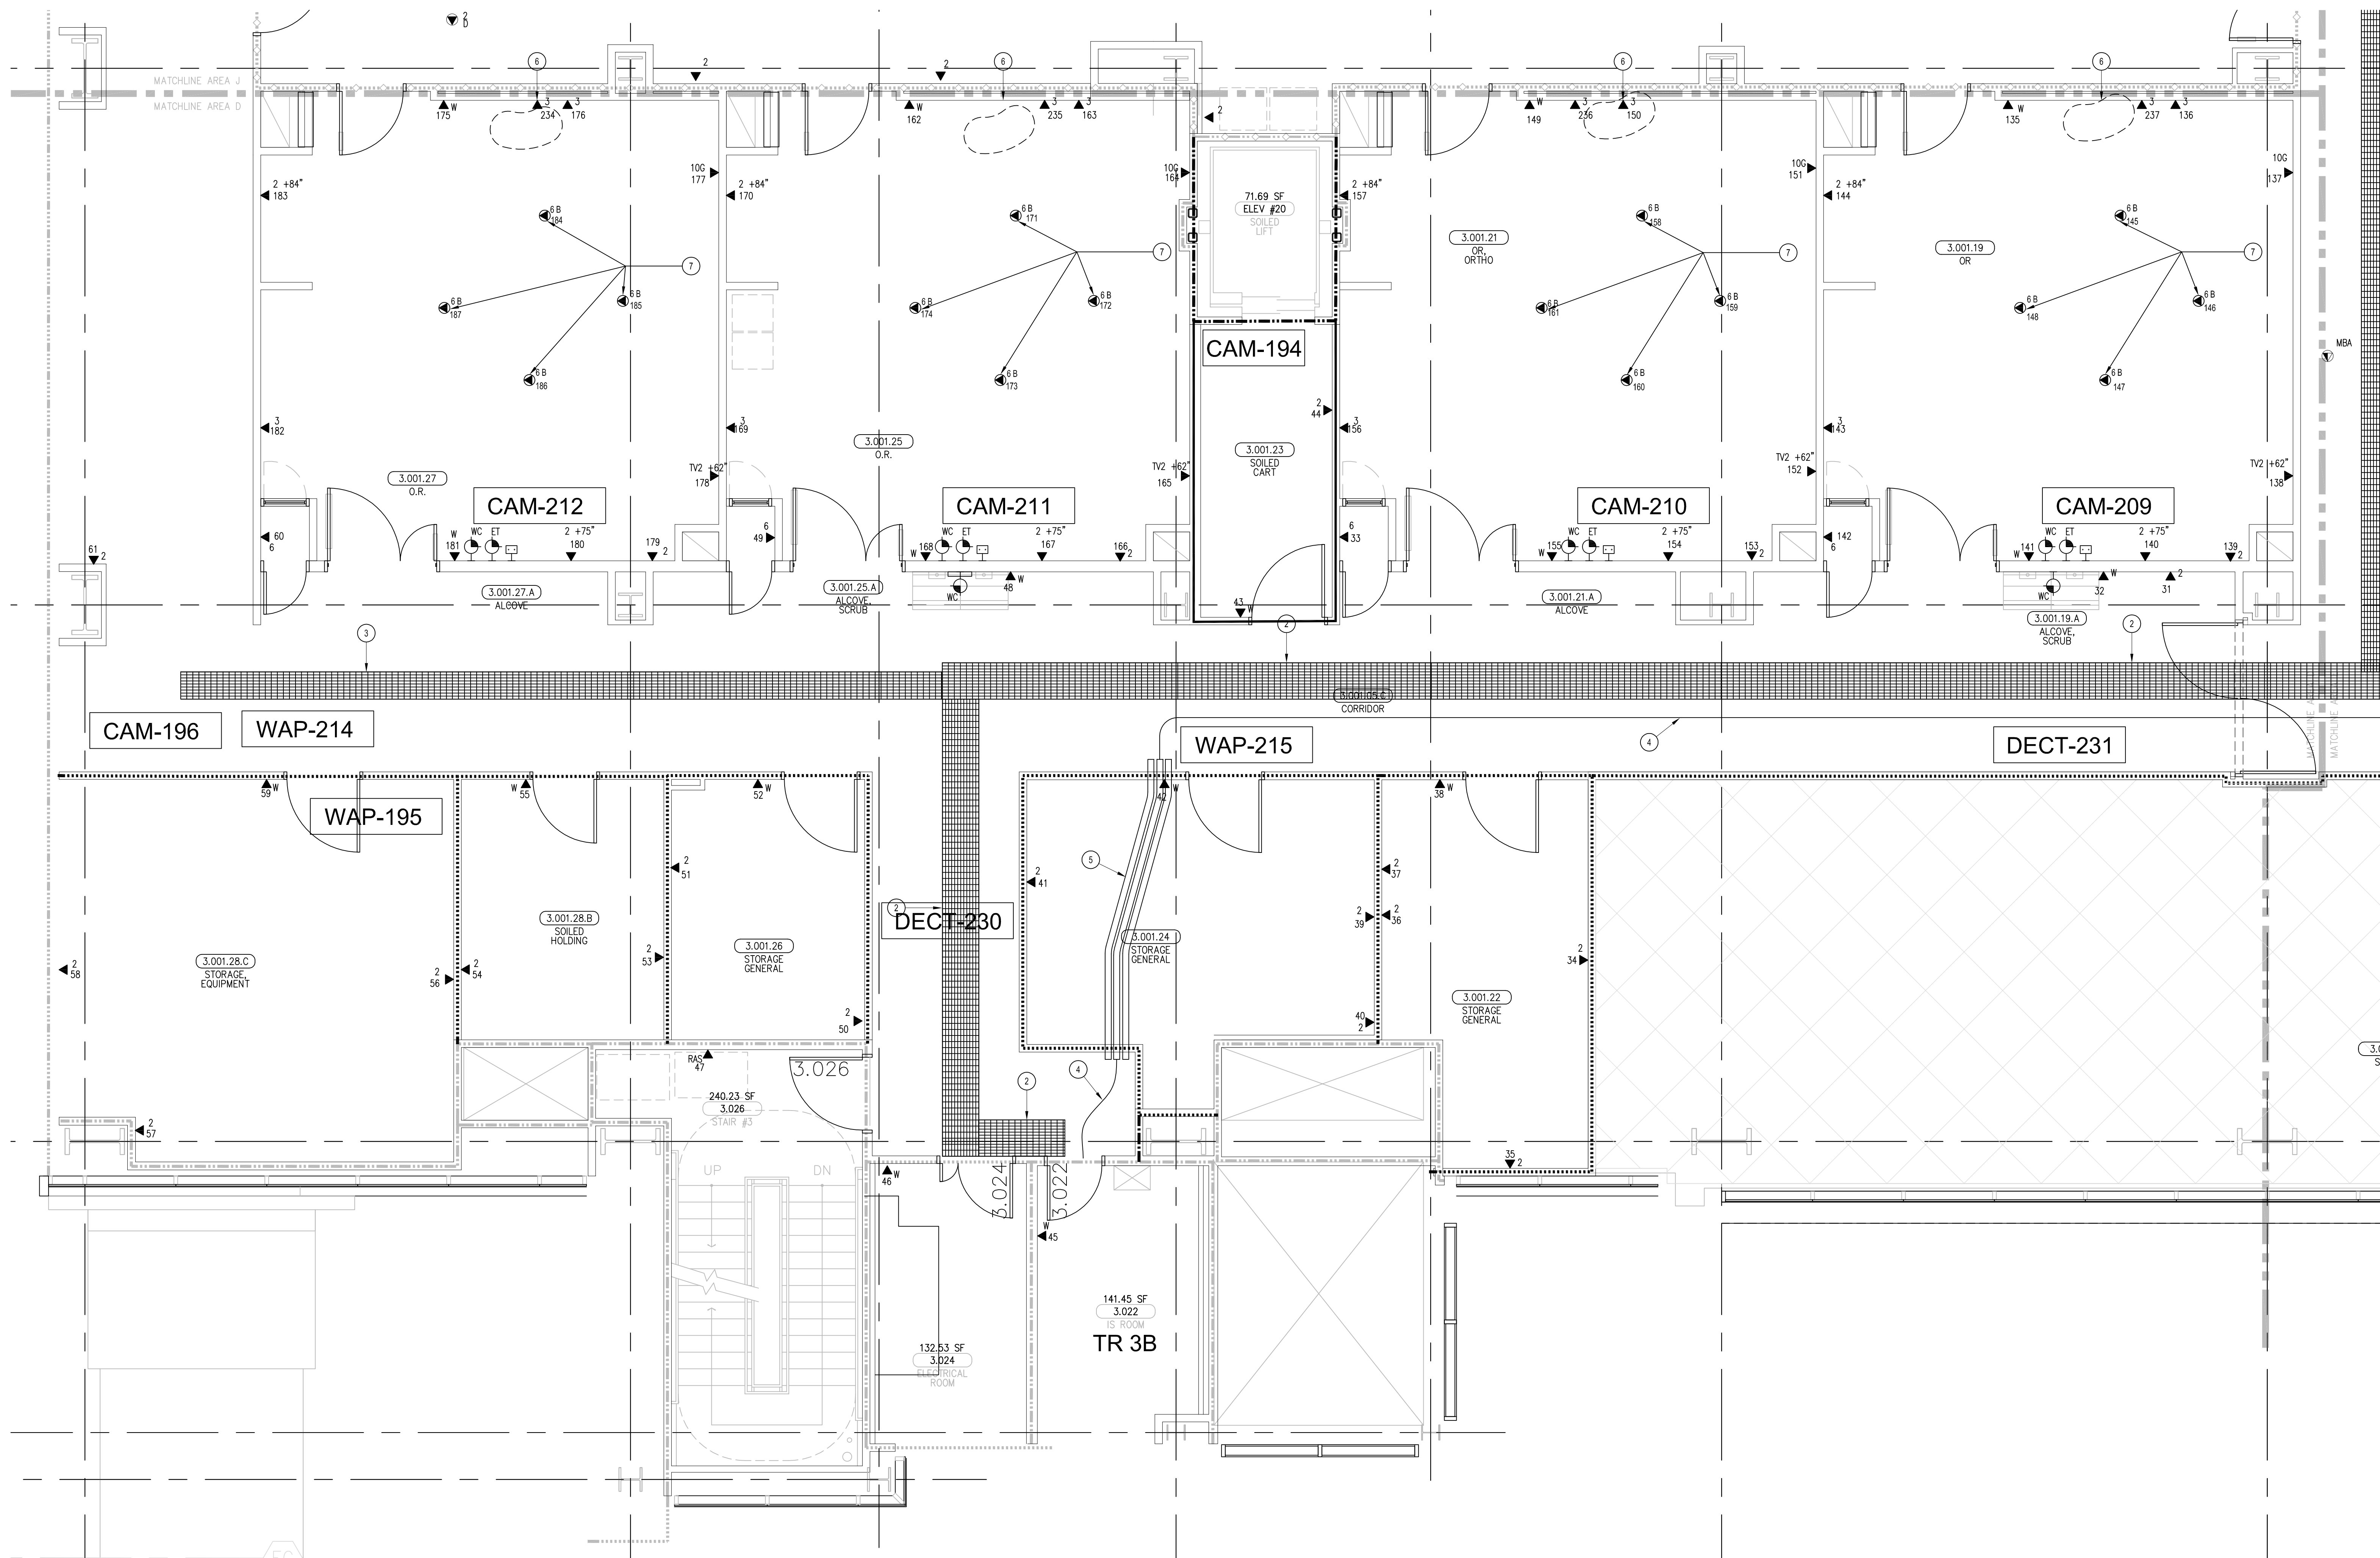


#### SHEET KEYNOTES

- 12" W X 6" H CABLE RUNWAY
- 24" W X 6" H CABLE RUNWAY
- 18" W X 6" H CABLE RUNWAY
- CABLE SUPPORT PATHWAY FOR BACKBONE CABLES
- THREE 4" CONDUITS
- 3 PORT WORK AREA OUTLET @ 2-VOICEDATA, 1C - CLINICAL NETWORK
- 6 PORT WORK AREA OUTLET @ CEILING BOOM: 5-VOICEDATA, 1C - CLINICAL NETWORK

#### GENERAL SHEET NOTES


- THE DRAWINGS ARE DIAGRAMMATIC ONLY AND MAY NOT SHOW ALL COMPONENTS, MATERIALS, OFFSETS, BENDS, ELBOWS AND OTHER SPECIFIC ELEMENTS THAT MAY BE REQUIRED FOR A COMPLETE INSTALLATION. THE CONTRACTOR SHALL BE RESPONSIBLE FOR PROVIDING ALL MATERIALS NEEDED FOR A COMPLETE AND FUNCTIONAL INSTALLATION.
- ELECTRIC EQUIPMENT AND DEVICES (E.G. PBX, NETWORK SWITCHES) ARE SHOWN FOR REFERENCE ONLY.
- REFER TO ARCHITECTURAL DETAIL PLANS FOR FINAL PATIENT ROOM DEVICE LOCATIONS. REFER TO ARCHITECTURAL DETAILS FOR OVERCOUNTER WAO HEIGHTS. REFER TO ARCHITECTURAL DETAILS FOR WALL-MOUNT WAO HEIGHTS.
- HORIZONTAL DATA/VOICE/VIDEO CABLE SHALL TERMINATE IN THE TECHNOLOGY ROOM ON THE SAME FLOOR AS THE WORK AREA OUTLETS.
- WORK AREA OUTLETS SHALL CONSIST OF SINGLE PLASTER REDUCING RINGS INSTALLED ON OVERSIZE DOUBLE GANG BACKBOXES, UNLESS OTHERWISE NOTED.
- TV COAX CABLES SHALL BE COILED IN THE RESPECTIVE TECHNOLOGY ROOMS WITH A 20' SERVICE LOOP PRIOR TO TERMINATIONS. COILS SHALL BE SECURED TO THE AUDIOVISUAL WALL FIELD FOR AV CONTRACTOR.
- COMMON LOW VOLTAGE CABLE RUNWAY IS 24" W X 6" H HIGH. PROVIDE ALL MATERIALS AS NEEDED FOR A COMPLETE, MANUFACTURER-APPROVED SYSTEM USING CABLE TRAY MANUFACTURERS' MATERIALS AND PARTS WHEN AVAILABLE FROM THE MANUFACTURER AND AS INTENDED. REFER TO DRAWING T4.01 FOR DETAILS. ALL CHANGES IN DIRECTION AND INTERSECTIONS SHALL USE PRE-MANUFACTURED OR FIELD-INSTALLED SWEEPS AND TEES. ALL SWEEPS AND TEES SHALL MAINTAIN A 1 FOOT MINIMUM RADIUS IN CHANGES OF DIRECTION.
- CABLE TRAY SHALL NOT PENETRATE WALLS. PROVIDE TRANSITION FROM CABLE TRAY TO LISTED FIRESTOP ASSEMBLIES IN ORDER TO PENETRATE FIRESTOP WALLS. TRANSITION TO 4" CONDUITS/SLEEVES FOR NON-RATED WALLS. PROVIDE SUFFICIENT CONDUITS/SLEEVES TO ACCOMMODATE 100% VISUAL CABLE TRAY LOAD AT 50% VISUAL CONDUIT FILL.
- REFER TO ELECTRICAL DRAWINGS & SPECIFICATIONS FOR SHARED FLOOR BOXES & LOW VOLTAGE CONDUIT.
- PROVIDE BRACING TO MEET OSHPP SEISMIC REQUIREMENTS. REFER TO SHEET T4.02 FOR MORE INFORMATION.
- PROVIDE ALL OUTLET CONDUITS FROM WORK AREA OUTLETS, DEVICES OR PULL BOXES TO NEAREST CABLE TRAY.
- INSTALL CABLE TRAY @ 8" ABOVE CEILING.

#### KEY PLAN

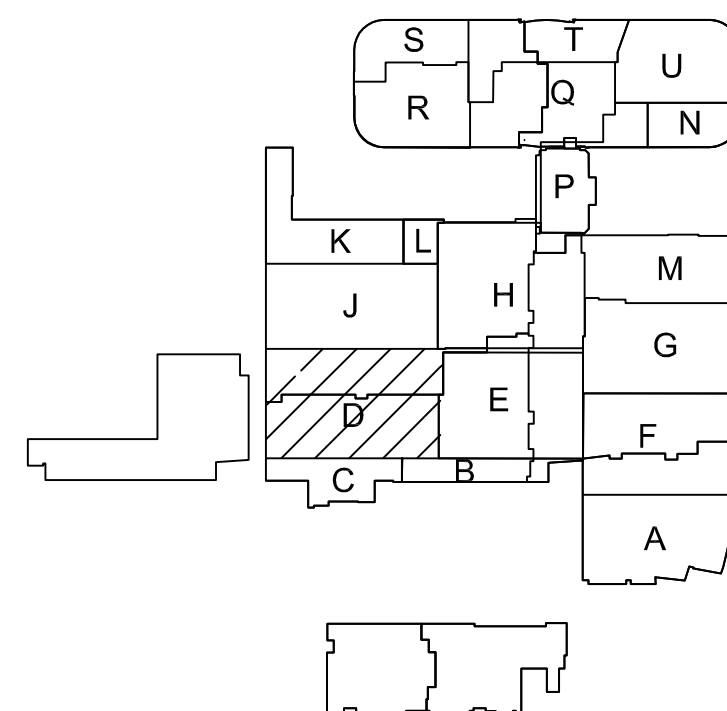

**T3** LEVEL 3 - TELECOM PLAN - AREA D  
1/4" = 1'-0"

Bergelectric Corp.  
Contractors & Engineers

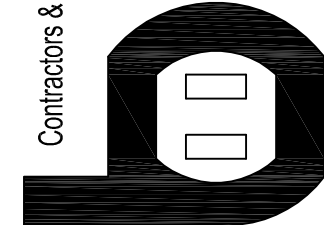

HC10-485046  
650 UPPER ST.  
ESCONDIDO, CA 92029  
(760) 746-1033  
FAX (760) 746-4619

**PROJECT:**  
CHILDREN'S HOSPITAL  
OF ORANGE COUNTY - TOWER II

**ADDRESS:**  
455 South Main Street  
Orange, CA 92668-3874  
12684

**W.O. NO.:**

**PROPRIETARY STATEMENT**  
THESE DRAWING DOCUMENTS HEREIN ATTACHED ARE THE PROPERTY OF BERGELECTRIC CORPORATION. ANY REUSE OR REPRODUCTION OF THESE DOCUMENTS WITHOUT WRITTEN PERMISSION OF BERGELECTRIC CORPORATION IS STRICTLY FORBIDDEN. ALL RIGHTS RESERVED.

**DRAWN BY:**  
J. RAMIREZ

**DESIGN SUPERVISOR:**

**INSTALL SUPERVISOR:**

Scott Adams  
Tel Data Systems  
Bergelectric Corporation  
650 Upper Street  
Escondido, CA 92029

**REVISION:**  
05-30-12 RECORD DRAWINGS

**SHEET TITLE:**

**TELECOM  
FLOOR PLAN  
LEVEL 3  
AREA-D**

**SCALE:**  
1/4" = 1'-0"

**DRAWING NO.:**

**T3.3D  
RECORD  
DRAWING**




#### SHEET KEYNOTES

- 12\"/>

#### GENERAL SHEET NOTES

- THE DRAWINGS ARE DIAGRAMMATIC ONLY AND MAY NOT SHOW ALL COMPONENTS, MATERIALS, OFFSETS, BENDS, ELBOWS AND OTHER SPECIFIC ELEMENTS THAT MAY BE REQUIRED FOR A COMPLETE INSTALLATION. THE CONTRACTOR SHALL BE RESPONSIBLE FOR PROVIDING ALL MATERIALS NEEDED FOR A COMPLETE AND FUNCTIONAL INSTALLATION.
- ELECTRIC EQUIPMENT AND DEVICES (E.G. Pbx, NETWORK SWITCHES) ARE SHOWN FOR REFERENCE ONLY.
- REFER TO ARCHITECTURAL DETAIL PLANS FOR FINAL PATIENT ROOM DEVICE LOCATIONS. REFER TO ARCHITECTURAL DETAILS FOR OVERCOUNTER WAO HEIGHTS. REFER TO ARCHITECTURAL DETAILS FOR WALL-MOUNT WAO HEIGHTS.
- HORIZONTAL DATA/VOICE/VIDEO CABLE SHALL TERMINATE IN THE TECHNOLOGY ROOM ON THE SAME FLOOR AS THE WORK AREA OUTLETS.
- WORK AREA OUTLETS SHALL CONSIST OF SINGLE PLASTER REDUCING RINGS INSTALLED ON OVERSIZE DOUBLE GANG BACKBOXES, UNLESS OTHERWISE NOTED.
- TV COAX CABLES SHALL BE COILED IN THE RESPECTIVE TECHNOLOGY ROOMS WITH A 2' SERVICE LOOP PRIOR TO TERMINATIONS. COILS SHALL BE SECURED TO THE AUDIOVISUAL WALL FIELD FOR AV CONTRACTOR.
- COMMON LOW VOLTAGE CABLE RUNWAY IS 24\"/>

#### KEY PLAN

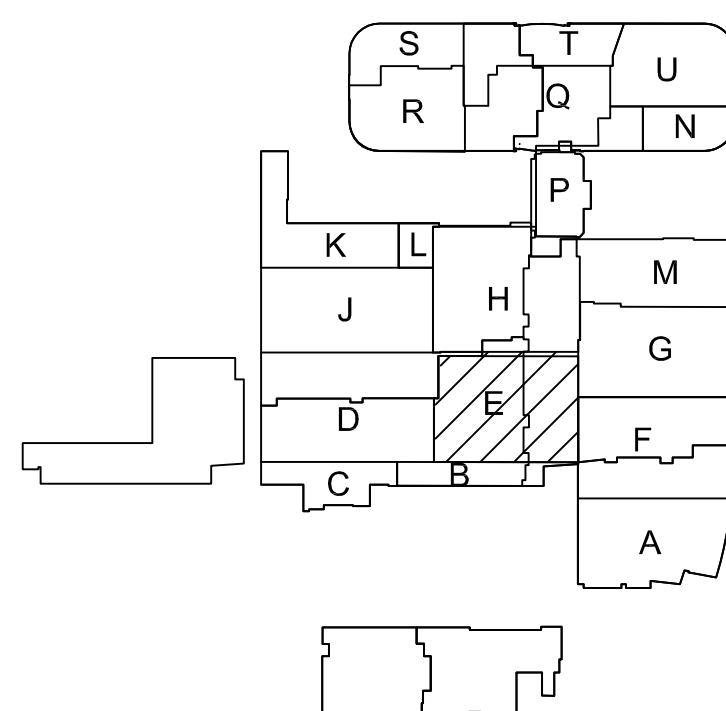

## CHILDREN'S HOSPITAL OF ORANGE COUNTY - TOWER II

PROJECT:  
ADDRESS:  
W.O. NO.:

PROPRIETARY STATEMENT  
THESE DRAWINGS AND DOCUMENTS HEREON ARE THE PROPERTY OF BERGELECTRIC CORPORATION AND ARE NOT TO BE REPRODUCED OR TRANSMITTED IN ANY FORM OR BY ANY MEANS, ELECTRONIC OR MECHANICAL, INCLUDING PHOTOCOPYING, RECORDING, OR BY ANY INFORMATION STORAGE AND RETRIEVAL SYSTEM, WITHOUT THE WRITTEN PERMISSION OF BERGELECTRIC CORPORATION. ALL RIGHTS RESERVED.

DRAWN BY:  
J. RAMIREZ

DESIGN SUPERVISOR:

INSTALL SUPERVISOR:  
Scott Adams  
Tel Data Systems  
Bergelectric Corporation  
850 Oppen Street  
Escondido, CA 92029

REVISION:  
05-30-12 RECORD DRAWINGS

SHEET TITLE:


TELECOM  
FLOOR PLAN  
LEVEL 3  
AREA-E

SCALE:  
1/4"=1'0"


DRAWING NO.:

T3.3E  
RECORD  
DRAWING

Bergelectric Corp.  
Contractors & Engineers

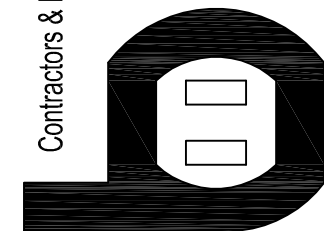

HC10-485046  
650 OPPEN ST.  
ESCONDIDO, CA 92029  
(760) 746-1033  
FAX (760) 746-4619

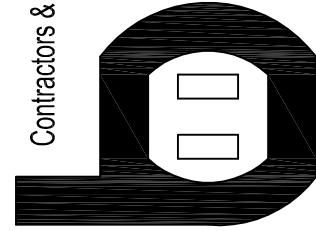PROJECT: **CHILDREN'S HOSPITAL  
OF ORANGE COUNTY - TOWER II**ADDRESS: 455 South Main Street  
Orange, CA 92668-3874  
W.O. NO.: 12684PROPRIETARY STATEMENT  
THESE DRAWINGS AND DOCUMENTS HEREIN ATTACHED ARE THE  
PROPERTY OF BERGELECTRIC CORPORATION. ANY REUSE OR  
REPRODUCTION OF THESE DOCUMENTS WITHOUT WRITTEN  
PERMISSION OF BERGELECTRIC CORPORATION IS STRICTLY  
FORBIDDEN. ALL RIGHTS RESERVED.DRAWN BY:  
J. RAMIREZ

DESIGN SUPERVISOR:

INSTALL SUPERVISOR:

Scott Adams  
Tel Data Systems  
Bergelectric Corporation  
650 Oppel Street  
Escondido, CA 92029

REVISION:

05-30-12 RECORD DRAWINGS


SHEET TITLE:

TELECOM  
FLOOR PLAN  
LEVEL 1  
AREA-F

SCALE:

1/4"=1'0"

DRAWING NO.:

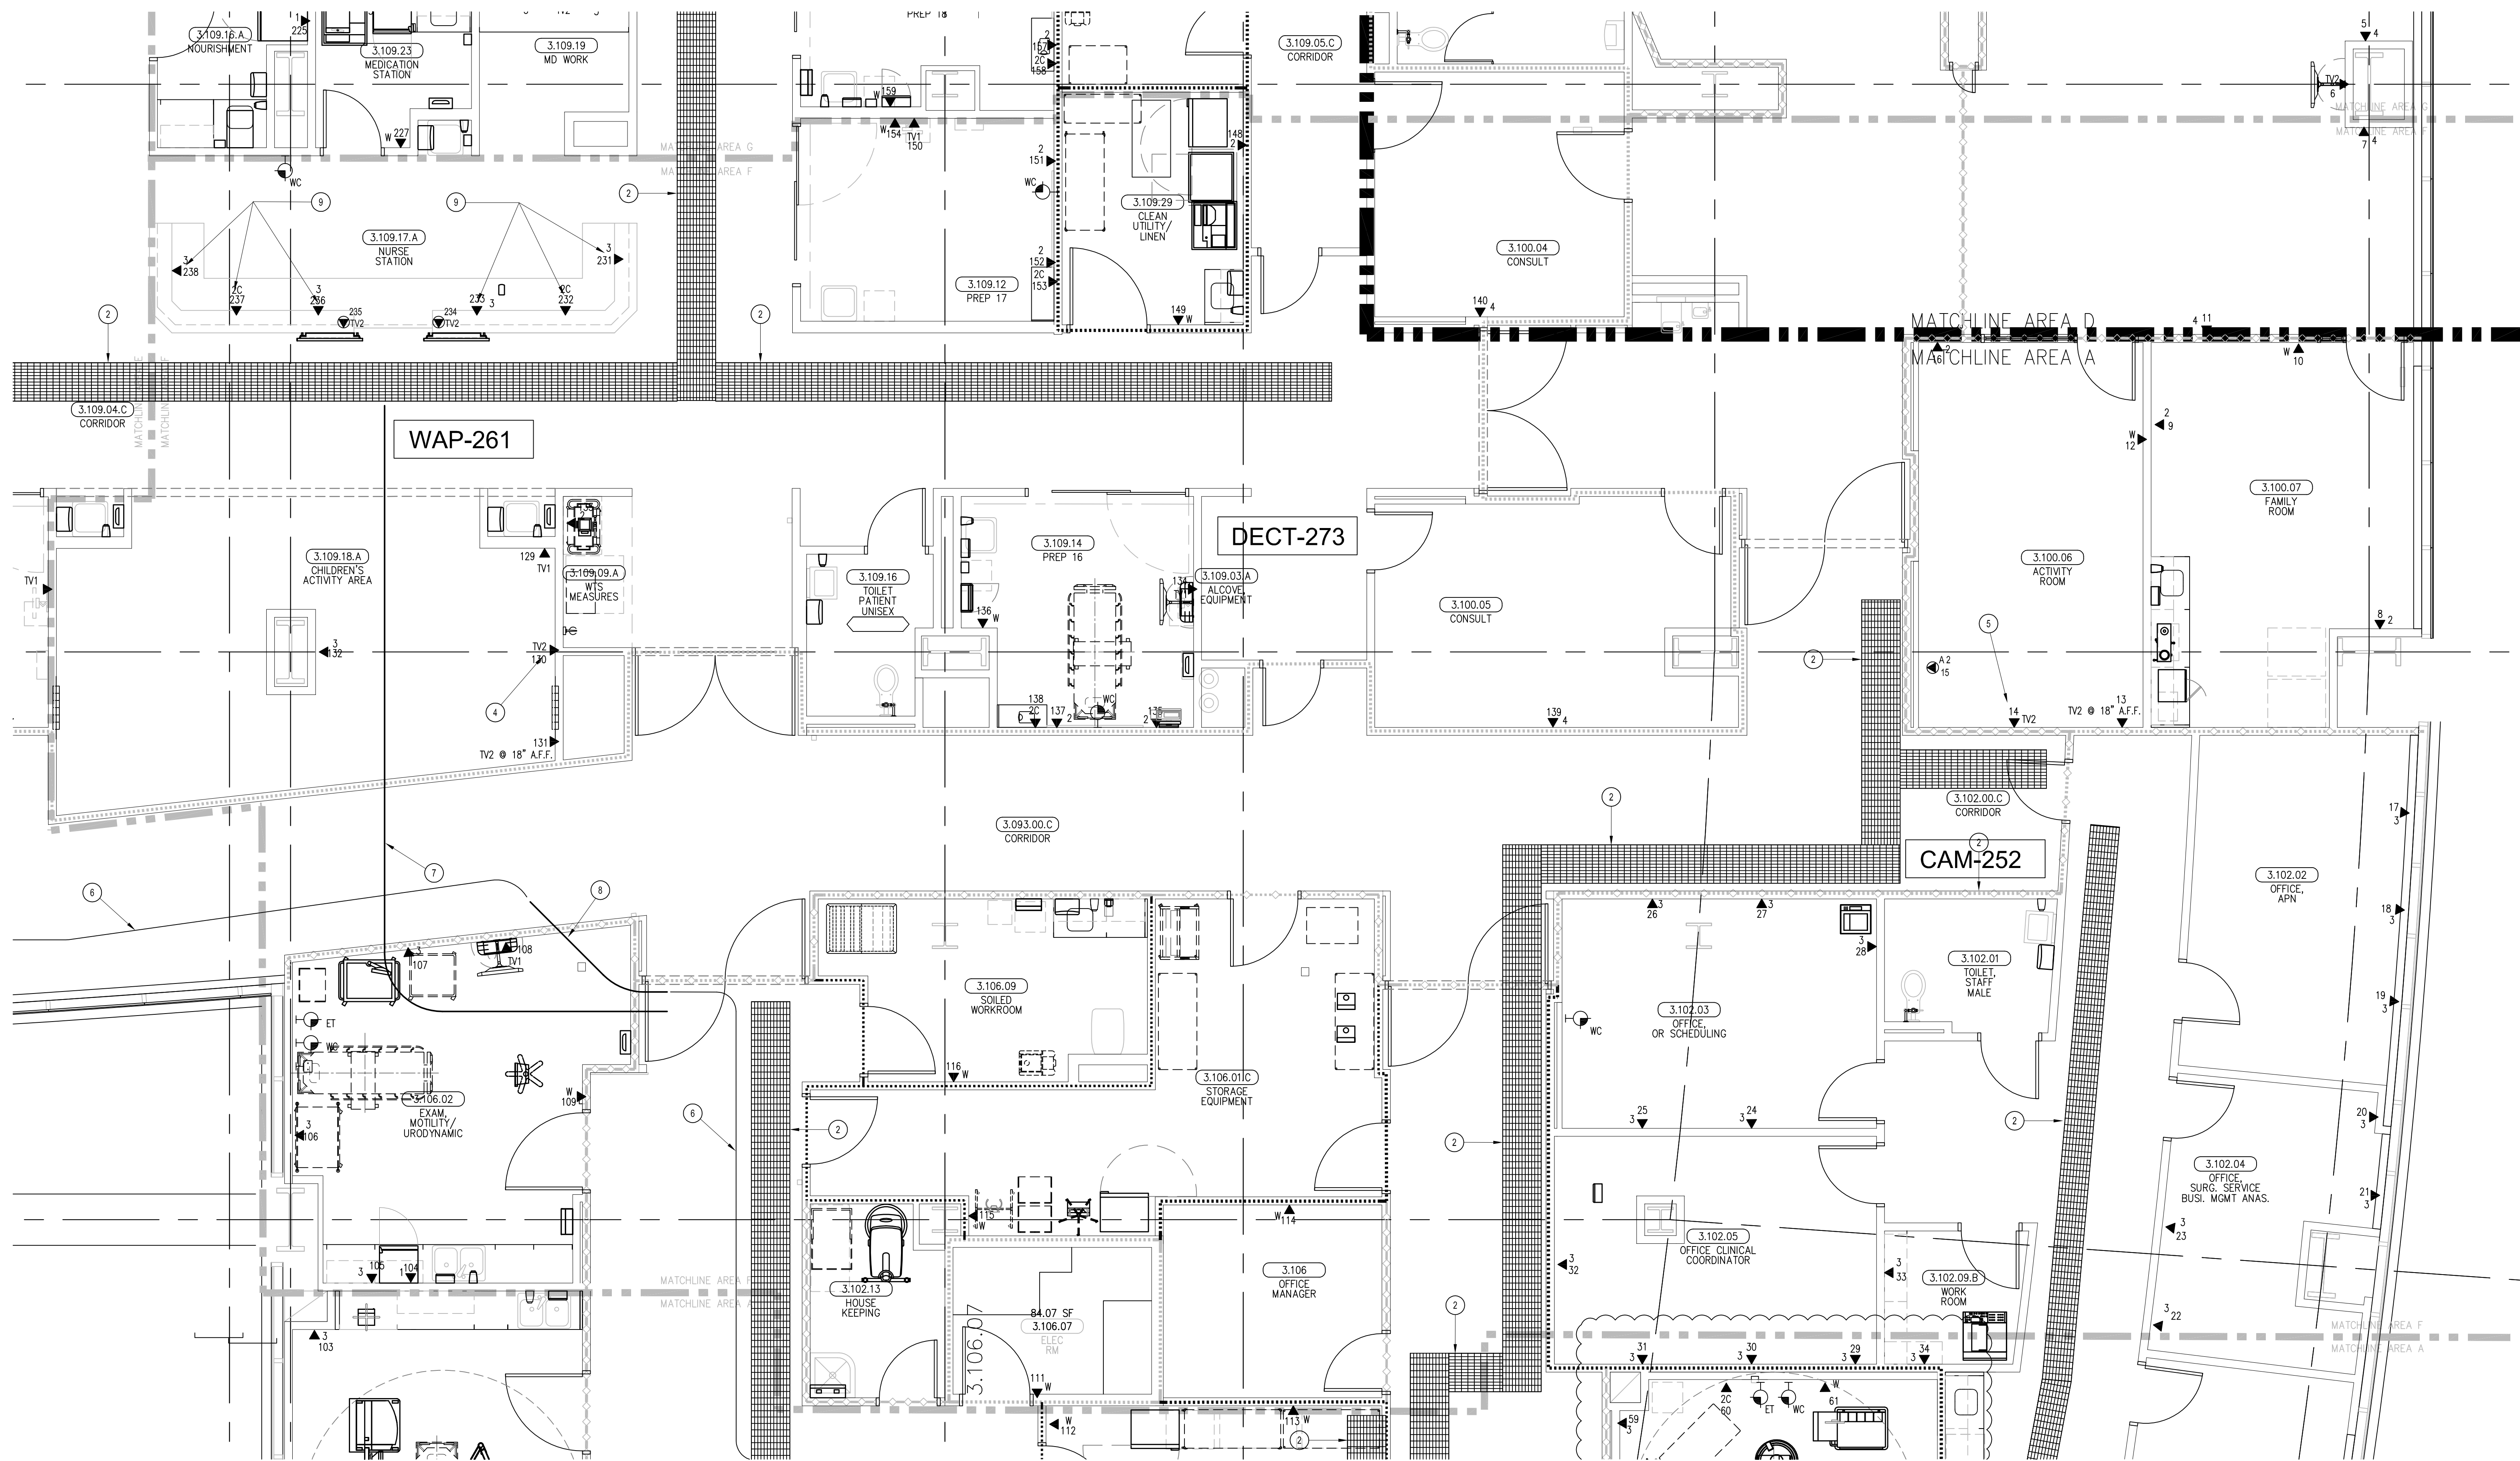T3.3F  
RECORD  
DRAWING


## SHEET KEYNOTES


- 12"W X 6"H CABLE RUNWAY
- 24"W X 6"H CABLE RUNWAY
- 18"W X 6"H CABLE RUNWAY
- MOUNT WAO IN DOUBLE-GANG BACKBOX; STUB ONE (1) 1" EMT TO ACCESSIBLE CEILING. COORDINATE CABLING AND BACKBOX INSTALLATION WITH AUDIOVISUAL REQUIREMENTS AS DESCRIBED ON AV SHEET T3.3A. COORDINATE WITH DETAIL 3 ON AV SHEET T3.01 FOR MOUNTING HEIGHT.
- MOUNT WAO IN DOUBLE-GANG BACKBOX; STUB ONE (1) 1" EMT TO ACCESSIBLE CEILING. COORDINATE CABLING AND BACKBOX INSTALLATION WITH AUDIOVISUAL REQUIREMENTS AS DESCRIBED ON AV SHEET T3.3A. COORDINATE WITH DETAIL 2 ON AV SHEET T3.02 FOR MOUNTING HEIGHT.
- CABLE SUPPORT PATHWAY FOR BACKBONE CABLES
- TWELVE 4" CONDUITS.
- ONE 4" CONDUIT.
- OUTLETS ARE TO BE FED VIA WALL FROM ABOVE CEILING SPACE. PROVIDE TWO (2) 1-1/4" CONDUITS FROM CABLE RUNWAY TO MILLWORK. TERMINATE CONDUITS AT 24" A.F.F. AND EXTEND ONTO MILLWORK USING NONMETALLIC SURFACE RACEWAYS WITH MINIMUM OF 1-1/2" INTERNAL AREA TO EACH OUTLET.

## GENERAL SHEET NOTES

- THE DRAWINGS ARE DIAGRAMMATIC ONLY AND MAY NOT SHOW ALL COMPONENTS, MATERIALS, OFFSETS, BENDS, ELBOWS AND OTHER SPECIFIC ELEMENTS THAT MAY BE REQUIRED FOR A COMPLETE INSTALLATION. THE CONTRACTOR SHALL BE RESPONSIBLE FOR PROVIDING ALL MATERIALS NEEDED FOR A COMPLETE AND FUNCTIONAL INSTALLATION.
- ELECTRIC EQUIPMENT AND DEVICES (E.G. PBX, NETWORK SWITCHES) ARE SHOWN FOR REFERENCE ONLY.
- REFER TO ARCHITECTURAL DETAIL PLANS FOR FINAL PATIENT ROOM DEVICE LOCATIONS. REFER TO ARCHITECTURAL DETAILS FOR OVERCOUNTER WAO HEIGHTS. REFER TO ARCHITECTURAL DETAILS FOR WALL-MOUNT WAO HEIGHTS.
- HORIZONTAL DATA/VOICE/VIDEO CABLE SHALL TERMINATE IN THE TECHNOLOGY ROOM ON THE SAME FLOOR AS THE WORK AREA OUTLETS.
- WORK AREA OUTLETS SHALL CONSIST OF SINGLE PLASTER REDUCING RINGS INSTALLED ON OVERSIZE DOUBLE GANG BACKBOXES, UNLESS OTHERWISE NOTED.
- TV COAX CABLES SHALL BE COILED IN THE RESPECTIVE TECHNOLOGY ROOMS WITH A 20' SERVICE LOOP PRIOR TO TERMINATIONS. COILS SHALL BE SECURED TO THE AUDIOVISUAL WALL FIELD FOR AV CONTRACTOR.
- COMMON LOW VOLTAGE CABLE RUNWAY IS 24" W X 6" HIGH. PROVIDE ALL MATERIALS AS NEEDED FOR A COMPLETE, MANUFACTURER-APPROVED SYSTEM USING CABLE TRAY MANUFACTURERS' MATERIALS AND PARTS WHEN AVAILABLE FROM THE MANUFACTURER AND AS INTENDED. REFER TO DRAWING T4.01 FOR DETAILS. ALL CHANGES IN DIRECTION AND INTERSECTIONS SHALL USE PRE-MANUFACTURED OR FIELD-INSTALLED SWEEPS AND TEES. ALL SWEEPS AND TEES SHALL MAINTAIN A 1 FOOT MINIMUM RADIUS IN CHANGES OF DIRECTION.
- CABLE TRAY SHALL NOT PENETRATE WALLS. PROVIDE TRANSITION FROM CABLE TRAY TO LISTED FIRESTOP ASSEMBLIES IN ORDER TO PENETRATE FIRESTOP WALLS. TRANSITION TO 4" CONDUITS/SLEEVES FOR NON-RATED WALLS. PROVIDE SUFFICIENT CONDUITS/SLEEVES TO ACCOMMODATE 100% VISUAL CABLE TRAY LOAD AT 50% VISUAL CONDUIT FILL.
- REFER TO ELECTRICAL DRAWINGS & SPECIFICATIONS FOR SHARED FLOOR BOXES & LOW VOLTAGE CONDUIT.
- PROVIDE BRACING TO MEET OSHPD SEISMIC REQUIREMENTS. REFER TO SHEET T4.02 FOR MORE INFORMATION.
- PROVIDE ALL OUTLET CONDUITS FROM WORK AREA OUTLETS, DEVICES OR PULL BOXES TO NEAREST CABLE TRAY.
- INSTALL CABLE TRAY @ 6" ABOVE CEILING.

## KEY PLAN

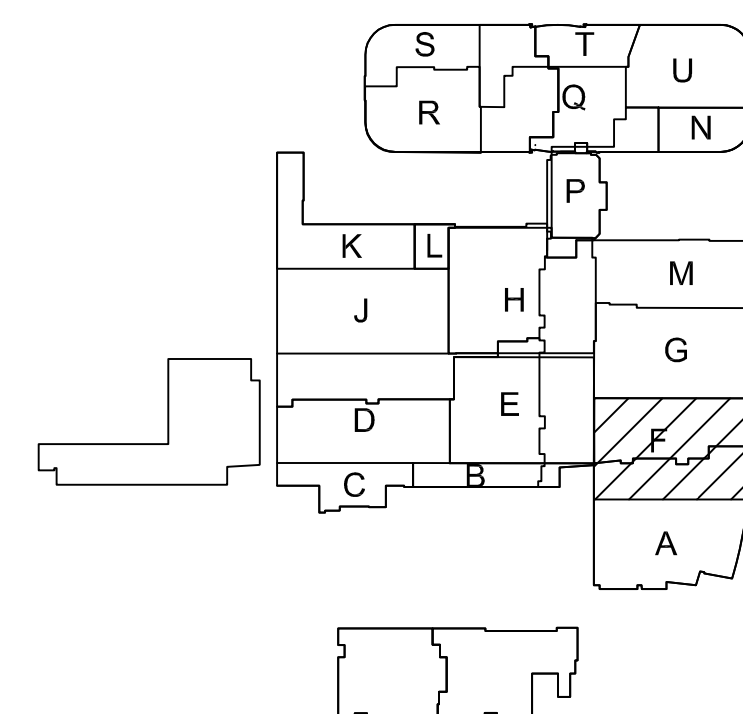T3 LEVEL 3 - TELECOM PLAN - AREA F  
1/4" = 1'-0"

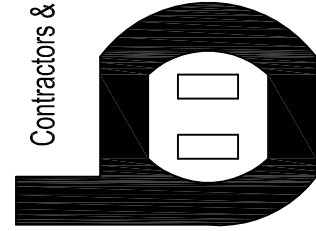PROJECT:  
**CHILDREN'S HOSPITAL  
OF ORANGE COUNTY - TOWER II**ADDRESS: 455 South Main Street  
Orange, CA 92668-3874  
W.O. NO.: 12684**PROPRIETARY STATEMENT**  
THESE DRAWING DOCUMENTS HEREIN ATTACHED ARE THE  
PROPERTY OF BERGELECTRIC CORPORATION. ANY REUSE OR  
REPRODUCTION OF THESE DOCUMENTS WITHOUT WRITTEN  
PERMISSION OF BERGELECTRIC CORPORATION IS STRICTLY  
FORBIDDEN. ALL RIGHTS RESERVED.DRAWN BY:  
J. RAMIREZ

DESIGN SUPERVISOR:

INSTALL SUPERVISOR:

Scott Adams  
Tel Data Systems  
Bergelectric Corporation  
650 Oppen Street  
Escondido, CA 92029REVISIONS:  
05-30-12 RECORD DRAWINGS


SHEET TITLE:

**TELECOM  
FLOOR PLAN  
LEVEL 3  
AREA-G**

SCALE:

1/4"=1'0"

DRAWING NO.:

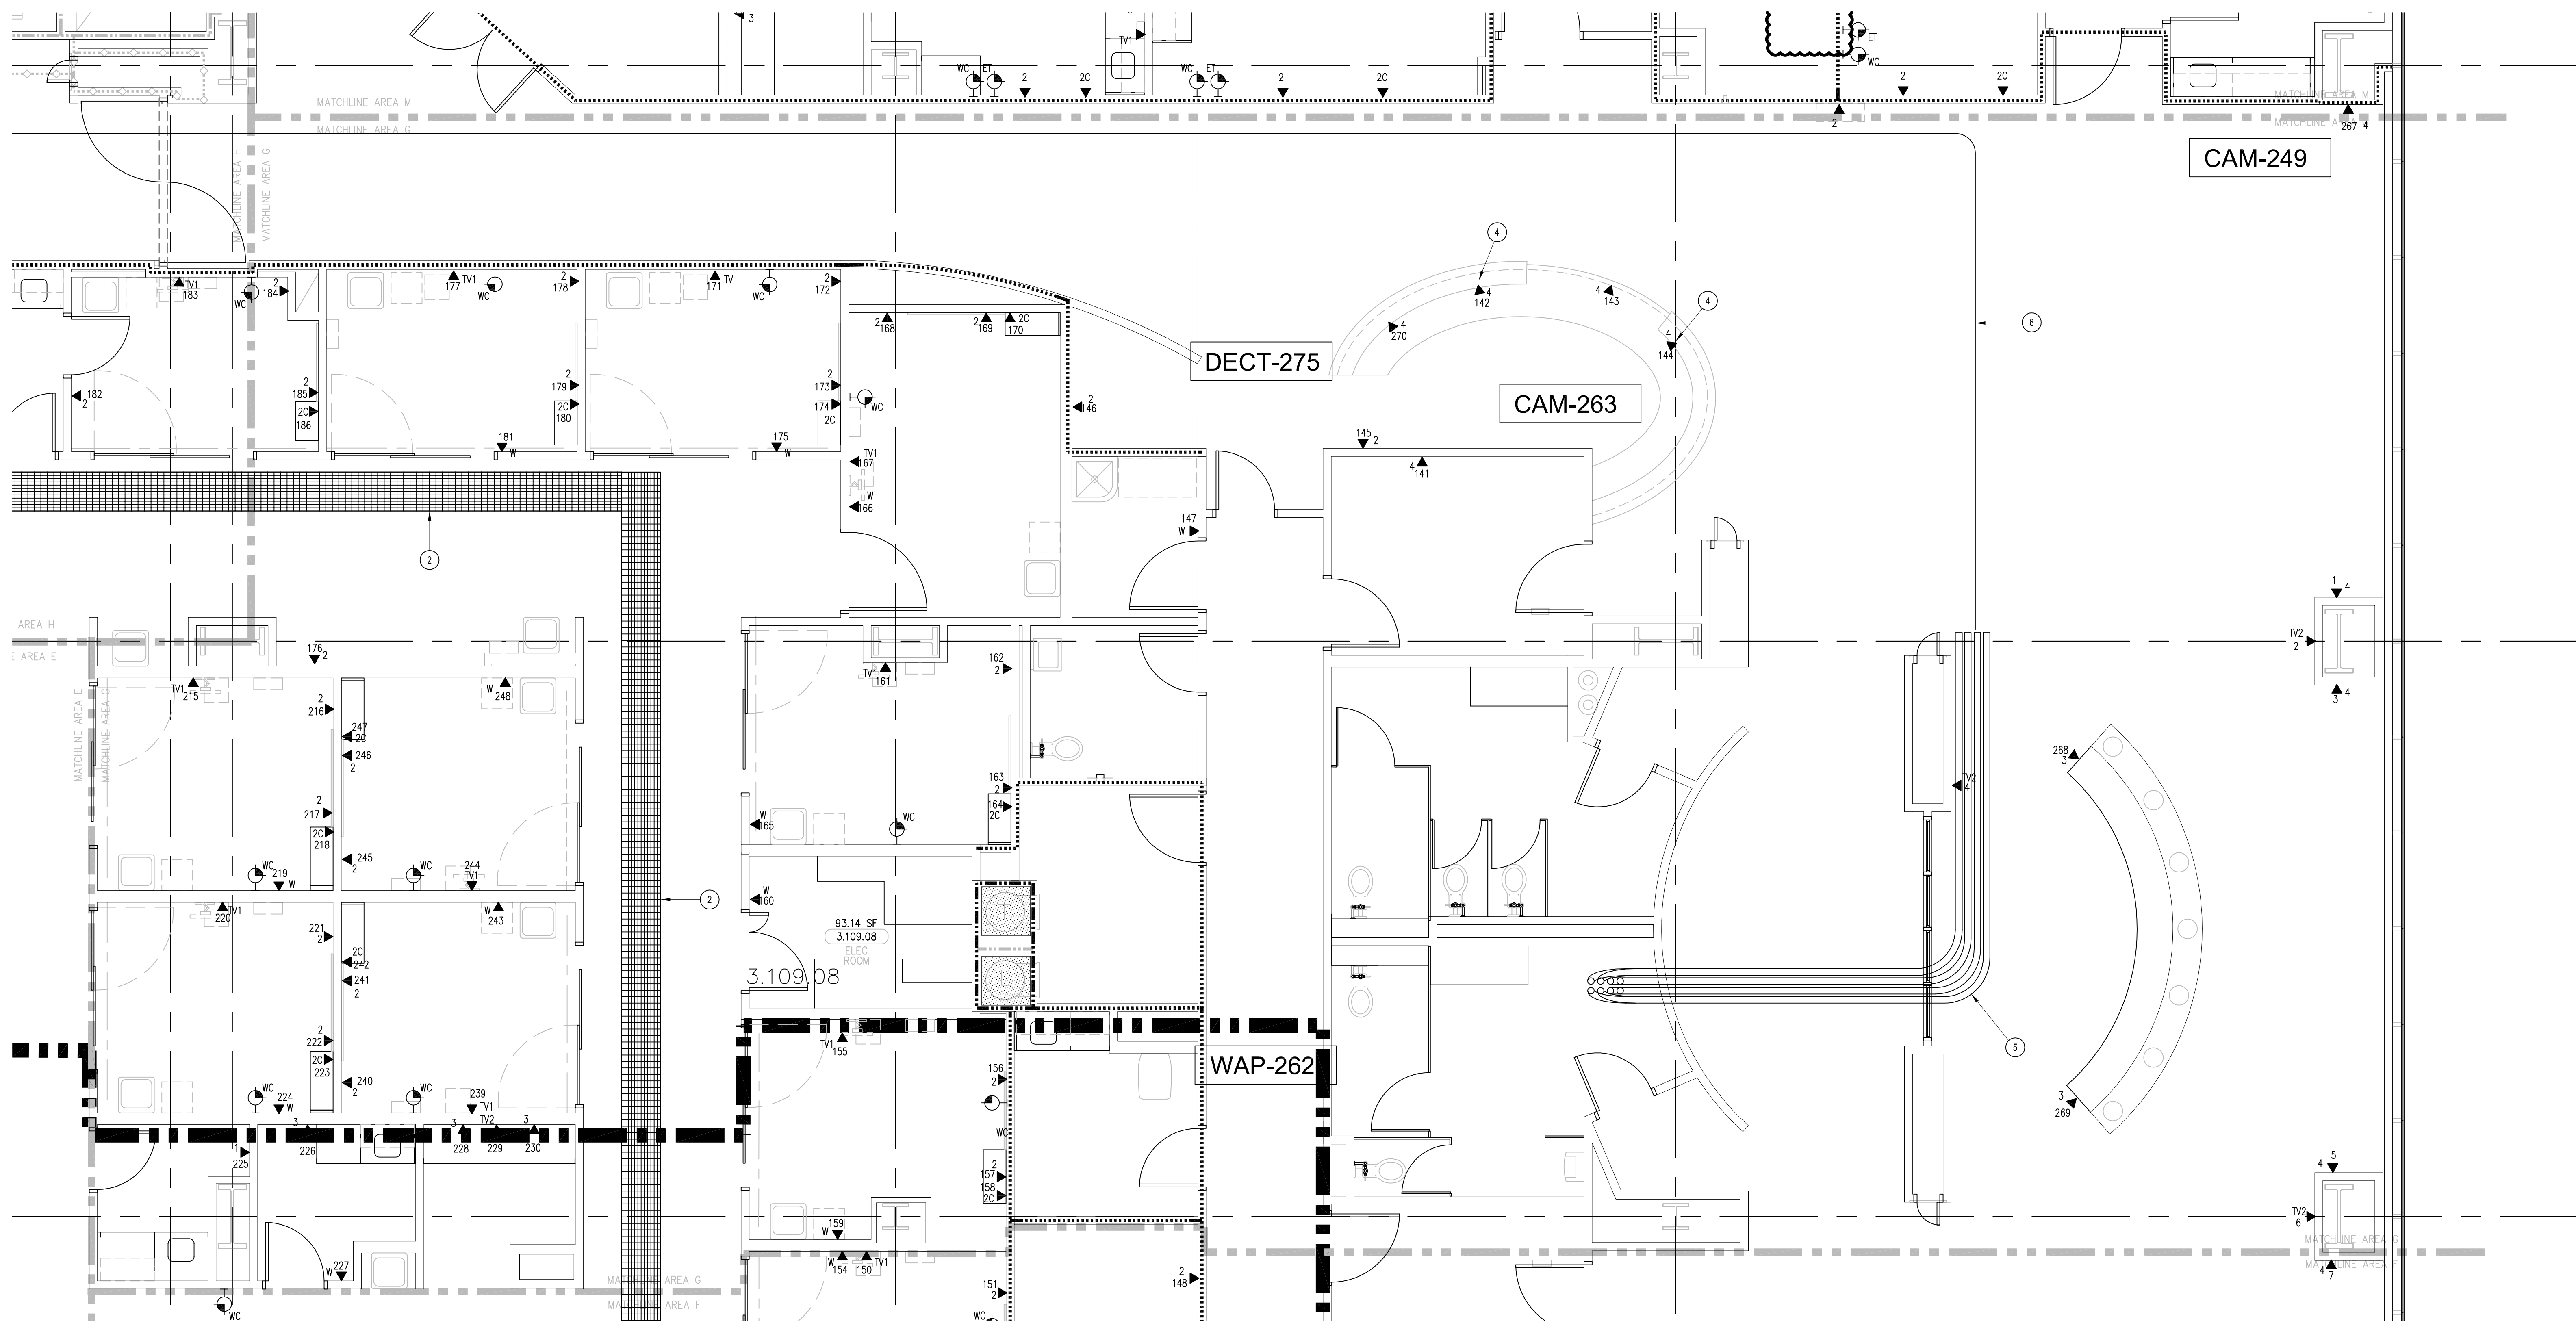**T3.3G  
RECORD  
DRAWING**


## SHEET KEYNOTES

- 12"W X 6"H CABLE RUNWAY
- 24"W X 6"H CABLE RUNWAY
- 18"W X 6"H CABLE RUNWAY
- OUTLETS ARE TO BE FED VIA WALL FROM ABOVE CEILING SPACE. PROVIDE TWO (2) 1-1/4" CONDUITS FROM CABLE RUNWAY TO MILLWORK. TERMINATE CONDUITS AT 24" A.F.F. AND EXTEND ONTO MILLWORK USING NON-METALLIC SURFACE RACEWAYS WITH MINIMUM OF 1"x1" INTERNAL AREA TO EACH OUTLET.
- EIGHT 4" EMT CONDUITS TO FOURTH FLOOR.
- CABLE SUPPORT PATHWAY FOR BACKBONE CABLES.


## GENERAL SHEET NOTES

- THE DRAWINGS ARE DIAGRAMMATIC ONLY AND MAY NOT SHOW ALL COMPONENTS, MATERIALS, OFFSETS, BENDS, ELBOWS AND OTHER SPECIFIC ELEMENTS THAT MAY BE REQUIRED FOR A COMPLETE INSTALLATION. THE CONTRACTOR SHALL BE RESPONSIBLE FOR PROVIDING ALL MATERIALS NEEDED FOR A COMPLETE AND FUNCTIONAL INSTALLATION.
- ELECTRIC EQUIPMENT AND DEVICES (E.G. PBX, NETWORK SWITCHES) ARE SHOWN FOR REFERENCE ONLY.
- REFER TO ARCHITECTURAL DETAIL PLANS FOR FINAL PATIENT ROOM DEVICE LOCATIONS. REFER TO ARCHITECTURAL DETAILS FOR OVERCOUNTER WAO HEIGHTS. REFER TO ARCHITECTURAL DETAILS FOR WALL-MOUNT WAO HEIGHTS.
- HORIZONTAL DATA/VOICE/VIDEO CABLE SHALL TERMINATE IN THE TECHNOLOGY ROOM ON THE SAME FLOOR AS THE WORK AREA OUTLETS.
- WORK AREA OUTLETS SHALL CONSIST OF SINGLE PLASTER REDUCING RINGS INSTALLED ON OVERSIZE DOUBLE GANG BACKBOXES, UNLESS OTHERWISE NOTED.
- TV COAX CABLES SHALL BE COILED IN THE RESPECTIVE TECHNOLOGY ROOMS WITH A 20' SERVICE LOOP PRIOR TO TERMINATIONS. COILS SHALL BE SECURED TO THE AUDIOVISUAL WALL FIELD FOR AV CONTRACTOR.
- COMMON LOW VOLTAGE CABLE RUNWAY IS 24" W X 6" HIGH. PROVIDE ALL MATERIALS AS NEEDED FOR A COMPLETE, MANUFACTURER-APPROVED SYSTEM USING CABLE RUNWAY MANUFACTURERS' MATERIALS AND PARTS WHEN AVAILABLE FROM THE MANUFACTURER AND AS INTENDED. REFER TO DRAWING T4.01 FOR DETAILS. ALL CHANGES IN DIRECTION AND INTERSECTIONS SHALL USE PREMANUFACTURED OR FIELD-INSTALLED SWEEPS AND TEES. ALL SWEEPS AND TEES SHALL MAINTAIN A 1 FOOT MINIMUM RADIUS IN CHANGES OF DIRECTION.
- CABLE RUNWAY SHALL NOT PENETRATE WALLS. PROVIDE TRANSITION FROM CABLE RUNWAY TO LISTED FIRESTOP ASSEMBLIES IN ORDER TO PENETRATE FIRE/SMOKE WALLS. TRANSITION TO 4" CONDUITS/SLEEVES FOR NON-RATED WALLS. PROVIDE SUFFICIENT CONDUITS/SLEEVES TO ACCOMMODATE 100% VISUAL CABLE RUNWAY LOAD AT 50% VISUAL CONDUIT FILL.
- REFER TO ELECTRICAL DRAWINGS & SPECIFICATIONS FOR SHARED FLOOR BOXES & LOW VOLTAGE CONDUIT.
- PROVIDE BRACING TO MEET OSHPO SEISMIC REQUIREMENTS. REFER TO SHEET T4.02 FOR MORE INFORMATION.
- PROVIDE ALL OUTLET CONDUITS FROM WORK AREA OUTLETS, DEVICES OR PULL BOXES TO NEAREST CABLE RUNWAY.
- INSTALL CABLE RUNWAY @ 8" ABOVE CEILING.

## KEY PLAN

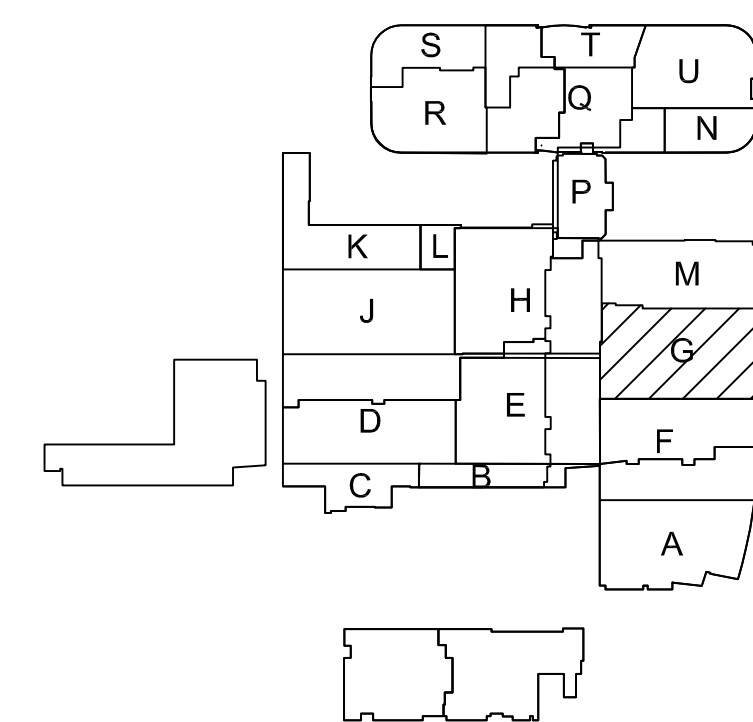**T3 LEVEL 3 - TELECOM PLAN - AREA G**

1/4"=1'-0"

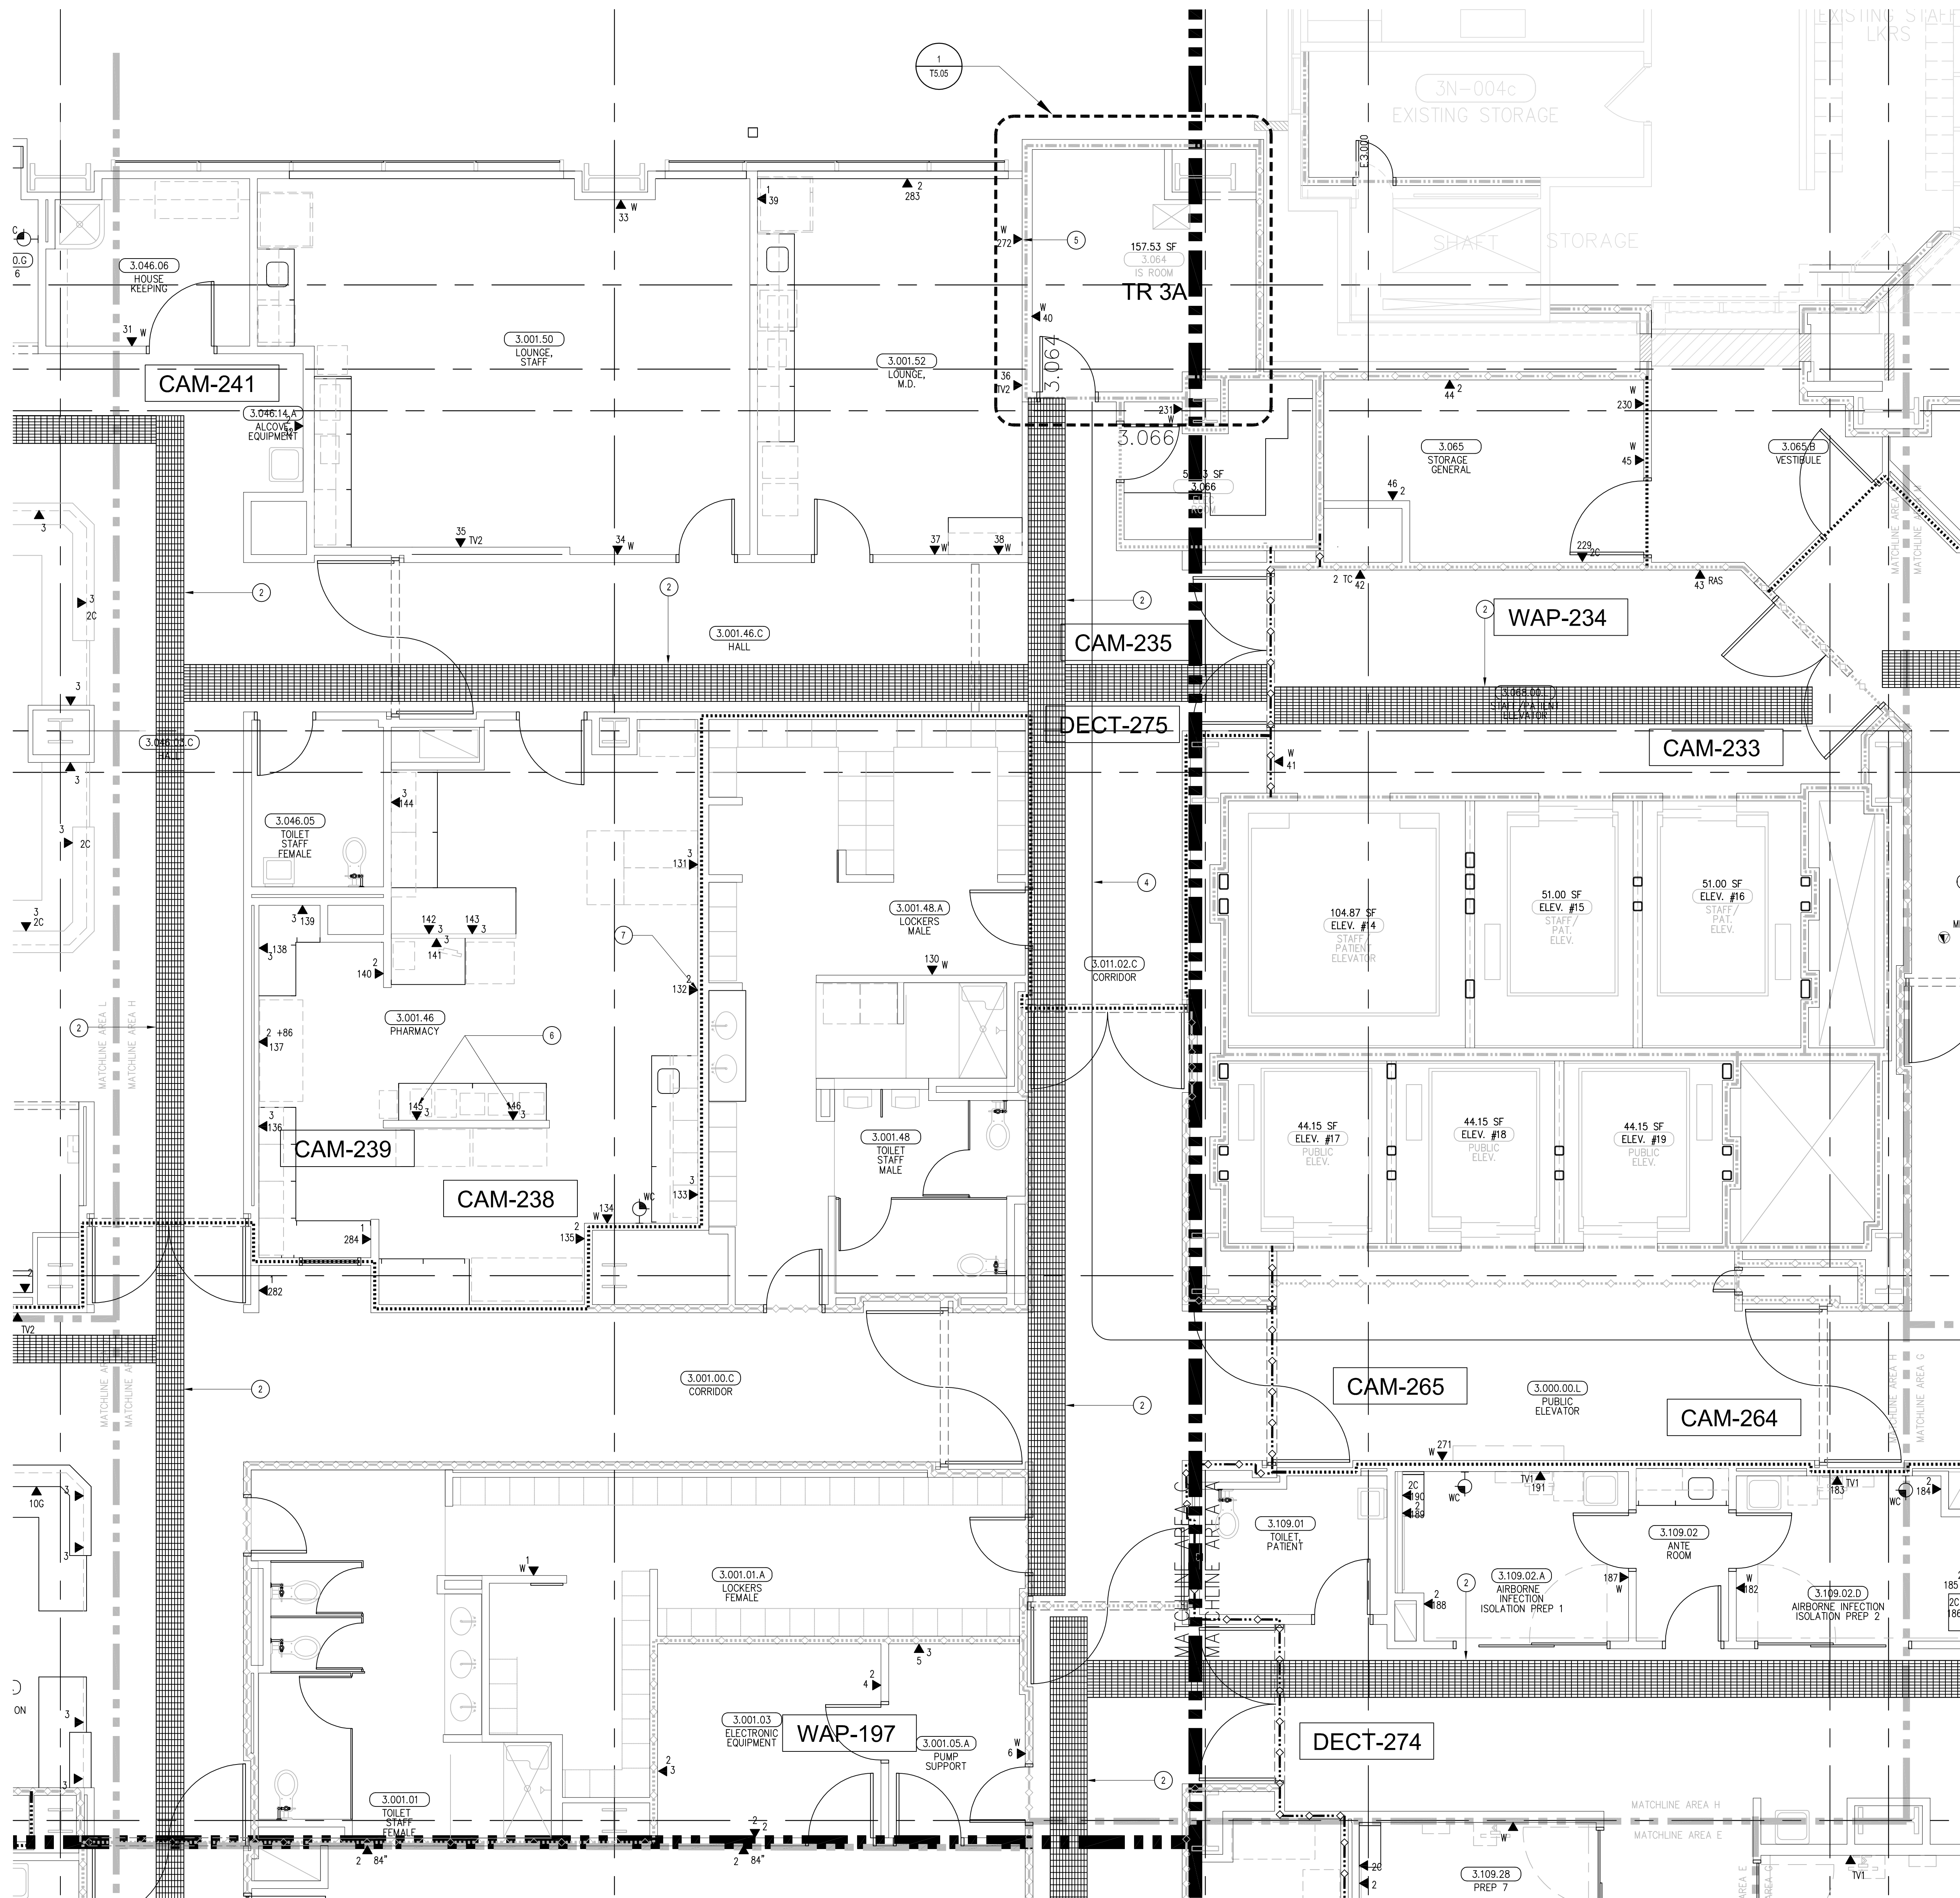


#### SHEET KEYNOTES


- 12" W X 6" H CABLE RUNWAY
- 24" W X 6" H CABLE RUNWAY
- 18" W X 6" H CABLE RUNWAY
- CABLE SUPPORT PATHWAY FOR BACKBONE CABLES.
- MOUNT WAD ABOVE CEILING ON WALL USING TWO-PORT SURFACE-MOUNT BOX. PROVIDE STAINLESS STEEL FACEPLATE WITH 1" MIN. GROMMET OPENING ON CEILING.
- OUTLETS ARE TO BE FED VIA WALL FROM ABOVE CEILING SPACE. PROVIDE TWO (2) 1-1/4" CONDUITS FROM CABLE RUNWAY TO MILLWORK. TERMINATE CONDUITS AT 24" A.F.F. AND EXTEND ONTO MILLWORK USING NONMETALLIC SURFACE RACEWAYS WITH MINIMUM OF 1"X1" INTERNAL AREA TO EACH OUTLET.
- COORDINATE WITH REFRIGERATORS.

#### GENERAL SHEET NOTES

- THE DRAWINGS ARE DIAGRAMMATIC ONLY AND MAY NOT SHOW ALL COMPONENTS, OFFSETS, BENDS, ELBOWS AND OTHER SPECIFIC ELEMENTS THAT MAY BE REQUIRED FOR A COMPLETE INSTALLATION. THE CONTRACTOR SHALL BE RESPONSIBLE FOR PROVIDING ALL MATERIALS NEEDED FOR A COMPLETE AND FUNCTIONAL INSTALLATION.
- ELECTRIC EQUIPMENT AND DEVICES (E.G. PBX, NETWORK SWITCHES) ARE SHOWN FOR REFERENCE ONLY.
- REFER TO ARCHITECTURAL DETAIL PLANS FOR FINAL PATIENT ROOM DEVICE LOCATIONS. REFER TO ARCHITECTURAL DETAILS FOR OVERCOUNTER WAD HEIGHTS. REFER TO ARCHITECTURAL DETAILS FOR WALL-MOUNT WAD HEIGHTS.
- HORIZONTAL DATA/VOICE/VIDEO CABLE SHALL TERMINATE IN THE TECHNOLOGY ROOM ON THE SAME FLOOR AS THE WORK AREA OUTLETS.
- WORK AREA OUTLETS SHALL CONSIST OF SINGLE PLASTER REDUCING RINGS INSTALLED ON OVERSIZE DOUBLE GANG BACKBOXES, UNLESS OTHERWISE NOTED.
- TV COAX CABLES SHALL BE COILED IN THE RESPECTIVE TECHNOLOGY ROOMS WITH A 20' SERVICE LOOP PRIOR TO TERMINATIONS. COILS SHALL BE SECURED TO THE AUDIOVISUAL WALL FIELD FOR AV CONTRACTOR.
- COMMON LOW VOLTAGE CABLE RUNWAY IS 24" W X 6" HIGH. PROVIDE ALL MATERIALS AS NEEDED FOR A COMPLETE, MANUFACTURER-APPROVED SYSTEM USING CABLE RUNWAY MANUFACTURERS' MATERIALS AND PARTS WHEN AVAILABLE FROM THE MANUFACTURER AND AS INTENDED. REFER TO DRAWING T4.01 FOR DETAILS. ALL CHANGES IN DIRECTION AND INTERSECTIONS SHALL USE PREMANUFACTURED OR FIELD-INSTALLED SWEEPS AND TEES. ALL SWEEPS AND TEES SHALL MAINTAIN A 1 FOOT MINIMUM RADIUS IN CHANGES OF DIRECTION.
- CABLE RUNWAY SHALL NOT PENETRATE WALLS. PROVIDE TRANSITION FROM CABLE RUNWAY TO LISTED FIRESSTOP ASSEMBLIES IN ORDER TO PENETRATE FIRESMoke WALLS. TRANSITION TO 4" CONDUITS/SLEEVES FOR NON-RATED WALLS. PROVIDE SUFFICIENT CONDUITS/SLEEVES TO ACCOMMODATE 100% VISUAL CABLE RUNWAY LOAD AT 50% VISUAL CONDUIT FILL.
- REFER TO ELECTRICAL DRAWINGS & SPECIFICATIONS FOR SHARED FLOOR BOXES & LOW VOLTAGE CONDUIT.
- PROVIDE BRACING TO MEET OSHPD SEISMIC REQUIREMENTS. REFER TO SHEET T4.02 FOR MORE INFORMATION.
- PROVIDE ALL OUTLET CONDUITS FROM WORK AREA OUTLETS, DEVICES OR PULL BOXES TO NEAREST CABLE RUNWAY.
- INSTALL CABLE RUNWAY @ 6" ABOVE CEILING.

#### KEY PLAN

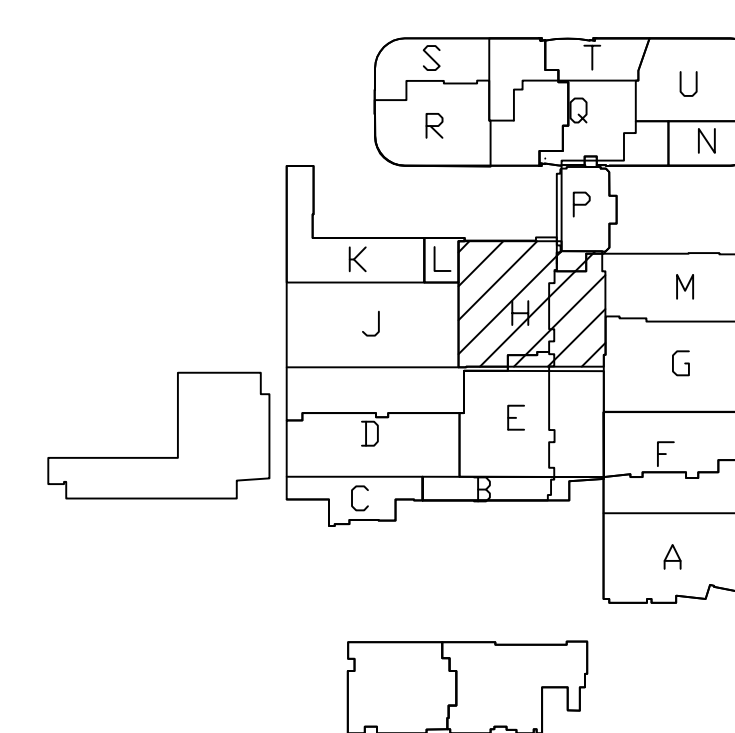

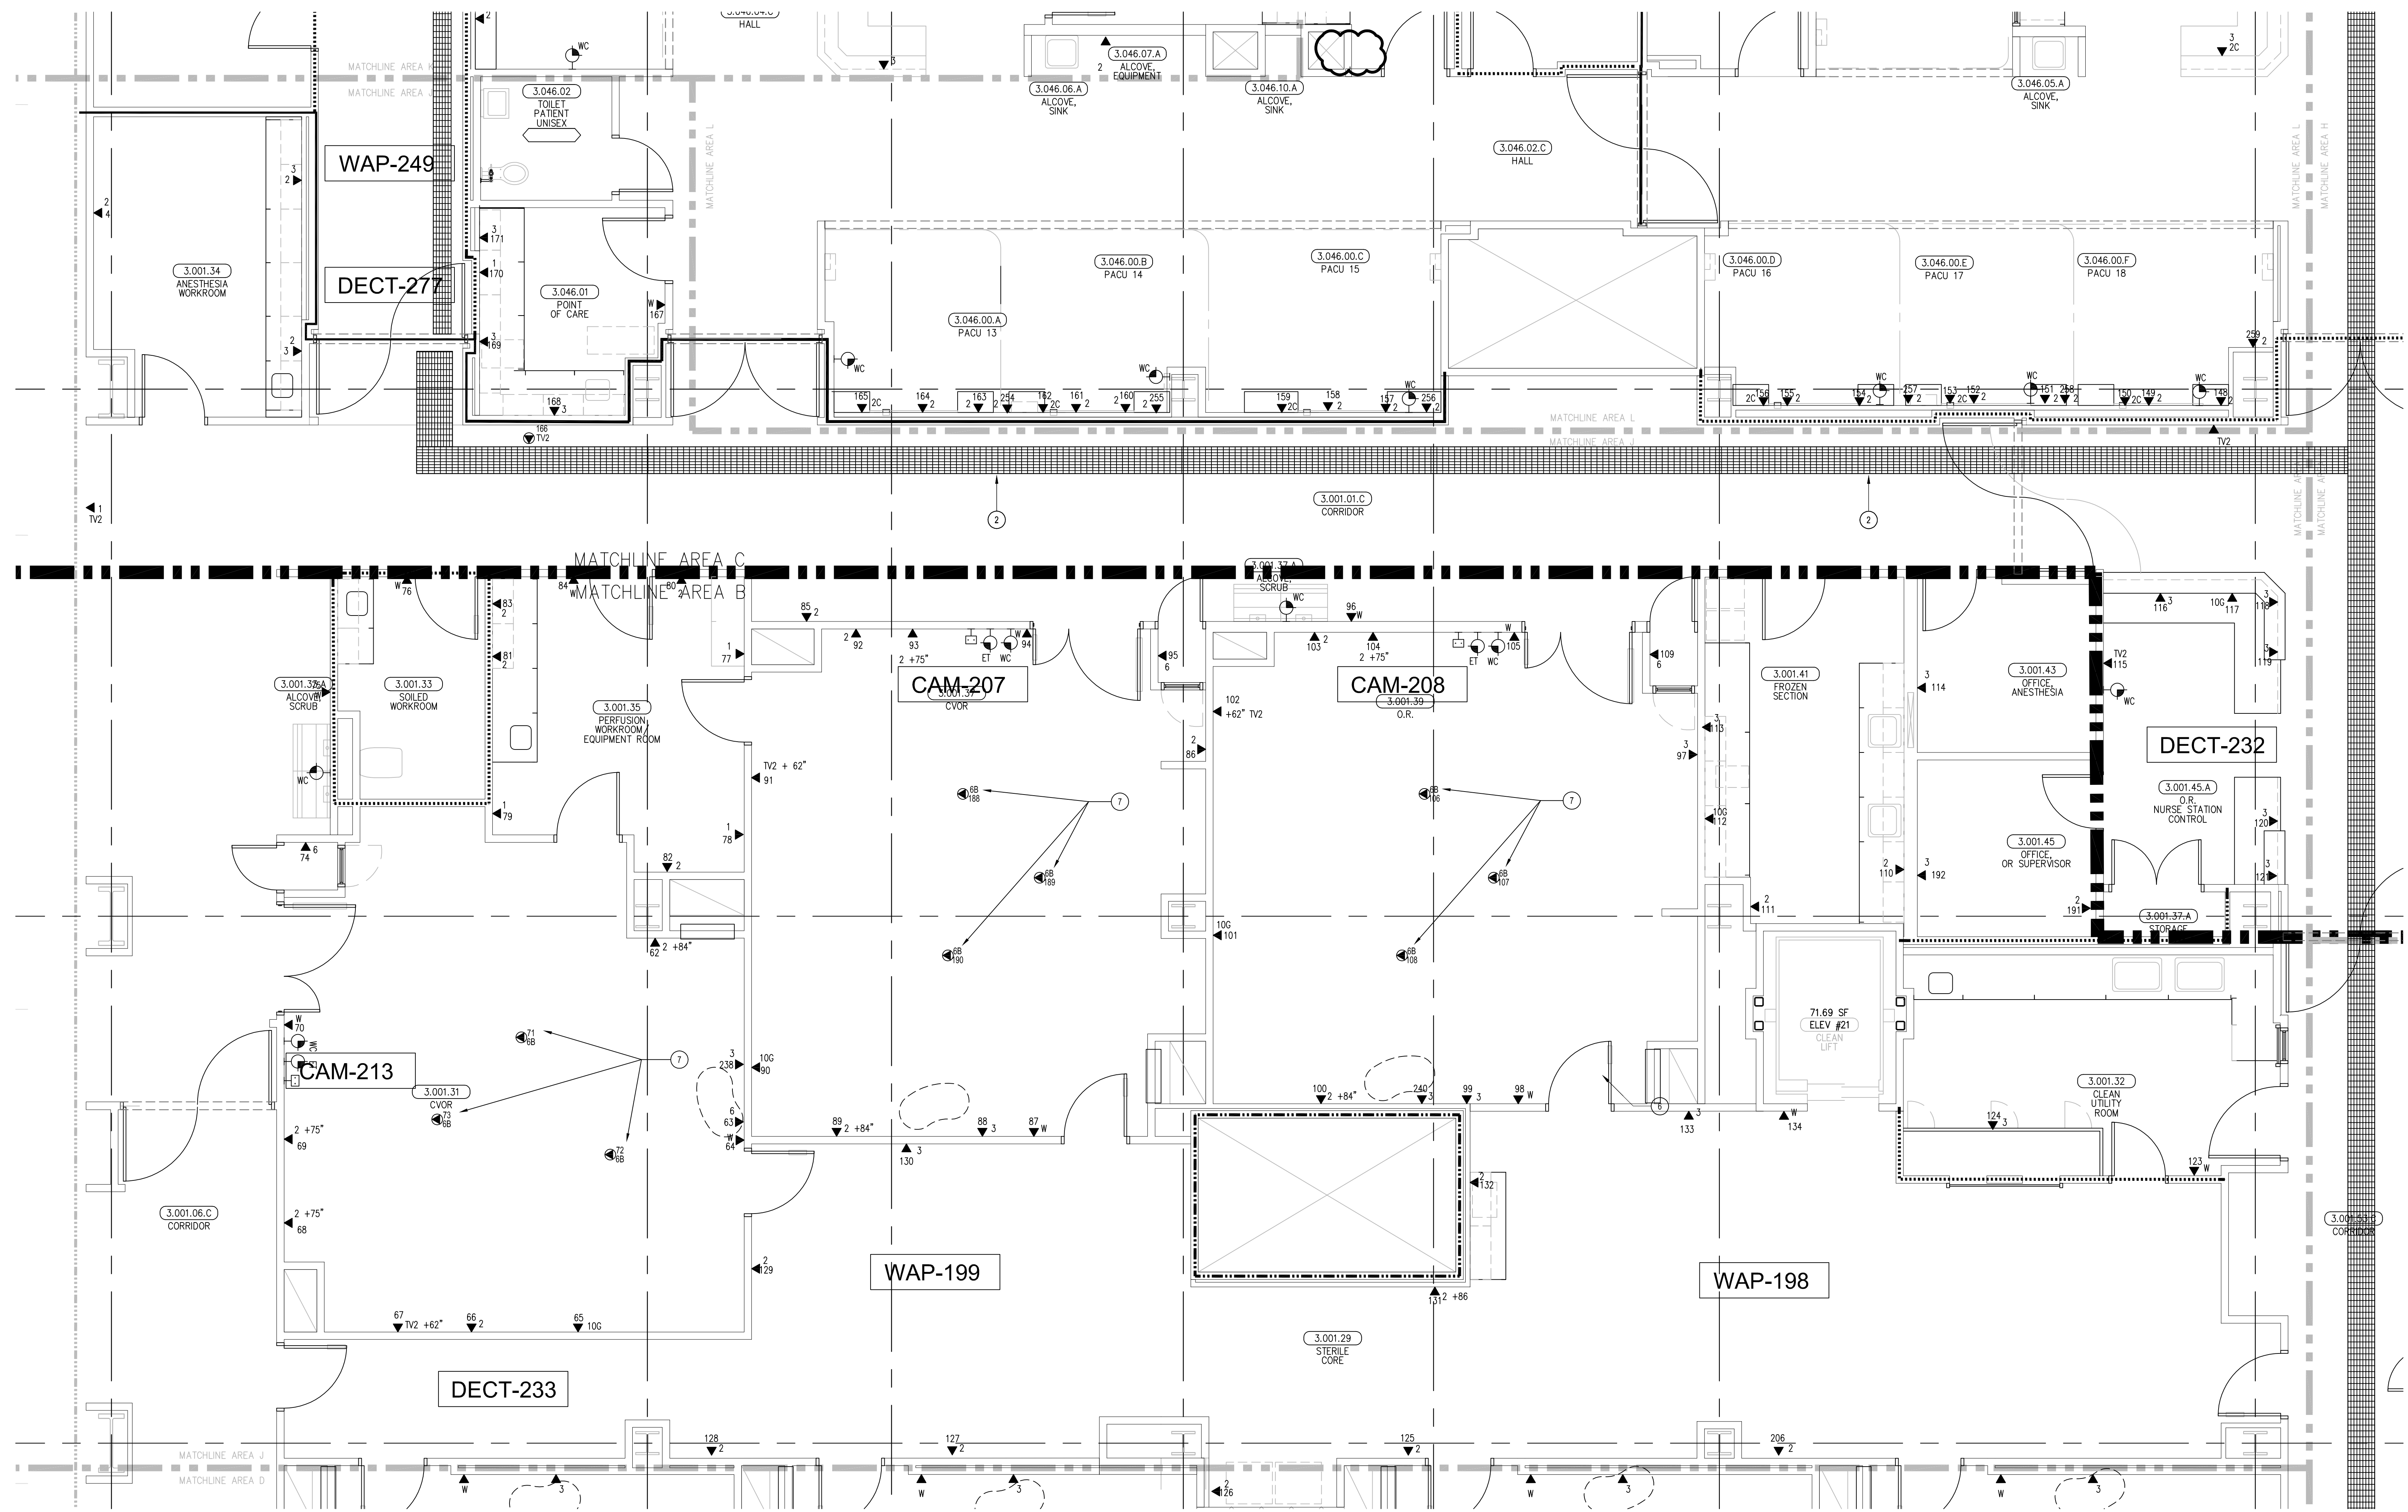


#### SHEET KEYNOTES

- 12" W X 6" H CABLE RUNWAY
- 24" W X 6" H CABLE RUNWAY
- 18" W X 6" H CABLE RUNWAY
- OUTLETS ARE TO BE FED VIA WALL FROM ABOVE CEILING SPACE. PROVIDE TWO (2) 1-1/4" CONDUITS FROM CABLE RUNWAY TO MILLWORK. TERMINATE CONDUITS AT 24" A.F.F. AND EXTEND ONTO MILLWORK USING NONMETALLIC SURFACE RACEWAYS WITH MINIMUM OF 1"1/4" INTERNAL AREA TO EACH OUTLET.
- COORDINATE WITH REFRIGERATOR
- 3 PORT WORK AREA OUTLET: 2 - VOICE/DATA, 1C - CLINICAL NETWORK
- 6 PORT WORK AREA OUTLET @ CEILING BOOM: 5 - VOICE/DATA, 1C - CLINICAL NETWORK

#### GENERAL SHEET NOTES

- THE DRAWINGS ARE DIAGRAMMATIC ONLY AND MAY NOT SHOW ALL COMPONENTS, MATERIALS, OFFSETS, BENDS, ELBOWS AND OTHER SPECIFIC ELEMENTS THAT MAY BE REQUIRED FOR A COMPLETE INSTALLATION. THE CONTRACTOR SHALL BE RESPONSIBLE FOR PROVIDING ALL MATERIALS NEEDED FOR A COMPLETE AND FUNCTIONAL INSTALLATION.
- ELECTRIC EQUIPMENT AND DEVICES (E.G. PSX, NETWORK SWITCHES) ARE SHOWN FOR REFERENCE ONLY.
- REFER TO ARCHITECTURAL DETAIL PLANS FOR FINAL PATIENT ROOM DEVICE LOCATIONS. REFER TO ARCHITECTURAL DETAILS FOR OVERCOUNTER WAO HEIGHTS. REFER TO ARCHITECTURAL DETAILS FOR WALL-MOUNT WAO HEIGHTS.
- HORIZONTAL DATA/VOICE/VIDEO CABLE SHALL TERMINATE IN THE TECHNOLOGY ROOM ON THE SAME FLOOR AS THE WORK AREA OUTLETS.
- WORK AREA OUTLETS SHALL CONSIST OF SINGLE PLASTER REDUCING RINGS INSTALLED ON OVERSIZE DOUBLE GANG BACKBOXES, UNLESS OTHERWISE NOTED.
- TV COAX CABLES SHALL BE COILED IN THE RESPECTIVE TECHNOLOGY ROOMS WITH A 20' SERVICE LOOP PRIOR TO TERMINATIONS. COILS SHALL BE SECURED TO THE AUDIOVISUAL WALL FIELD FOR AV CONTRACTOR.
- COMMON LOW VOLTAGE CABLE RUNWAY IS 24" W X 6" H HIGH. PROVIDE ALL MATERIALS AS NEEDED FOR A COMPLETE, MANUFACTURER-APPROVED SYSTEM USING CABLE TRAY MANUFACTURERS' MATERIALS AND PARTS WHEN AVAILABLE FROM THE MANUFACTURER AND AS INTENDED. REFER TO DRAWING T4-01 FOR DETAILS. ALL CHANGES IN DIRECTION AND INTERSECTIONS SHALL USE PRE-MANUFACTURED OR FIELD-INSTALLED SWEEPS AND TEES. ALL SWEEPS AND TEES SHALL MAINTAIN A 1 FOOT MINIMUM RADIUS IN CHANGES OF DIRECTION.
- CABLE TRAY SHALL NOT PENETRATE WALLS. PROVIDE TRANSITION FROM CABLE TRAY TO LISTED FIRESTOP ASSEMBLIES IN ORDER TO PENETRATE FIRE-RATING WALLS. TRANSITION TO 4" CONDUITS/SLEEVES FOR NON-RATED WALLS. PROVIDE SUFFICIENT CONDUITS/SLEEVES TO ACCOMMODATE 100% VISUAL CABLE TRAY LOAD AT 50% VISUAL CONDUIT FILL.
- REFER TO ELECTRICAL DRAWINGS & SPECIFICATIONS FOR SHARED FLOOR BOXES & LOW VOLTAGE CONDUIT.
- PROVIDE BRACING TO MEET OSHDP SEISMIC REQUIREMENTS. REFER TO SHEET T4-02 FOR MORE INFORMATION.
- PROVIDE ALL OUTLET CONDUITS FROM WORK AREA OUTLETS, DEVICES OR PULL BOXES TO NEAREST CABLE TRAY.
- INSTALL CABLE TRAY @ 6" ABOVE CEILING.

#### KEY PLAN

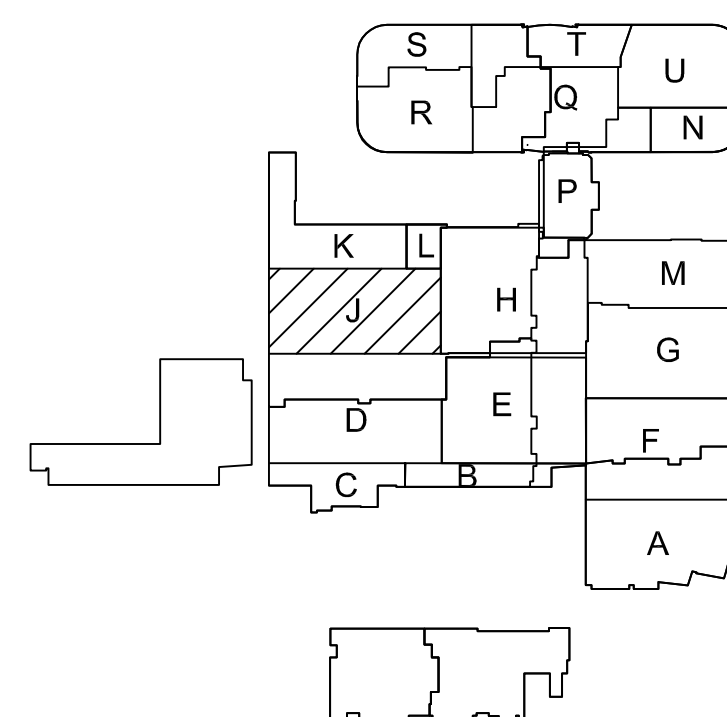

## CHILDREN'S HOSPITAL OF ORANGE COUNTY - TOWER II

PROJECT:  
ADDRESS:  
W.O. NO.:

PROPRIETARY STATEMENT  
THESE DRAWING DOCUMENTS HEREBY ATTACHED ARE THE PROPERTY OF BERGELECTRIC CORPORATION. ANY REUSE OR REPRODUCTION OF THESE DOCUMENTS WITHOUT WRITTEN PERMISSION OF BERGELECTRIC CORPORATION IS STRICTLY FORBIDDEN. ALL RIGHTS RESERVED.

DRAWN BY:  
J. RAMIREZ

DESIGN SUPERVISOR:

INSTALL SUPERVISOR:  
Scott Adams  
Tel Data Systems  
Bergelectric Corporation  
850 Upper Street  
Escondido, CA 92029

REVISION:  
05-30-12 RECORD DRAWINGS

SHEET TITLE:


TELECOM  
FLOOR PLAN  
LEVEL 3  
AREA-J

SCALE:  
1/4"=1'0"


DRAWING NO.:


T3.3J  
RECORD  
DRAWING

Bergelectric Corp.  
Contractors & Engineers  
#C10-485046  
650 UPPER ST.  
ESCONDIDO, CA 92029  
(760) 742-1033  
FAX (760) 742-4619

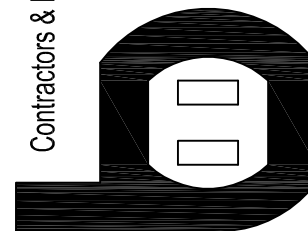

T3 LEVEL 3 - TELECOM PLAN - AREA J  
1/4"=1'0"

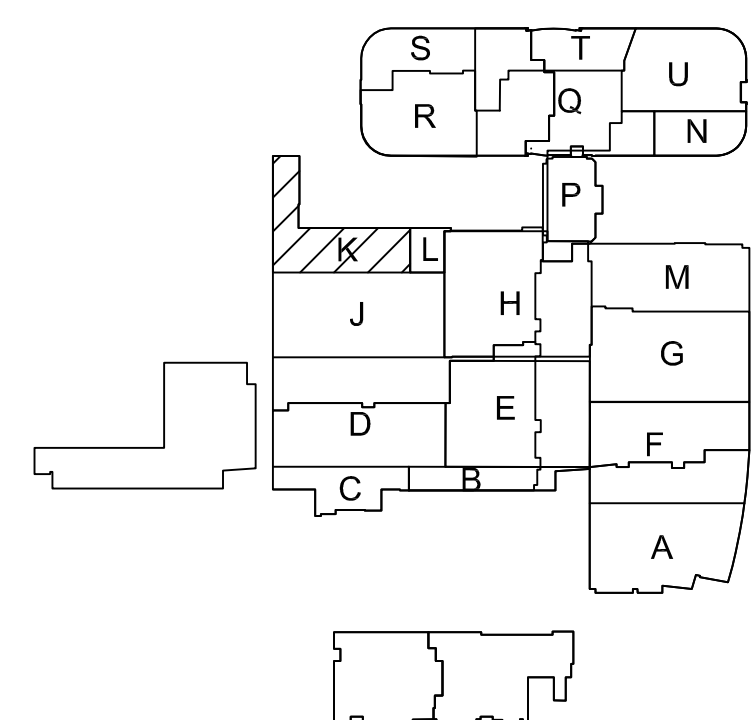

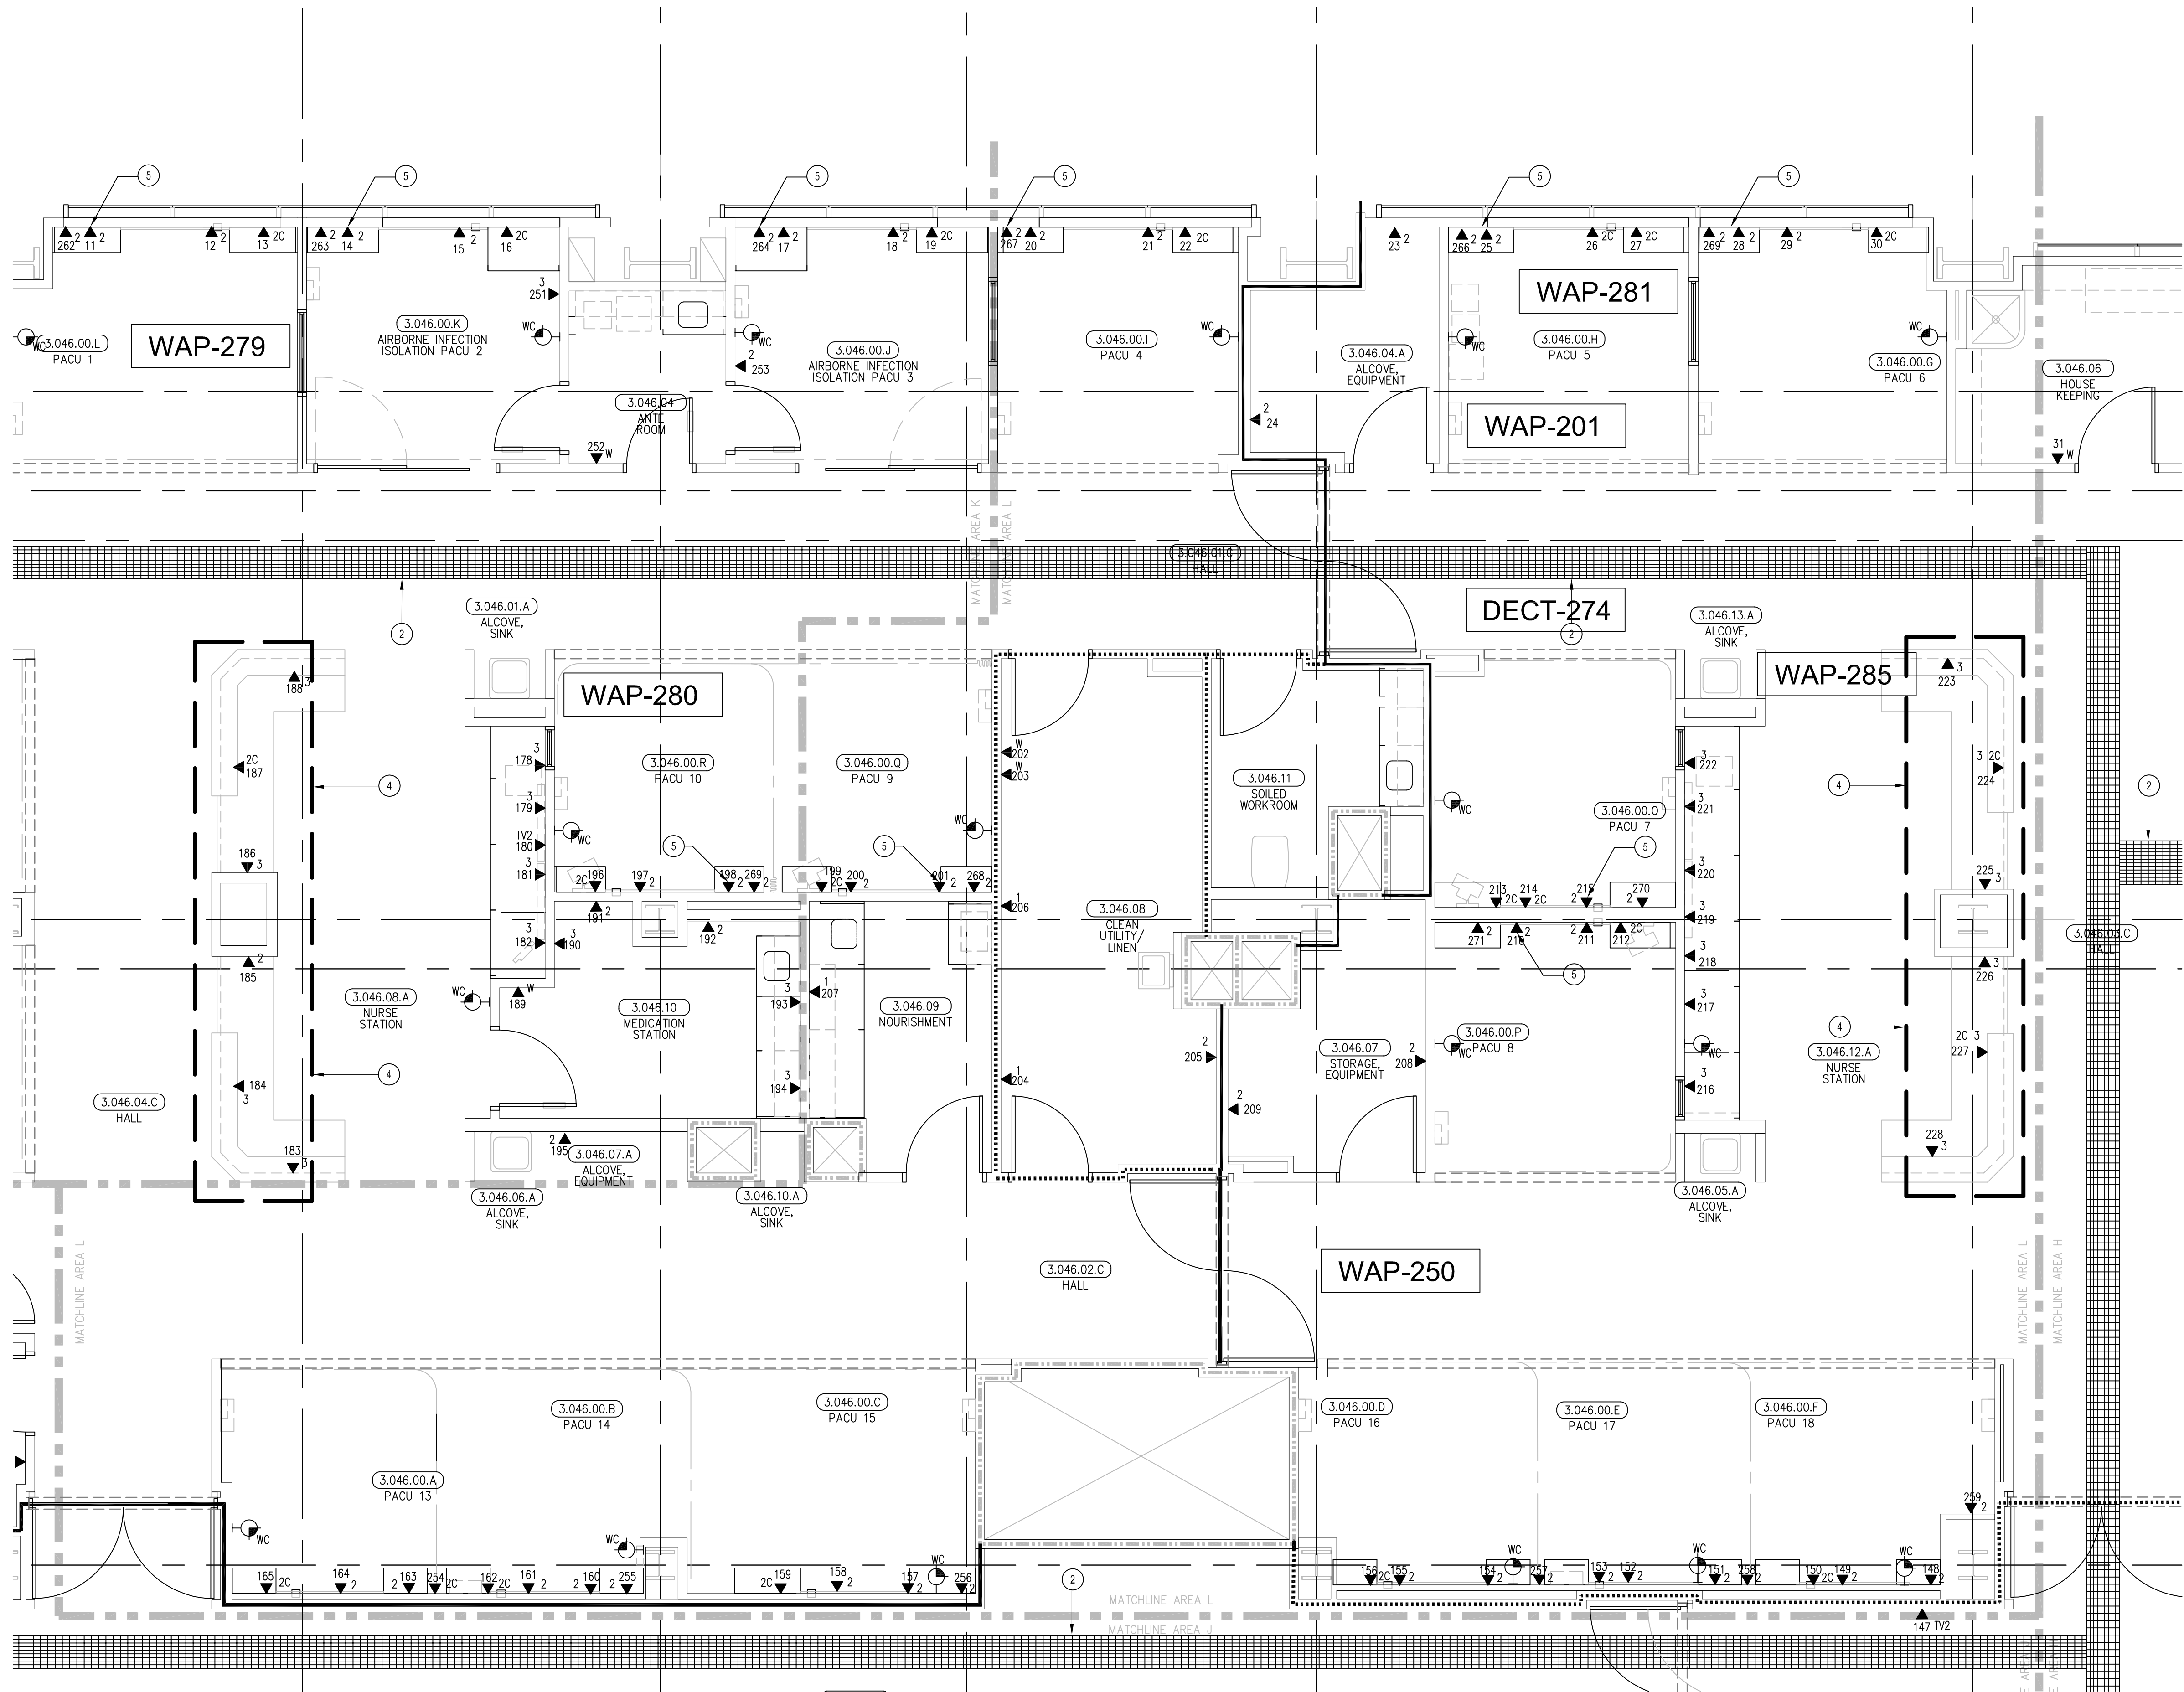


#### SHEET KEYNOTES

- 12" W X 6" H CABLE RUNWAY
- 24" W X 6" H CABLE RUNWAY
- 18" W X 6" H CABLE RUNWAY
- OUTLETS ARE TO BE FED VIA WALL FROM ABOVE CEILING SPACE. PROVIDE TWO (2) 1-1/4" CONDUITS FROM CABLE TRAY TO MILLWORK. TERMINATE CONDUITS AT 24" A.F.F. AND EXTEND ONTO MILLWORK USING NON-METALLIC SURFACE RACEWAYS WITH MINIMUM OF 1"X1" INTERNAL AREA TO EACH OUTLET.
- WORK AREA OUTLET TO BE LOCATED +72" A.F.F.

#### GENERAL SHEET NOTES

- THE DRAWINGS ARE DIAGRAMMATIC ONLY AND MAY NOT SHOW ALL COMPONENTS, MATERIALS, OFFSETS, BENDS, ELBOWS AND OTHER SPECIFIC ELEMENTS THAT MAY BE REQUIRED FOR A COMPLETE INSTALLATION. THE CONTRACTOR SHALL BE RESPONSIBLE FOR PROVIDING ALL MATERIALS NEEDED FOR A COMPLETE AND FUNCTIONAL INSTALLATION.
- ELECTRIC EQUIPMENT AND DEVICES (E.G. PBX, NETWORK SWITCHES) ARE SHOWN FOR REFERENCE ONLY.
- REFER TO ARCHITECTURAL DETAIL PLANS FOR FINAL PATIENT ROOM DEVICE LOCATIONS. REFER TO ARCHITECTURAL DETAILS FOR OVERCOUNTER WAO HEIGHTS. REFER TO ARCHITECTURAL DETAILS FOR WALL-MOUNT WAO HEIGHTS.
- HORIZONTAL DATA/VIDEO/VEIDED CABLE SHALL TERMINATE IN THE TECHNOLOGY ROOM ON THE SAME FLOOR AS THE WORK AREA OUTLETS.
- WORK AREA OUTLETS SHALL CONSIST OF SINGLE PLASTER REDUCING RINGS INSTALLED ON OVERSIZE DOUBLE GANG BACKBOXES, UNLESS OTHERWISE NOTED.
- TV COAX CABLES SHALL BE COILED IN THE RESPECTIVE TECHNOLOGY ROOMS WITH A 2' SERVICE LOOP PRIOR TO TERMINATIONS. COILS SHALL BE SECURED TO THE INDIVIDUAL WALL FIELD FOR ANY CONTRACTOR.
- COMMON LOW VOLTAGE CABLE RUNWAY IS 24" W X 6" HIGH. PROVIDE ALL MATERIALS AS NEEDED FOR A COMPLETE, MANUFACTURER-APPROVED SYSTEM USING CABLE TRAY MANUFACTURERS MATERIALS AND PARTS WHEN AVAILABLE FROM THE MANUFACTURER AND AS INTENDED. REFER TO DRAWING T4.01 FOR DETAILS. ALL CHANGES IN DIRECTION AND INTERSECTIONS SHALL USE PRE-MANUFACTURED OR FIELD-INSTALLED SWEEPS AND TEES. ALL SWEEPS AND TEES SHALL MAINTAIN A 1' FOOT MINIMUM RADIUS IN CHANGES OF DIRECTION.
- CABLE TRAY SHALL NOT PENETRATE WALLS. PROVIDE TRANSITION FROM CABLE TRAY TO LISTED FIRESTOP ASSEMBLIES IN ORDER TO PENETRATE FIRE/SMOKE WALLS. TRANSITION TO 4" CONDUITS/SLEEVES FOR NON-RATED WALLS. PROVIDE SUFFICIENT CONDUITS/SLEEVES TO ACCOMMODATE 100% VISUAL CABLE TRAY LOAD AT 50% VISUAL CONDUIT FILL.
- REFER TO ELECTRICAL DRAWINGS & SPECIFICATIONS FOR SHARED FLOOR BOXES & LOW VOLTAGE CONDUIT.
- PROVIDE BRACING TO MEET OSHPD SEISMIC REQUIREMENTS. REFER TO SHEET T4.02 FOR MORE INFORMATION.
- PROVIDE ALL OUTLET CONDUITS FROM WORK AREA OUTLETS, DEVICES OR PULL BOXES TO NEAREST CABLE TRAY.
- INSTALL CABLE TRAY @ 6" ABOVE CEILING.

#### KEY PLAN

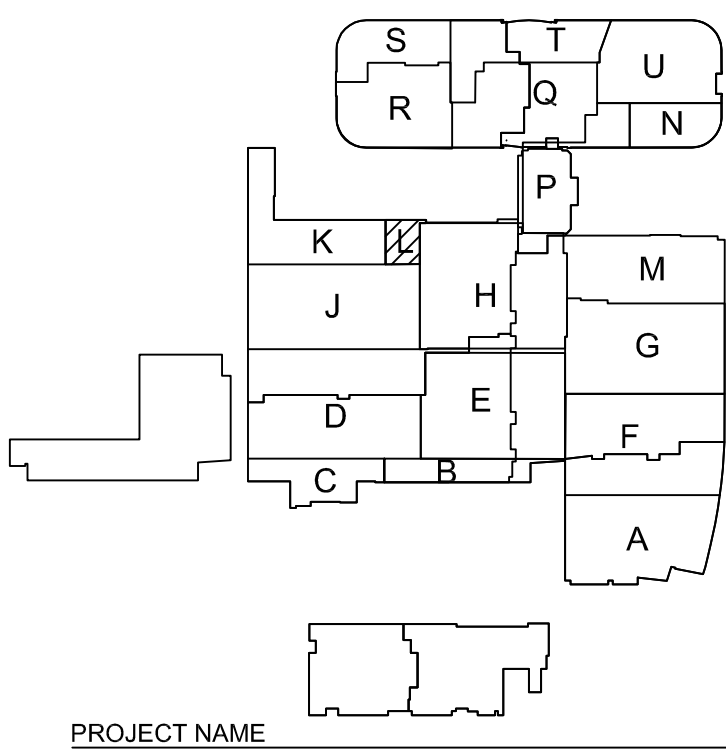

## CHILDREN'S HOSPITAL OF ORANGE COUNTY - TOWER II

PROJECT:

ADDRESS: 455 South Main Street  
Orange, CA 92668-3874

W.O. NO.:

#### PROPRIETARY STATEMENT

THESE DRAWING DOCUMENTS HEREIN ATTACHED ARE THE PROPERTY OF BERGELECTRIC CORPORATION. ANY REUSE OR REPRODUCTION OF THESE DOCUMENTS WITHOUT WRITTEN PERMISSION OF BERGELECTRIC CORPORATION IS STRICTLY FORBIDDEN. ALL RIGHTS RESERVED.

#### DRAWN BY:

J. RAMIREZ

#### DESIGN SUPERVISOR:

#### INSTALL SUPERVISOR:

Scott Adams  
Tel Data Systems  
Bergelectric Corporation  
850 Oppen Street  
Escondido, CA 92029

#### REVISIONS:

05-30-12 RECORD DRAWINGS

#### SHEET TITLE:

TELECOM  
FLOOR PLAN  
LEVEL 3  
AREA-L


#### SCALE:

1/4"=1'0"

#### DRAWING NO.:


T3.3L  
RECORD  
DRAWING

Bergelectric Corp.  
Contractors & Engineers

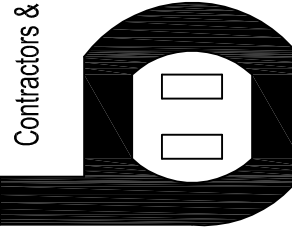

HC10-485046  
(760) 746-1033  
650 OPPEN ST.  
ESCONDIDO, CA 92029  
FAX (760) 746-4619

T3 LEVEL 3 - TELECOM PLAN - AREA L  
1/4" = 1'-0"

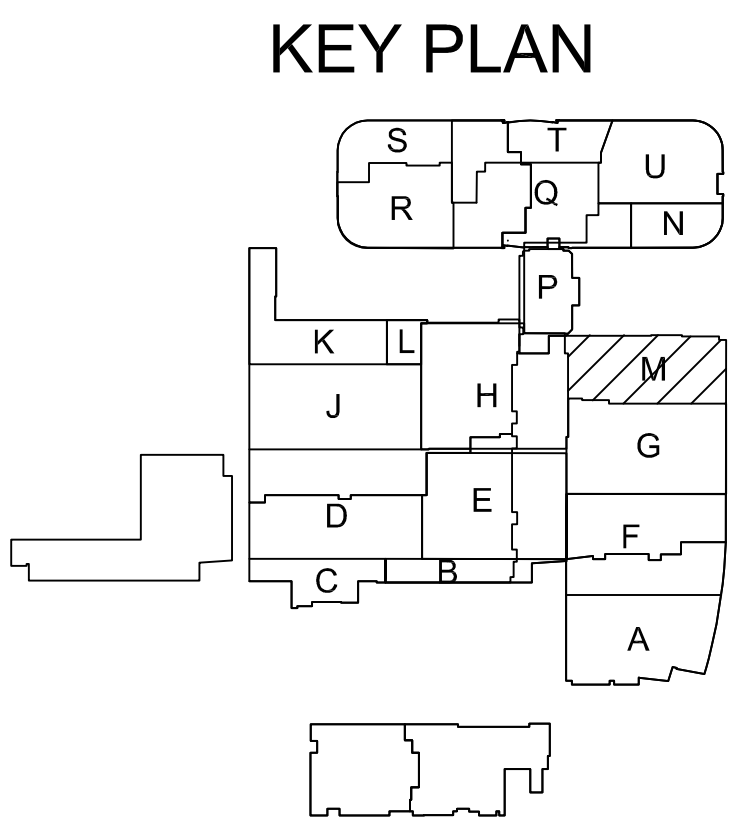

T3.3M  
RECORD  
DRAWING