


FKP Architects

RFI 5039  
CASp Item #75 - Change wall type  
ARCHITECT OF RECORD  
Paul C. Gloriot

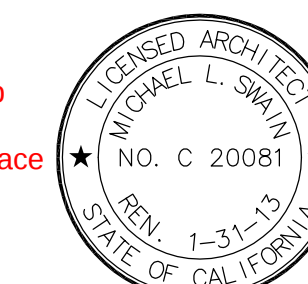


Changes on these drawings do not consist of  
materially altered changes to approved drawings  
and don't require a change order.  
OSHPD review ACO  
OSHPD review FLSO  
OSHPD review DSE

#### REVISIONS

|    |          |           |
|----|----------|-----------|
| 44 | 05/28/10 | ASI #08   |
| 35 | 08/27/10 | ASI #29   |
| 33 | 11/15/10 | ASI #29R1 |
| 19 | 03/28/11 | CO #156   |
| 23 | 05/20/11 | ASI #90   |
| 33 | 09/19/11 | ASI #110  |
| 39 | 11/14/11 | ASI #139  |

#### APPROVAL

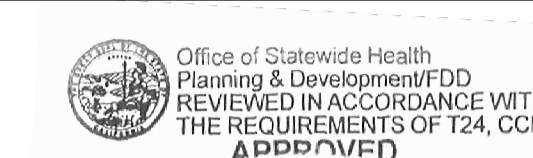

CHANGE ORDER/INSTRUCTION BULLETIN/DEFERRED APPROVAL/

#### PROJECT NAME

CHILDREN'S HOSPITAL  
OF ORANGE COUNTY

455 S. Main St.  
Orange, CA 92668-3874

#### TOWER II



#### PROJECT NUMBER

12011.00  
Increment #7

#### OSHPD - PROJECT NUMBER

IL 072072-30

#### ISSUE

OSHPD PERMIT

#### DATE

01/27/2010

#### SCALE


1/4" = 1'

#### DRAWING TITLE

LOWER LEVEL ENLARGED  
PLAN AREA - D

#### DRAWING NUMBER


A3.0D

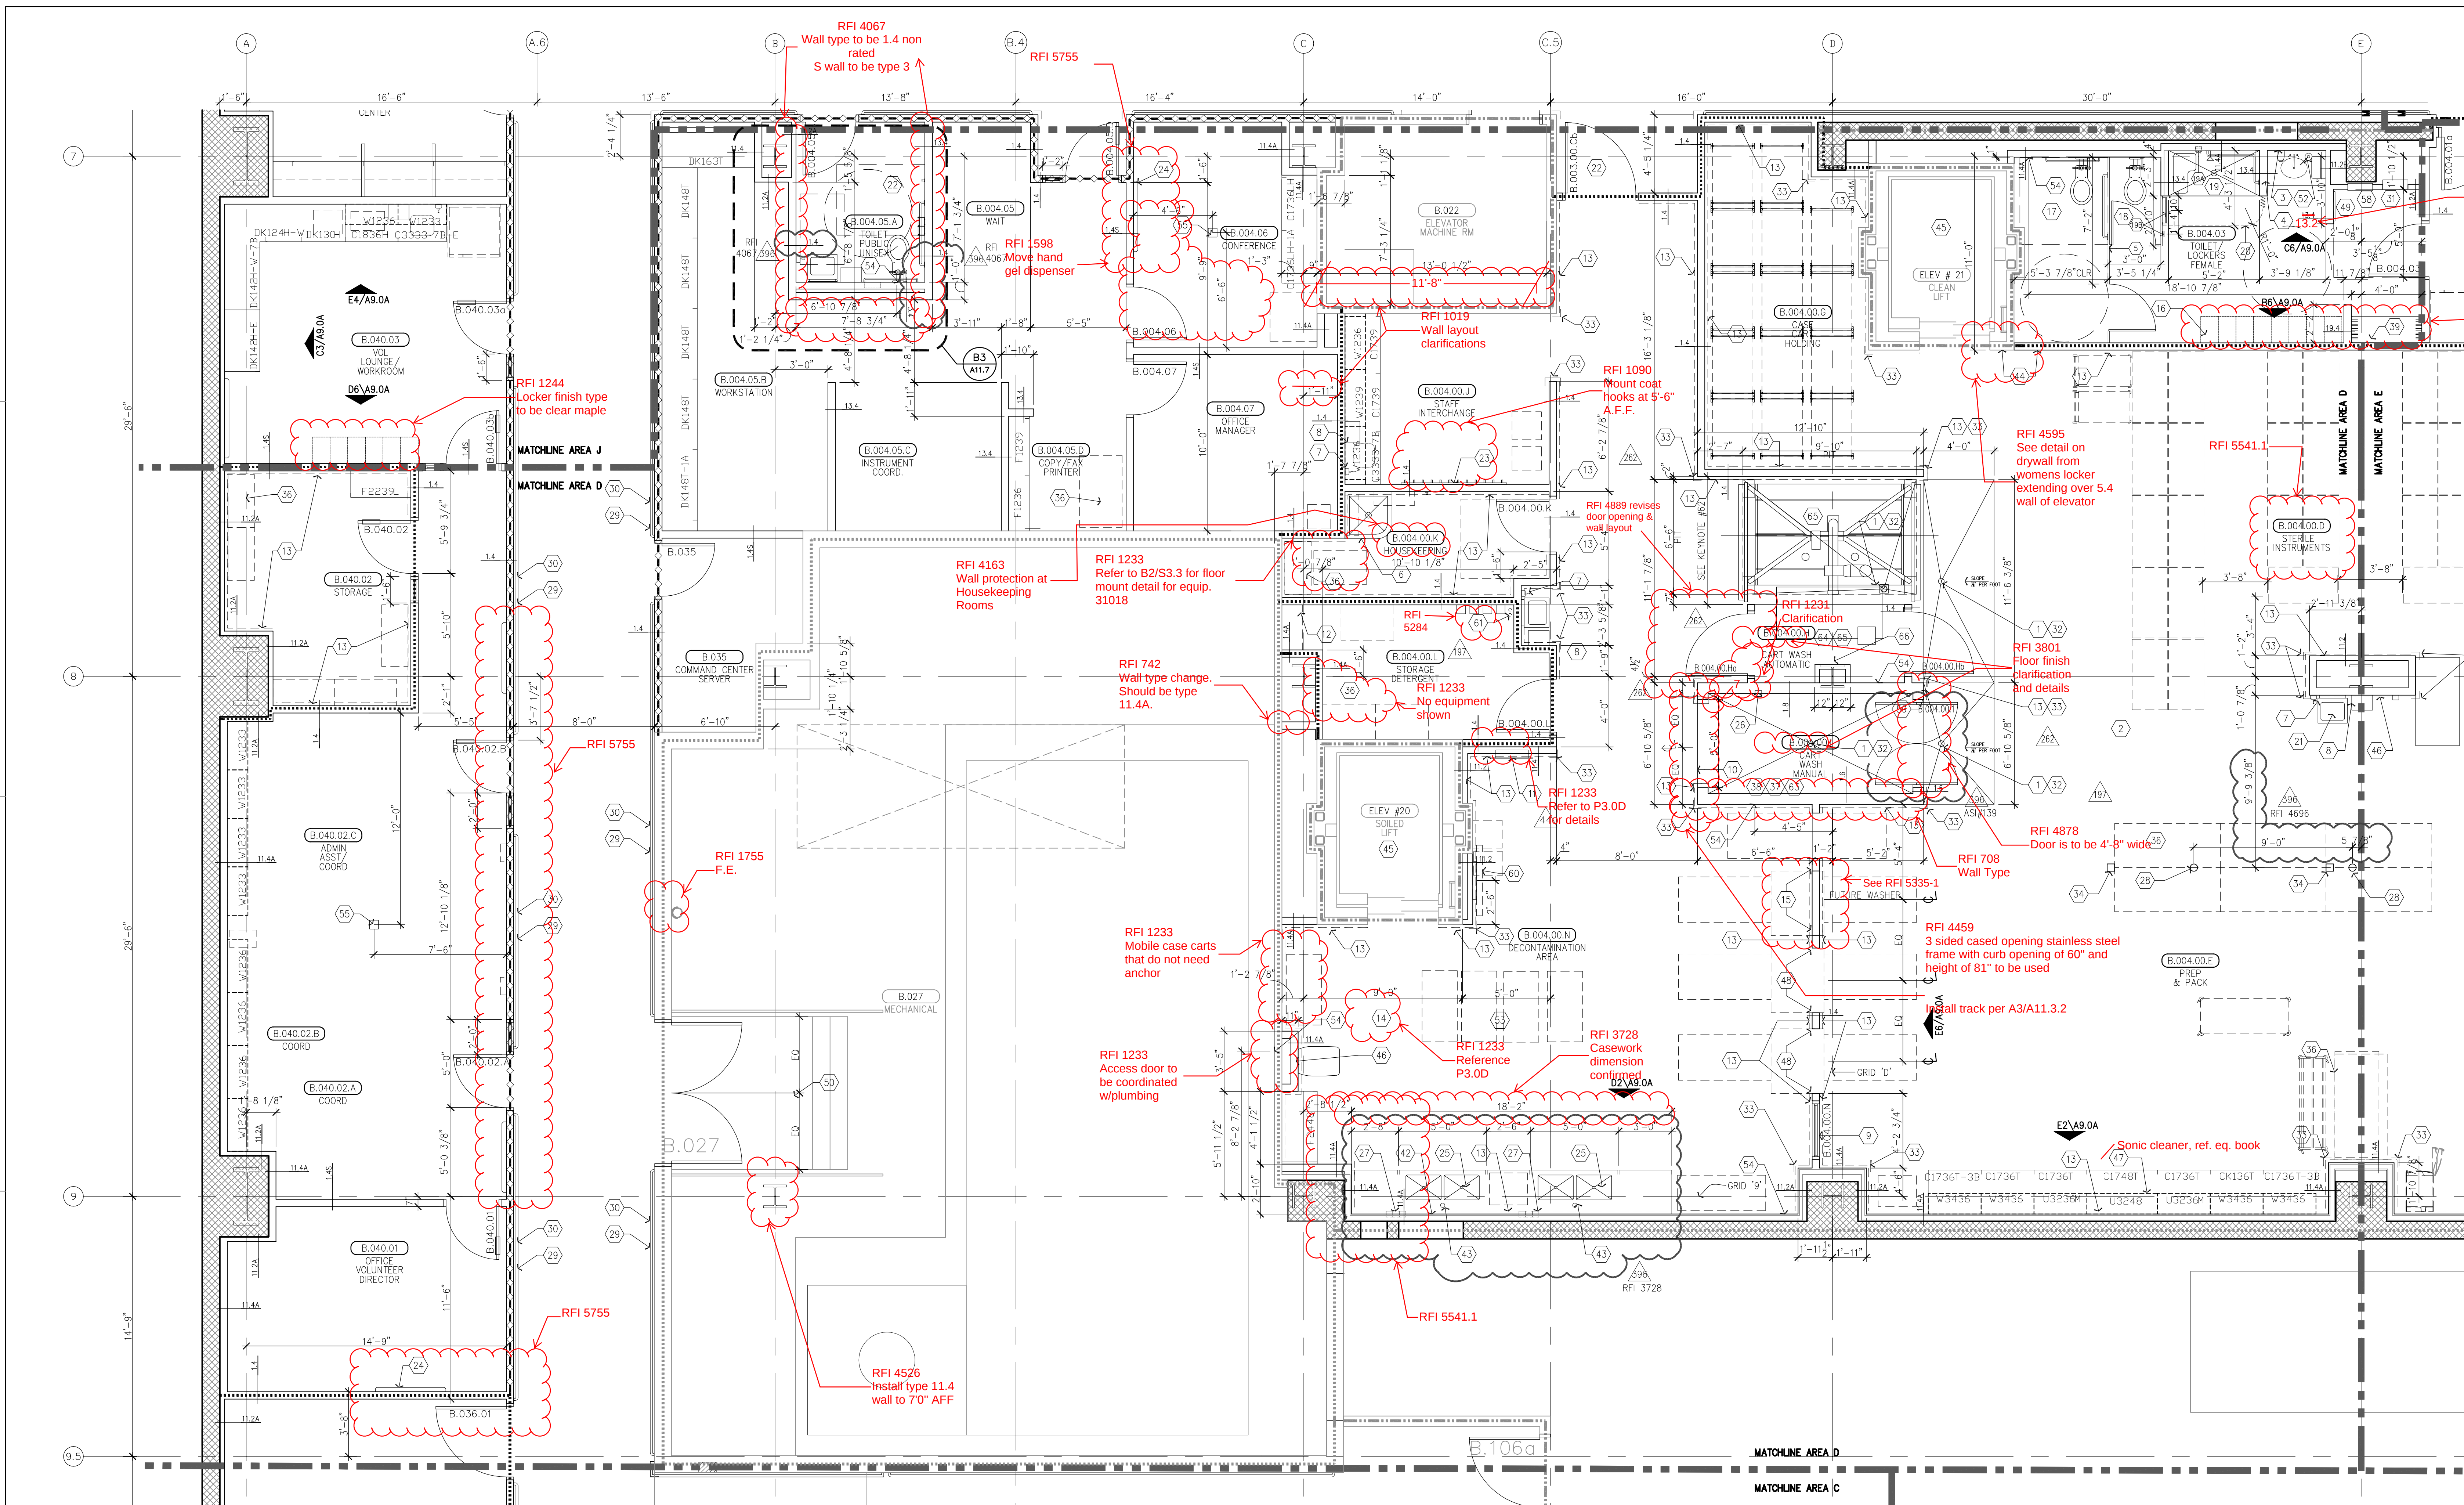

1. Floor drain, sloped floor to drain.  
2. Seamless flooring with integral cove base. See Finish Schedule.  
3. Mirror, full width of counter, from top of splash to 7'-0" A.F.F., wall mounted.  
4. Solid surface material countertop.  
5. Toilet partition, floor mounted.  
6. Housekeeping mop sink. See detail B2/A11.7.  
7. Soap dispenser, wall mounted. See Equipment drawings & workbook.  
8. Paper towel dispenser, wall mounted. See Equipment drawings & workbook.  
9. Fixed window. See Det. 06/A10.3.1.  
10. Eye wash, recessed in wall.  
11. 14" deep shelf above, wall mounted with standards and brackets. Top of shelf at 6'-0" A.F.F. See detail B6/A11.8.  
12. Sheet wall protection to 48" A.F.F. Sheet wall protection to full height at fur out wall to receive recessed eyewash unit.  
13. Clinical sink.  
14. Removable partition. Removable Partition Type 1.4 above, provide header bottom at 2" below scheduled ceiling. Casing beads at drywall perimeter line, csk joint.  
15. Personal effects storage units, 2 high, with integrated shoe storage at bottom, Plas Lam finish. See referenced elevation.  
16. Accessible toilet stall. See typical plan detail B5/A11.7. For side view See A5/A11.7 for required accessories.  
17. Toilet stall. See detail A4/A11.7 for mounting heights and required accessories.  
18. Accessible shower. See Plumbing & D3/A11.7.  
19. Accessible shower. See Plumbing & D3/A11.7.  
20. Accessible shower. See Plumbing & D3/A11.7.  
100. Accessible shower. See Plumbing & D3/A11.7.

57. Temporary door 2'-4" x 7'-0".  
58. Sanitary dispenser. See detail B6/A11.7 for mounting location.  
59. Traffic Door - (Durulite Evolution XL5270) color to be submitted by the contractor.  
60. TV monitor, wall mounted with external & CCTV data connection.  
61. Corner guard, full height, high impact plastic. See B4/A11.8 sim. Provide at all outside corners this area.  
62. Provide (2) 4" conduits from detergent pumps to cart wash & washer. Coordinate w/ vendor.  
63. Coordinate opening in wall per manufacture requirements. Provide backing @ corners where needed to receive manufacturer's trim pieces.  
64. Provide paper faced moisture resistant gypsum board @ ceiling to receive epoxy paint. Seal tile joint at ceiling w/ mildew resistant sealant.  
65. Provide fluid applied waterproofing sealant @ concrete pit.  
66. Frame tight to column (Partition Type 11.2) to 48"-0" A.F.F.  
67. Patient Monitor. See RTKL Low voltage drawings for model info.  
68. Patient Monitor. See RTKL Low voltage drawings for model info.  
69. Patient Monitor. See RTKL Low voltage drawings for model info.  
70. Patient Monitor. See RTKL Low voltage drawings for model info.  
71. Patient Monitor. See RTKL Low voltage drawings for model info.  
72. Patient Monitor. See RTKL Low voltage drawings for model info.  
73. Patient Monitor. See RTKL Low voltage drawings for model info.  
74. Patient Monitor. See RTKL Low voltage drawings for model info.  
75. Patient Monitor. See RTKL Low voltage drawings for model info.  
76. Patient Monitor. See RTKL Low voltage drawings for model info.  
77. Patient Monitor. See RTKL Low voltage drawings for model info.  
78. Patient Monitor. See RTKL Low voltage drawings for model info.  
79. Patient Monitor. See RTKL Low voltage drawings for model info.  
80. Patient Monitor. See RTKL Low voltage drawings for model info.  
81. Patient Monitor. See RTKL Low voltage drawings for model info.  
82. Patient Monitor. See RTKL Low voltage drawings for model info.  
83. Patient Monitor. See RTKL Low voltage drawings for model info.  
84. Patient Monitor. See RTKL Low voltage drawings for model info.  
85. Patient Monitor. See RTKL Low voltage drawings for model info.  
86. Patient Monitor. See RTKL Low voltage drawings for model info.  
87. Patient Monitor. See RTKL Low voltage drawings for model info.  
88. Patient Monitor. See RTKL Low voltage drawings for model info.  
89. Patient Monitor. See RTKL Low voltage drawings for model info.  
90. Patient Monitor. See RTKL Low voltage drawings for model info.  
91. Patient Monitor. See RTKL Low voltage drawings for model info.  
92. Patient Monitor. See RTKL Low voltage drawings for model info.  
93. Patient Monitor. See RTKL Low voltage drawings for model info.  
94. Patient Monitor. See RTKL Low voltage drawings for model info.  
95. Patient Monitor. See RTKL Low voltage drawings for model info.  
96. Patient Monitor. See RTKL Low voltage drawings for model info.  
97. Patient Monitor. See RTKL Low voltage drawings for model info.  
98. Patient Monitor. See RTKL Low voltage drawings for model info.  
99. Patient Monitor. See RTKL Low voltage drawings for model info.  
100. Patient Monitor. See RTKL Low voltage drawings for model info.

- A. Information shown or referenced on enlarged and/or 1/4" scale drawings will generally not be shown on the smaller scale drawings.  
B. Partition types are scheduled on plans by number. See the "General Notes to Partition Types" on B2/A11.3 and Partition Types on Sheet A11.3, A11.3.1, and A11.3.2 for the definition of partition type references.  
C. Field coordinate all field routed pipe, conduit runs, etc., with locations of recessed accessories and equipment. In the event of a conflict, accessory locations take precedence.  
D. Close all joints between plumbing fixtures/accessories and dissimilar materials w/ sealant (i.e. between sinks and countertops, toilet fixtures and accessories to wall, etc.).  
E. Cabinet numbers noted on enlarged plans refer to Cabinet component numbers, as defined or elevated on Sheet A3.0 unless specific detail references are keyed.  
F. Plan dimensions - refer to B2/A11.3 (General Notes).  
G. For vertical mounting heights of shower accessories. See Detail D6/A11.7.  
H. For vertical mounting heights of typical toilet stall accessories. See Detail A4/A11.7.  
I. For vertical mounting heights of accessible toilet stall accessories. See Detail A5/A11.7.  
J. For vertical mounting heights of typical restroom accessories. See Detail B6/A11.7.  
K. For vertical mounting heights of accessible accessories to restrooms. See Detail A6/A11.7.  
L. For equipment not identified on plan, see Equipment drawings and workbook-Increment #7, Vol. 2E.  
M. For partial enlarged plan at janitor closets. See Detail A3/A11.1.  
N. Public/handicapped restroom graphics will be furnished and installed by the Owner's graphics supplier.  
O. Standard equipment wall mounting heights, see detail A2/A11.9.  
P. Medical equipment wall mounting heights, see details A4/A11.9, D3/A11.9 & Q.02-Increment #7, Vol. 2E.  
Q. Fire Protection equipment wall Mounting Heights, see detail D2/A11.9.  
R. Communication equipment wall Mounting Heights, see detail A3/A11.9.  
S. Equipment mounting heights at Countertops, see detail D3/A11.9.  
T. Equipment mounting heights at Desks, see detail A4/A11.9.  
U. A minimum head clearance of 6'-8" must be maintained at all points in stairways including stair and landing framing.  
V. For all dashed in equipment not identified, refer to EQ drawing series-Increment #7, Vol. 2E and Equipment workbook. Specific items requiring structural support are cross referenced to structural support details via matrix shown on the Equipment drawings-Increment #7, Vol. 2F.  
W. All elevator hoist way entrance frames to have an embossed stainless steel graphic plaque with the floor landing number and Standard Braille markings for the blind. Conform to governing Accessibility codes and standards.  
X. All stair floor landings to receive stencil painted, semi-gloss enamel floor landing numerals 12" high adjacent to the door at 5'-0" AFF in a contrasting color to the scheduled wall color unless a graphic plaque is specifically detailed or noted.  
Y. Elevator Equipment wall mounting heights, see detail A6/A11.9 and B3/A11.9.  
Z. Doors, Frames, Sidelites and Windows: (See Door Schedule). See A11 sheet series.  
AA. Provide wall blocking/backing for items weighing 20lbs or less. See A6/A11.3.1.  
BB. For personal effects storage unit types and sizes see A4/A11.9.  
CC. For typical equipment backing support, see A4/S11-Increment #5.  
DD. For boundaries of alternatives and phasing, see the AP drawing series.  
EE. Provide 3" grommet, unless otherwise noted at 3'-0" O.C. maximum, field located at all electrical components at Nurses stations and Reception desks.  
FF. For vertical mounting heights of service accessories. See Detail A3/A11.7-Increment #7, Vol. 2E.  
GG. Provide access panels below the Patient Room countertops to serve as inspection ports for the Patient Room bathtubs.

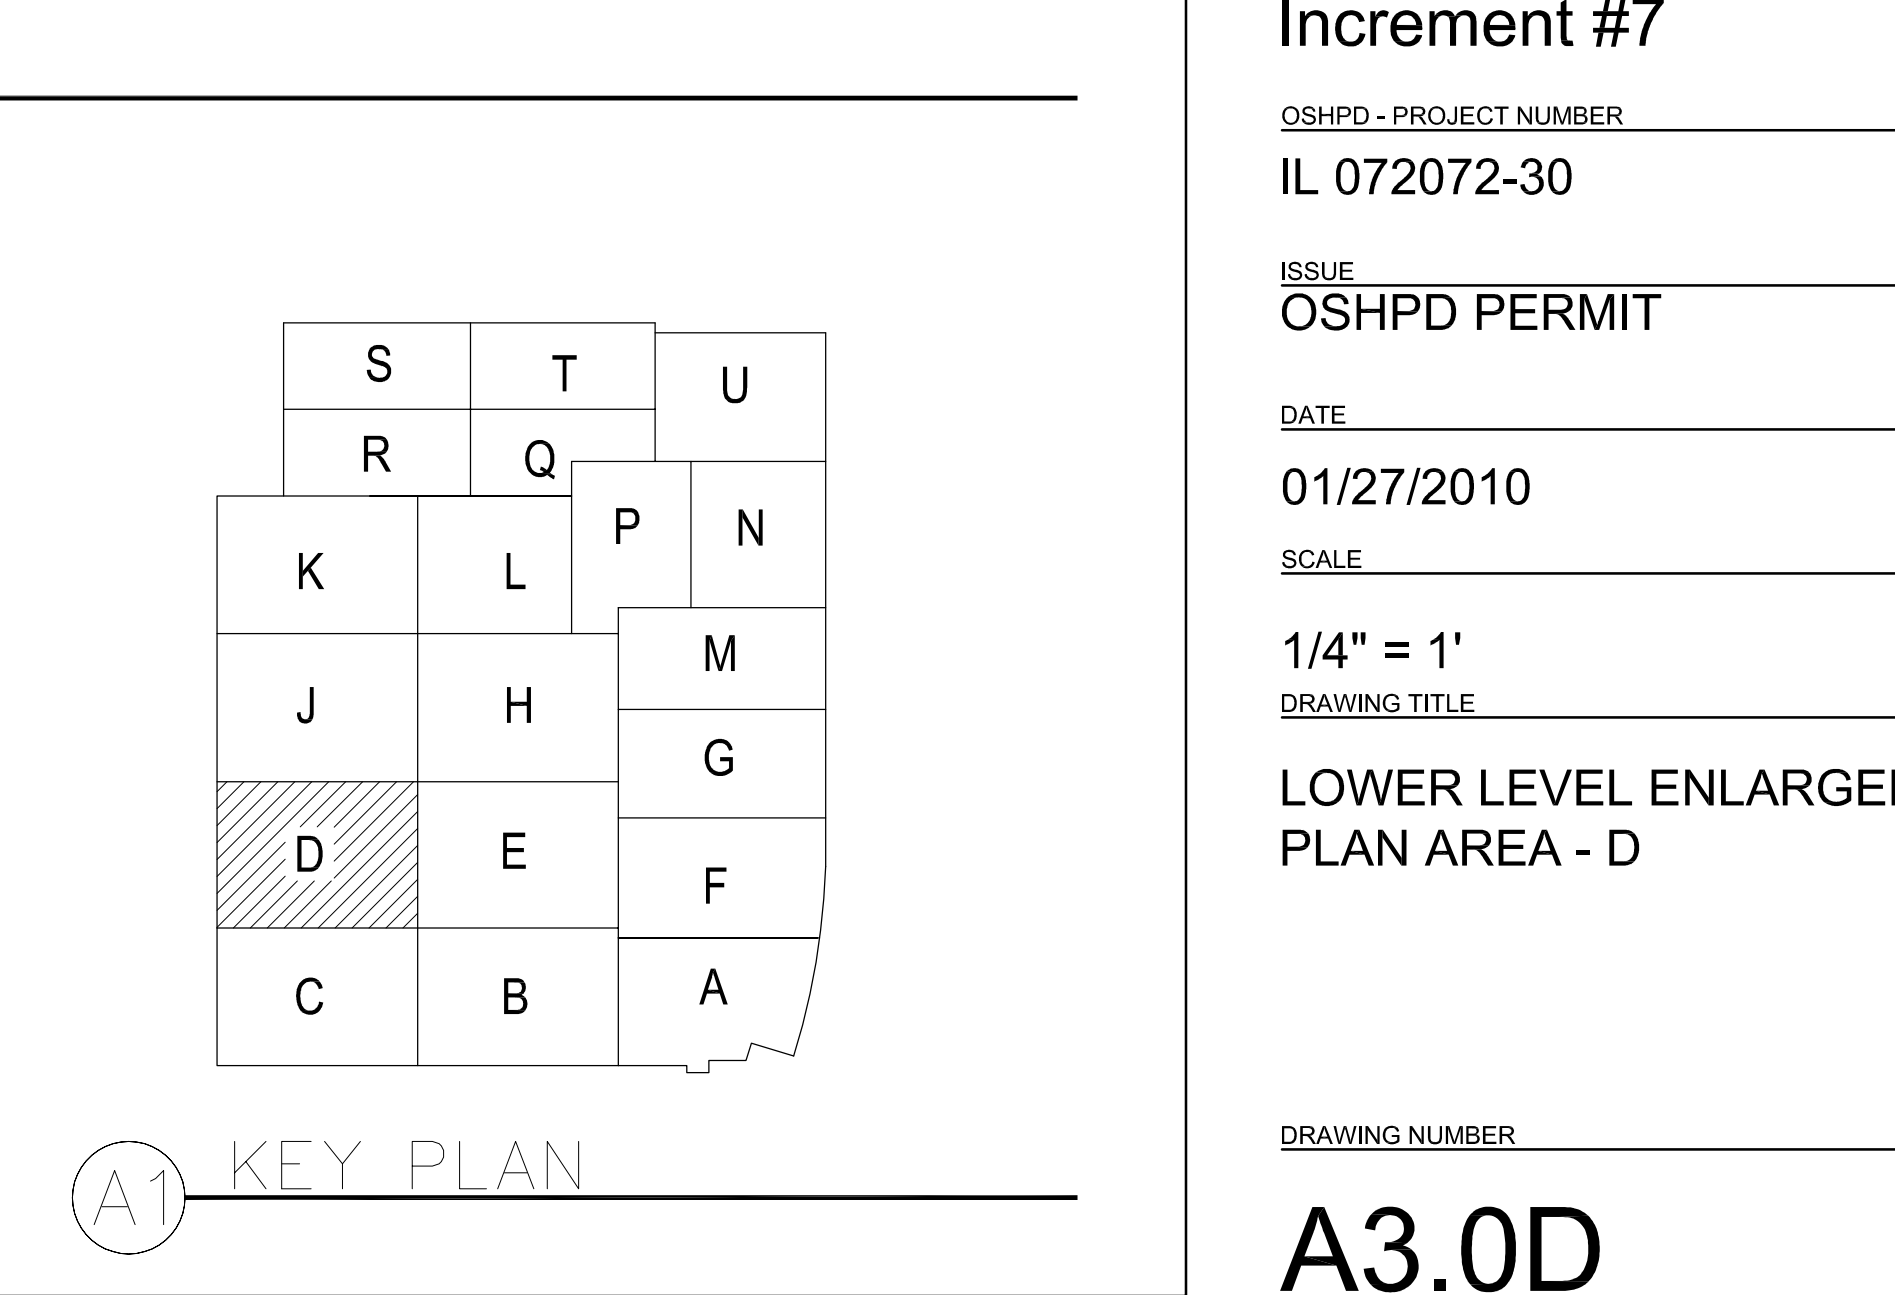

NOTES TO SHEET

GENERAL NOTES

KEY PLAN