


FKP Architects

ARCHITECT OF RECORD
Paul C. Gloriot

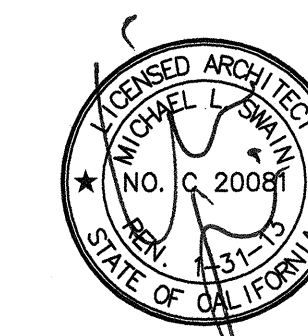

Changes on these drawings do not consist of
materially altered changes to approved drawings
and don't require a change order.
OSHPD review ACO
OSHPD review FLSQ
OSHPD review DSE

REVISIONS

44	05/28/10	ASI #08
38	12/01/10	ASI #48
46	02/24/11	CO #107
49	03/21/11	CO #156
29	07/18/11	CO #226
33	09/28/11	CO #262

OSHPD/FDD Field Review Tracking	
Project:	IL072072-30
Plan:	2011-00639
ACO:	10/19/11
Architectural:	AC D X Refer
Mechanical:	AC D X Refer
Electrical:	AC D X Refer
Structural:	AC D X Refer
OSHPD:	10/19/11
FLSQC:	AC D X Refer
Final Life Safety:	AC D X Refer

APPROVAL



CHANGE ORDER: PAD-2011-00639
INSTRUCTION BULLETIN:
DEFERRED APPROVAL
ADDENDUM

PROJECT NAME
**CHILDREN'S HOSPITAL
OF ORANGE COUNTY**
455 S. Main St.
Orange, CA 92668-3874

RECEIVED
TOWER II OCTOBER 13, 2011
McCarthy



PROJECT NUMBER

**12011.00
Increment #7**

OSHPD - PROJECT NUMBER
IL 072072-30

ISSUE
OSHPD PERMIT

DATE
01/27/2010

SCALE

1/4"=1'-0"

DRAWING TITLE

**LOWER LEVEL ENLARGED
PLAN AREA - E**

DRAWING NUMBER

A3.0E

- Equipment item, see Equipment drawings & workbook.
- Mirror, full width of counter, full height from counter to 7'-0" A.F.
- Framed Mirror, 24" wide x 52" high, Mounted at 18" A.F.F.
- Alcohol gel dispenser, wall mounted, O.F.O.
- Accessible toilet stall, See typical plan detail B5/A11.7.
- Accessible shower, See Plumbing and D2/A11.7.
- Soap holder, See D6-B/A11.7 for dimension/ mounting location.
- Towel rack and towel bar, See detail D6-A/A11.7 for mounting height location.
- Robe hook, See B6/A11.7 for mounting height.
- Toilet seat cover dispenser, See A6/A11.7 for mounting height location.
- Shower curtain track, ceiling mounted.
- Soap dispenser, wall mounted, See Equipment drawings & workbook.
- Paper towel dispenser, wall mounted, See Equipment drawings & workbook.
- Personal effects storage units, 2 high, Type C, with integrated shoe space at bottom, See A6/A10.3.
- Coordinate partition openings with supplied OFC equipment vendor requirements.
- Stainless back plates.
- Terrazzo floor with coved base, See Finish schedule.
- Solid surface material countertop.
- Toilet partition, floor mounted.
- Integrated double egress door, wall recessed, See D6/A11.4.
- Future wall.
- Sheet wall protection to 48" A.F.F.
- Bumper rail, See detail B4/A11.6.
- Hand rail/crash rail, See detail B4/A11.8.
- Fully recessed paper towel and trash receptacle, See B6/A11.7.
- Corner guard, full height, high impact plastic, See detail B4/A11.8 sim.
- Wall mounted urinal, See Plumbing.
- Furniture Item, See Furniture.
- Case cart staging.
- Infill partition to deck with header at 8'-0" A.F.F. Casing joints at 8'-0" A.F.F. Seal all joints, rock bolts sides above 8'-0" A.F.F.
- For construction requirements, partition types and dimensions, this area, see increments 5 and 6, Vol. 2A and 2B.
- Wall mounted bench, See B2/A11.7.
- Soap dispenser, lanyard mounted, See Specifications.
- Cable Tray, 8'-6" underside elevation a.f.f. - See T5.13A for detail.
- Telecom Equipment Rack - See T5.13A for detail. For anchorage detail, see Structural Plan.
- CRAC Unit - See Mechanical Plan (M3.0E) for detail. For anchorage detail, see Structural Plan.
- Modified countertop to 25 1/2" deep for entire cabinet length, Detail CSA/A9.0.
- Freestanding plasma sterilizer, See equipment plan and low voltage for mega-galga.
- TV/ACR wall mounted, CO#252
- CO 107
- CO#226


(D1) NOTES TO SHEET

- A. Information shown or referenced on enlarged and/or 1/4" scale drawings will generally not be shown on the smaller scale drawings.
- B. Partition types are scheduled on plans by number. See the "General Notes to Partition Types" on B2/A11.3 and Partition Types on Sheet A11.3, A11.3.1, and A11.3.2 for the definition of partition type references.
- C. Field coordinate of field routed pipe, conduit runs, etc., with locations of recessed accessories and equipment. In the event of a conflict, accessory locations take precedence.
- D. Close all joints between plumbing fixtures/accessories and dissimilar materials w/sealant (i.e. between sinks and countertops, toilet fixtures and accessories to wall, etc.)
- E. Cabinet numbers noted on enlarged plans refer to Cabinet component numbers, fixtures, accessories, etc. that are defined or elevated on Sheet A9.0 unless specific detail references are keyed.
- F. Plan dimensions - refer to B2/A11.3 (General Notes).
- G. For vertical mounting heights of shower accessories, See Detail D6/A11.7.
- H. For vertical mounting heights of typical toilet stall accessories, See Detail A4/A11.7.
- I. For vertical mounting heights of accessible toilet stall accessories, See Detail A5/A11.7.
- J. For vertical mounting heights of typical restroom accessories, See Detail B6/A11.7.
- K. For vertical mounting heights of accessible accessories at restrooms, See Detail A6/A11.7.
- L. For equipment not identified on plan, see Equipment drawings and workbook-Increment #7, Vol. 2E.
- M. For partial enlarged plan at janitor closets, See Detail A3/A11.7.
- N. Public/handicapped restroom graphics will be furnished and installed by the Owner's graphics supplier.
- O. Standard equipment wall mounting heights, see detail A2/A11.9.
- P. Medical equipment wall mounting heights, see details A4/A11.9, D3/A11.9 & Q002-Increment #7, Vol. 2E.
- Q. Fire Protection equipment wall mounting heights, see detail D2/A11.9.
- R. Communication equipment wall mounting heights, see detail A3/A11.9.
- S. Equipment mounting heights at Countertops, see detail D3/A11.9.
- T. Equipment mounting heights at Desks, see detail A4/A11.9.
- U. A minimum head clearance of 6'-8" must be maintained at all points in stairways including stair and landing framing.
- V. For all dashed in equipment not identified, refer to EQ drawing series-Increment #7, Vol. 2E and Equipment workbook. Specific items requiring structural support are cross referenced to structural support details via matrix shown on the Equipment drawings-Increment #7, Vol. 2F.
- W. All elevator hoist way entrance frames to have an embossed stainless steel graphic plaque with the floor landing number and Standard Braille markings for the blind. Conform to governing Accessibility codes and standards.
- X. All stair floor landings to receive stencil painted, semi-gloss enamel floor landing numerals 12" high adjacent to the door at 5'-0" AFF in a contrasting color to the scheduled wall color unless a graphic plaque is specifically detailed or noted.
- Y. Elevator Equipment Wall Mounting Heights, see detail A6/A11.9 and B3/A11.9.
- Z. Doors, Frames, Sidelites and Windows: (See Door Schedule). See A11 sheet series.
- AA. Provide wall blocking/backing for items weighing 200lb or less. See A6/A11.3.1.
- BB. For personal effects storage unit types and sizes see A4/A11.8.
- CC. For typical equipment backing support, see A4/S11-Increment #5.
- DD. For boundaries of alternates and phasing, see the AP drawing series.
- EE. Provide 3" grommet, unless otherwise noted at 3'-0" O.C. maximum, field located at all electrical components at Nurses stations and Reception desks.
- FF. For vertical mounting heights of service accessories, See Detail A3/A11.
- GG. Provide access panels below the Patient Room countertops to serve as inspection ports for the Patient Room bathtubs.

(B1) GENERAL NOTES

S	T	U
R	Q	P
K	L	N
J	H	M
D	E	G
C	B	A

(A1) KEY PLAN

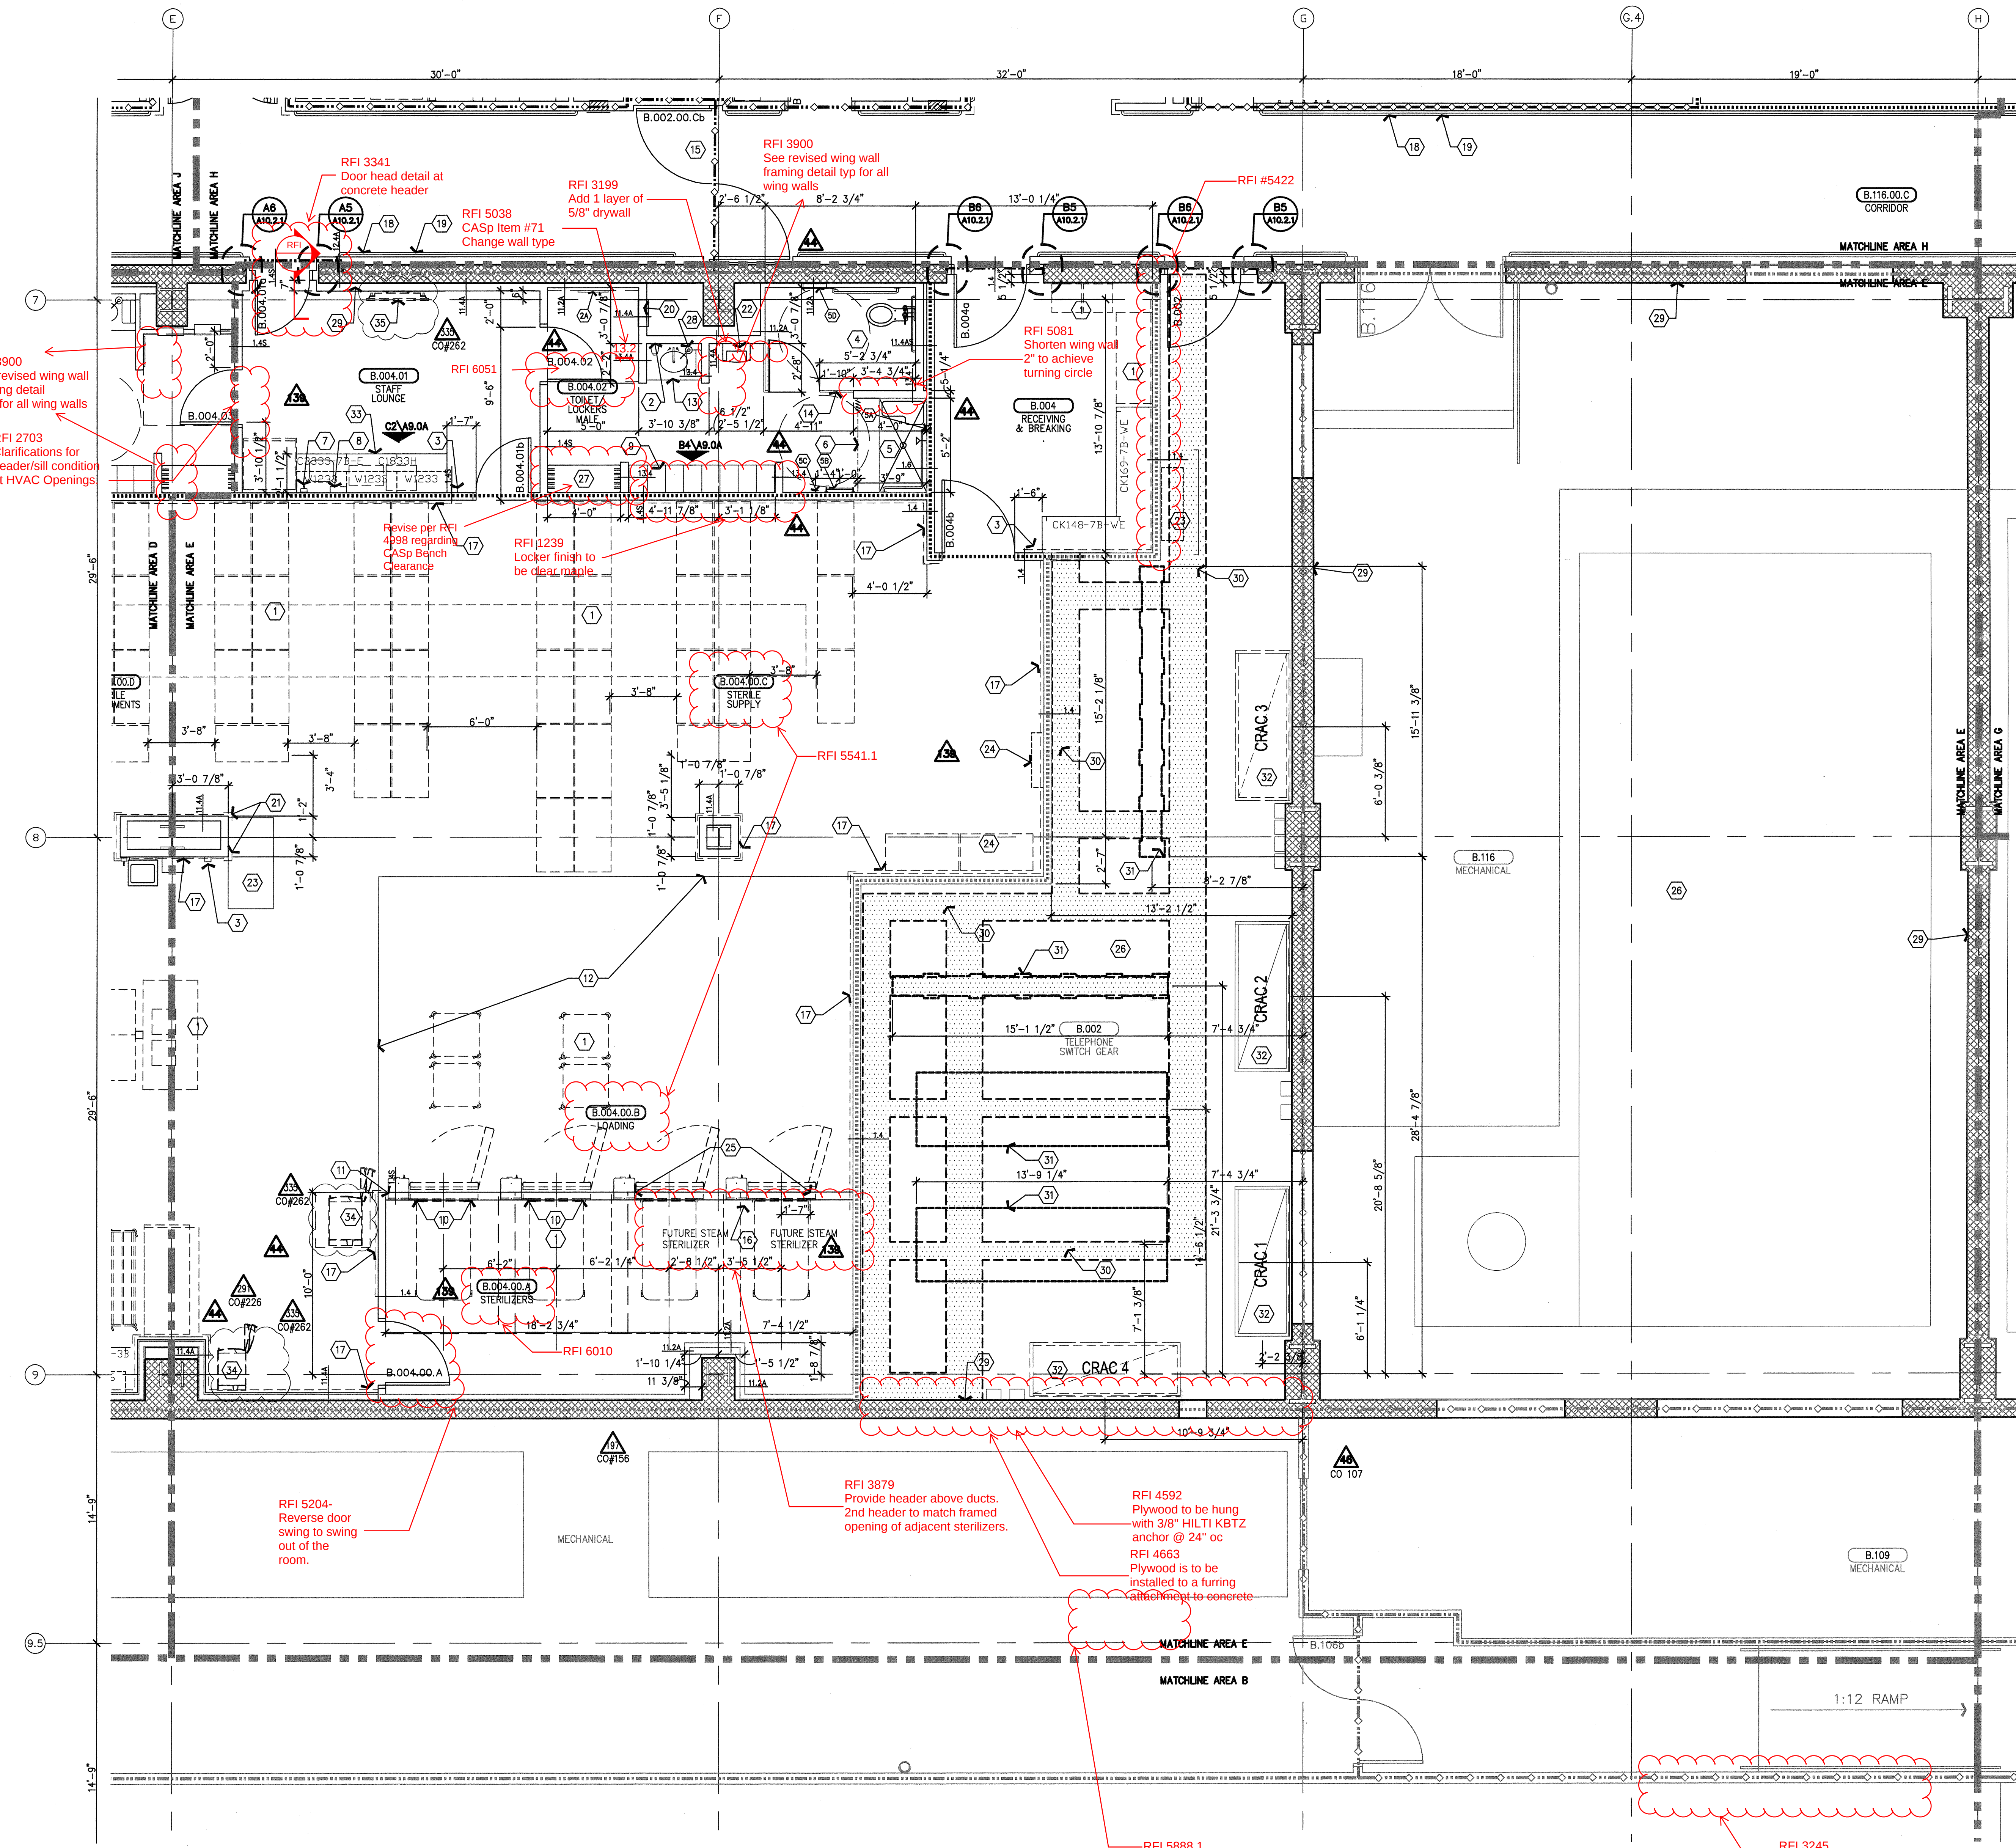

(A6) AREA "E"