

FKP Architects

ARCHITECT OF RECORD

Paul C. Gloriot



Changes on these drawings do not consist of materially altered changes to approved drawings and do not require a change order.
OSHPD review ACO
OSHPD review FLSO
OSHPD review DSE

REVISIONS

44	05/28/10	ASI #08
91	11/18/10	ASI #27
335	09/28/11	CO#262
398	11/14/11	ASI#139

- Personal effects storage units, type C, 2 high (58 total), integrated shelf at bottom, plastic laminate finish. See A6/A10.3 for detail.
- Accessible toilet stall. See typical plan detail B5/A11.7 and A5/A11.7.
- Toilet stall. See detail A4/A11.7.
- Fully recessed paper towel and trash receptacle. See B5/A11.7.
- Soap dispenser, lavatory mounted. See Specifications.
- Toilet paper dispenser, door mounted, pointed metal.
- Circulator/cabinet wall recessed, paint to match adjacent wall, typical. See A2 or B2/A11.8.
- Floor mounted bench. See B2/A11.7.
- Framed mirror, 24" wide x 52" high, mounted at 18" A.F.F.
- Mirror, full width of counter, top of splash to 7'-0" A.F.F.
- Solid surface material countertop. See A2/A11.7.
- Wall protection to 48" A.F.F.
- Bumprail. See detail B4/A11.8.
- Handrail/corral. See detail B4/A11.8.
- Future OSHPD Increment 13. Shelf space this issue, see also Bid Alternates.
- Corner guards at all outside corners this space, high impact plastic, full height. See detail B4/A11.8.
- Equipment item, OFOL. See Equipment plans and workbook.
- Plastic laminate closure/scribe to close joints, match lockers, typical.
- Sloped top, continuous, mylar at corners, typical.
- For ramp requirements, see Increment 5.
- Plastic laminate base cabinets, countertop type 2, chemical resistant plastic laminate. See A5/A11.9. Countertop extends over capwall.
- Capwall partition, align top of partition with top of base cabinet, 6 studs. See similar detail B6/A11.3.
- Plastic laminate finish panel to match base cabinets.
- Existing laminate closure/filler panels to match base cabinets.
- Existing North Tower.
- Soap dispenser.
- Not used.
- Janitor mop sink. See detail A3/A11.7.
- Cart #1, refer to C3/A9.0B for details.
- Cart #2, refer to C4/A9.0B for details.
- Cart #3, refer to C2/A9.0B for details.
- Modified casework/base cabinet designated with M in casework code, to have movable shelves, this area.
- Modified casework/base cabinet designated with M in casework code, pull out shelf at 24" below counter this cabinet.
- Modified casework/base cabinet designated with M in casework code, pull out shelf at 15" below counter this cabinet.
- Modified casework/base cabinet designated with M in casework code, shelf at 6" below counter this cabinet.
- Type 18 low partition with wood cap - 36" high. See detail B6/A11.3.
- Double Tier lockers 12" W x 16" D x 36" H.
- 36" wide accessible path.
- 30" x 48" accessible door.
- Roll back door.
- Chemical waste storage equipment.
- Sanitary dispenser, see detail B6/A11.7 for mounting location.
- Add additional panel style E for support for heavy equipment.

NOTES TO SHEET


- A. Information shown or referenced on enlarged and/or 1/4" scale drawings will generally not be shown on the smaller scale drawings.
- B. Partition types are scheduled on plans by number. See the "General Notes" Partition Types" on B2/A11.3 and Partition Types on Sheet A11.3, A11.3.1, and A11.3.2 for the definition of partition type references.
- C. Field coordinate all field routed pipe, conduit runs, etc., with locations of recessed accessories and equipment. In the event of a conflict, accessory locations take precedence.
- D. Close all joints between plumbing fixtures/accessories and dissimilar materials w/sealant (i.e. between sinks and countertops, toilet fixtures and accessories to wall, etc.).
- E. Cabinet numbers noted on enlarged plans refer to Cabinet component numbers.
- F. Fixtures, accessories, etc. that are defined or elevated on Sheet A9.0 unless specific detail references are keyed.
- G. Plan dimensions - refer to B2/A11.3 (General Notes).
- H. For vertical mounting heights of shower accessories, see Detail D6/A11.7.
- I. For vertical mounting heights of typical toilet stall accessories, see Detail A4/A11.7.
- J. For vertical mounting heights of accessible toilet stall accessories, see Detail A5/A11.7.
- K. For vertical mounting heights of typical restroom accessories, see Detail B6/A11.7.
- L. For vertical mounting heights of accessible accessories at restrooms, see Detail A6/A11.7.
- M. For equipment not identified on plan, see Equipment drawings and workbook-Increment #7, Vol. 2E.
- N. For partial enlarged plan at janitor closets, see Detail A3/A11.7.
- O. Public/handicapped restroom graphics will be furnished and installed by the Owner's graphics supplier.
- P. Standard equipment wall mounting heights, see detail A2/A11.9.
- Q. Medical equipment wall mounting heights, see details A4/A11.9, D3/A11.9 & 00.02-Increment #7, Vol. 2E.
- R. Fire Protection equipment wall mounting heights, see detail D2/A11.9.
- S. Communication equipment wall mounting heights, see detail A3/A11.9.
- T. Equipment mounting heights at Countertops, see detail D3/A11.9.
- U. A minimum head clearance of 6'-8" must be maintained at all points in stairways including stair and landing framing.
- V. For all dashed in equipment not identified, refer to ED drawing series-Increment #7, Vol. 2E and Equipment workbook. Specific items requiring structural support are cross referenced to structural support details via matrix shown on the Equipment drawings-Increment #7, Vol. 2F.
- W. All elevator hold way entrance frames to have an embossed stainless steel graphic plaque with the floor landing number and Standard Braille markings for the blind. Conform to governing Accessibility codes and standards.
- X. All stair floor landings to receive sternal pointed, semi-gloss enamel floor landing numerals 12" high adjacent to the door at 5'-0" AFF in a contrasting color to the scheduled wall color unless a graphic plaque is specifically detailed or noted.
- Y. Elevator Equipment Wall Mounting Heights, see detail A6/A11.9 and B3/A11.9.
- Z. Doors, Frames, Sidelites and Windows: (See Door Schedule). See A11 sheet series.
- AA. Provide wall blocking/backing for items weighing 20lbs or less. See A6/A11.3.1.
- BB. For personal effects storage units types and sizes see A4/A11.8.
- CC. For typical equipment backing support, see A4/S11-Increment #5.
- DD. For boundaries of alternates and phasing, see the AP drawing series.
- EE. Provide 3" grommet, unless otherwise noted at 3'-0" O.C. maximum, field located at all electrical components at Nurses stations and Reception desks.
- FF. For vertical mounting heights of service accessories, see Detail A3/A11.
- GG. Provide access panels below the Patient Room countertops to serve as inspection ports for the Patient Room bathlubs.

GENERAL NOTES

S	T	U
R	Q	P
K	L	N
J	H	M
D	E	G
C	B	A

KEY PLAN

N.I.C.
SEE
INC. #13

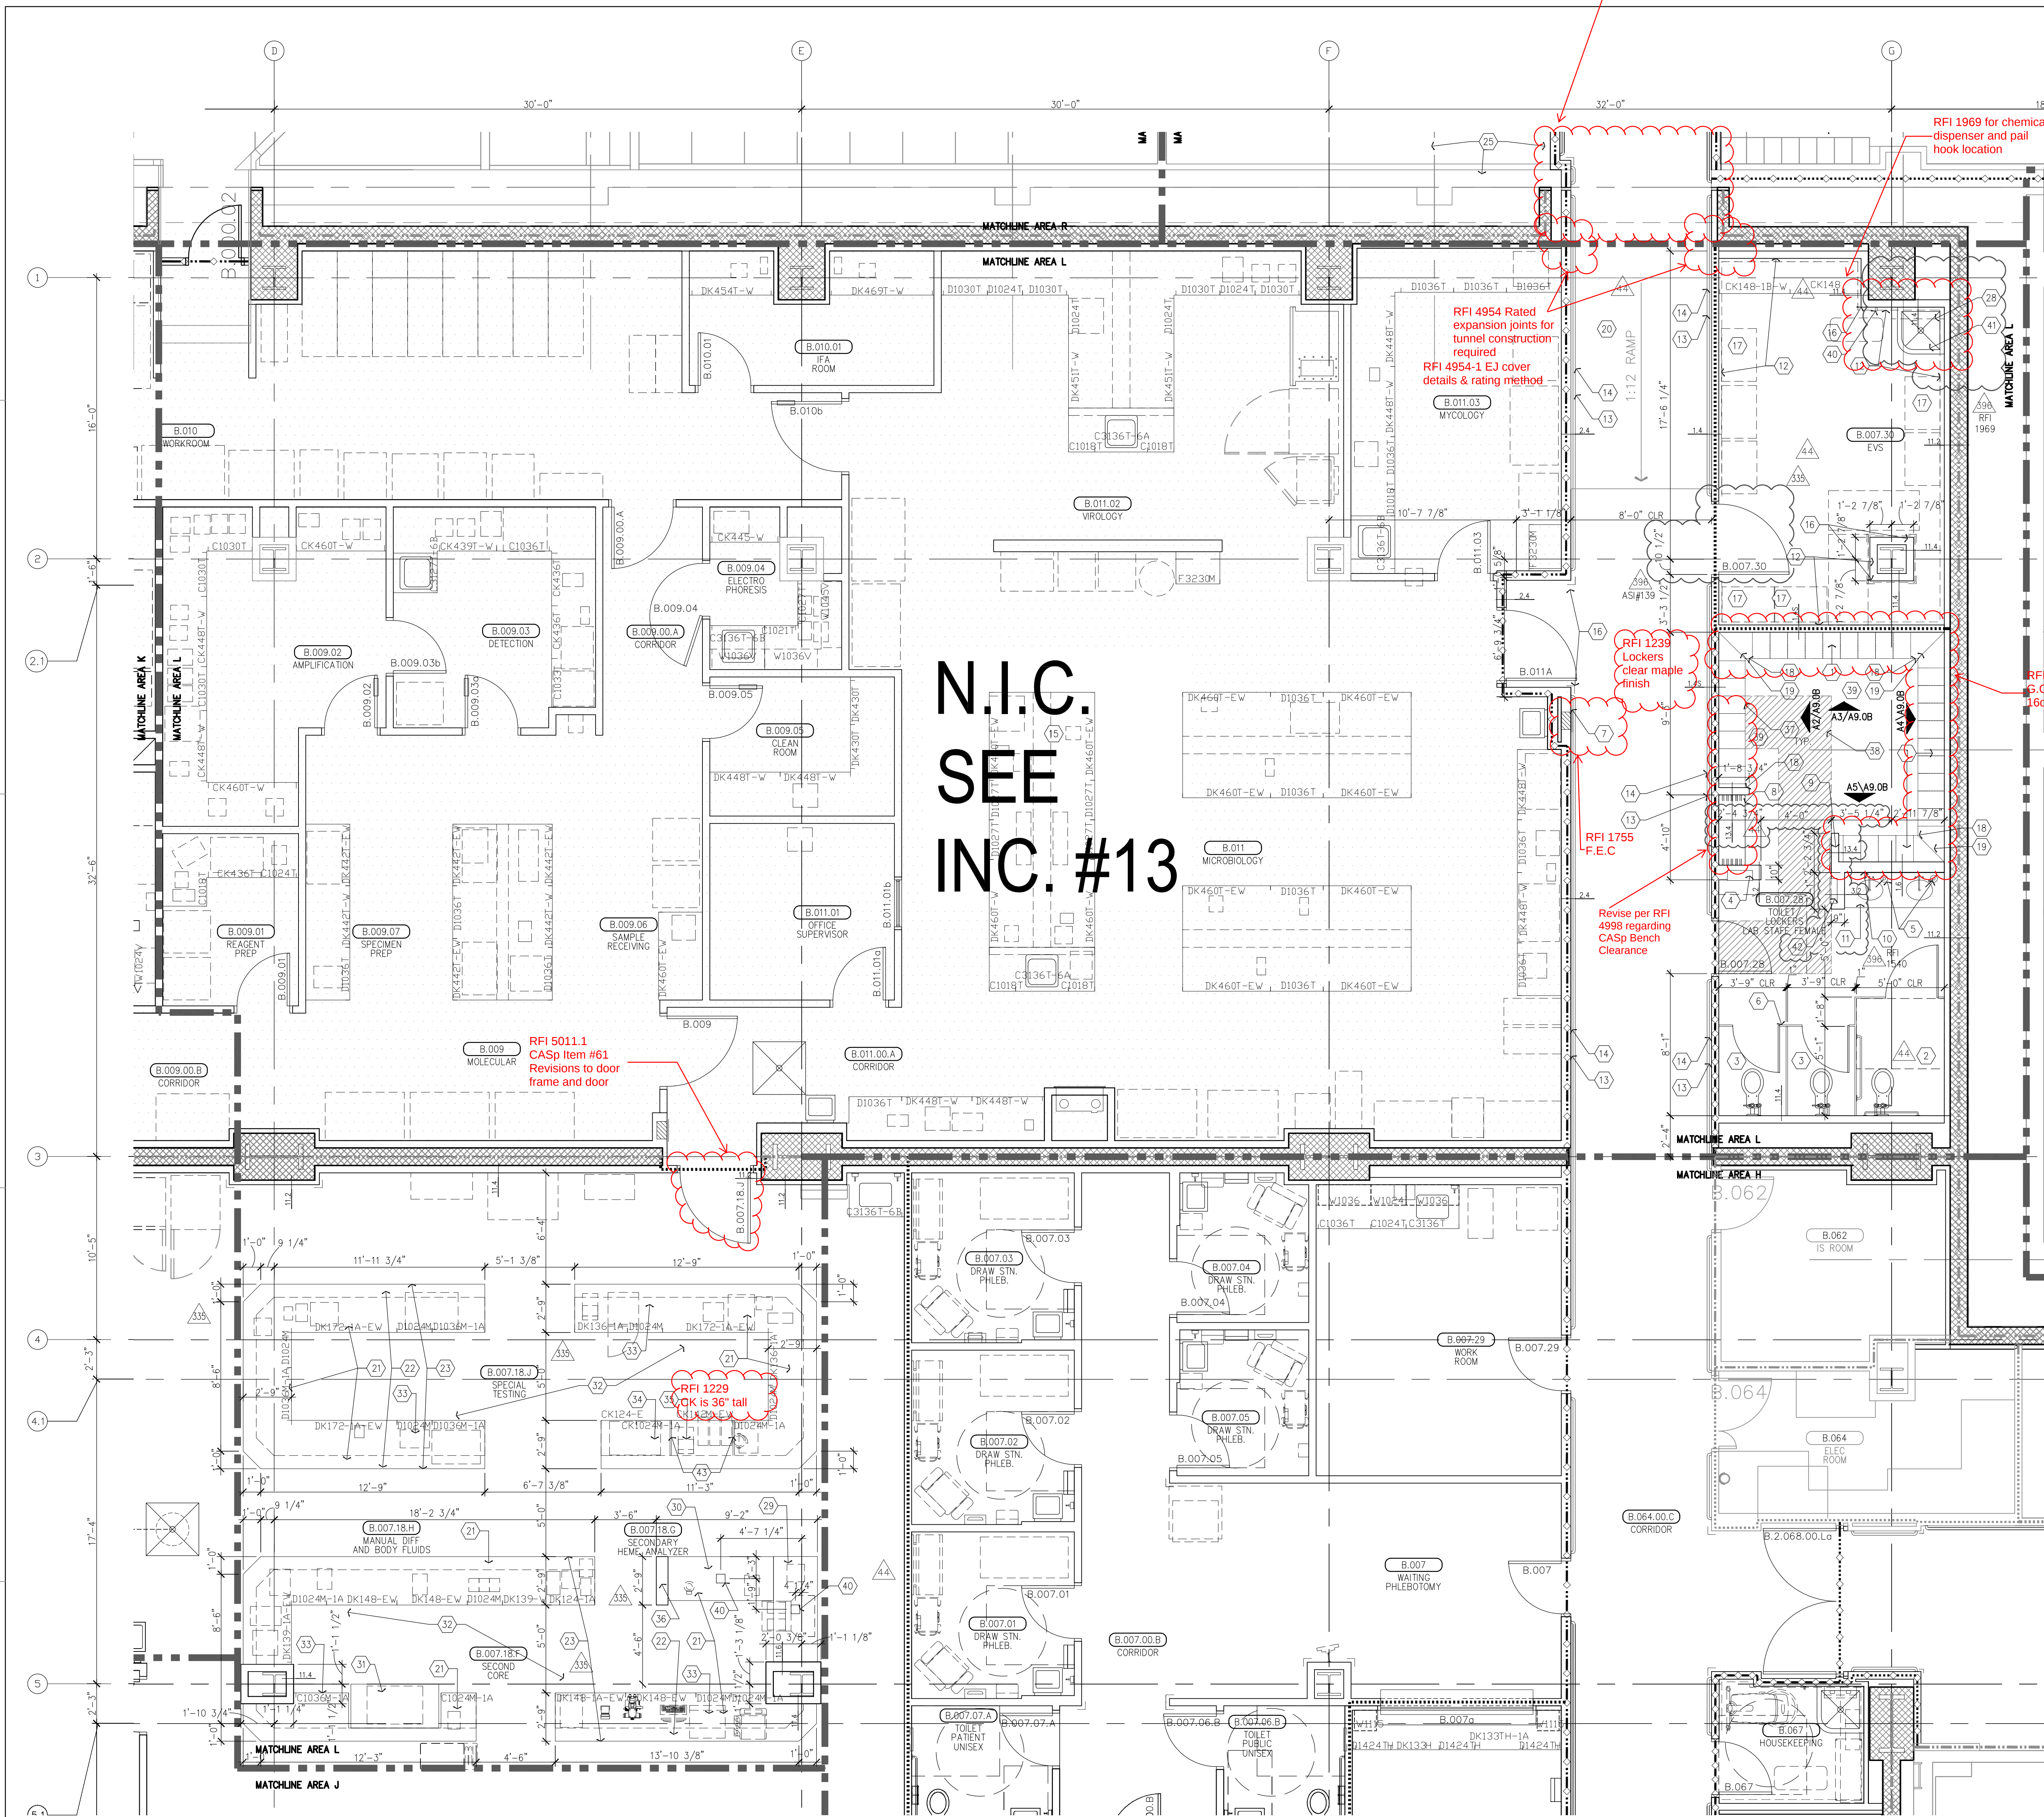

A6 AREA "L"
1/4" = 1' - 0"

DRAWING NUMBER

A3.0L