


FKP Architects

ARCHITECT OF RECORD
Paul C. Gloriot

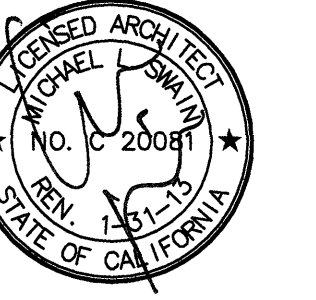


Changes on these drawings do not consist of materials altered changes to approved drawings and don't require a change order.
OSHPD review ACO
OSHPD review FLSO
OSHPD review DSE

REVISIONS

44	05/28/10	ASI #08
25	05/10/10	CO #25
13	12/8/10	CO #109
22	03/21/11	ASI #77
18	05/09/11	CO #148
11	05/28/11	CO #170
16	03/01/11	CO #134
22	07/18/11	CO #176

APPROVAL

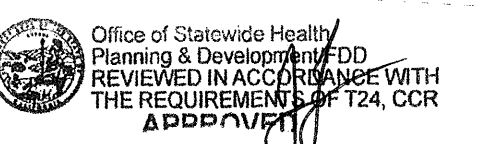

CHANGE ORDER # 176
INSTRUCTION BULLETIN
DEFERRED APPROVAL
"ADDENDUM"

PROJECT NAME

CHILDREN'S HOSPITAL
OF ORANGE COUNTY
455 S. Main St.
Orange, CA 92668-3874

TOWER II

RECEIVED
July 20 2011
McCARTHY



PROJECT NUMBER

12011.00
Increment #7

OSHPD - PROJECT NUMBER

IL 072072-30

ISSUE

OSHPD PERMIT

DATE

01/27/2010

SCALE


1/4" = 1' - 0"

DRAWING TITLE

LEVEL 2 ENLARGED PLAN
AREA - E

DRAWING NUMBER

A3.2E

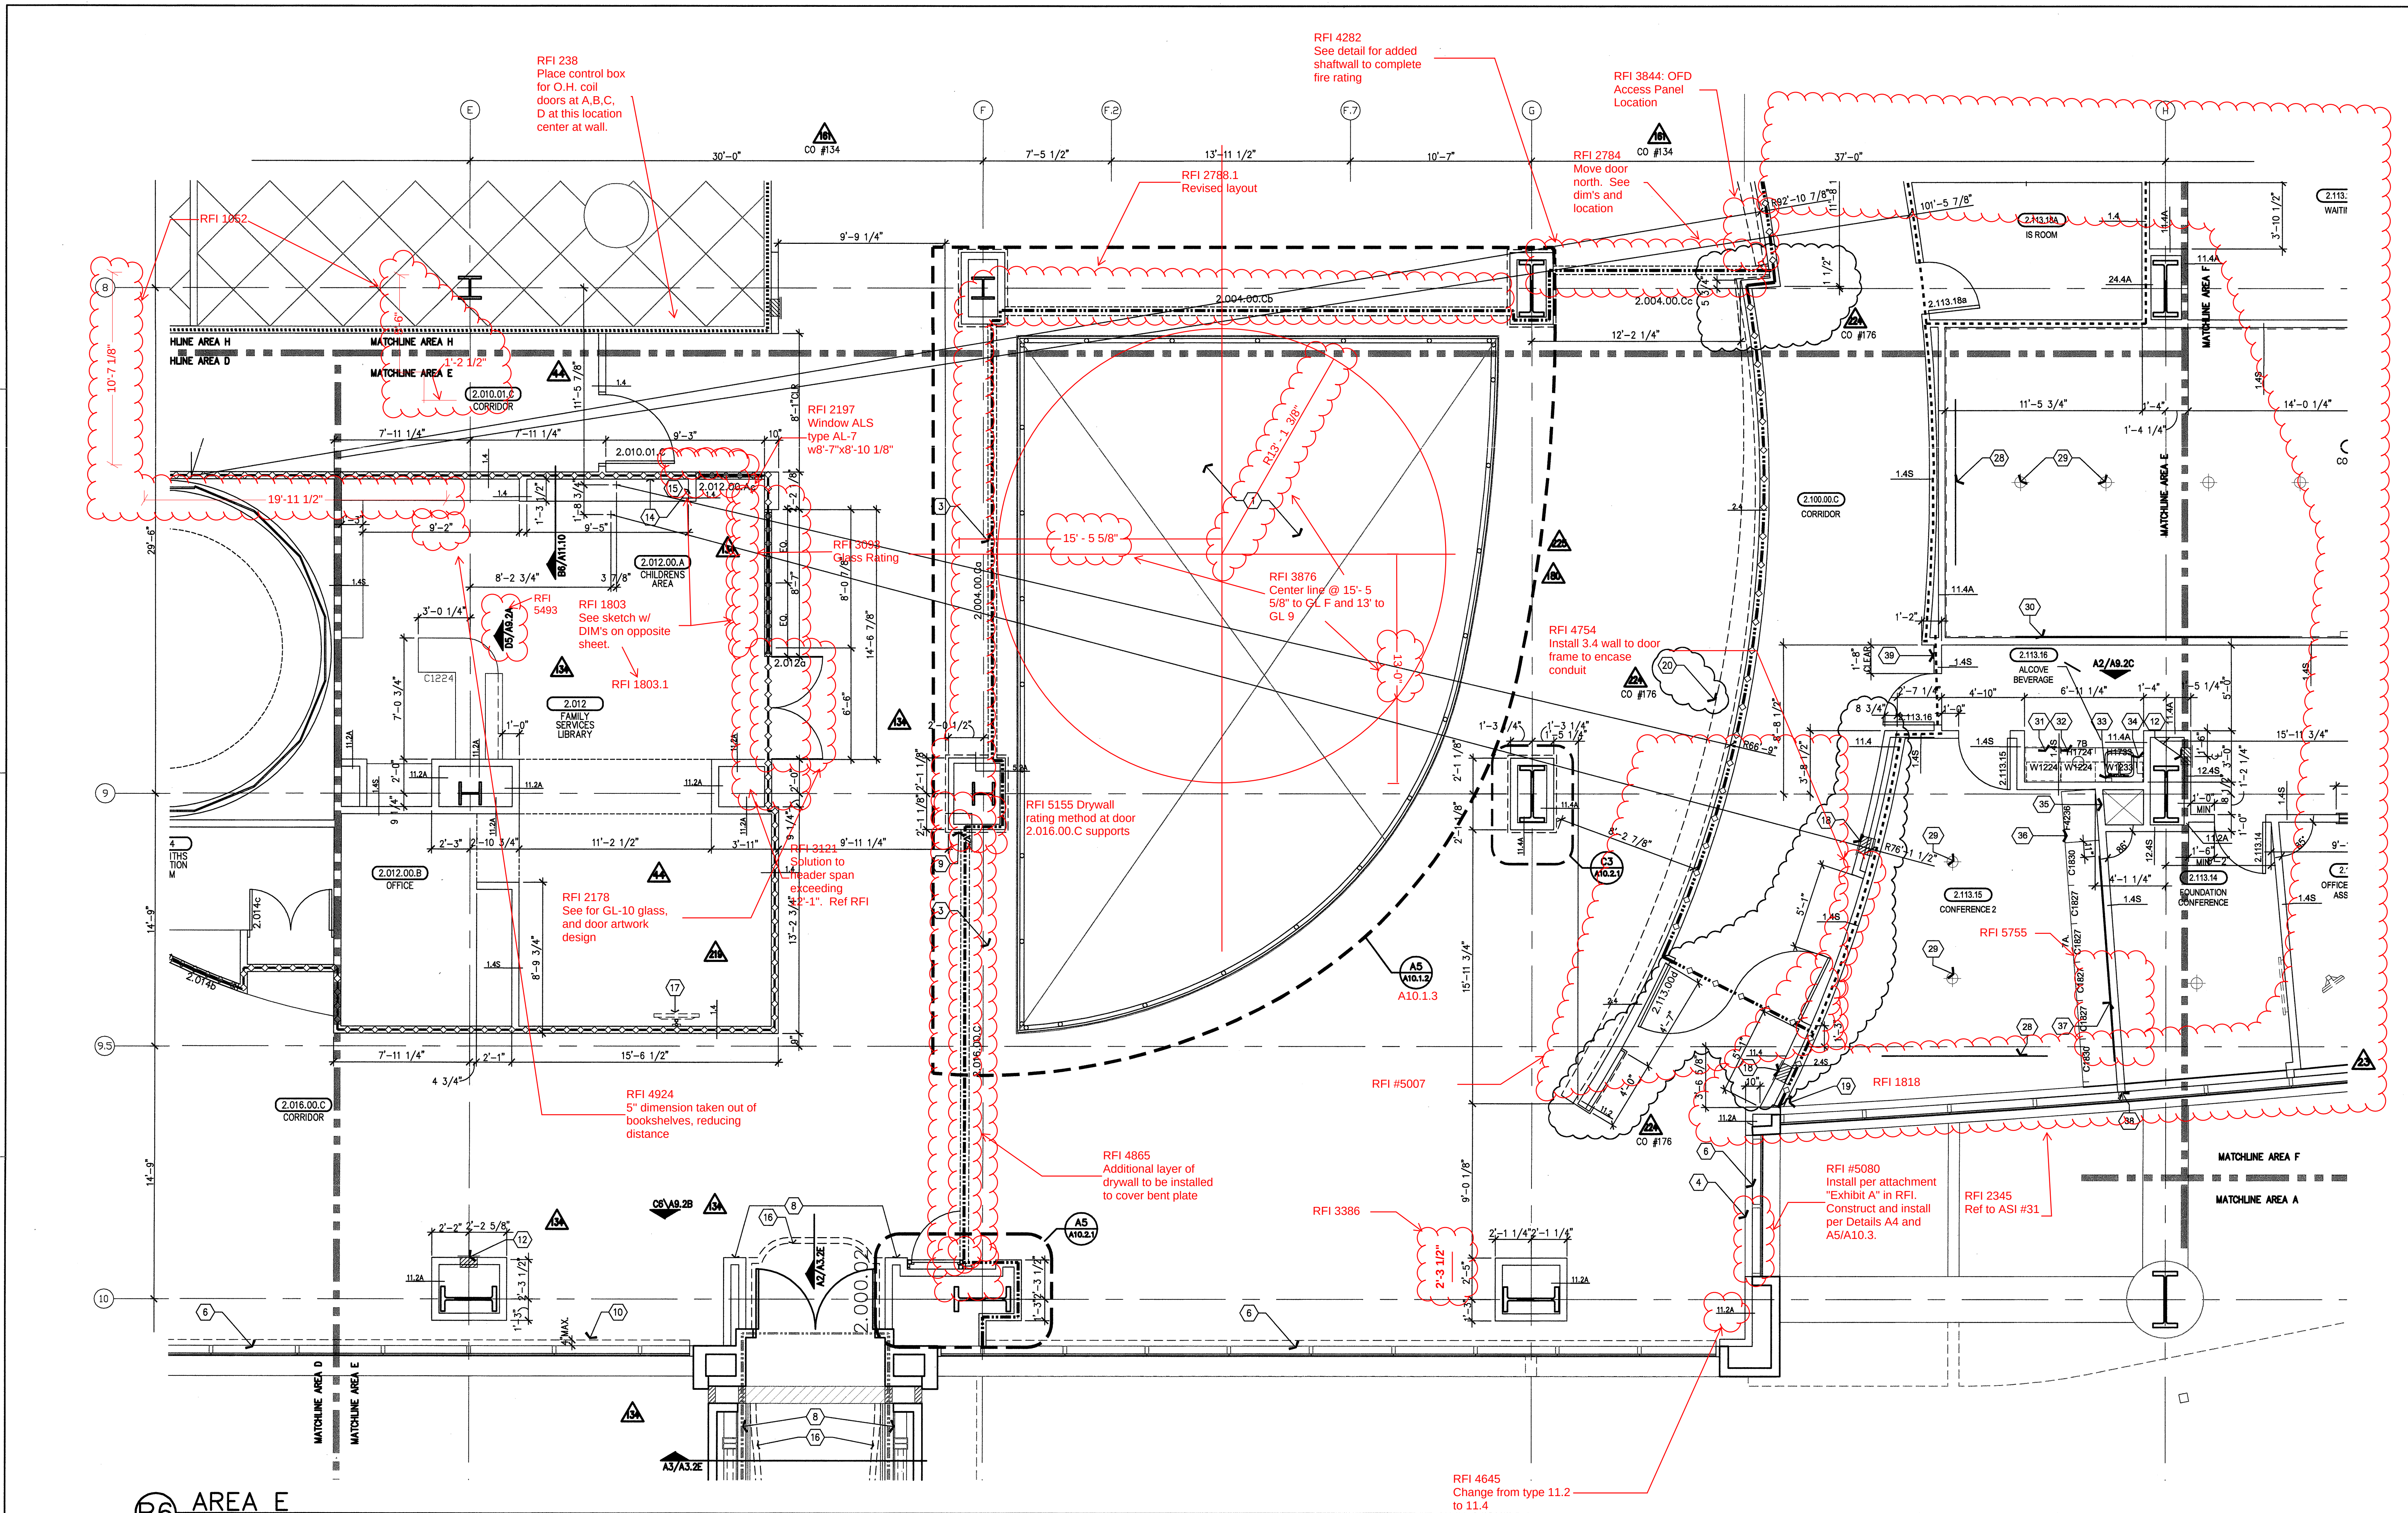

B6 AREA E
14'-1'-0"


- Open to below.
- Not used.
- Fire shutter, automatic roll down, ceiling recessed, see Door Schedule.
- Sill wall, 2'-10" A.F.F., typical. See C5/A10.1 for detail.
- Integrated double egress door, wall recessed. See A5/A11.4.2 for detail.
- No roller window shade.
- Not used.
- For construction requirements this area, see Increment 6, Vol. 2A and 2B.
- Decorative glass panel. See D3/A8.6.
- Composite metal filler panel mullion extrusion or inner side of curtain wall system - by curtain wall manufacturer. Point finish. See Referenced Elevation.
- Integrated double egress door, wall recessed. See B6/A10.2.2 for detail.
- Fire extinguisher cabinet, wall recessed, point to match adjacent wall, typical. See detail A2 or B2/A11.6.
- Surface mounted fire extinguisher.
- Point all (3) wall surface 'bright white'.
- CHOC History Wall. Refer to electrical for lighting/ power.
- DONOR DISPLAY- Refer to graphic package for additional information (ACC 30.0)
- Coordinated equipment. See RTKL low voltage drawings for model info.
- For wall attachment detail refer to structural drawings det. A4/S3.3 - Inc. # 7.
- Fire Valve and Fire Extinguisher Cabinet, wall recessed, point to match adjacent wall. See A2 or B2/A11.6 for detail.
- Recessed wall of egress of egress.
- Refer to A7.8 for interior finishes.
- Not used.
- Not used.
- Not used.
- Not used.

A6 NOTES TO SHEET

- Not used.
- Not used.
- Not used.
- Projection screen, recessed in ceiling. Align center with centerline of projector, see detail D3/A11.6 and Telecom drawings.
- Core, see Electrical and refer to ASI #46.
- Wallpaper, write surface. Direct glue to wall.
- Refrigerator under-counter. See Equipment, OF/Ci
- Trash receptacle cut-out, 8" diameter. Locate opening in center of cabinet. Provide stainless steel gronomat.
- Soap dispenser, wall mounted, OFCI, see Equipment drawings and Workbook.
- Paper towel dispenser, wall mounted, OFCI, see Equipment drawings and Workbook.
- Low air supply in cabinet with return grill on cabinet top.
- Provide seats on cabinet doors.
- Marker board, 6'x3', wall mounted at 42" A.F.F. to bottom. Provide blocking, see A6/A11.3.1.
- Card reader. See Security and Electrical.
- Align center of scheduled partition with center of mullion. See detail A5/A11.3.1.
- Card reader. See Security and Electrical.


A. For GENERAL NOTES TO SHEET see sheet A3.2F.

A4 GENERAL NOTES

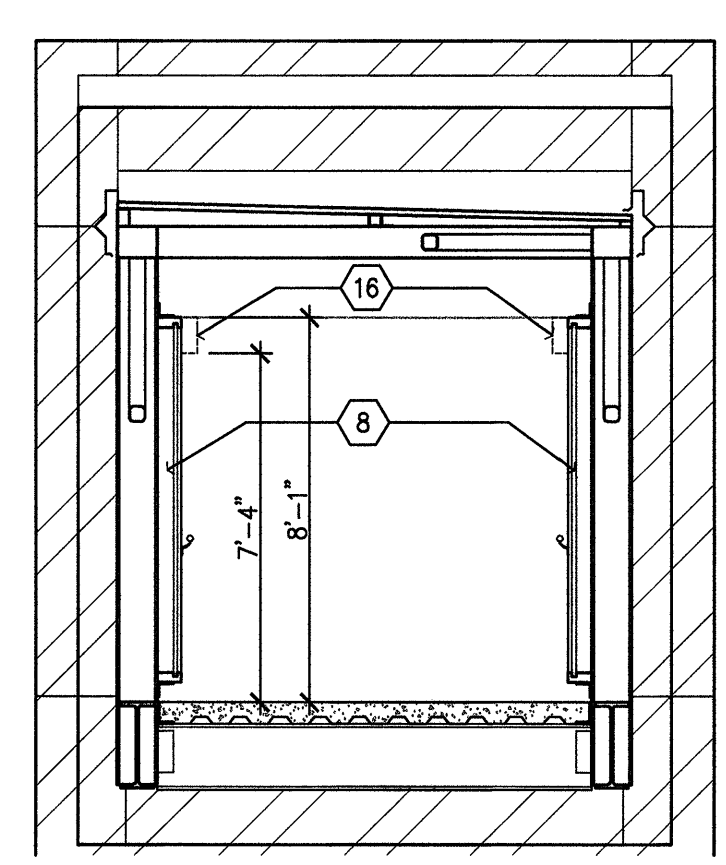


SEE A6/A3.2E FOR KEYNOTES

A3 BRIDGE SECTION

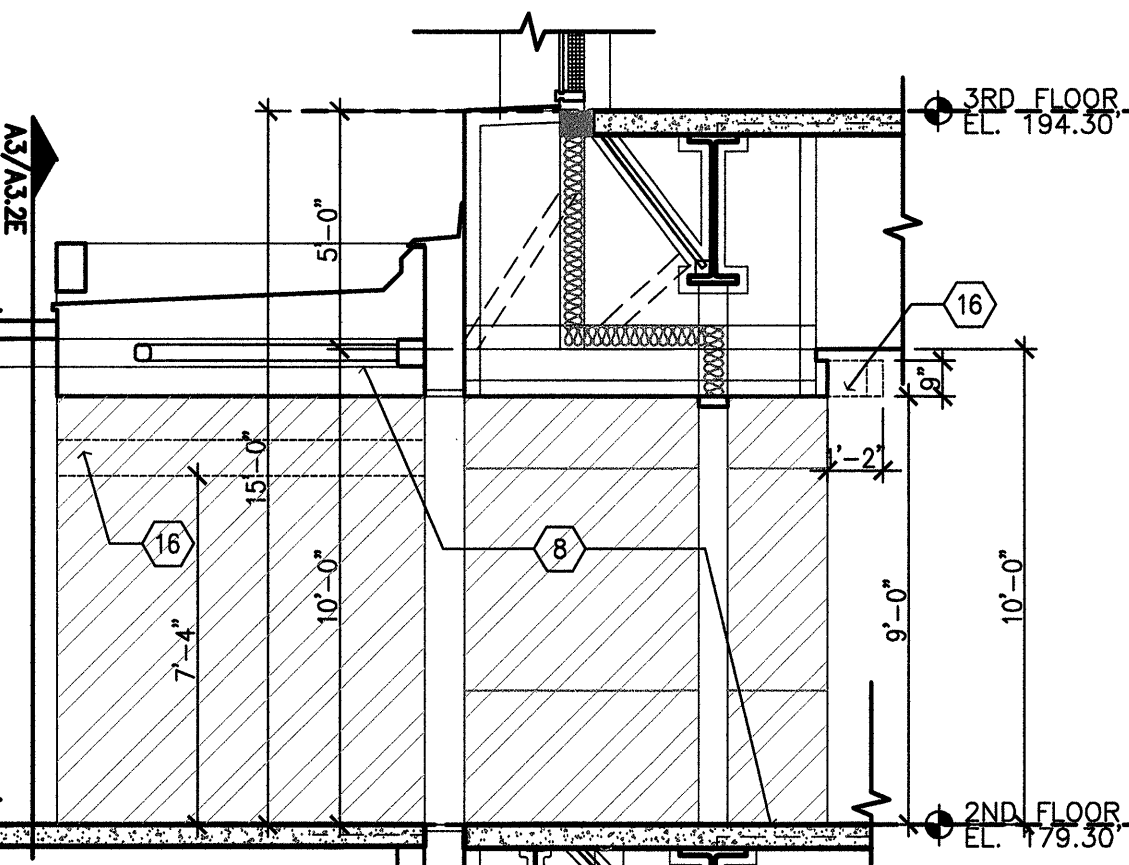

SEE A6/A3.2E FOR KEYNOTES

A2 BRIDGE SECTION

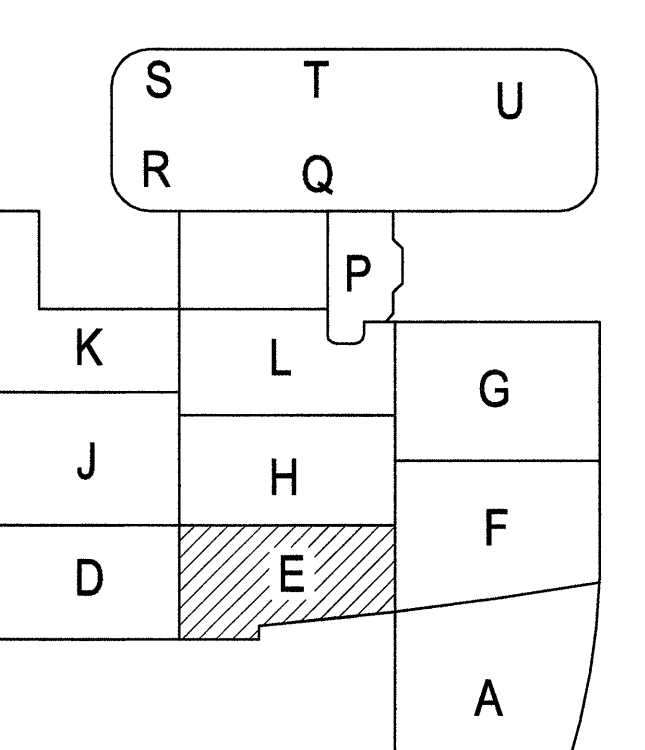

A1 KEY PLAN