


FKP Architects

ARCHITECT OF RECORD
Paul C. Gloriot

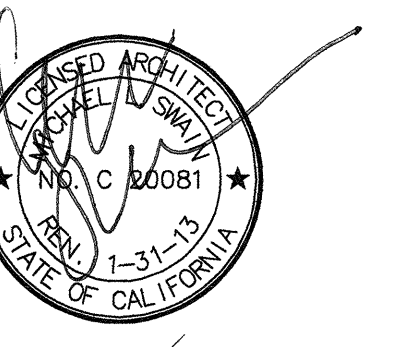

Changes on these drawings do not consist of material alterations or changes to approved drawings and do not require a change order.
OSHPD review/CO
OSHPD review/FLSO
OSHPD review/DSE

REVISIONS

44	05/28/10	ASI #08
40	00/00/10	CO #61
38	10/11/10	CO #96
37	10/25/10	ASI #6
35	08/19/11	CO# 261
34	11/29/11	CO#295
33	03/12/12	CO#281
32	07/30/12	CO #361

APPROVAL

Office of Statewide Health Planning & Development
REVIEWED IN ACCORDANCE WITH THE REQUIREMENTS FOR T24, CCR A PROPOSED PROJECT
PAD-2012-07948
CHANGE ORDER NO. 1
INSTRUCTION BULLETIN DEFERRED APPROVAL
10/00/00

PROJECT NAME

CHILDREN'S HOSPITAL
OF ORANGE COUNTY
455 S. Main St.
Orange, CA 92668-3874

TOWER II



PROJECT NUMBER

12011.00
Increment #7

OSHPD - PROJECT NUMBER

IL 072072-30

ISSUE

OSHPD PERMIT

DATE

01/27/2010

SCALE


1/4" = 1' - 0"

DRAWING TITLE

LEVEL 3 ENLARGED PLAN
AREA - G

DRAWING NUMBER

A3.3G

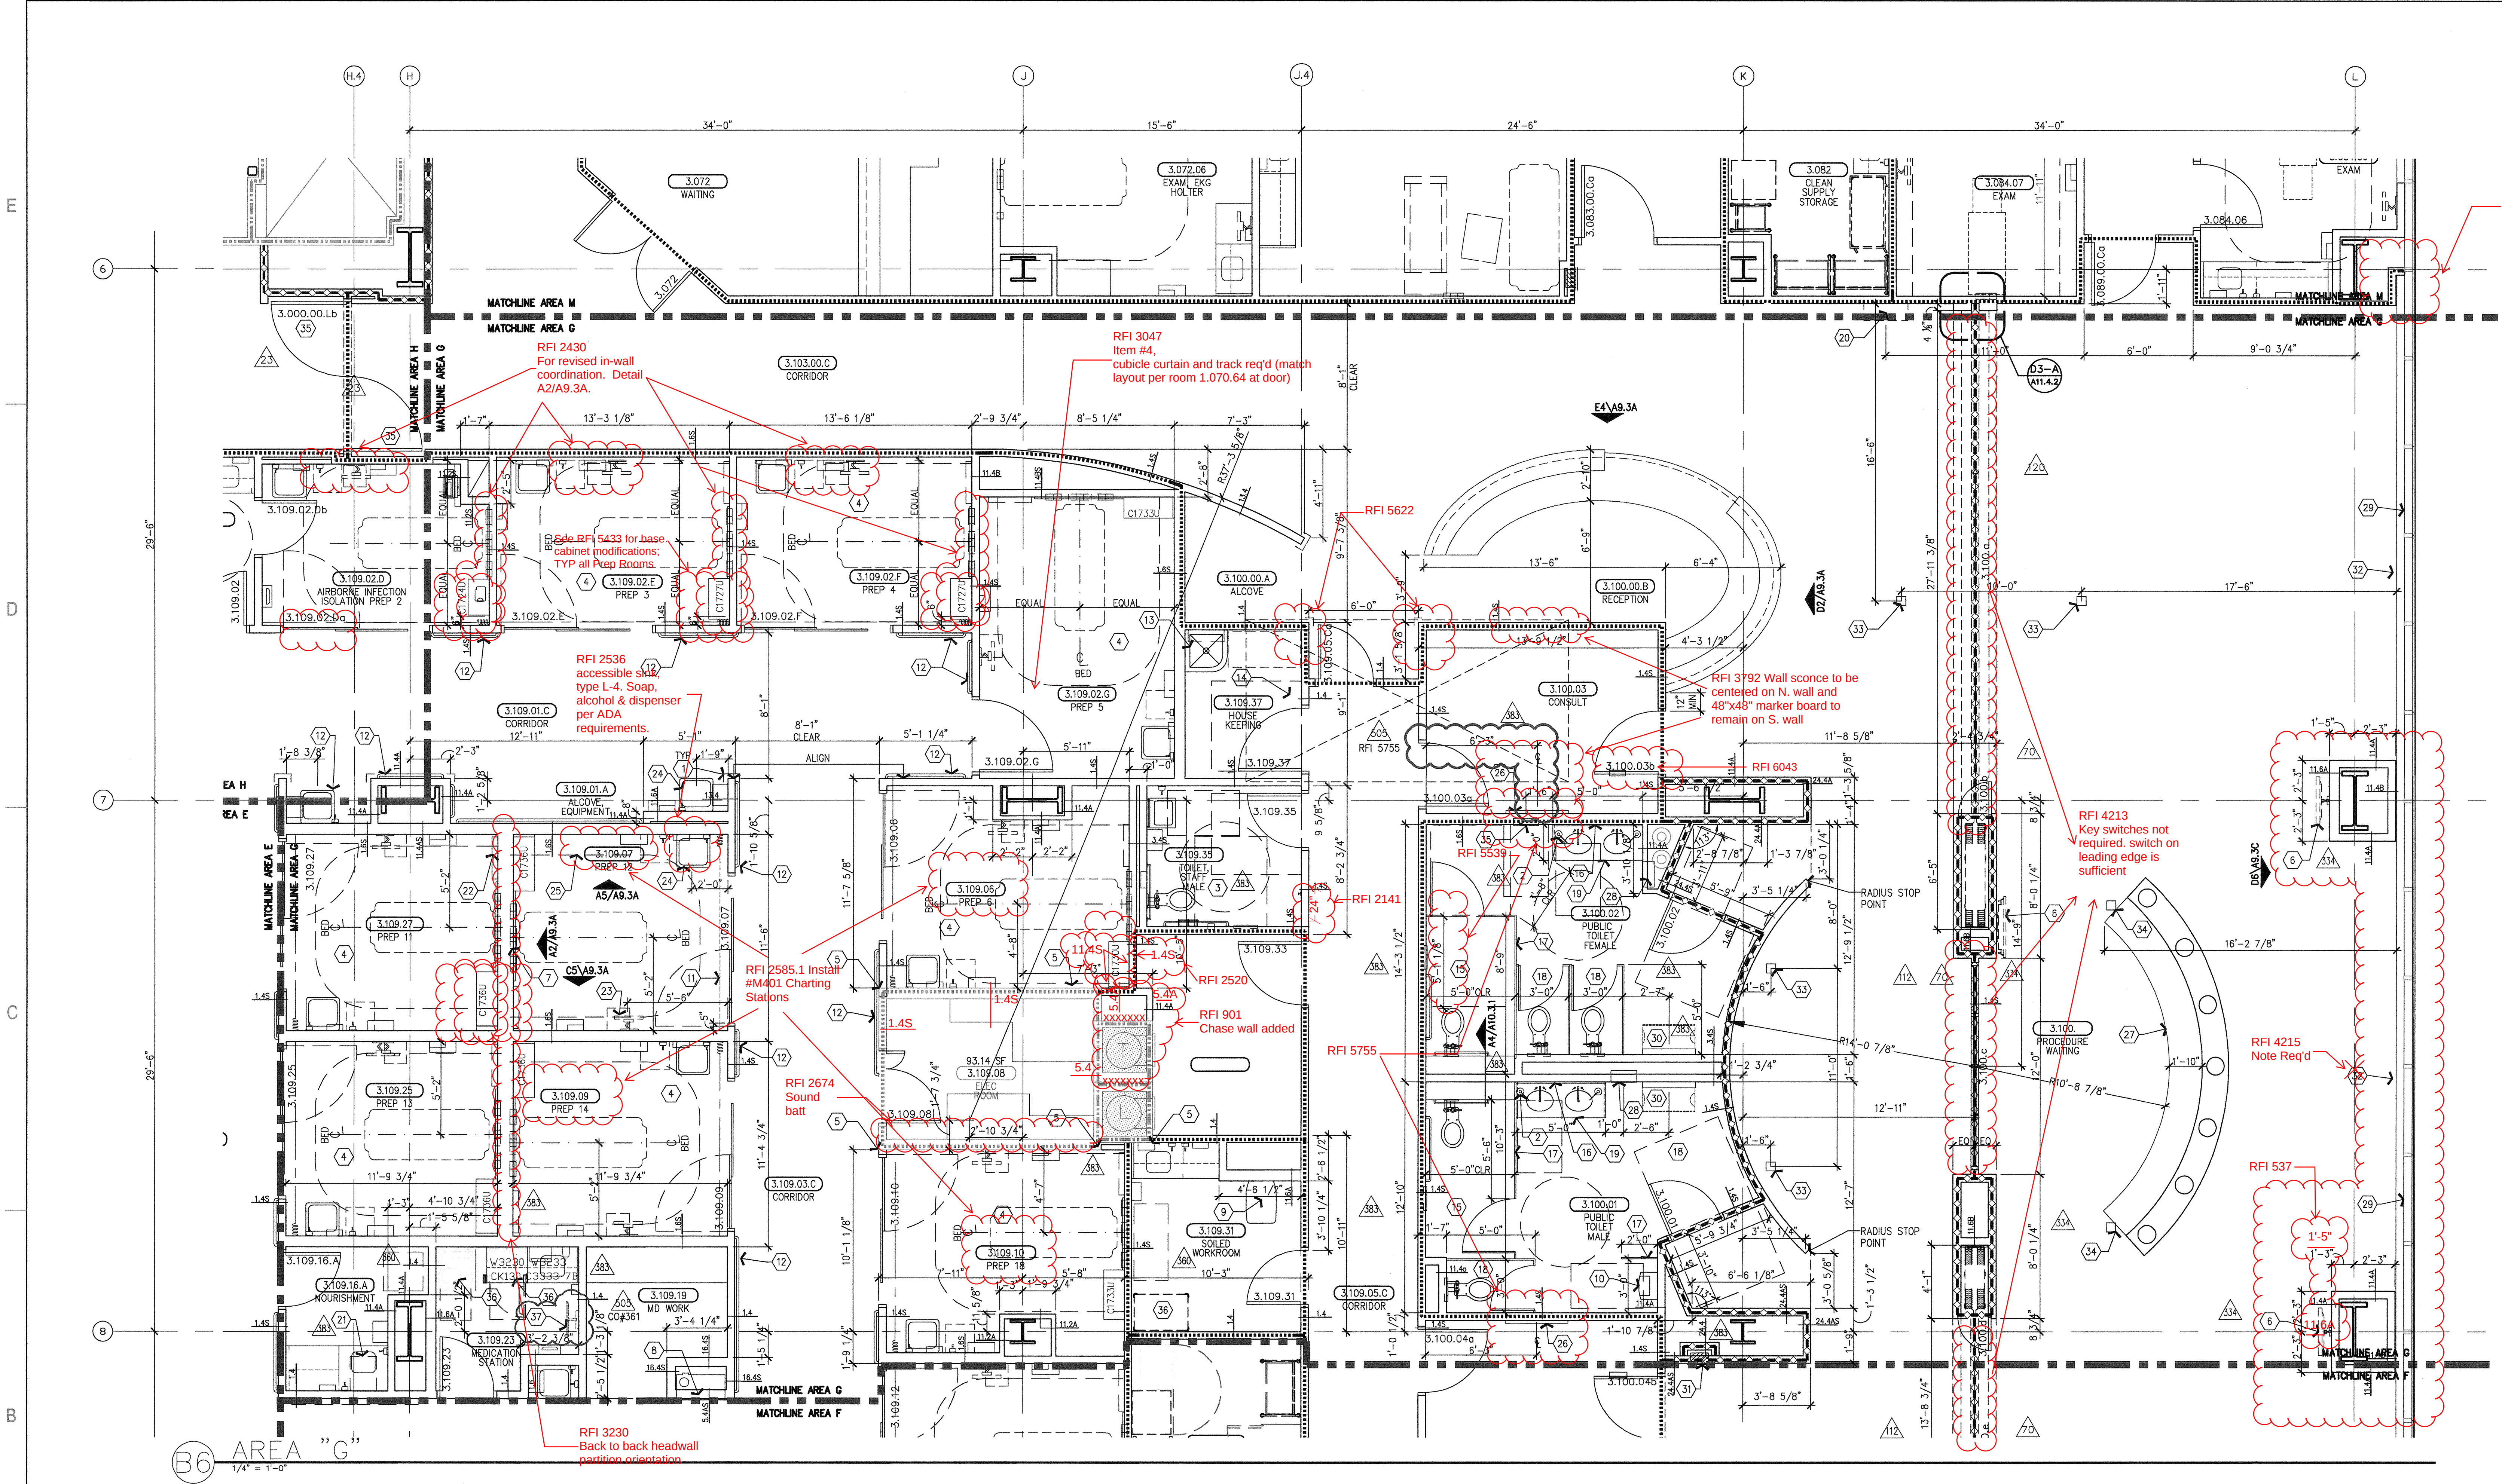


1. Corner guard, high impact plastic. See B4/A11.8 for detail.
2. Soap dispenser, counter mounted.
3. Accessible toilet room. See typical plan detail B3/A11.7.
4. See room 3.109.07 for typical note designations.
5. Align finished face of partition.
6. TV/VCR, wall mounted.
7. Medical gas outlet, see Plumbing drawings. See B2/A11.9 for mounting height.
8. Pneumatic tube station.
9. Clinical sink, see Plumbing drawings.
10. Urinal, see detail D4/A11.7.
11. Cubicle curtain track, ceiling mounted. See D4/A11.8.
12. Handrail/crashrail. See detail B4/A11.8.
13. Janitor mop sink. See detail A3/A11.7.
14. 14" deep shelf above, wall mounted with standards and brackets at 5'-0" A.F.F.
15. Accessible toilet stall. See typical plan detail B5/A11.7.
16. Mirror, full width of counter, full height from top of splash to 7'-0" A.F.F.
17. Toilet partitions, floor mounted.
18. Toilet stall. See detail A4/A11.7 for mounting heights.
19. Solid surface material counter. See detail A2/A11.7. Counter top end support refer to E1/A9.0, style "T".
20. Self check-in kiosk, future location. Provide blocking from 2' to 6' A.F.F. See Increment #7 detail D5/S3.5.
21. Wall mounted ice machine. See Equipment drawings. Provide backing as per Increment #7 detail A4/S3.5.
22. Charting station, wall-mounted, hold down with electrical and data outlets. Provide wall bracing. See Equipment drawings.
23. Wall mounted TV / DVD & TV support bracket. See detail A5/S3.5 and D1/S3.6 for mounting height. See Equipment drawings.
24. Accessible sink, mount top of rim at 34" A.F.F. See Plumbing drawings.
25. OSHPD clearance zone around bed.
26. Dzy erase marker board, 48"Wx48"H, wall mounted, bottom at 36" A.F.F. See A6/A11.3.1.
27. Millwork / banquet seating. See Interiors detail A4/A11.8.
28. Fully recessed paper towel dispenser and trash receptacle. See detail B6/A11.7.
29. No roller shade.
30. Baby changing station, top of station. See detail D6/A11.8.
31. Fire extinguisher cabinet, wall recessed, paint to match adjacent wall. See A2 or B2/A11.8 for detail.
32. Sill wall, 2'-10" A.F.F., typical. See C5/A11.0.1 for detail.
33. Electrical floor box. See Electrical Drawings for UL Design.
34. Electrical box (Side of bench). See Electrical Drawings for UL Design.
35. Sanitary dispenser. See B6/A11.7 for mounting location.
36. Equipment dispenser. See Equipment drawings and detail A1/S3.6 for backing details.
37. Charting station. See electrical & low voltage drawings for power & data information. Refer to det. A1/S3.6 for backing details.

- A. Information shown or referenced on enlarged and/or 1/4" scale drawings will generally not be shown on the smaller scale drawings.
- B. Partition types are scheduled on plans by number. See the "General Notes to Partition Types" on B2/A11.3 and Partition Types on Sheet A11.3, A11.3.1, and A11.3.2 for the definition of partition type references.
- C. Field coordinates of field routed pipe, conduit runs, etc., with locations of recessed accessories and equipment. In the event of a conflict, accessory locations take precedence.
- D. Close all joints between plumbing fixtures/accessories and dissimilar materials w/ caulkant (i.e. between sinks and countertops, toilet fixtures and accessories to wall, etc.)
- E. Cabinet numbers noted on enlarged plans refer to Cabinet component numbers, fixtures, accessories, etc. that are defined or elevated on Sheet A9.0 unless specific detail references are keyed.
- F. Plan dimensions - refer to B2/A11.3 (General Notes).
- G. For vertical mounting heights of shower accessories. See detail D6/A11.7.
- H. For vertical mounting heights of typical toilet stall accessories. See detail A4/A11.7.
- I. For vertical mounting heights of accessible toilet stall accessories. See detail A5/A11.7.
- J. For vertical mounting heights of typical restroom accessories. See detail B6/A11.7.
- K. For vertical mounting heights of accessible accessories at restrooms. See detail A6/A11.7.
- L. For equipment not identified on plan, see Equipment drawings and workbook-Increment #7, Vol. 2E.

- M. For partial enlarged plan at janitor closets. See detail A3/A11.7.
- N. Public/handicapped restroom graphics will be furnished and installed by the Owner's graphics supplier.
- O. Standard equipment wall mounting heights, see detail A2/A11.9.
- P. Medical equipment wall mounting heights, see details A4/A11.9, D3/A11.9 & D0.02-Increment #7, Vol. 2E.
- Q. Fire Protection equipment wall Mounting Heights, see detail D2/A11.9.
- R. Fire Protection equipment wall Mounting Heights, see detail A3/A11.9.
- S. Equipment mounting heights at Countertops, see detail D3/A11.9.
- T. Equipment mounting heights at Desks, see detail A4/A11.9.
- U. A minimum head clearance of 6'-8" must be maintained at all points in stairways including stair and landing framing.
- V. For all dashed in equipment not identified, refer to EQ drawing series-Increment #7, Vol. 2E and Equipment workbook. Specific items requiring structural support are cross referenced to structural support details via matrix shown on the Equipment Drawings-Increment #7, Vol. 2E.
- W. All elevator hoist way entrance frames to have an embossed stainless steel graphic plaque with the floor landing number and Standard Braille markings for the blind. Conform to governing Accessibility codes and standards.
- X. All stair floor landings to receive stencil painted, semi-gloss enamel floor landing numerals 12" high adjacent to the door at 5'-0" AFF in a contrasting color to the scheduled wall color unless a graphic plaque is specifically detailed or noted.
- Y. Elevator Equipment wall mounting heights, see detail A6/A11.9 and B3/A11.9.
- Z. Doors, Frames, Sidelites and Windows: (See Door Schedule). See A11 sheet series.
- AA. Provide wall blocking/backing for items weighing 20lbs or less. See A6/A11.3.1.
- BB. For personal effects storage unit types and sizes see A4/A11.8.
- CC. For typical equipment backing support, see A4/S3.1-Increment #5.
- DD. For boundaries of attendants and phoning, see the AP drawing series.
- EE. Provide 3" grammet, unless otherwise noted at 3'-0" O.C. maximum, field located at all electrical components at Nurses stations and Reception desks.
- FF. For vertical mounting heights of service accessories, See detail A3/A11.7-Increment #7, Vol. 2E.
- GG. Provide access panels below the Patient Room countertops to serve as inspection ports for the Patient Room bathrooms.

GENERAL NOTES

KEY PLAN

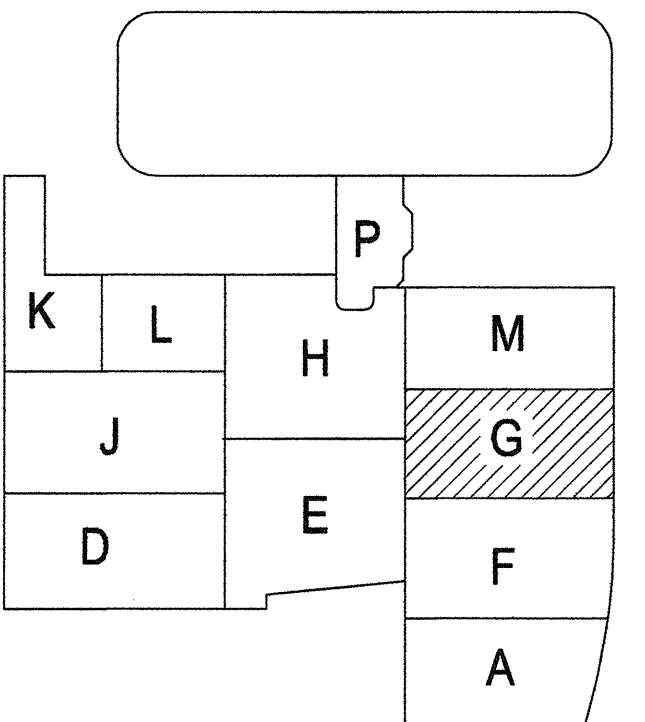

NOTES TO SHEET