




Paul C. Gloriod

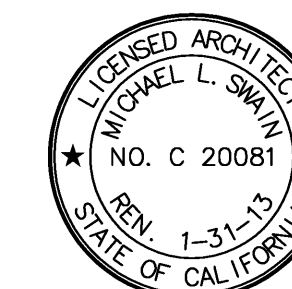

A. Information shown or referenced on enlarged and/or 1/4" scale drawings will generally not be shown on the smaller scale drawings.

B. Partition types are scheduled on plans by number. See the "General Notes to Architectural" on B07 (Partitions) for details as set forth on Sheet A3/A1.1, A3.1.3, and A3.1.3.1 for the definition of partition type references.

C. Field coordinate all fixed routed pipe, conduit runs, etc., with locations of recessed cabinets and equipment to avoid interference with specific accessory locations like precedence.

D. Close all joints between plumbing fixtures/accessories and dissimilar materials.

E. Coordinate (i.e. between sinks and countertops, toilet fixtures and accessories to wall, etc.)

F. Cabinet numbers noted on enlarged plans refer to Cabinet component numbers, fixtures, etc., that are defined or enlarged on Sheet A80 for similar detail references are keyed.

G. Non dimensional reference callouts (e.g. Detail A3/A1.1 (General Notes).

H. For vertical mounting heights of shower accessories, see Detail D6/A11.7.

I. For vertical mounting heights of typical toilet stall accessories, see Detail A6/A11.7.

J. For vertical mounting heights of accessible toilet stall accessories, see Detail A5/A11.7.

K. For vertical mounting heights of typical restroom accessories, see Detail B6/A11.7.

L. For vertical mounting heights of accessible accessories at restrooms, see Detail A6/A11.7.

M. For equipment not identified on plan, see Equipment drawings and workbooks—Increment F7.

N. For partial enlarged plan at junior closets, see Detail A3/A11.7.

O. Public/handicapped restroom graphics will be furnished and installed by the Owner's graphic supplier.

P. Standard equipment wall mounting heights, see detail A2/A11.9.

Q. Medical equipment wall mounting heights, see details A4/A11.3 & A3/A11.9 & QD-02-Increment F7.

R. Fire Protection equipment wall mounting heights, see detail D2/A11.9.

S. Communication equipment wall mounting heights, see detail A3/A11.9.

T. Equipment mounting heights at Countertops, see detail D3/A11.9.

U. Equipment mounting heights at Vanities, see detail D4/A11.9.

V. A minimum head clearance of 5'-8" must be maintained at all points in storerooms including stair and landing framing.

W. Equipment mounting heights are related to EDD drawing series—Increment #7. Vol. 2E and Equipment workbook. Specific items requiring structural support are indicated in relation to equipment details via matrix shown on the Equipment Drawings—Increment #7. Vol. 2F.

X. All elevator hoist way entrance frames to have an embossed stainless steel graphic plaque on the floor frame area with the following information:

Conform to governing Accessibility codes and standards.

A. All stair floor landings to receive etched painted, semi-gloss enamel floor landing numerals in high relief (minimum 1/4") and a contrasting border to the perimeter of the scheduled wall color unless a graphic plaque is specifically detailed or noted.

1. Elevator Vertical Wall Mounting Heights, see Detail A6/A11.3 and B3/A11.9.

2. Stairs, Frontal, Sidelite, and Landing Glass Partitions, see Detail A11.9.

AA. Provide wall blocking/backing for item weights 20lbs or less, see AA6/A11.3.1.

AB. For personal effects storage unit types and sizes, see AA4/A11.8.

AC. For typical equipment, see Equipment drawings and workbooks—Increment J5.

AD. For boundaries of delineates and phasing, see the AP drawing series.

AE. Surfaces 5' grommet, unless otherwise noted at 3'-0" O.C. maximum, field located at all electrical components.

AF. For service access below the service accessories, see Detail A3/A11.

AG. Provide access panels below the Patient Room counters to serve as inspection ports for the Patient Room.

44	05/28/10	ASI #08
91	11/18/10	ASI #27
219	05/09/11	CO #17
246	05/09/11	ASI #84


PROJECT NAME

RECEIVED
May 05 2011
McCARThY



DRAWING NUMBER

A1 KEY PLAN

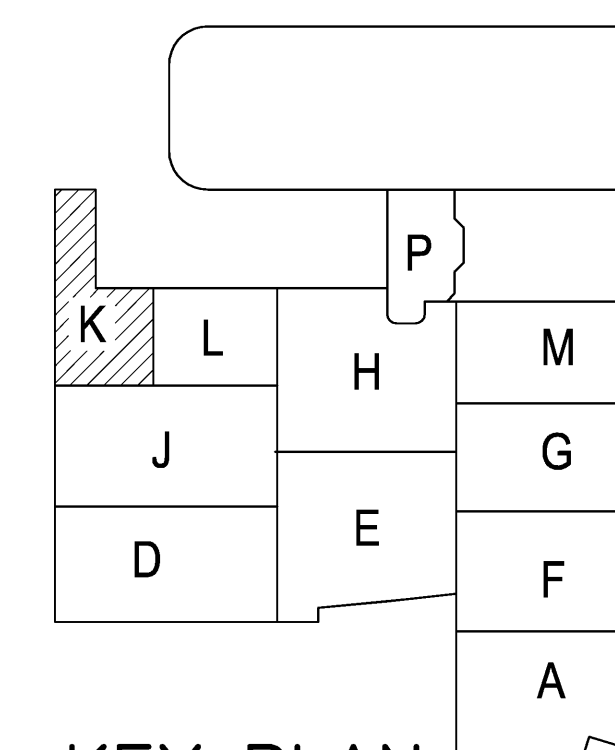

A1 KEY PLAN

C4 HAZARDOUS MATERIALS INVENTORY STATEMENT

(A6) AREA "K"
1/4" = 1'-0"

RFO 4094
See detail for bracing
where equipment
dictates