


FKP Architects

ARCHITECT OF RECORD
Paul C. Gloriot

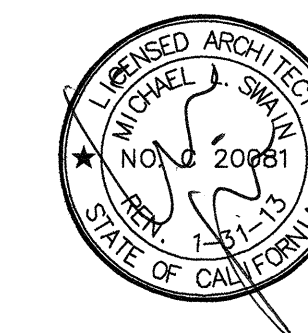

Changes on these drawings do not consist of materials altered changes to approved drawings and don't require a change order.
OSHPD review ACO
OSHPD review FLSO
OSHPD review DSE

REVISIONS

NO.	DATE	DESCRIPTION
44	05/28/10	ASI #08
23	05/10/10	CO #25
13	12/01/10	ASI #48
48	05/09/11	ASI #84
21	05/26/11	CO #170
16	06/16/11	ASI #95
16	08/08/11	CO #135
33	11/02/11	CO #264
38	12/23/11	ASI #131
45	03/06/12	CO #340

Project	Rev	By	Check	Date
12011.00	12	PK	PK	12/23/11
Architect		AC	D	12/23/11
Engineer		AC	D	12/23/11
Electrical		AC	D	12/23/11
MEP		AC	D	12/23/11
Structural		AC	D	12/23/11
Fire Safety		AC	D	12/23/11



CHANGE ORDER: 3410
INSTRUCTION BULLETIN: DEFERRED APPROVAL
ADDENDUM

PROJECT NAME
**CHILDREN'S HOSPITAL
OF ORANGE COUNTY**
455 S. Main St.
Orange, CA 92688-3874

TOWER II



PROJECT NUMBER
**12011.00
Increment #7**

OSHPD - PROJECT NUMBER
IL 072072-30

ISSUE
OSHPD PERMIT

DATE
01/27/2010

SCALE
1/4" = 1' - 0"

DRAWING TITLE
**LEVEL 5 ENLARGED PLAN
AREA - H**

DRAWING NUMBER


A3.5H

1. PC monitor, wall mounted. See Equipment drawings and workbook.
2. Accessible toilet room. See typical plan detail B3/A11.7.
3. Electrical power strip @ 24" & 48" A.F.F. See Electrical drawings.
4. Flat panel monitor, see Equipment drawings and workbook. See A5/S3.5.
5. Window treatment, manual roller window shades, typical all exterior glazing.
6. Juniper map sink. See A3/A11.7 for detail.
7. Sill wall, 2'-10" A.F.F., typical. See C5/A10.1 for detail.
8. Microwave. See Equipment drawings and workbook.
9. The extinguisher cabinet, wall recessed, point to match adjacent wall, typical. See A2 or B2/A11.8 for detail.
10. Corner guard, high impact plastic, typical. See B4/A11.8 for detail.
11. See enlarged plan A3/A3.5A for typical note designations.
12. See room 5.122 in Sheet A3.5A for typical note designations.
13. Receptacle, see Equipment drawings and workbook.
14. Integrated double egress door, wall recessed. See D5/A11.4 for detail.
15. Electric drinking fountain, bi-level. See Plumbing and D2/A11.8.
16. Personal effects storage units, 5 high type D. See A4/A11.8.
17. Flat panel monitor. See Equipment drawings and workbook. See A2/S3.4.
18. Overhead ceiling door, fire rated. See door schedule, 1'-0" off the counter top edge to the center line of the shutter.
19. For construction requirements this area. See Increment 6, Vol.2A & 2B.
20. Handrail/crashrail. See detail B4/A11.8.
21. Accessible shower, see D3/A11.7.
22. 30" X 48" Refuge Space.
23. 2-way communication system and signage.
24. Refrigerator, undercounter.
25. Provide self-closing spring loaded hinge cabinet doors.
26. Integrated double egress door, wall recessed. See D4/A11.4.2.
27. Integrated double egress door, wall recessed. See D3/A11.4.2.
28. Move casework to intersect/overlap wall. Notch transaction top 3-1/2" as required.
29. Modified countertop to 25 1/2" deep for entire cabinet length. Detail C5/A9.0.
30. Coordinated equipment. See RTKL low voltage drawings for model info.
31. For wall attachment detail refer to structural drawings det. A4/S3.3 - Inc # 7/21A.
32. Pneumatic tube chase.
33. Handrail.
34. Concrete landing and ramp. See Increment 6, sheet A2.50.
35. Align partition with soffit above.
36. Concrete pad.
37. Exhaust Fan Control Panel.

NOTES TO SHEET

- A. Information shown or referenced on enlarged and/or 1/4" scale drawings will generally not be shown on the smaller scale drawings.
- B. Partition types are scheduled on plans by number. See the "General Notes to Partition Types" on B2/A11.3 and Partition Types on Sheet A11.3, A11.3.1, and A11.3.2 for the definition of partition type references.
- C. Field coordinate all field routed pipes, conduit runs, etc., with locations of recessed accessories and equipment. In the event of a conflict, accessory locations take precedence.
- D. Close all joints between plumbing fixtures/accessories and dissimilar materials w/sealant (i.e. between sinks and countertops, toilet fixtures and accessories to wall, etc.)
- E. Cabinet numbers noted on enlarged plans refer to Cabinet component numbers, fixtures, accessories, etc., that are defined or elevated on Sheet A9.0 unless specific detail references are keyed.
- F. Plan dimensions - refer to B2/A11.3 (General Notes).
- G. For vertical mounting heights of shower accessories. See Detail D6/A11.7.
- H. For vertical mounting heights of typical toilet stall accessories. See Detail A4/A11.7.
- I. For vertical mounting heights of accessible toilet stall accessories. See Detail A5/A11.7.
- J. For vertical mounting heights of typical restroom accessories. See Detail B6/A11.7.
- K. For vertical mounting heights of accessible accessories at restrooms. See Detail A6/A11.7.
- L. For equipment not identified on plan, see Equipment drawings and workbook-Increment #7, Vol. 2E.
- M. For partial enlarged plan at similar closets. See Detail A3/A11.7.
- N. Public/handicapped restroom graphics will be furnished and installed by the Owner graphics supplier.
- O. Standard equipment wall mounting heights, see detail A2/A11.9.
- P. Medical equipment wall mounting heights, see details A4/A11.9, D3/A11.9 & D0.02-Increment #7, Vol. 2E.
- Q. Fire Protection equipment wall mounting heights, see detail D2/A11.9.
- R. Communication equipment wall mounting heights, see detail A3/A11.9.
- S. Equipment mounting heights at Countertops, see detail D3/A11.9.
- T. Equipment mounting heights at Desks, see detail A4/A11.9.
- U. A minimum head clearance of 6'-8" must be maintained at all points in stairways including stair and landing framing.
- V. For all dashed in equipment not identified, refer to EQ drawing series-Increment #7, Vol. 2E and Equipment workbook. Specific items requiring structural support are cross referenced to structural support details via matrix shown on the Equipment drawings-Increment #7, Vol. 2F.
- W. All elevator hold way entrance frames to have an embossed stainless steel graphic plaque with the floor landing number and Standard Braille markings for the blind. Conform to governing Accessibility code and standards.
- X. All stair floor landings to receive stencil painted, semi-gloss enamel floor landing numerals 12" high adjacent to the door at 5'-0" AFF in a contrasting color to the scheduled wall color unless a graphic plaque is specifically detailed or noted.
- Y. Elevator Equipment Wall Mounting Heights, see detail A6/A11.9 and B3/A11.9.
- Z. Doors, Frames, Sidelites and Windows: (See Door Schedule). See A11 sheet series.
- AA. Provide wall blocking/backing for items weighing 20lbs or less. See A6/A11.3.1.
- BB. For personal effects storage unit types and sizes see A4/A11.8.
- CC. For typical equipment backing support, see A4/S1.1-Increment #6.
- DD. For boundaries of alternates and phasing, see the AP drawing series.
- EE. Provide 3" grommet, unless otherwise noted at 3'-0" O.C. maximum, field located at all electrical components at Nurses stations and Reception desks.
- FF. For vertical mounting heights of service accessories, See Detail A3/A11.
- GG. Provide access panels below the Patient Room countertops to serve as inspection ports for the Patient Room bathtubs.

GENERAL NOTES


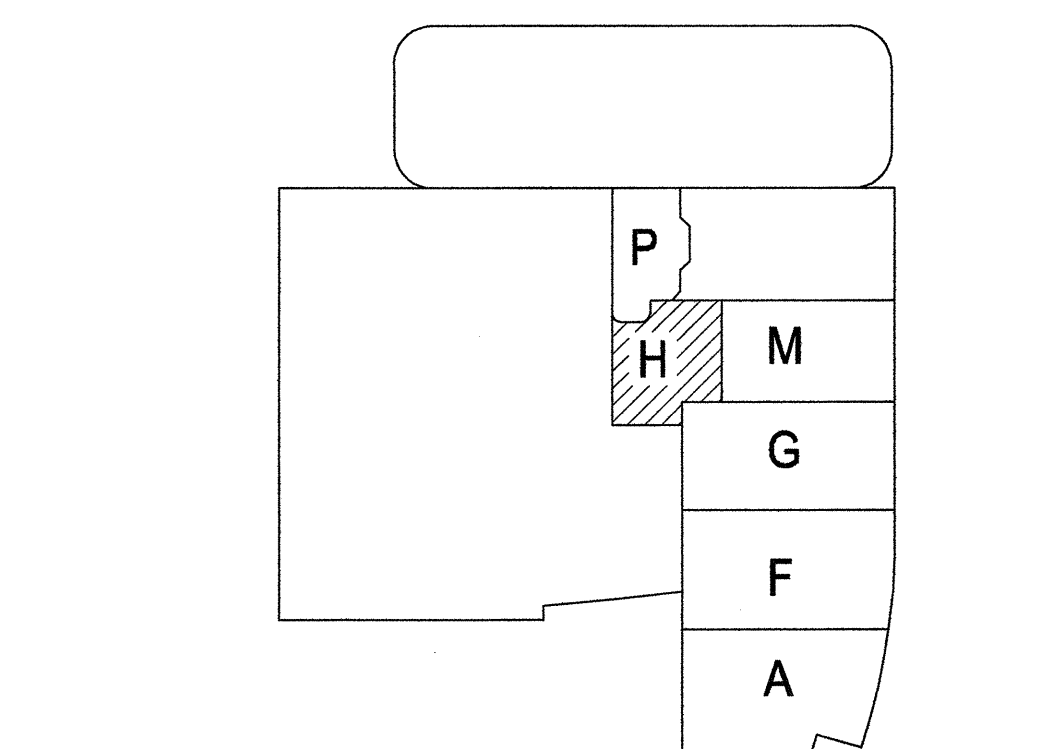


KEY PLAN

GLAZING AREA TABULATION

1/4" = 1' - 0"

ROOM 5.134.00A
WALL AREA:
Section A 6'-2 3/8" x 8'-0" = 49.6 SQ.FT.
49.6 SQ.FT. X 25% = 12.4 SQ.FT. Allowable Glazed Area
Section B 5'-7 1/2" x 5'-0" = 45 SQ.FT.
45 SQ.FT. X 25% = 11.25 SQ.FT. Allowable Glazed Area
ACTUAL GLAZING AREA (2 1/2" FRAME):
Section A 3'-2" x 3'-6" = 11.1 SQ.FT.
Section B 3'-0" x 3'-6" = 10.5 SQ.FT.

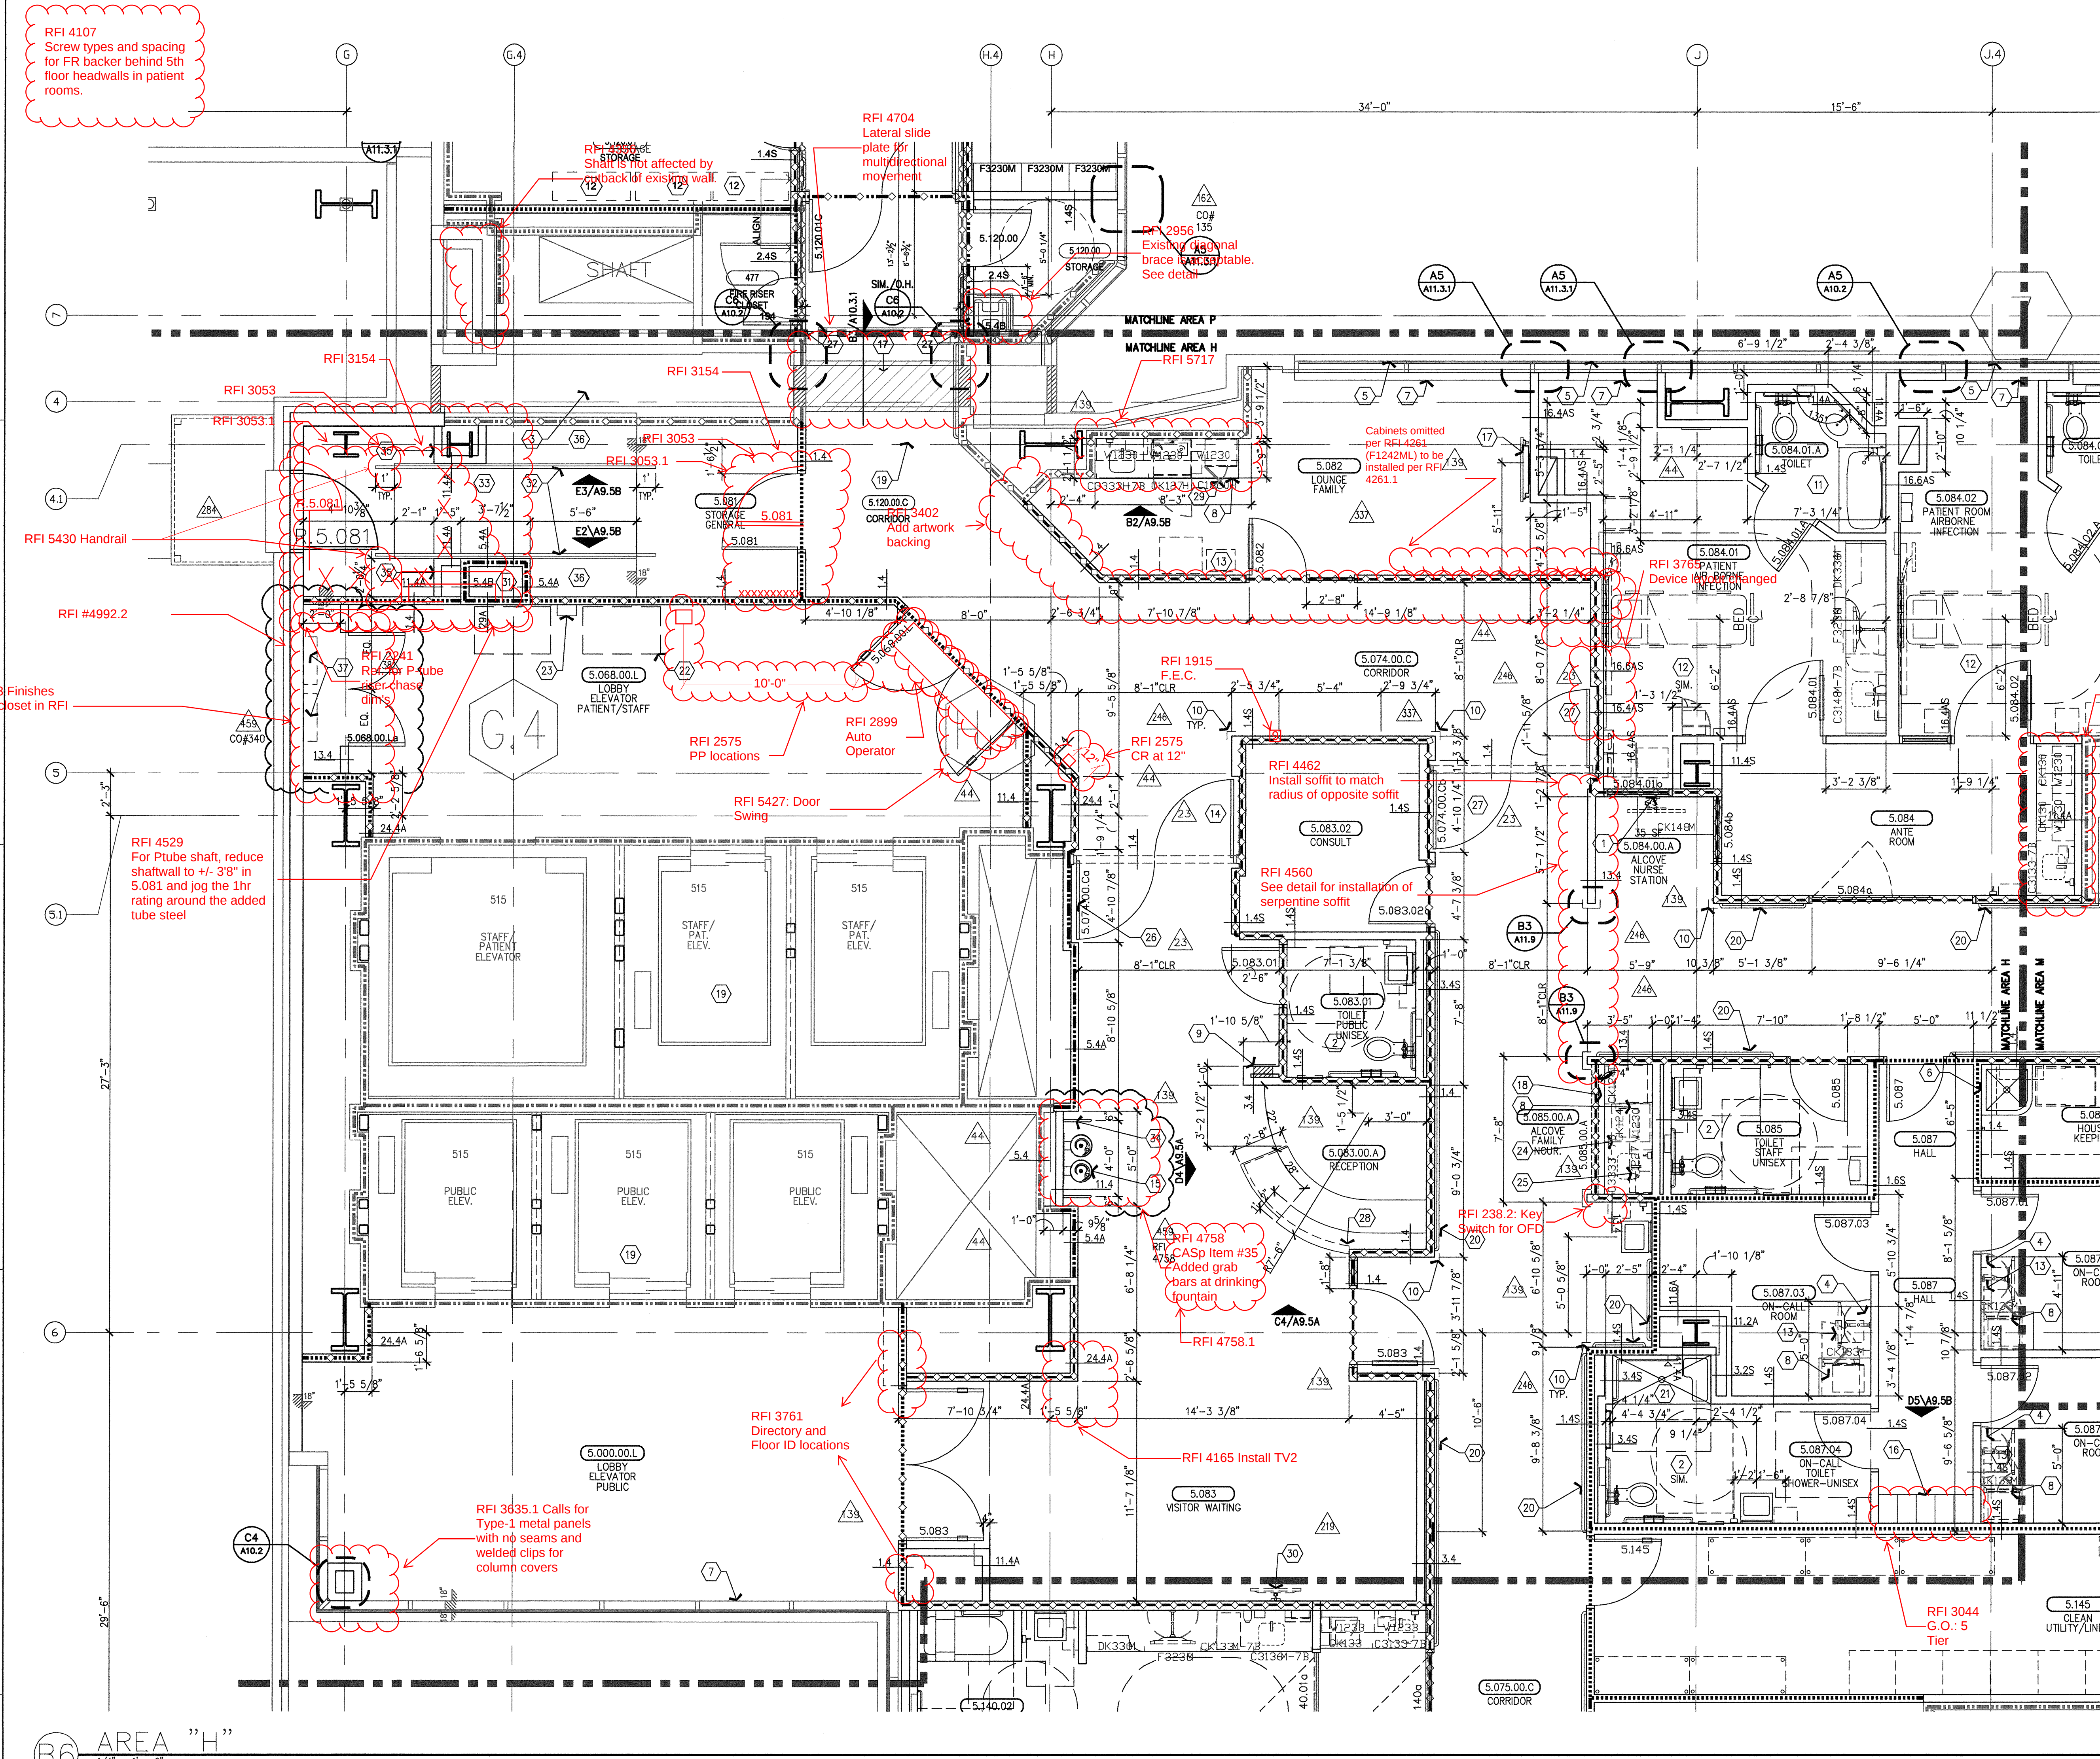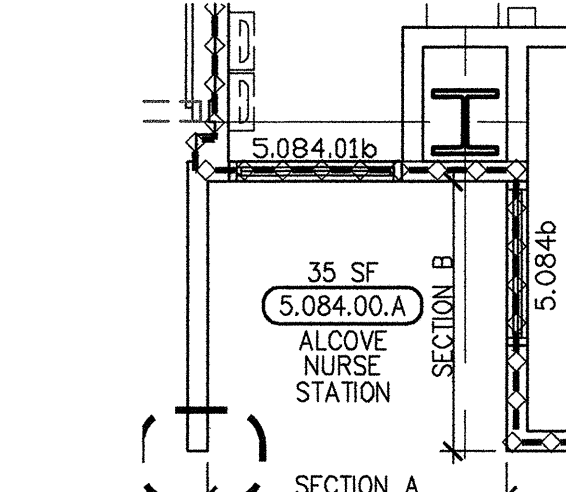

AREA "H"
1/4" = 1' - 0"

1/4" = 1' - 0"

