


FKP Architects

ARCHITECT OF RECORD
Paul C. Gloriod

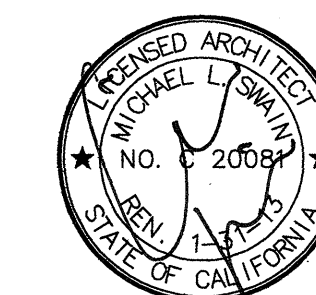


Changes on these drawings do not consist of
materially altered changes to approved drawings
and don't require a change order.
OSHPD review ACO
OSHPD review FLSO
OSHPD review DSE

REVISIONS

NO.	DATE	DESCRIPTION
44	05/28/10	ASI #08
28	07/12/10	CO #28
12	10/20/10	CO #98
72	11/18/10	CO #63
128	01/24/11	ASI #51
208	03/10/11	ASI #74
312	08/22/11	CO#247
338	08/24/11	ASI #111
344	09/05/11	CO#266
344	10/24/11	ASI#115
368	12/05/10	CO #303
398	12/19/11	ASI#141
444	04/03/12	CO#329

APPROVAL

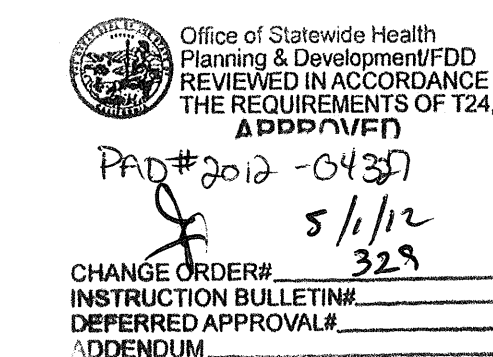

PROJECT NAME
**CHILDREN'S HOSPITAL
OF ORANGE COUNTY**
455 S. Main St.
Orange, CA 92668-3874

TOWER II



PROJECT NUMBER

**12011.00
Increment #7**

OSHPD - PROJECT NUMBER
IL 072072-30

ISSUE
OSHPD PERMIT

DATE
01/27/2010

SCALE

1/8" = 1' - 0"

DRAWING TITLE

**LEVEL 1
REFLECTED
CEILING PLAN
AREA - D**

DRAWING NUMBER

A4.1D


- LASER - IN USE LIGHT
- EXIT LIGHT FIXTURE
- RECESSED COMPACT FLUORESCENT DOWN LIGHT
- RECESSED COMPACT FLUORESCENT DIRECTIONAL SPOT LIGHT
- RECESSED LED DOWN LIGHT, WALL WASH TRIM, JUNO
- WALL MOUNTED LIGHT FIXTURE
- RECESSED COMPACT FLUORESCENT DOWN LIGHT WITH DIMMER
- RECESSED EXAM LIGHT, W/ WALL MOUNTED CONTROLS
- LOUIE LIGHTING, SD-888 RECESSED LIGHT
- RECESSED FIXTURE, P-8900, PRUDENTIAL LIGHTING
- LOUIS POULSEN, COLLAGE PENDANT
- PENDANT FIXTURE, QUEENY DOWN II, BRUCK
- BOYD, 9955 ARCHETYPE PENDANT, DIMMING SATIN NICKEL
- BOYD, 10217 CATAEOS PENDANT (30"), DIMMING SATIN NICKEL
- CORELITE, VERTECH 218 4' SUSPENDED DIRECT/INDIRECT LINEAR FIXTURE
- BOA CALO SWING SPOT, BRUCK, WITH V/A TRACK, BRUCK
- BRUCK LEDRA DISPLAY TRACK AND SPOT LIGHT
- COLOR KINETICS, ICOLOR FLEX SL, TRACK MOUNTING
- COLOR KINETICS, ICOLOR FLEX SL, STRING LIGHT
- INDIRECT COVE FIXTURE, P-58, PRUDENTIAL LIGHTING
- PERIMETER WALL WASHER W/ ACRYLIC LENS, FOCUS 1, FOCAL POINT
- LED COVE LIGHT
- FLUORESCENT COVE LIGHT
- FLUORESCENT WITH FLUSH LENS, AVENUE D, FOCAL POINT
- EUREKA C49169 LIGHT FIXTURE
- CEILING MOUNTED NURSE CALL INDICATOR
- 4" X 2" FLUORESCENT WALL MOUNTED LIGHT FIXTURE
- RECESSED FLUORESCENT LIGHT FIXTURE
- 1' X 4" FLUORESCENT WALL MOUNTED LIGHT FIXTURE
- 1' X 4" FLUORESCENT UTILITY LIGHT FIXTURE
- SURFACE MOUNTED LED LIGHT
- 2' X 4" FLUORESCENT LIGHT FIXTURE WITH PARABOLIC LENS
- 2' X 4" FLUORESCENT LIGHT FIXTURE DIRECT/INDIRECT
- 2' X 4" FLUORESCENT LIGHT FIXTURE WITH PRISMATIC LENS
- MULTI FUNCTION PATIENT LIGHT FIXTURE
- SQUARE MECHANICAL GRILLES
- LINEAR MECHANICAL GRILLES
- PLASTER CEILING
- METAL PANEL SOFFIT
- GYPSUM BOARD CEILING
- OVERHEAD CABLE TRAY - SEE T5.13A FOR DETAIL

C1 Legend

- REFER TO "FINISH SCHEDULE" FOR FURTHER DEFINITION OF CEILING MATERIALS AND FINISHES.
- CEILING HEIGHT WILL TYPICALLY BE [9'-0"], UNLESS OTHERWISE NOTED ON THE REFLECTED CEILING PLAN.
- LOCATE ALL CEILING MOUNTED SMOKE DETECTORS AND SPEAKERS IN THE CENTER OF FULL PANELS AT LAY-IN CEILINGS.
- LOCATE ALL SPRINKLER HEADS IN THE CENTER OF FULL PANELS AT LAY-IN CEILINGS. AT GYPSUM BOARD CEILINGS, SYMMETRICALLY SPACE HEADS AND CENTER ON LIGHT ROWS WHERE AREA LIMITATIONS PERMIT.
- REFER TO MEP DOCUMENTS FOR LOCATIONS OF CEILING ACCESS PANELS. UNLESS NOTED OR OTHERWISE ACCESS PANELS IN TOILETS AND BACK OF HOUSE SPACES WITH DRYWALL OR PLASTER CEILINGS ARE TO BE PAINTED METAL. PLASTER OR DRYWALL CEILINGS WITH ACCESS PANELS IN AUTOPSY AND BODY HOLDING AREAS ARE TO BE STAINLESS STEEL.
- FOR SEISMIC BRACING AND ANCHORAGE REQUIREMENTS FOR SUSPENDED ACoustical CEILINGS, SEE SHEET A11.10.
- FOR SEISMIC BRACING AND ANCHORAGE REQUIREMENTS FOR SUSPENDED GYPSUM BOARD CEILINGS SEE SHEET A11.10.1.
- GYPSUM BOARD FURROWED HEADERS WILL NOT BE LOWER THAN 8" A.F.F.
- ALL CEILING MOUNTED ITEMS WITH EQUIPMENT TAGS IDENTIFIED ON EQUIPMENT SERIES SHEETS ARE CROSSED REFERENCE TO STRUCTURAL SUPPORT DETAILS VIA MATRIX SHOWN ON EQUIPMENT DRAWINGS.
- FOR ALL LAY IN CEILING PANELS ARRANGE CEILINGS TO NOT HAVE LESS THAN 3" CEILING TILE UNLESS OTHERWISE NOTED.
- PROVIDE 2" WIDE TRIM AT ALL PERIMETER OF ACoustical CEILING GRID SYSTEM TO MEET SEISMIC REQUIREMENTS.
- IN THE EVENT OF A CONFLICT BETWEEN REFLECTED CEILING PLANS AND FINISH SCHEDULES, THE REQUIREMENTS OF TABLE 1224.1 CBC 2007 PART 2 SHALL GOVERN.
- FOR O.R. DIFFUSER ARRAY, PROVIDE 2x4 SUSPENSION SYS. W/ GASKETS (GORDON INC. - GC-15). HOLD DOWN CLIPS, ALUMINUM PANELS (USD: PANZ 2x4 (SMOOTH) SQUARE EDGE LAY-IN.

B1 General Notes

- RFI 4014 See revised ceiling layout per access panel coordination.

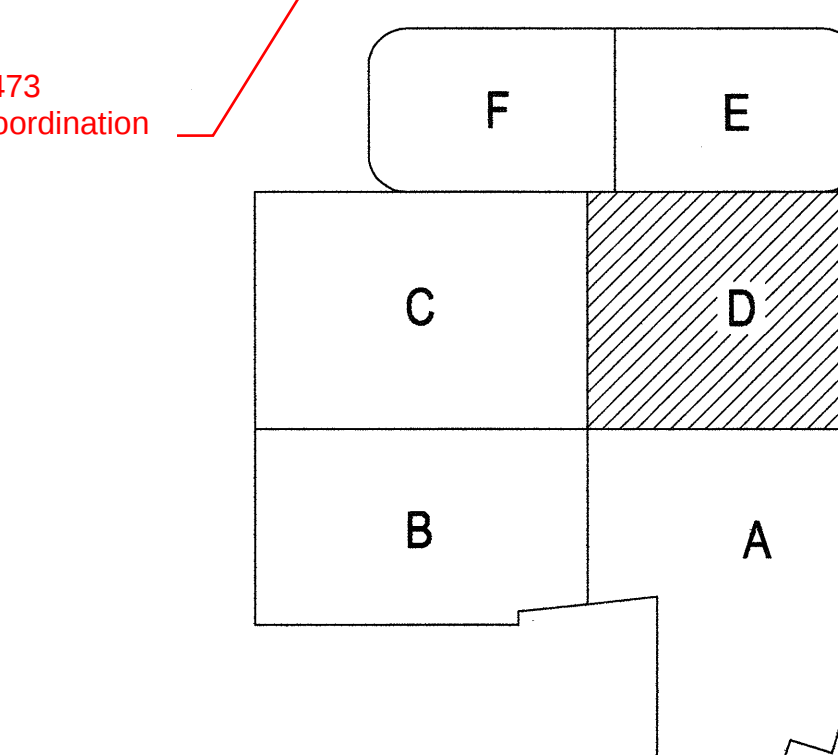


A1 Key Plan

N.T.S.

B3 Enlarged Plan

1/4" = 1'-0"

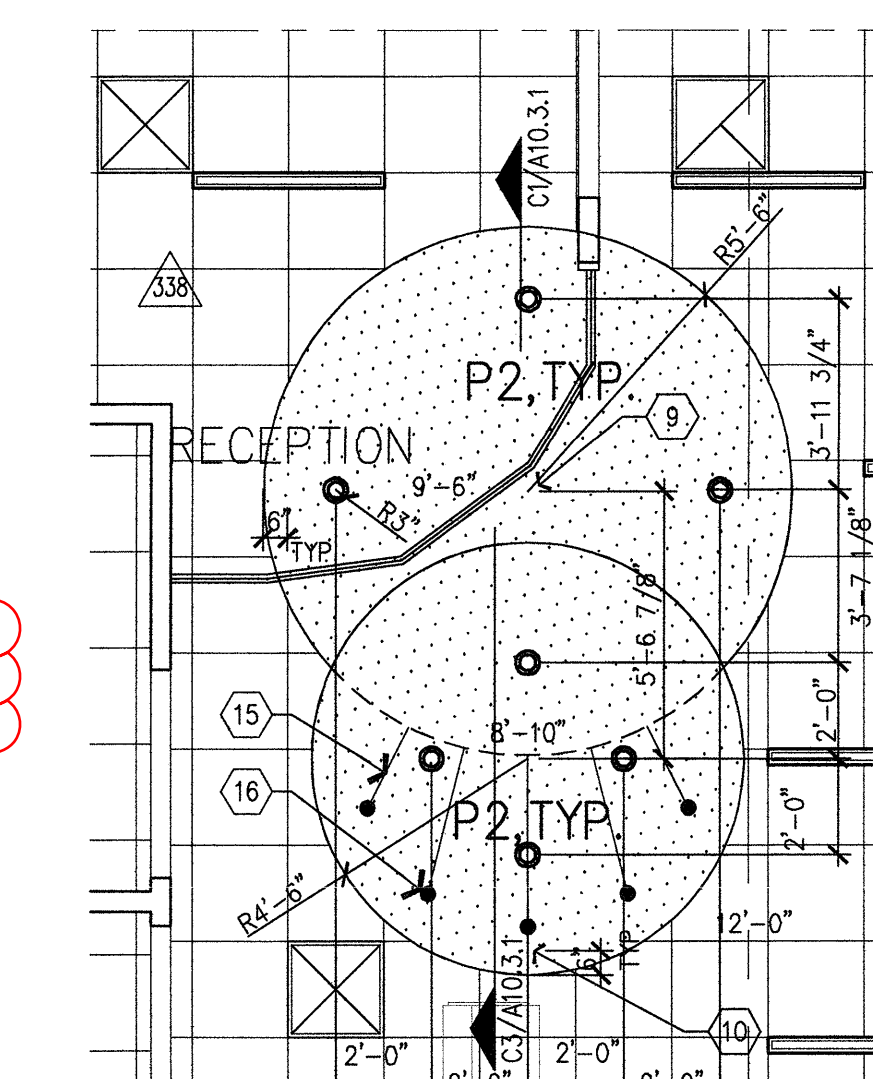


B2 Enlarged Plan

1/4" = 1'-0"

- No ceiling, exposed to structure.
- See Electrical & Mechanical for lighting & HVAC in this space.
- Seismic expansion joint ceiling cover, Type 4A or 5A.
- Align finish face of furrdown with finish face of partition.
- Align centerline of fixture with centerline of bed. See plan.
- Unistrut grid system, see structural details C1/S.2.
- Light support, see Equipment drawings and workbook.
- Tracking monitor, see Equipment drawings and workbook. See Det. B4/S5 for structural mount detail.
- Center point location, see 1/8" reflected ceiling plan. Suspended decorative ceiling, see detail A10.1. See referenced interior elevations.
- Gypsum board furr down to 9'-0" a.f.f., 2-hour rated vertical and horizontal assembly.
- Tamper resistant fixture. Align light fixture and diffusers on a 24" module.
- Provide high impact gypsum wallboard.
- 'Smoke Guard' smoke & draft control assembly, Model 900.
- Holding Rod
- Approved Wall/Ceiling Expansion Joint System.

A2 Notes To Sheet

N.T.S.

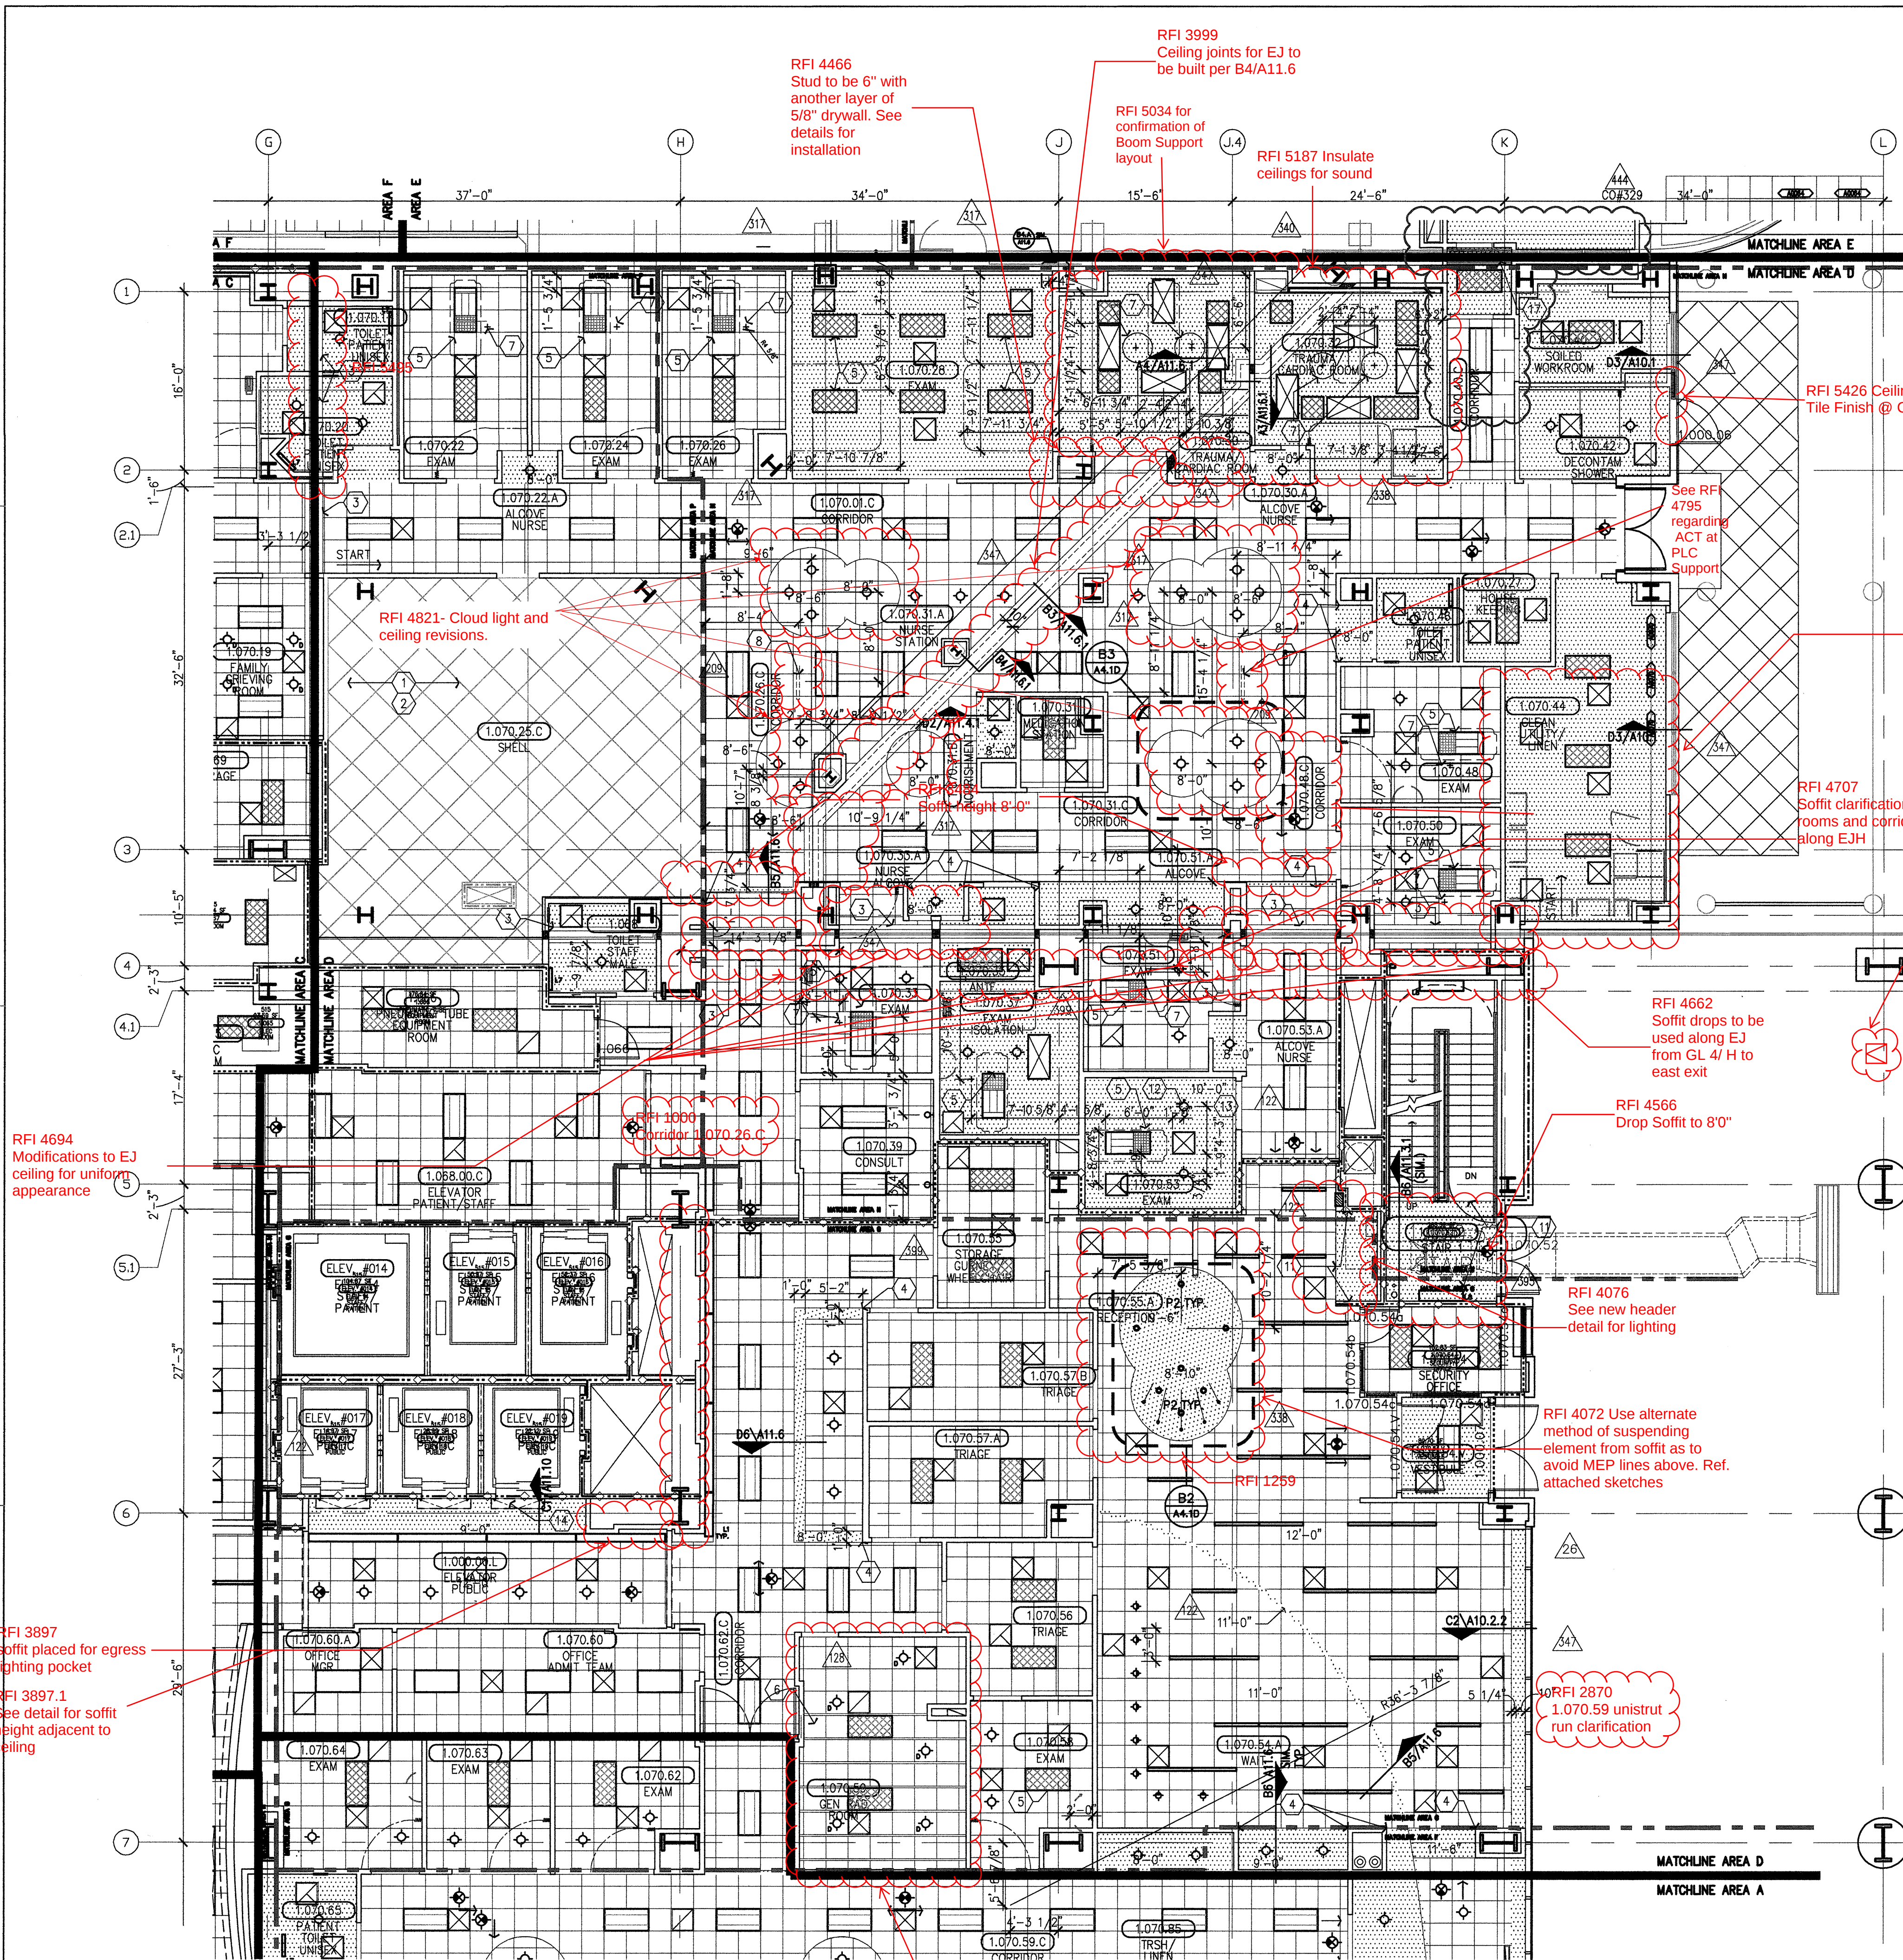

A6 AREA D

1/8" = 1'-0"

A

N.T.S.

6

5

4

3

2

1