
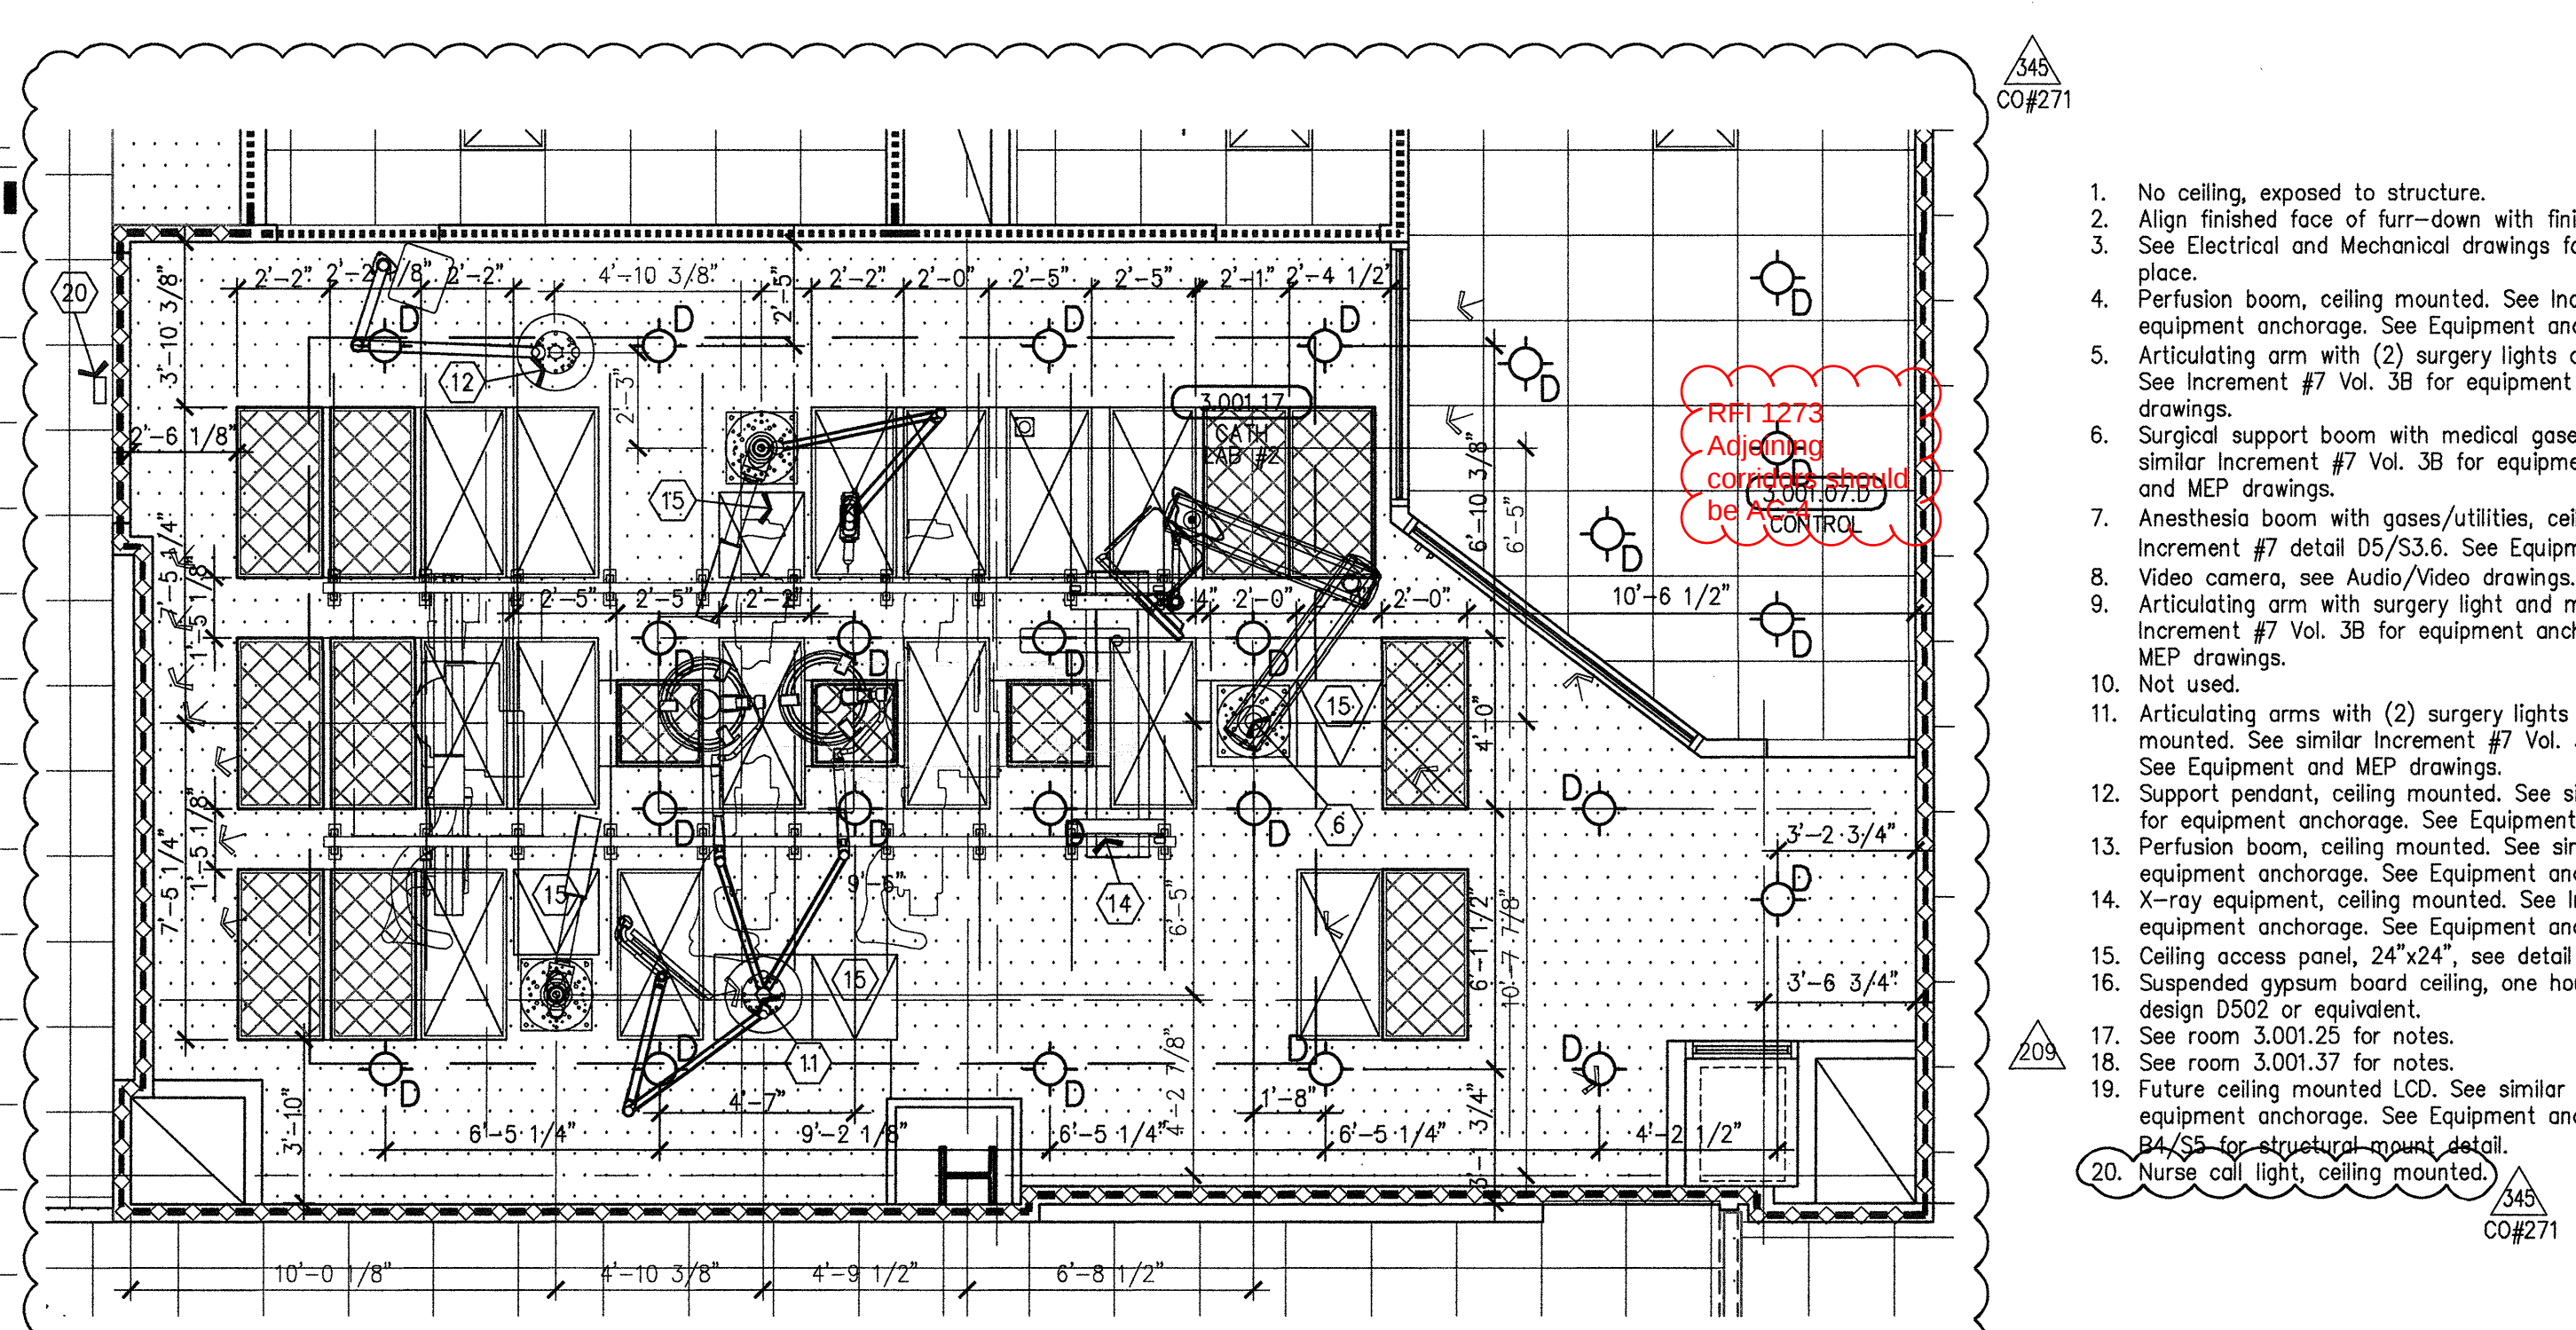
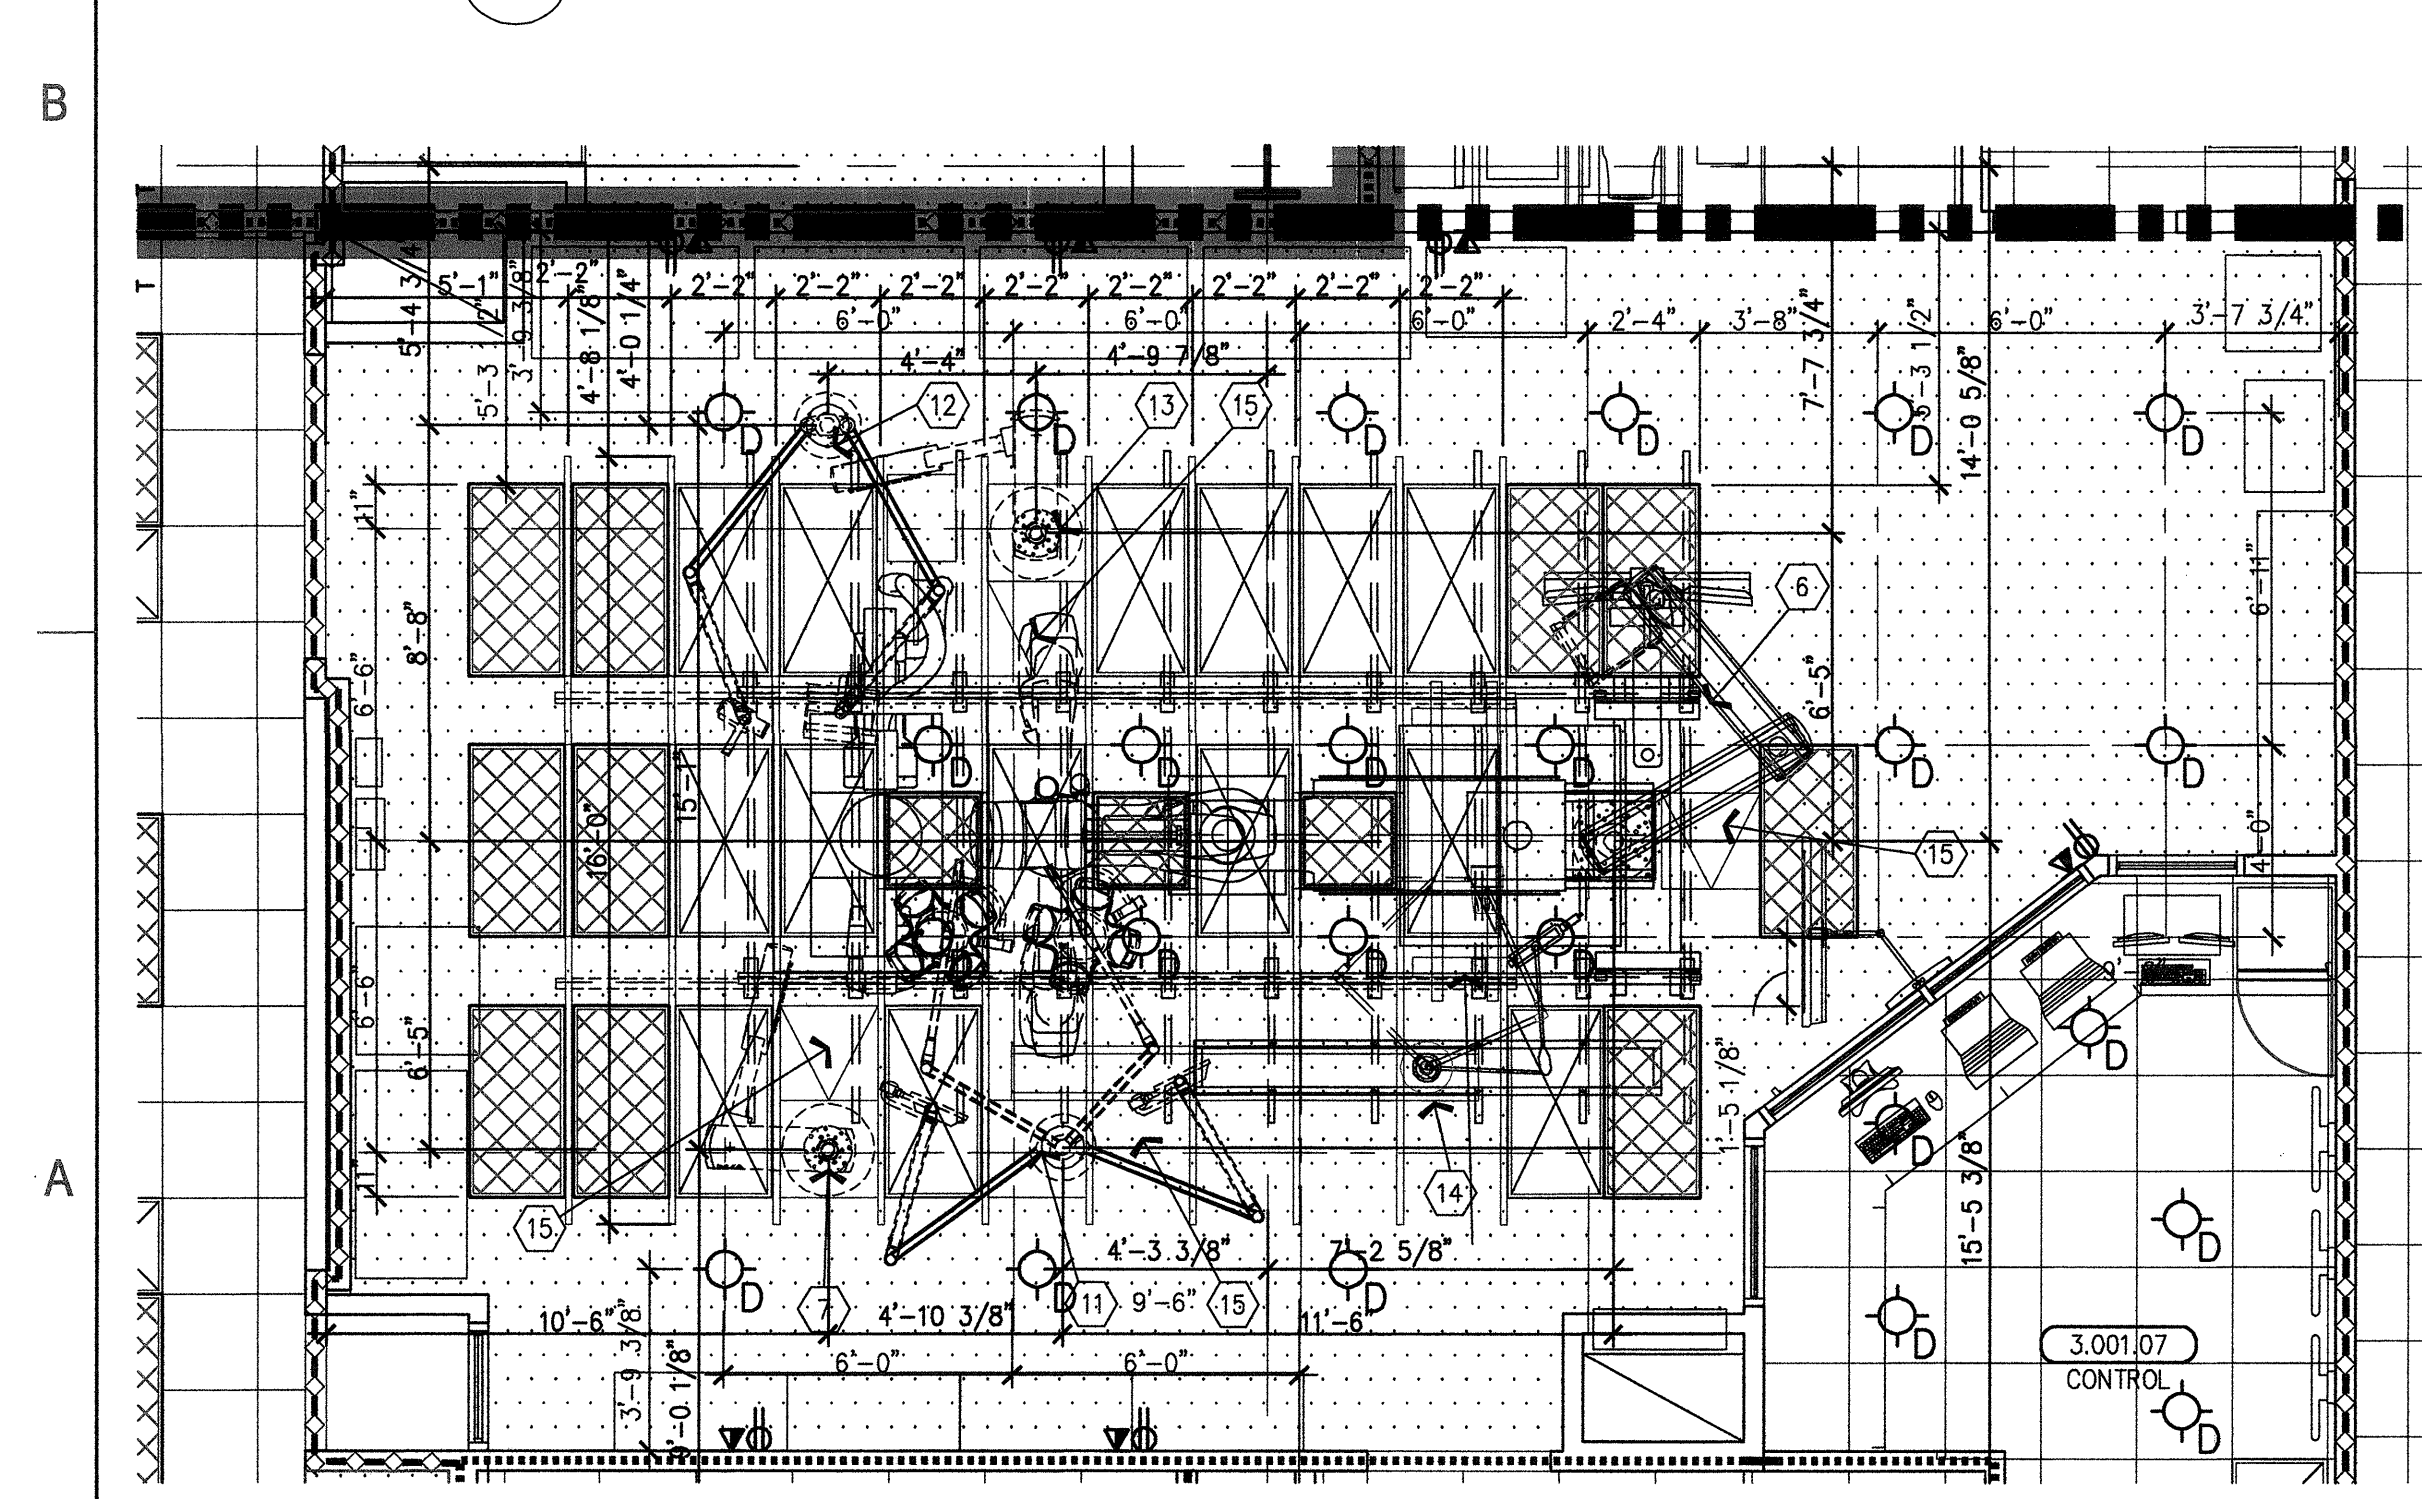


RFI #5494
OR Access Panels
See ceiling layout detail
and materials clarifications
RFI #5048
No ceiling in
cabinet closets
for OR's

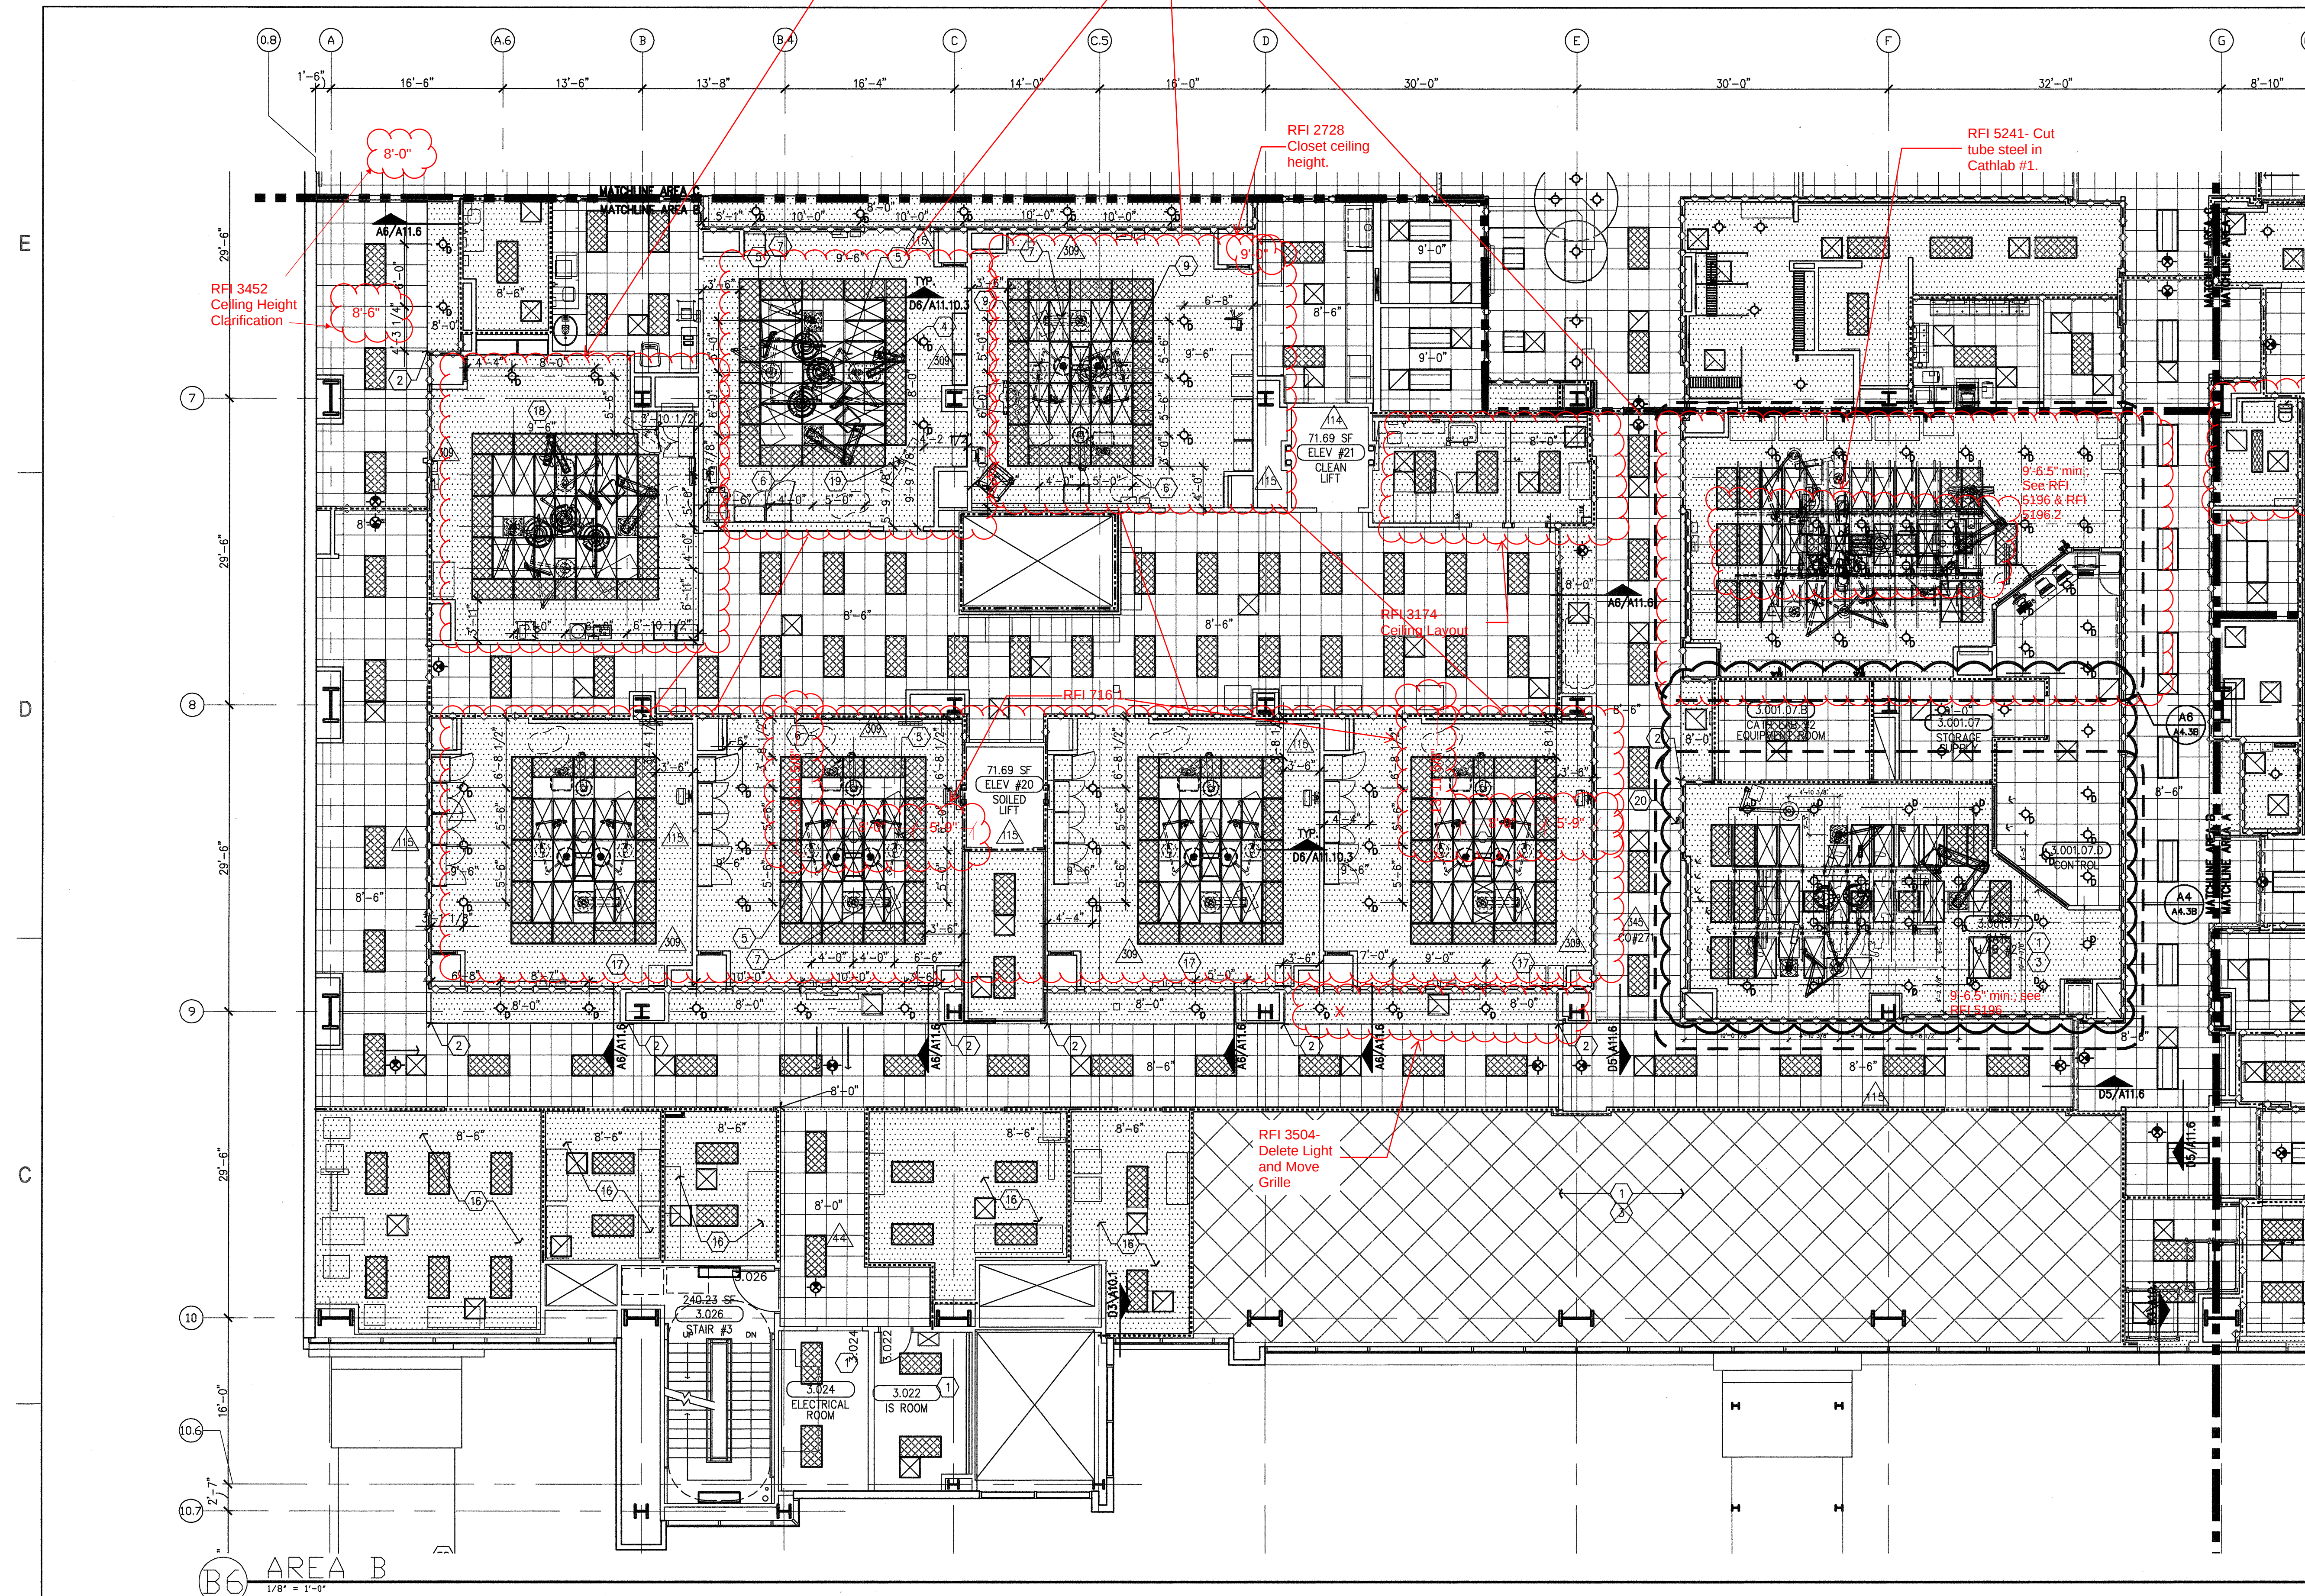

1. No ceiling, exposed to structure.
2. Align finished face of furr-down with finished face of partition.
3. See Electrical and Mechanical drawings for lighting and HVAC in this place.
4. Perfusion boom, ceiling mounted. See Increment #7 Vol. 3B for equipment anchorage. See Equipment and Plumbing drawings.
5. Articulating arm with (2) surgery lights and monitor, ceiling mounted. See Increment #7 Vol. 3B for equipment anchorage. See Equipment drawings.
6. Surged support boom with medical gases, ceiling mounted. See similar Increment #7 Vol. 3B for equipment anchorage. See Equipment and MEP drawings.
7. Anesthesia boom with gases/utilities, ceiling mounted. See similar Increment #7 detail D5/33.6. See Equipment and MEP drawings.
8. Video camera, see Audio/Video drawings.
9. Articulating arm with surgery light and monitor, ceiling mounted. See Increment #7 Vol. 3B for equipment anchorage. See Equipment and MEP drawings.
10. Not used.
11. Articulating arms with (2) surgery lights and (2) monitors, ceiling mounted. See similar Increment #7 Vol. 3B for equipment anchorage. See Equipment and MEP drawings.
12. Support pendant, ceiling mounted. See similar Increment #7 Vol. 3B for equipment anchorage. See Equipment and MEP drawings.
13. Perfusion boom, ceiling mounted. See similar Increment #7 Vol. 3B for equipment anchorage. See Equipment and MEP drawings.
14. X-ray equipment, ceiling mounted. See Increment #7 Vol. 3B for equipment anchorage. See Equipment and MEP drawings.
15. Ceiling access panel, 24"x24", see detail B6/A11.4.
16. Suspended gypsum board ceiling, one hour rated ceiling assembly UL design D502 or equivalent.
17. See room 3.001.25 for notes.
18. See room 3.001.37 for notes.
19. Future ceiling mounted LCD. See similar Increment #7 Vol. 3B for equipment anchorage. See Equipment and Electrical drawings. See Det. B4/S for structural mount detail.
20. Nurse call light, ceiling mounted.


- X-RAY - IN USE LIGHT
- LASER - IN USE LIGHT
- EXIT LIGHT FIXTURE
- RECESSED COMPACT FLUORESCENT DOWN LIGHT
- RECESSED COMPACT FLUORESCENT DIRECTIONAL SPOT LIGHT
- RECESSED LED DOWN LIGHT, WALL WASH TRIM, JUNO
- WALL MOUNTED LIGHT FIXTURE
- RECESSED COMPACT FLUORESCENT DOWN LIGHT WITH DIMMER
- RECESSED EXAM LIGHT, W/ WALL MOUNTED CONTROLS
- LOUIE LIGHTING, SD-888 RECESSED LIGHT
- RECESSED FIXTURE, P-8900, PRUDENTIAL LIGHTING
- LOUIS POULSEN, COLLAGE PENDANT
- PENDANT FIXTURE, QUEENY DOWN II, BRUCK
- BOYD, 9955 ARCHETYPE PENDANT, DIMMING SATIN NICKEL
- BOYD, 10217 CATACOGS PENDANT (30"), DIMMING SATIN NICKEL
- CORELITE, VERTECH 278 4' SUSPENDED DIRECT/INDIRECT LINEAR FIXTURE
- BOA CALO SWING SPOT, BRUCK, WITH V/A TRACK, BRUCK
- BRUCK LEDRA DISPLAY TRACK AND SPOT LIGHT
- COLOR KINETICS, ICOLOR FLEX SL, TRACK MOUNTING
- COLOR KINETICS, ICOLOR FLEX SL, STRING LIGHT
- INDIRECT COVE FIXTURE, P-59, PRUDENTIAL LIGHTING
- PERIMETER WALL WASHER W/ ACRYLIC LENS, FOCUS 1, FOCAL POINT
- LED COVE LIGHT
- FLUORESCENT COVE LIGHT
- FLUORESCENT WITH FLUSH LENS, AVENUE b, FOCAL POINT
- EUREKA C49169 LIGHT FIXTURE
- CEILING MOUNTED NURSE CALL INDICATOR
- 4" X 2' FLUORESCENT WALL MOUNTED LIGHT FIXTURE
- RECESSED FLUORESCENT LIGHT FIXTURE
- 1' X 4' FLUORESCENT WALL MOUNTED LIGHT FIXTURE
- 1' X 4' FLUORESCENT UTILITY LIGHT FIXTURE
- SURFACE MOUNTED LED LIGHT
- 2' X 4' FLUORESCENT LIGHT FIXTURE WITH PARABOLIC LENS
- 2' X 4' FLUORESCENT LIGHT FIXTURE DIRECT/INDIRECT
- 2' X 4' FLUORESCENT LIGHT FIXTURE WITH PRISMATIC LENS
- MULTI FUNCTION PATIENT LIGHT FIXTURE
- SQUARE MECHANICAL GRILLES
- LINEAR MECHANICAL GRILLES
- PLASTER CEILING
- METAL PANEL SOFFIT
- GYPSUM BOARD CEILING
- OVERHEAD CABLE TRAY- SEE T5.13A FOR DETAIL
- 2' X 2' SUSPENDED ACOUSTICAL TILE

Legend

- A. REFER TO "FINISH SCHEDULE" FOR FURTHER DEFINITION OF CEILING MATERIALS AND FINISHES.
- B. CEILING HEIGHT WILL TYPICALLY BE [9'-0"] UNLESS OTHERWISE NOTED ON THE REFLECTED CEILING PLAN.
- C. LOCATE ALL CEILING MOUNTED SMOKE DETECTORS AND SPEAKERS IN THE CENTER OF FULL PANELS AT LAY-IN CEILINGS.
- D. LOCATE ALL SPRINKLER HEADS IN THE CENTER OF FULL PANELS AT LAY-IN CEILINGS. AT GYPSUM BOARD CEILINGS, SYMMETRICALLY SPACE HEADS AND CENTER ON LIGHT ROWS WHERE AREA LIMITATIONS PERMIT.
- E. REFER TO MEP DOCUMENTS FOR LOCATIONS OF CEILING ACCESS PANELS. UNLESS NOTED OR DETAILED OTHERWISE ACCESS PANELS IN TOILETS AND BACK OF HOUSE SPACES WITH DRYWALL OR PLASTER CEILINGS ARE TO BE PAINTED METAL. PLASTER OR DRYWALL CEILINGS WITH ACCESS PANELS IN AUTOPSY AND BODY HOLDING AREAS ARE TO BE STAINLESS STEEL.
- F. FOR SEISMIC BRACING AND ANCHORAGE REQUIREMENTS FOR SUSPENDED ACOUSTICAL CEILINGS, SEE SHEET A11.10.
- G. FOR SEISMIC BRACING AND ANCHORAGE REQUIREMENTS FOR SUSPENDED GYPSUM BOARD CEILINGS, SEE SHEET A11.10.
- H. GYPSUM BOARD FURRODOWN HEADERS WILL NOT BE LOWER THAN 8" A.F.F.
- I. ALL CEILING MOUNTED ITEMS WITH EQUIPMENT TAGS IDENTIFIED ON EQUIPMENT SERIES SHEETS ARE CROSSED REFERENCE TO STRUCTURAL SUPPORT DETAILS VIA MATRIX SHOWN ON EQUIPMENT DRAWINGS.
- J. FOR ALL LAY IN CEILING PANELS ARRANGE CEILINGS TO NOT HAVE LESS THAN 1/2" CEILING TILE UNLESS OTHERWISE NOTED.
- K. PROVIDE 2" WIDE TRIM AT ALL PERIMETER OF ACOUSTICAL CEILING GRID SYSTEM TO MEET SEISMIC REQUIREMENTS.
- L. IN THE EVENT OF A CONFLICT BETWEEN REFLECTED CEILING PLANS AND FINISH SCHEDULES, THE REQUIREMENTS OF TABLE 1224.1 CBC 2007 PART 2 SHALL GOVERN.
- M. FOR G.R. DIFFUSER ARRAY, PROVIDE 2x4 SUSPENSION SYS. W/ GASKETS (GORDON INC. : GC-15); HOLD DOWN CLIPS; ALUMINUM PANELS (USG: PANX 2x4 SMOOTH) SQUARE EDGE LAY-IN.

B1 General Notes


RFI #5457
3rd floor RCP
coordination.

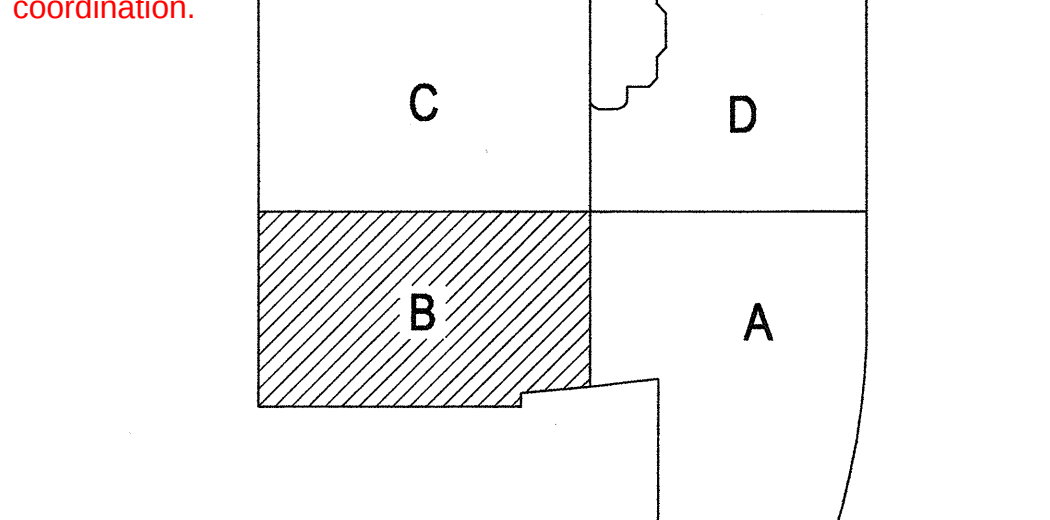

A1 KEY PLAN




ARCHITECT OF RECORD
Paul C. Gloriot

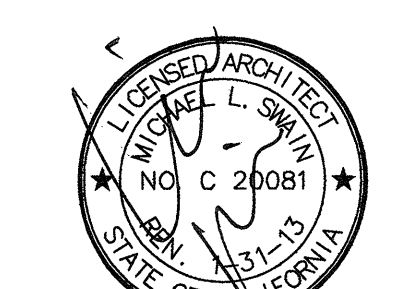

Changes on these drawings do not consist of materials altered changes to approved drawings and don't require a change order.
OSHPD review ACO
OSHPD review FLSO
OSHPD review DSE

REVISIONS			
44	05/28/10	ASI #08	
113	10/01/10	ASI #39	
114	10/29/10	CO#83	
128	01/24/11	ASI #51	
209	03/10/11	ASI #74	
308	07/24/11	CO #245	
345	12/19/11	CO#271	

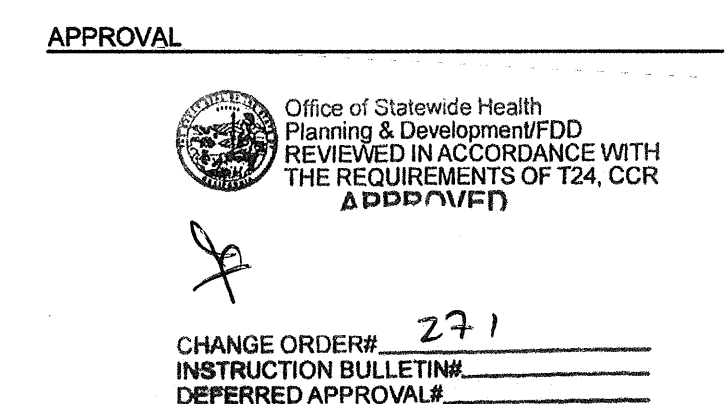

PROJECT NAME
CHILDREN'S HOSPITAL OF ORANGE COUNTY
455 S. Main St.
Orange, CA 92668-3874



PROJECT NUMBER
12011.00
Increment #7
OSHPD - PROJECT NUMBER
IL 072072-30

ISSUE
OSHPD PERMIT

DATE
01/27/2010

SCALE
1/8" = 1' - 0"

DRAWING TITLE
LEVEL 3 REFLECTED CEILING PLAN AREA - B

DRAWING NUMBER
44

A4.3B