


FKP Architects


ARCHITECT OF RECORD

Paul C. Gloriod

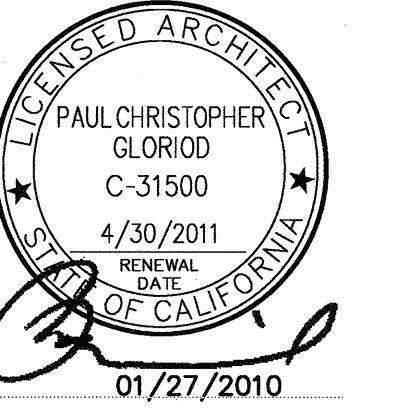

REVISIONS

APPROVAL

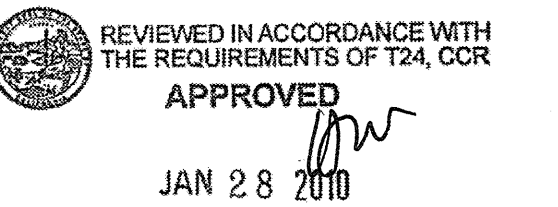

PROJECT NAME

CHILDREN'S HOSPITAL  
OF ORANGE COUNTY

455 S. Main St.  
Orange, CA 92868-3874

TOWER II



PROJECT NUMBER

12011.00  
Increment #7

OSHPD - PROJECT NUMBER

IL 072072-30

ISSUE

OSHPD PERMIT

DATE

01/27/2010

SCALE


1/16" = 1'-0"

DRAWING TITLE


LEVEL 6 REFLECTED  
CEILING PLAN

DRAWING NUMBER

A4.61

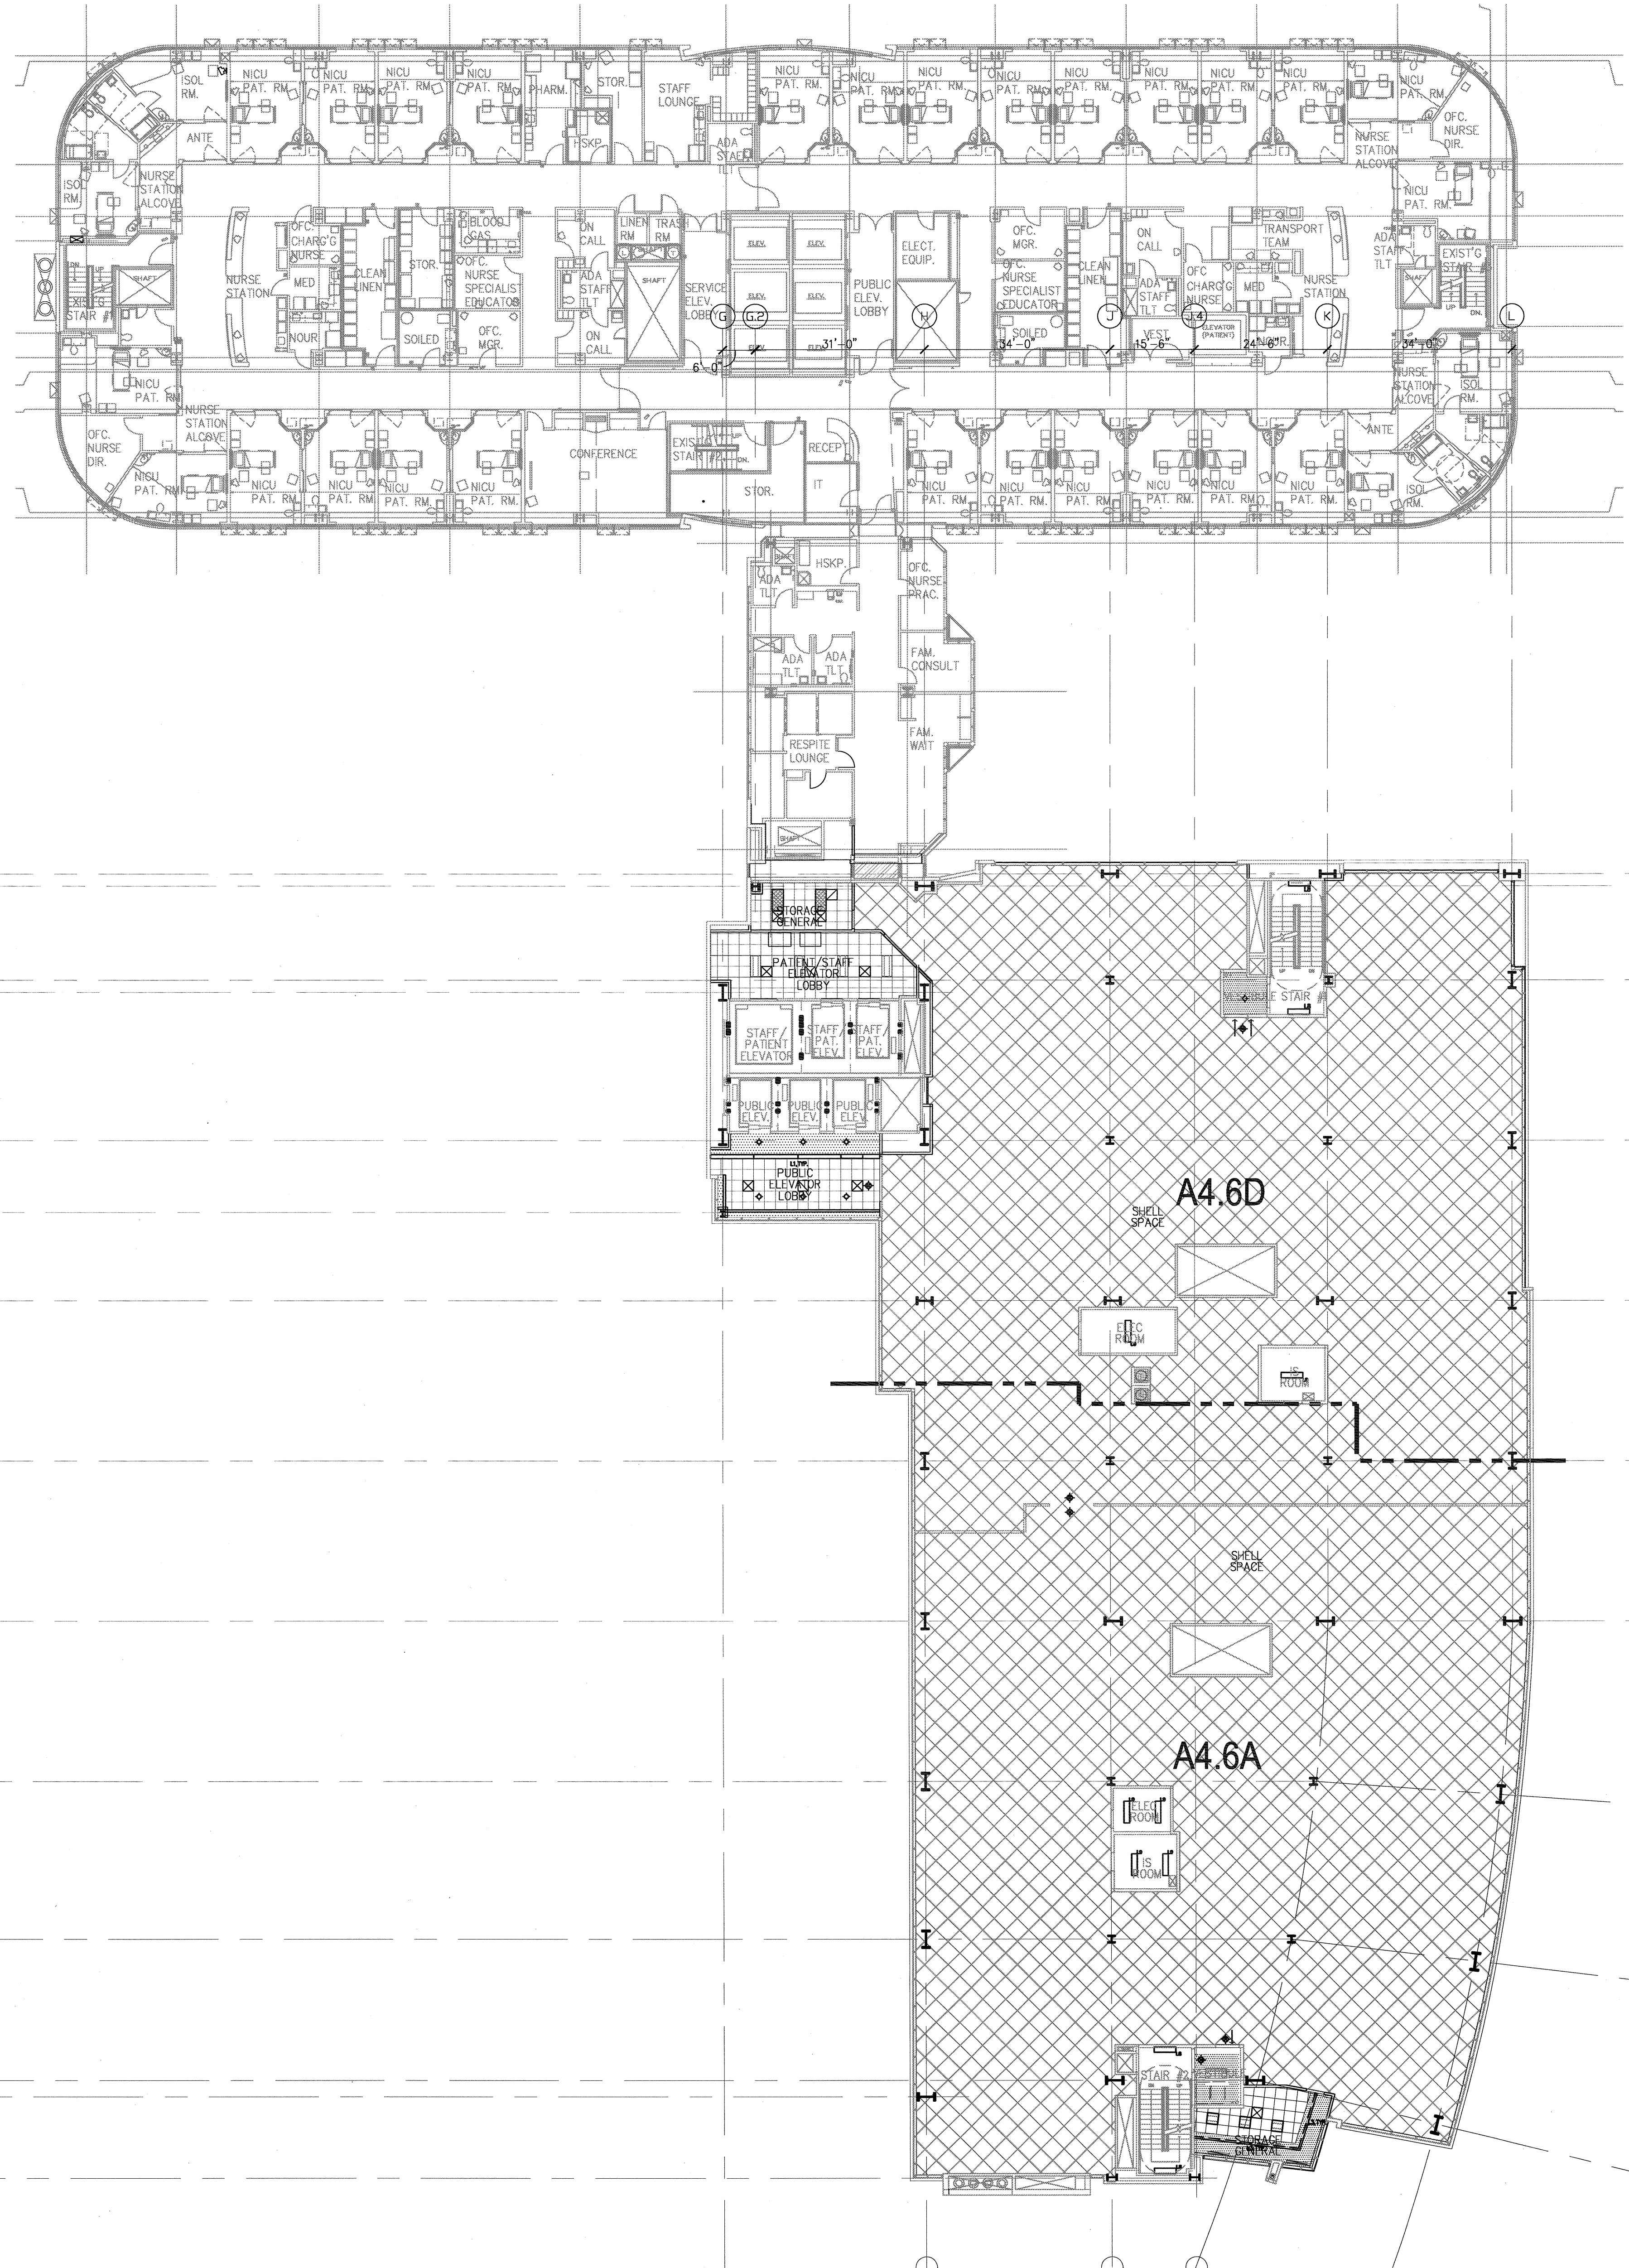

RFI 1018  
Refer to electrical lighting plans for  
light fixture locations in "shell space"

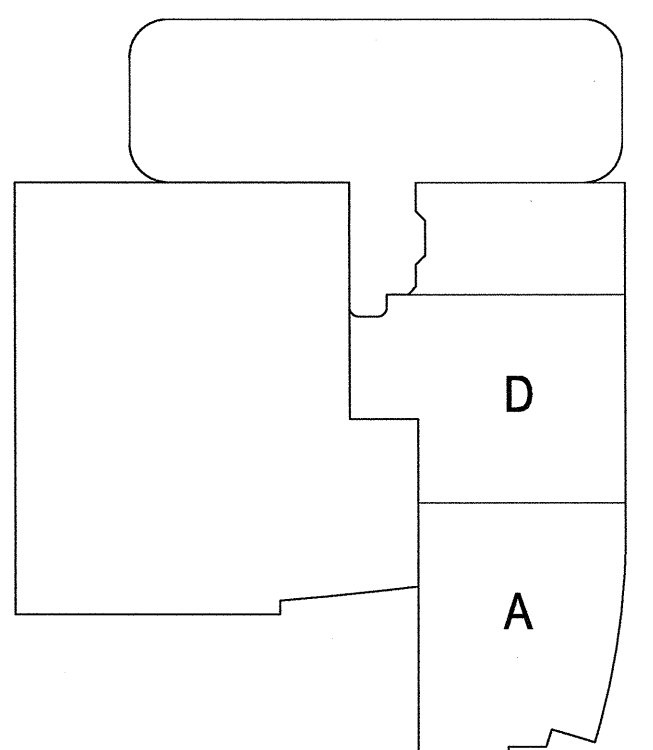

A1 KEY PLAN

A6 LEVEL 6  
1/16" = 1'-0"