


FKP Architects


ARCHITECT OF RECORD

Paul C. Gloriod

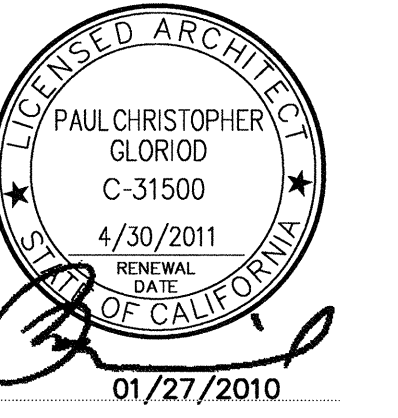

REVISIONS

APPROVAL

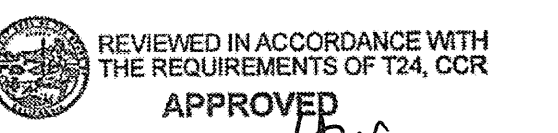

JAN 28 2010

Office of Statewide Health  
Planning & Development  
FACILITIES DEVELOPMENT DIVISION

PROJECT NAME

CHILDREN'S HOSPITAL  
OF ORANGE COUNTY

455 S. Main St.  
Orange, CA 92868-3874

TOWER II



PROJECT NUMBER

12011.00  
Increment #7

OSHPD - PROJECT NUMBER

IL 072072-30

ISSUE

OSHPD PERMIT

DATE

01/27/2010

SCALE


1/16" = 1'-0"

DRAWING TITLE


LEVEL 7 REFLECTED  
CEILING PLAN

DRAWING NUMBER

A4.71

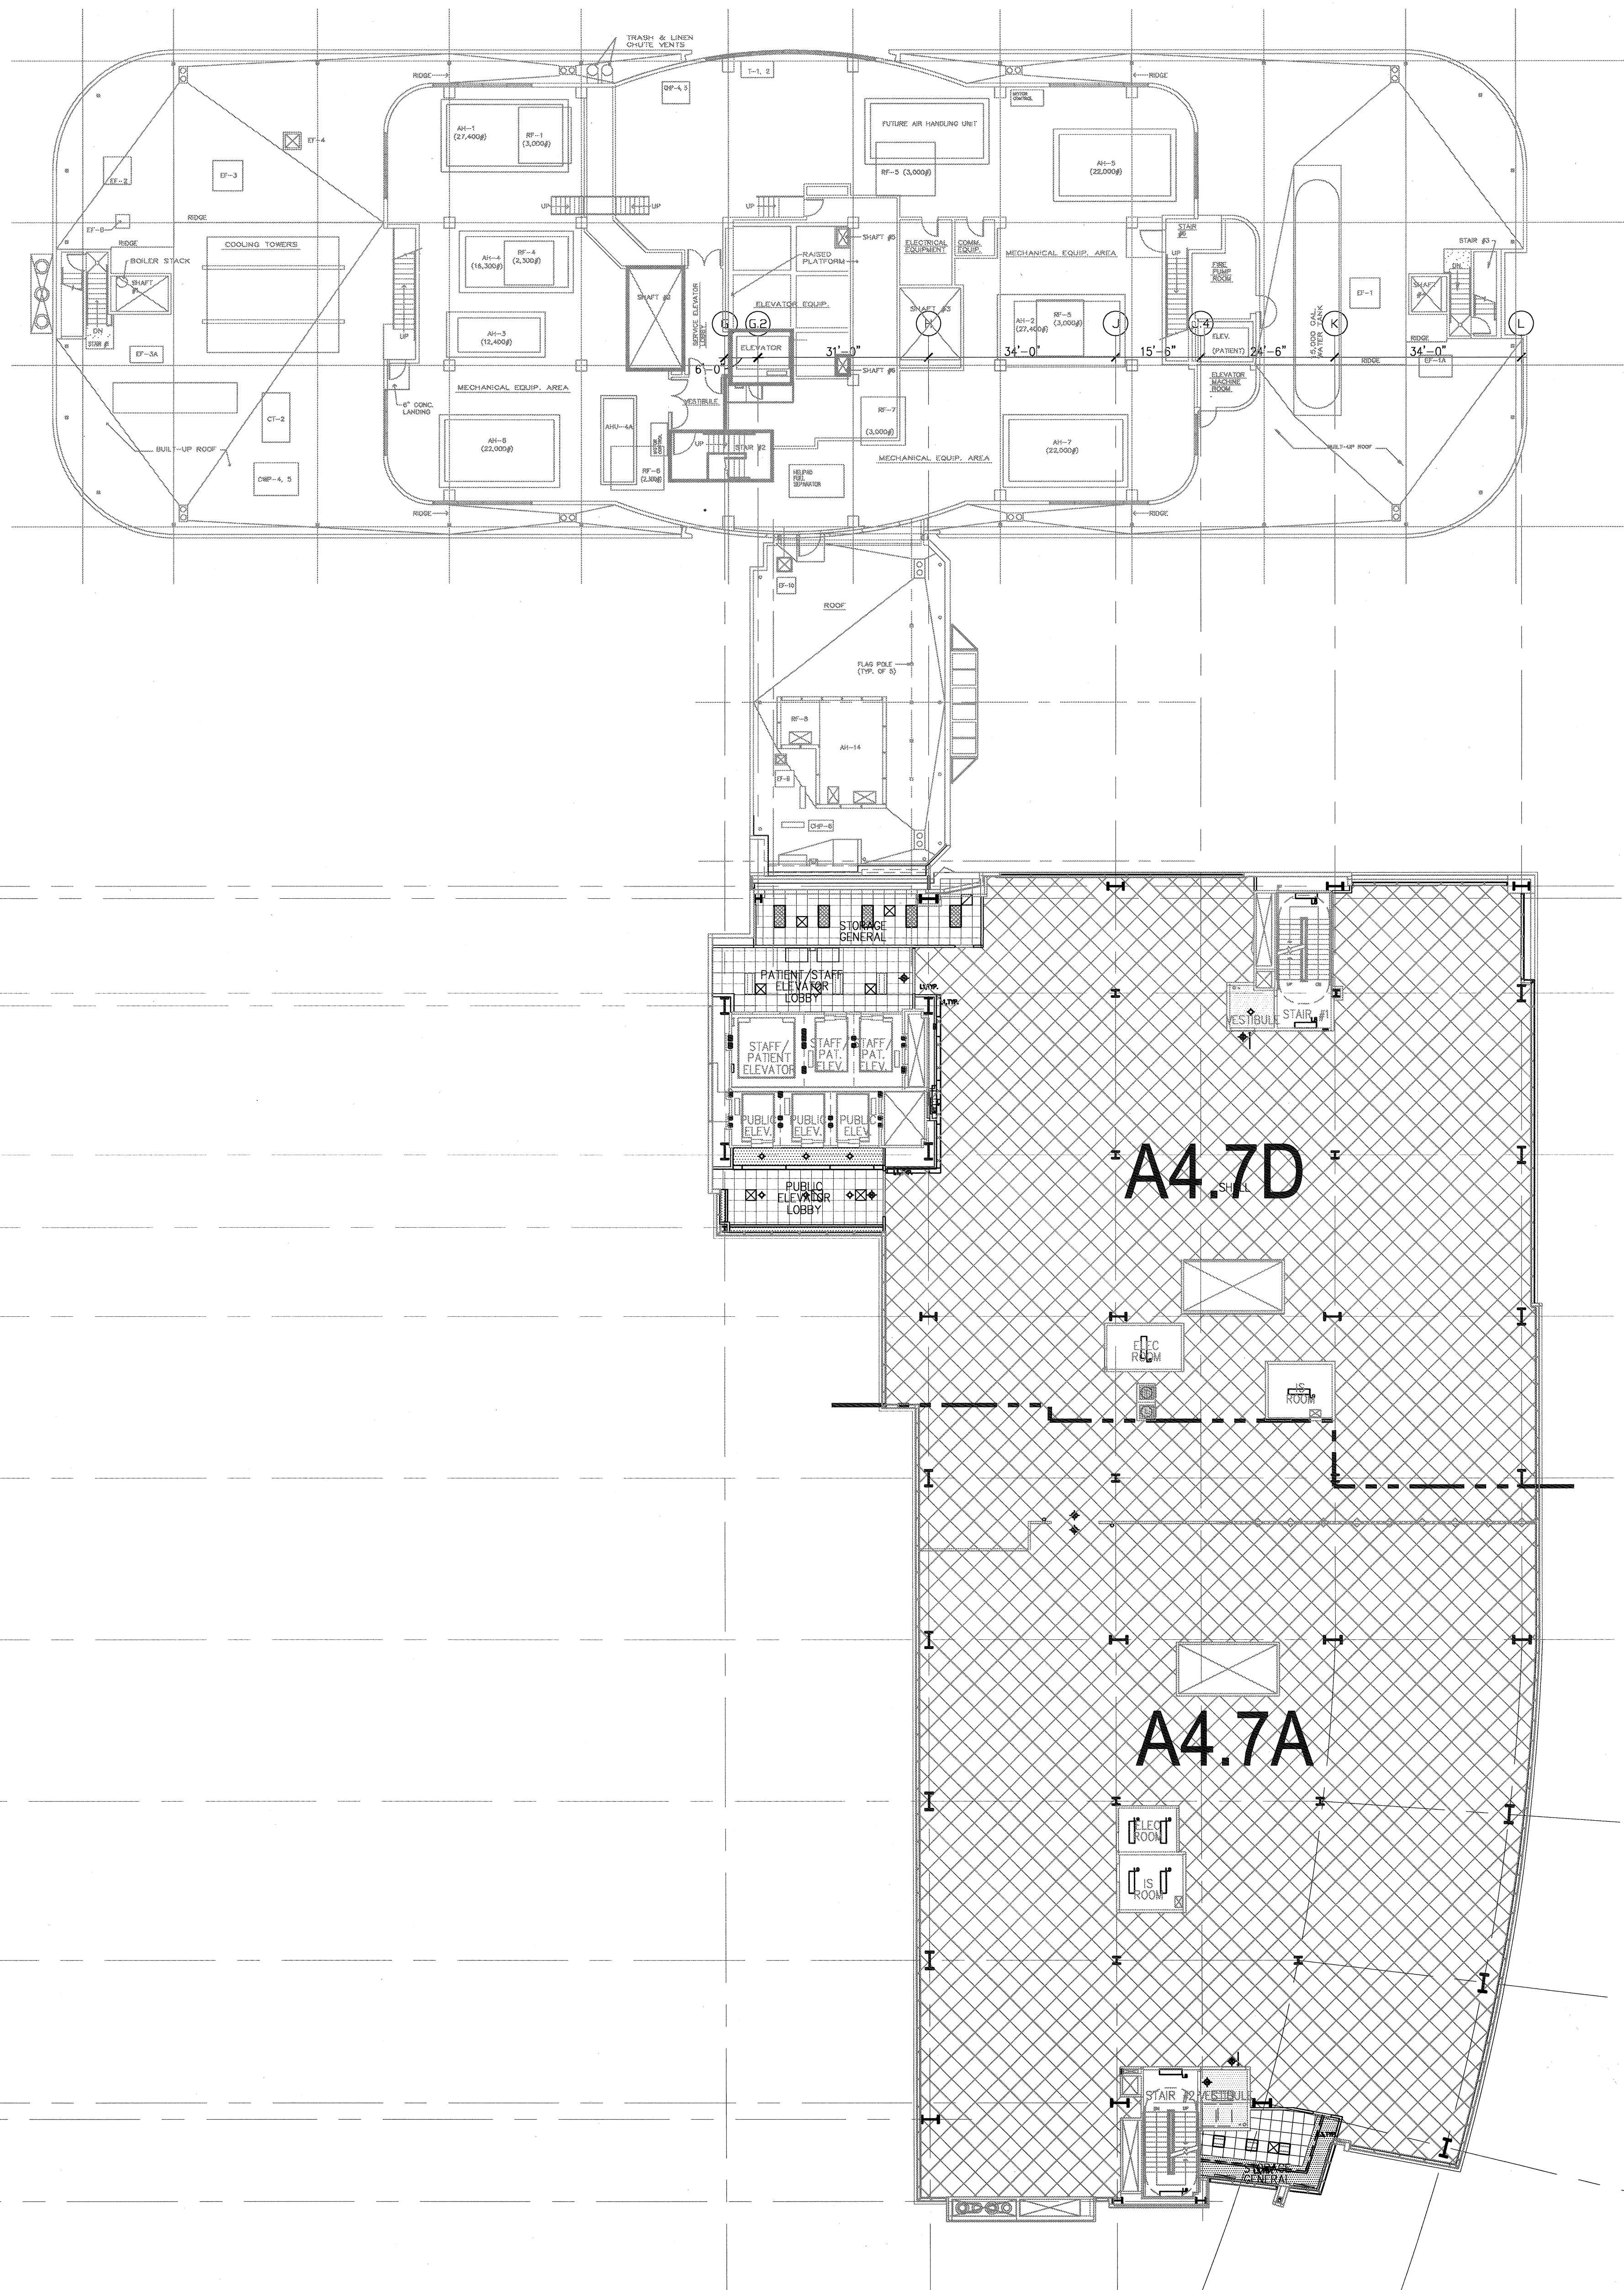

RFI 1018  
Refer to electrical lighting plans for light  
fixture locations in shell space.

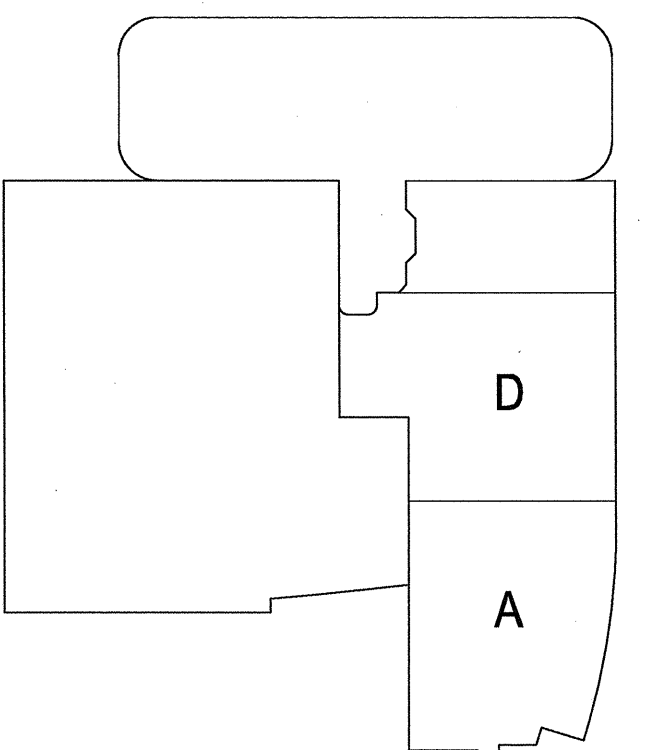

A6 LEVEL 7  
1/16" = 1'-0"

A1 KEY PLAN