


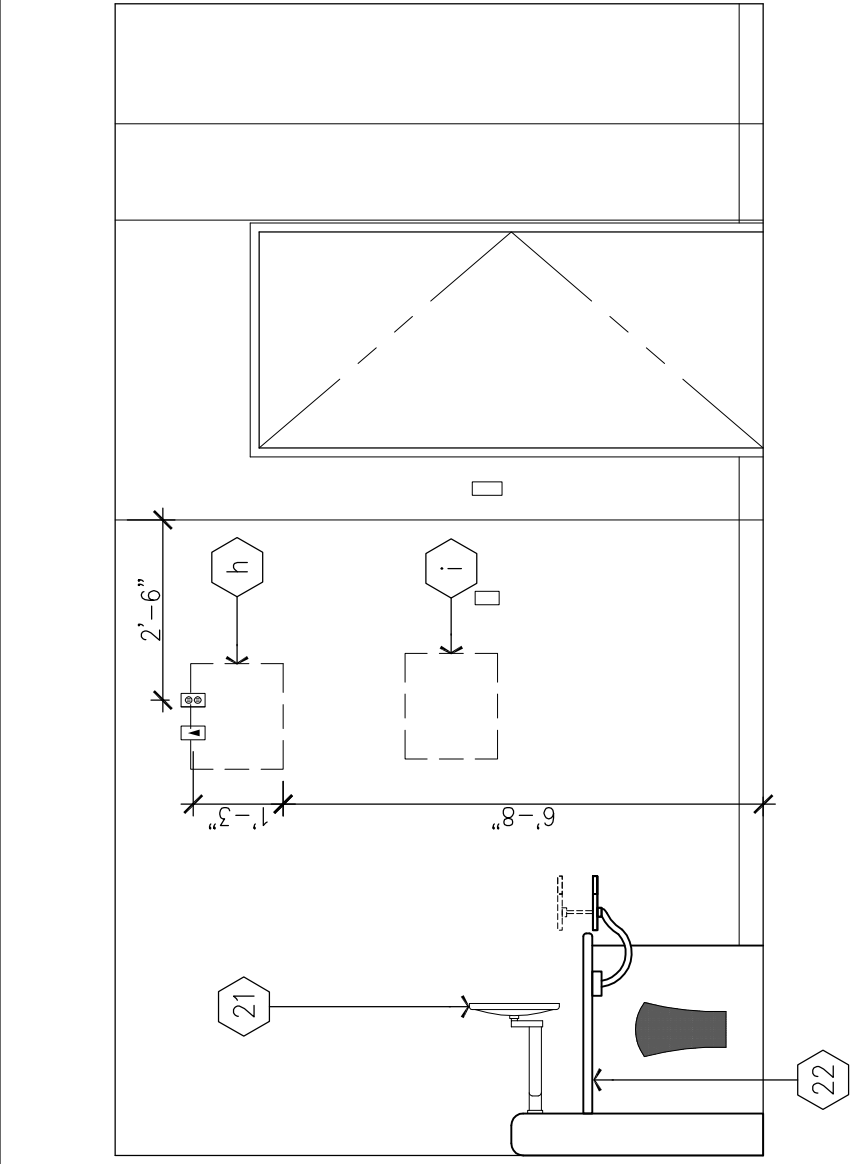


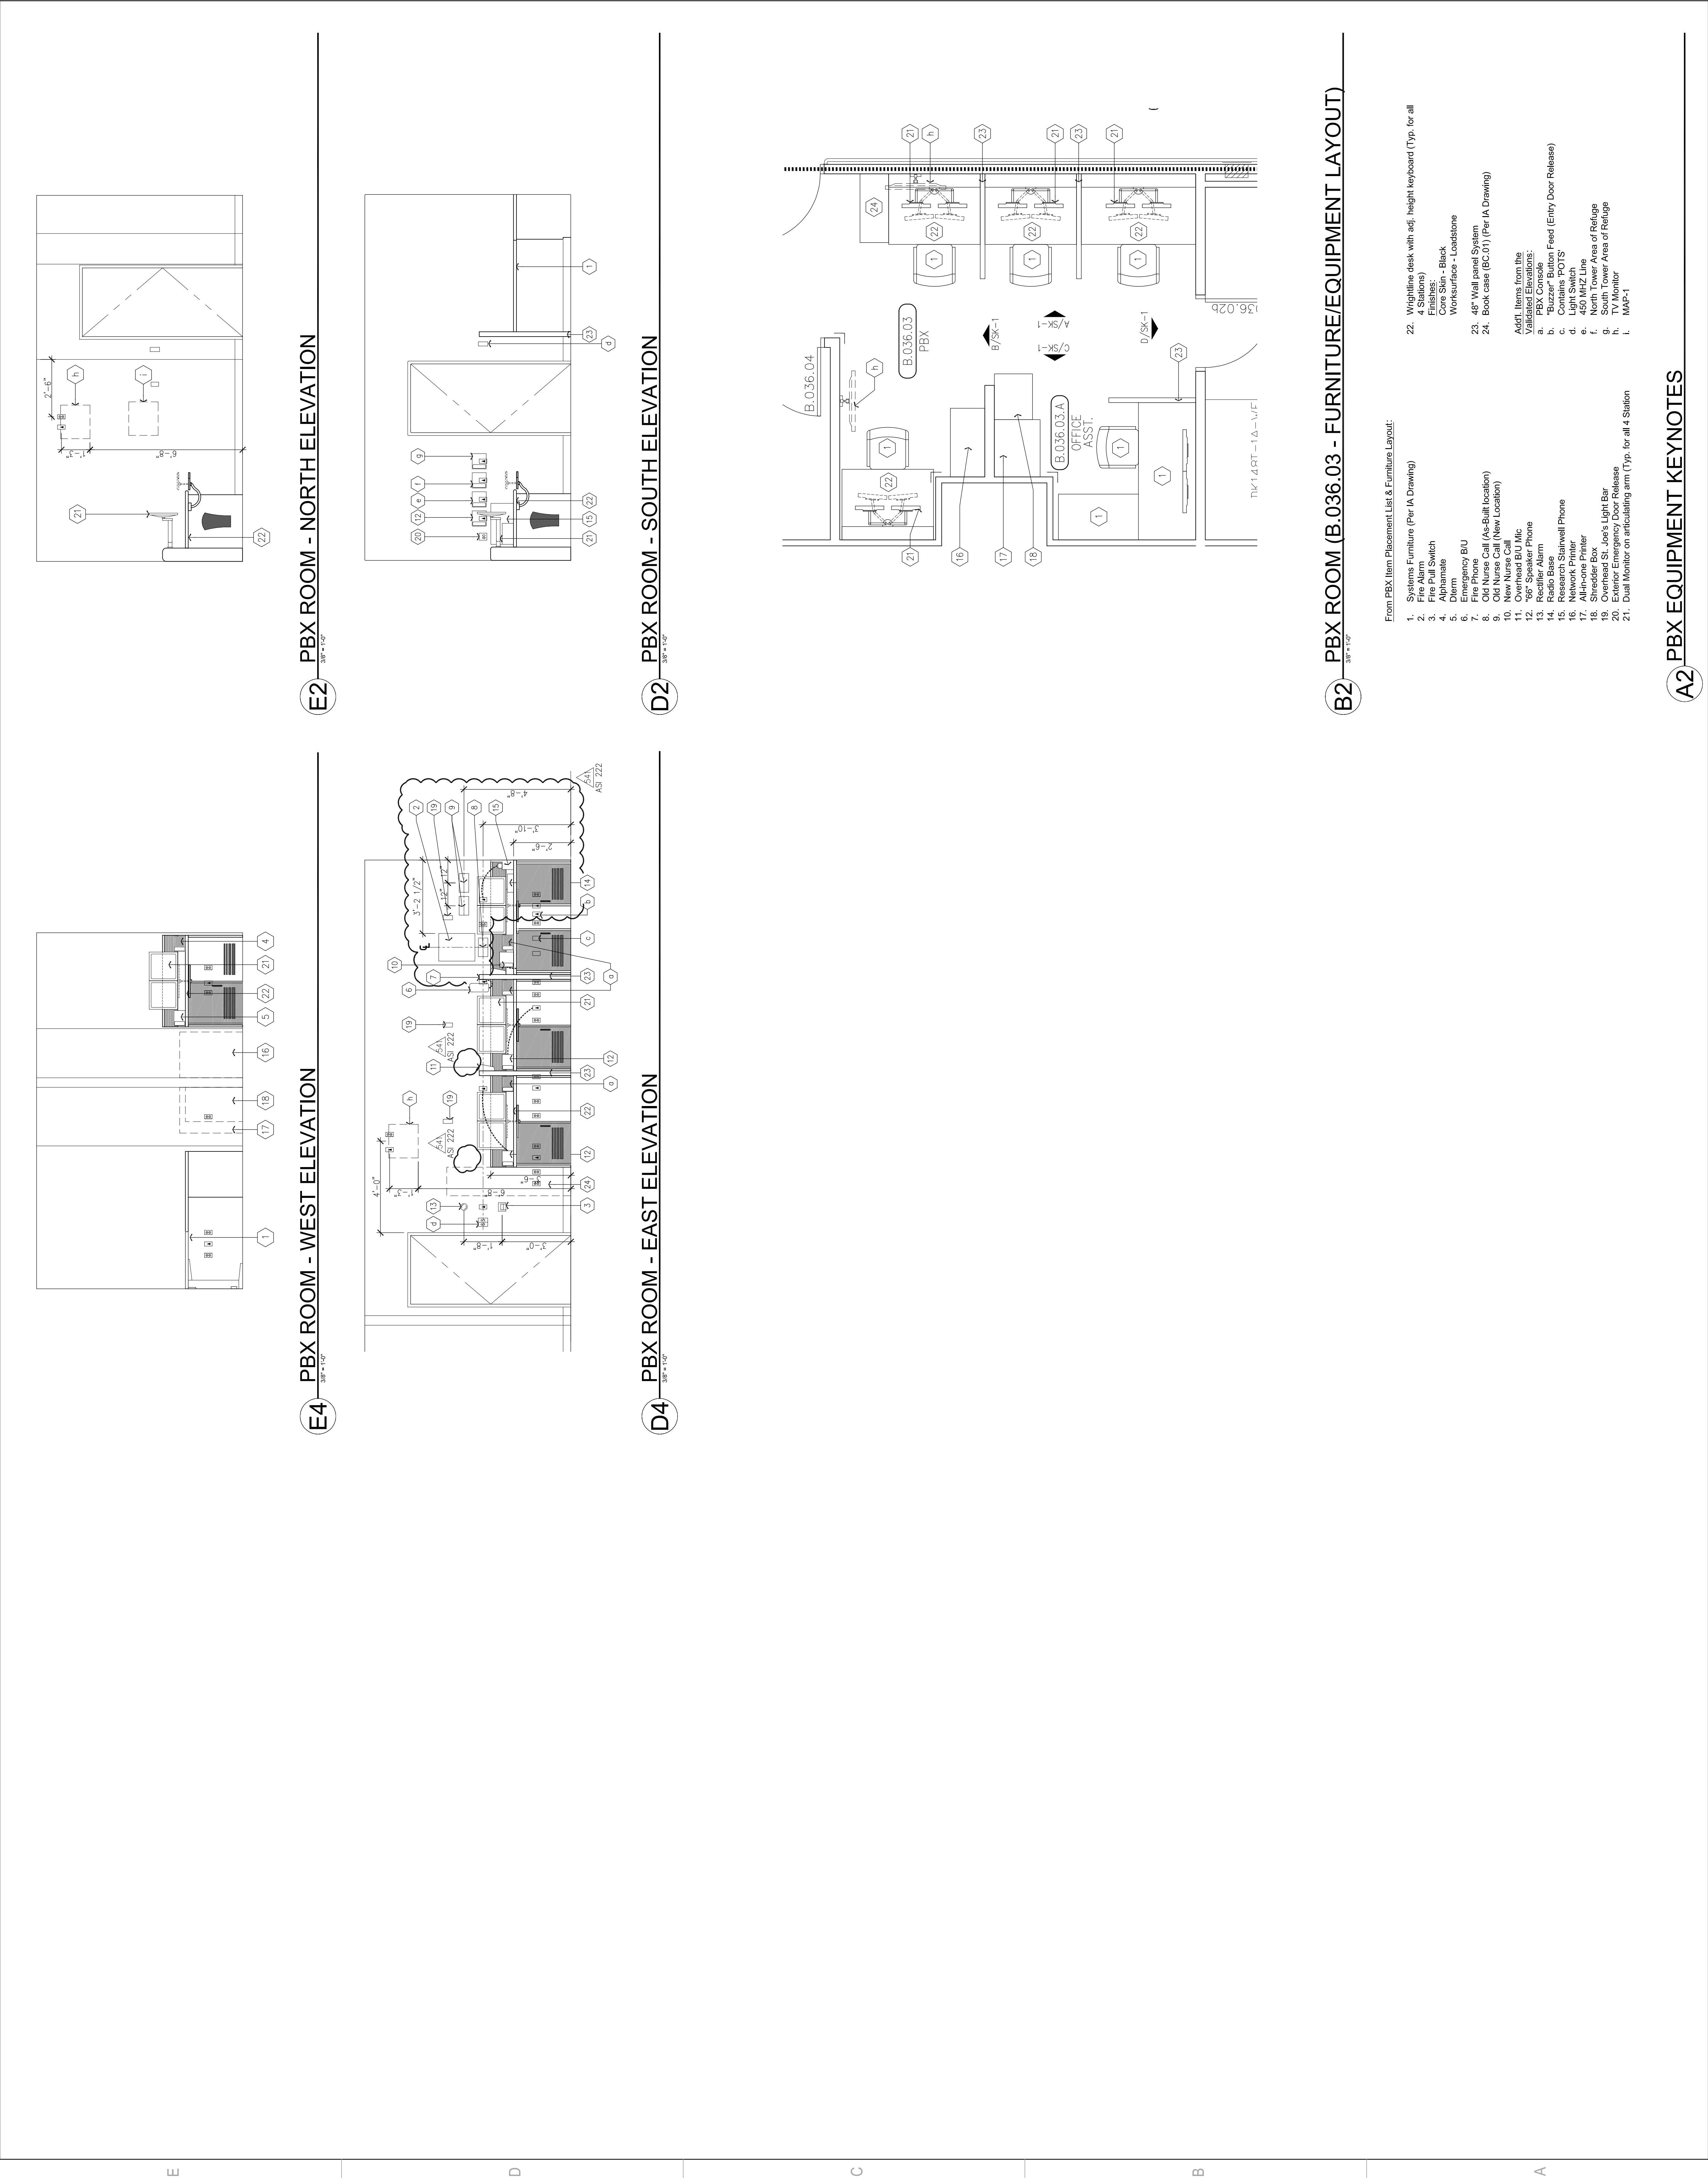

E2 PBX ROOM - NORTH ELEVATION
38'0" x 11'0"

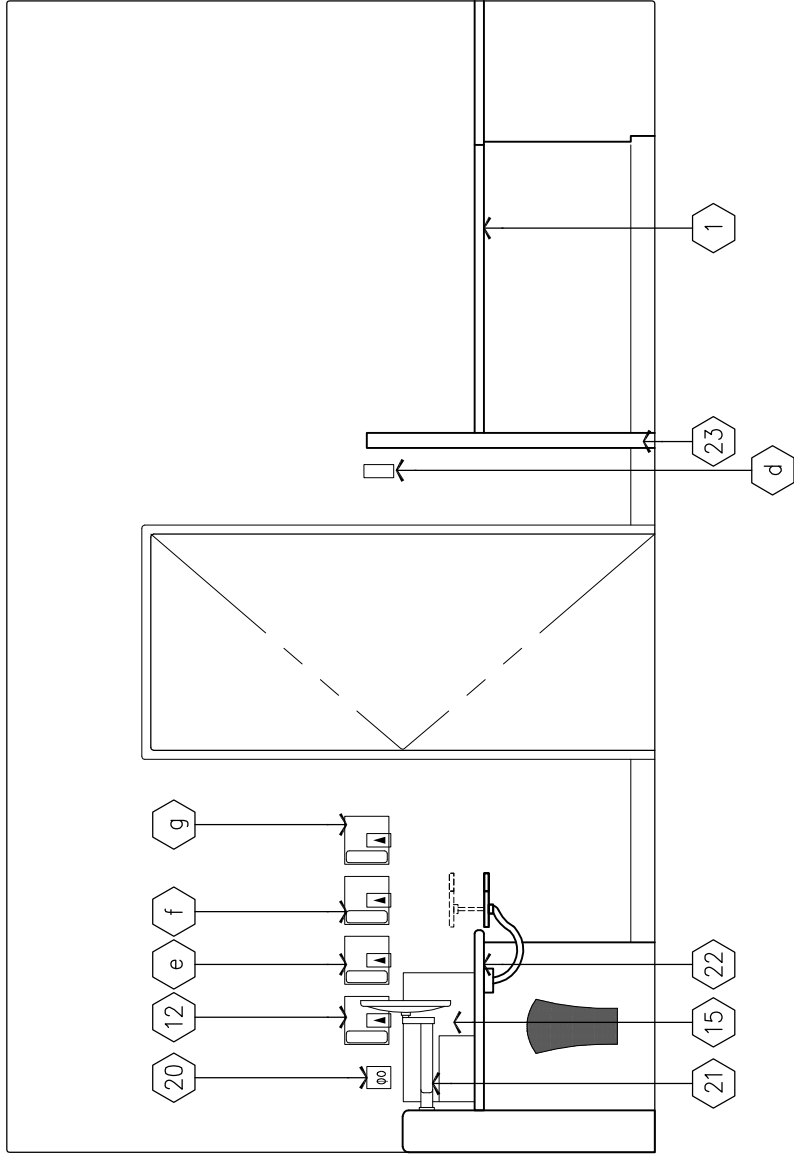

D2 PBX ROOM - SOUTH ELEVATION
38'0" x 11'0"

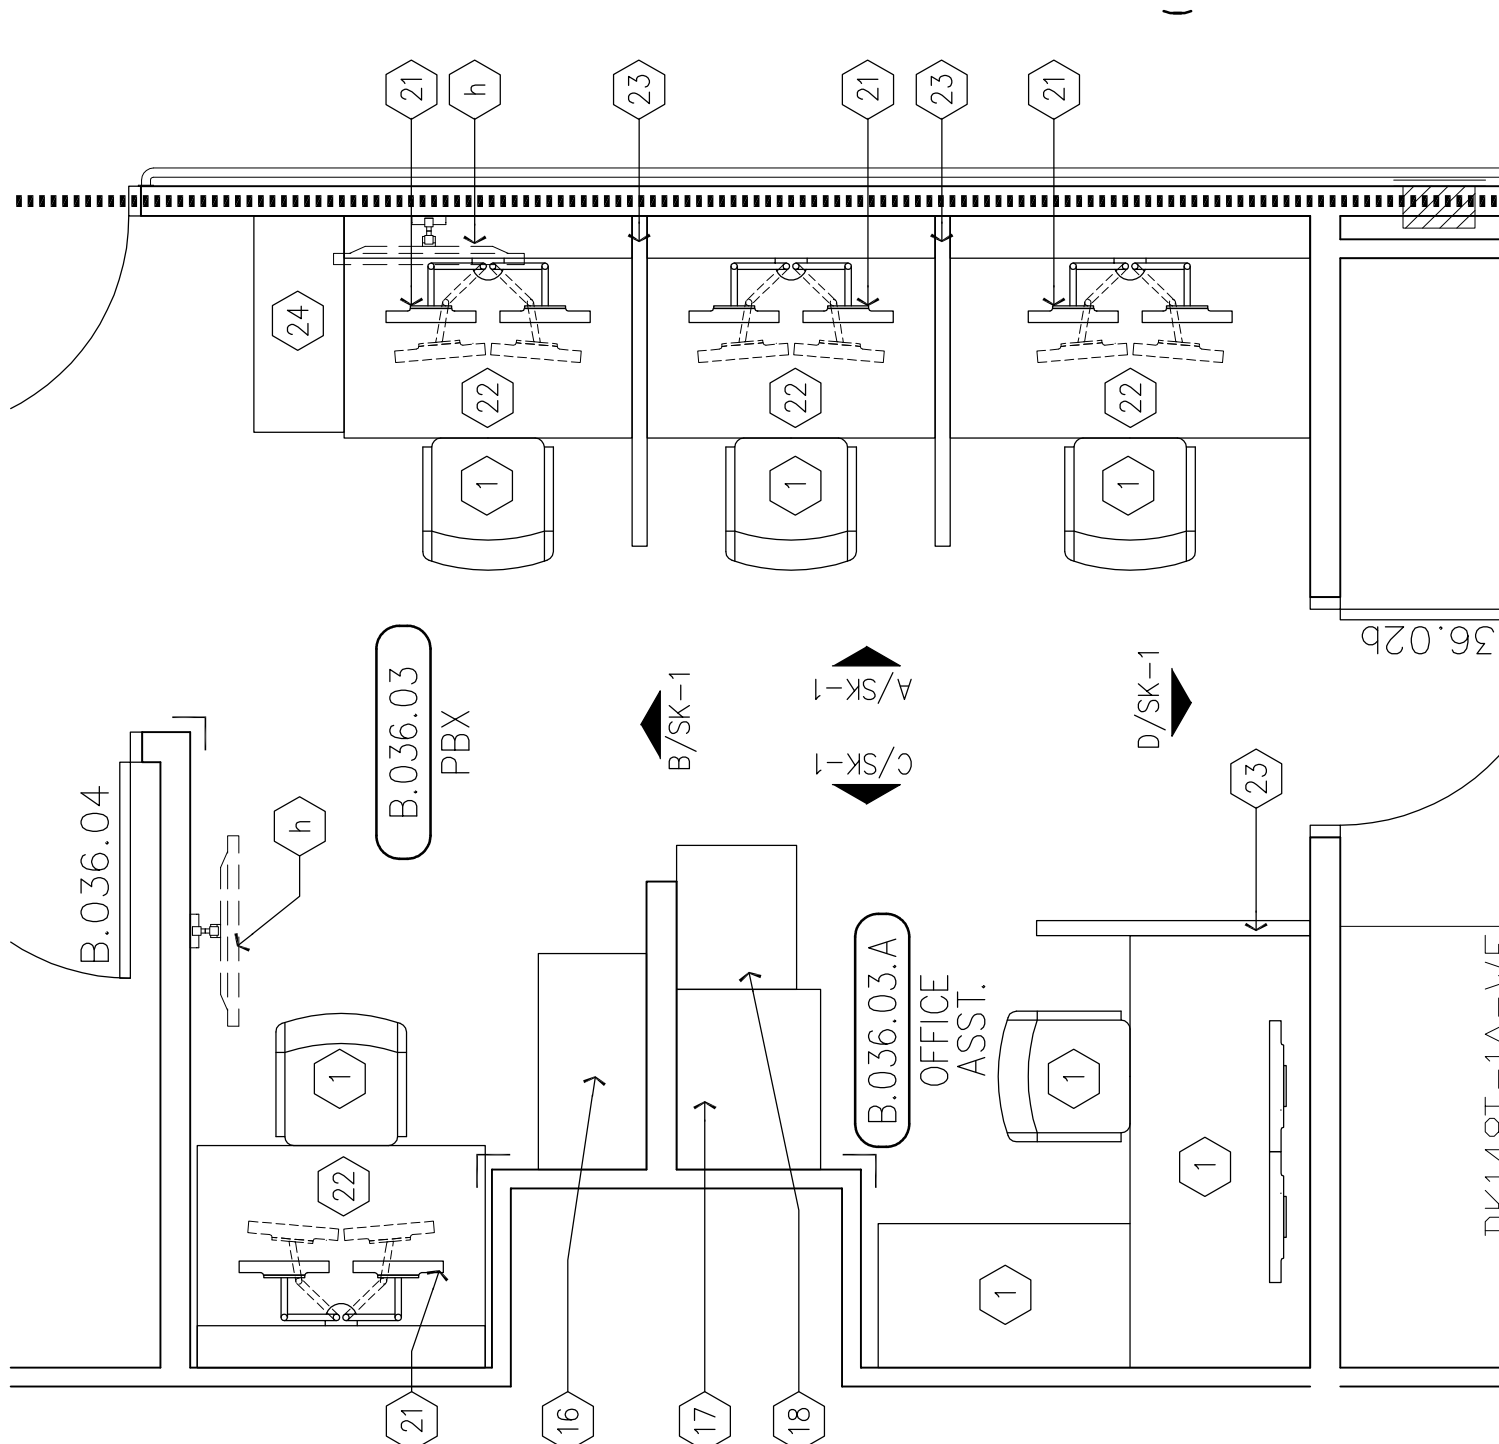


B2 PBX ROOM (B.036.03 - FURNITURE/EQUIPMENT LAYOUT)
38'0" x 11'0"

From PBX Item Placement List & Furniture Layout:

- 1. Systems Furniture (Per IA Drawing)
- 2. Fire Alarm Control Panel
- 3. Fire Pull Switch
- 4. Alphamale
- 5. Diem
- 6. Emergency BU
- 7. Fire Phone
- 8. Old Nurse Call (As-Built location)
- 9. Old Nurse Call (New Location)
- 10. New Nurse Call
- 11. 100' Speaker Phone
- 12. 100' Speaker Phone
- 13. Rectifier Alarm
- 14. Radio Base
- 15. Resonator Spinwell Phone
- 16. Resonator Spinwell Phone
- 17. All-in-one Printer
- 18. Shredder Box
- 19. Overhead St. Joe's Light Bar
- 20. 40" LCD Monitor
- 21. Dual Monitor on articulating arm (Typ. for all 4 Station)
- 22. Worklight desk with adj. height keyboard (Typ. for all 4 Stations)
- 23. Core Skin - Black
- 24. Worksurface - Loadstone
- 25. 48" Wall panel System
- 26. Book Case (BC.01) (Per IA Drawing)
- 27. Addtl. Items from the Validation Elevations:
 - a. PBX Console
 - b. "Buzzer" Button Feed (Entry Door Release)
 - c. Console POTS
 - d. Console Skin
 - e. 450 MHz Line
 - f. North Tower Area of Refuge
 - g. South Tower Area of Refuge
 - h. 40" LCD Monitor
 - i. MAP-1

A2 PBX EQUIPMENT KEYNOTES

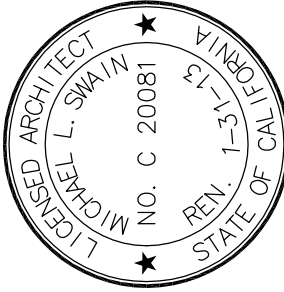

Changes on these drawings do not constitute an approval of the drawings. The drawings are to be used as a guide only. The drawings are to be used as a guide only. The drawings are to be used as a guide only.

REVISIONS	DATE	BY	APP'D
43	04/23/12	CO #857	
44	06/07/12	ASI #222	

APPROVAL
Office of Statewide Health
INSTRUCTION BULLETIN
THE ADDRESS OF 124 CCR
(ADDITION)

CHANGE ORDER
INSTRUCTION BULLETIN
THE ADDRESS OF 124 CCR
(ADDITION)

PROJECT NAME
CHILDREN'S HOSPITAL
OF ORANGE COUNTY
455 S. Main St.
Orange, CA 92668-3874

TOWER II



PROJECT NUMBER
12011.00
Increment #7
OSHPD - PROJECT NUMBER
IL 072072-30

ISSUE
OSHPD PERMIT
DATE
01/27/2010
SCALE
3/8" = 1'-0"

DRAWING TITLE
LOWER LEVEL PBX
OPERATORS' ROOM