

ARCHITECT OF RECORD

ARCHITECT - PAUL C. GLORIO

CONSULTANT

- STRUCTURAL
- MECHANICAL
- ELECTRICAL
- CIVIL

REVISIONS

APPROVAL: _____

JAN 28 2011

Office of Statewide Health
Planning & Development
FACILITIES DEVELOPMENT DIVISION

PROJECT NAME

455 S. Main St.
Orange, CA 92668-3874

TOWER II



PROJECT NUMBER

12011.00
Increment #7

OSHPD - PROJECT NUMBER
IL 072072-30

ISSUE

OSHPD PERMIT

DATE _____

01/27/2010

SCALE




$$1'' = 20' - 0''$$

DRAWING TITLE

PENTHOUSE 2 COMPOSITE MECHANICAL PLAN

DRAWING NUMBER

M1.90

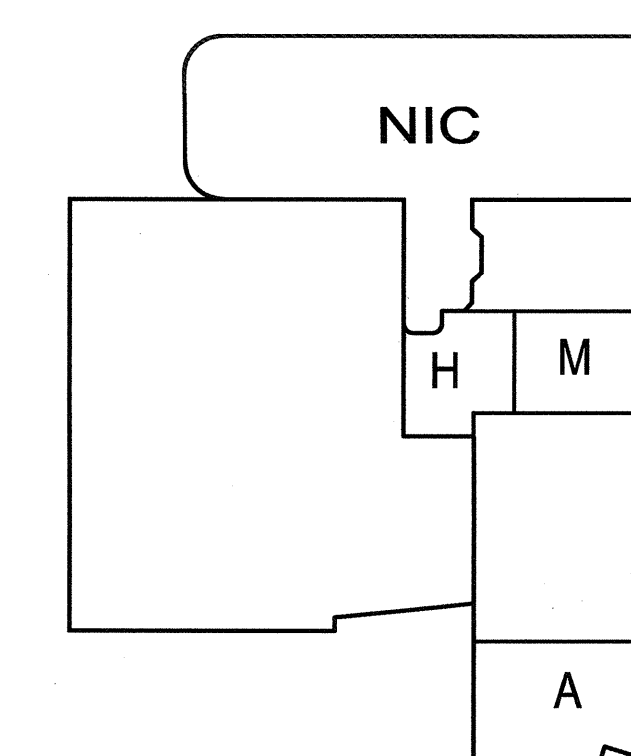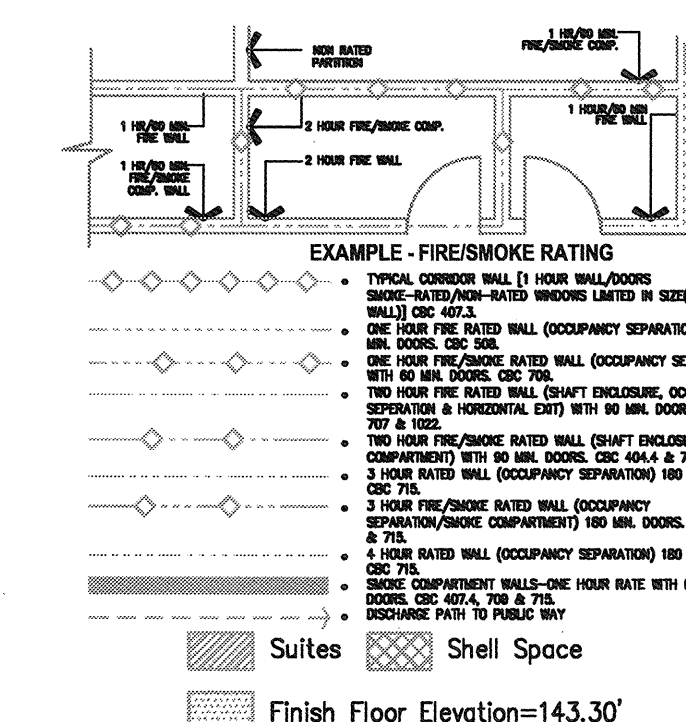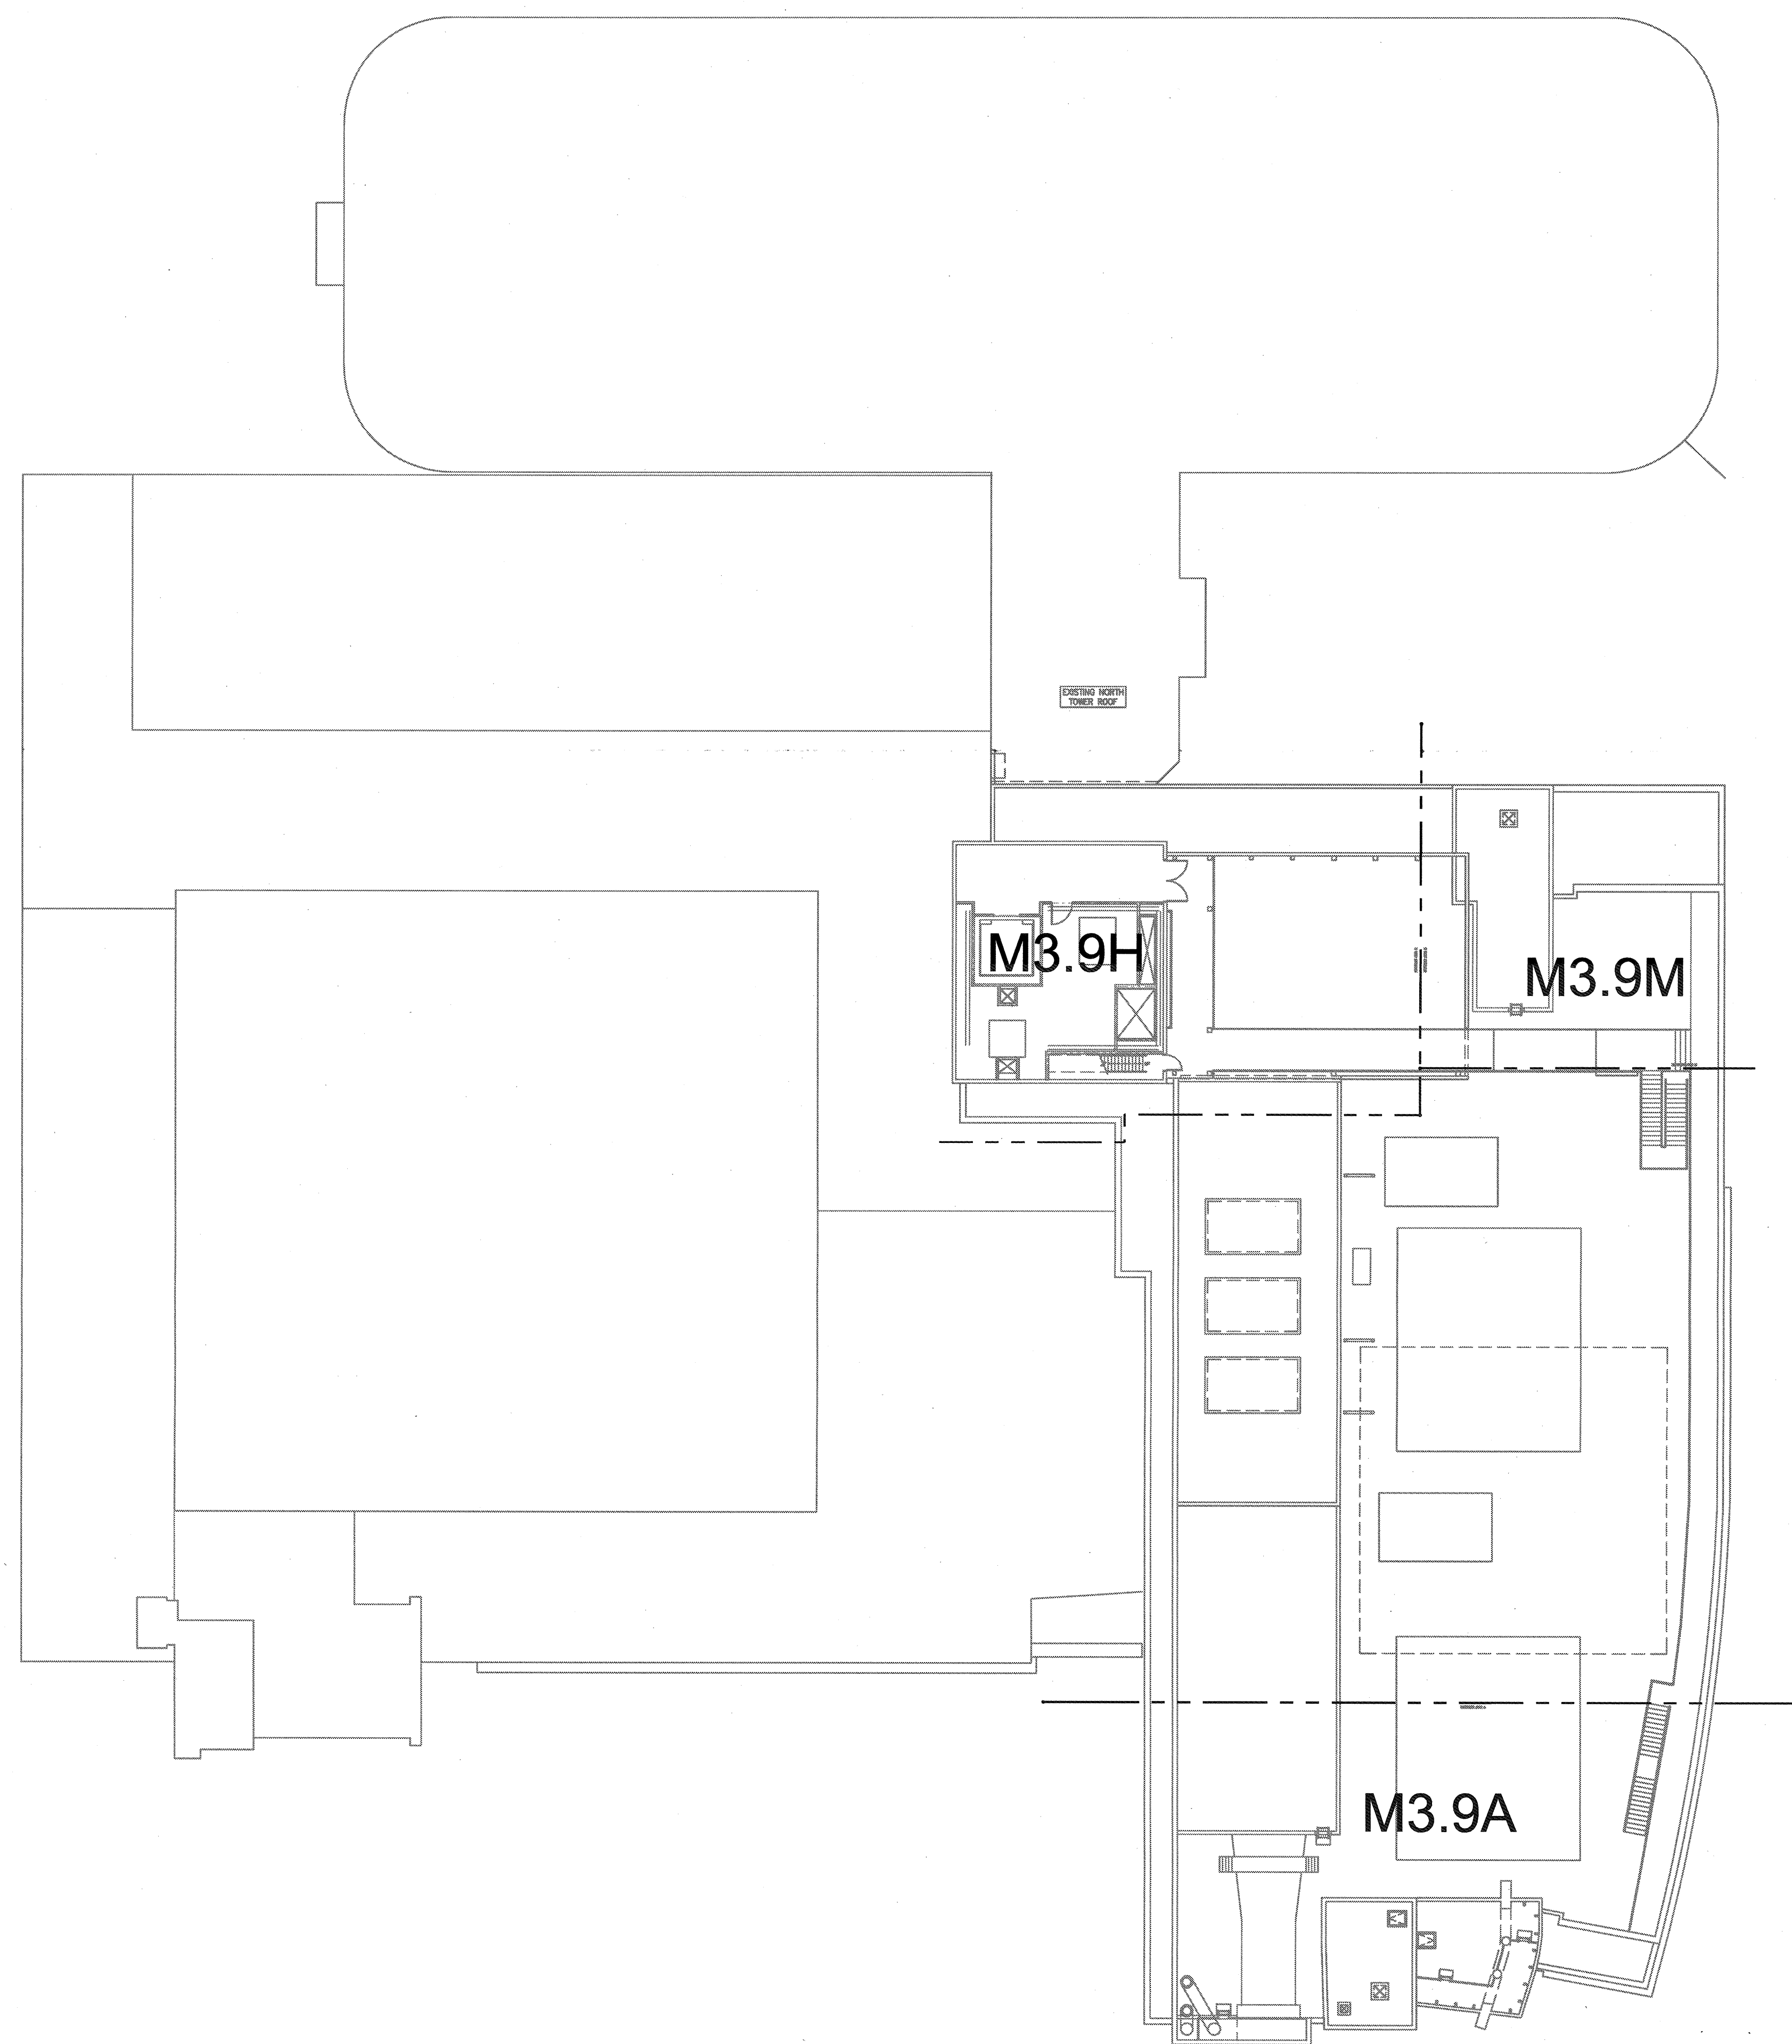

A1 Key Plan