

ARCHITECT - PAUL C. GLORIOT

CONSULTANT

T M A D
TAYLOR
& GAINES

- STRUCTURAL
- MECHANICAL
- ELECTRICAL
- CIVIL

100 South Anaheim Boulevard, Suite 150
Anaheim, California 92805
Phone: 714.490.5555 Fax: 714.490.5560
Project No. 2305-163-07




Changes on these drawings do not consist of
materially altered changes to approved drawing
and don't require a change order.

OSHPD review ACO _____
OSHPD review FLSO _____
OSHPD review DSE _____

REVISIONS

238	04/06/2011	CHANGE ORDER #18
537	06/11/2012	CHANGE ORDER #375

APPROVAL: _____

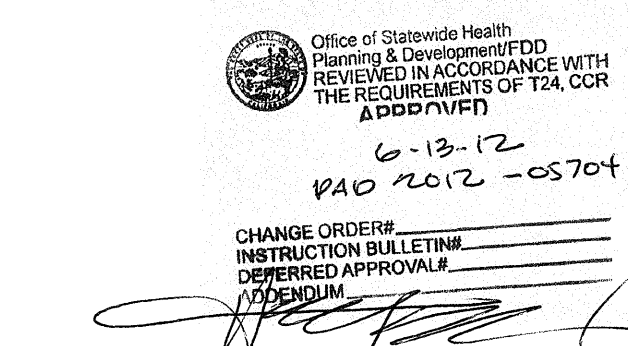

PROJECT NAME

**CHILDREN'S HOSPITAL
OF ORANGE COUNTY**
455 S. Main St.
Orange, CA 92868-3874

TOWER II



PROJECT NUMBER

12011.00
Increment #7
OSHPD - PROJECT NUMBER
IL 072072-30

 
ISSUE _____
OSHPD PERMIT
DATE _____
01/27/2010
SCALE _____

DRAWING TITLE

MECHANICAL DETAILS -
HVAC EQUIPMENT -
ANCHORAGE DETAILS


DRAWING NUMBER

M10.02




(SF-E-1)SEPARATOR FILTER ANCHORAGE DETAIL

SCALE	5
NONE	

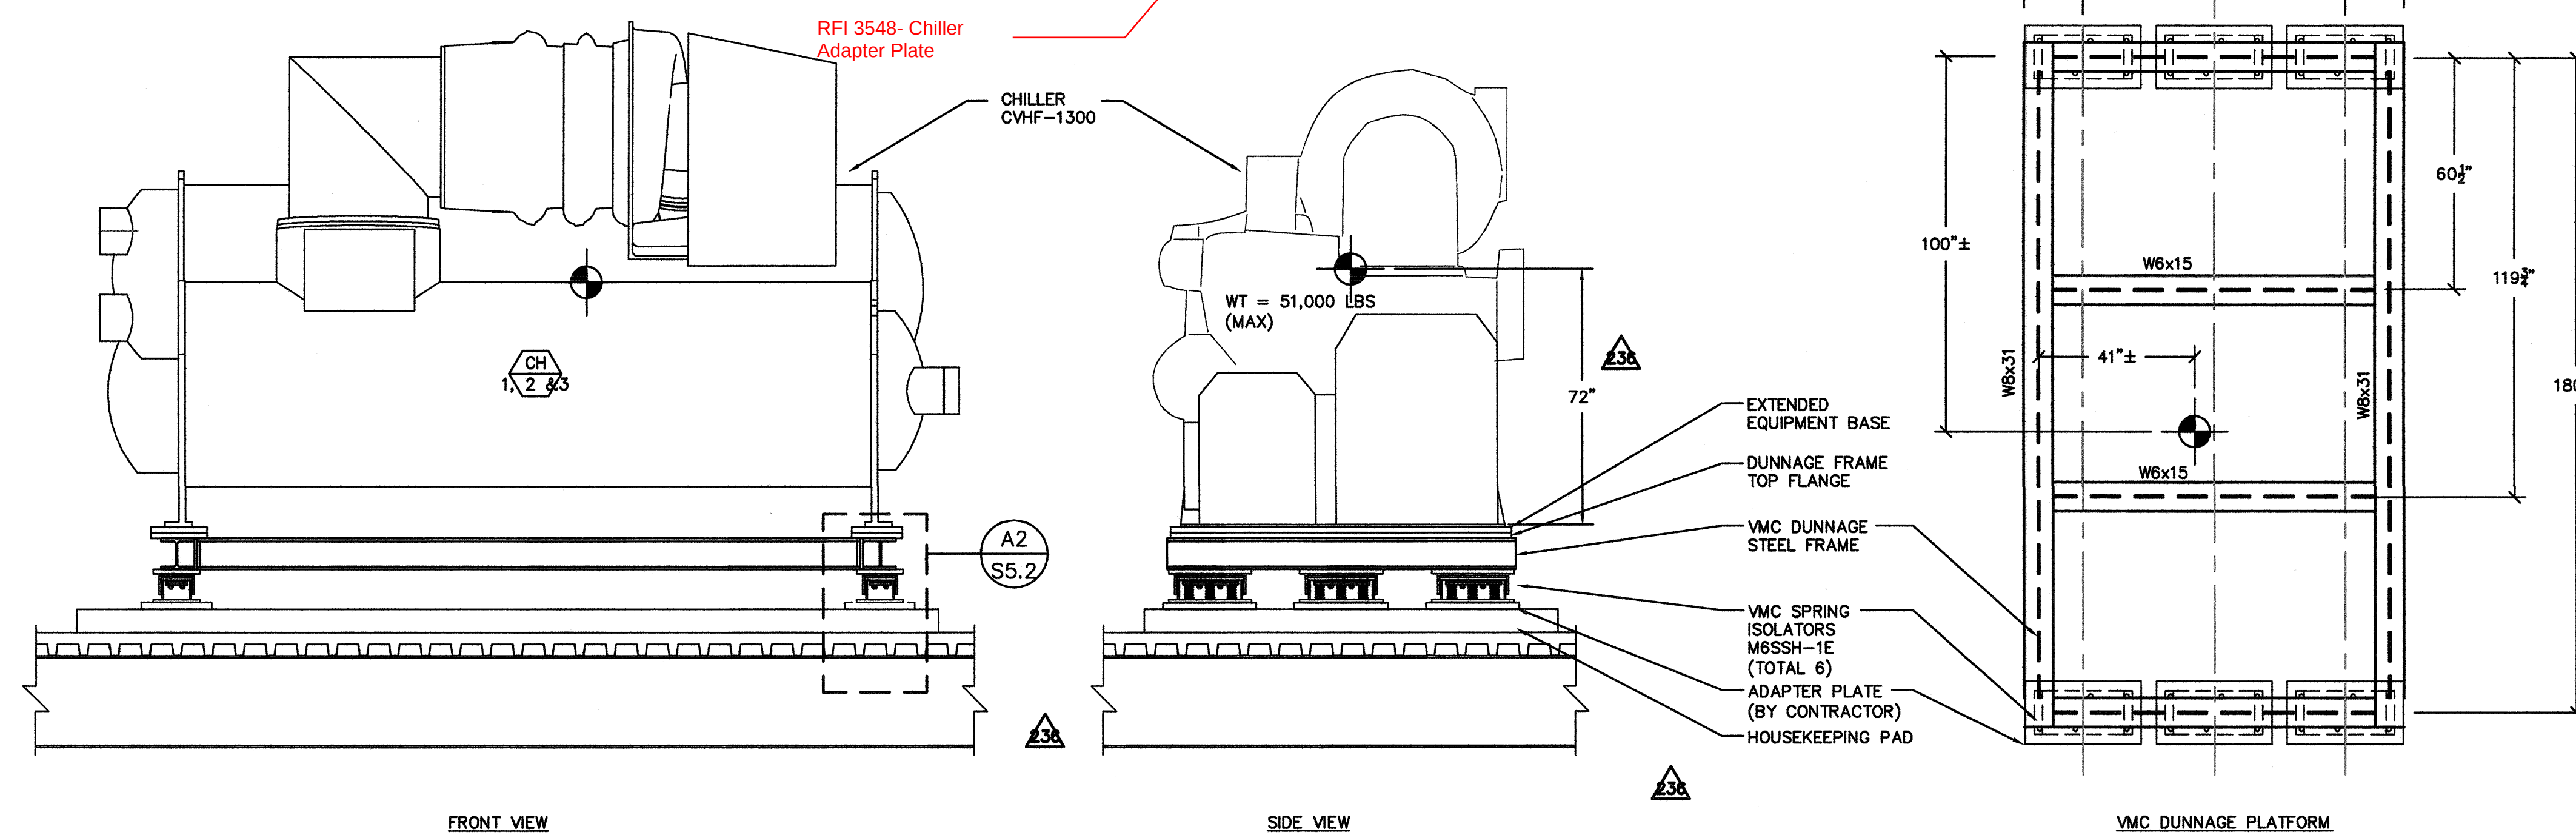


(CH-1, 2 & 3) CHILLER ANCHOR DETAIL

	SCALE	
	NONE	

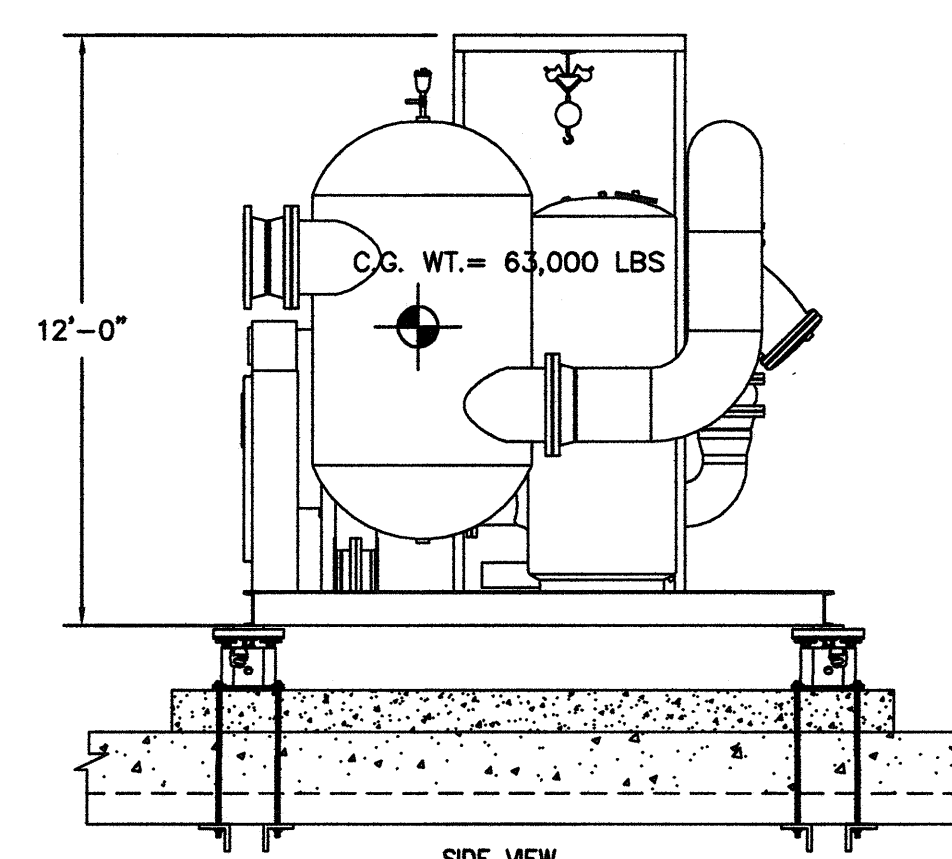


CHILLED WATER PUMP PACKAGE ANCHORAGE DETAIL (CHWP-1,2,3, AND 4)

SCALE	3
NONE	

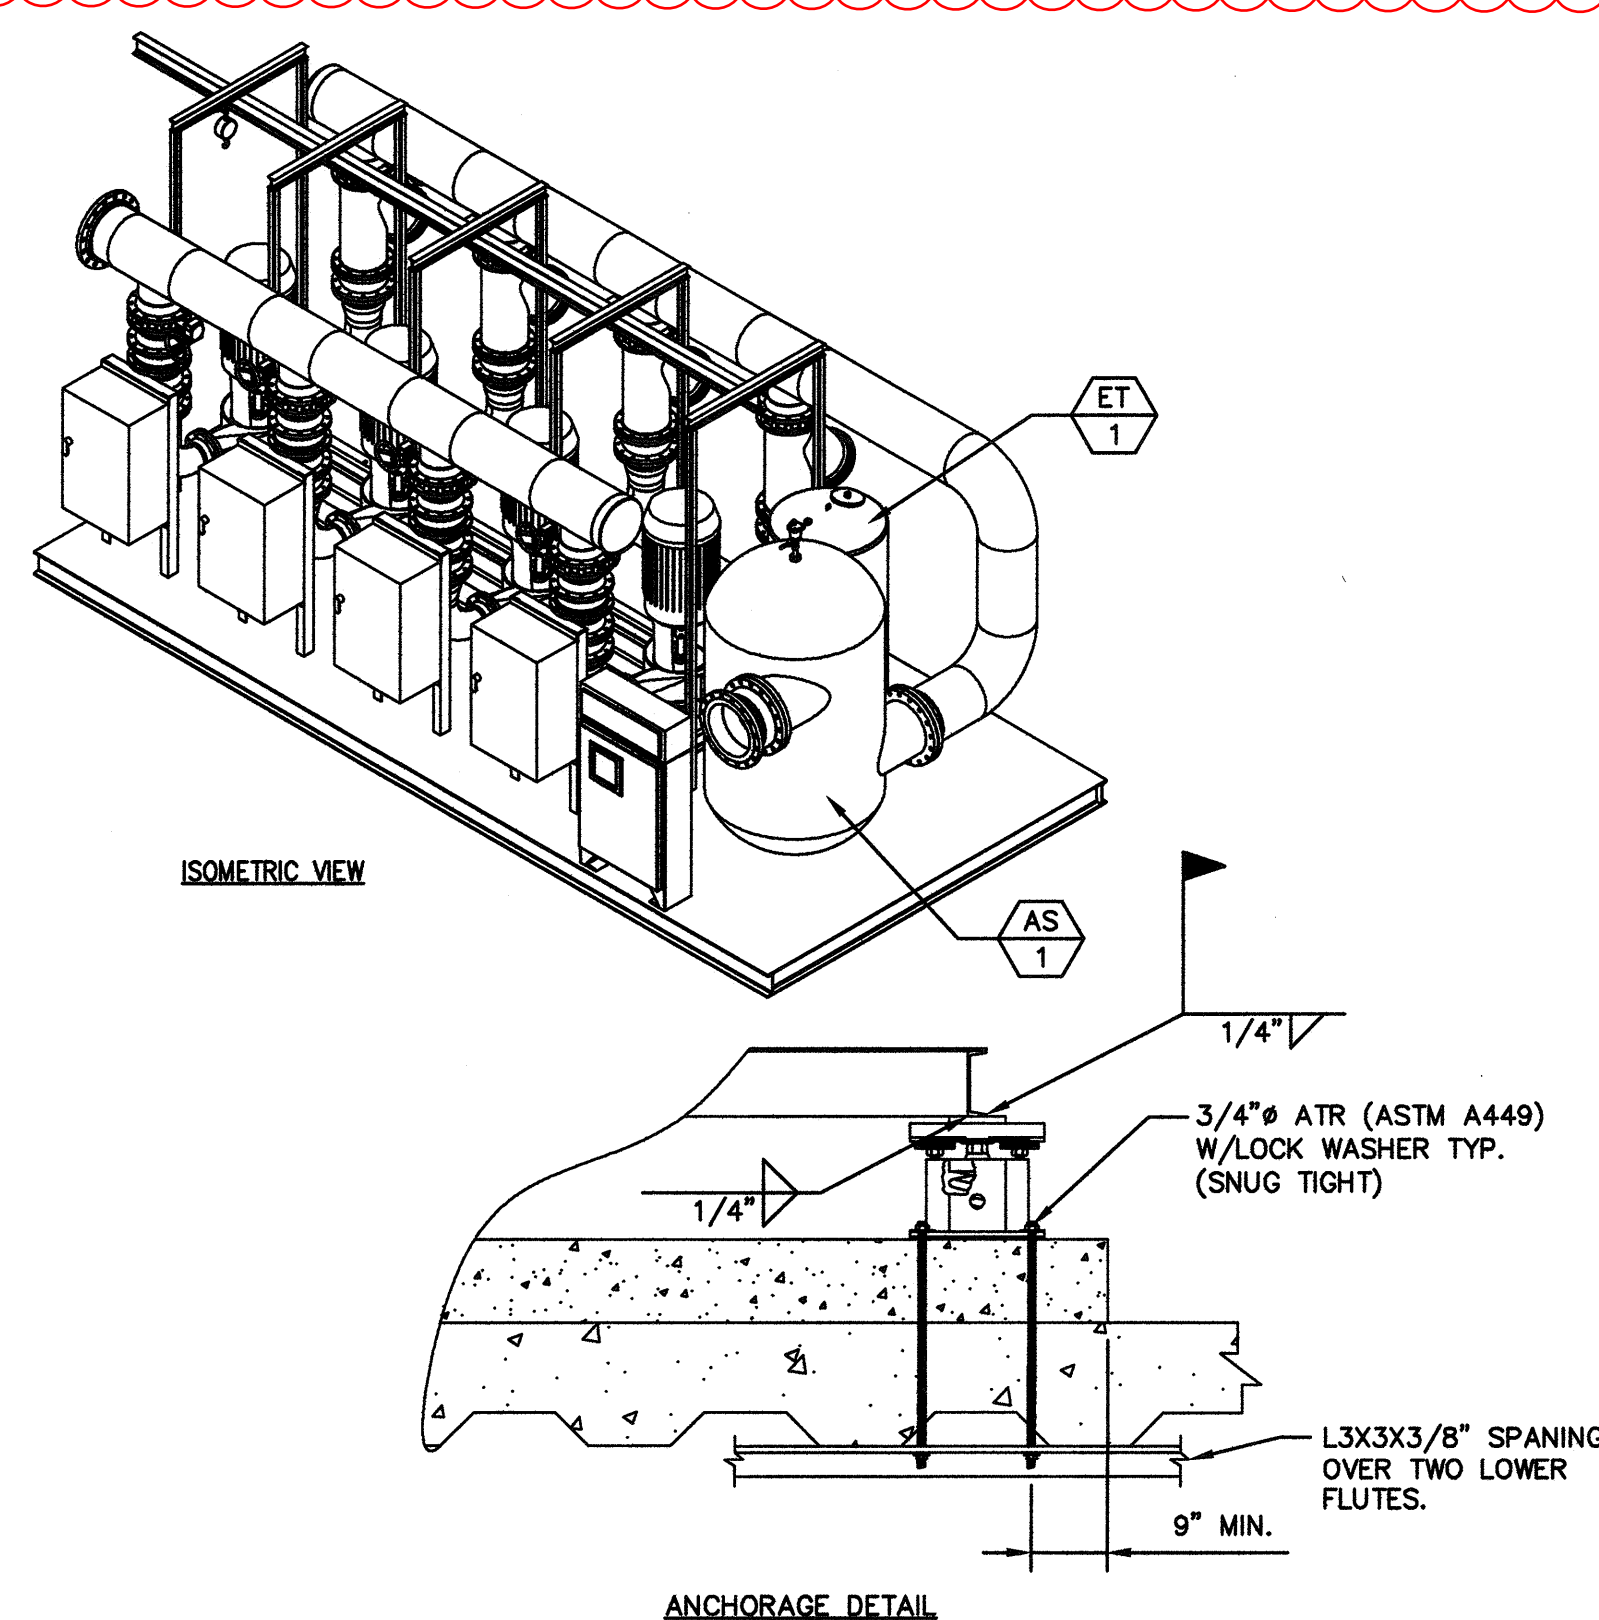


ISOMETRIC VIEW

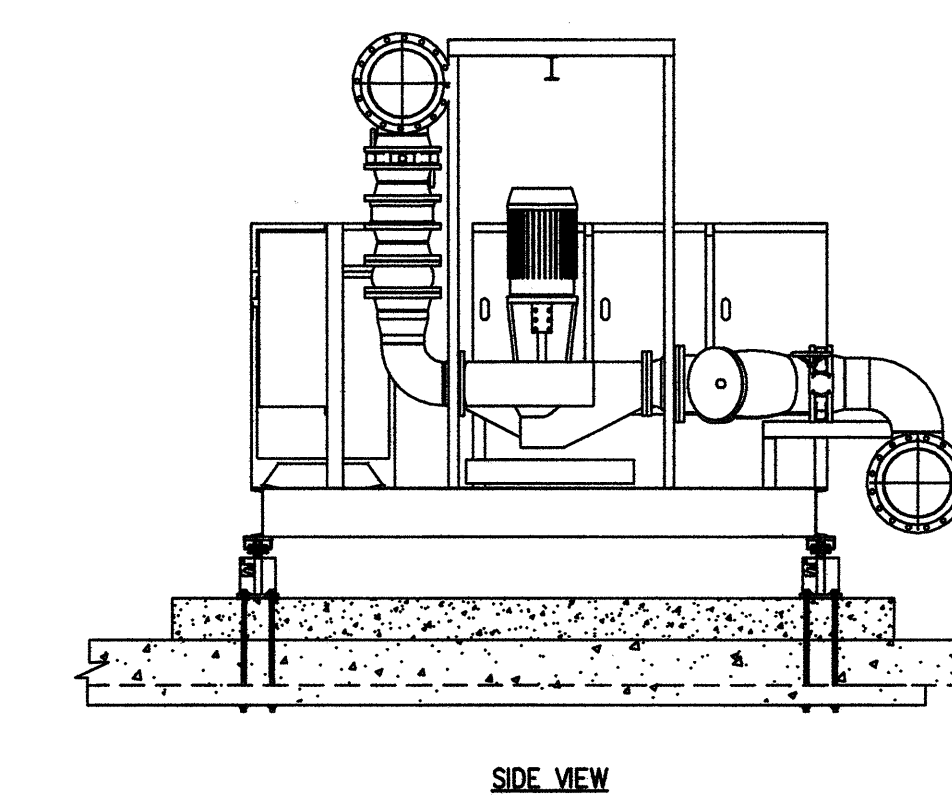


CONDENSER WATER PUMP PACKAGE ANCHORAGE DETAIL (CWP-123, AND 4)

SCALE	4
NONE	

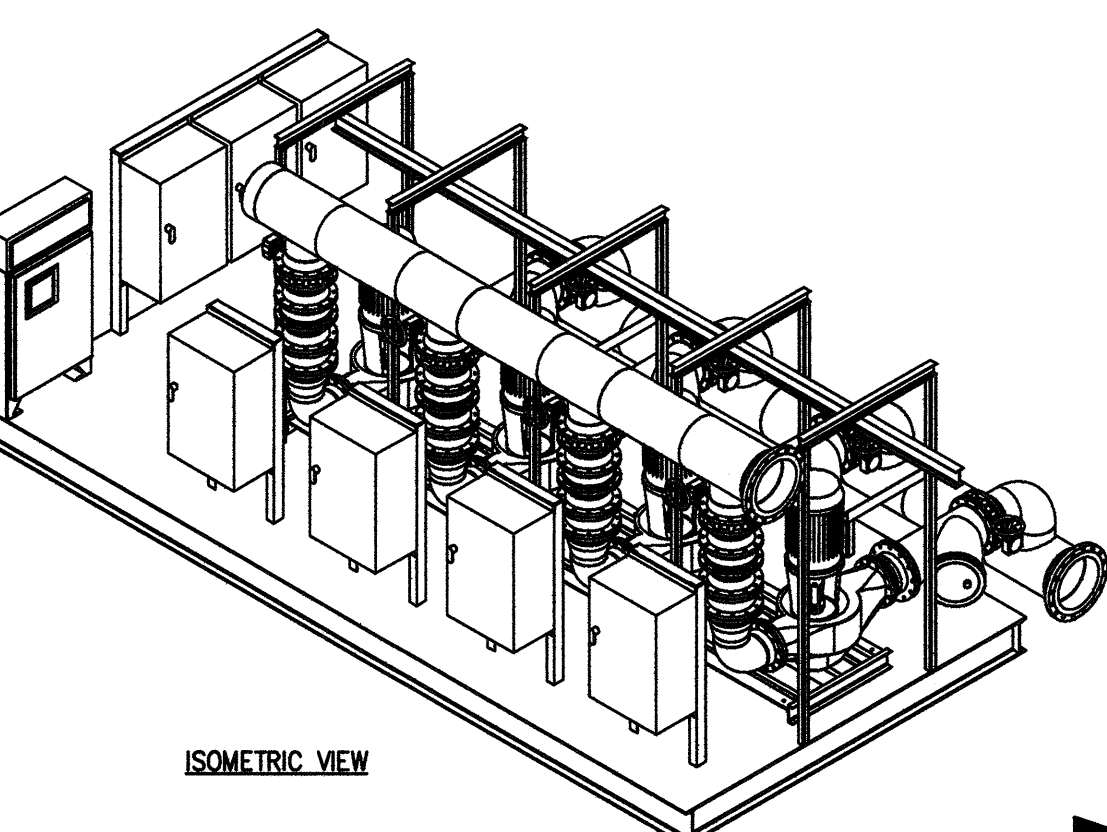

ISOMETRIC VIEW

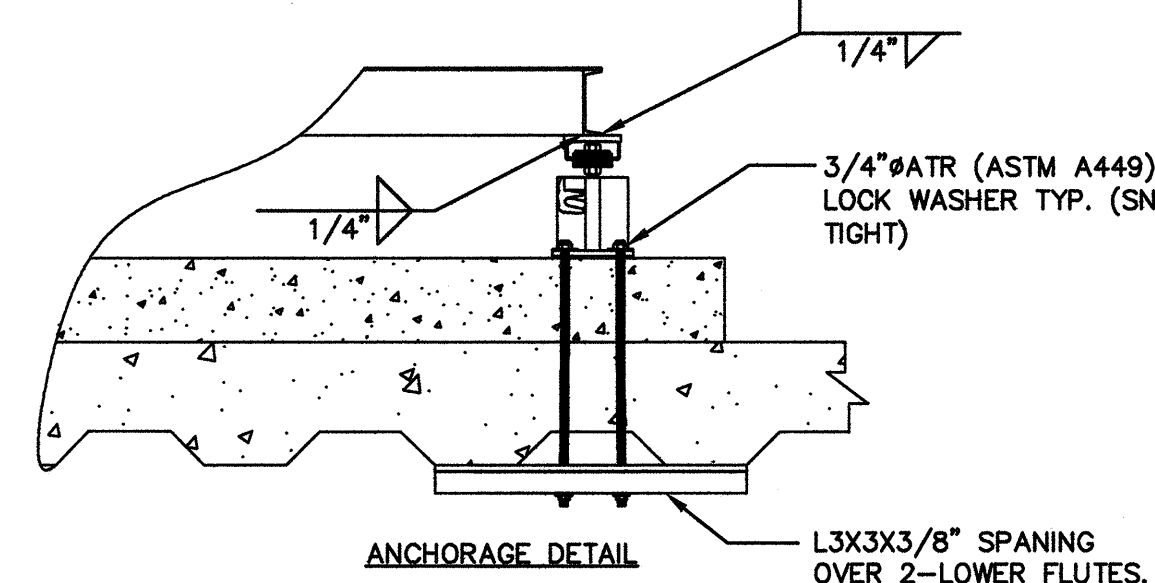

ANCHORAGE DETAIL L3X3X3/8" SPANING
OVER 2-LOWER FLUTES.

COOLING TOWER ANCHOR DETAIL

SCALE	
NONE	

REI 517

M10.02