

FKP Architects

ARCHITECT OF RECORD

*Architect of Record signature line only; this drawing was not prepared under the direct supervision of the Architect of Record. The direct responsibility for preparation of this sheet lies with its corresponding professional stamp and signature. The signature of the Architect of Record in general responsible for the project is provided as required by Title 24, Part 9, Section 7-115 (a).

ARCHITECT - PAUL C. GLORIOD

CONSULTANT

TAYLOR & GAINES

100 South Anaheim Boulevard, Suite 150
Anaheim, California 92805
Phone: 714.490.5555 Fax: 714.490.5560
Project No. 2305-163-07



Changes on these drawings do not consist of materially altered charges to approved drawings and don't require a change order.
OSHPD review ACO
OSHPD review FLSO
OSHPD review DSE

REVISIONS

09/21/2011 CHANGE ORDER #278

APPROVAL



CHANGE ORDER #278
INSTRUCTION BULLETIN
UNREVIEWED APPROVAL
(DO NOT USE)

PROJECT NAME

CHILDREN'S HOSPITAL
OF ORANGE COUNTY

455 S. Main St.
Orange, CA 92668-3874

RECEIVED
TOWER II September 21 2011
McCarthy



PROJECT NUMBER

12011.00
Increment #7

OSHPD - PROJECT NUMBER

IL 072072-30

ISSUE

OSHPD PERMIT

DATE

01/27/2010


SCALE

DRAWING TITLE

MECHANICAL DETAILS -
HVAC EQUIPMENT -
ANCHORAGE DETAILS


DRAWING NUMBER

M10.04

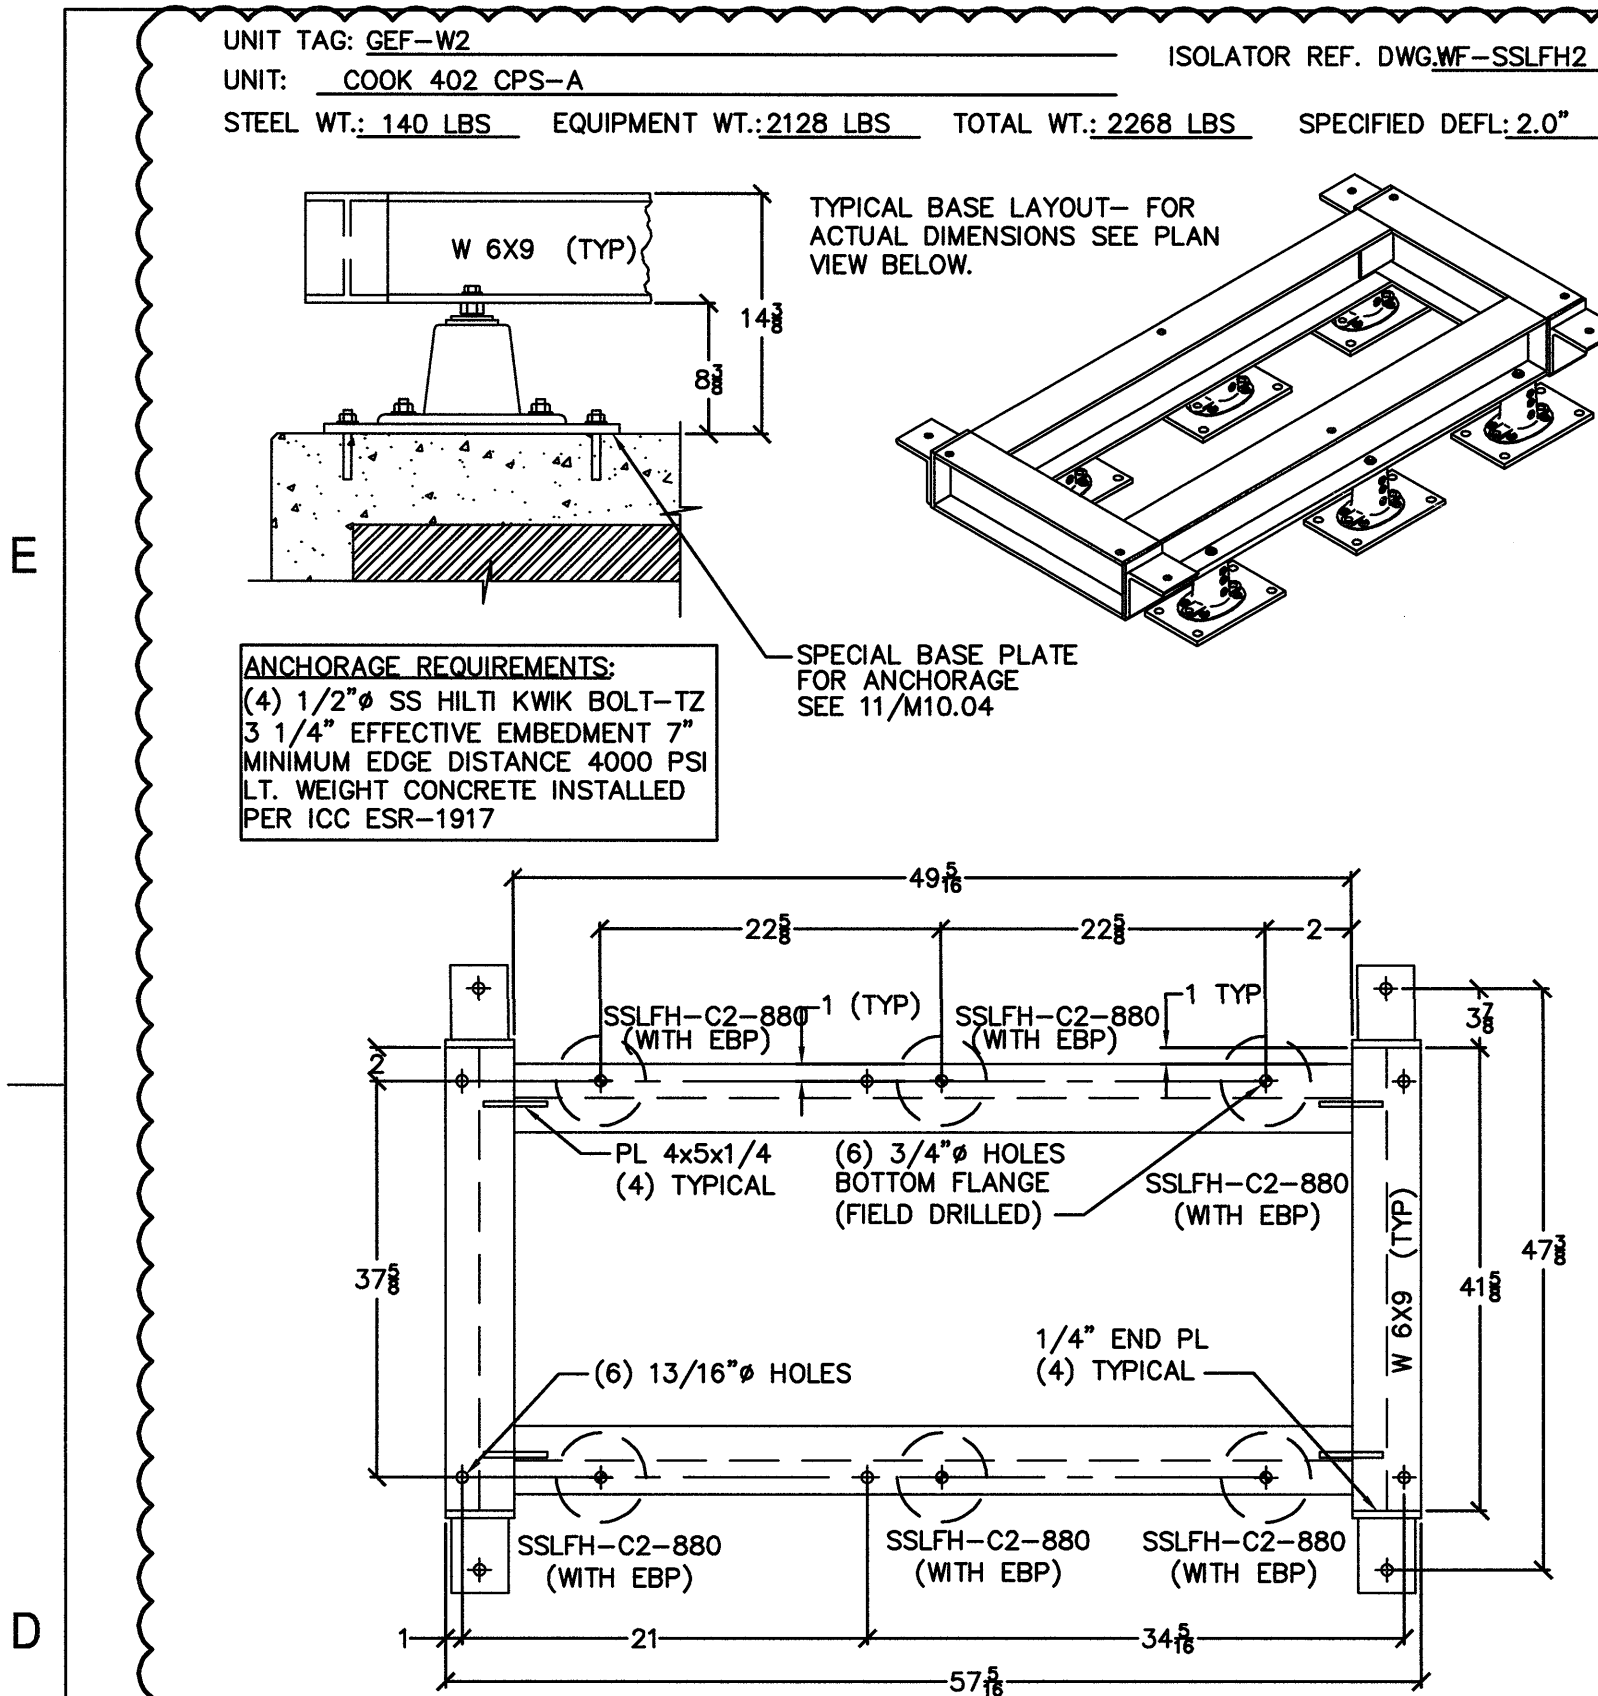


ANCHORAGE DETAIL

SCALE NONE

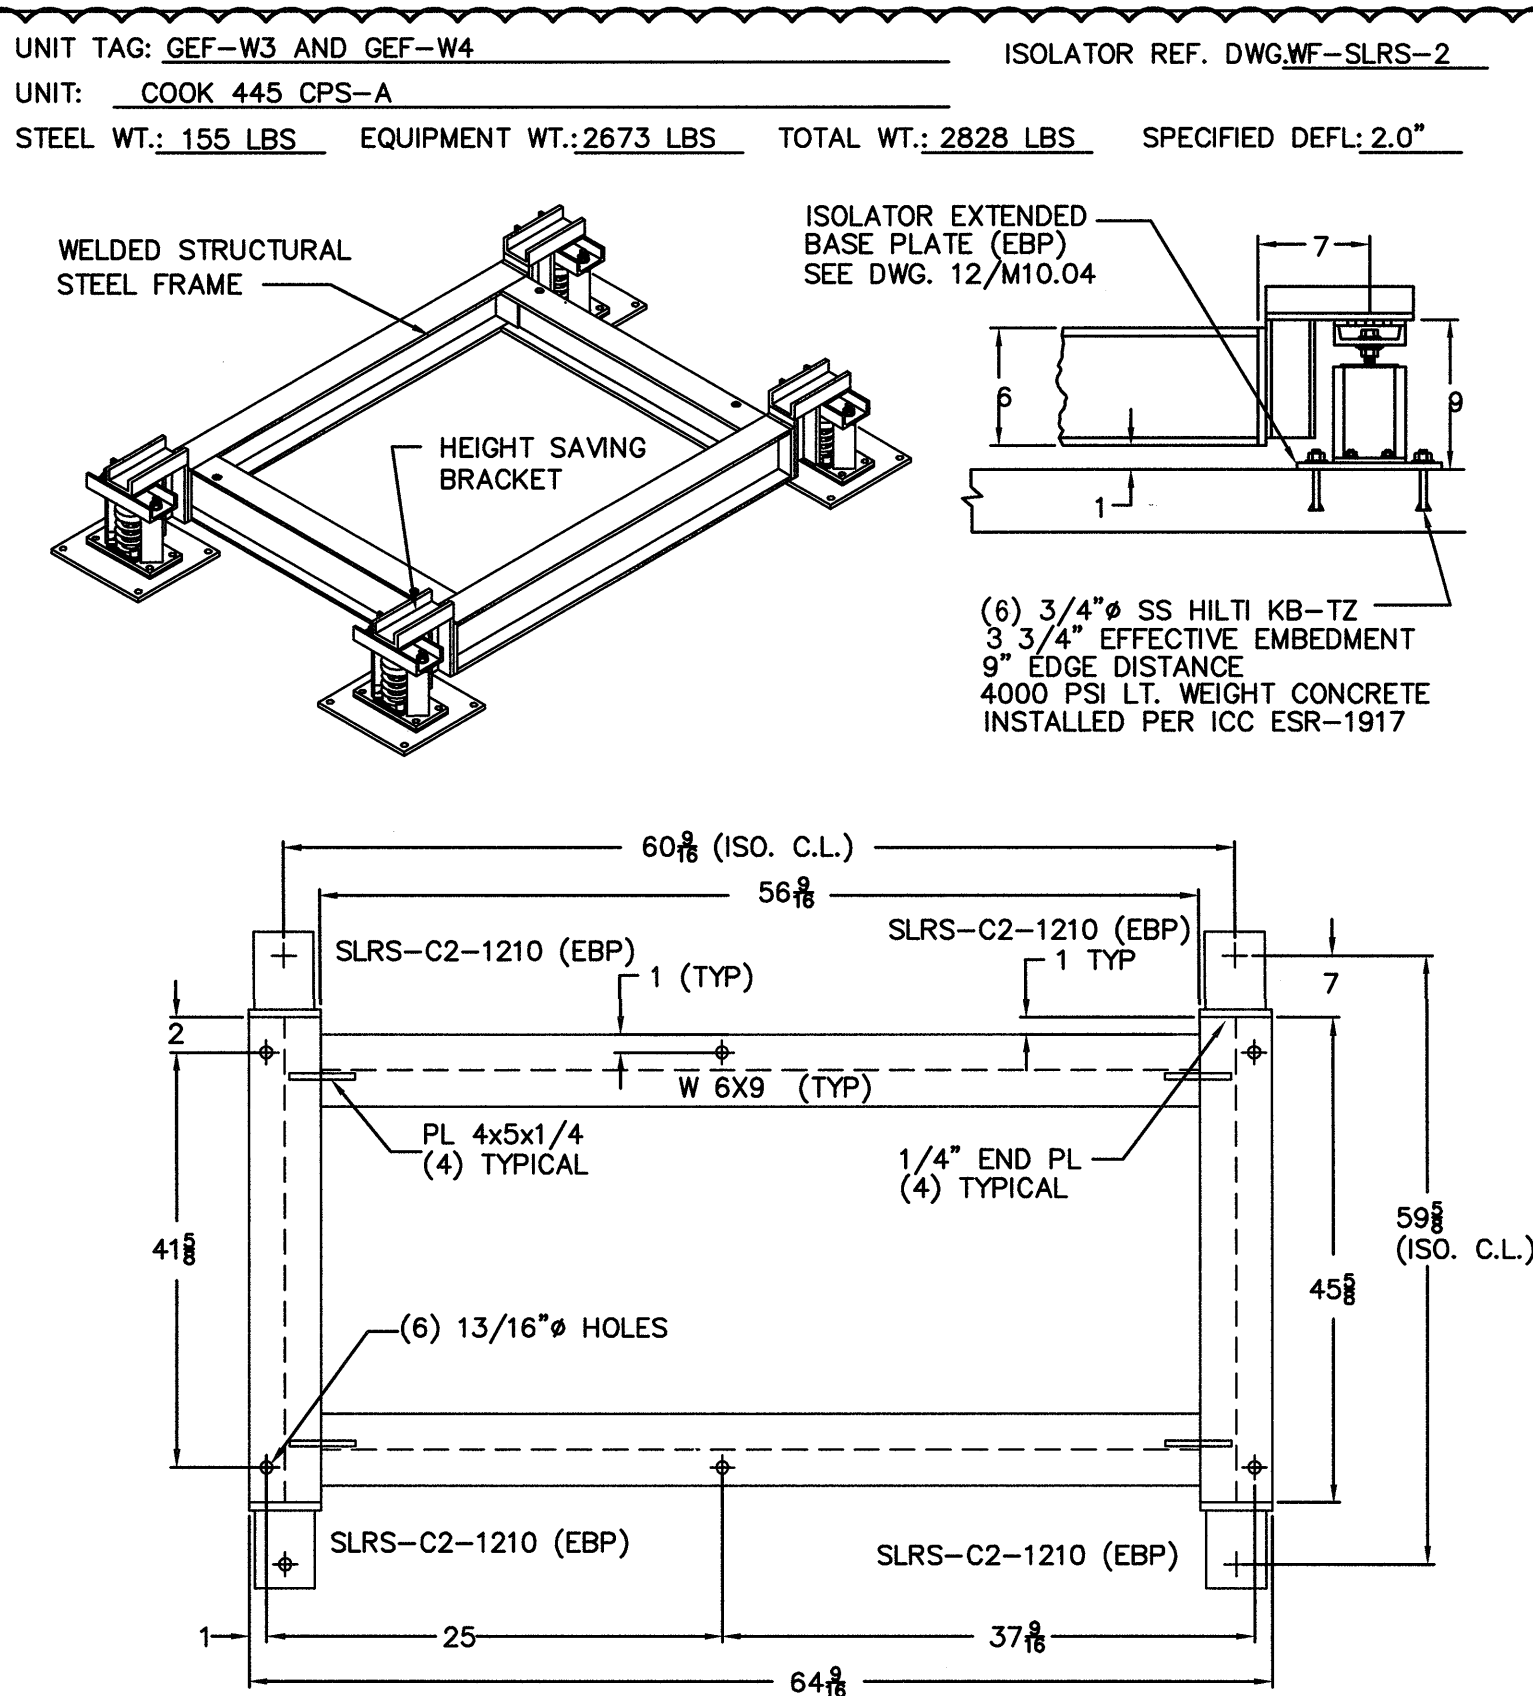


EXHAUST FAN ANCHORAGE DETAIL

SCALE NONE

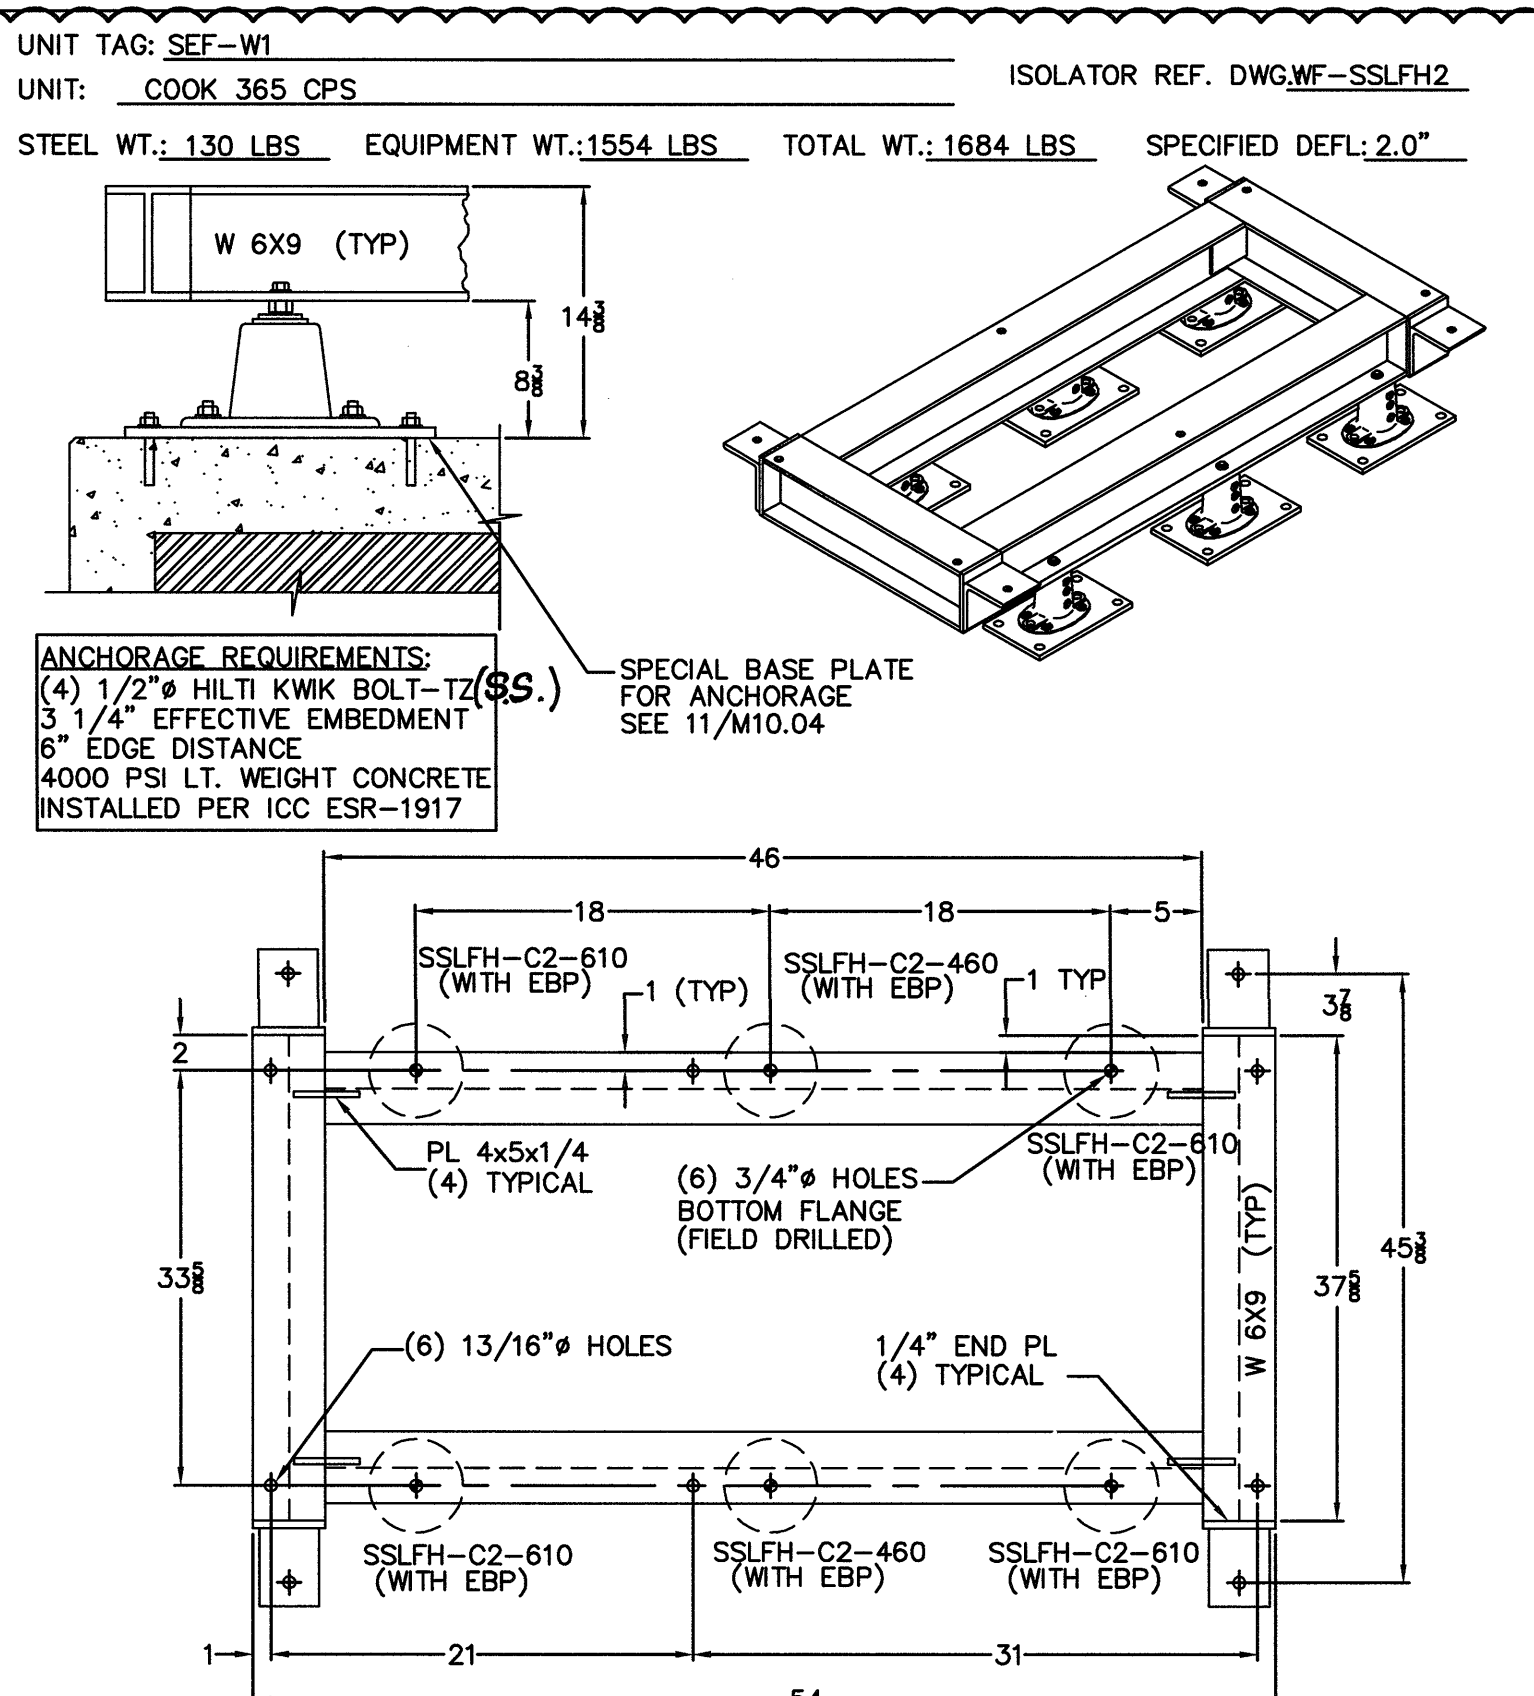


EXHAUST FAN ANCHORAGE DETAIL

SCALE NONE

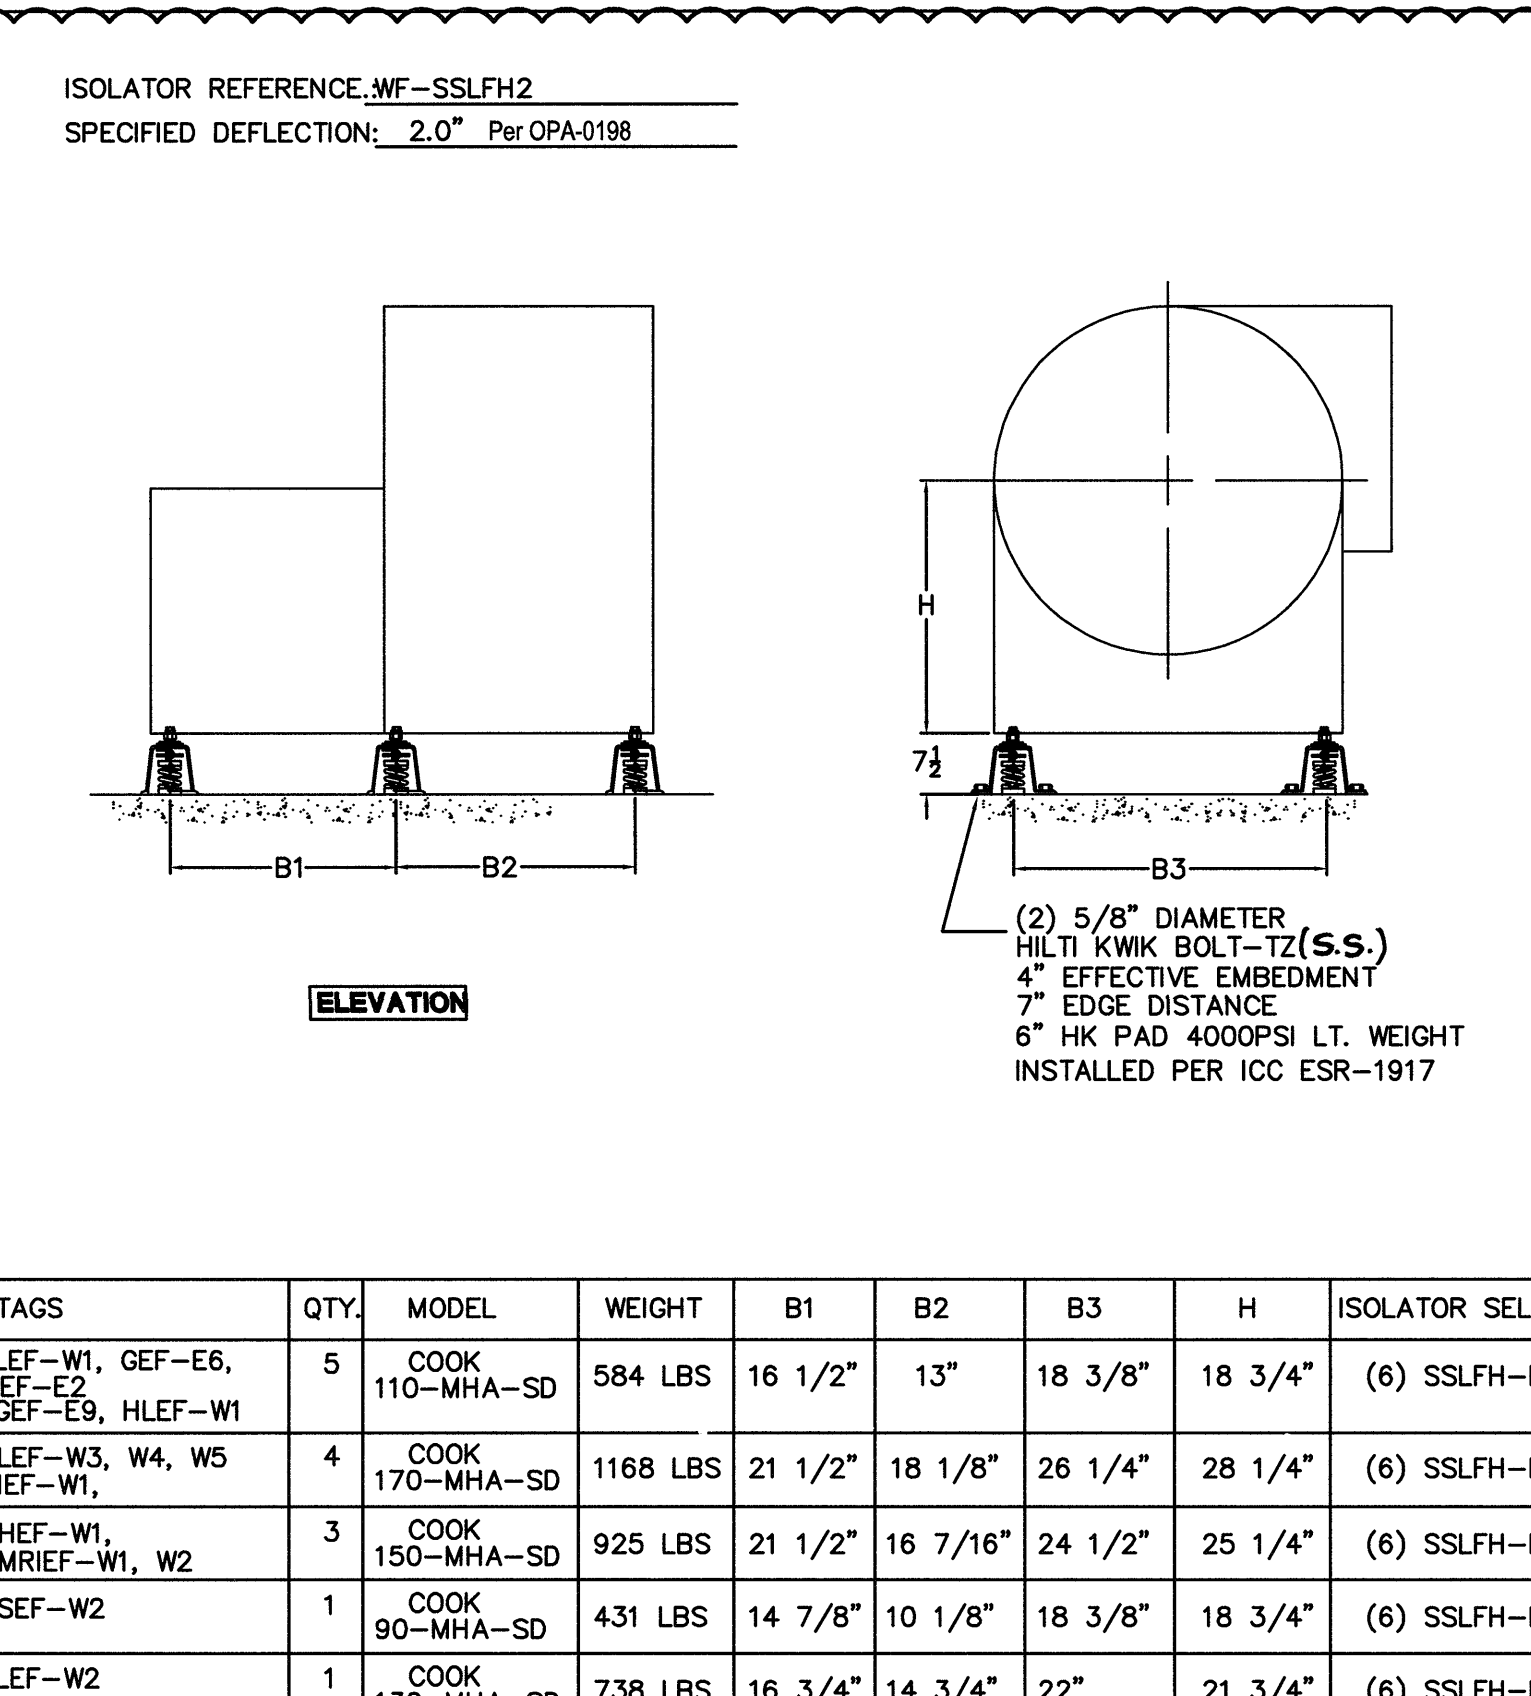


EXHAUST FAN ANCHORAGE DETAIL

SCALE NONE

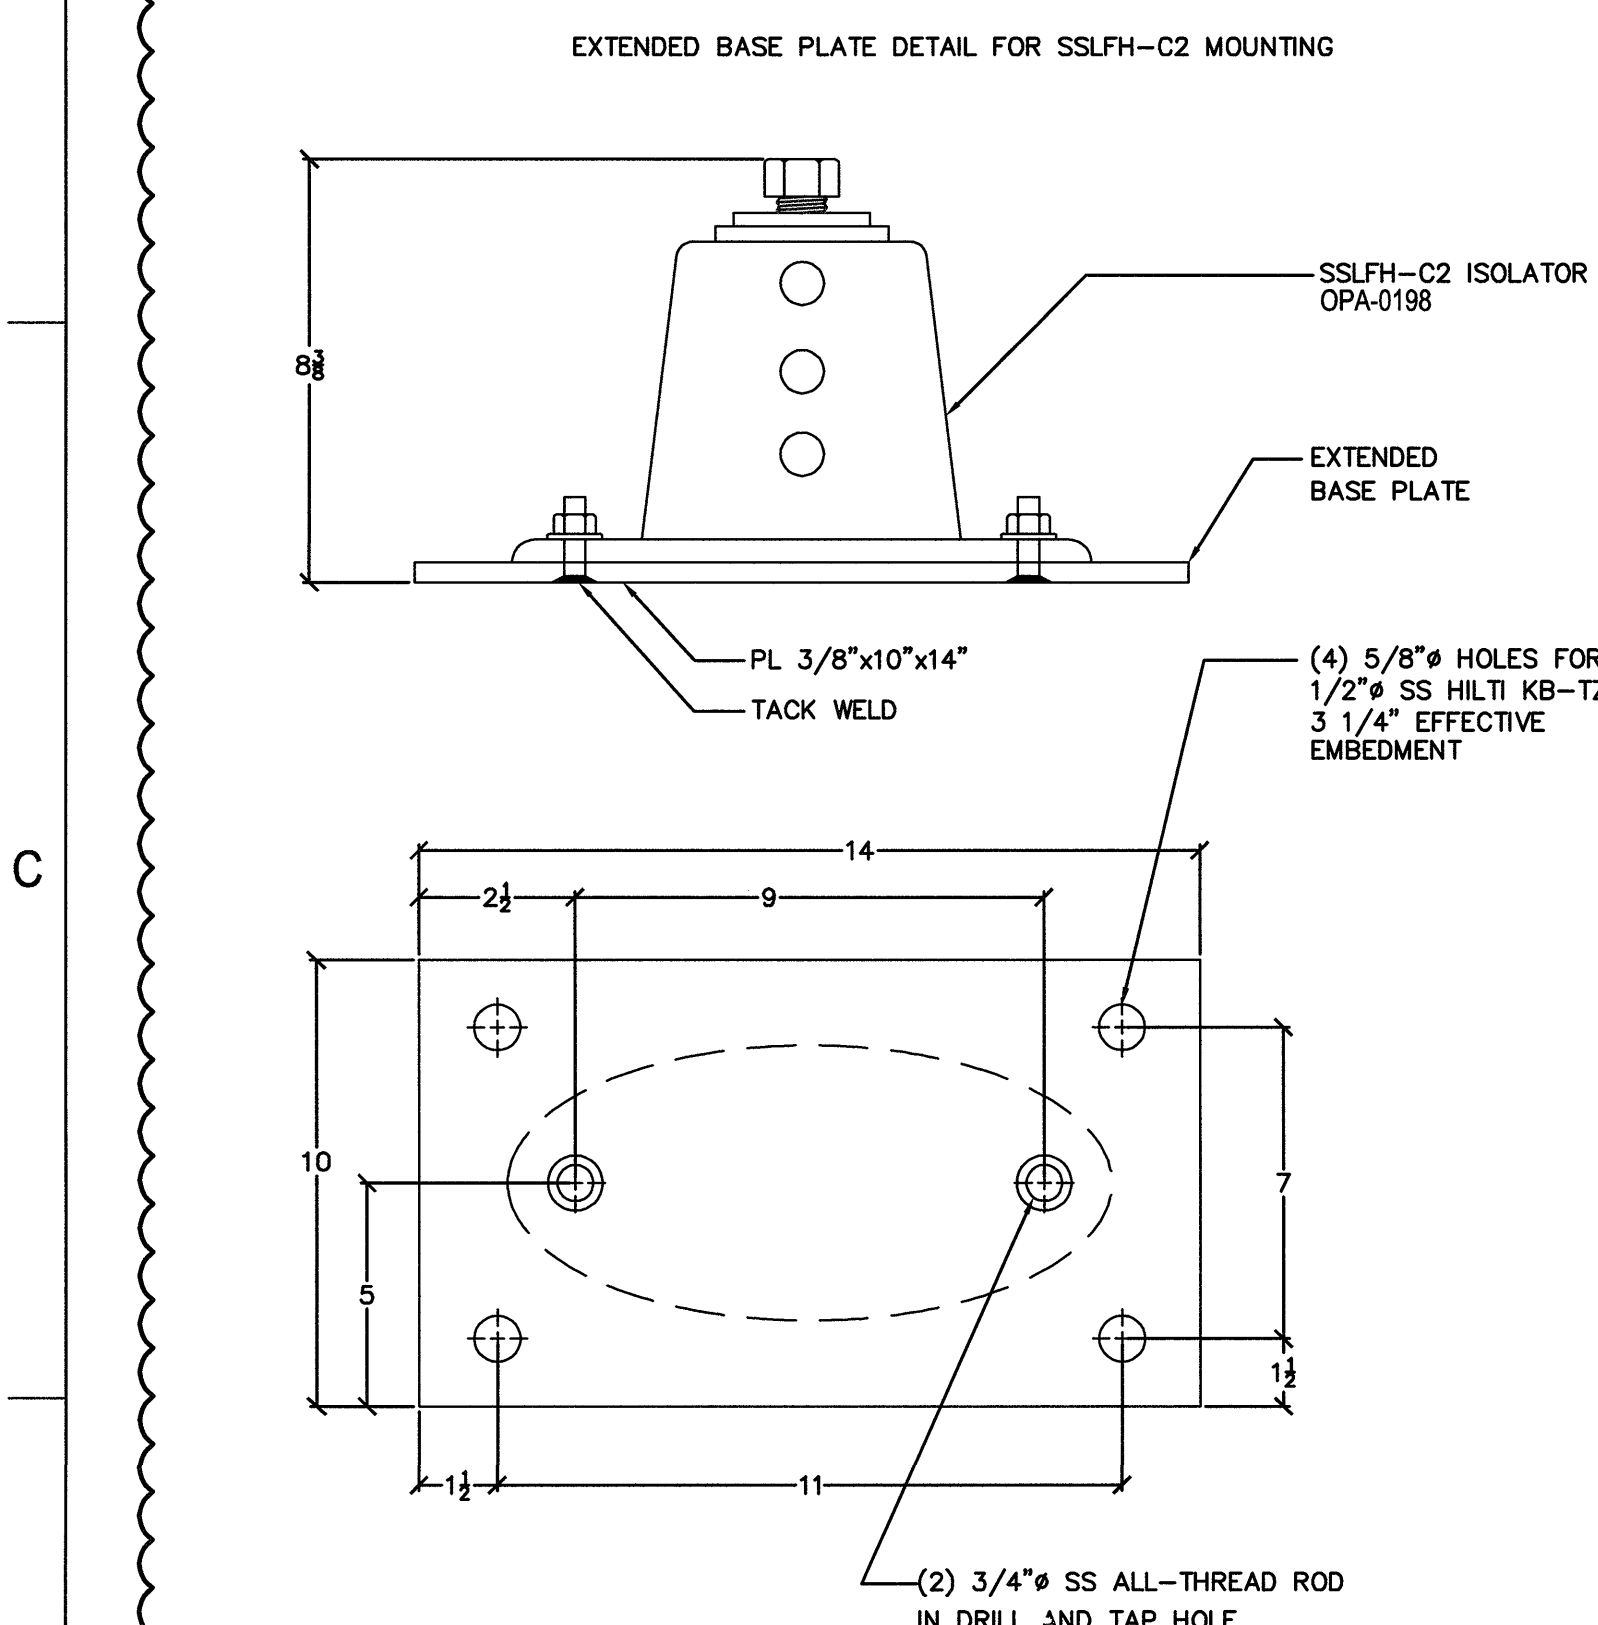


ISOLATOR AND PLATE ANCHORAGE DETAIL

SCALE NONE

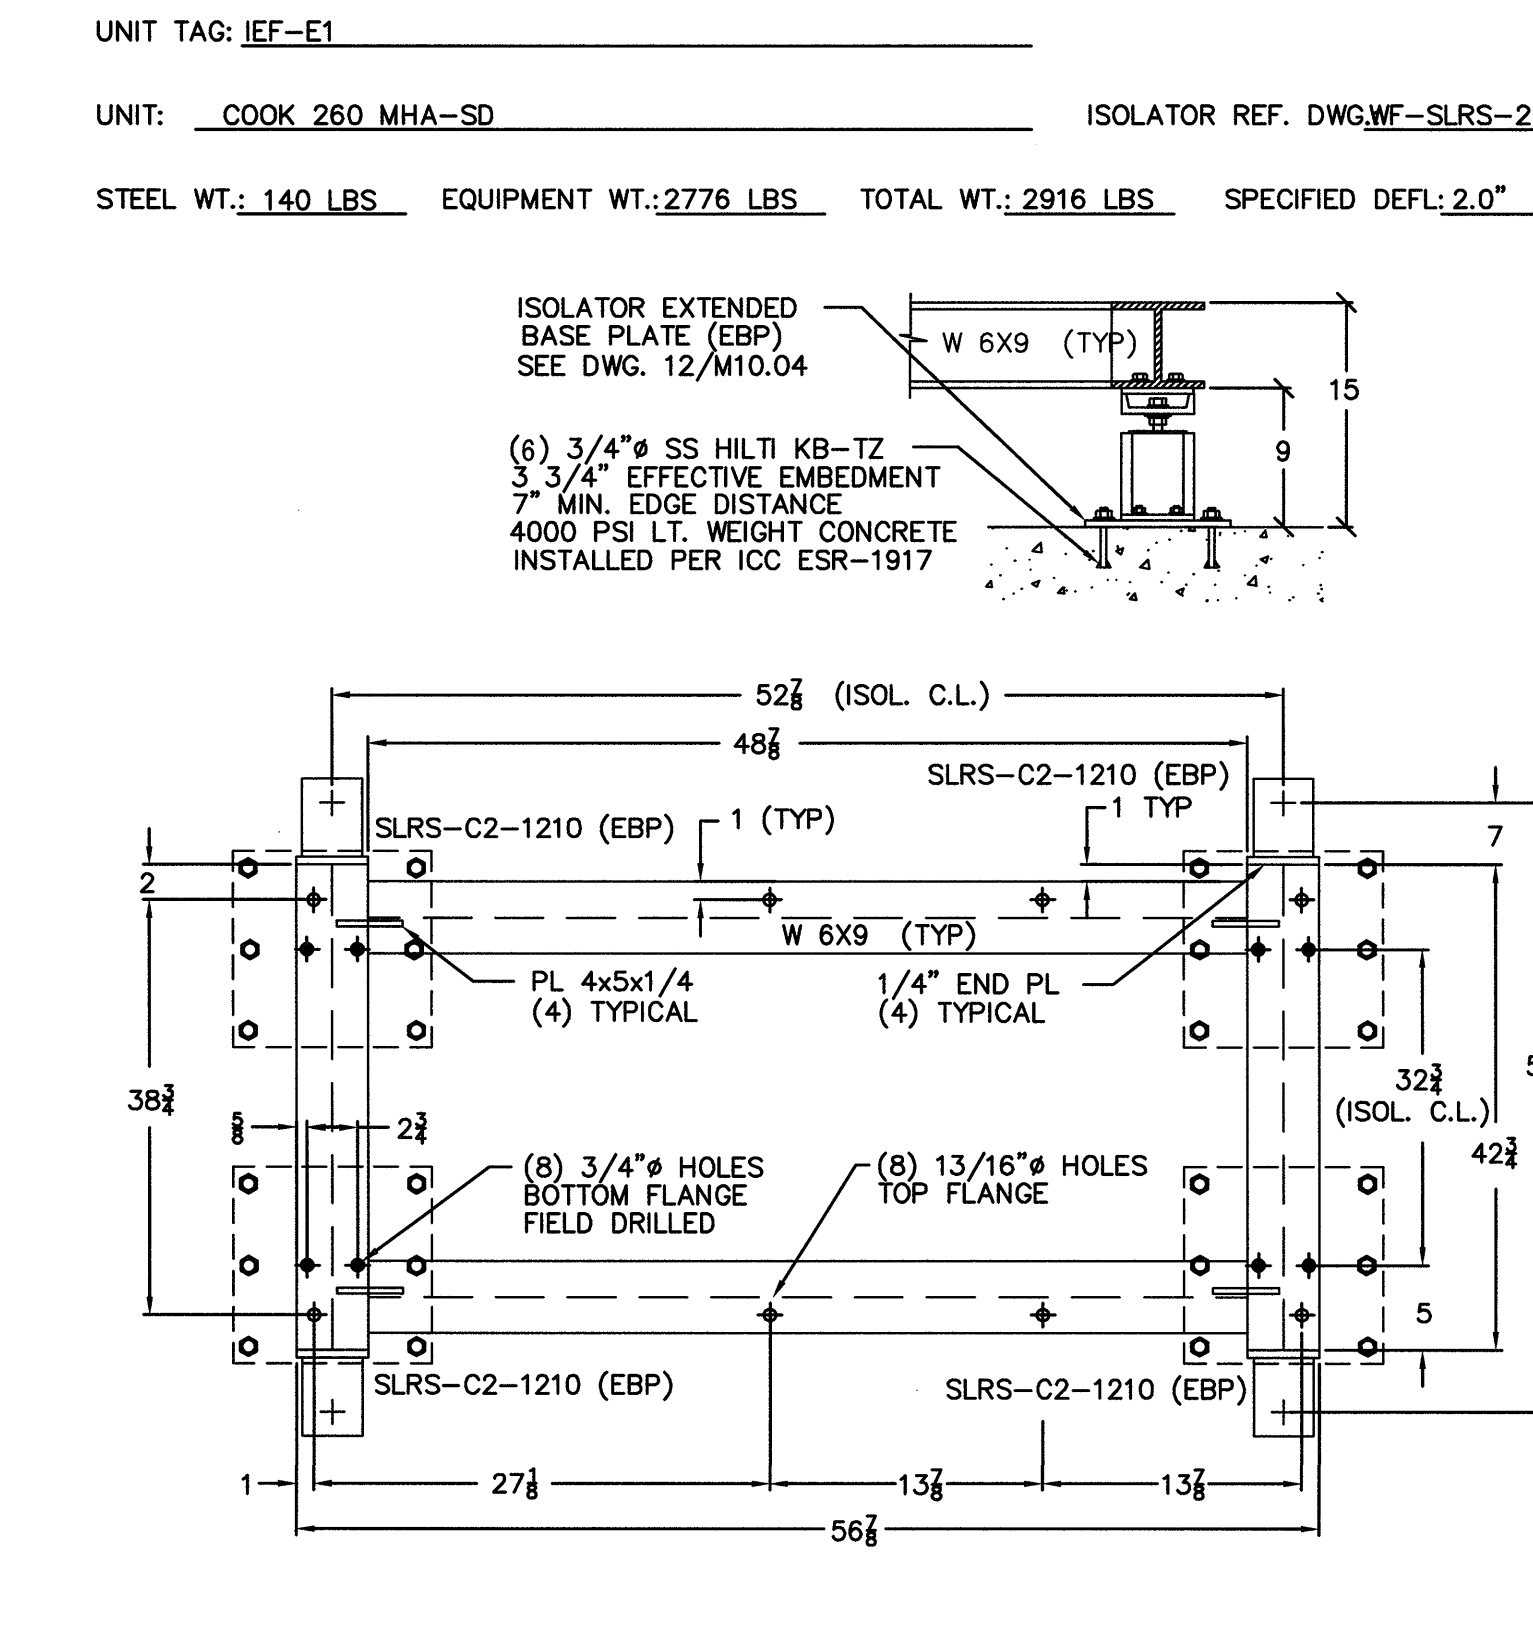


EXHAUST FAN ANCHORAGE DETAIL

SCALE NONE

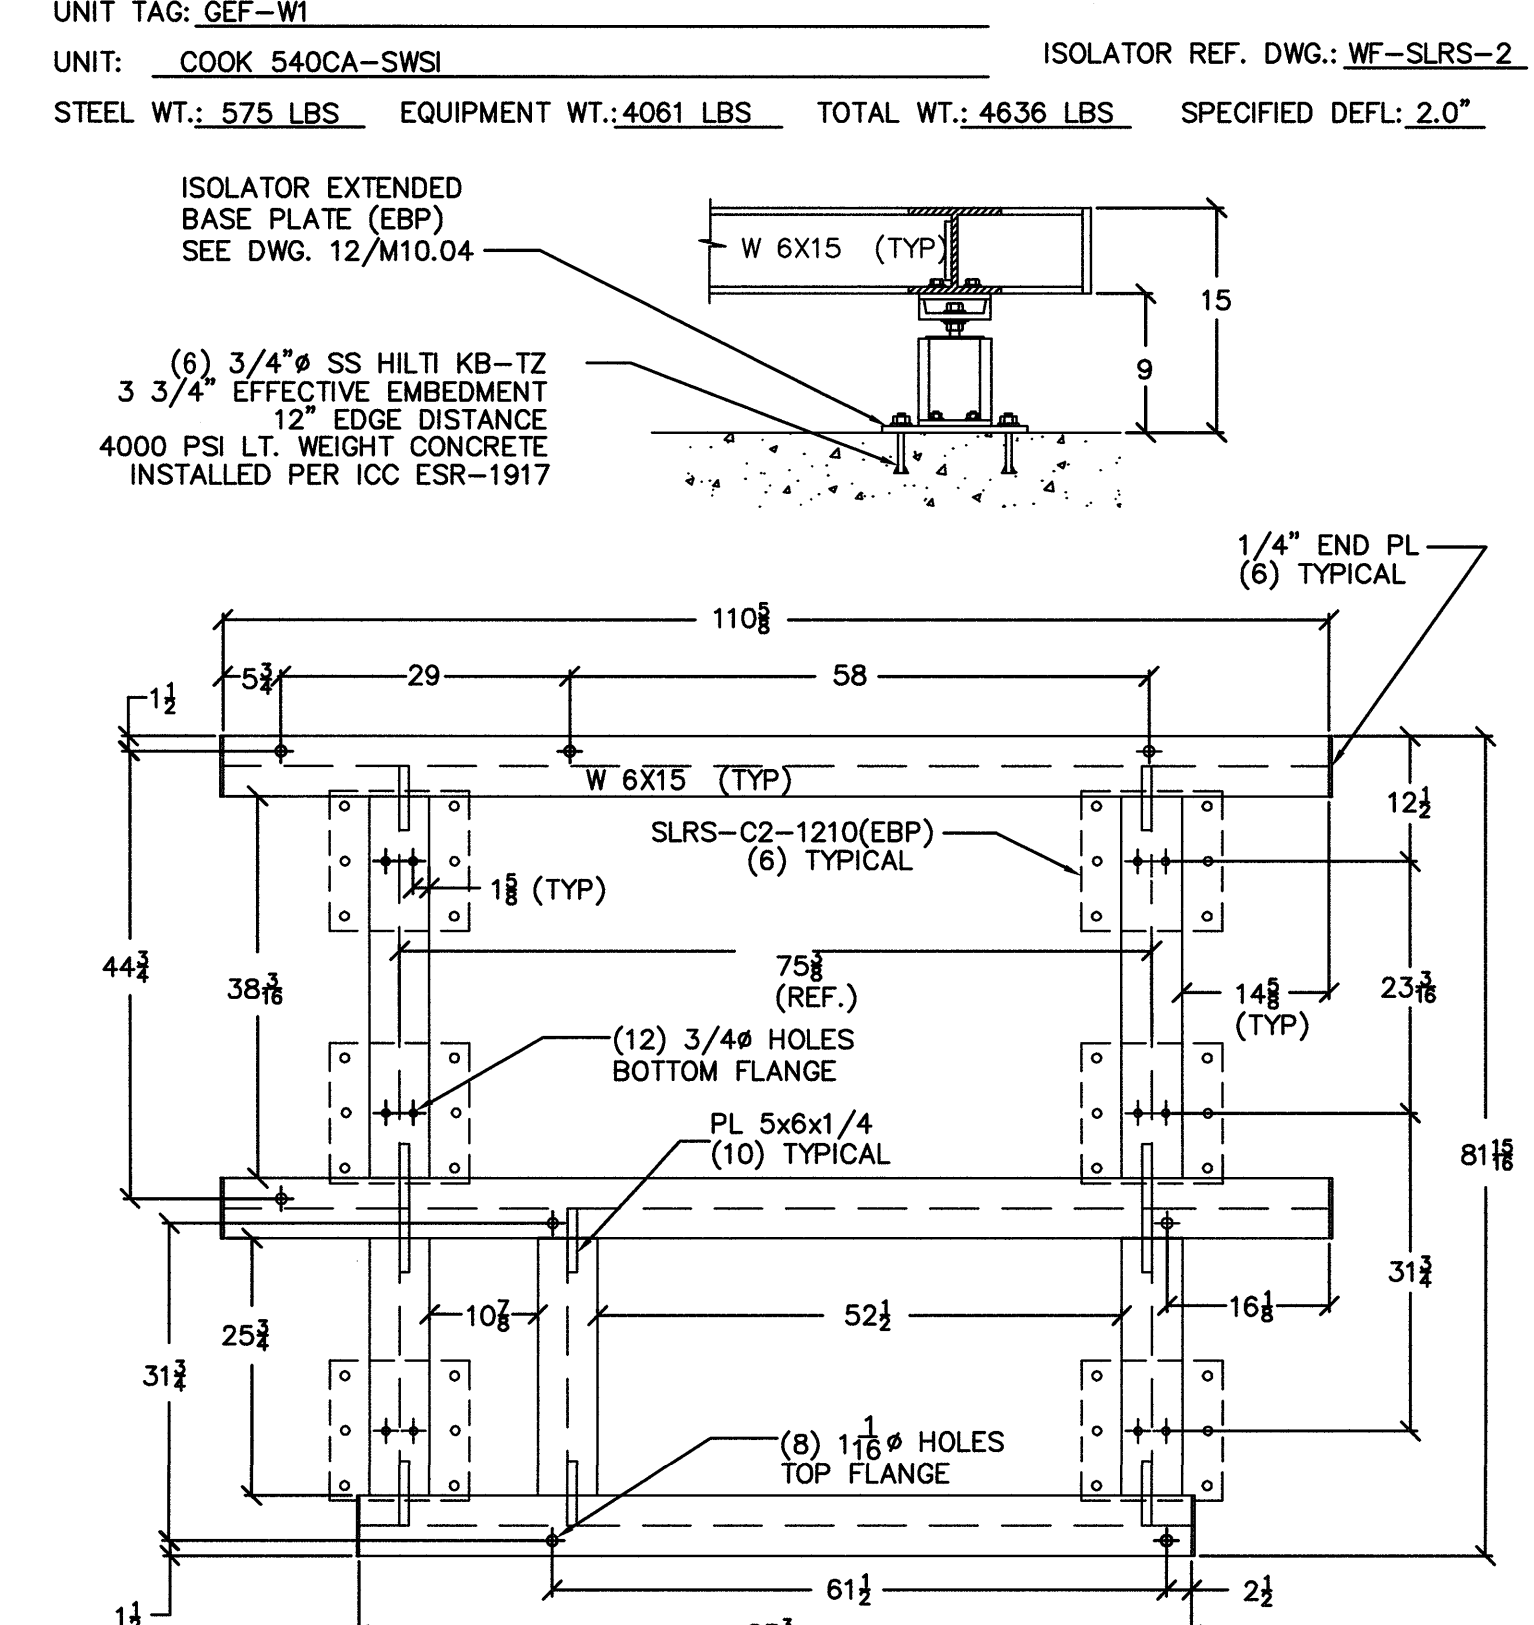


EXHAUST FAN ANCHORAGE DETAIL

SCALE NONE

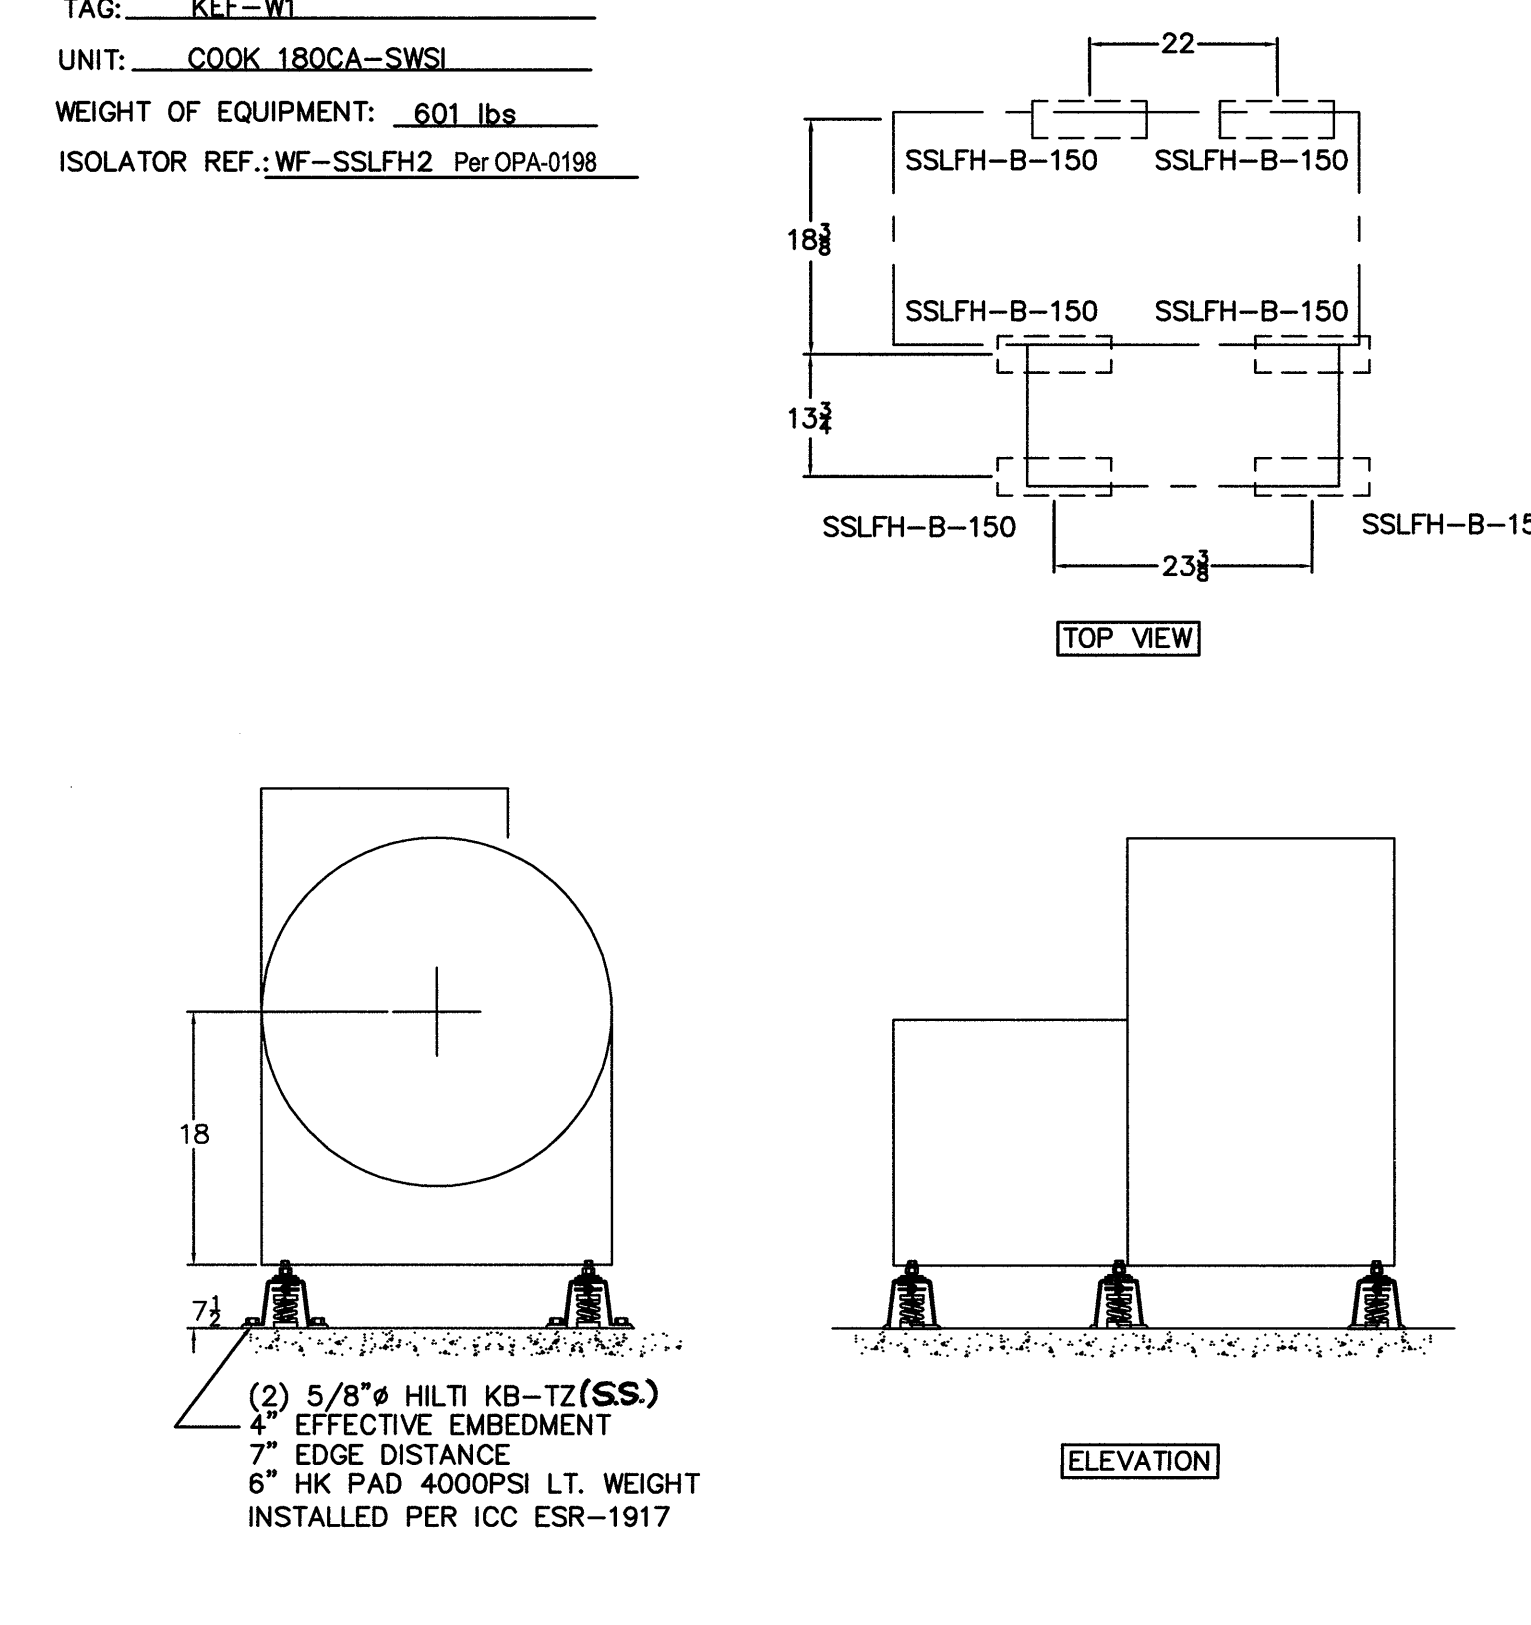


EXHAUST FAN ANCHORAGE DETAIL

SCALE NONE

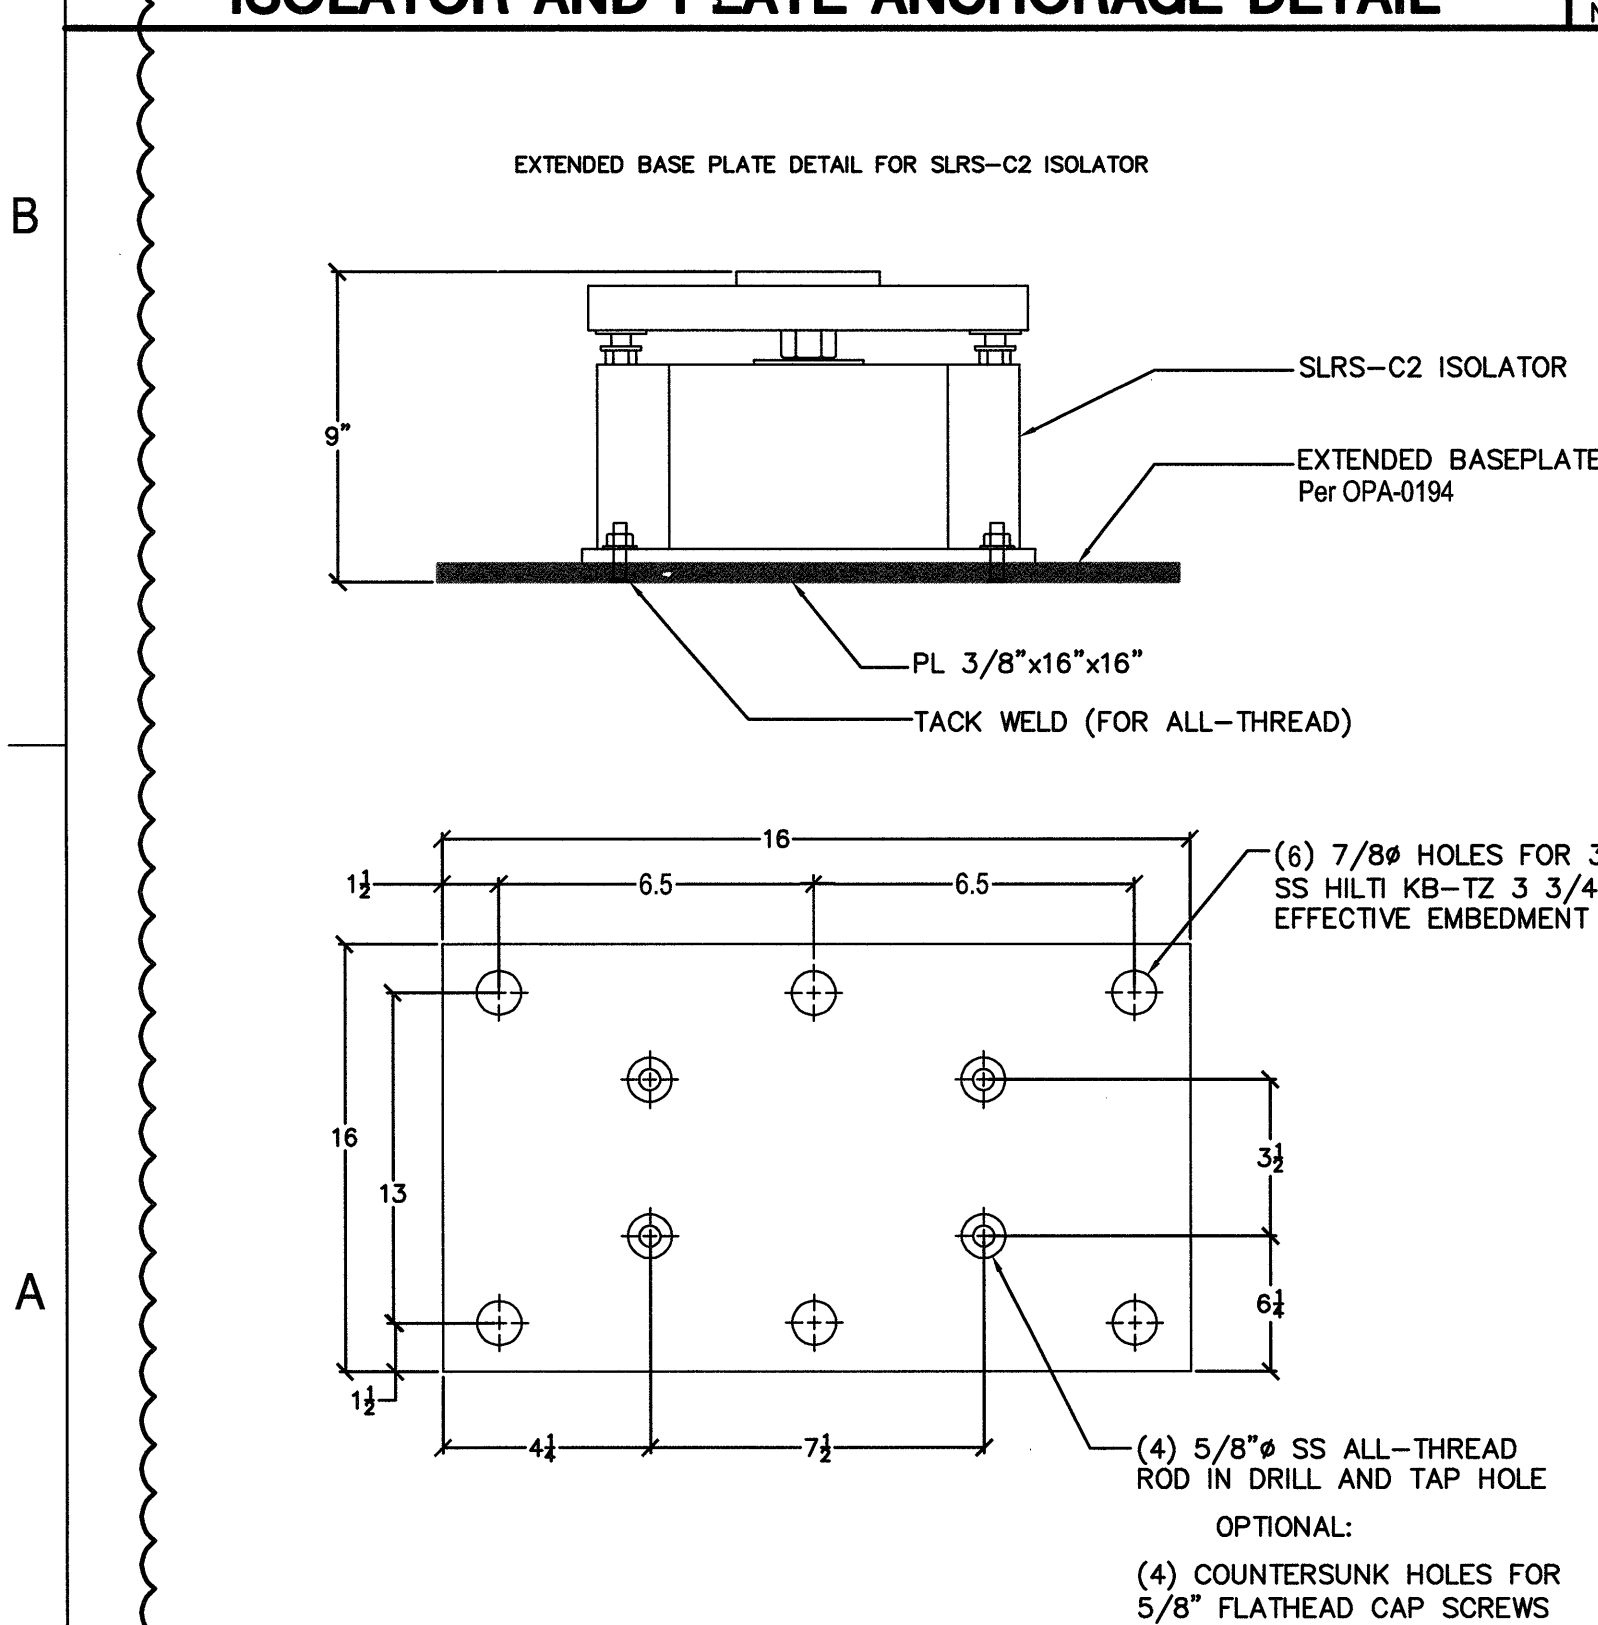


ISOLATOR AND PLATE ANCHORAGE DETAIL

SCALE NONE

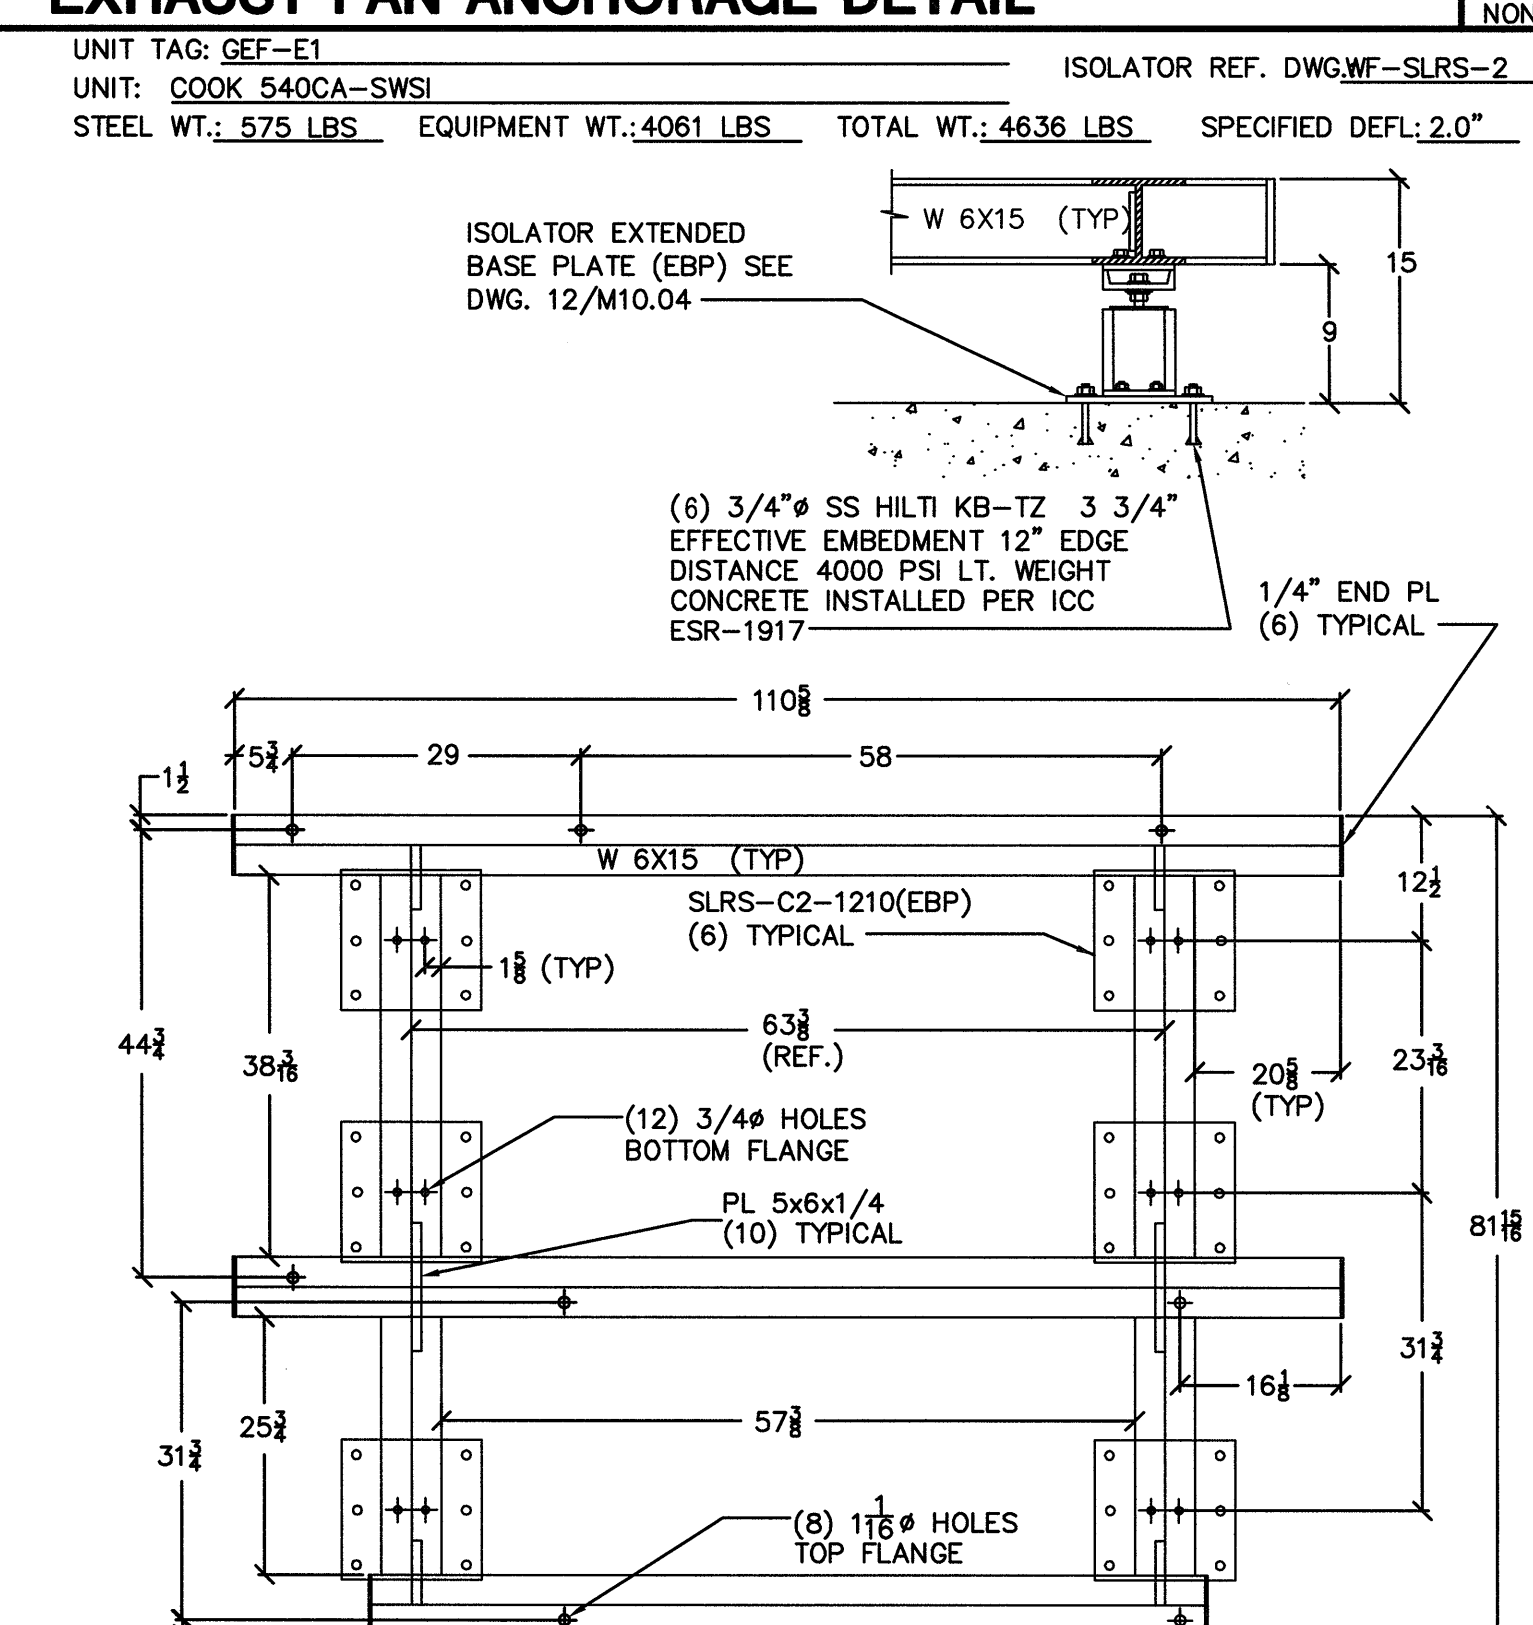


EXHAUST FAN ANCHORAGE DETAIL

SCALE NONE

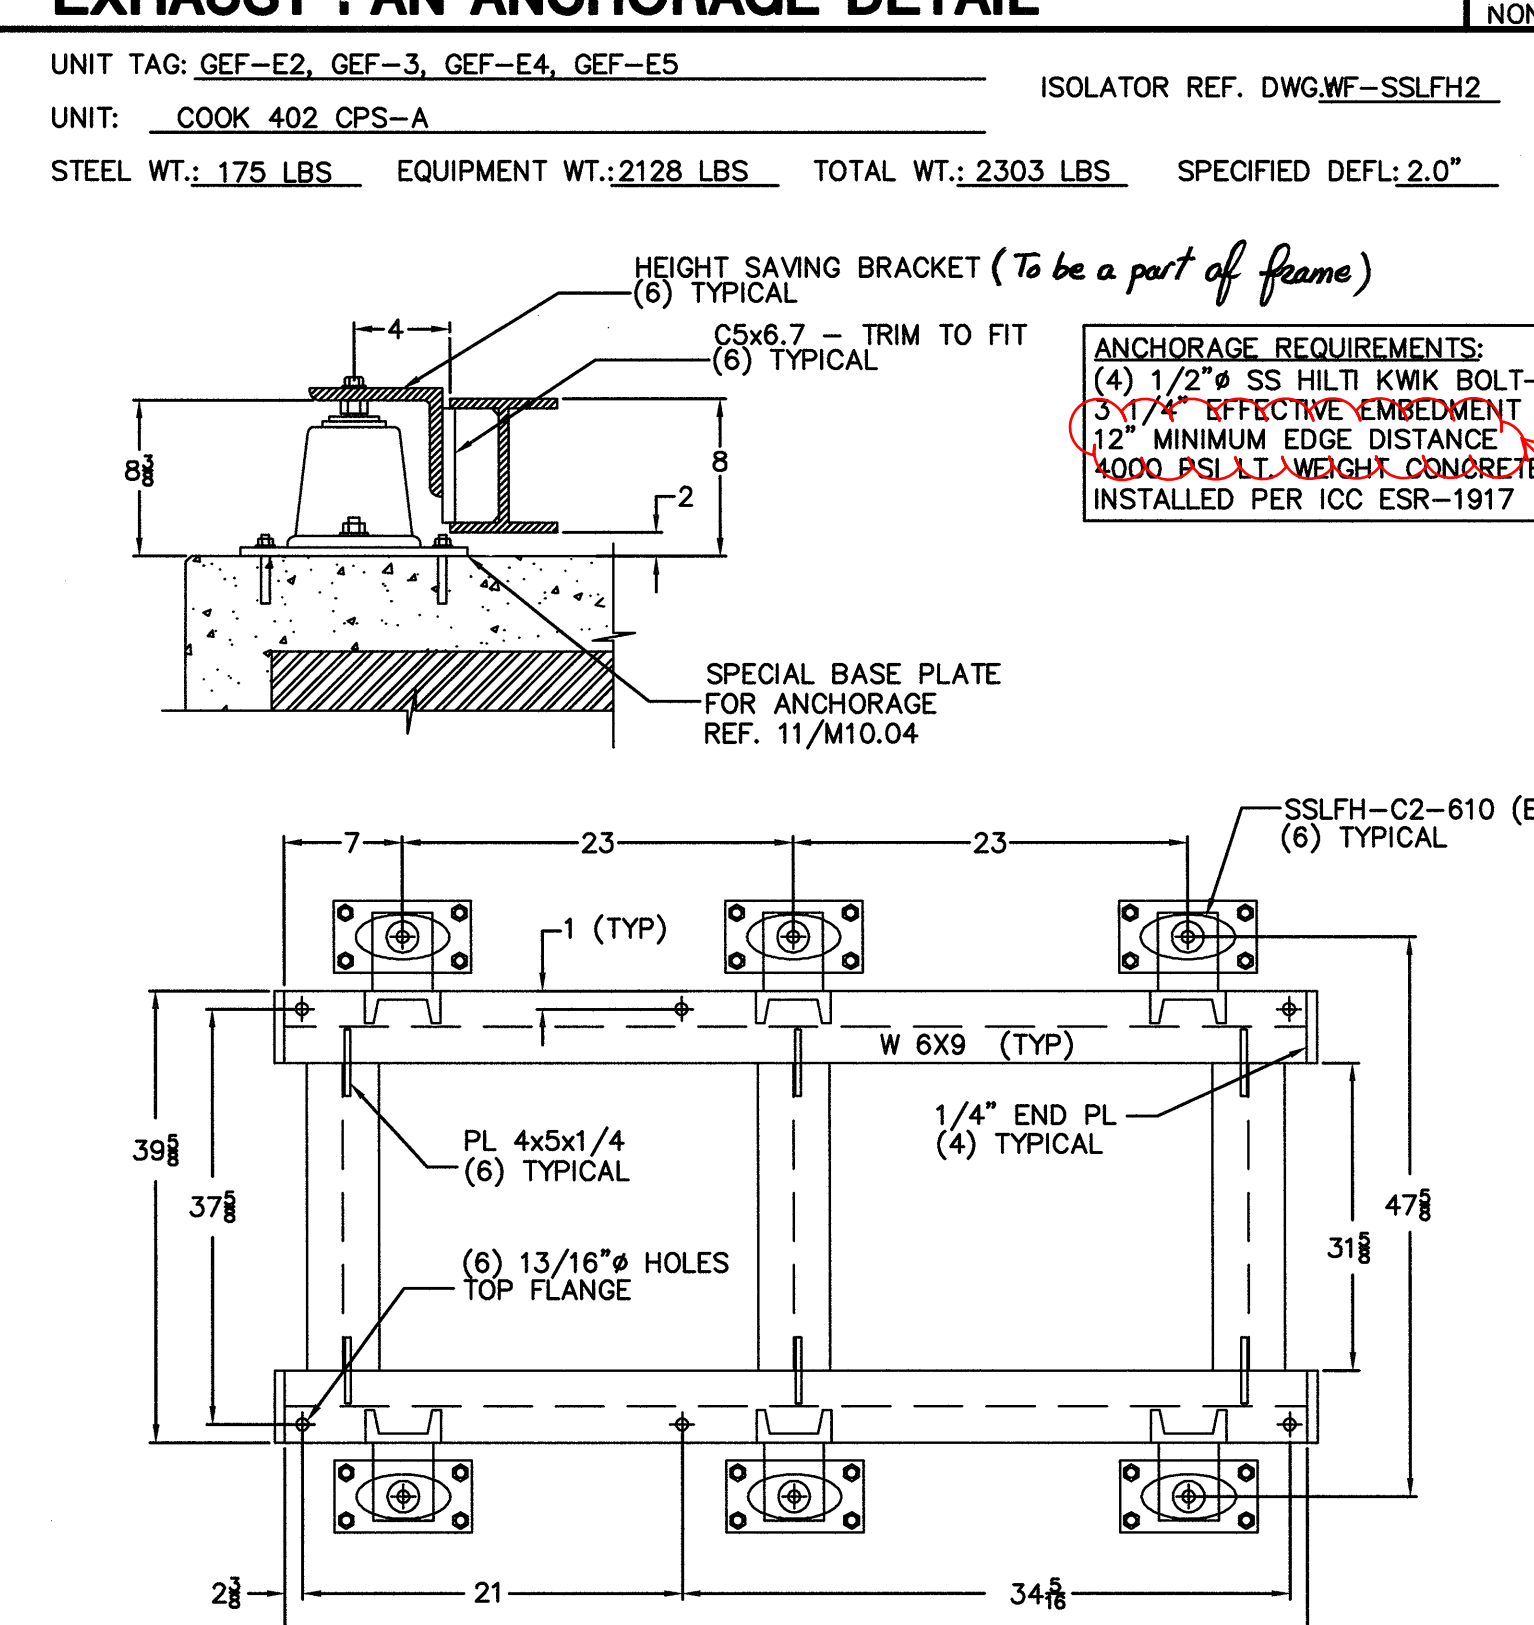

EXHAUST FAN ANCHORAGE DETAIL

SCALE NONE

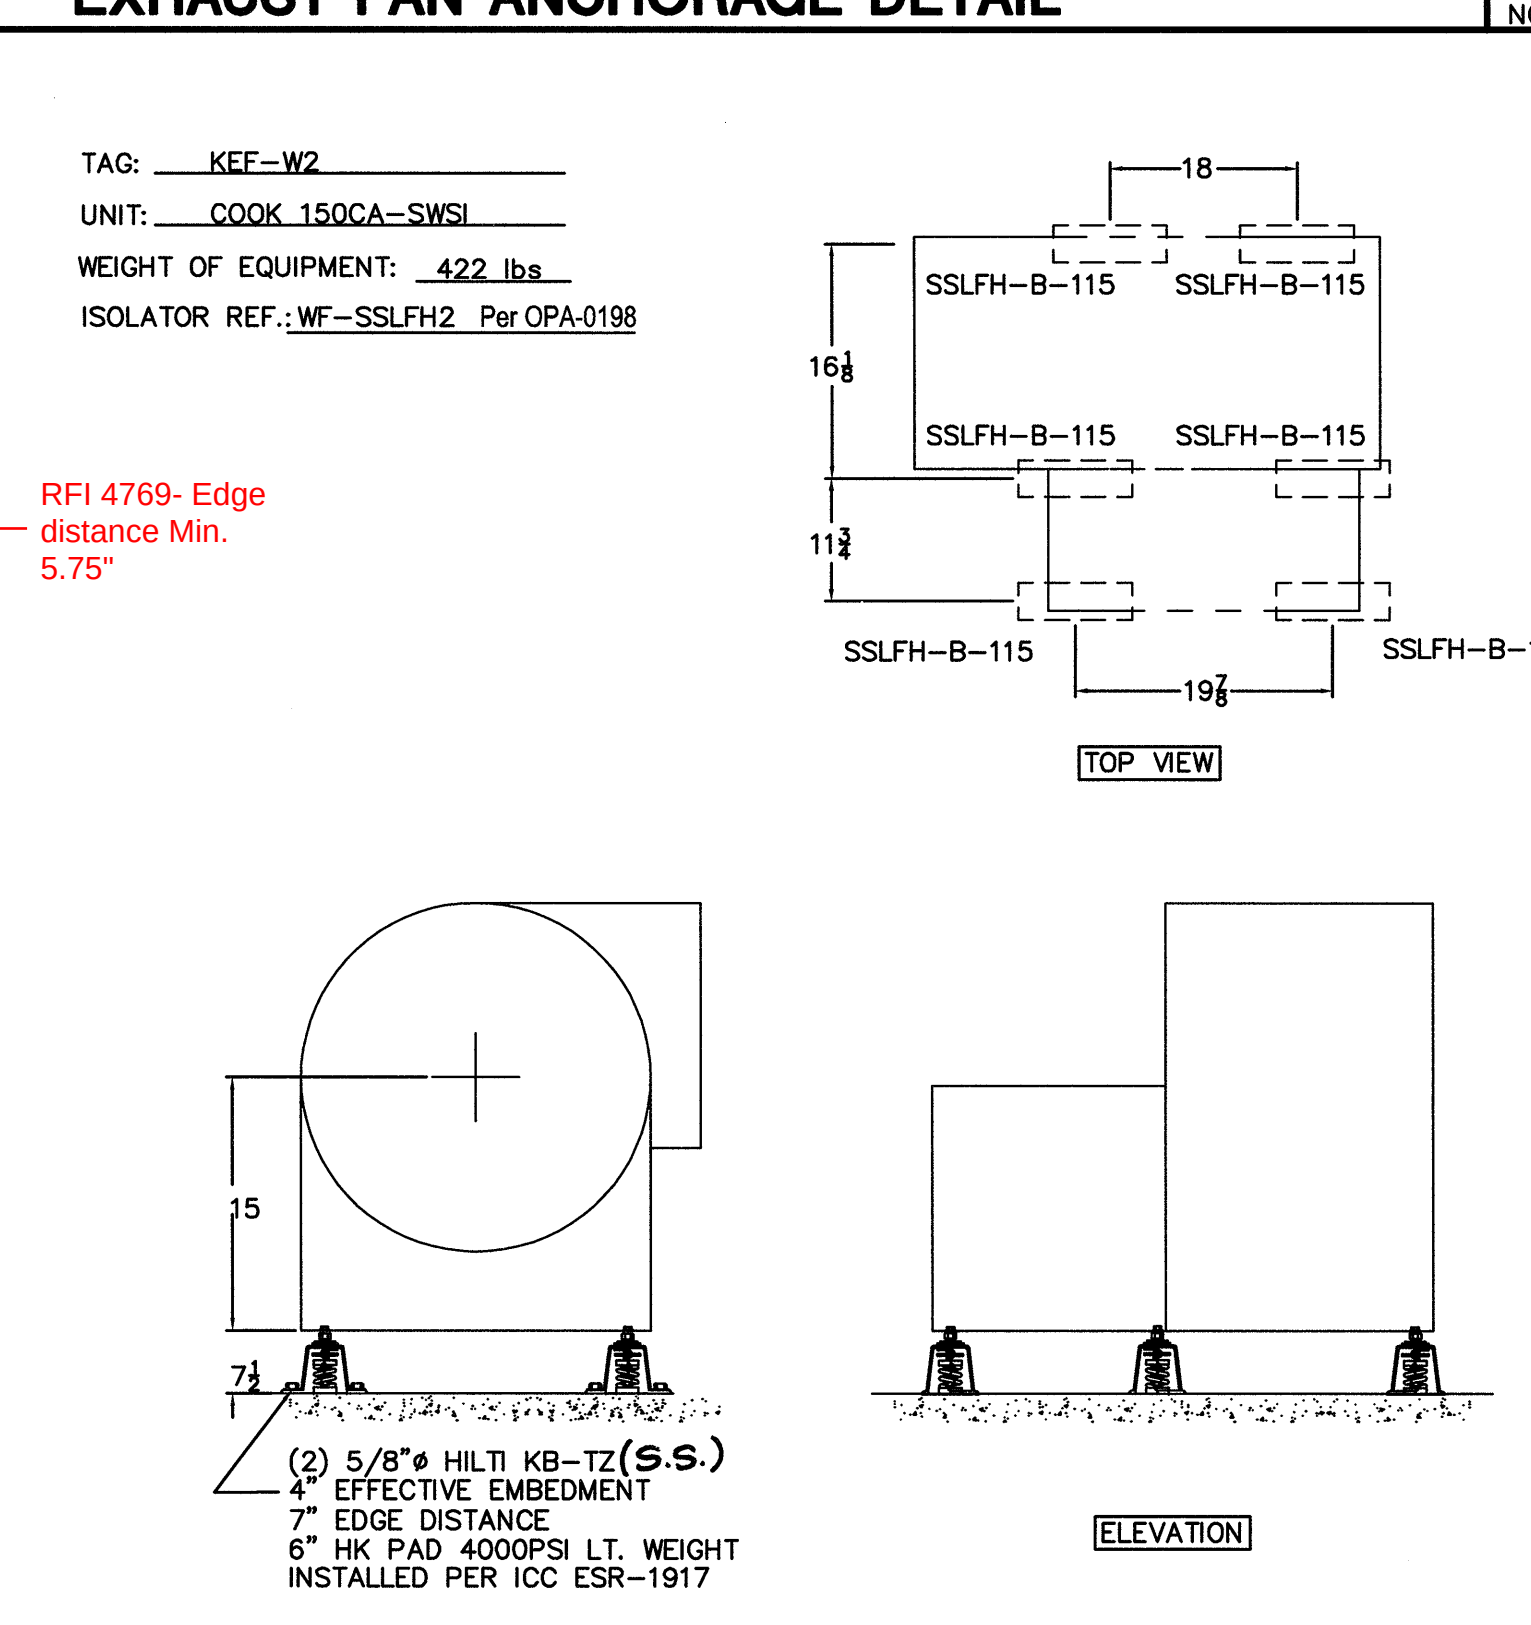

EXHAUST FAN ANCHORAGE DETAIL

SCALE NONE