



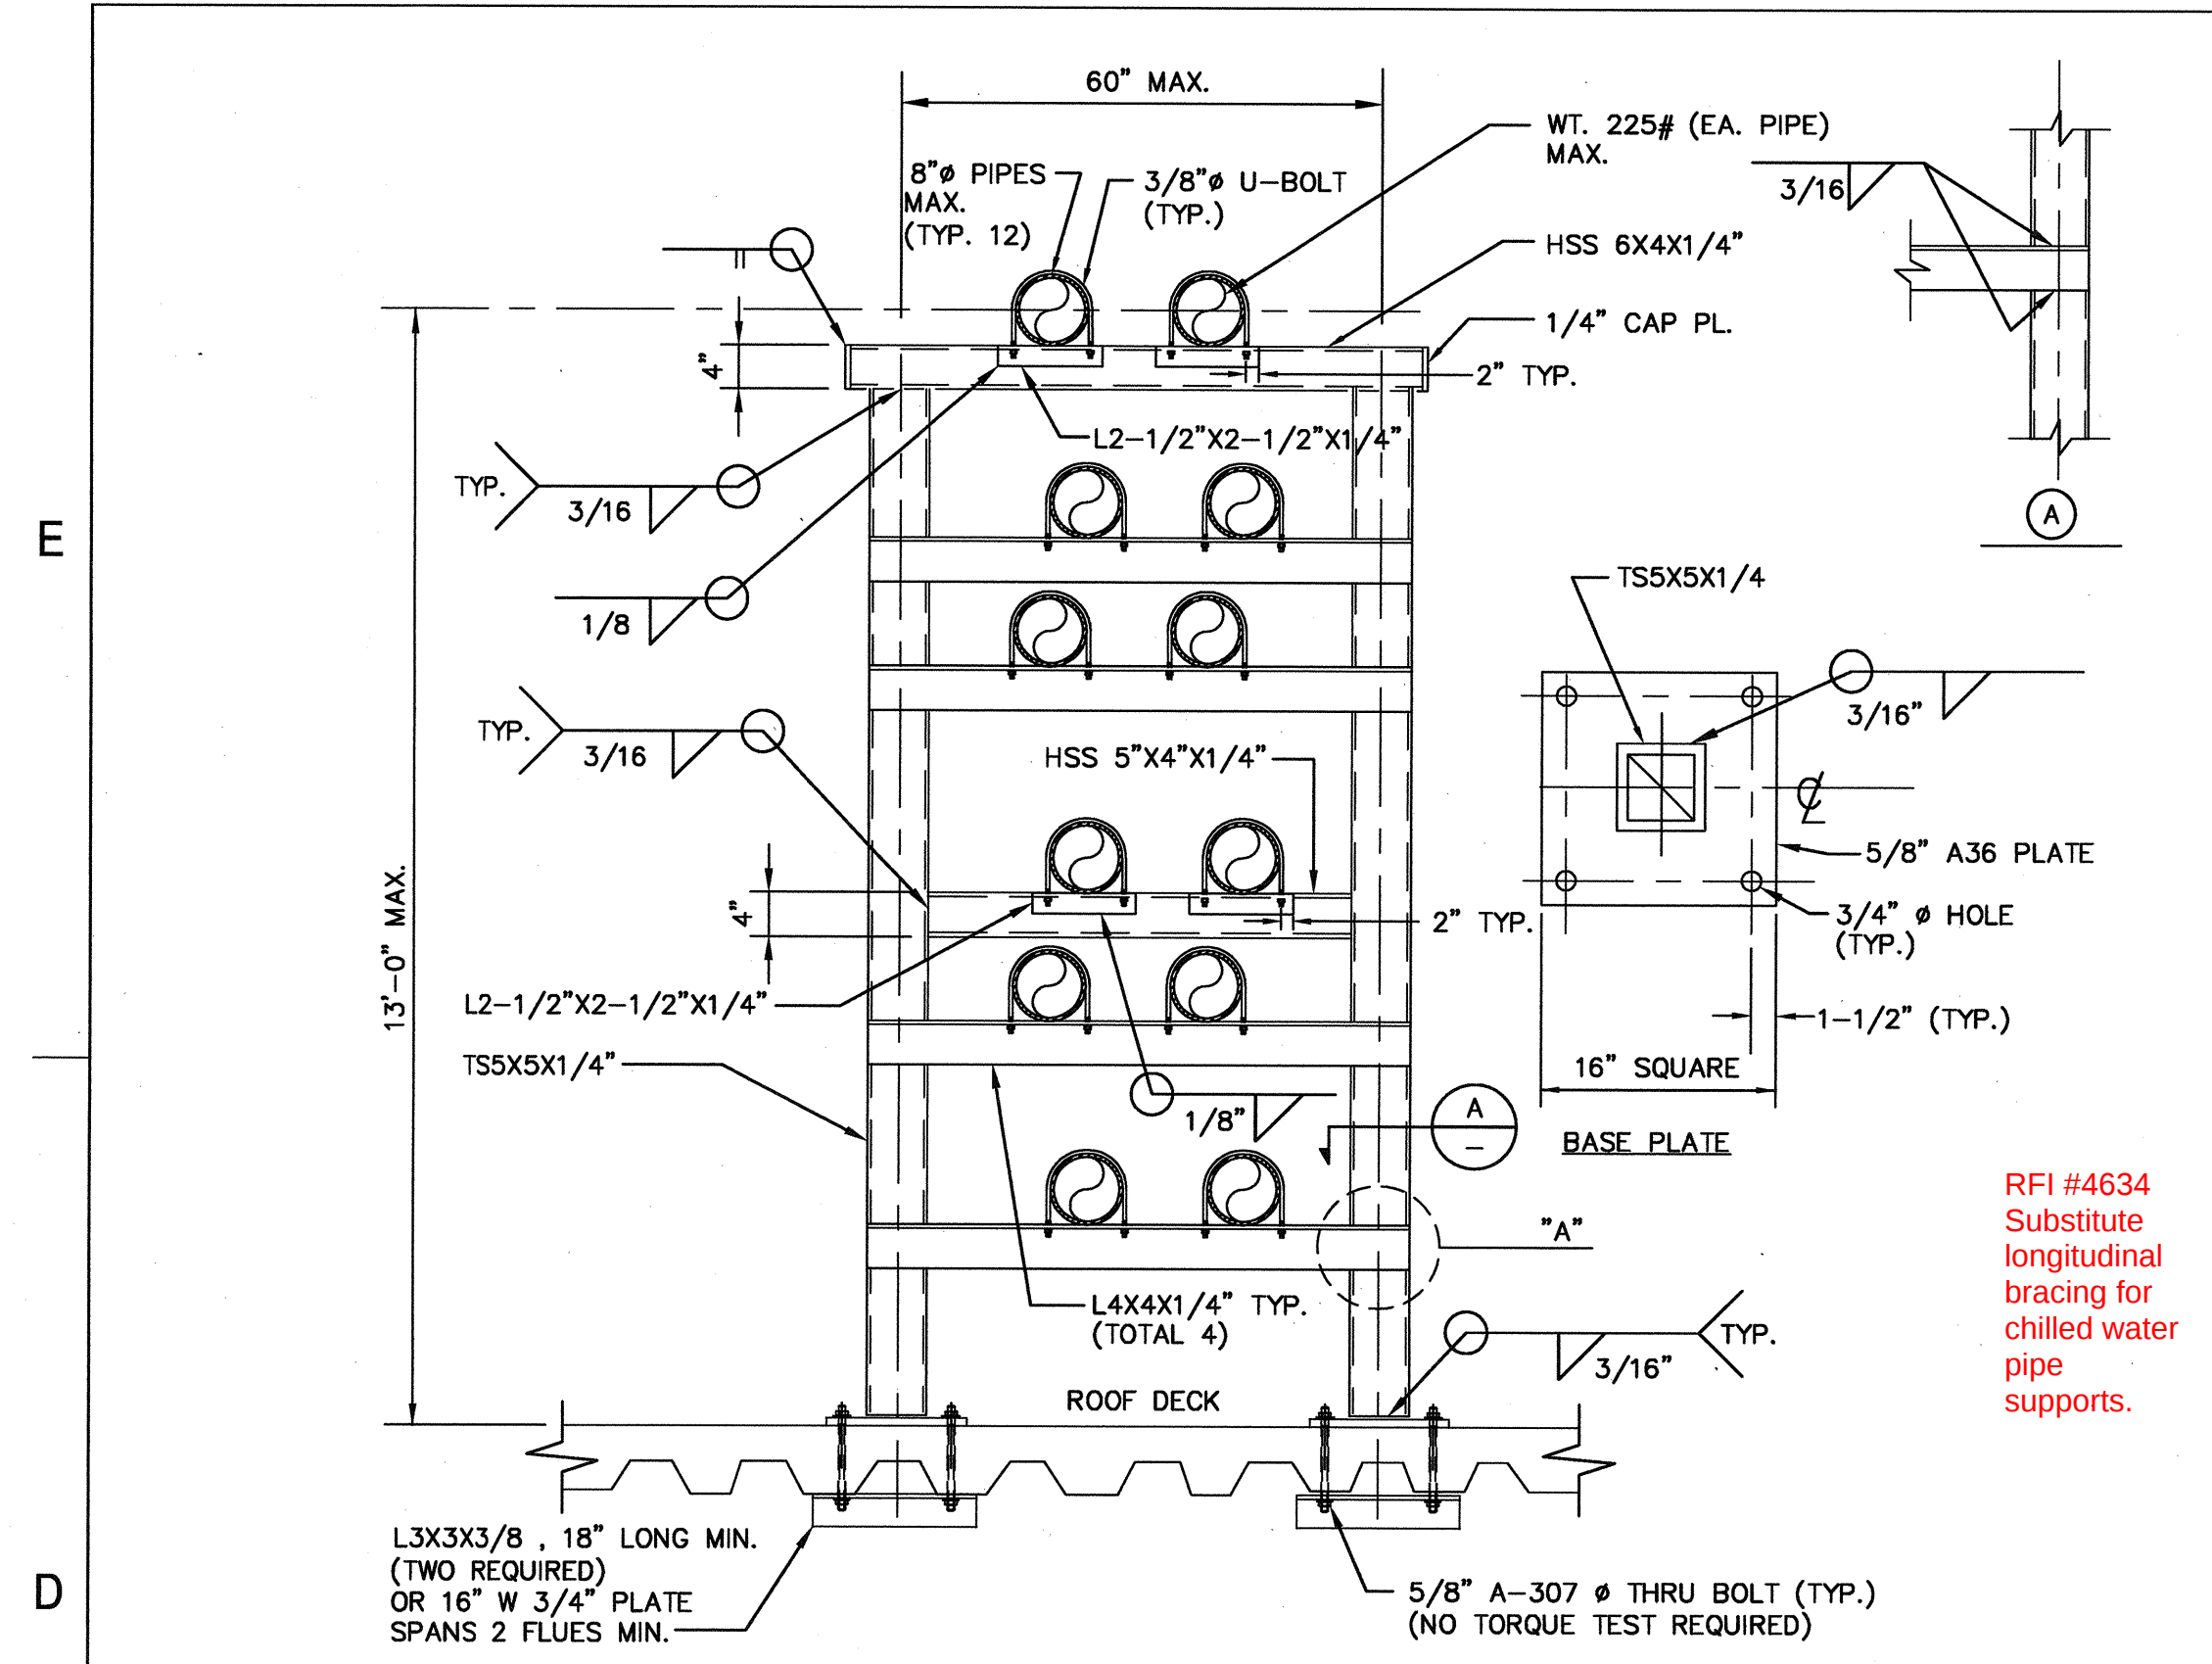


PIPE SUPPORT DETAIL PS-4 AT AHU COILS' CONNECTION

SCALE
NONE

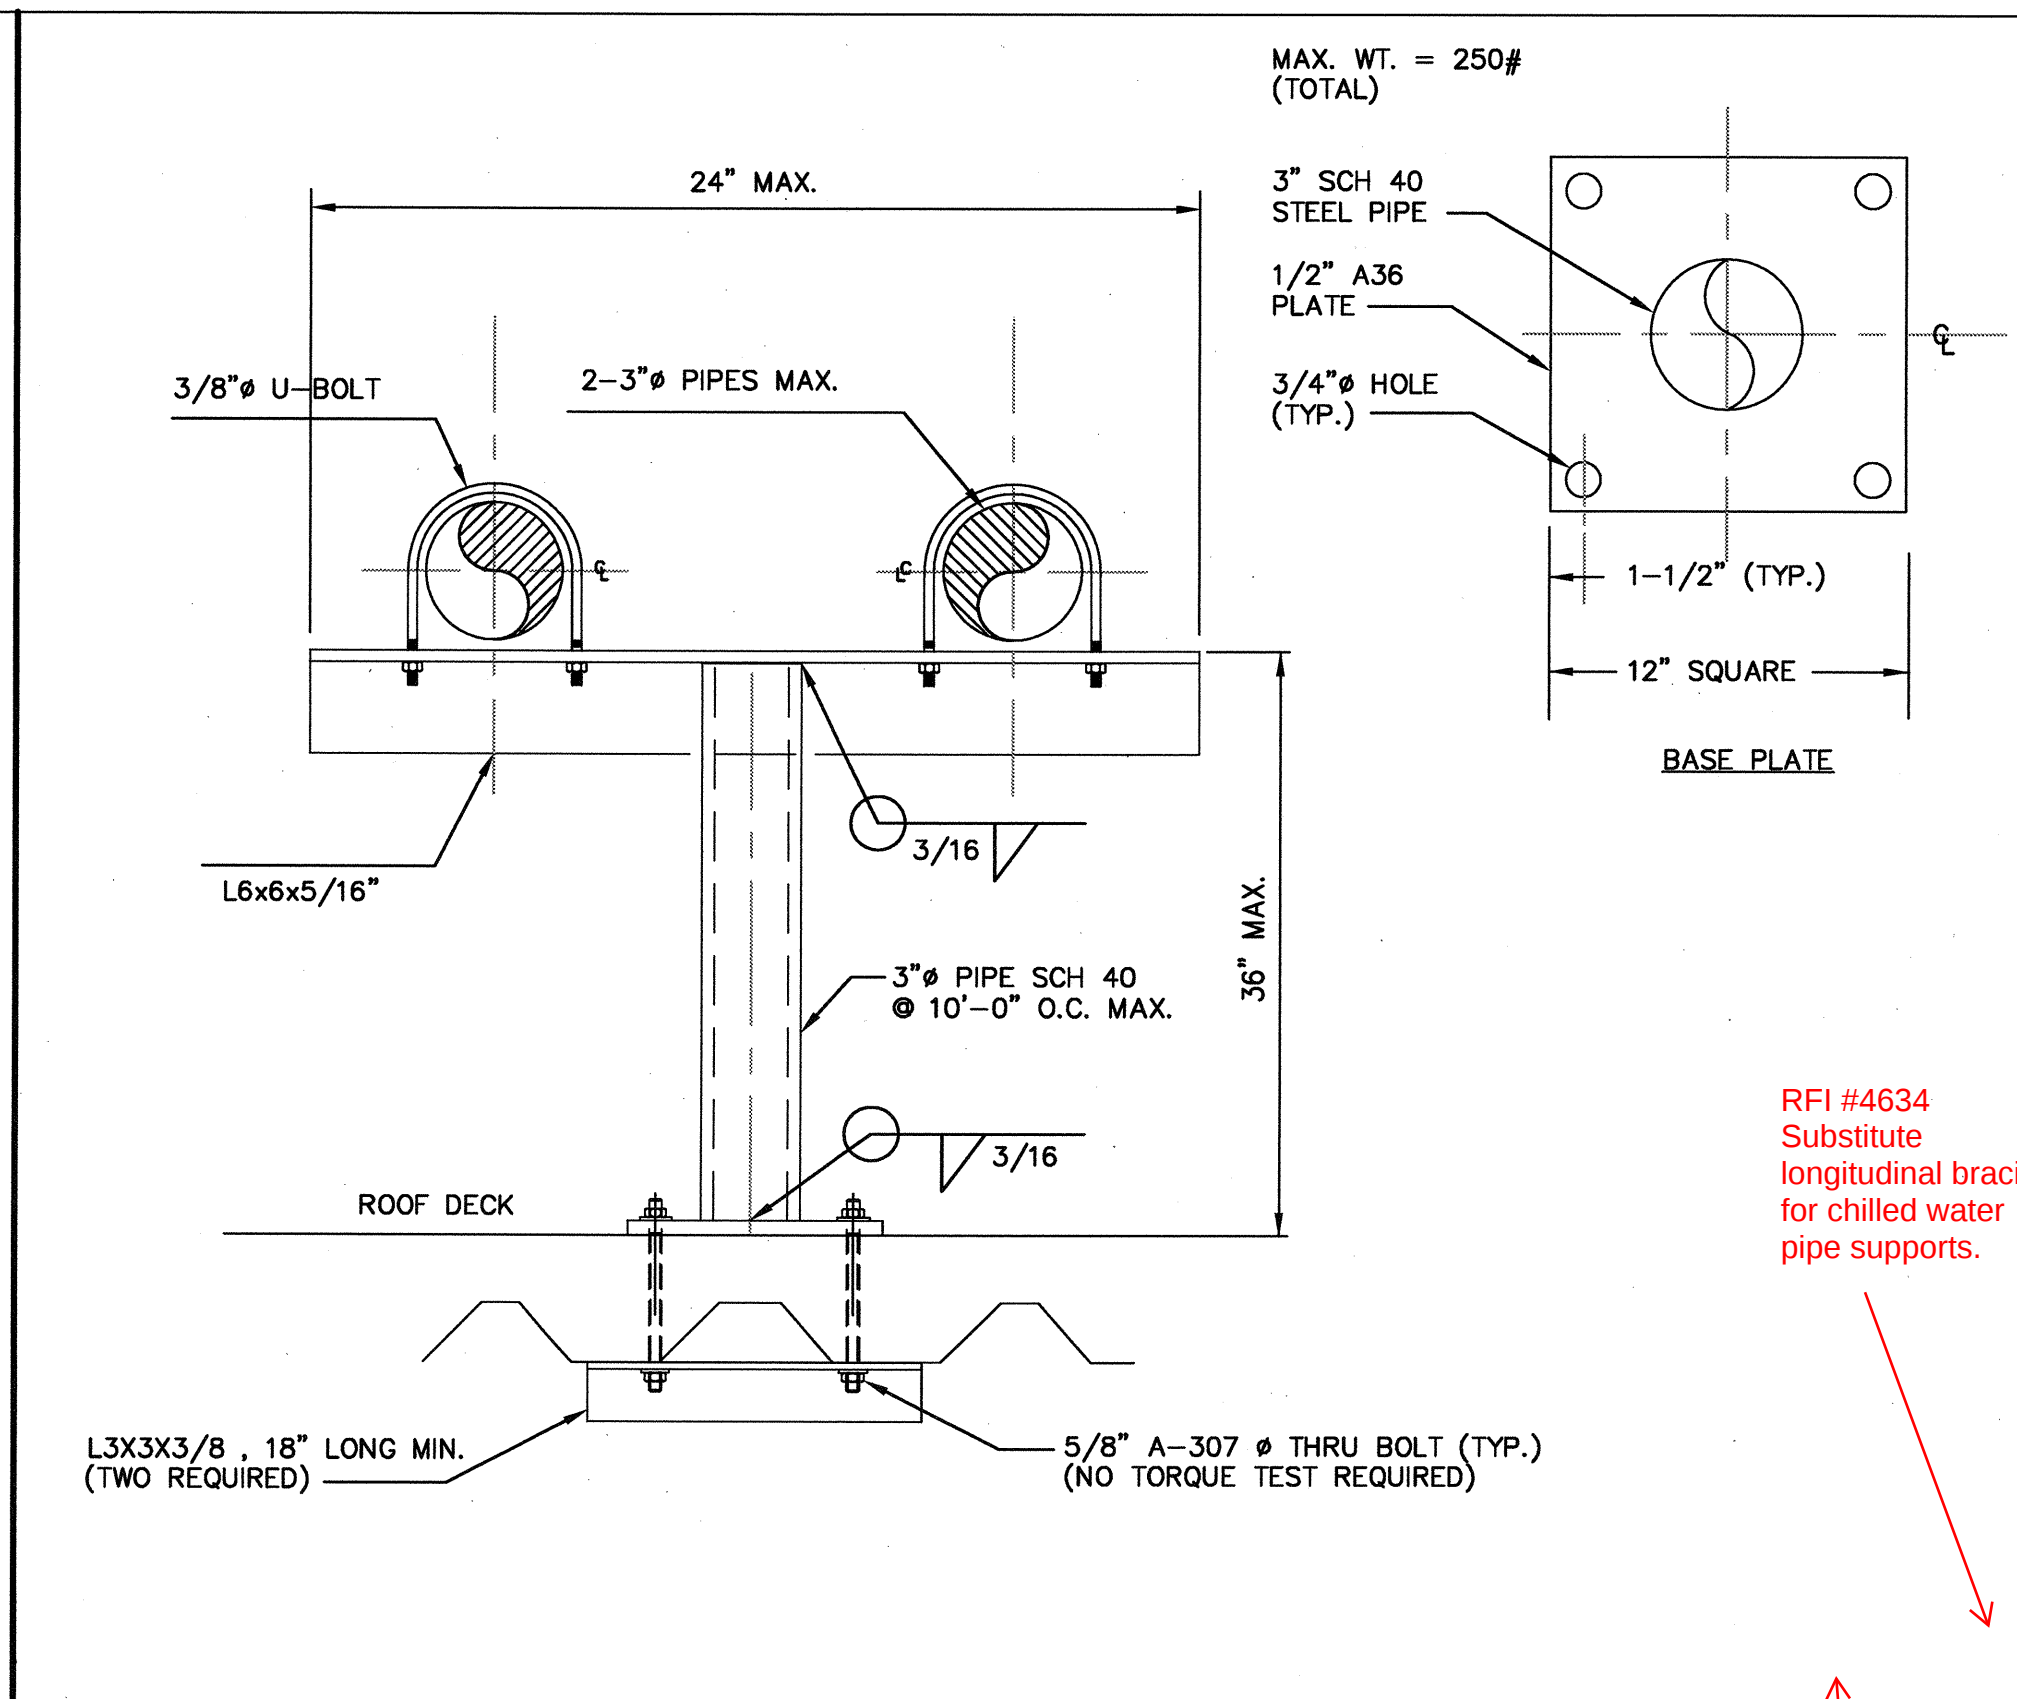


PIPE SUPPORT DETAIL PS-5 AT 10' O.C.

SCALE
NONE

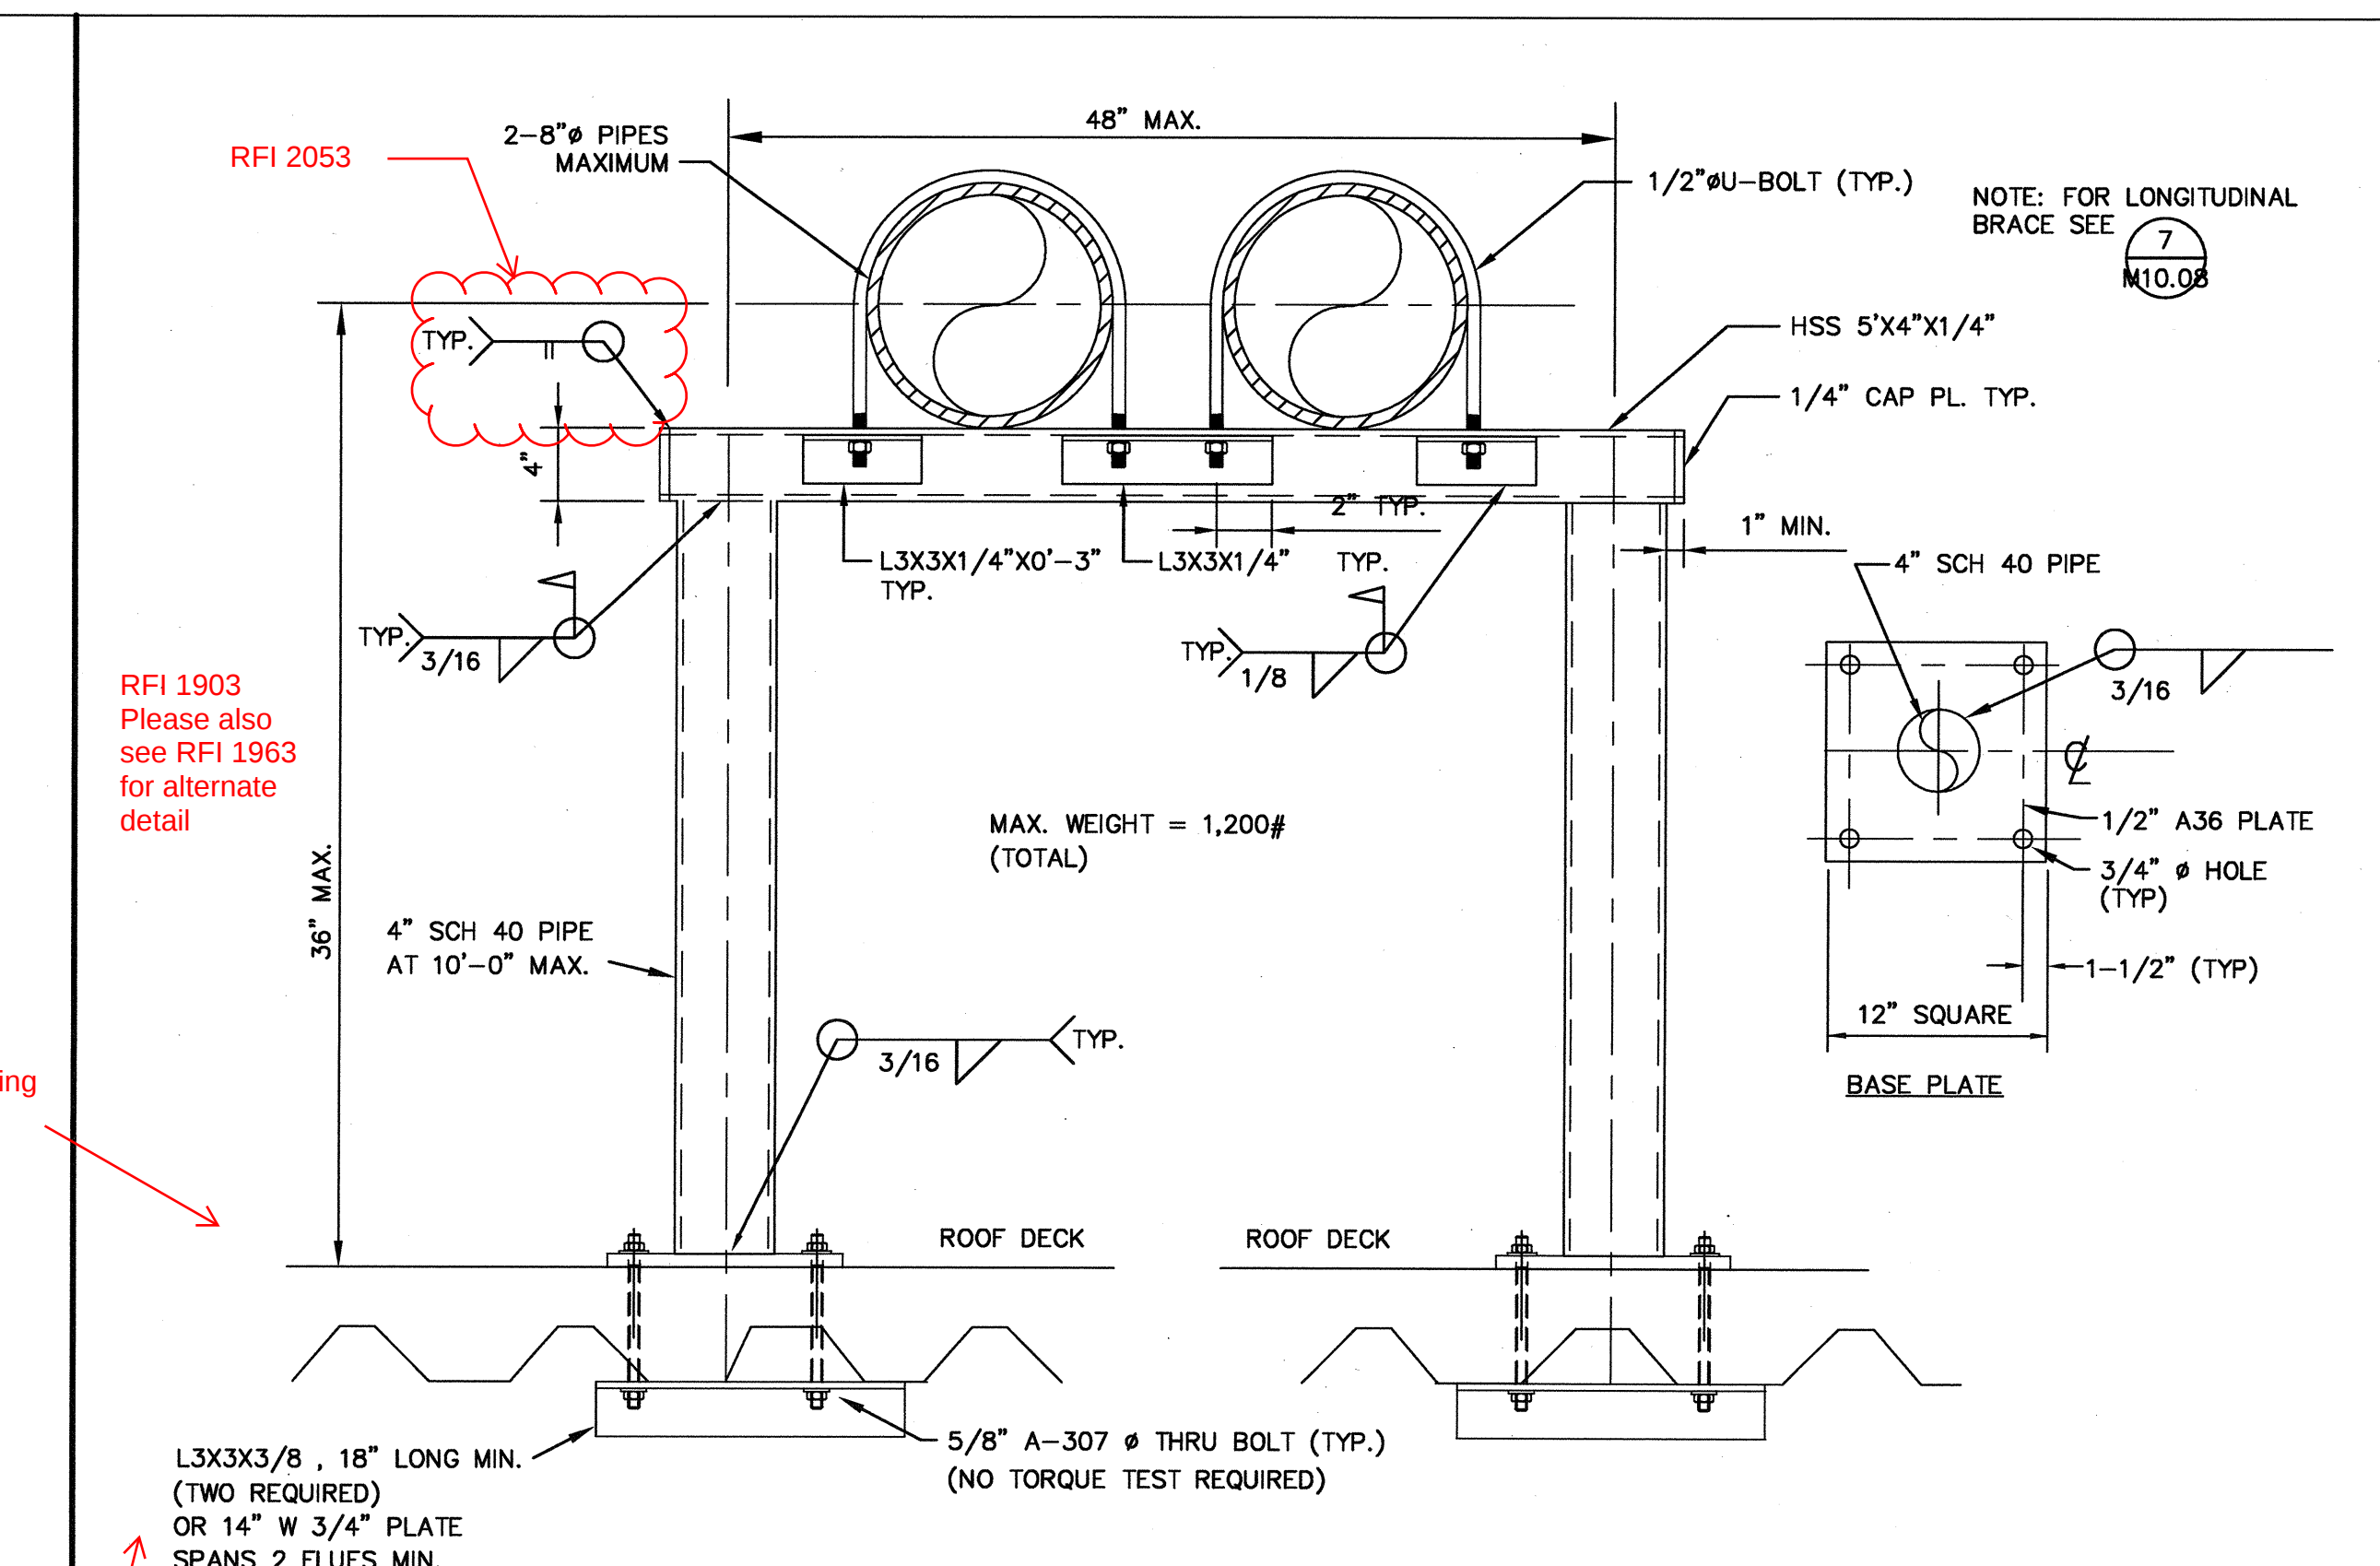


PIPE SUPPORT DETAIL PS-1 AT 10' O.C.

SCALE
NONE

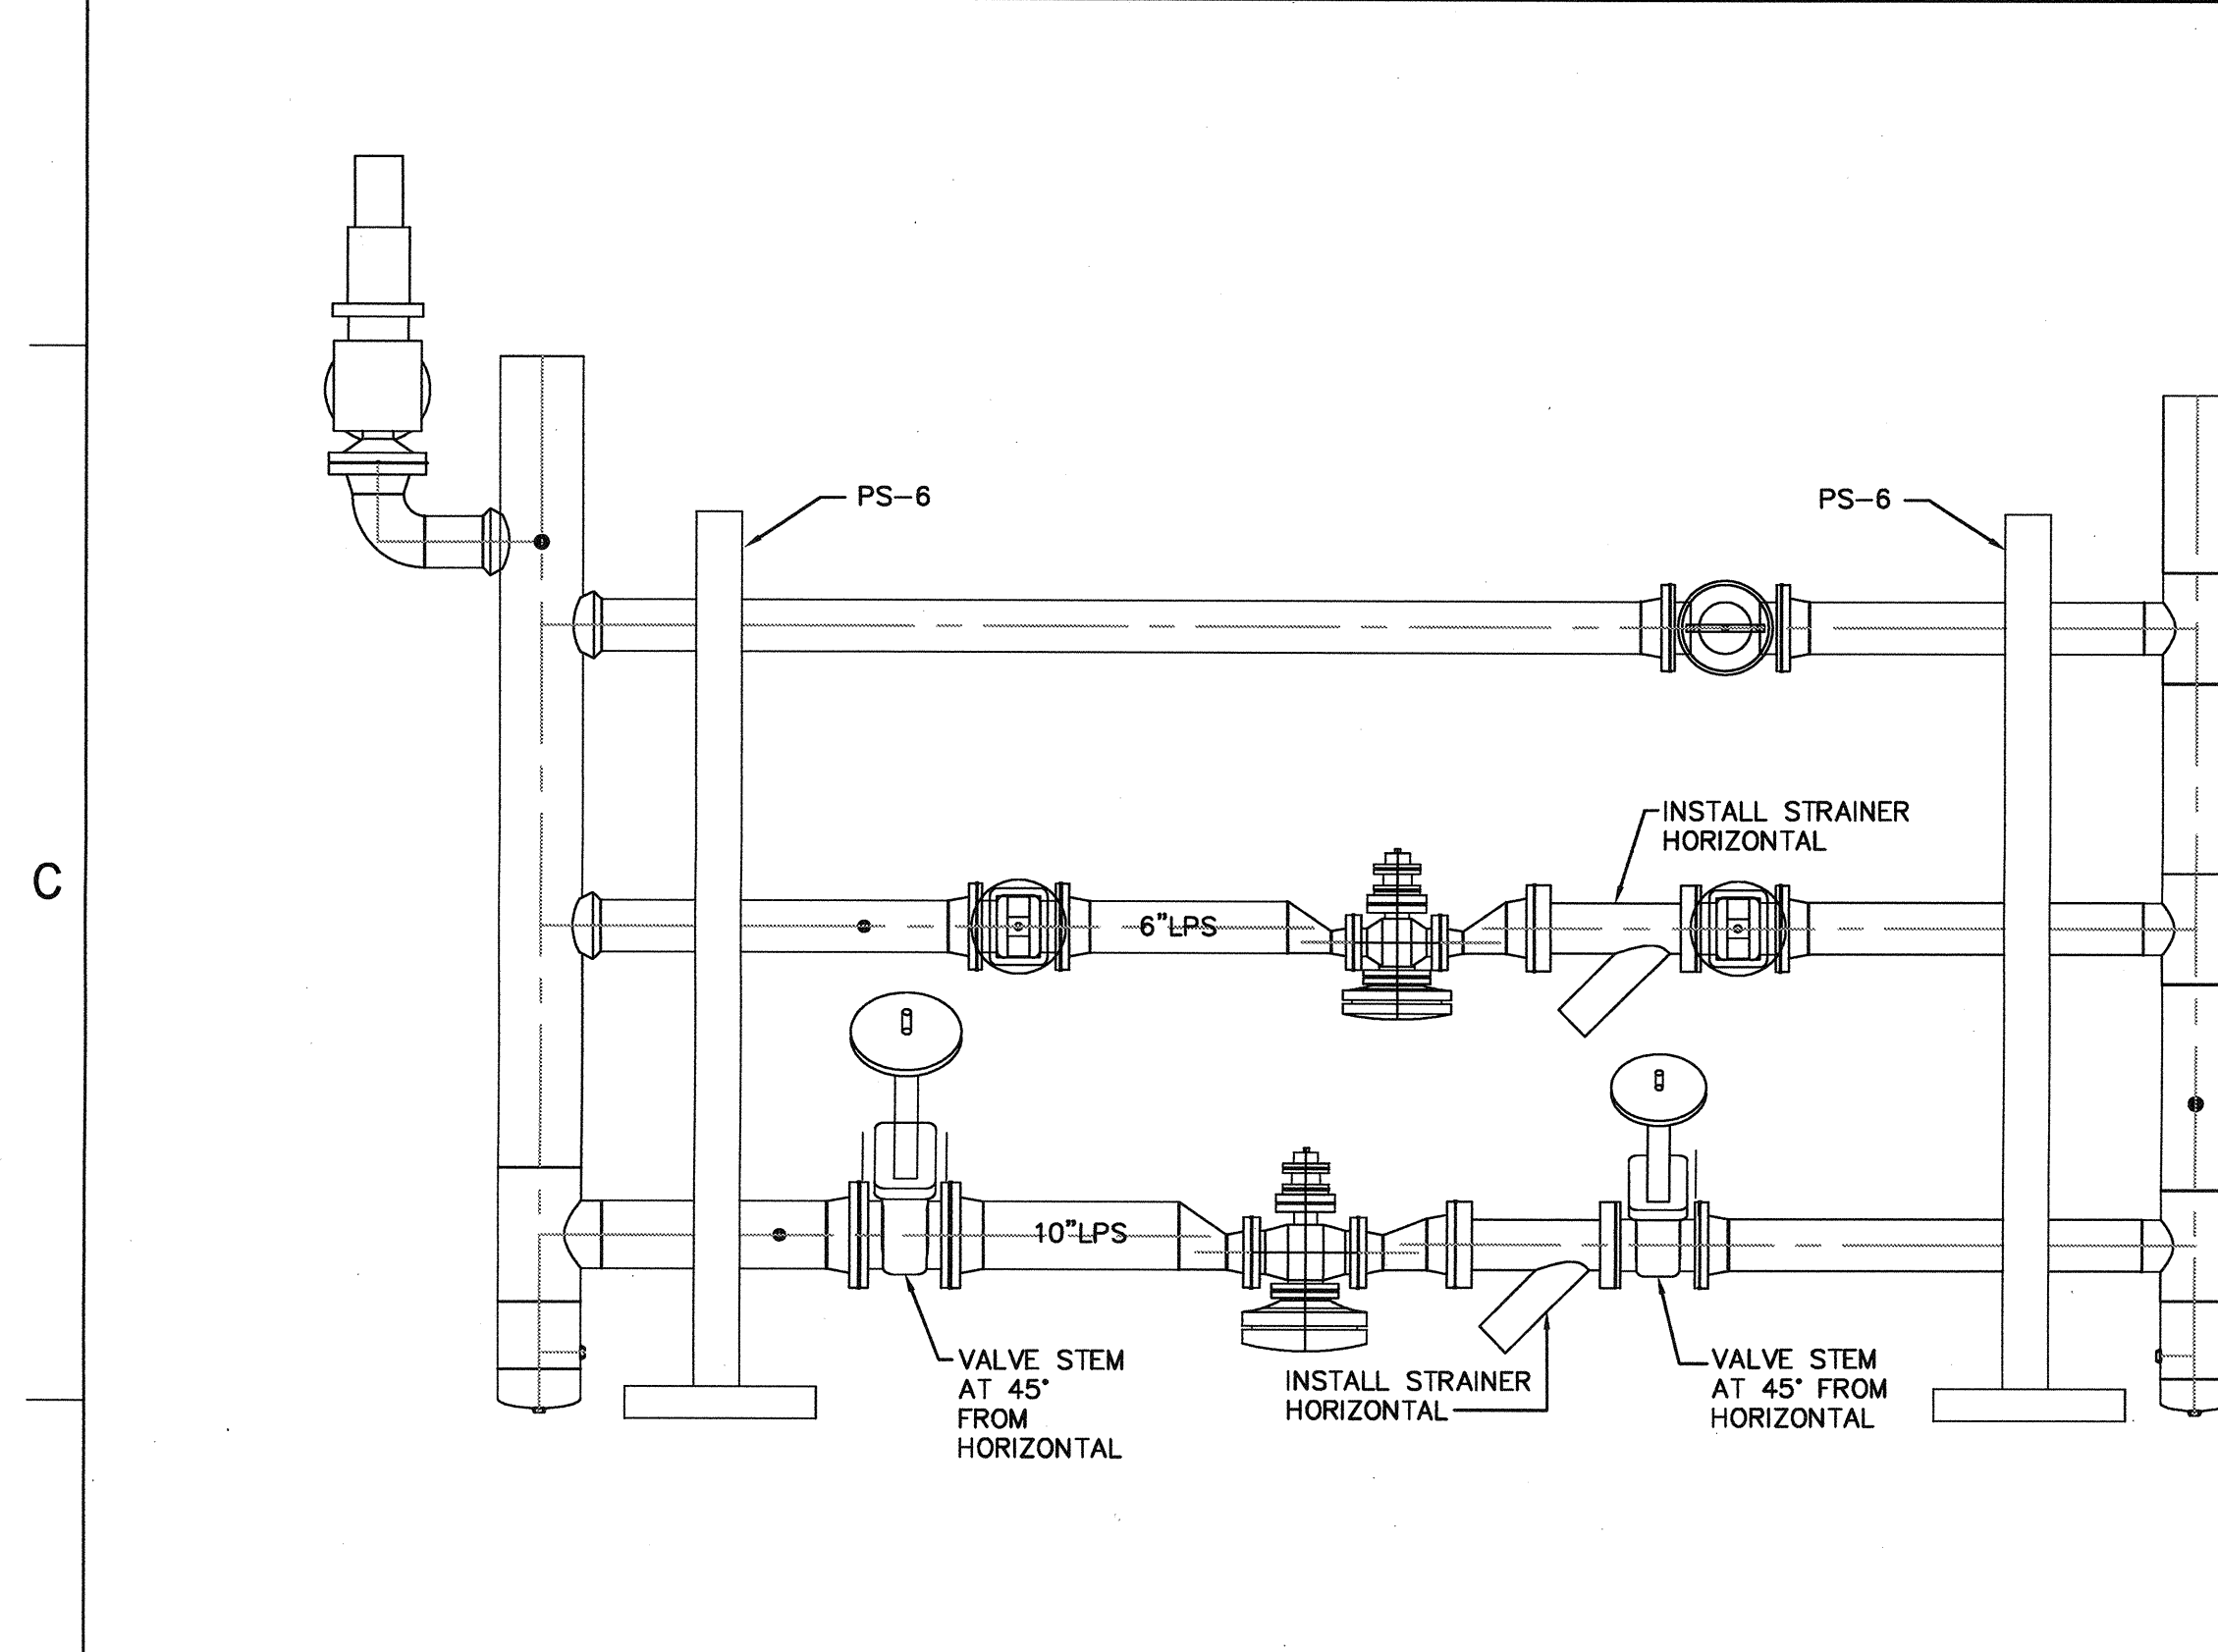


MEDIUM TO LOW PRESSURE PRV STATION #2, 3 AND 4 PIPING DETAIL

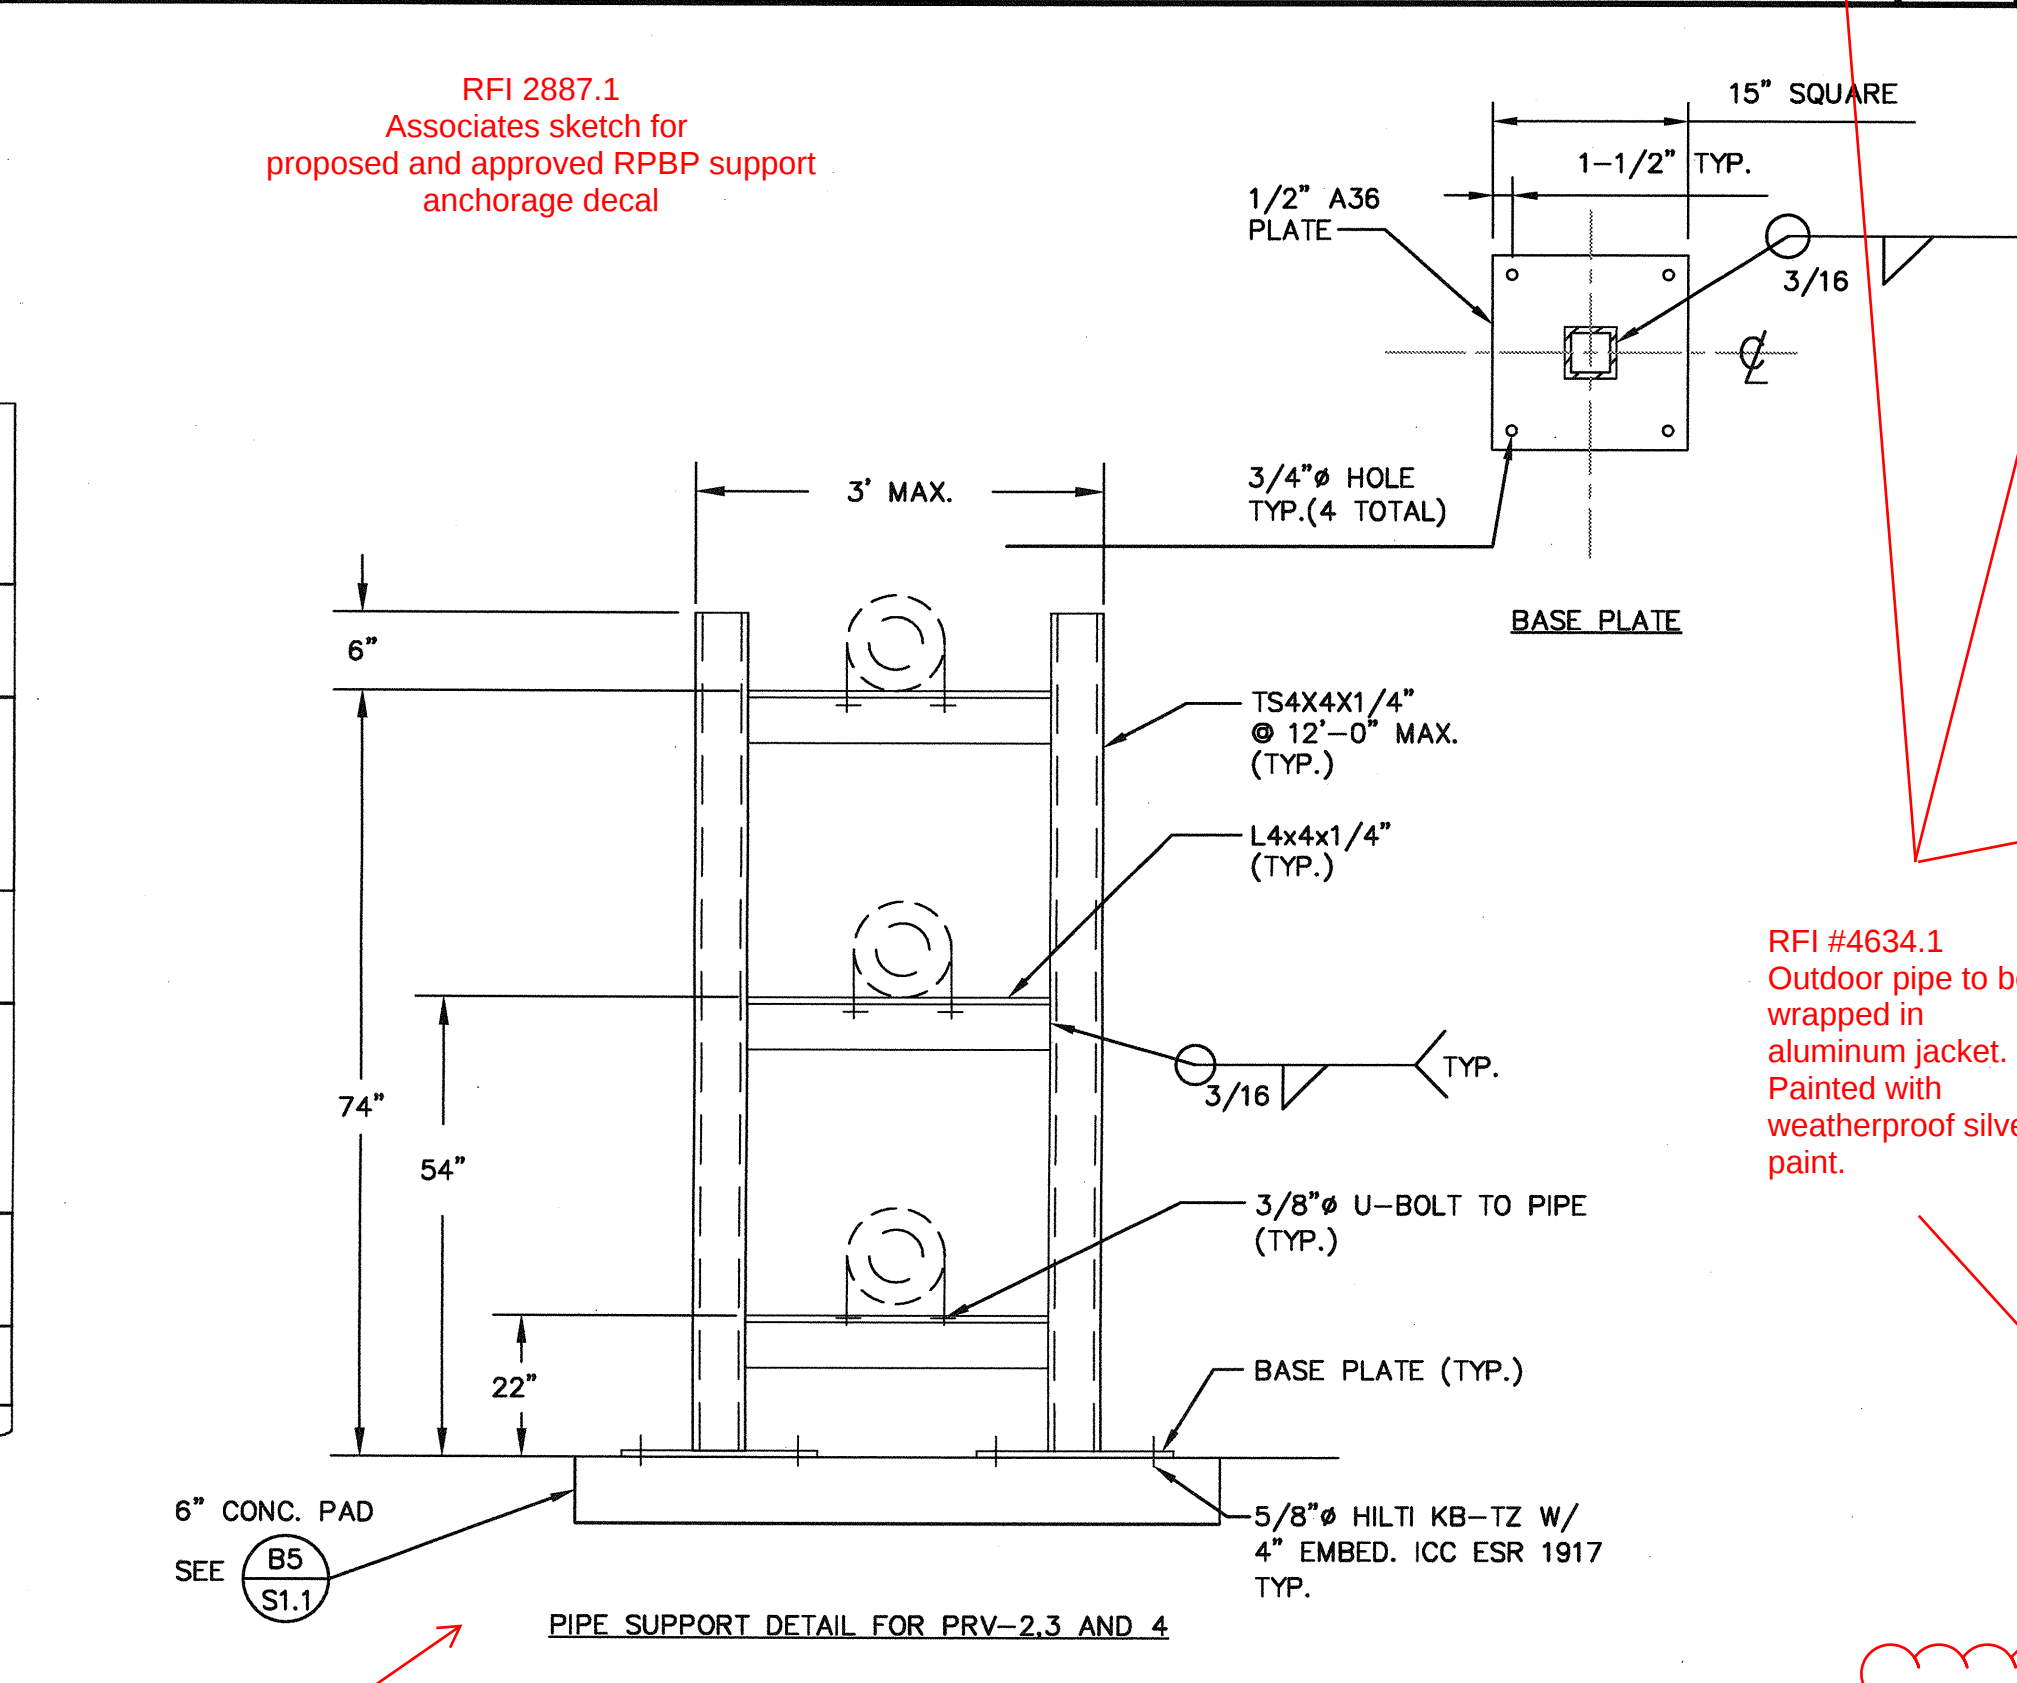


SUPPORT TYPE PS-6 (FOR BASEMENT)

SCALE
NONE

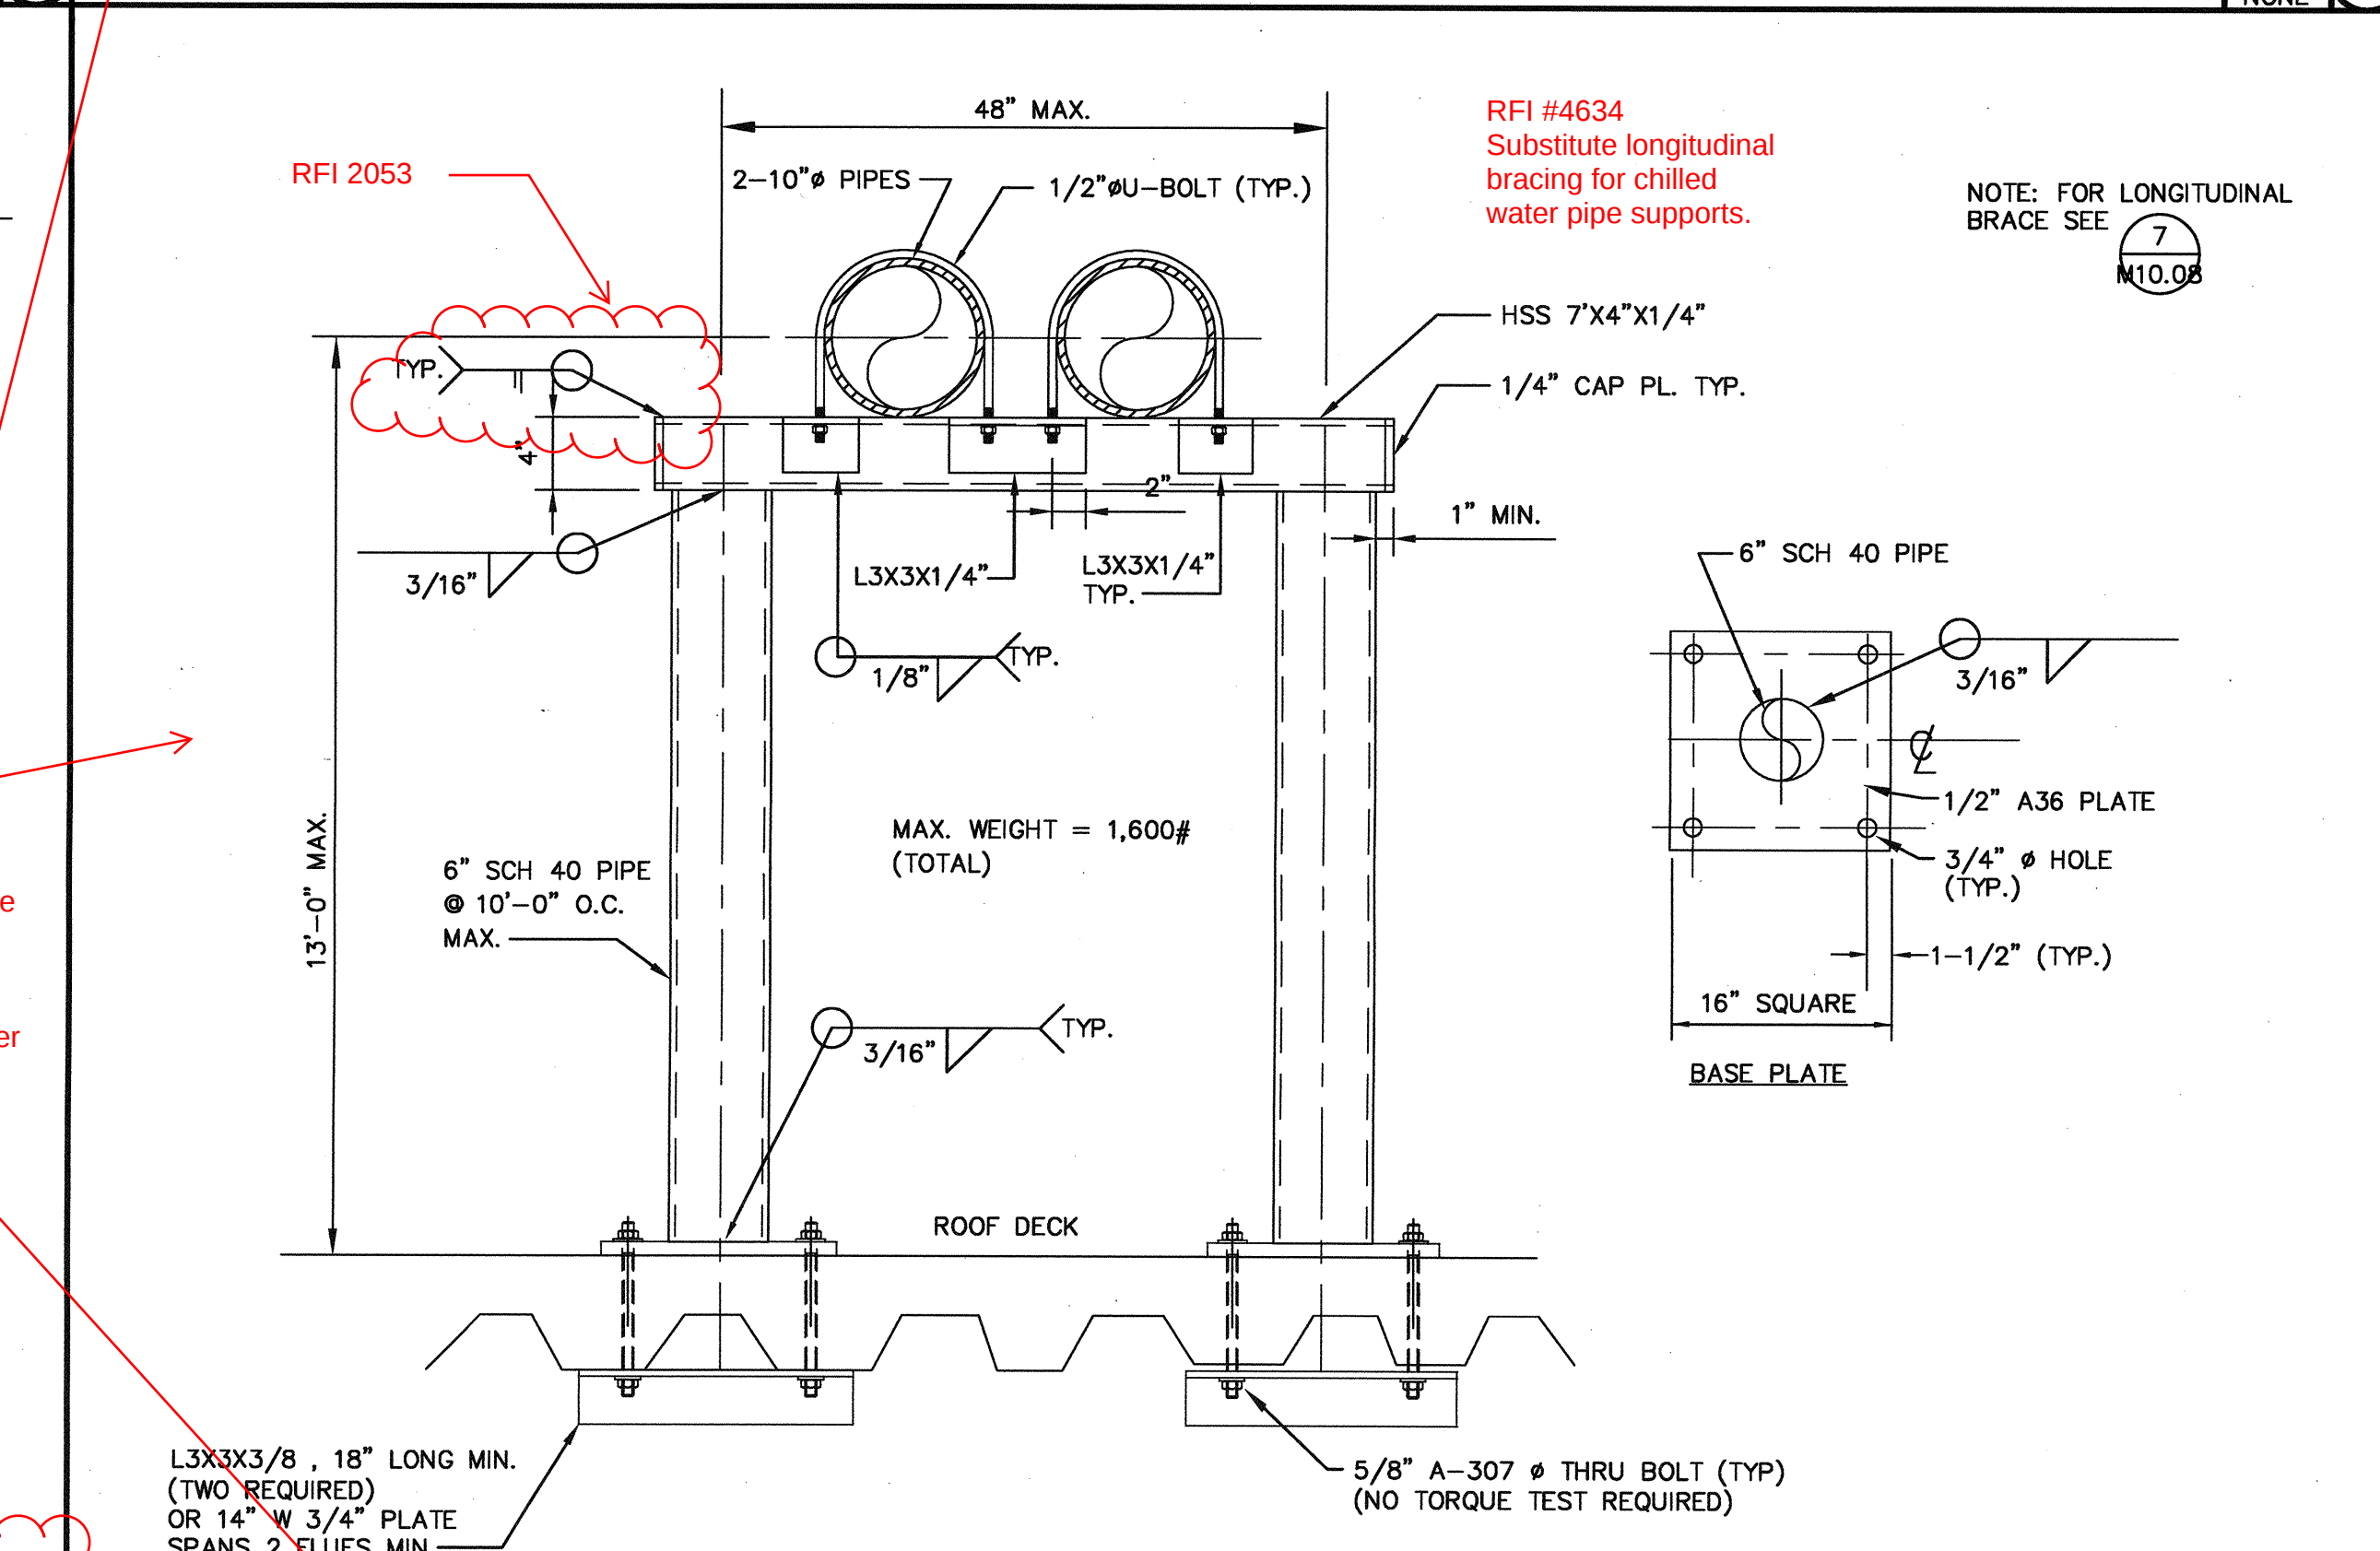


PIPE SUPPORT DETAIL PS-2 AT 10' O.C.

SCALE
NONE

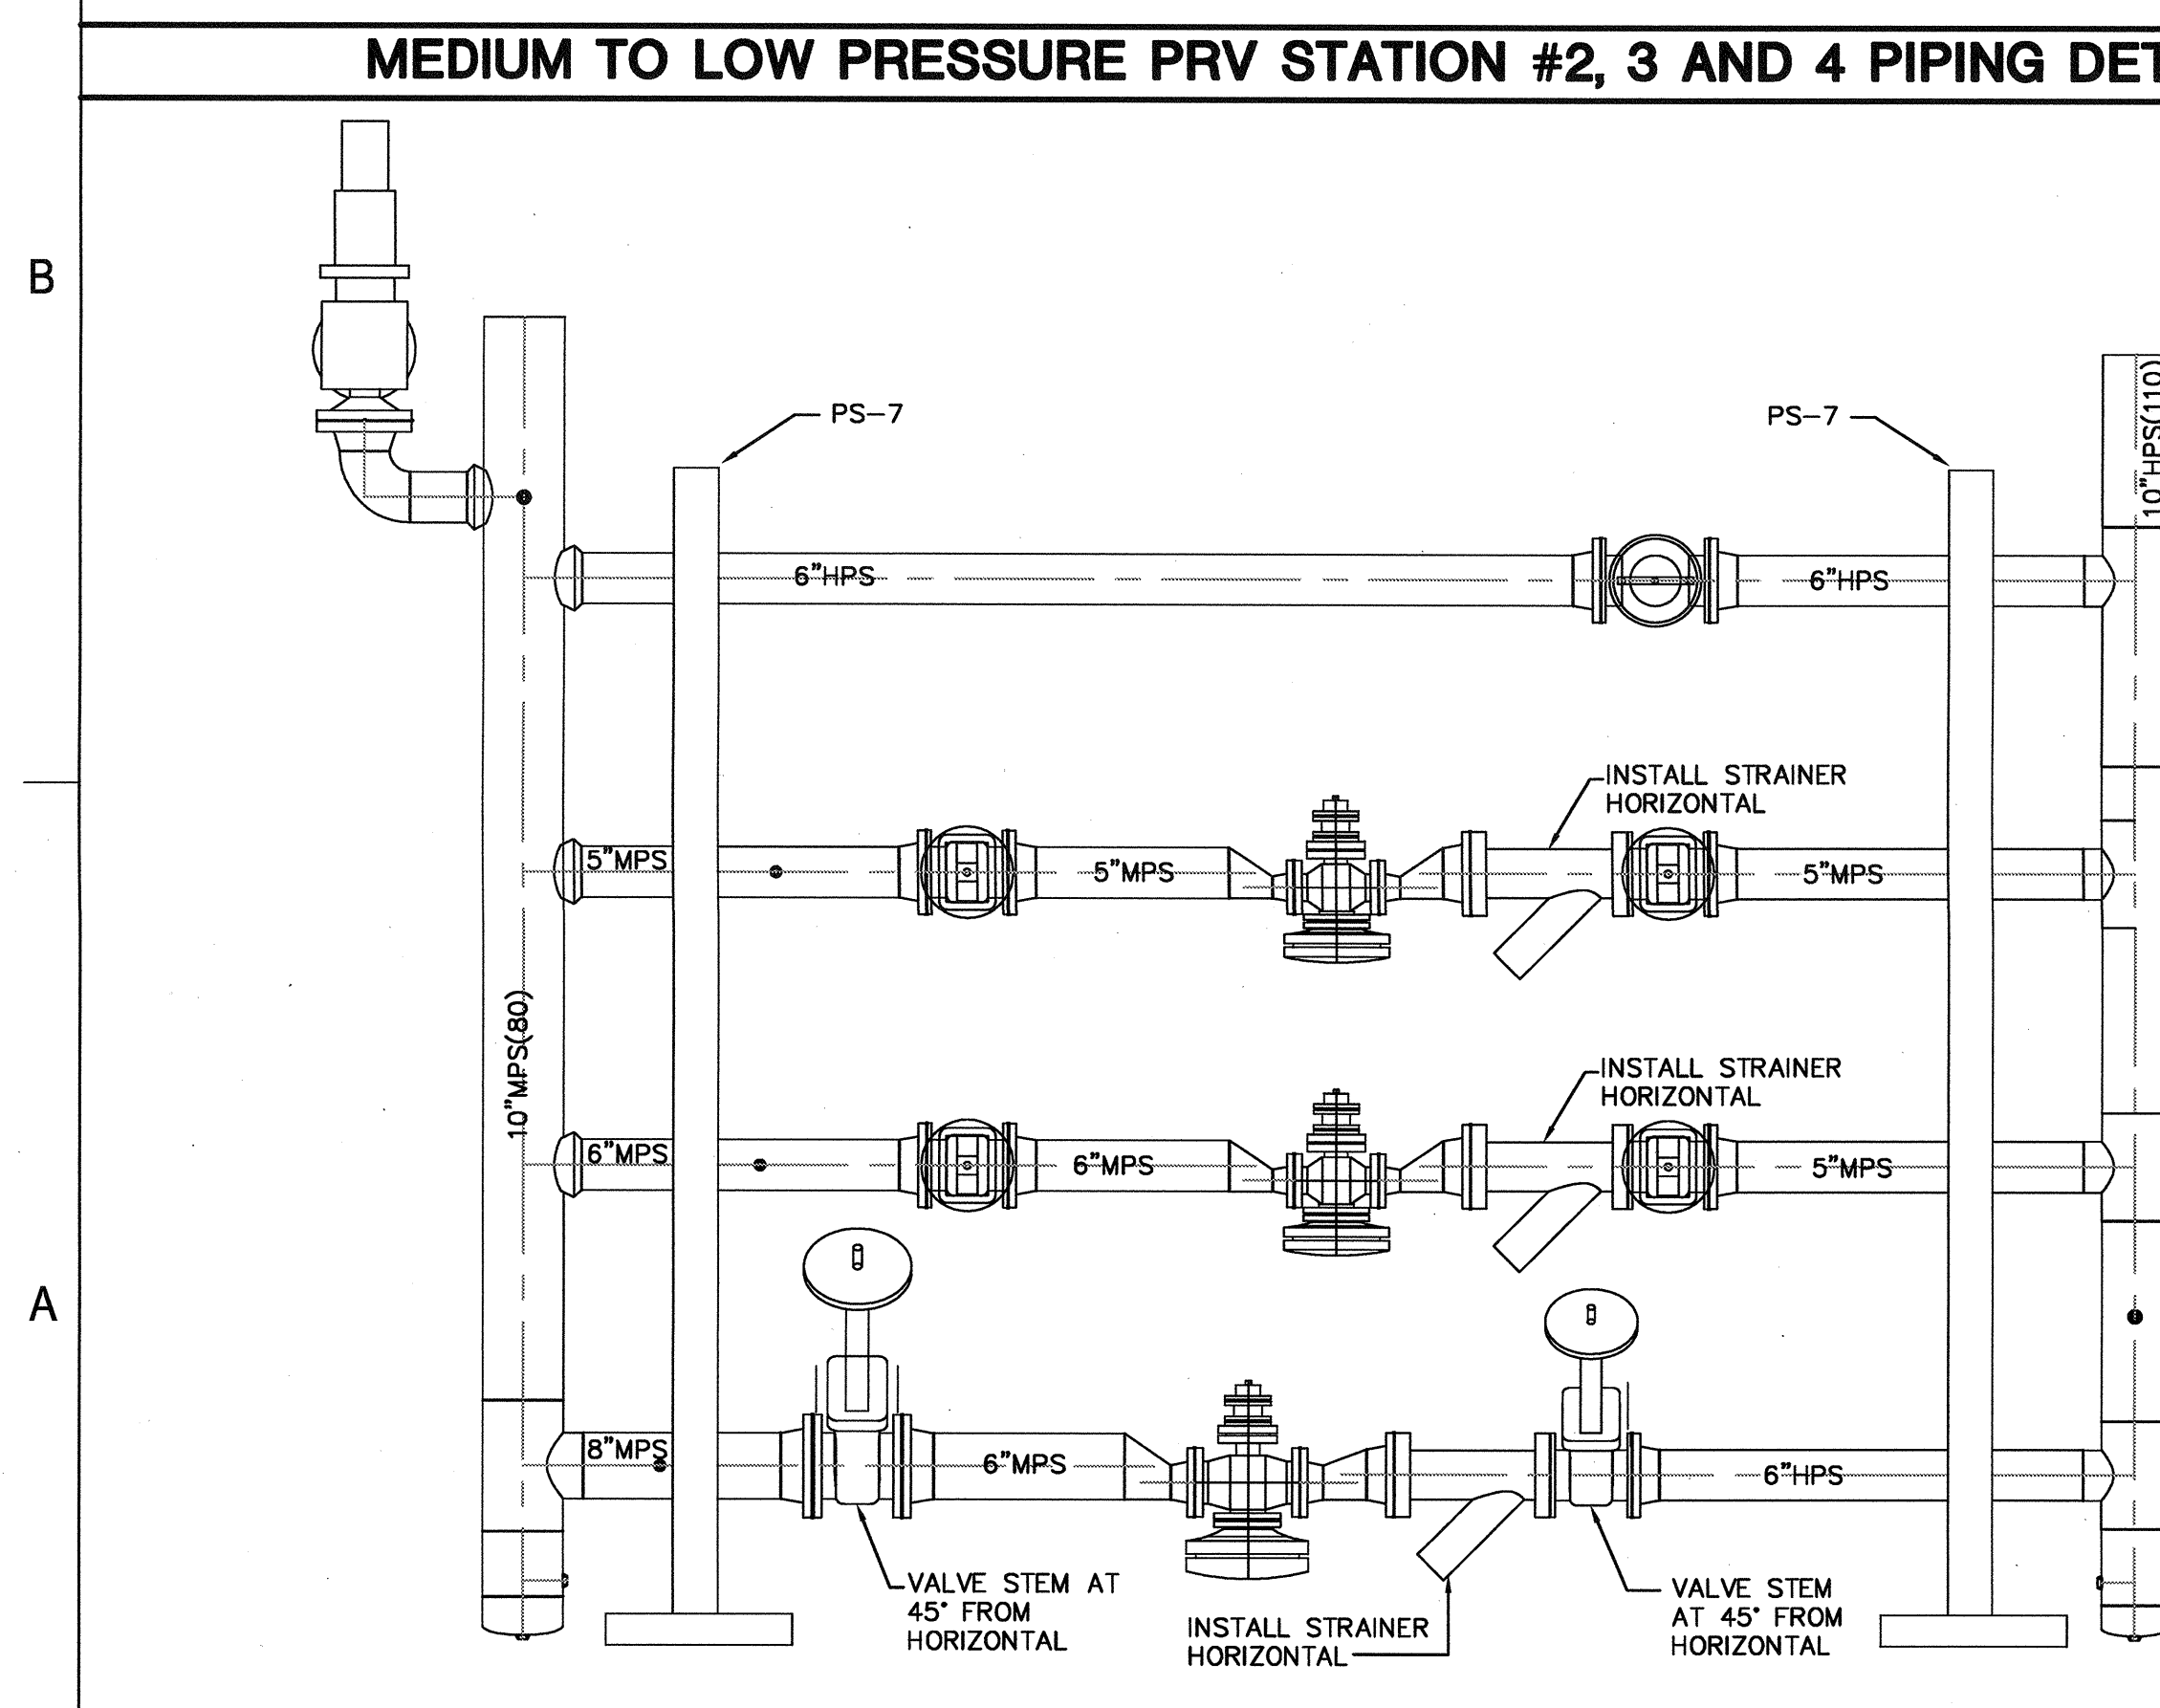


HIGH TO MEDIUM PRESSURE PRV STATION #1 PIPING DETAIL

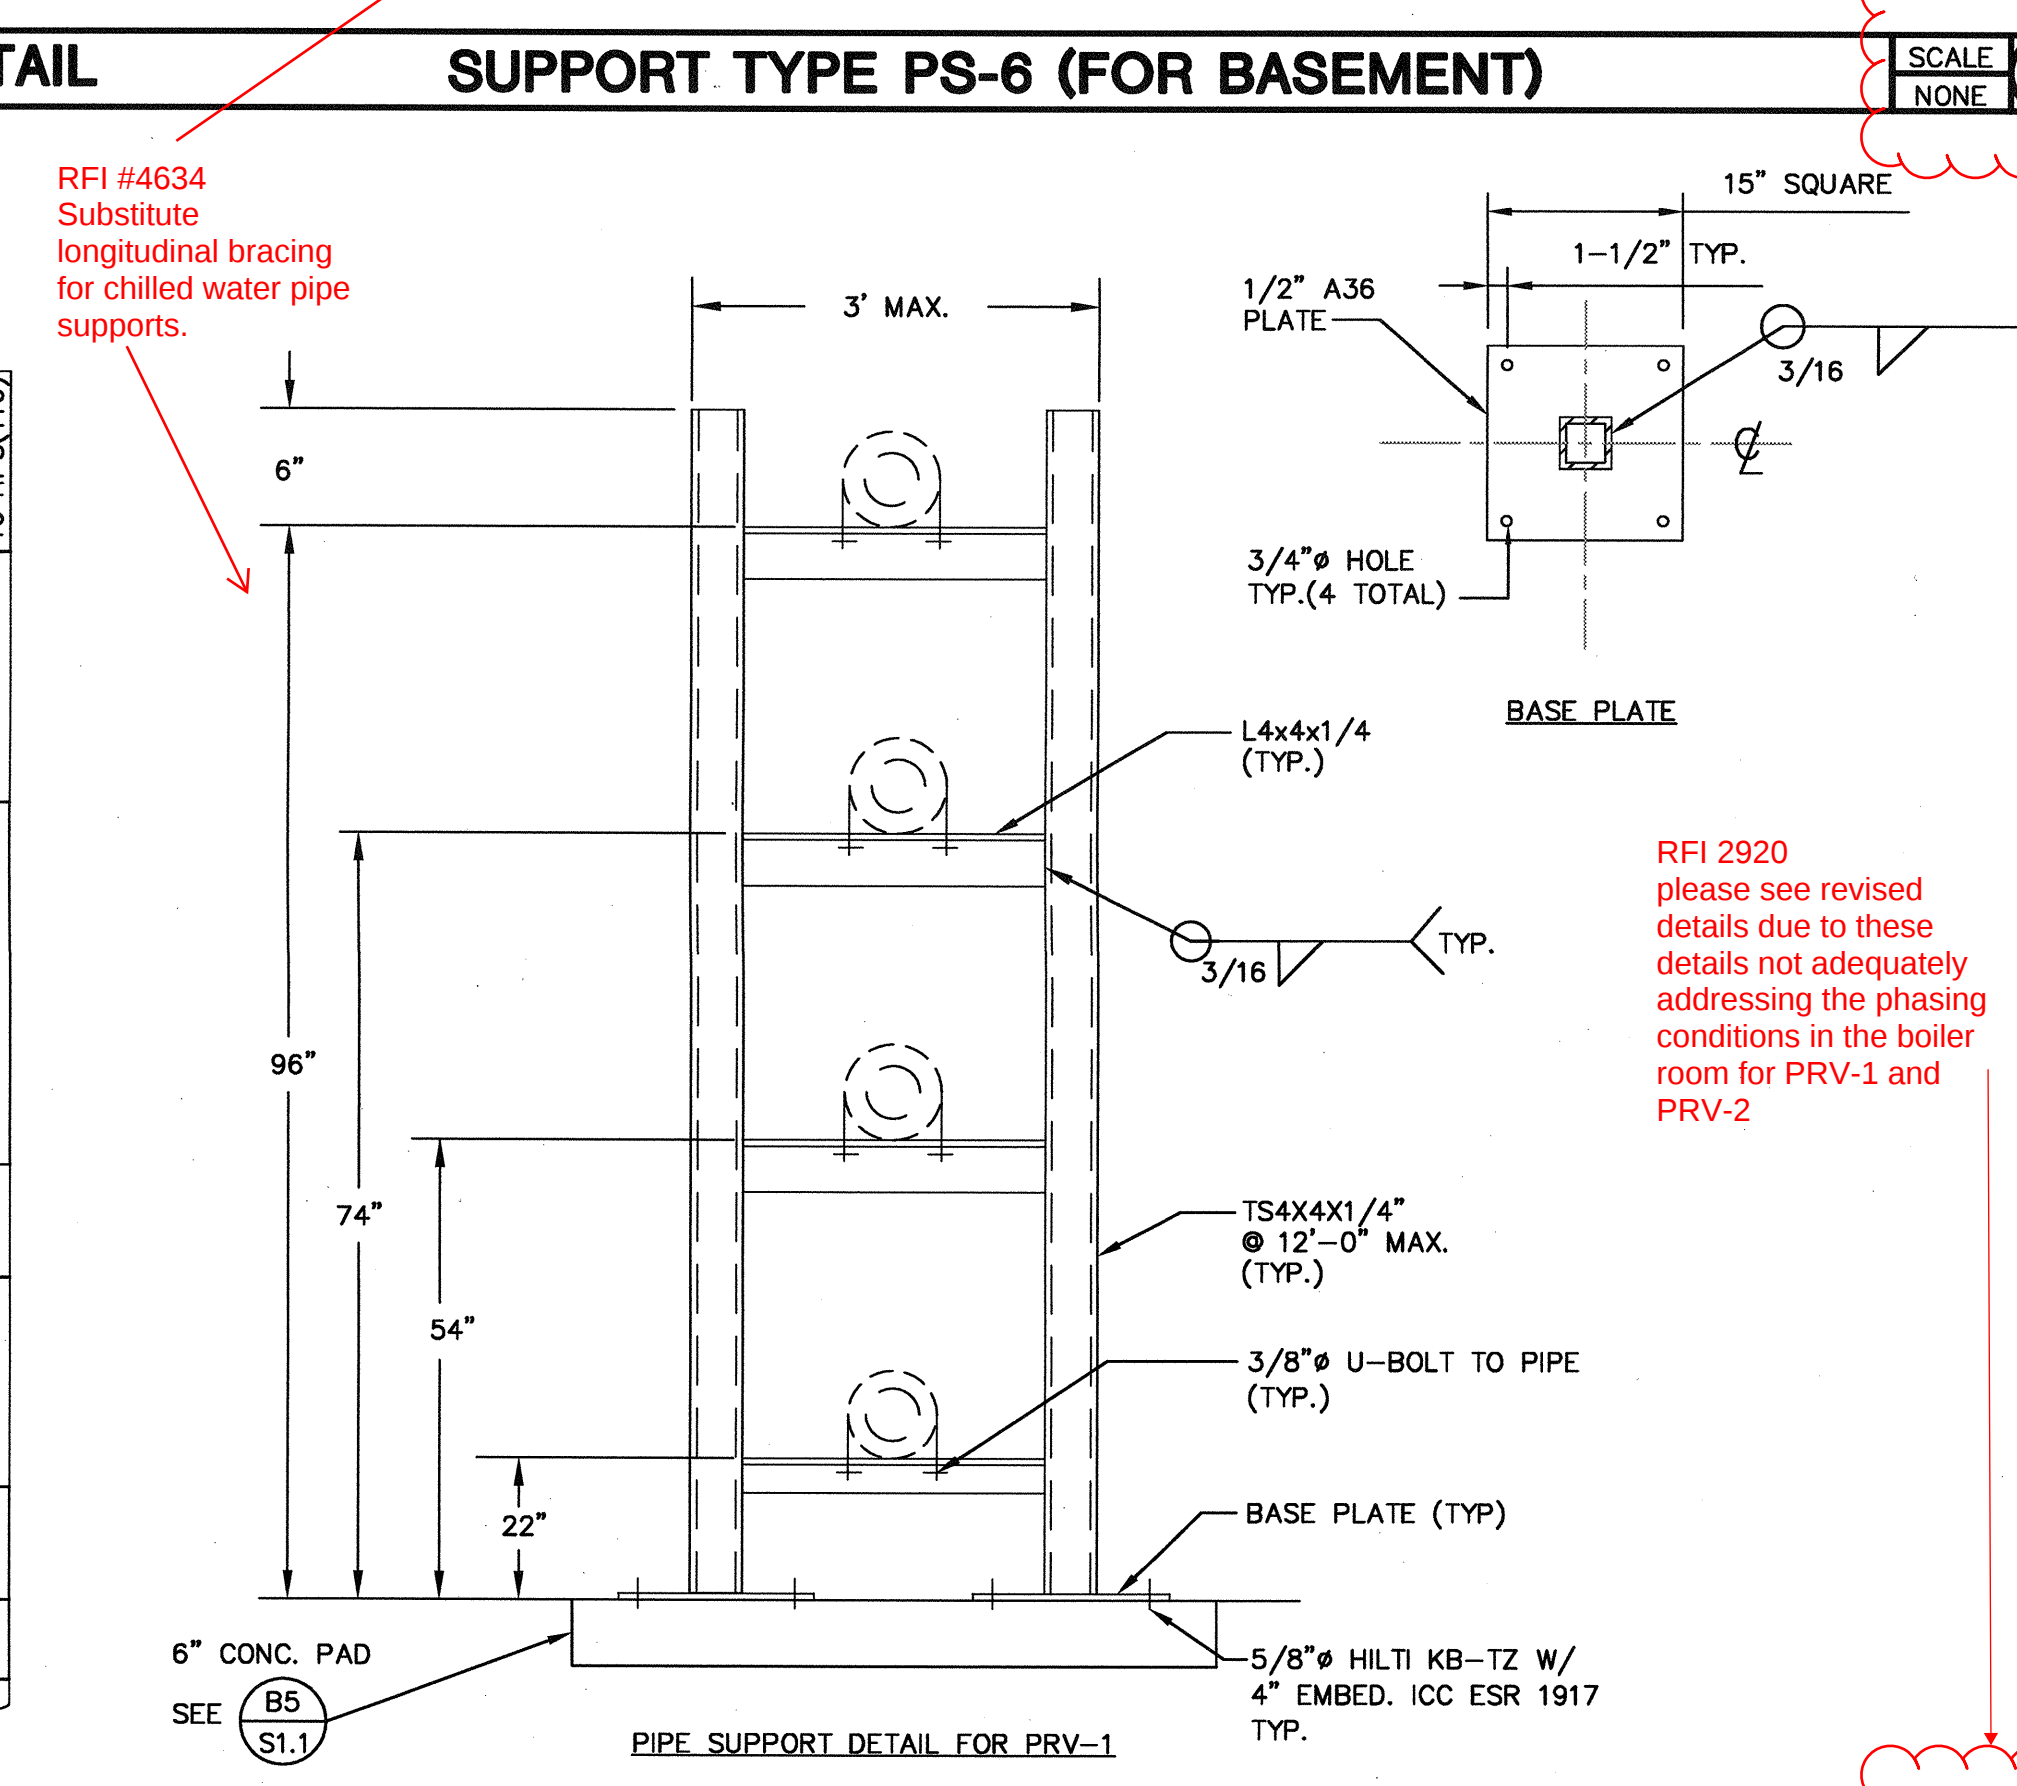


PIPE SUPPORT TYPE PS-7 (FOR BASEMENT)

SCALE
NONE

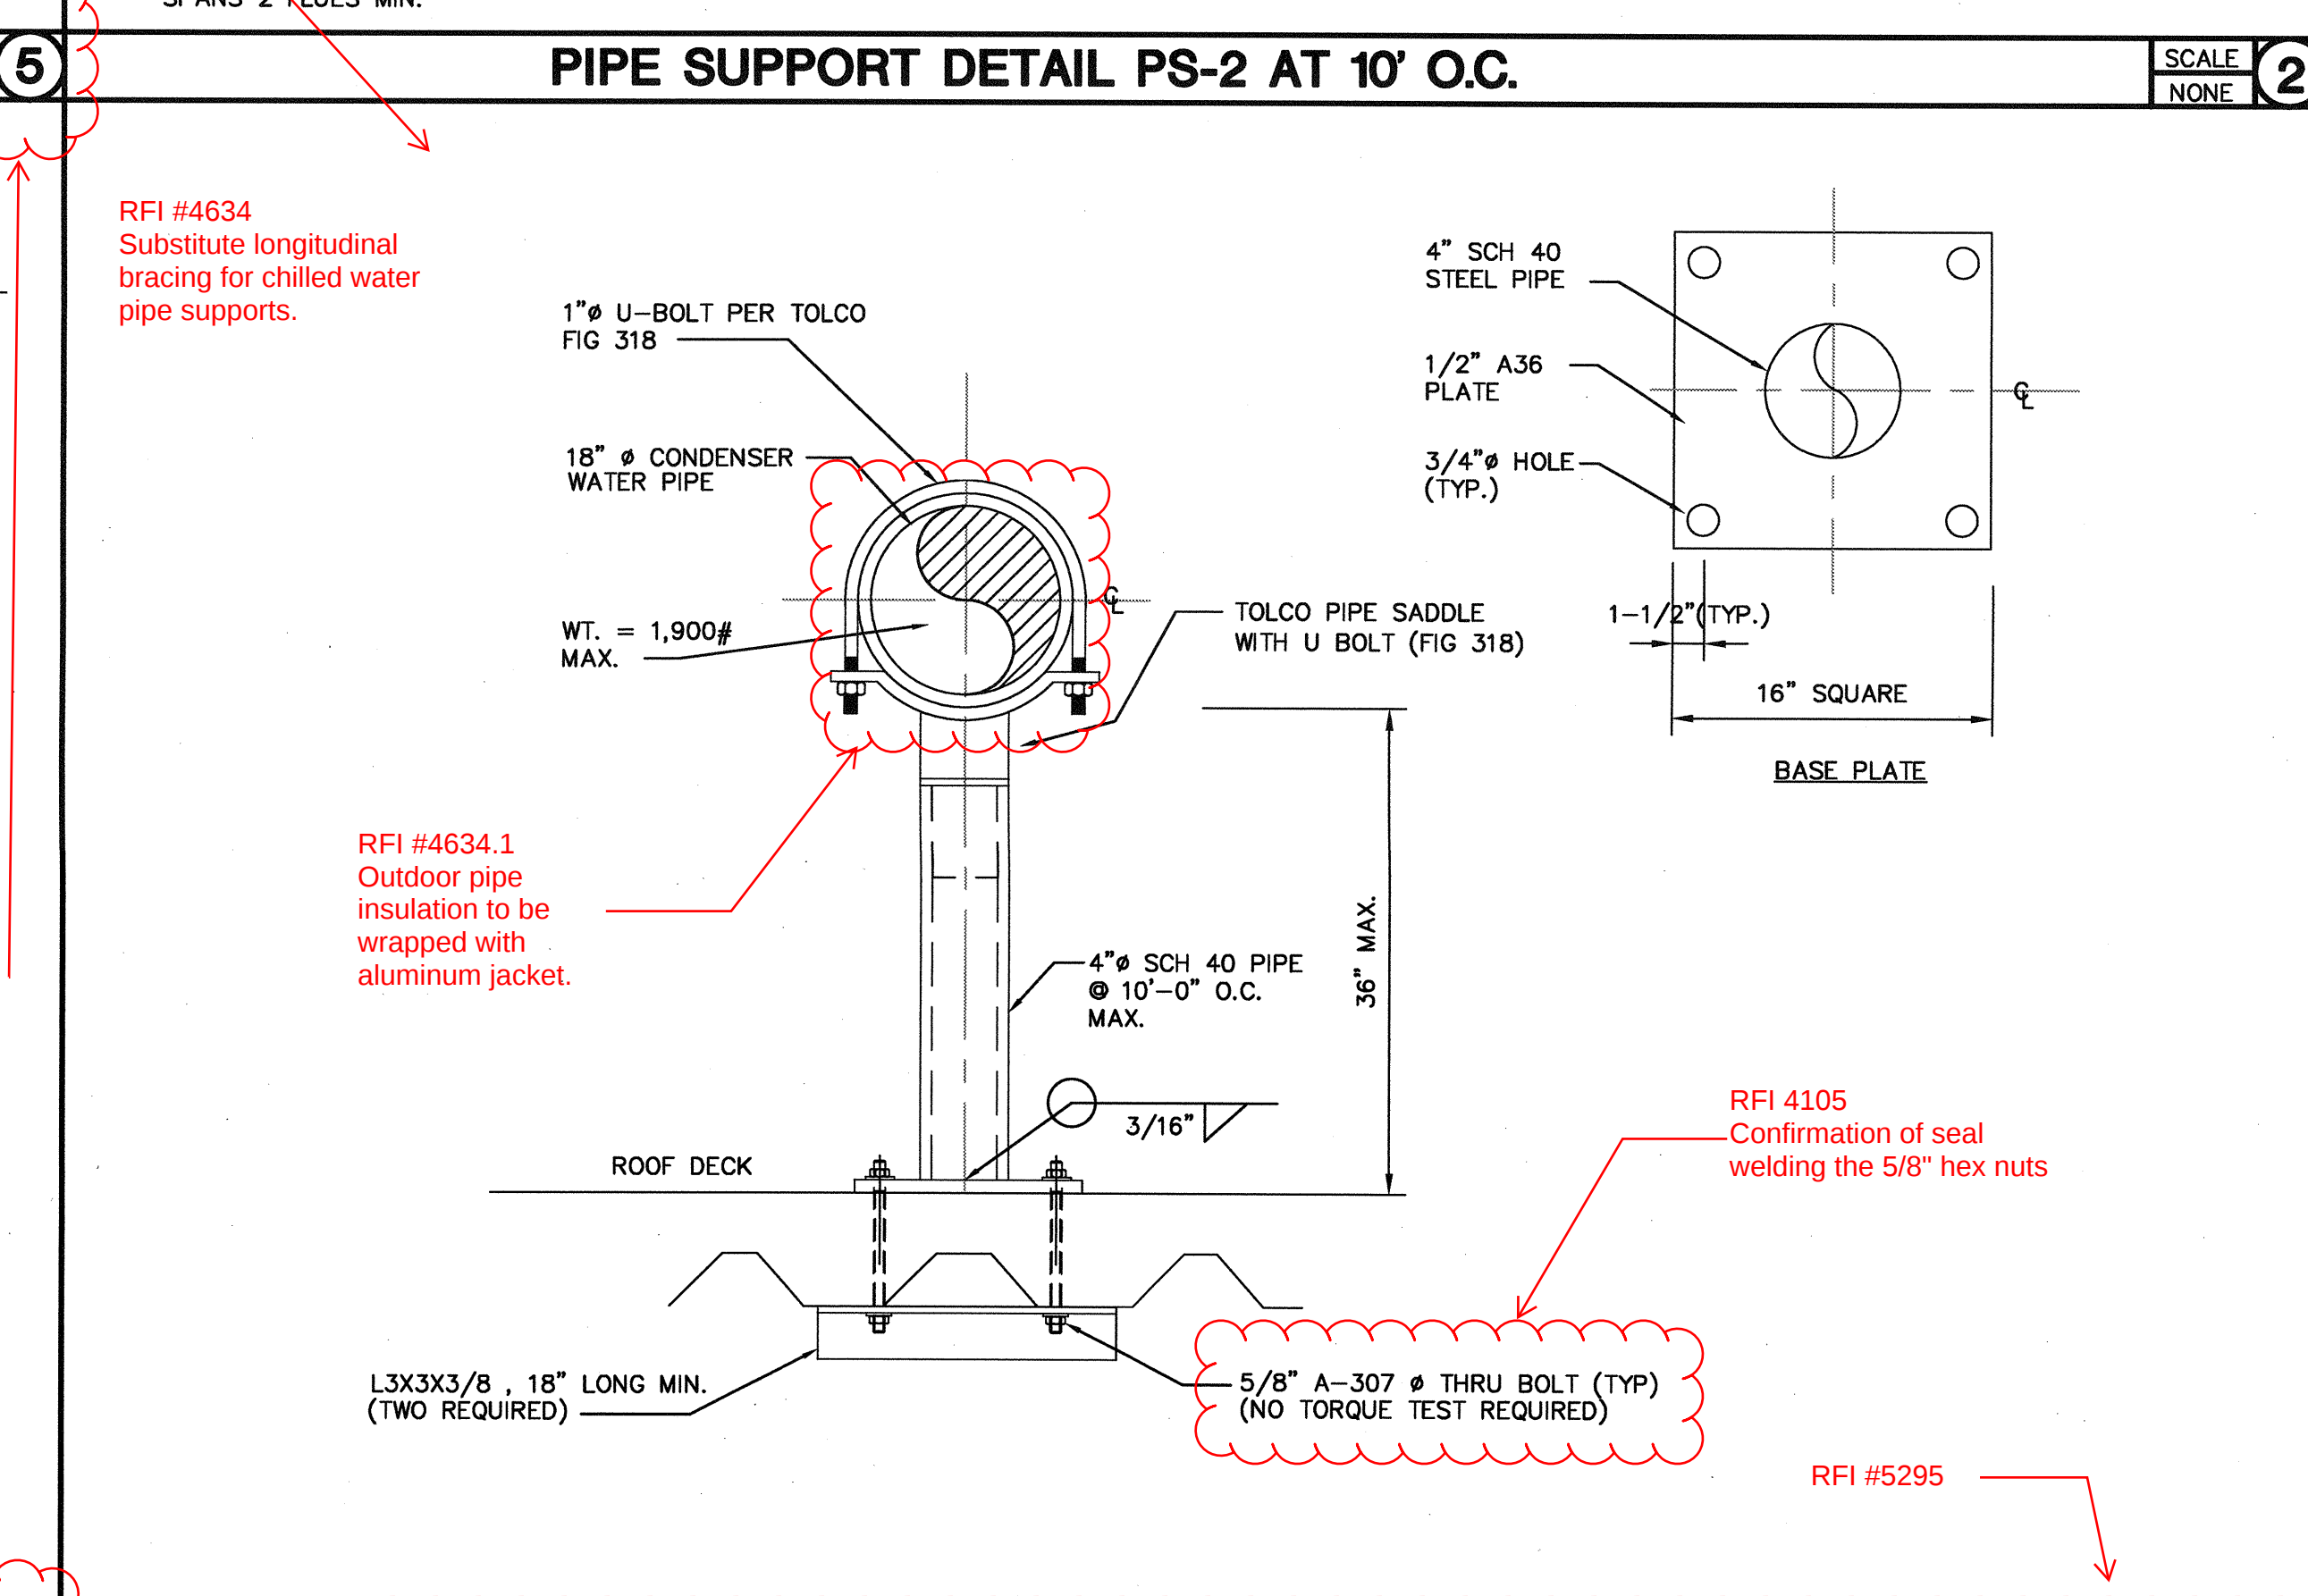

PIPE SUPPORT DETAIL PS-3 AT 10' O.C.

SCALE
NONE

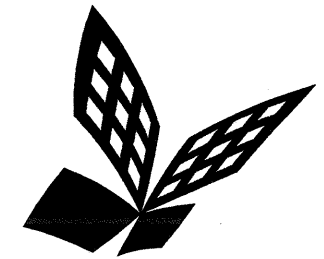

FKP Architects

ARCHITECT OF RECORD

"Architect of Record signature line only; this drawing was not prepared under the direct supervision of the Architect of Record. The direct responsibility for preparation of this sheet lies with its corresponding professional stamp and signature. The signature of the Architect of Record in general responsible for the project is provided as required by Title 24, Part 1, Section 7-115 (a)." ARCHITECT - PAUL C. GLORIO

CONSULTANT

T.M.A.D. TAYLOR & GAINES

100 South Anaheim Boulevard, Suite 150
Anaheim, California 92805
Phone: 714.490.5555 Fax: 714.490.5560
Project No. 2305-163-07



REVISIONS

APPROVAL



PROJECT NAME

CHILDREN'S HOSPITAL
OF ORANGE COUNTY
455 S. Main St.
Orange, CA 92668-3874

TOWER II



PROJECT NUMBER

12011.00
Increment #7

OSHPD - PROJECT NUMBER
IL 072072-30

ISSUE

OSHPD PERMIT

DATE

01/27/2010

SCALE

DRAWING TITLE

MECHANICAL DETAILS -
PIPE SUPPORT DETAILS

RFI #3944

Temperature controls conduit
acceptable to attach to pipe and duct
supports on roof.

DRAWING NUMBER

M10.06