

FKP Architects

ARCHITECT OF RECORD


"Architect of Record signature line only; this drawing was not prepared under the direct supervision of the Architect of Record. The direct responsibility for preparation of this sheet lies with its corresponding professional stamp and signature. The signature of the Architect of Record in general responsible charge of the project is provided as required by Title 24, Part 1, Section 7-115 (a)."

ARCHITECT - PAUL C. GLORIOD

CONSULTANT

T M A D TAYLOR & GAINES
• STRUCTURAL
• MECHANICAL
• ELECTRICAL
• CIVIL

100 South Anaheim Boulevard, Suite 150
Anaheim, California 92805
Phone: 714.490.5555 Fax: 714.490.5560
Project No. 2305-163-07

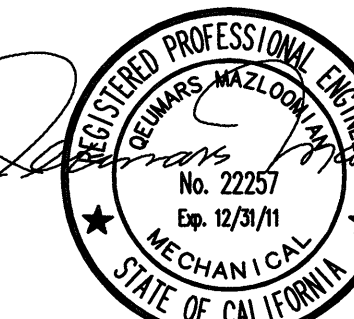


Changes on these drawings do not consist of materially altered changes to approved drawings and don't require a change order.
OSHPD review ACO
OSHPD review FLSO
OSHPD review DSE

REVISIONS

09/21/2011 CHANGE ORDER #278

 APPROVAL



CHANGE ORDER #278
INSTRUCTION BULLETIN
REVISION APPROVAL
DATE

PROJECT NAME

CHILDREN'S HOSPITAL
OF ORANGE COUNTY

455 S. Main St.
Orange, CA 92868-3874

RECEIVED
TOWER II September 21 2011
McCarthy



PROJECT NUMBER

12011.00
Increment #7

OSHPD - PROJECT NUMBER
IL 072072-30

ISSUE

OSHPD PERMIT

DATE

01/27/2010


SCALE

DRAWING TITLE

MECHANICAL DETAILS -
HVAC EQUIPMENT -
ANCHORAGE DETAILS


DRAWING NUMBER

M10.07

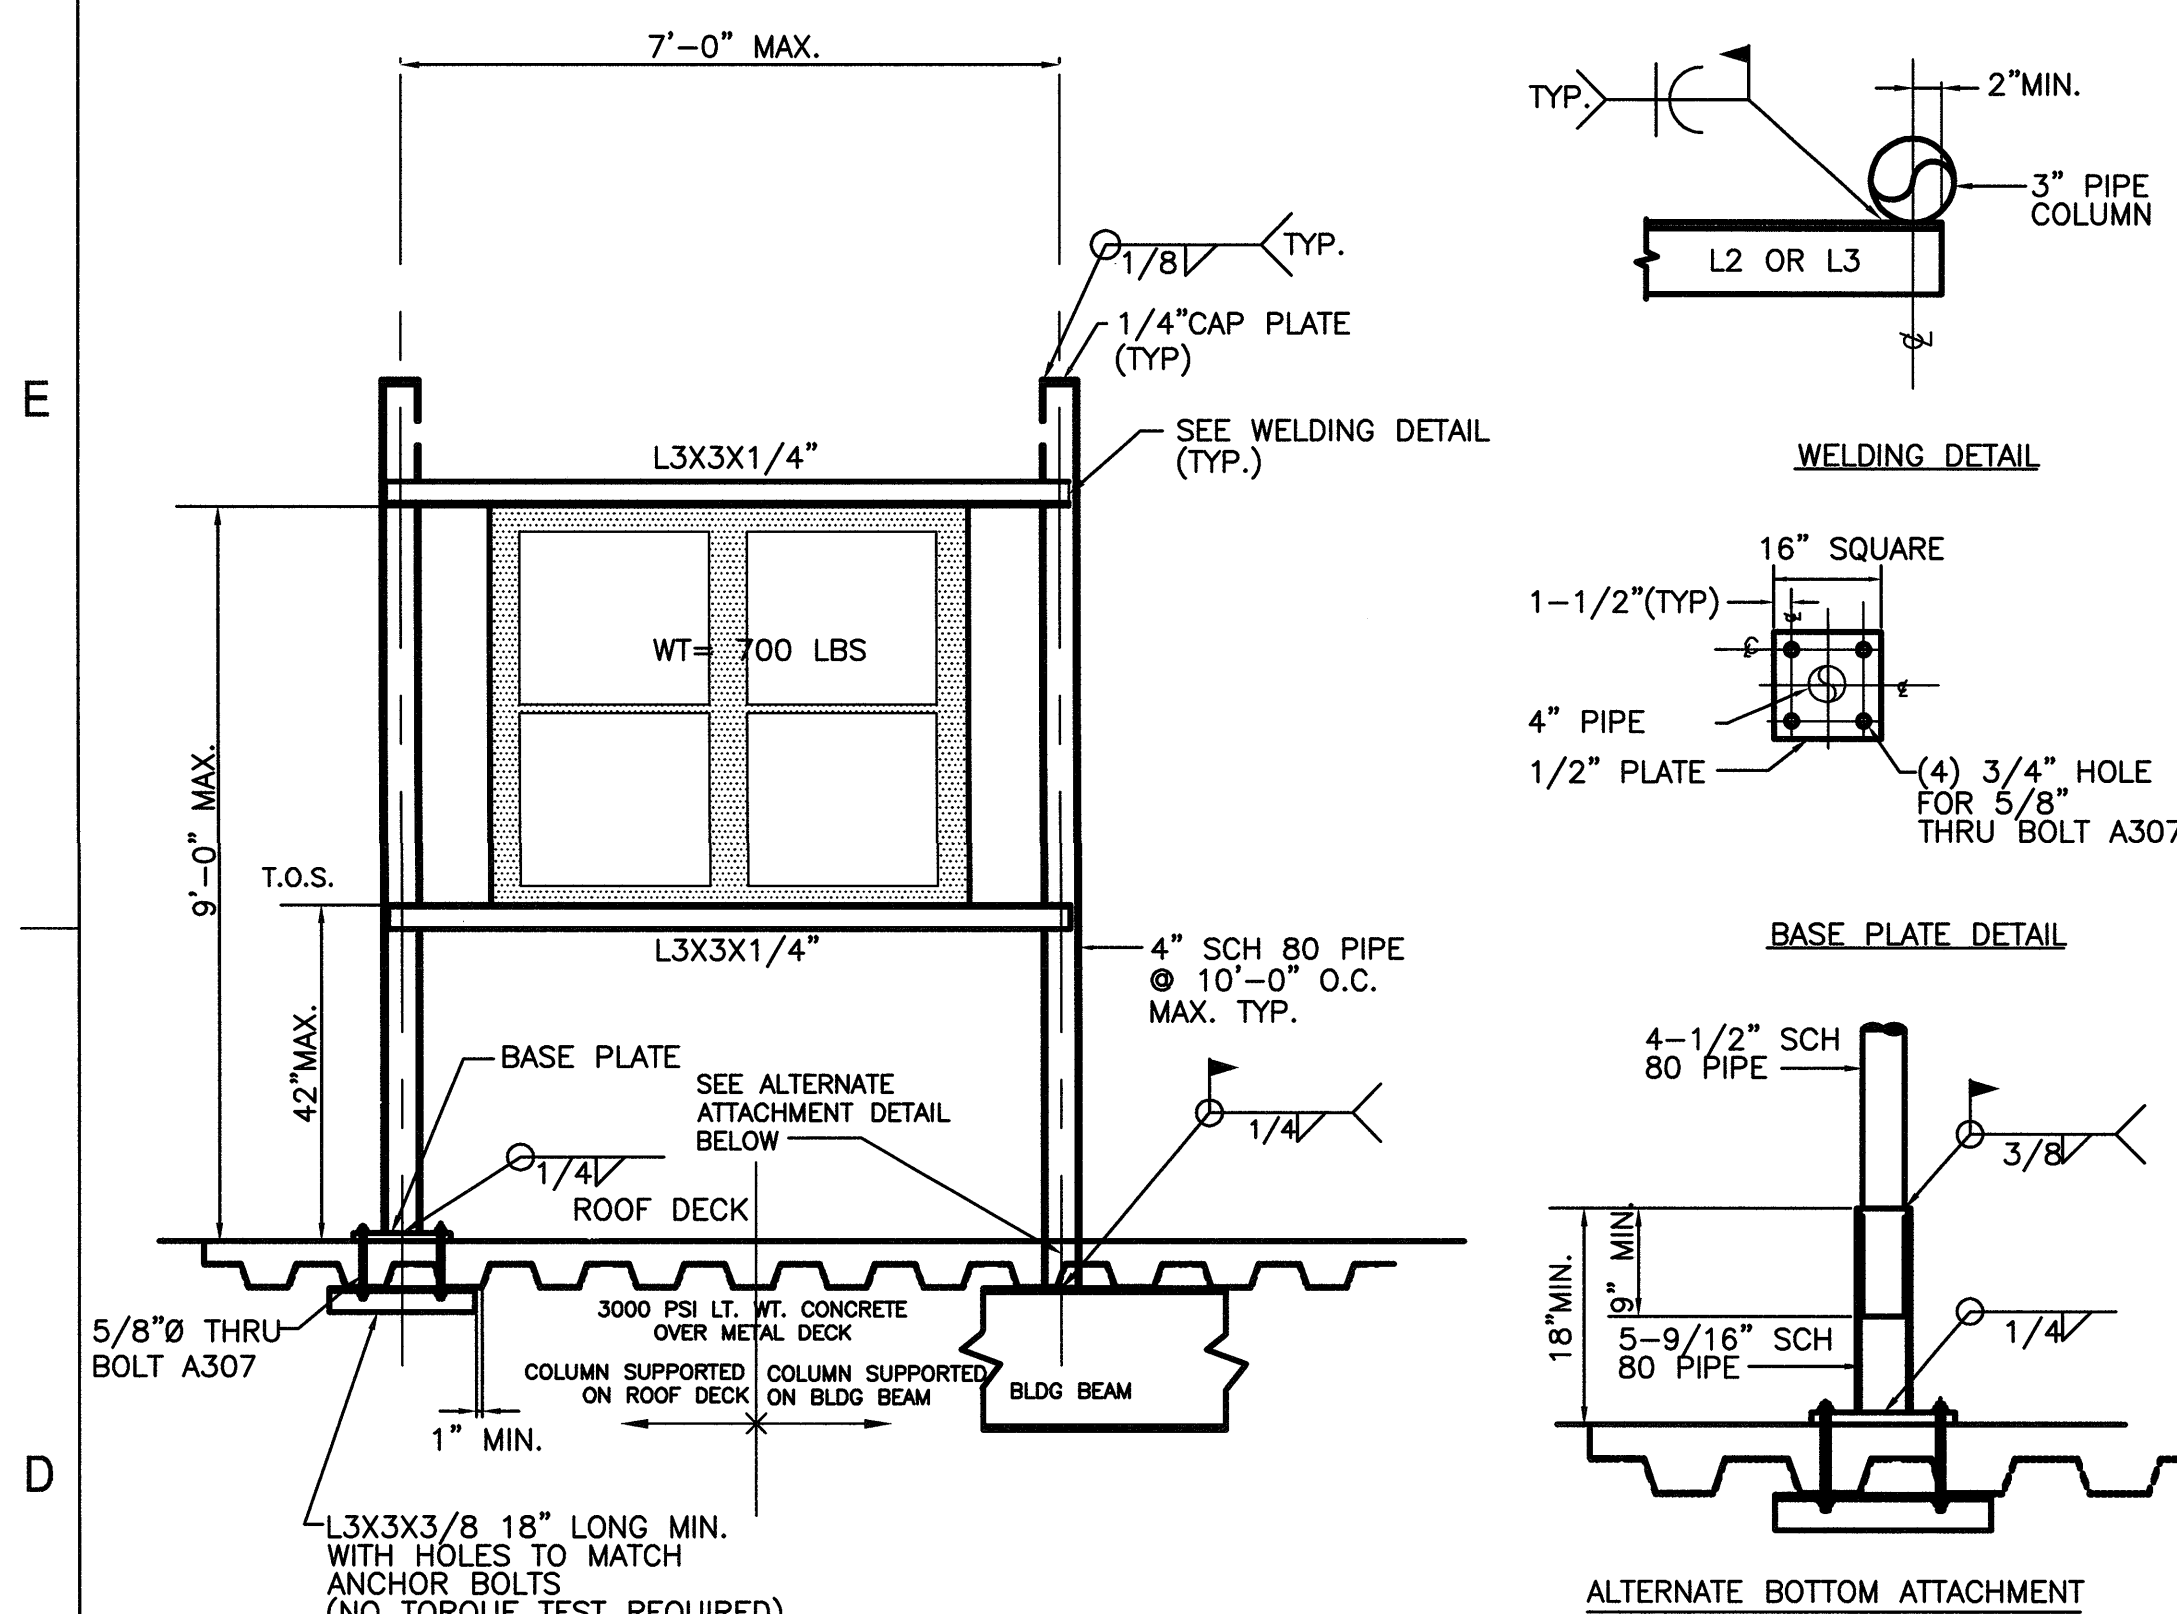


HEPA FILTER HOUSING ANCHORAGE DETAIL (TYP. FOR ALL)

SCALE: NONE

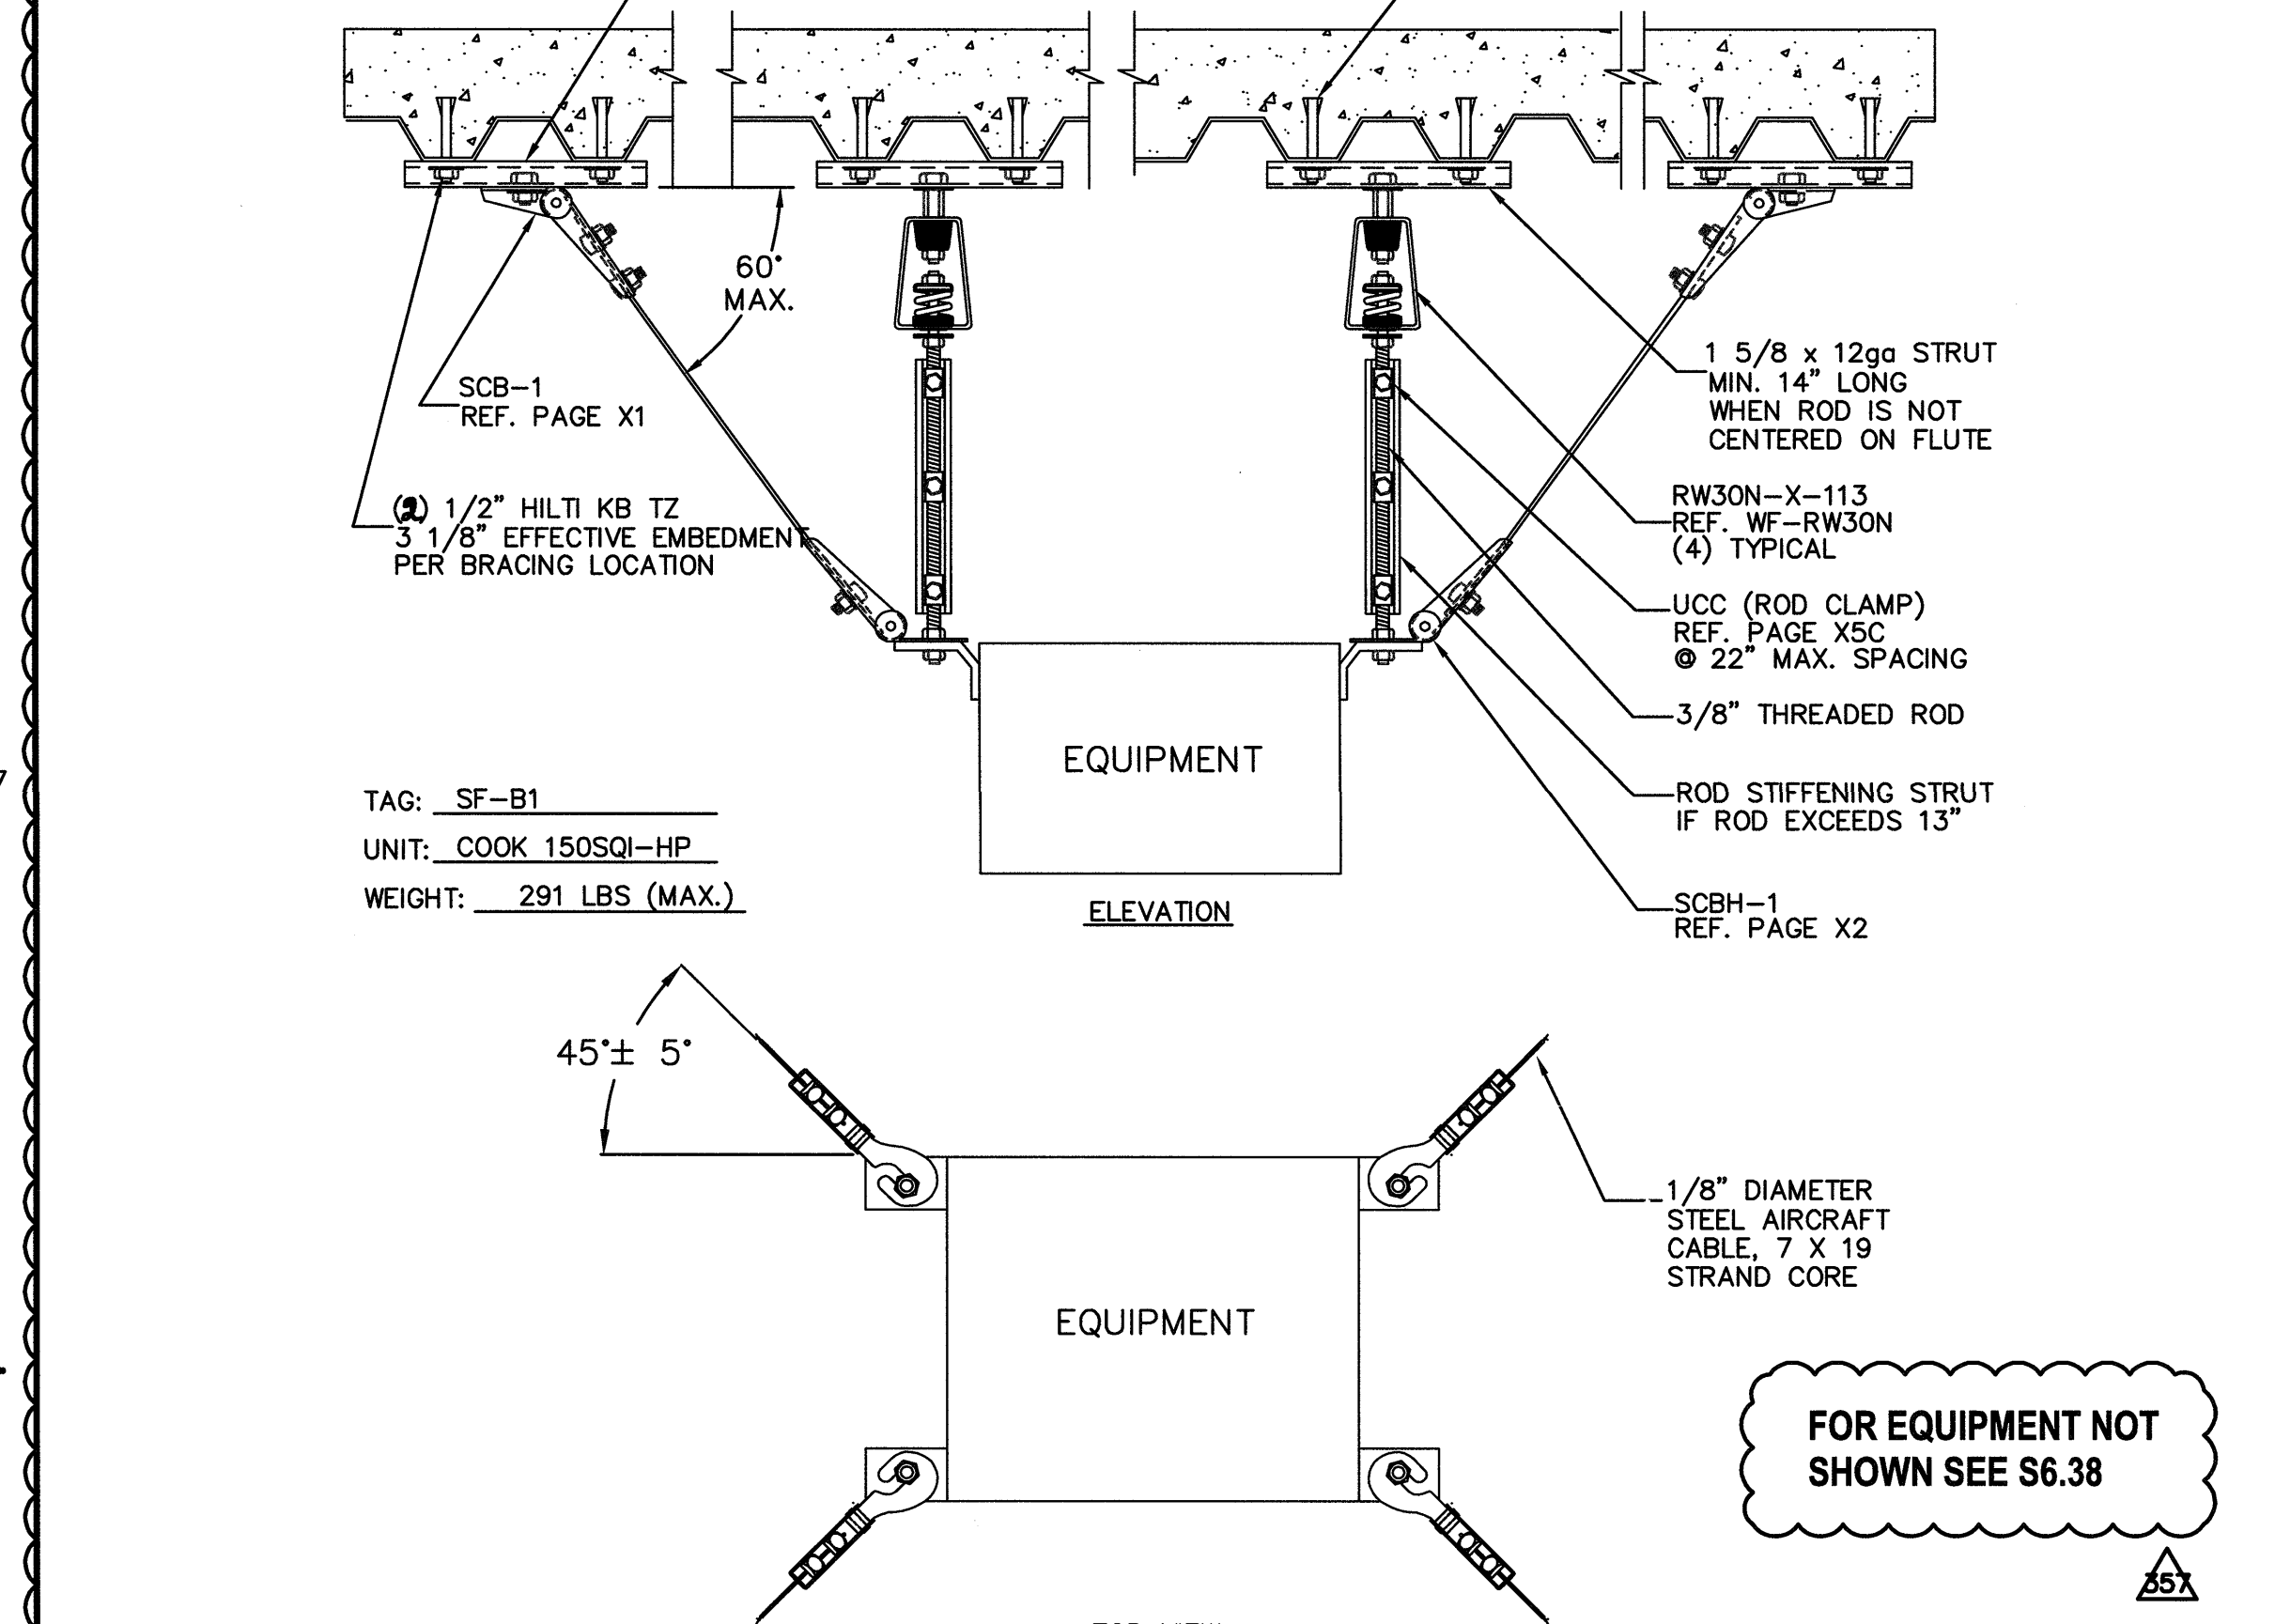


STAIR PRESSURIZATION FANS & EXHAUST FAN ANCHORAGE DETAIL

SCALE: NONE

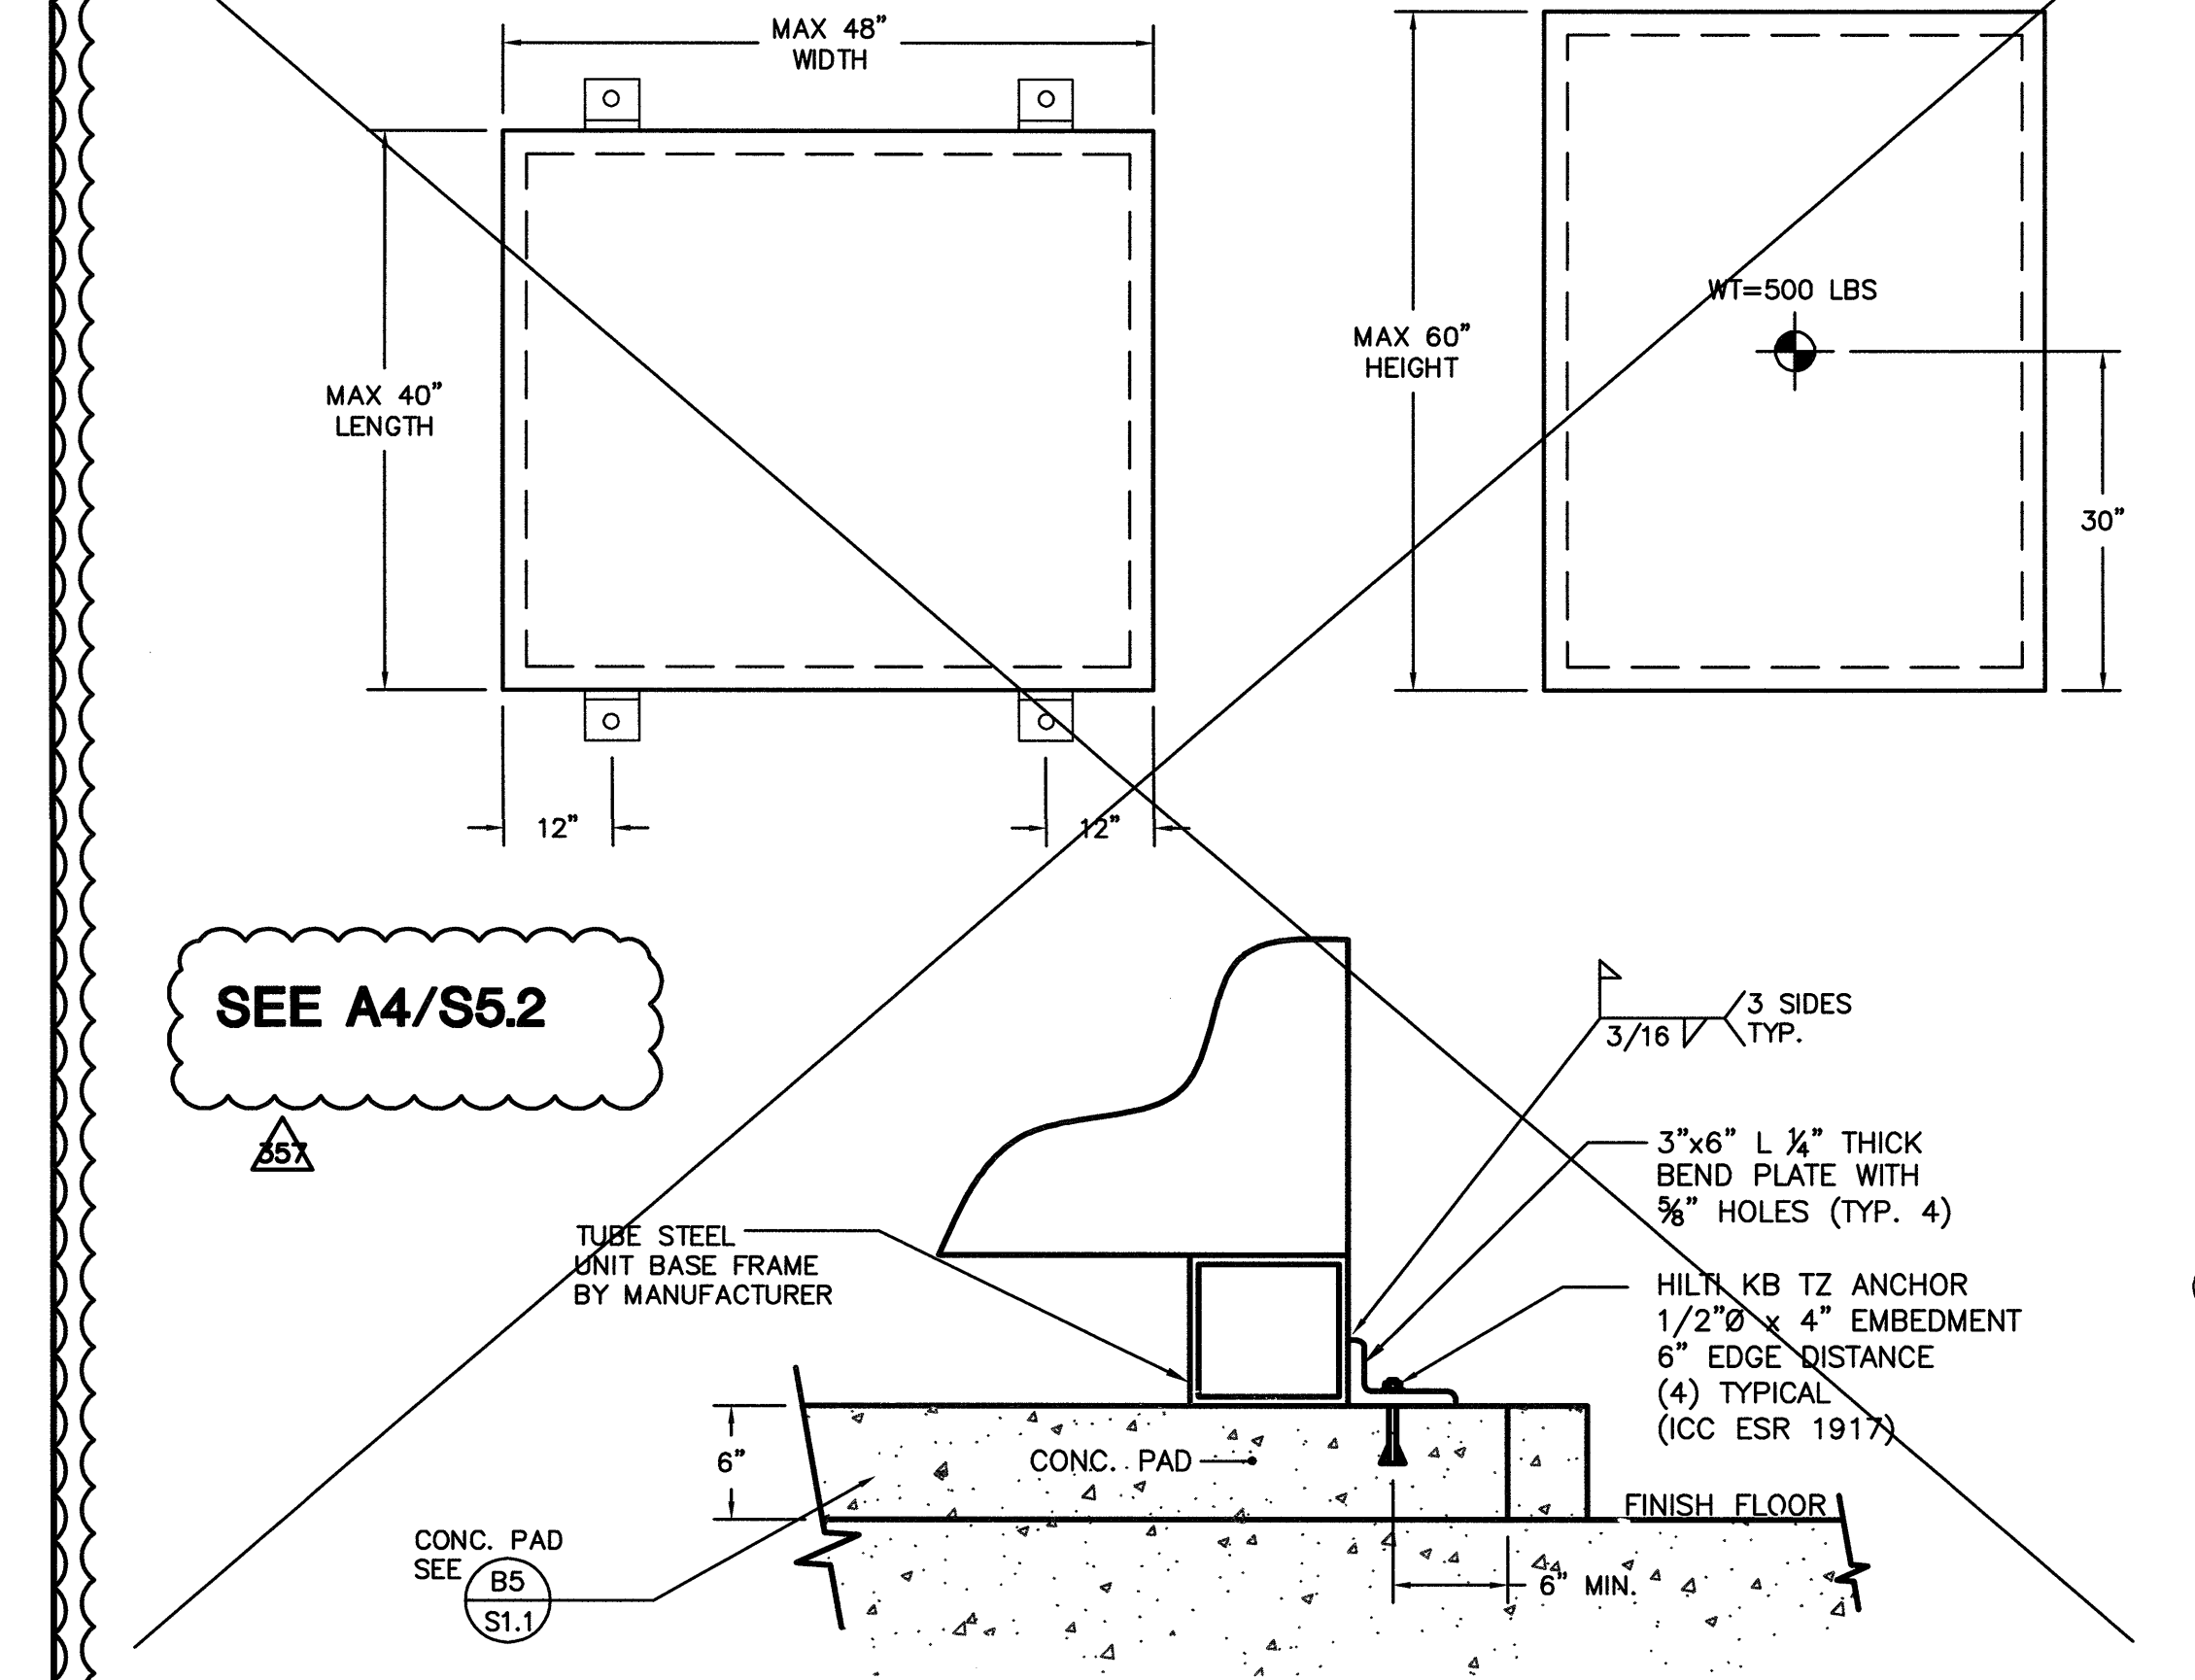


FCU-W1, FCU-E5 AND FCU-P3 ANCHORAGE DETAIL

SCALE: NONE

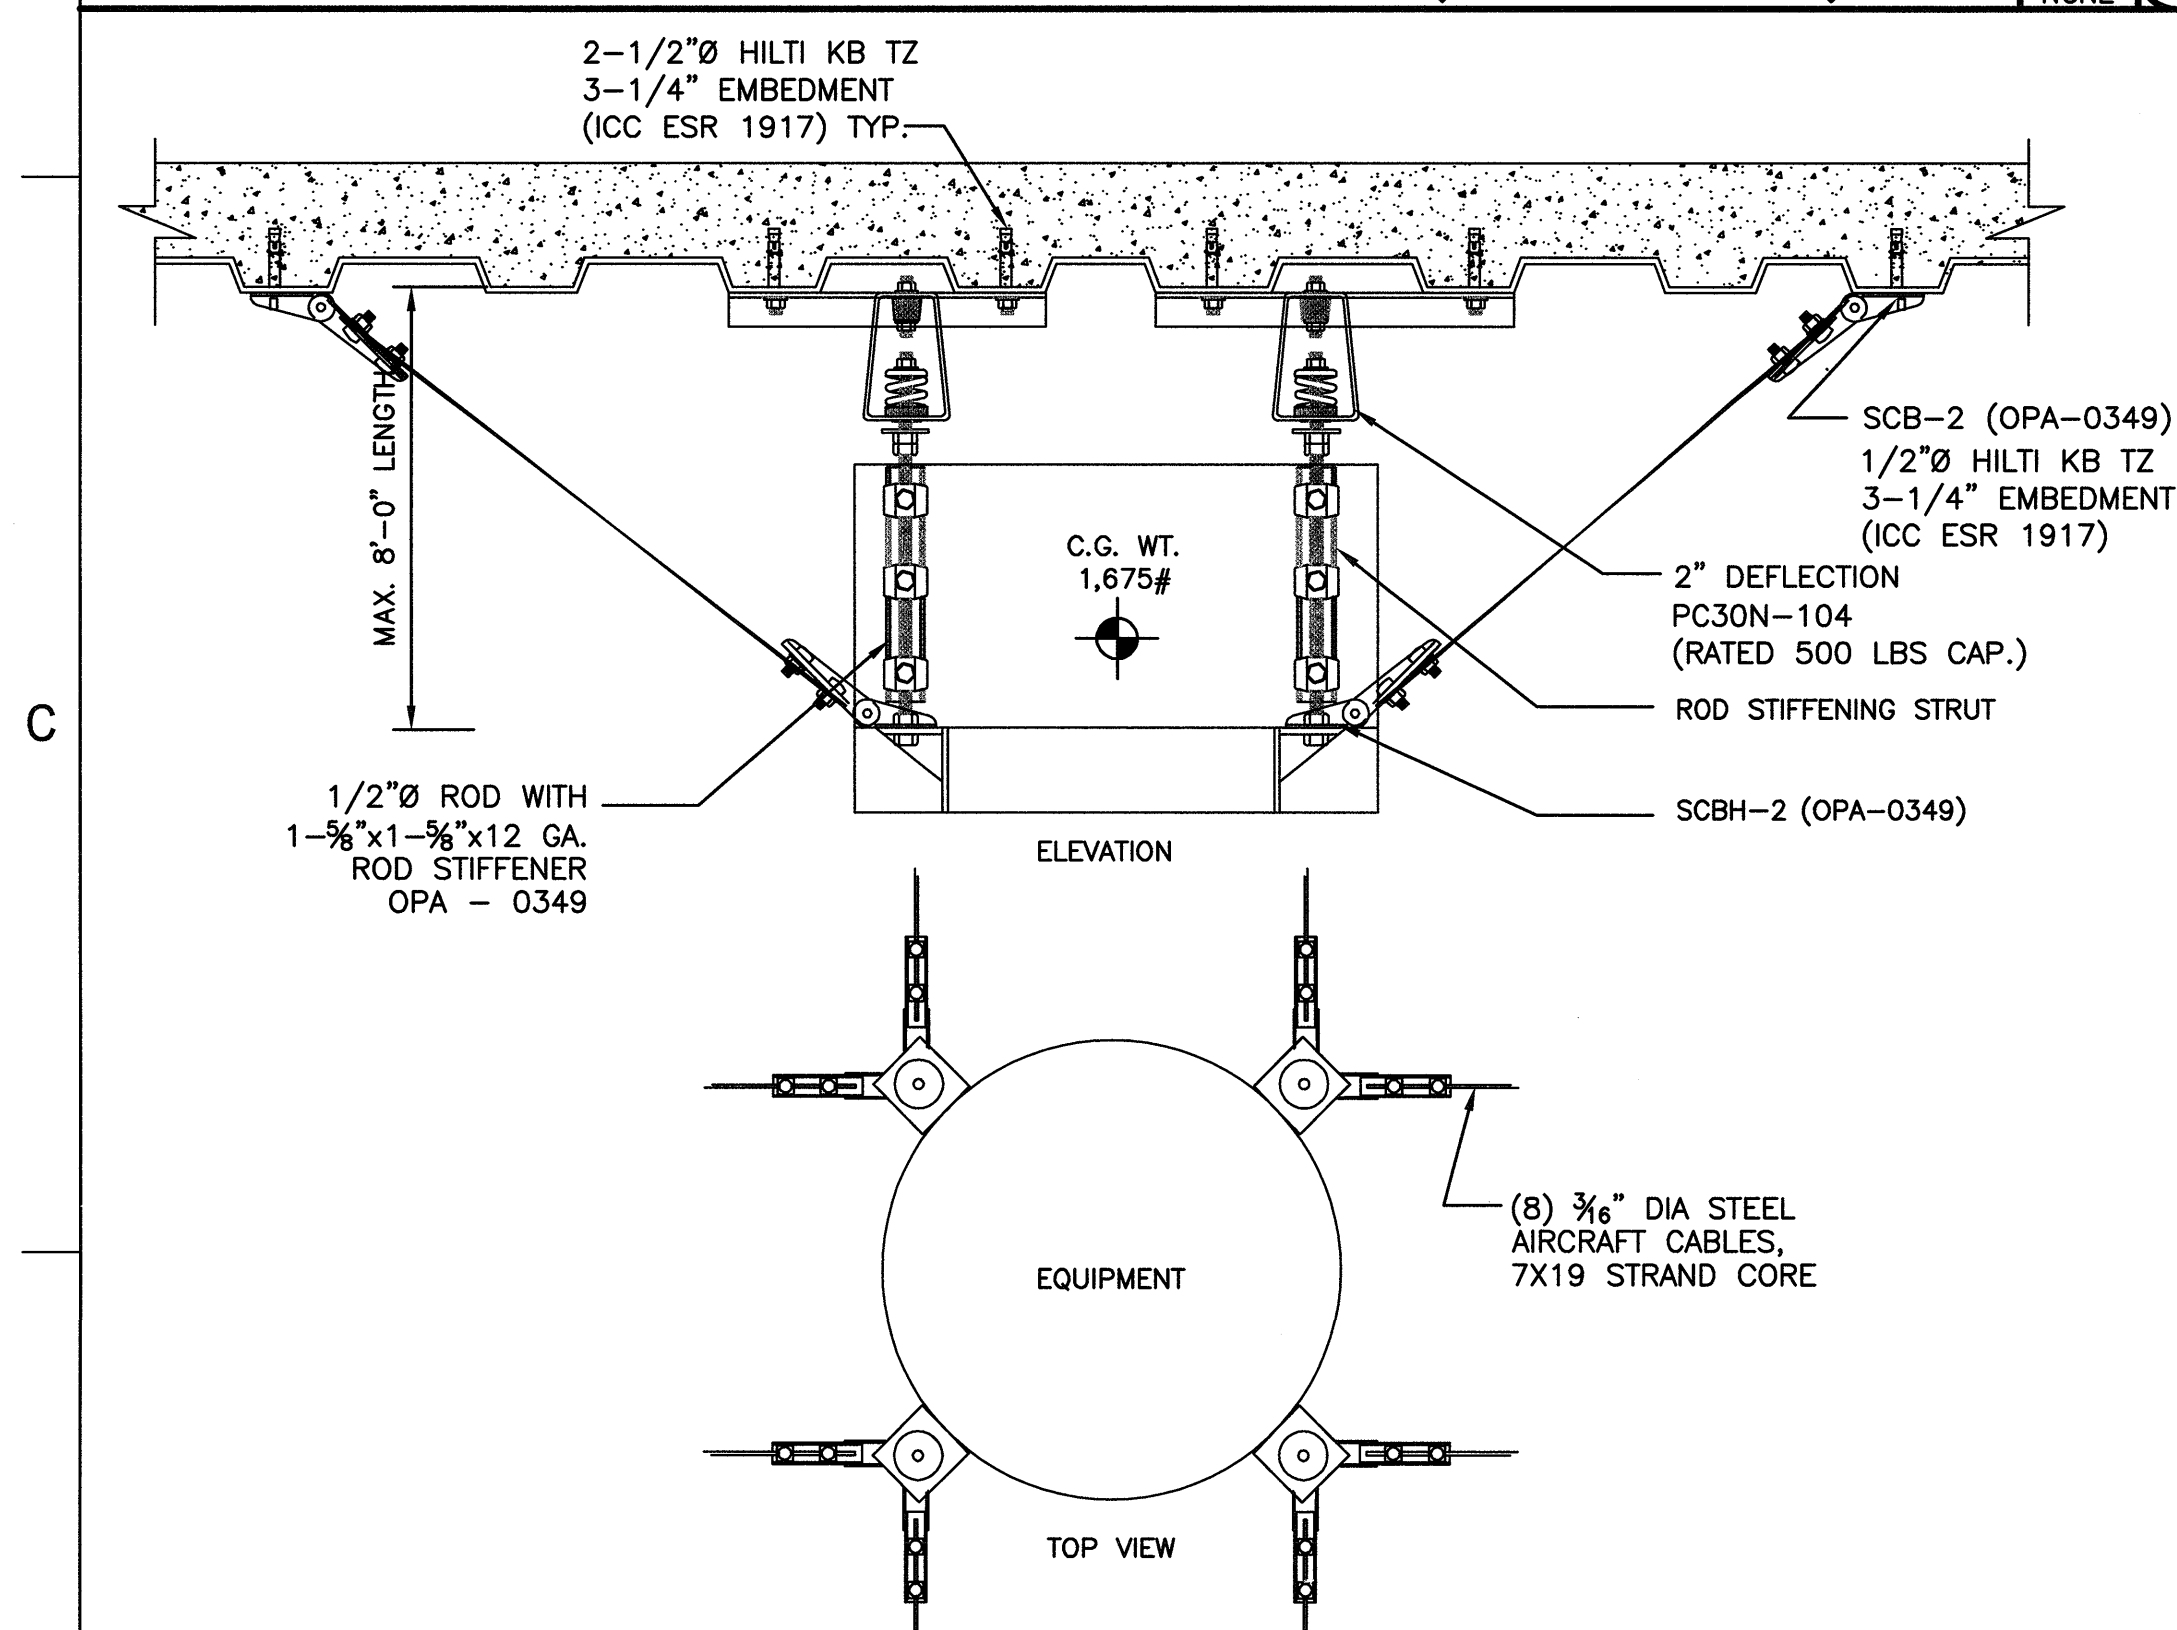


MUFFLER ANCHORAGE DETAIL (M-1 & M-2)

SCALE: NONE

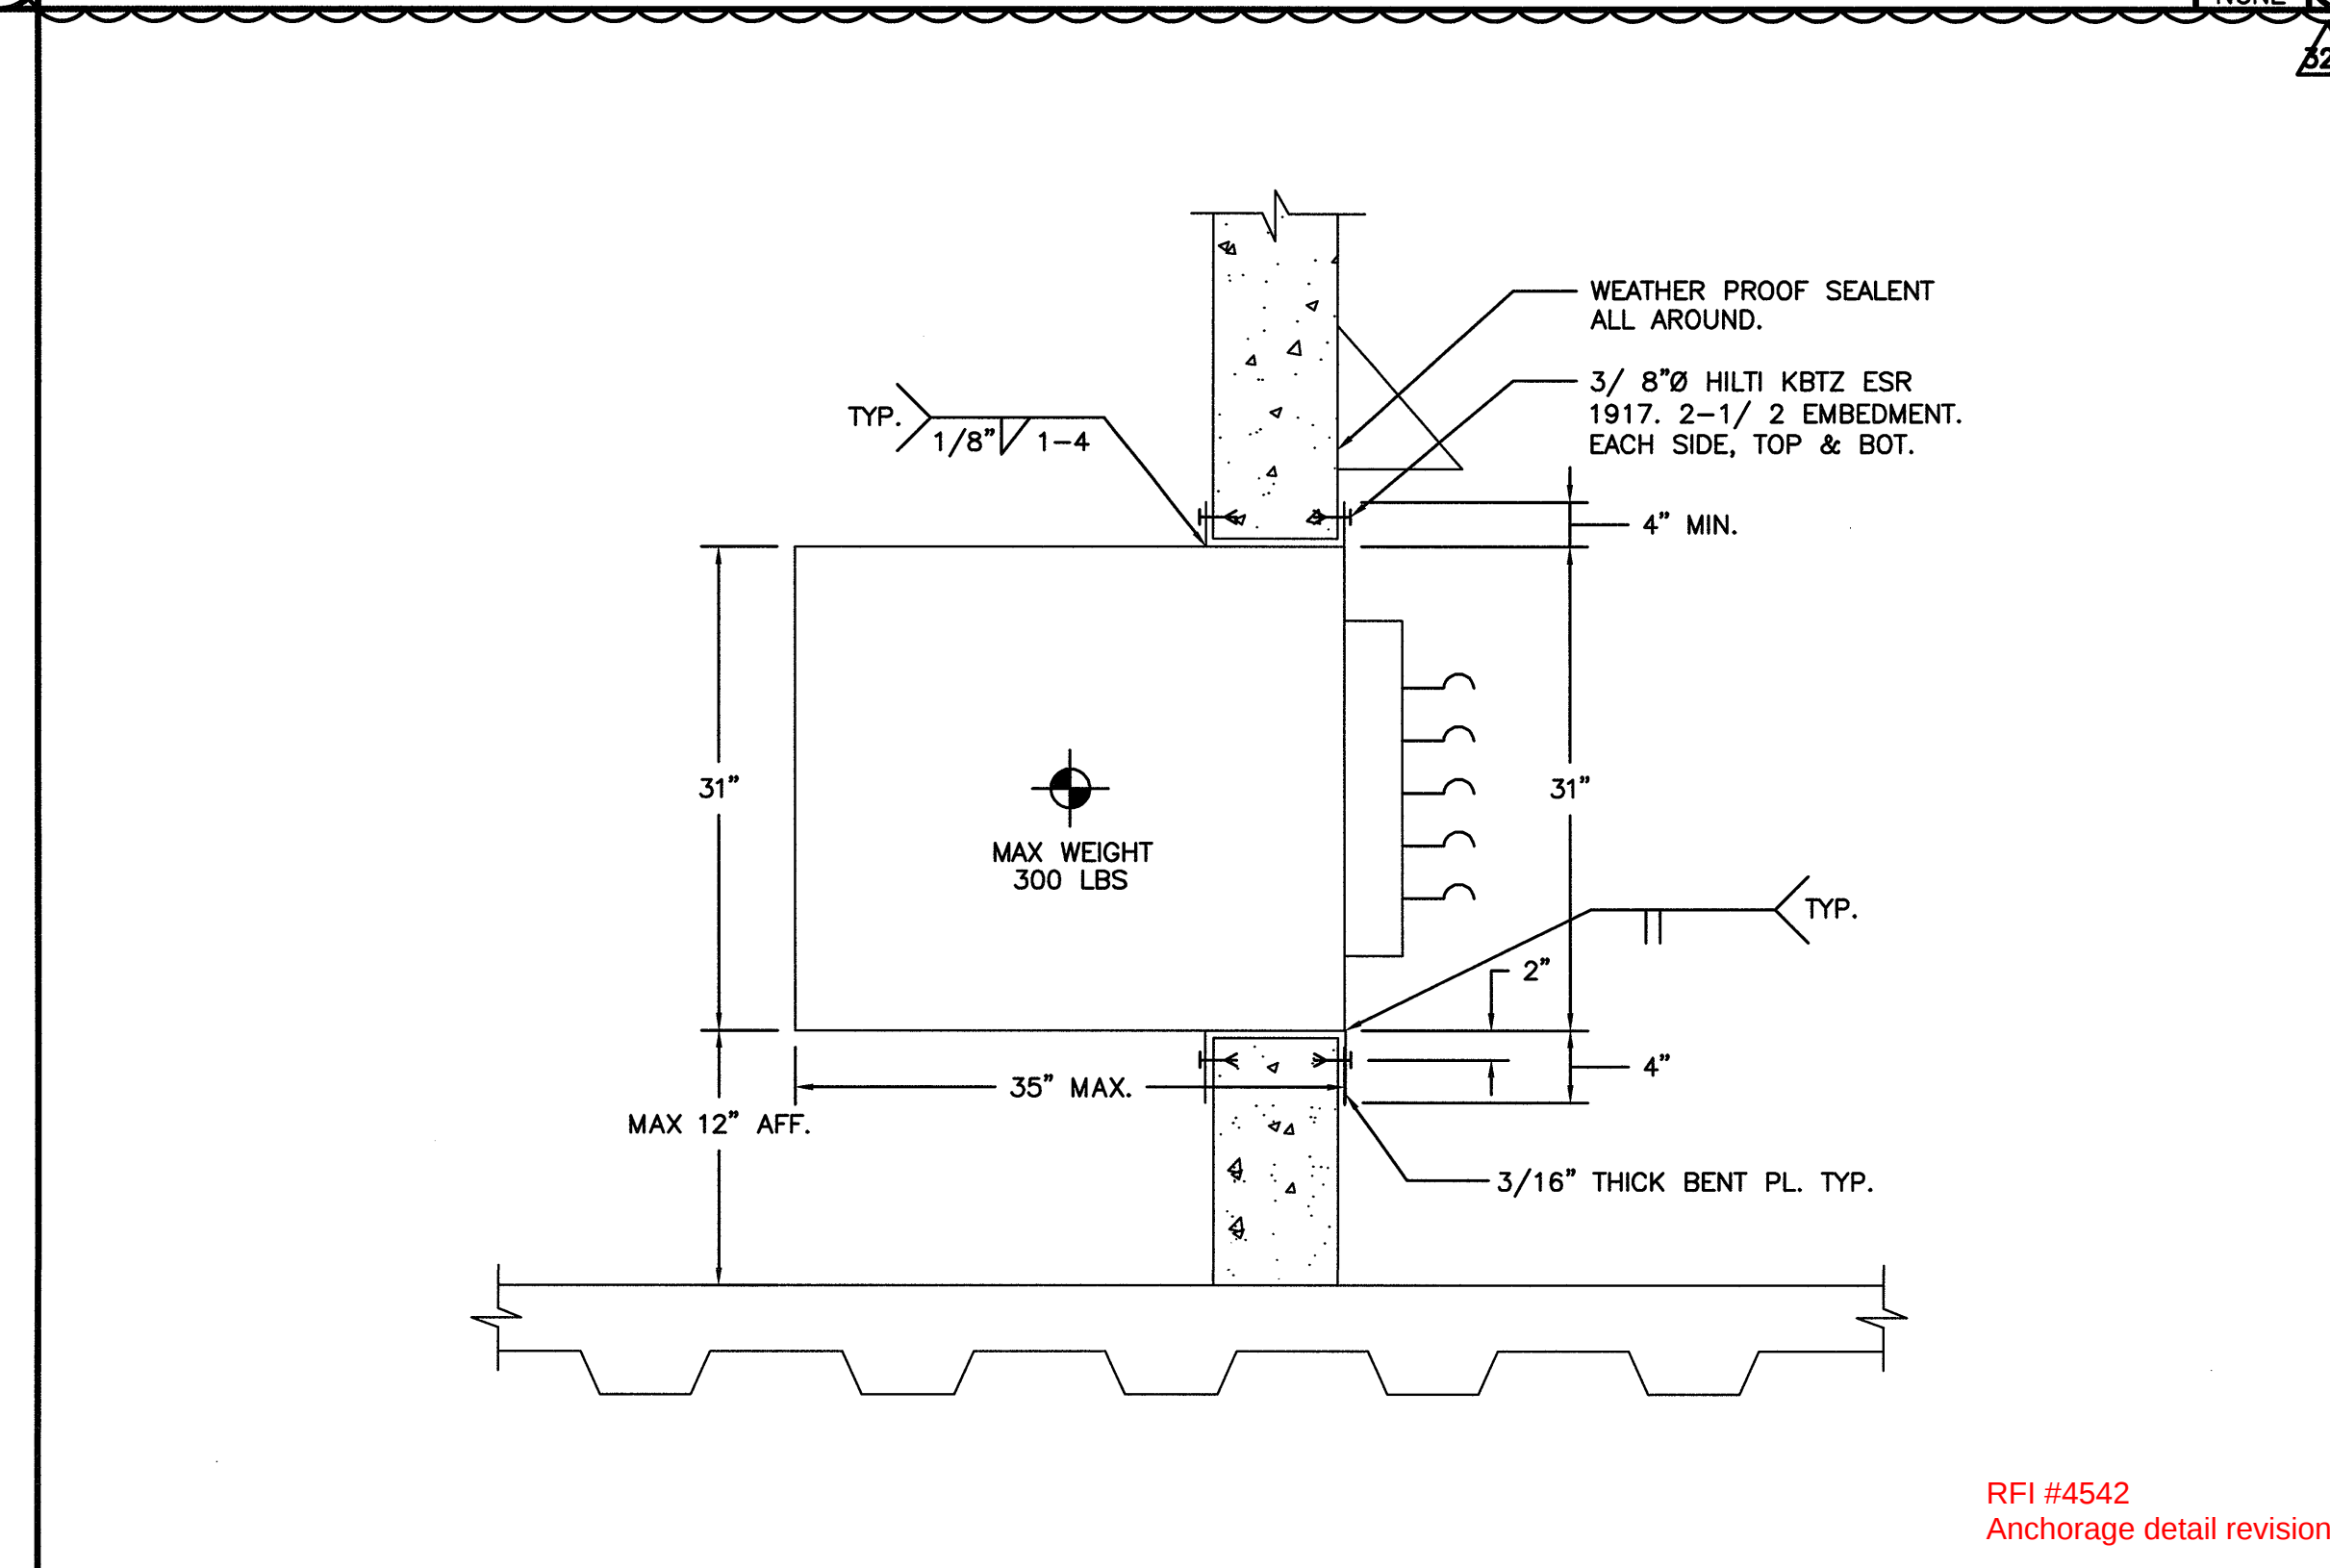


REF-1 & 2 ANCHORAGE DETAIL

SCALE: NONE

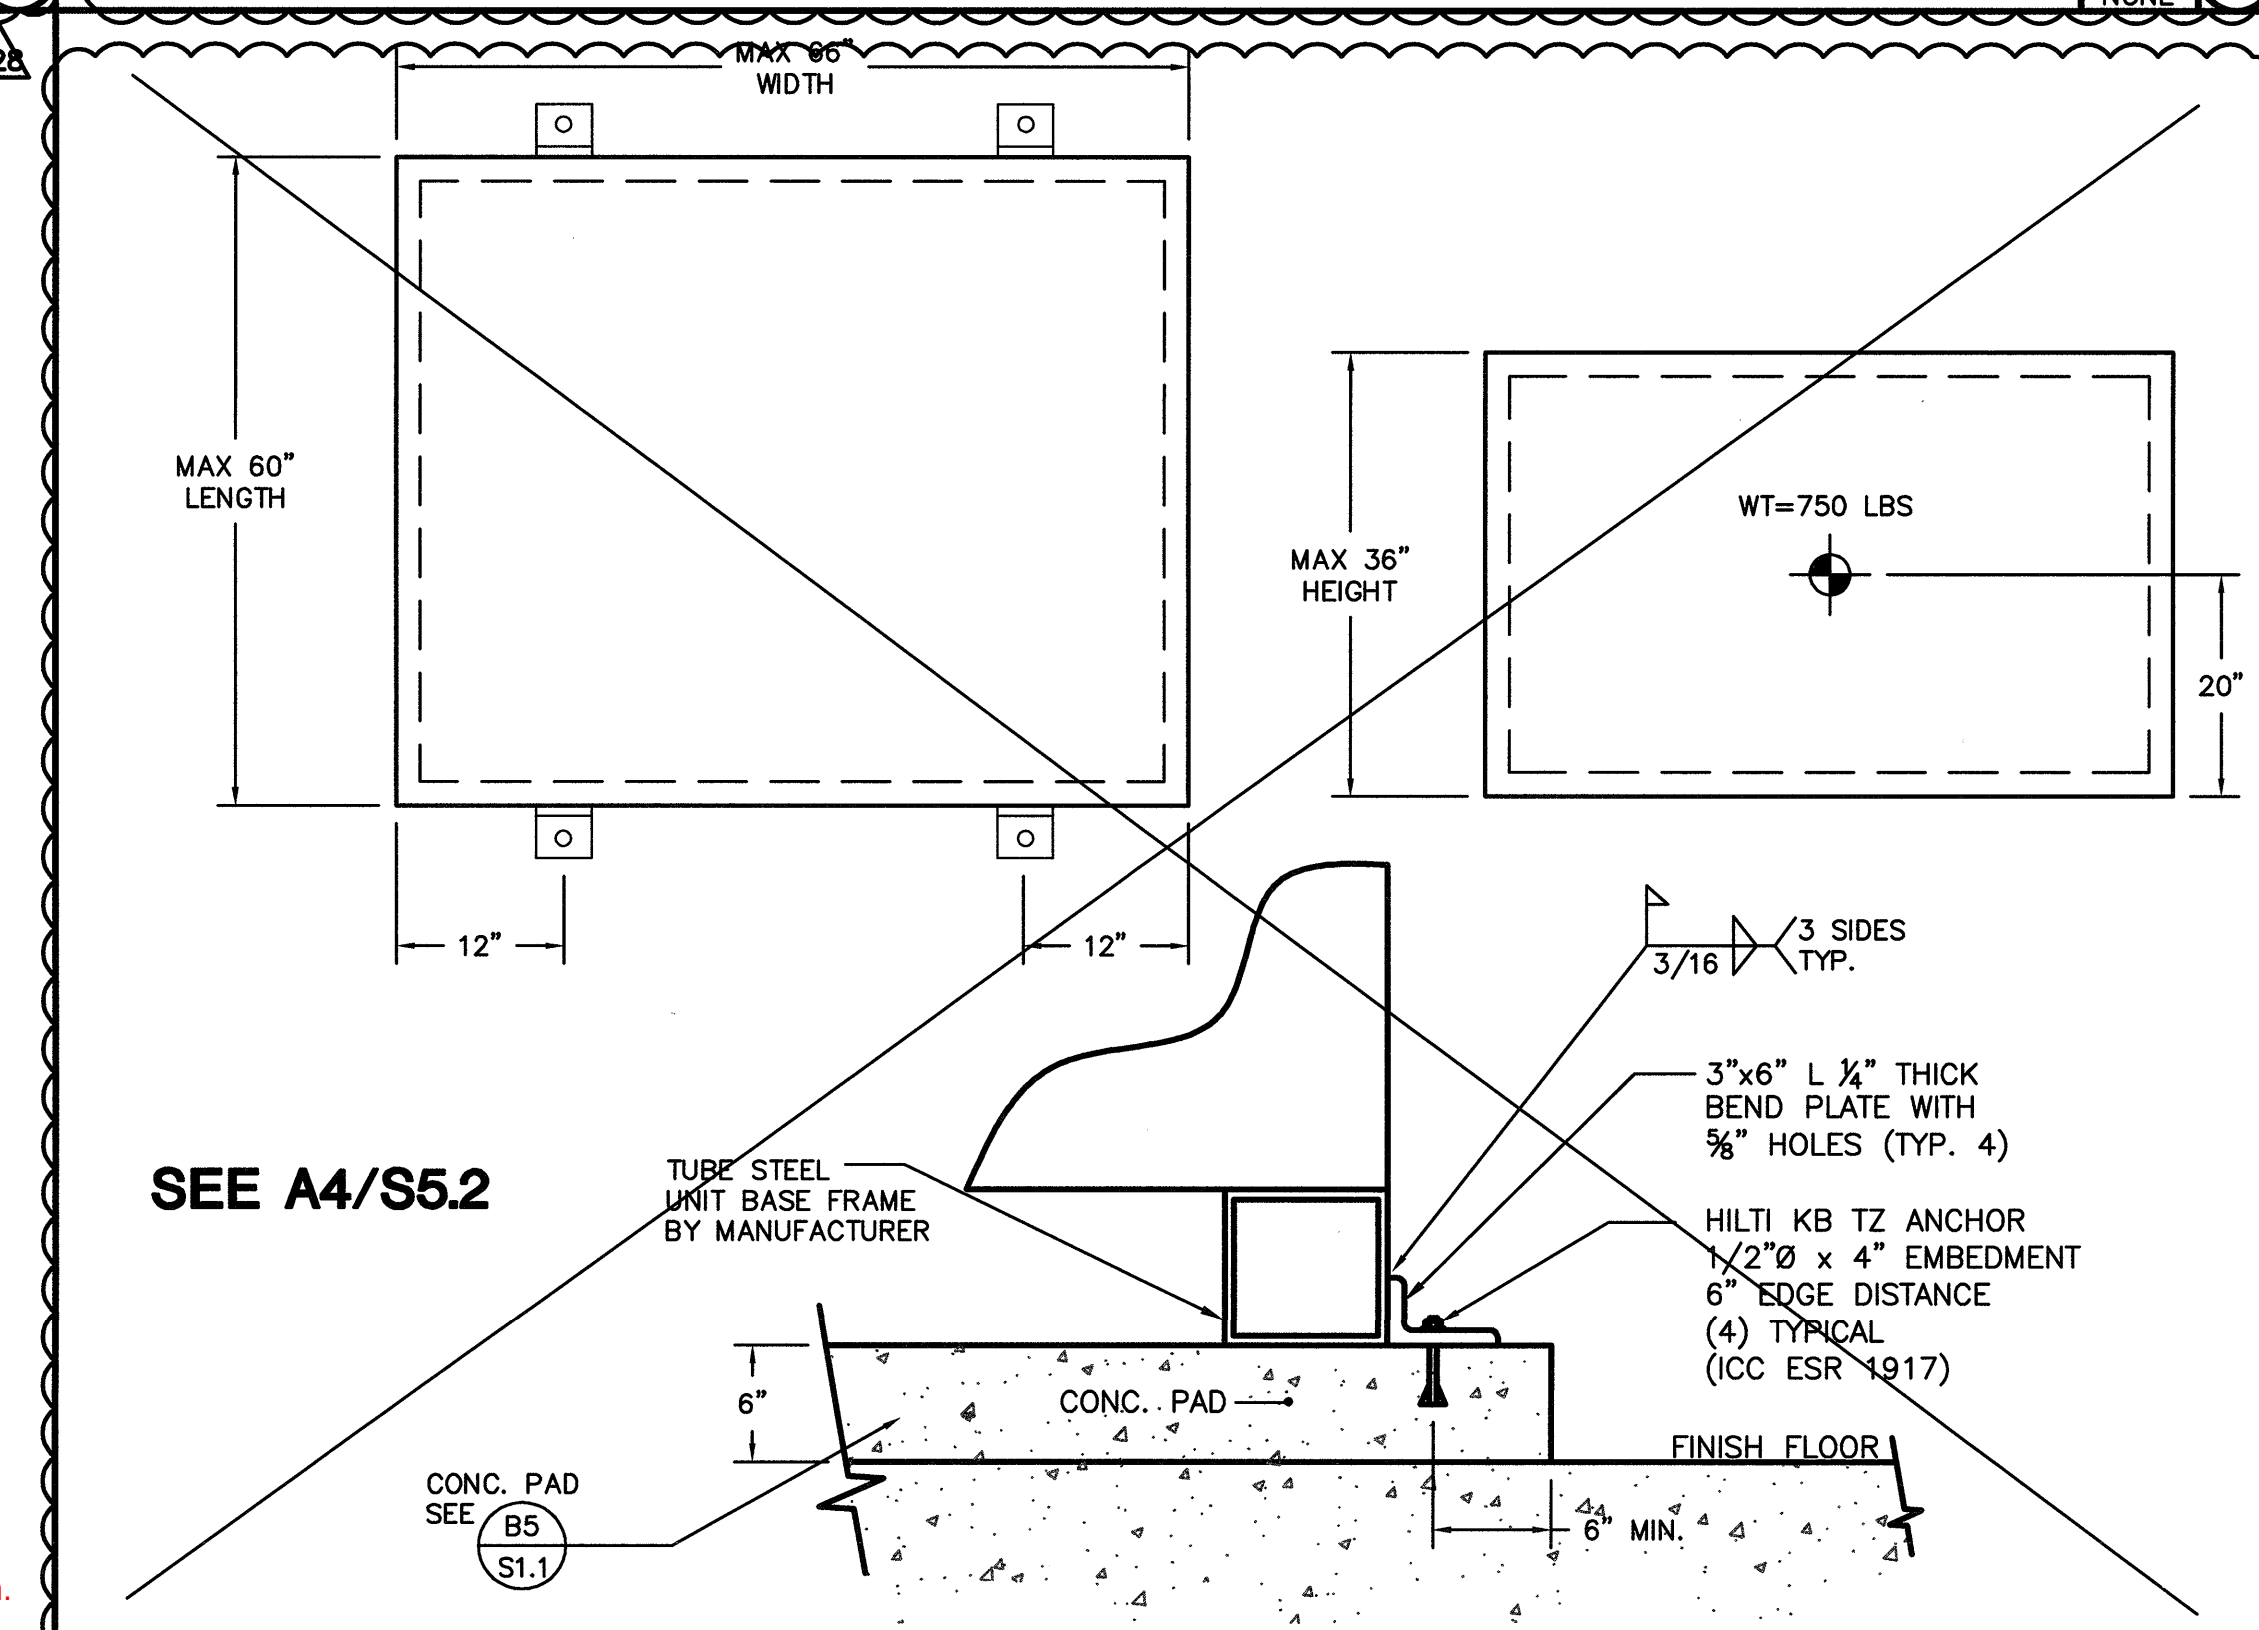


FCU-P2 ANCHORAGE DETAIL

SCALE: NONE

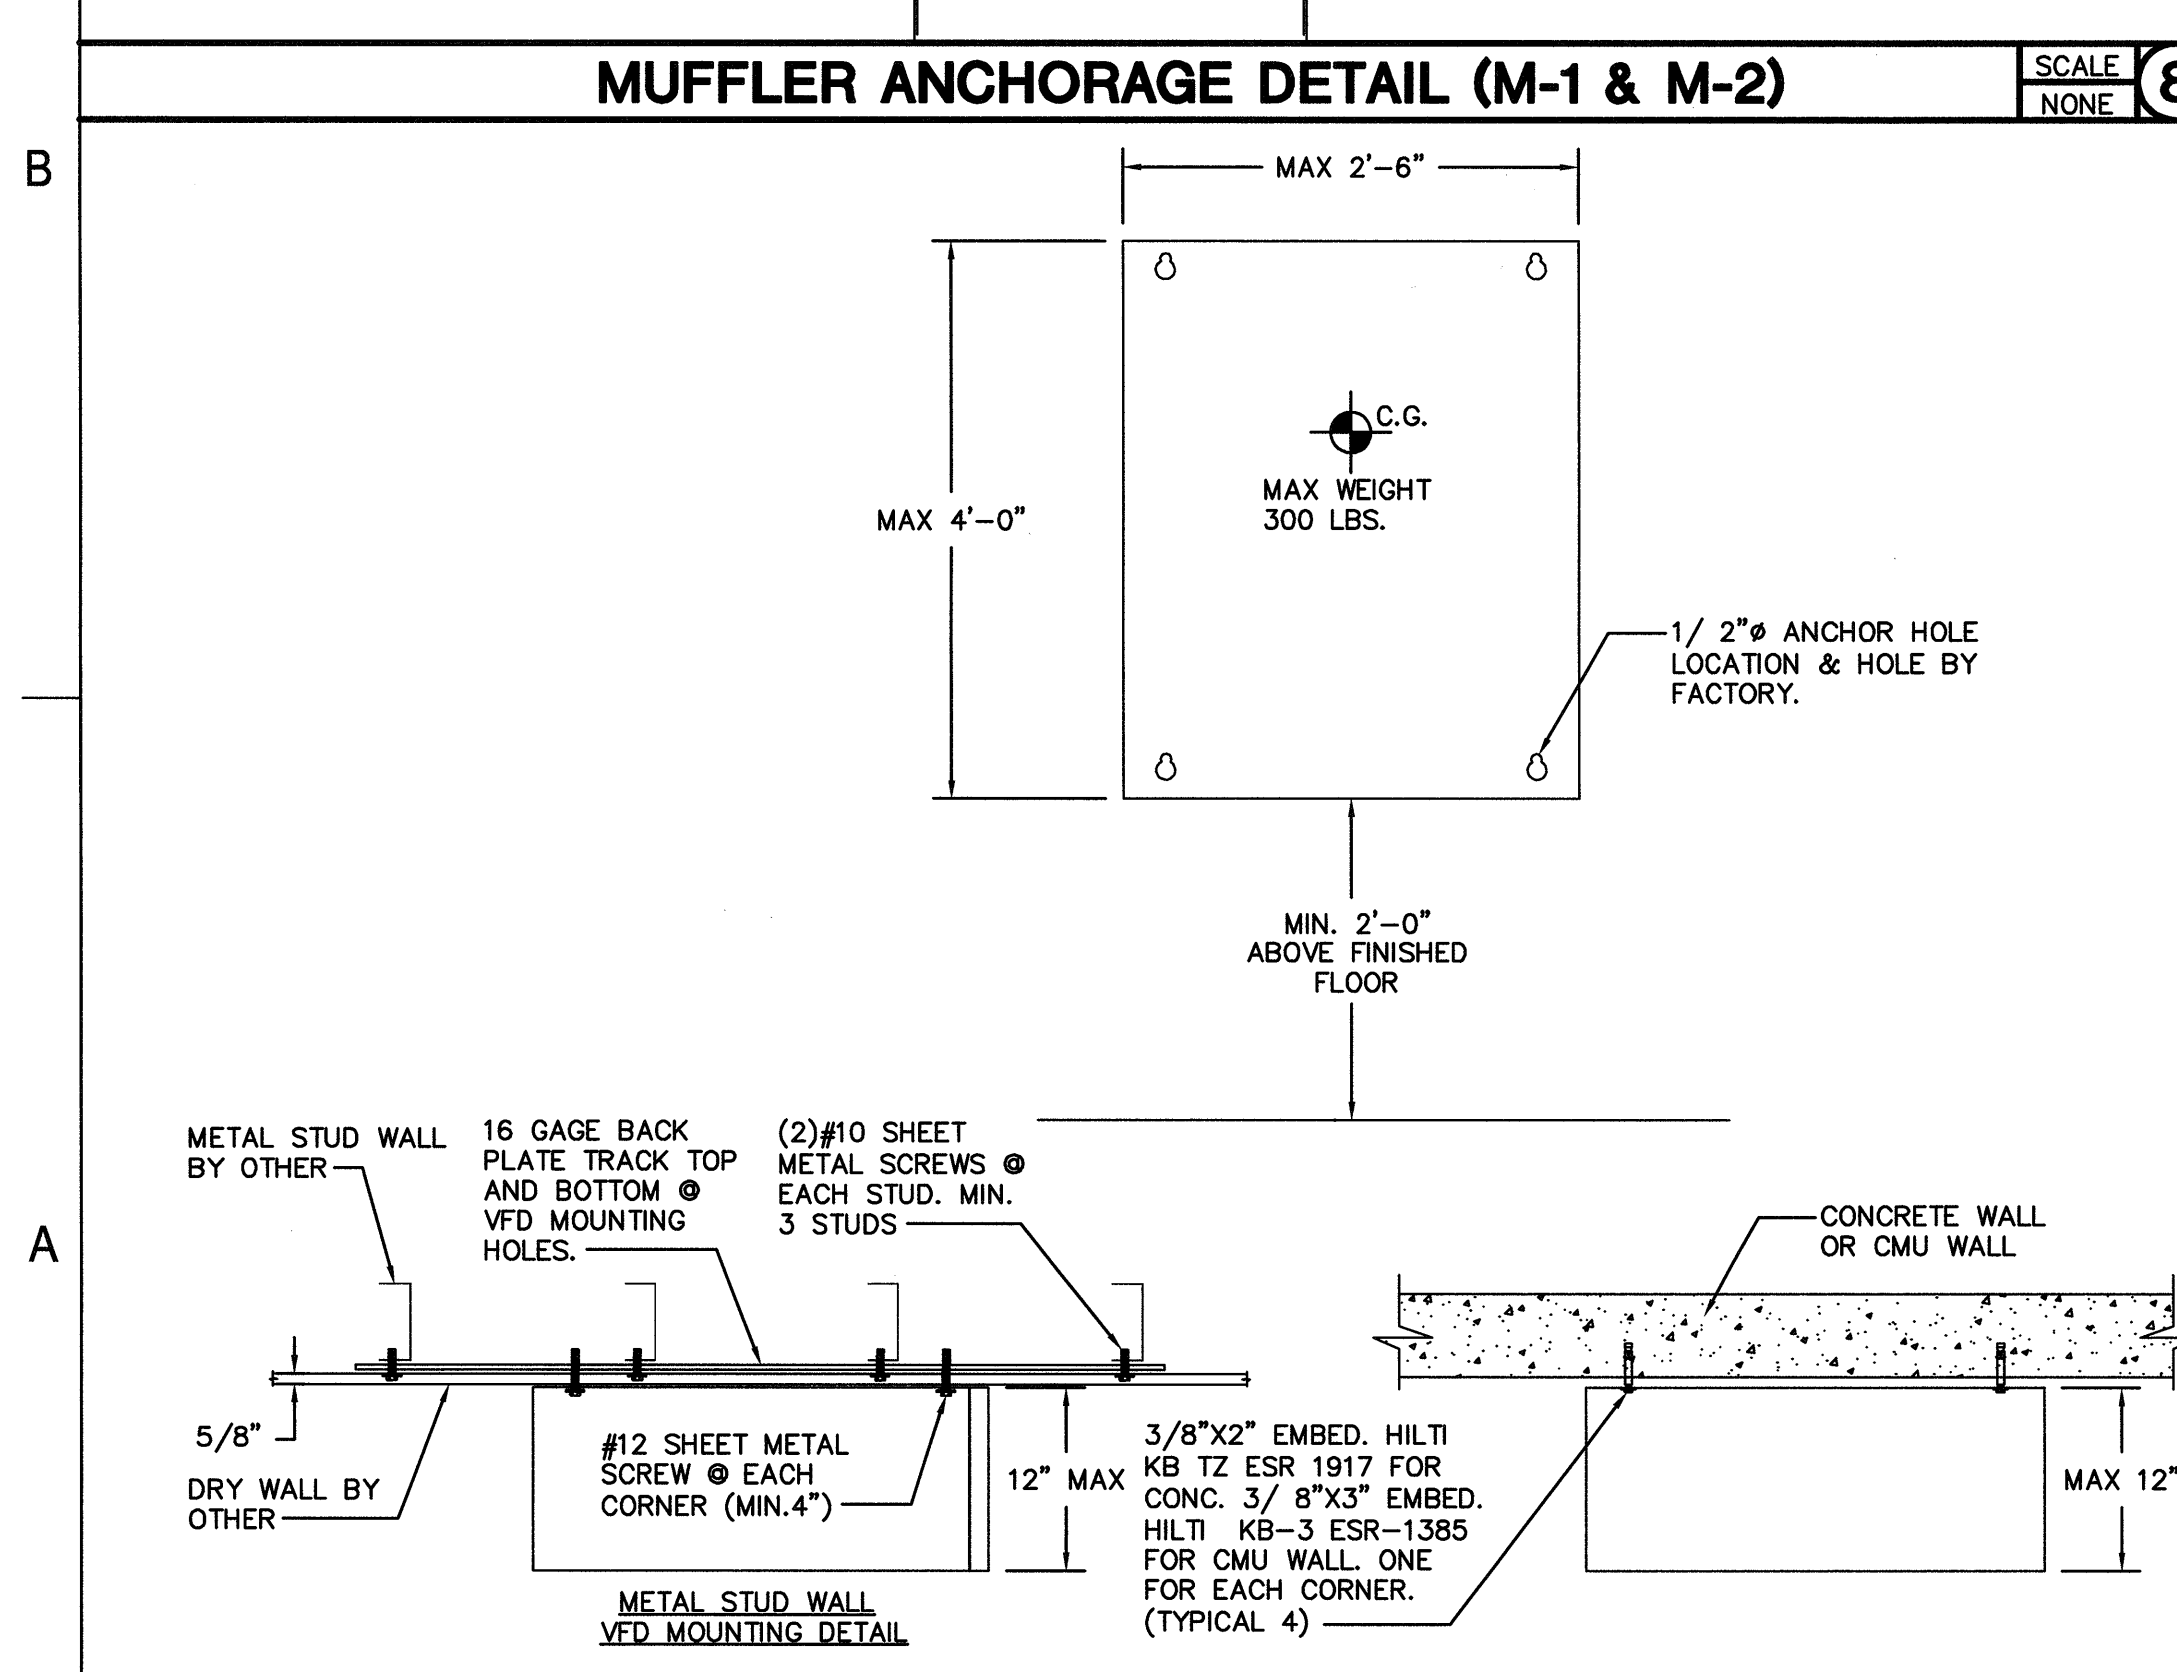

VFD AND DDC CONTROL PANEL ANCHORAGE DETAIL

SCALE: NONE

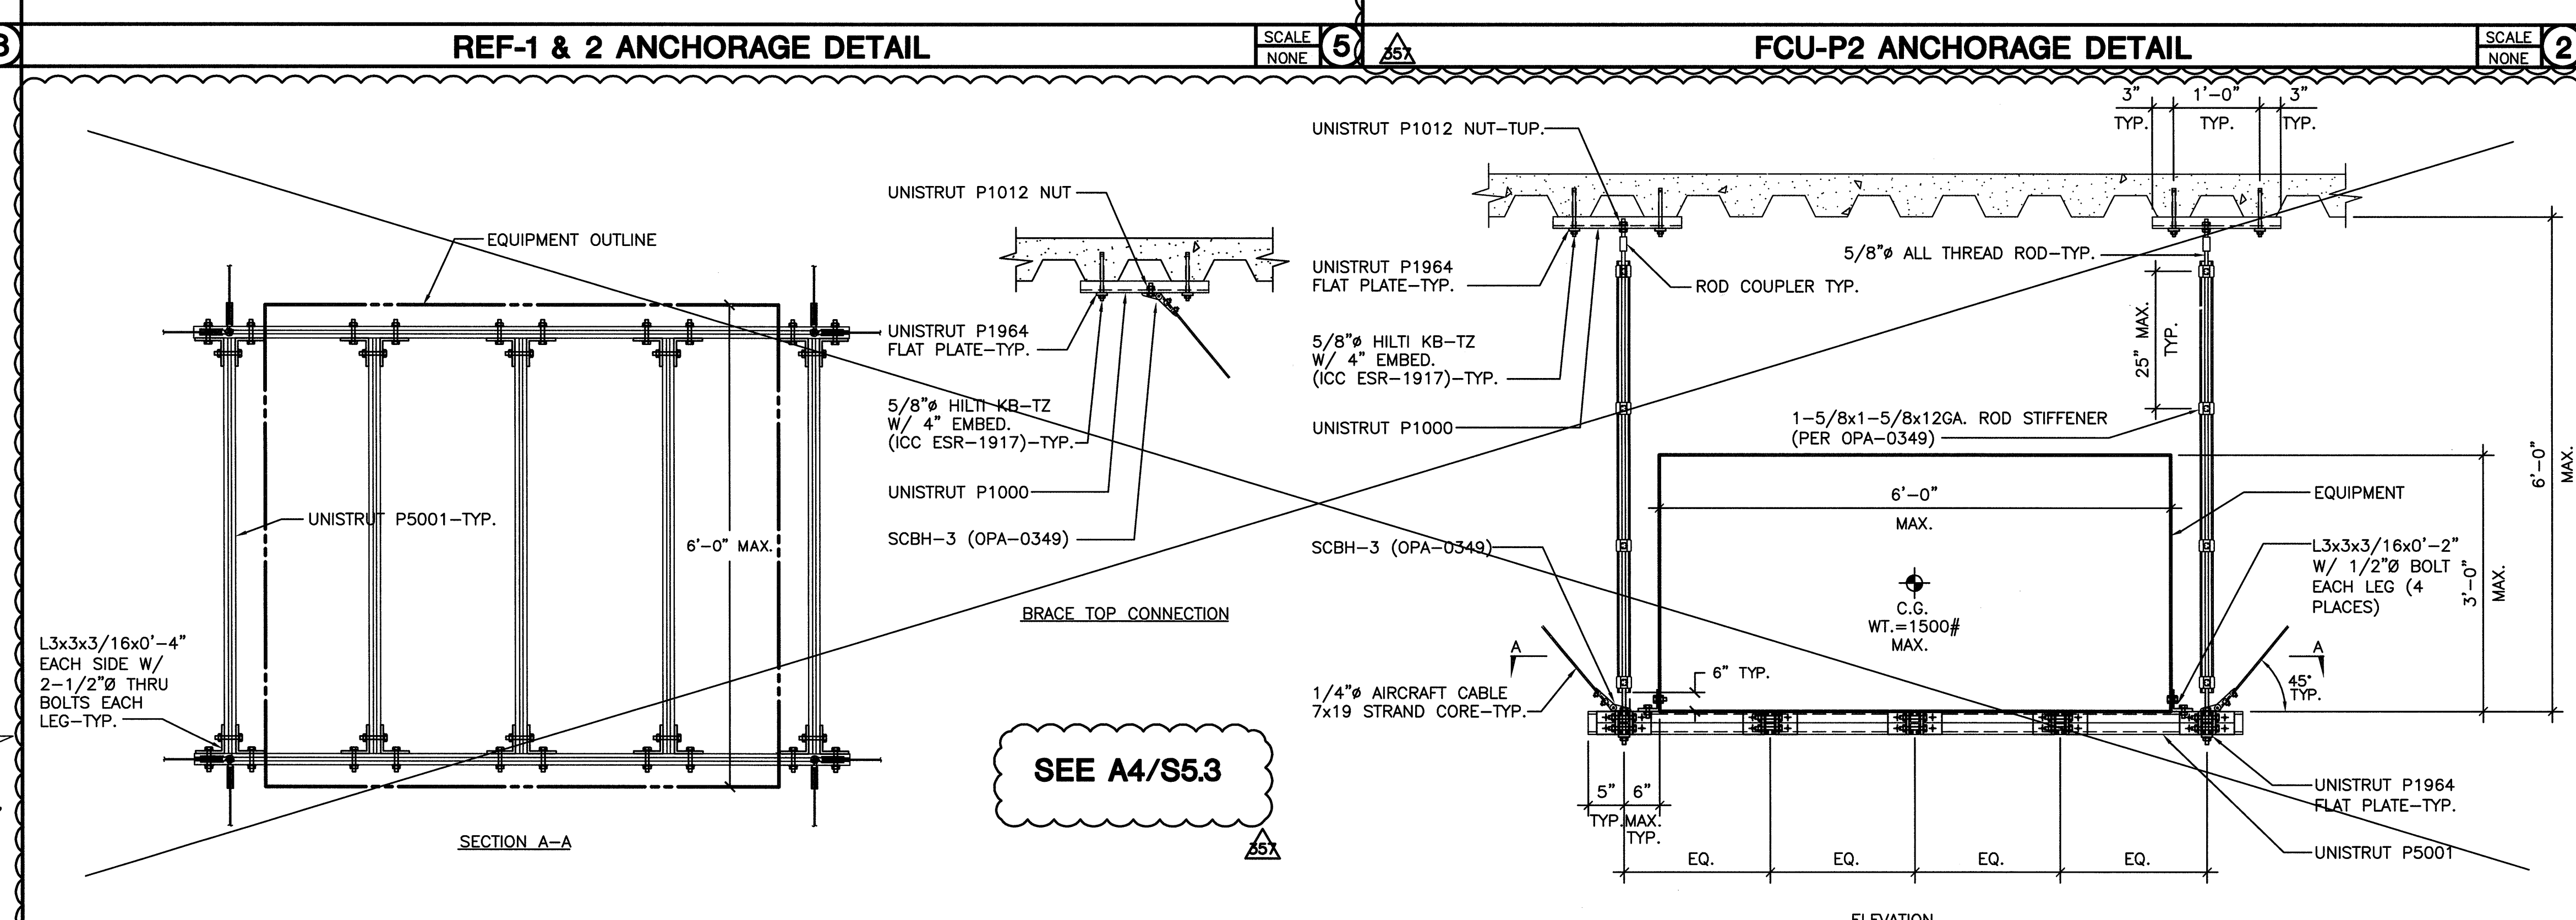

FCU MAX WEIGHT 1500 LBS ANCHORAGE DETAIL

SCALE: NONE