

FKP Architects

ARCHITECT OF RECORD

*Architect of Record signature line only; this drawing was not prepared under the direct supervision of the Architect of Record. The direct responsibility for preparation of this sheet lies with its corresponding professional stamp and signature. The signature of the Architect of Record in general responsible charge of the project is provided as required by Title 24, Part 01, Section 7-115 (a).

ARCHITECT - PAUL C. GLORIO

CONSULTANT

T M A D
TAYLOR & GAINES

STRUCTURAL
MECHANICAL
ELECTRICAL
CIVIL

100 South Anaheim Boulevard, Suite 150
Anaheim, California 92805
Phone: 714.490.5555 Fax: 714.490.5560
Project No. 2305-163-07



Changes on these drawings do not consist of materially altered changes to approved drawings and don't require a change order.
OSHPD review ACO
OSHPD review FLSO
OSHPD review DSE

REVISIONS

NO.	DATE	DESCRIPTION
1	08/22/2011	CHANGE ORDER #256
2	09/21/2011	CHANGE ORDER #278

APPROVAL



CHANGE ORDER #278
INSTRUCTION BLANKET
DISPERSED APPROVAL
ADDENDUM

PROJECT NAME

CHILDREN'S HOSPITAL
OF ORANGE COUNTY

455 S. Main St.
Orange, CA 92868-3874

RECEIVED
TOWER II September 21 2011
McCarthy



PROJECT NUMBER

12011.00
Increment #7

OSHPD - PROJECT NUMBER
IL 072072-30

ISSUE

OSHPD PERMIT

DATE

01/27/2010



SCALE

DRAWING TITLE

MECHANICAL DETAILS -
HVAC EQUIPMENT -
ANCHORAGE DETAILS


DRAWING NUMBER

M10.08

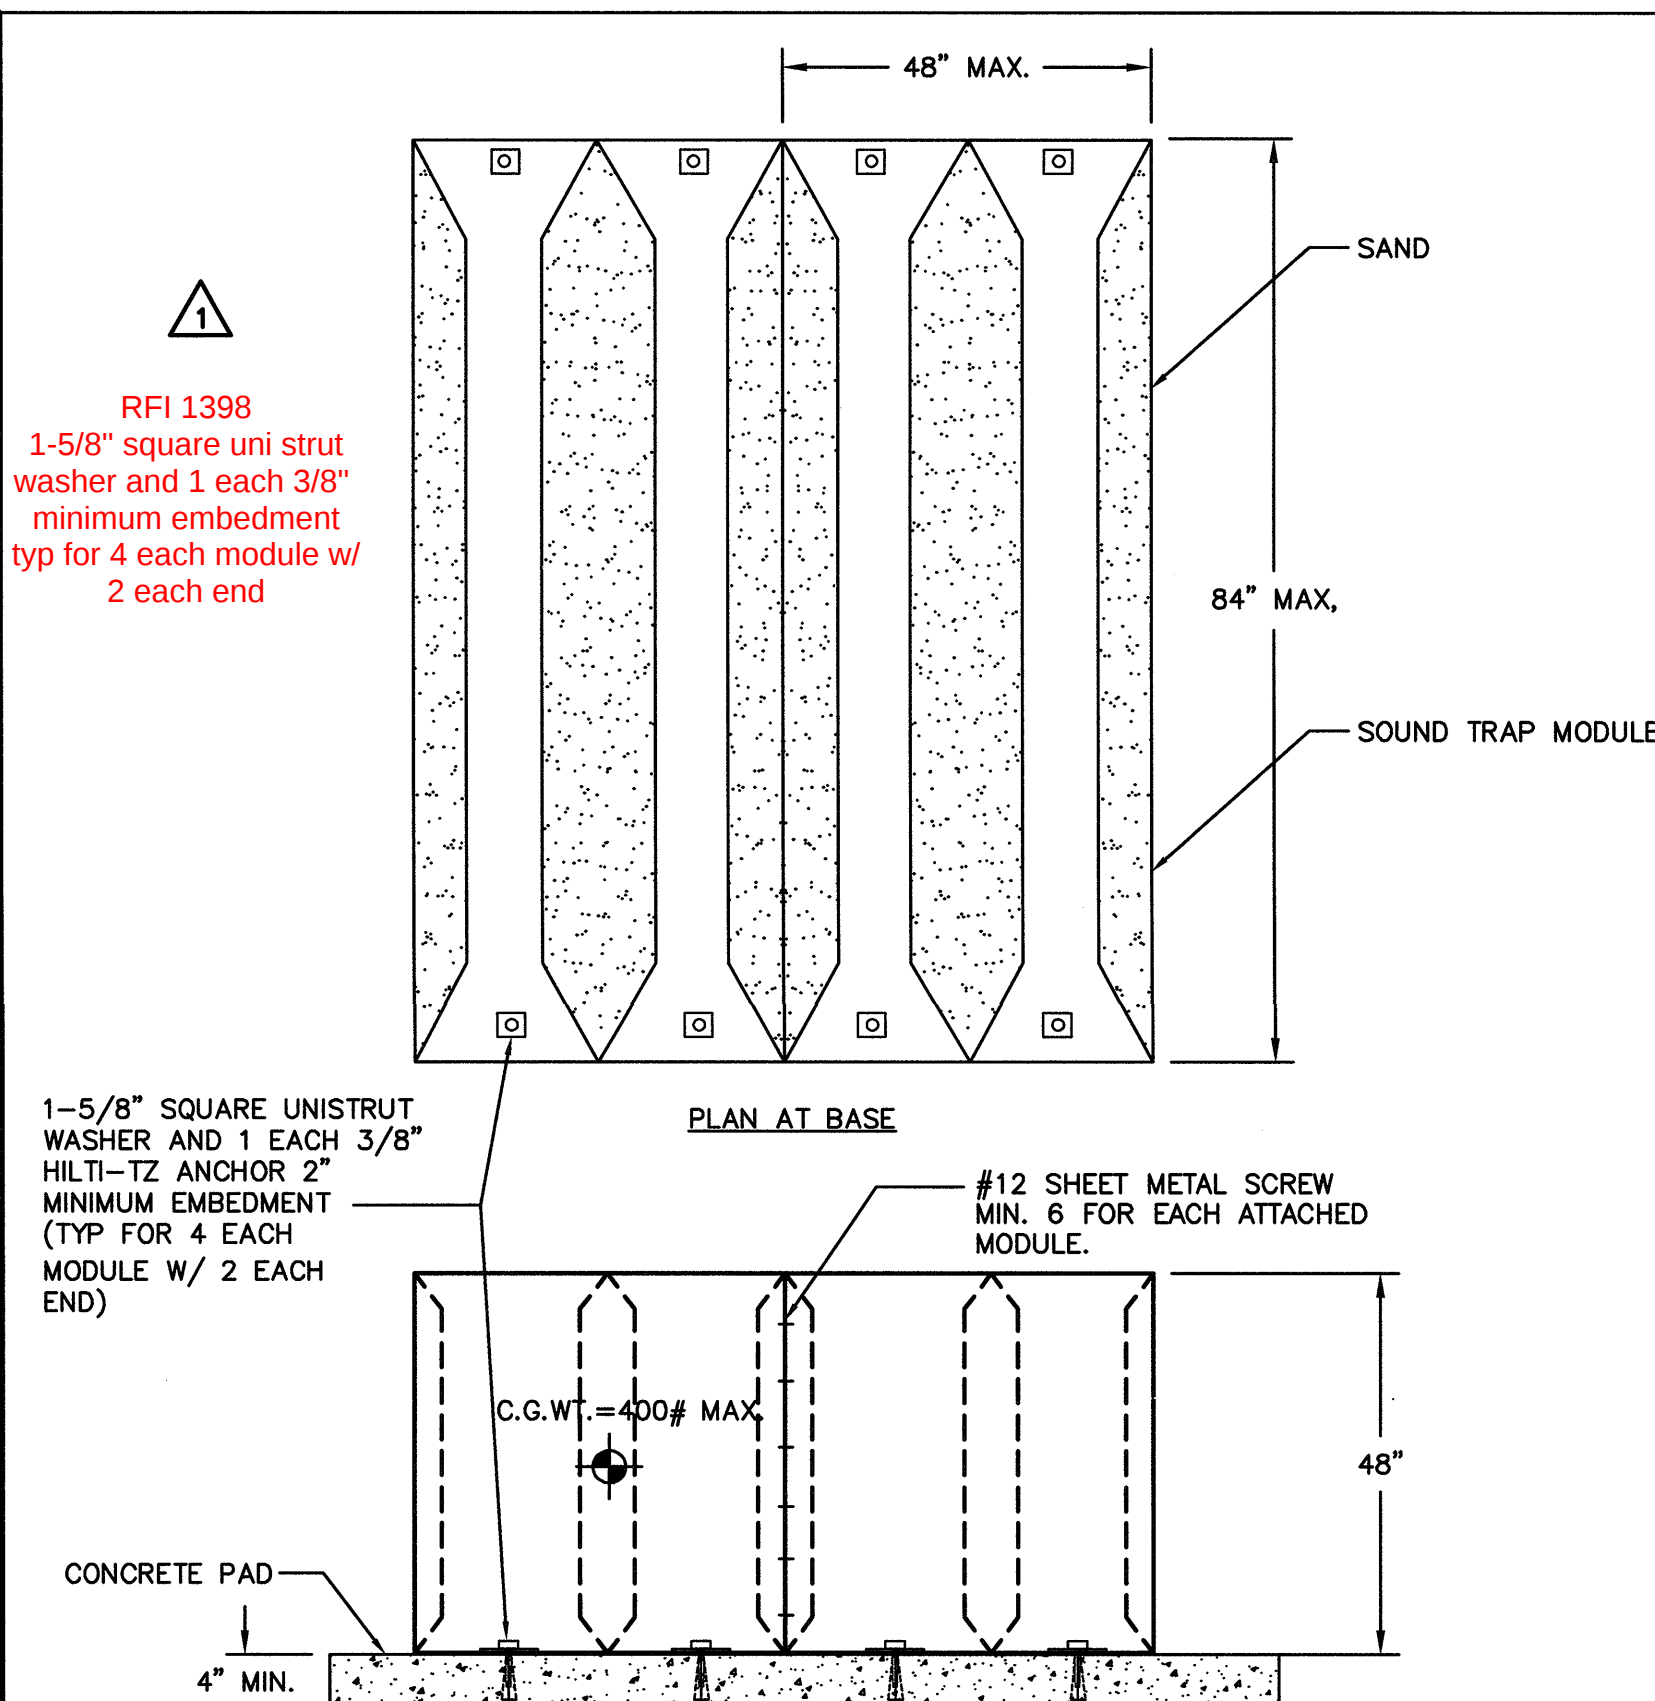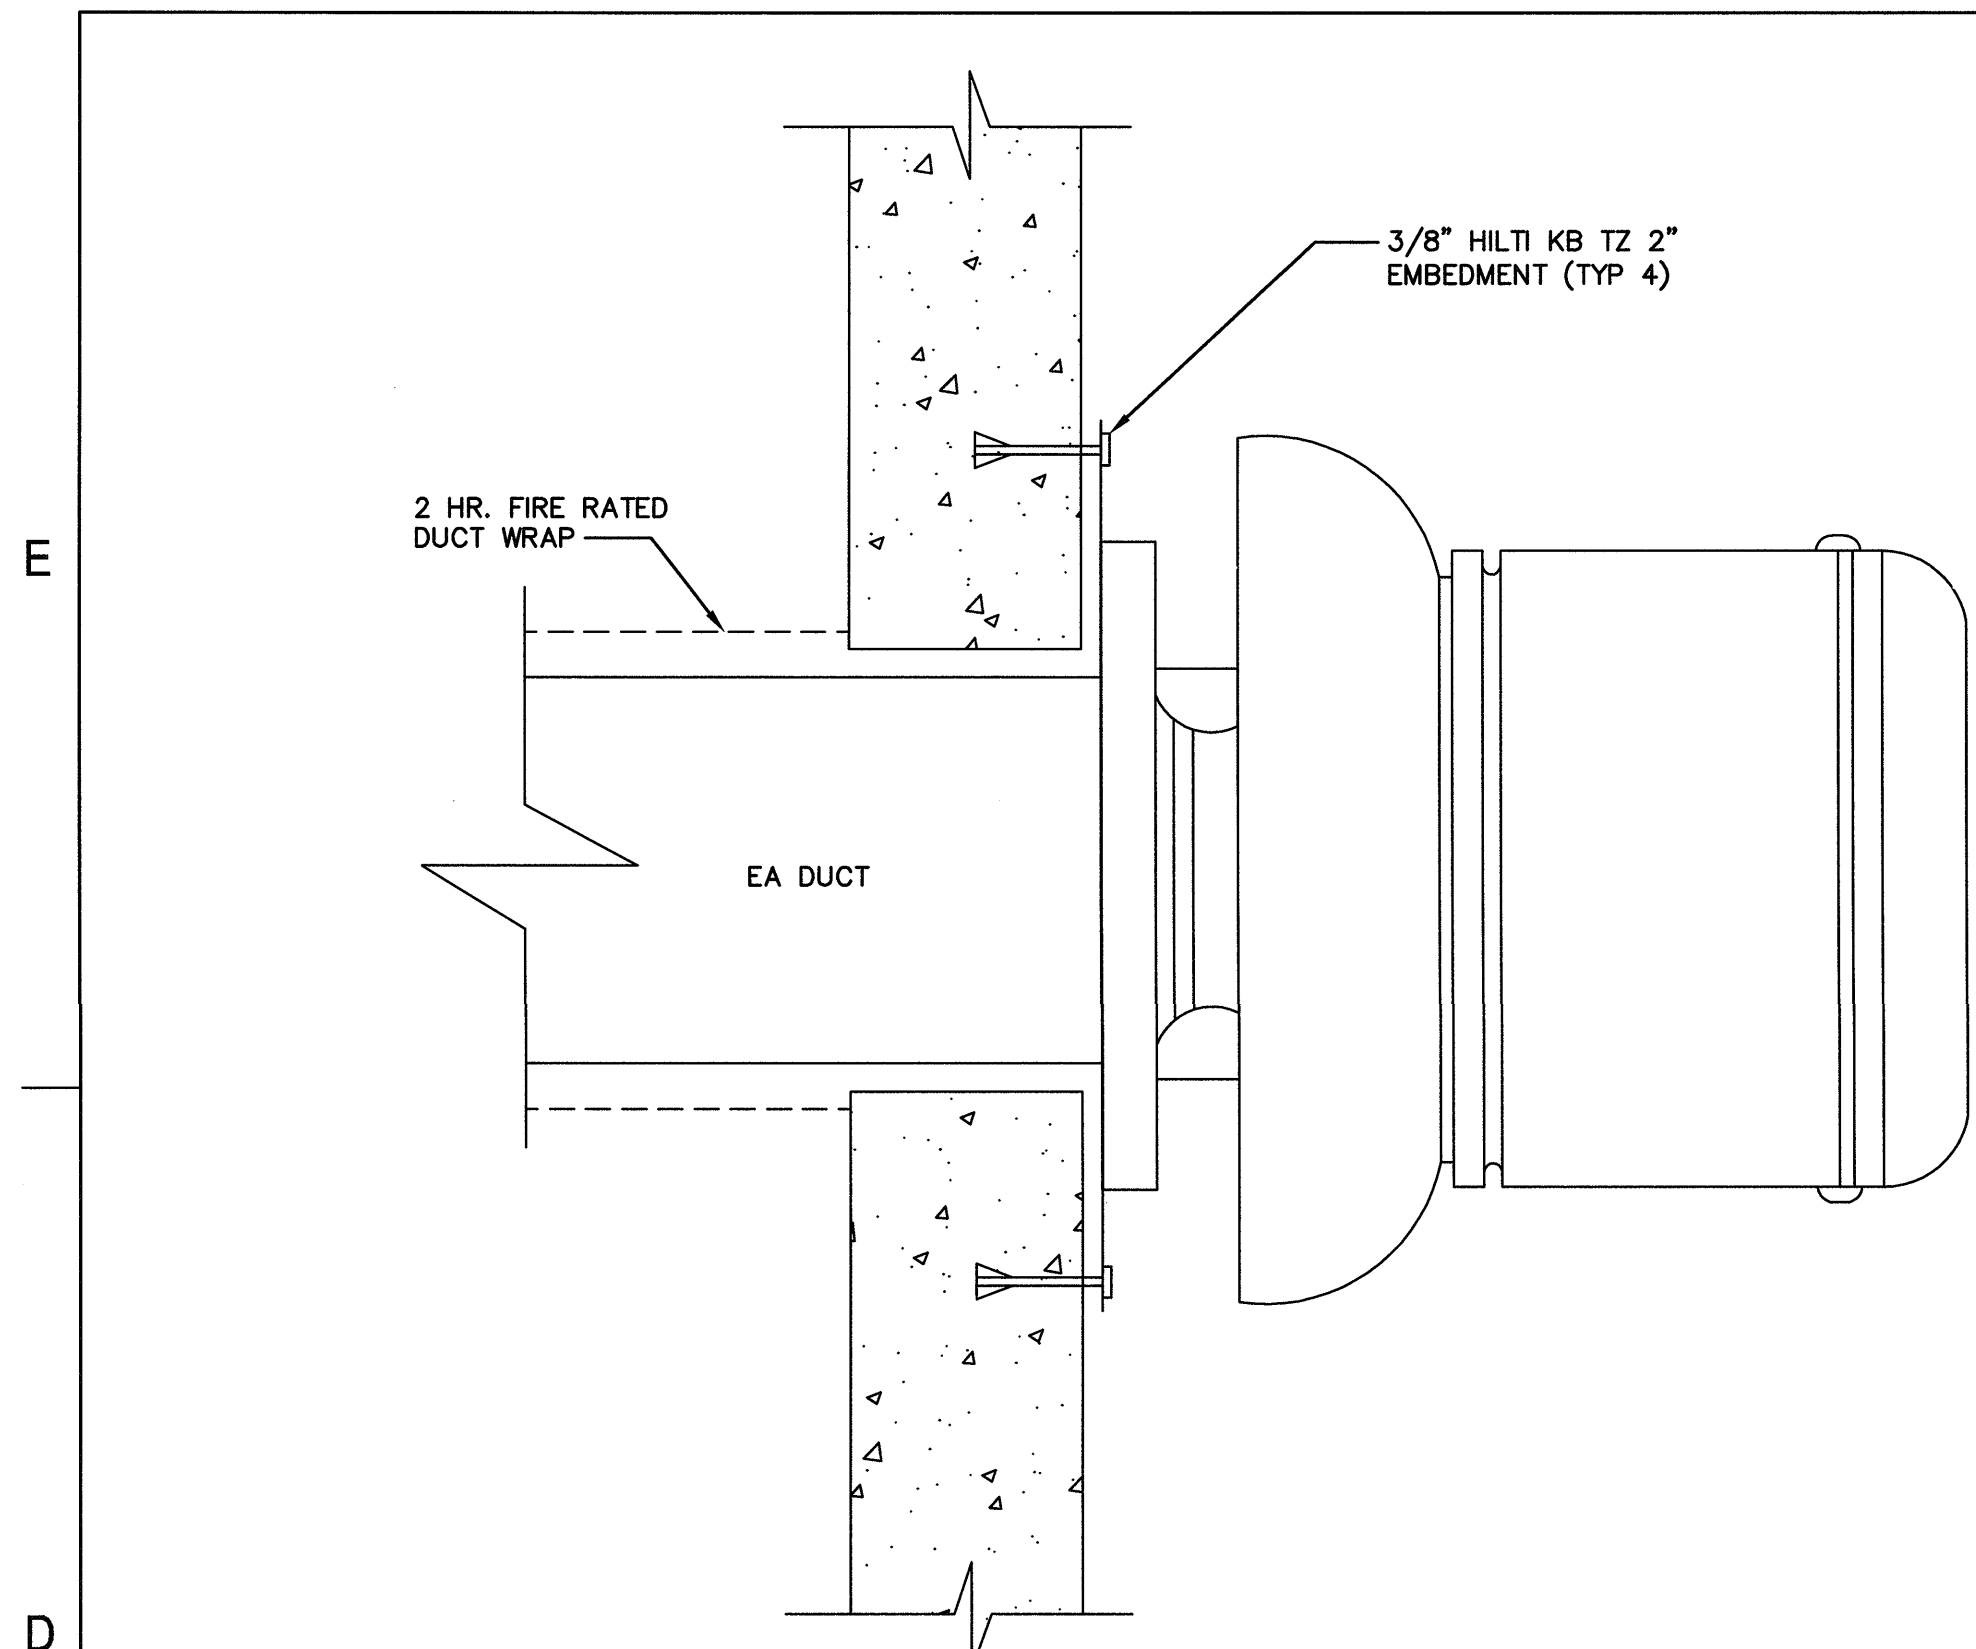


SOUND TRAP ANCHORAGE DETAIL

SCALE
NONE

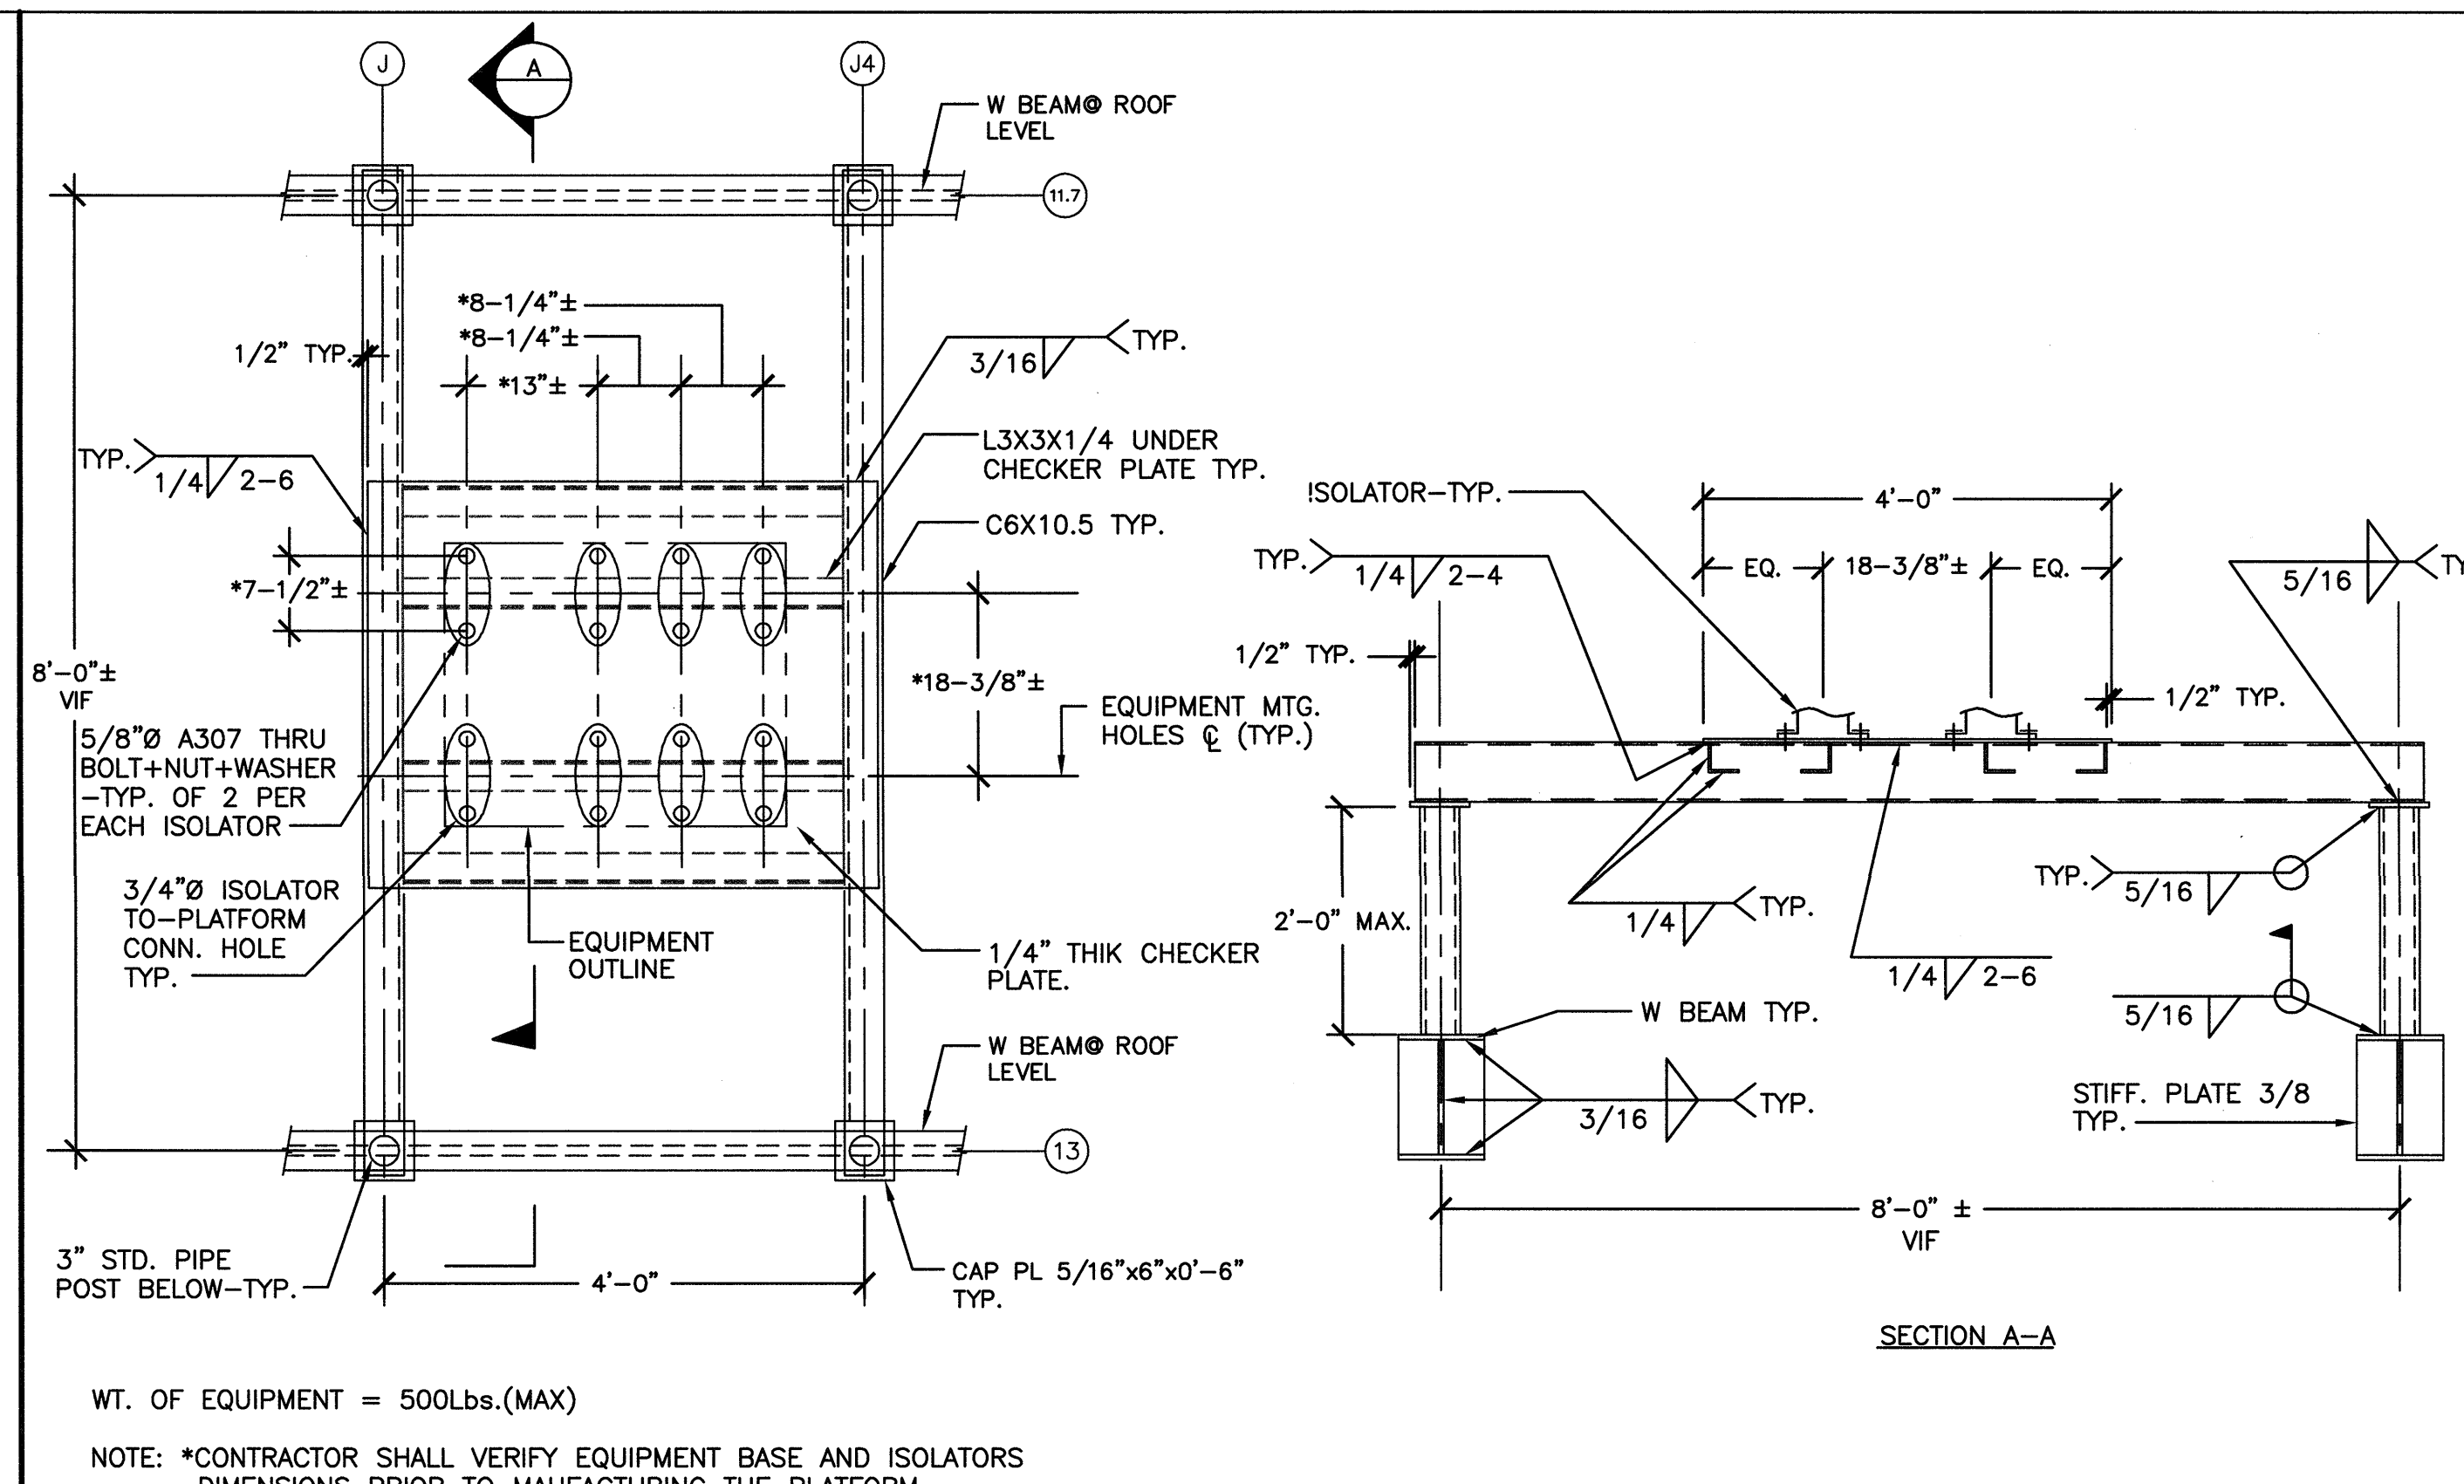


ANCHORAGE DETAIL EXHAUST FAN GEF-W5

SCALE
NONE

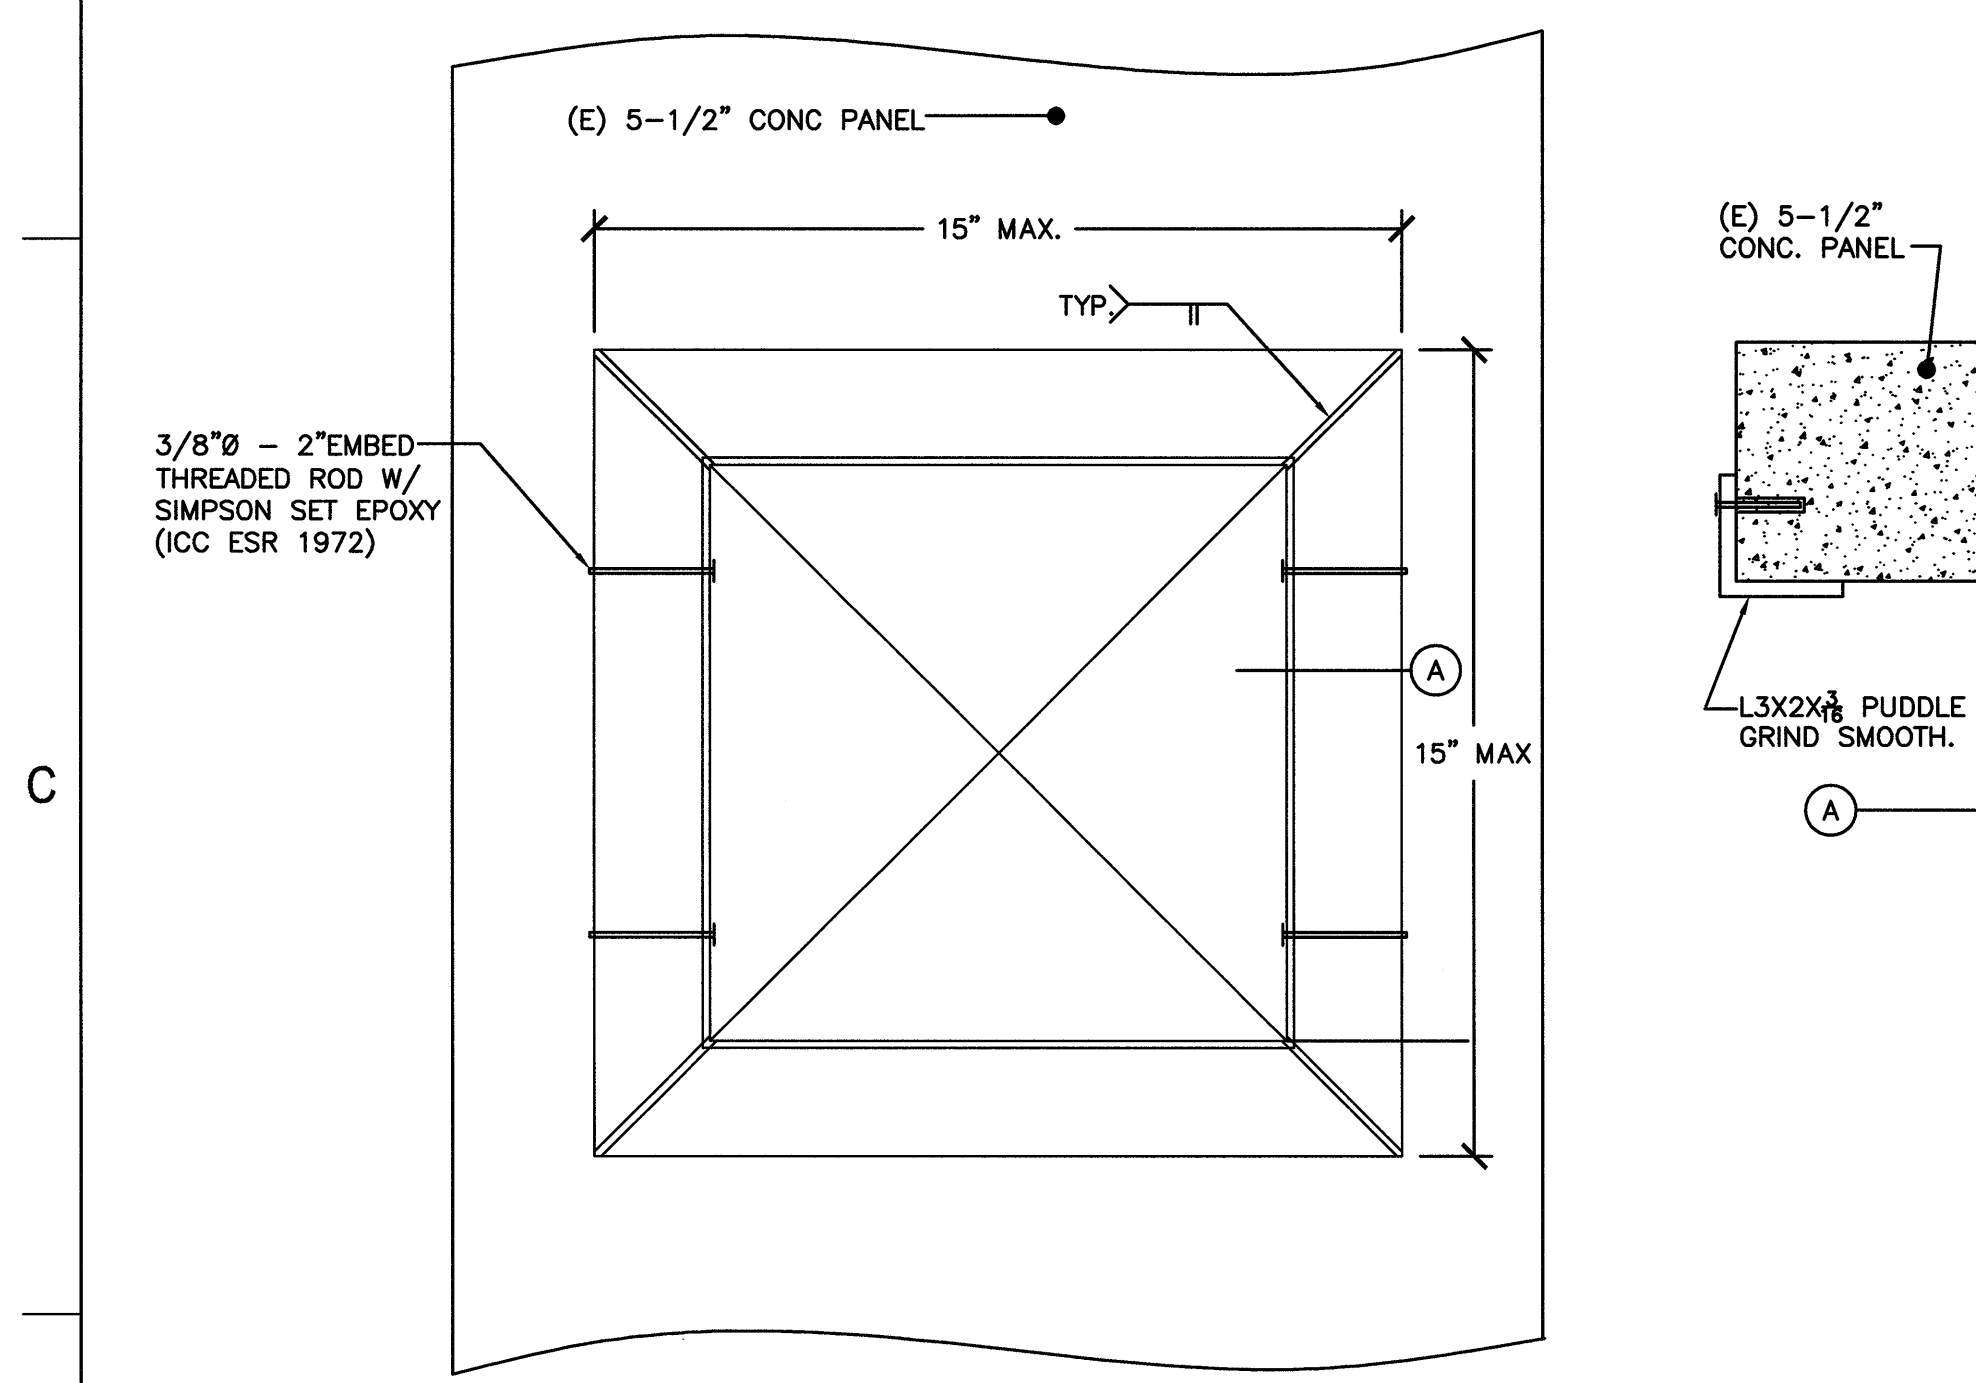


EXHAUST FAN MOUNTING DETAIL(EF-B2)

SCALE
NONE

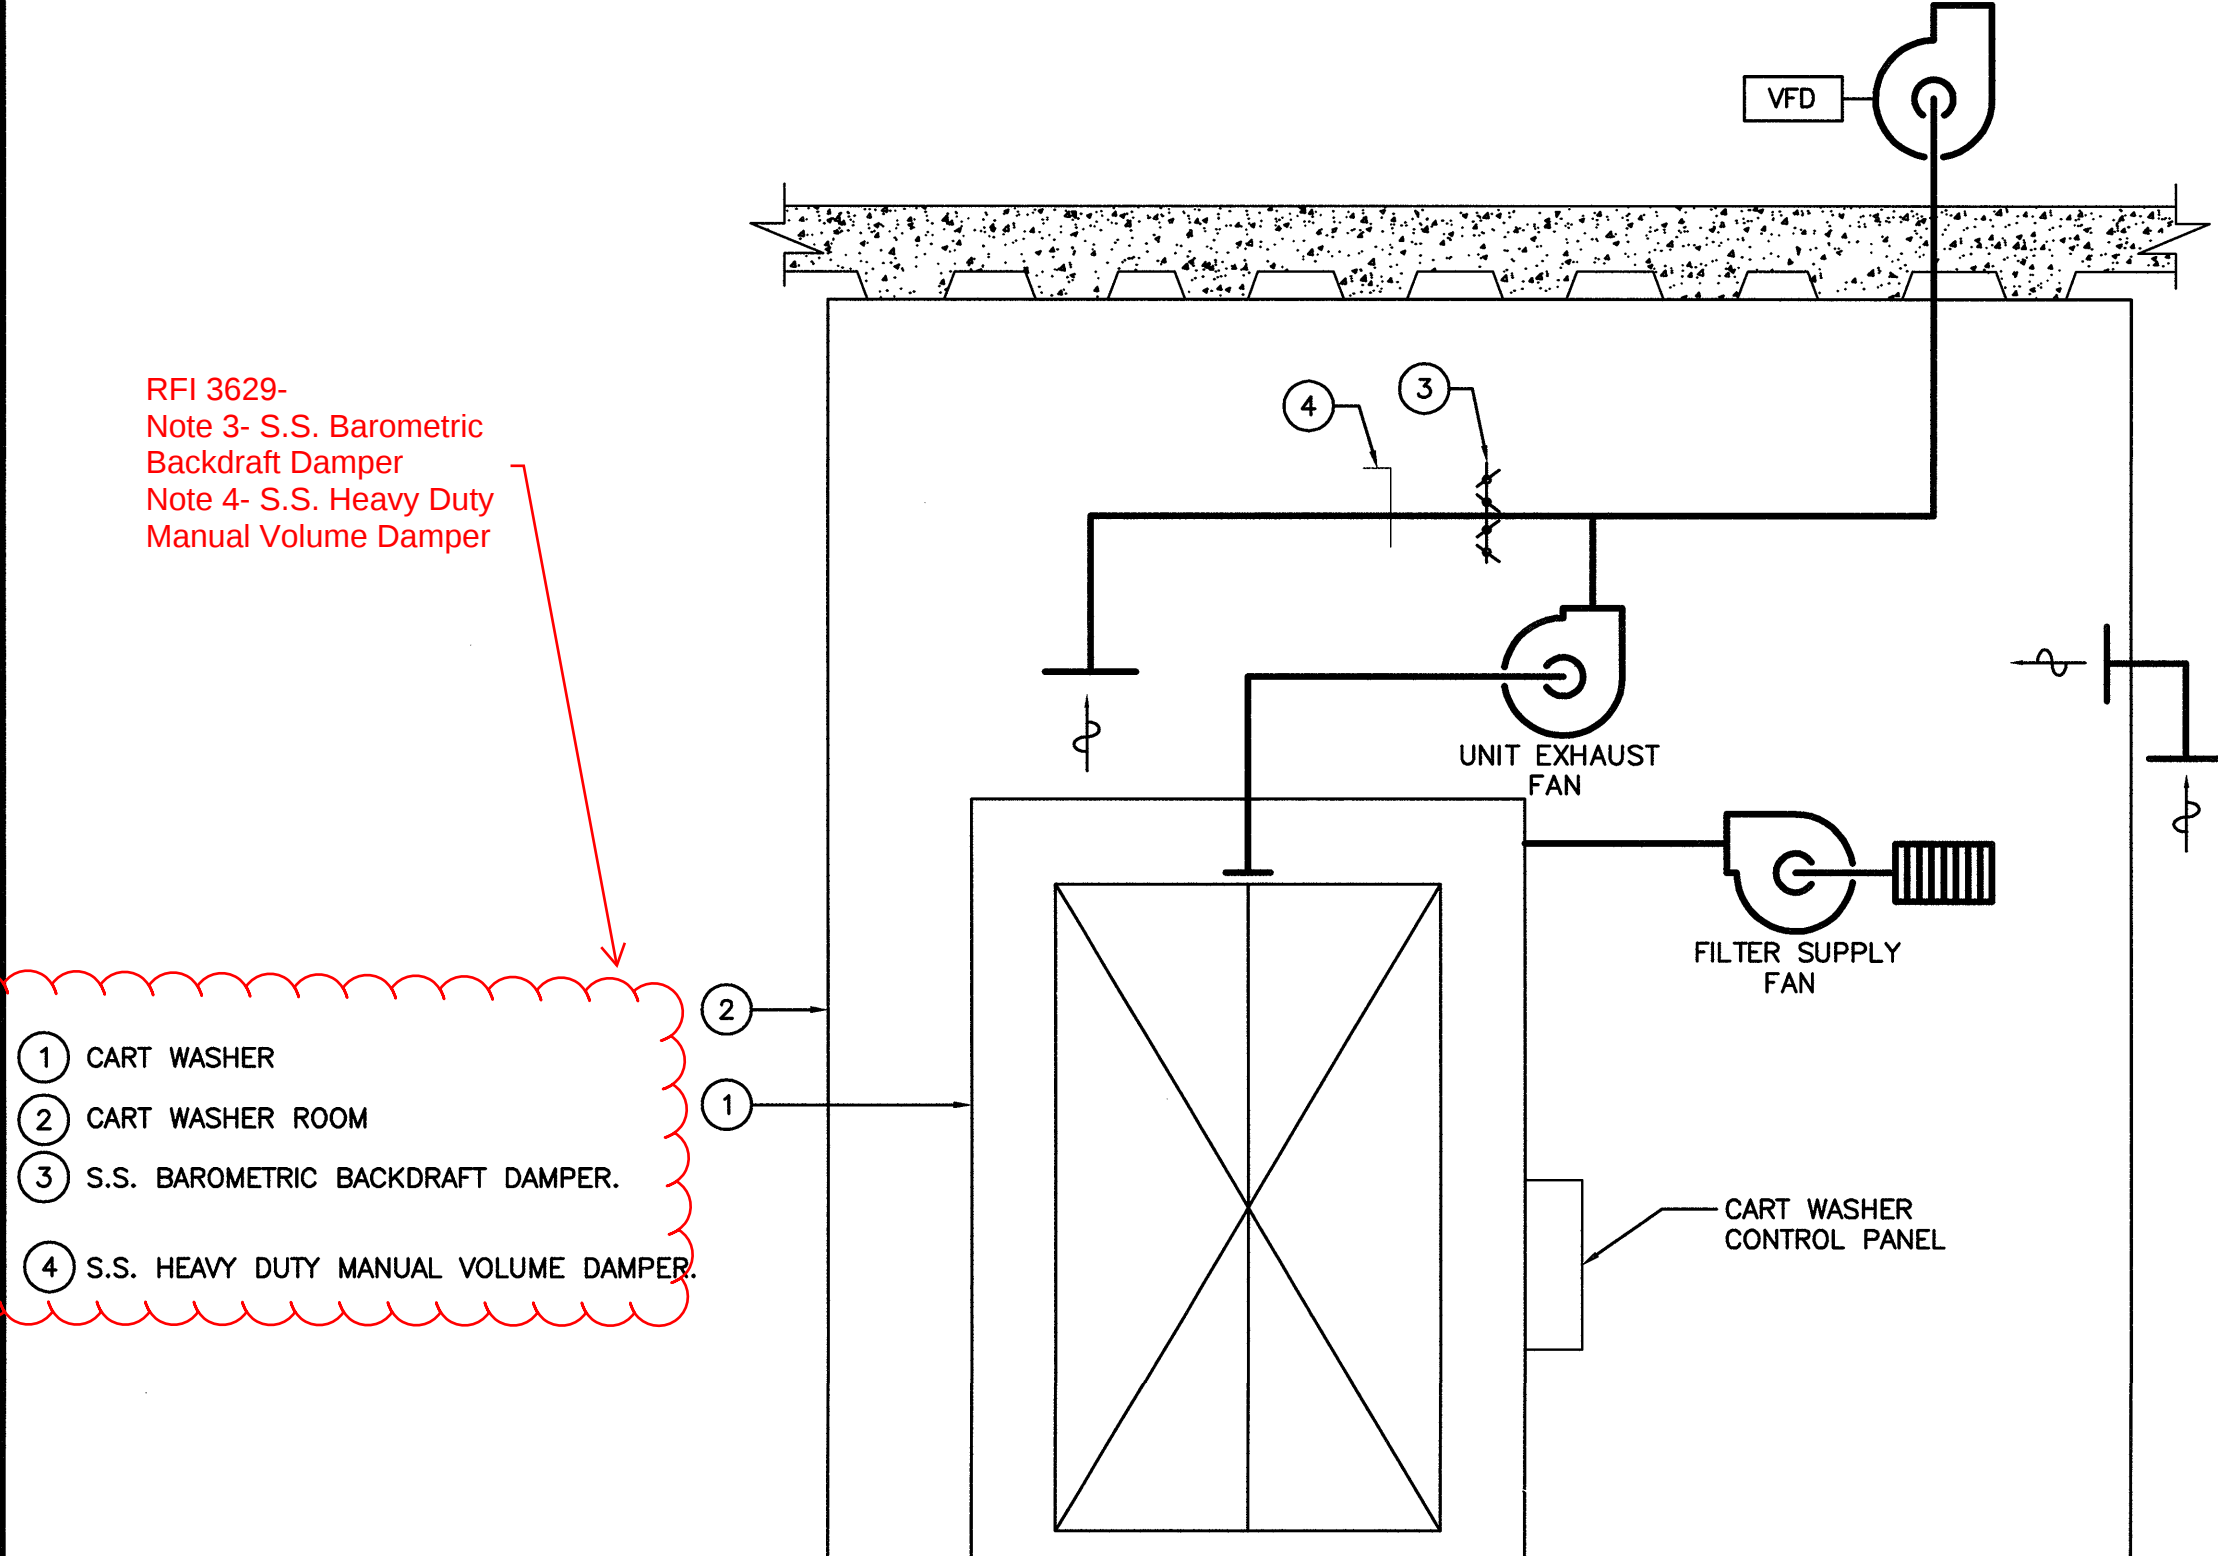


CART WASH CONTROL DIAGRAM

SCALE
NONE

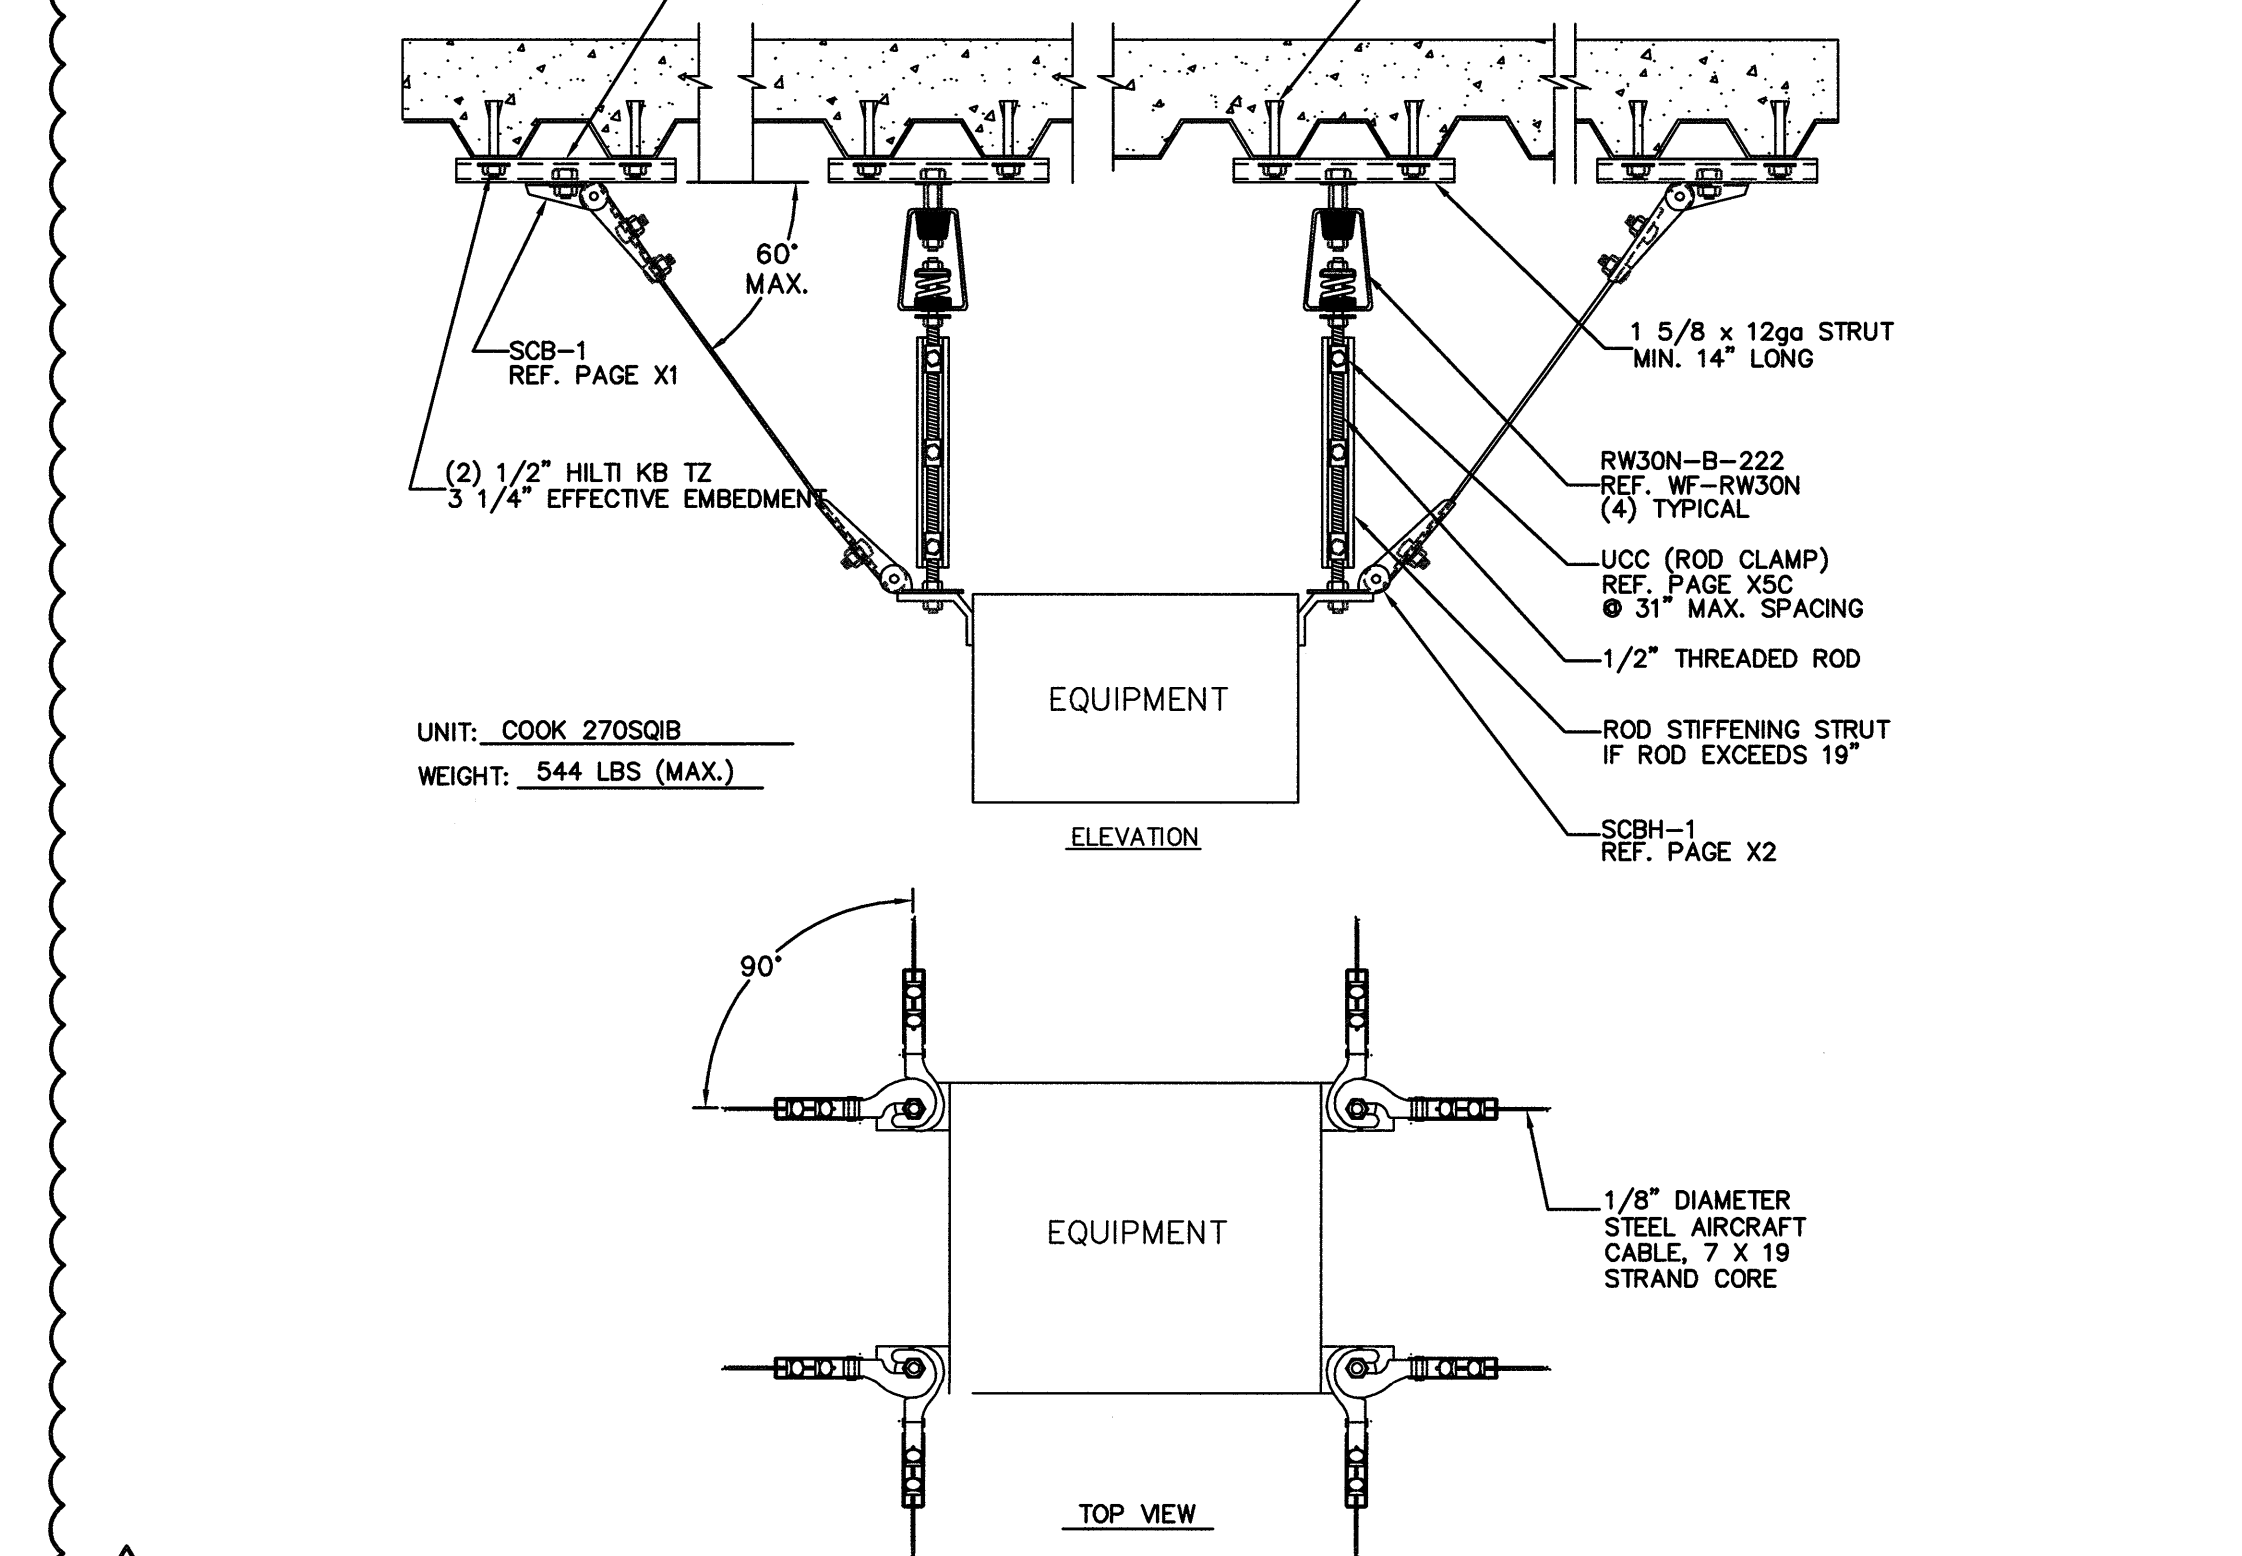


ANCHORAGE DETAIL FOR FAN EF-B1

SCALE
NONE

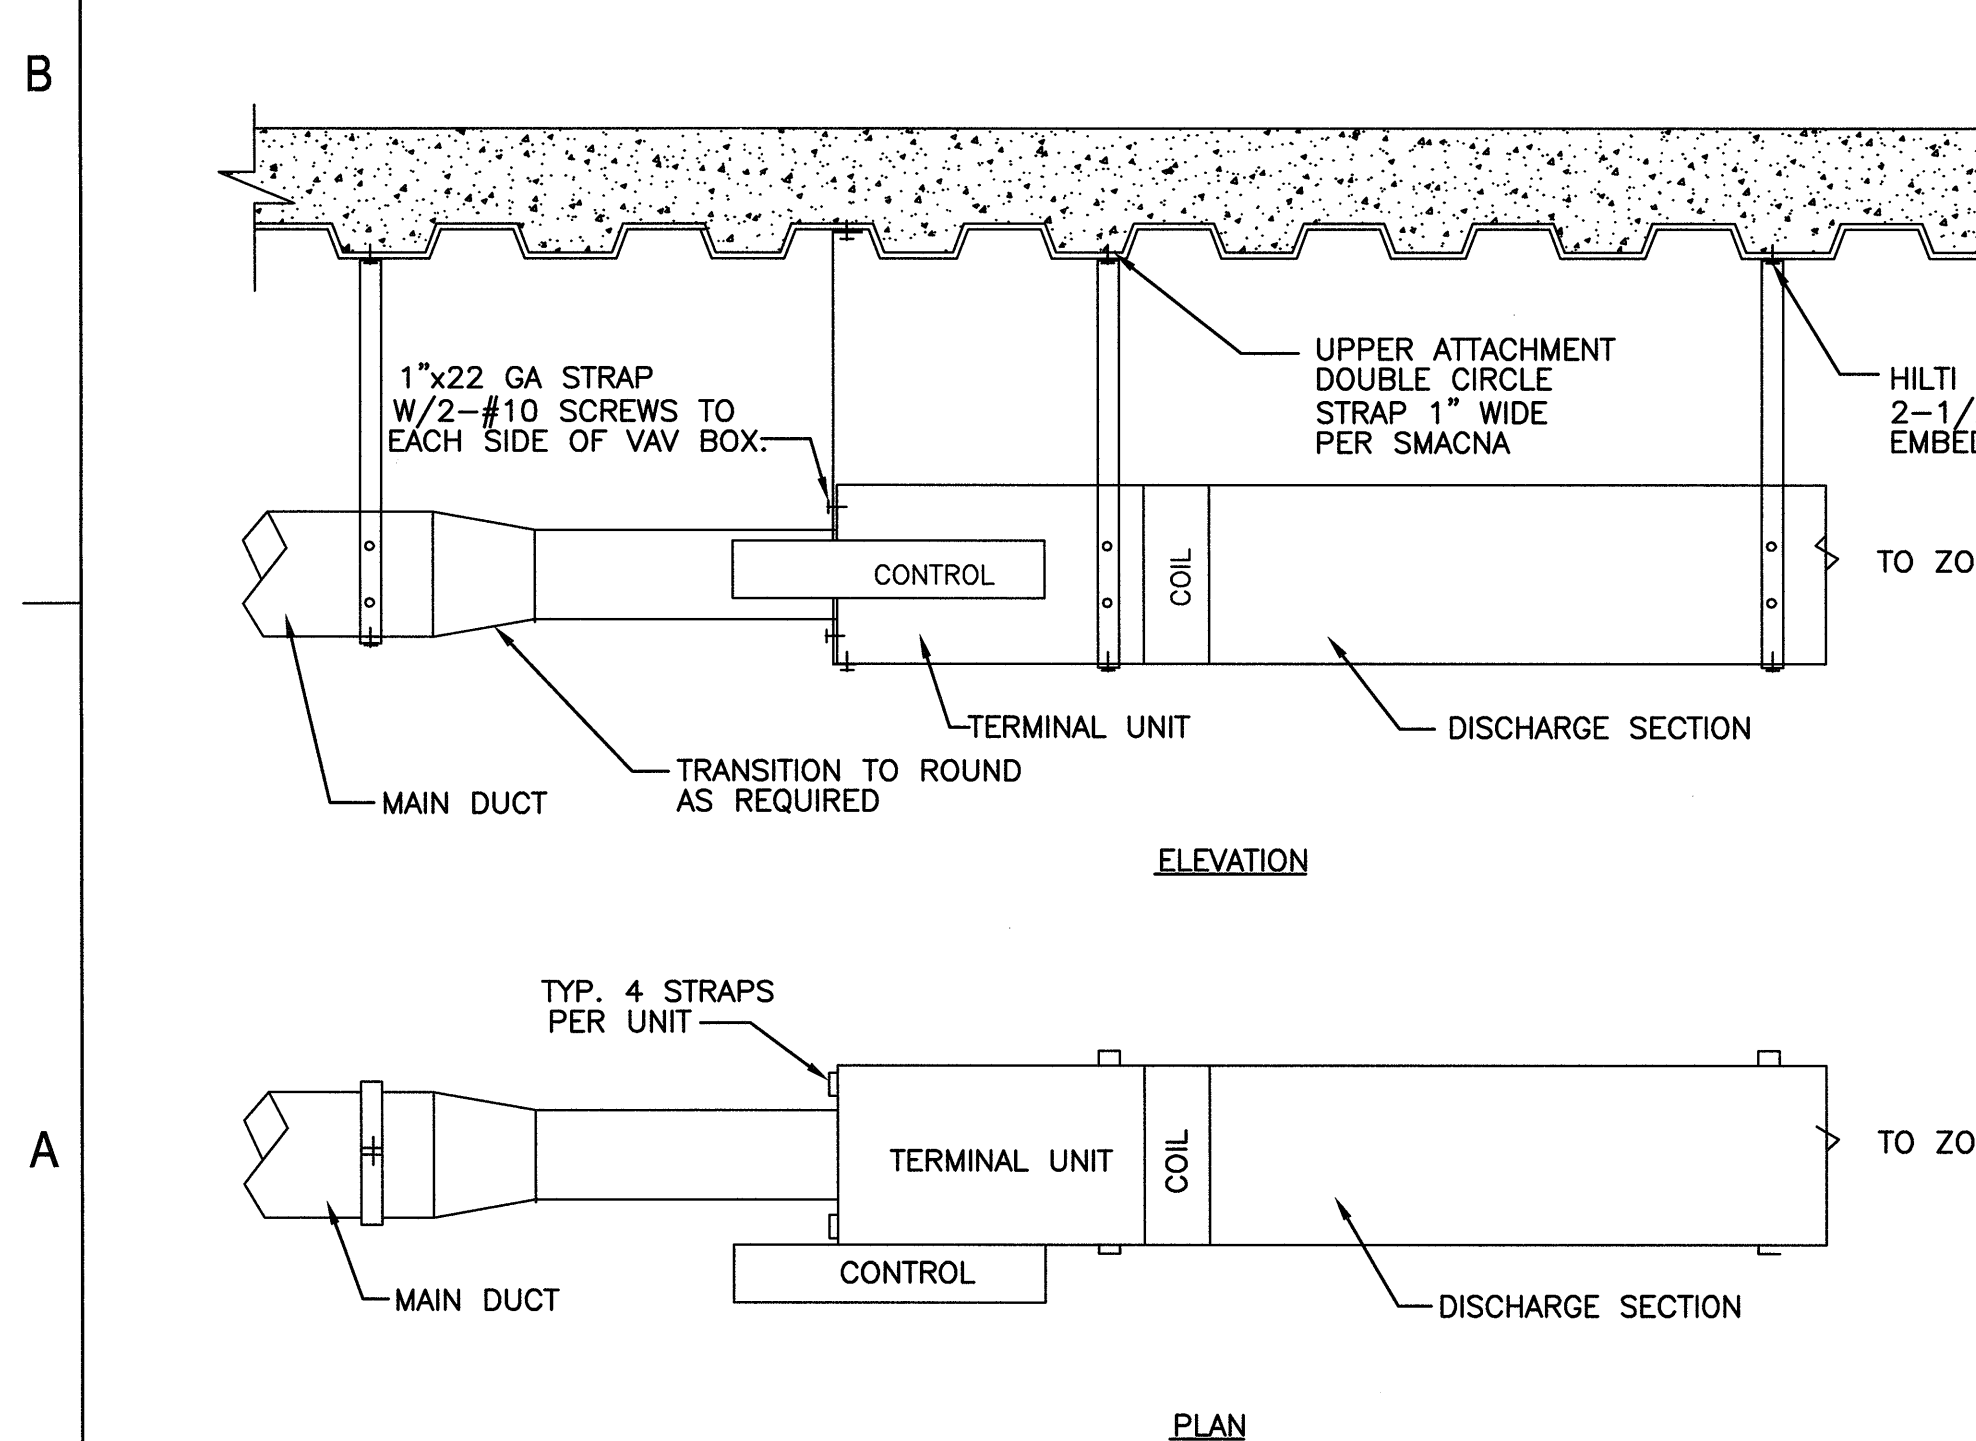


ANCHORAGE DETAIL FOR TERMINAL BOX LESS THAN 50 LBS

SCALE
NONE

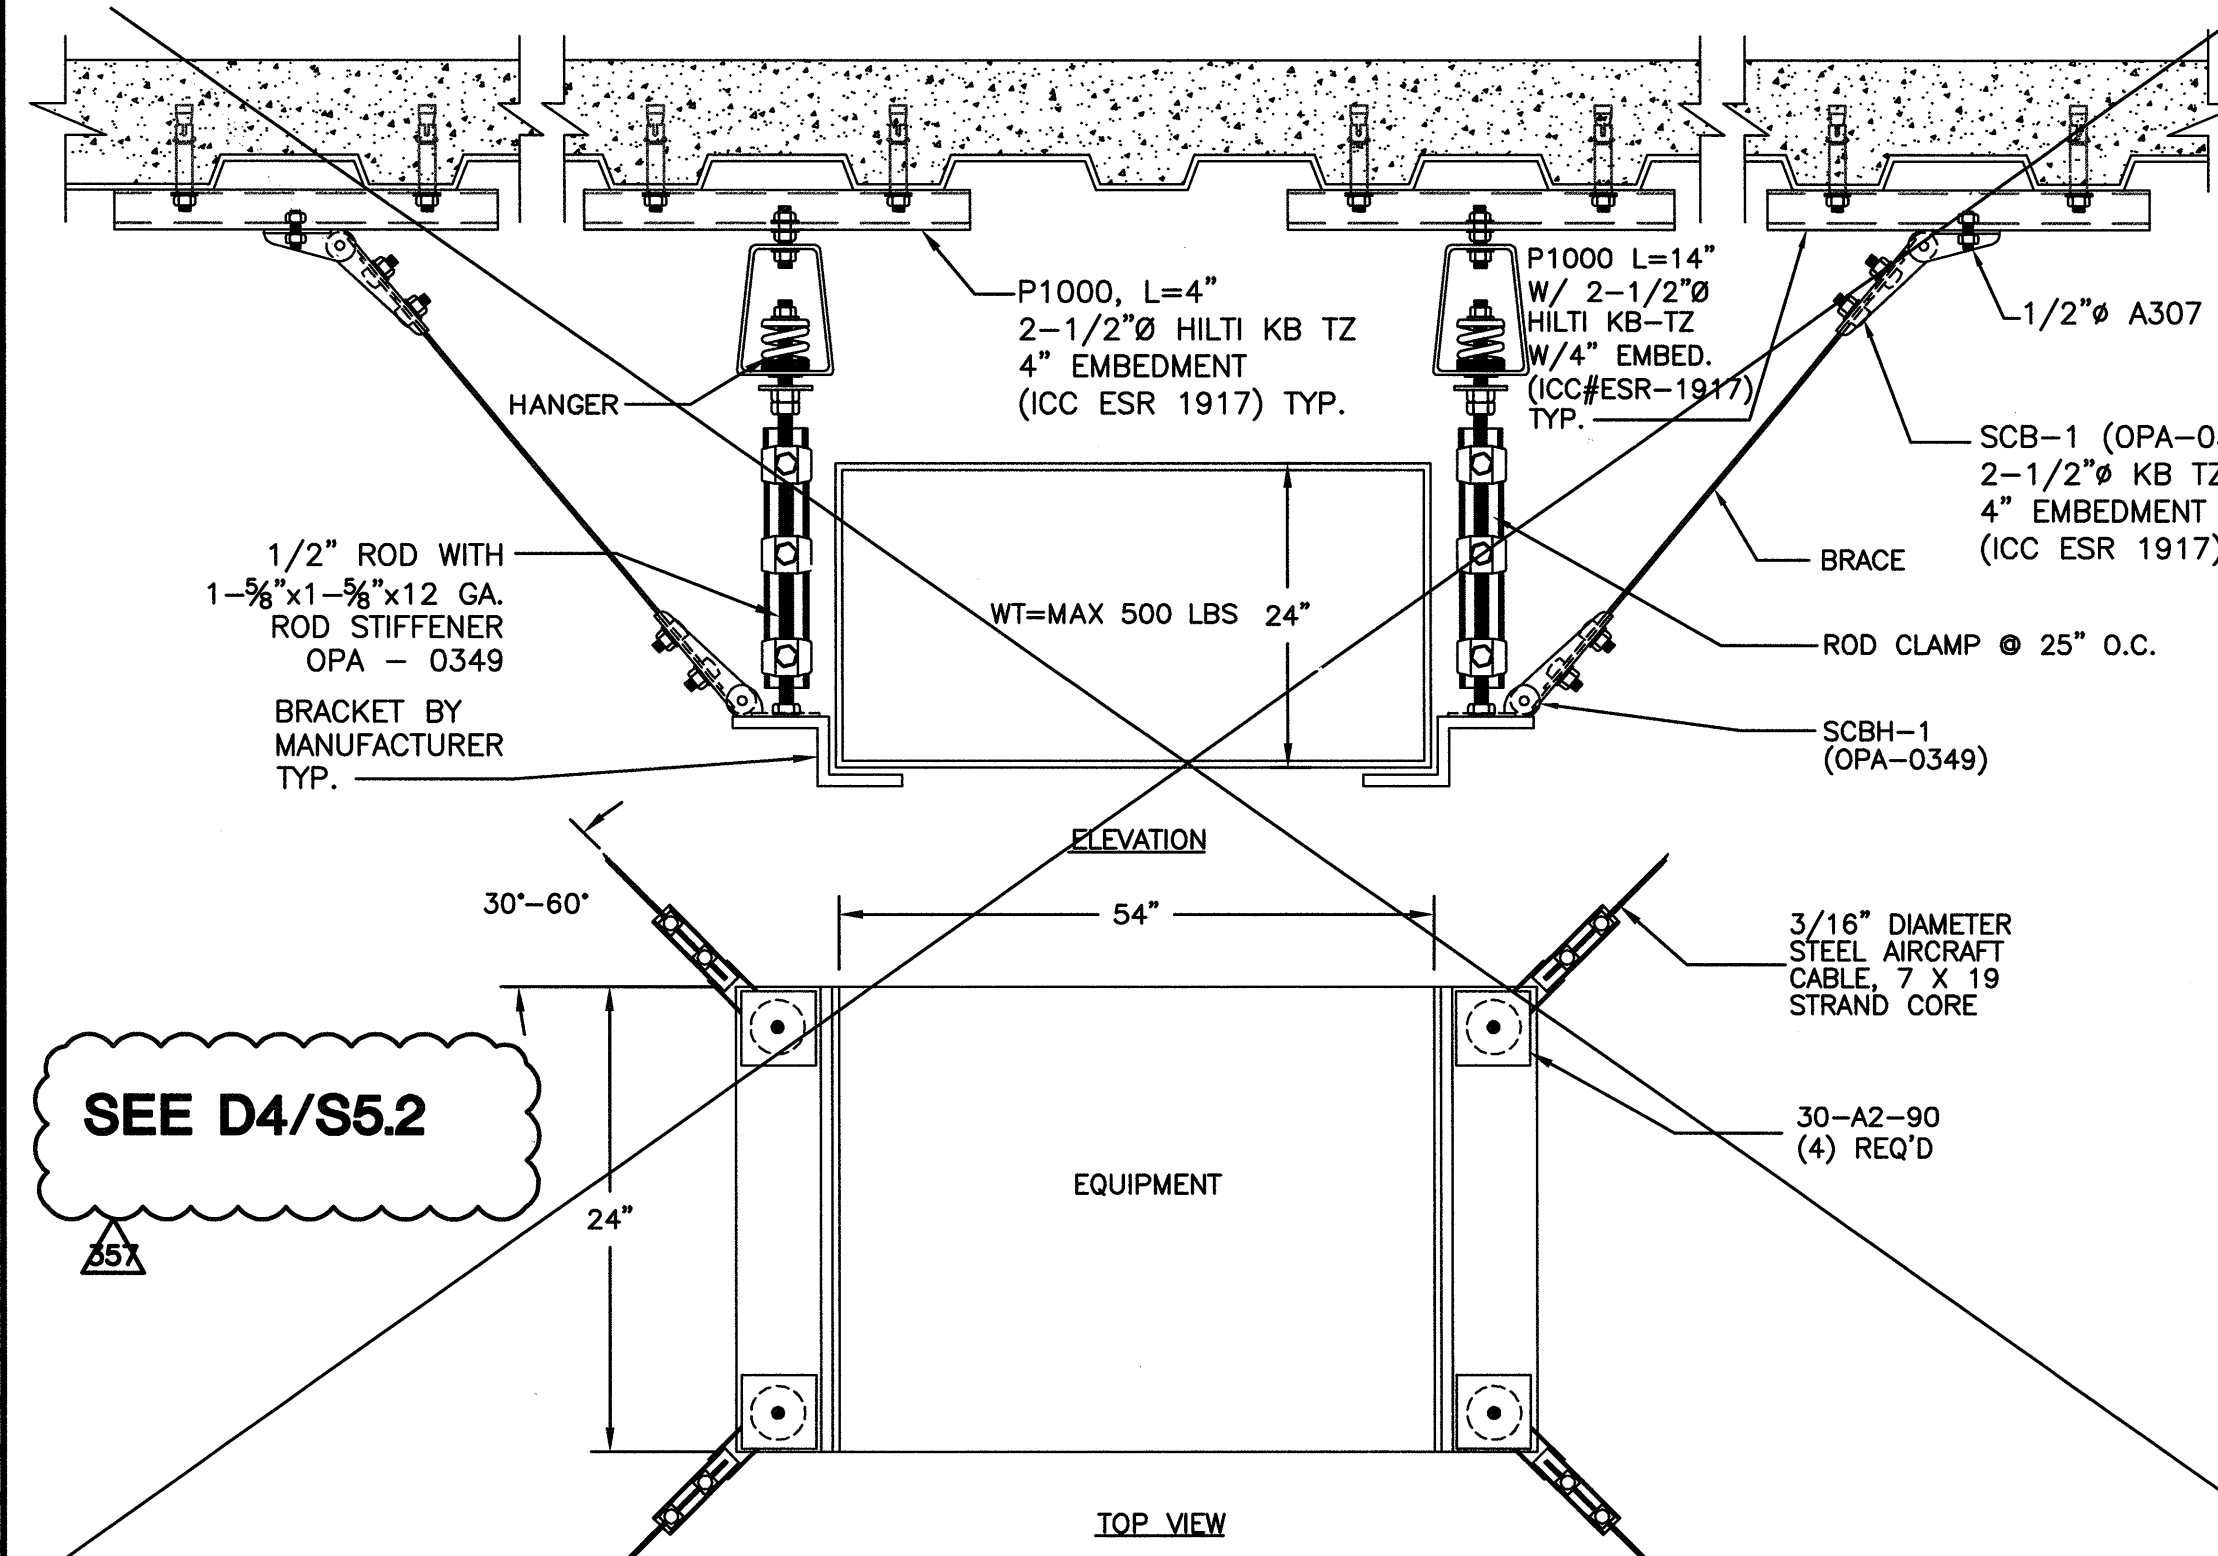

ANCHORAGE DETAIL FOR FC UNIT LESS THAN 500 LBS

SCALE
NONE

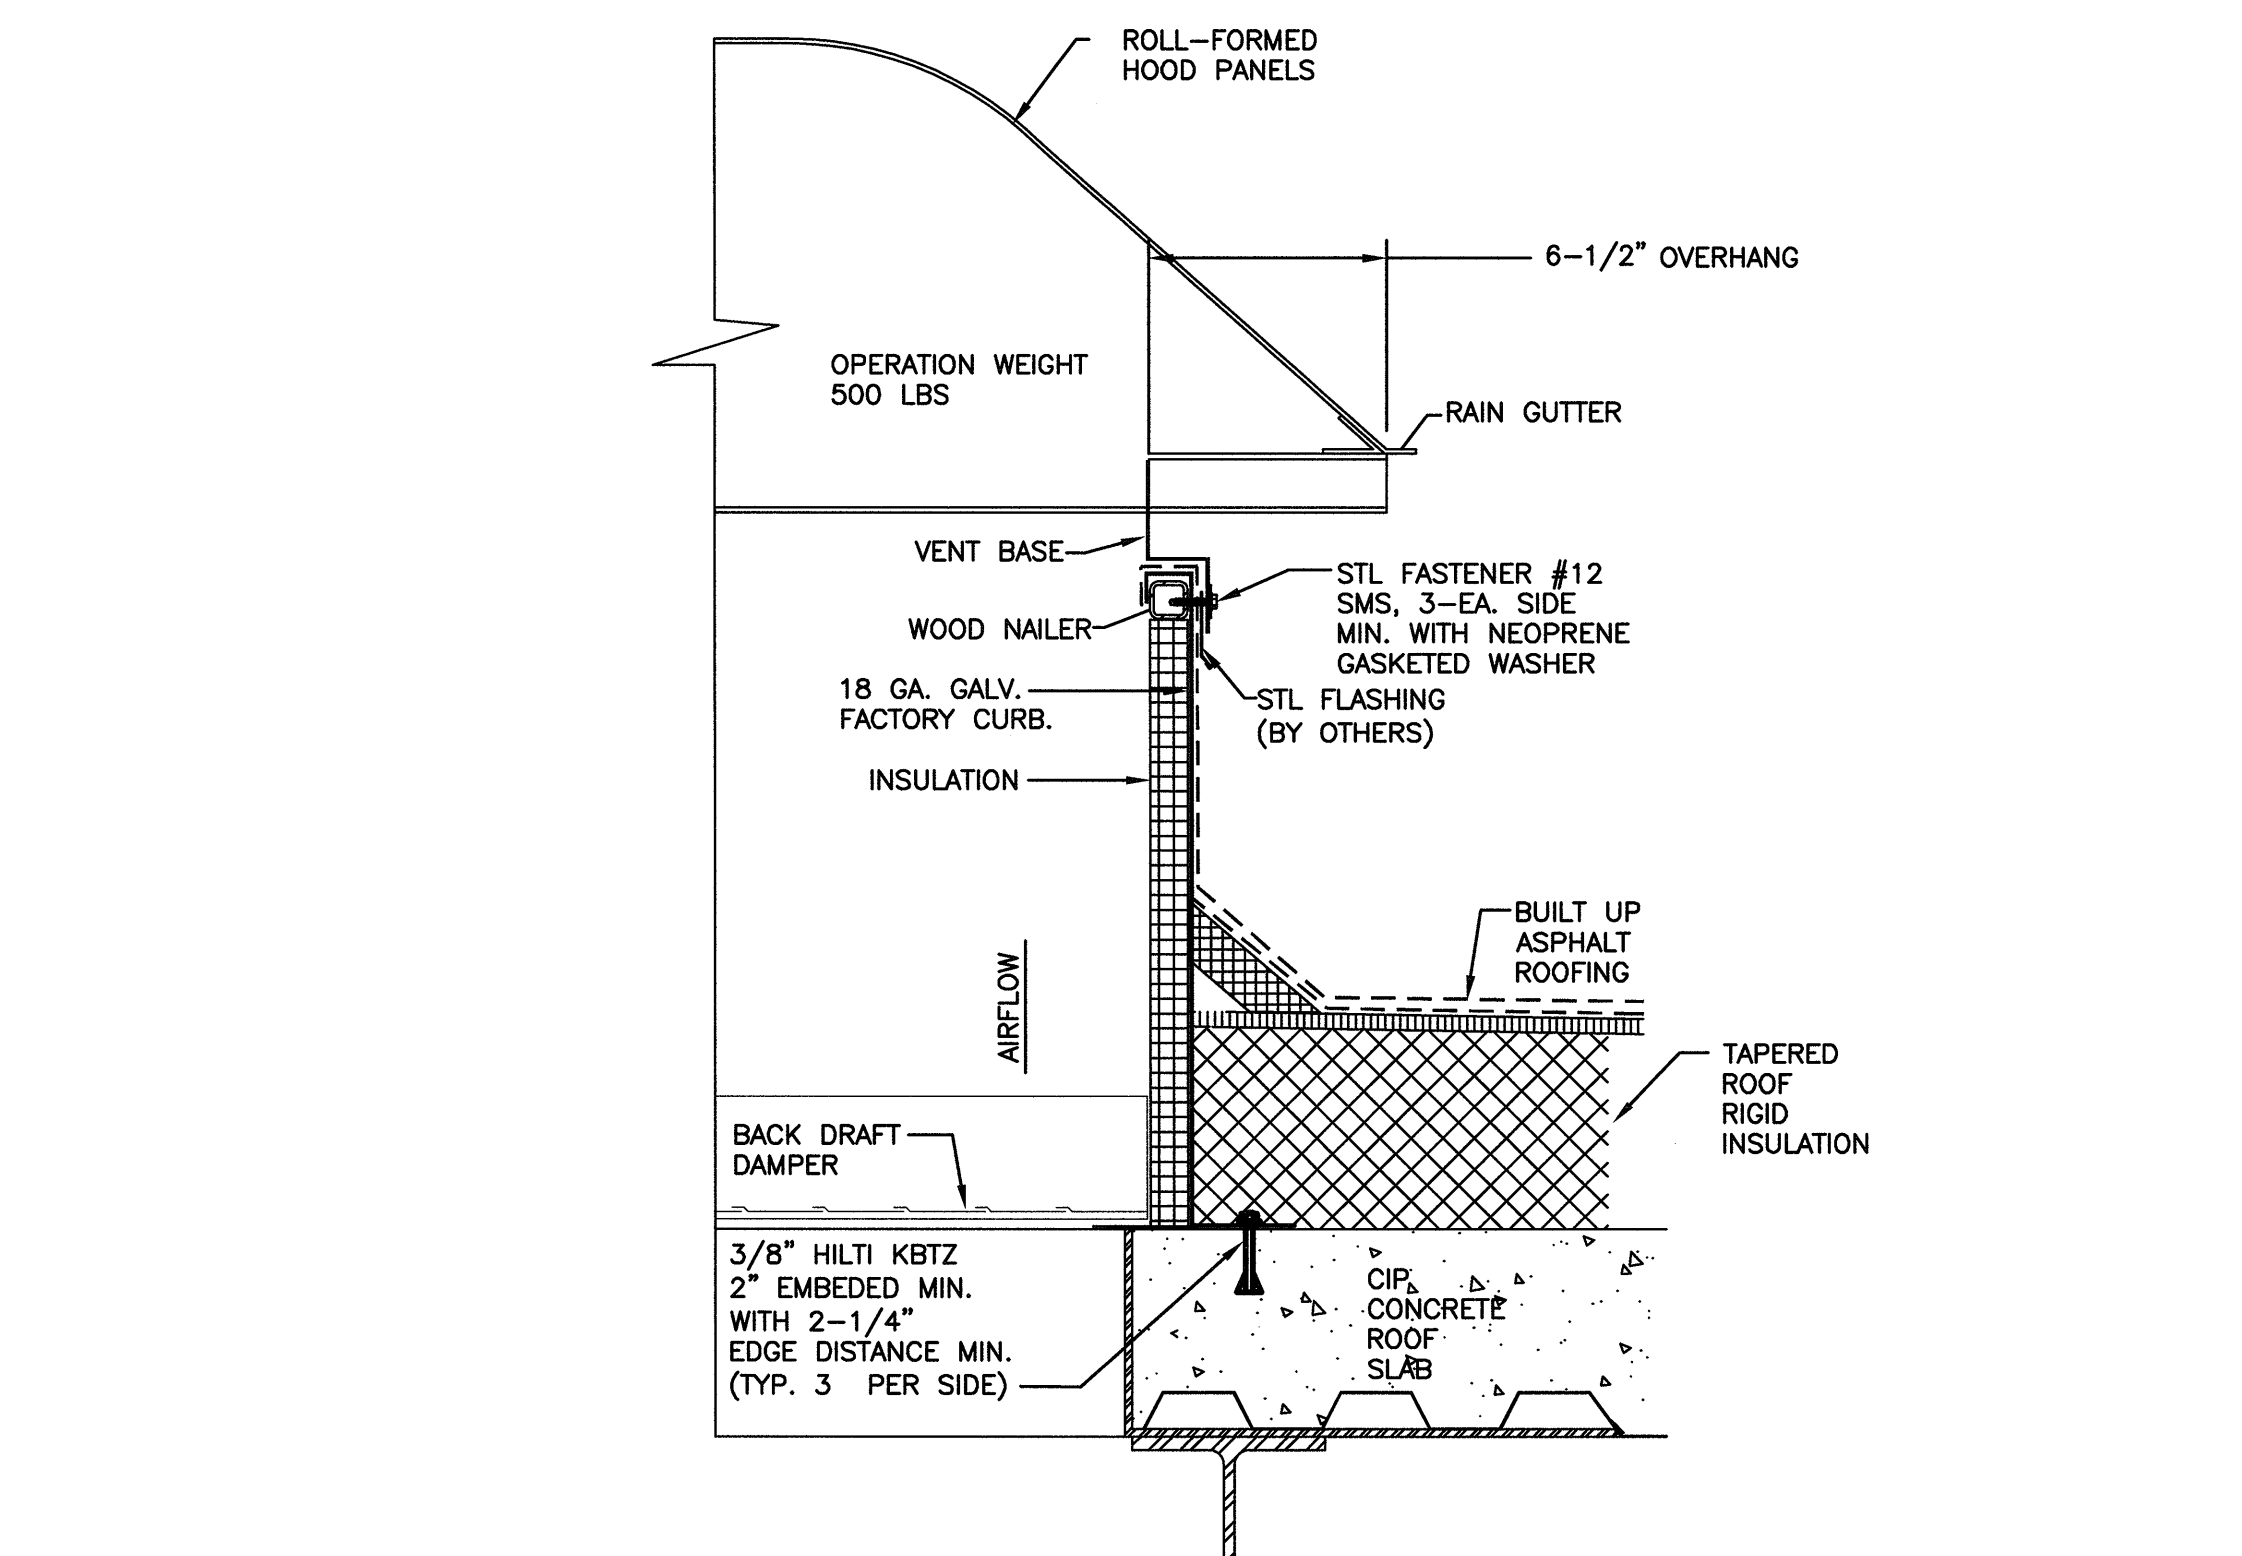

GRAVITY VENT/MUSHROOM EXHAUST FAN MOUNTING DETAIL

SCALE
NONE