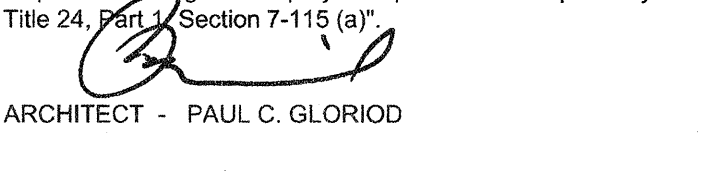


FKP Architects

ARCHITECT OF RECORD

"Architect of Record signature line only; this drawing was not prepared under the direct supervision of the Architect of Record. The direct responsibility for preparation of this sheet lies with its corresponding professional stamp and signature. The signature of the Architect of Record in general responsible for the project is provided as required by Title 24, Part 7, Section 7-115 (a)."


ARCHITECT - PAUL C. GLORIOSO

CONSULTANT

T M A D
TAYLOR & GAINES
 • STRUCTURAL
 • MECHANICAL
 • ELECTRICAL
 • CIVIL

100 South Anaheim Boulevard, Suite 150
 Anaheim, California 92805
 Phone: 714.490.5555 Fax: 714.490.5560
 Project No. 2305-163-07

REVISIONS

05/19/2010 OSHPD CHANGE ORDER #30
 09/14/2010 CHANGE ORDER #26

APPROVAL

Office of Planning and Research
 Planning & Development
 1501 Clay Street, Suite 200
 San Francisco, CA 94109
 00# 26

PROJECT NAME

**CHILDREN'S HOSPITAL
 OF ORANGE COUNTY**

455 S. Main St.
 Orange, CA 92668-3874

TOWER II



PROJECT NUMBER

**12011.00
 Increment #7**

OSHPD - PROJECT NUMBER
 IL 072072-30

ISSUE

OSHPD PERMIT

DATE

01/27/2010

SCALE






DRAWING TITLE

**MECHANICAL DETAILS -
 HVAC EQUIPMENT -
 ANCHORAGE DETAILS**






DRAWING NUMBER

M10.10




E

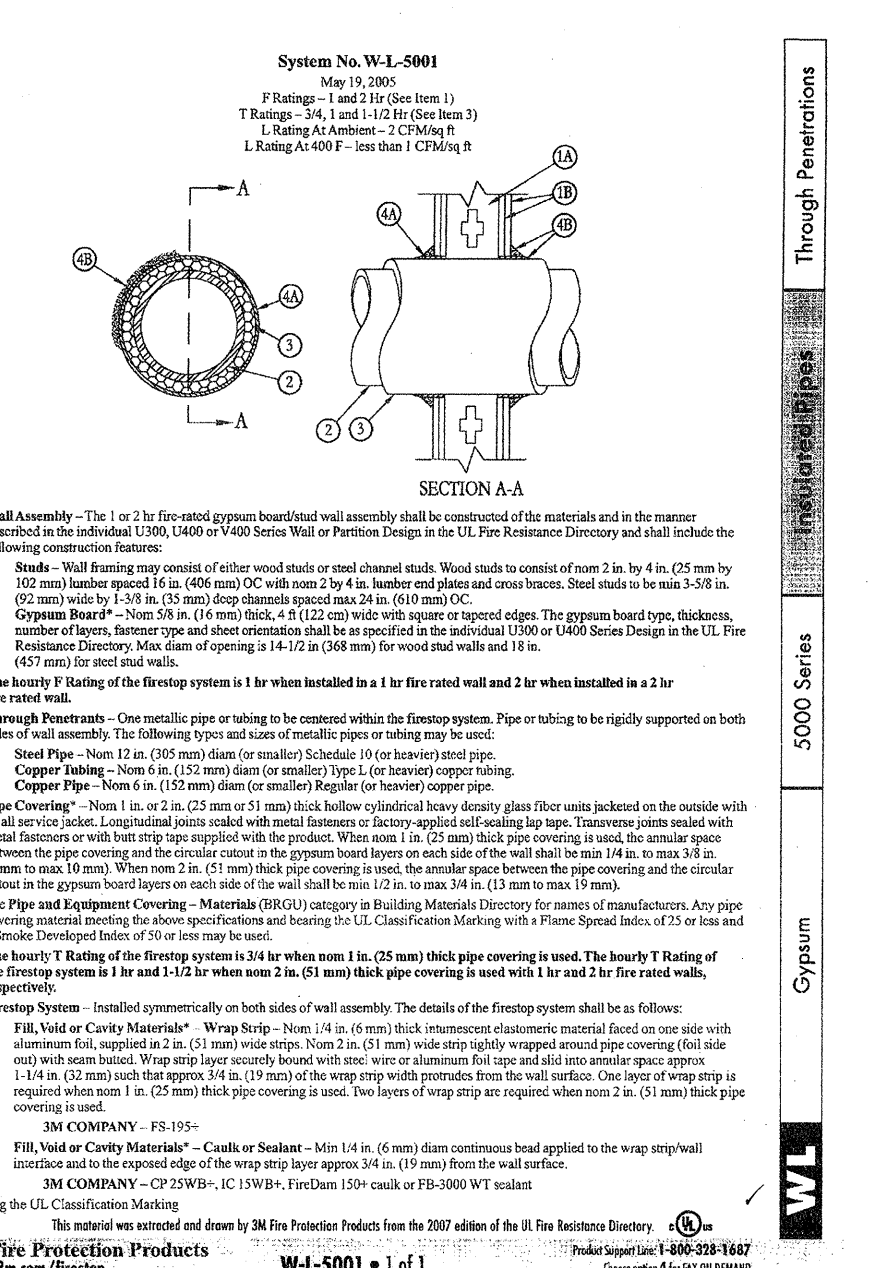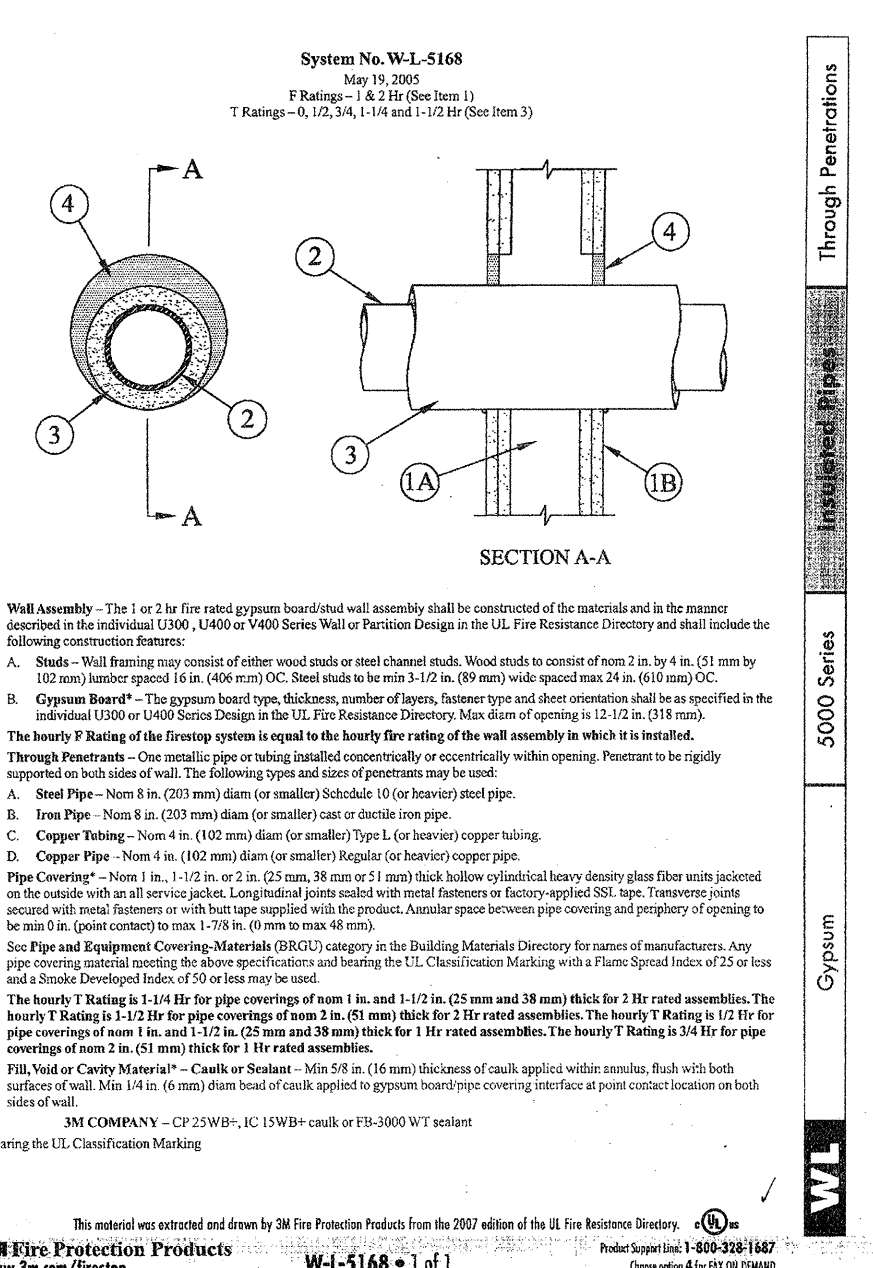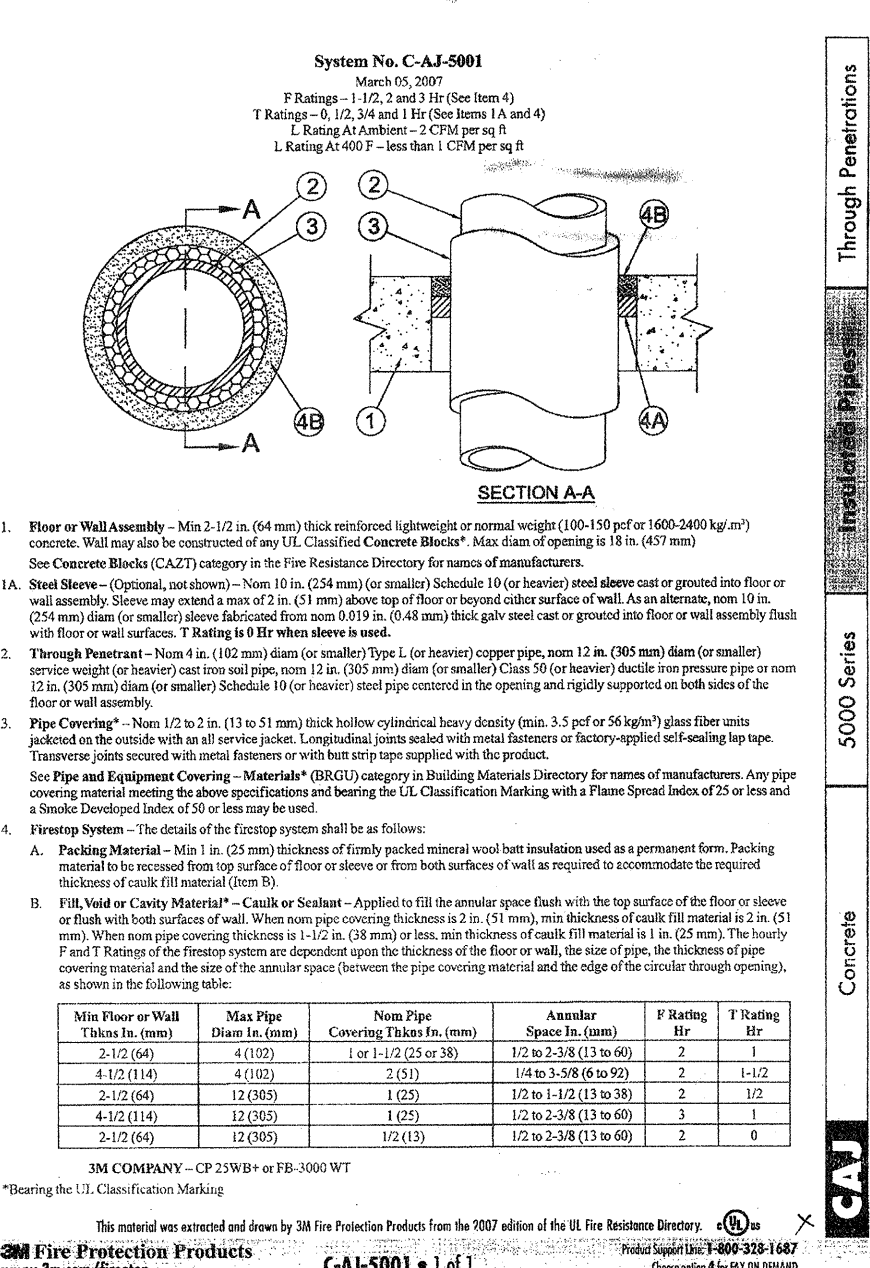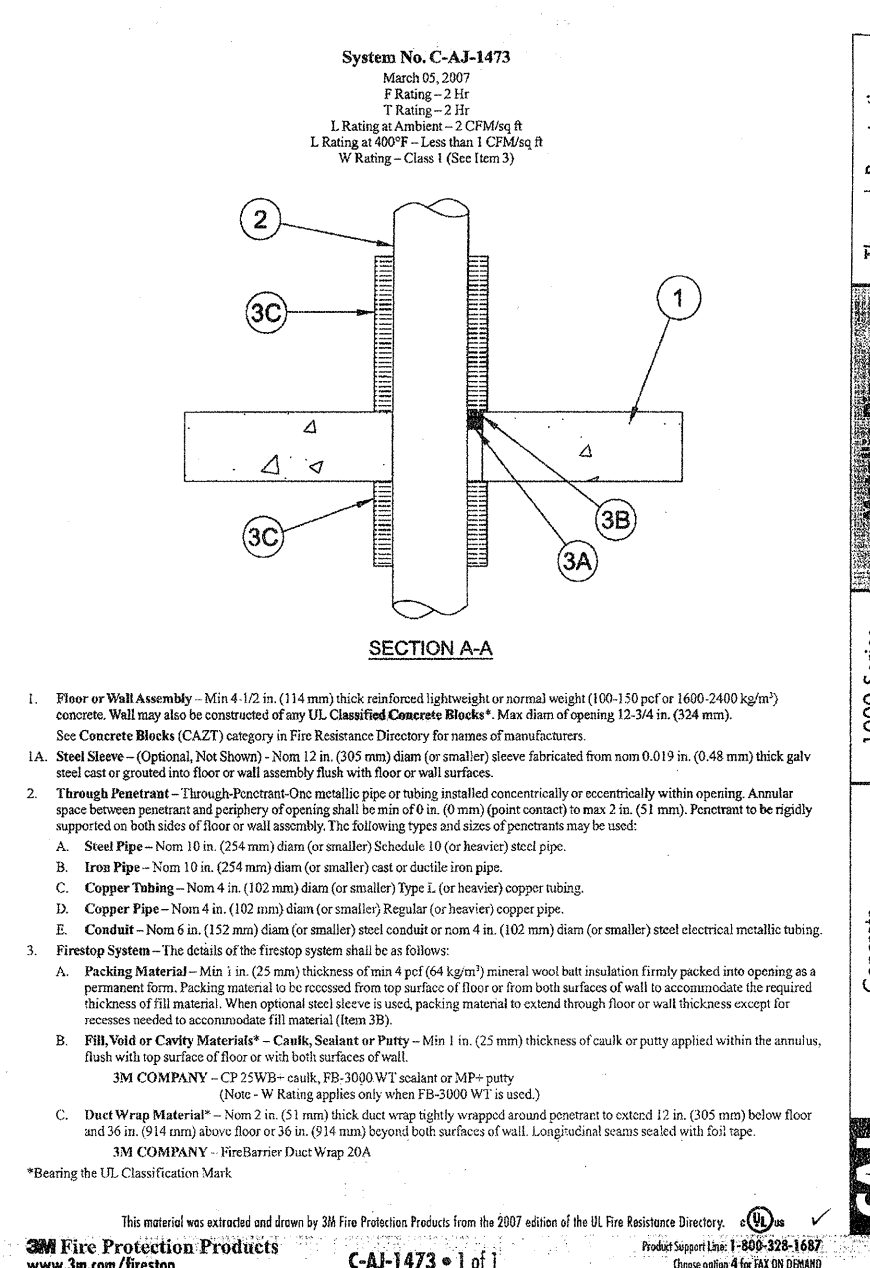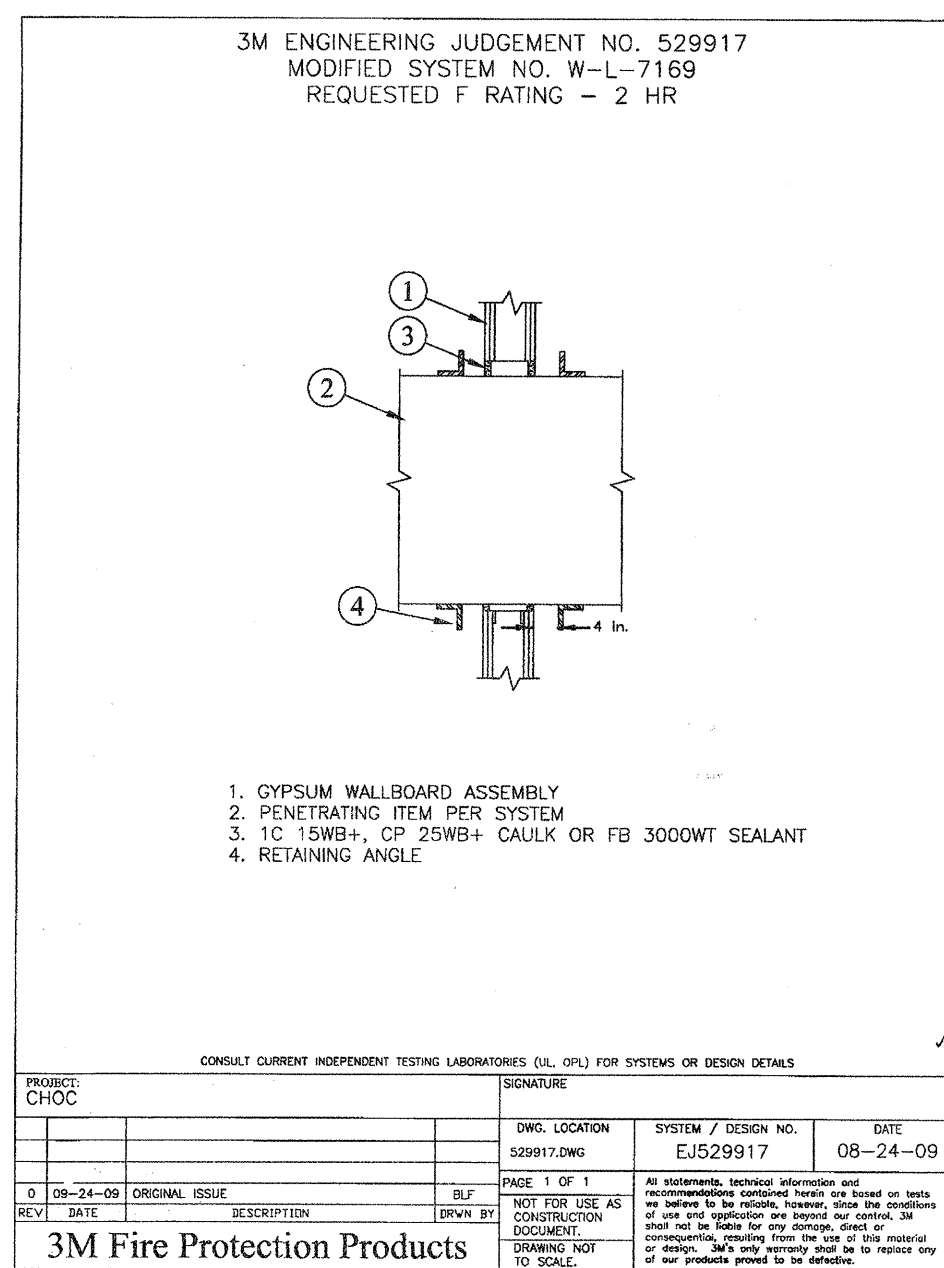

D

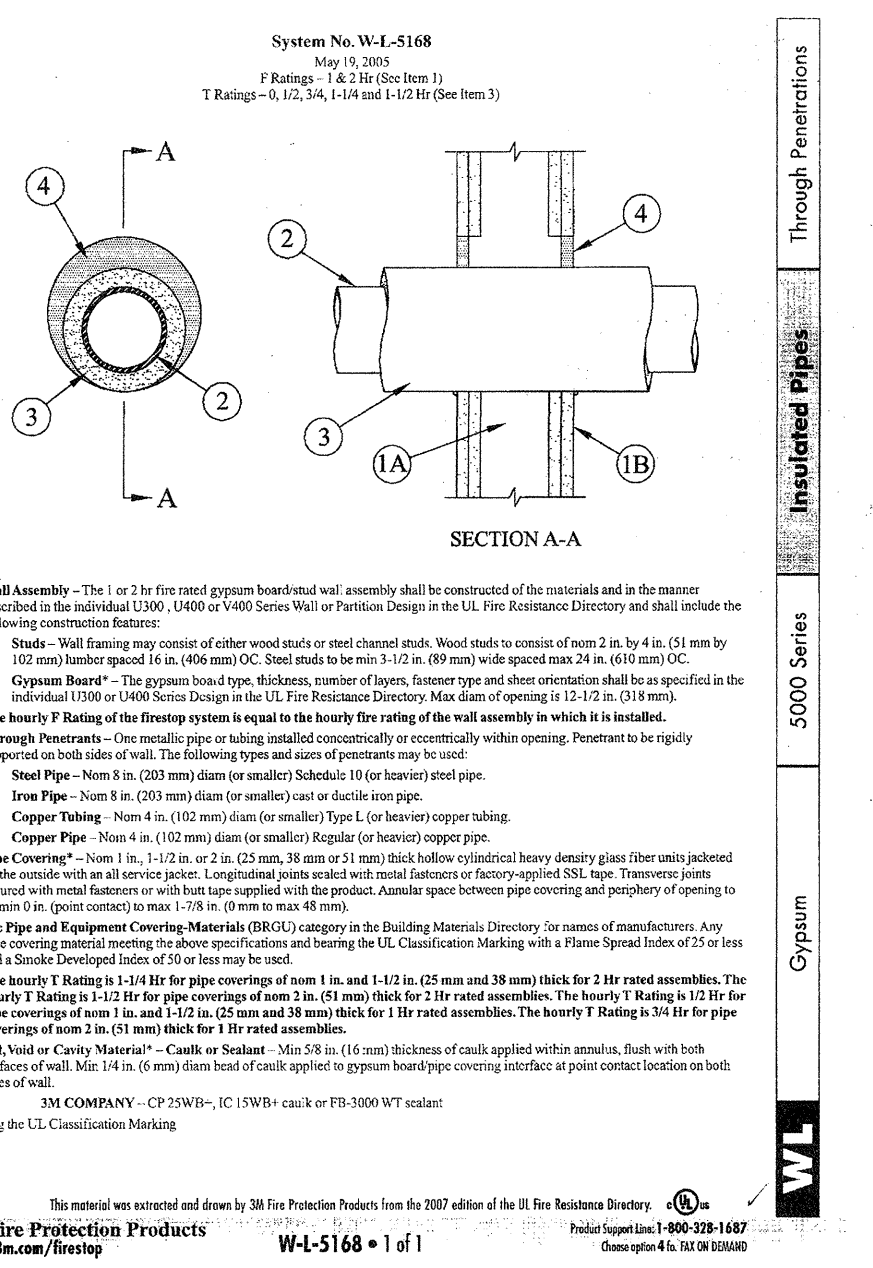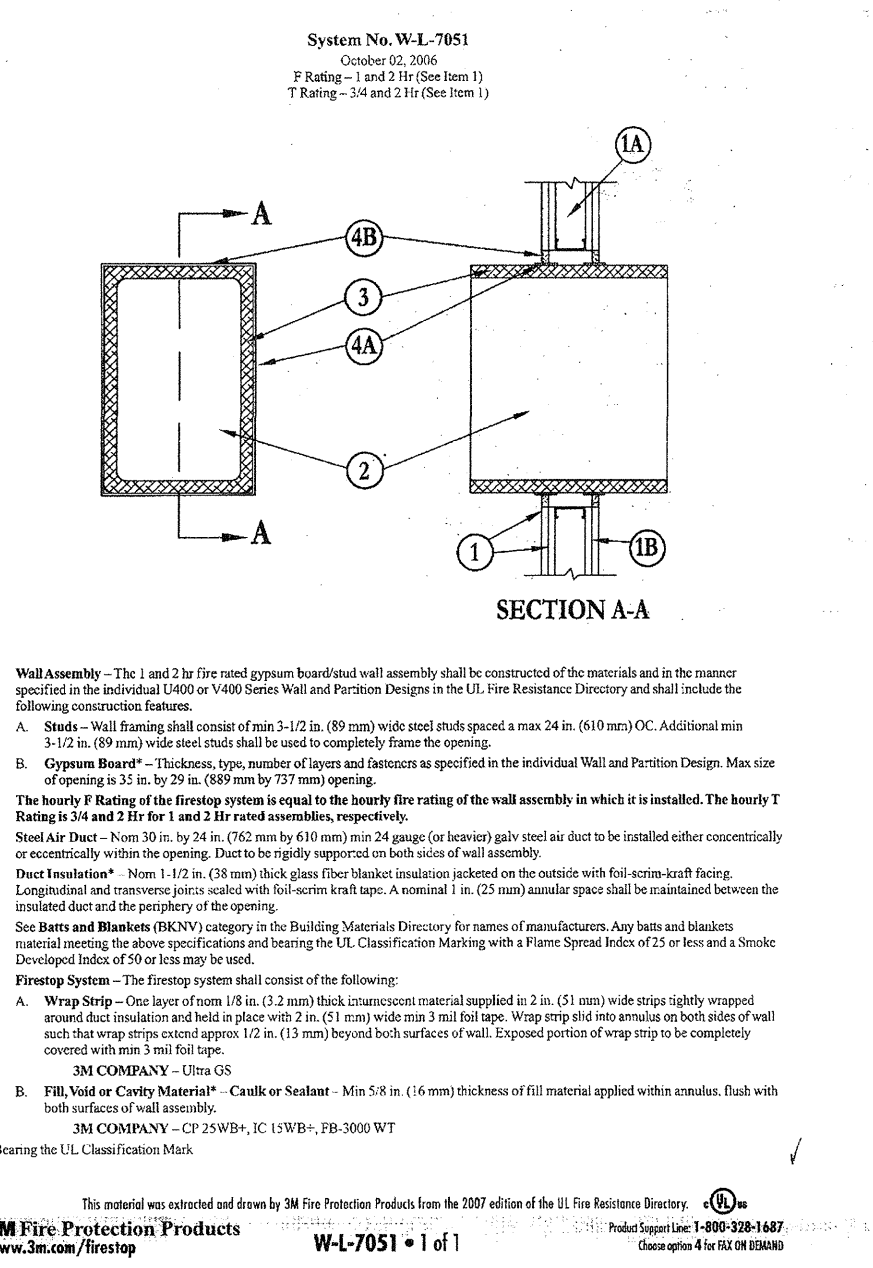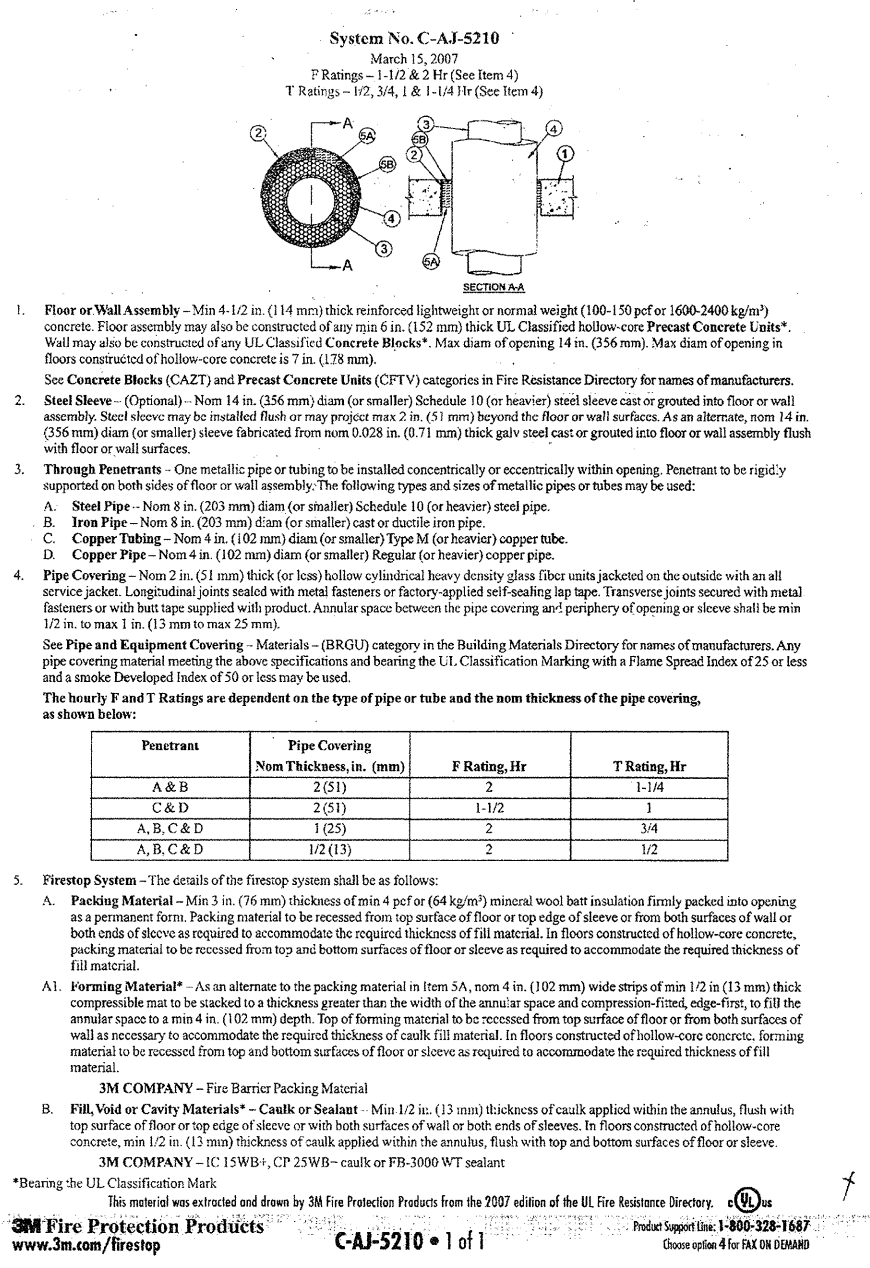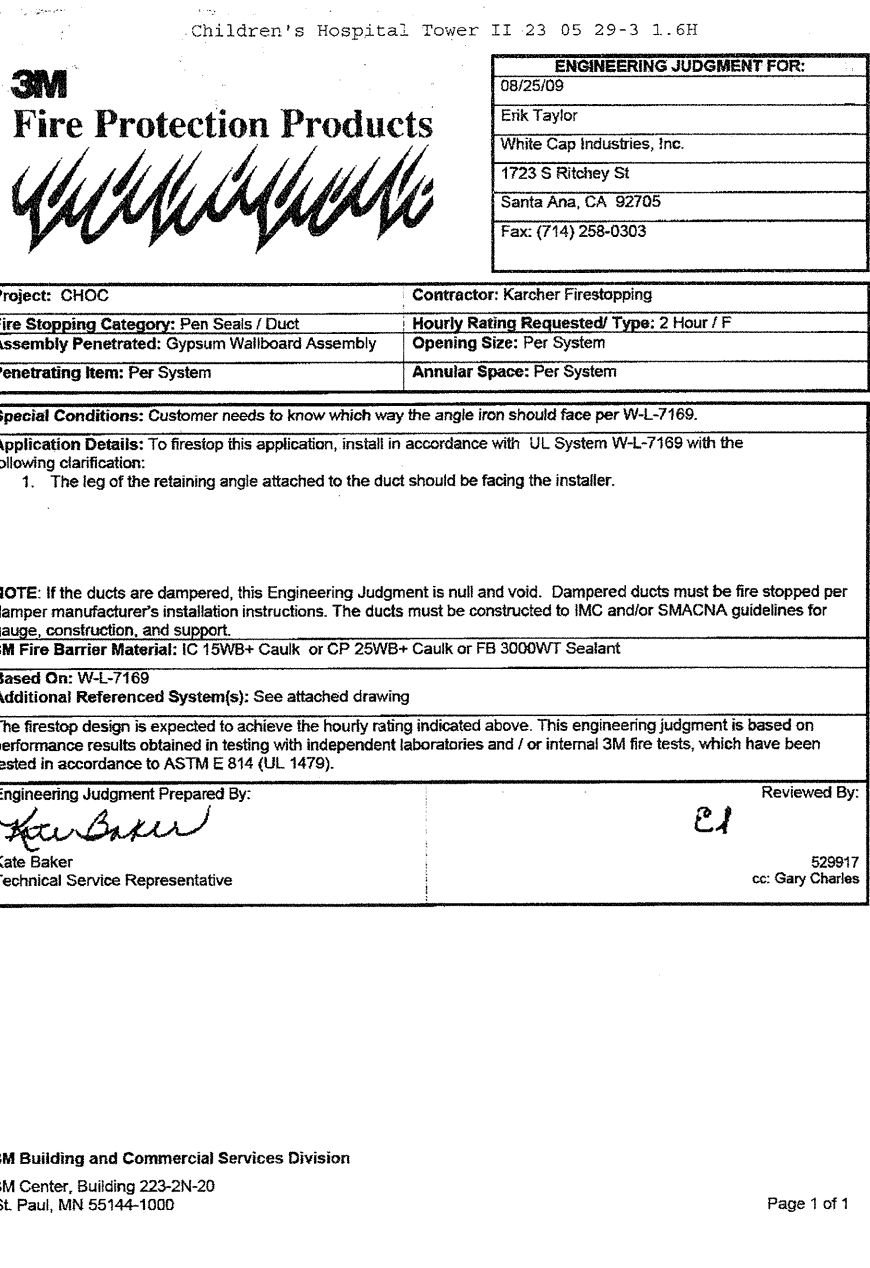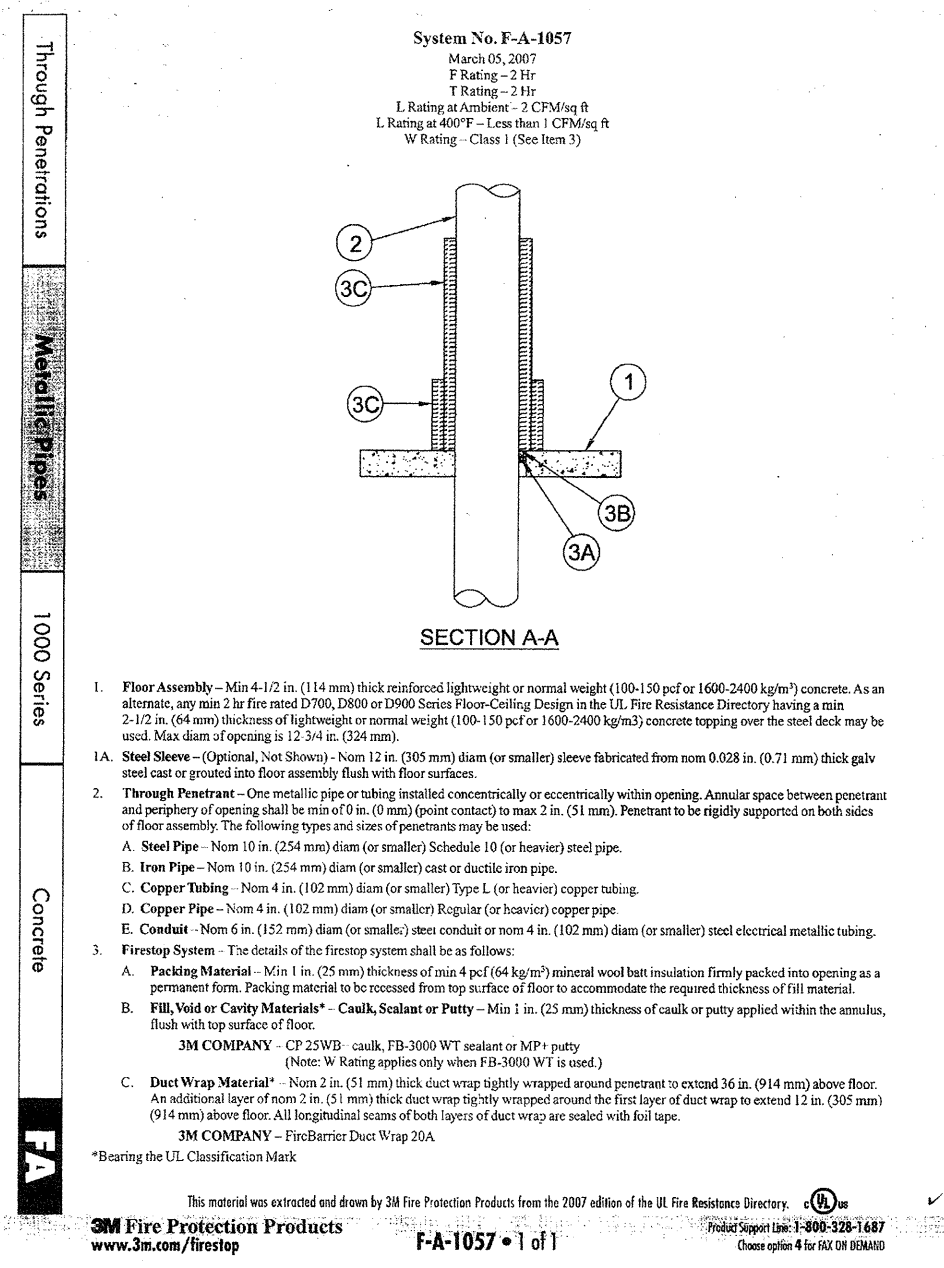

C

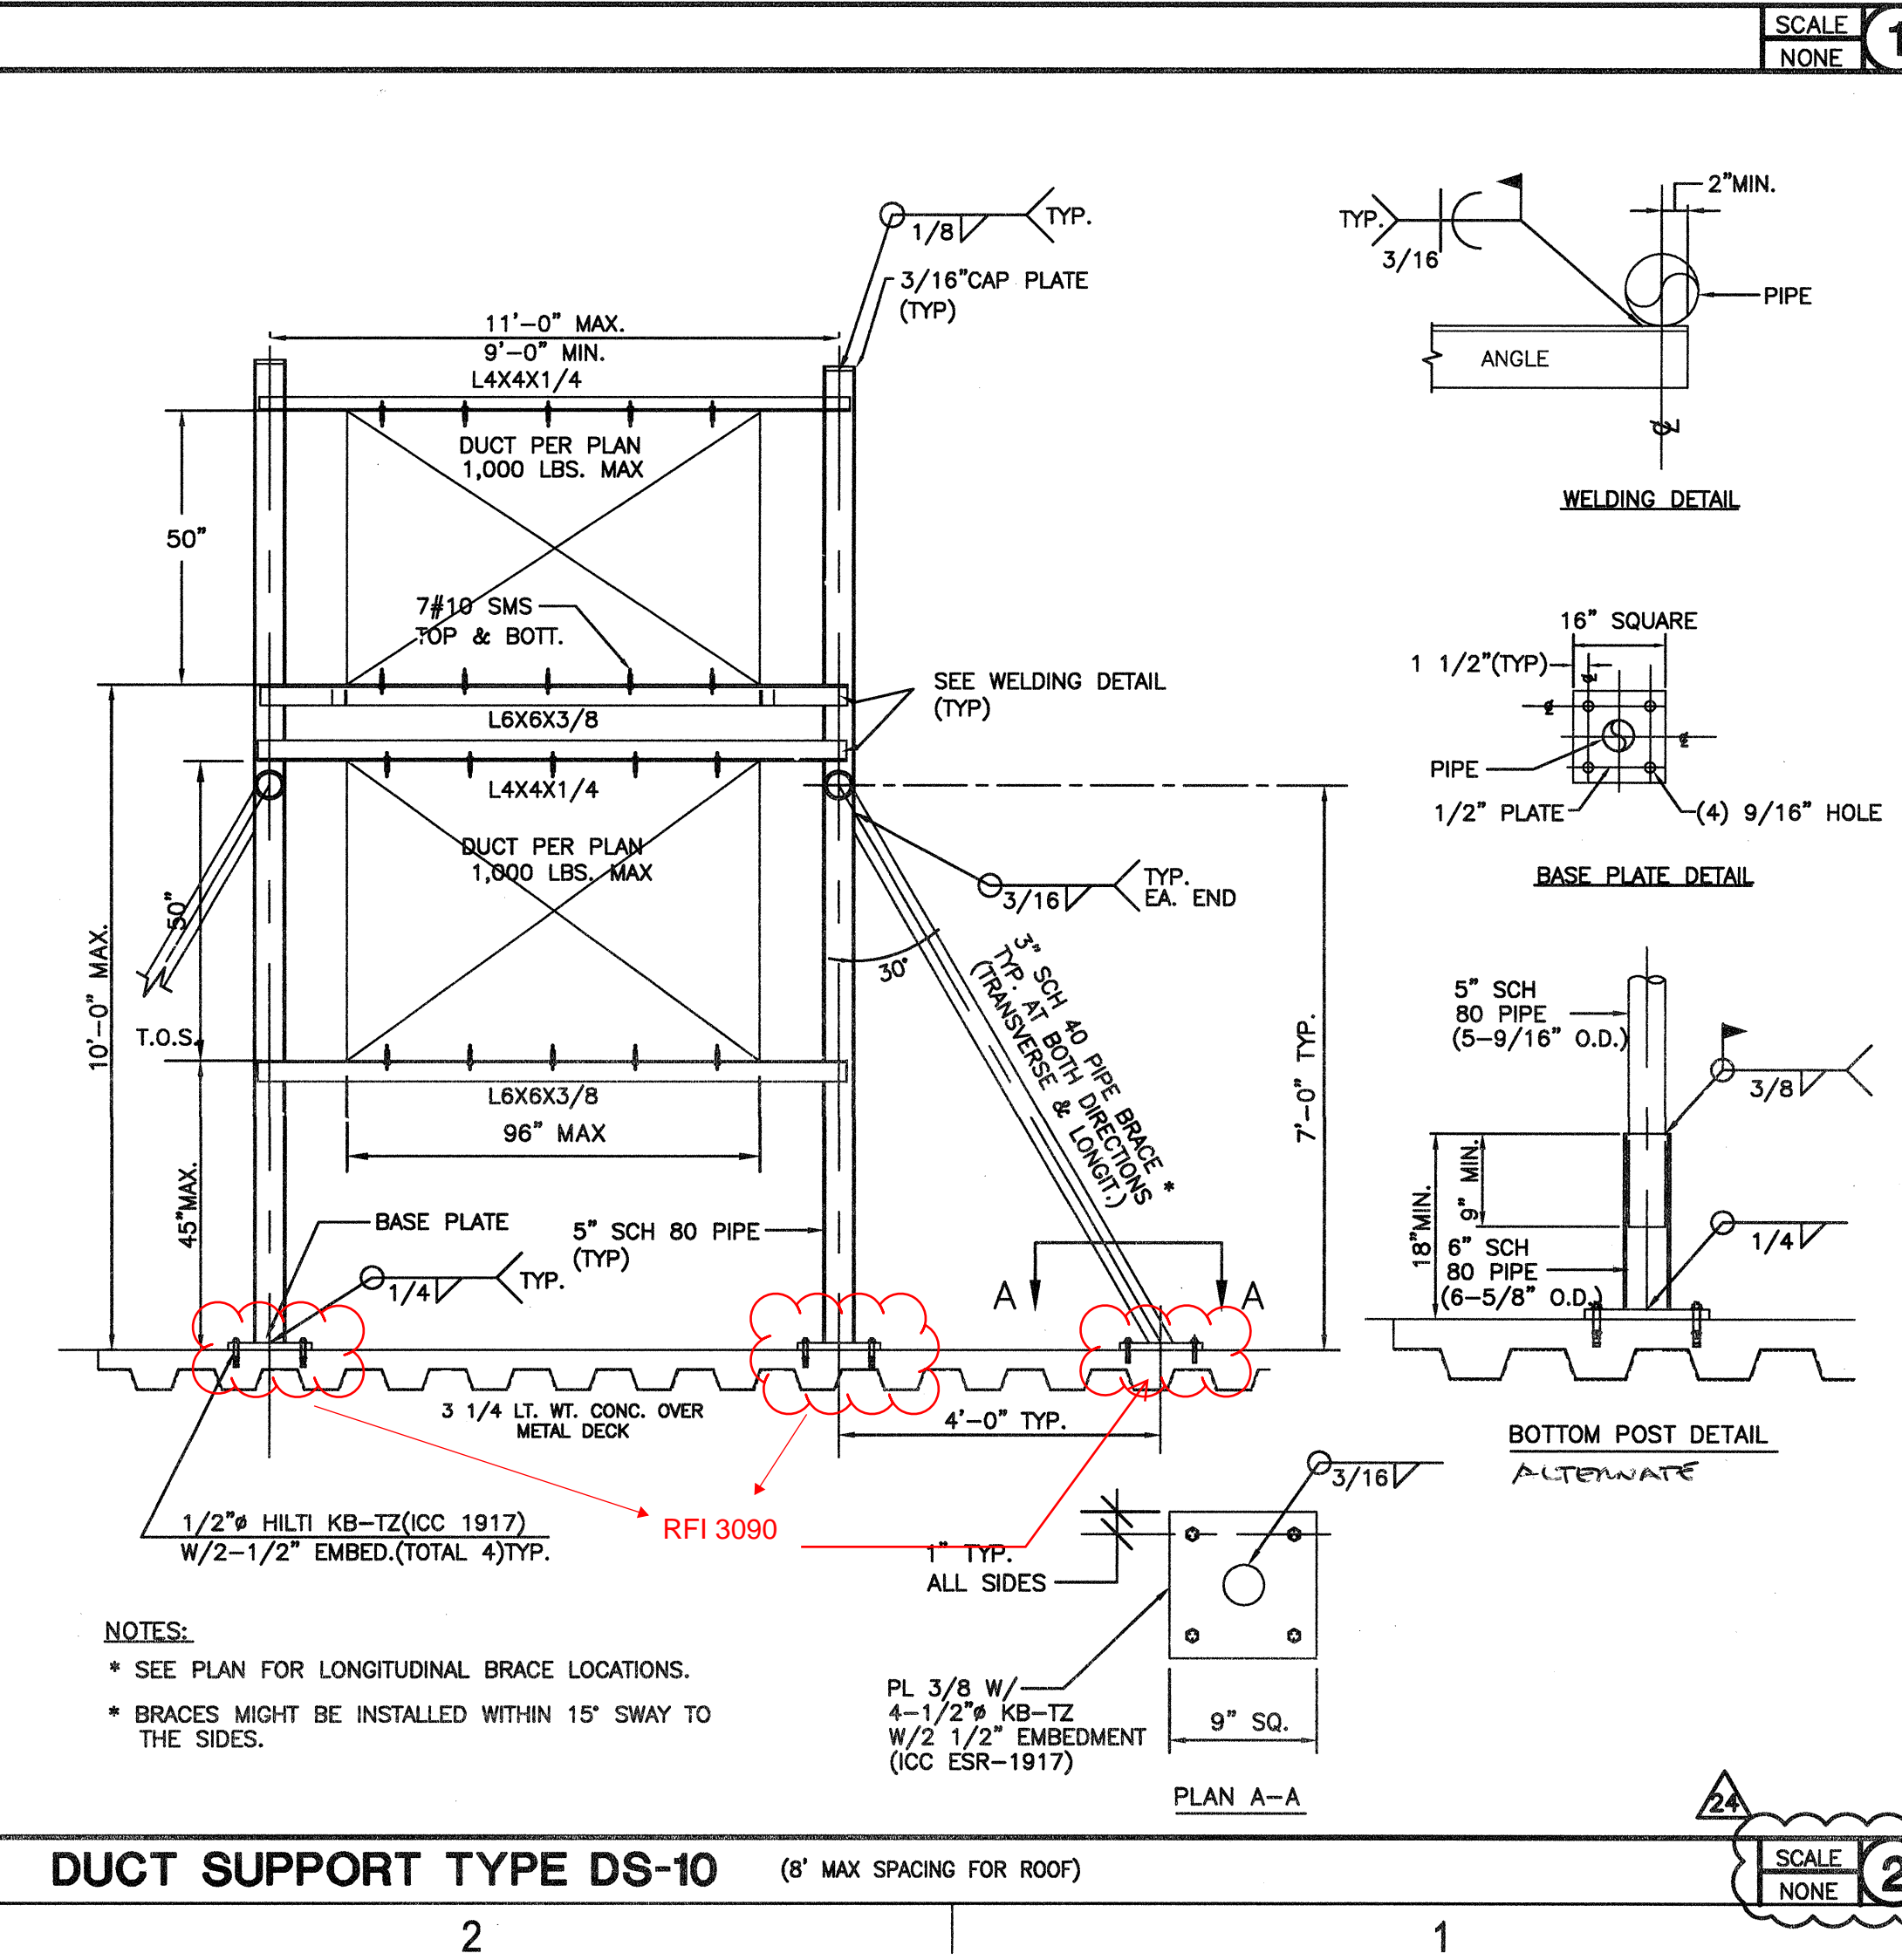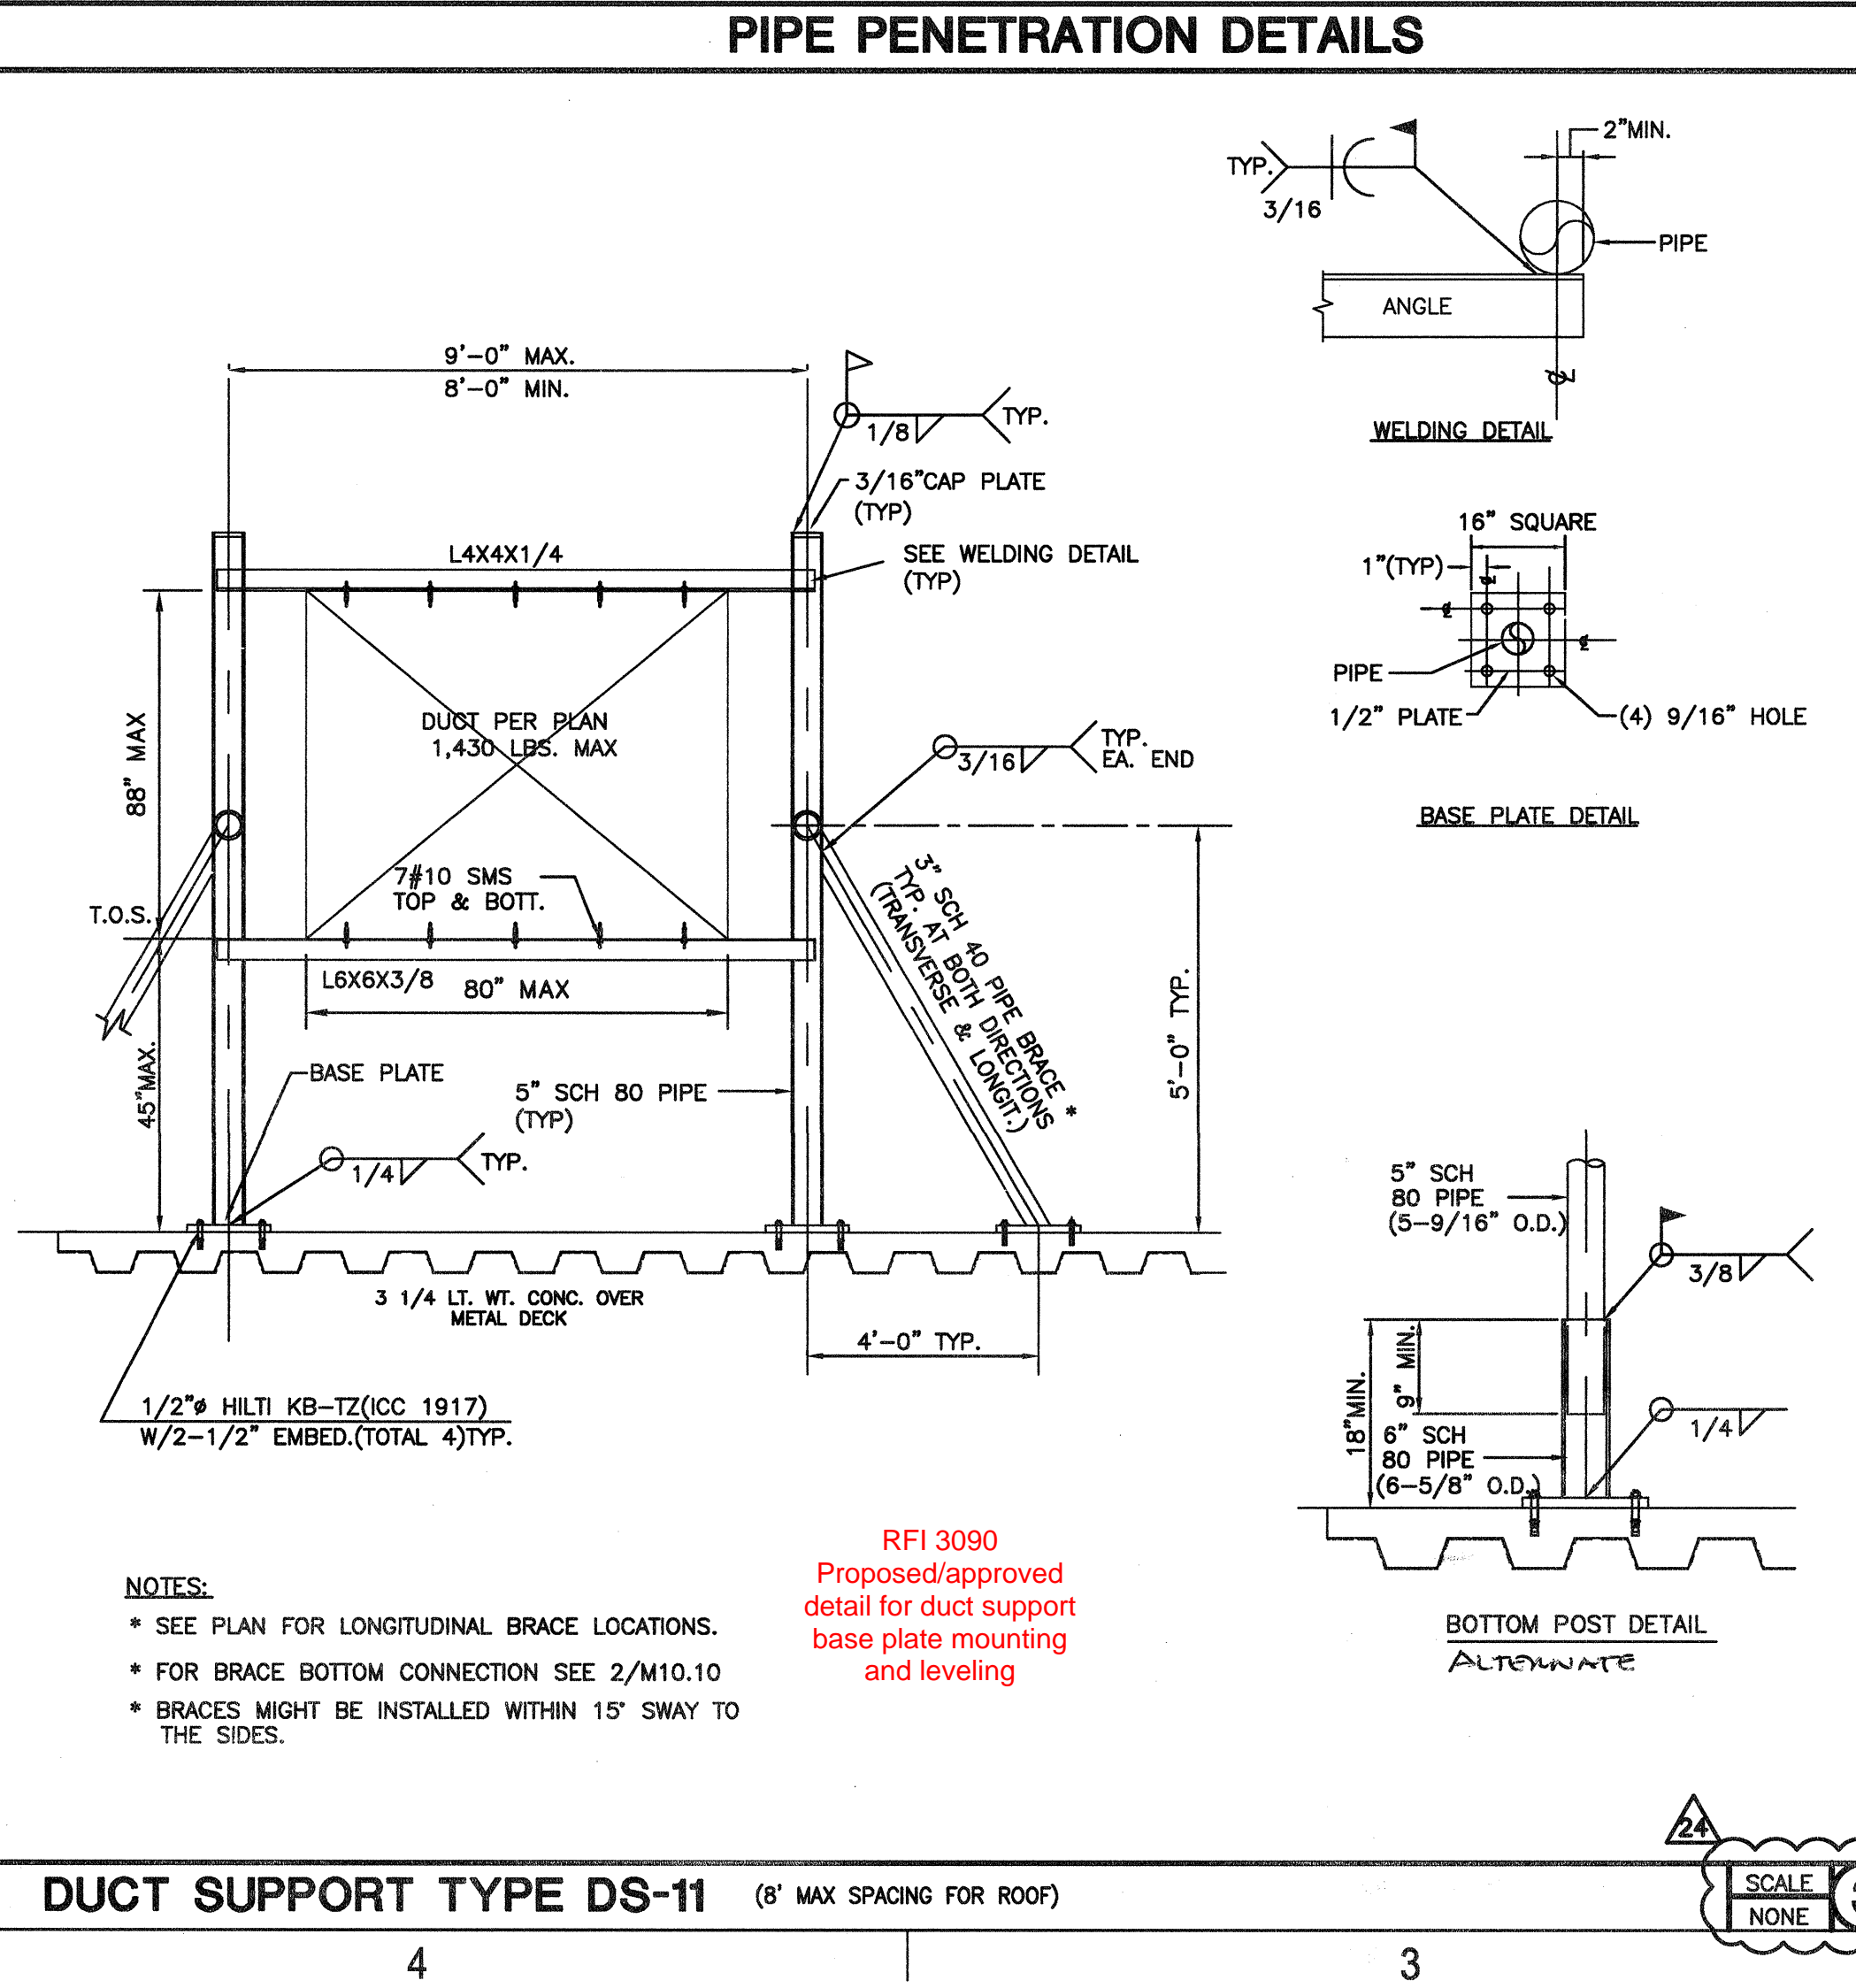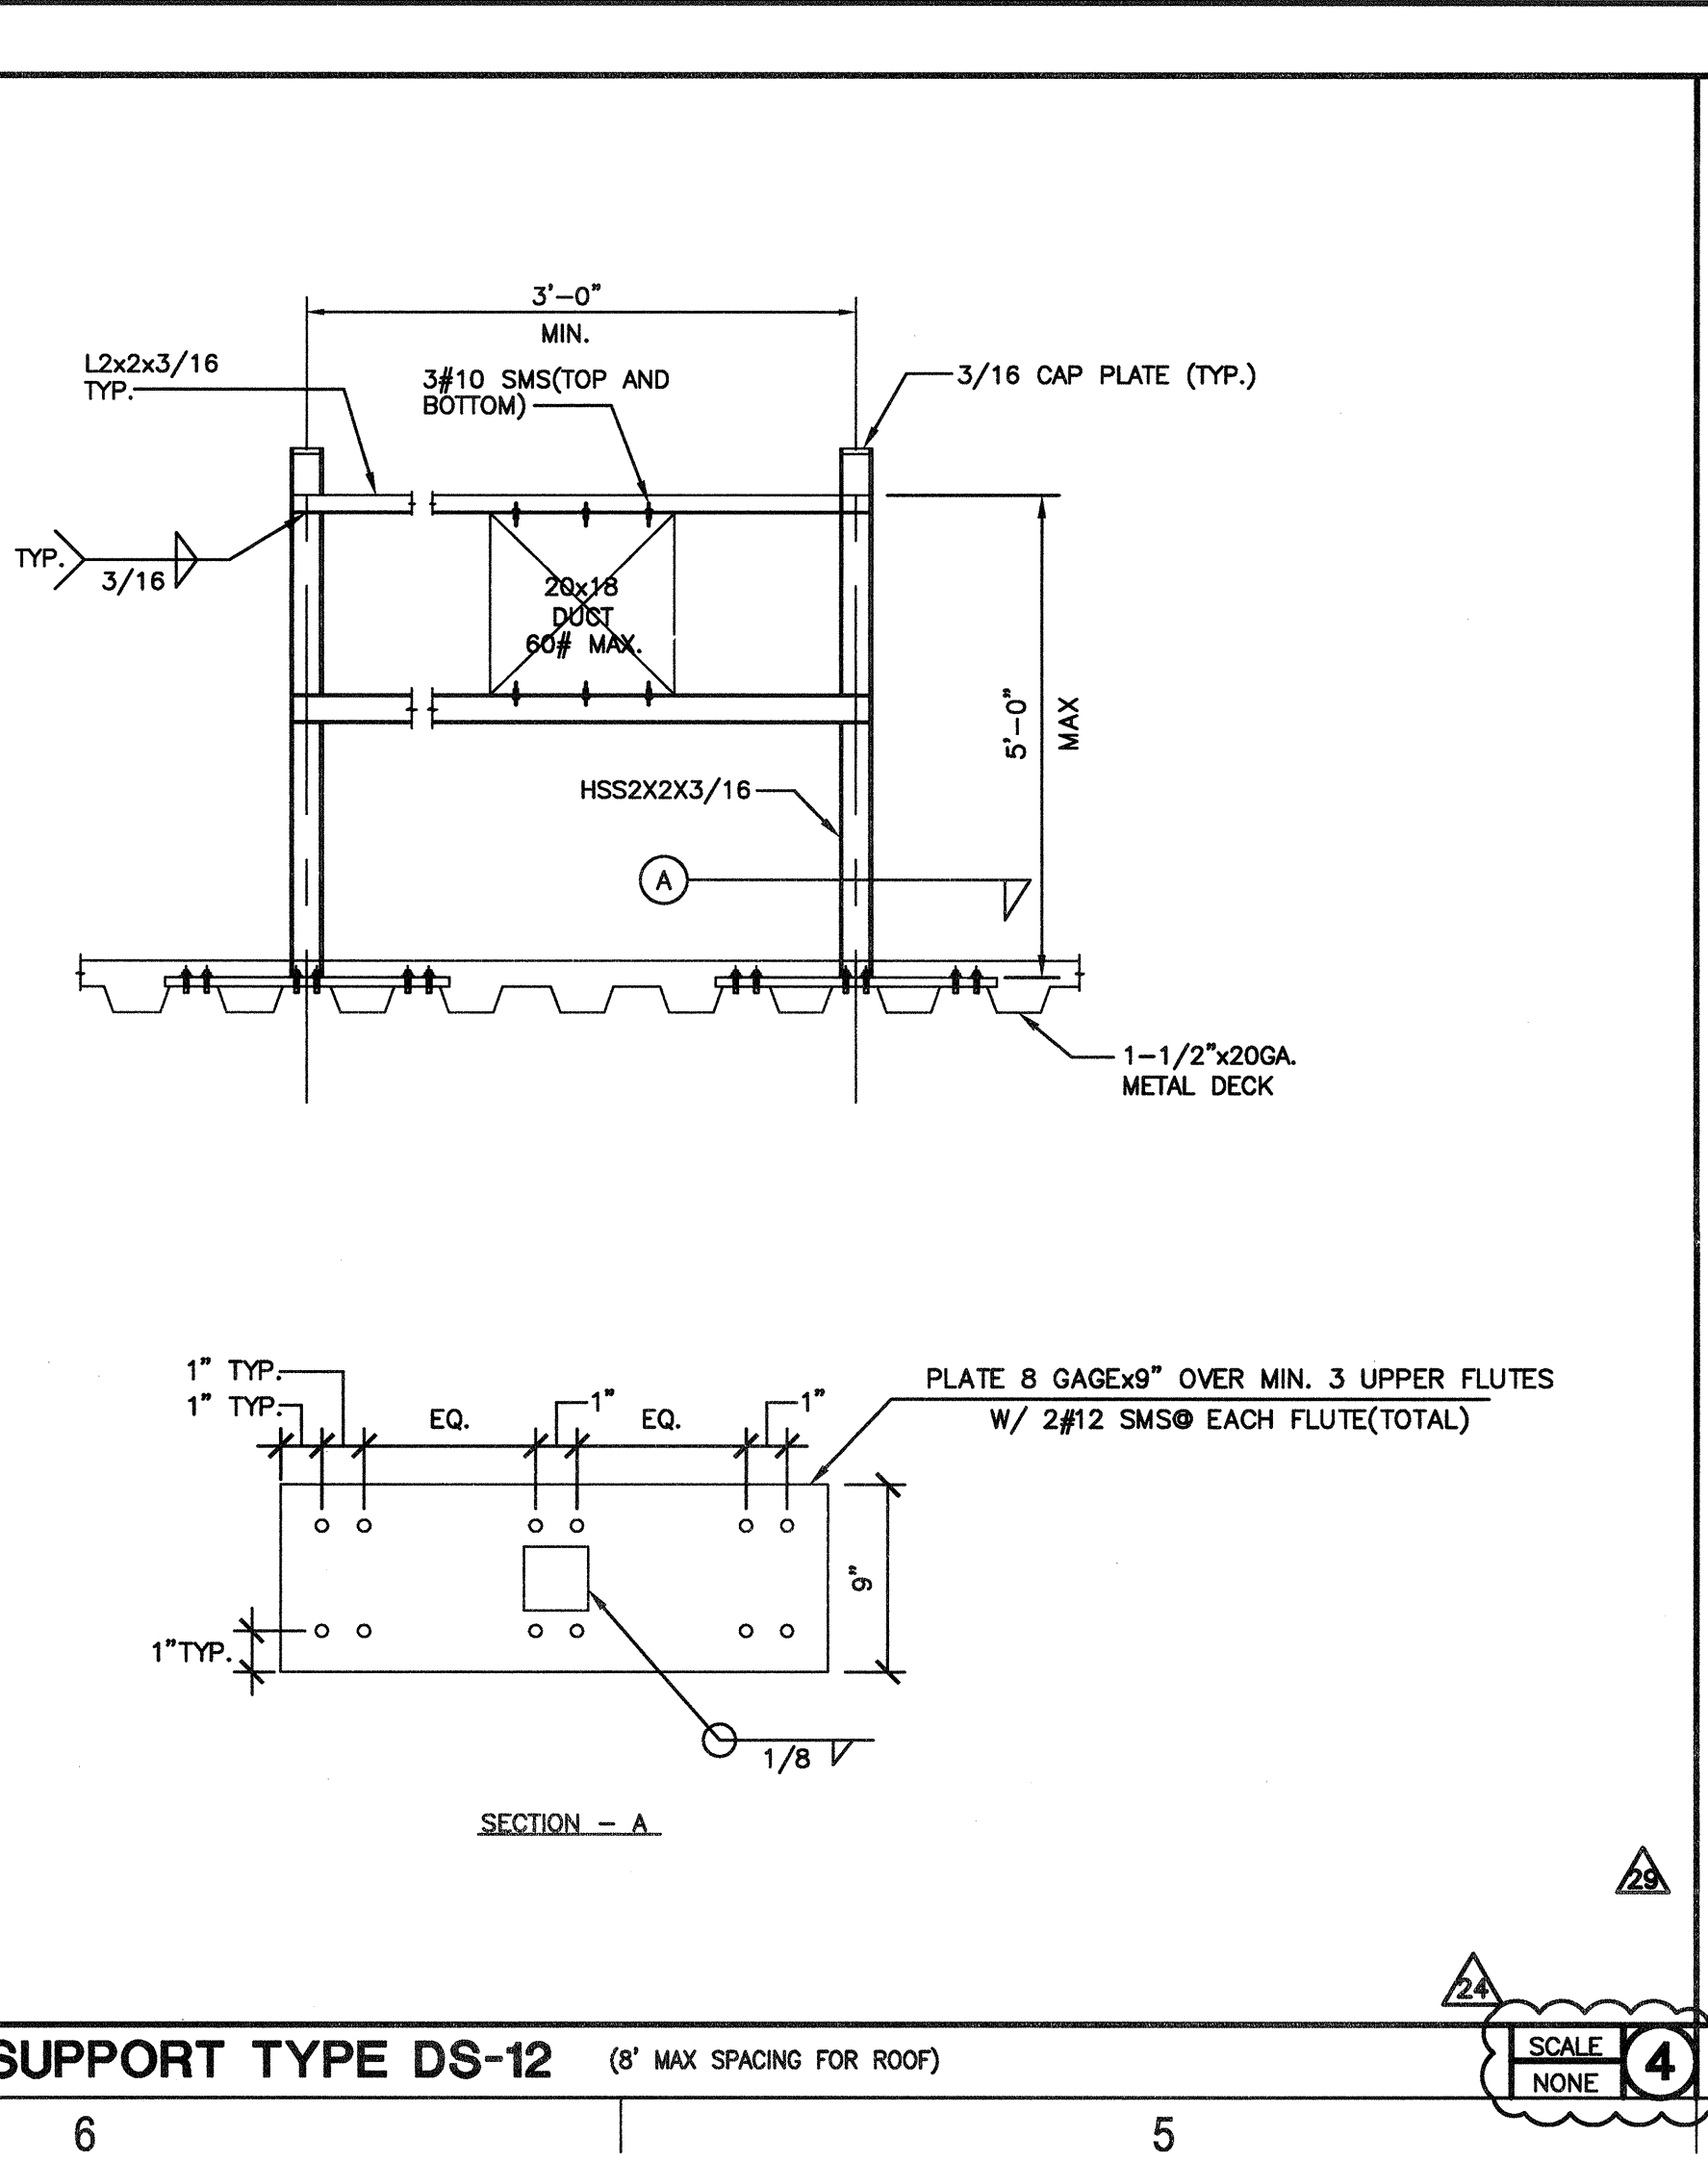

A

B