 


FKP Architects

ARCHITECT OF RECORD

"Architect of Record signature line only; this drawing was not prepared under the direct supervision of the Architect of Record. This direct responsibility for preparation of this sheet lies with its corresponding professional stamp and signature. The signature of the Architect of Record in general responsible charge of the project is provided as required by Title 24, Part 1, Section 7-115 (a)." 

CONSULTANT


**T M A D**  
**TAYLOR & GAINES**

100 South Anaheim Boulevard, Suite 150  
Anaheim, California 92805  
Phone: 714.490.5555 Fax: 714.490.5560  
Project No. 2305-163-07



Changes on these drawings do not consist of materially altered changes to approved drawings and don't require a change order.  
OSHDP review ACO  
OSHDP review FLSO  
OSHDP review DSE

| REVISIONS                                                                           |                              |
|-------------------------------------------------------------------------------------|------------------------------|
|  | 09/14/2010 CHANGE ORDER #26  |
|  | 12/06/2010 CHANGE ORDER #117 |
|  | 06/07/2011 CHANGE ORDER #104 |

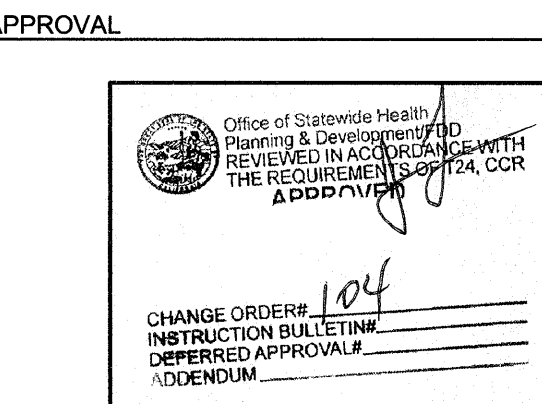

PROJECT NAME  
**CHILDREN'S HOSPITAL OF ORANGE COUNTY**  
455 S. Main St.  
Orange, CA 92868-3874

TOWER II RECEIVED  
June 08 2011  
McCarthy




PROJECT NUMBER  
**12011.00**  
**Increment #7**  
OSHDP - PROJECT NUMBER  
IL 072072-30

ISSUE  
**OSHDP PERMIT**  
DATE  
01/27/2010  
SCALE


DRAWING TITLE  
**MECHANICAL DETAILS - HVAC EQUIPMENT - ANCHORAGE DETAILS**

DRAWING NUMBER


**M10.11**

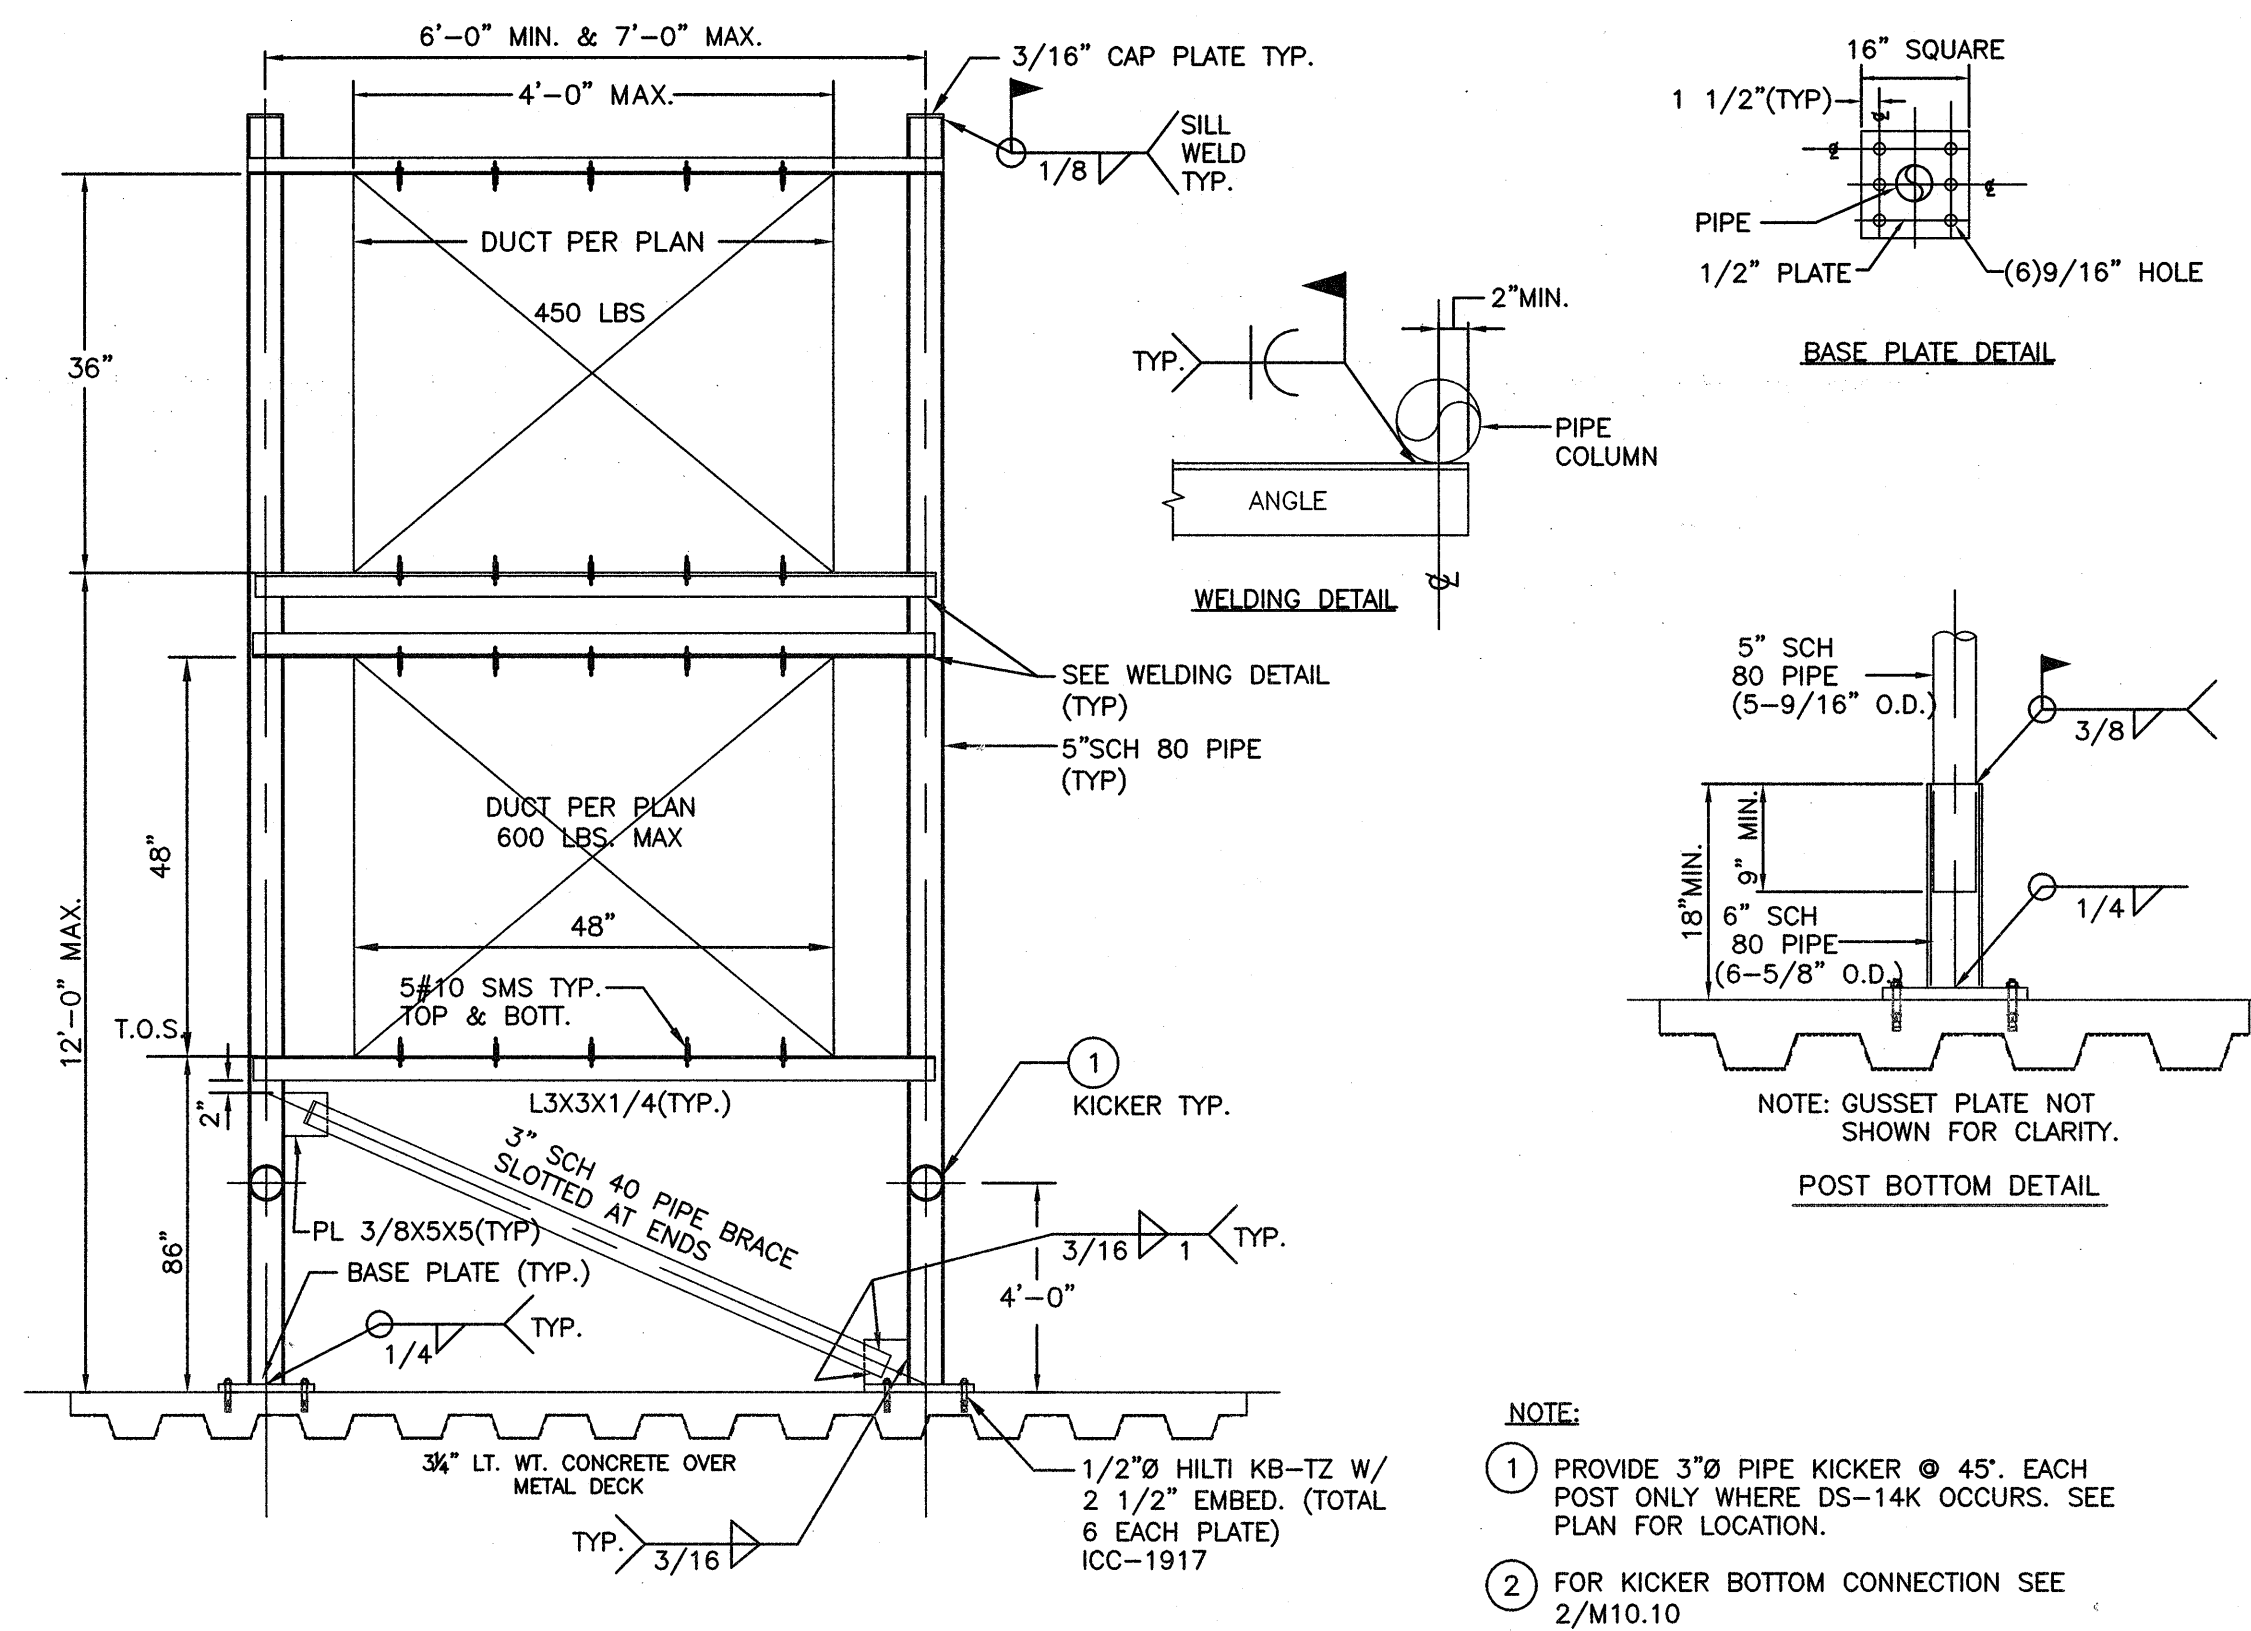


DUCT SUPPORT TYPE DS-14 AND DS-14K (8' MAX SPACING FOR ROOF)

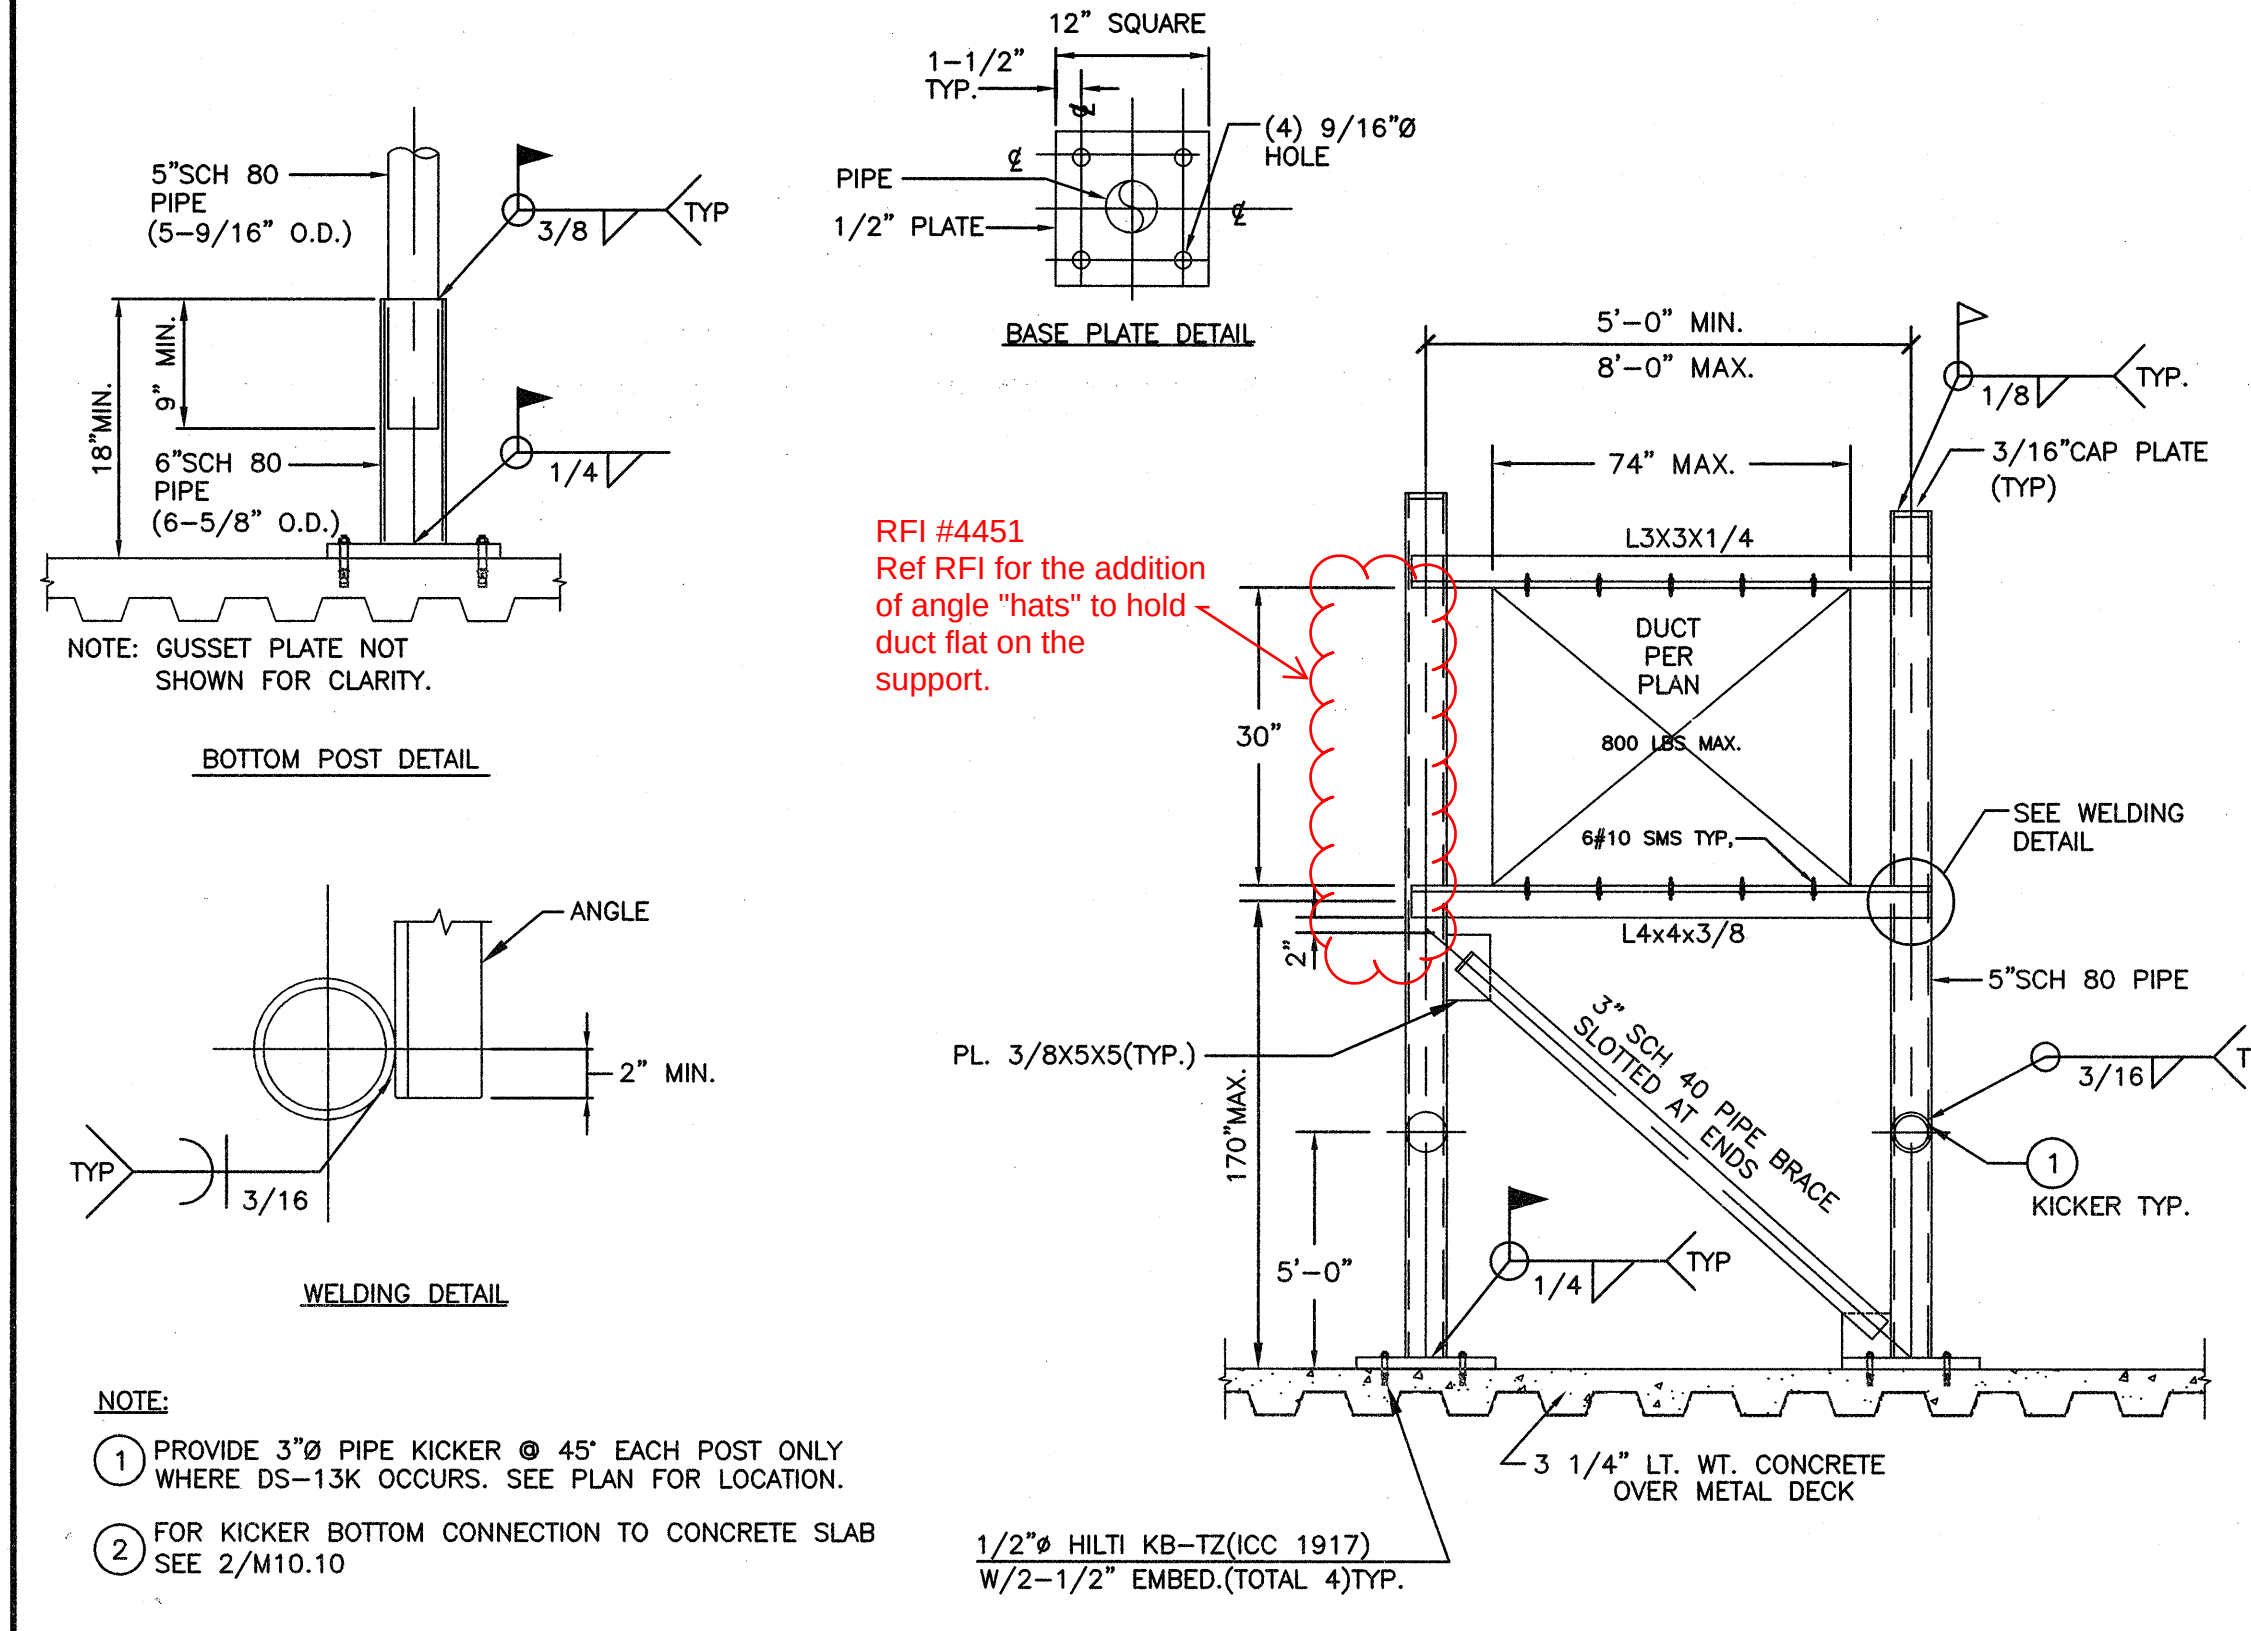


DUCT SUPPORT TYPE DS-13 & DS-13K (8' O.C. MAX)

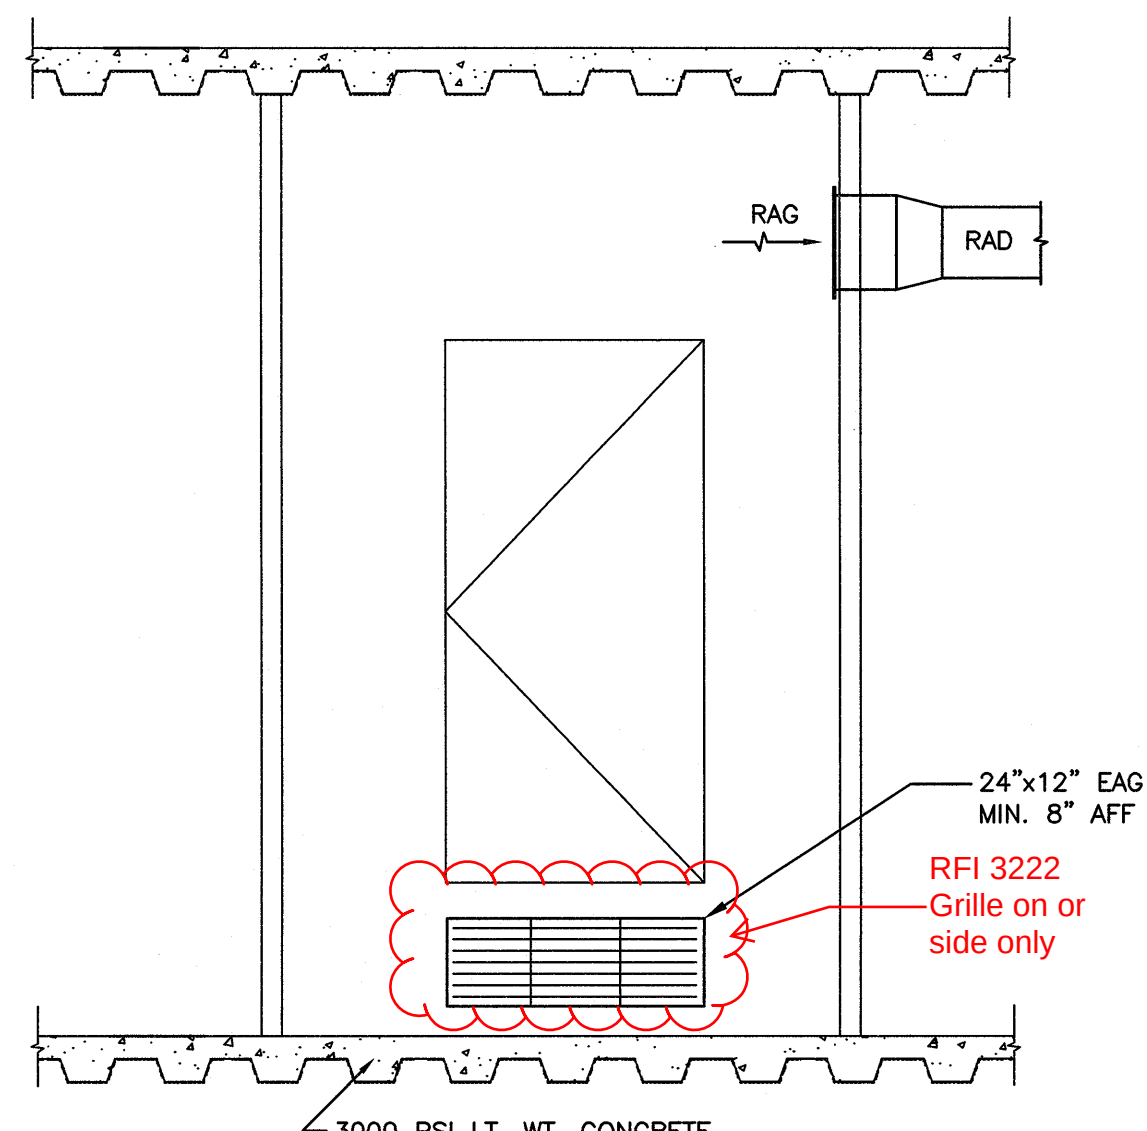


IT CLOSET IN OPERATING ROOM DETAIL

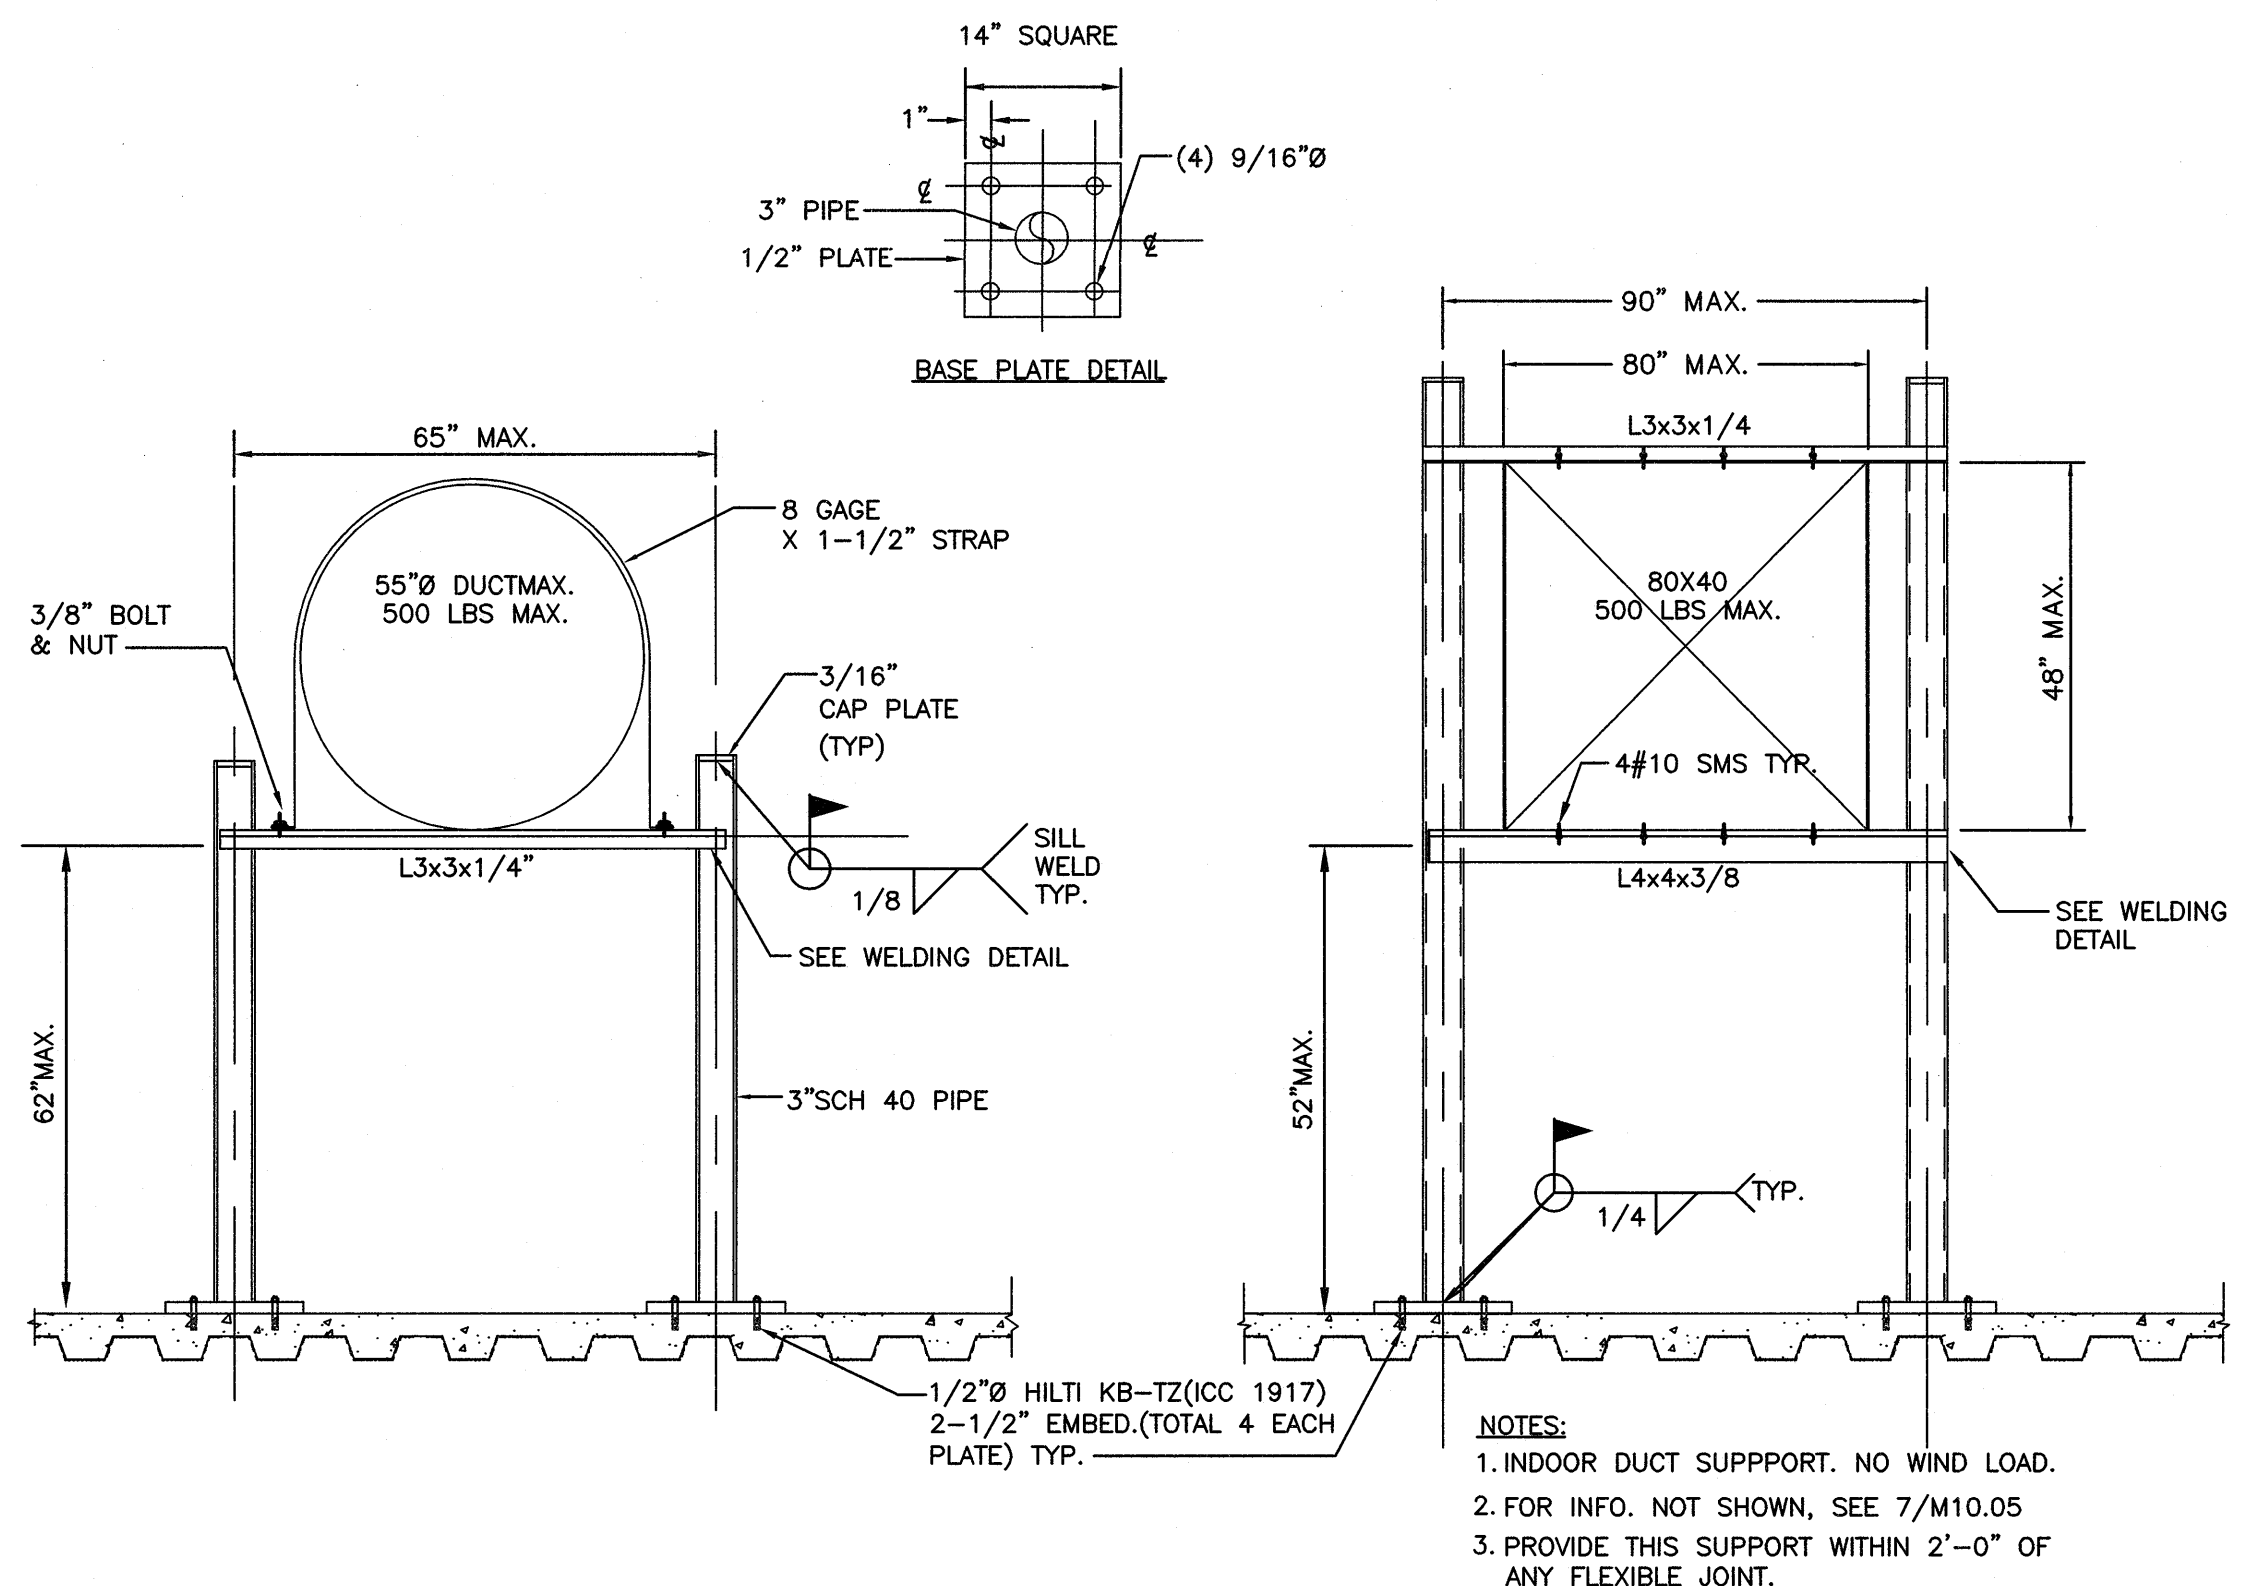


DUCT SUPPORT TYPE DS-15 (10' MAX SPACING)

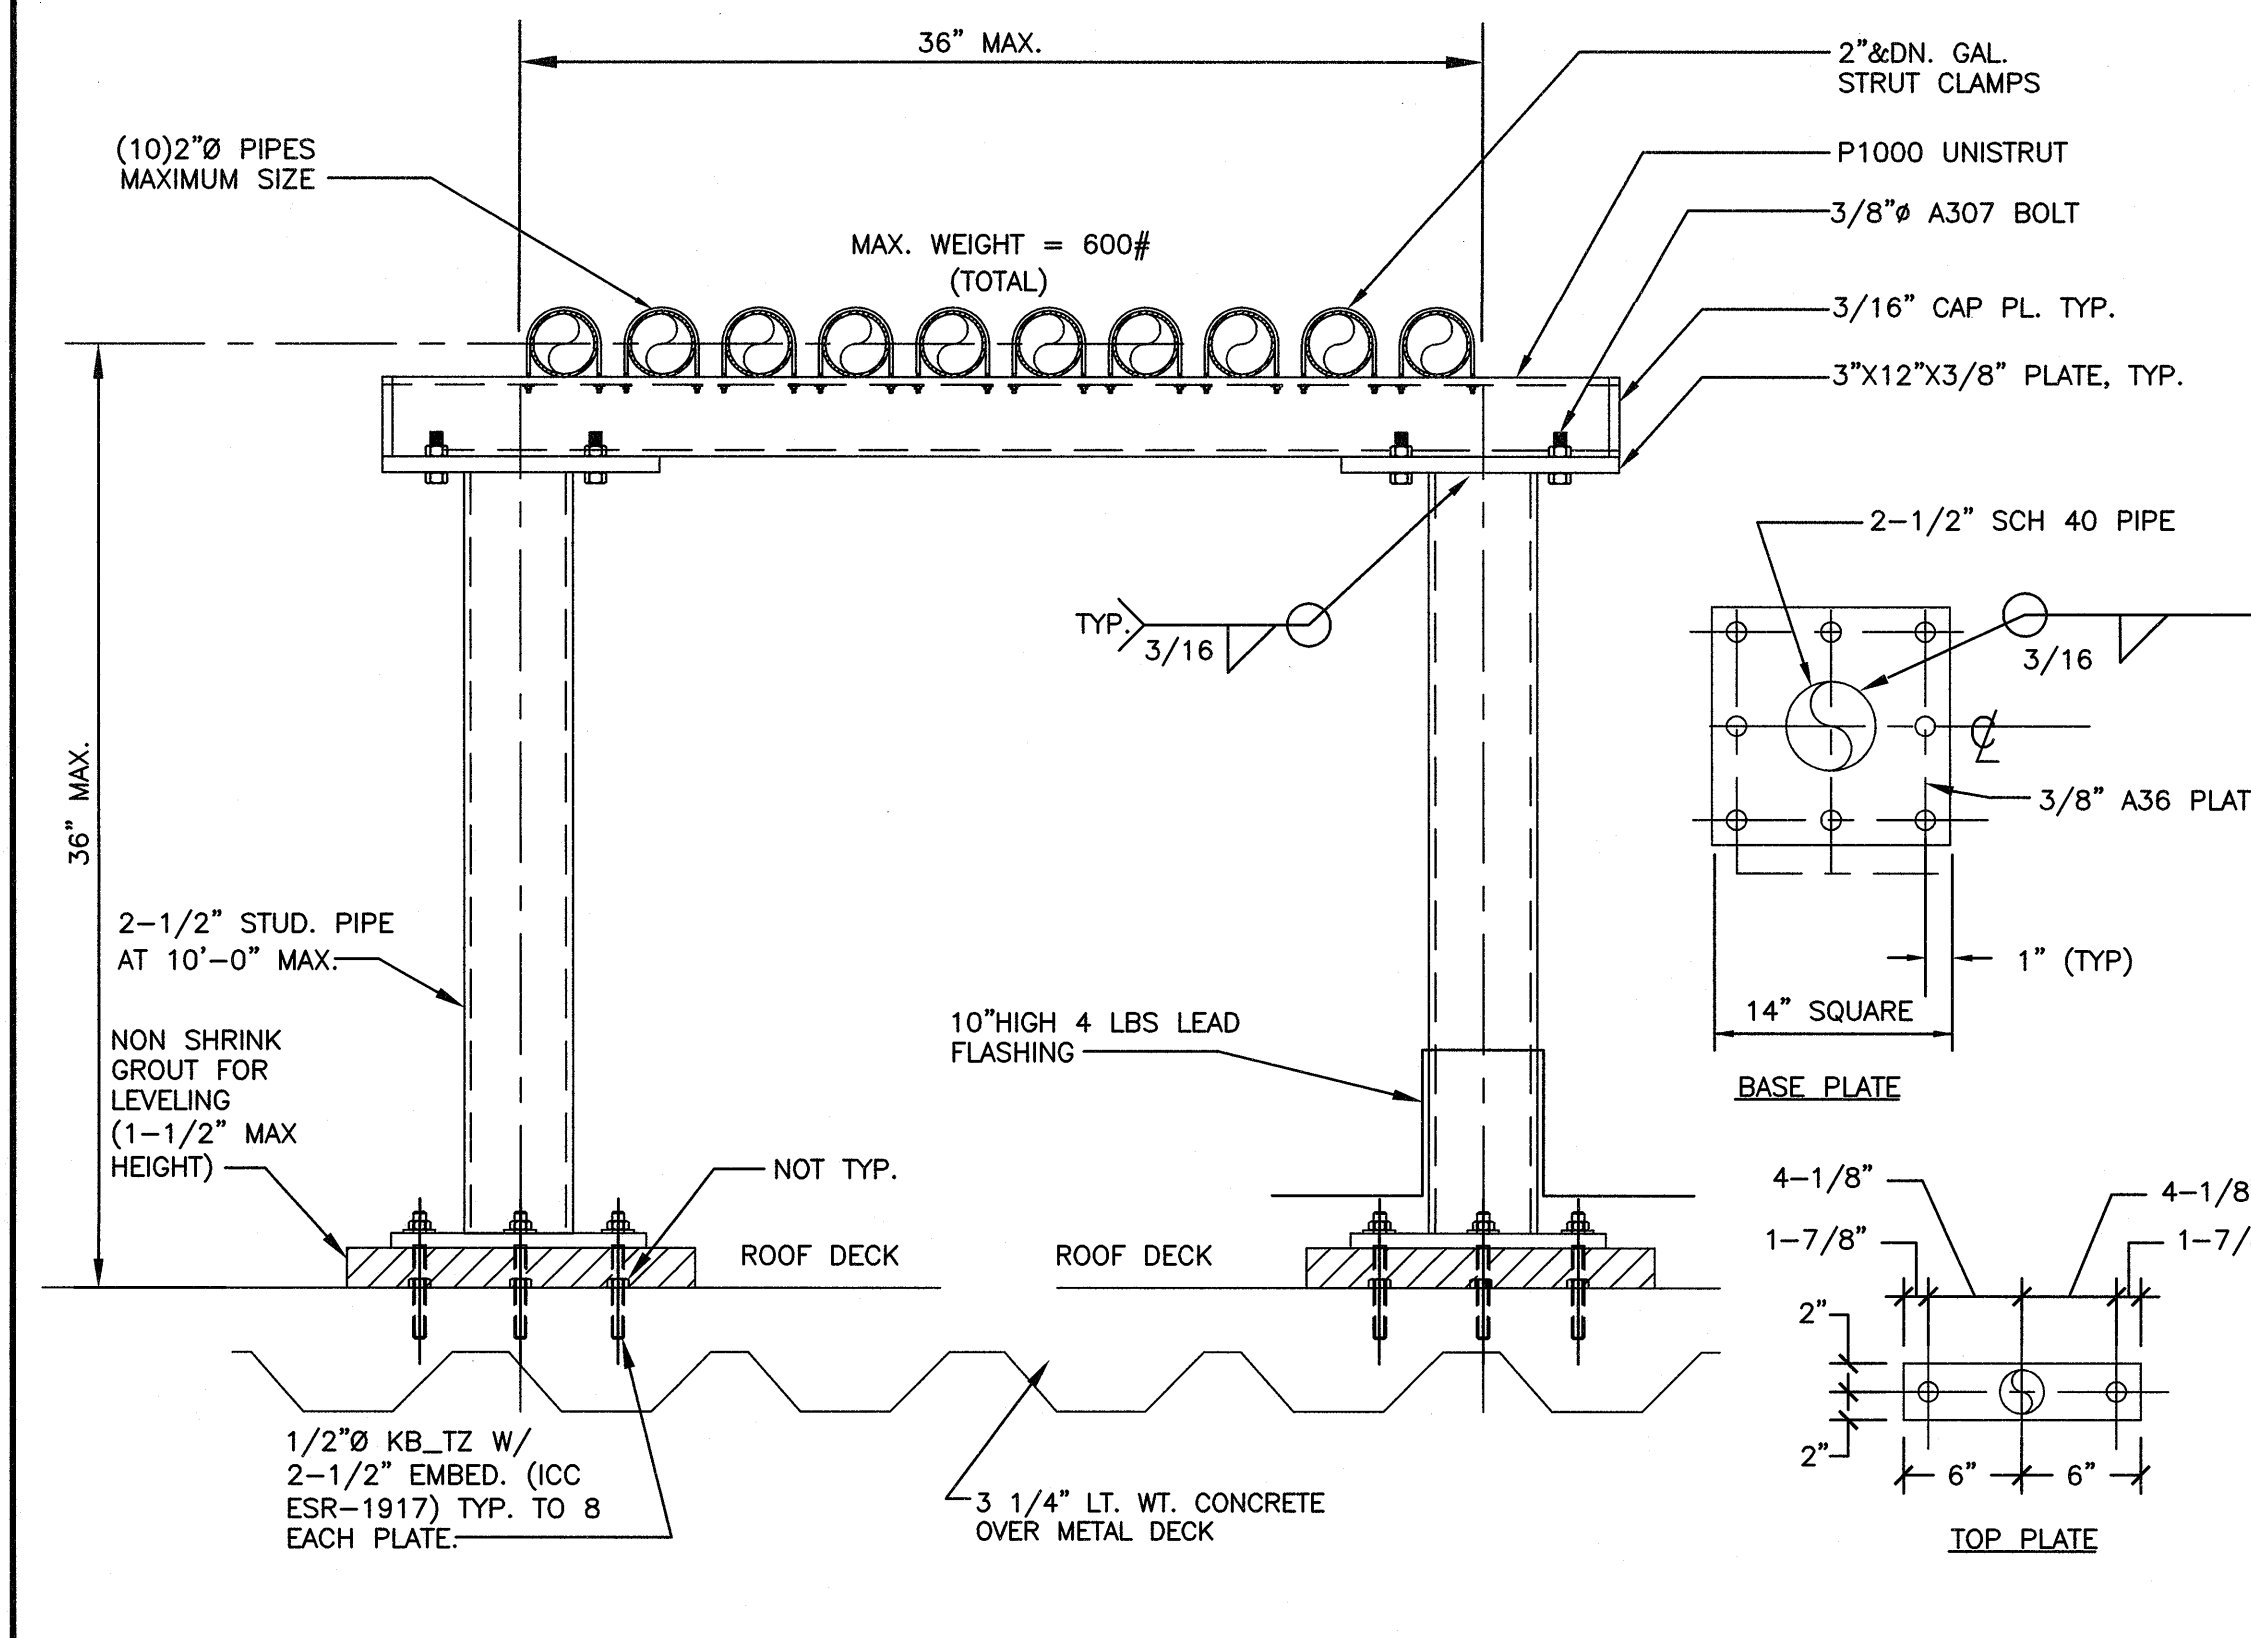

MISC PIPE SUPPORT DETAIL (10'-0" O.C. MAX)

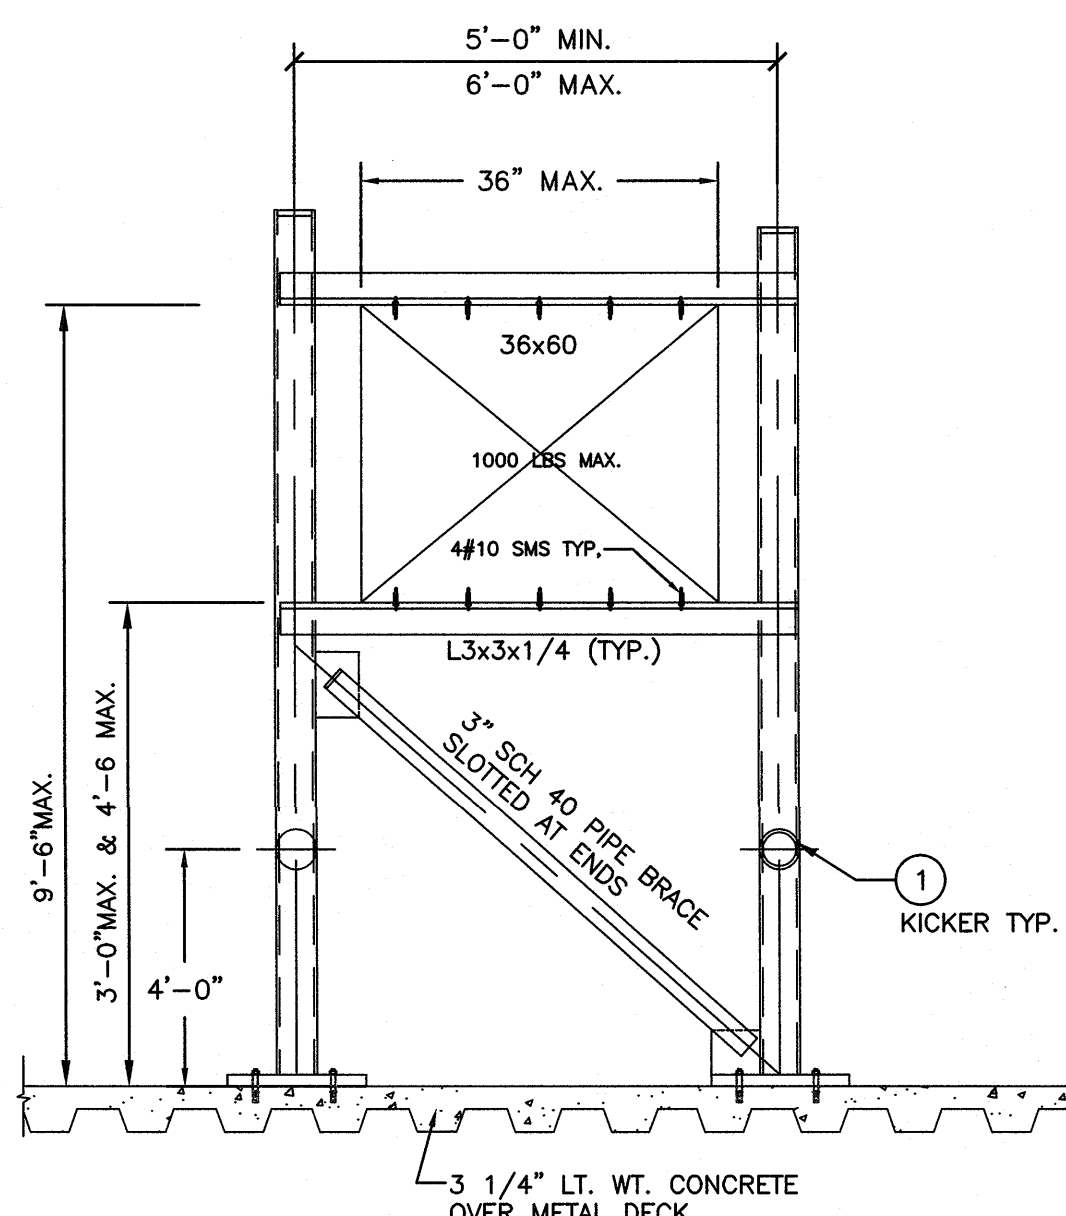

DUCT SUPPORT TYPE DS-17 AND DS-17K (10' MAX SPACING)

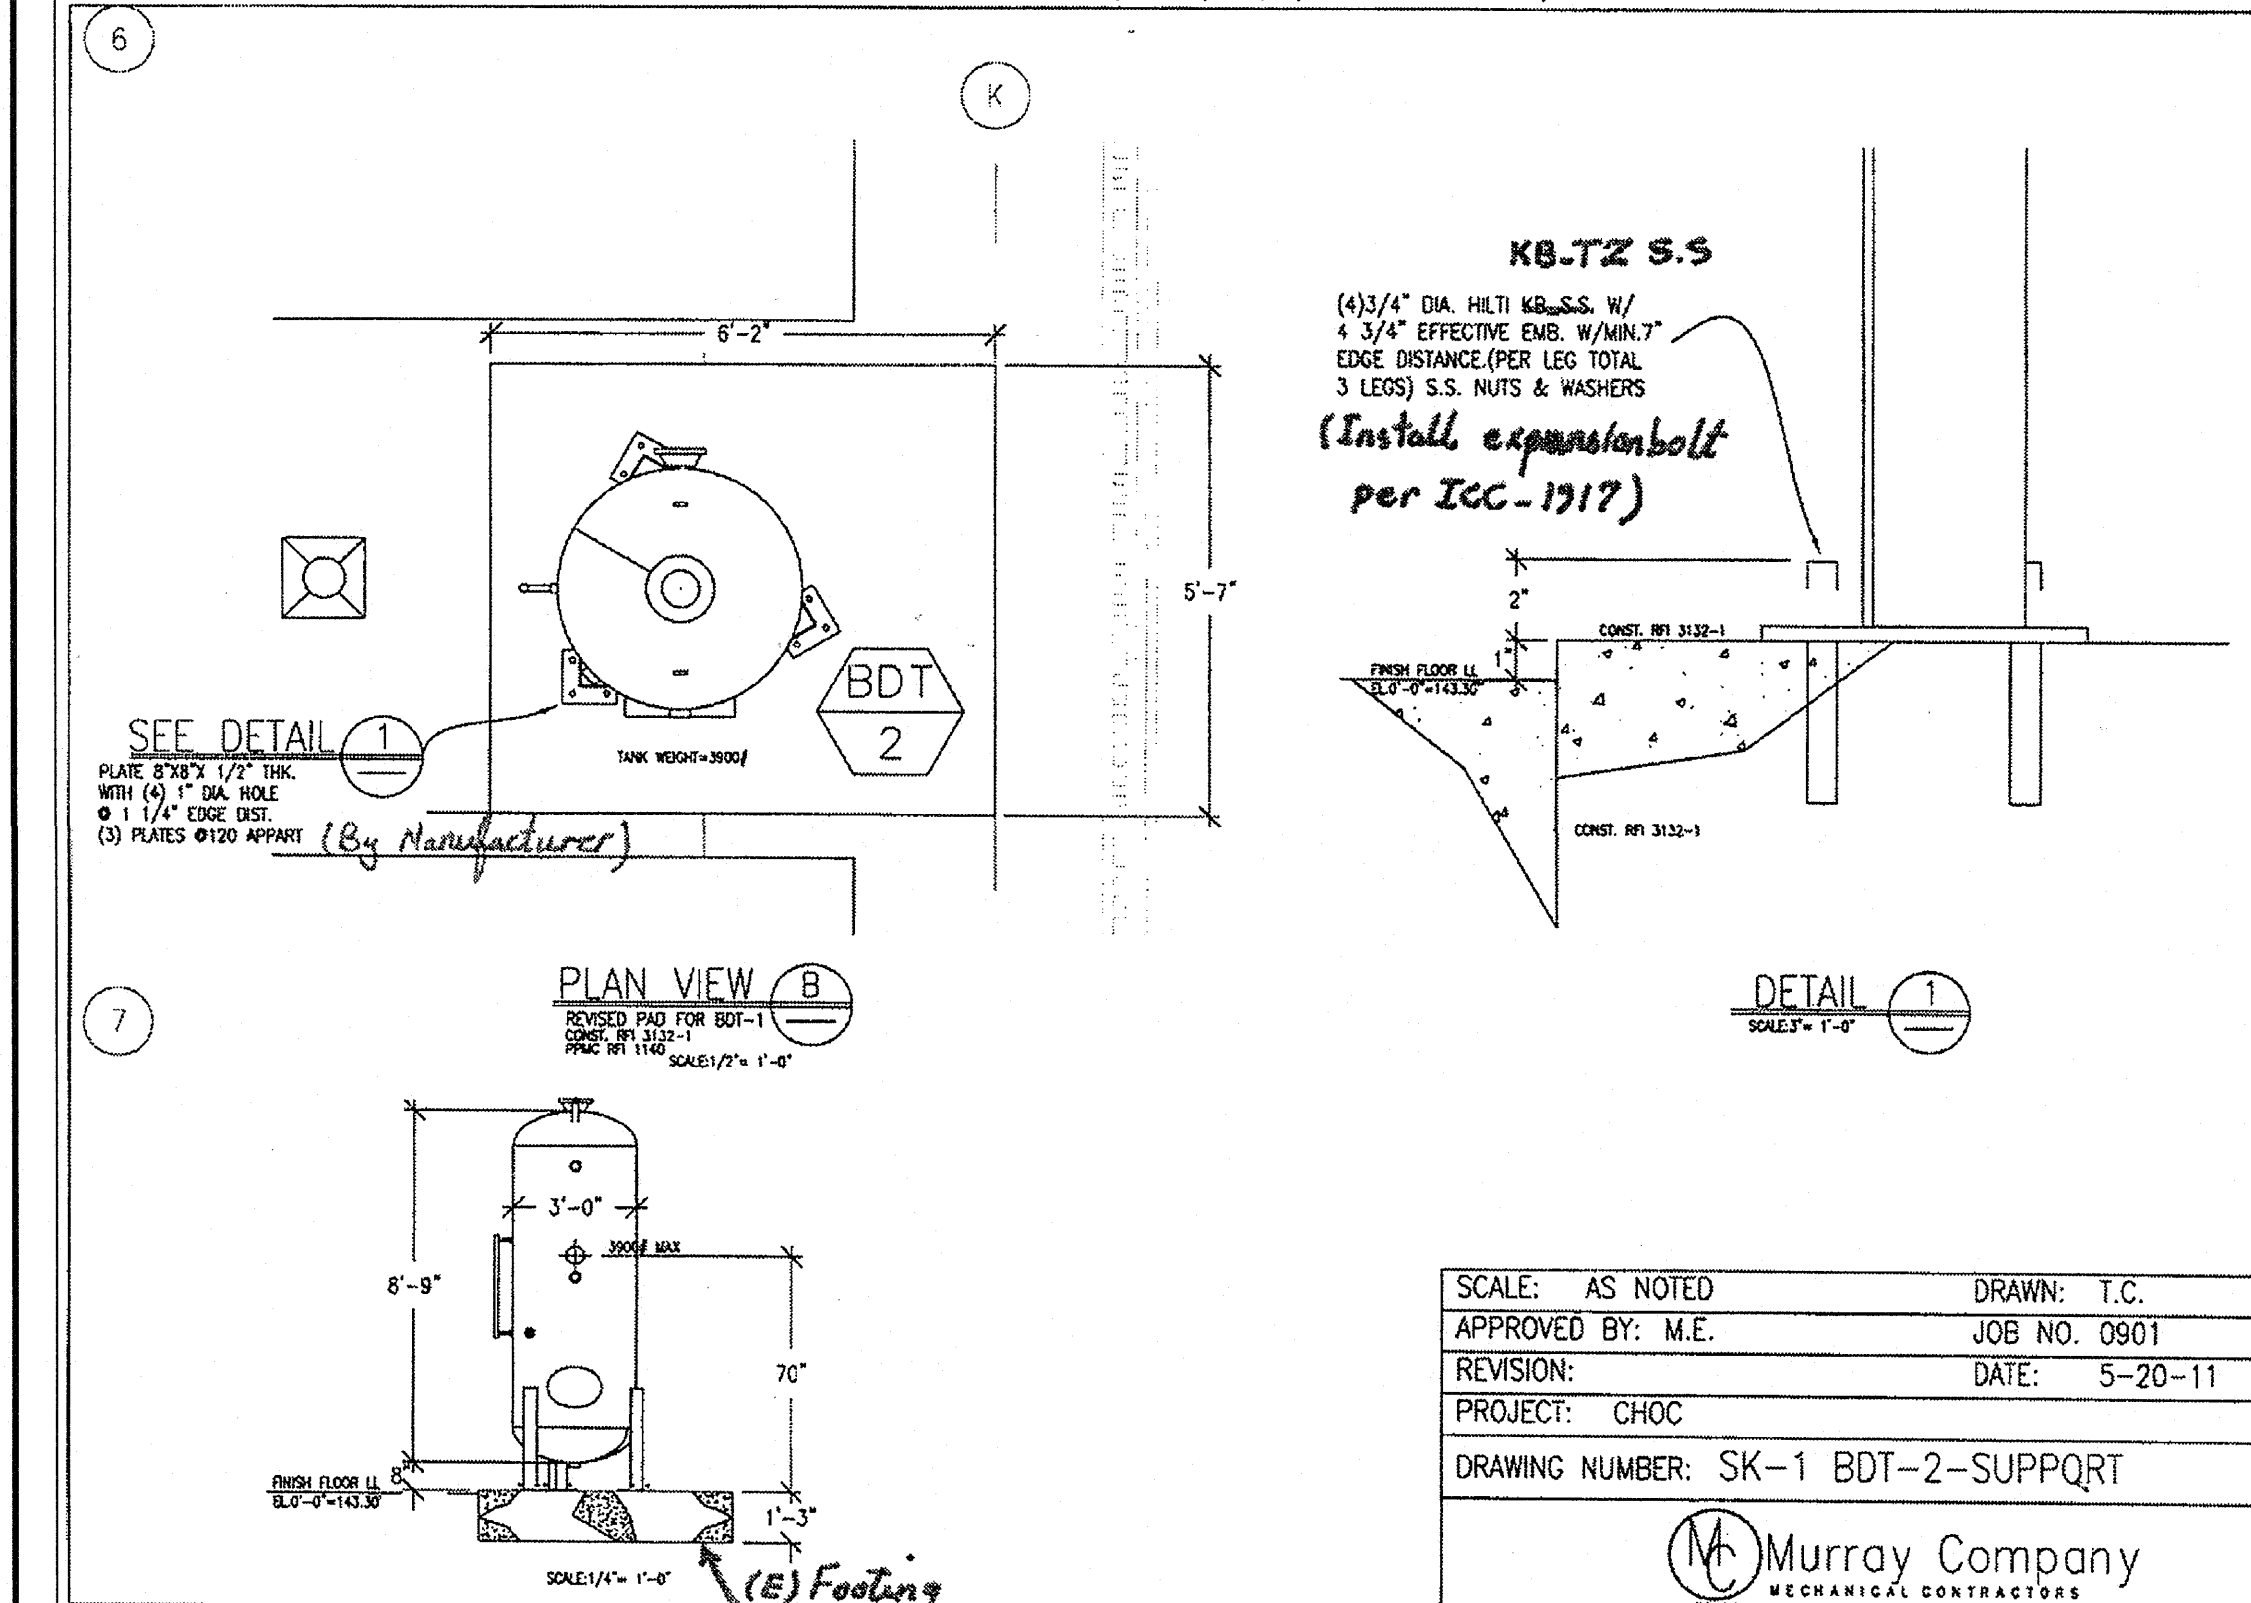

DUCT SUPPORT TYPE DS-17 AND DS-17K (10' MAX SPACING)

E

D

C

B

A

IT CLOSET IN 2ND FLOOR CONFERENCE ROOM

6

5

4

3

2

1