

FKP Architects

ARCHITECT OF RECORD

*Architect of Record signature line only; this drawing was not prepared under the direct supervision of the Architect of Record. The direct responsibility for preparation of this sheet lies with its corresponding professional stamp and signature. The signature of the Architect of Record in general responsible for the project is provided as required by Title 24, Part 2, Section 7-115 (a).

ARCHITECT - PAUL C. GLORIOT

CONSULTANT

T M A D
TAYLOR
& GAINES

- STRUCTURAL
- MECHANICAL
- ELECTRICAL
- CIVIL

100 South Anaheim Boulevard, Suite 150
Anaheim, California 92805
Phone: 714.490.5555 Fax: 714.490.5560
Project No. 2305-163-07



REVISIONS

APPROVAL



REVIEWED IN ACCORDANCE WITH
THE REQUIREMENTS OF T24, CCR

APPROVED

JAN 28 2010

Office of Statewide Health
Planning & Development
FACILITIES DEVELOPMENT DIVISION

PROJECT NAME

CHILDREN'S HOSPITAL
OF ORANGE COUNTY

455 S. Main St.
Orange, CA 92868-3874

TOWER II



PROJECT NUMBER

12011.00
Increment #7

OSHPD - PROJECT NUMBER

IL 072072-30

ISSUE

OSHPD PERMIT

DATE

01/27/2010

SCALE




1" = 20' - 0"

DRAWING TITLE

PENTHOUSE 3 COMPOSITE
MECHANICAL PLAN

DRAWING NUMBER

M2.00

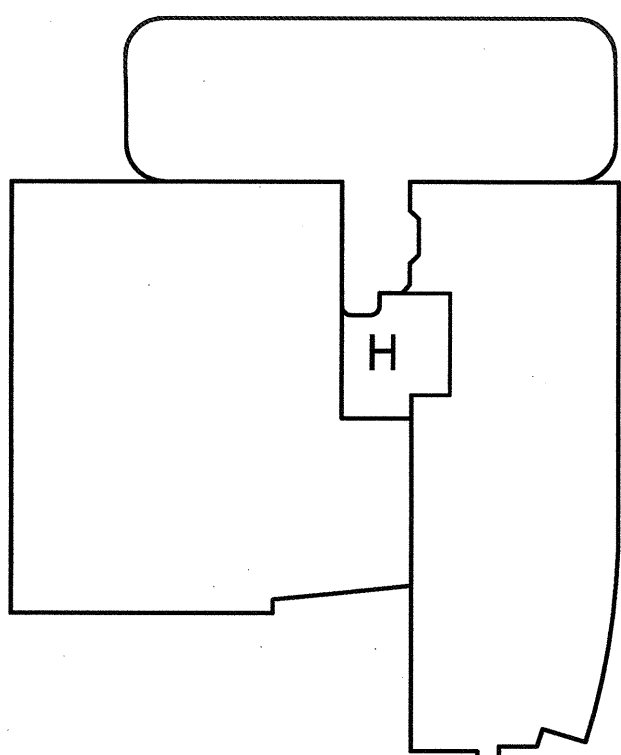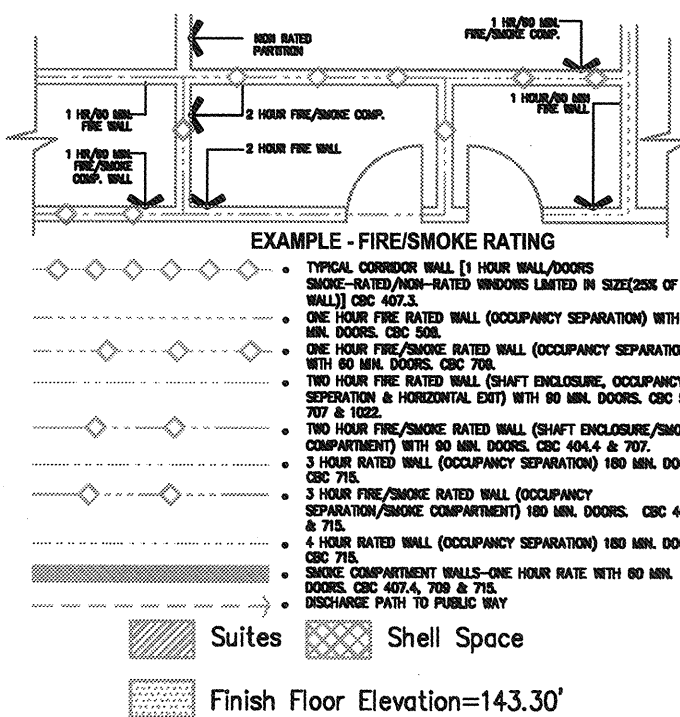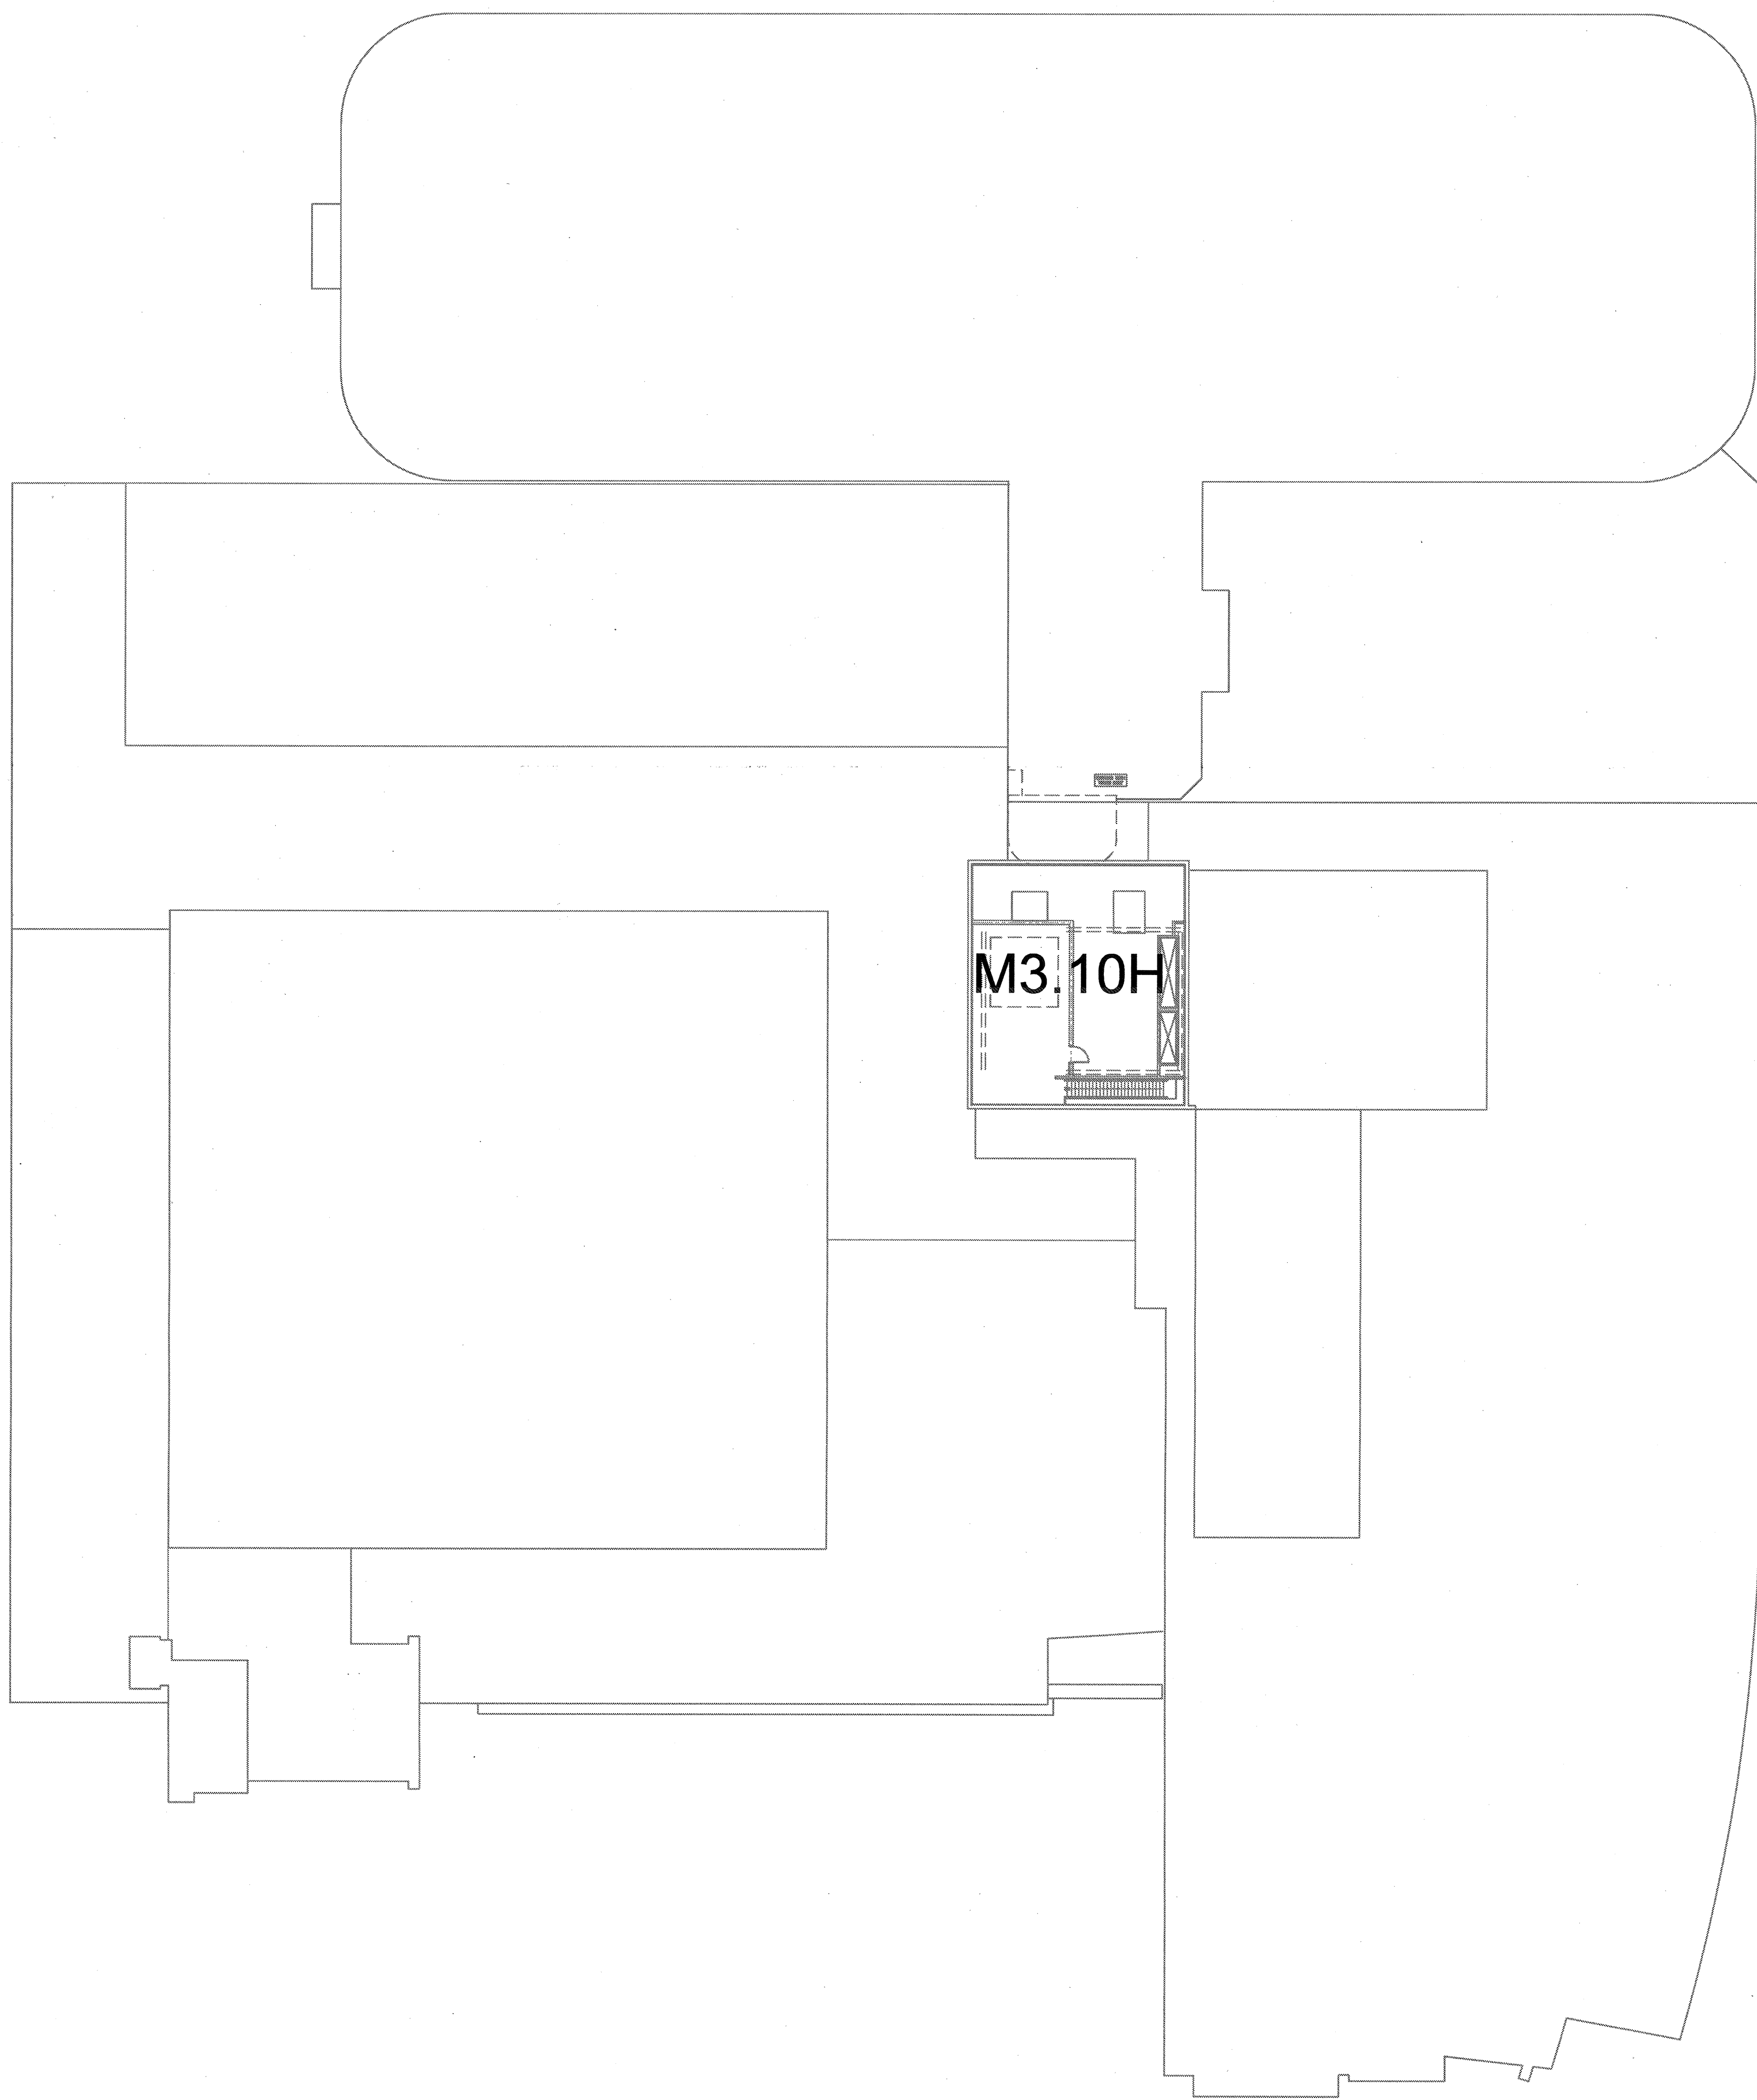

A1 Key Plan
N.T.S.

E

D

C

B

A

6

5

4

3

2

1