 


FKP Architects

ARCHITECT OF RECORD

"Architect of Record signature line only; this drawing was not prepared under the direct supervision of the Architect of Record. The direct responsibility for preparation of this sheet lies with its corresponding professional stamp and signature. The signature of the Architect of Record in general responsible phase of the project is provided as required by Title 24, Part 2, Section 7-115 (a)." 

ARCHITECT - PAUL C. GLORIOD

CONSULTANT

 • STRUCTURAL
• MECHANICAL
• ELECTRICAL
• CIVIL

100 South Anaheim Boulevard, Suite 150
Anaheim, California 92805
Phone: 714.490.5555 Fax: 714.490.5560
Project No. 2305-163-07



REVISIONS

APPROVAL



Office of Statewide Health
Planning & Development
FACILITIES DEVELOPMENT DIVISION

PROJECT NAME

CHILDREN'S HOSPITAL
OF ORANGE COUNTY

455 S. Main St.
Orange, CA 92868-3874

TOWER II



PROJECT NUMBER

12011.00
Increment #7

OSHPD - PROJECT NUMBER

IL 072072-30

ISSUE

OSHPD PERMIT

DATE

01/27/2010

SCALE

1/4"=1'-0"


DRAWING TITLE

LOWER LEVEL MECHANICAL
PLAN AREA - B

DRAWING NUMBER

M3.0B

LOWER LEVEL MECHANICAL PLAN AREA - B

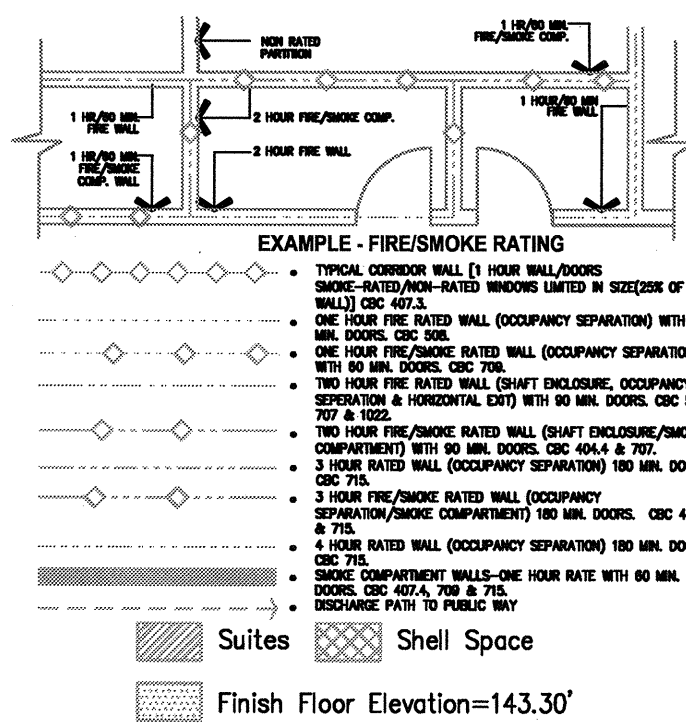

Suites Shell Space
Finish Floor Elevation=143.30'

(A1) Key Plan
N.T.S.

KEY PLAN

DESIGN KEY NOTES

6

5

4

3

2

1