

FKP Architects

ARCHITECT OF RECORD

"Architect of Record signature line only; this drawing was not prepared under the direct supervision of the Architect of Record. The direct responsibility for preparation of this sheet lies with its corresponding professional stamp and signature. The signature of the Architect of Record in general responsible for the project is provided as required by Title 24, Part 1, Section 7-115 (a)"

ARCHITECT - PAUL C. GLORIO

CONSULTANT

T M A D
TAYLOR
& GAINES

100 South Anaheim Boulevard, Suite 150
Anaheim, California 92805
Phone: 714.490.5555 Fax: 714.490.5560
Project No. 2305-163-07




Changes on these drawings do not consist of materially altered changes to approved drawings and don't require a change order.
OSHPD review ACO
OSHPD review FLSO
OSHPD review DSE

REVISIONS

1/24/2011 CHANGE ORDER #104

 APPROVAL



CHANGE ORDER #104
DEFINITION OF THE PROJECT
DEFERRED APPROVAL
1/24/2011

PROJECT NAME

**CHILDREN'S HOSPITAL
OF ORANGE COUNTY**

455 S. Main St.
Orange, CA 92668-3874

TOWER II RECEIVED
JUNE 08 2011
MCCARTHY



PROJECT NUMBER

12011.00
Increment #7

OSHPD - PROJECT NUMBER
IL 072072-30

ISSUE

OSHPD PERMIT

DATE

01/27/2010

SCALE

1/4"=1'-0"

DRAWING TITLE

**LOWER LEVEL MECHANICAL
PLAN AREA - F**

DRAWING NUMBER

M3.0F

RFI 3540- Relocate
steam drip legs,
chilled water drain
and 3" chilled water
pipe per MEOR
report dated 4/15/11

RFI 3870-
Penetration E3

RFI 3267 Floor mount
pipe supports

RFI 3498- HX 1
& 2 VFD
location and
mounting

RFI #5396

RFI #6056

RFI #5095
Relocate North to
allow clearances
for installation.

RFI #6058

LOWER LEVEL MECHANICAL PLAN AREA - F

GENERAL NOTES:

- FOR PIPING NOTES AND ENLARGED BASEMENT REFER TO SHEET M5.06.


DESIGN KEY NOTES:

- 14" STAINLESS STEEL DUCT CONNECTED TO AUTOMATIC WASHER - EXHAUST 1000 CFM.
- STAINLESS STEEL METAL LINER ALL CEILING PLUS 2 FEET ON WALL ALL AROUND.
- (2) 36x18 STAINLESS STEEL EXHAUST AIR GRILLE WITH 24x14 DUCT CONNECTION.
- (3) 4" STAINLESS EXHAUST AIR DUCT CONNECTED TO DISINFECTED CLEANER.
- 20x20 STAINLESS STEEL EXHAUST AIR GRILLE WITH STAINLESS STEEL MANUAL DAMPER, RIGID STAINLESS STEEL 12" DUCT CONNECTION.
- 36x18 S.S. TRANSFER AIR GRILLES & S.S. SLEEVE, WALL MOUNTED AT 7' ABOVE FINISHED FLOOR. GRILLES SHALL BE BOTH SIDE OF THE WALL.
- (2) EXHAUST STAINLESS STEEL GRILLES 24x16 500 CFM EA.
- DDC CONTROL PANEL (PER CONTRACT & PROJECT REQUIREMENTS)
- THREE WAY CONTROL VALVE FOR HEAT COIL.

- MPS DRIP LEG STEAM TRAP CONNECT CONDENSATE RETURN TO SPARROW PIPE CONNECTION.
- MPR CONNECTED TO PUMPED PCR WITH SPARROW PIPE CONNECTION.
- 1" MPS WITH 3/4" MPR SERVING STERILIZER (TYP. FOR 2 & 2 FOR FUTURE UNITS)
- 1 1/2" MPS & 1" MPR SERVING AUTOMATIC WASHING MACHINE.
- 2 1/2" COPPER INSULATED CONDENSATE DRAIN TO FLOOR SINK.
- 1 1/2" COPPER INSULATED CONDENSATE DRAIN TO FLOOR SINK.
- S.S. SECONDARY DRAIN PAN WITH 3/4" DRAIN LINE TO EXPOSE AREA TERMINATED @ 6" ABOVE FINISH FLOOR.
- PROVIDE 3 WAY CONTROL VALVE FOR CV BOX REHEAT COIL.
- OPPOSED BLADES MVD, HEAVY DUTY.
- CONNECT 14" S.S. WITH TRANSITION TO 10" TO AUTOMATIC CART WASH BLOWER.

- S.S. BAROMETRIC BACKDRAFT DAMPER
- TRANSFERRING AIR TO CART WASH CEILING SPACE TO MAKE-UP AIR FOR CART WASH BLOWER.
- 14" UNDERGROUND EXHAUST AIR DUCT IN CONCRETE ENCASUREMENT WITH 4" STUB-OUT ABOVE FINISHED FLOOR (FOR AUTOPSY TABLE CONNECTION.)
- TWO 3-1/2"x14" S.S. EXHAUST AIR DUCT IN THE WALL DOWN TO UNDERGROUND AND CONNECT TO THE UNDERGROUND 4"x36" PLENUM. UNDERGROUND DUCT SHALL BE WRAPPED WITH MIN. TWO LAYER 10 MIL PROTECTION.
- 6" S.S. EXHAUST AIR DUCT CONNECTED TO THE VENTED CABINET.
- 4" S.S. EXHAUST AIR DUCT CONNECTED TO THE BACKSIDE OF THE LAB VENTED EQUIPMENT.
- PRESSURE MONITOR PANEL BETWEEN ANTE ROOM & AUTOPSY.
- PRESSURE MONITOR PANEL BETWEEN AUTOPSY ROOM AND BODY HOLDING.
- PRESSURE MONITOR PANEL BETWEEN MYCOLOGY AND MICROBIOLOGY.

- 1" MPS AND 3/4" MPR SERVING STEAM GUN.
- CSFD ACTUATOR TO BE LOCATED OUTSIDE OF ELECTRICAL ROOM.
- LPS(CS) & LPR(CS) SERVING THE NORTH ZONE OF PANCAKE 100' - 120 RUN BACK TO CRU.
- 2 HR FIRE RATED DUCTWRAP.
- 3" CHWS/R CONNECTED TO 6" CHWS/R W/ SHUT-OFF VALVES.
- 1" CHWS/R SERVING THE FCU-B11 W/ 3/4" CONDENSATE DRAIN TO TAILPIPE OF THE SINK WASTE LINE SINK IN TOILET STAFF FEMALE B.O.36.03. PROVIDE S.S. SECONDARY DRAIN PAN AND SECONDARY CONDENSATE DRAIN TERMINATED @ CEILING LEVEL.
- SEE INCREMENT 7 M3.5K FOR EXHAUST AIR FANS AND TERMINATION ON ROOF.
- 1" CHWS/R W/ CIRCUIT SETTER SERVING X-RAY IRRADIATOR.

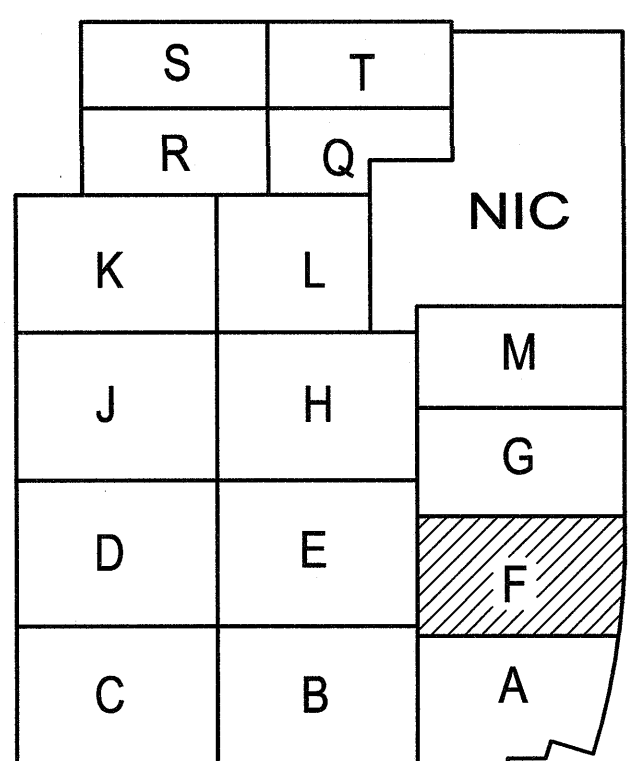

A1 Key Plan
N.T.S.

KEY PLAN

6

5

4

3

2

1

T:\32040\3205\3205-163-07\MC-7-JM-P\M3_0F.DWG
6/1/2011
HERNANDEZ