

FKP Architects

ARCHITECT OF RECORD

"Architect of Record signature line only; this drawing was not prepared under the direct supervision of the Architect of Record. The direct responsibility for preparation of this sheet lies with its corresponding professional stamp and signature. The signature of the Architect of Record in general responsible for the project is provided as required by Title 24, Part 9, Section 7-115 (a)."
ARCHITECT - PAUL C. GLORIO

CONSULTANT


T M A D
TAYLOR & GAINES
• STRUCTURAL
• MECHANICAL
• ELECTRICAL
• CIVIL

100 South Anaheim Boulevard, Suite 150
Anaheim, California 92805
Phone: 714.490.5555 Fax: 714.490.5560
Project No. 2305-163-07



REVISIONS

09/27/2010 CHANGE ORDER #75
02/24/2011 CHANGE ORDER #141

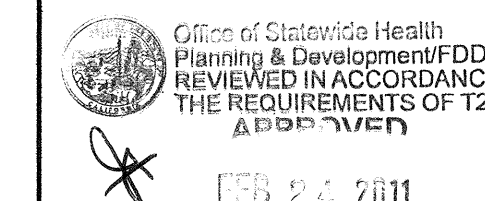

CHANGE ORDER #141
INSTRUCTION BULLETIN
REVISION APPROVAL
APPENDIX

PROJECT NAME

CHILDREN'S HOSPITAL
OF ORANGE COUNTY

455 S. Main St.
Orange, CA 92668-3874

TOWER II



PROJECT NUMBER

12011.00

Increment #7

OSHPD - PROJECT NUMBER

IL 072072-30

ISSUE

OSHPD PERMIT

DATE

01/27/2010

SCALE

1/4"=1'-0"

DRAWING TITLE


LOWER LEVEL MECHANICAL
PLAN AREA - K

DRAWING NUMBER

M3.0K


DESIGN KEY NOTES

- 14" STAINLESS STEEL DUCT CONNECTED TO AUTOMATIC WASHER - EXHAUST 1000 CFM.
- STAINLESS STEEL METAL LINER ALL CEILING PLUS 2 FEET ON WALL ALL AROUND.
- 26x18 STAINLESS STEEL EXHAUST AIR GRILLE WITH 24x14 DUCT CONNECTION.
- 4" STAINLESS EXHAUST AIR DUCT CONNECTED TO DISINFECTED CLEANER.
- 20x20 STAINLESS STEEL EXHAUST AIR GRILLE WITH STAINLESS STEEL MANUAL DAMPER, RIGID STAINLESS STEEL 12" DUCT CONNECTION.
- 26"x3" STAINLESS STEEL CANOPY HOOD WITH (4) 24x12 OPENING FOR AIR TRANSFER.
- 14"x3" STAINLESS STEEL CANOPY HOOD WITH (2) EXHAUST STAINLESS STEEL GRILLE 24x18 FOR 1000 CFM.
- DDC CONTROL PANEL (PER CONTRACT & PROJECT REQUIREMENTS)
- THREE WAY CONTROL VALVE FOR HEAT COIL.
- MPS DRIP LEG STEAM TRAP CONNECT CONDENSATE RETURN TO SPARROW PIPE CONNECTION.
- MPS CONNECTED TO PUMPED PCR WITH SPARROW PIPE CONNECTION.
- 1" MPS WITH 3/4" MPS SERVING STERILIZER (TYP. FOR 2 & 2 FOR FUTURE UNITS)
- 1 1/2" MPS & 1" MPS SERVING AUTOMATIC WASHING MACHINE.
- 2 1/2" COPPER INSULATED CONDENSATE DRAIN TO FLOOR SINK.
- 1 1/2" COPPER INSULATED CONDENSATE DRAIN TO FLOOR SINK.
- S.S. SECONDARY DRAIN PAN WITH 3/4" DRAIN LINE TO EXPOSE AREA TERMINATED @ 6" ABOVE FINISH FLOOR.
- PROVIDE 3 WAY CONTROL VALVE FOR CV BOX REHEAT COIL.
- OPPOSED BLADES MVD, HEAVY DUTY.
- CONNECT 14" S.S. WITH TRANSITION TO 10" TO AUTOMATIC CART WASH BLOWER.
- S.S. MOTORIZED DAMPER TO BE INTERLOCKED FOR OPERATION WITH CART WASH BLOWER.
- TRANSFERRING AIR TO CART WASH CEILING SPACE TO MAKE-UP AIR FOR CART WASH BLOWER.
- 14" UNDERGROUND EXHAUST AIR DUCT IN CONCRETE ENCASEMENT WITH 4" STUB-OUT ABOVE FINISHED FLOOR (FOR AUTOPSY TABLE CONNECTION.)
- TWO 3-1/2"x14" S.S. EXHAUST AIR DUCT IN THE WALL DOWN TO UNDERGROUND AND CONNECT TO THE UNDERGROUND 4"x36" PLENUM. UNDERGROUND DUCT SHALL BE WRAPPED WITH MIN. TWO LAYER 10 MIL PROTECTION.
- 6" S.S. EXHAUST AIR DUCT CONNECTED TO THE VENTED CABINET.
- 4" S.S. EXHAUST AIR DUCT CONNECTED TO THE BACKSIDE OF THE LAB VENTED EQUIPMENT.
- PRESSURE MONITOR PANEL BETWEEN ANTE ROOM & AUTOPSY.
- PRESSURE MONITOR PANEL BETWEEN AUTOPSY ROOM AND BODY HOLDING.
- PRESSURE MONITOR PANEL BETWEEN MYCOLOGY AND MICROBIOLOGY.
- 1" MPS AND 3/4" MPS SERVING STEAM GUN.
- CSFD ACTUATOR TO BE LOCATED OUTSIDE OF ELECTRICAL ROOM.
- LPS(CS) & LPR(CS) SERVING THE NORTH ZONE OF PANCAKE 100' - 120' RUN BACK TO CRU.
- 2 HR FIRE RATED DUCTWRAP.
- 1" CHWS/R SERVING THE FCU-B11 W/ 3/4" CONDENSATE DRAIN TO THE HOUSE KEEPING SINK. PROVIDE SECONDARY DRAIN PAN AND SECONDARY CONDENSATE DRAIN TERMINATED @ CEILING LEVEL.
- 3" CHWS/R CONNECTED TO 6" CHWS/R W/ SHUT-OFF VALVES.
- 1" CHWS/R SERVING THE FCU-B10 W/ 3/4" CONDENSATE DRAIN TO TAILPIECE OF THE SINK WASTE LINE SINK IN TOILET STAFF FEMALE B.036.03. PROVIDE S.S. SECONDARY DRAIN PAN AND SECONDARY CONDENSATE DRAIN TERMINATED @ CEILING LEVEL.
- SEE INCREMENT 7 M3.5K FOR EXHAUST AIR FANS AND TERMINATION ON ROOF.
- 1" CHWS/R W/ CIRCUIT SETTER SERVING X-RAY IRRADIATOR.

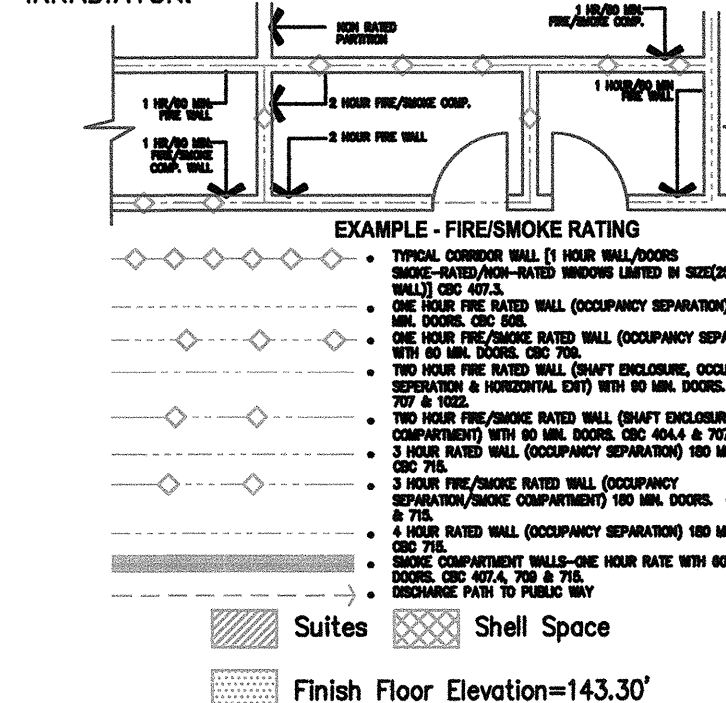

A1 Key Plan
N.T.S.

KEY PLAN

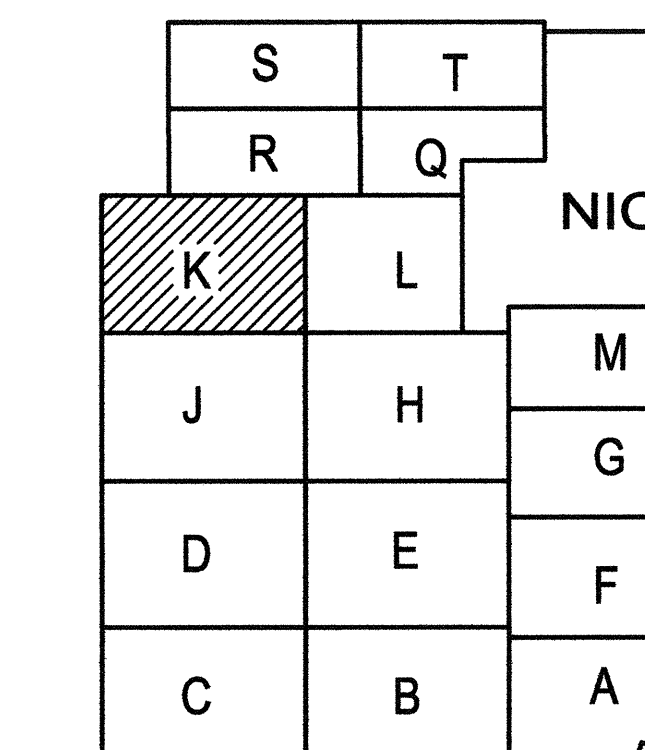

LOWER LEVEL MECHANICAL PLAN AREA - K

