

ARCHITECT OF RECORD

ARCHITECT - PAUL G. GLOBION

CONSULTANT

- STRUCTURAL
- MECHANICAL
- ELECTRICAL
- CIVIL



APPROVA



JAN 28 2010

Office of Statewide Health
Planning & Development
FACILITIES DEVELOPMENT DIVISION

PROJECT NAME

455 S. Main St.
Orange, CA 92868-3874



PROJECT NUMBER

OSHPD - PROJECT NUMBER
IL 072072-30

ISSUE

OSHPD PERMIT

DATE _____

01/27/2010

SCALE


$$1/4"=1'-0"$$

DRAWING TITLE

LOWER LEVEL MECHANICAL
PLAN AREA - T

DRAWING NUMBER

M3.0T

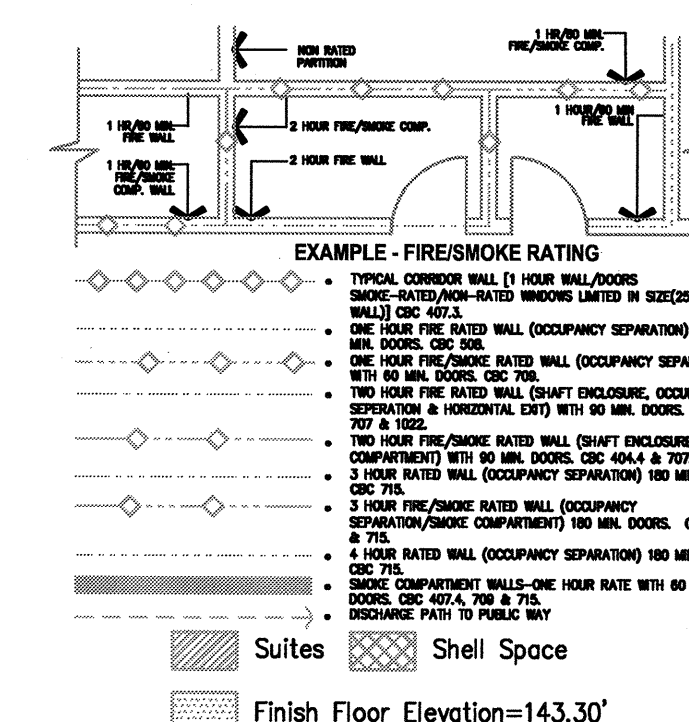

A1 Key Plan

KEY PLAN

LOWER LEVEL MECHANICAL PLAN AREA - T

DESIGN KEY NOTES

6

5

4

2
