


DESIGN KEY NOTES

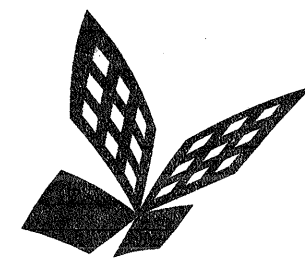

FKP Architects

ARCHITECT OF RECORD

"Architect of Record signature line only; this drawing was not prepared under the direct supervision of the Architect of Record. The direct responsibility for preparation of this sheet lies with its corresponding professional stamp and signature. The signature of the Architect of Record in general responsible charge of the project is provided as required by Title 24, Part 1, Section 7-115 (a)."

ARCHITECT - PAUL C. GLORIOD

CONSULTANT

T M A D
TAYLOR
& GAINES

• STRUCTURAL
• MECHANICAL
• ELECTRICAL
• CIVIL

100 South Anaheim Boulevard, Suite 150
Anaheim, California 92805
Phone: 714.490.5555 Fax: 714.490.5560
Project No. 2305-163-07



REVISIONS

09/14/2010 CHANGE ORDER #26

APPROVAL

PROJECT NAME
CHILDREN'S HOSPITAL
OF ORANGE COUNTY
455 S. Main St.
Orange, CA 92868-3874

TOWER II



PROJECT NUMBER

12011.00
Increment #7

OSHPD - PROJECT NUMBER
IL 072072-30

ISSUE

OSHPD PERMIT

DATE

01/27/2010

SCALE



1/4" = 1' - 0"

DRAWING TITLE

PENTHOUSE 3 MECHANICAL
PLAN AREA - H

DRAWING NUMBER

M3.10H

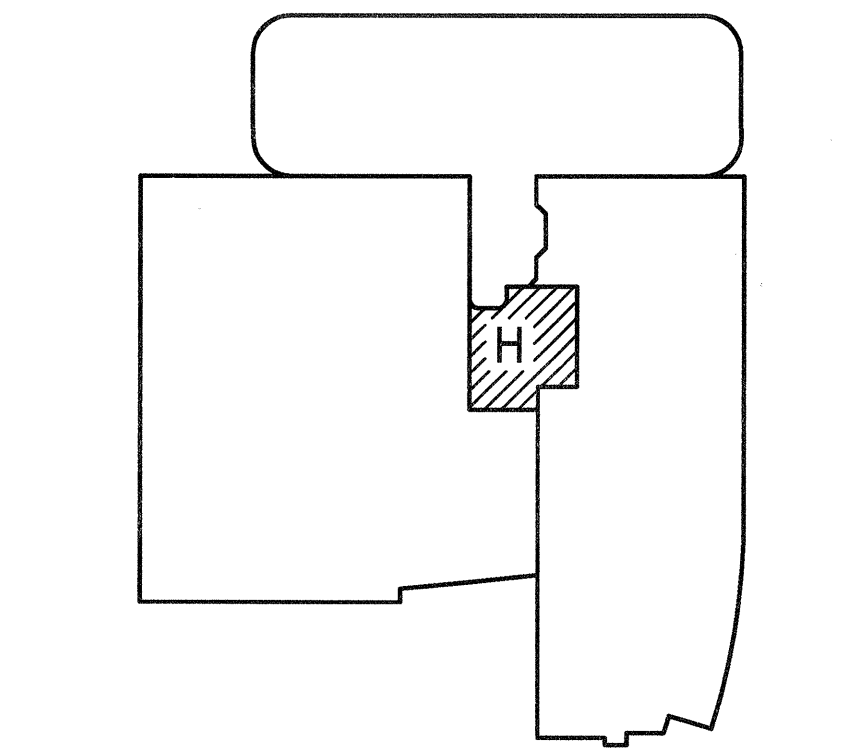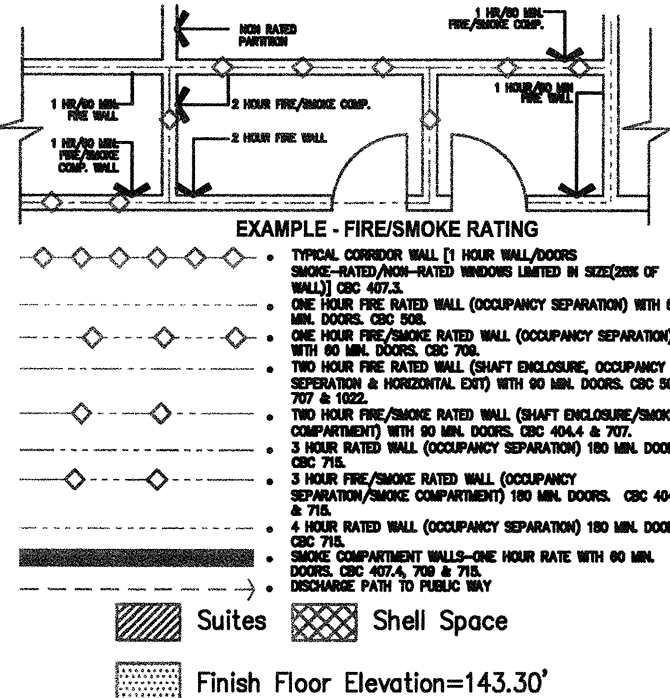

Key Plan
N.T.S.

PENTHOUSE 3 MECHANICAL PLAN AREA - H

KEY PLAN

EXISTING NOTH
TOWER ROOF

RFI 2585
Pad to move 6" to
north and pad
height goes from
24" to 6"

RFI #4360.1

RFI #5037
RWG to be changed to
36" wide x 30" high.

0.91 SF
R.003
ELEV. MACHINE
ROOM

R.003.1
MECHANICAL
ROOM

6" BOT. V.
6" CRU. V.
6" CSG. V.
4" DA. V.
4" DA. V.

10" PRV. V.

2" CHWS/R
DOWN.

40X28 & DN.

RFI 1726