 


FKP Architects

ARCHITECT OF RECORD

"Architect of Record signature line only: this drawing was not prepared under the direct supervision of the Architect of Record. The direct responsibility for preparation of this sheet lies with its corresponding professional stamp and signature. The signature of the Architect of Record in general responsible charge of the project is provided as required by Title 24, Part 1, Section 7-115 (a)." 

ARCHITECT - PAUL C. GLORIOD

CONSULTANT

T M A D  
TAYLOR  
& GAINES

- STRUCTURAL
- MECHANICAL
- ELECTRICAL
- CIVIL

100 South Anaheim Boulevard, Suite 150  
Anaheim, California 92805  
Phone: 714.490.5555 Fax: 714.490.5560  
Project No. 2305-163-07



REVISIONS

	DATE	DESCRIPTION
4A	02/05/2010	INFORMATION BULLETIN #5
	05/28/2010	ASI #8

APPROVAL

PROJECT NAME

CHILDREN'S HOSPITAL  
OF ORANGE COUNTY

455 S. Main St.  
Orange, CA 92868-3874

TOWER II



PROJECT NUMBER

12011.00  
Increment #7

OSHPD - PROJECT NUMBER

IL 072072-30

ISSUE

OSHPD PERMIT

DATE

01/27/2010

SCALE

1/4"=1' 0"



DRAWING TITLE

LEVEL 1 MECHANICAL PLAN  
AREA - A

DRAWING NUMBER

M3.1A

LEVEL 1 MECHANICAL PLAN AREA - A

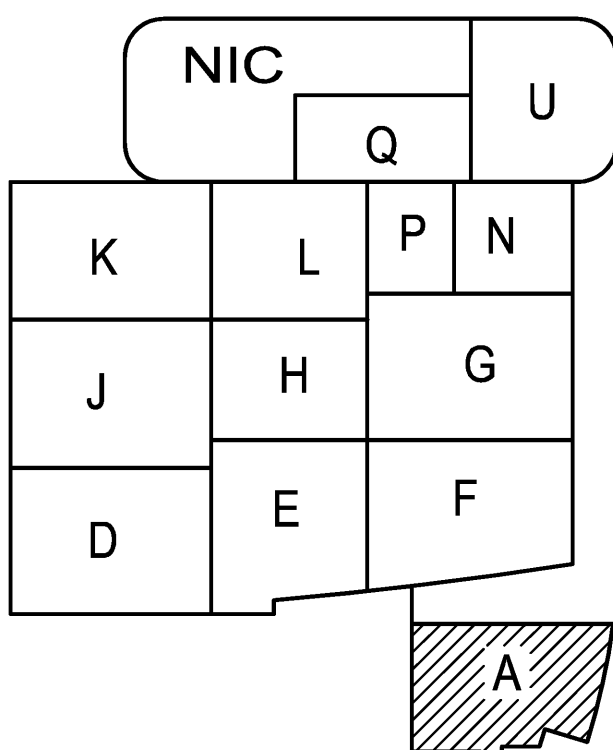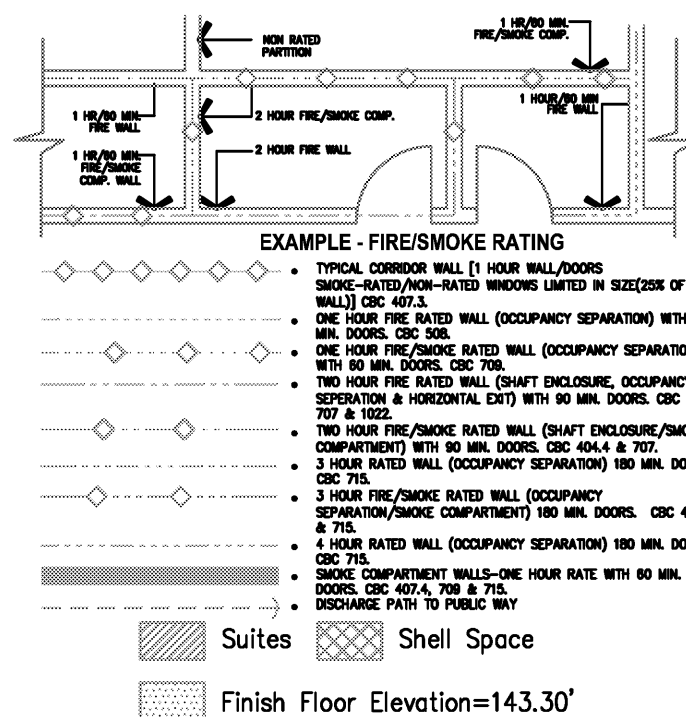

A1 Key Plan  
N.T.S.

DESIGN KEY NOTES

KEY PLAN