 


FKP Architects

ARCHITECT OF RECORD

"Architect of Record signature line only; this drawing was not prepared under the direct supervision of the Architect of Record. The direct responsibility for preparation of this sheet lies with its corresponding professional stamp and signature. The signature of the Architect of Record in general responsible for the project is provided as required by Title 24, Part 9, Section 7-115 (a)." 

ARCHITECT - PAUL C. GLORIOSO

CONSULTANT

 T M A D TAYLOR & GAINES • STRUCTURAL • MECHANICAL • ELECTRICAL • CIVIL

100 South Anaheim Boulevard, Suite 150
Anaheim, California 92805
Phone: 714.490.5555 Fax: 714.490.5560
Project No. 2305-163-07




Changes on these drawings do not consist of materially altered changes to approved drawings and don't require a change order.
OSHPD review ACO
OSHPD review FLSO
OSHPD review DSE

REVISIONS

 04/24/2012 CHANGE ORDER #360

 APPROVAL



CHANGE ORDER #360
INSTRUCTION SHEET
SUBMITTED FOR APPROVAL
DATE 2012-04151

PROJECT NAME

CHILDREN'S HOSPITAL
OF ORANGE COUNTY

455 S. Main St.
Orange, CA 92868-3874

TOWER II



PROJECT NUMBER

12011.00
Increment #7

OSHPD - PROJECT NUMBER

IL 072072-30

ISSUE

OSHPD PERMIT

DATE

01/27/2010

SCALE


1/4"=1'-0"

DRAWING TITLE



LEVEL 1 MECHANICAL PLAN
AREA - Q

DRAWING NUMBER

M3.1Q

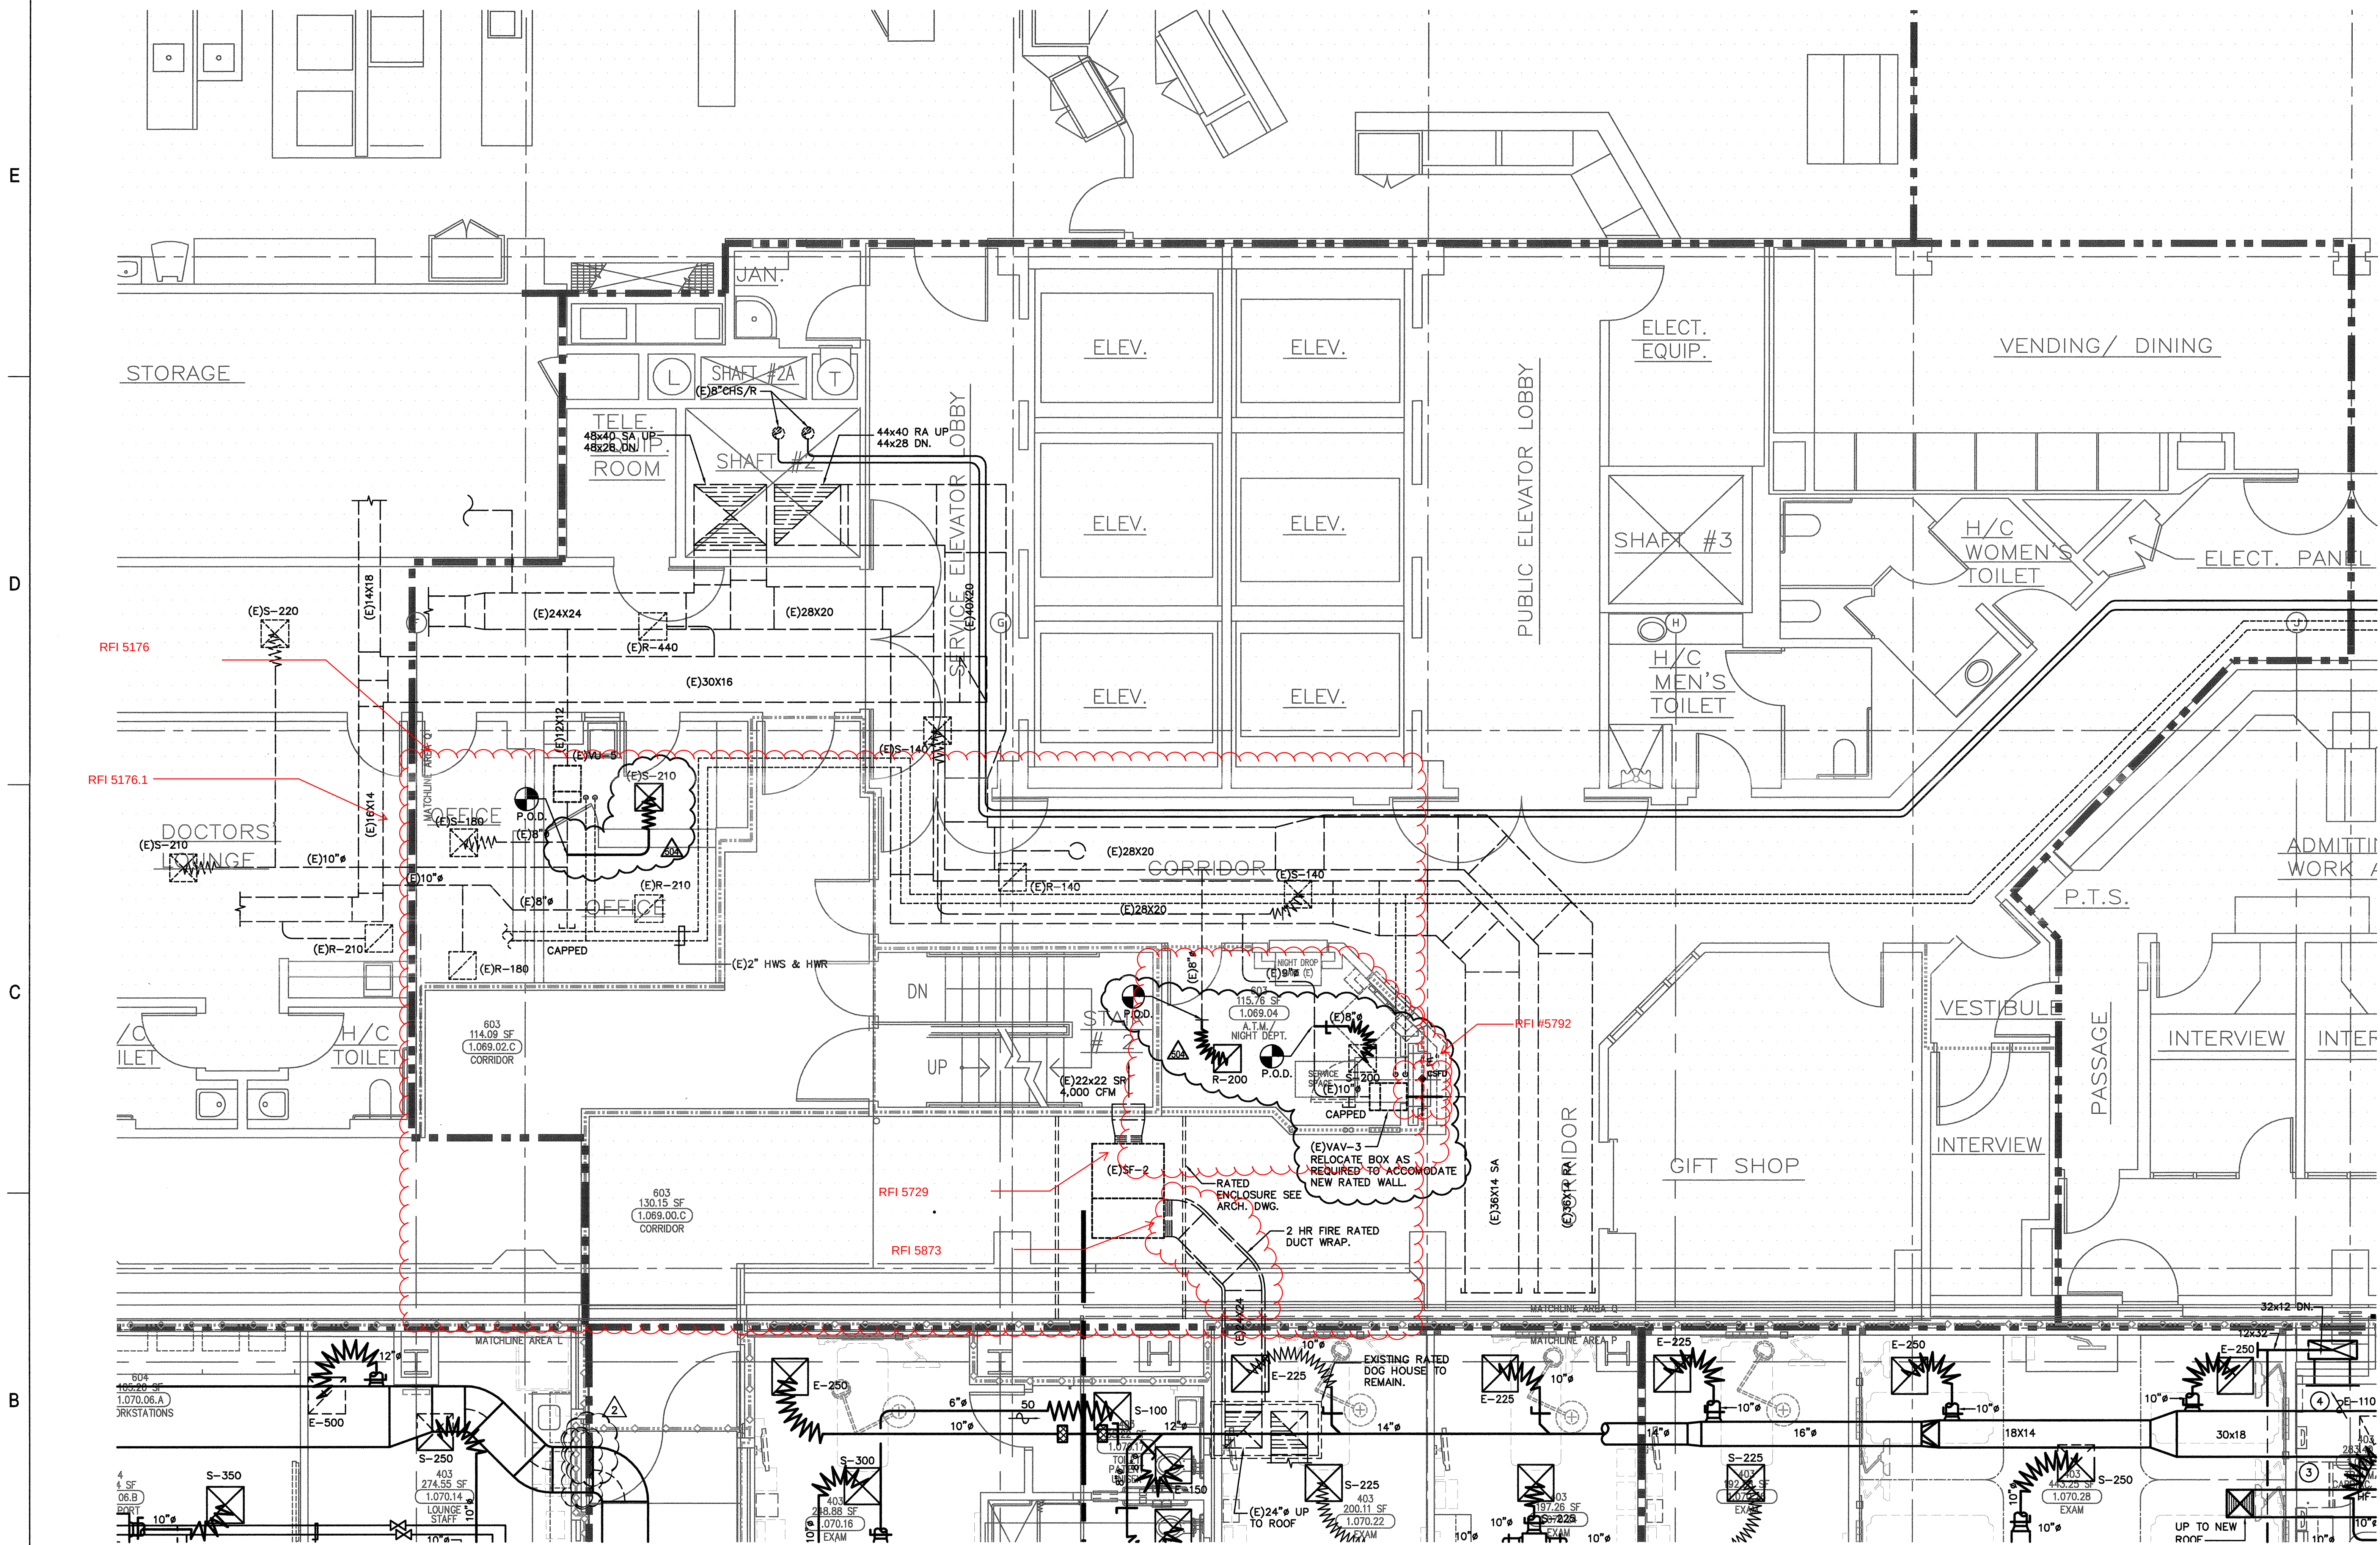

LEVEL 1 MECHANICAL PLAN AREA - Q

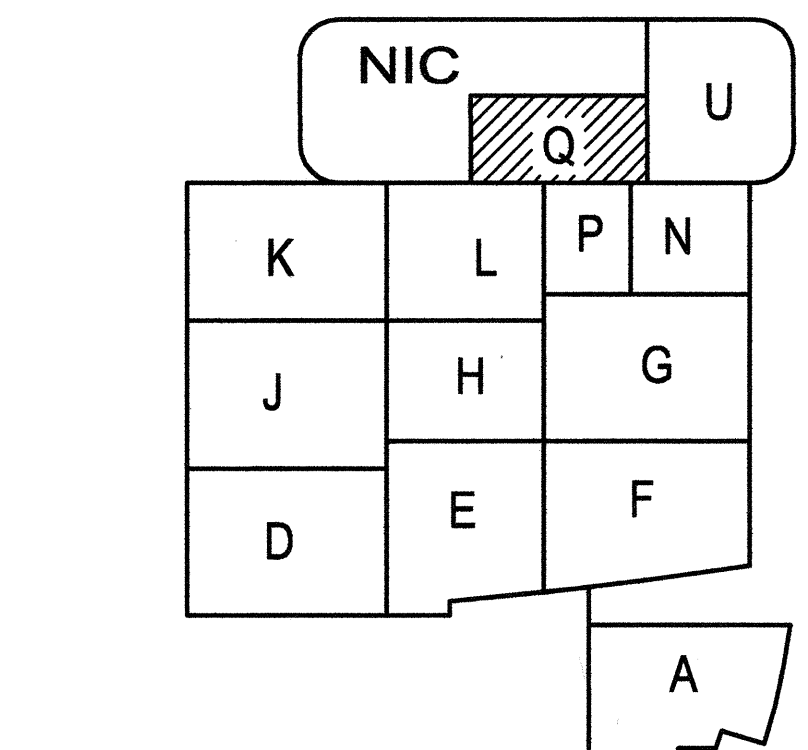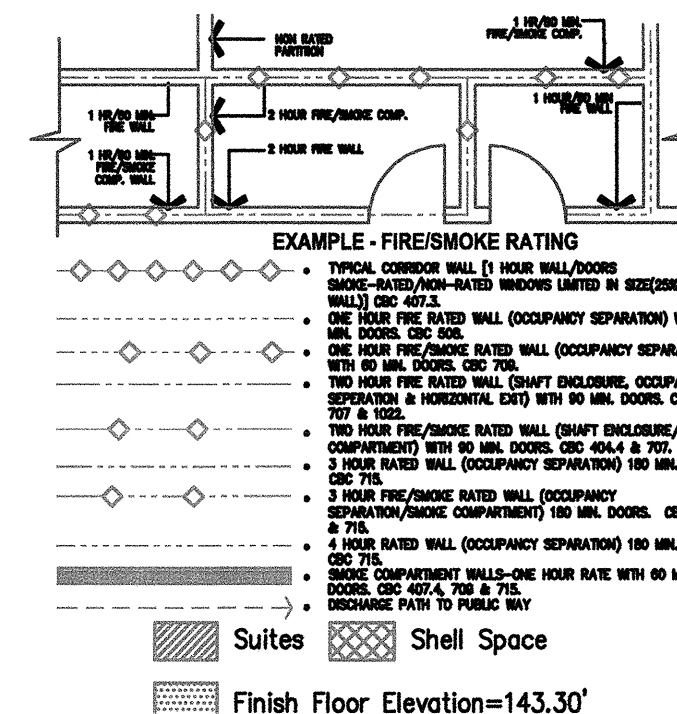

Key Plan

DESIGN KEY NOTES

KEY PLAN