

FKP Architects

ARCHITECT OF RECORD

*Architect of Record signature line only; this drawing was not prepared under the direct supervision of the Architect of Record. The direct responsibility for preparation of this sheet lies with its corresponding professional stamp and signature. The signature of the Architect of Record in general responsible charge of the project is provided as required by Title 24, Part 1, Section 7-115 (a)7.

ARCHITECT - PAUL C. GLORIO

CONSULTANT

T M A D
TAYLOR
& GAINES

• STRUCTURAL
• MECHANICAL
• ELECTRICAL
• CIVIL

100 South Anaheim Boulevard, Suite 150
Anaheim, California 92805
Phone: 714.490.5555 Fax: 714.490.5560
Project No. 2305-163-07




Changes on these drawings do not consist of materially altered changes to approved drawings and don't require a change order.
OSHPD review ACO
OSHPD review FL30
OSHPD review DGE

REVISIONS

NO.	DATE	DESCRIPTION
1	11/08/2010	CHANGE ORDER #99
2	03/01/2011	CHANGE ORDER #134

APPROVAL

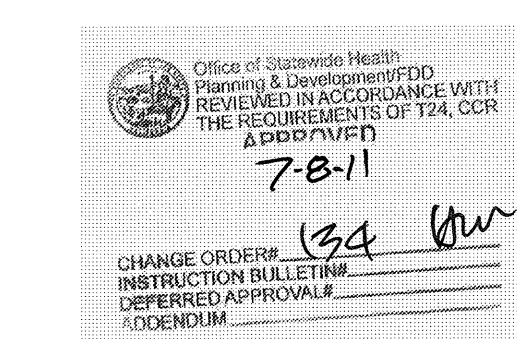

PROJECT NAME

CHILDREN'S HOSPITAL
OF ORANGE COUNTY

455 S. Main St.
Orange, CA 92668-3874

TOWER II

RECEIVED
July 12 2011
McCarthy

CHOC
HOSPITAL

PROJECT NUMBER

12011.00
Increment #7

OSHPD - PROJECT NUMBER
IL 072072-30

ISSUE

OSHPD PERMIT

DATE

01/27/2010

SCALE


1/4" = 1' - 0"

DRAWING TITLE

LEVEL 2 MECHANICAL PLAN
AREA - J

DRAWING NUMBER

M3.2J


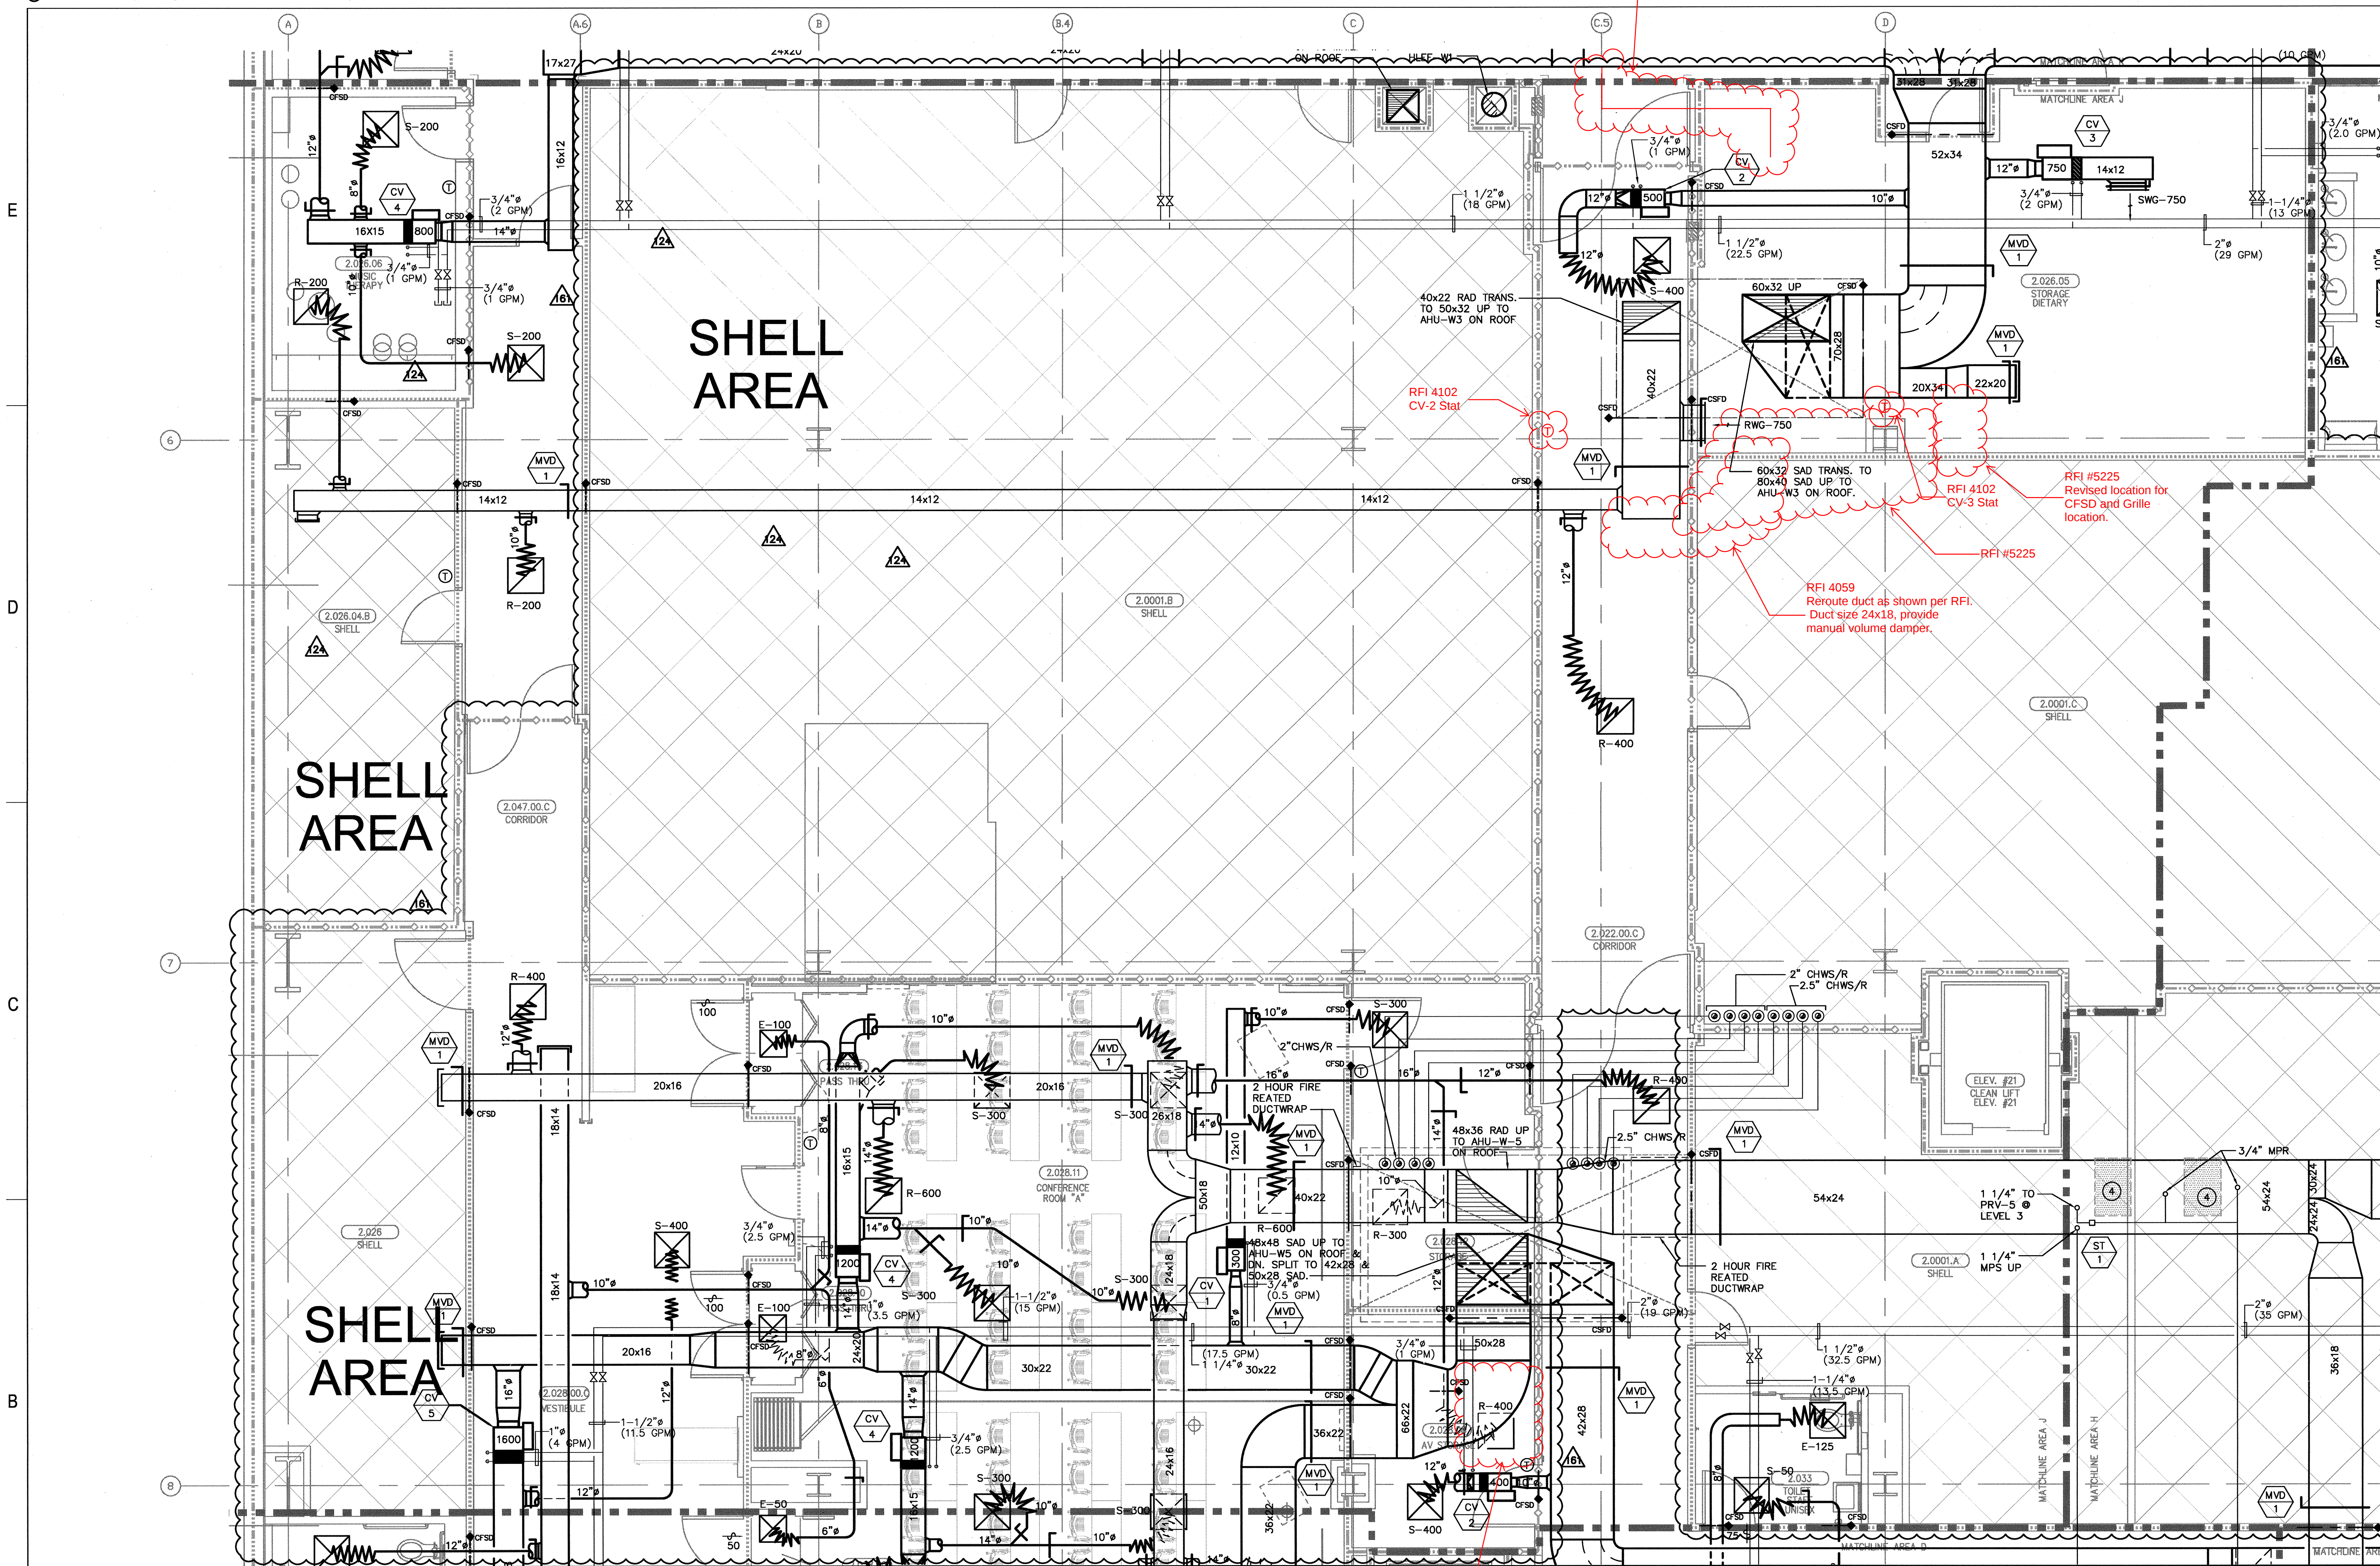


LEVEL 2 MECHANICAL PLAN AREA - J

RFI #4450
Relocate return grille
and reroute duct
feeding room 2.028.08.

DESIGN KEY NOTES

- DDC CONTROL PANEL (PER CONTRACT & PROJECT REQUIREMENTS)
- ALL WELDED SS CONSTRUCTION WITH 2 HR. FIRE RATED DUCT SHAFT.
- PROVIDE 3-WAY VALVE FOR REHEAT COIL.
- STERILIZER LOCATED ON THE THIRD FLOOR. STEAM LINE SUPPLY AND CONDENSATE RETURN SERVING THE STERILIZERS FROM LEVEL 2.
- COOLING ONLY CV BOX

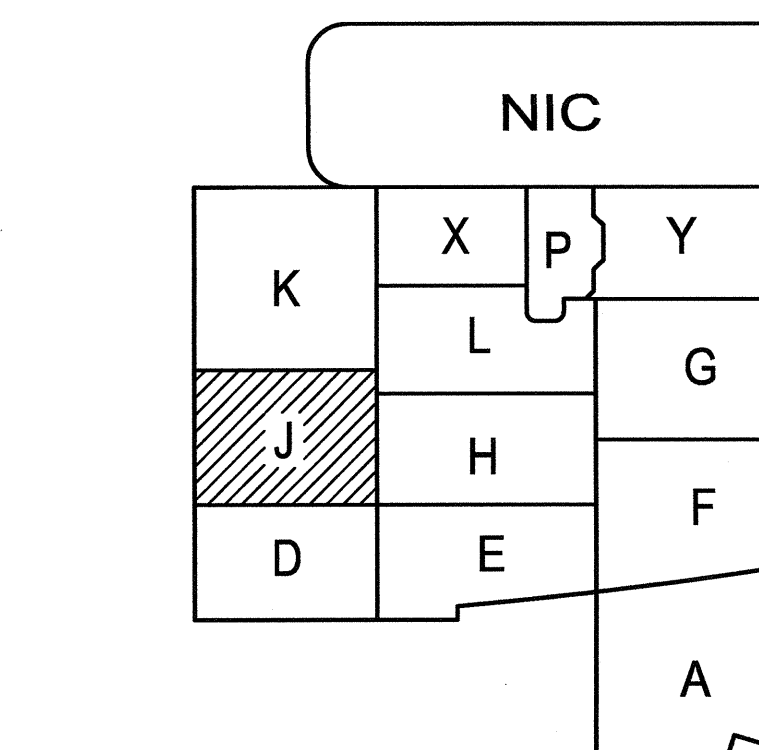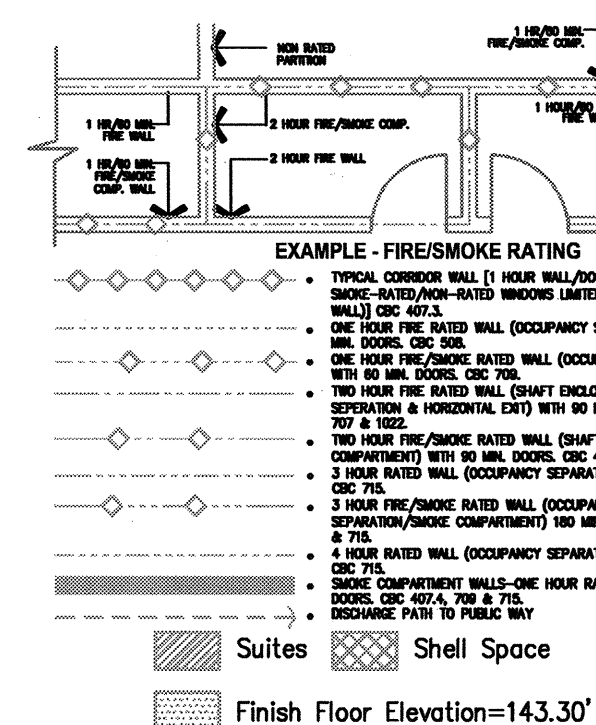

A1 Key Plan
N.T.S.

DESIGN KEY NOTES

KEY PLAN