

ARCHITECT OF RECORD  
"Architect of Record signature line only; this drawing was not prepared under the direct supervision of the Architect of Record. The direct responsibility for preparation of this sheet lies with its corresponding professional stamp and signature. The signature of the Architect of Record in general responsible change of the project is provided as required by Title 24, Part 1, Section 7-113 (a)."

ARCHITECT - PAUL C. GLORIO  
CONSULTANT  
T M A D  
TAYLOR  
& GAINES  
• STRUCTURAL  
• MECHANICAL  
• ELECTRICAL  
• CIVIL  
100 South Anaheim Boulevard, Suite 150  
Anaheim, California 92805  
Phone: 714.490.5555 Fax: 714.490.5560  
Project No. 2305-163-07

REGISTERED PROFESSIONAL ENGINEER  
PAUL C. GLORIO  
No. 22251  
Exp. 12/31/11  
MECHANICAL  
STATE OF CALIFORNIA  
Changes on these drawings do not consist of materially altered changes to approved drawings and don't require a change order.  
OSHPD review AGO  
OSHPD review FLSO  
OSHPD review DSC

REVISIONS  
05/28/2010 ASI #8  
03/01/2011 CHANGE ORDER #134

APPROVAL  
Office of Statewide Health Planning & Development  
RECEIVED JULY 12 2011  
7-5-11  
CHANGE ORDER #134  
INSTRUCTION BUILDING SYSTEM  
DEFERRED APPROVAL  
LOCKDOWN


PROJECT NAME  
CHILDREN'S HOSPITAL  
OF ORANGE COUNTY  
455 S. Main St.  
Orange, CA 92668-3874

TOWER II  
RECEIVED  
July 12 2011  
McCarthy  
CHOC  
HOSPITAL

PROJECT NUMBER  
12011.00  
Increment #7  
OSHPD - PROJECT NUMBER  
IL 072072-30

ISSUE  
OSHPD PERMIT  
DATE  
01/27/2010  
SCALE  
1/4" = 1' - 0"  
DRAWING TITLE  
LEVEL 2 MECHANICAL PLAN  
AREA - L


DRAWING NUMBER  
M3.2L

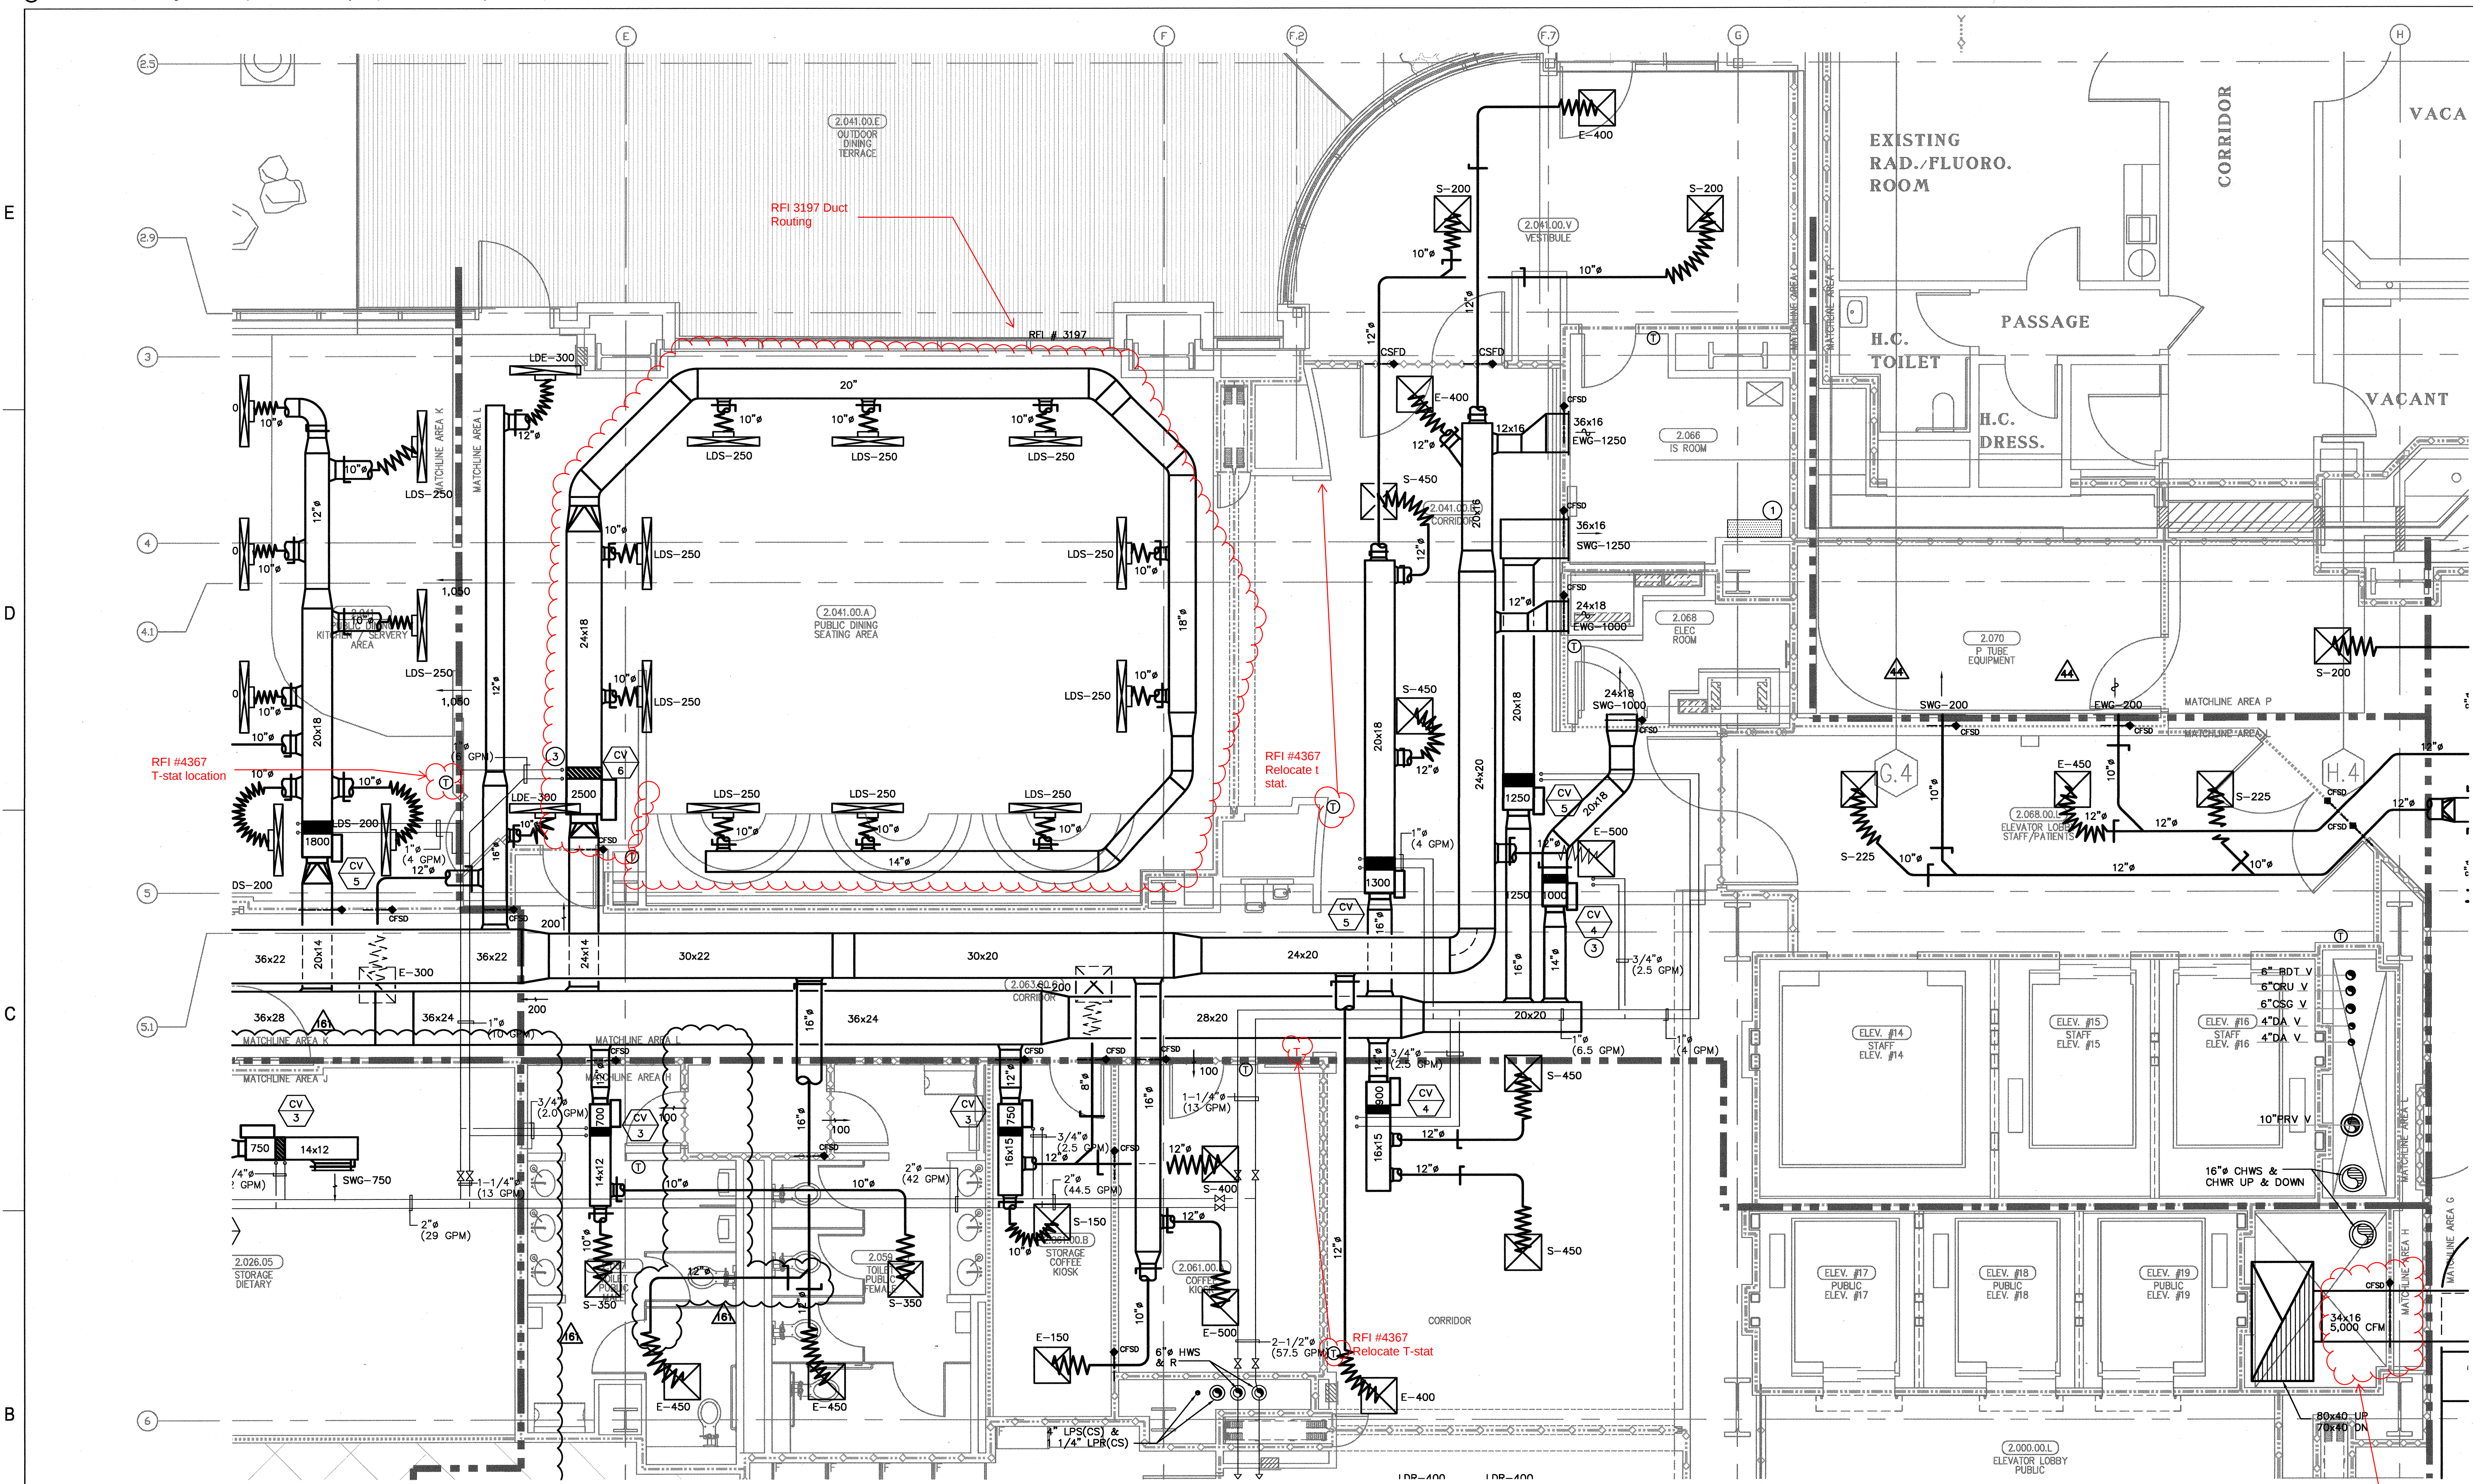

LEVEL 2 MECHANICAL PLAN AREA - L

DESIGN KEY NOTES

- 1 DDC CONTROL PANEL (PER CONTRACT & PROJECT REQUIREMENTS)
- 2 ALL WELDED SS CONSTRUCTION WITH 2 HR. FIRE RATED DUCT SHAFT.
- 3 PROVIDE 3-WAY VALVE FOR REHEAT COIL.
- 4 STERILIZER LOCATED ON THE THIRD FLOOR. STEAM LINE SUPPLY AND CONDENSATE RETURN SERVING THE STERILIZERS FROM LEVEL 2.
- 5 COOLING ONLY CV BOX

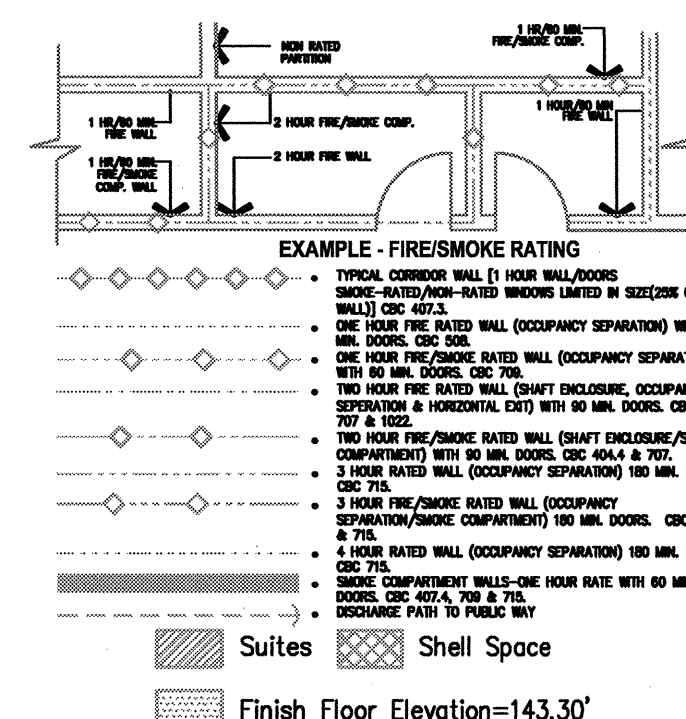

A1 Key Plan  
N.T.S.

KEY PLAN

DESIGN KEY NOTES