


ARCHITECT - PAUL C. GLORIO

CONSULTANT



T M A D
TAYLOR
& GAINES

100 South Anaheim Boulevard, Suite 150
Anaheim, California 92805
Phone: 714.490.5555 Fax: 714.490.5560
Project No. 2305-163-07

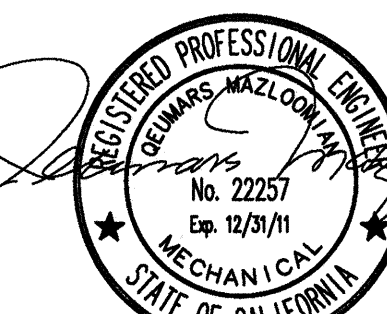

Changes on these drawings do not consist of materially altered changes to approved drawing and don't require a change order.

OSHPD review ACO _____


OSHPD review FLSO _____

OSHPD review DSE _____

REVISIONS

162 04/15/2011 CHANGE ORDER #13

APPROVAL _____

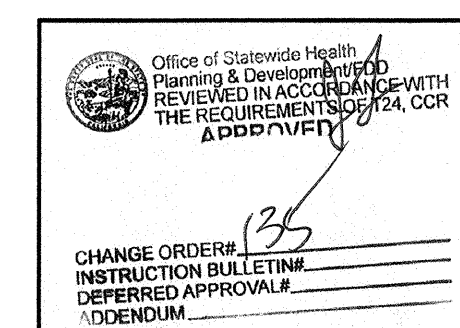

PROJECT NAME

CHILDREN'S HOSPITAL
OF ORANGE COUNTY

455 S. Main St.
Orange, CA 92868-3874

97

TOWER II

DISCUSSION



PROJECT NUMBER

12011.00
Increment #7

OSHPD - PROJECT NUMBER

U 072072-30

ISSUE
OSHPD PERMIT

DATE _____

01/27/2010

SCALE

DRAWING TITLE


LEVEL 2
MECHANICAL PLAN
AREA - P ENLARGED

DRAWING NUMBER

M3.2P.1

 EXISTING NOT IN CONTRACT
 EXISTING TO REMAIN
 NEW CONSTRUCTION

LEGEND

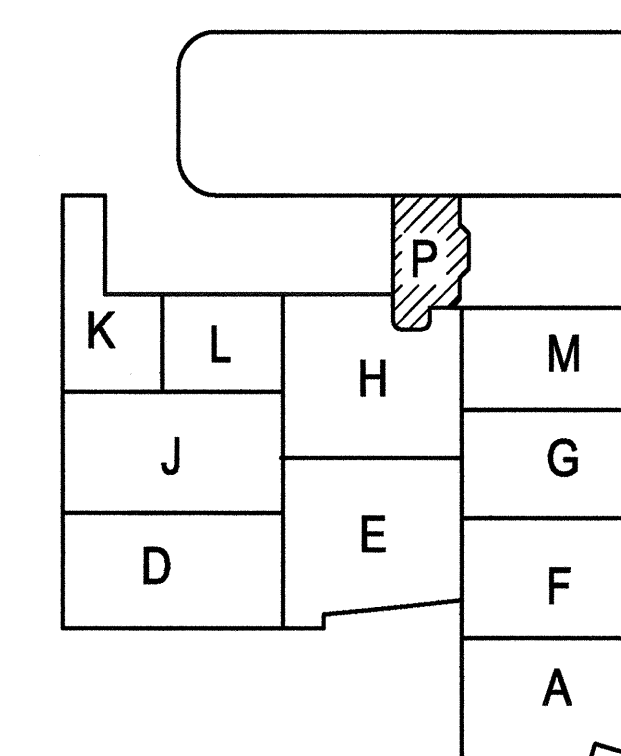

KEY PLAN

REMODEL LEVEL 2 - PHASE I

SCALE	2
1/4"=1'-0"	

REMODEL LEVEL 2 - PHASE II

SCALE	1
1/4"=1'-0"	

RFI #5552
T-stats on demo'd
walls are to be deleted