

UTILITY NOTES Phased Site Utilization Plan


- INSTALL FLO-GARD® PLUS CATCH BASIN FILTER INSERT FPG-24F PER DETAIL
- INSTALL NEW STORM DRAIN MANHOLE OVER EXISTING 10" STORM DRAIN LINE
- INSTALL THRUST BLOCK PER DETAIL
- CONNECT TO EXISTING 4" RECYCLED WATER SERVICE. (1000' ± FROM THIS POINT TO THE SERVICE)
- INSTALL DOUBLE WYE SEWER CLEANOUT PER DETAIL
- INSTALL FLO-GARD® DUAL-VORTEX HYDRODYNAMIC SEPARATOR PER DETAIL
- FOLLOW SEPARATION REQUIREMENTS FOR RECYCLED WATERLINES AS OUTLINED IN SDRW STANDARD NOTES.

GENERAL UTILITY NOTES

- BRING FIRE WATER TO OUTER FACE OF BUILDING AND UP TO FIRST FLANGE APPROXIMATELY 1' ABOVE FINISHED FLOOR.
- ALL OTHER UTILITIES TO BE BROUGHT WITHIN 5' OF BUILDING
- ALL UTILITY CROSSINGS MUST BE 1" CLEAR

** Hazardous Waste Site (Turnover) - Phase B

J. Lewis
1-28-08

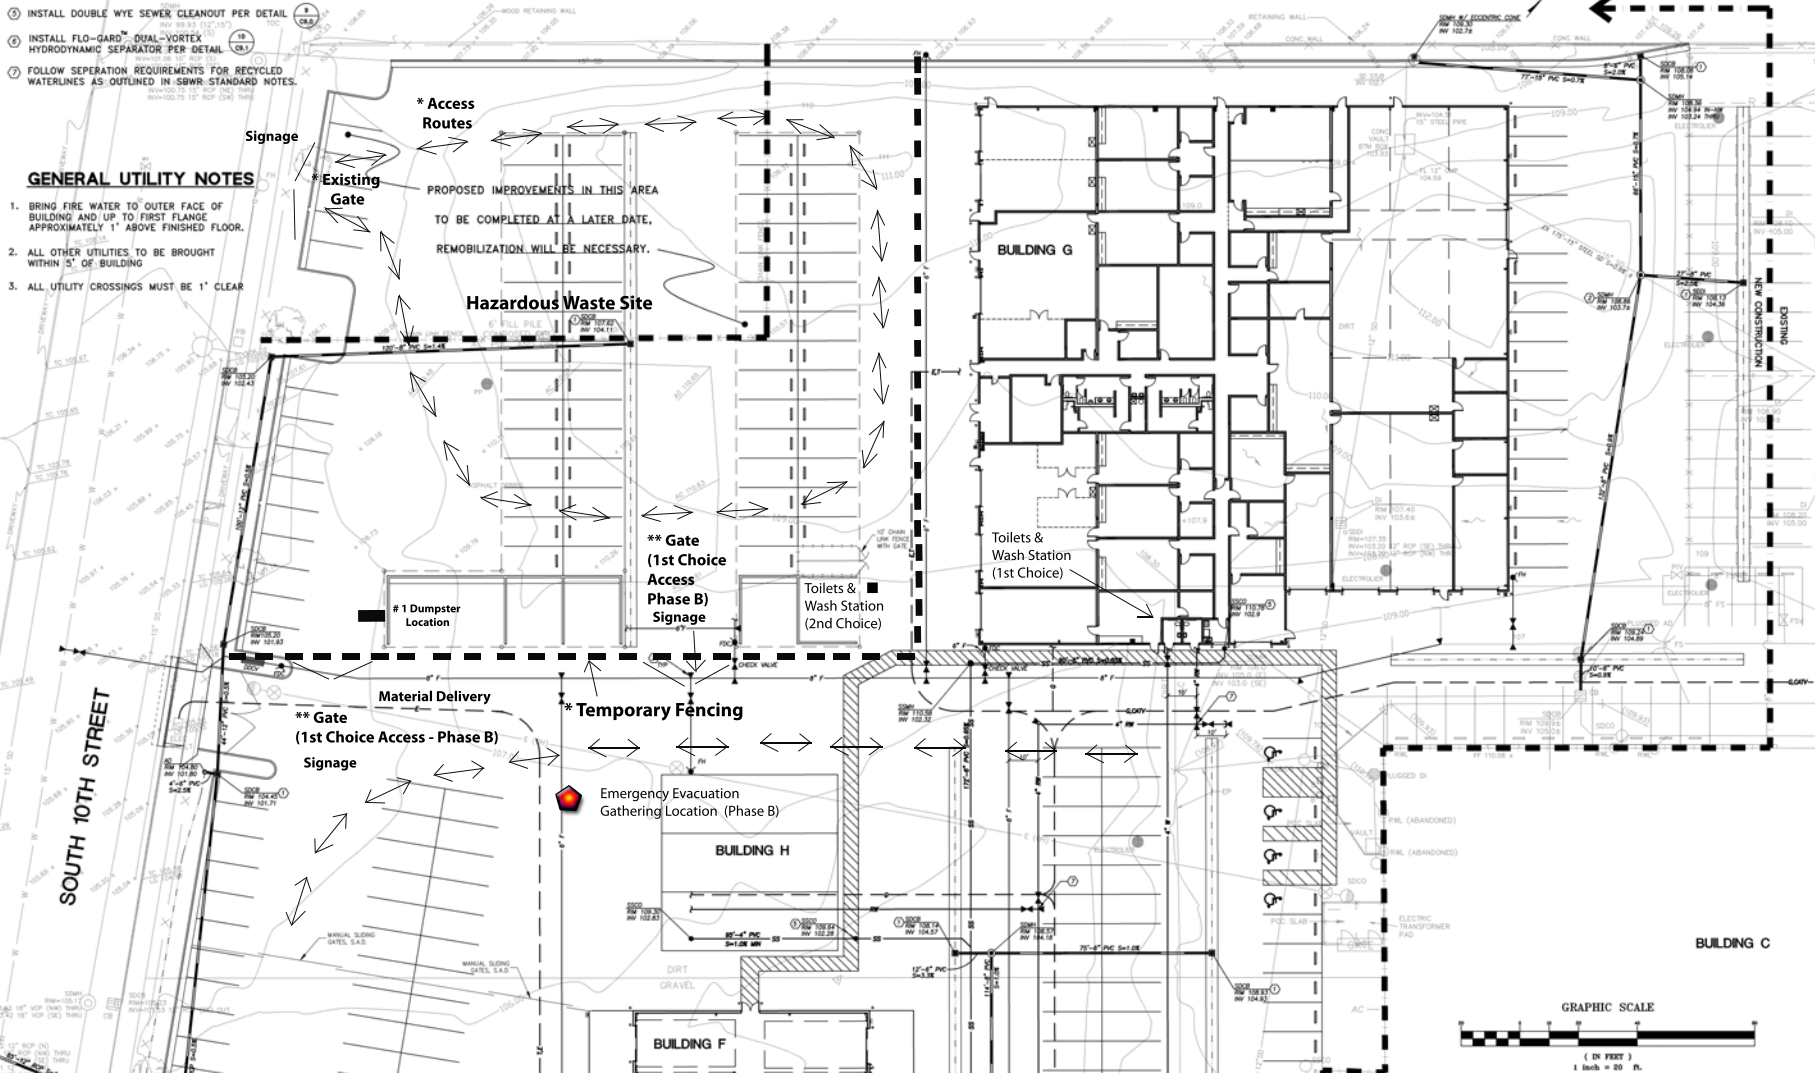

FOR CONTINUATION, SEE SHEET C5.1

FOR CONTINUATION, SEE SHEET C5.3

COPYRIGHT © FENTRESS BRADBURN ARCHITECTS, LTD. ISSUED FOR: DATE: PERMIT SET 24 APR 08	
CONSULTANT: BKf FENTRESS BRADBURN ARCHITECTS, LTD. 1000 10TH STREET, SUITE 100 SAN JOSE, CA 95128 PHONE: (408) 281-1100 FAX: (408) 281-1101	
CENTRAL SERVICE YARD PHASE II PROJECT PROJECT ADDRESS: 1000 10TH STREET, SUITE 100 SAN JOSE, CA 95128 PROJECT NO. 04 DATE: 1-28-08	
SAN JOSE DEPARTMENT OF PUBLIC WORKS CITY FACILITIES ARCHITECTURAL SERVICES DIV. 1000 10TH STREET, SUITE 100 SAN JOSE, CA 95128 PHONE: (408) 281-1100 FAX: (408) 281-1101	
Fentress Bradburn ARCHITECTS, LTD. Architecture • Interiors • Planning 400 Broadway, Suite 200 San Francisco, CA 94111 Phone: (415) 774-2000 Fax: (415) 774-2001	
DRAWING TITLE: UTILITY PLAN DRAWN BY: J. MARELLO PROJECT # 200525.000 SHEET NUMBER C5.2	