




CONSULTANT

Lankford/Phelps Consortium LLC
1915555555
1915555555

FENTRESS ARCHITECTS
401 Broadway, Denver, CO 80202
303.733.0000
303.733.0000

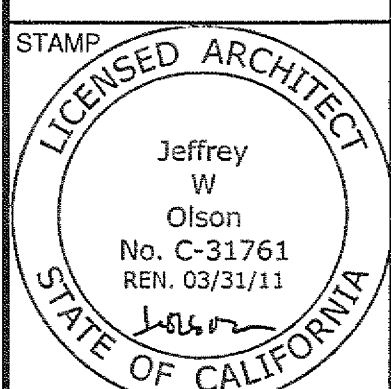


SHEET NAME
WALL SECTIONS

DRAWN BY: Author


PROJECT #: 200725.000

SHEET NUMBER


A6207

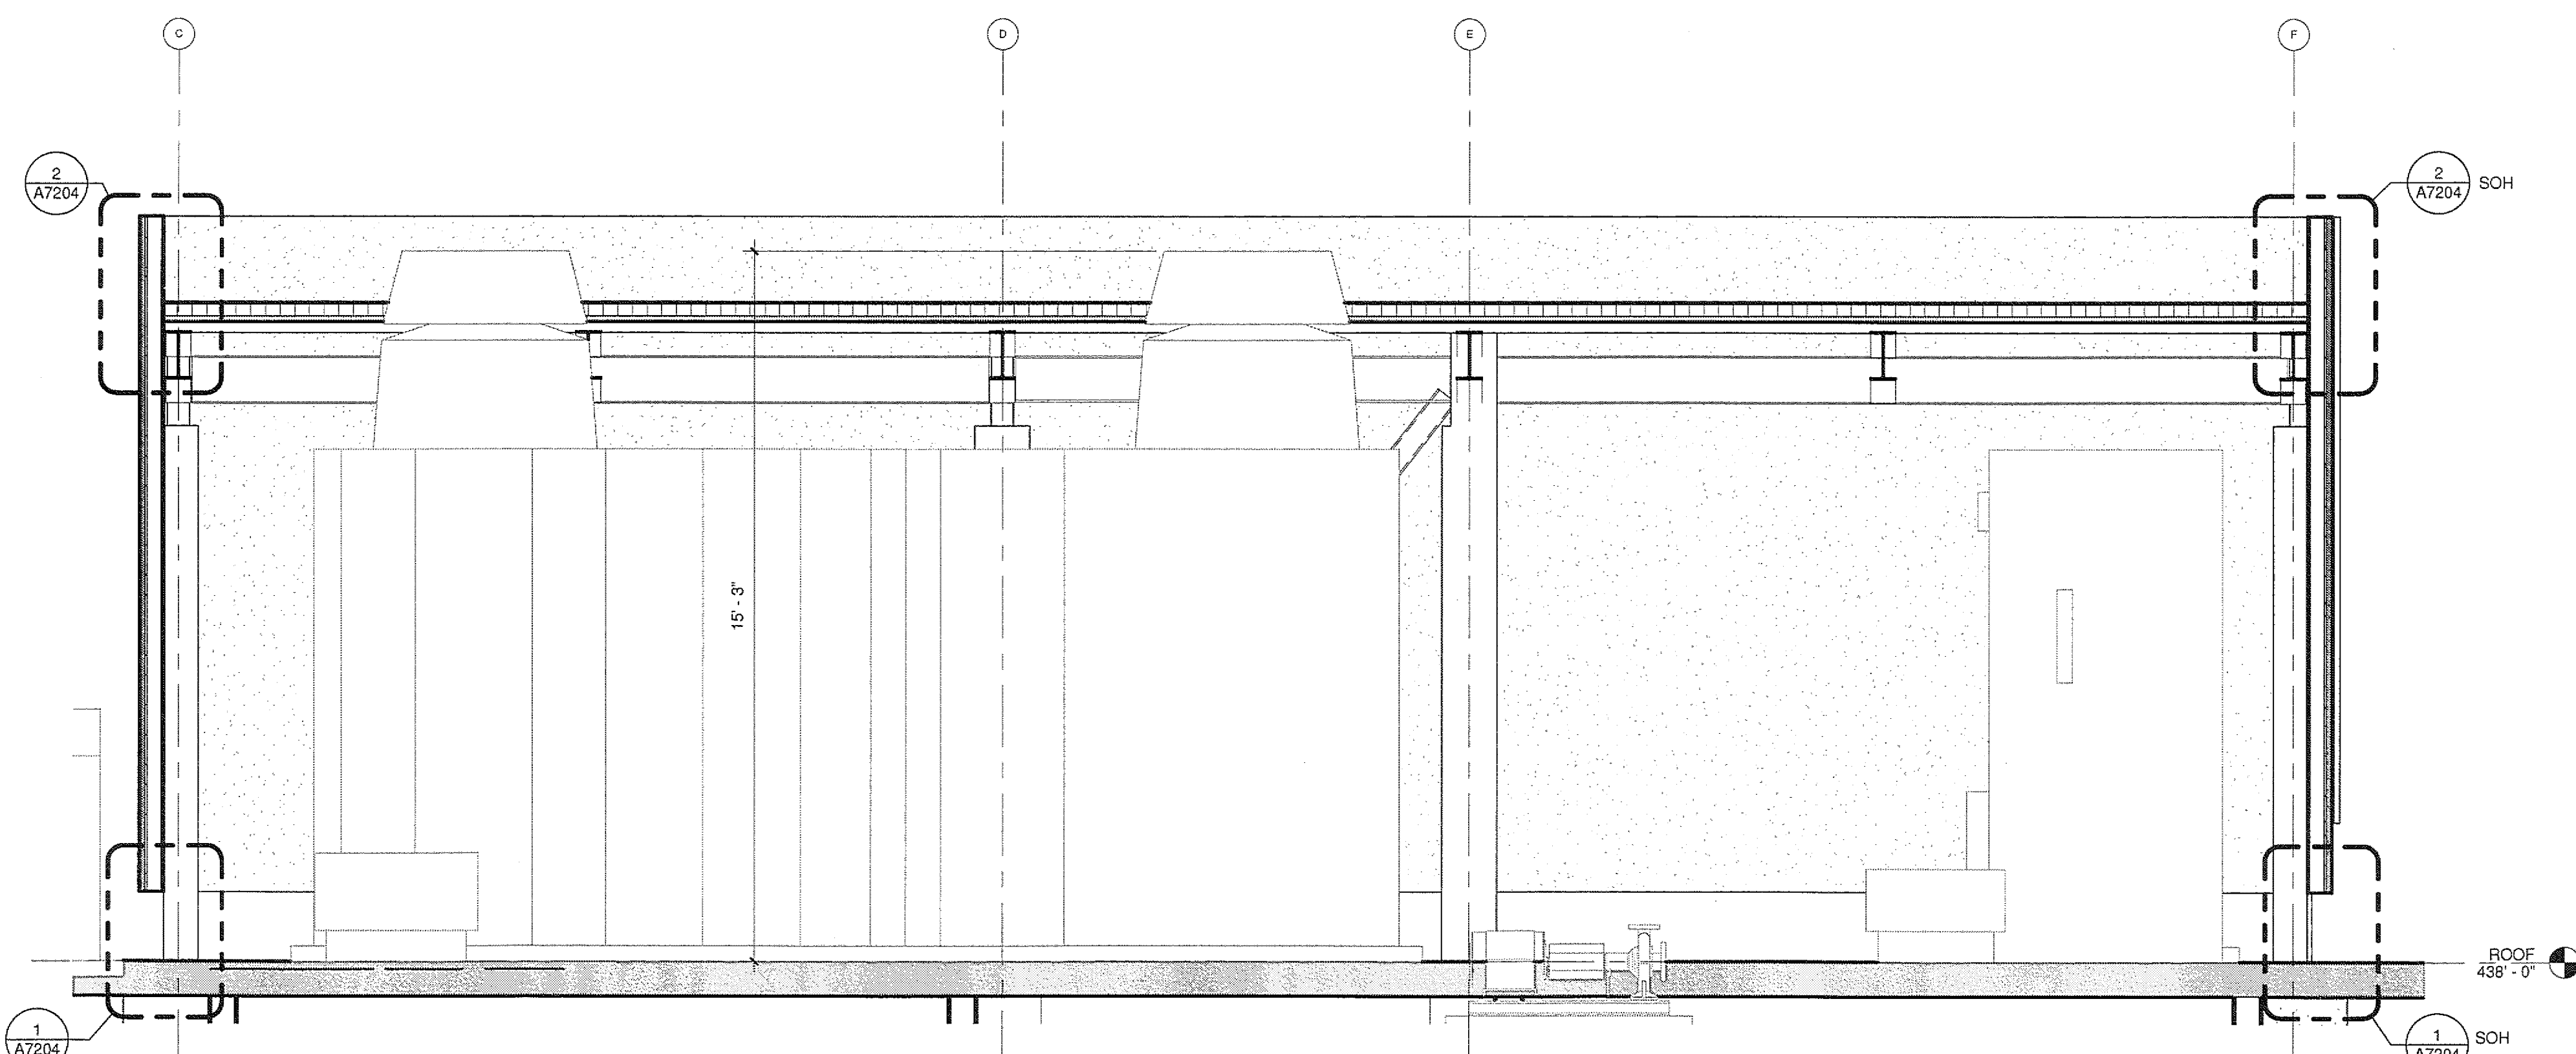


11 MECH PENTHOUSE SECTION
A2251 A6207 3/8" = 1'-0"

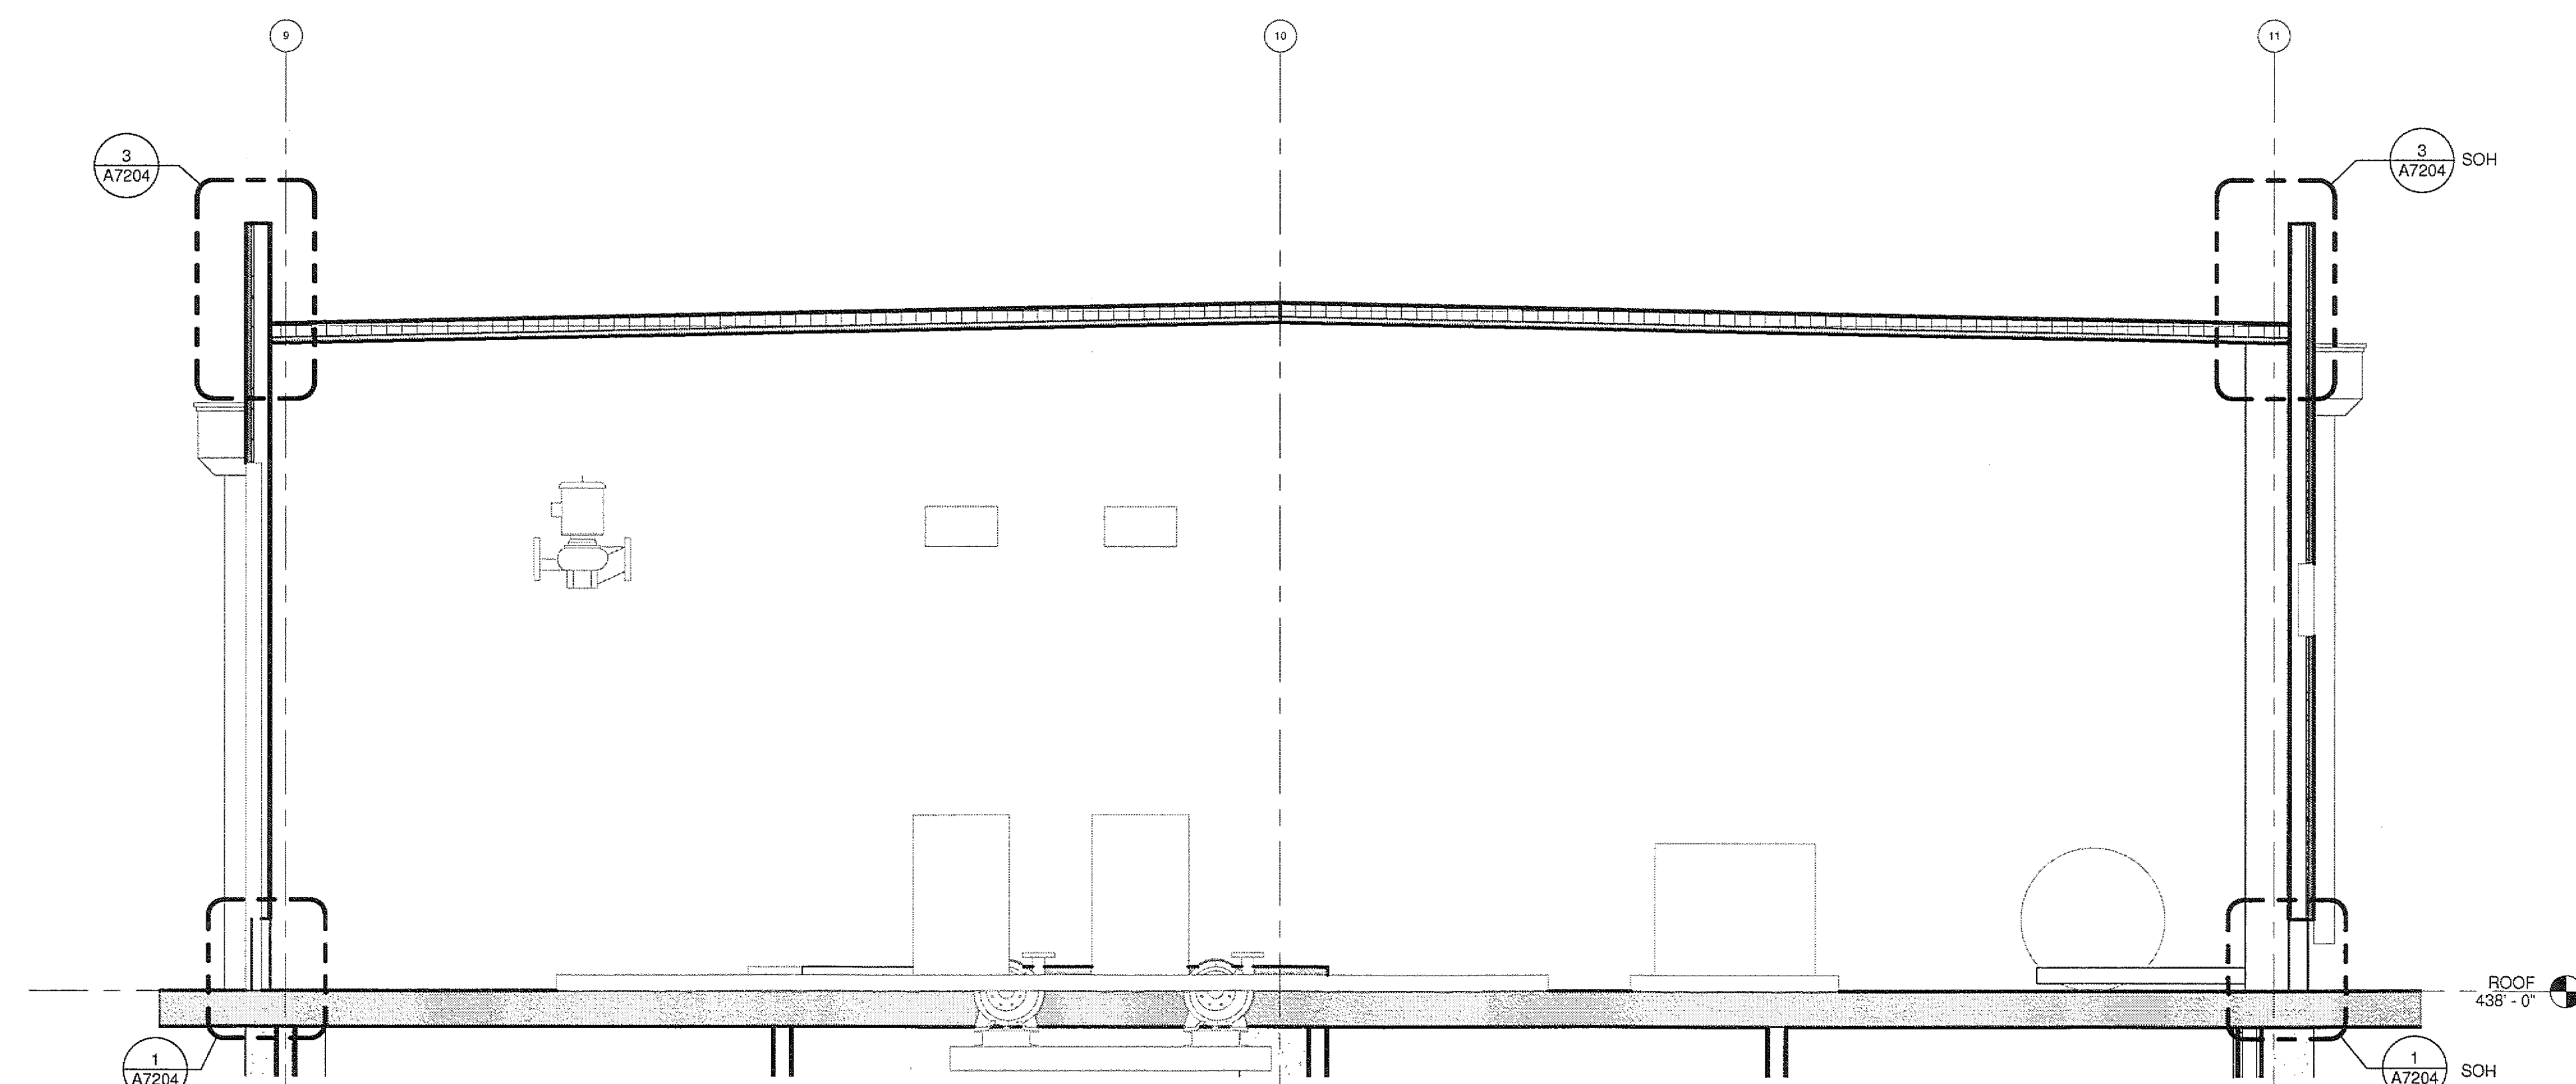


3 MECH PENTHOUSE SECTION
A2251 A6207 3/8" = 1'-0"

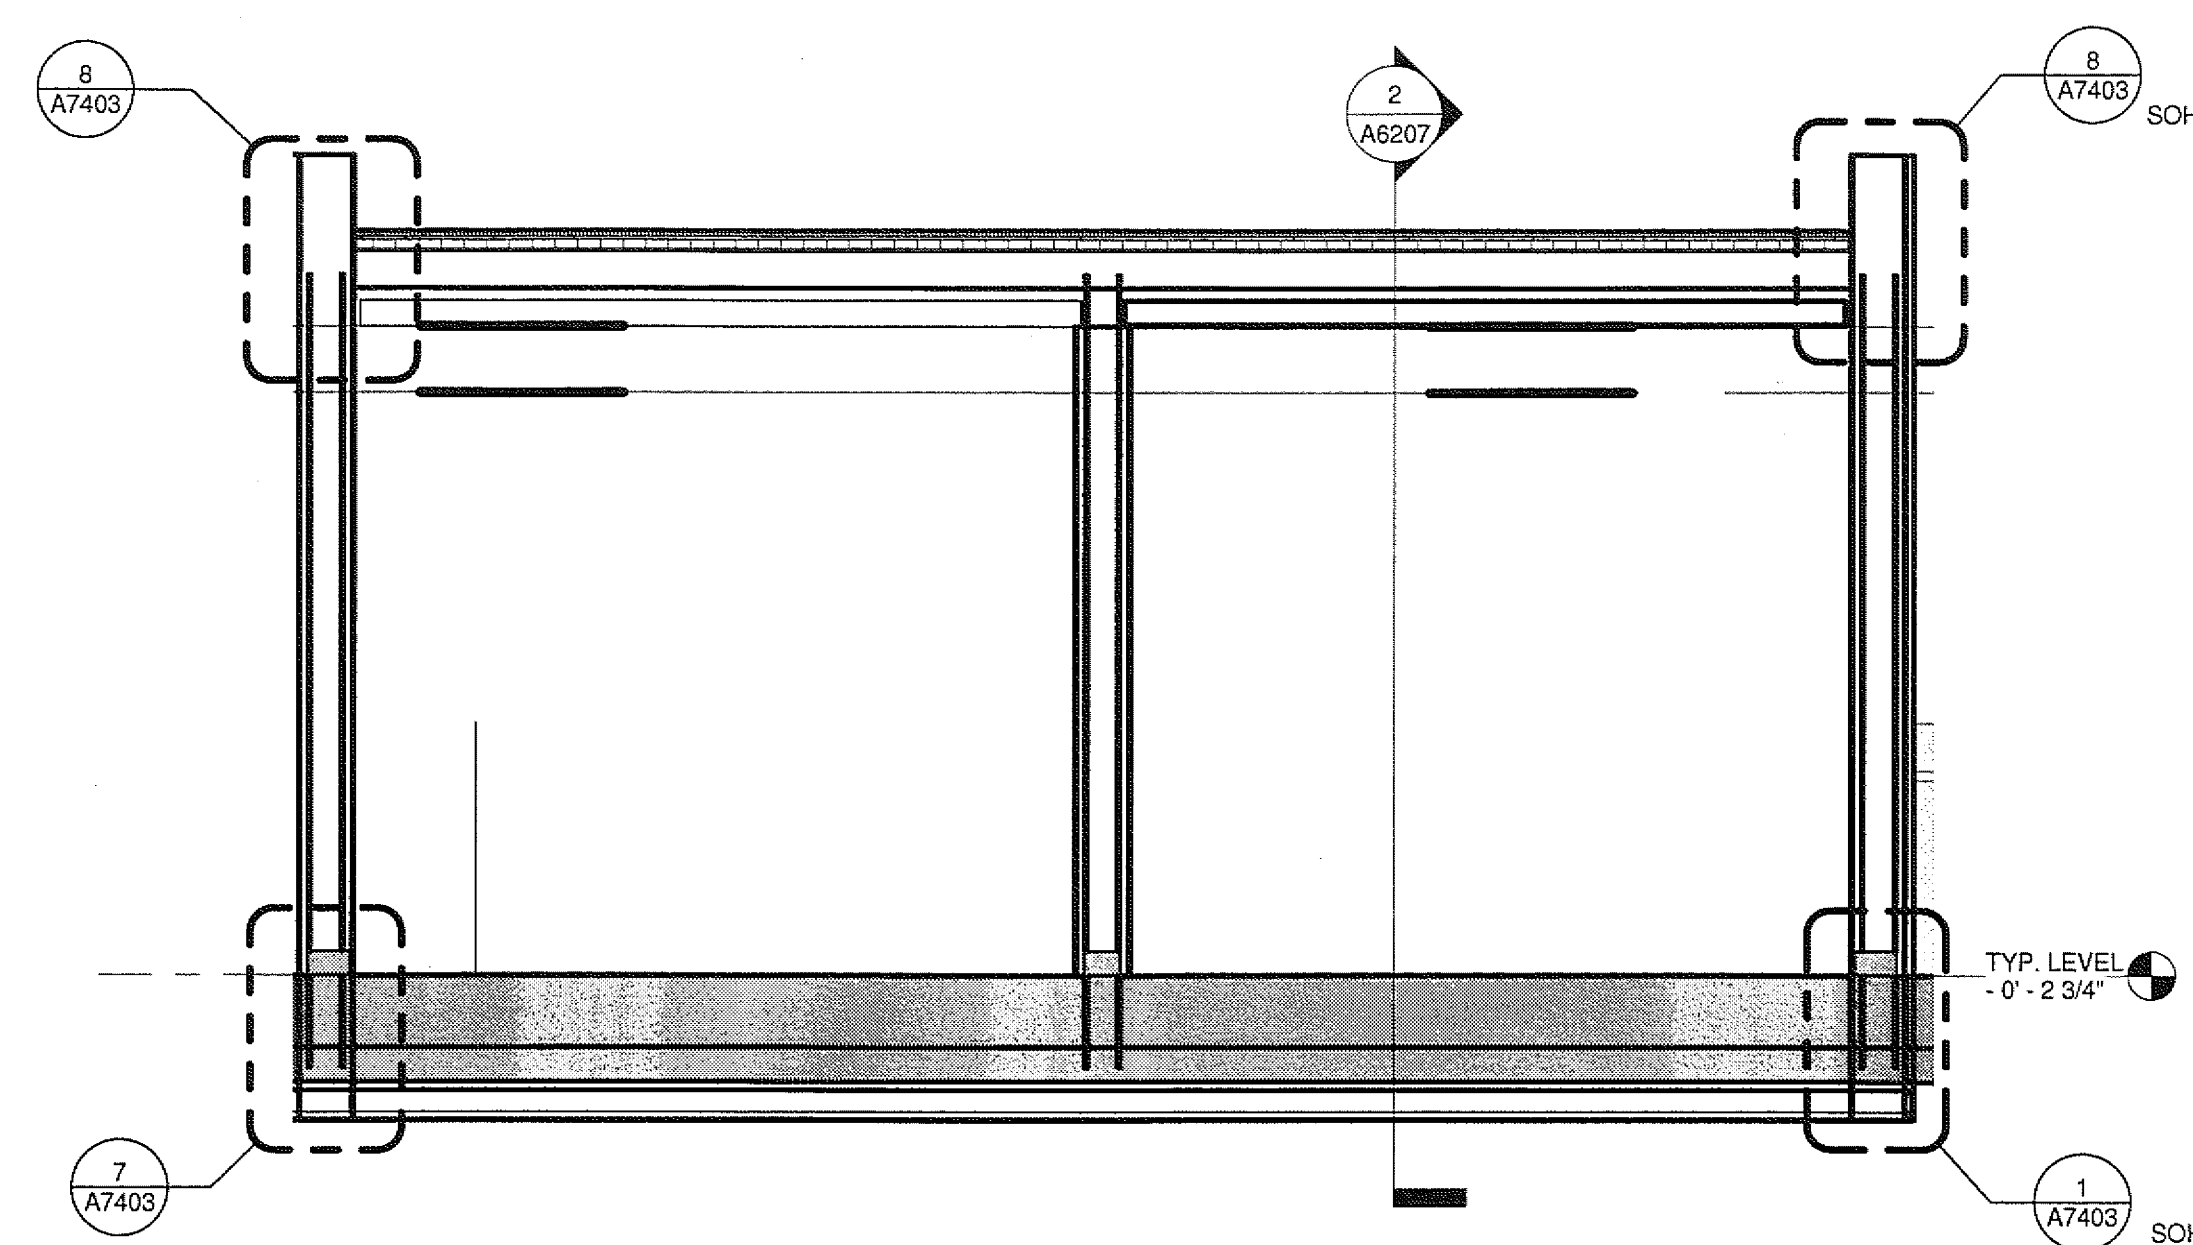


10 JUNIOR POD SECTION
A2601 A6207 3/8" = 1'-0"

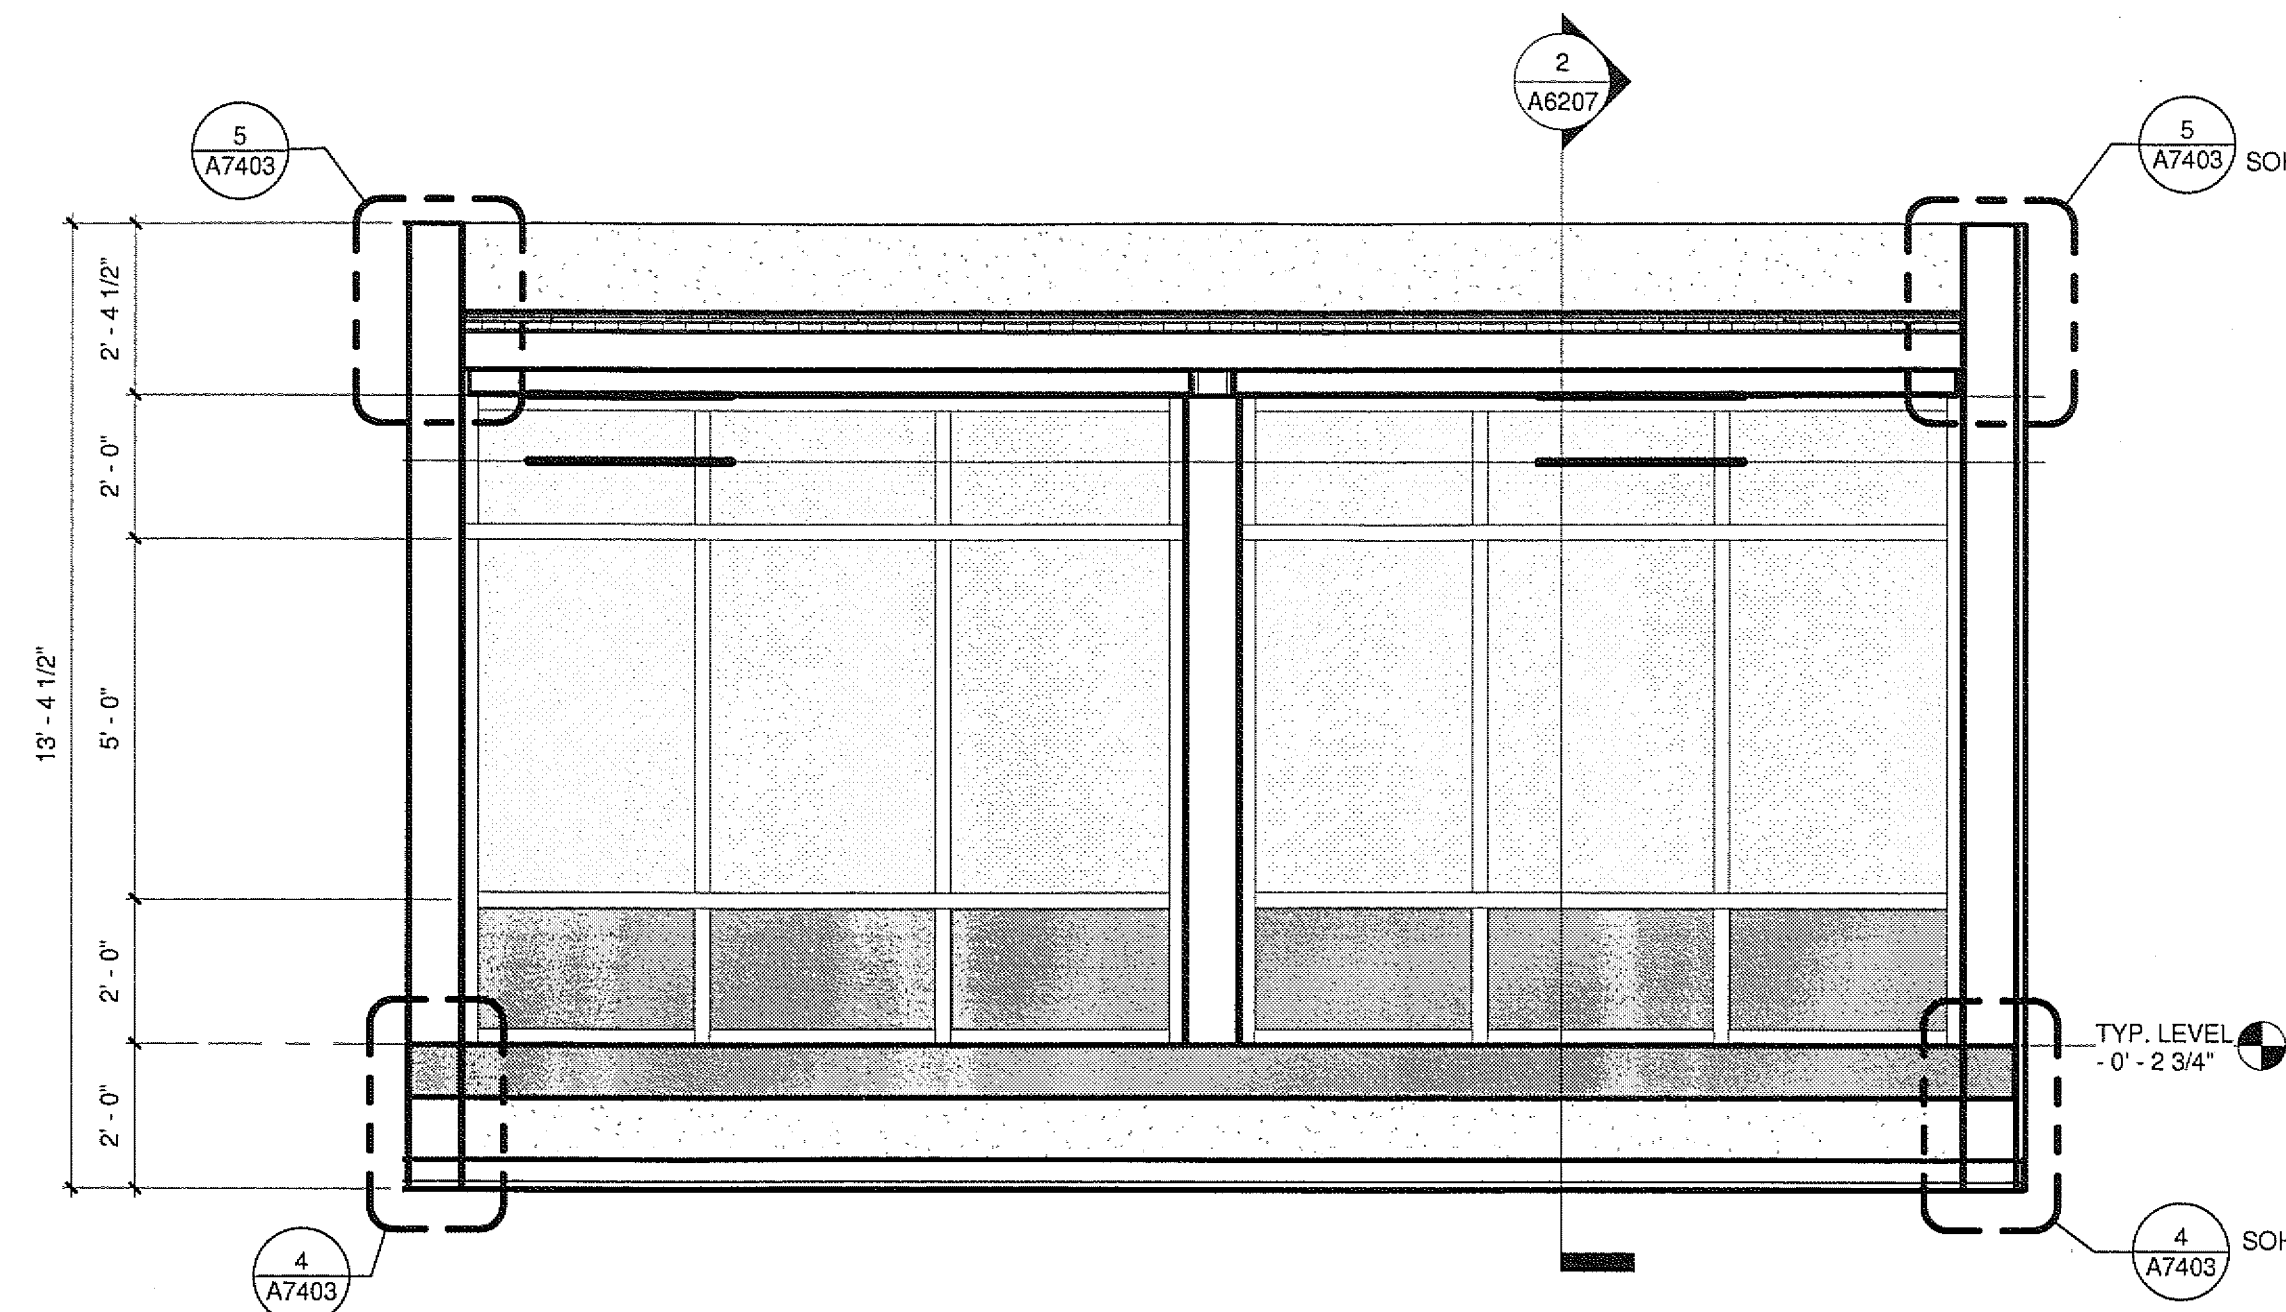


6 JUNIOR POD SECTION
A2601 A6207 3/8" = 1'-0"

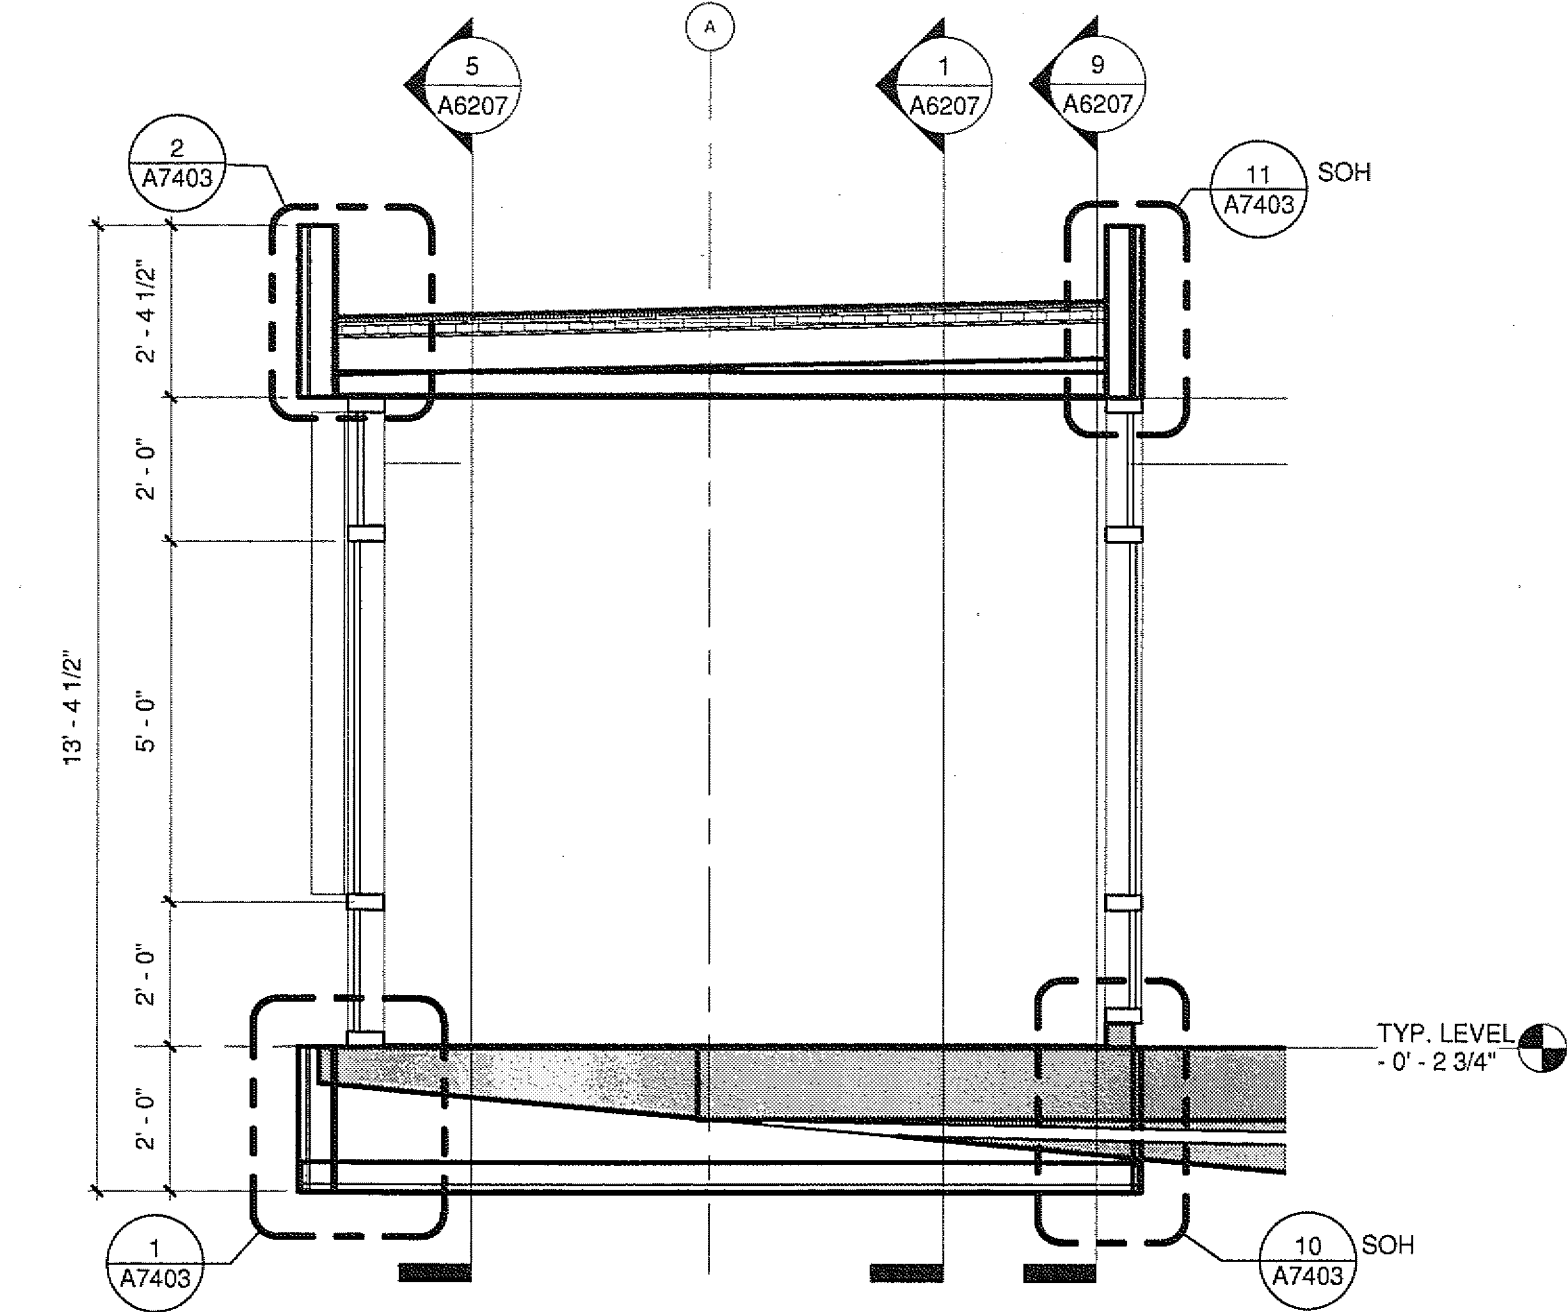


2 TYPICAL POD SECTION
A2601 A6207 3/8" = 1'-0"

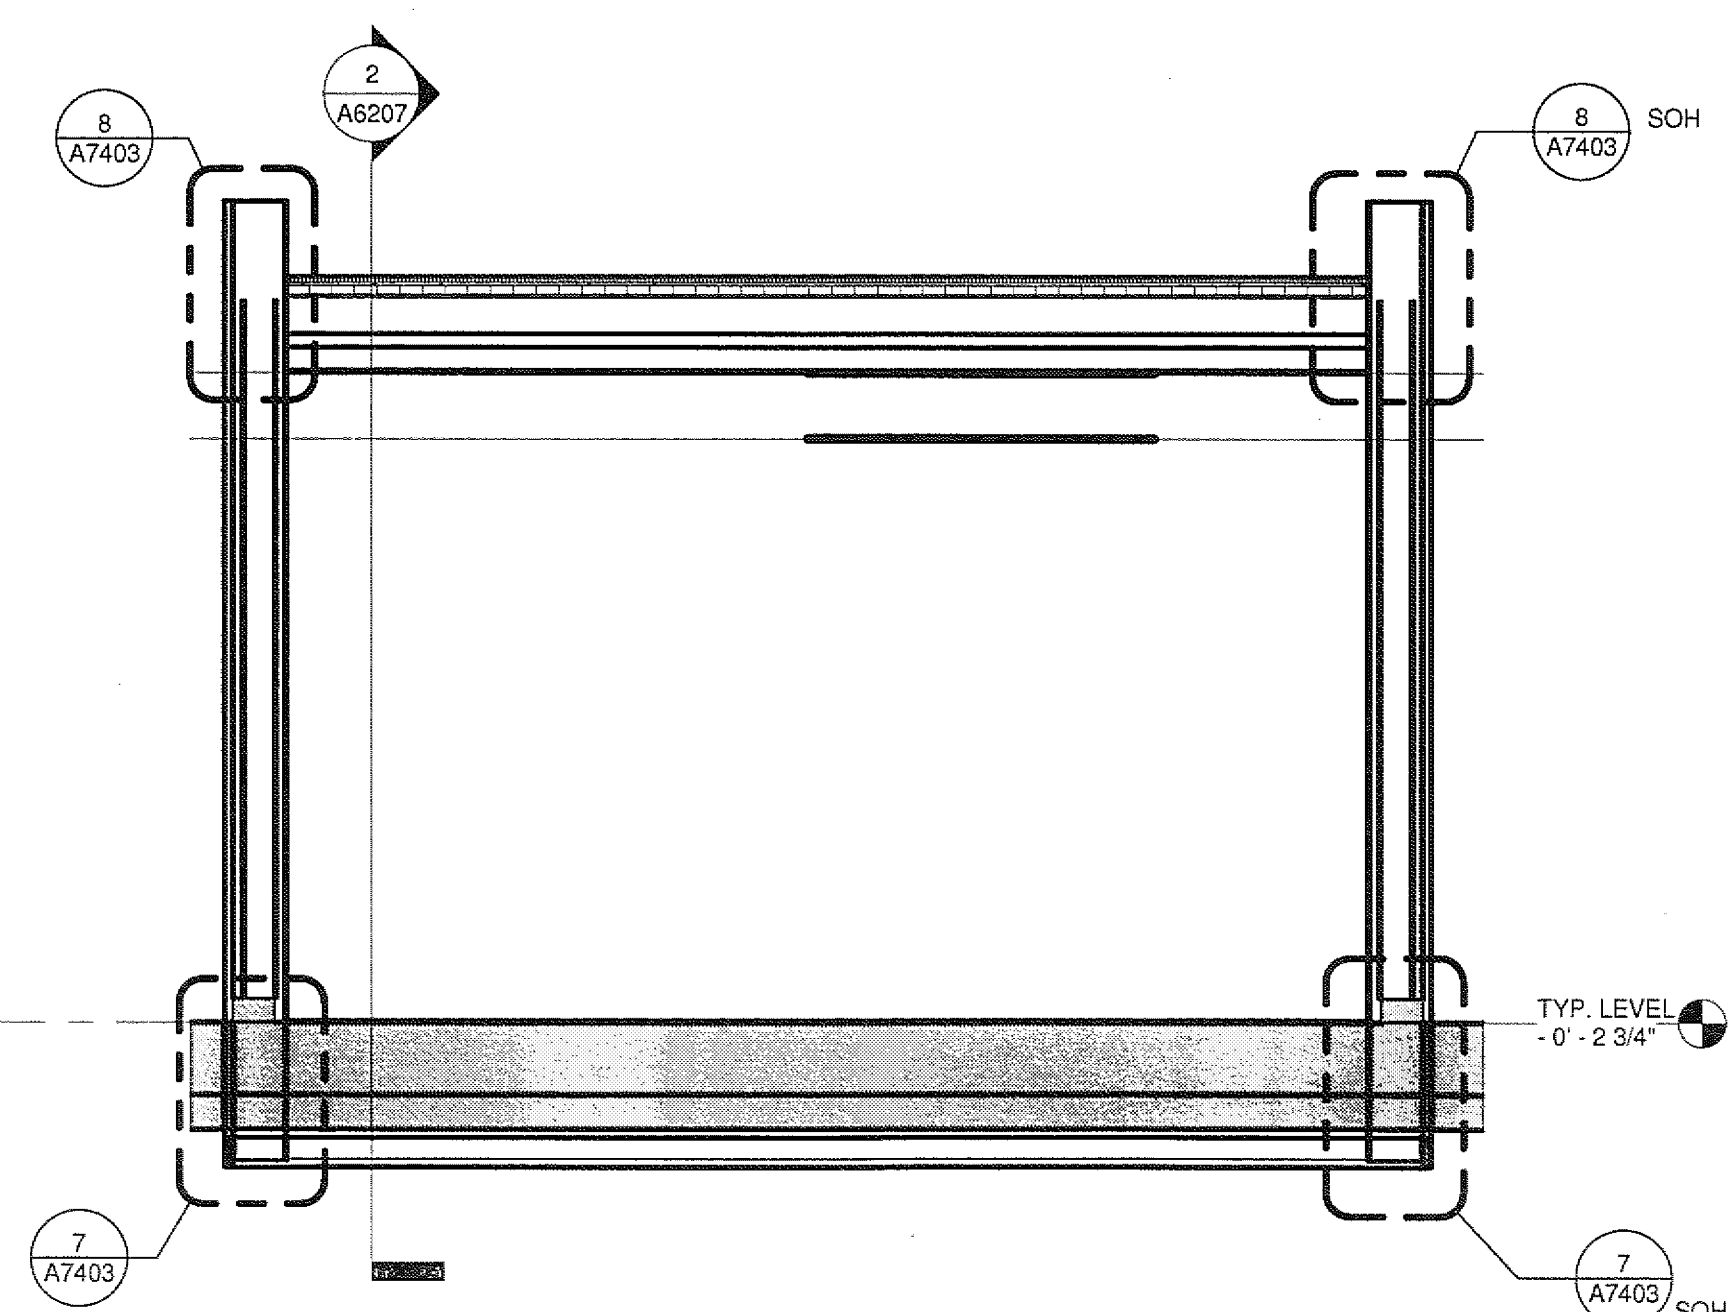

9 SENIOR POD SECTION
A2601 A6207 3/8" = 1'-0"

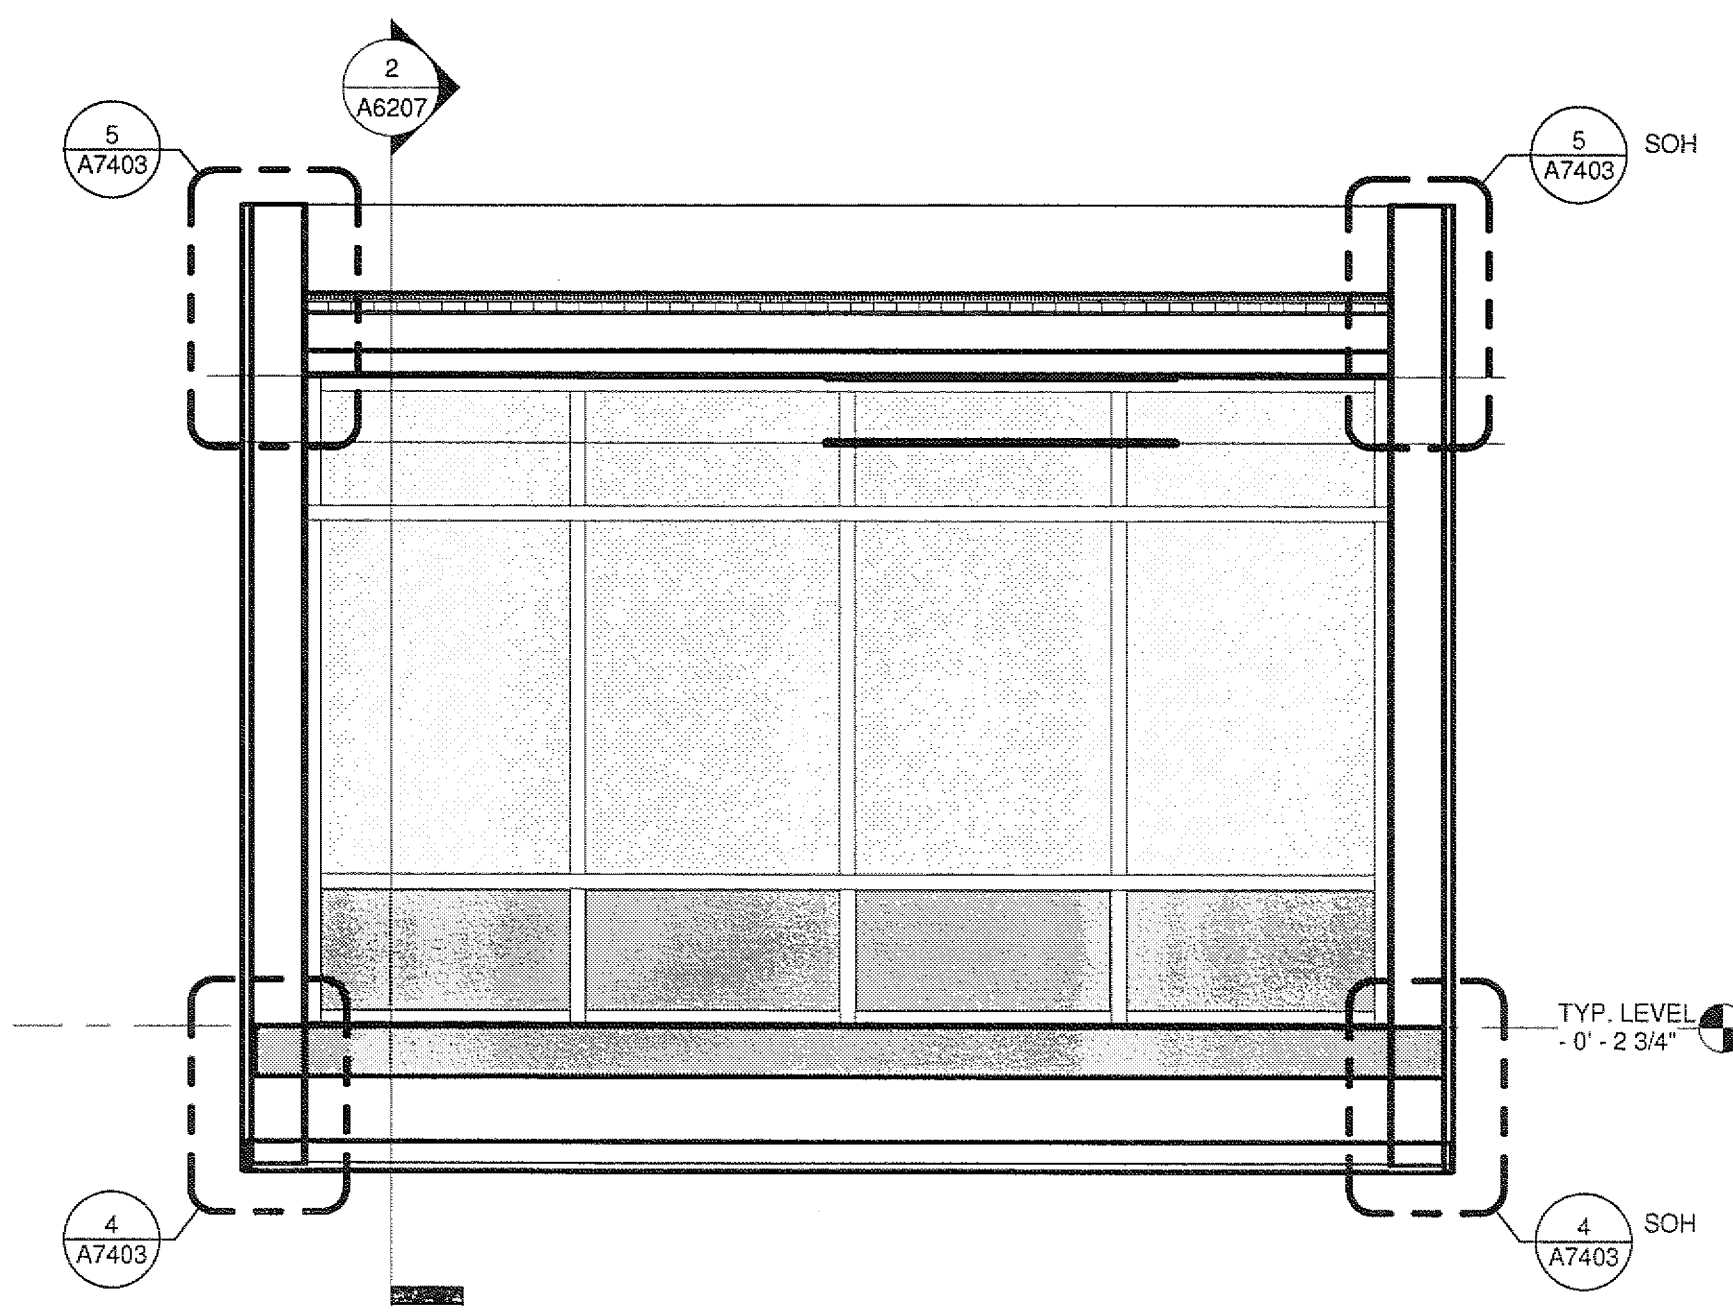

5 SENIOR POD SECTION
A2601 A6207 3/8" = 1'-0"

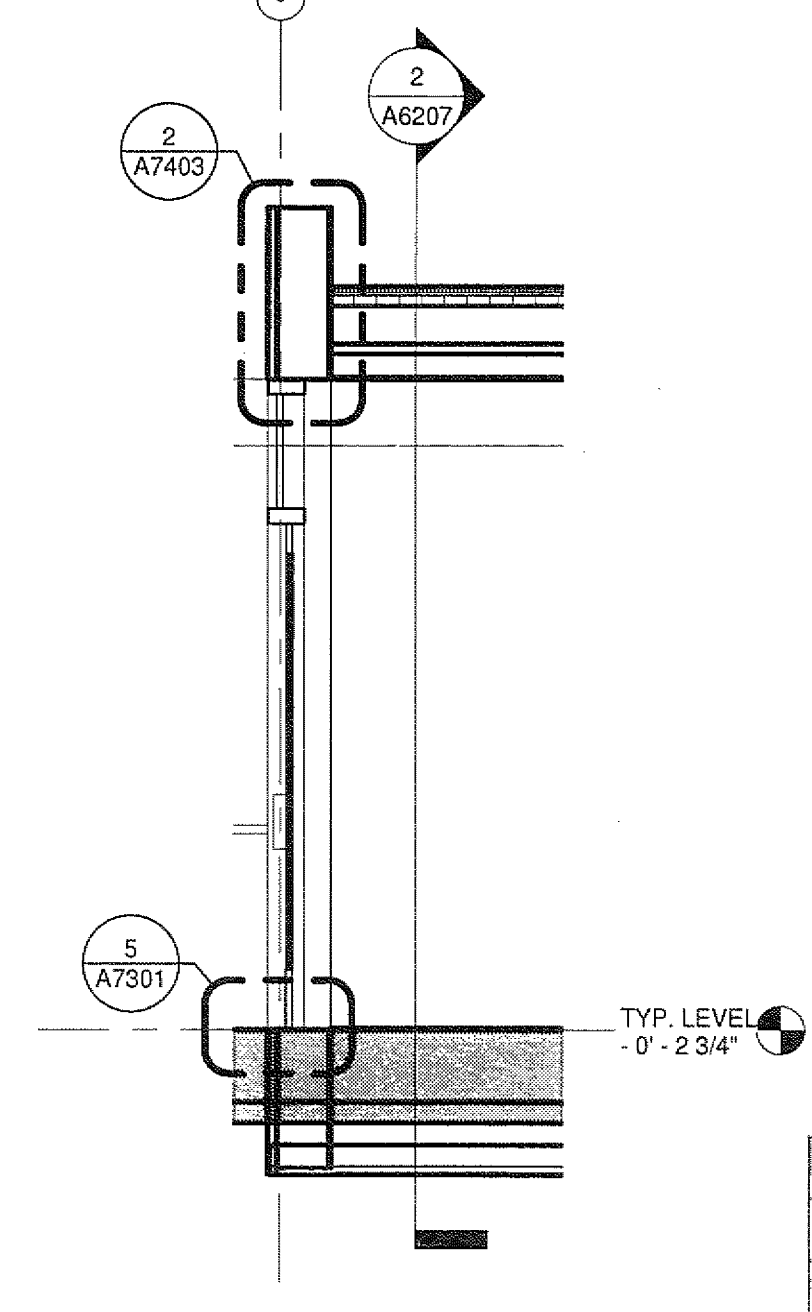

1 POD SECTION THROUGH DOOR
A2601 A6207 3/8" = 1'-0"

U.C.S.D.
PRELIMINARY DRAWINGS
PROGRESS DRAWINGS
REVIEW DRAWINGS
CONSTRUCTION DRAWINGS