

12/20/2008 4:52:10 PM
F:\11111111\11111111.dwg

Warning: It is a violation of the law for any person, unless acting under the direction of a licensed architect, to alter an item in any way. If an item in this document is altered, the altering architect, if other than the architect of record, shall affix to the item his seal and the notation "altered by" followed by his signature and the date of such alteration, and the specific description of the alteration.

SIGNAL SITE PLAN - SOUTH


SCALE
1" = 20'-0"

1

E1103

SHEET NAME
SIGNAL SITE PLAN - SOUTH

DRAWN BY: Author
PROJECT #: 200725.000
SHEET NUMBER

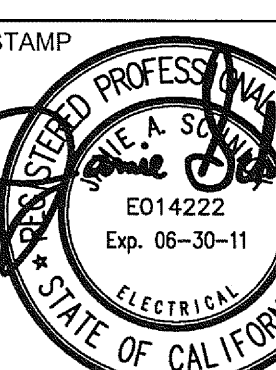

FENTRESS ARCHITECTS
4000 Wilshire Avenue, Suite 1000
San Francisco, CA 94115
(415) 774-1111
www.fentress.com

DAVIS HILL
2001 First Avenue, Suite 1000
San Francisco, CA 94107
(415) 398-1111
www.davis-hill.com

Lankford/Phelps Consortium LLC
1000 Wilshire Avenue, Suite 1000
San Francisco, CA 94115
(415) 774-1111
www.lankfordphelps.com


CONSULTANT
Xanthus
1000 Wilshire Avenue, Suite 1000
San Francisco, CA 94115
(415) 774-1111
www.xanthus.com




SANFORD CONSORTIUM FOR REGENERATIVE MEDICINE
2880 TORREY PINES SCENIC DRIVE
LA JOLLA, CALIFORNIA 92037

ISSUED FOR	DATE
Pre-Schematic Design	07/14/2008
Schematic Design	07/28/2008
BID PK #1	10/06/2008
80% Progress	10/24/2008
BID PK #1 80 CD	12/01/2008
BID PK #1 100 CD	02/15/2009
BID PK #2 100 CD	03/25/2009
100% CD	05/08/2009
CD #1	01/07/2010
CD #2	02/28/2010
CD #3	02/28/2010
CD #4	04/15/2010

COE	U.C.S.D.
4/21/10	DATE
	PRELIMINARY DRAWINGS
	PROGRESS DRAWINGS
	REVIEW DRAWINGS
	CONSTRUCTION DRAWINGS

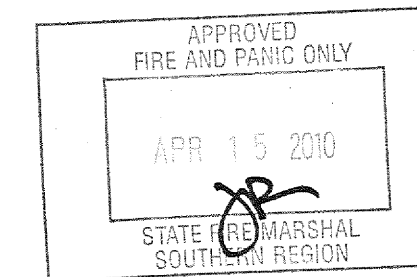

- KEY NOTES:
- POINT OF CONNECTION TO AT&T. PROPOSED AT&T CABINET. VERIFY EXACT LOCATION WITH SERVICE PROVIDER PLANNER AND IN FIELD. CONTACT JAMES MENG WITH AT&T TEL:650-288-6716. STUB AND CAP (2) 4" C.
 - CH-1. POINT OF CONNECTION TO TIME WARNER COMMUNICATIONS. VERIFY EXACT LOCATION WITH SERVICE PROVIDER PLANNER AND IN FIELD. PROVIDE 24"W x 36"L x 24"D PULLBOX WITH COVER. SEE SHEET E4001, DETAIL 7.
 - CH-2. PROVIDE 3/4" TELECOMMUNICATIONS PULLBOX. SEE SHEET E4001, DETAIL 5.
 - CH-3. PROVIDE 3/4" TELECOMMUNICATIONS PULLBOX. SEE SHEET E4001, DETAIL 2.
 - TELECOM/SIGNAL CONDUIT TO THE INTERSTITIAL LEVEL CEILING. SEE SHEETS E42B11 & E42B12 FOR CONTINUATION.

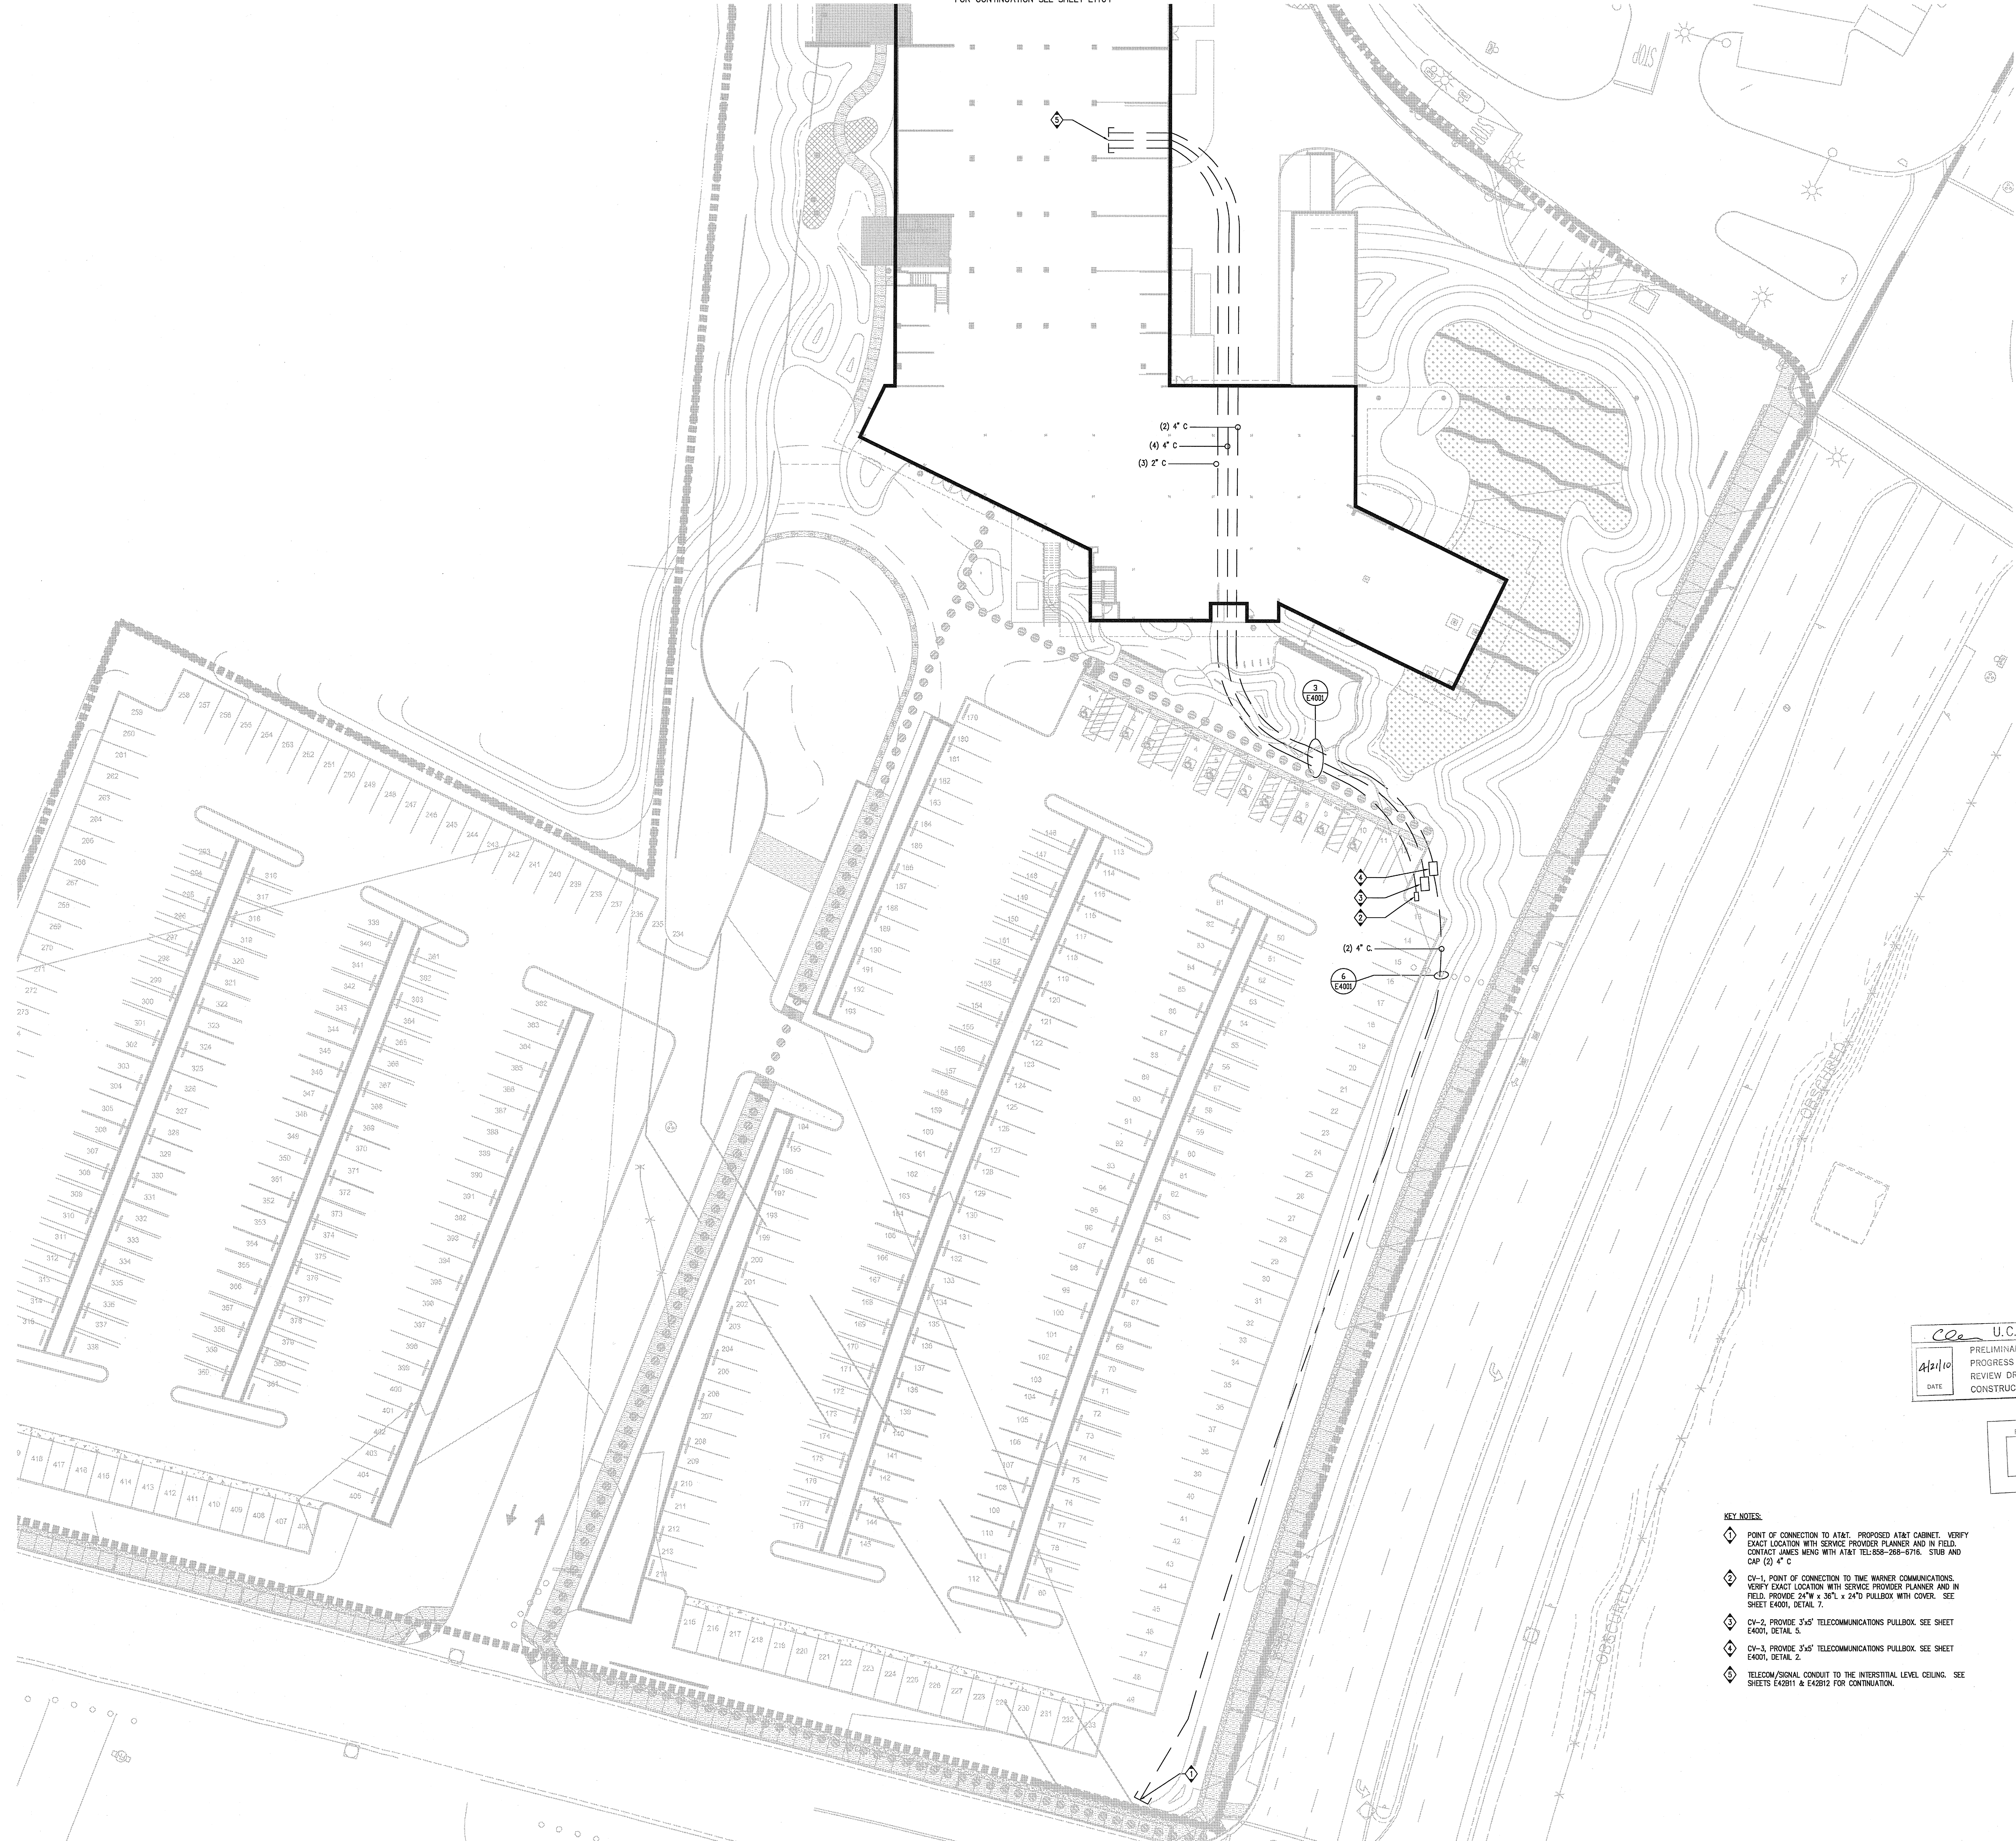

FOR CONTINUATION SEE SHEET E1104