

COPYRIGHT © FENTRESS ARCHITECTS	
ISSUED FOR DATE	
Pre-Schematic Design	07/14/2009
Schematic Design	07/28/2008
BID PK #1	10/08/2008
50% Progress	10/24/2008
BID PK #1 80 CD	12/01/2008
BID PK #1 100 CD	02/16/2009
BID PK #2 100 CD	03/26/2009
100% CD	05/08/2009
CD 4	01/07/2010
COB 1	02/26/2010
COB 2	02/26/2010
CD 4	04/15/2010
RVP PERMIT	05/05/2010
ASIM008 RL	07/01/2010
ASIM009	07/06/2010
ASIM015	07/09/2010
ASIM004	07/12/2010
ASIM009S	07/13/2010
ASIM010	08/13/2010

GENERAL NOTES:





1. REFER TO ARCHITECTURAL PLANS AND ELEVATIONS FOR COORDINATION OF EXACT LOCATION AND MOUNTING HEIGHTS OF LUMINAIRES AND ELECTRICAL DEVICES.

KEY NOTES:

- ⬇ FIXTURES ARE PHOTOCELL CONTROLLED. ROUTE CIRCUIT THROUGH PHOTOCELL CONTROLLER LOCATED IN THE MAIN ELECTRICAL ROOM.
- ⬇ NOT USED.

SANFORD CONSORTIUM FOR REGENERATIVE MEDICINE

2880 TORREY PINES SCENIC DRIVE
LA JOLLA, CALIFORNIA 92037

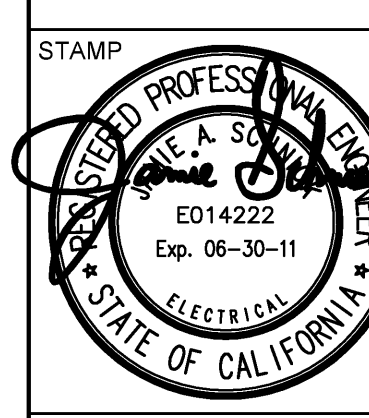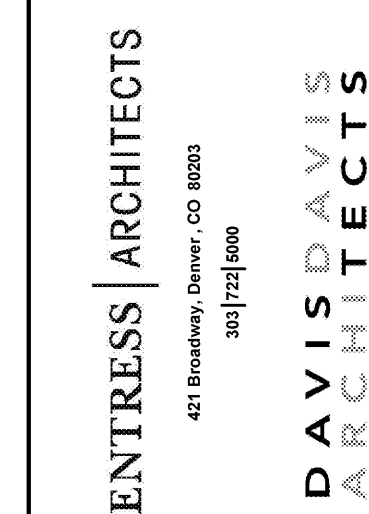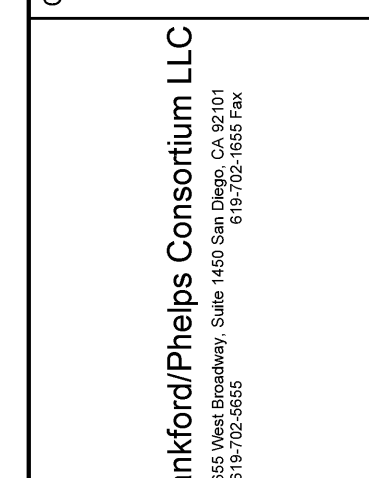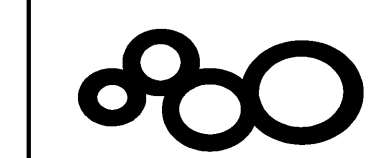


SHEET NAME
PARTIAL LIGHTING FIRST
FLOOR PLAN - ZONE 2

DRAWN BY: Author
PROJECT # 200725.000
SHEET NUMBER

E2212

SCALE
1/4" = 1'-0"

1

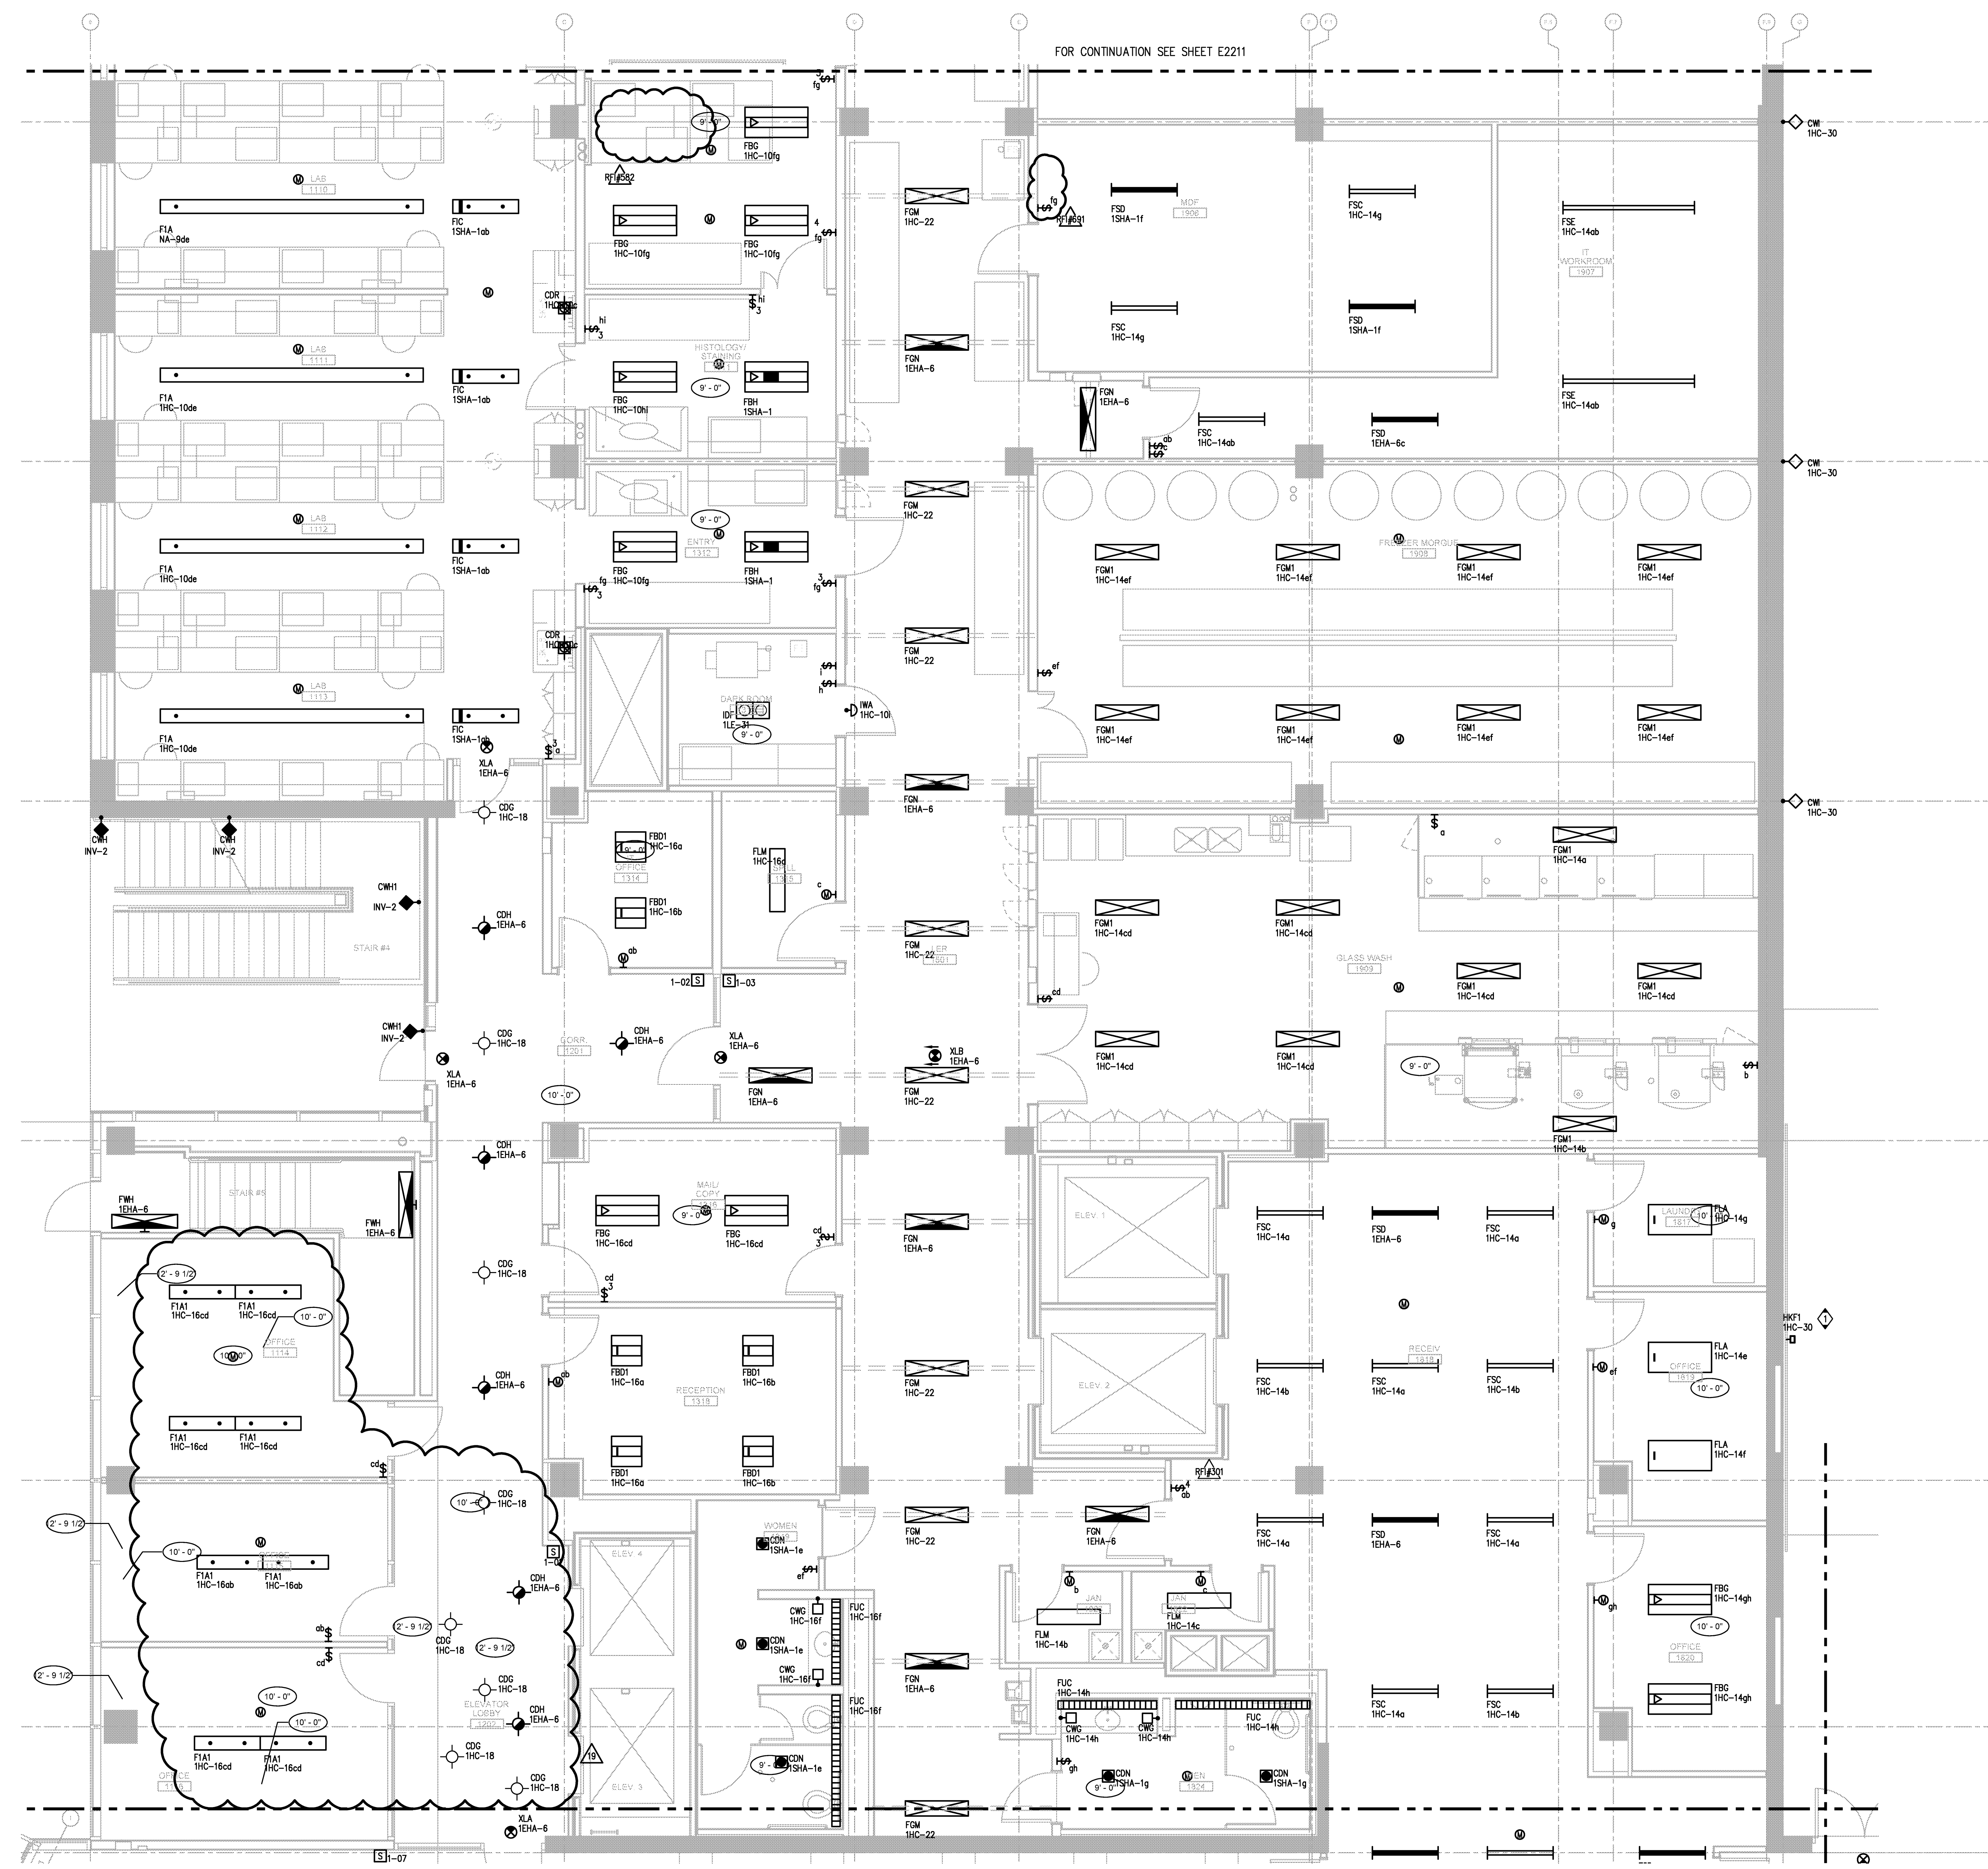

PARTIAL LIGHTING FIRST FLOOR PLAN - ZONE 2

10/22/2008 4:22:10 PM
F:\A\200725\A\200725.dwg
F:\A\200725\A\200725.dwg

Warning: It is a violation of the law for any person, unless acting under the direction of a licensed architect, to alter an item in any way. If an item in this document is altered, the altering architect, if other than the architect of record, shall affix the item his seal and the notation "altered by" followed by his signature and the date of such alteration, and the specific description of the alteration.