



ISSUED FOR		DATE
Pre-Schematic Design	07/14/2008	
Schematic Design	07/28/2008	
BID PK #1	10/06/2008	
50% Progress	10/24/2008	
BID PK #1 80 CD	12/01/2008	
BID PK #1 100 CD	02/10/2009	
BID PK #2 100 CD	03/26/2009	
100% CD	05/06/2009	
CD 4	01/07/2010	
CD 1	02/26/2010	
CD 2	02/26/2010	
CD 4	04/15/2010	


KEY NOTES:
1. FIXTURES ARE PHOTOCELL CONTROLLED. ROUTE CIRCUIT THROUGH PHOTOCELL CONTRACTOR LOCATED IN THE MAIN ELECTRICAL ROOM.

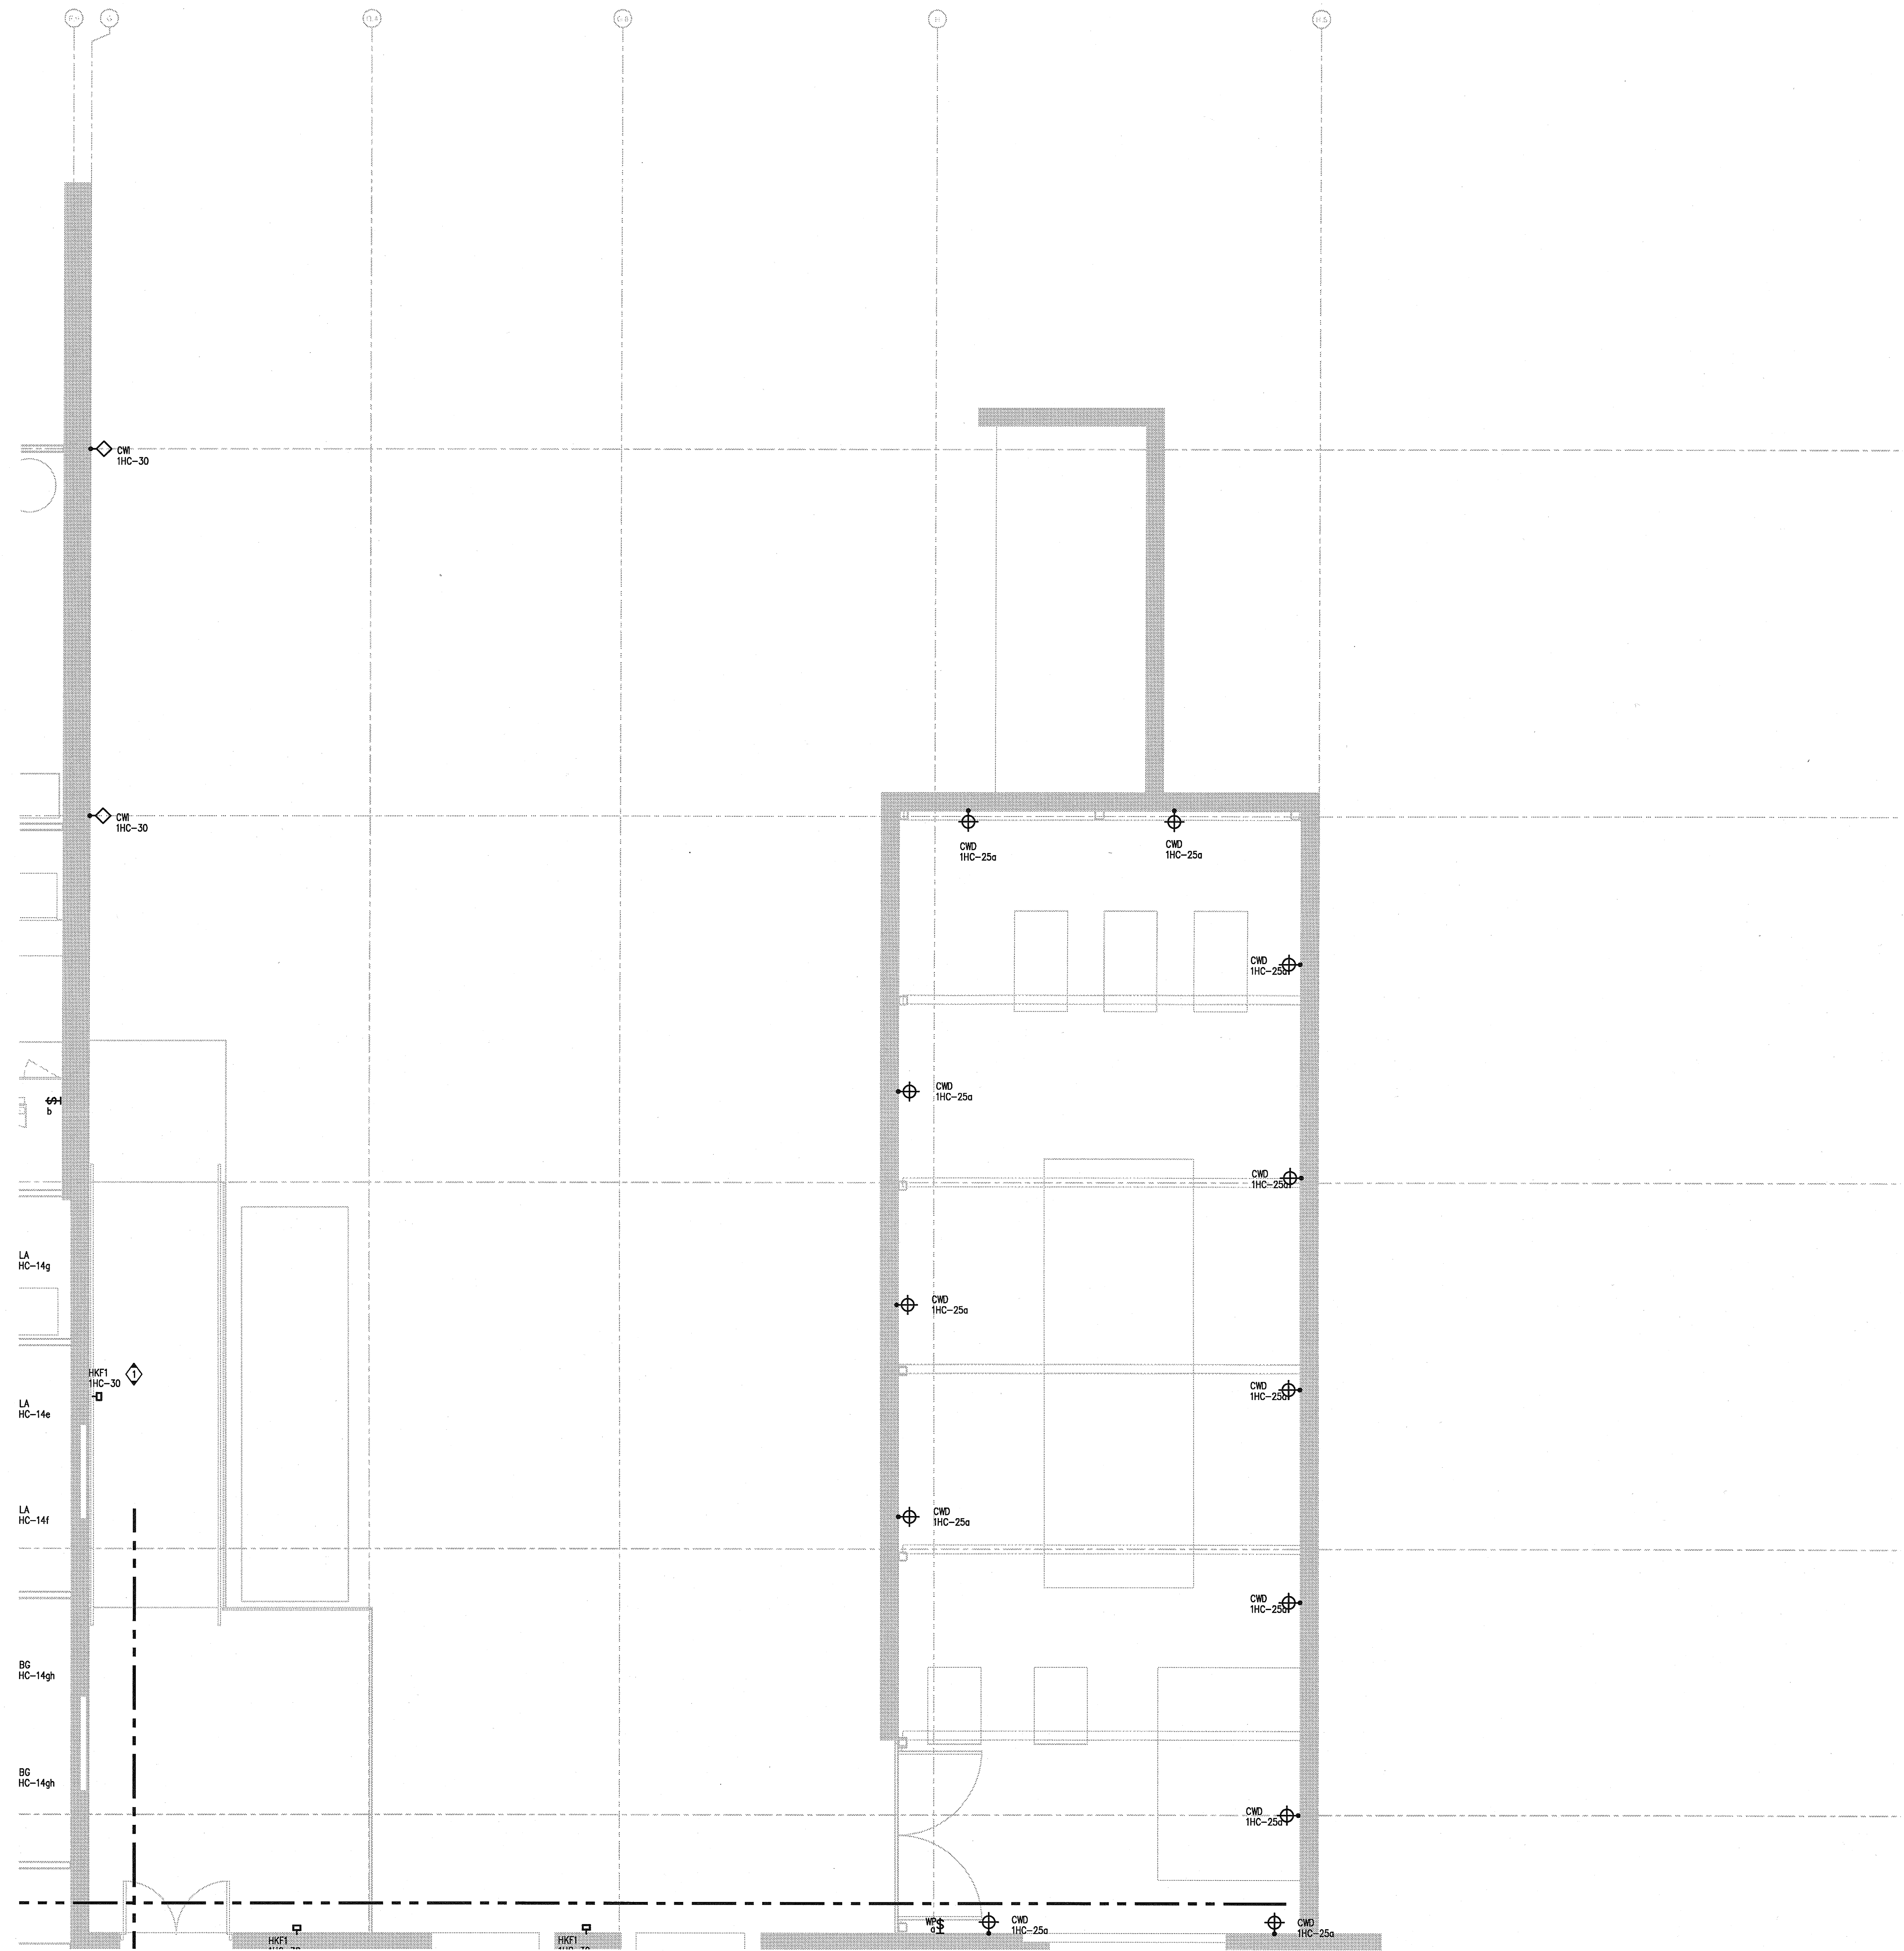

FOR CONTINUATION SEE SHEET E2214



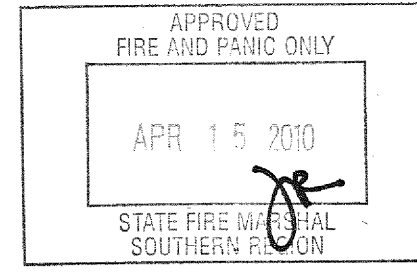


U.C.S.D.	DATE
PRELIMINARY DRAWINGS	
PROGRESS DRAWINGS	
REVIEW DRAWINGS	
CONSTRUCTION DRAWINGS	

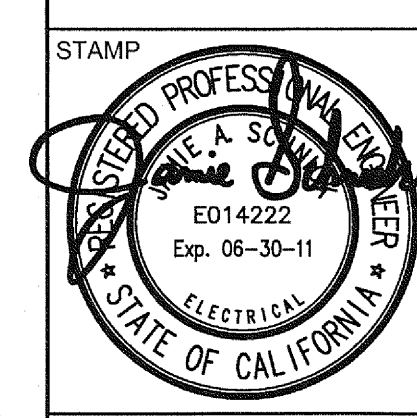

SHEET NAME	PARTIAL LIGHTING FIRST FLOOR PLAN - ZONE 5
DRAWN BY:	Author
PROJECT #:	200725.000
SHEET NUMBER	E2215

SANFORD CONSORTIUM FOR REGENERATIVE MEDICINE
2880 TORREY PINES SCENIC DRIVE
LA JOLLA, CALIFORNIA 92037

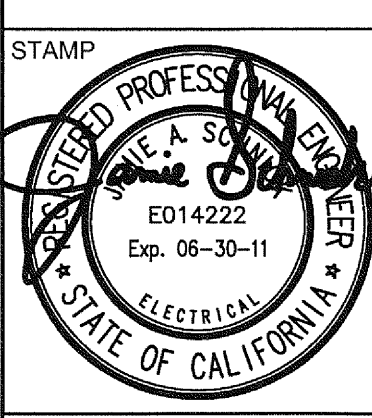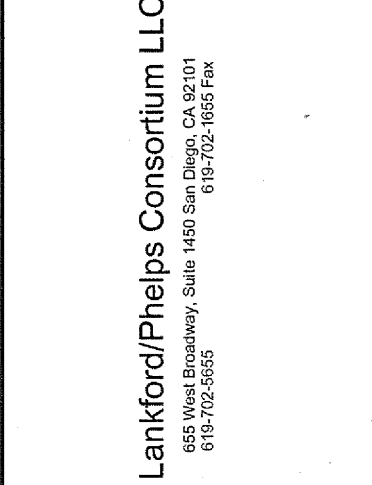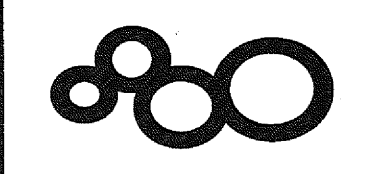

12/22/2009 4:52:10 PM
File Path: \\s:\projects\200725\200725.dwg