




Linkford/Phelps Consortium LLC
1555 North Broadway, Suite 1400 San Diego, CA 92101
619-762-0000

ANTRESS | ARCHITECTS
451 Broadway, Denver, CO 80202
303.733.6000

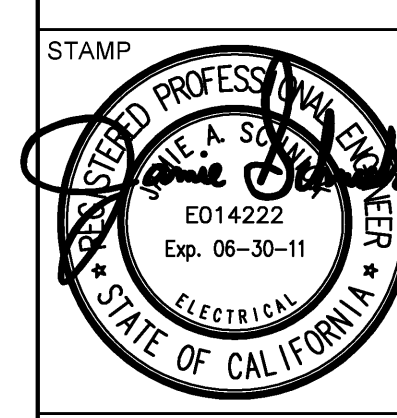

SHEET NAME
PARTIAL LIGHTING THIRD FLOOR PLAN - ZONE 1
DRAWN BY: Author
PROJECT #: 200725.000
SHEET NUMBER

E2231

GENERAL NOTES:


1. REFER TO ARCHITECTURAL PLANS AND ELEVATIONS FOR COORDINATION OF EXACT LOCATION AND MOUNTING HEIGHTS OF LUMINAIRES AND ELECTRICAL DEVICES.

KNOWNOTES:

① MOUNT POWER SUPPLY FOR STAIRWELL LIGHTING IN CEILING SPACE BELOW ROUTE 1'C. CONDUIT IN THE SLAB. STUD CONDUIT INTO HANDRAIL AND CONNECT TO HANDRAIL LIGHTING CIRCUIT TO TESTA. FIXTURES ARE PHOTOCELL CONTROLLED. ROUTE CIRCUIT THROUGH PHOTOCELL CONTACTOR LOCATED IN THE MAIN ELECTRICAL ROOM.

② HANDRAIL WITH INTEGRAL HIGH OUTPUT LED LIGHT FIXTURE PER ARCHITECTURAL PLANS AND DETAILS.

③ FIXTURES ARE PHOTOCELL CONTROLLED. ROUTE CIRCUIT THROUGH PHOTOCELL CONTACTOR LOCATED IN THE SOUTH ELECTRICAL ROOM.

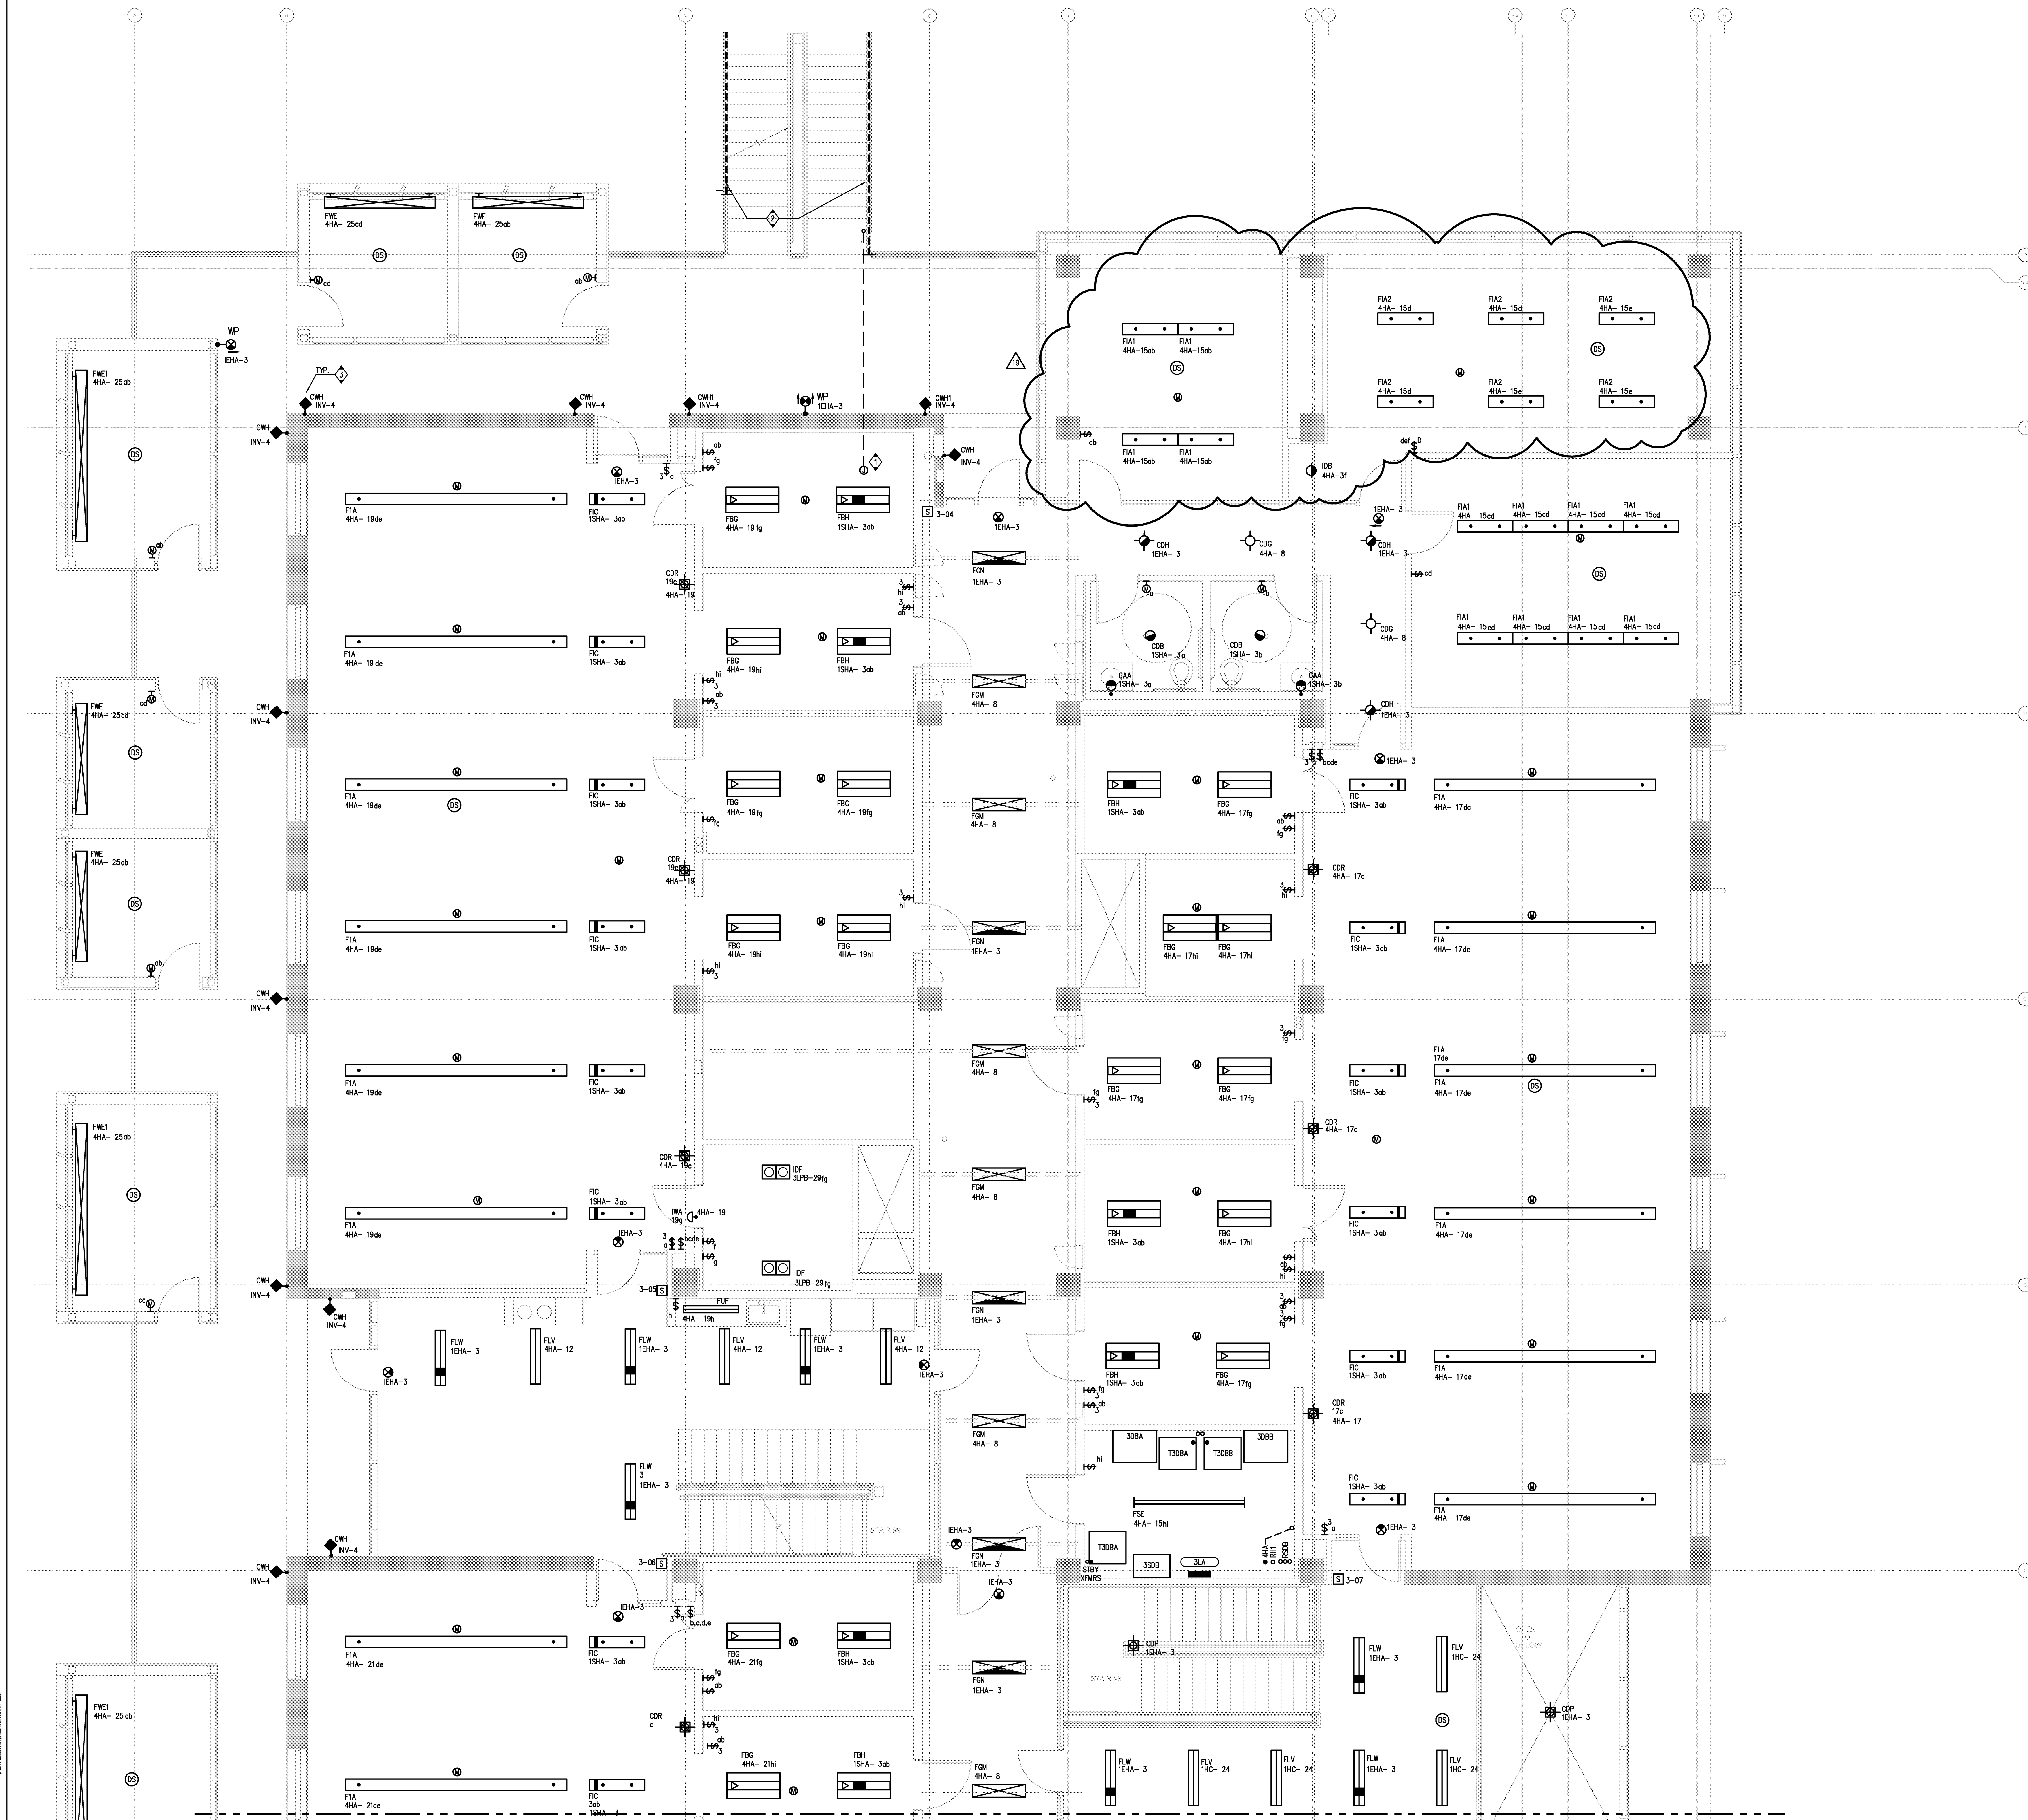

FOR CONTINUATION SEE SHEET E2232

PARTIAL LIGHTING THIRD FLOOR PLAN – ZONE 1

SCALE	1
1/4" = 1'-0"	

E2231

11/22/2008 4:52:10 PM
File Path

Warning: It is a violation of the law for any person, unless acting under the direction of a licensed architect, to alter an item in any way. If an item in this document is altered, the altering architect, if other than the architect of record, shall affix to the item his seal and the notation "altered by" follows by his signature and the date of such alteration, and the specific description of the alteration.