


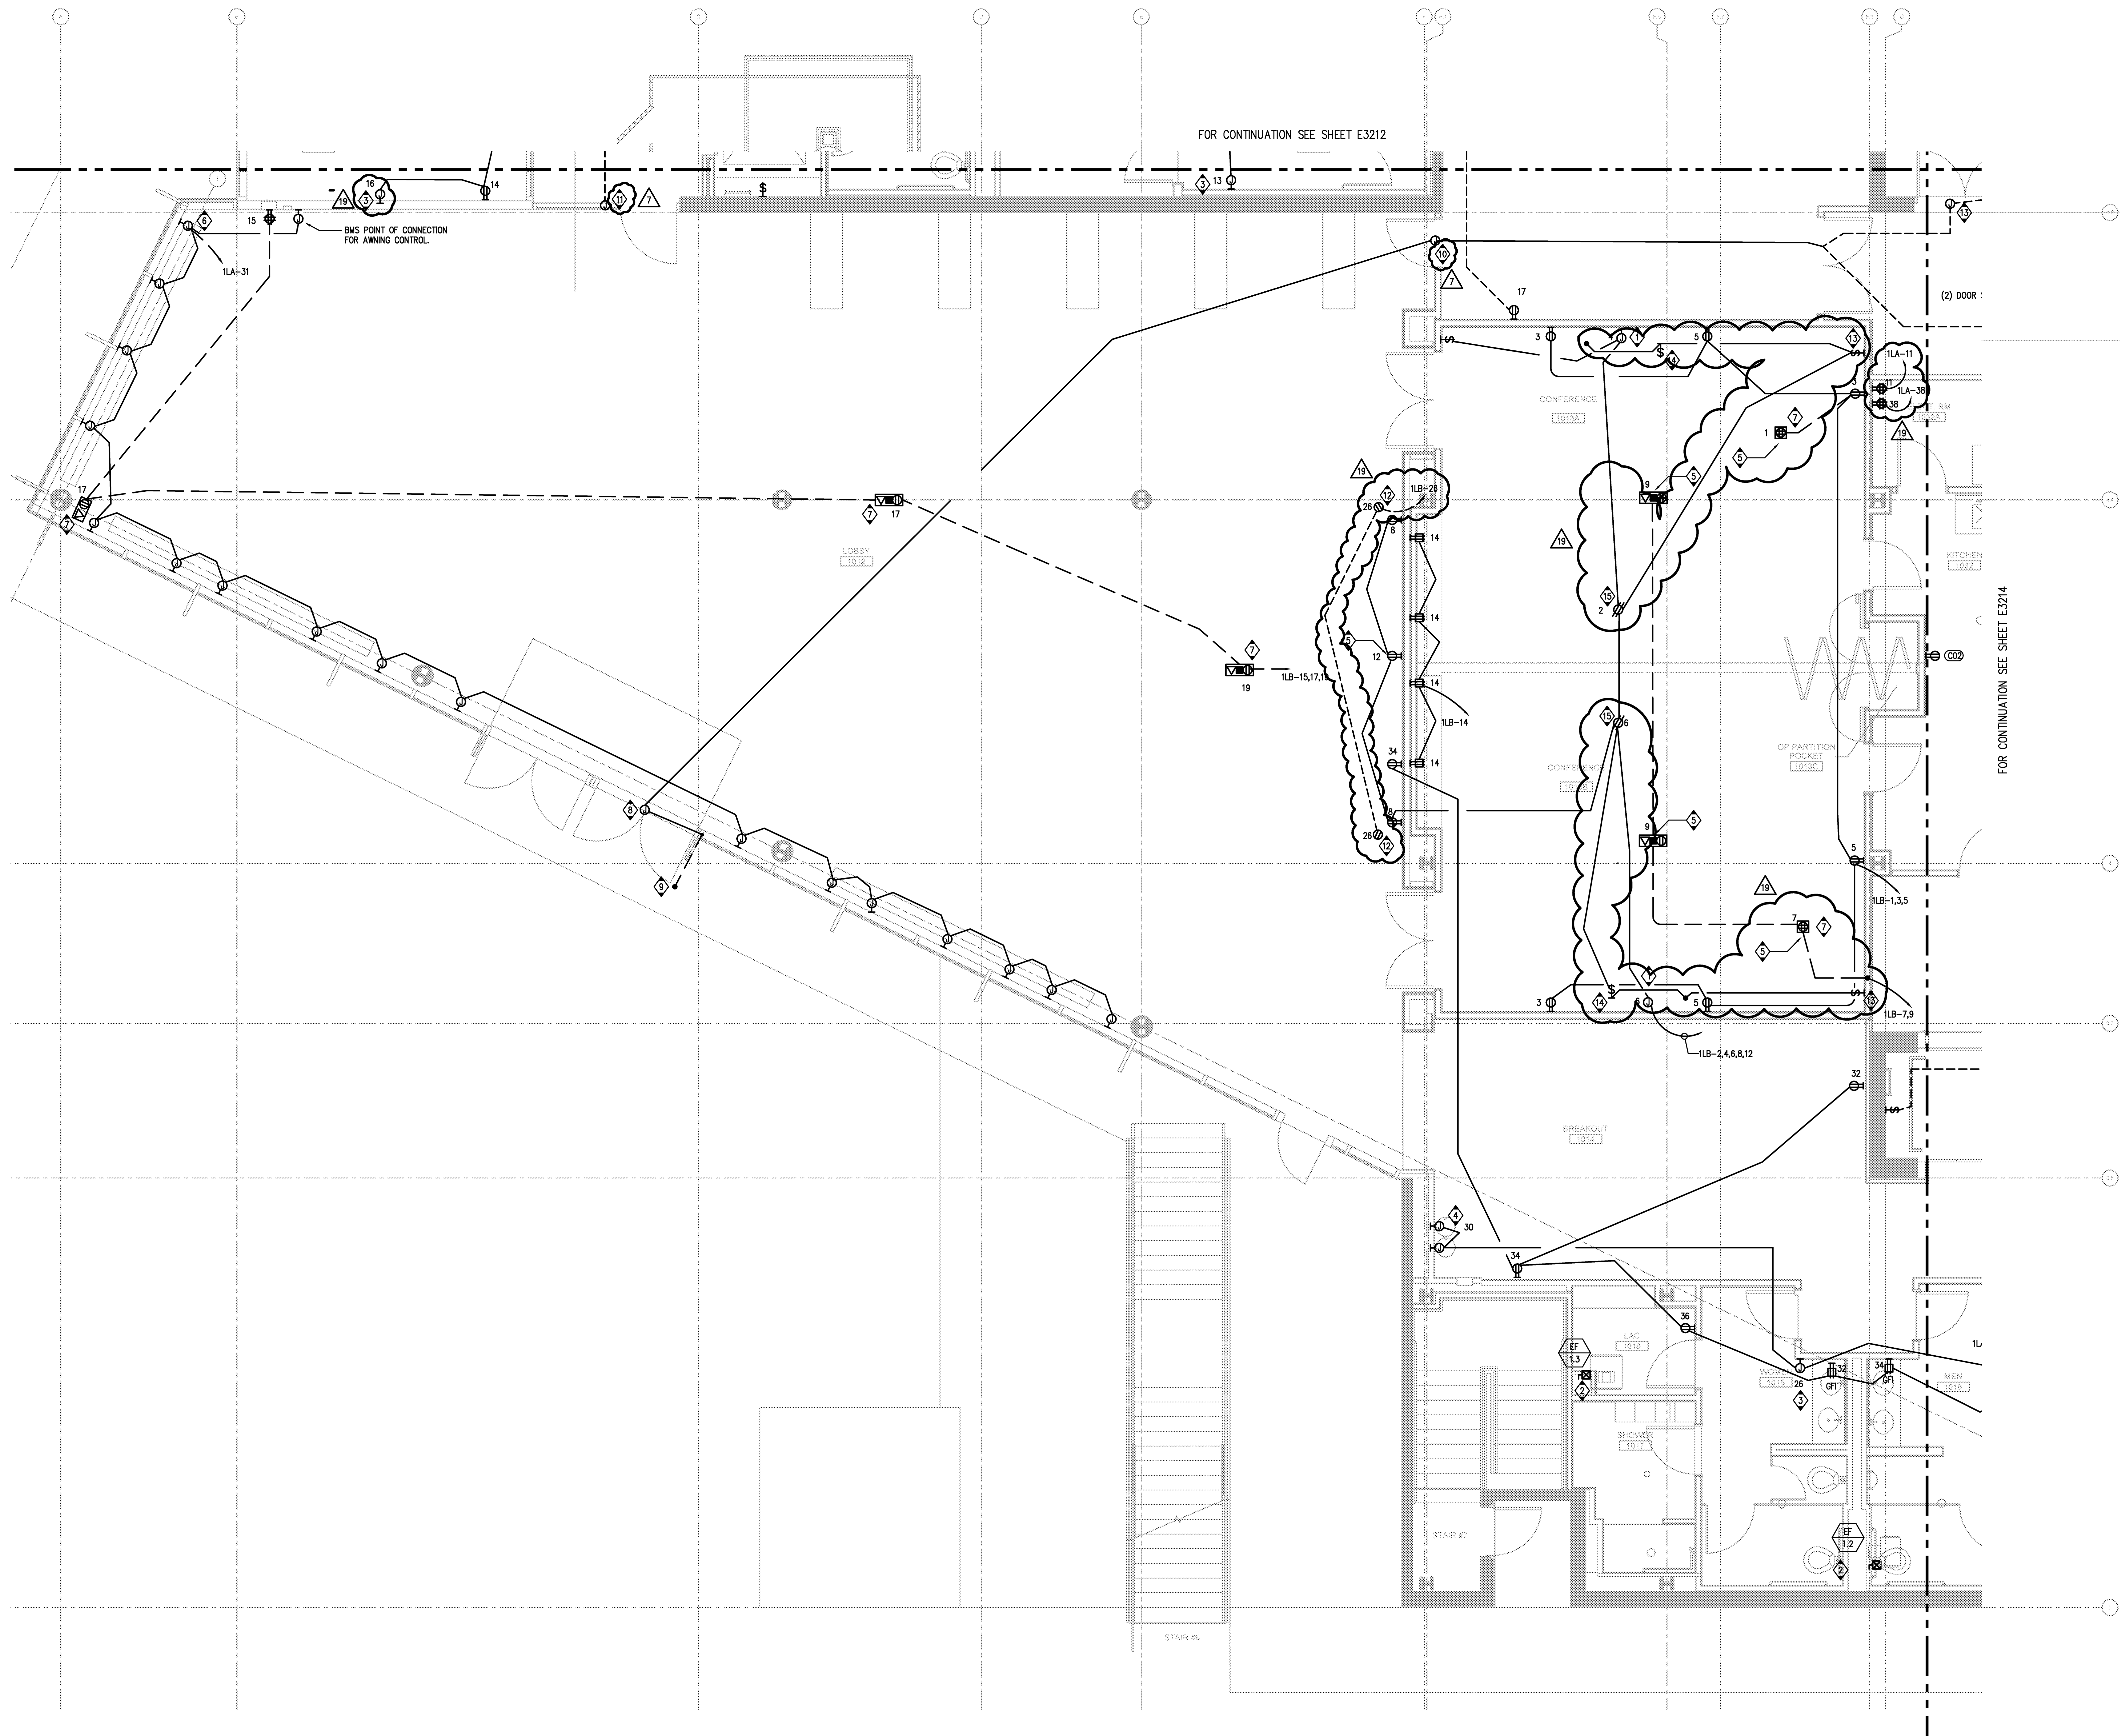

- GENERAL NOTES:**
1. REFERENCE AV DRAWINGS FOR BOX AND RACEWAY REQUIREMENTS FOR AV SYSTEM.
 2. MOUNT ELECTRICAL DEVICES IN LER AT 42" AFF.
 3. REFERENCE EQUIPMENT CONNECTION SCHEDULE ON SHEET E3000 FOR EQUIPMENT INFORMATION.
- KEY NOTES:**
1. CONNECT TO MOTORIZED SCREEN.
 2. CONNECT TO EXHAUST FAN.
 3. CONNECT TO HAND DRYER.
 4. CONNECT TO DRINKING FOUNTAIN.
 5. PROVIDE ISOLATED GROUND.
 6. MOUNT BOX TO MULLION. CONNECT TO WINDOW OPERATOR WITH SO CORD, TYP. FOR 14.
 7. INSTALL RECEPTACLE IN AV BOX.
 8. CONNECT TO ADA DOOR OPERATOR.
 9. STUD 3/4" CONDUIT FOR ADA DOOR ACTUATOR BOLLARD. COORDINATE BOLLARD LOCATION WITH ARCHITECTURAL PLANS.
 10. PROVIDE POWER JBOX AND CONNECT TO SECURITY XFRM.
 11. PROVIDE JBOX AND CONNECT TO DOOR HARDWARE POWER SUPPLY.
 12. POWER FOR LCD SCREEN. COORDINATE EXACT LOCATION WITH ARCHITECTURAL DRAWINGS PRIOR TO ROUGH-IN.
 13. WALL SWITCH FOR PROJECTION SCREEN. PROVIDED BY PROJECTOR VENDOR.
 14. CEILING MOUNTED DISCONNECT FOR PROJECTION SCREEN.
 15. MOUNT TO PROJECTOR MOUNTING PLATE AT CEILING. PROVIDE 10"HPF FOR INSTALLATION FLEXIBILITY.

COPYRIGHT © FENTRESS ARCHITECTS

ISSUED FOR	DATE
Pre-Schematic Design	07/14/2009
Schematic Design	07/28/2008
BID PK #1	10/08/2008
50% Progress	10/24/2008
BID PK #1 80 CD	12/01/2008
BID PK #1 100 CD	02/16/2009
BID PK #2 100 CD	03/26/2009
100% CD	05/08/2009
CD 4	01/07/2010
COB 1	02/26/2010
COB 2	02/26/2010
CD 4	04/15/2010
RVP PERMIT	05/05/2010
ASIM008 RL	07/01/2010
ASIM009	07/06/2010
ASIM015	07/09/2010
ASIM004	07/12/2010
ASIM005	07/19/2010
ASIM010	08/13/2010

SANFORD CONSORTIUM FOR REGENERATIVE MEDICINE

2880 TORREY PINES SCENIC DRIVE
LA JOLLA, CALIFORNIA 92037

CONSULTANT

xrth
Xanthos Research & Technology, Inc.
3071 Torrey Pines Road, Suite 100
La Jolla, CA 92037
Tel: 858.592.5555
Fax: 858.592.5555
www.xrth.com

CONSULTANT

Lanford/Phelps Consortium LLC
10000 La Jolla Village Drive, Suite 100
La Jolla, CA 92037
Tel: 858.592.5555
Fax: 858.592.5555
www.lanfordphelps.com

FENTRESS ARCHITECTS
415 Broadway, Denver, CO 80202
303.733.0000
www.fentressarchitects.com

DAVIS ARCHITECTS
3001 Fifth Avenue, San Diego, CA 92109
619.594.0000
www.davisarchitects.com

STAMP

REGISTERED PROFESSIONAL ENGINEER
ELECTRICAL
No. 10000
Exp. 06-30-11
STATE OF CALIFORNIA

SHEET NAME
PARTIAL POWER FIRST FLOOR
PLAN - ZONE 3

DRAWN BY: Author
PROJECT # 200725.000
SHEET NUMBER

E3213

SCALE
1/4" = 1'-0"

1

PARTIAL POWER FIRST FLOOR PLAN - ZONE 3