


FOR CONTINUATION SEE SHEET E3223

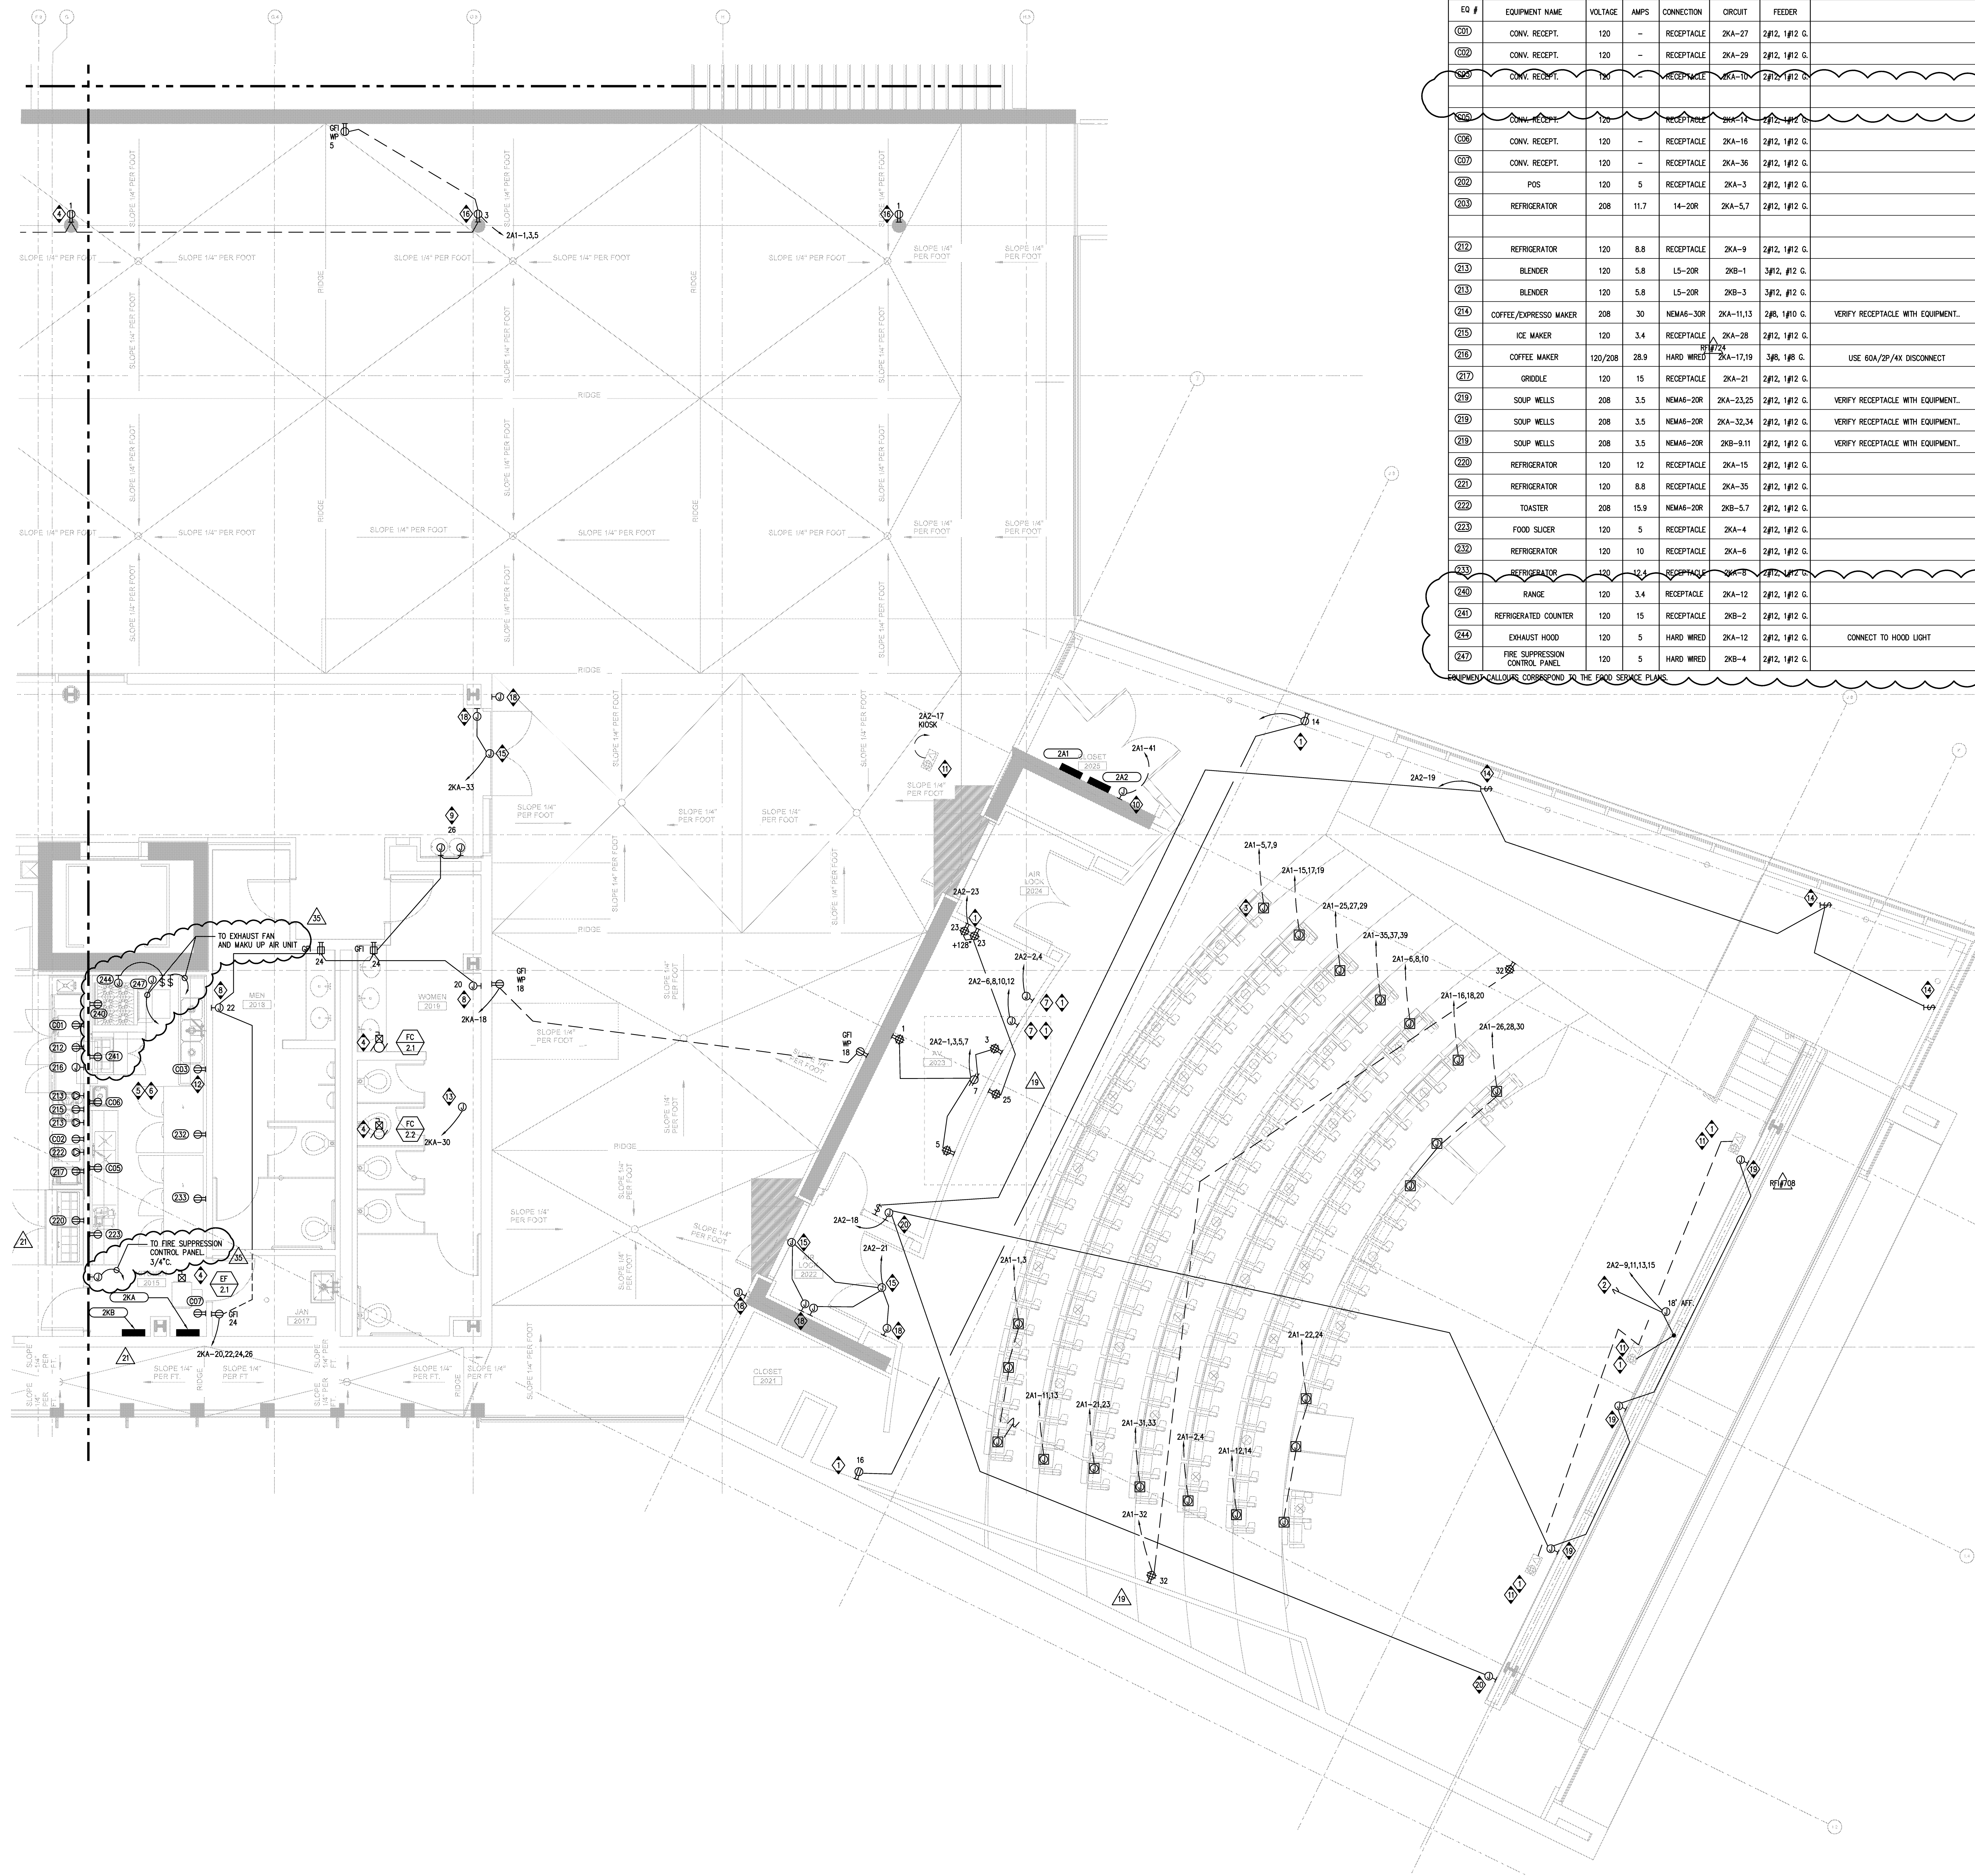

KITCHEN EQUIPMENT SCHEDULE						
EQ #	EQUIPMENT NAME	VOLTAGE	AMPS	CONNECTION	CIRCUIT	FEEDER
000	CONV. RECEPT.	120	-	RECEPTACLE	2KA-27	2#12, 1#12 G.
000	CONV. RECEPT.	120	-	RECEPTACLE	2KA-29	2#12, 1#12 G.
000	CONV. RECEPT.	120	-	RECEPTACLE	2KA-10	2#12, 1#12 G.
000	CONV. RECEPT.	120	-	RECEPTACLE	2KA-14	2#12, 1#12 G.
000	CONV. RECEPT.	120	-	RECEPTACLE	2KA-16	2#12, 1#12 G.
000	CONV. RECEPT.	120	-	RECEPTACLE	2KA-36	2#12, 1#12 G.
000	POS	120	5	RECEPTACLE	2KA-3	2#12, 1#12 G.
000	REFRIGERATOR	208	11.7	14-20R	2KA-5,7	2#12, 1#12 G.
012	REFRIGERATOR	120	8.8	RECEPTACLE	2KA-9	2#12, 1#12 G.
013	BLENDER	120	5.8	L5-20R	2KB-1	3#12, #12 G.
013	BLENDER	120	5.8	L5-20R	2KB-3	3#12, #12 G.
014	COFFEE/ESPRESSO MAKER	208	30	NEMA6-30R	2KA-11,13	2#8, 1#10 G.
015	ICE MAKER	120	3.4	RECEPTACLE	2KA-28	2#12, 1#12 G.
016	COFFEE MAKER	120/208	28.9	HARD WIRED	2KA-17,19	3#8, 1#8 G.
017	GRIDDLE	120	15	RECEPTACLE	2KA-21	2#12, 1#12 G.
019	SOUP WELLS	208	3.5	NEMA6-20R	2KA-23,25	2#12, 1#12 G.
019	SOUP WELLS	208	3.5	NEMA6-20R	2KA-32,34	2#12, 1#12 G.
019	SOUP WELLS	208	3.5	NEMA6-20R	2KB-9,11	2#12, 1#12 G.
020	REFRIGERATOR	120	12	RECEPTACLE	2KA-15	2#12, 1#12 G.
021	REFRIGERATOR	120	8.8	RECEPTACLE	2KA-35	2#12, 1#12 G.
022	TOASTER	208	15.9	NEMA6-20R	2KB-5,7	2#12, 1#12 G.
023	FOOD SLICER	120	5	RECEPTACLE	2KA-4	2#12, 1#12 G.
023	REFRIGERATOR	120	10	RECEPTACLE	2KA-6	2#12, 1#12 G.
023	REFRIGERATOR	120	12.4	RECEPTACLE	2KA-8	2#12, 1#12 G.
024	RANGE	120	3.4	RECEPTACLE	2KA-12	2#12, 1#12 G.
024	REFRIGERATED COUNTER	120	15	RECEPTACLE	2KB-2	2#12, 1#12 G.
024	EXHAUST HOOD	120	5	HARD WIRED	2KA-12	2#12, 1#12 G.
027	FIRE SUPPRESSION CONTROL PANEL	120	5	HARD WIRED	2KB-4	2#12, 1#12 G.

EQUIPMENT CALLOUTS CORRESPOND TO THE FOOD SERVICE PLANS.

- GENERAL NOTES:
1. REFERENCE AV DRAWINGS FOR BOX AND RACEWAY REQUIREMENTS FOR AV SYSTEM.
- KEY NOTES:
- 1 PROVIDE ISOLATED GROUND.
 - 2 CONNECT TO MOTORIZED SCREEN.
 - 3 CONNECT TO AUDITORIUM SEATING, TYPICAL.
 - 4 CONNECT TO MECHANICAL EQUIPMENT.
 - 5 REFERENCE FOOD SERVICE DRAWINGS FOR MOUNTING HEIGHTS AND EXACT LOCATION OF DEVICES.
 - 6 PROVIDE ALL 15A AND 20A 125V RECEPTACLES IN KITCHEN WITH GFCI PROTECTION.
 - 7 CONNECT TO AV RACK.
 - 8 CONNECT TO HAND DRYER.
 - 9 CONNECT TO DRINKING FOUNTAINS.
 - 10 CONNECT TO IRRIGATION CONTROLLER. FIELD COORDINATE EXACT LOCATION.
 - 11 INSTALL RECEPTACLE IN AV BOX.
 - 12 PROVIDE WP WHILE IN USE COVER.
 - 13 CONNECT TO MECHANICAL CONTROLS.
 - 14 CONNECT TO MOTORIZED SHADES AND BLACK OUT CURTAINS.
 - 15 CONNECT TO ADA DOOR OPERATOR. REF#101
 - 16 PROVIDE "WEATHER PROOF WHILE IN USE" DUPLEX RECEPTACLE IN LIGHT POLE BASE.
 - 17 STRIP 3/4" CONDUIT FOR ADA DOOR ACTUATOR BOLLARD. COORDINATE BOLLARD LOCATION WITH ARCHITECTURAL PLANS.
 - 18 ROUTE 3/4" CONDUIT FOR ADA DOOR ACTUATOR WALL PUSHPLATE. COORDINATE LOCATION WITH ARCHITECTURAL PLANS.
 - 19 CONNECT TO BLACKOUT SHADE OPERATORS. REF#108
 - 20 CONTROL POINT FOR BLACKOUT SHADE CONTROL.

ISSUED FOR DATE	
BID PK #1	10/09/2009
50% Progress	10/24/2009
BID PK #1 80 CD	12/01/2009
BID PK #1 100 CD	02/16/2009
BID PK #2 100 CD	03/26/2009
100% CD	05/08/2009
CD 4	01/07/2010
COB 1	02/06/2010
COB 2	02/26/2010
CD 4	04/15/2010
RAW PERMIT	05/05/2010
ASIM008 R1	07/01/2010
ASIM005	07/08/2010
ASIM015	07/09/2010
ASIM004	07/12/2010
ASIM008R2	07/19/2010
ASIM010	08/13/2010
ASIM011	08/27/2010
ASIM020	09/20/2010
ASIM018	11/17/2010
ASIM028	12/15/2010
ASIM028R2	01/14/2011
ASIM028	01/21/2011
ASIM028R1	01/28/2011
ASIM018R1	02/16/2011
RFI#1203	02/16/2011

SANFORD CONSORTIUM FOR REGENERATIVE MEDICINE

2880 TORREY PINES SCENIC DRIVE
LA JOLLA, CALIFORNIA 92037



CONSULTANT

xyth
xth Inc. (an Equal Opportunity Employer)
3701 DeSoto Dr., Suite 200
San Diego, CA 92108
619.594.8888
www.xth.com


Sanford/Phelps Consortium LLC
415 Broadway, Denver, CO 80202
303.733.0688
www.sanfordphelps.com

FENTRESS ARCHITECTS

415 Broadway, Denver, CO 80202
303.733.0688
www.fentressarchitects.com

DAVIS ARCHITECTS

3001 Park Avenue, San Diego, CA 92106

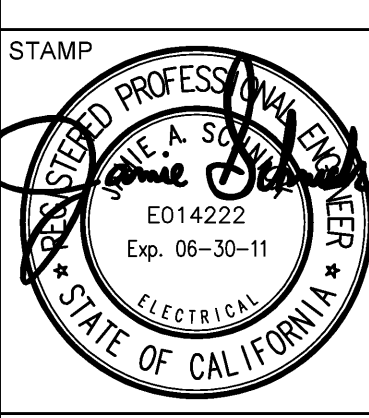

SHEET NAME
PARTIAL POWER SECOND FLOOR PLAN - ZONE 4

DRAWN BY: Author

PROJECT # 200725.000

SHEET NUMBER

E3224

PARTIAL POWER SECOND FLOOR PLAN - ZONE 4

SCALE
1/4" = 1'-0"

1

1/25/2009 4:22:10 PM
C:\Users\james\Documents\Sanford\Sanford_Power\Sanford_Power.dwg
File Print

Warning: It is a violation of the law for any person, unless acting under the direction of a licensed architect, to alter an item in any way. If an item in this document is altered, the altering architect, if other than the architect of record, shall affix the item his seal and the notation "altered by" followed by his signature and the date of such alteration, and the specific description of the alteration.