


COPYRIGHT © FENTRESS ARCHITECTS	
ISSUED FOR DATE	07/14/2009
Pre-Schematic Design	07/28/2008
Schematic Design	10/08/2008
BID PK #1	10/24/2008
BID PK #1 80 CD	12/01/2008
BID PK #1 100 CD	02/16/2009
BID PK #2 100 CD	03/26/2009
100% CD	05/08/2009
CD 4	01/07/2010
COB 1	02/26/2010
COB 2	02/26/2010
CD 4	04/15/2010
RVI PERMIT	05/05/2010
ASIM008 RT	07/01/2010
ASIM009	07/06/2010
ASIM015	07/09/2010
ASIM004	07/12/2010
ASIM005	07/13/2010
ASIM010	08/13/2010


SANFORD CONSORTIUM FOR REGENERATIVE MEDICINE
2880 TORREY PINES SCENIC DRIVE
LA JOLLA, CALIFORNIA 92037

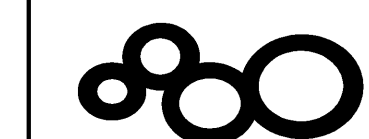

CONSULTANT
Arch
Architectural Group
3070 Torrey Pines Road, Suite 100
La Jolla, CA 92037
Tel: 858.592.5555
Fax: 858.592.5555

CONSULTANT
Lankford/Heaps Consortium LLC
415 Broadway, Denver, CO 80202
Tel: 303.733.8888
Fax: 303.733.8888


FENTRESS ARCHITECTS
415 Broadway, Denver, CO 80202
Tel: 303.733.8888
Fax: 303.733.8888

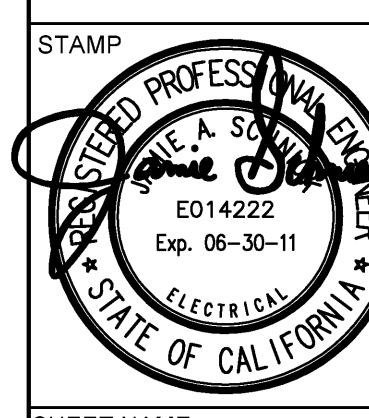

SHEET NAME
PARTIAL POWER THIRD FLOOR
PLAN - ZONE 1
DRAWN BY: Author
PROJECT # 200725.000
SHEET NUMBER

E3231

- GENERAL NOTES:**
1. SEE AV DRAWINGS FOR ADDITIONAL CONDUIT REQUIREMENTS.
2. MOUNT ELECTRICAL DEVICES IN LER AT 42" AFF.
- KEY NOTES:**
1. INSTALL IN AV BOX.
2. CONNECT TO MOTORIZED SCREEN.
3. STUB OUT TO CABLE TRAY, ROUTE 1" C. TIGHT TO SLAB, TYP. FOR EQUIPMENT SPACE.
4. CONNECT TO CER CONTROLS.
5. CONNECT TO CER CONDENSER UNIT.
6. PROVIDE 2 POLE SWITCH IN CEILING FOR DISCONNECTING MEANS. TYPICAL FOR POD FAN COIL.
7. CONNECT TO HAND DRYER.
8. NOT USED.
9. CONNECT TO SYSTEMS FURNITURE.
10. CONNECT TO FUME HOOD.
11. NEMA 6-20R.
12. NEMA 6-30R. PROVIDE 2/10, 1/10G.
13. NEMA 5-20R.
14. PROVIDE ISOLATED GROUND.
15. CONNECT TO MECHANICAL CONTROLS.
16. NOT USED.
17. CONNECT TO SECURITY POWER SUPPLY.
18. PROVIDE A 5-20R RECEPTACLE IN SURFACE RACEWAY FOR CONNECTION TO EQUIPMENT.
19. WALL SWITCH FOR PROJECTION SCREEN. PROVIDED BY PROJECTOR VENDOR.
20. CEILING MOUNTED DISCONNECT FOR PROJECTION SCREEN.
21. MOUNT TO PROJECTOR MOUNTING PLATE AT CEILING. PROVIDE 10" MIN. FOR INSTALLATION FLEXIBILITY.
22. CONNECT TO BMS CONTROLS. COORDINATE EXACT LOCATION WITH CONTROLS CONTRACTOR.

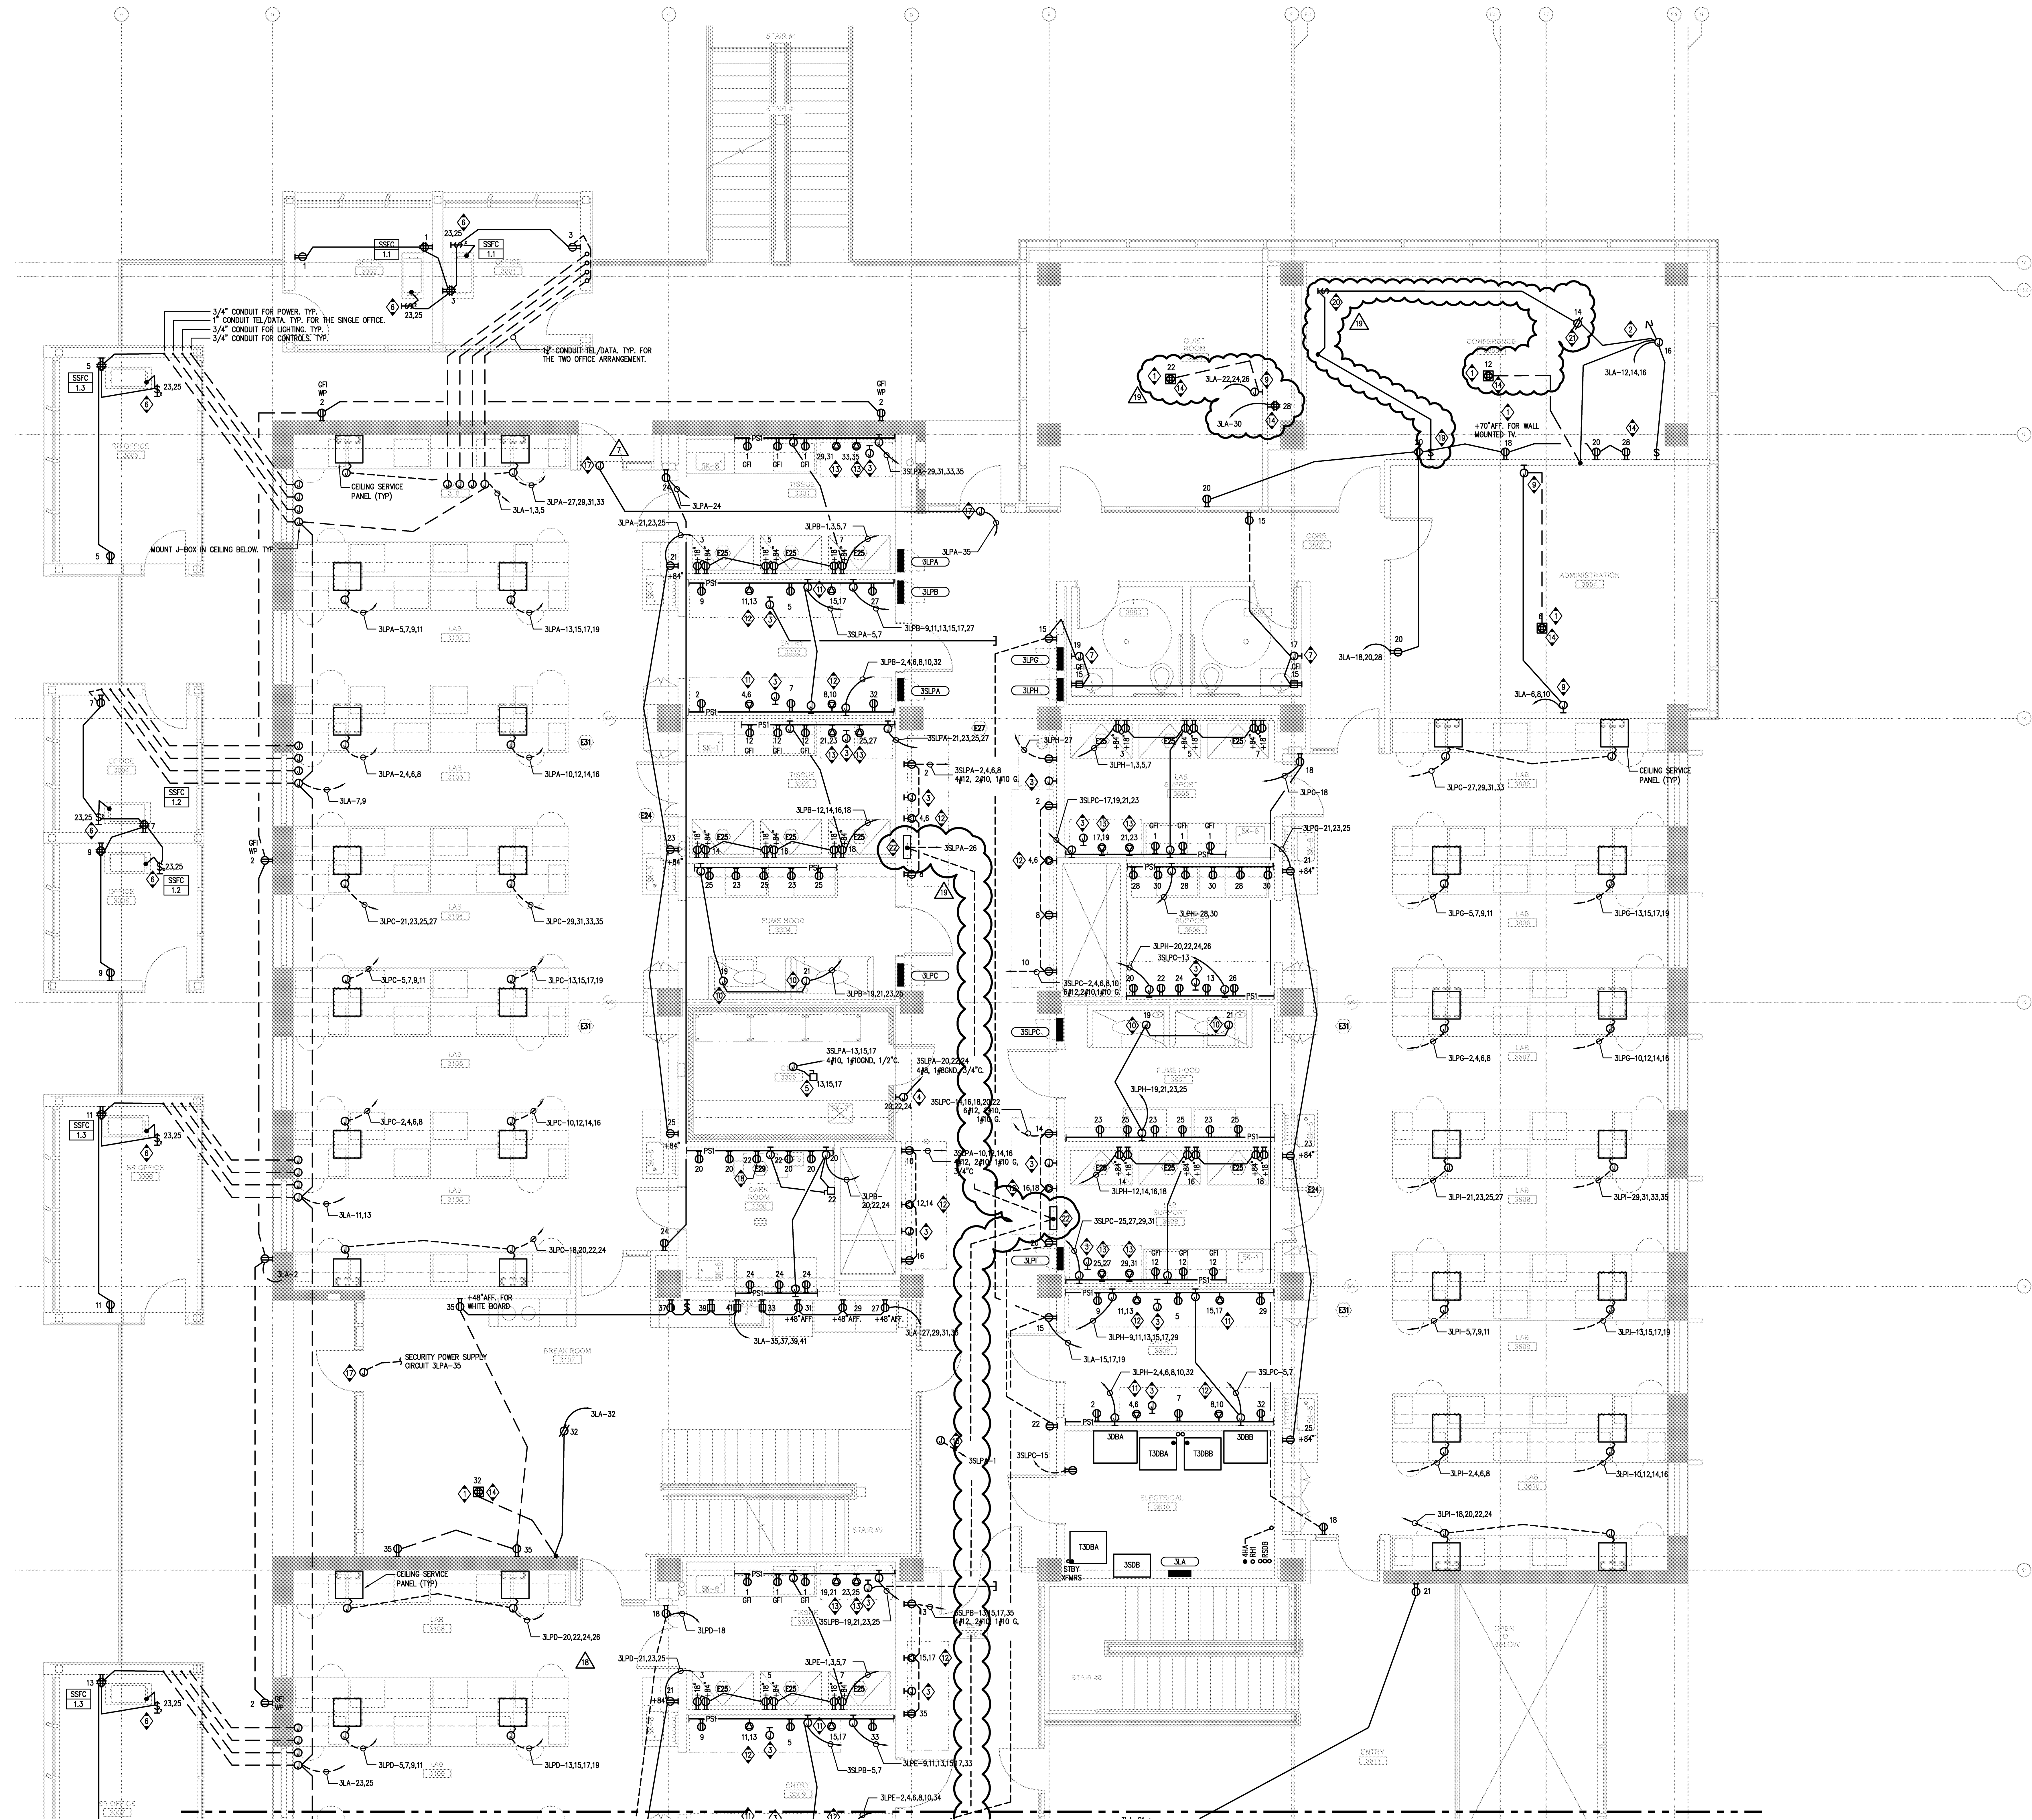

PARTIAL POWER THIRD FLOOR PLAN - ZONE 1

SCALE 1/4" = 1'-0" 1

10/22/2009 4:42:10 PM
F:\A\200725\000\A\A3231.dwg
F:\A\200725\000\A\A3231.dwg

Warning: It is a violation of the law for any person, unless acting under the direction of a licensed architect, to alter an item in any way. If an item in this document is altered, the altering architect, if other than the architect of record, shall affix the item his seal and the notation "altered by" followed by his signature and the date of such alteration, and the specific description of the alteration.